

INDEX TO DRAWINGS	
SHEET NO.	DESCRIPTION
1	TITLE SHEET
2	STANDARD PLAN SUMMARY
3 – 7	ABBREVIATIONS, LEGEND AND NOTES
8 – 15	TYPICAL ROADWAY & BRIDGE SECTIONS
16 – 18	PAVEMENT DETAILS
19	GENERAL SITE PLAN
20 – 30	ROADWAY PLAN & PROFILE AND SUPERELEVATION DIAGRAM
31 – 32	ROADWAY PLAN & PROFILE – HOKIOKIO CONNECTOR
33	ROADWAY PLAN & PROFILE – KAUAULA ROAD / AG. CROSSING
34	ROADWAY PLAN & PROFILE – GRAVEL ACCESS ROAD
35 – 37	KAUAULA STREAM BRIDGE – LAYOUT PLAN, PROFILE, AND GRADING PLAN
38	RETAINING WALL PLAN & PROFILE
39 – 42	P.C.C. PAVEMENT JOINTING PLAN
43	GENERAL GRADING PLAN
44 – 56	GRADING & DRAINAGE PLAN AND DRAINLINE PROFILES
57 – 62	DRAINAGE CULVERT CROSSING PLAN & PROFILE
63 – 64	PAVEMENT MARKING LEGEND, NOTES & DETAILS
65 – 70	SIGNAGE & PAVEMENT MARKING PLAN
71 – 76	TEMPORARY EROSION CONTROL & PERMANENT BMP PLAN AND DETAILS
77	TRAFFIC CONTROL PLAN – LAHAINALUNA ROAD
78 – 82	DRAINAGE CULVERT DETAILS
83	DRAINAGE DETAILS
84 – 88	WATER QUALITY CONTROL DEVICE DETAILS
89 – 99	GUARDRAIL DETAILS
100 – 104	TRAFFIC SIGNAL PLANS AND DETAILS
105	BORING LOCATION PLAN
106 – 112	BORING LOGS
113 – 166	STRUCTURAL PLANS
167 – 174	ELECTRICAL PLANS
175 – 213	CROSS SECTIONS

STATE OF HAWAII

DEPARTMENT OF TRANSPORTATION

HIGHWAYS DIVISION

HONOLULU, HAWAII

**AS-BUILT**

PLANS FOR

HONOAPIILANI HIGHWAY REALIGNMENT


PHASE 1B-1

LAHAINALUNA ROAD TO HOKIOKIO PLACE

FEDERAL AID PROJECT NO. NH-030-1(38)

DISTRICT OF LAHAINA

ISLAND OF MAUI

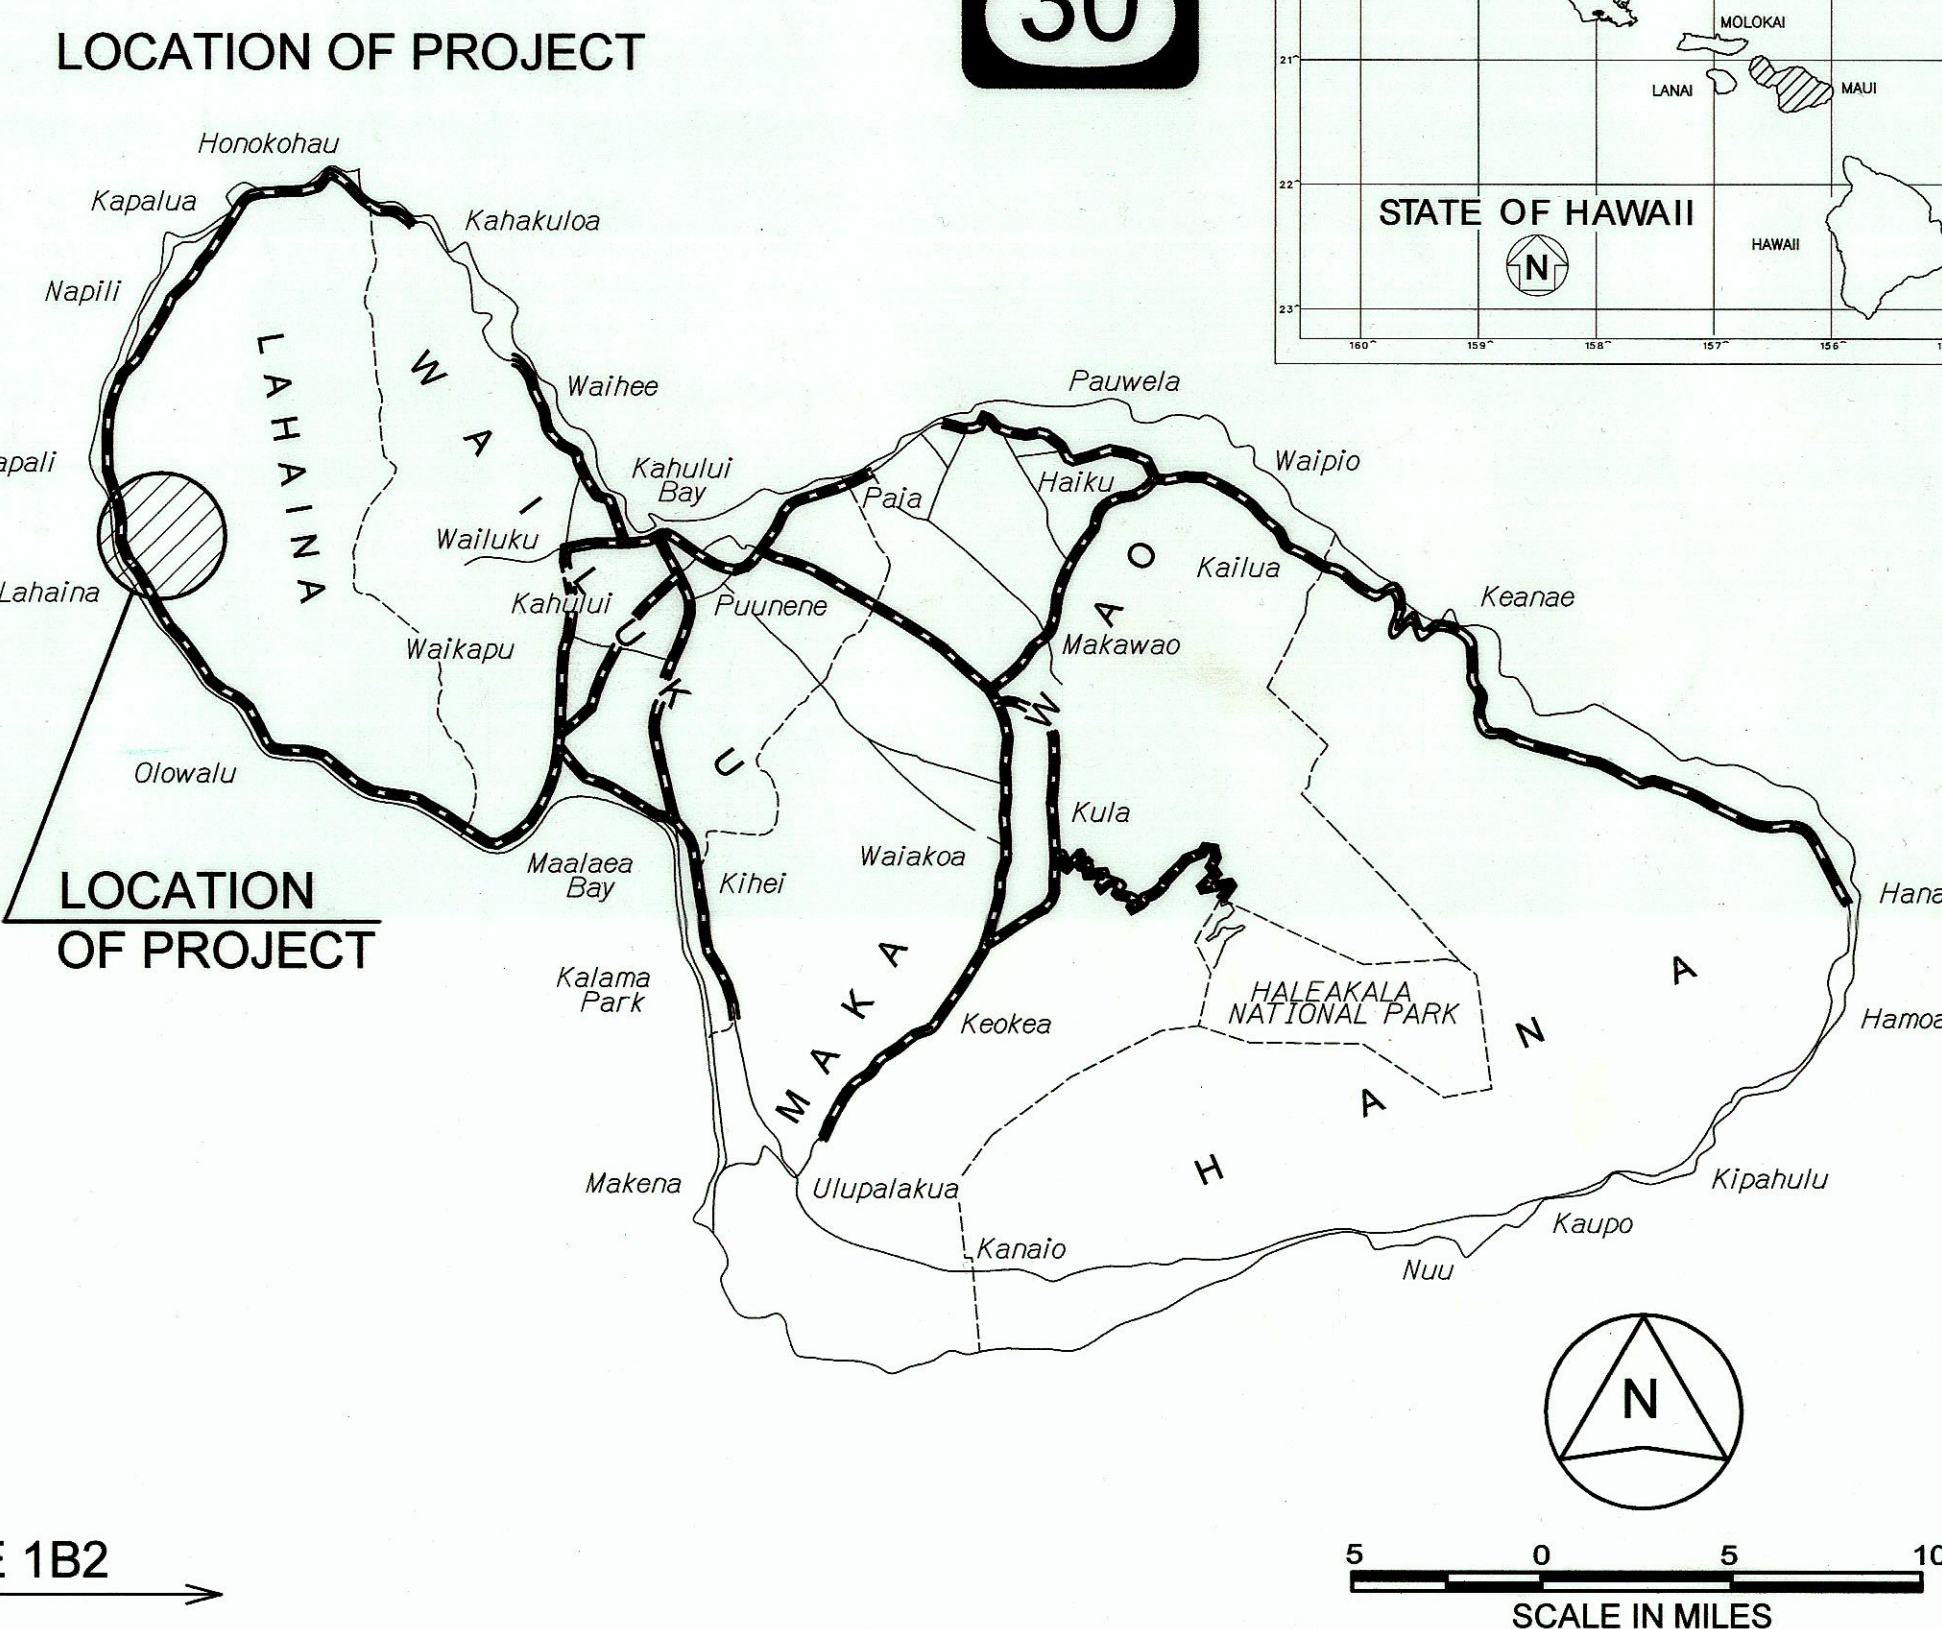

CHANGES MADE DURING CONSTRUCTION HAVE BEEN  
INCORPORATED ON THESE PLANS EXCEPT CHANGES  
IN THE ORIGINAL THEORETICAL QUANTITIES. FOR  
ACTUAL QUANTITIES, REFER TO PROJECT LEDGER  
AND/OR COMPUTATION BOOK.

*H. J. Gillan* 1/27/2023  
\_\_\_\_\_  
RESIDENT ENGINEER DATE