




FED. ROAD DIST. NO.	STATE	PROJ. NO.	FISCAL YEAR	SHEET NO.	TOTAL SHEETS
HAWAII	HAW.	HSIP-030-1(42)	2013	21	21

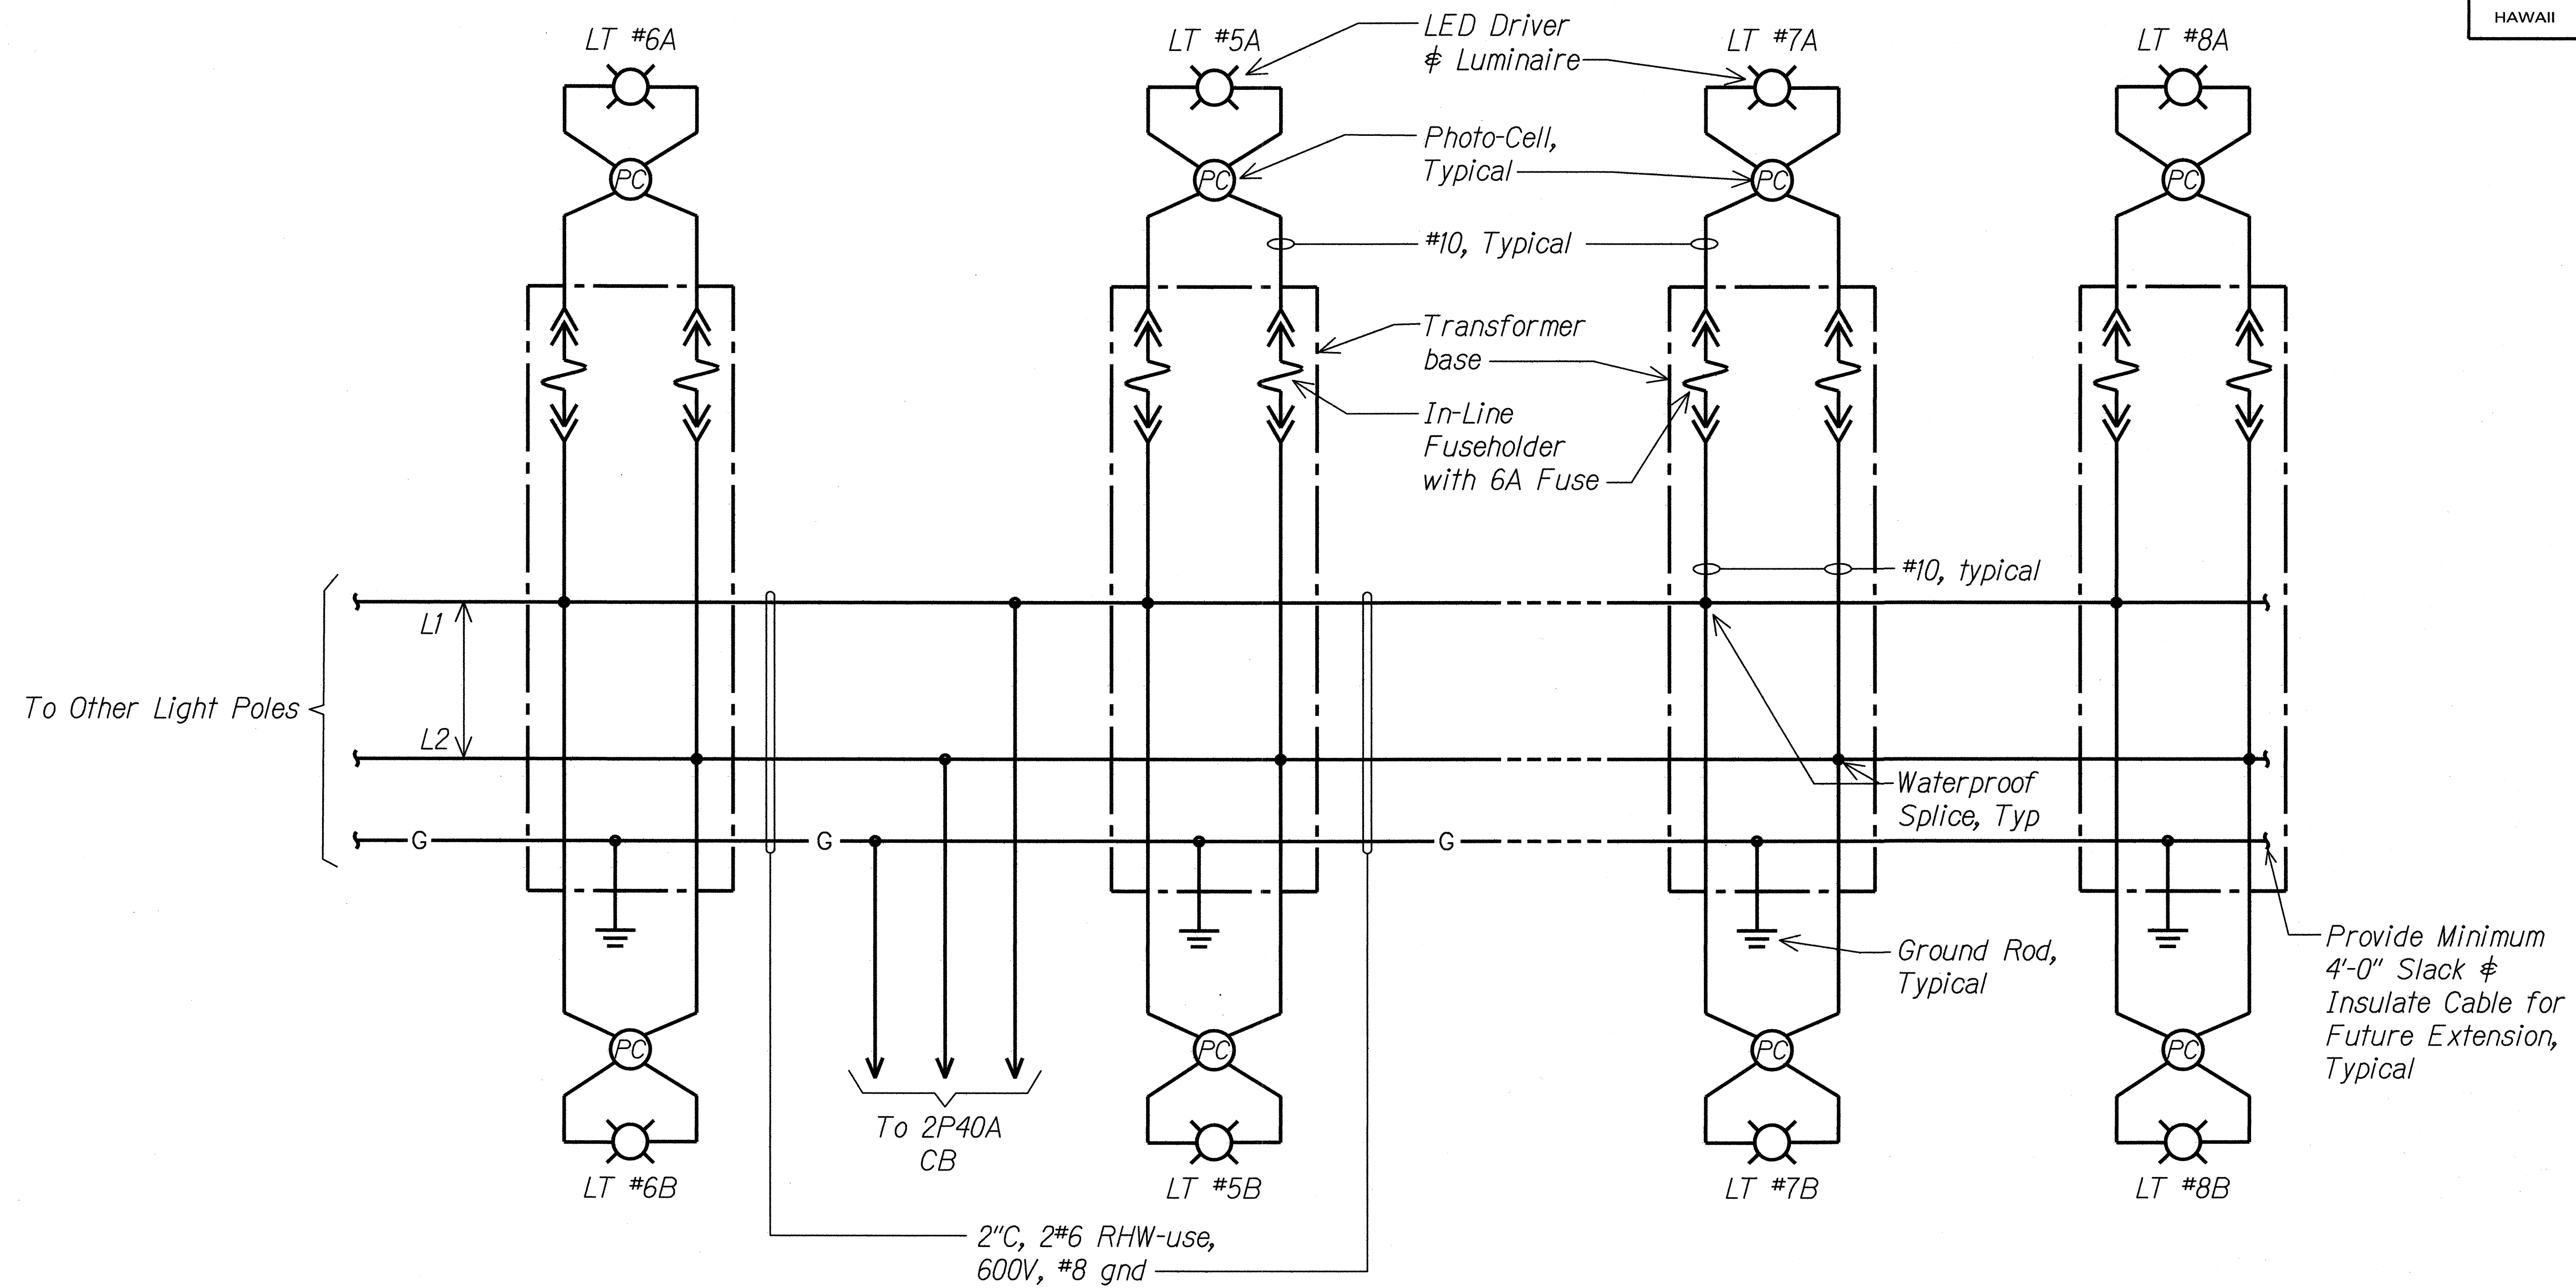

STREET LIGHT FIXTURE CONNECTION DIAGRAM
NTS

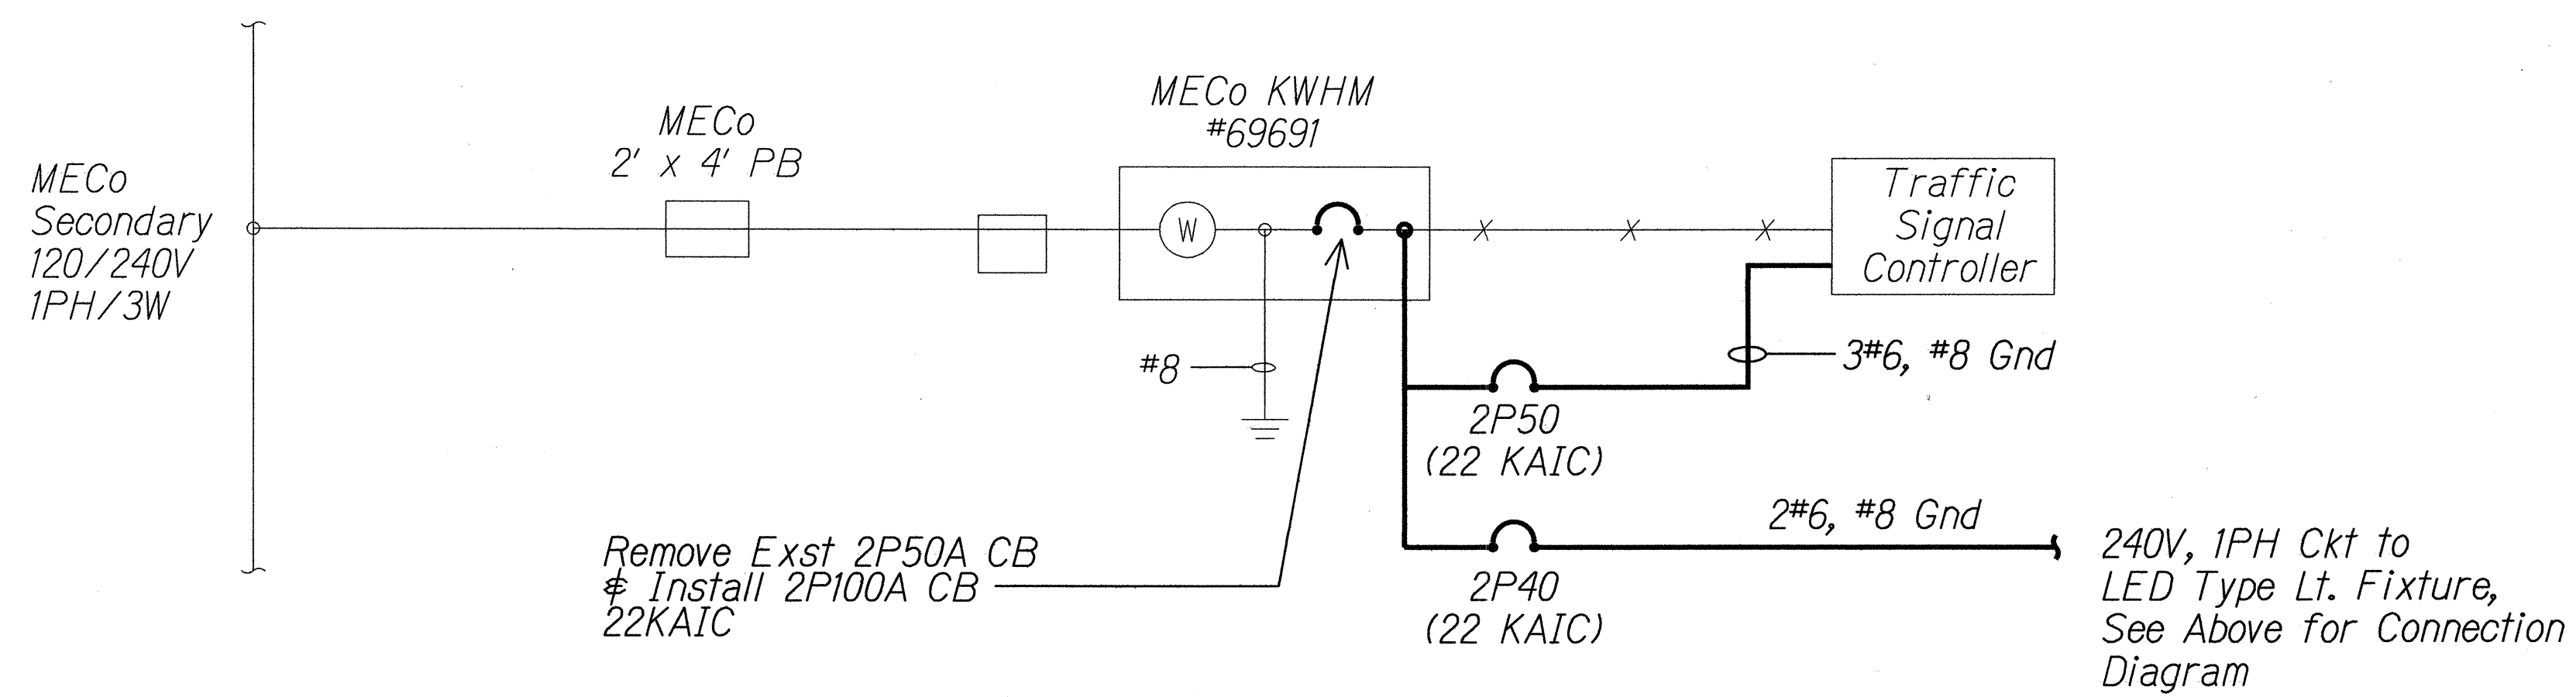

ONE-LINE DIAGRAM
NTS

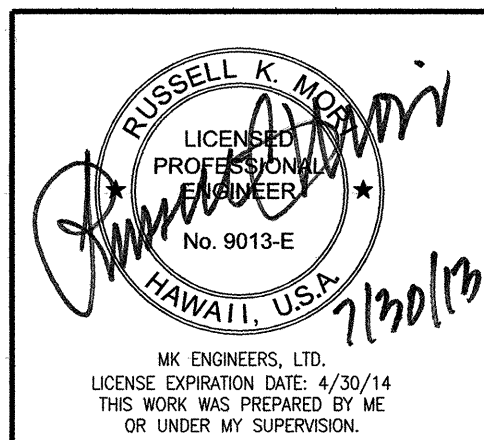

STATE OF HAWAII
DEPARTMENT OF TRANSPORTATION
HIGHWAYS DIVISION
ONE-LINE DIAGRAMS
HONOAPIILANI HIGHWAY, SAFETY
IMPROVEMENTS AT KAAHAPALI
PARKWAY AND HALELO STREET
Federal Aid Project No. HSIP-030-1(42)
Scale: As Noted
Date: July 2013
SHEET No. E-007 OF 7 SHEETS

7/20/13

SURVEY PLOTTED BY	DATE
DRAWN BY	
DESIGNED BY	
QUANTITIES BY	
CHECKED BY	
ORIGINAL PLAN	
NOTE BOOK	
N.	