



FED. ROAD DIST. NO.	STATE	FED. AID PROJ. NO.	FISCAL YEAR	SHEET NO.	TOTAL SHEETS
HAWAII	HAW.	STP-030-1(29)	1998	9	11

ELECTRICAL SYMBOLS

SYMBOL	DESCRIPTION
●	STREET LIGHT STANDARD, SINGLE LUMINAIRE ARM, SEE A/E3
○	EXISTING STREET LIGHT LUMINAIRE & LUMINAIRE ARM, MTD ON WOOD POLE
○ PP16	EXISTING UTILITY POLE, POLE #16 INDICATED
△	EXISTING POLE MOUNTED XFMR
---	EXISTING ANCHOR GUYING
---	STUB UP, CONDUIT
□	EXISTING HANDHOLE/PULLBOX
⊖	EXISTING WEATHERHEAD
⊖	WEATHERHEAD
⊖	EXISTING METER
⊖	COMBINATION METER/BREAKER
⊖	EXISTING TRAFFIC SIGNAL FLASHER
---	EXISTING UNDERGROUND DUCTLINES
---	EXISTING UNDERGROUND DUCTLINES TO BE REMOVED
---	EXISTING OVERHEAD ELECTRICAL/SIGNAL LINES
---	EXISTING OVERHEAD SECONDARY CABLE
---	UNDERGROUND DUCTLINE AND WIRING: TYPE "A" DUCT SECTION AND "I" TYPE "2E" DUCT INDICATED, SEE SHT E3 FOR DUCT SECTION.
X	"X"ED OUT INDICATES TO REMOVE

NOTES:



- 1 THE CONTRACTOR SHALL COORDINATE HIS WORK WITH MECO FOR REMOVAL AND INSTALLATION OF MECO EQUIPMENT.
- 2 REMOVAL BY MECO, CONTRACTOR TO COORDINATE.
- 3 EXISTING TRAFFIC SIGNAL EQUIPMENT DEMOLITION AND REMOVAL WORK SHALL BE INCIDENTAL TO OTHER ITEMS OF WORK.

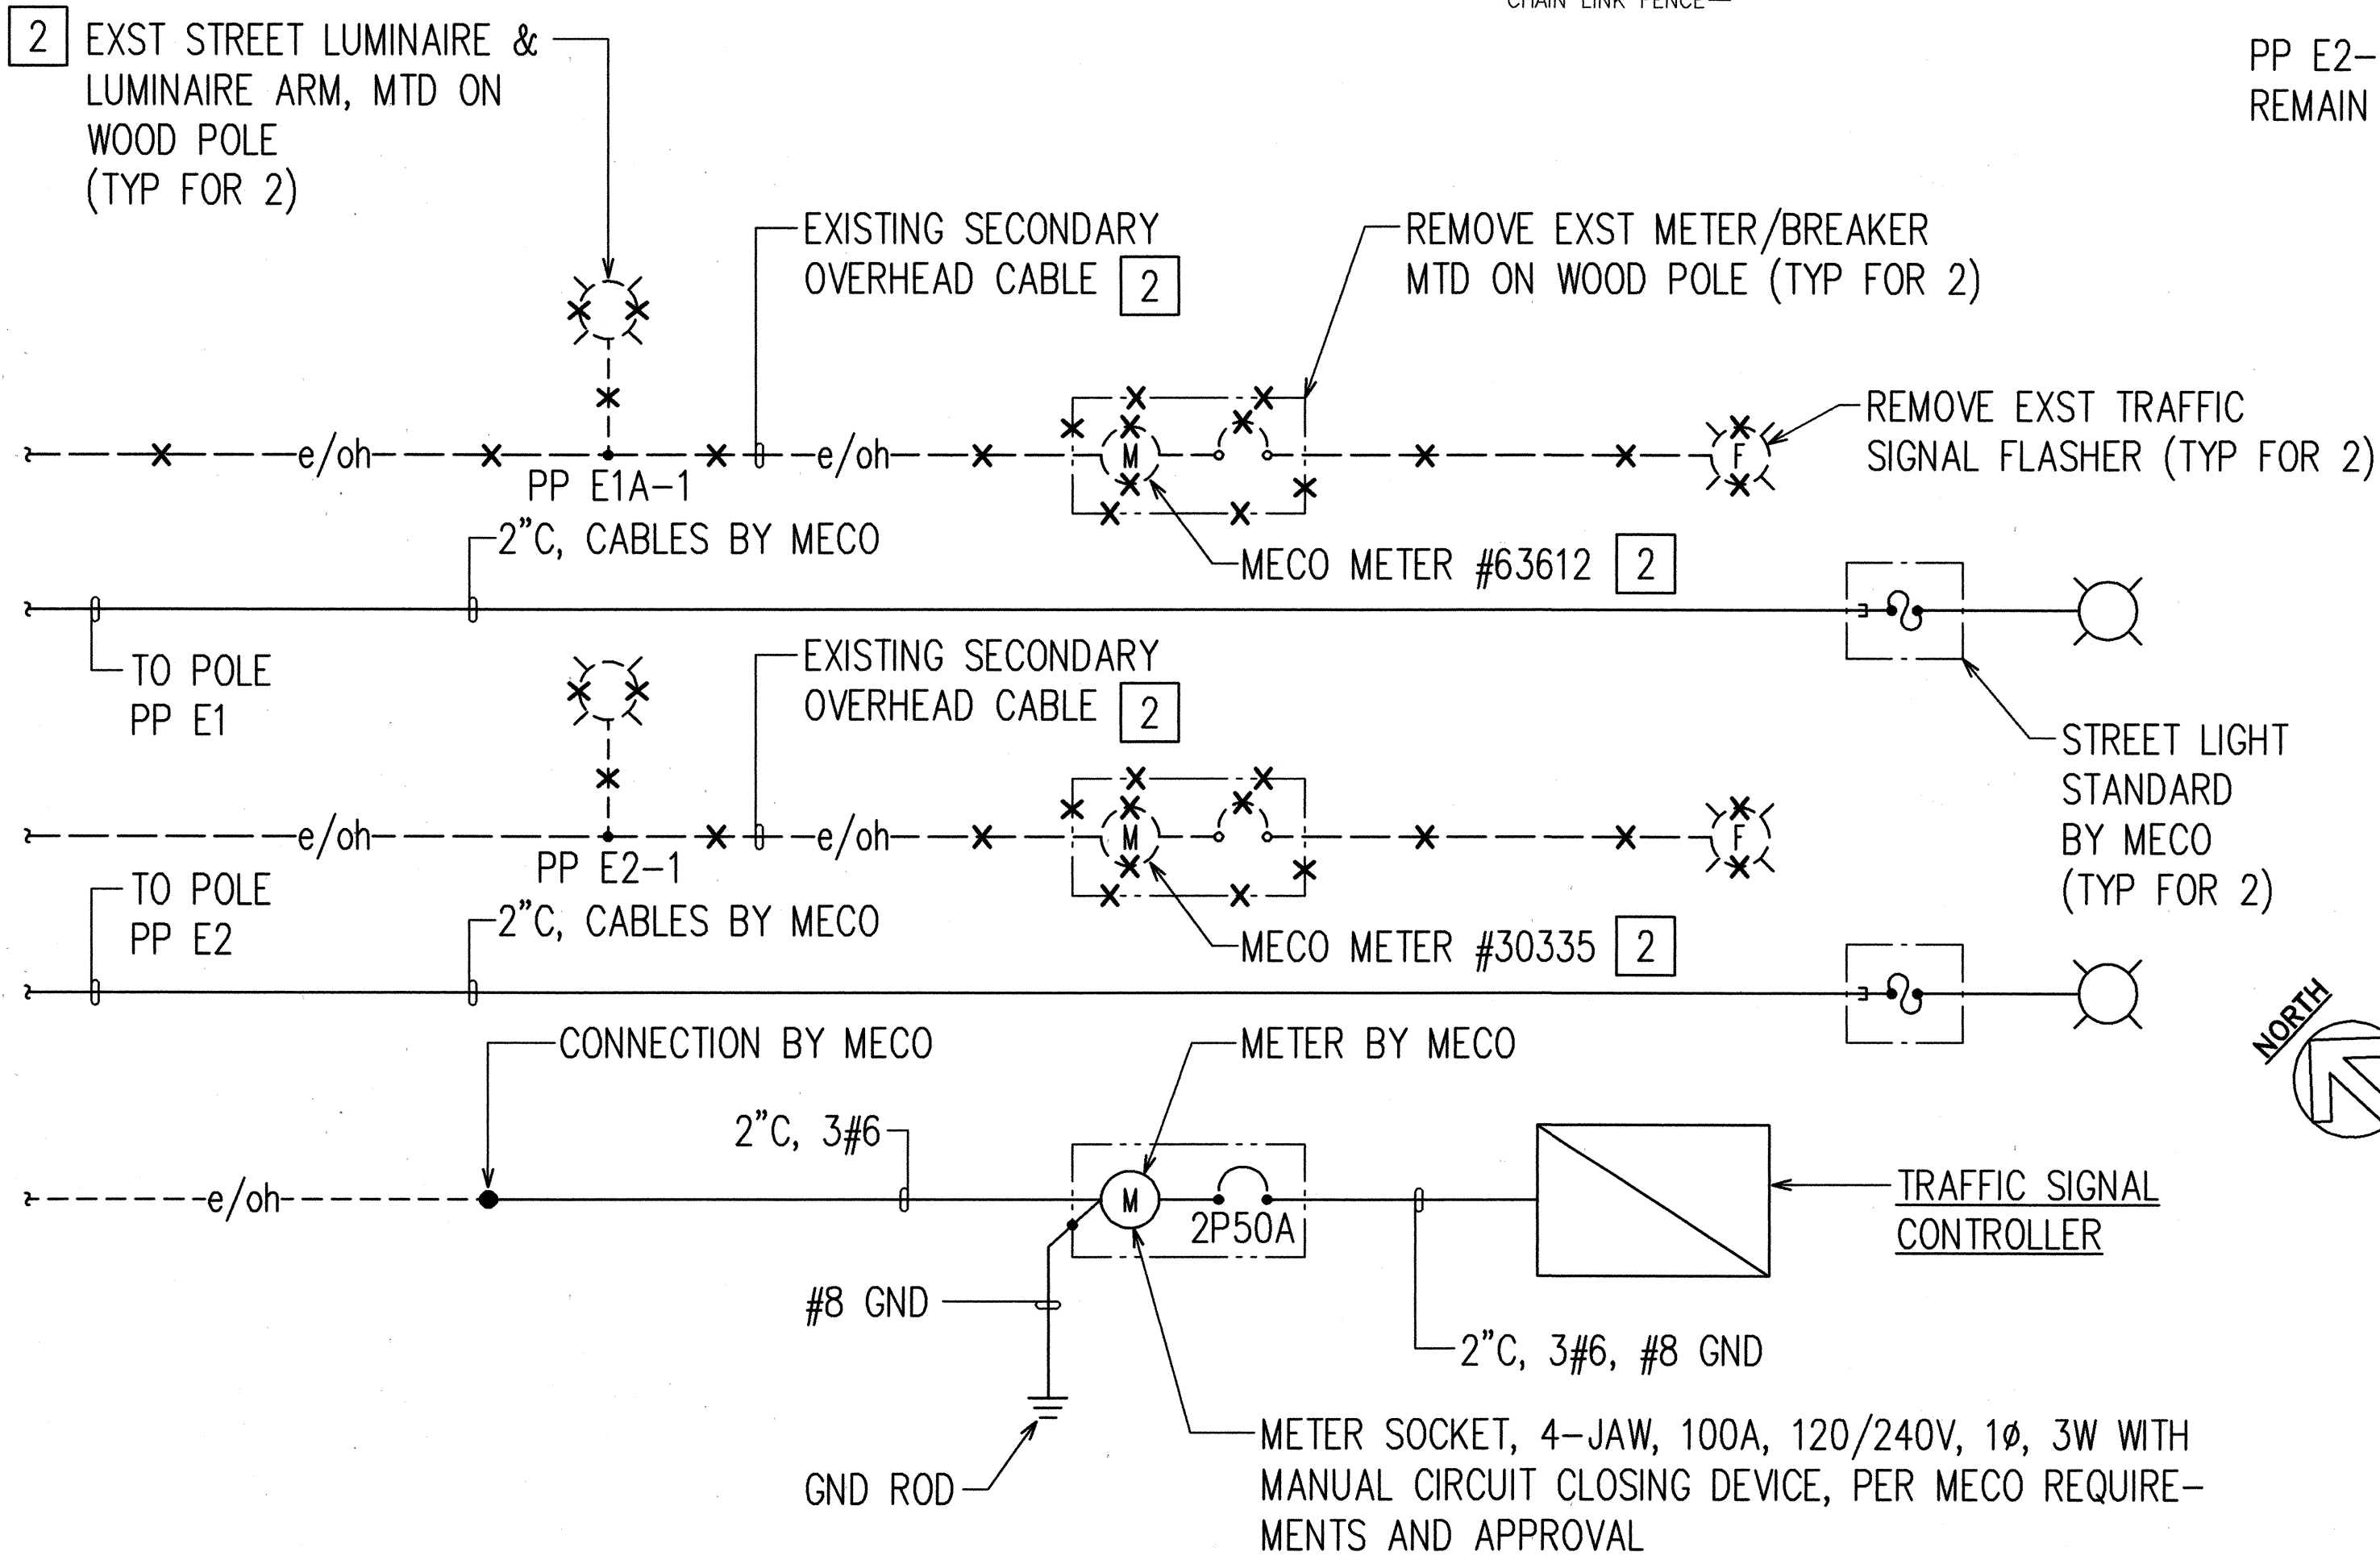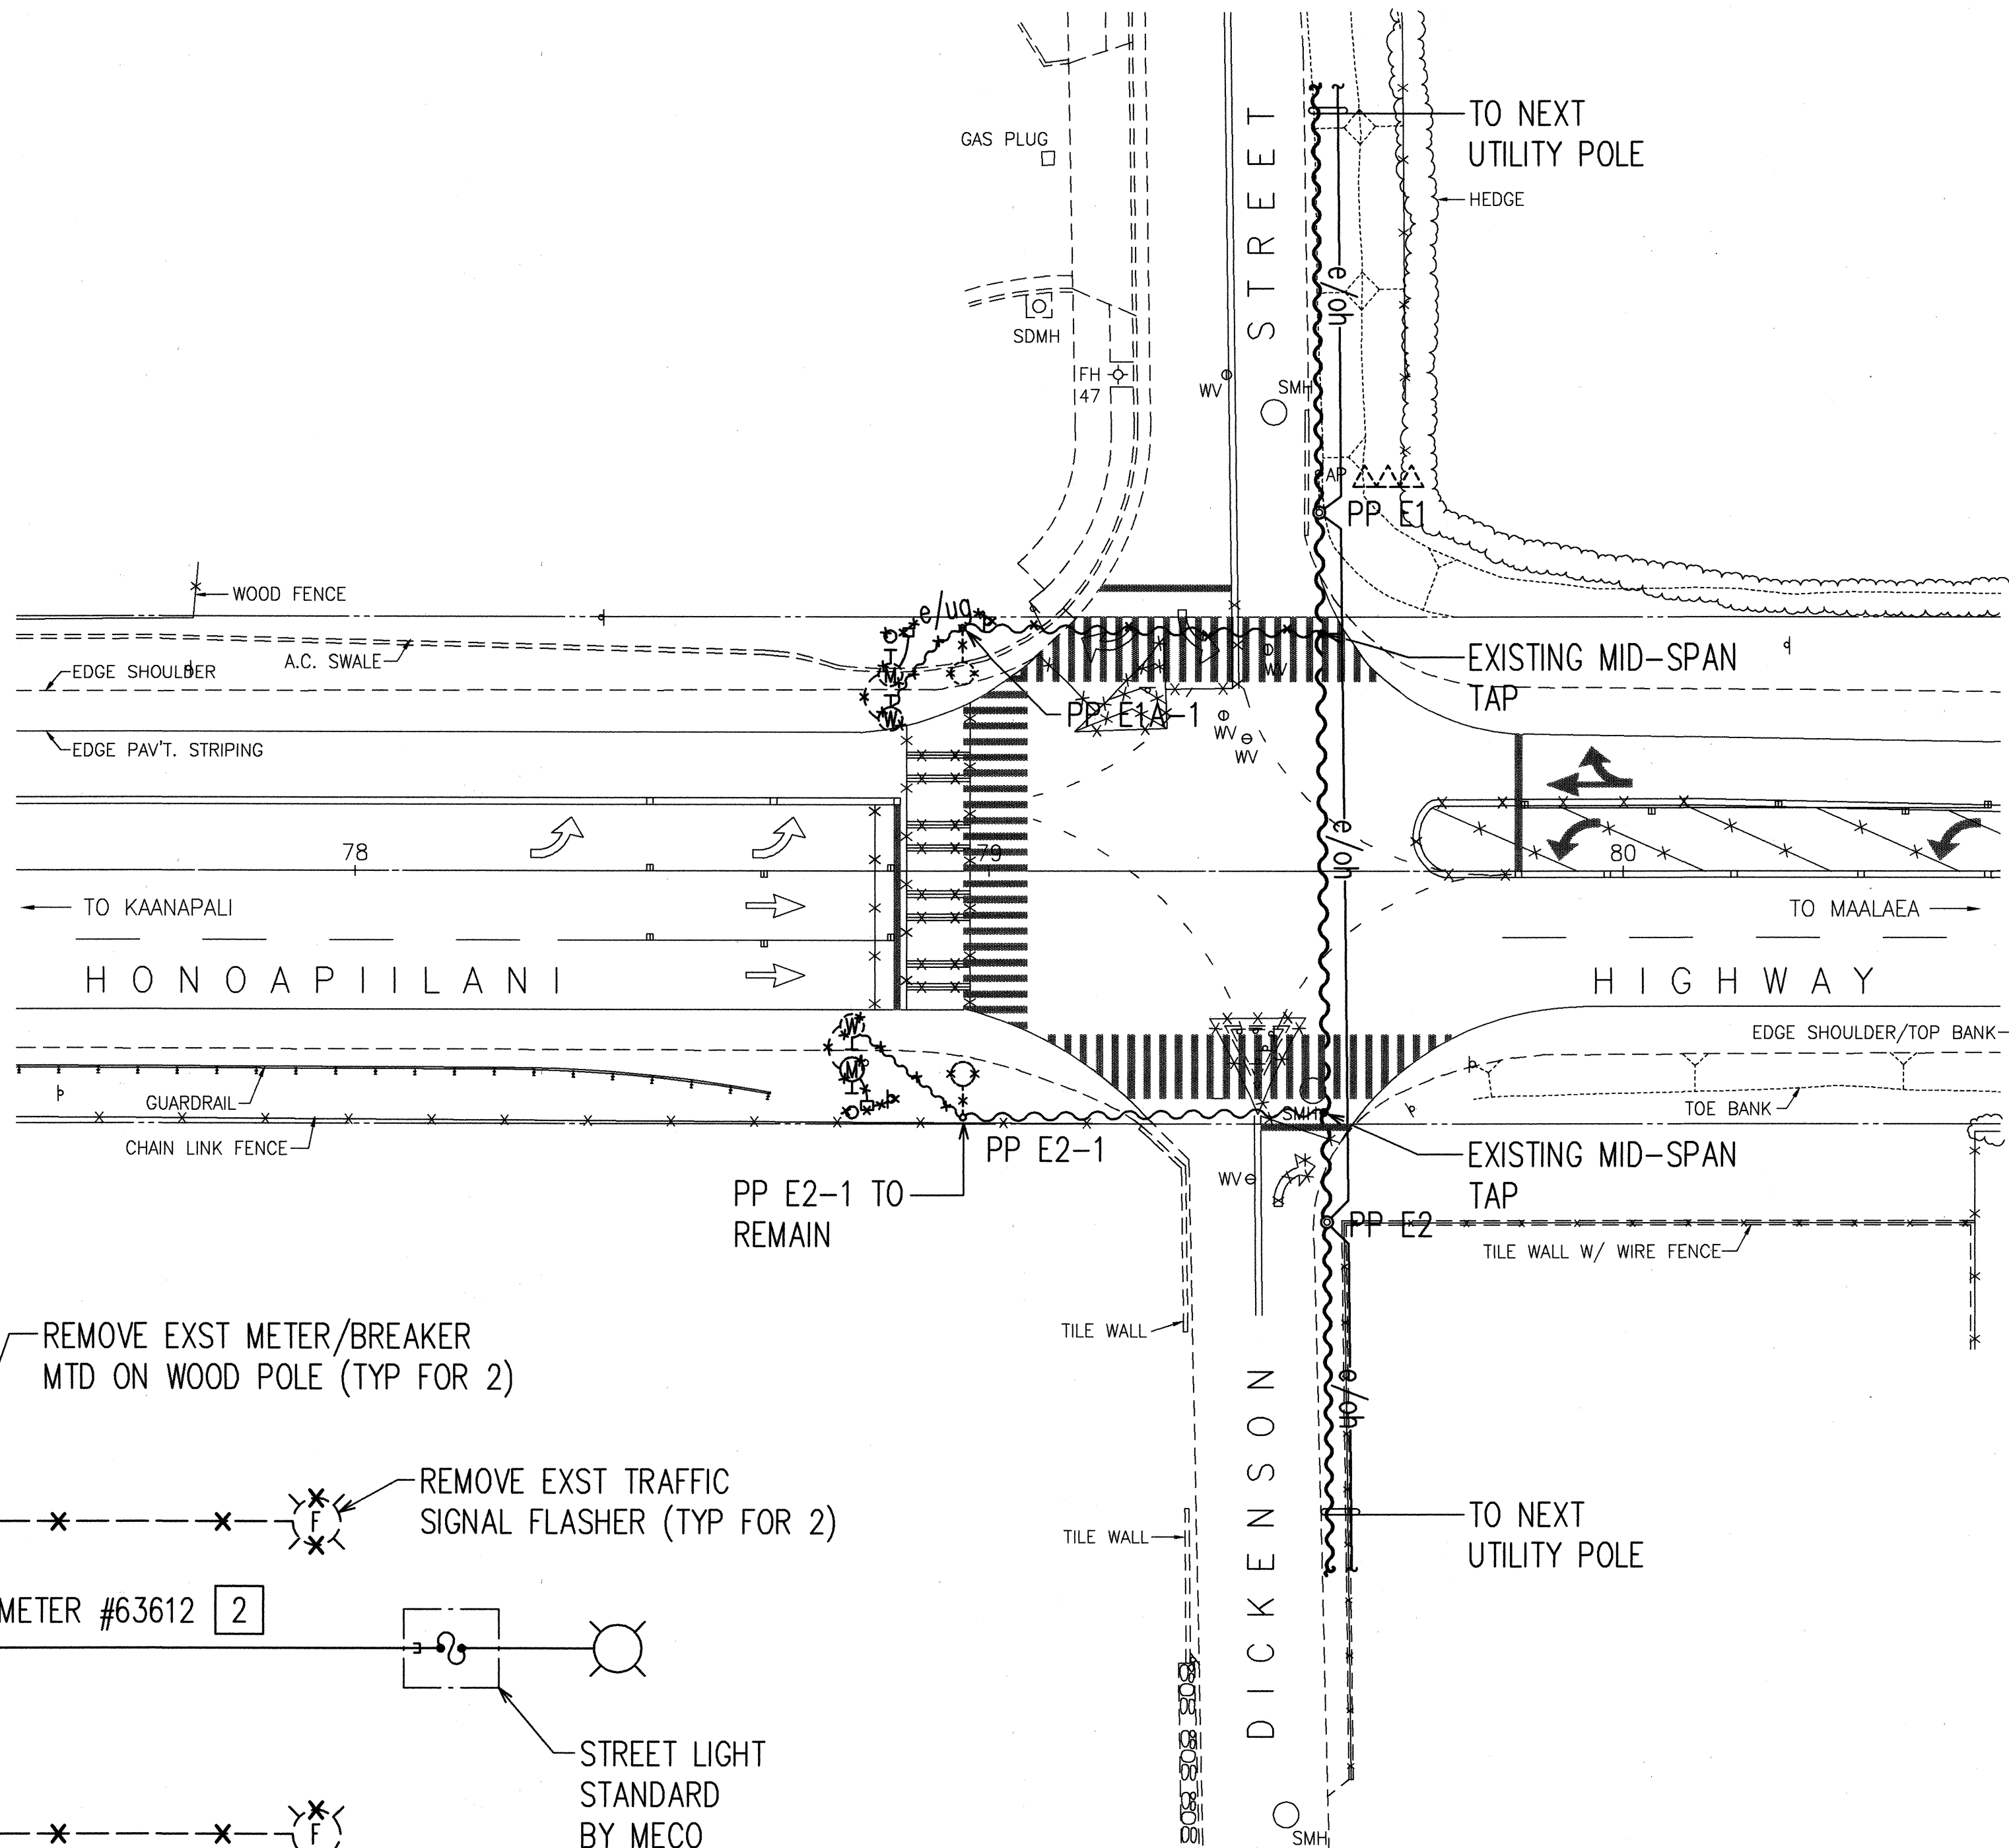

ONE-LINE DIAGRAM

ELECTRICAL DEMOLITION PLAN 1 3

SCALE: 1"=20'

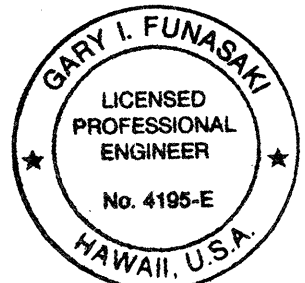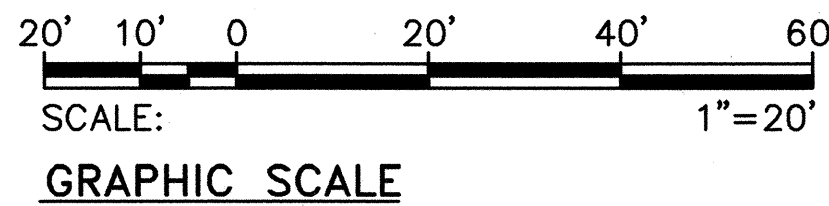

THIS WORK WAS PREPARED BY ME
OR UNDER MY SUPERVISION
19 FEB 1998
Signature

STATE OF HAWAII
DEPARTMENT OF TRANSPORTATION
HIGHWAYS DIVISION

ELECTRICAL DEMOLITION PLAN
ONE-LINE DIAGRAM
HONOAPIILANI HIGHWAY
INTERSECTION IMPROVEMENTS
AT DICKENSON STREET
FAP NO. STP-030-1(29)

SCALE: AS NOTED DATE: SEP 3 1997
SHEET No. E1 OF E3 SHEETS