



FED. ROAD DIST. NO.	STATE	FED. AID PROJ. NO.	FISCAL YEAR	SHEET NO.	TOTAL SHEETS
HAWAII	HAW.	STP-030-1(29)	1998	10	11



- NOTES:
- 1 RISER UP POLE PER MECO STANDARDS.
 - 2 FURNISHED WITH 8'-0" LUMINAIRE ARM.
 - 3 FURNISHED WITH 12'-0" LUMINAIRE ARM.

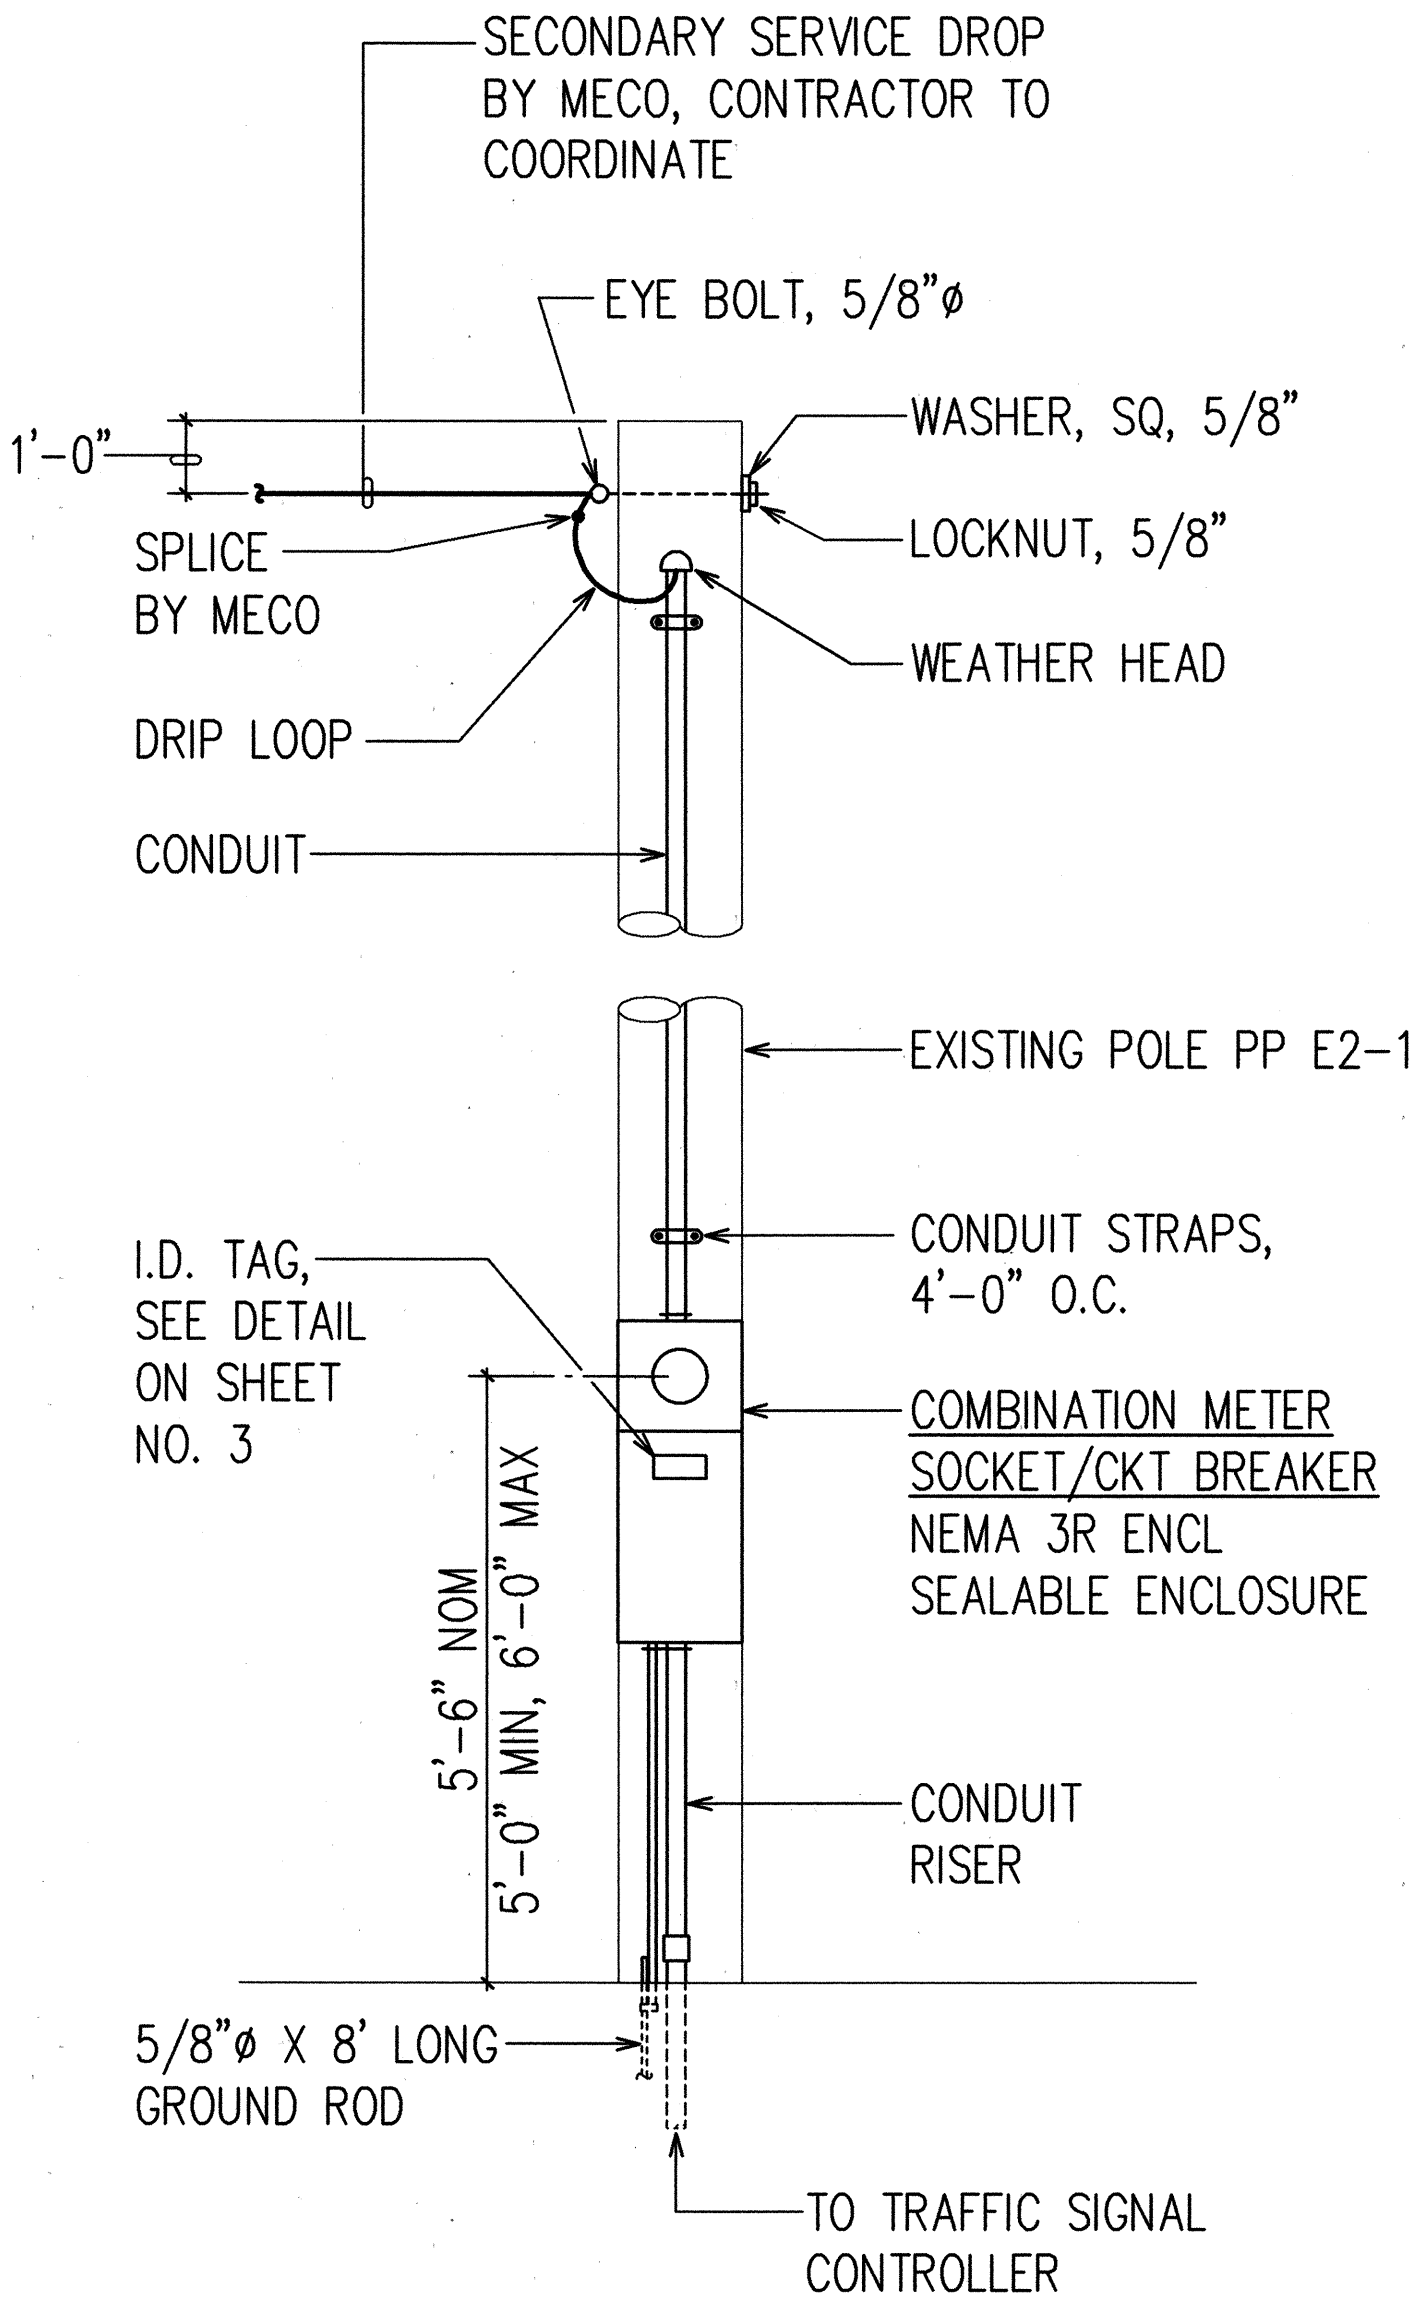

A METER EQUIPMENT ELEVATION
E2 NOT TO SCALE

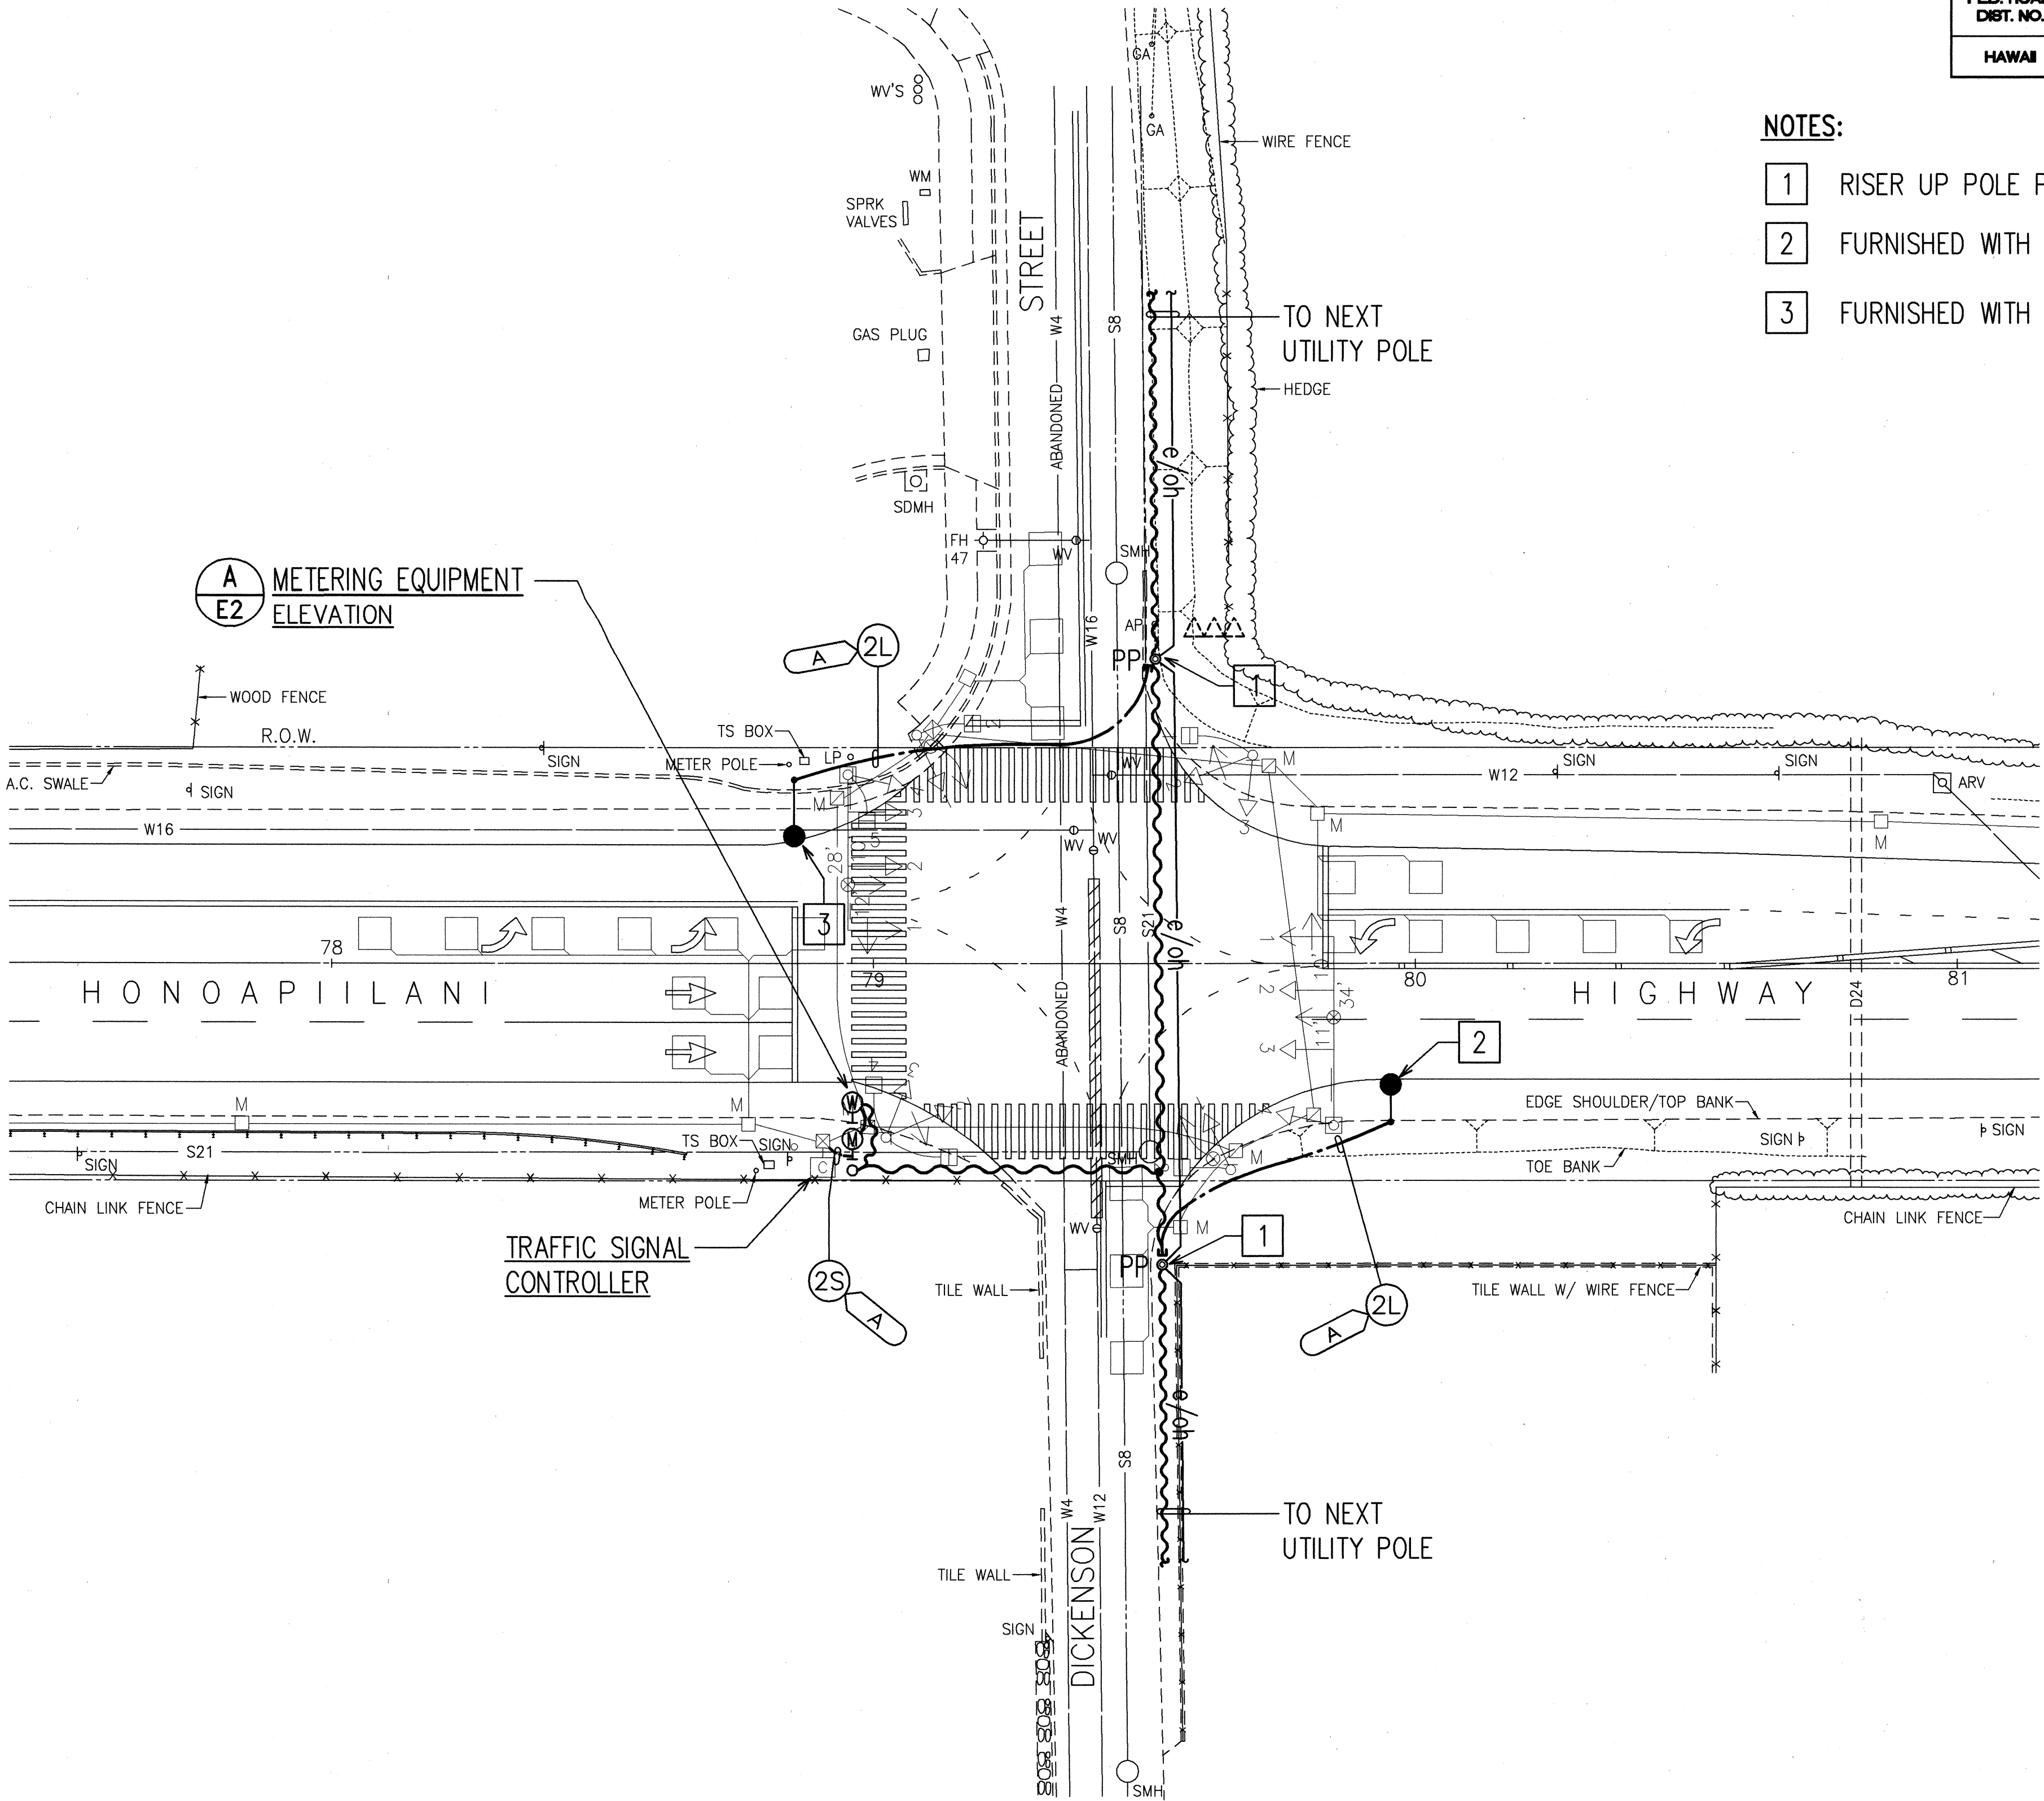

ELECTRICAL SITE PLAN
SCALE: 1"=20'

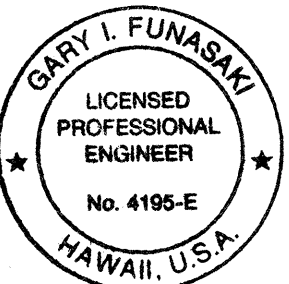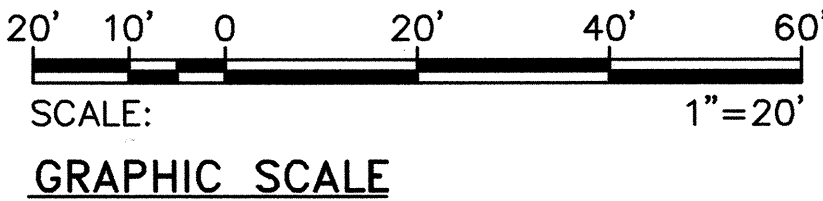

THIS WORK WAS PREPARED BY ME
OR UNDER MY SUPERVISION
Gary I. Funakura
19 Feb 1998
Signature

STATE OF HAWAII
DEPARTMENT OF TRANSPORTATION
HIGHWAYS DIVISION
ELECTRICAL SITE PLAN

**HONOAPIILANI HIGHWAY
INTERSECTION IMPROVEMENTS
AT DICKENSON STREET
FAP NO. STP-030-1(29)**

SCALE: AS NOTED DATE: SEP 3 1997
SHEET No. E2 OF E3 SHEETS