




AUSTIN, TSUTSUMI DESIGNED BY KARL KUNISHIGE 587-2173 1-29-98
P. S. & E. BY PHONE DATE

INDEX TO DRAWINGS	
SHEET NO.	DESCRIPTION
1	TITLE SHEET
2	STANDARD PLANS SUMMARY
3	TRAFFIC SIGNAL LEGEND, NOTES AND DETAILS
4	SIGNING AND STRIPING PLAN
5	TRAFFIC SIGNAL PLAN
6	MISCELLANEOUS DETAILS
7	MISCELLANEOUS DETAILS
8	STREET NAME SIGN DETAILS
9	ELECTRICAL DEMOLITION PLAN & ONE-LINE DIAGRAM
10	ELECTRICAL SITE PLAN
11	CONCRETE BASE AND STREET LIGHT DETAILS

STATE OF HAWAII
DEPARTMENT OF TRANSPORTATION
HIGHWAYS DIVISION
HONOLULU, HAWAII
"AS-BUILT"
PLANS FOR
HONOAPIILANI HIGHWAY
INTERSECTION IMPROVEMENTS
AT DICKENSON STREET
FEDERAL AID PROJECT NO. STP-030-1(29)
DISTRICT OF LAHAINA
ISLAND OF MAUI

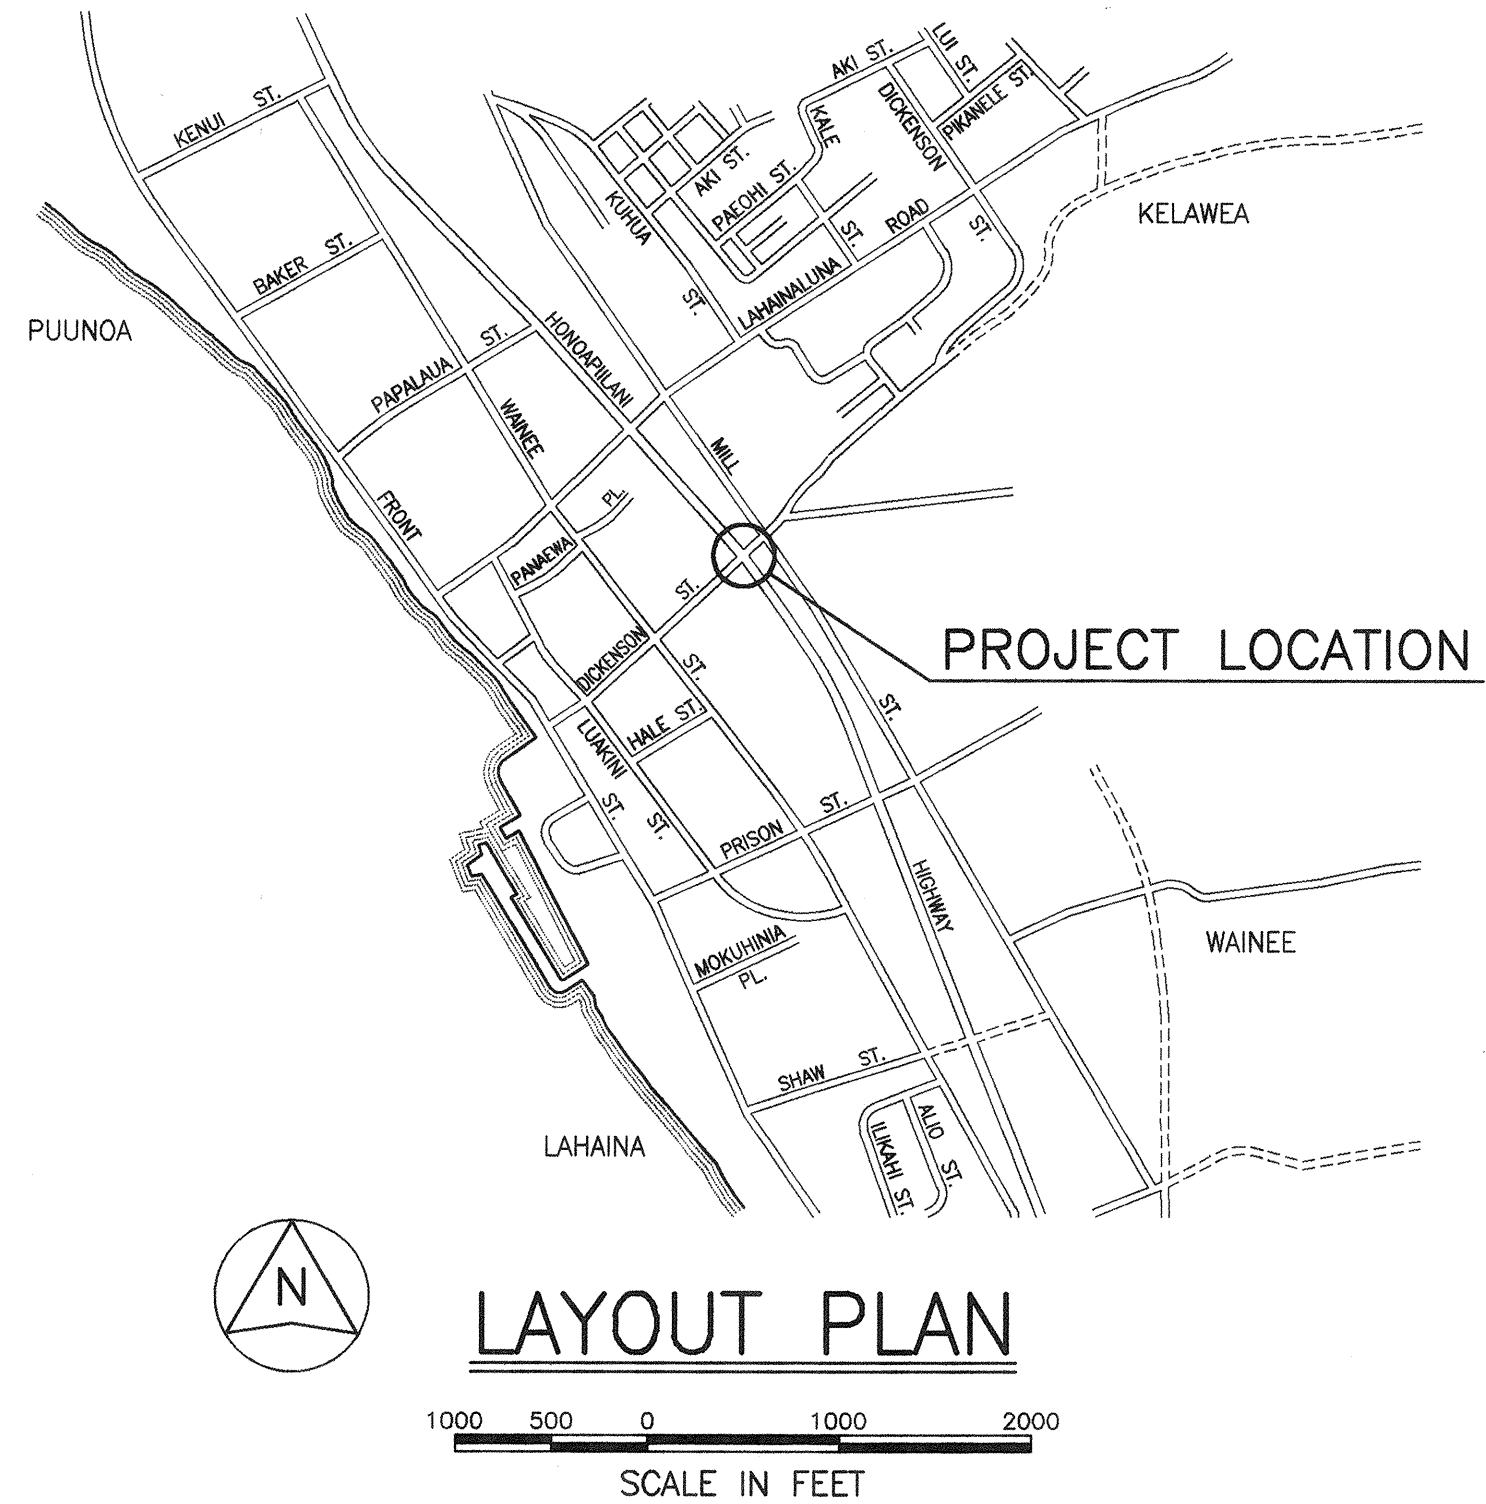

FED. ROAD DIST. NO.	STATE	FED. AID PROJ. NO.	FISCAL YEAR	SHEET NO.	TOTAL SHEETS
HAWAII	HAW.	STP-030-1(29)	1998	1	11

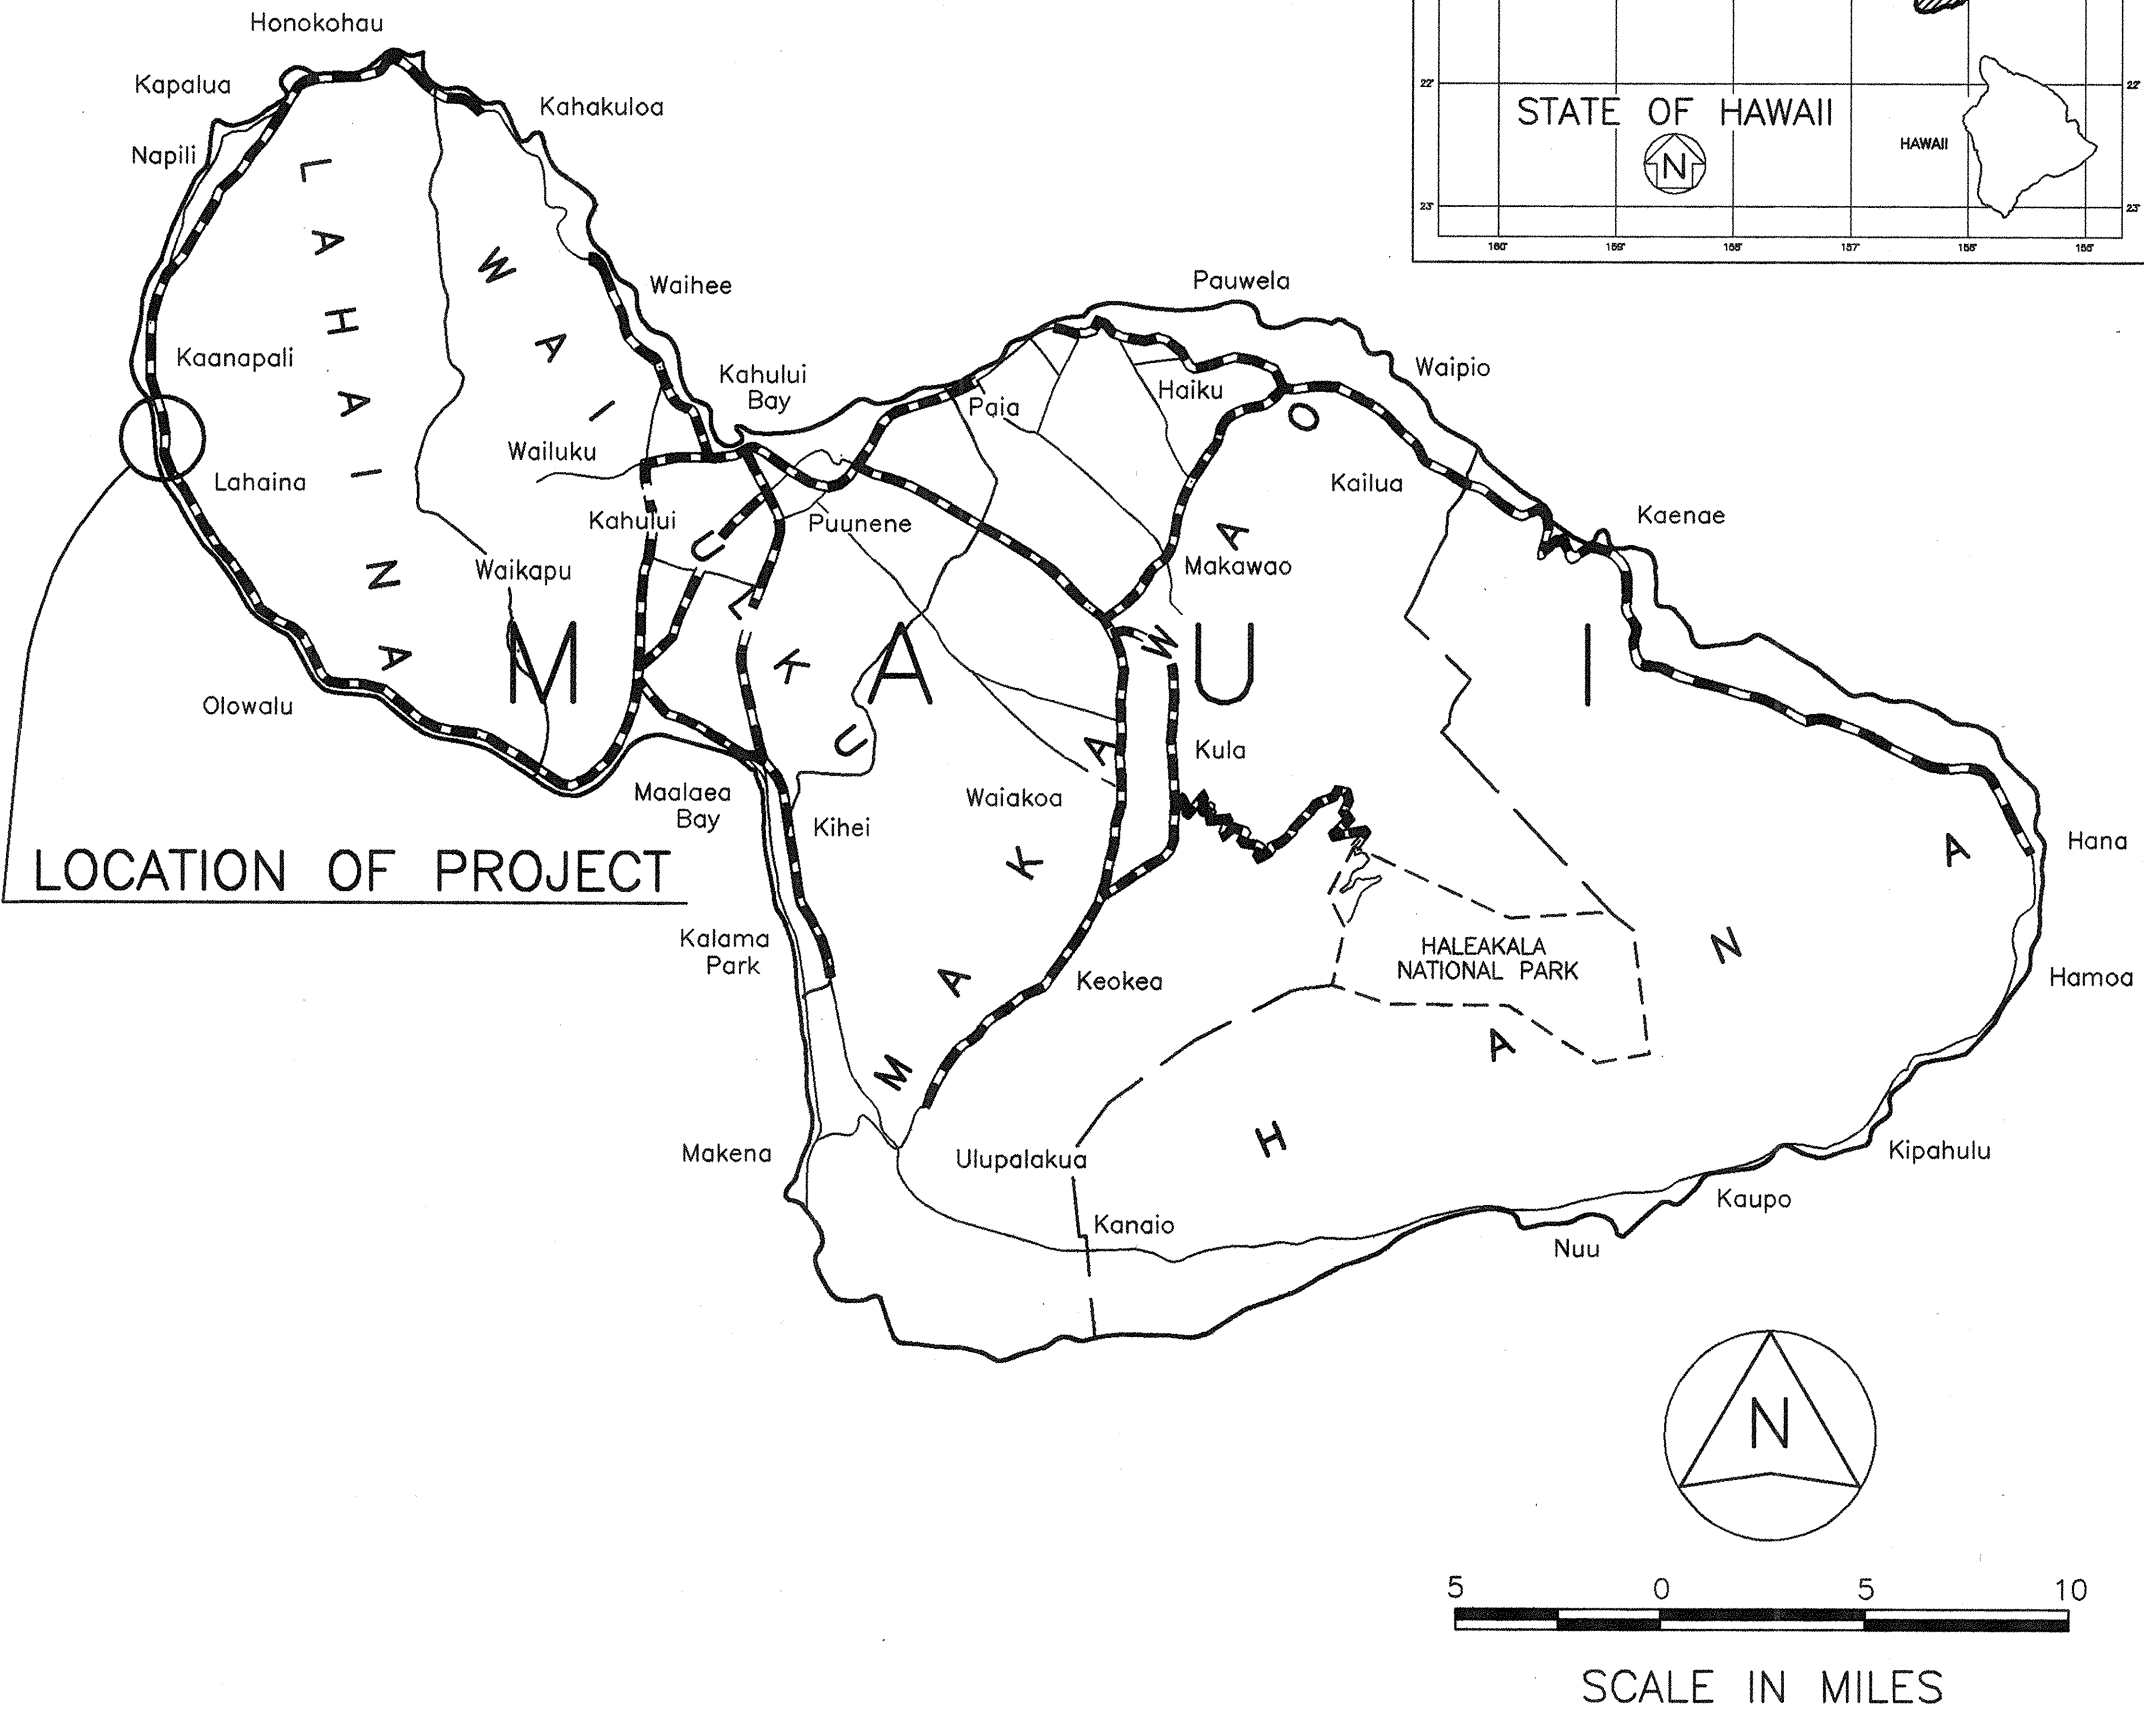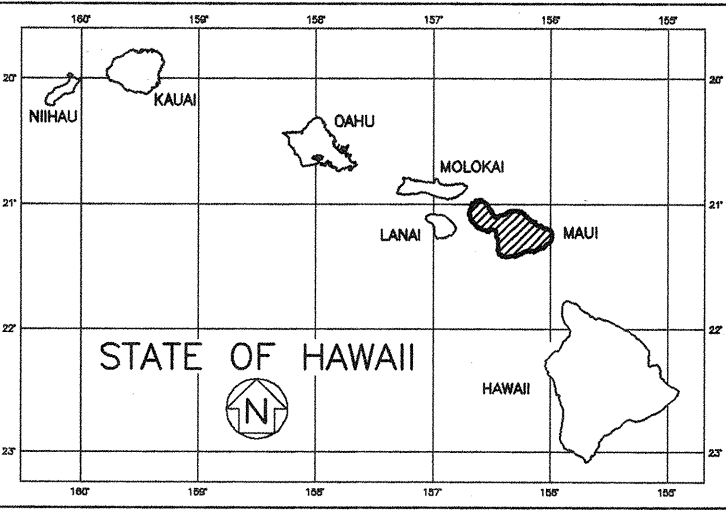

FEDERAL AID PROJECTS PREVIOUSLY CONSTRUCTED OR UNDER CONSTRUCTION
MILE POST 1.45 TO MILE POST 1.33

CHANGES MADE DURING CONSTRUCTION HAVE BEEN INCORPORATED ON THESE PLANS EXCEPT CHANGES IN THE ORIGINAL THEORETICAL QUANTITIES. FOR ACTUAL QUANTITIES, REFER TO PROJECT LEDGER AND/OR COMPUTATION BOOK.
RESIDENT ENGINEER 11/23/98 DATE

DEPARTMENT OF TRANSPORTATION
STATE OF HAWAII
APPROVED: 2/23/98
DIR. OF TRANSPORTATION DATE