

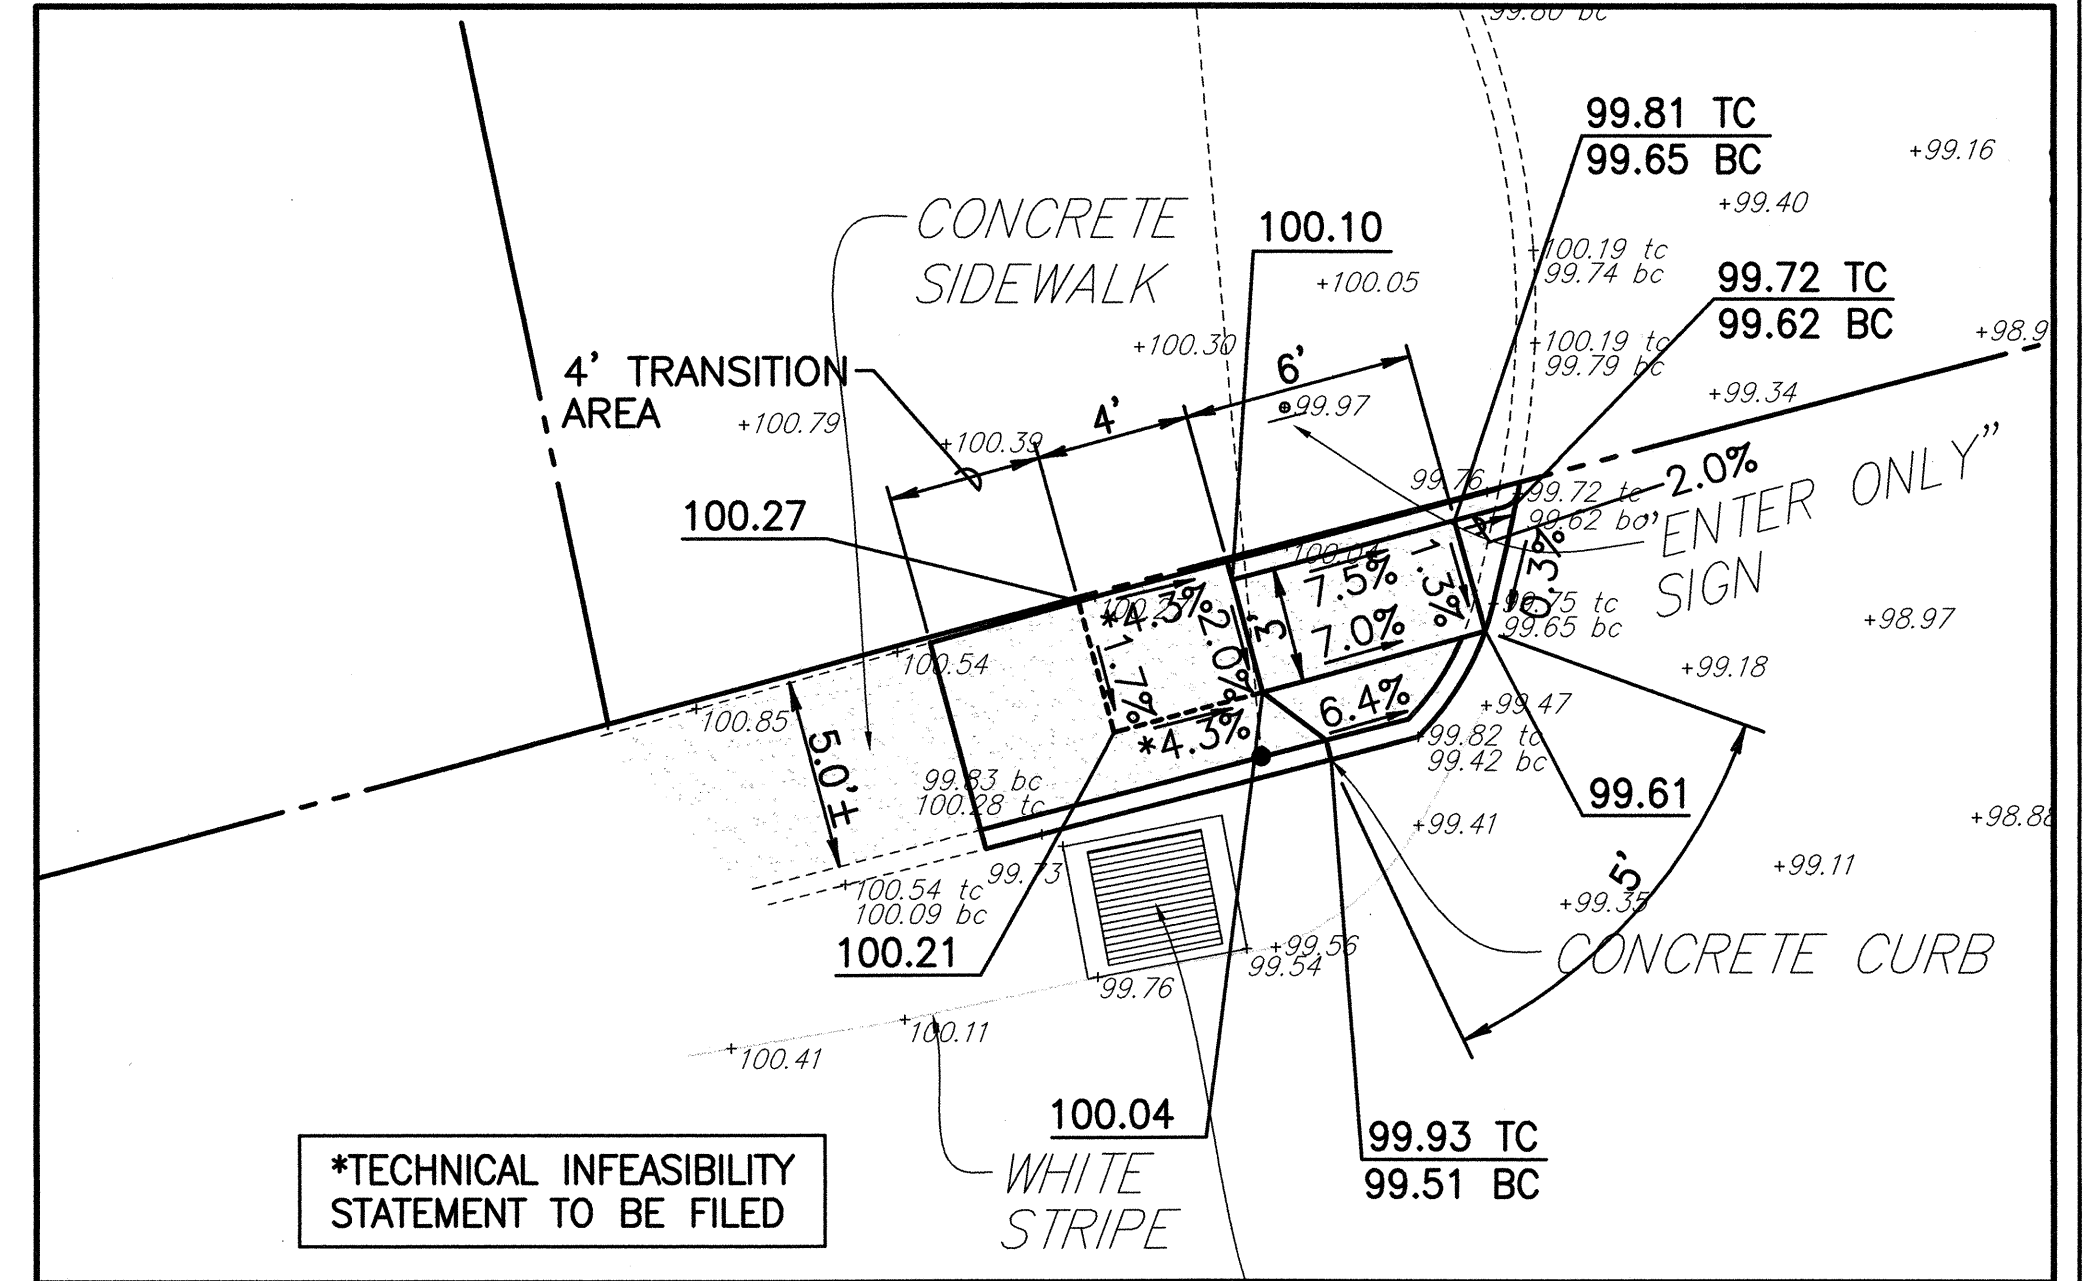


--	--	--	--	--

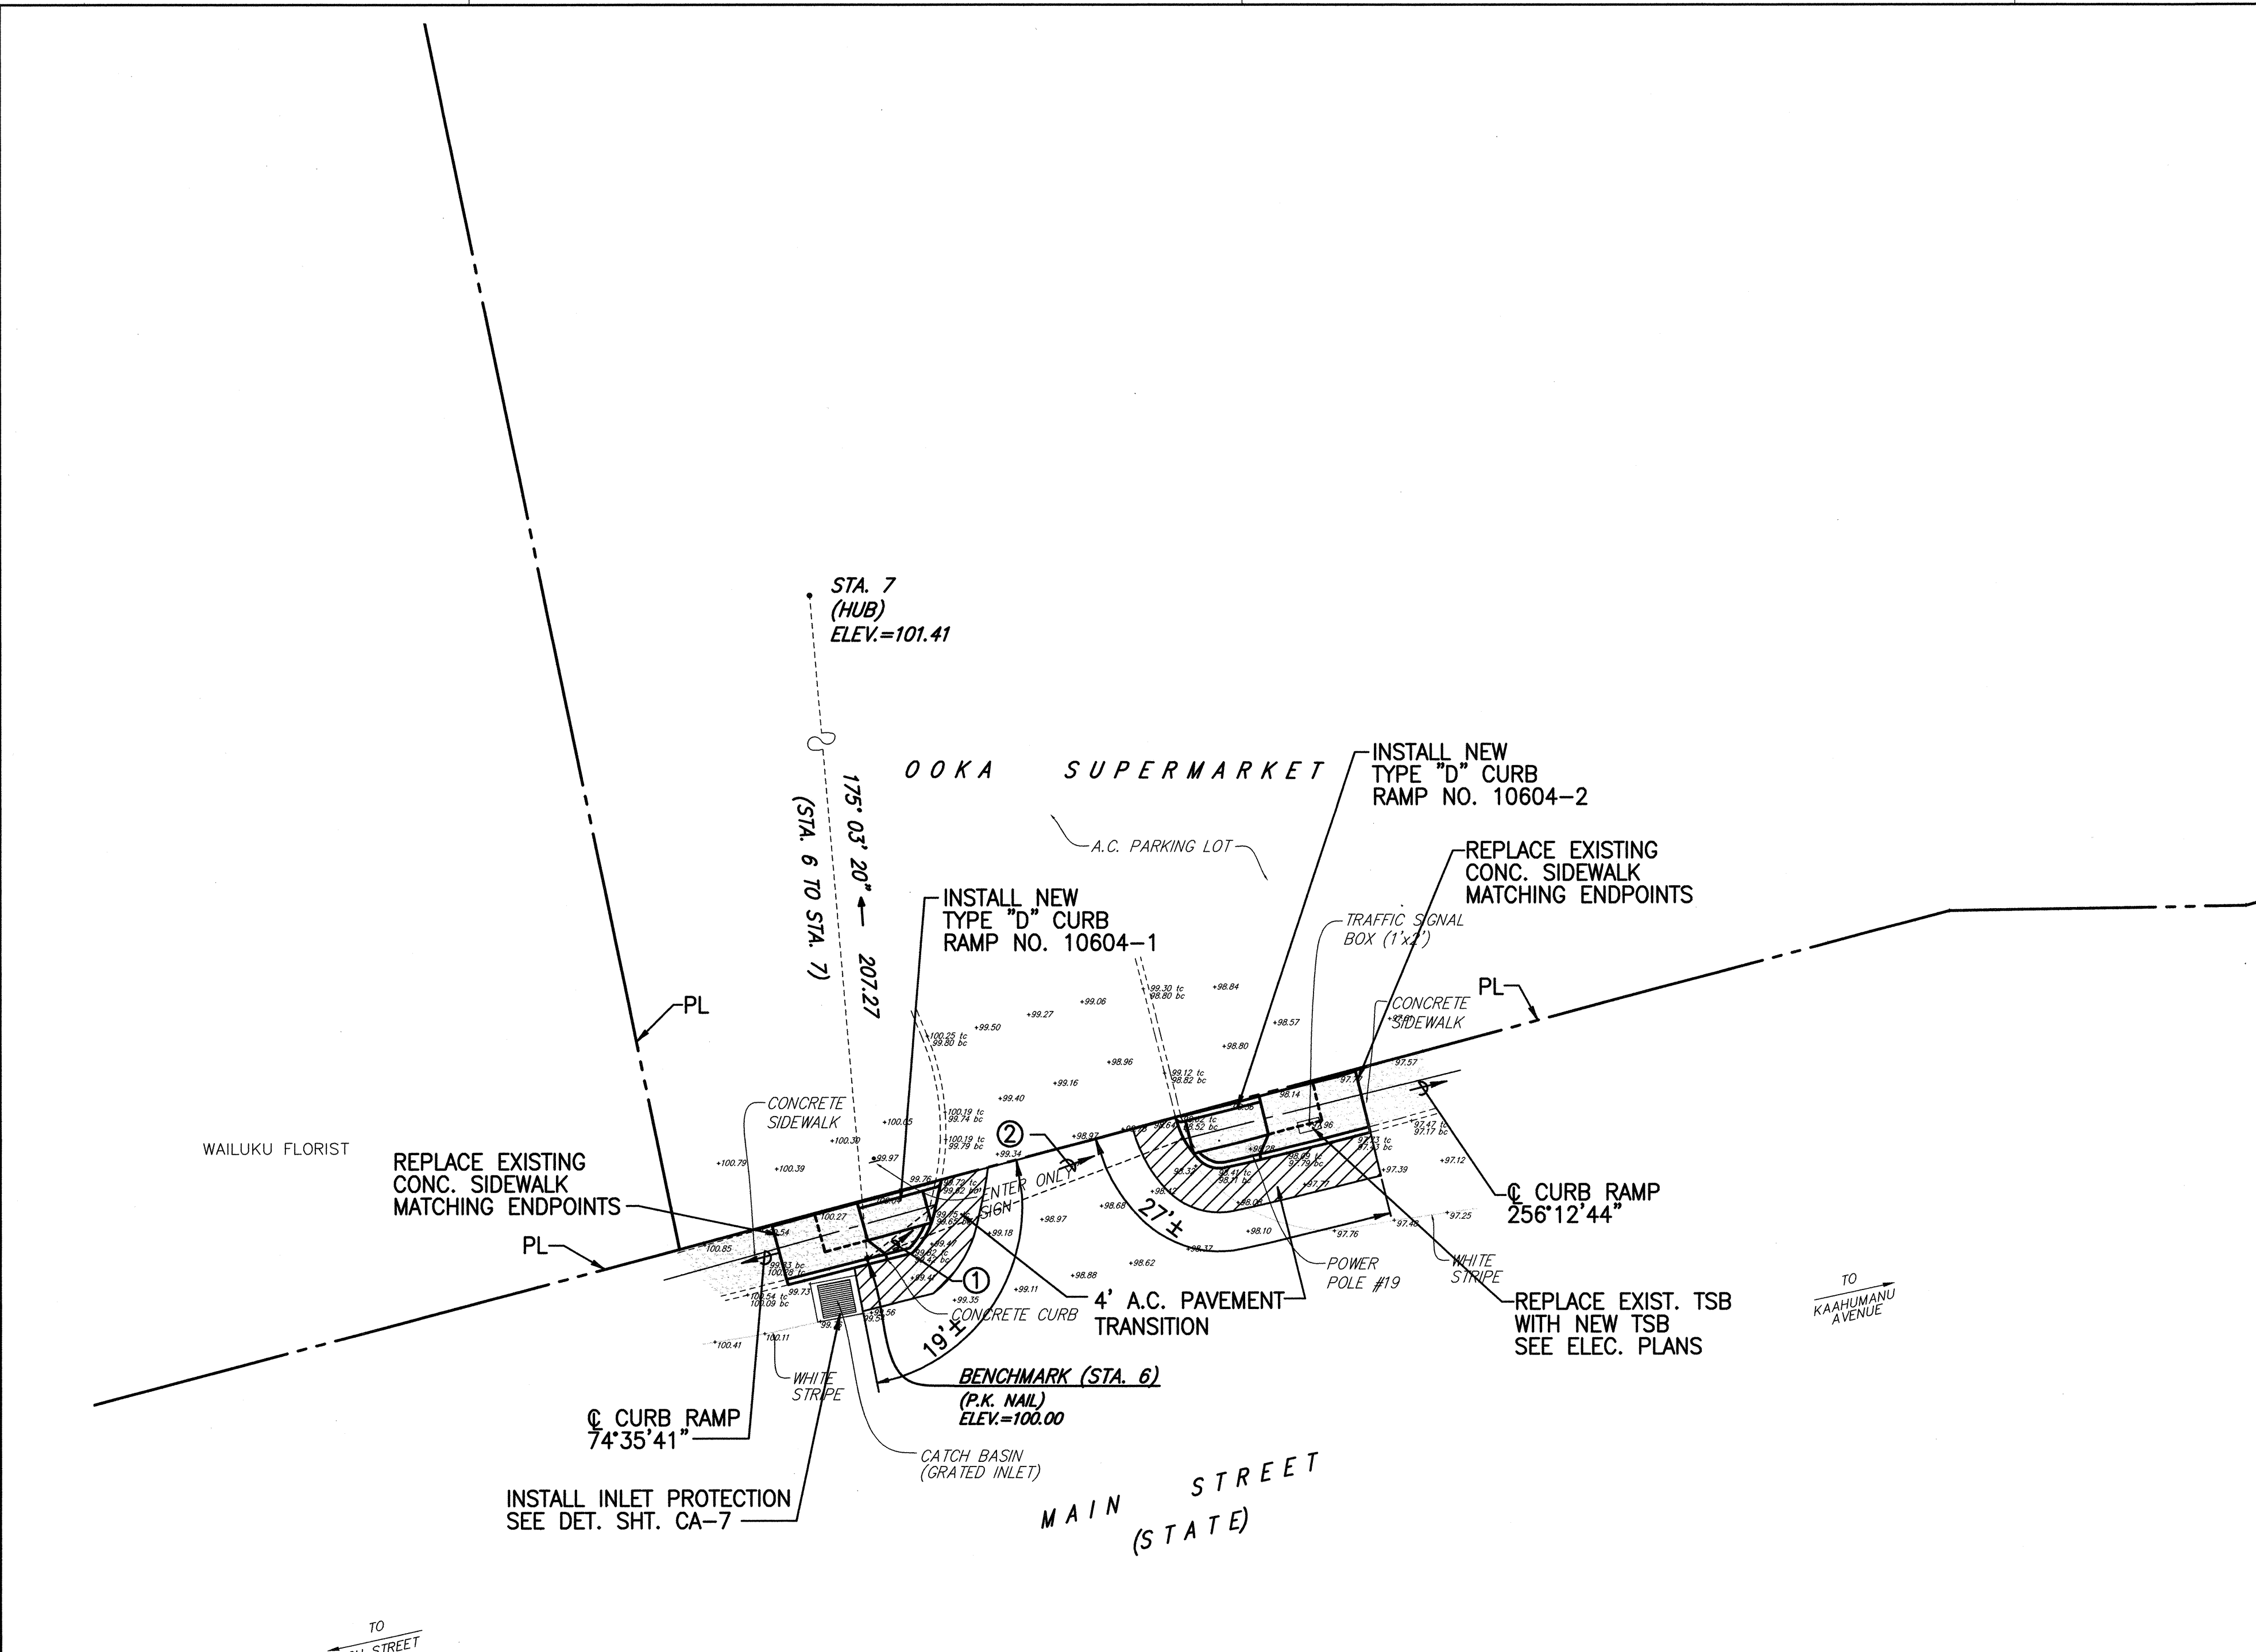

CURB RAMP NO. 10604-1 DETAILS

SCALE: 1"= 5'

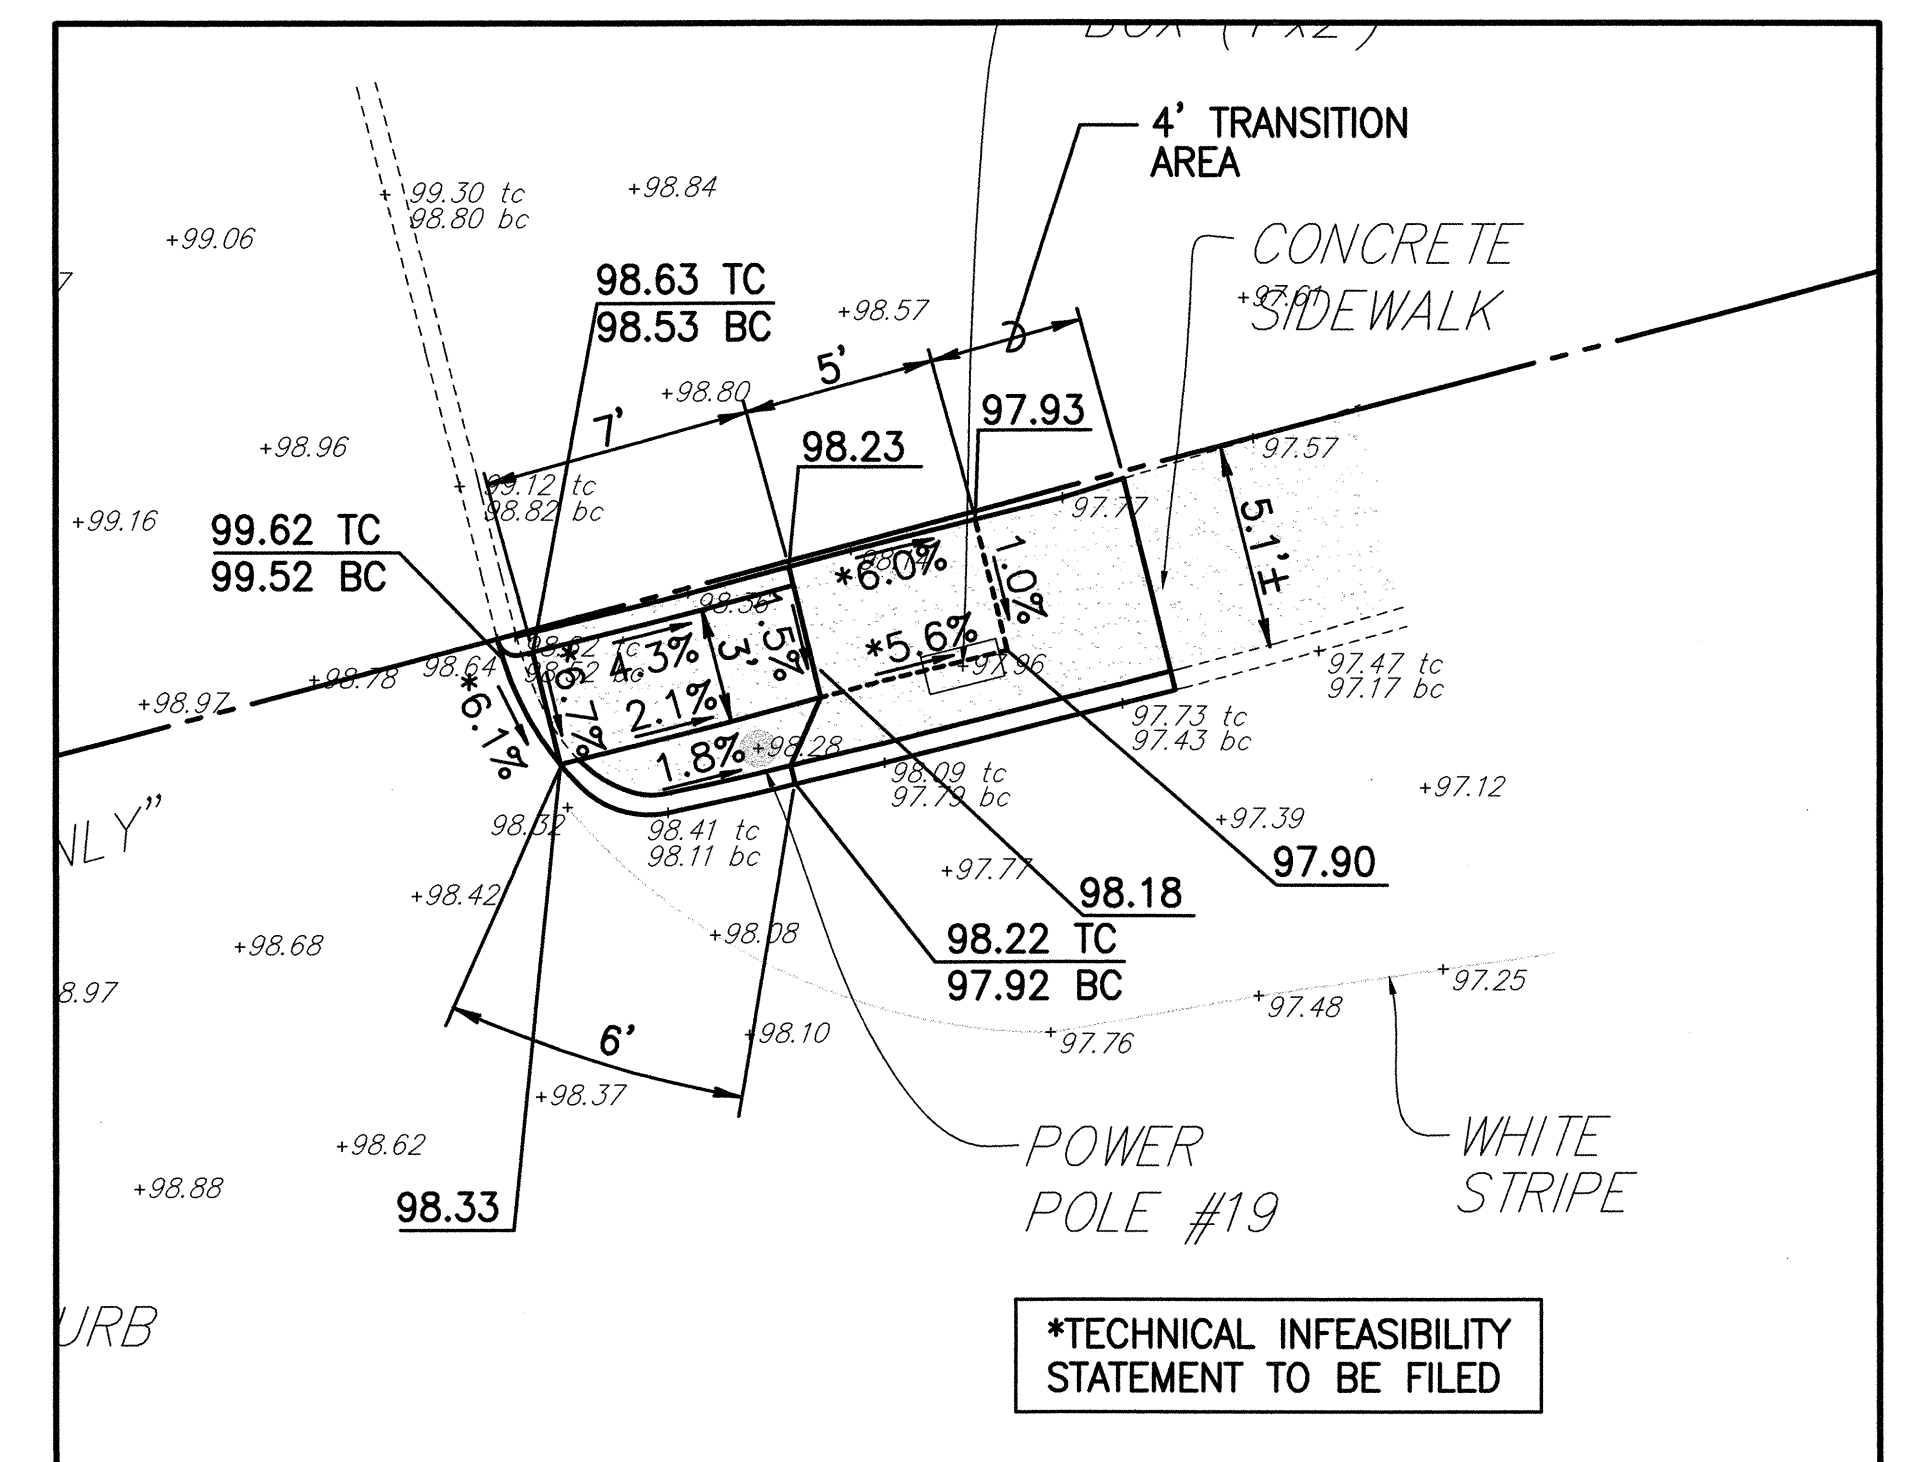

CURB RAMP NO. 10604-2 DETAILS

SCALE: 1"= 5'


- ① 232'02'29" 7.95'
(BM TO INTERSECTION OF C
RAMP EDGE & CURB FACE)
- ② 249'23'02" 30.65'
(BM TO INTERSECTION OF C
RAMP EDGE & CURB FACE)

NOTES:




1. SEE SHEETS CB-1 TO CB-10 FOR CURB RAMP, STRIPING, AND MISCELLANEOUS DETAILS.
2. FOR ALL ELECTRICAL WORK, SEE ELECTRICAL PLANS.





SITE PLAN
SCALE: 1"= 10'

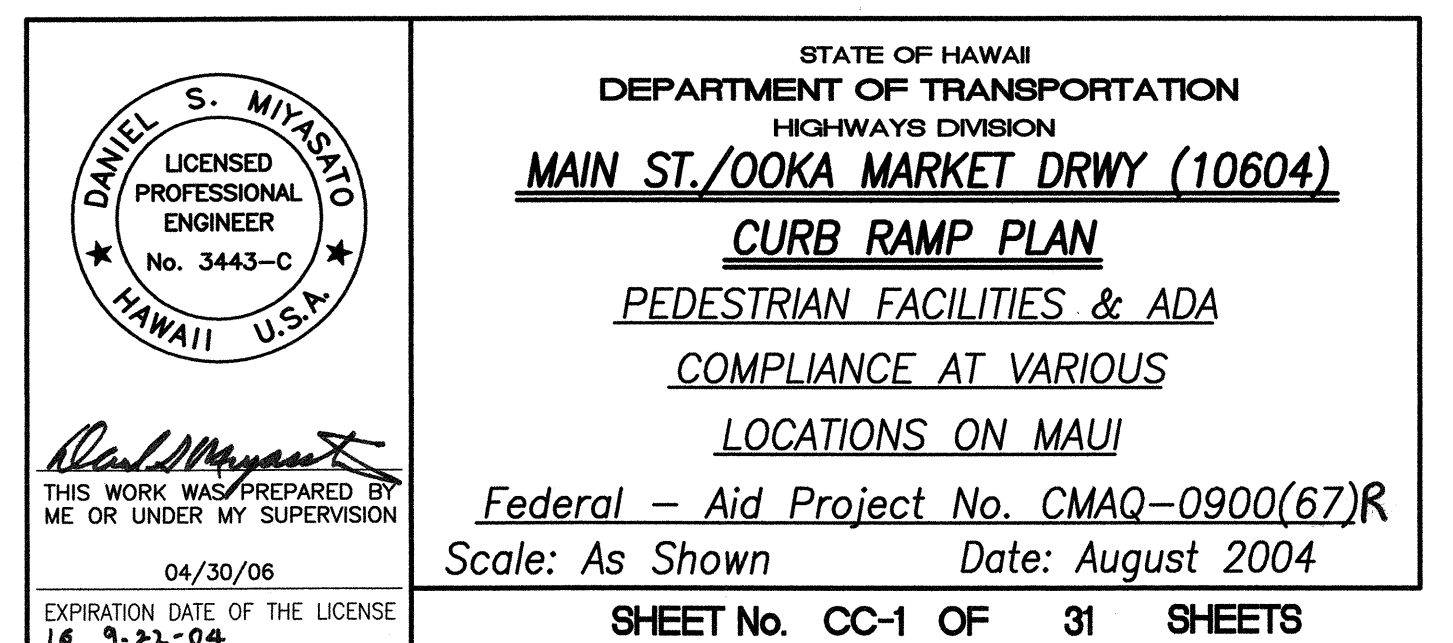

FED. ROAD DIST. NO.	STATE	FEDERAL - AID PROJ. NO.	FISCAL YEAR	SHEET NO.	TOTAL SHEETS
HAWAII	HAW.	CMAQ-0900(67)R	2004	23	109

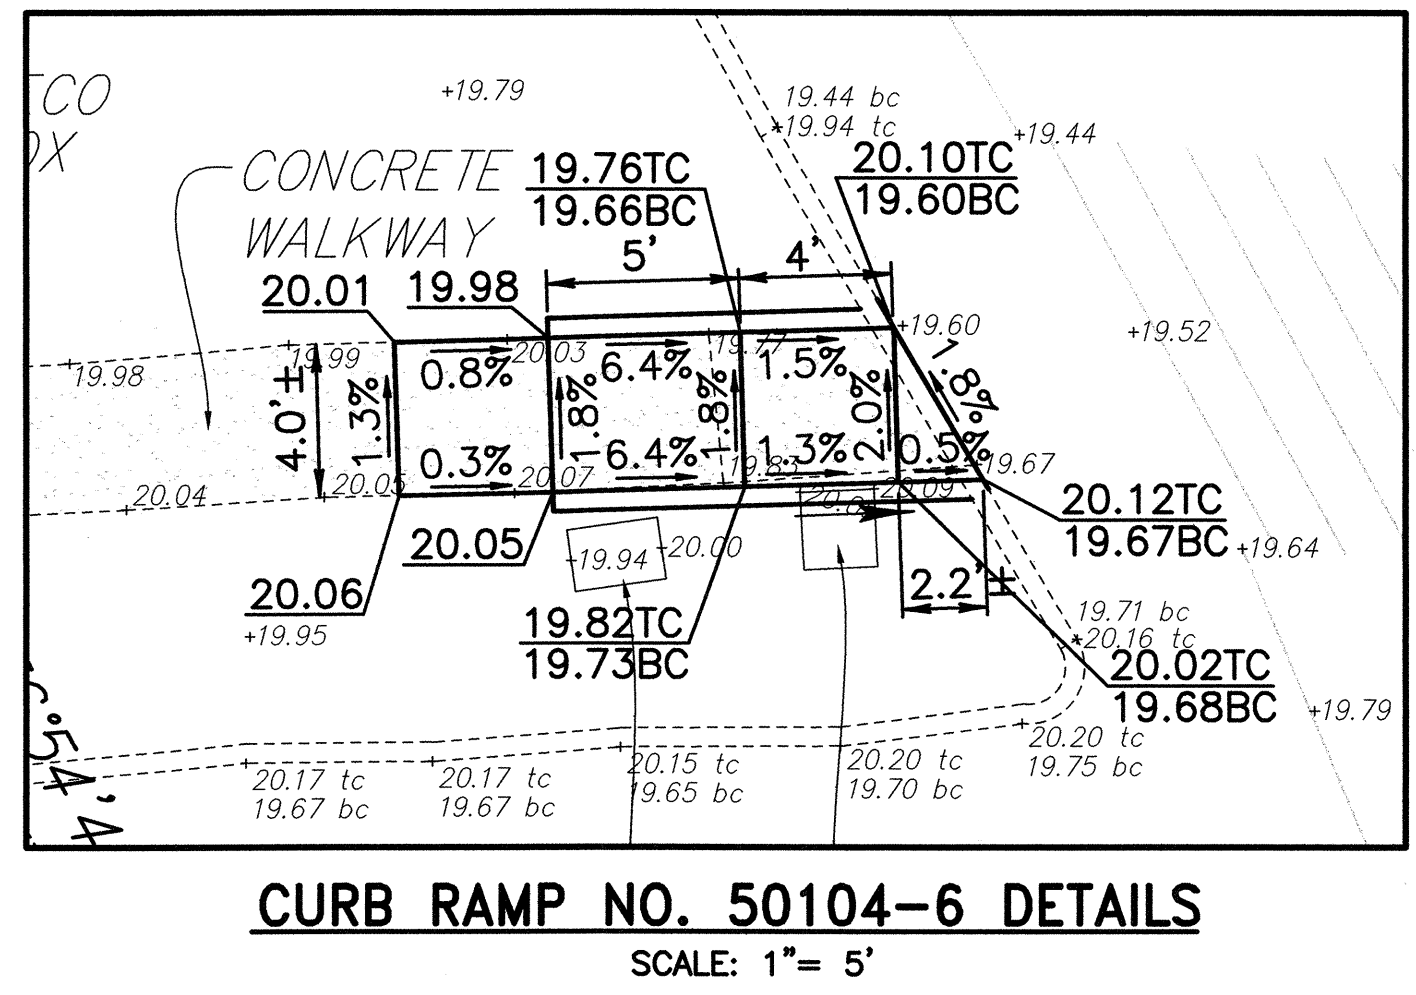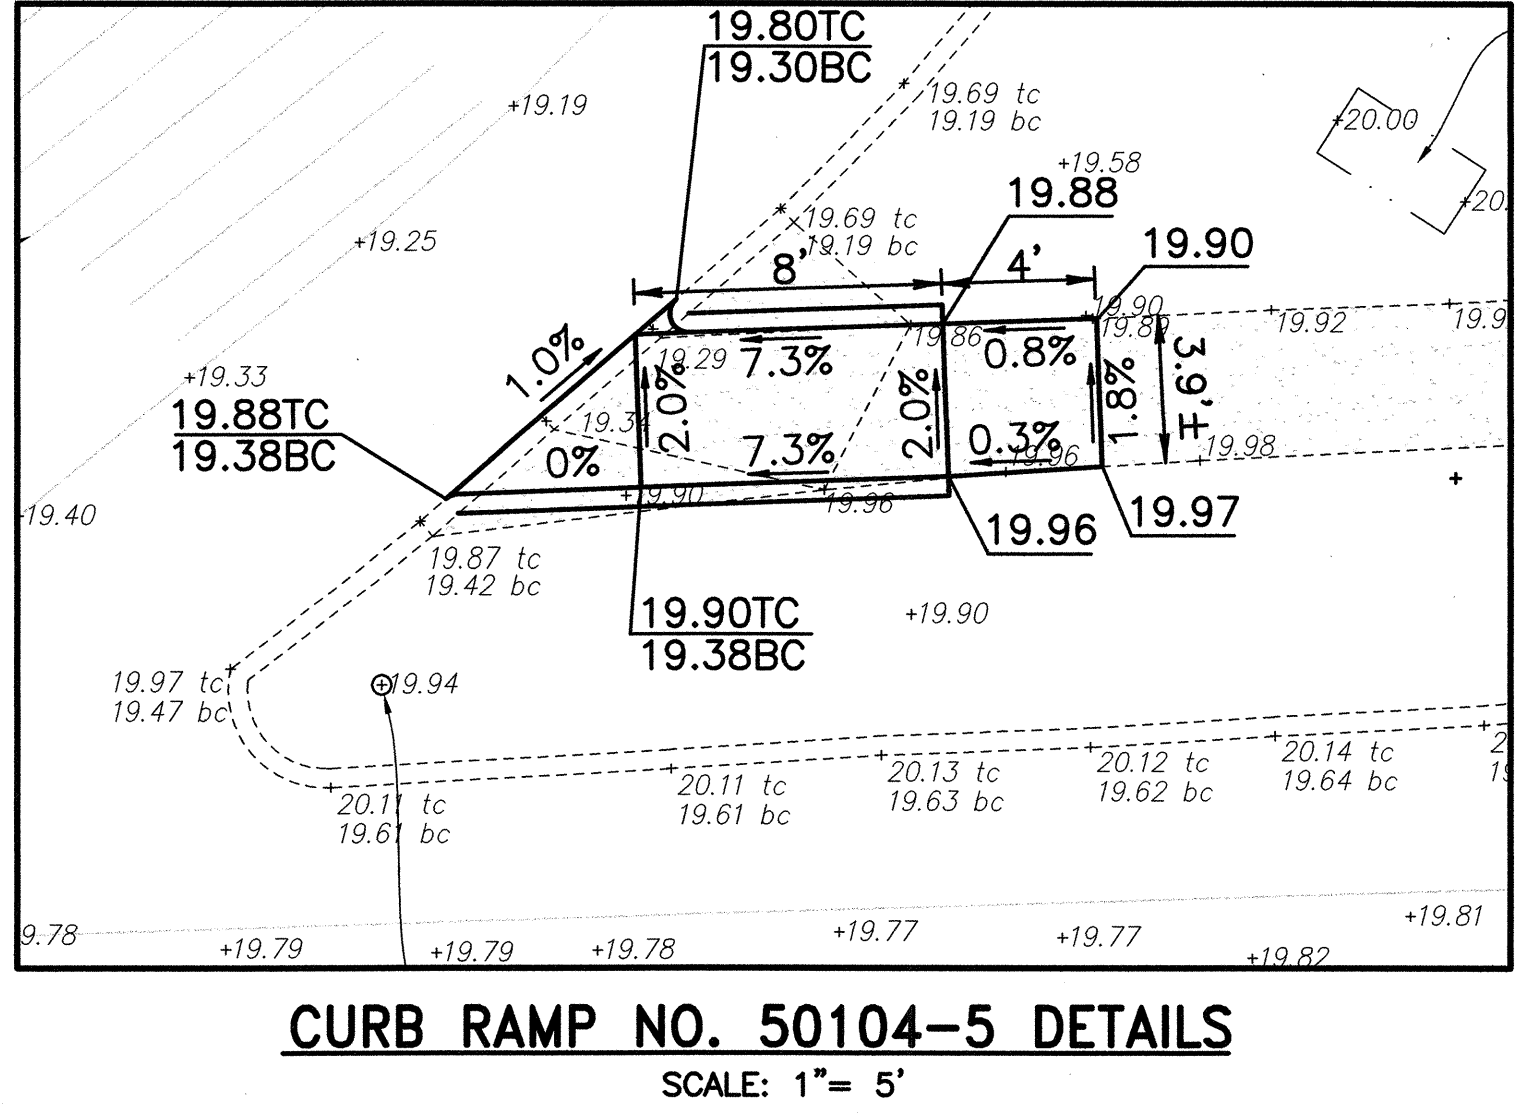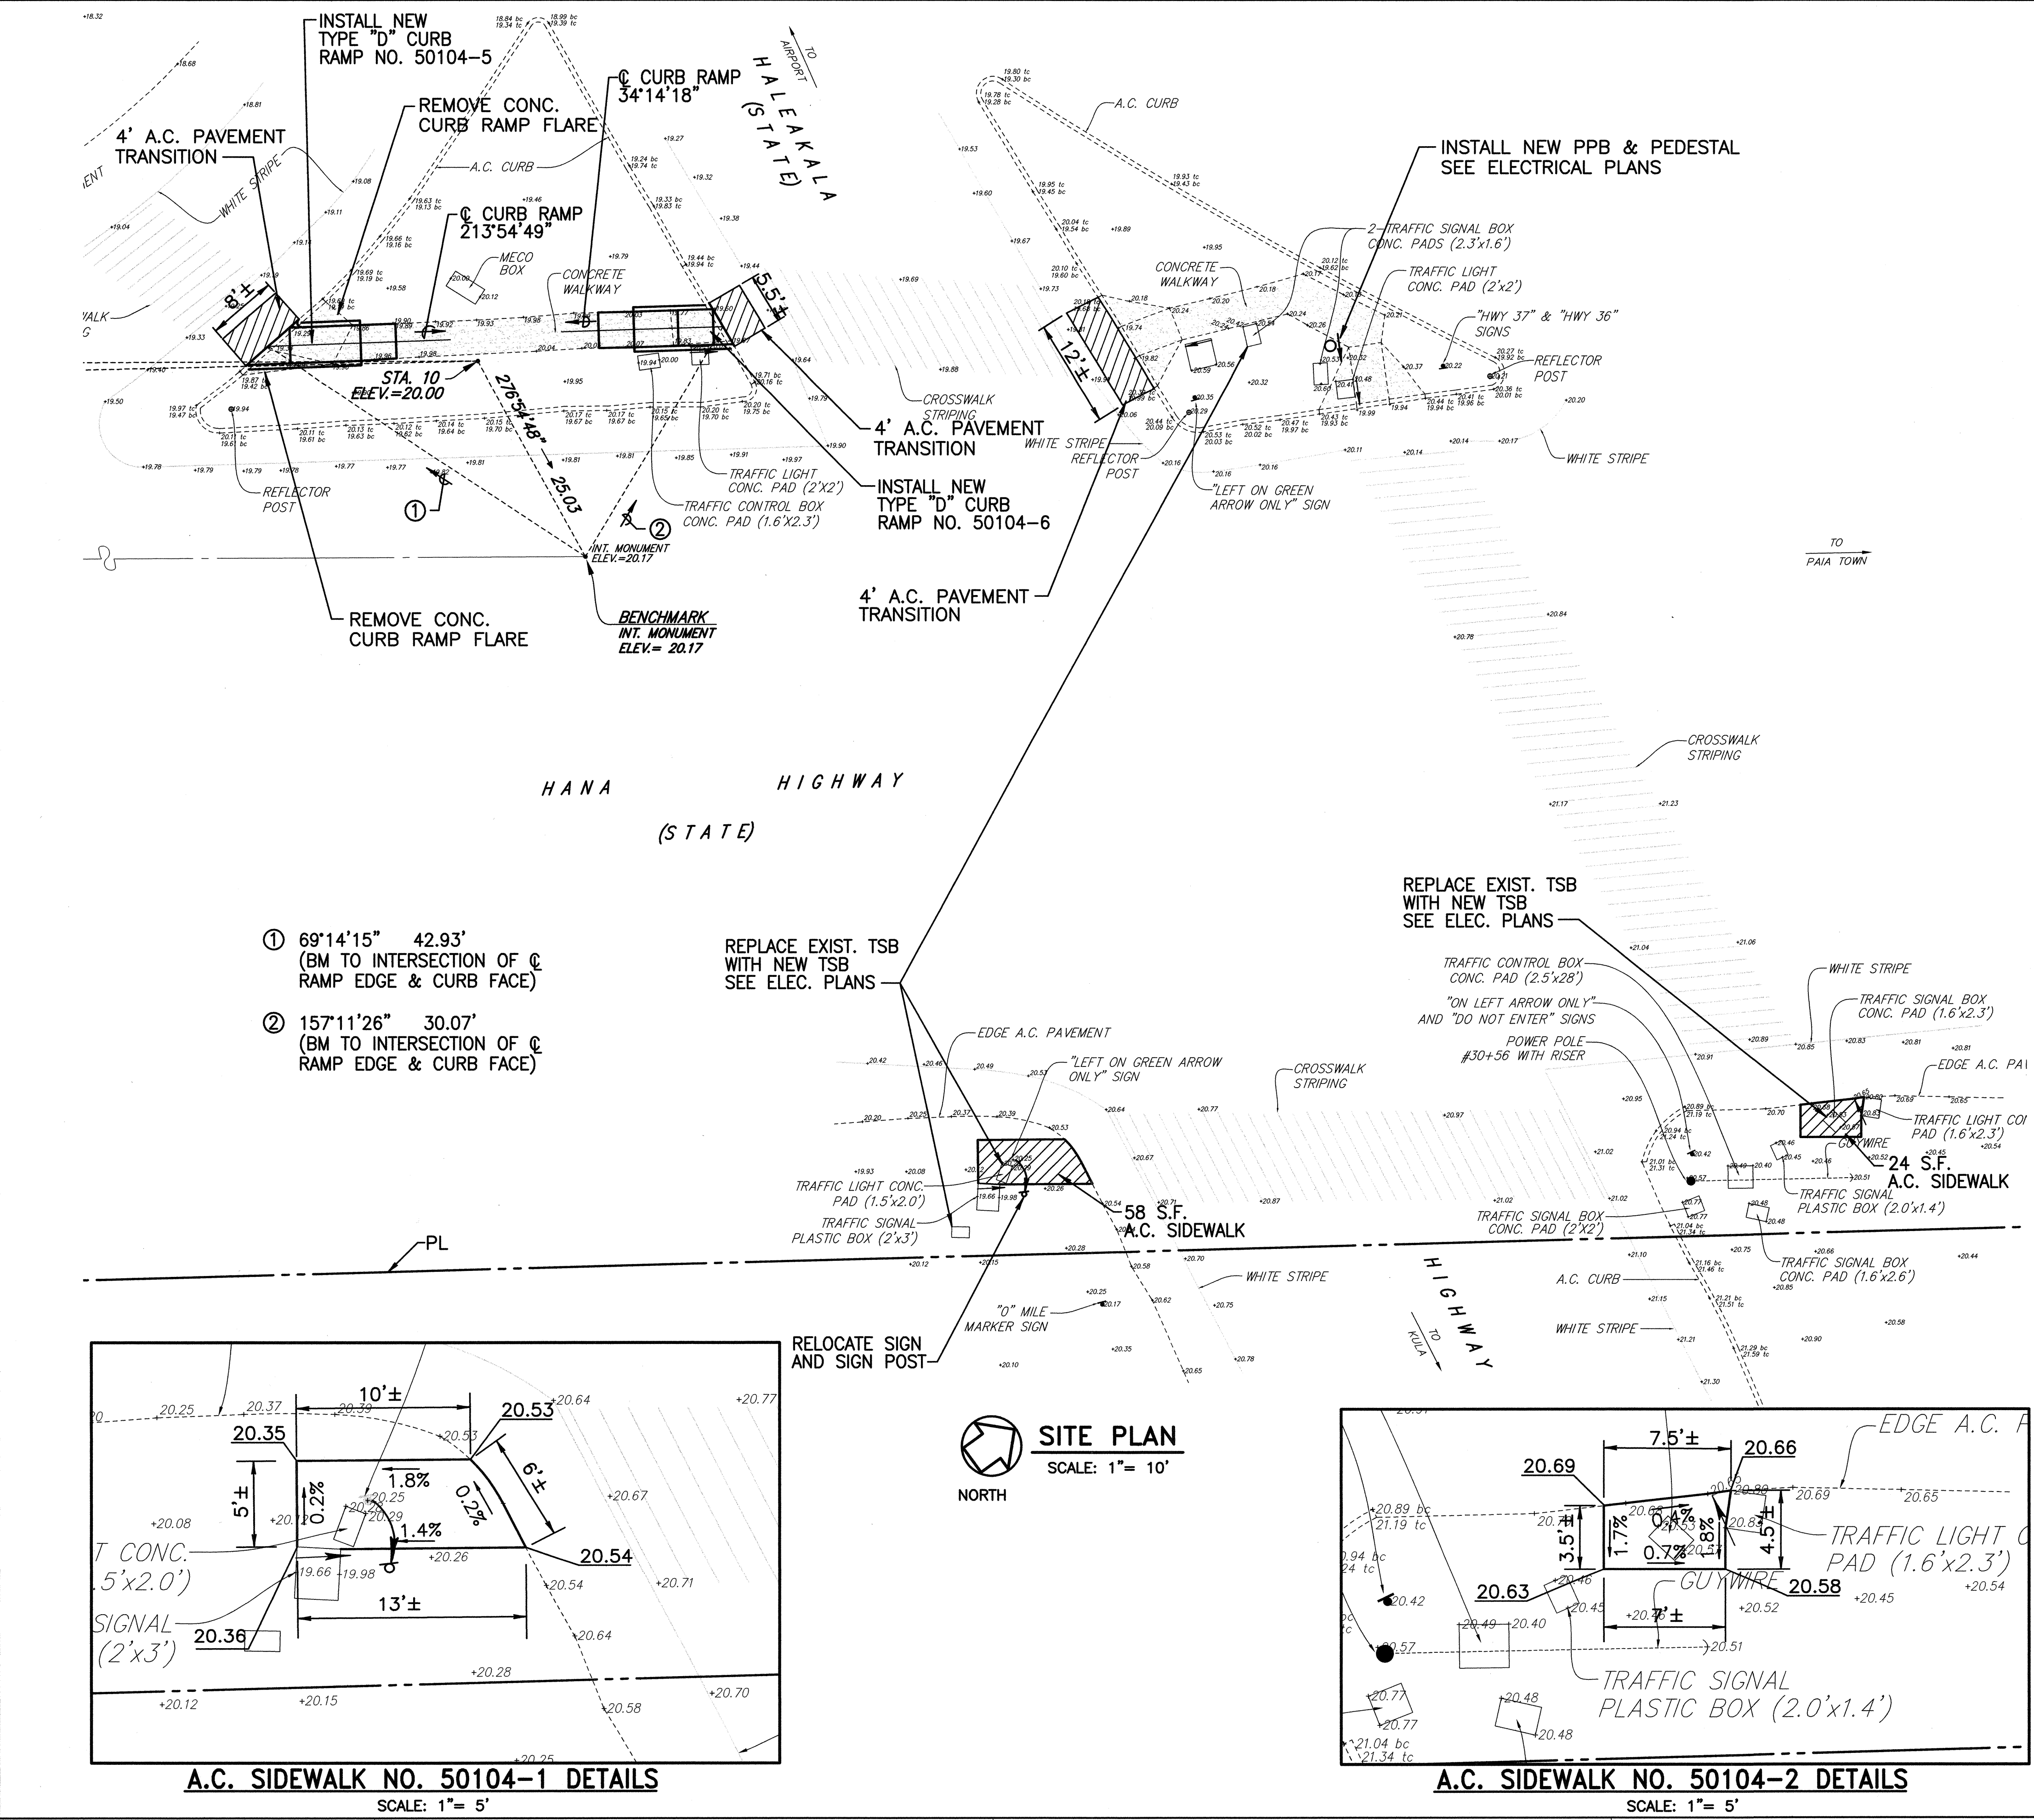

- NOTES:
- SEE SHEETS CB-1 TO CB-10 FOR CURB RAMP, STRIPING, AND MISCELLANEOUS DETAILS.
 - FOR ALL ELECTRICAL WORK, SEE ELECTRICAL PLANS.

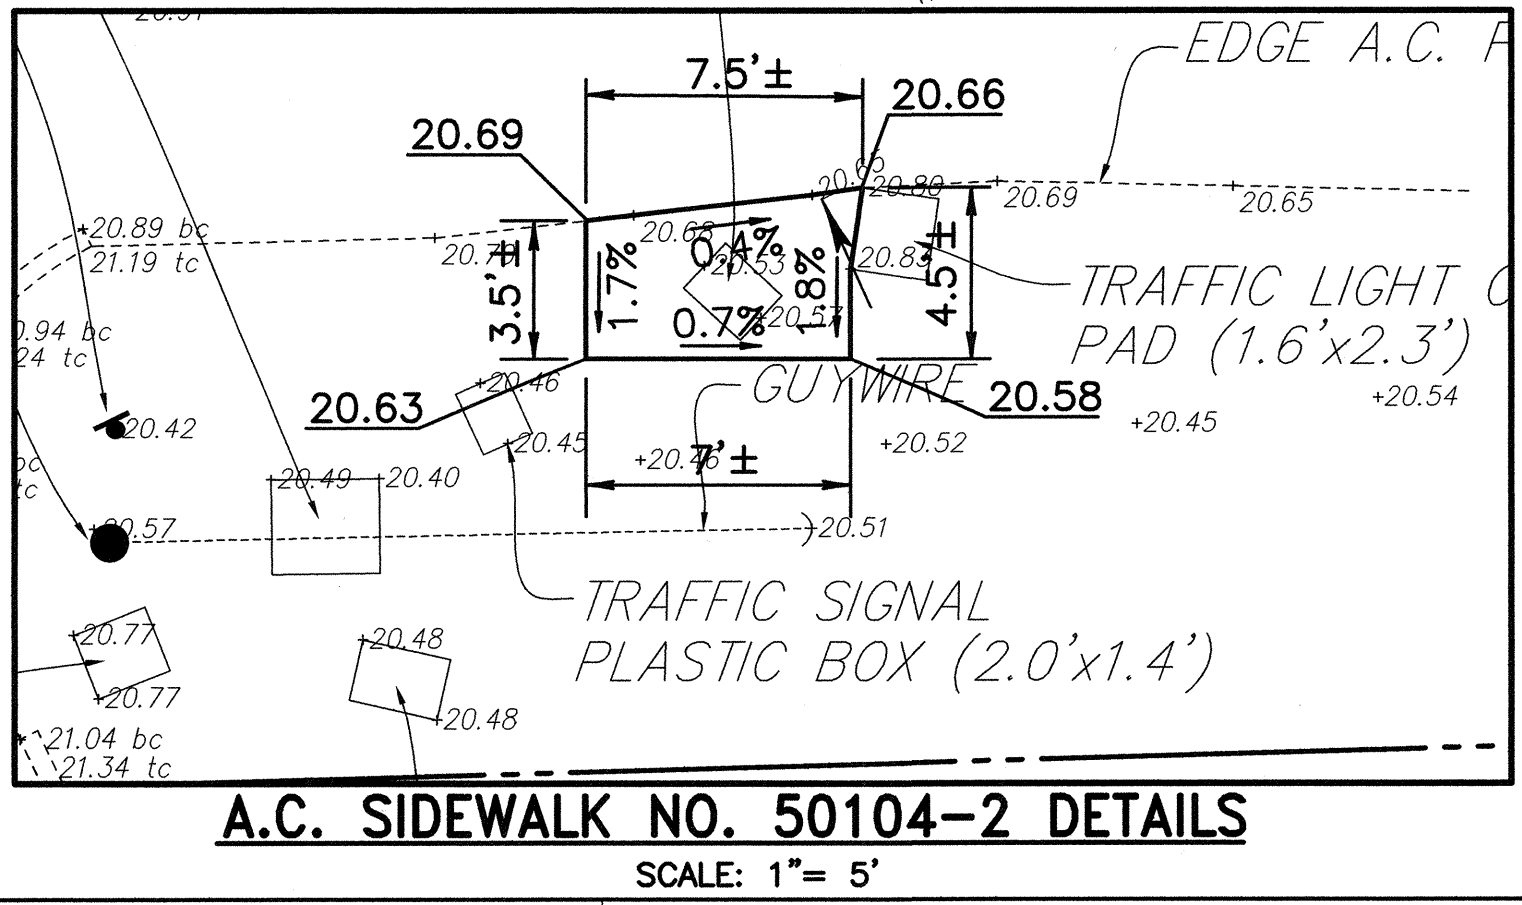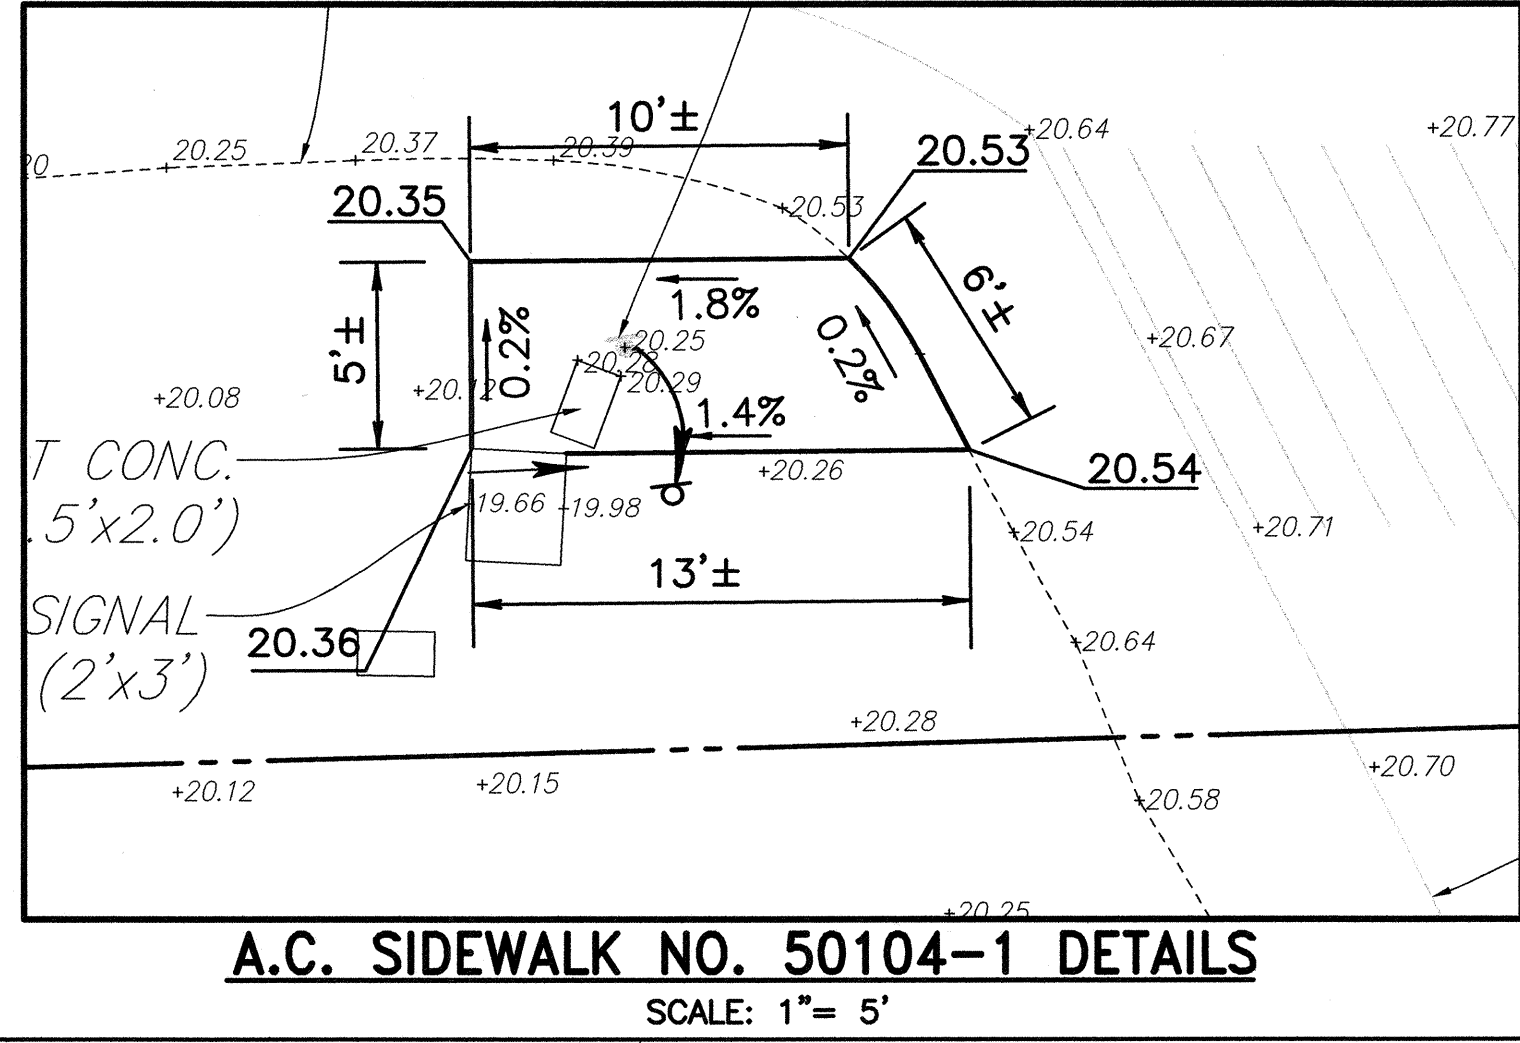


THIS WORK WAS PREPARED BY ME OR UNDER MY SUPERVISION
EXPIRATION DATE OF THE LICENSE: 04/30/06
10-22-04

STATE OF HAWAII
DEPARTMENT OF TRANSPORTATION
HIGHWAYS DIVISION
HANA HWY./ HALEAKALA HWY. (50104)
CURB RAMP PLAN
PEDESTRIAN FACILITIES & ADA
COMPLIANCE AT VARIOUS
LOCATIONS ON MAUI
Federal - Aid Project No. CMAQ-0900(67)R
Scale: As Shown Date: August 2004
SHEET No. CC-2 OF 31 SHEETS

PROJ. NO.: 04008-00	DATE: 3/10/04
SURVEY PLOTTED BY: _____	
DESIGNED BY: _____	
CHECKED BY: _____	
ORIGINAL PLAN	NO.
NOTE BOOK	
QUANTITIES BY	
CHECKED BY	


FED. ROAD DIST. NO.	STATE	FEDERAL - AID PROJ. NO.	FISCAL YEAR	SHEET NO.	TOTAL SHEETS
HAWAII	HAW.	CMAQ-0900(67)R	2004	24	109

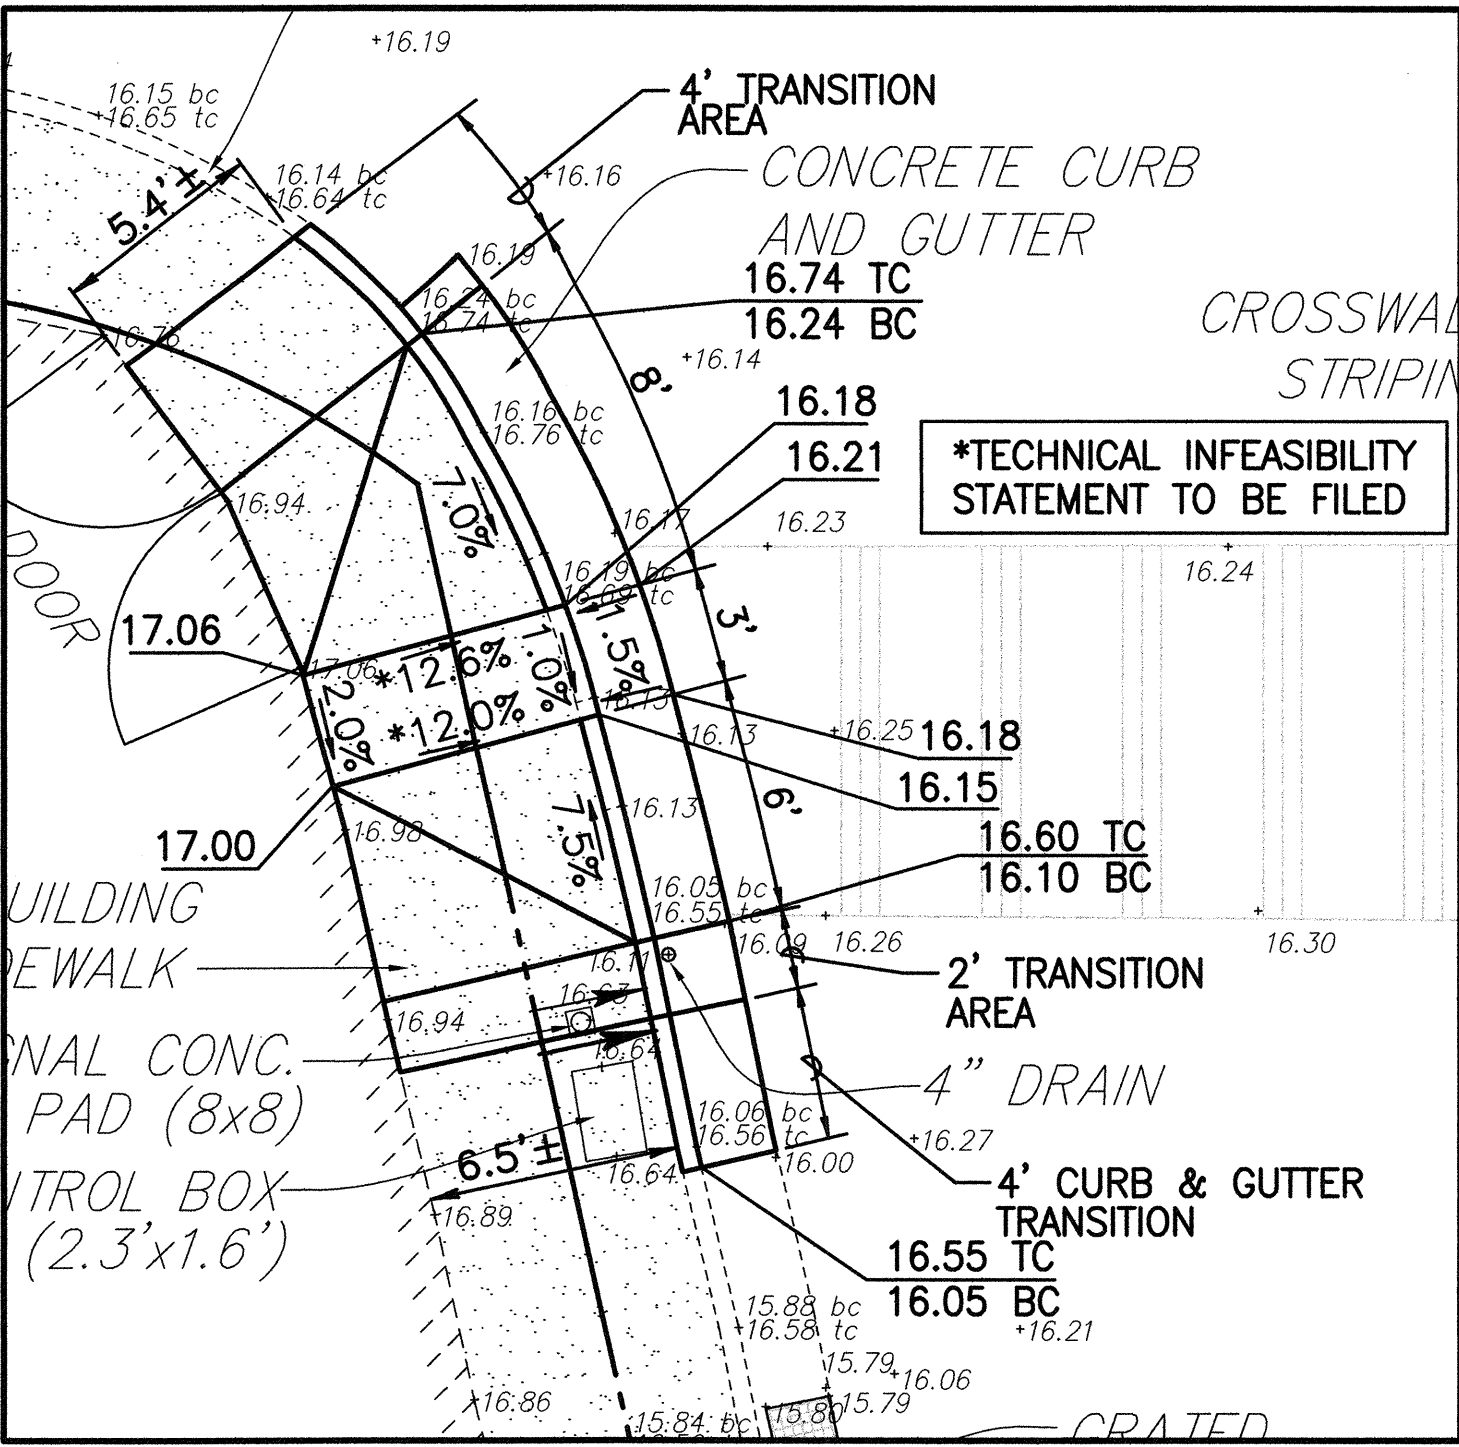


CURB RAMP NO. 50204-3 DETAILS
SCALE: 1"= 5'

NOTES:

1. SEE SHEETS CB-1 TO CB-10 FOR CURB RAMP, STRIPING, AND MISCELLANEOUS DETAILS.
2. FOR ALL ELECTRICAL WORK, SEE ELECTRICAL PLANS.

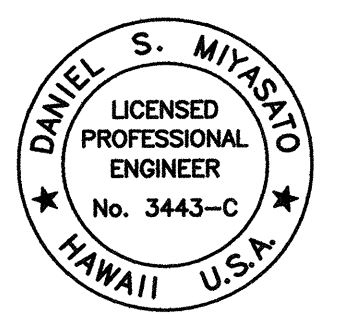
 <i>Daniel S. Miyasato</i> THIS WORK WAS PREPARED BY ME OR UNDER MY SUPERVISION EXPIRATION DATE OF THE LICENSE: 04/30/06 18-9-22-04	STATE OF HAWAII DEPARTMENT OF TRANSPORTATION HIGHWAYS DIVISION HANA HWY./ BALDWIN AVE. (50204) CURB RAMP PLAN PEDESTRIAN FACILITIES & ADA COMPLIANCE AT VARIOUS LOCATIONS ON MAUI Federal - Aid Project No. CMAQ-0900(67)R Scale: As Shown Date: August 2004 SHEET No. CC-3 OF 31 SHEETS
--	--

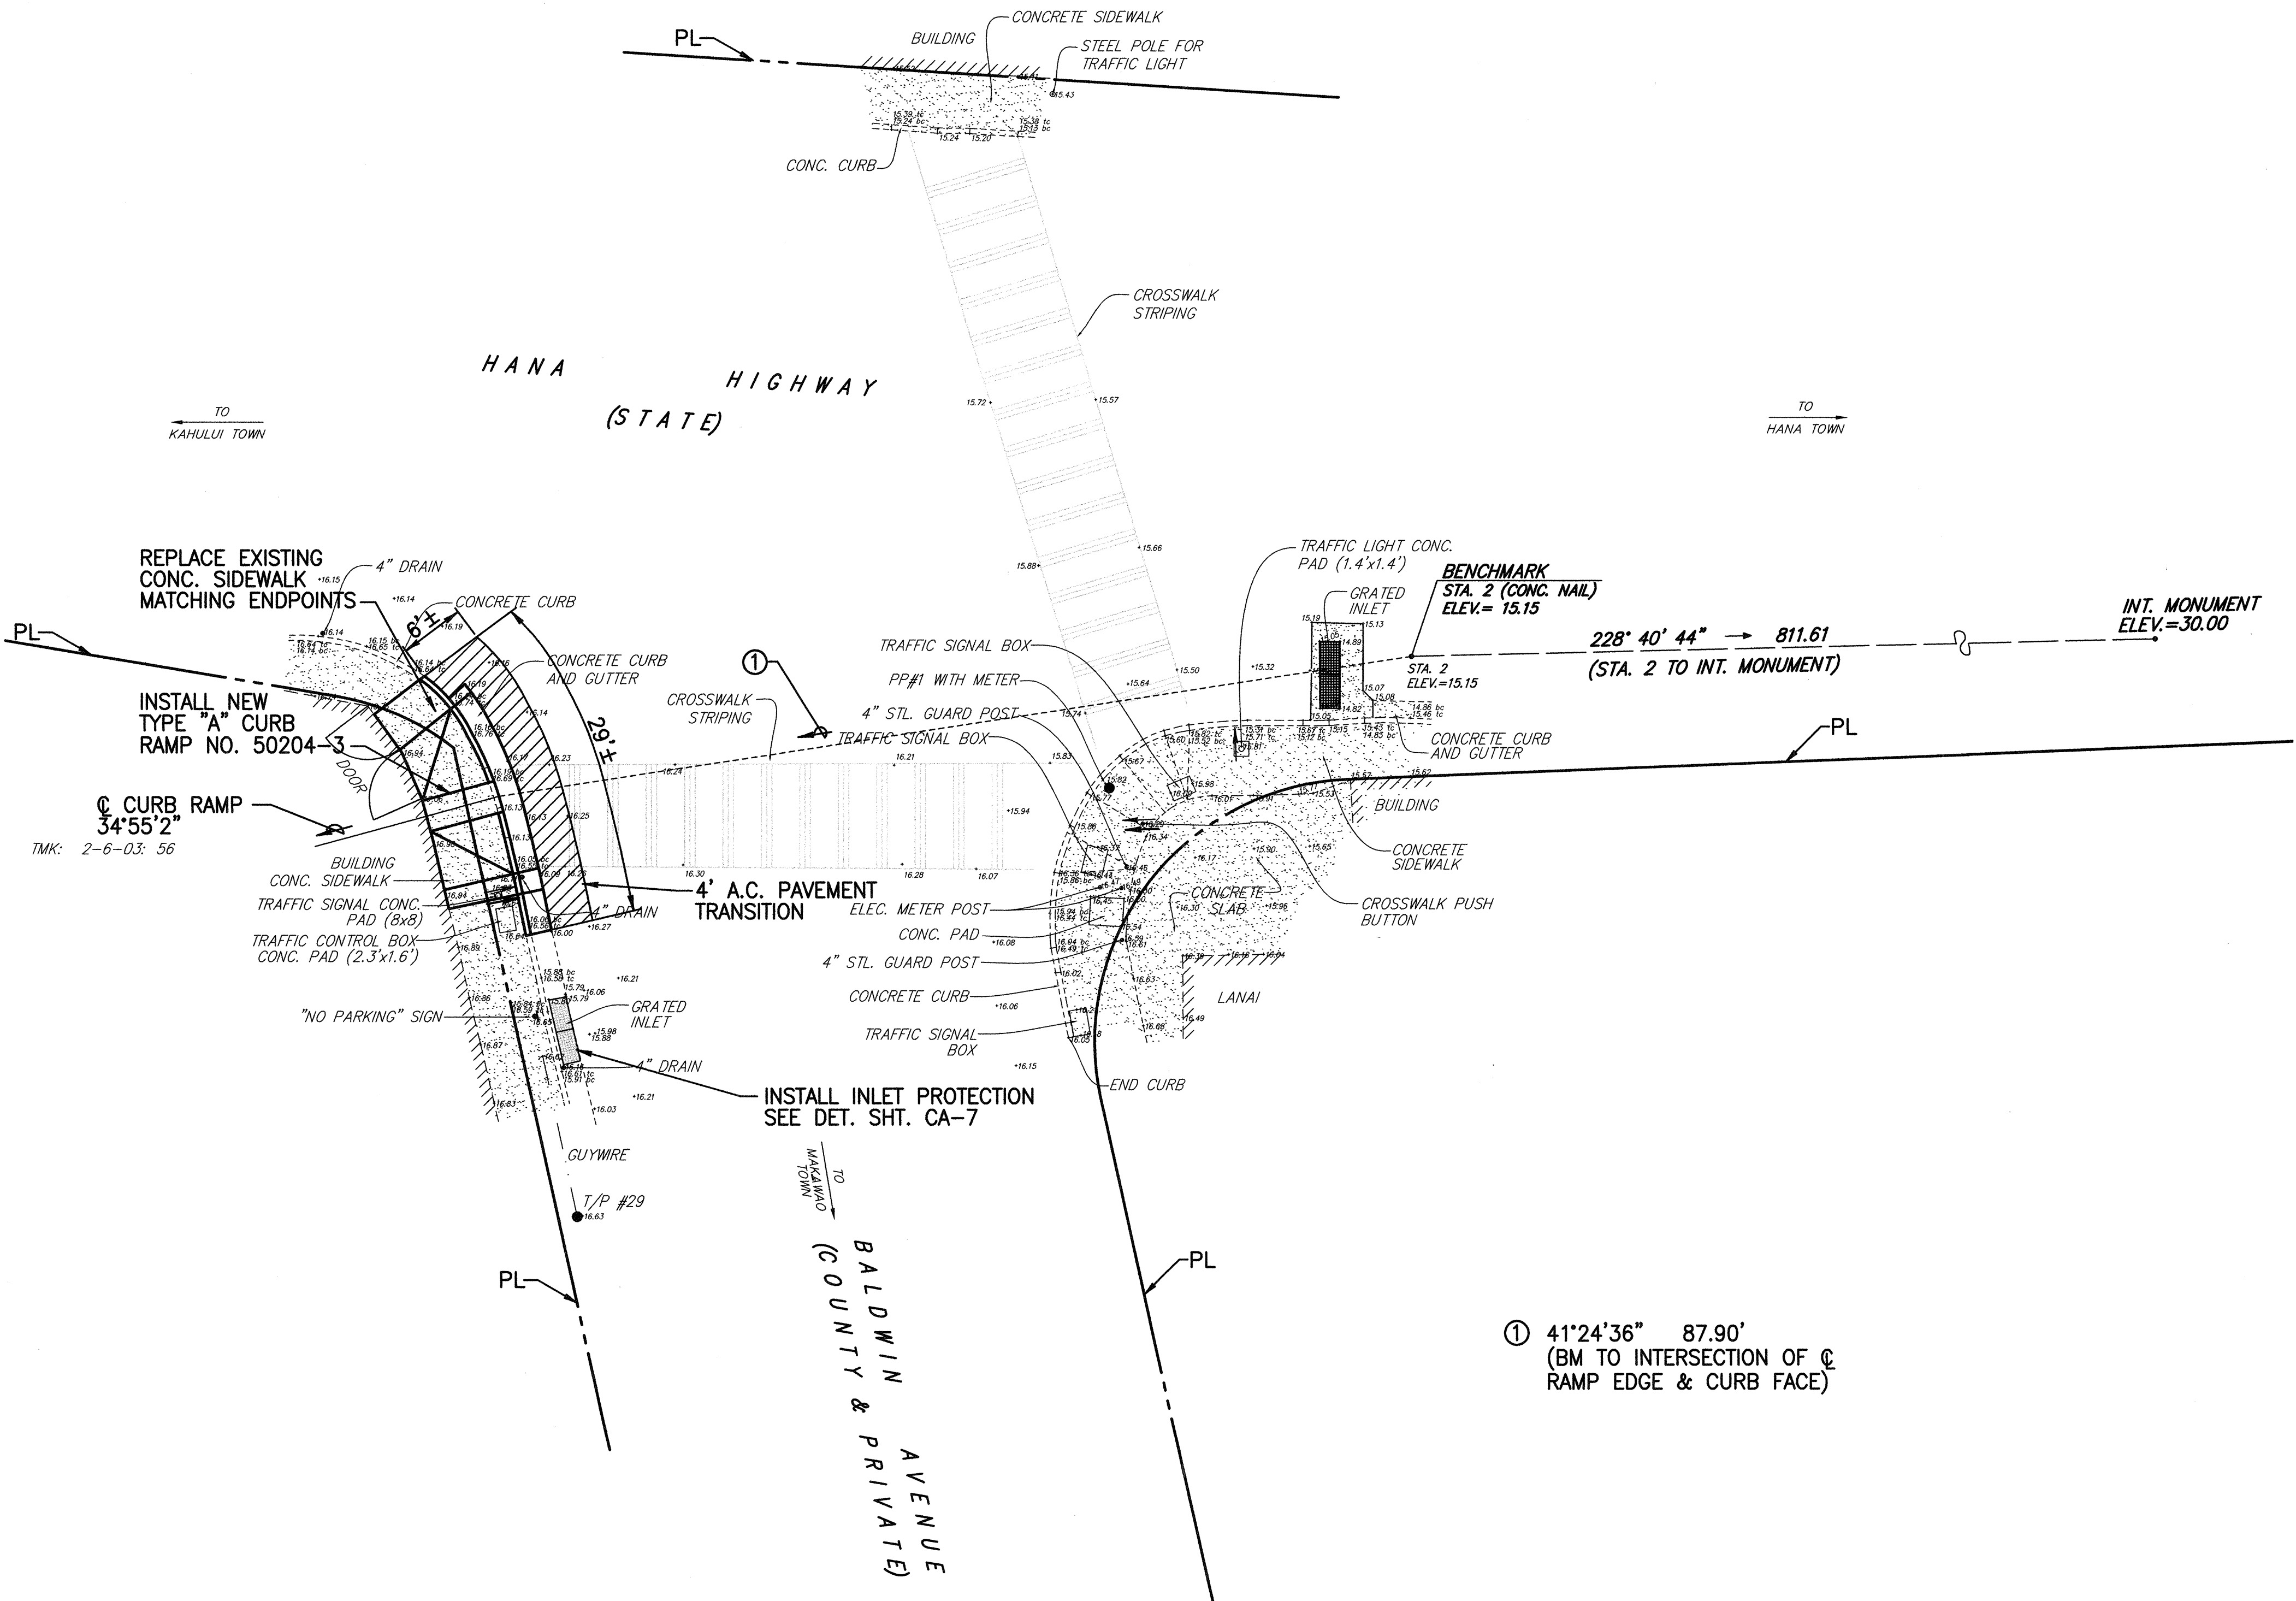

SITE PLAN
SCALE: 1"= 10'
NORTH

SURVEY PLOTTED BY	DATE
DESIGNED BY	
NOTED BY	
CHECKED BY	
ORIGINAL PLAN	No.

FED. ROAD DIST. NO.	STATE	FEDERAL - AID PROJ. NO.	FISCAL YEAR	SHEET NO.	TOTAL SHEETS
HAWAII	HAW.	CMAQ-0900(67)R	2004	25	109

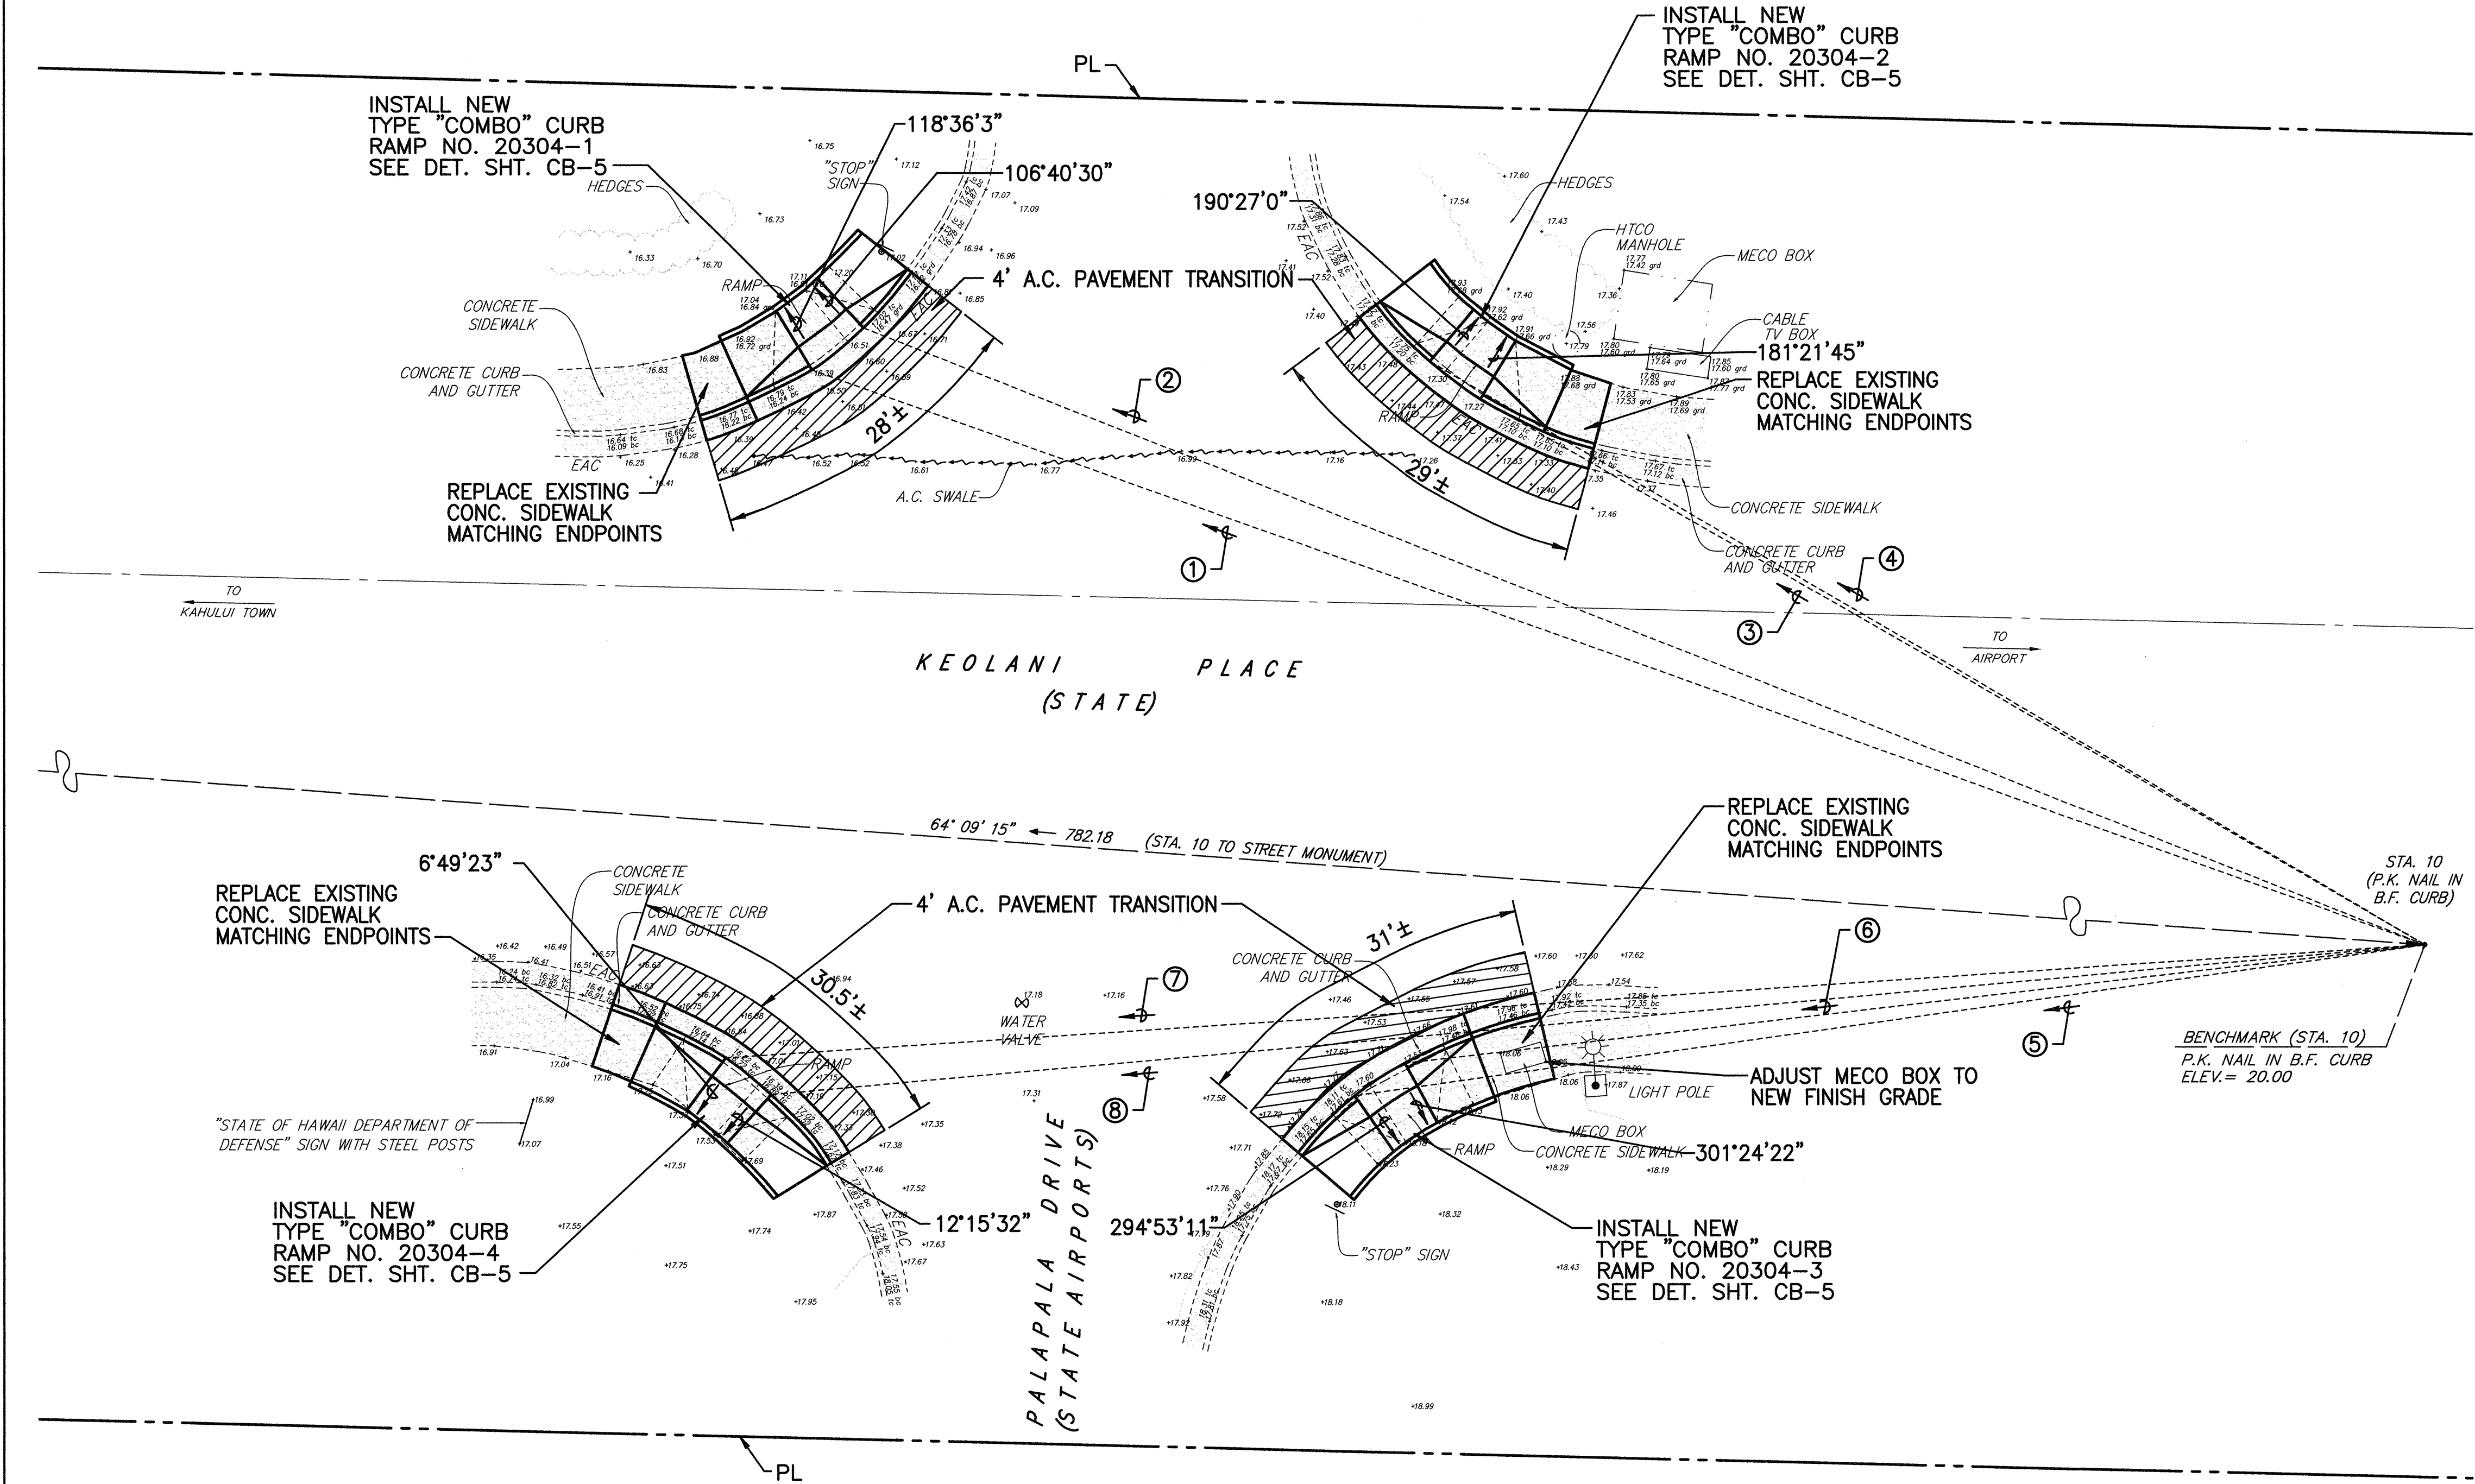

- ① 79°34'36" 163.87' (BM TO INTERSECTION OF RAMP EDGE & CURB FACE)
- ② 81°30'51" 160.67' (BM TO INTERSECTION OF RAMP EDGE & CURB FACE)
- ③ 89°58'7" 104.37' (BM TO INTERSECTION OF RAMP EDGE & CURB FACE)
- ④ 90°20'1" 110.36' (BM TO INTERSECTION OF RAMP EDGE & CURB FACE)
- ⑤ 52°0'1" 103.49' (BM TO INTERSECTION OF RAMP EDGE & CURB FACE)
- ⑥ 53°25'6" 98.32' (BM TO INTERSECTION OF RAMP EDGE & CURB FACE)
- ⑦ 56°13'7" 163.04' (BM TO INTERSECTION OF RAMP EDGE & CURB FACE)
- ⑧ 54°50'30" 159.00' (BM TO INTERSECTION OF RAMP EDGE & CURB FACE)

- NOTES:
1. SEE SHEETS CB-1 TO CB-10 FOR CURB RAMP, STRIPING, AND MISCELLANEOUS DETAILS.
 2. FOR ALL ELECTRICAL WORK, SEE ELECTRICAL PLANS.


DANIEL S. MIYAMOTO
LICENSED PROFESSIONAL ENGINEER
No. 3443-C
HAWAII U.S.A.

STATE OF HAWAII
DEPARTMENT OF TRANSPORTATION
HIGHWAYS DIVISION
KEOLANI PL./ PALAPALA DR. (20304)
CURB RAMP PLAN
PEDESTRIAN FACILITIES & ADA
COMPLIANCE AT VARIOUS
LOCATIONS ON MAUI
Federal - Aid Project No. CMAQ-0900(67)R
Scale: As Shown Date: August 2004
SHEET No. CC-4 OF 31 SHEETS


ORIGINAL PLAN	DATE
NOTE BOOK	DESIGNED BY
QUANTITIES BY	CHECKED BY
No.	

SITE PLAN
SCALE: 1"= 10'
NORTH


FED. ROAD DIST. NO.	STATE	FEDERAL - AID PROJ. NO.	FISCAL YEAR	SHEET NO.	TOTAL SHEETS
HAWAII	HAW.	CMAQ-0900(67)R	2004	26	109

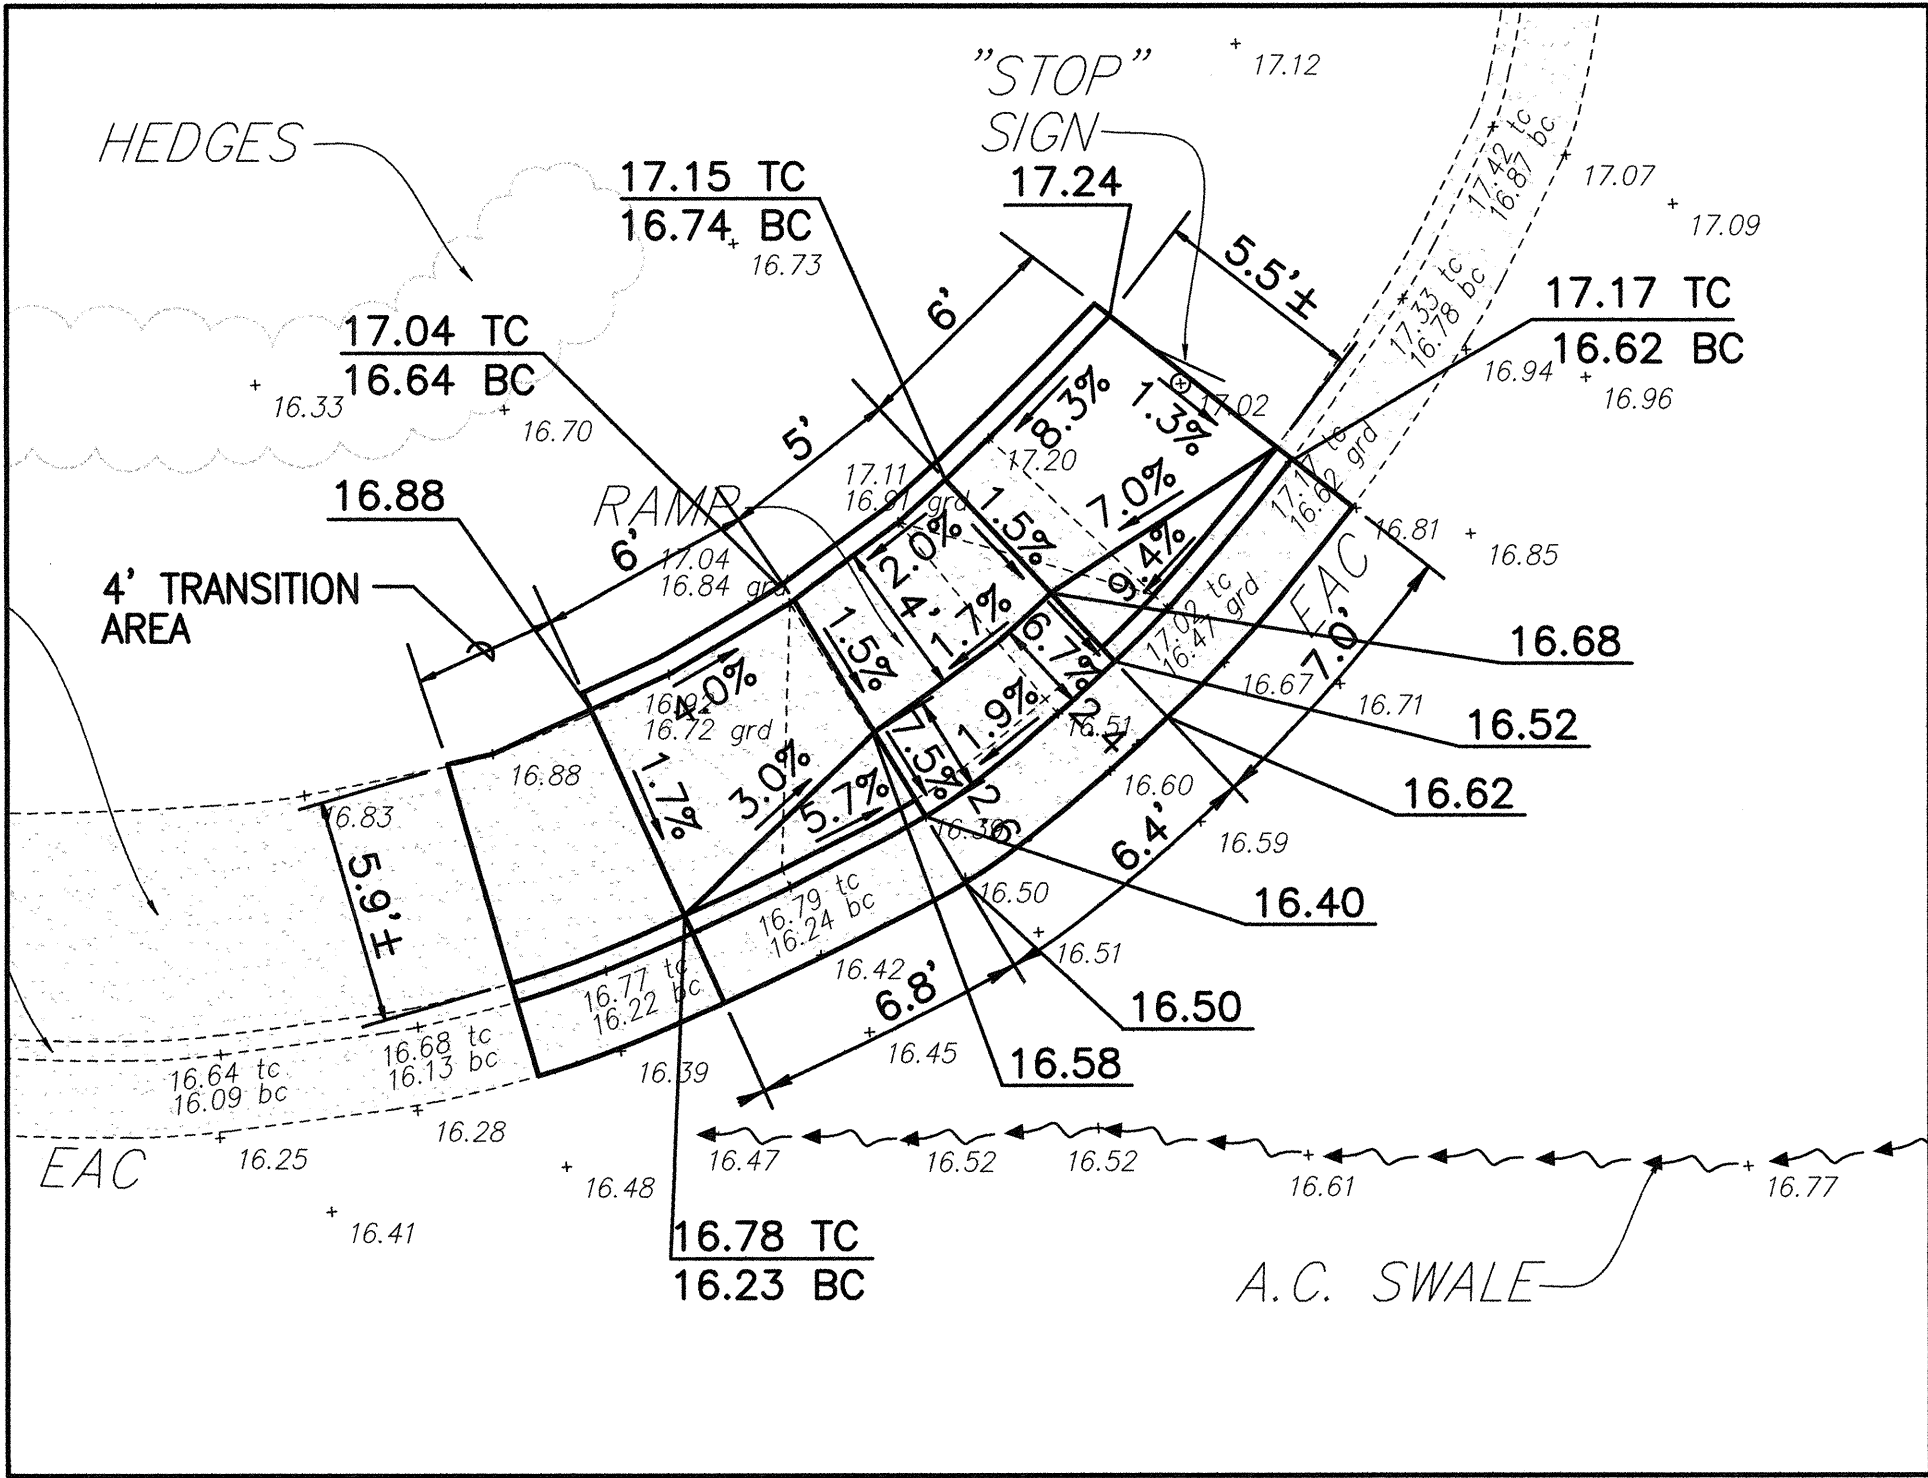


CURB RAMP NO. 20304-1 DETAILS
SCALE: 1"= 5'

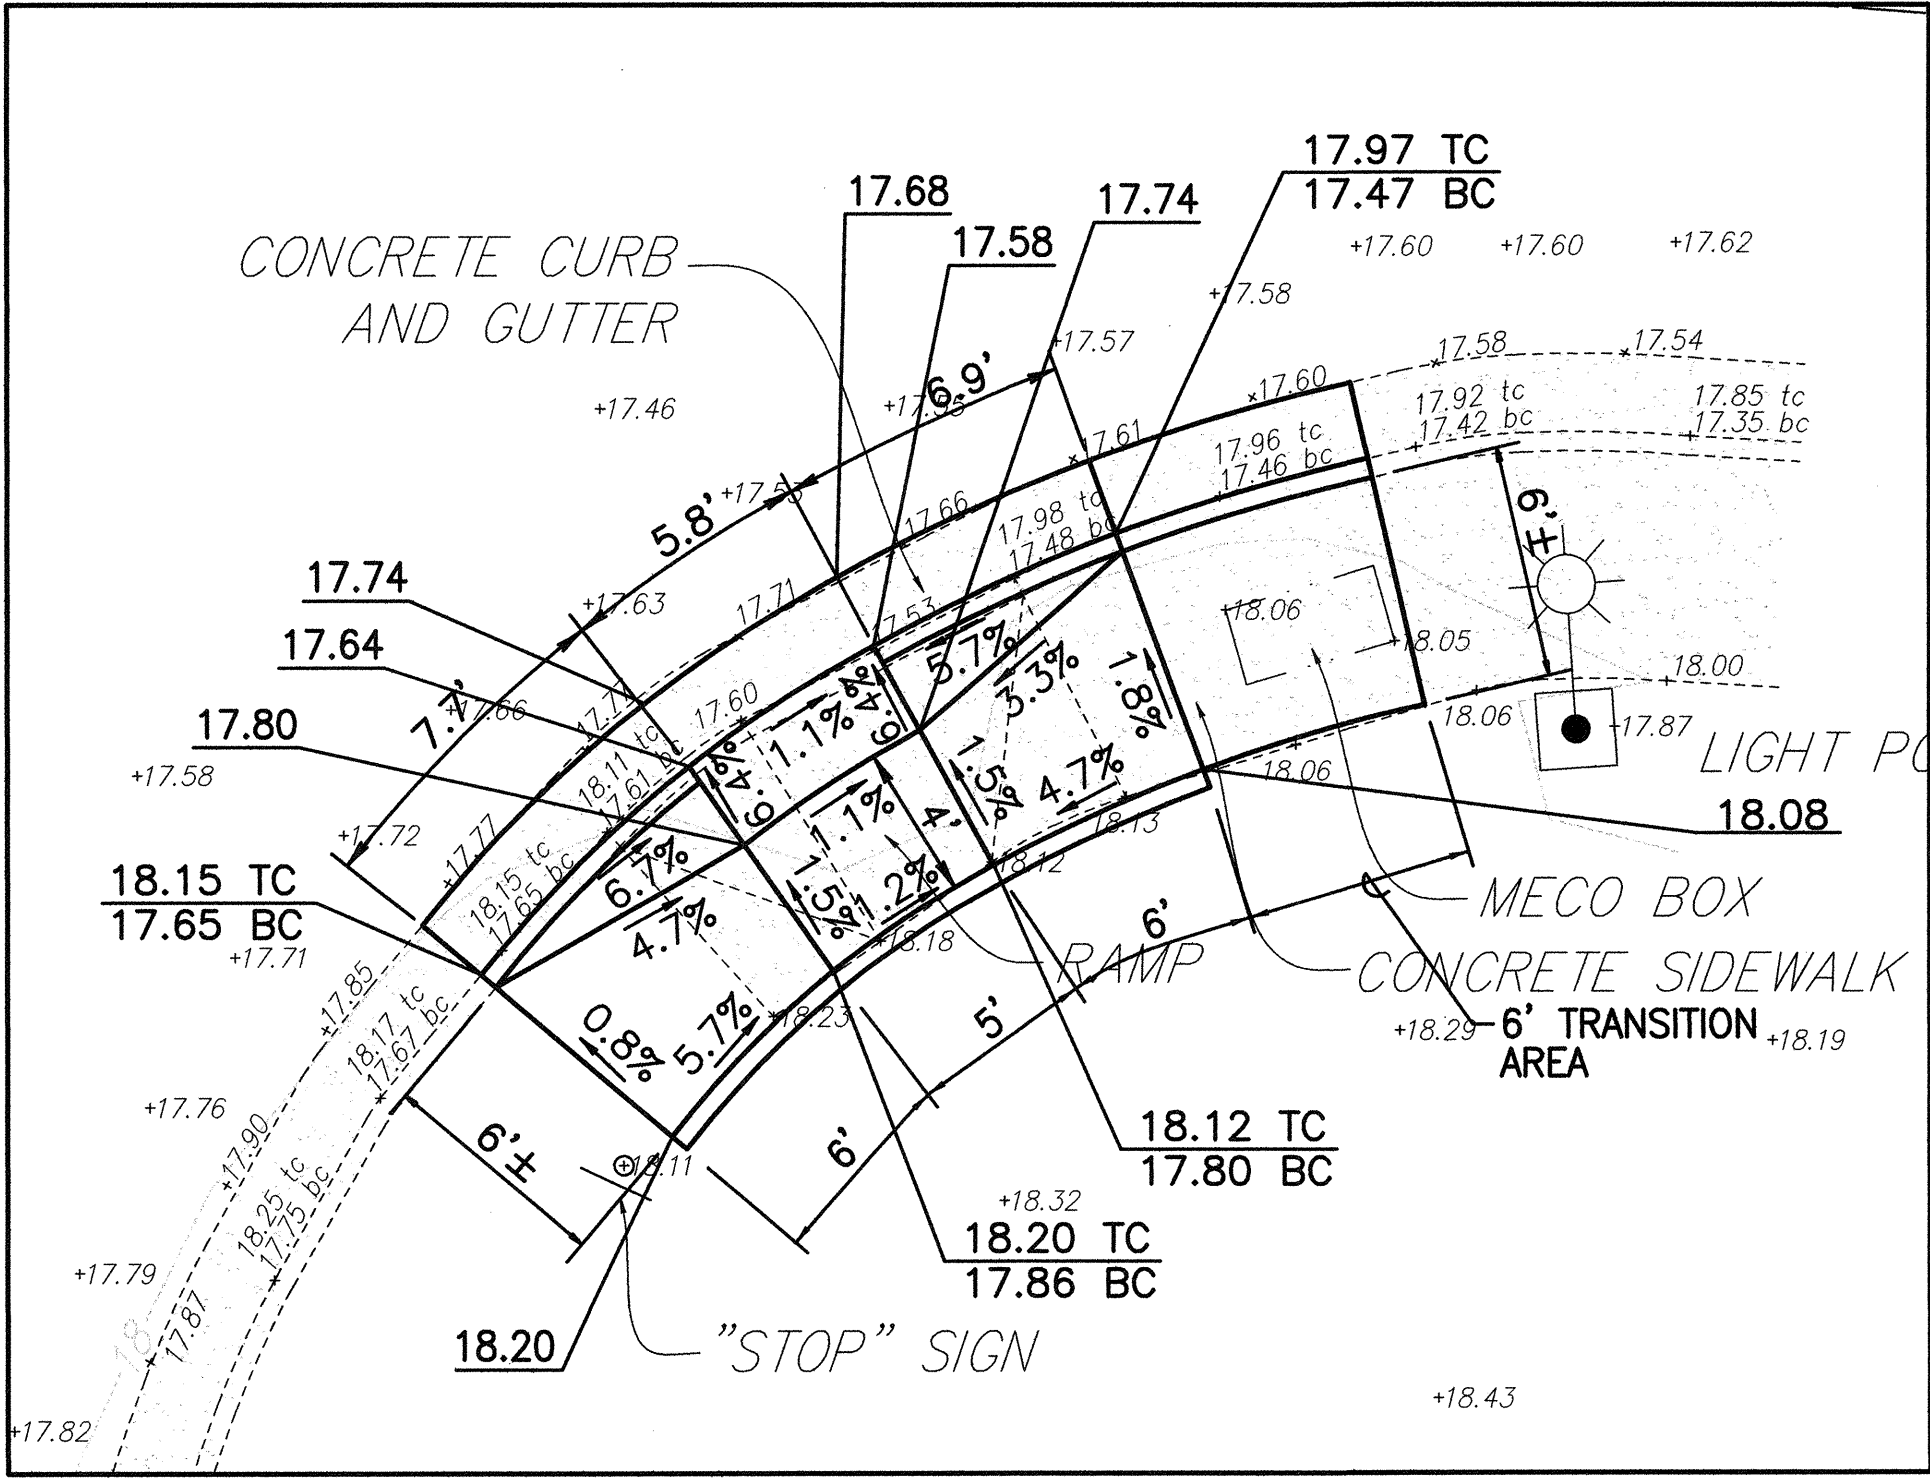

CURB RAMP NO. 20304-3 DETAILS
SCALE: 1"= 5'

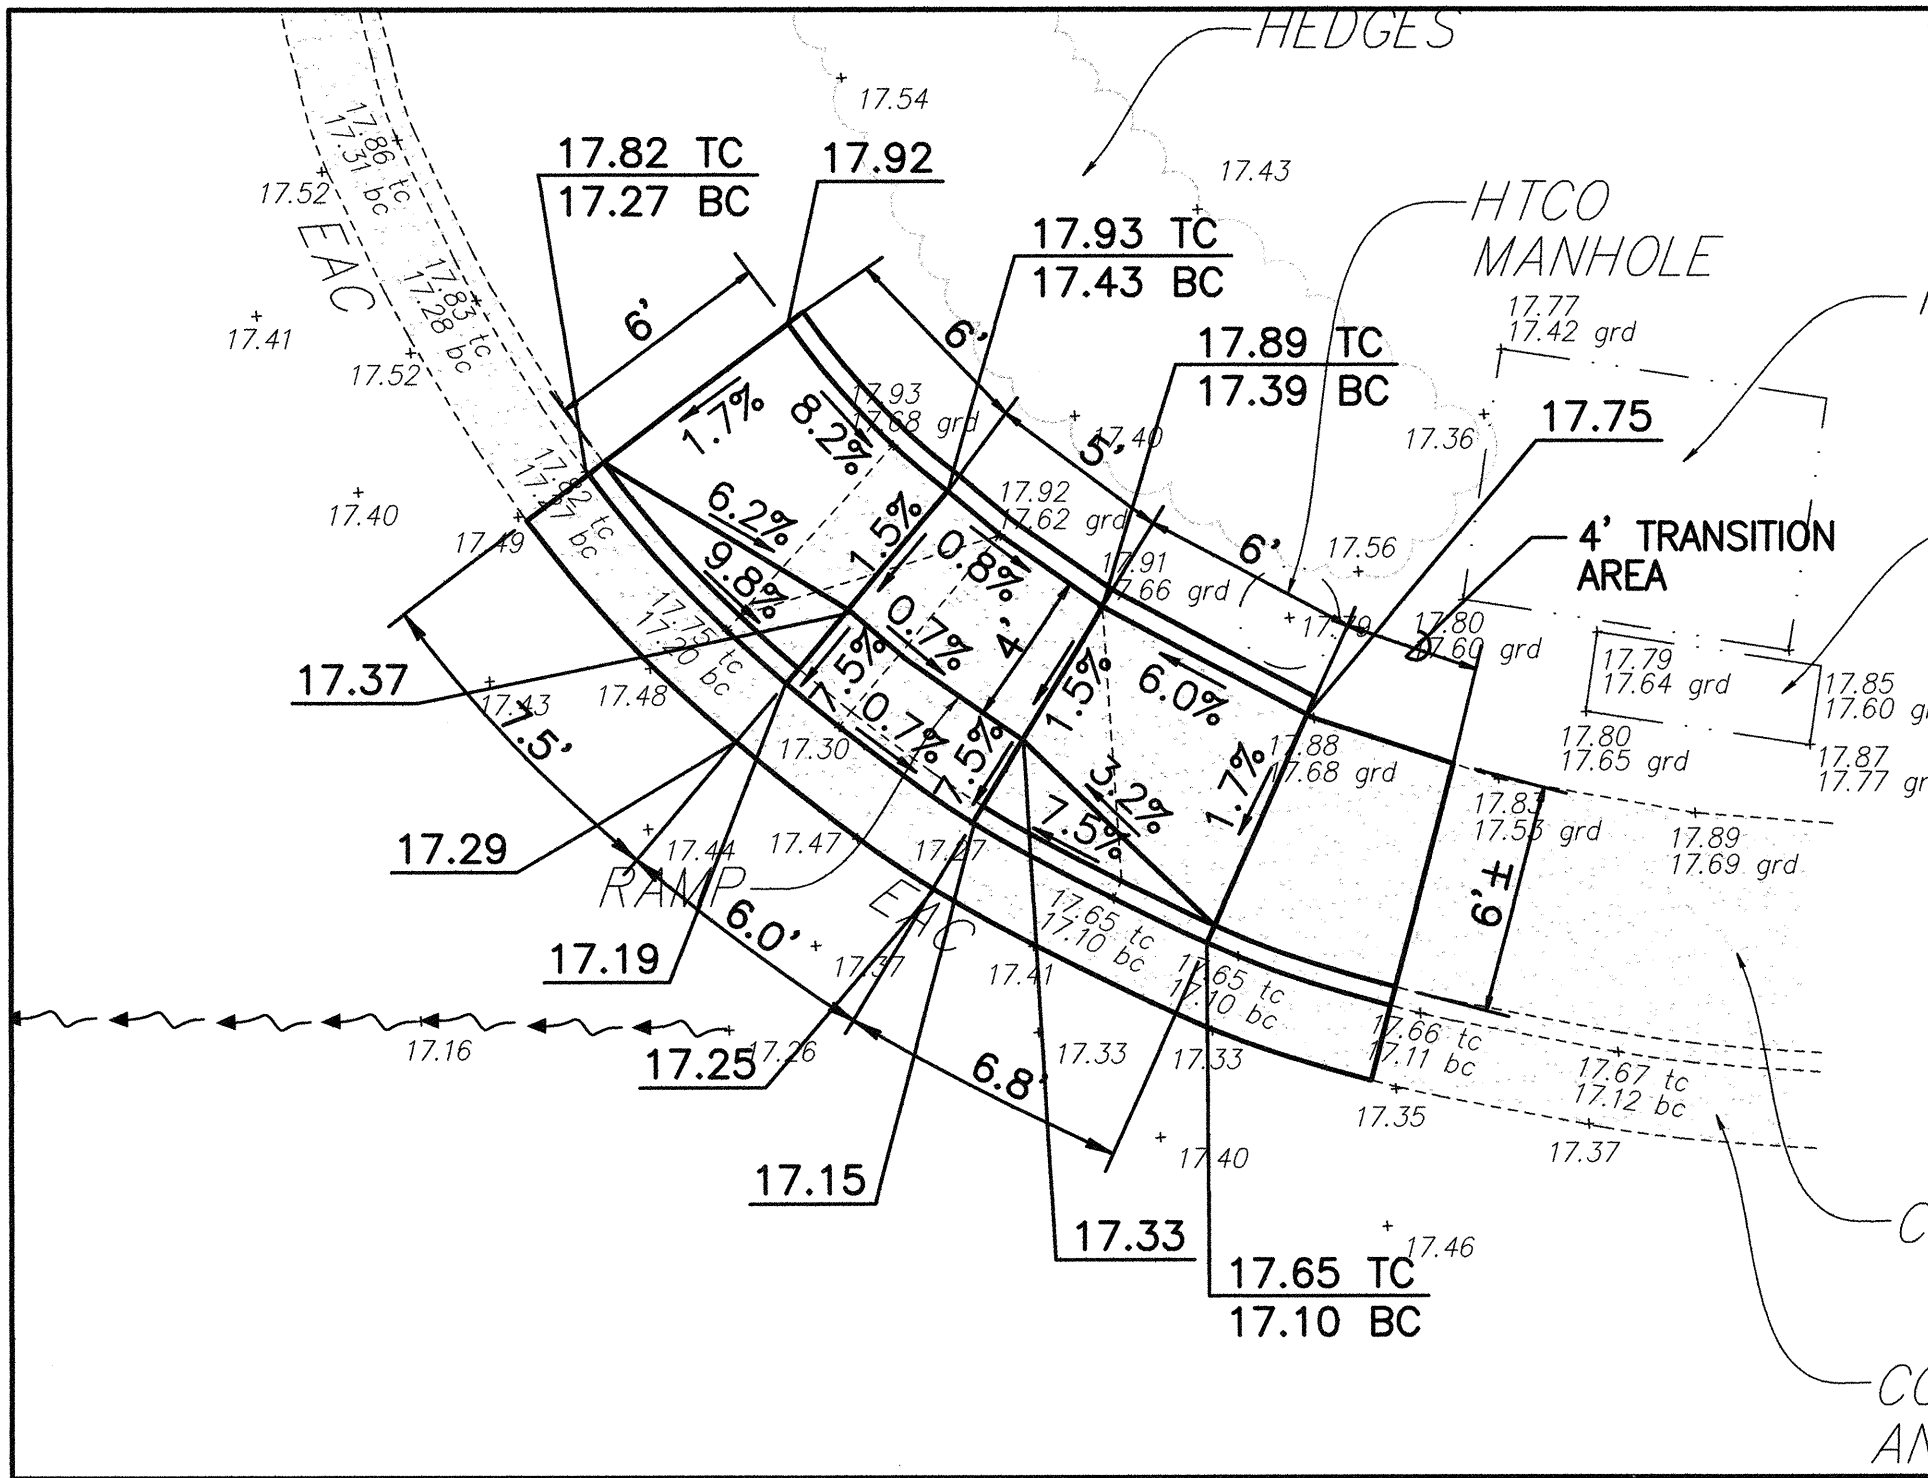

CURB RAMP NO. 20304-2 DETAILS
SCALE: 1"= 5'

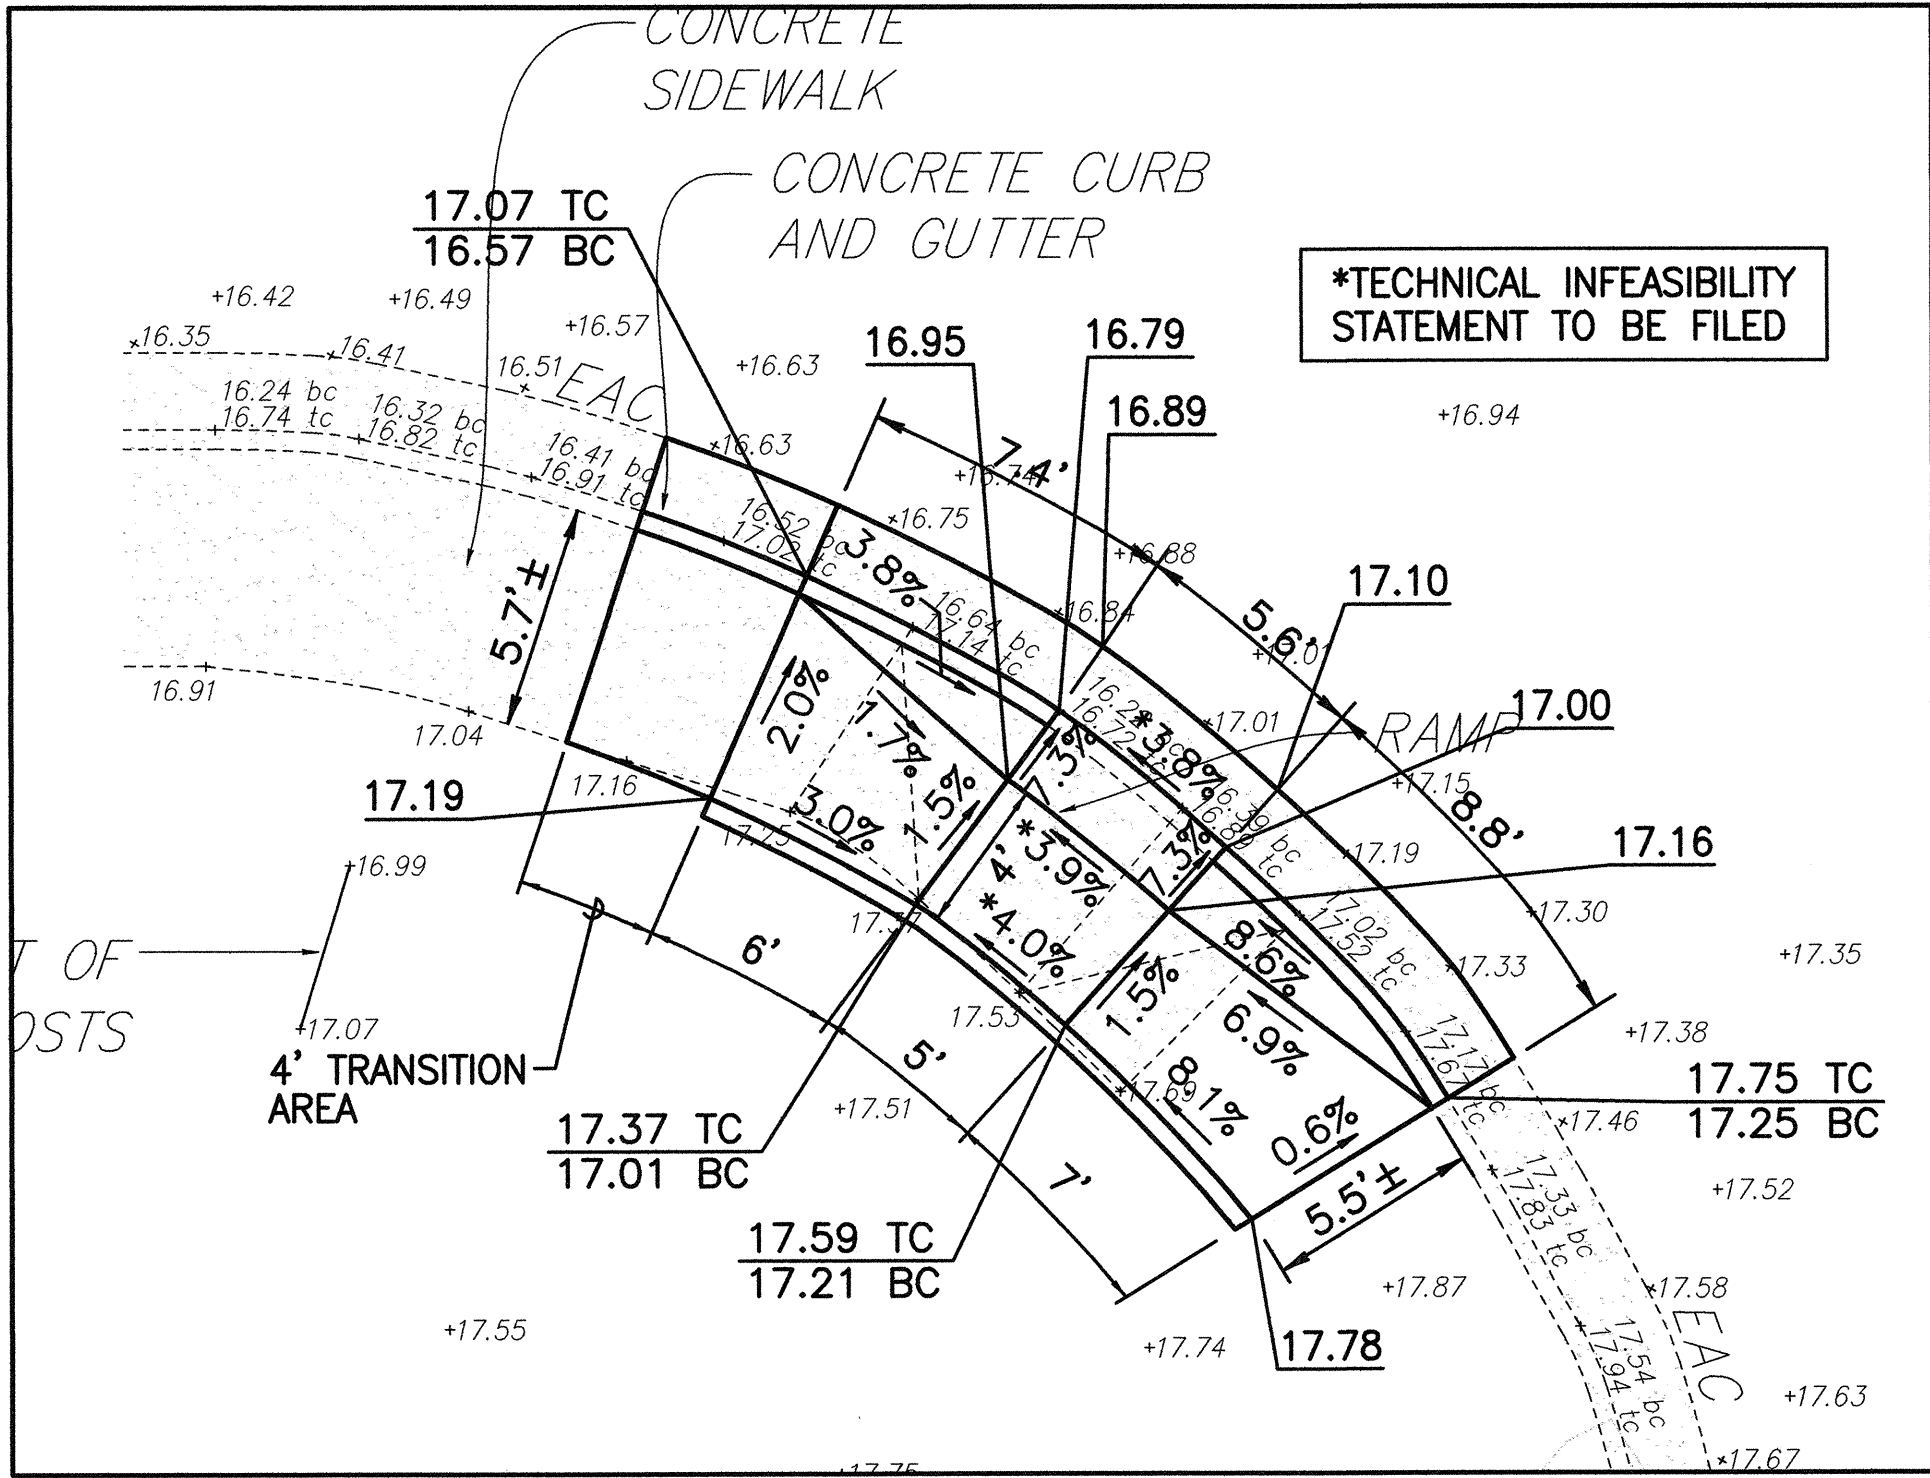

CURB RAMP NO. 20304-4 DETAILS
SCALE: 1"= 5'

NOTES:


- SEE SHEETS CB-1 TO CB-10 FOR CURB RAMP, STRIPING, AND MISCELLANEOUS DETAILS.
- FOR ALL ELECTRICAL WORK, SEE ELECTRICAL PLANS.

DATE	_____
SURVEY PLOTTED BY	_____
ORIGINAL PLAN	_____
TRACED BY	_____
NOTES BY	_____
QUANTITIES BY	_____
CHECKED BY	_____
No.	_____

DANIEL S. MIYASATO
LICENSED PROFESSIONAL ENGINEER
No. 3443-C
HAWAII U.S.A.


STATE OF HAWAII
DEPARTMENT OF TRANSPORTATION
HIGHWAYS DIVISION
KEOLANI PL./ PALAPALA DR. (20304)
CURB RAMP PLAN
PEDESTRIAN FACILITIES & ADA
COMPLIANCE AT VARIOUS
LOCATIONS ON MAUI
Federal - Aid Project No. CMAQ-0900(67)R
Scale: As Shown Date: August 2004
SHEET No. CC-5 OF 31 SHEETS

FED. ROAD DIST. NO.	STATE	FEDERAL - AID PROJ. NO.	FISCAL YEAR	SHEET NO.	TOTAL SHEETS
HAWAII	HAW.	CMAQ-0900(67)R	2004	27	109

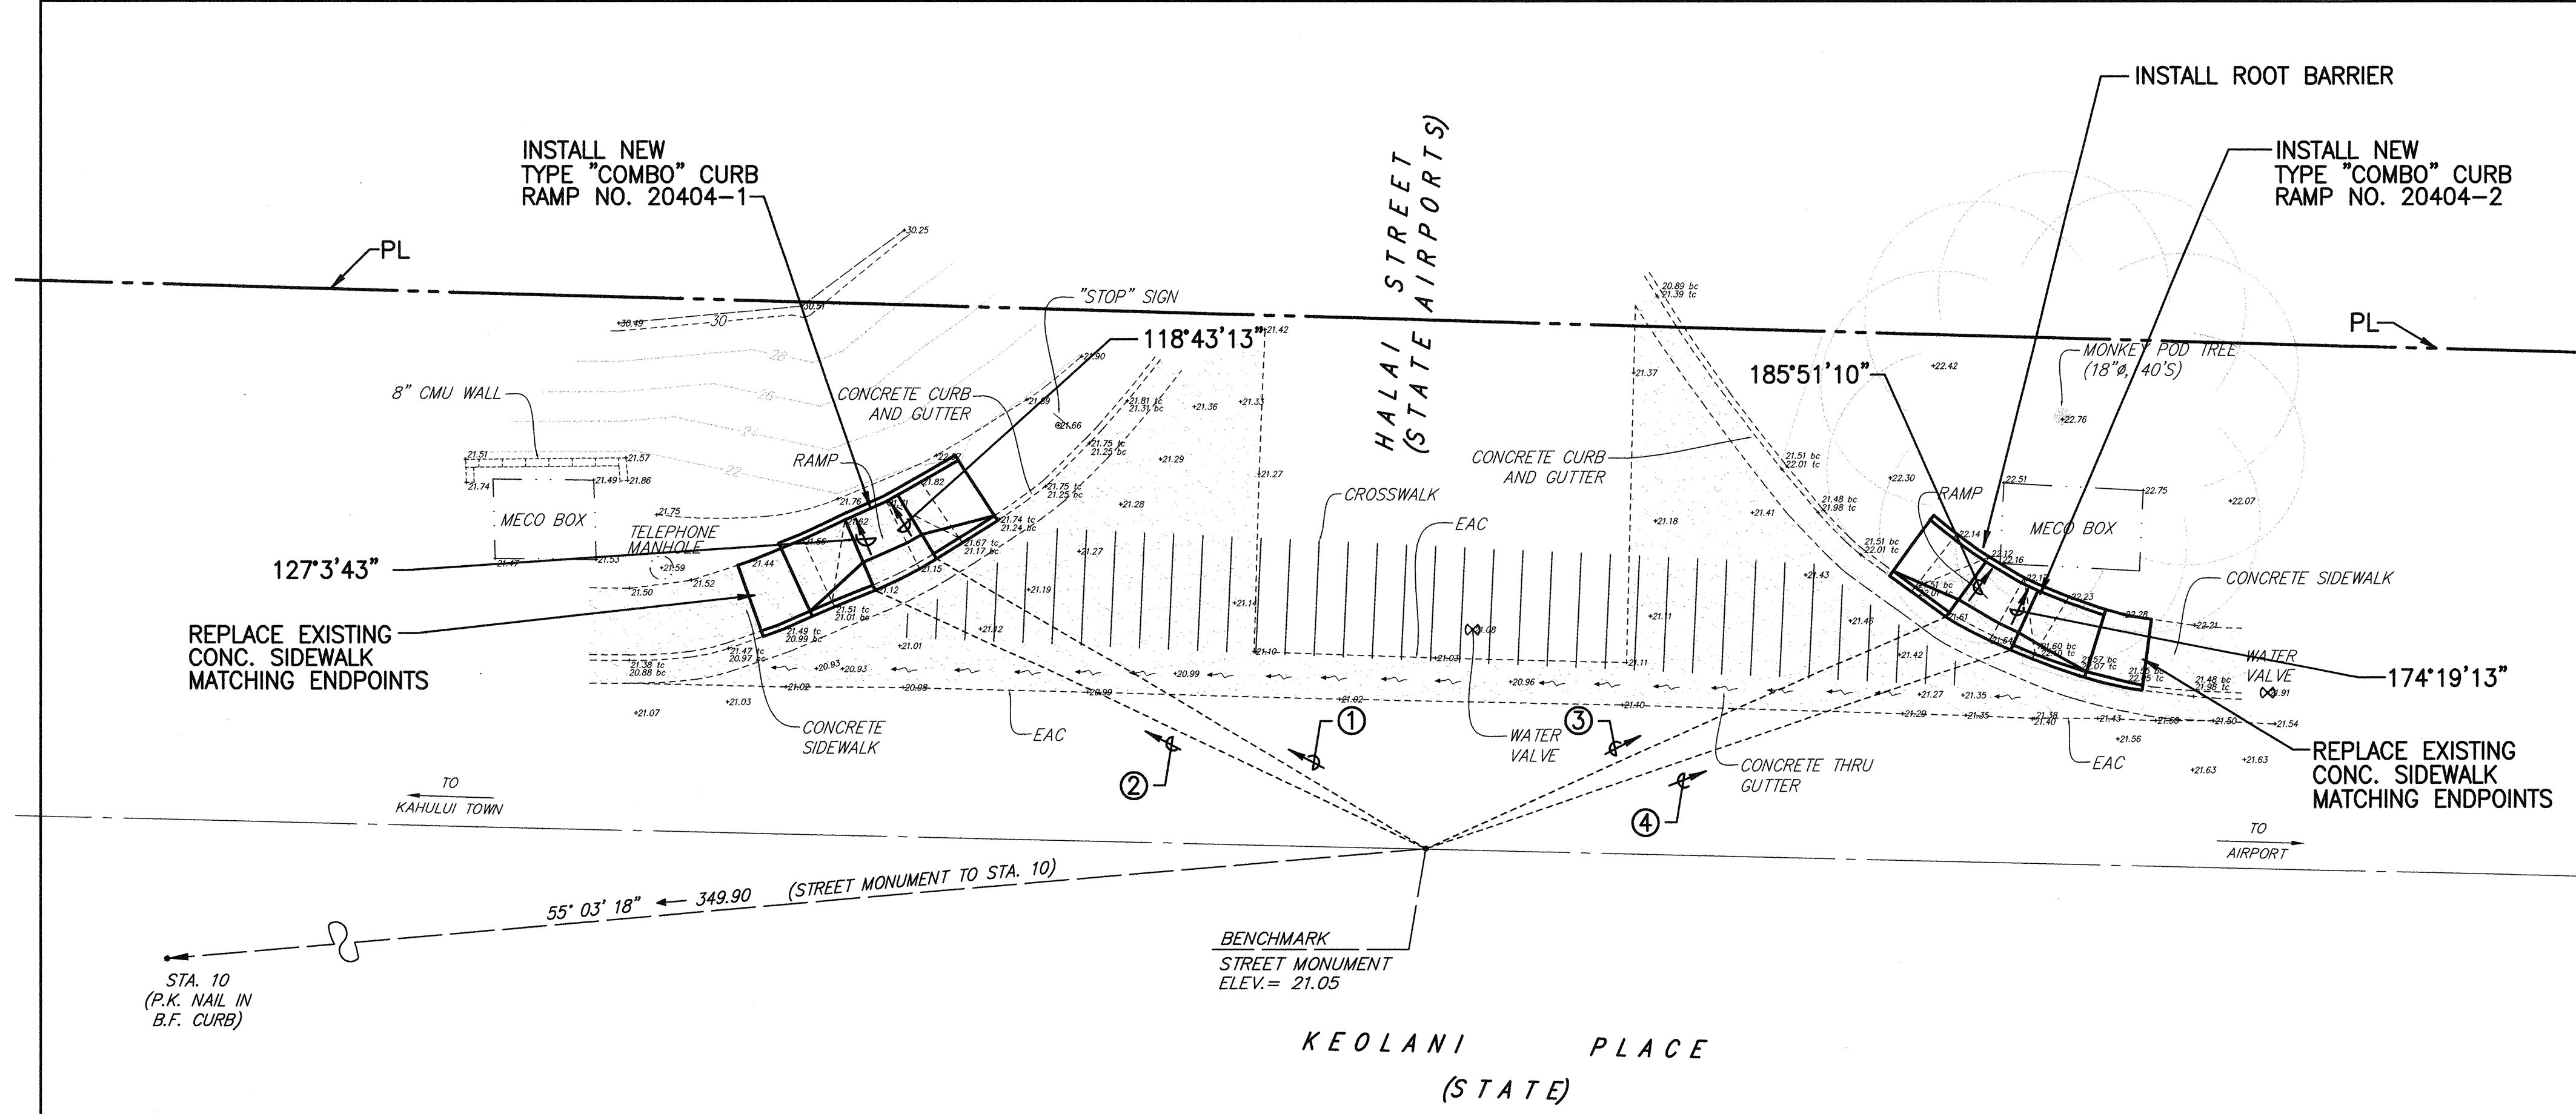


- ① 90°34'54" 48.77' (BM TO INTERSECTION OF RAMP EDGE & CURB FACE)
- ② 85°2'49" 52.18' (BM TO INTERSECTION OF RAMP EDGE & CURB FACE)
- ③ 216°2'57" 48.81' (BM TO INTERSECTION OF RAMP EDGE & CURB FACE)
- ④ 221°21'27" 52.95' (BM TO INTERSECTION OF RAMP EDGE & CURB FACE)

NOTE: CONTRACTOR TO CONTACT THE ARBORIST 2 WEEKS PRIOR TO DEMOLITION

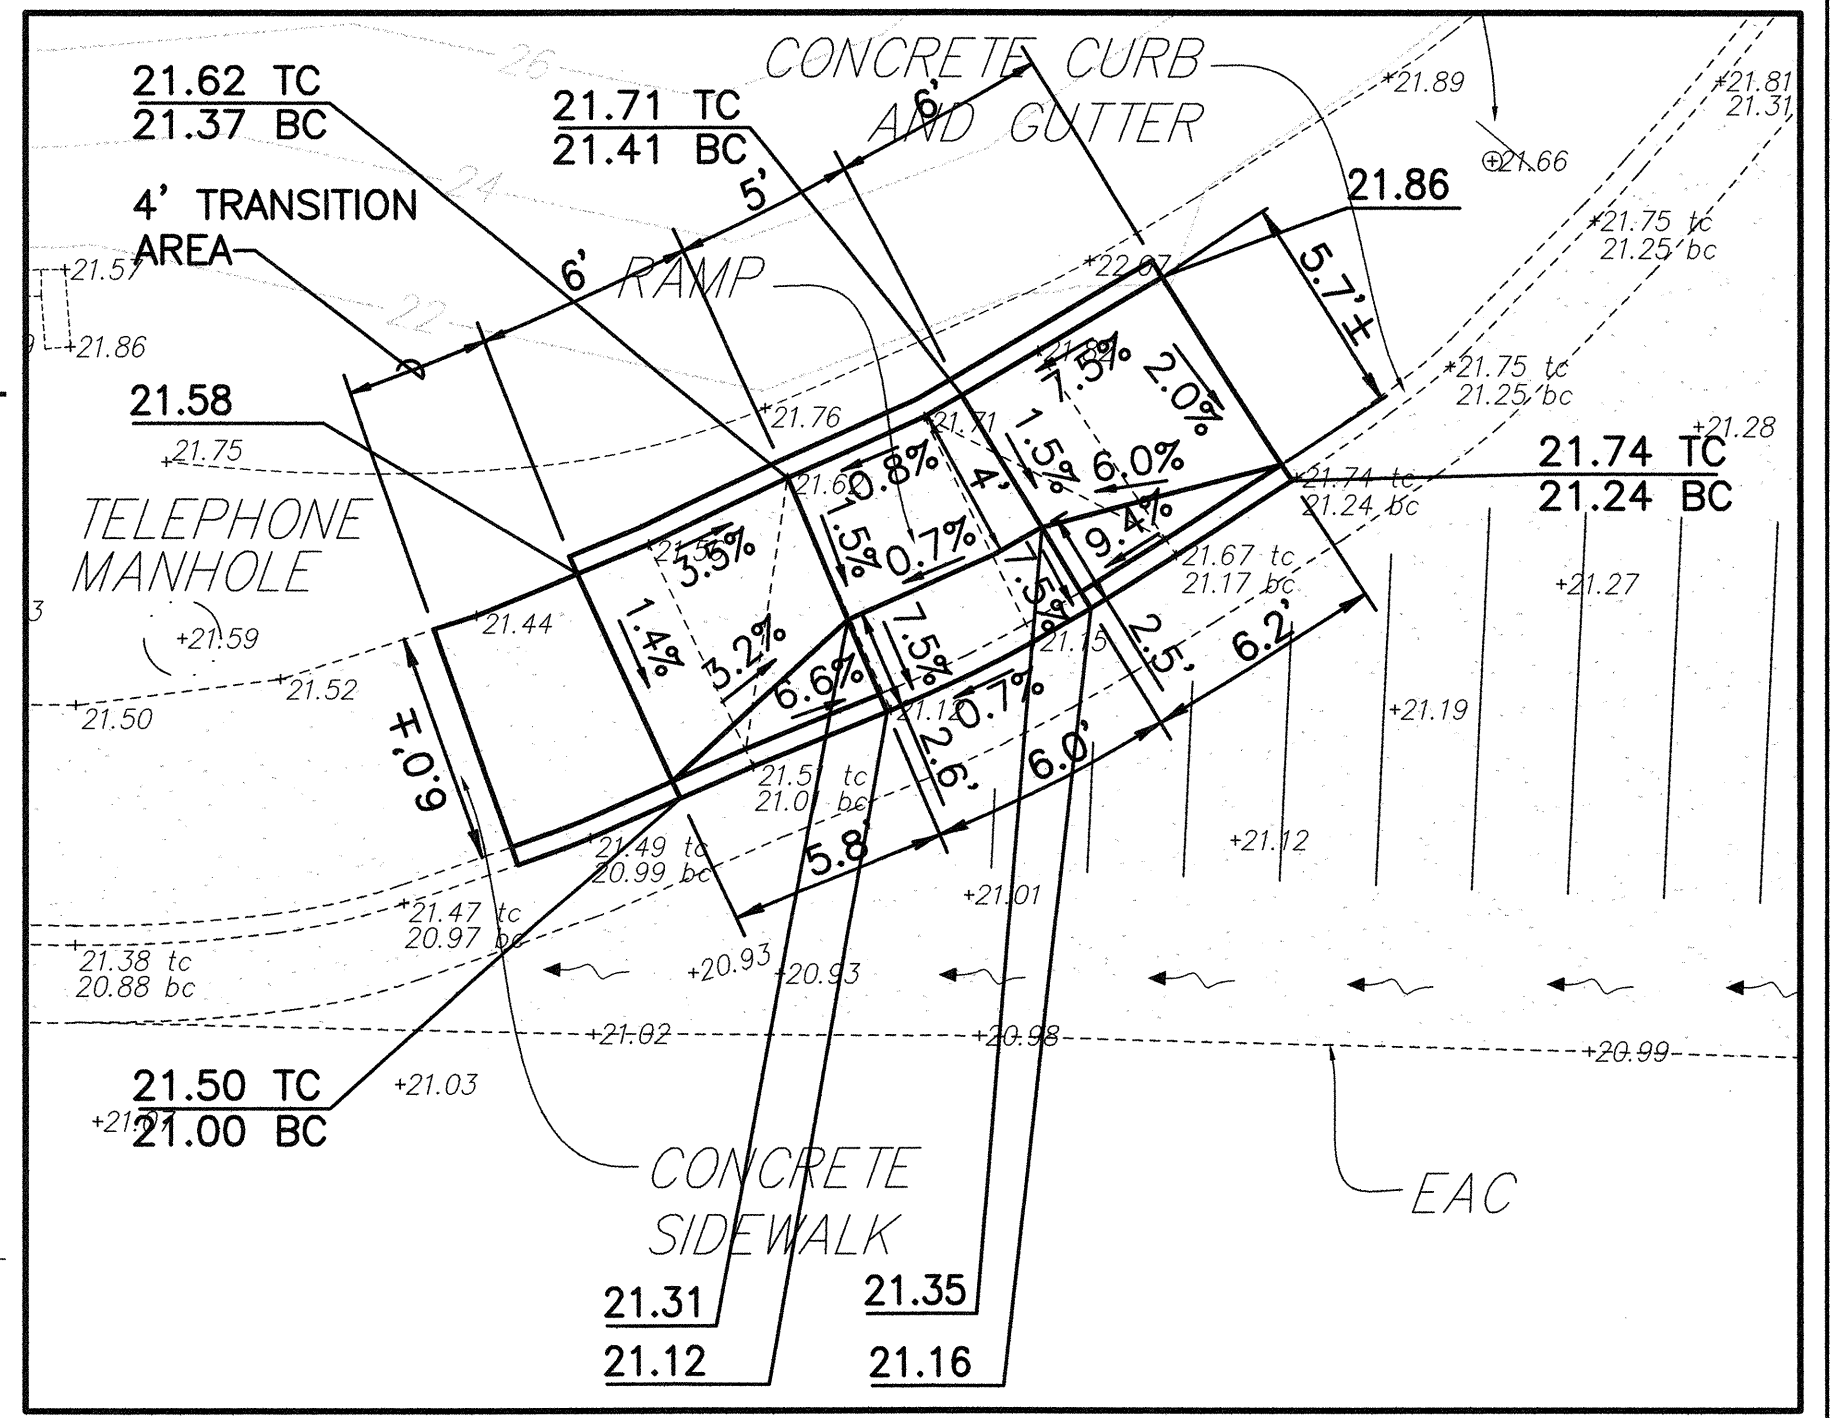

CURB RAMP NO. 20404-1 DETAILS
SCALE: 1"= 5'

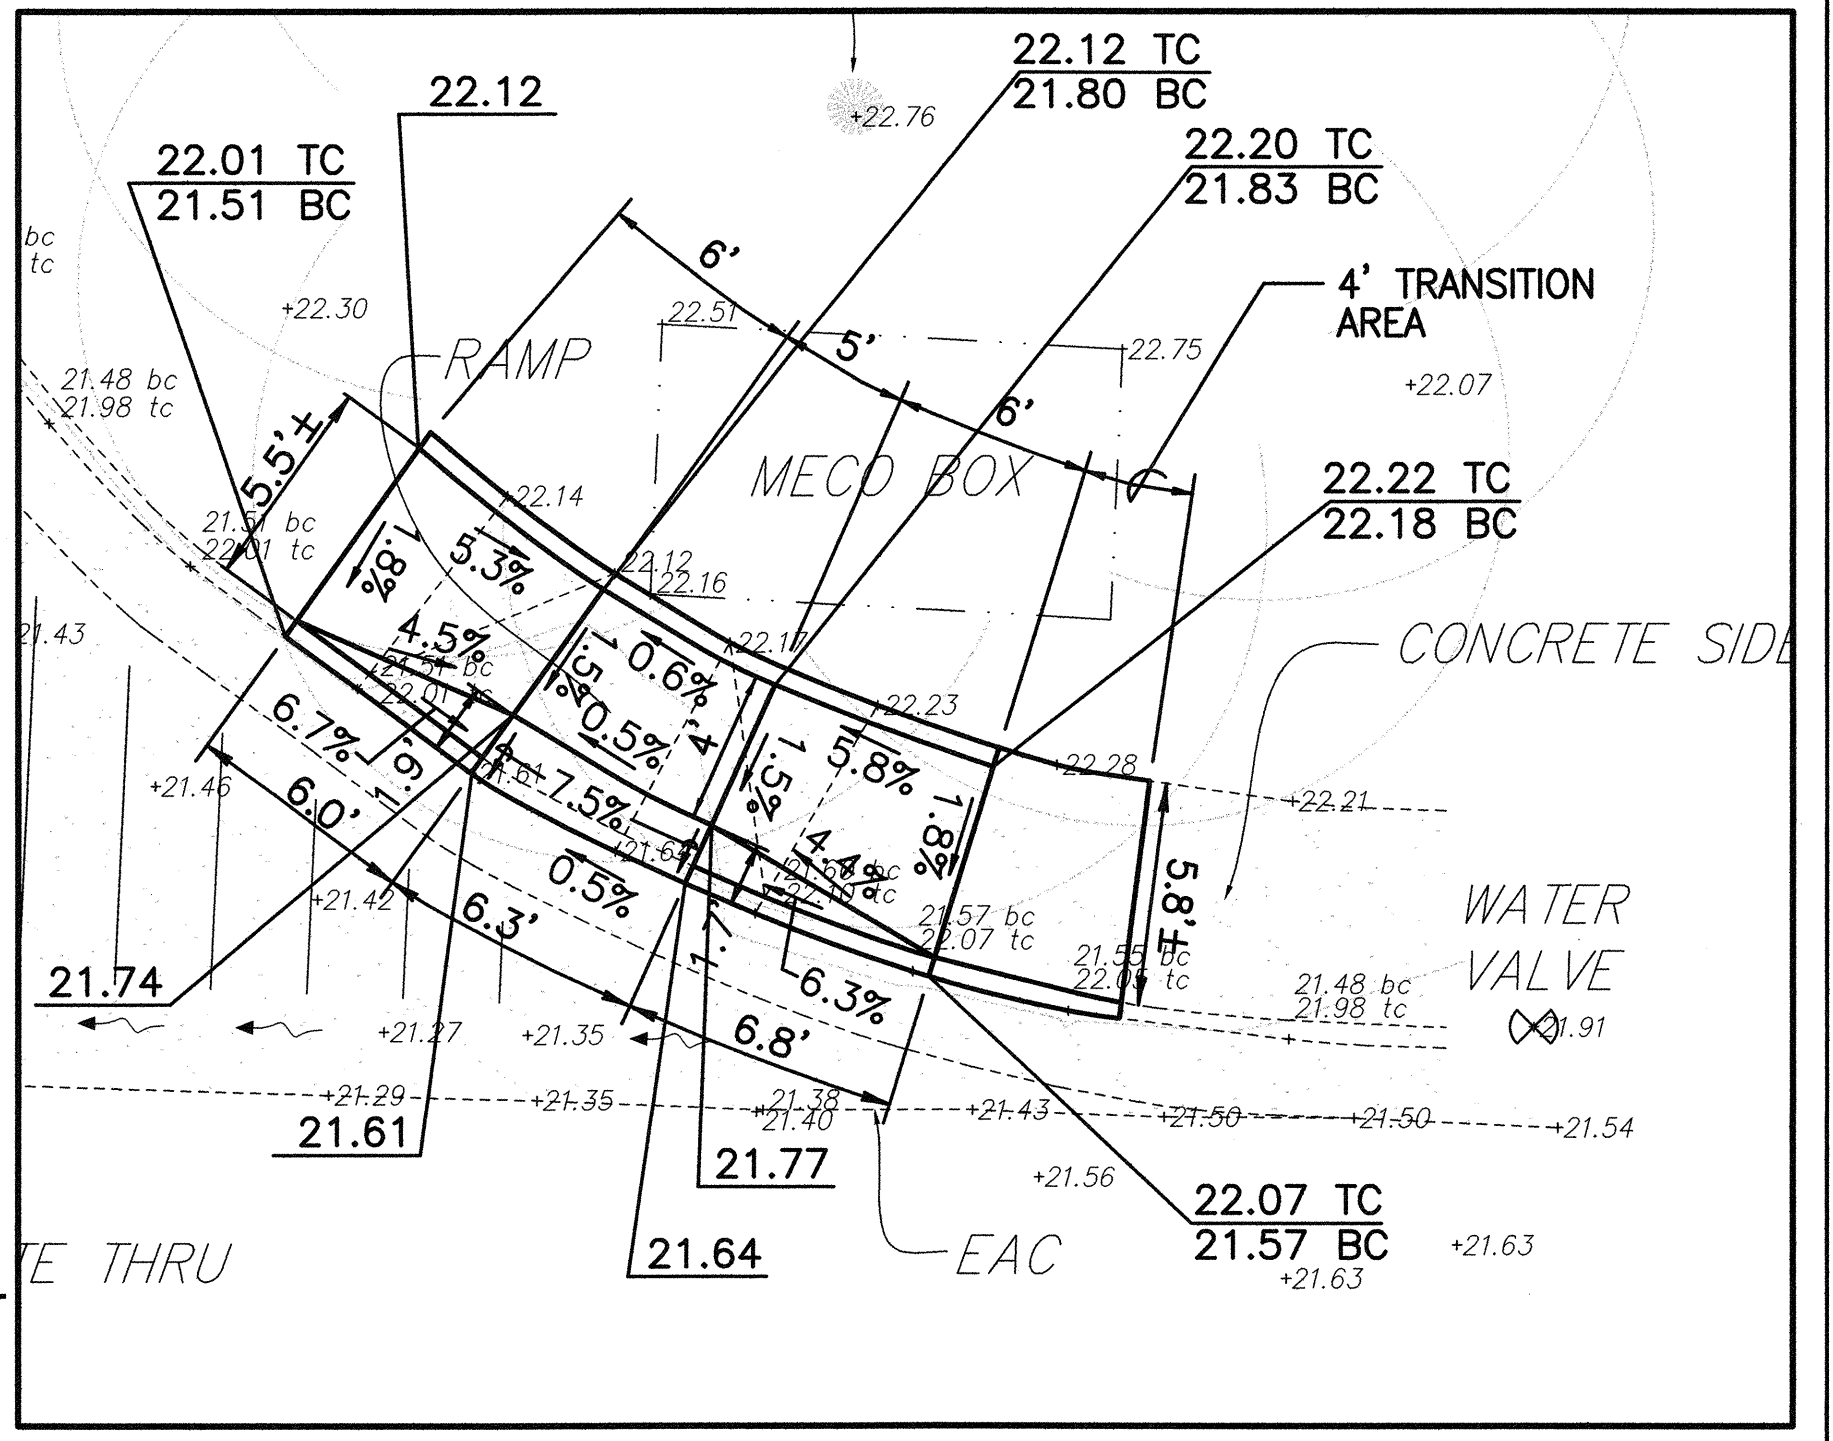

CURB RAMP NO. 20404-2 DETAILS
SCALE: 1"= 5'

- NOTES:
- 1. SEE SHEETS CB-1 TO CB-10 FOR CURB RAMP, STRIPING, AND MISCELLANEOUS DETAILS.
 - 2. FOR ALL ELECTRICAL WORK, SEE ELECTRICAL PLANS.

SITE PLAN
SCALE: 1"= 10'


STATE OF HAWAII
DEPARTMENT OF TRANSPORTATION
HIGHWAYS DIVISION
KEOLANI/ HALAI ST. (20404)
CURB RAMP PLAN
PEDESTRIAN FACILITIES & ADA
COMPLIANCE AT VARIOUS
LOCATIONS ON MAUI
Federal - Aid Project No. CMAQ-0900(67)R
Scale: As Shown Date: August 2004
SHEET No. CC-6 OF 31 SHEETS

DANIEL S. MIYASATO
LICENSED PROFESSIONAL ENGINEER
No. 3443-C
HAWAII U.S.A.

THIS WORK WAS PREPARED BY ME OR UNDER MY SUPERVISION
04/30/06
EXPIRATION DATE OF THE LICENSE 12-31-04


ORIGINAL PLAN	SURVEY PLOTTED BY	DATE
NOTE BOOK	DRAWN BY	
DESIGNED BY		
CHECKED BY		
No.		

FED. ROAD DIST. NO.	STATE	FEDERAL - AID PROJ. NO.	FISCAL YEAR	SHEET NO.	TOTAL SHEETS
HAWAII	HAW.	CMAQ-0900(67)R	2004	28	109

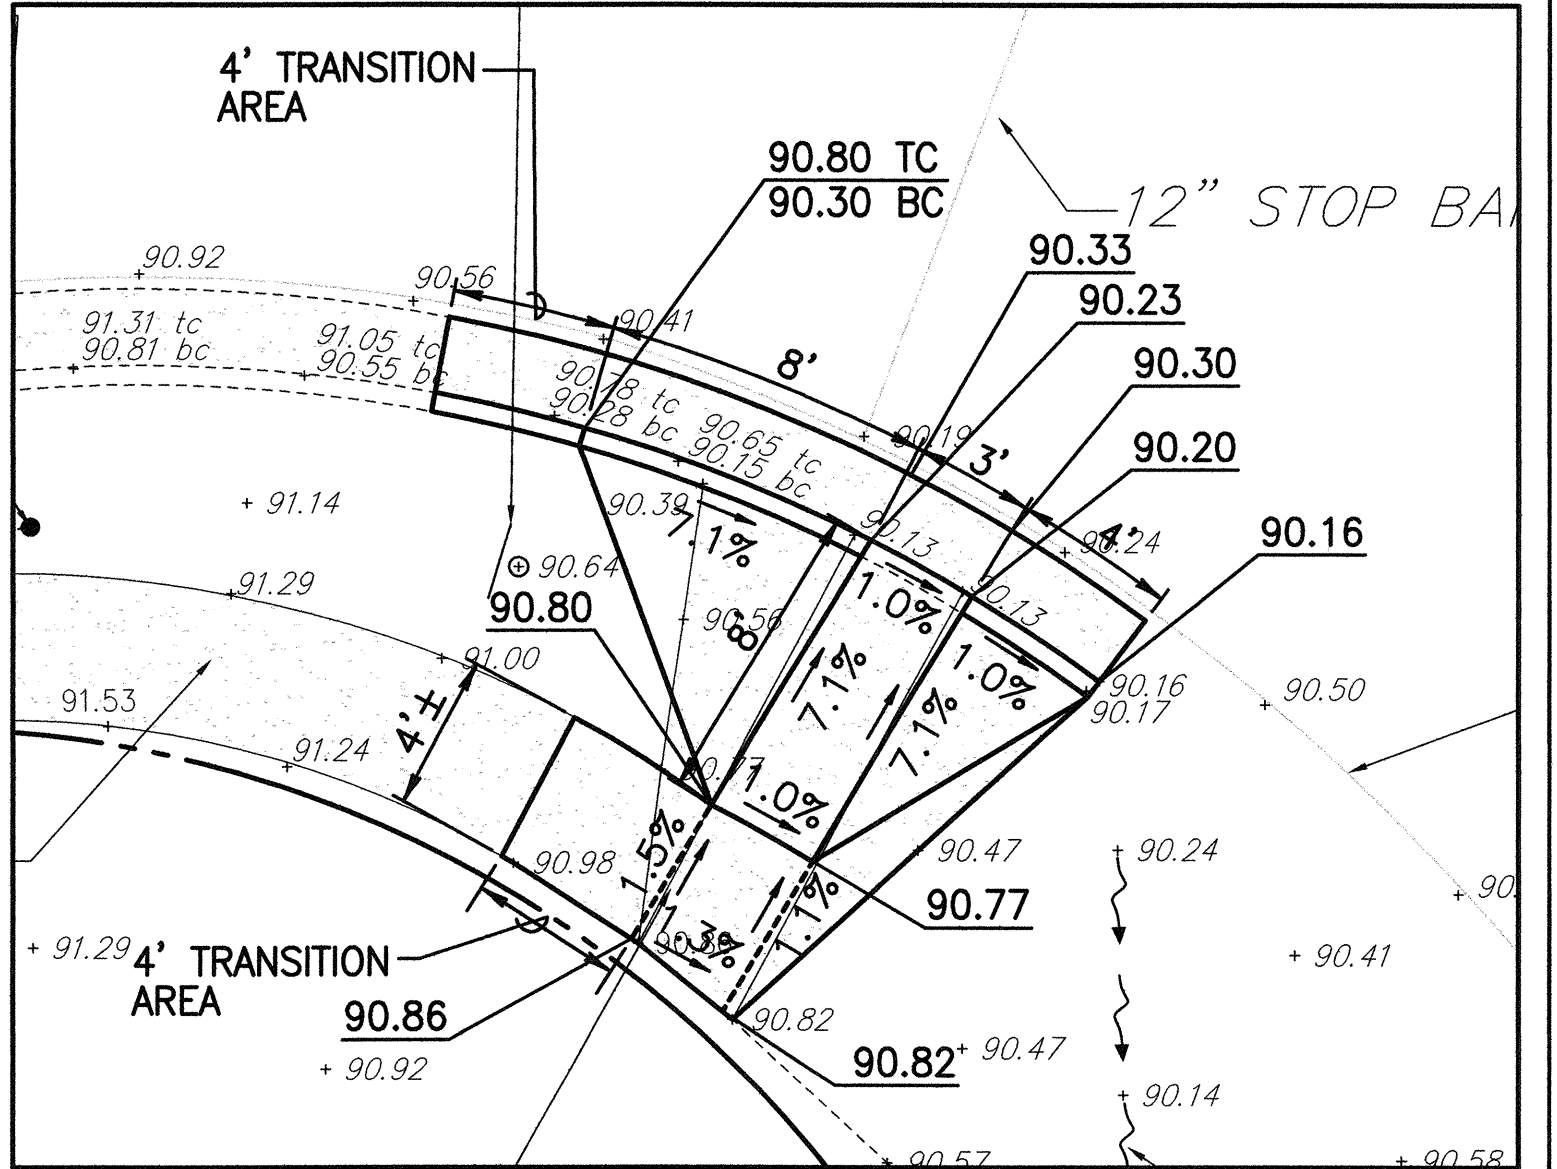

CURB RAMP NO. 22304-1 DETAILS
SCALE: 1"= 5'

- NOTES:**
- SEE SHEETS CB-1 TO CB-10 FOR CURB RAMP, STRIPING, AND MISCELLANEOUS DETAILS.
 - FOR ALL ELECTRICAL WORK, SEE ELECTRICAL PLANS.

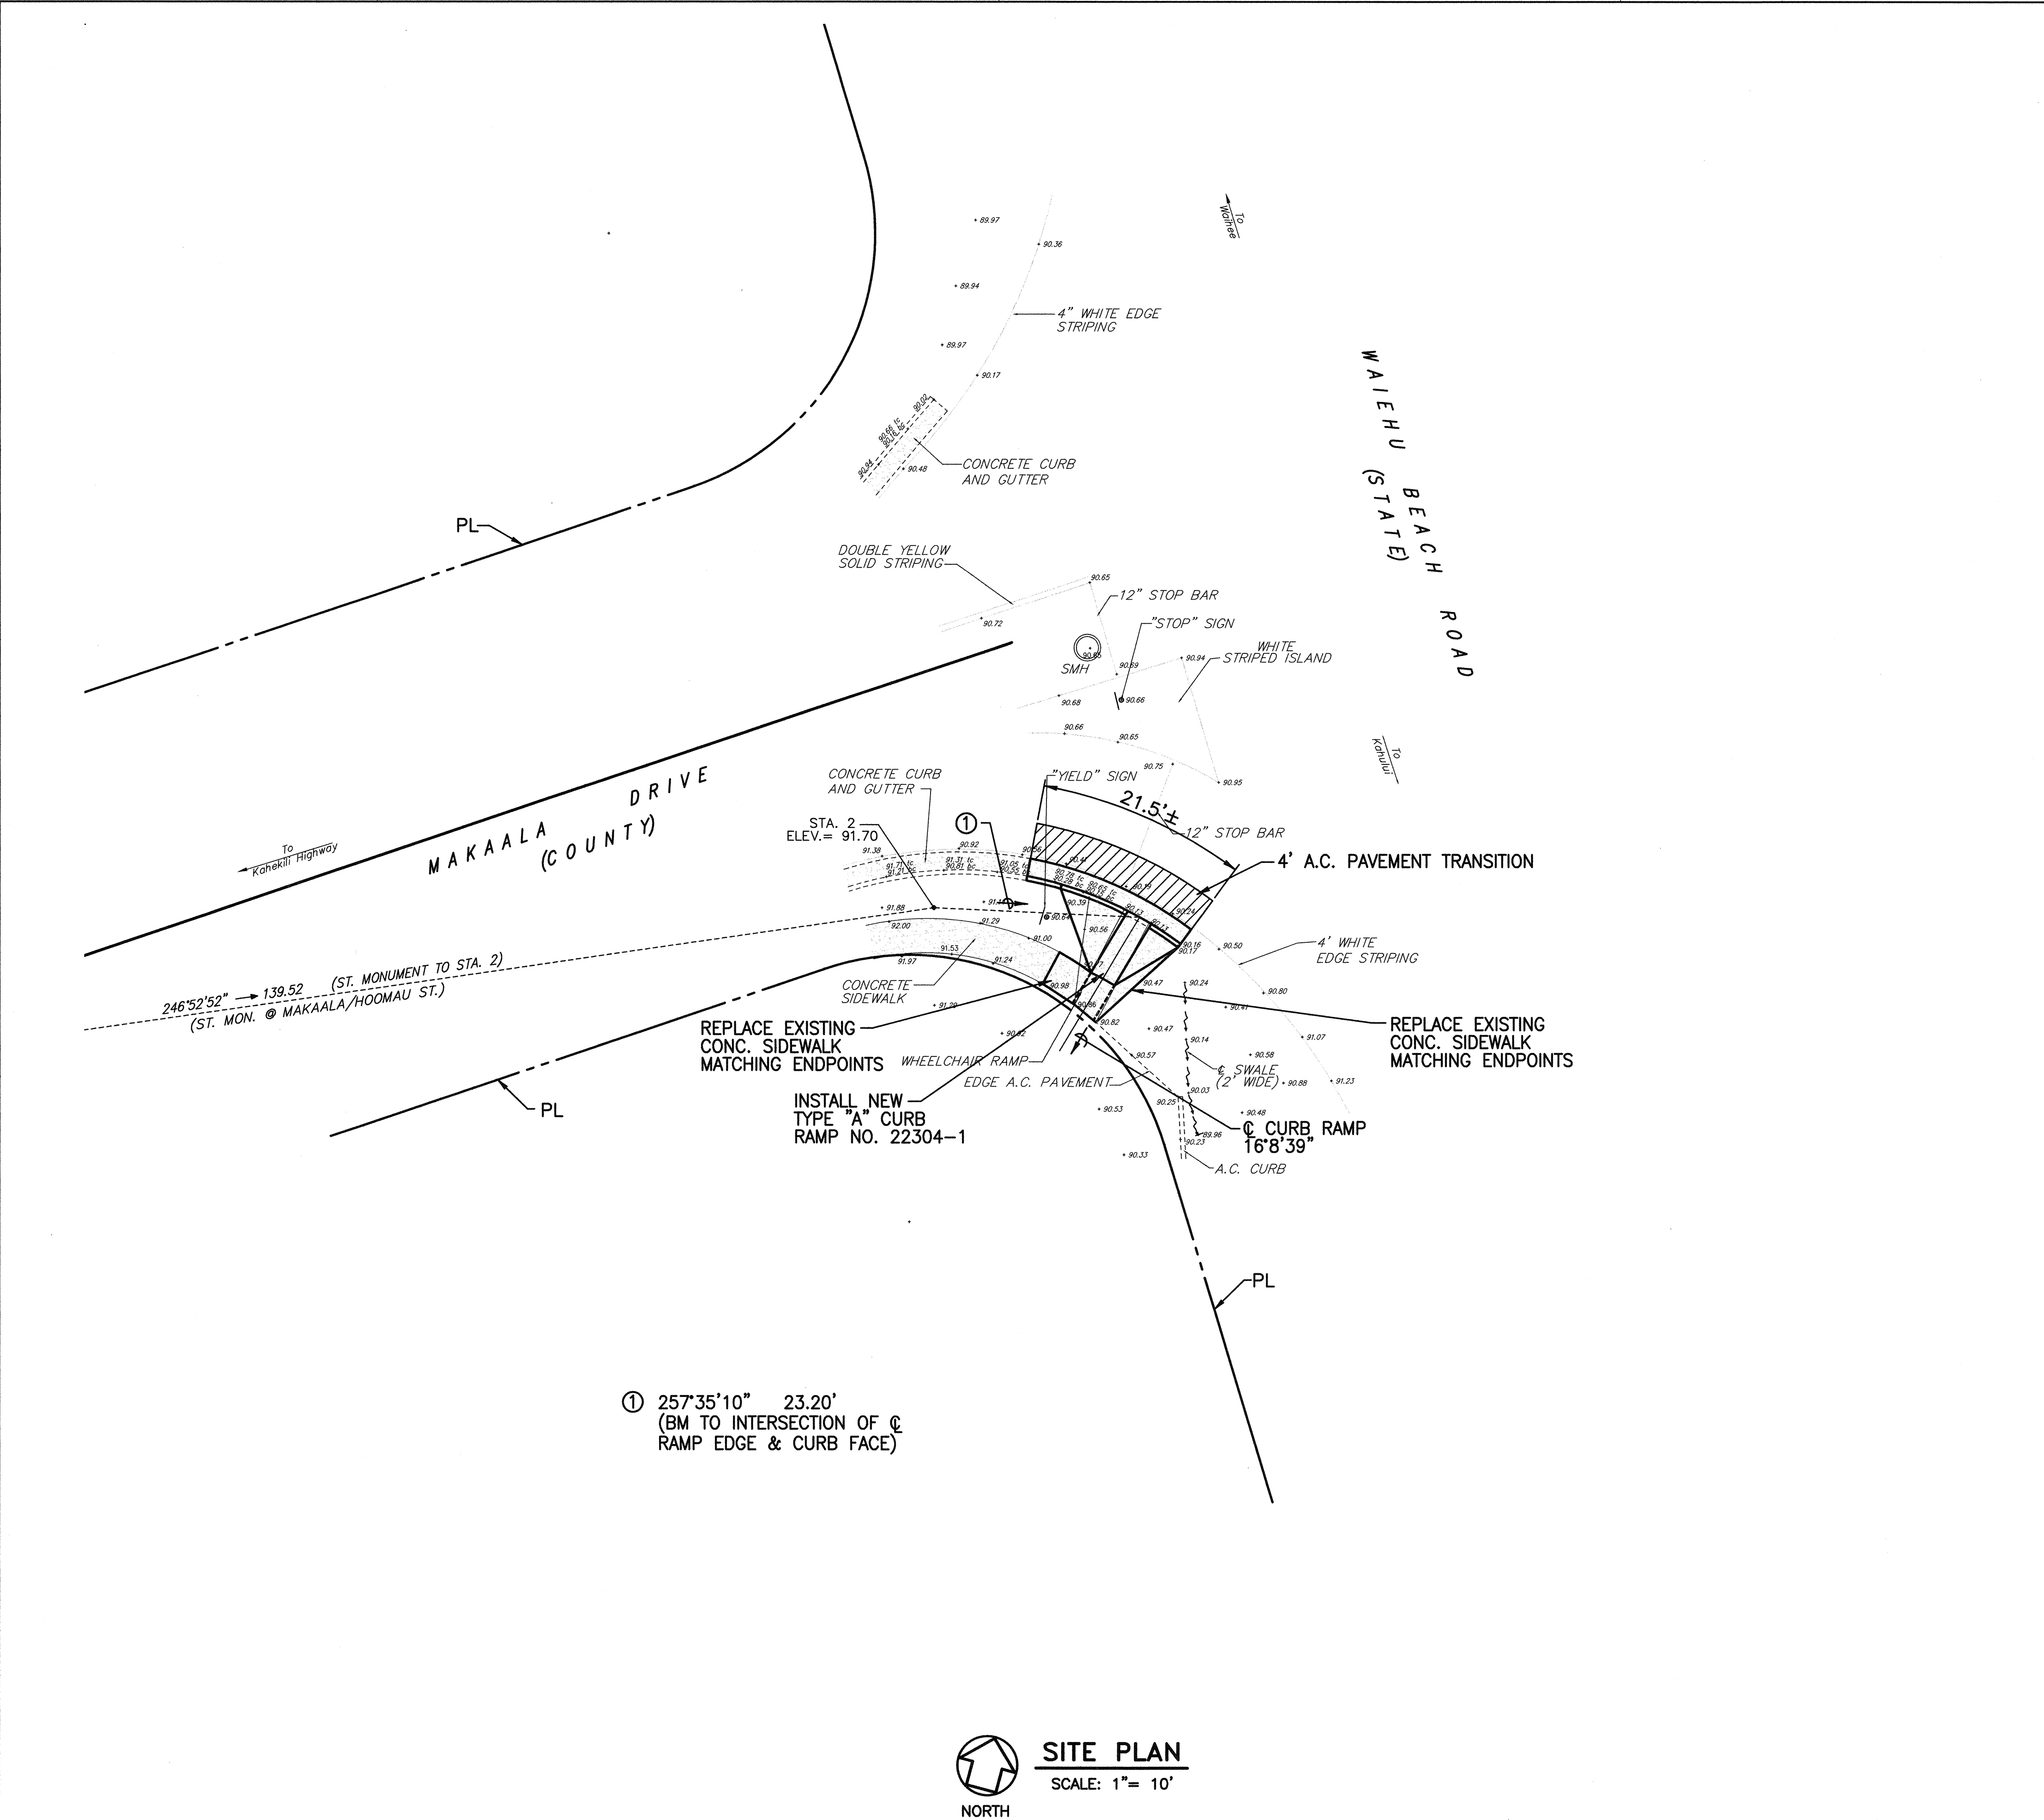


SITE PLAN
SCALE: 1"= 10'

STATE OF HAWAII
DEPARTMENT OF TRANSPORTATION
HIGHWAYS DIVISION
WAIIEHU BEACH RD./ MAKAALA DR. (22304)
CURB RAMP PLAN
PEDESTRIAN FACILITIES & ADA
COMPLIANCE AT VARIOUS
LOCATIONS ON MAUI
Federal - Aid Project No. CMAQ-0900(67)R
Scale: As Shown Date: August 2004
SHEET No. CC-7 OF 31 SHEETS

DANIEL S. MIYASHIRO
LICENSED PROFESSIONAL ENGINEER
No. 3443-C
HAWAII U.S.A.
THIS WORK WAS PREPARED BY ME OR UNDER MY SUPERVISION
04/30/06
EXPIRATION DATE OF THE LICENSE
1-22-04

ORIGINAL PLAN	DATE
NOTE BOOK	
DESIGNED BY	
QUANTITIES BY	
CHECKED BY	
No.	

FED. ROAD DIST. NO.	STATE	FEDERAL - AID PROJ. NO.	FISCAL YEAR	SHEET NO.	TOTAL SHEETS
HAWAII	HAW.	CMAQ-0900(67)2	2004	29	109

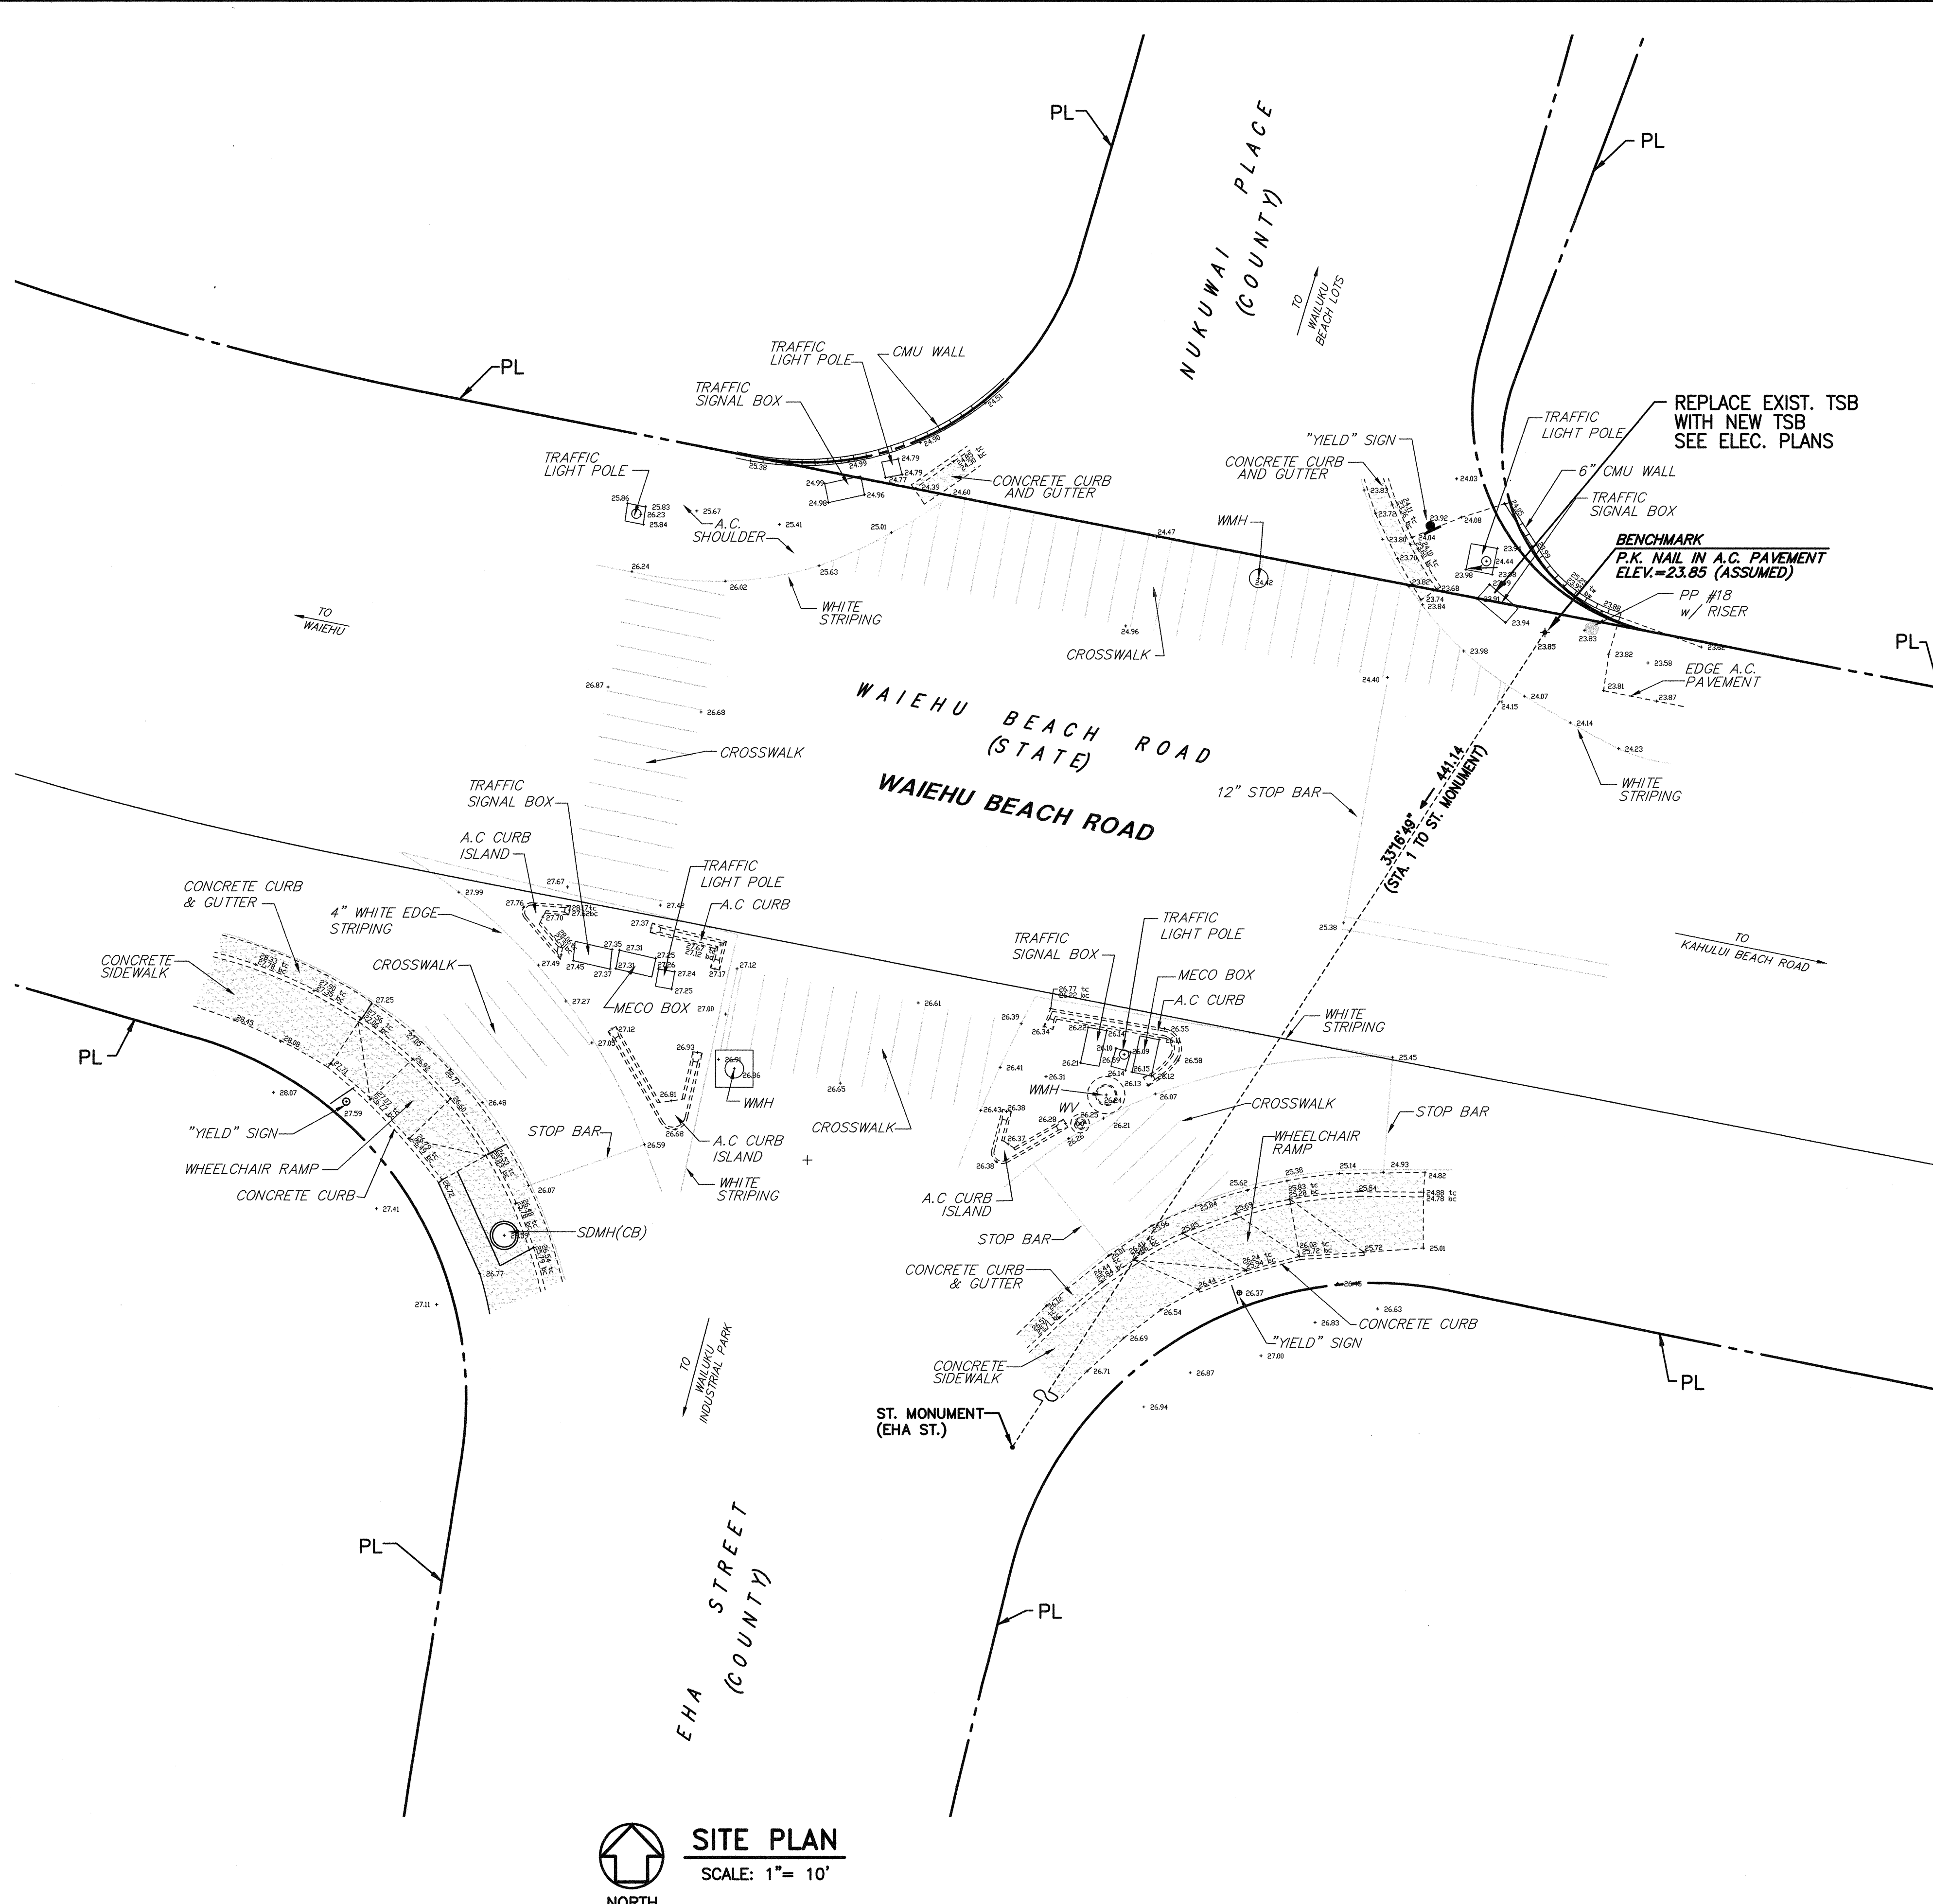

NOTES:

1. SEE SHEETS CB-1 TO CB-10 FOR CURB RAMP, STRIPING, AND MISCELLANEOUS DETAILS.
2. FOR ALL ELECTRICAL WORK, SEE ELECTRICAL PLANS.

ORIGINAL PLAN	SURVEY PLOTTED BY _____ DATE _____
NOTE BOOK	DRAWN BY _____
	TRACED BY _____
	DESIGNED BY _____
	QUANTITIES BY _____
No. _____	CHECKED BY _____



SITE PLAN

SCALE: 1" = 10'



THIS WORK WAS PREPARED BY
ME OR UNDER MY SUPERVISION

04/30/06

EXPIRATION DATE OF THE LICENSE

18 9-22-04

STATE OF HAWAII
DEPARTMENT OF TRANSPORTATION
HIGHWAYS DIVISION
WAIHEHU ROAD RD. / EHA ST. (22904)
CURB RAMP PLAN
PEDESTRIAN FACILITIES & ADA
COMPLIANCE AT VARIOUS
LOCATIONS ON MAUI
Federal - Aid Project No. CMAQ-0900(67)
le: As Shown Date: August 2004
SHEET No. CC-8 OF 31 SHEETS

INSTALL NEW PPB & PEDESTAL
SEE ELECTRICAL PLANS

INSTALL NEW
TYPE "A" CURB
RAMP NO. 32204-3

4.5'x4.5' CONC.
BOX

12" WIDE WHITE
STOP BAR

REMOVE EXIST. STOP BAR

INSTALL INLET PROTECTION
SEE DET. SHT. CA-7

CONC. CURB
AND GUTTER

WHITE STRIPING

CONC. CURB
AND GUTTER

10' WIDE
CROSSWALK
MARKINGS

REMOVE EXIST.
CROSSWALK MARKINGS

4' A.C. PAVEMENT TRANSITION

LOWER MAIN STREET
(STATE)

WAIERU BEACH ROAD
(STATE)

KAHULUI BEACH ROAD
(STATE)

123'55'2" 97.27'
(BM TO INTERSECTION OF C
RAMP EDGE & CURB FACE)

NOTES:

1. SEE SHEETS
MISCELLANEOUS
2. FOR ALL ELE

DANIEL S. MIYAKI
LICENSED
PROFESSIONAL
ENGINEER
No. 3443-C
HAWAII, U.S.A.

THIS WORK WAS PREPARED
BY ME OR UNDER MY SUPERVISION

04/30/06

INSTALL NEW PPB & PEDESTAL
SEE ELECTRICAL PLANS

INSTALL NEW
TYPE "A" CURB
RAMP NO. 32204-3

4.5'x4.5' CONC.
BOX

12" WIDE WHITE
STOP BAR

REMOVE EXIST. STOP BAR

INSTALL INLET PROTECTION
SEE DET. SHT. CA-7

CONC. CURB
AND GUTTER

WHITE STRIPING

CONC. CURB
AND GUTTER

10' WIDE
CROSSWALK
MARKINGS

REMOVE EXIST.
CROSSWALK MARKINGS

4' A.C. PAVEMENT TRANSITION

LOWER MAIN STREET
(STATE)

WAIERU BEACH ROAD
(STATE)

KAHULUI BEACH ROAD
(STATE)

123'55'2" 97.27'
(BM TO INTERSECTION OF C
RAMP EDGE & CURB FACE)

NOTES:

1. SEE SHEETS
MISCELLANEOUS
2. FOR ALL ELE

DANIEL S. MIYAKI
LICENSED
PROFESSIONAL
ENGINEER
No. 3443-C
HAWAII, U.S.A.

THIS WORK WAS PREPARED
BY ME OR UNDER MY SUPERVISION

04/30/06

INSTALL NEW PPB & PEDESTAL
SEE ELECTRICAL PLANS

INSTALL NEW
TYPE "A" CURB
RAMP NO. 32204-3

4.5'x4.5' CONC.
BOX

12" WIDE WHITE
STOP BAR

REMOVE EXIST. STOP BAR

INSTALL INLET PROTECTION
SEE DET. SHT. CA-7

CONC. CURB
AND GUTTER

WHITE STRIPING

CONC. CURB
AND GUTTER

10' WIDE
CROSSWALK
MARKINGS

REMOVE EXIST.
CROSSWALK MARKINGS

4' A.C. PAVEMENT TRANSITION

LOWER MAIN STREET
(STATE)

WAIERU BEACH ROAD
(STATE)

KAHULUI BEACH ROAD
(STATE)

123'55'2" 97.27'
(BM TO INTERSECTION OF C
RAMP EDGE & CURB FACE)

NOTES:

1. SEE SHEETS
MISCELLANEOUS
2. FOR ALL ELE

DANIEL S. MIYAKI
LICENSED
PROFESSIONAL
ENGINEER
No. 3443-C
HAWAII, U.S.A.

THIS WORK WAS PREPARED
BY ME OR UNDER MY SUPERVISION

04/30/06

-
- INSTALL NEW PPB & PEDESTAL
SEE ELECTRICAL PLANS
- INSTALL NEW
TYPE "A" CURB
RAMP NO. 32204-3
- 4.5'x4.5' CONC.
BOX
- 12" WIDE WHITE
STOP BAR
- REMOVE EXIST. STOP BAR
- INSTALL INLET PROTECTION
SEE DET. SHT. CA-7
- CONC. CURB
AND GUTTER
- WHITE STRIPING
- CONC. CURB
AND GUTTER
- 10' WIDE
CROSSWALK
MARKINGS
- REMOVE EXIST.
CROSSWALK MARKINGS
- 4' A.C. PAVEMENT TRANSITION
- LOWER MAIN STREET
(STATE)
- WAIERU BEACH ROAD
(STATE)
- KAHULUI BEACH ROAD
(STATE)
- 123'55'2" 97.27'
(BM TO INTERSECTION OF C
RAMP EDGE & CURB FACE)
- NOTES:
1. SEE SHEETS
MISCELLANEOUS
 2. FOR ALL ELE
- DANIEL S. MIYAKI
LICENSED
PROFESSIONAL
ENGINEER
No. 3443-C
HAWAII, U.S.A.
- THIS WORK WAS PREPARED
BY ME OR UNDER MY SUPERVISION
- 04/30/06

INSTALL NEW PPB & PEDESTAL
SEE ELECTRICAL PLANS

INSTALL NEW
TYPE "A" CURB
RAMP NO. 32204-3

4.5'x4.5' CONC.
BOX

12" WIDE WHITE
STOP BAR

REMOVE EXIST. STOP BAR

INSTALL INLET PROTECTION
SEE DET. SHT. CA-7

CONC. CURB
AND GUTTER

WHITE STRIPING

CONC. CURB
AND GUTTER

10' WIDE
CROSSWALK
MARKINGS

REMOVE EXIST.
CROSSWALK MARKINGS

4' A.C. PAVEMENT TRANSITION

LOWER MAIN STREET
(STATE)

WAIERU BEACH ROAD
(STATE)

KAHULUI BEACH ROAD
(STATE)

123'55'2" 97.27'
(BM TO INTERSECTION OF C
RAMP EDGE & CURB FACE)

NOTES:


1. SEE SHEETS
MISCELLANEOUS
2. FOR ALL ELE

DANIEL S. MIYAKI
LICENSED
PROFESSIONAL
ENGINEER
No. 3443-C
HAWAII, U.S.A.

THIS WORK WAS PREPARED
BY ME OR UNDER MY SUPERVISION

04/30/06

FED. ROAD DIST. NO.	STATE	FEDERAL - AID PROJ. NO.	FISCAL YEAR	SHEET NO.	TOTAL SHEETS
HAWAII	HAW.	CMAQ-0900(67)K	2004	31	109

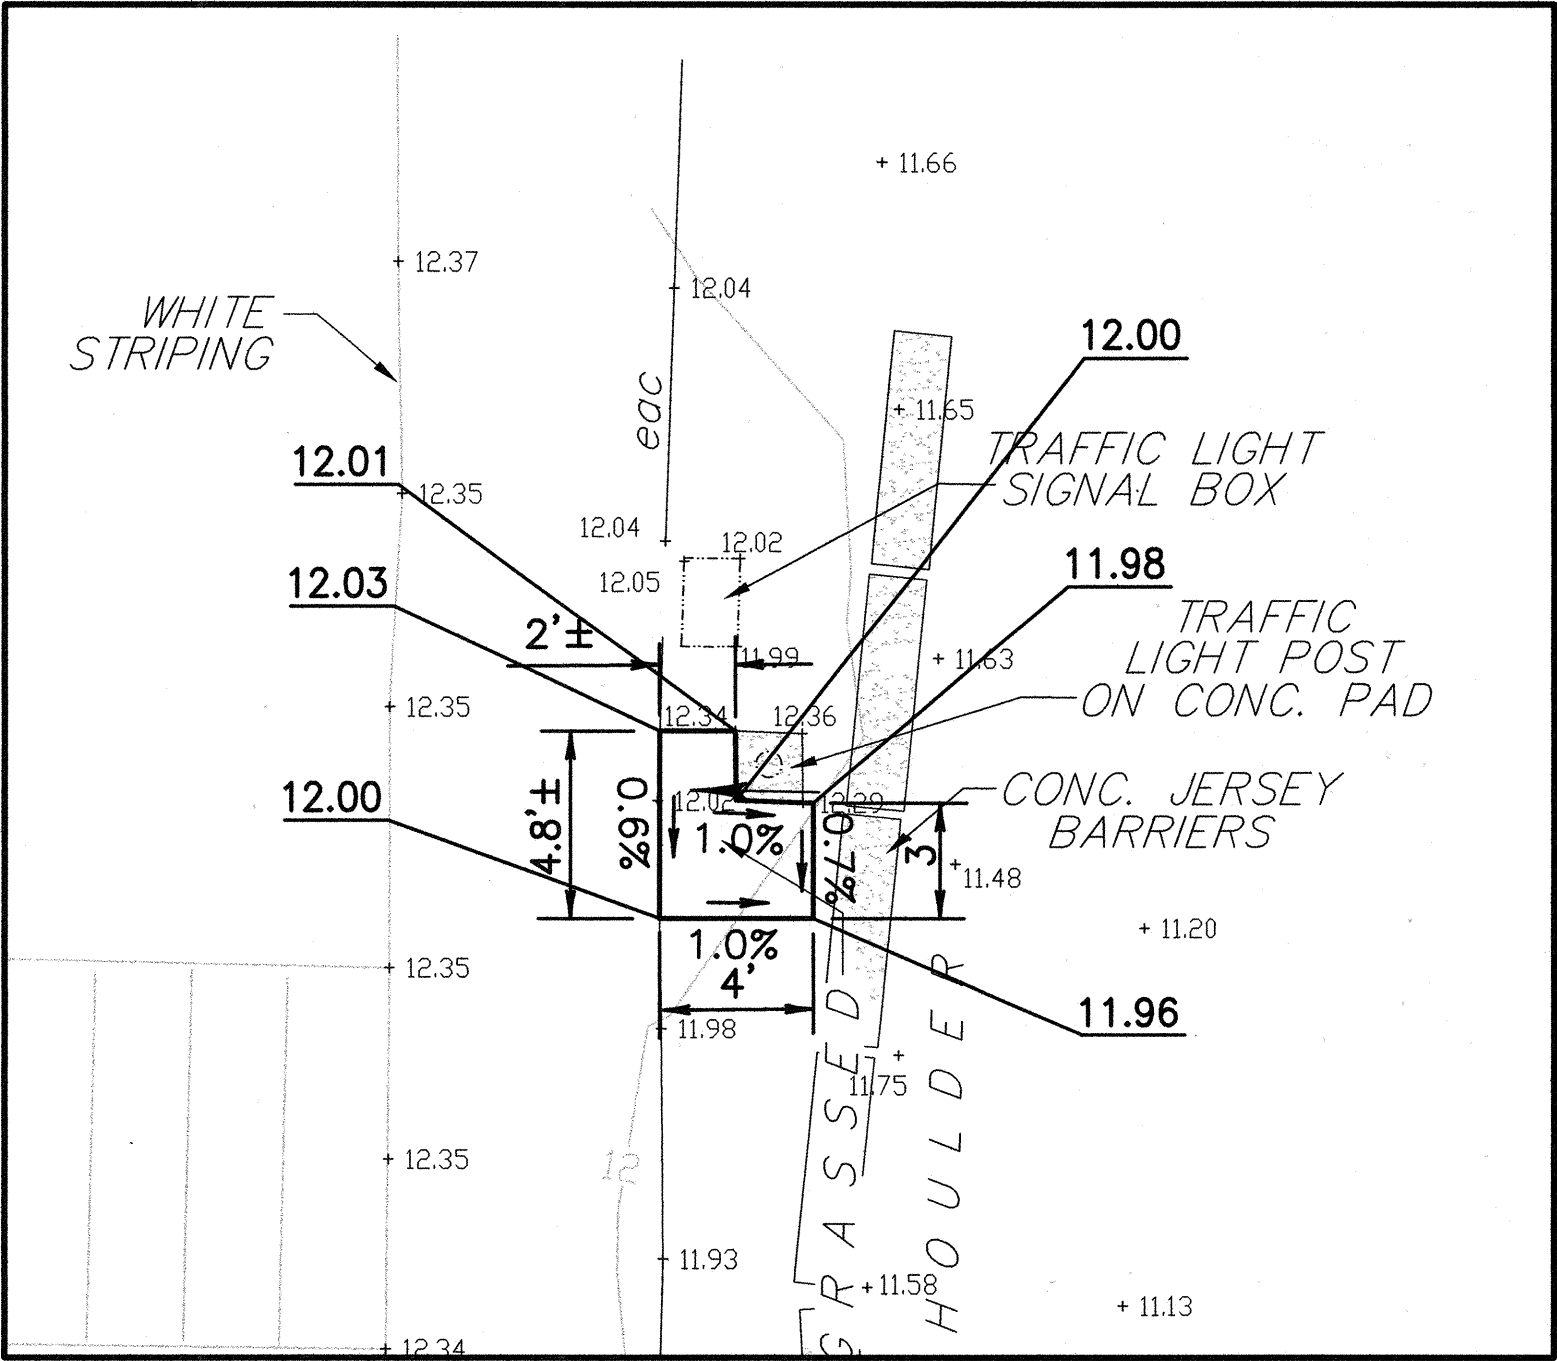

A.C. SIDEWALK NO. 32304-5 DETAILS
SCALE: 1"= 5'

- NOTES:**
- SEE SHEETS CB-1 TO CB-10 FOR CURB RAMP, STRIPING, AND MISCELLANEOUS DETAILS.
 - FOR ALL ELECTRICAL WORK, SEE ELECTRICAL PLANS.

DANIEL S. MIYASATO
LICENSED PROFESSIONAL ENGINEER
No. 3443-C
HAWAII U.S.A.

STATE OF HAWAII
DEPARTMENT OF TRANSPORTATION
HIGHWAYS DIVISION

KAHULUI BEACH RD./KANALOA AVE. (32304)

CURB RAMP PLAN

PEDESTRIAN FACILITIES & ADA
COMPLIANCE AT VARIOUS
LOCATIONS ON MAUI


Federal - Aid Project No. CMAQ-0900(67)R
Scale: As Shown Date: August 2004

THIS WORK WAS PREPARED BY ME OR UNDER MY SUPERVISION

04/30/06

EXPIRATION DATE OF THE LICENSE 12-9-22-04


SHEET No. CC-10 OF 31 SHEETS

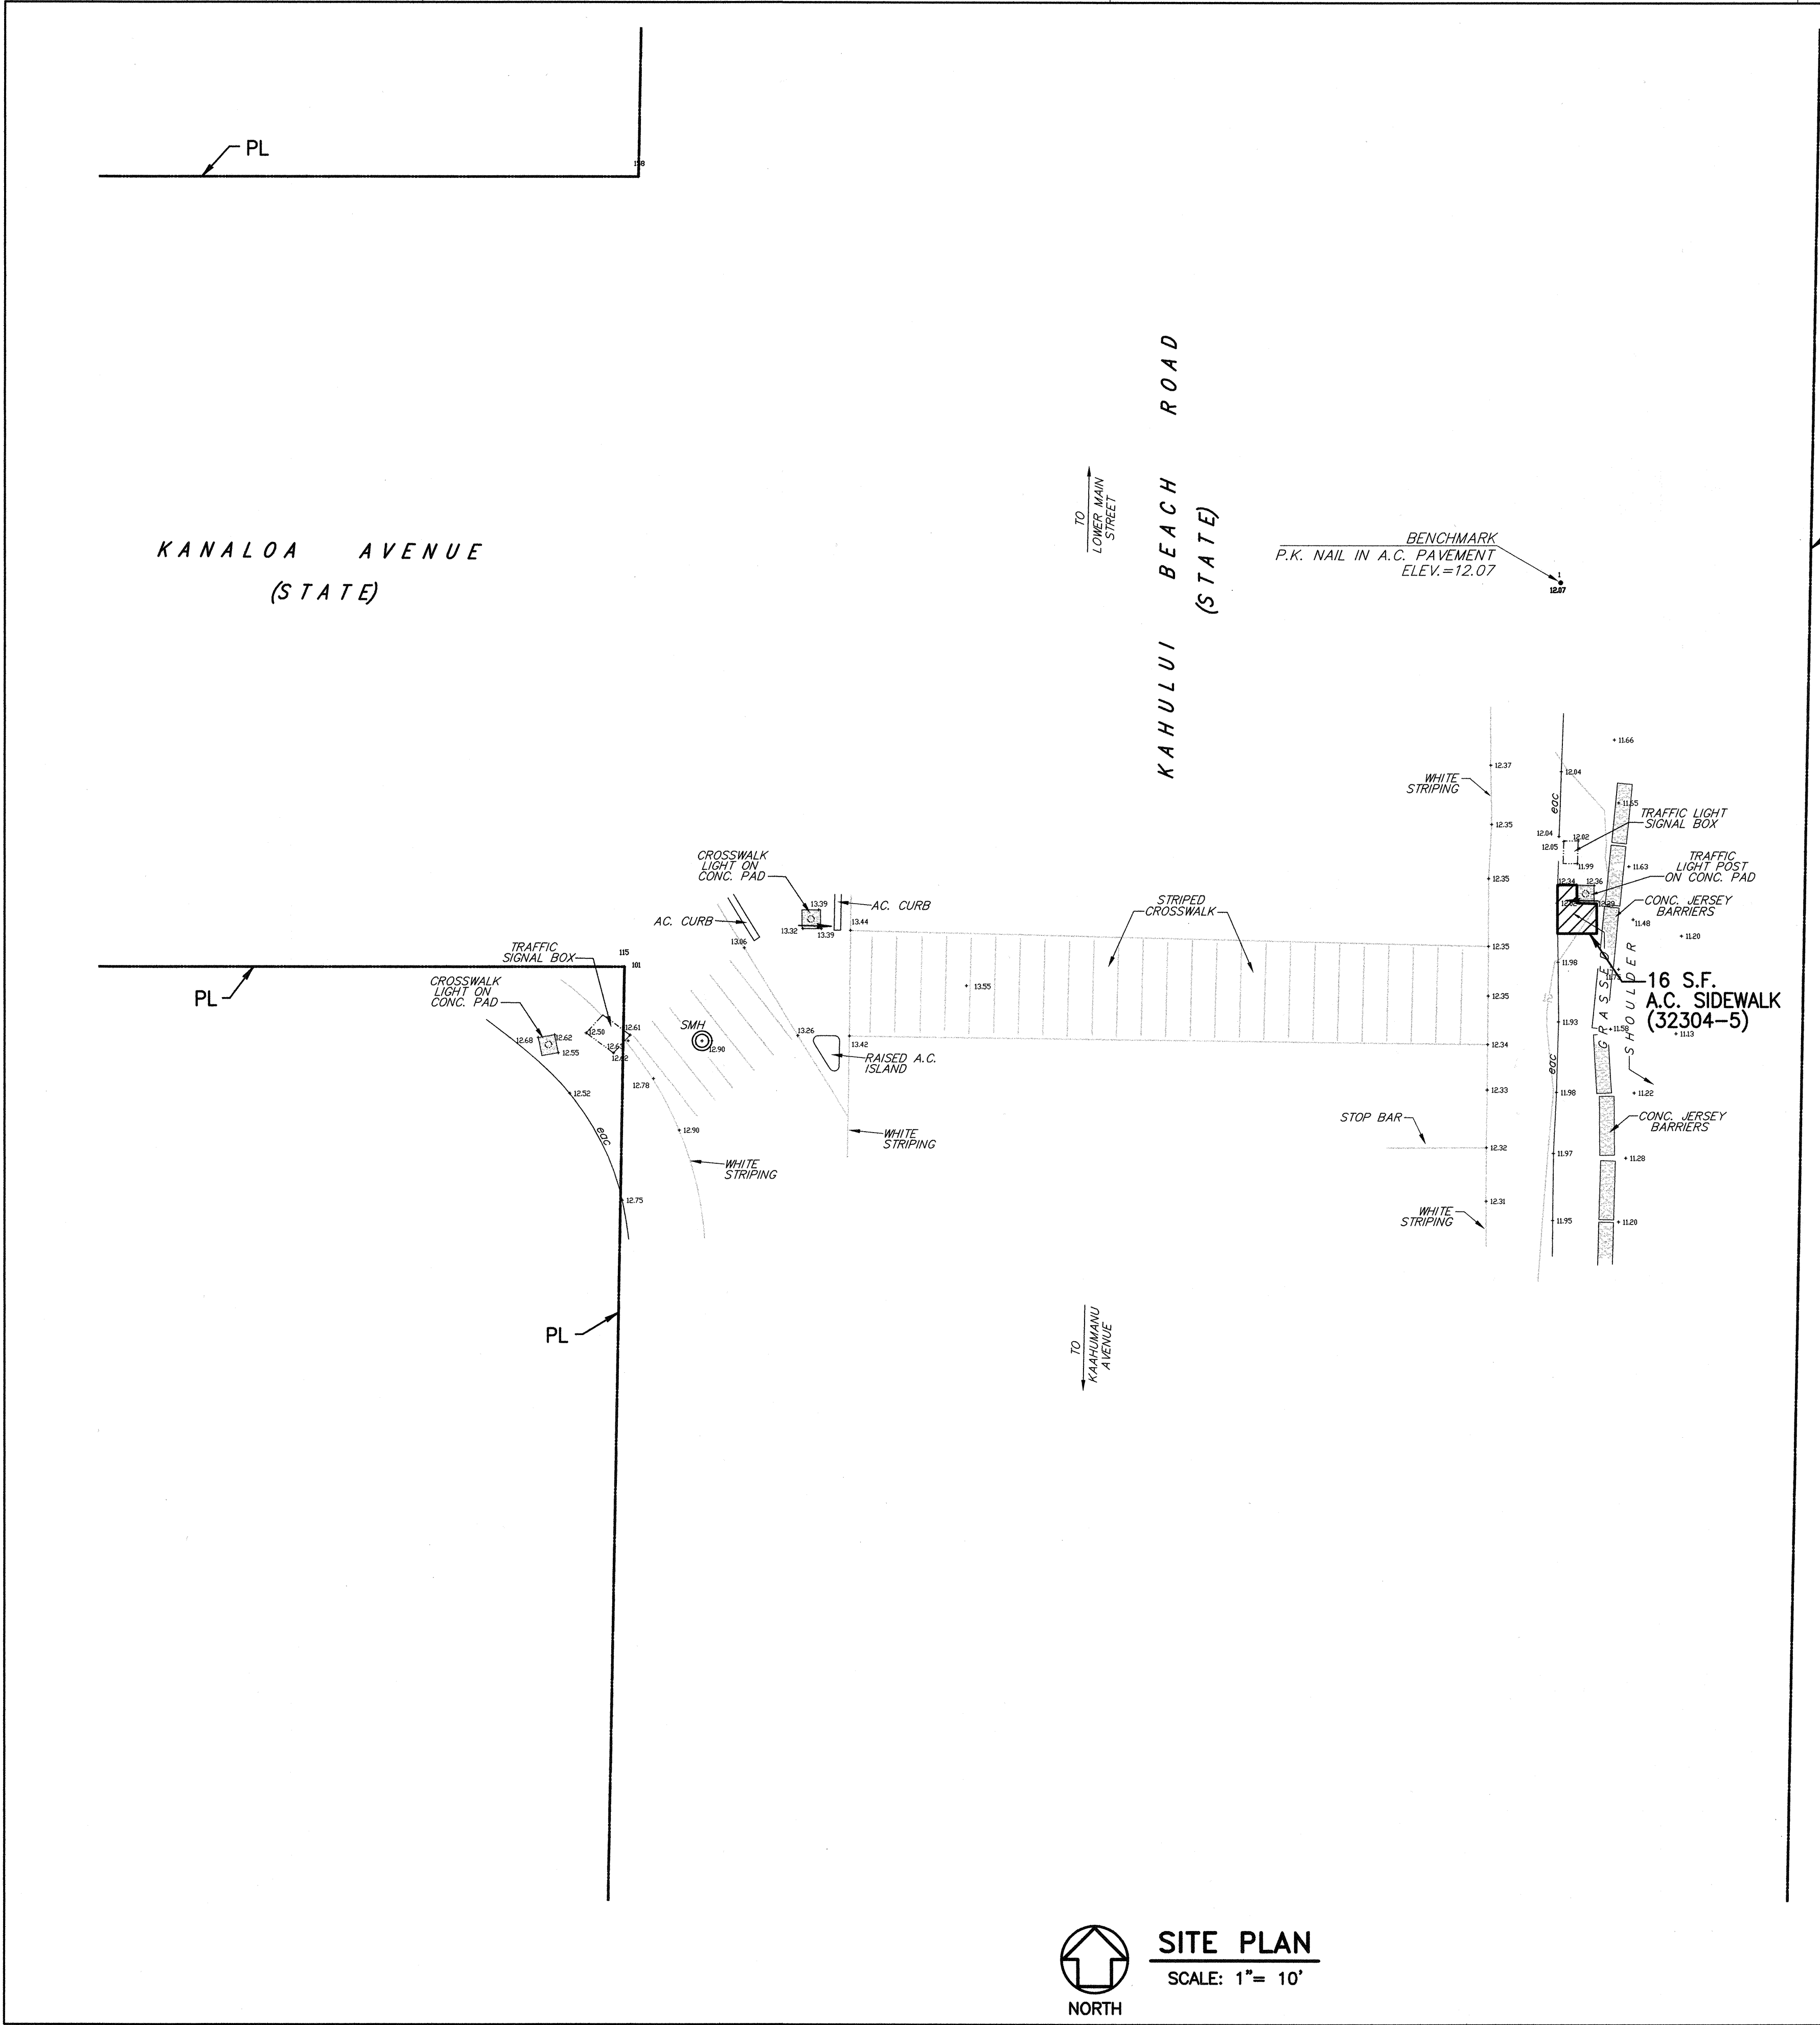

SITE PLAN
SCALE: 1"= 10'

ORIGINAL PLAN	DATE
SURVEY PLOTTED BY	
DRAWN BY	
DESIGNED BY	
QUANTITIES BY	
CHECKED BY	
No.	


FED. ROAD DIST. NO.	STATE	FEDERAL - AID PROJ. NO.	FISCAL YEAR	SHEET NO.	TOTAL SHEETS
HAWAII	HAW.	CMAQ-0900(67)R	2004	32	109

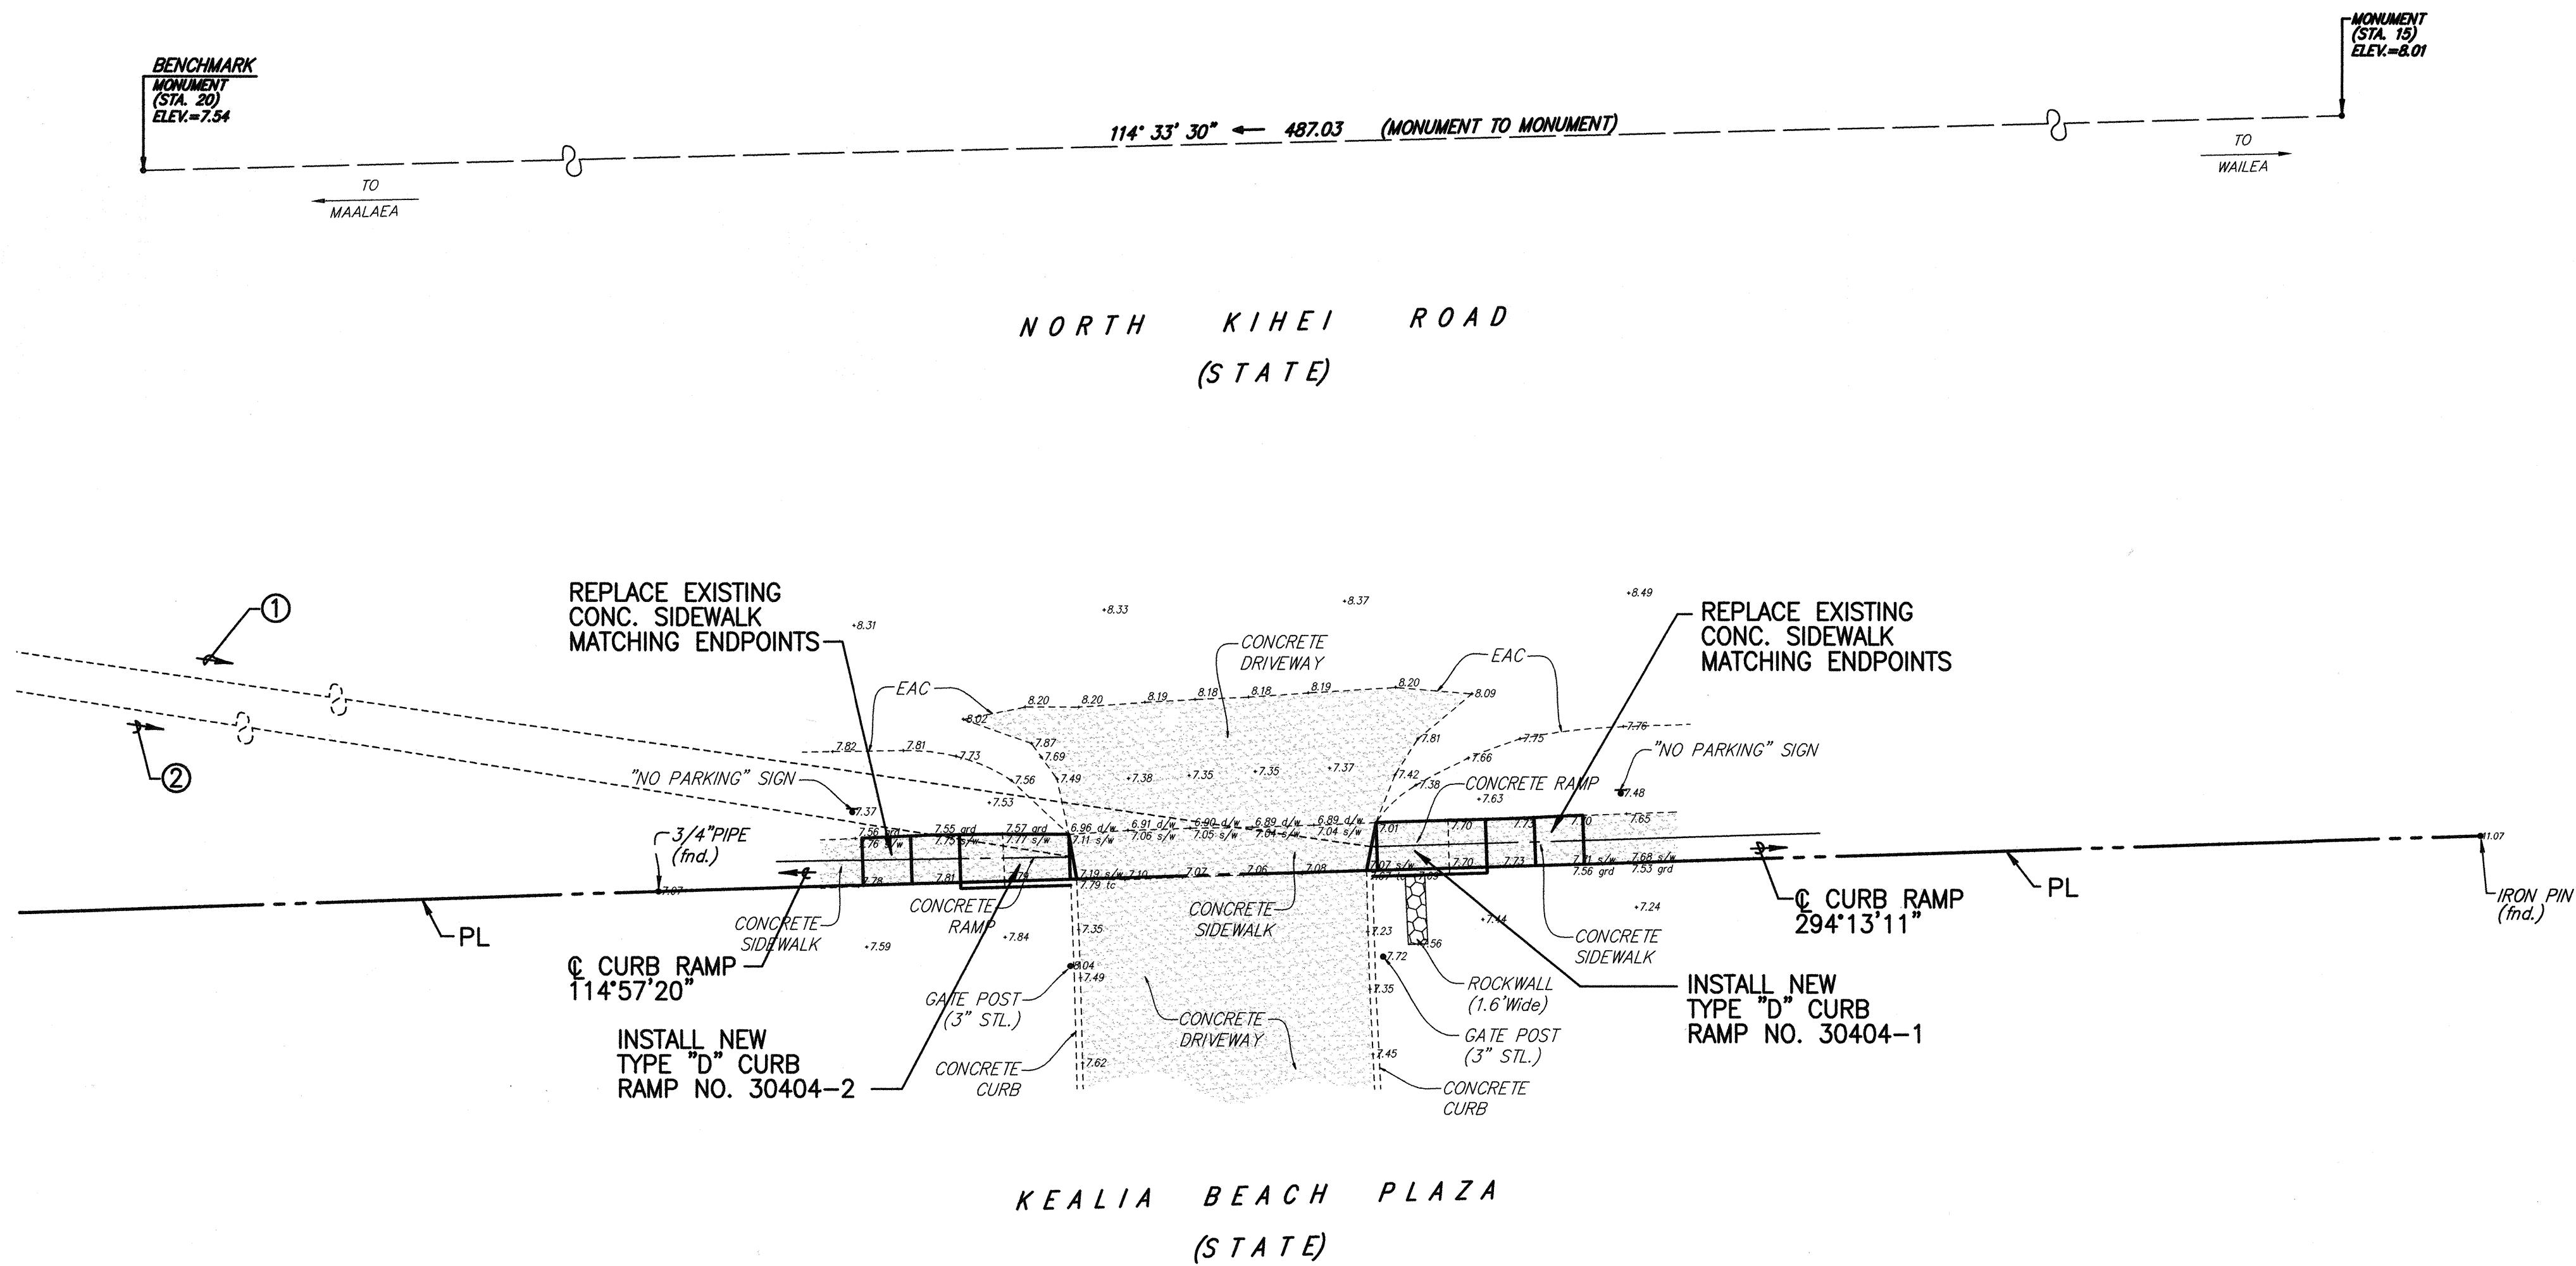


- ① 304°1'23" 350.39'
(BM STA. 20 TO INTERSECTION
OF C RAMP EDGE & CURB FACE)
- ② 304°46'39" 326.26'
(BM STA. 20 TO INTERSECTION
OF C RAMP EDGE & CURB FACE)



SITE PLAN
SCALE: 1"= 10'

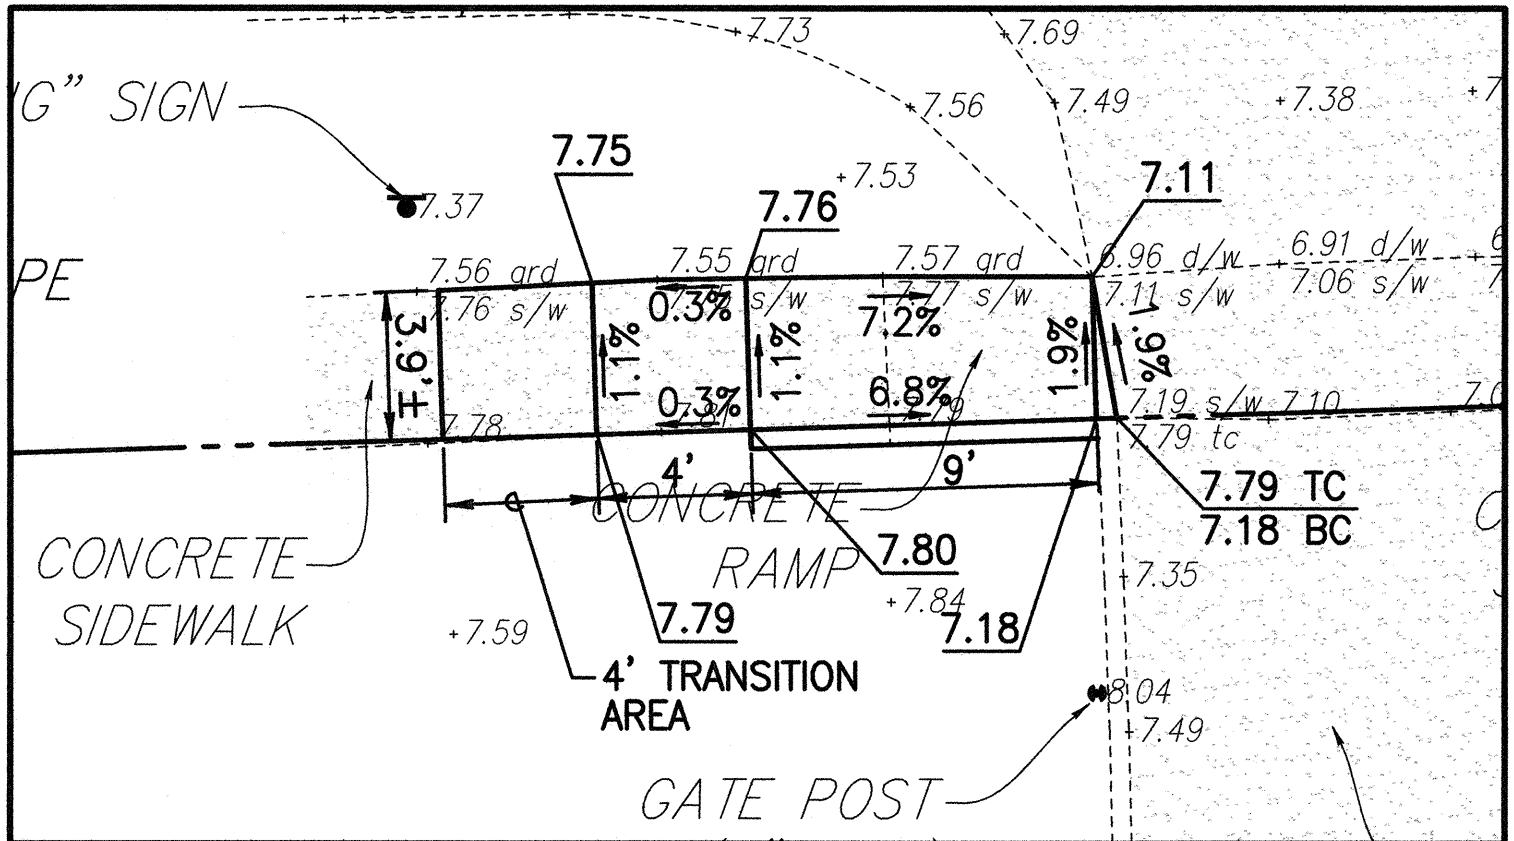

CURB RAMP NO. 30404-1 DETAILS
SCALE: 1"= 5'

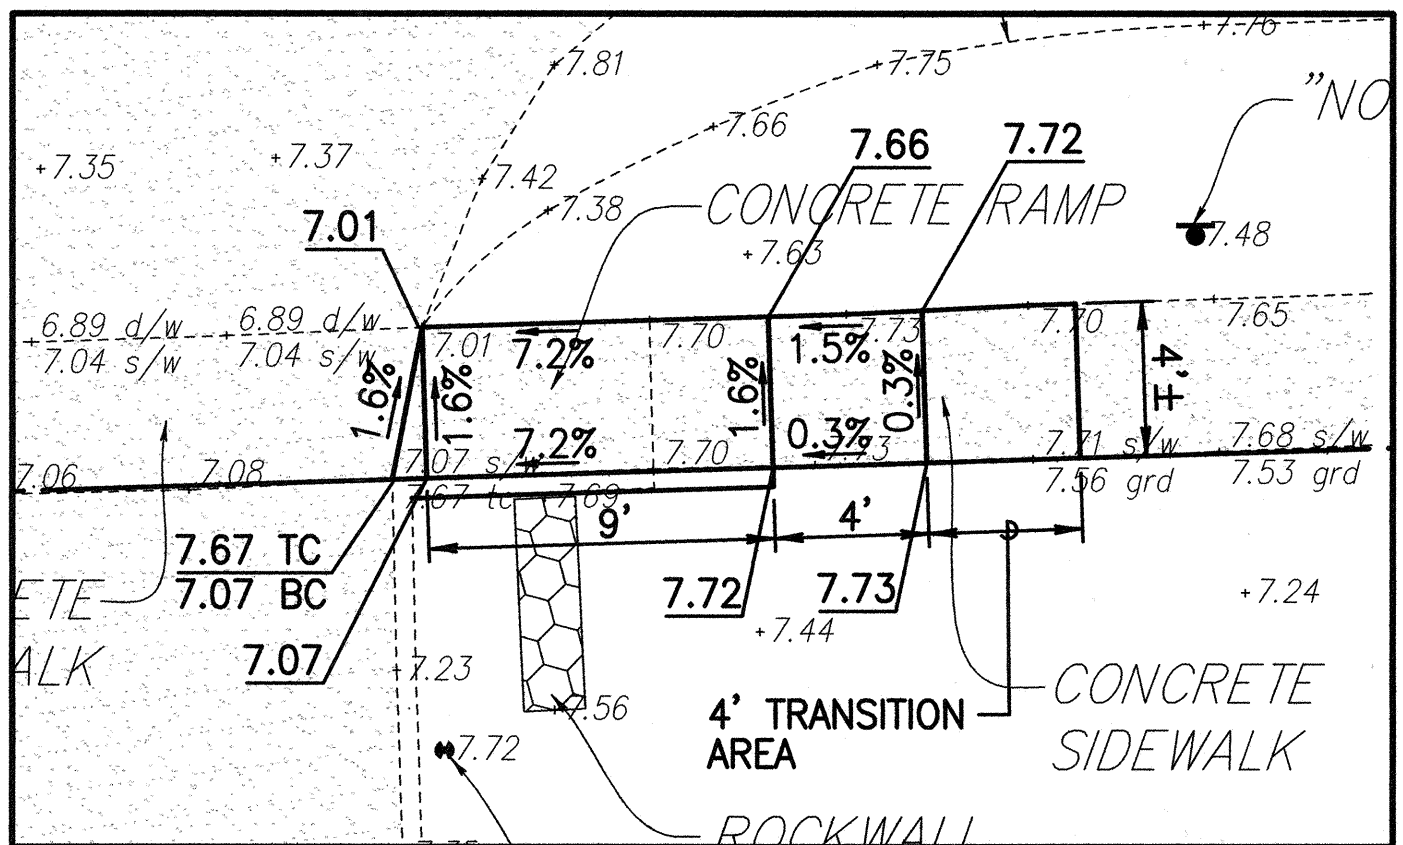

CURB RAMP NO. 30404-2 DETAILS
SCALE: 1"= 5'

NOTES:


- SEE SHEETS CB-1 TO CB-10 FOR CURB RAMP, STRIPING, AND MISCELLANEOUS DETAILS.
- FOR ALL ELECTRICAL WORK, SEE ELECTRICAL PLANS.

 THIS WORK WAS PREPARED BY ME OR UNDER MY SUPERVISION 04/30/06 EXPIRATION DATE OF THE LICENSE 10/1-22-04	STATE OF HAWAII DEPARTMENT OF TRANSPORTATION HIGHWAYS DIVISION NORTH KIHAI RD./KEALIA BEACH PLAZA (30404) CURB RAMP PLAN PEDESTRIAN FACILITIES & ADA COMPLIANCE AT VARIOUS LOCATIONS ON MAUI Federal - Aid Project No. CMAQ-0900(67)R Scale: As Shown Date: August 2004 SHEET No. CC-11 OF 31 SHEETS


[illegible]

[illegible]



	STATE OF HAWAII
	DEPARTMENT OF TRANSPORTATION
	HIGHWAYS DIVISION
	<u>PUUNENE AVE./HOLOLEA ST. (60704)</u>
<u>CURB RAMP PLAN</u>	
<u>PEDESTRIAN FACILITIES & ADA</u>	
<u>COMPLIANCE AT VARIOUS</u>	
<u>LOCATIONS ON MAUI</u>	
<u>Federal - Aid Project No. CMAQ-0900(67)R</u>	
Scale: As Shown	Date: August 2004
EXPIRATION DATE OF THE LICENSE	
04/30/06	
SHEET No. CC-13 OF 31 SHEETS	

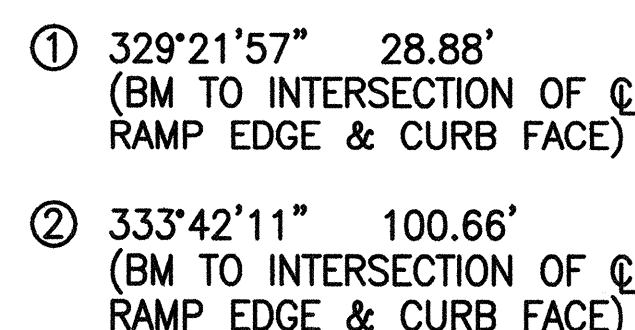

1. SEE SHEETS CB-1 TO CB-10 FOR CURB RAMP, STRIPING, AND MISCELLANEOUS DETAILS.
2. FOR ALL ELECTRICAL WORK, SEE ELECTRICAL PLANS.

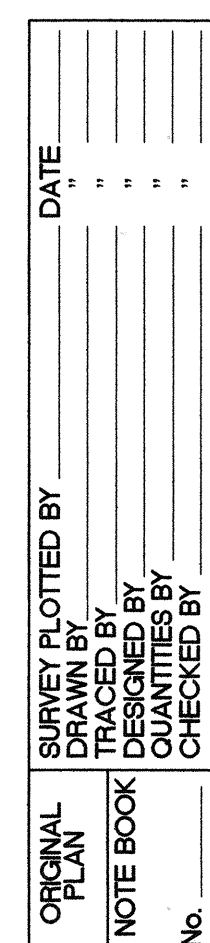

FED. ROAD DIST. NO.	STATE	FEDERAL - AID PROJ. NO.	FISCAL YEAR	SHEET NO.	TOTAL SHEETS
HAWAII	HAW.	CMAQ-0900(67)R	2004	35	109

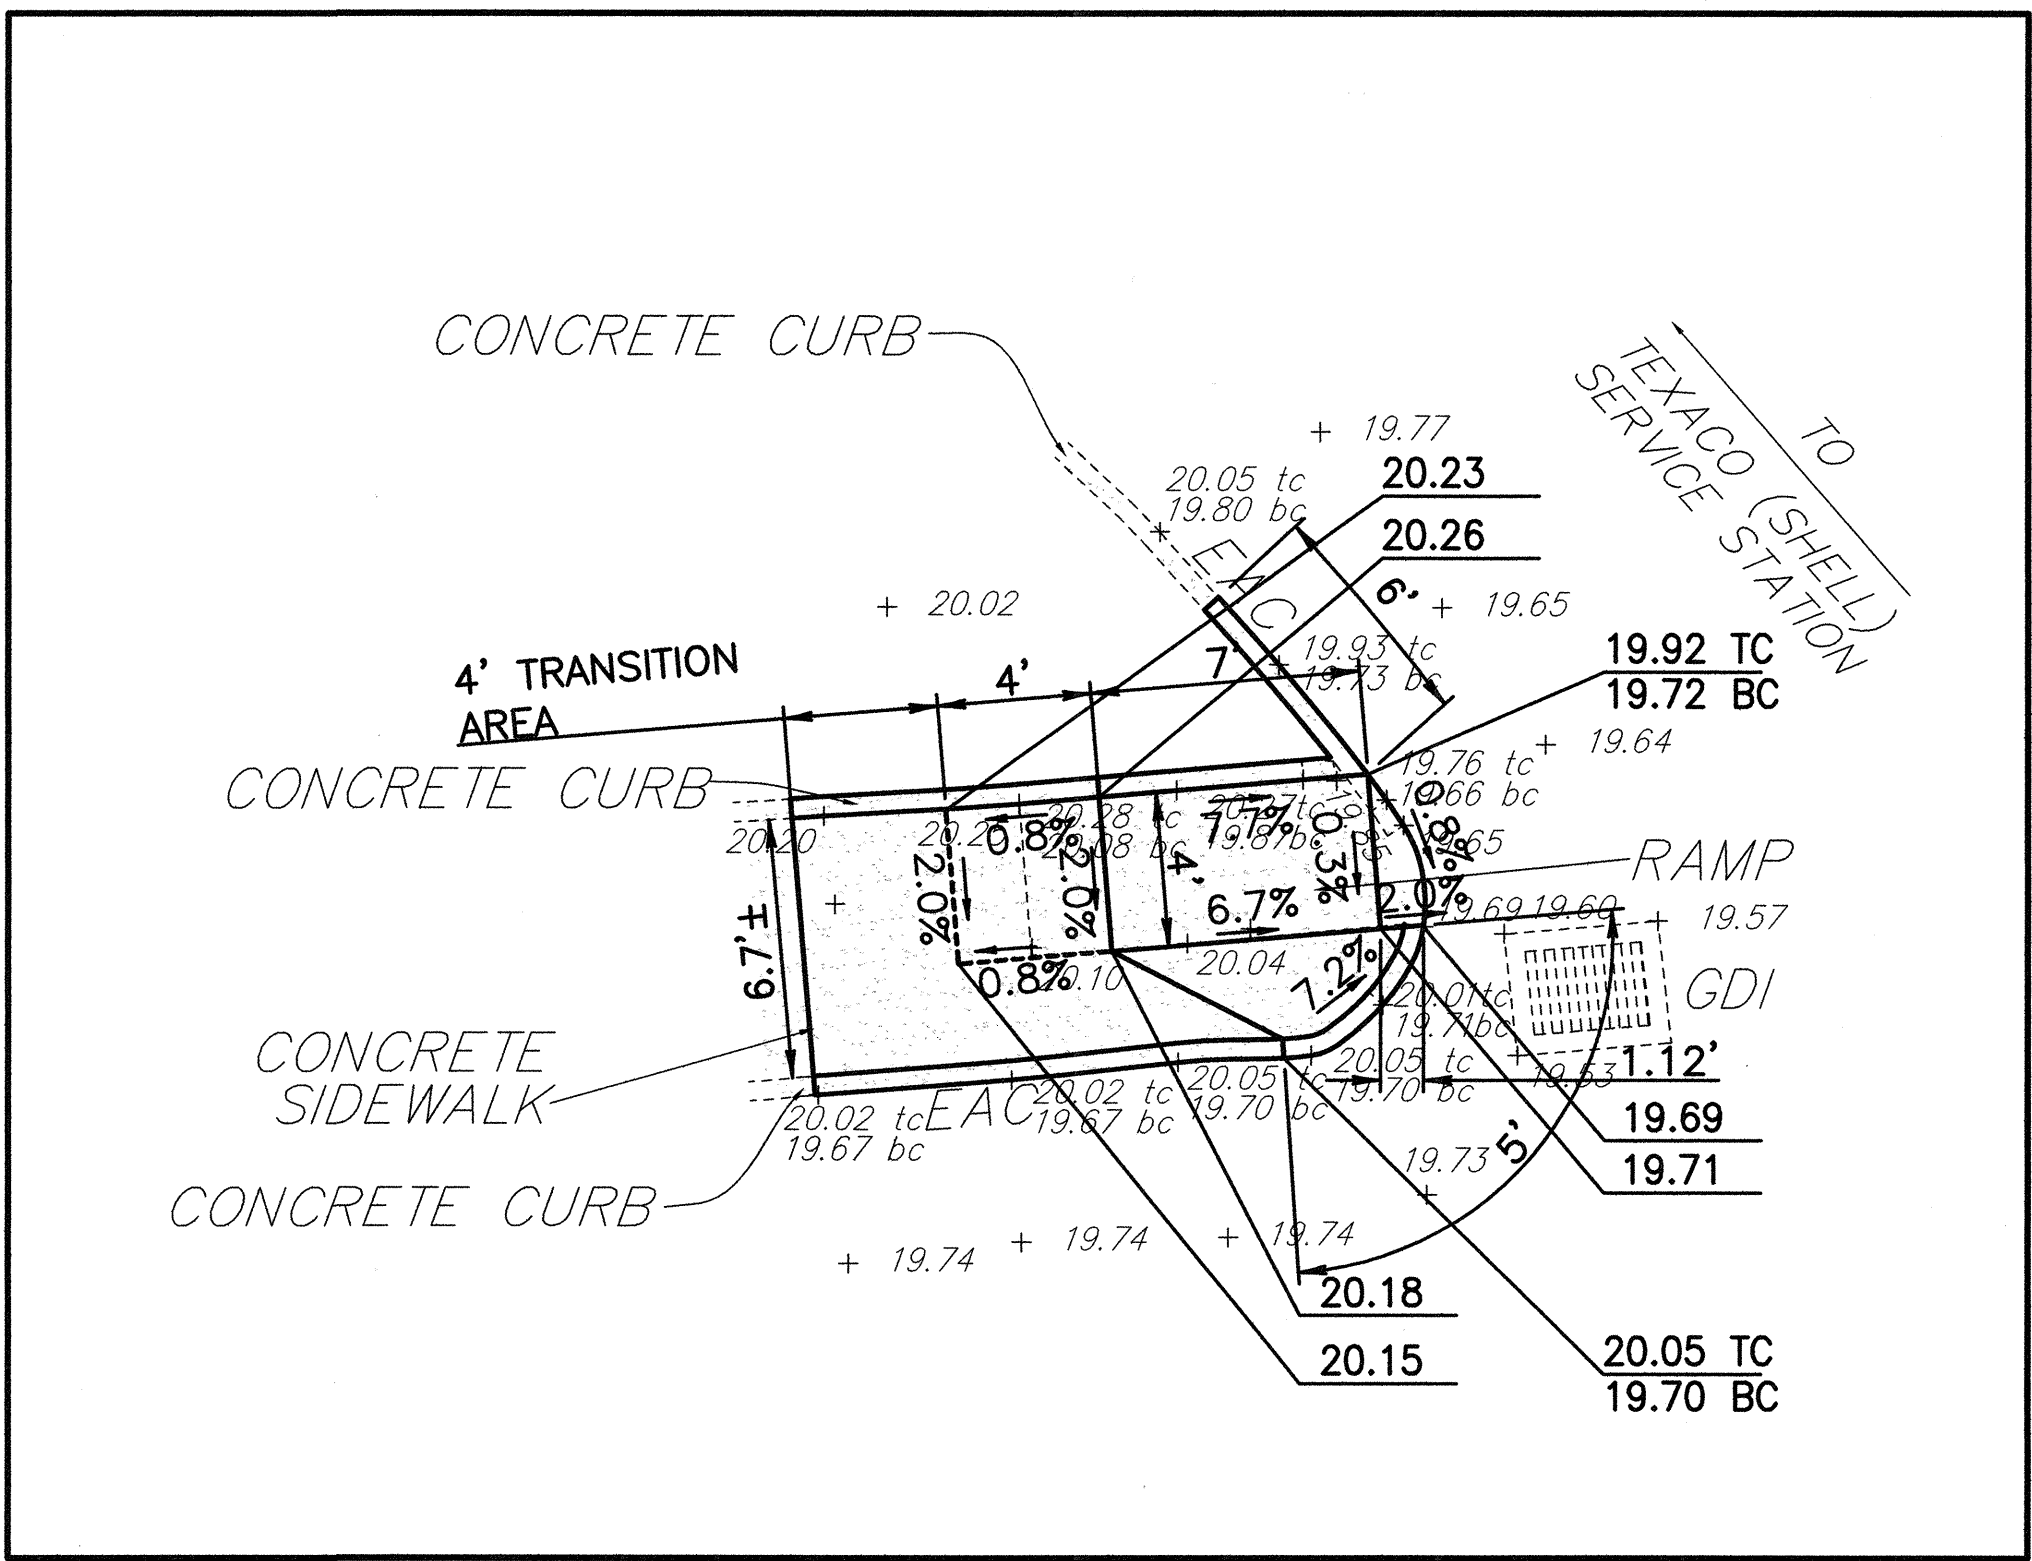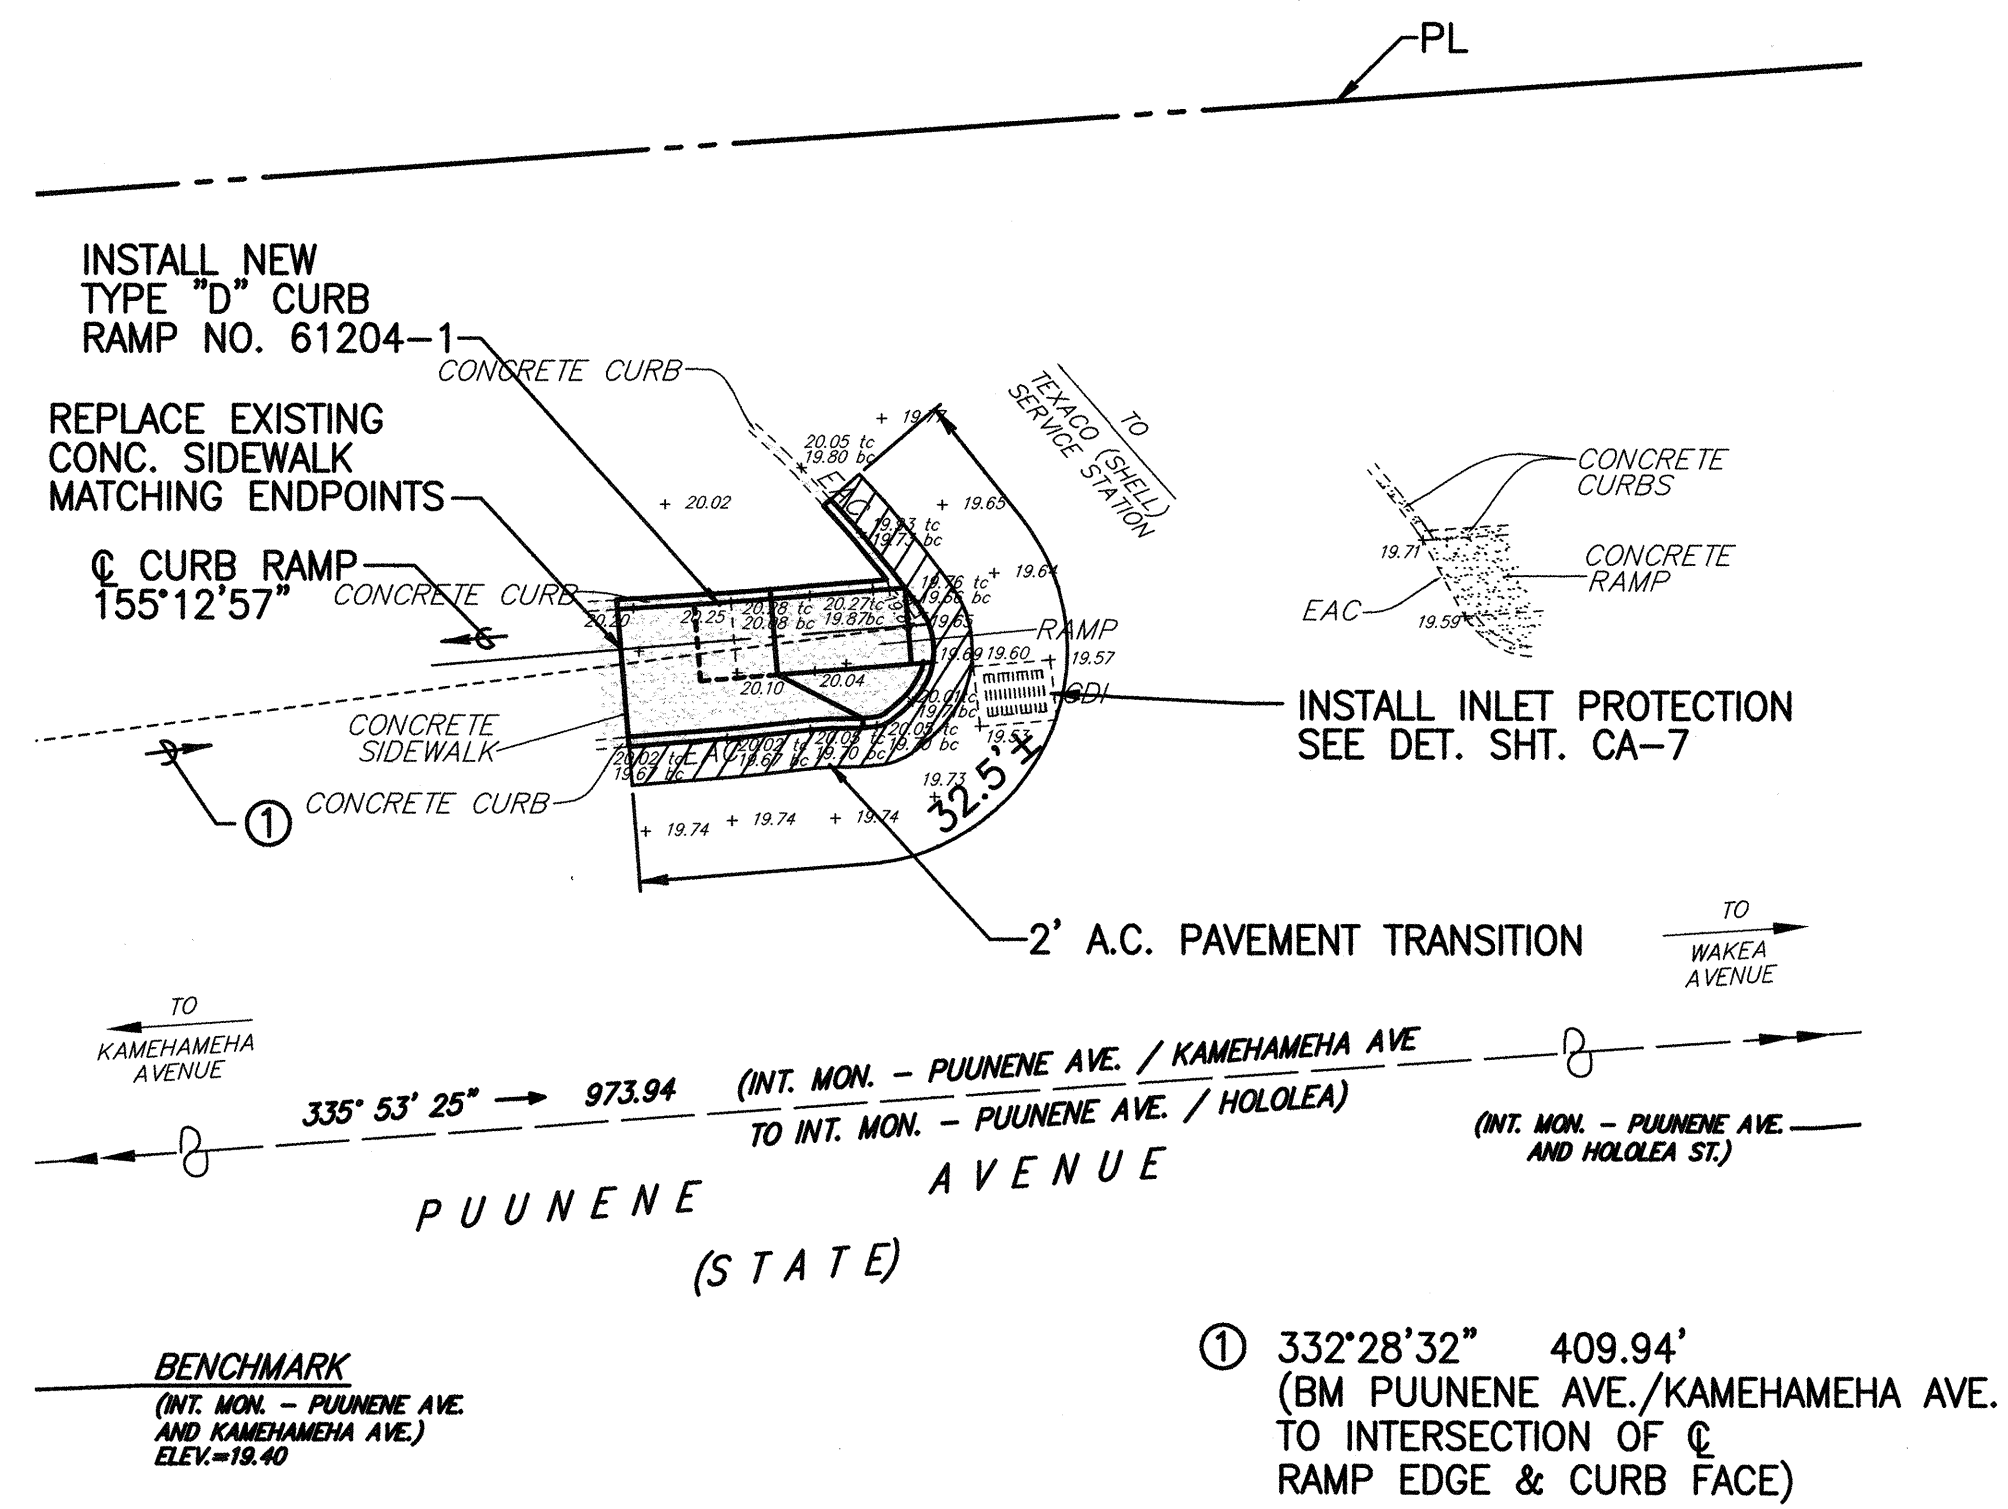


CURB RAMP NO. 61204-1 DETAILS
SCALE: 1" = 5'


NOTES:

- SEE SHEETS CB-1 TO CB-10 FOR CURB RAMP, STRIPING, AND MISCELLANEOUS DETAILS.
- FOR ALL ELECTRICAL WORK, SEE ELECTRICAL PLANS.

 THIS WORK WAS PREPARED BY ME OR UNDER MY SUPERVISION 04/30/06 EXPIRATION DATE OF THE LICENSE 04-22-04	STATE OF HAWAII DEPARTMENT OF TRANSPORTATION HIGHWAYS DIVISION PUUNENE AVE./TEXACO ENTRANCE(61204) CURB RAMP PLAN PEDESTRIAN FACILITIES & ADA COMPLIANCE AT VARIOUS LOCATIONS ON MAUI Federal - Aid Project No. CMAQ-0900(67)R Scale: As Shown Date: August 2004 SHEET No. CC-14 OF 31 SHEETS
---	---

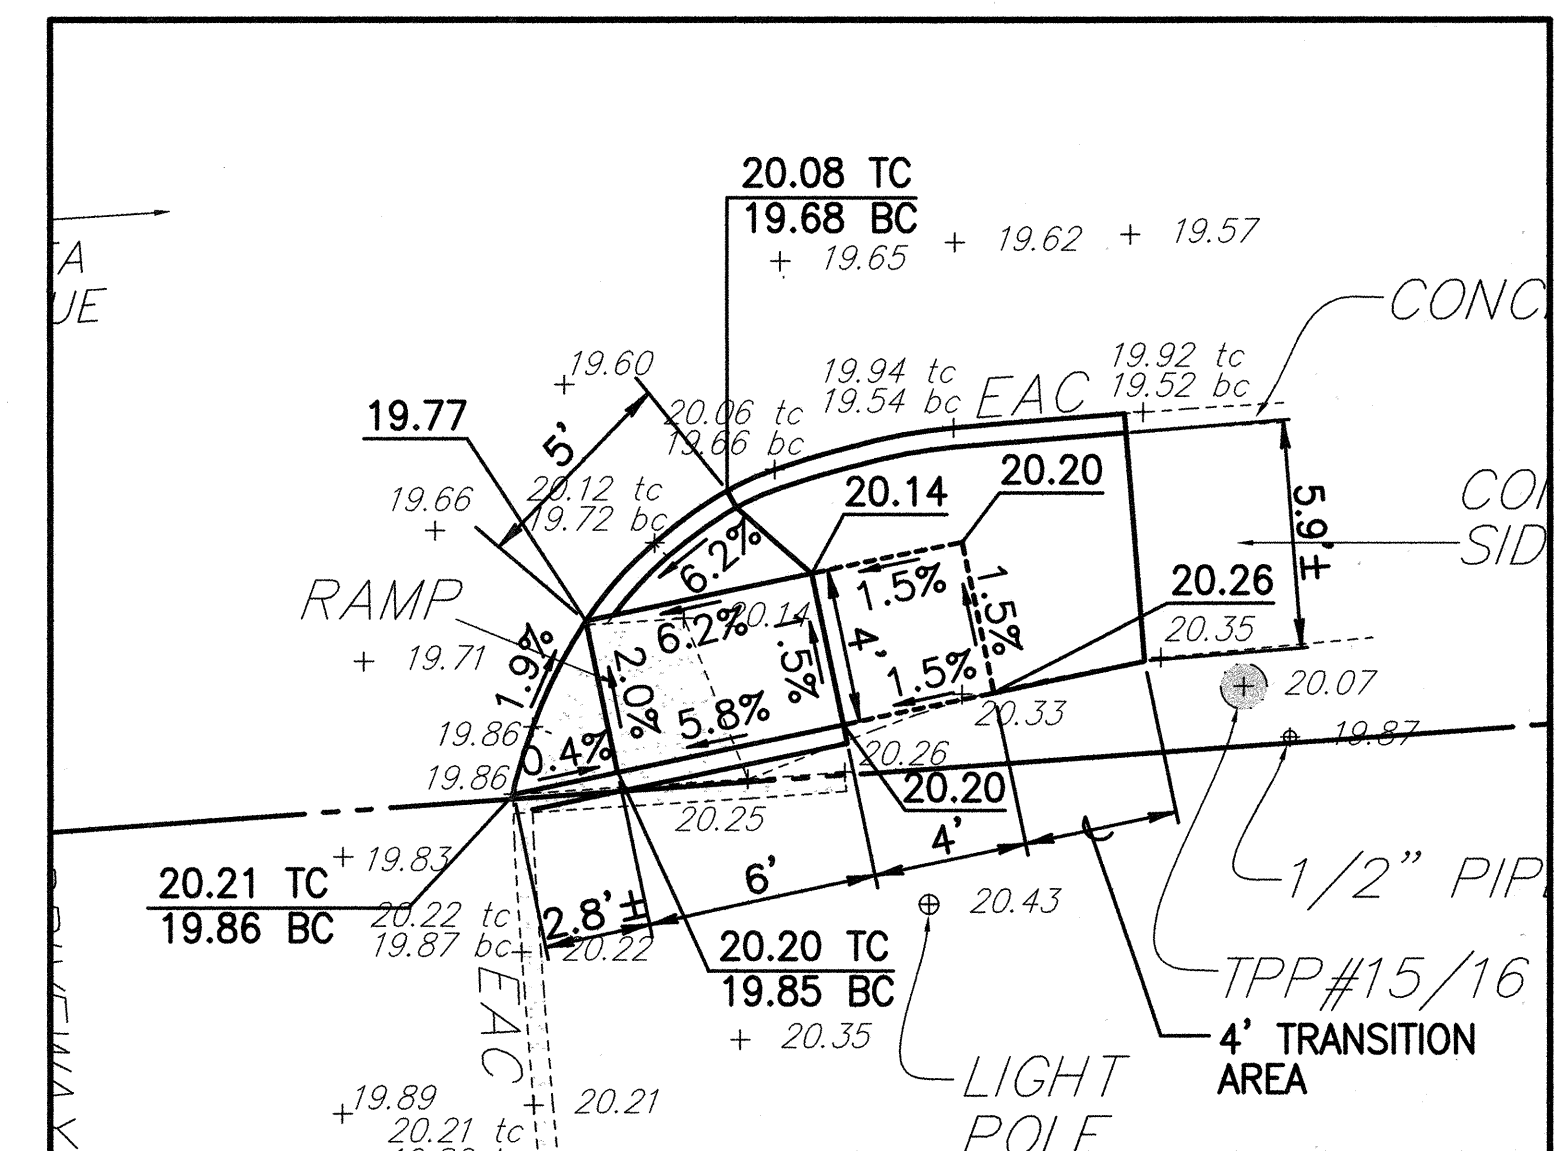[illegible]

CURB RAMP NO. 61304-1 DETAILS
SCALE: 1" = 5'

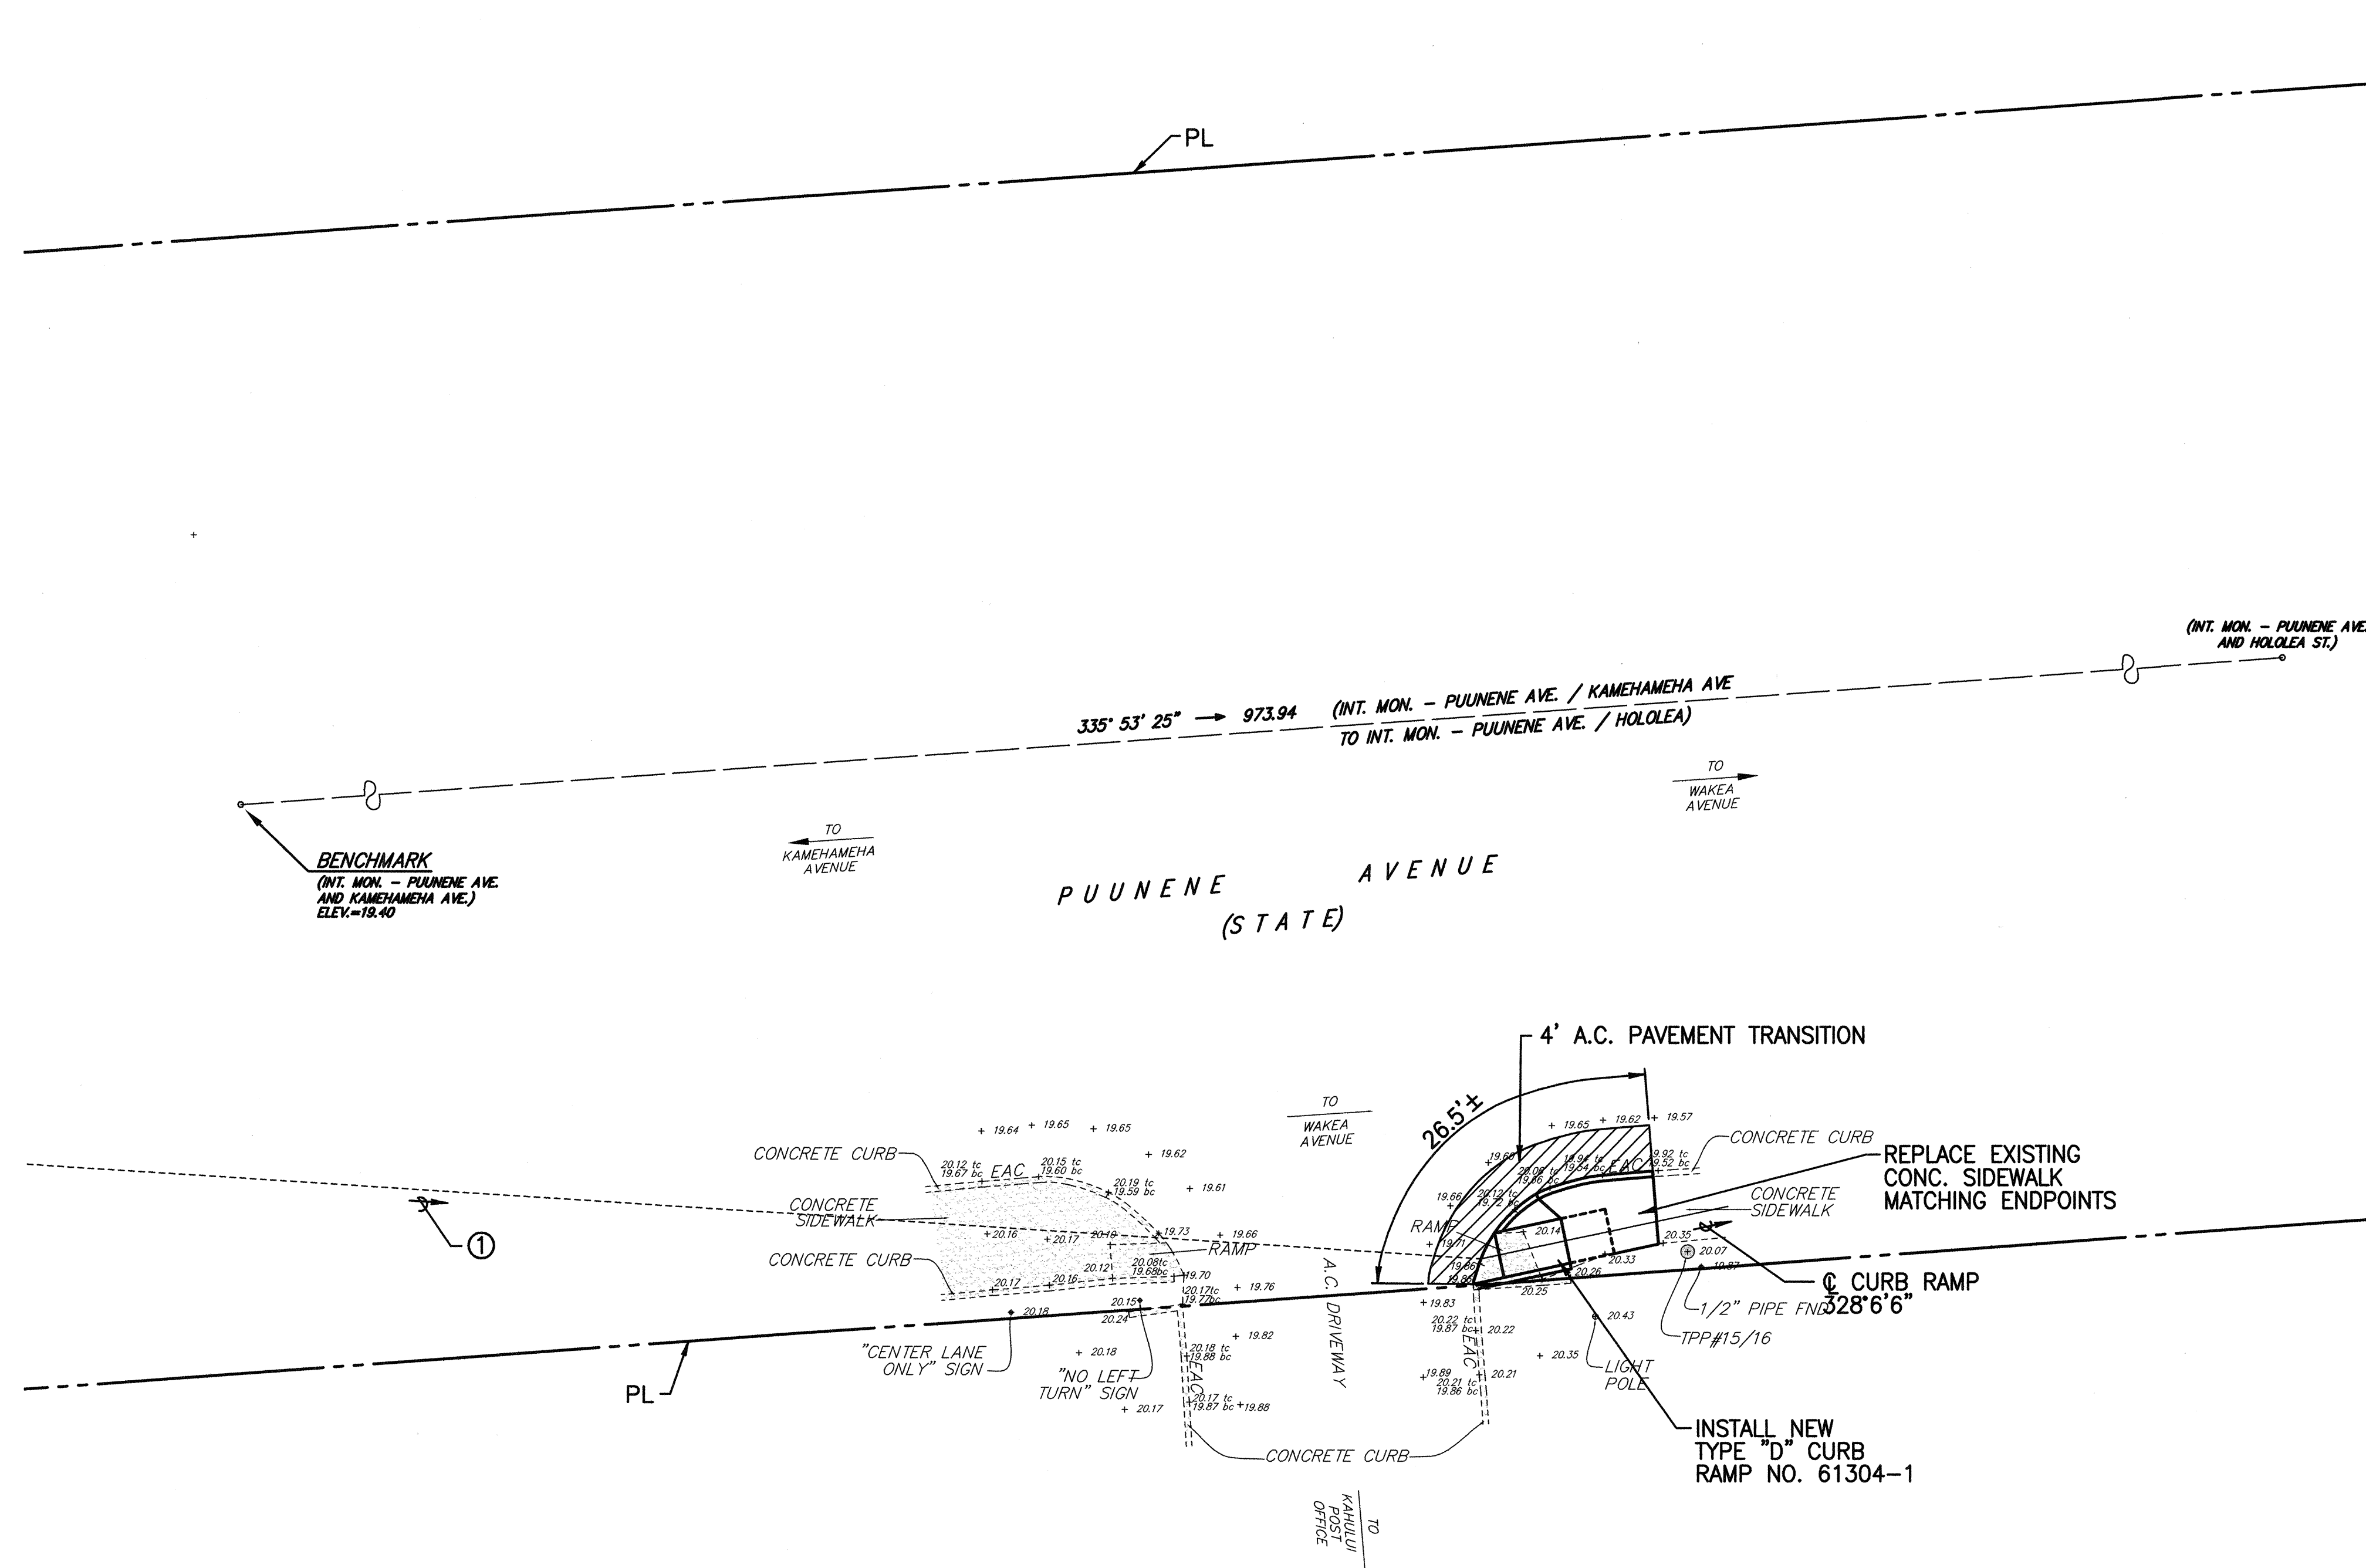

NOTES:


1. SEE SHEETS CB-1 TO CB-10 FOR CURB RAMP, STRIPING, AND MISCELLANEOUS DETAILS.
2. FOR ALL ELECTRICAL WORK, SEE ELECTRICAL PLANS.

ORIGINAL PLAN	SURVEY PLOTTED BY _____	DATE _____
NOTE BOOK	DRAWN BY _____	" _____
	DESIGNED BY _____	" _____
	QUANTITIES BY _____	" _____
	CHECKED BY _____	" _____
No. _____		

① 343°39'40" 353.09'
(BM PUUNENE AVE./KAMEHAMEHA AVE.
TO INTERSECTION OF C
RAMP EDGE & CURB FACE)



SITE PLAN
SCALE: 1"= 10'

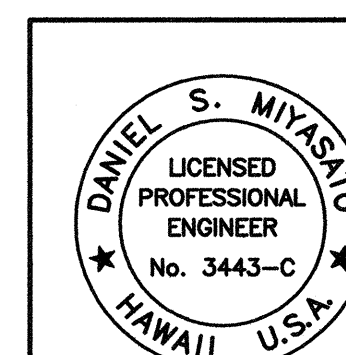



THIS WORK WAS PREPARED BY
ME OR UNDER MY SUPERVISION

04/30/06

EXPIRATION DATE OF THE LICENSE
10-9-22-04

STATE OF HAWAII
DEPARTMENT OF TRANSPORTATION
HIGHWAYS DIVISION
PUUNENE AVE./POST OFFICE ENTRANCE(61304)
CURB RAMP PLAN
PEDESTRIAN FACILITIES & ADA
COMPLIANCE AT VARIOUS
LOCATIONS ON MAUI
Federal - Aid Project No. CMAQ-0900(67)R
Scale: As Shown Date: August 2004
SHEET No. CC-15 OF 31 SHEETS

FED. ROAD DIST. NO.	STATE	FEDERAL - AID PROJ. NO.	FISCAL YEAR	SHEET NO.	TOTAL SHEETS
HAWAII	HAW.	CMAQ-0900(67)R	2004	37	109

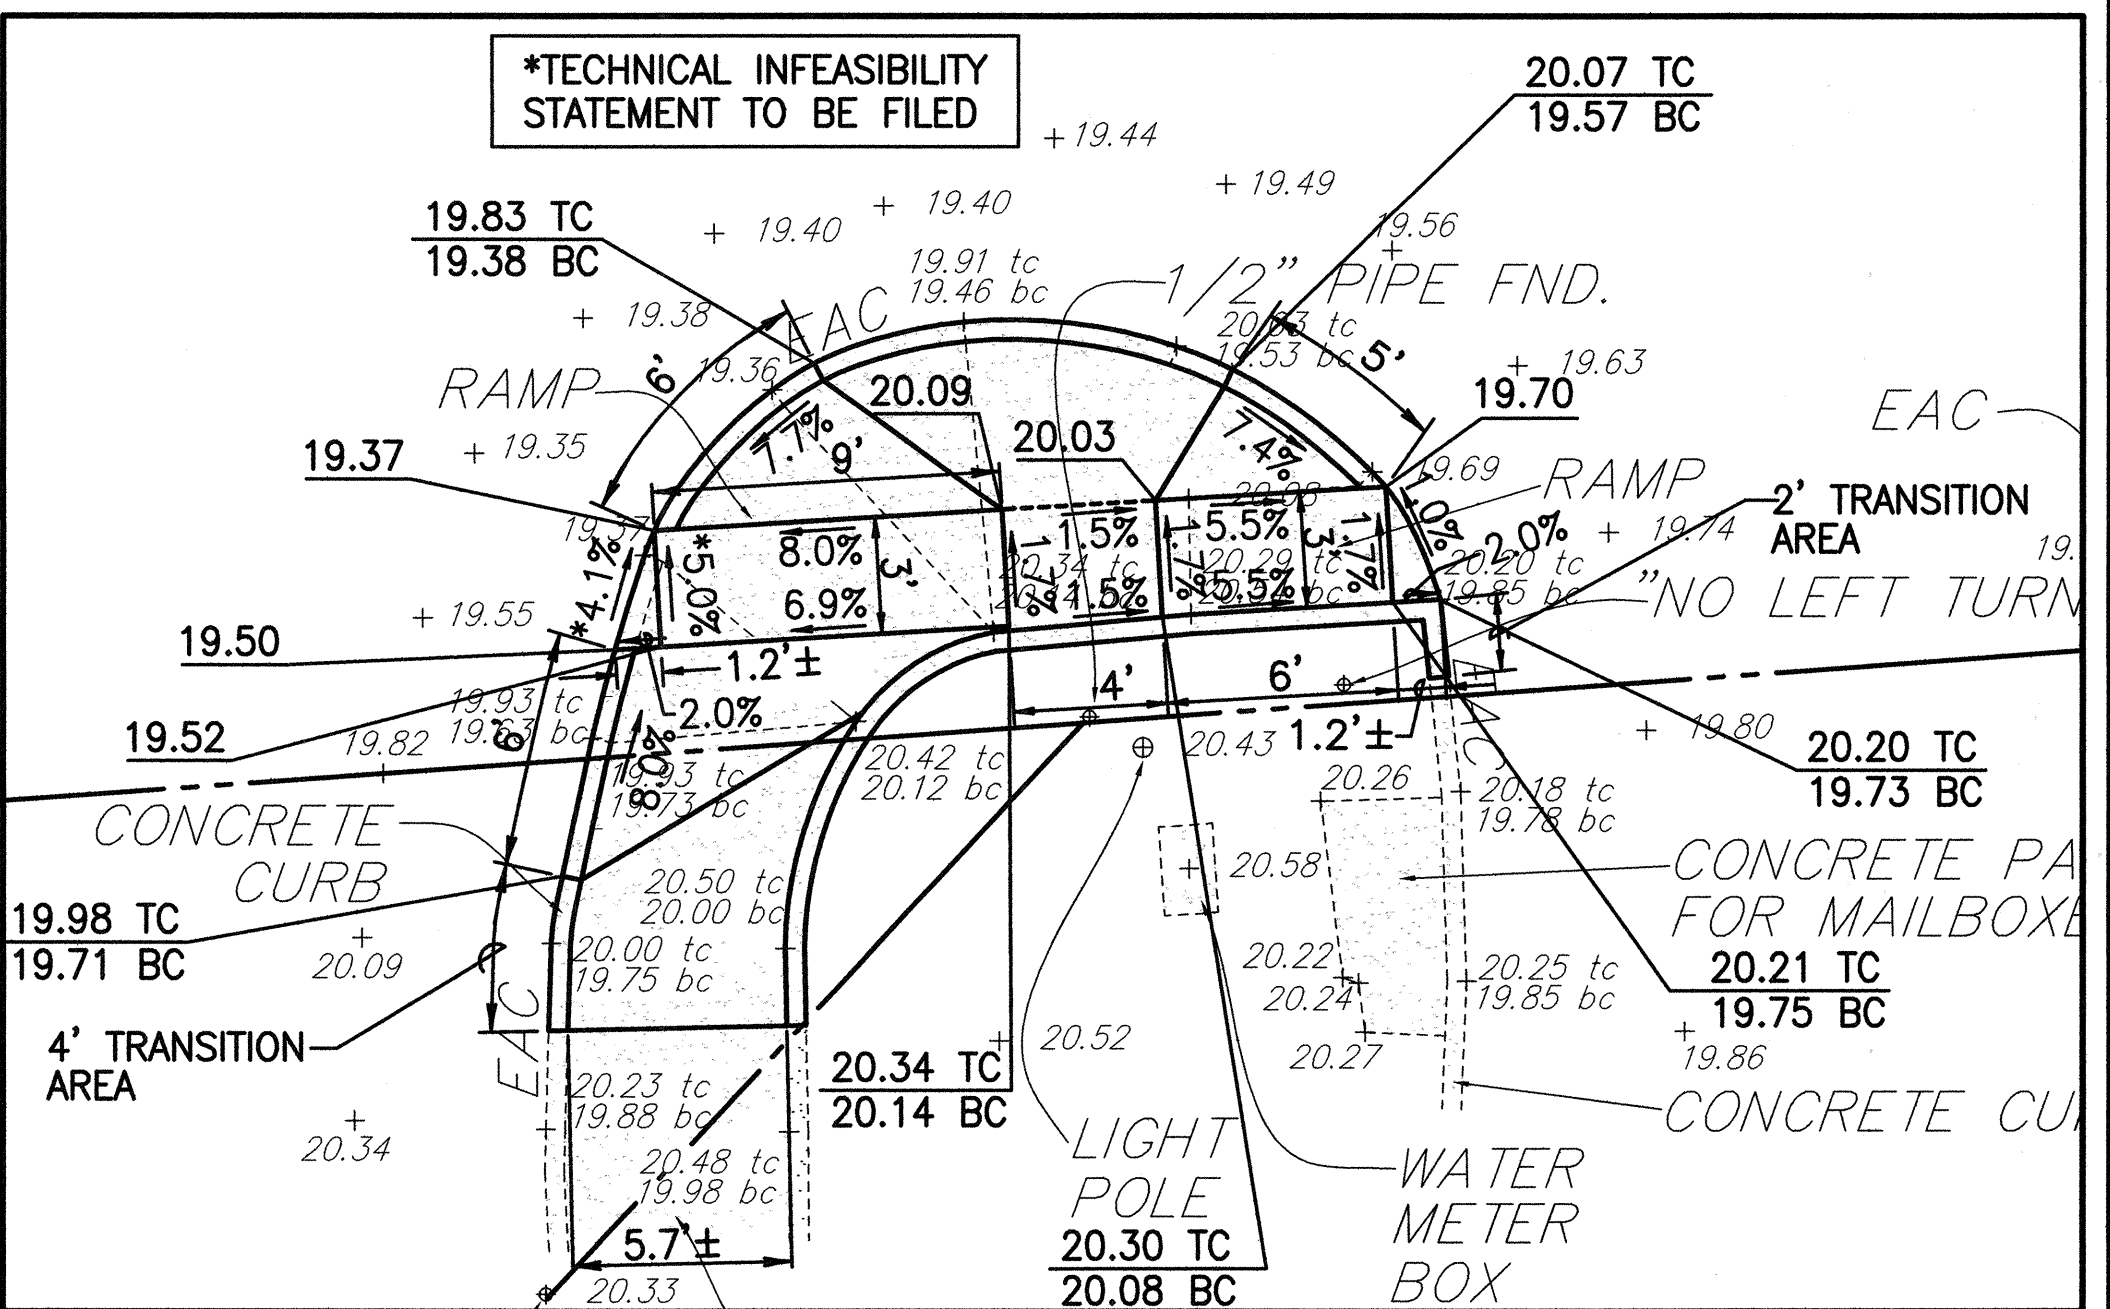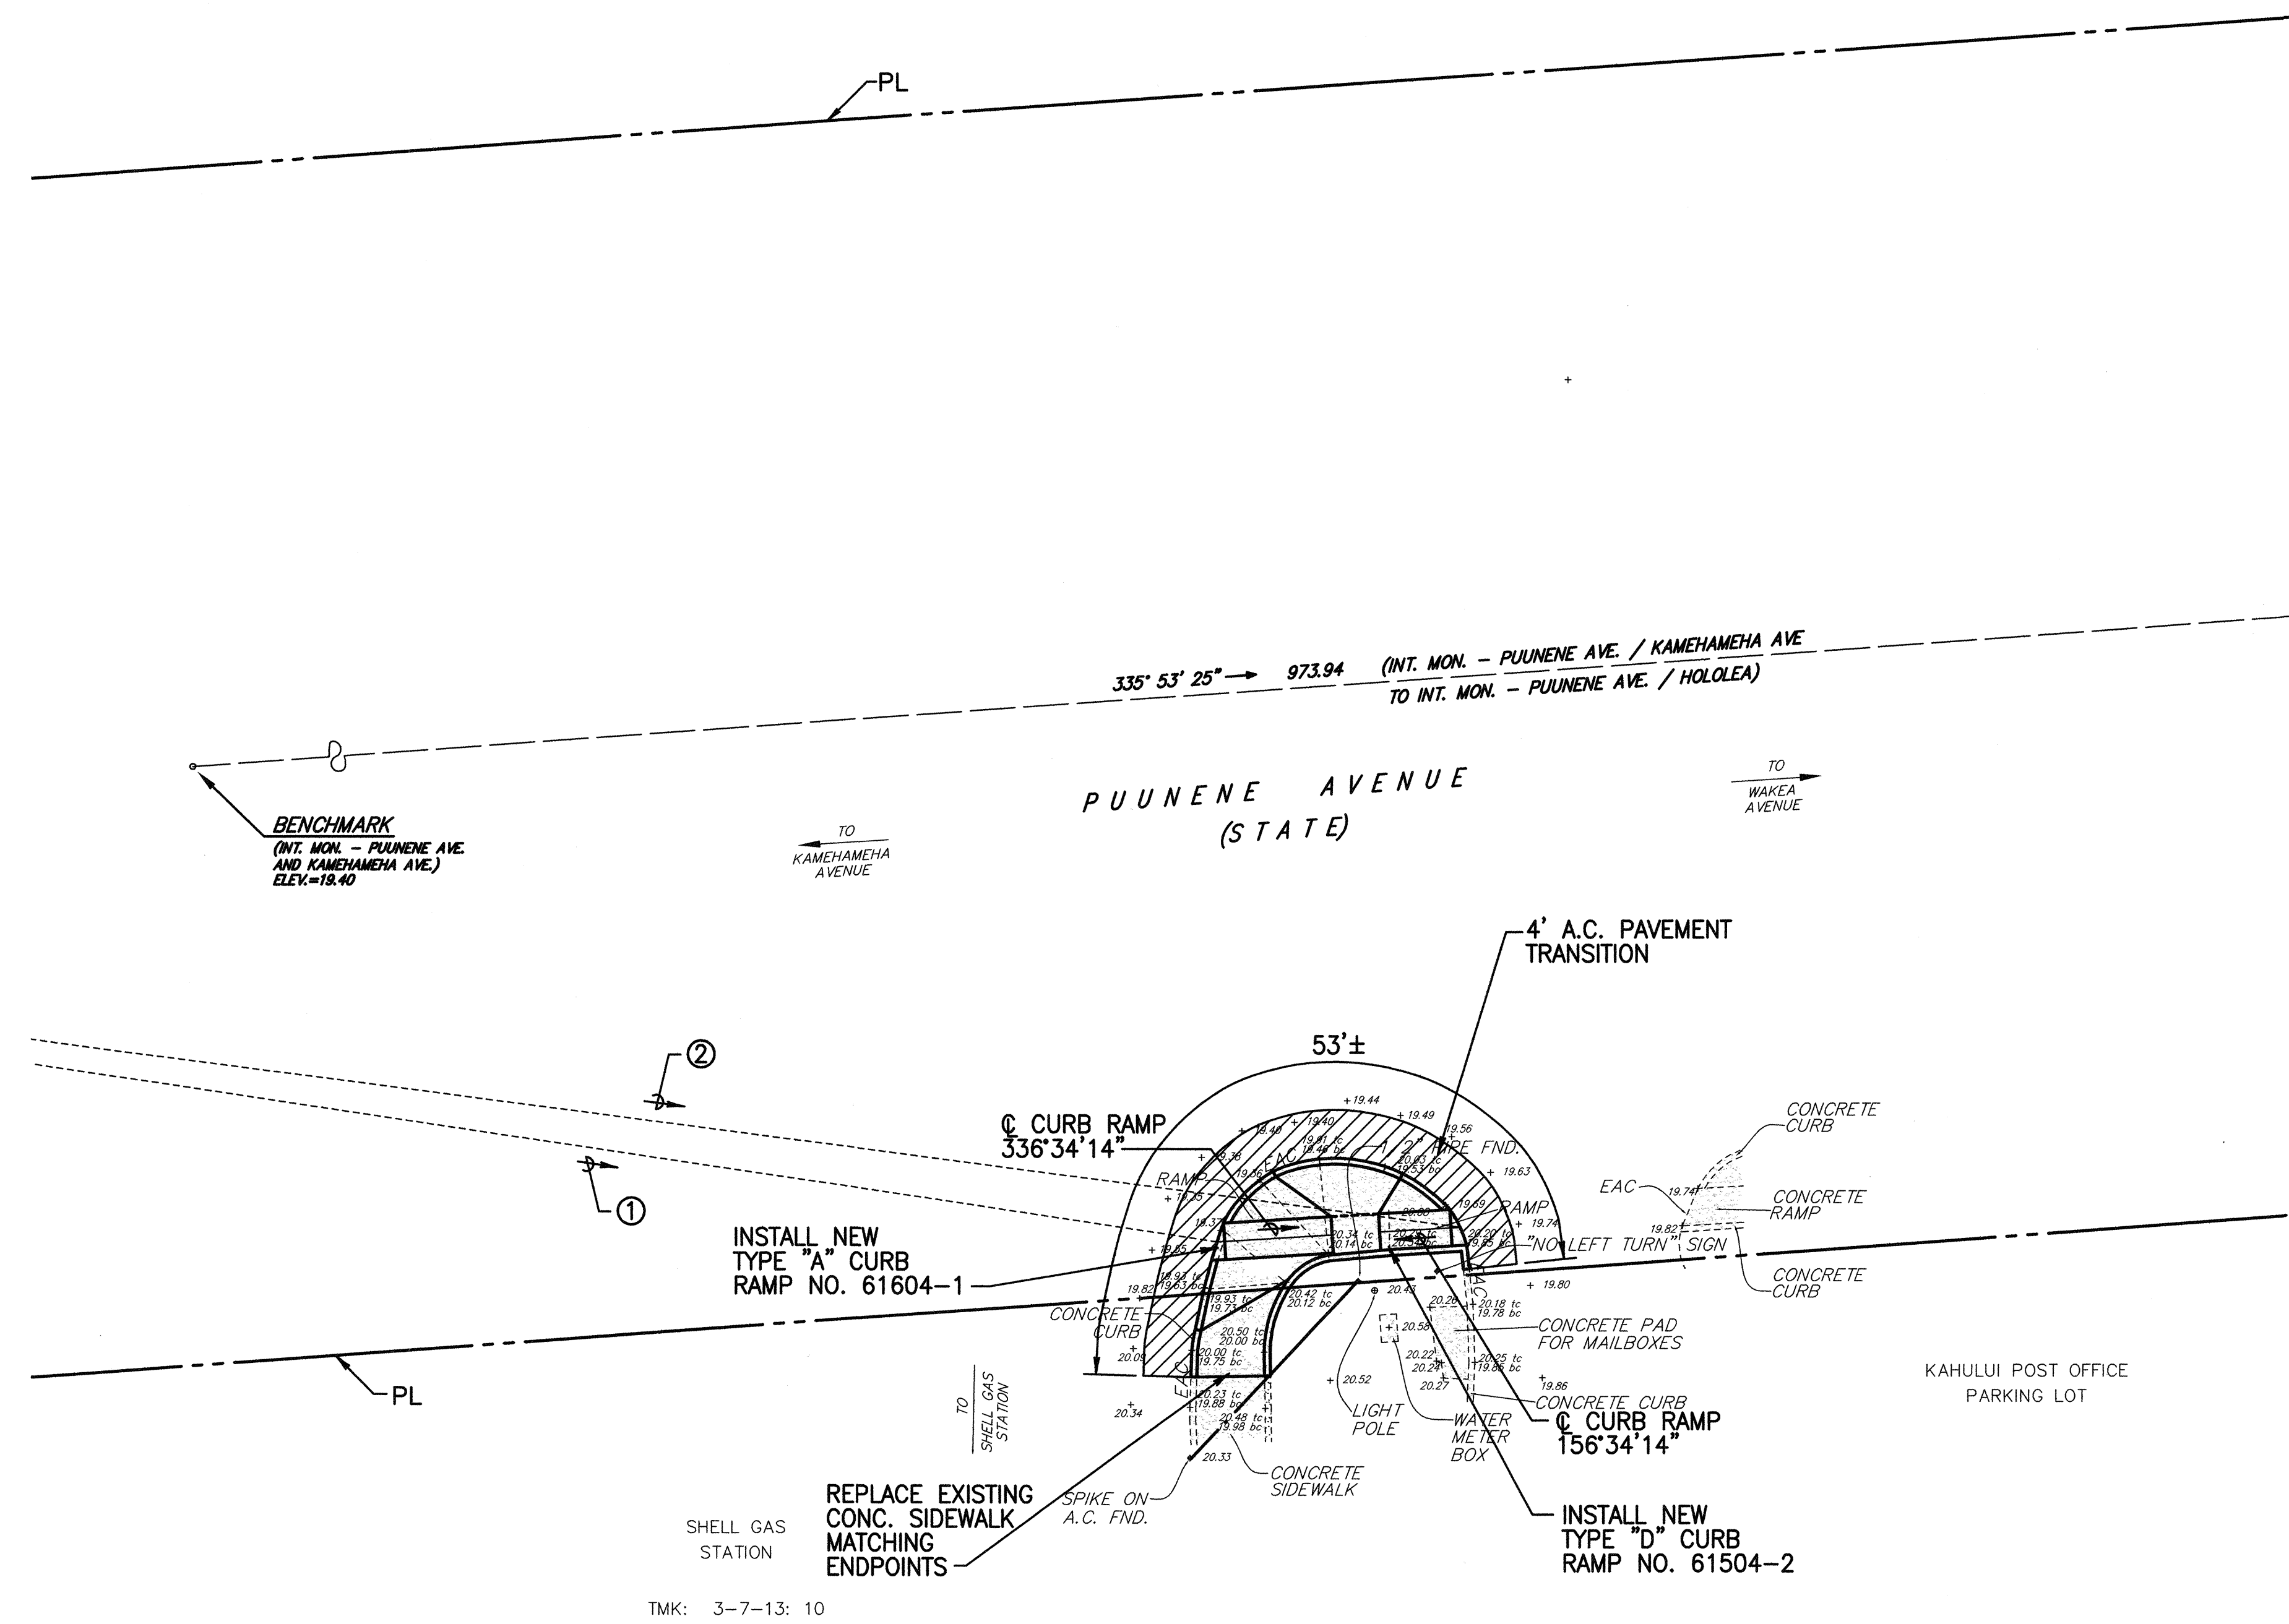

CURB RAMP NO. 61504-2/61604-1 DETAILS
SCALE: 1"= 5'


NOTES:

- SEE SHEETS CB-1 TO CB-10 FOR CURB RAMP, STRIPING, AND MISCELLANEOUS DETAILS.
- FOR ALL ELECTRICAL WORK, SEE ELECTRICAL PLANS.


	STATE OF HAWAII	
	DEPARTMENT OF TRANSPORTATION	
	HIGHWAYS DIVISION	
	PUUNENE AVE./POST OFFICE EXIT (61504)/SHELL	
	GAS STATION ENTRANCE (61604) CURB RAMP PLAN	
PEDESTRIAN FACILITIES & ADA		
COMPLIANCE AT VARIOUS		
LOCATIONS ON MAUI		
Federal - Aid Project No. CMAQ-0900(67)R		
Scale: As Shown Date: August 2004		
SHEET No. CC-16 OF 31 SHEETS		

SITE PLAN
SCALE: 1"= 10'

DATE	3/10/04
SURVEY PLOTTED BY	
DESIGNED BY	
NOTED BY	
CHECKED BY	
NO.	

 [illegible]

FED. ROAD DIST. NO.	STATE	FEDERAL - AID PROJ. NO.	FISCAL YEAR	SHEET NO.	TOTAL SHEETS
HAWAII	HAW.	CMAQ-0900(67)R	2004	39	109



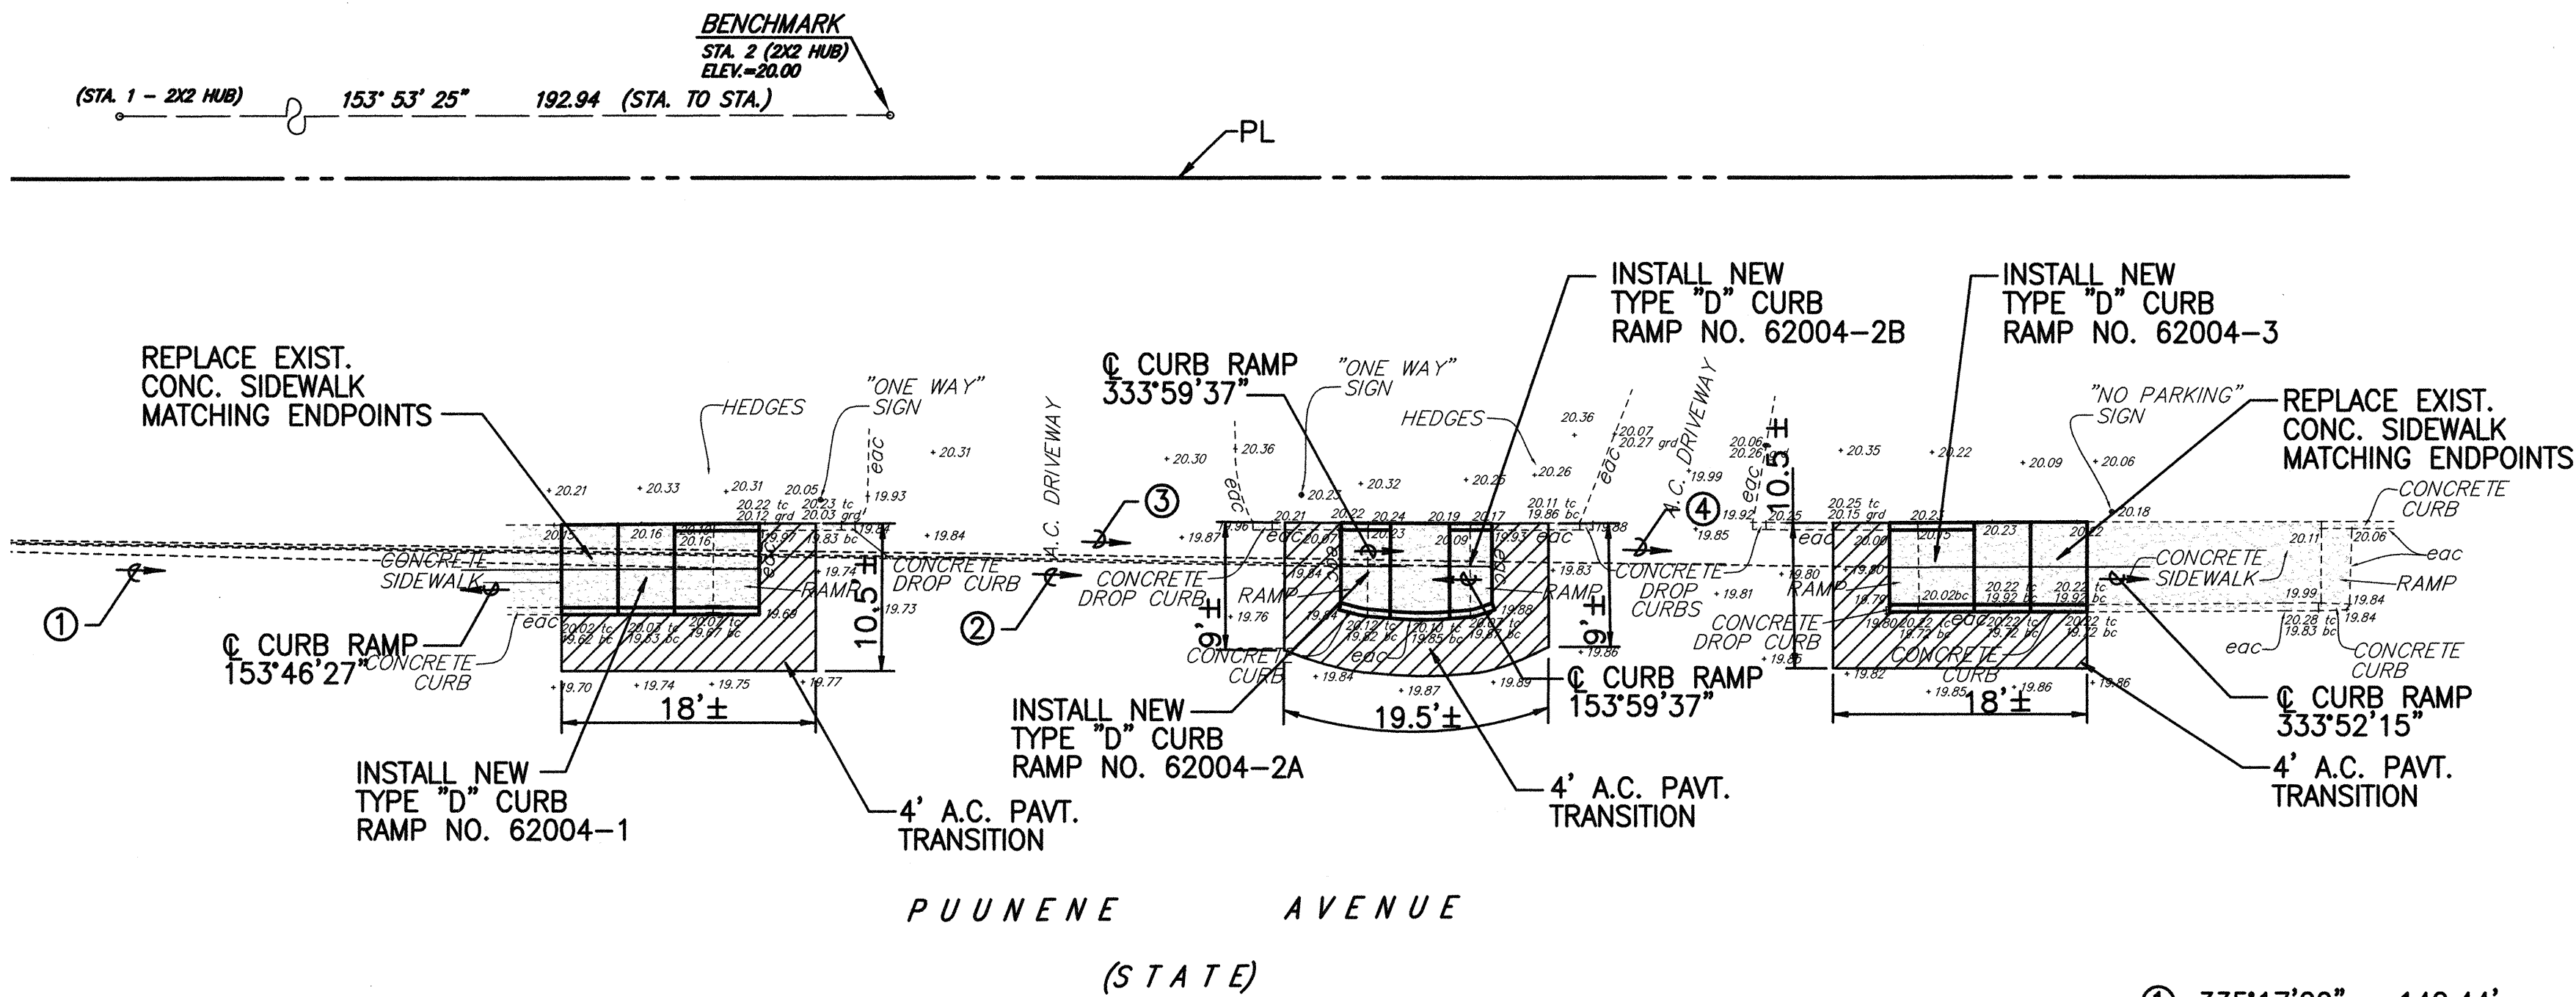


- NOTES:
- SEE SHEETS CB-1 TO CB-10 FOR CURB RAMP, STRIPING, AND MISCELLANEOUS DETAILS.
 - FOR ALL ELECTRICAL WORK, SEE ELECTRICAL PLANS.



SITE PLAN
SCALE: 1"= 10'

- 335°17'20" 142.44'
(BM STA. 2 TO INTERSECTION OF
C RAMP EDGE & CURB FACE)
- 334°55'27" 183.69'
(BM STA. 2 TO INTERSECTION OF
C RAMP EDGE & CURB FACE)
- 334°52'23" 194.38'
(BM STA. 2 TO INTERSECTION OF
C RAMP EDGE & CURB FACE)
- 334°45'59" 222.56'
(BM STA. 2 TO INTERSECTION OF
C RAMP EDGE & CURB FACE)

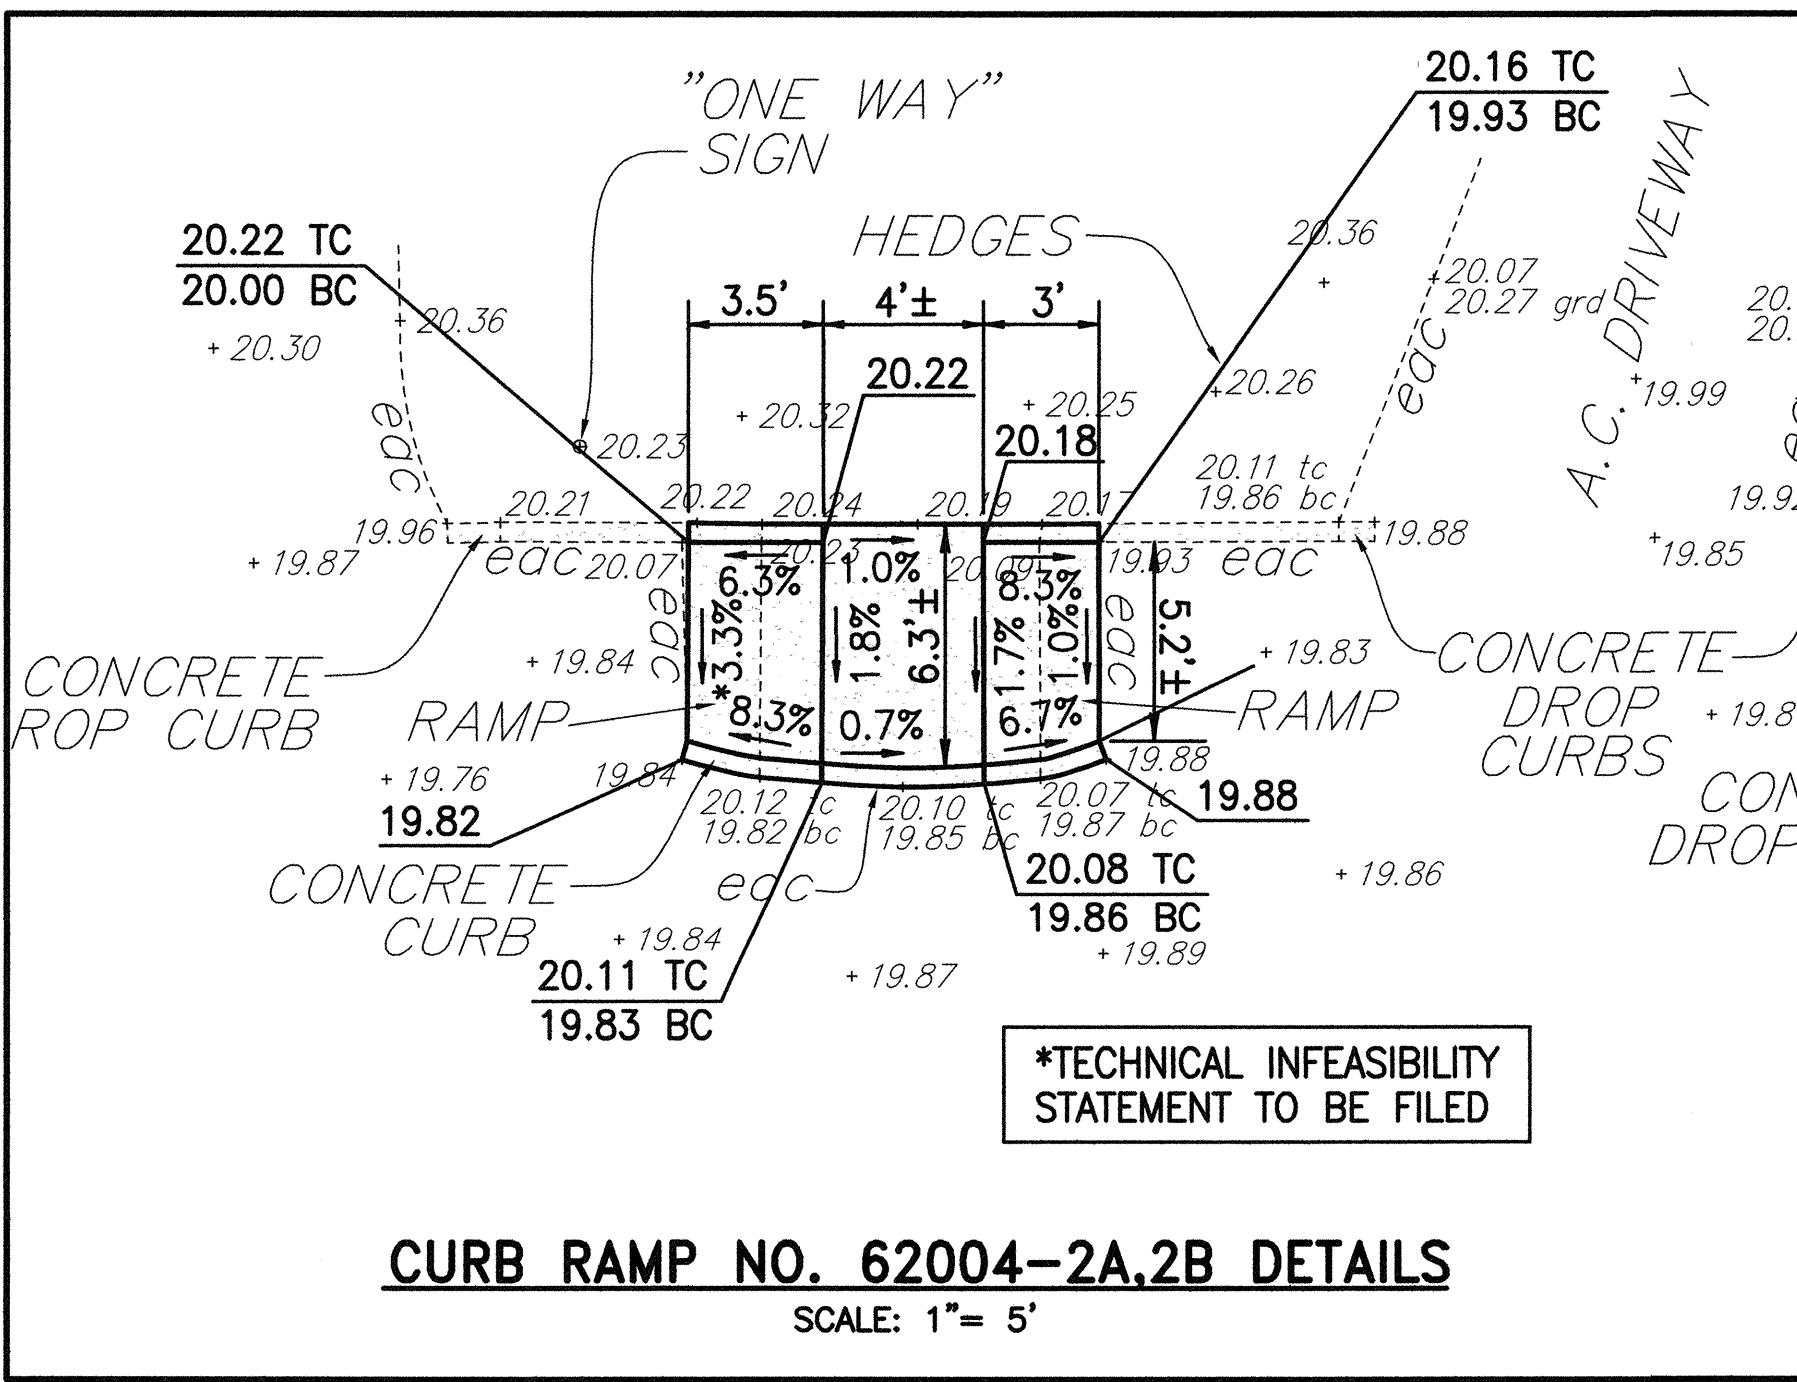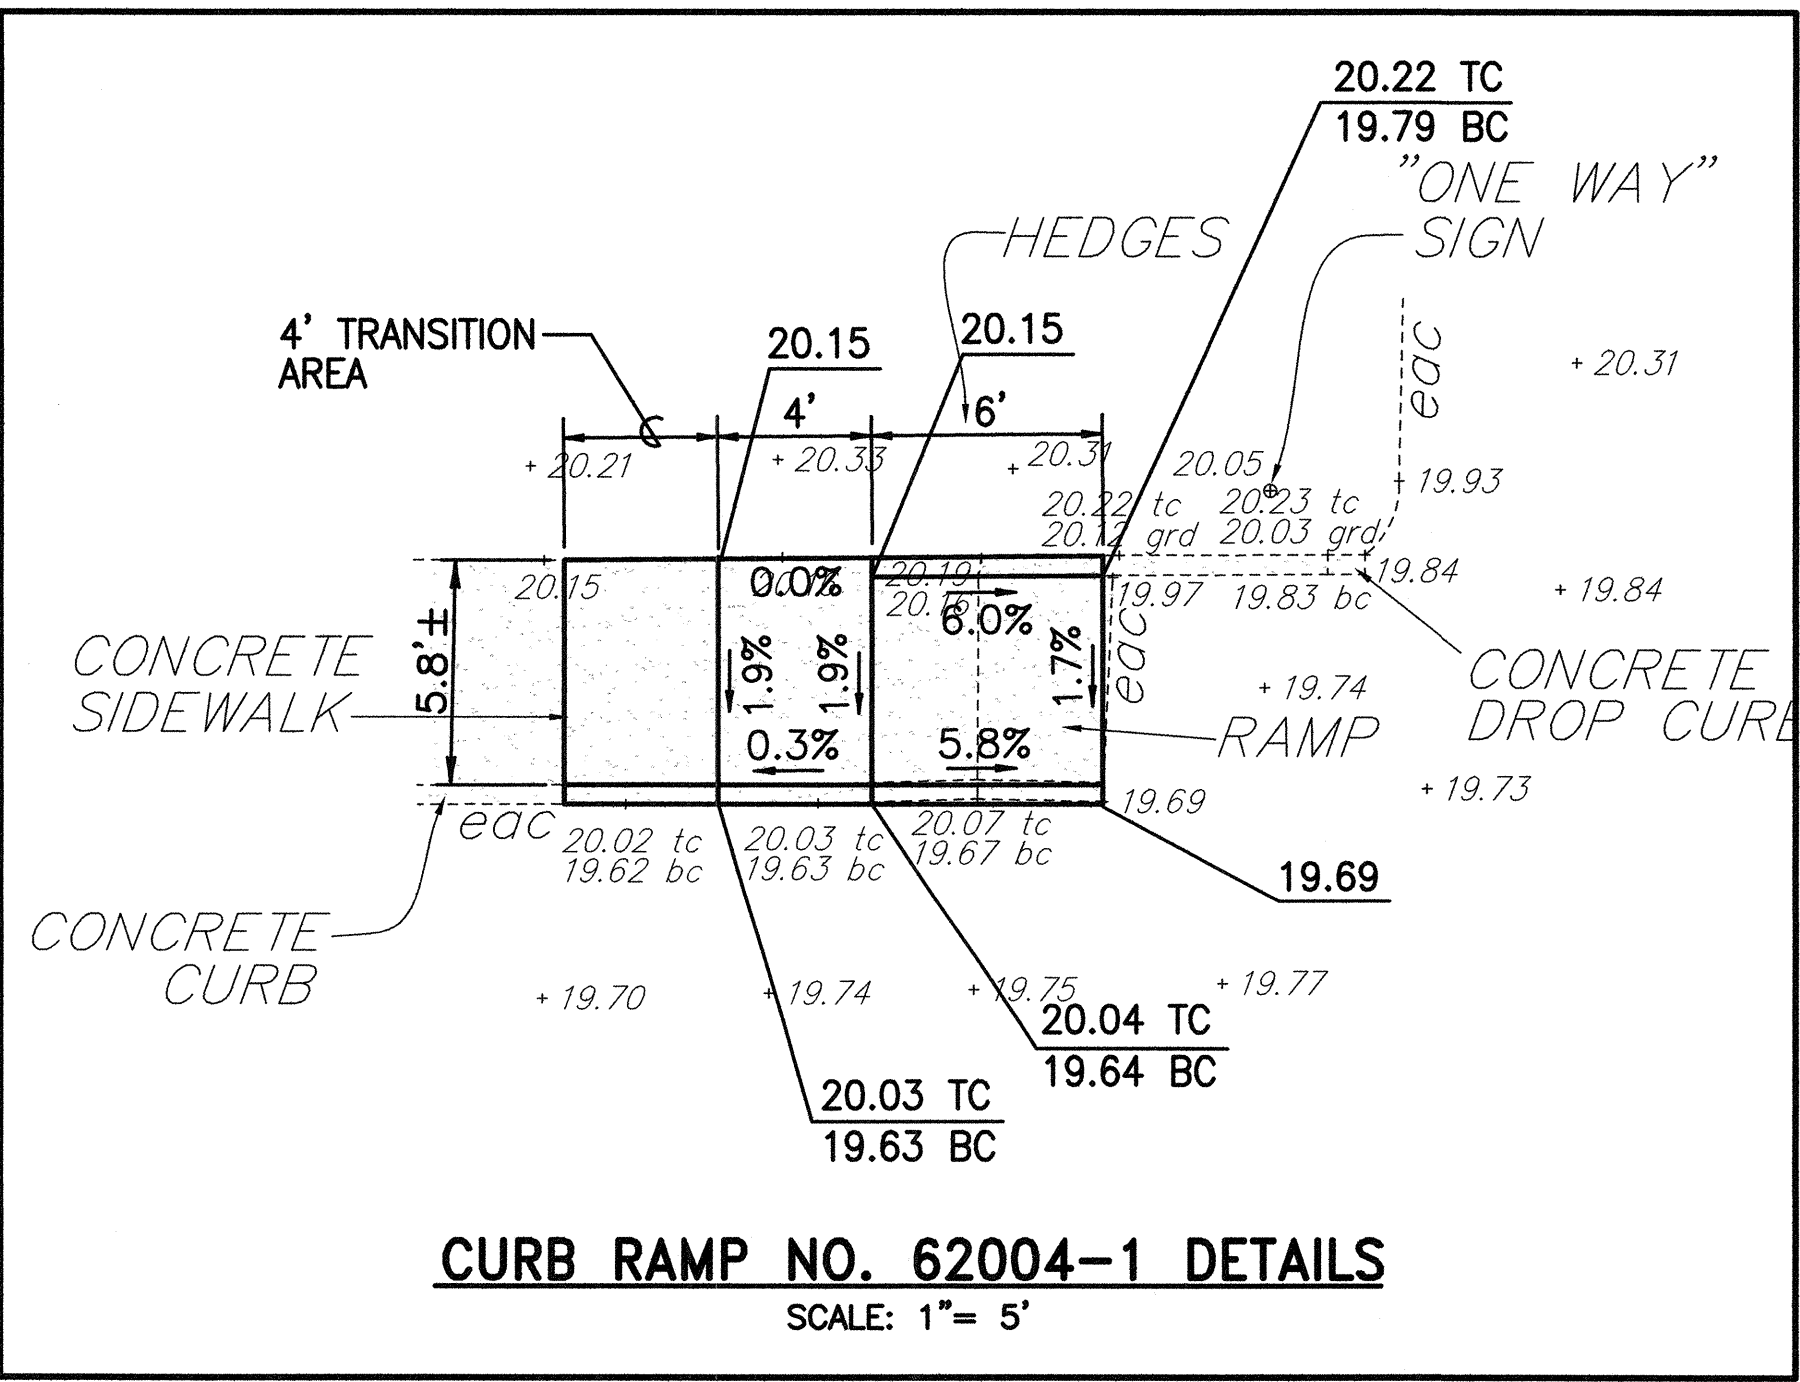
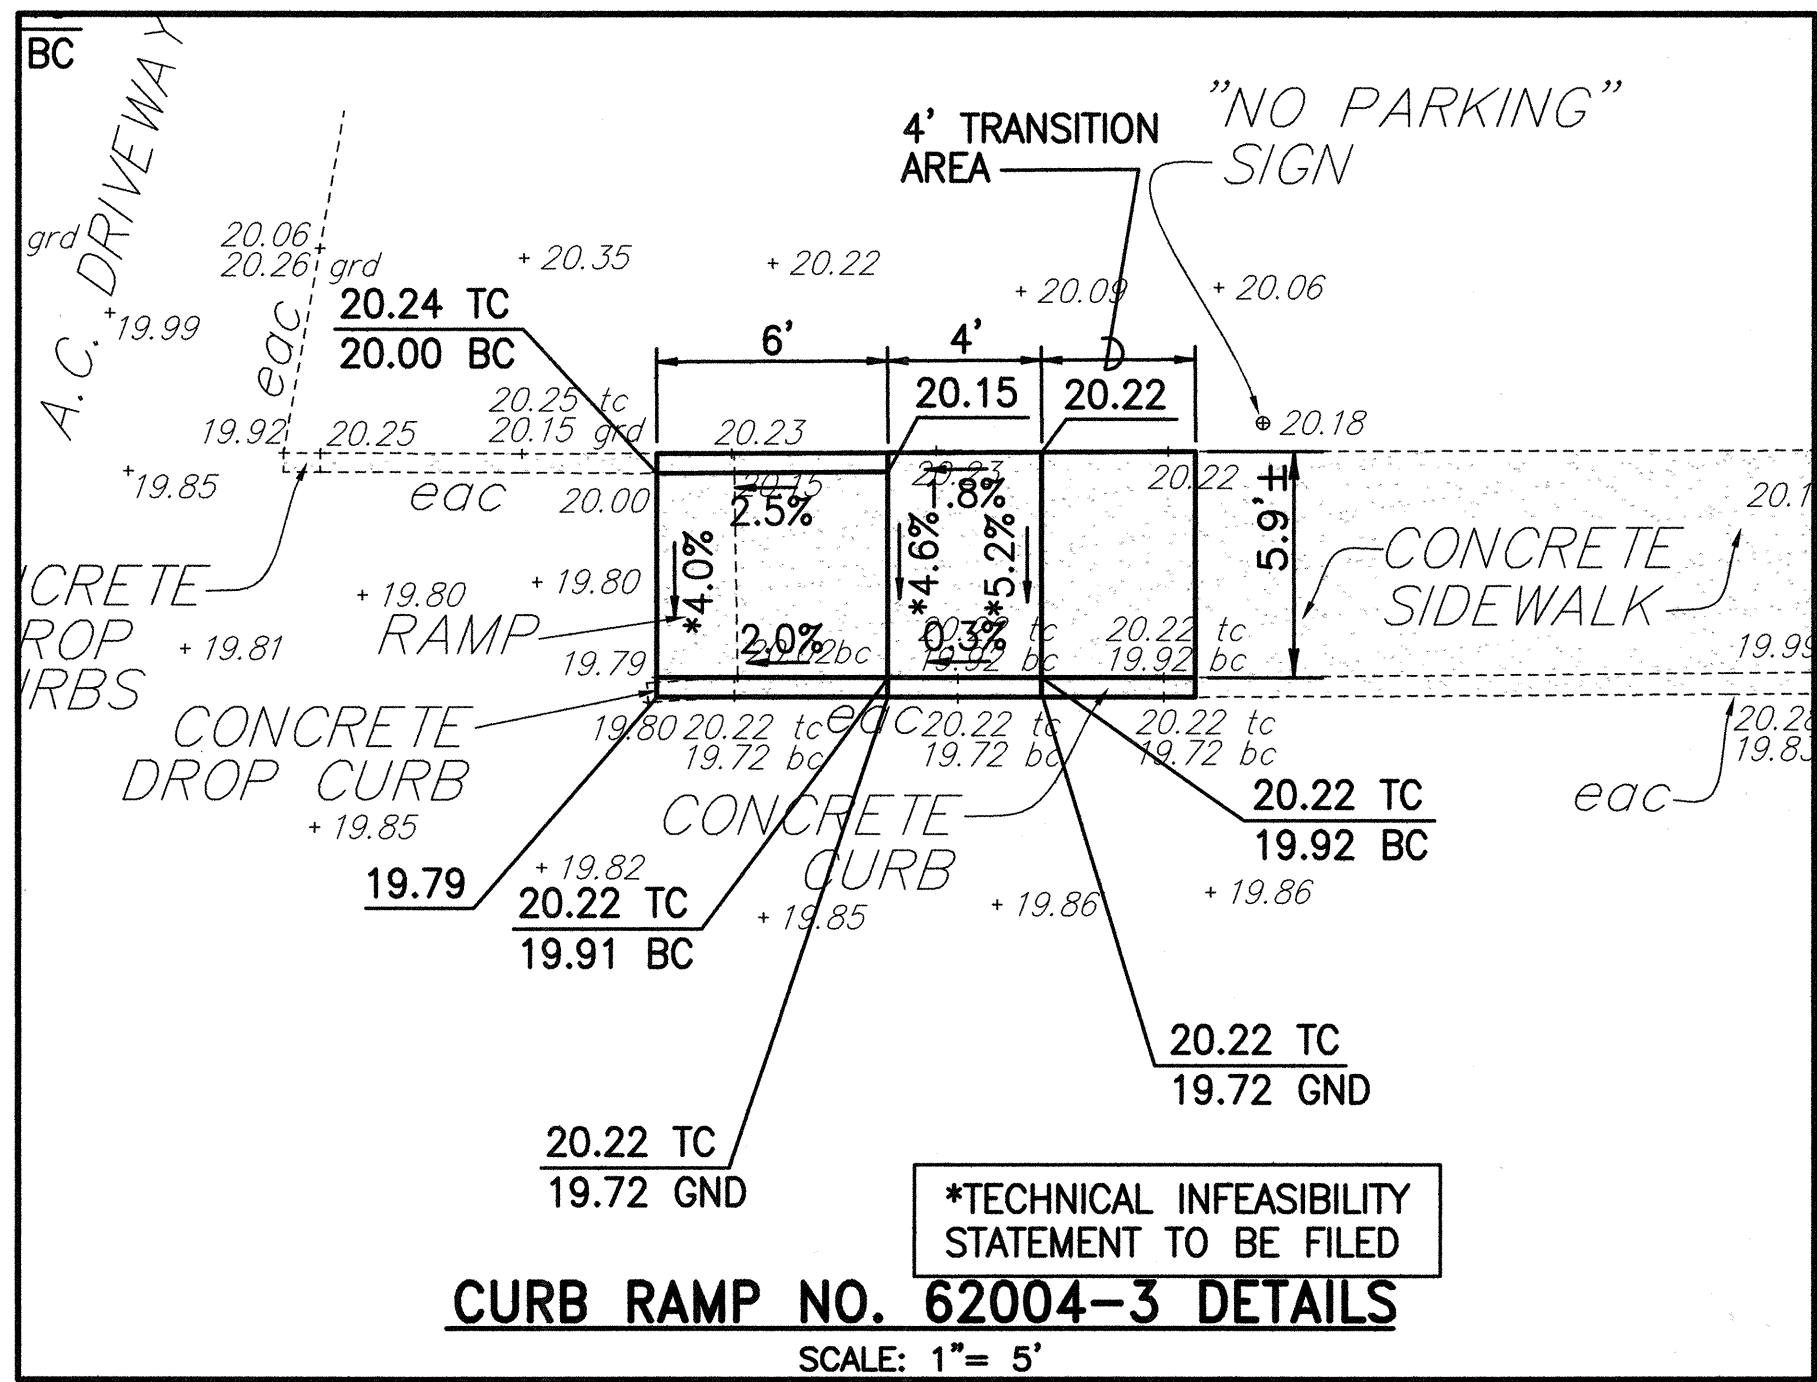


 DANIEL S. MIYAMOTO LICENSED PROFESSIONAL ENGINEER No. 3443-C HAWAII U.S.A. THIS WORK WAS PREPARED BY ME OR UNDER MY SUPERVISION 04/30/06 EXPIRATION DATE OF THE LICENSE 18-9-22-04	STATE OF HAWAII DEPARTMENT OF TRANSPORTATION HIGHWAYS DIVISION PUUNENE AVE./ROCKY'S LIMO AND A.S.B.(62004) CURB RAMP PLAN PEDESTRIAN FACILITIES & ADA COMPLIANCE AT VARIOUS LOCATIONS ON MAUI Federal - Aid Project No. CMAQ-0900(67)R Scale: As Shown Date: August 2004 SHEET No. CC-18 OF 31 SHEETS
---	---

PROJ. NO.: 04008-00
5/7/04
R:\temp-s\mami\pump\28PUUNENE_ROCKY_ASB.dwg

DATE	_____
SURVEY PLOTTED BY	_____
TRACED BY	_____
DESIGNED BY	_____
QUANTITIES BY	_____
CHECKED BY	_____
ORIGINAL PLAN	_____
NOTE BOOK	_____
No.	_____

FED. ROAD DIST. NO.	STATE	FEDERAL - AID PROJ. NO.	FISCAL YEAR	SHEET NO.	TOTAL SHEETS
HAWAII	HAW.	CMAQ-0900(67)R	2004	40	109

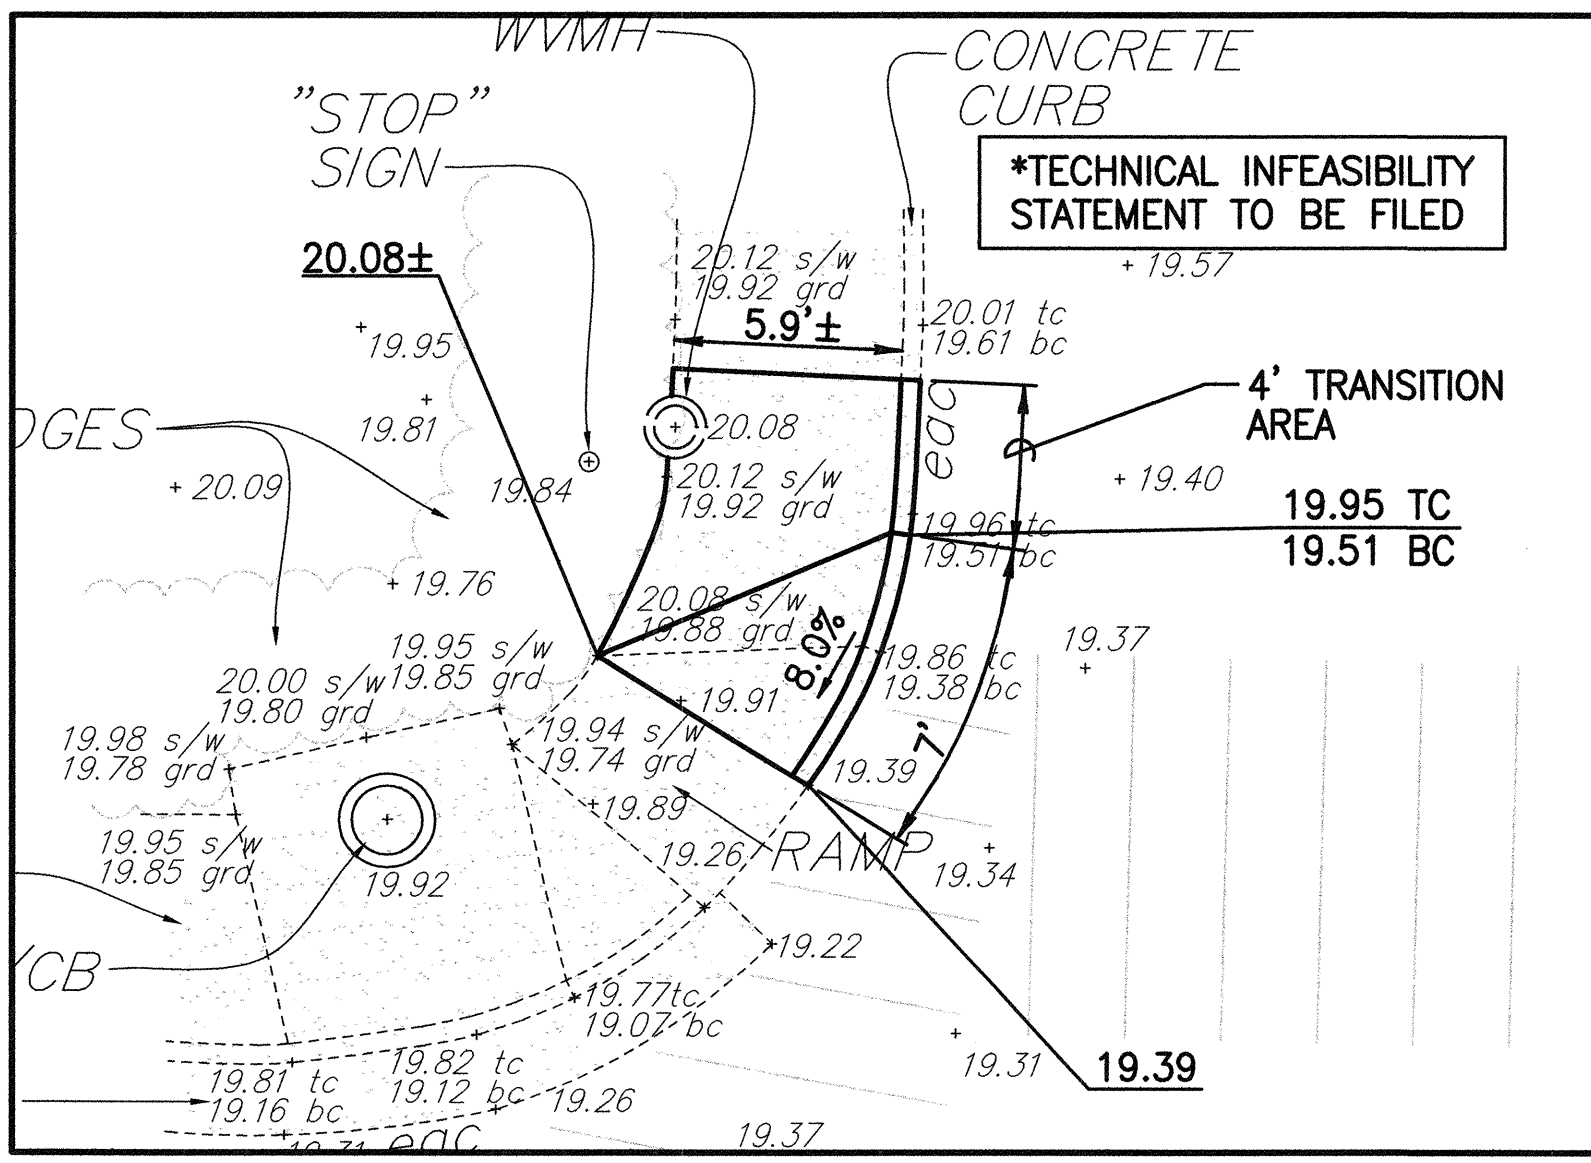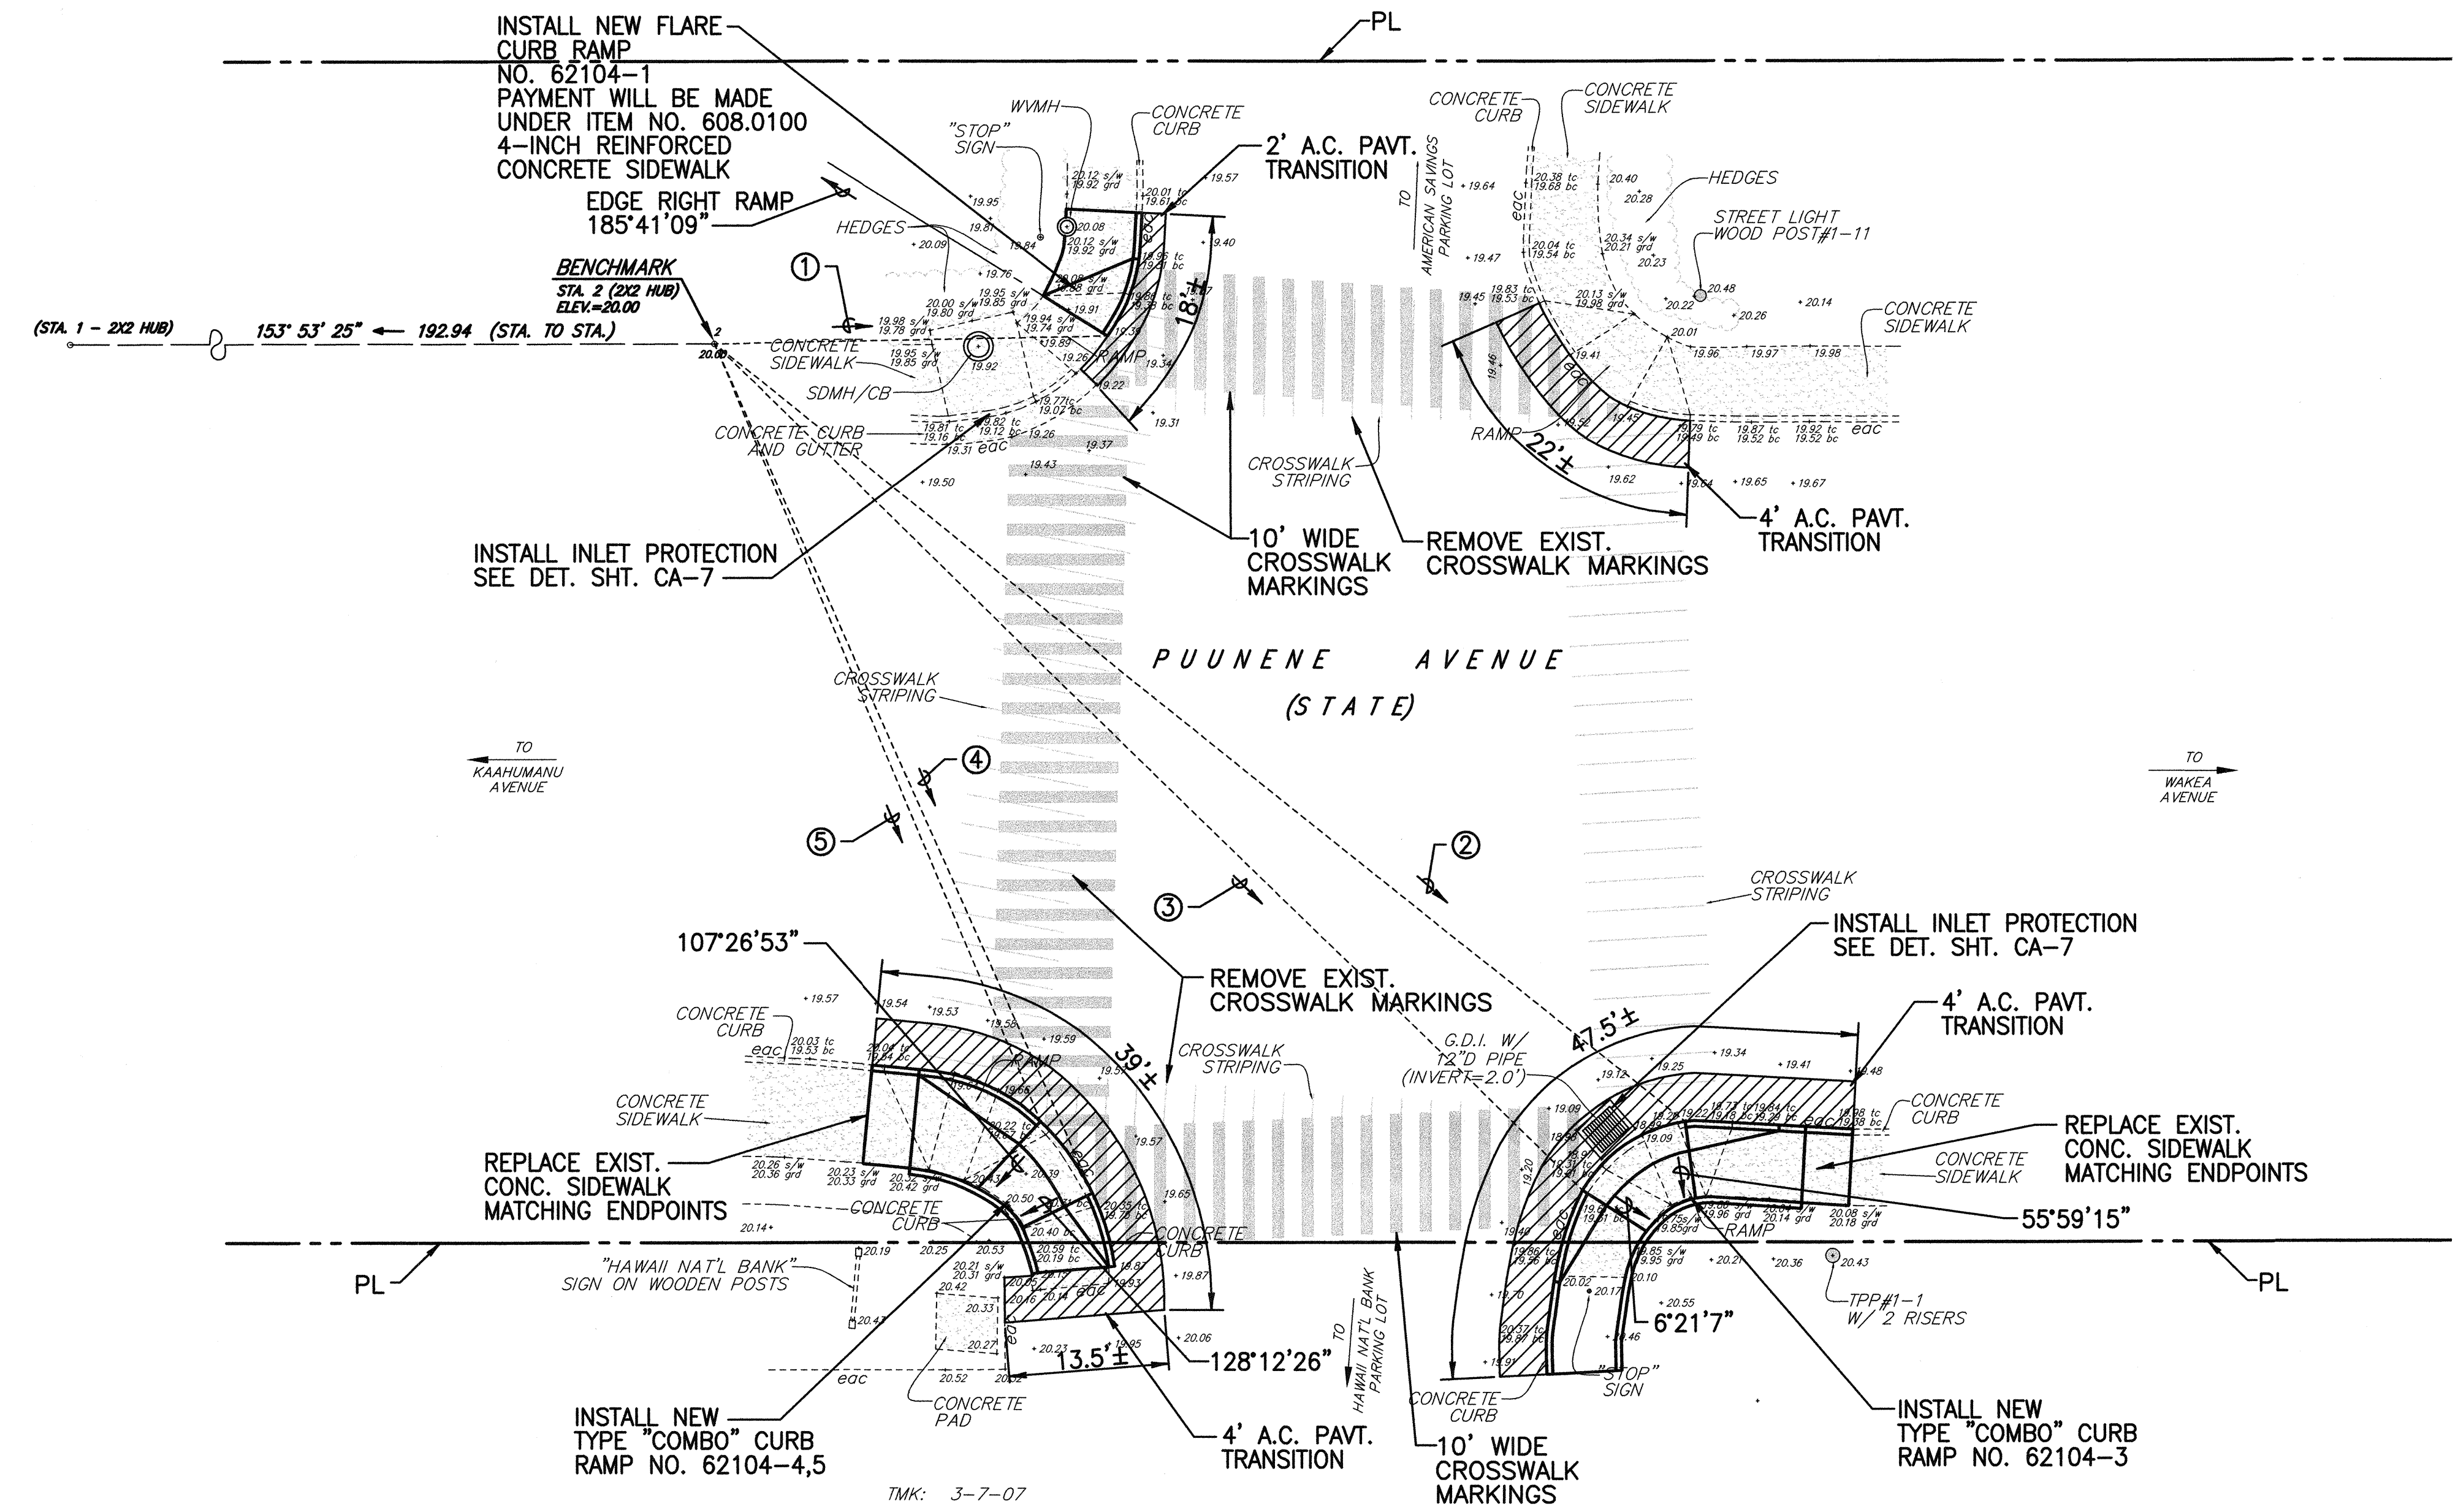


CURB RAMP NO. 62104-1 DETAILS
SCALE: 1"= 5'




- ① 332'44"13" 33.37' (BM TO INTERSECTION OF EDGE RIGHT RAMP & CURB FACE)
- ② 12'36"5" 105.34' (BM TO INTERSECTION OF RAMP EDGE & CURB FACE)
- ③ 18'9"25" 102.64' (BM TO INTERSECTION OF RAMP EDGE & CURB FACE)
- ④ 39'55"4" 78.65' (BM TO INTERSECTION OF RAMP EDGE & CURB FACE)
- ⑤ 41'10"24" 71.37' (BM TO INTERSECTION OF RAMP EDGE & CURB FACE)

NOTES:
1. SEE SHEETS CB-1 TO CB-10 FOR CURB RAMP, STRIPING, AND MISCELLANEOUS DETAILS.
2. FOR ALL ELECTRICAL WORK, SEE ELECTRICAL PLANS.

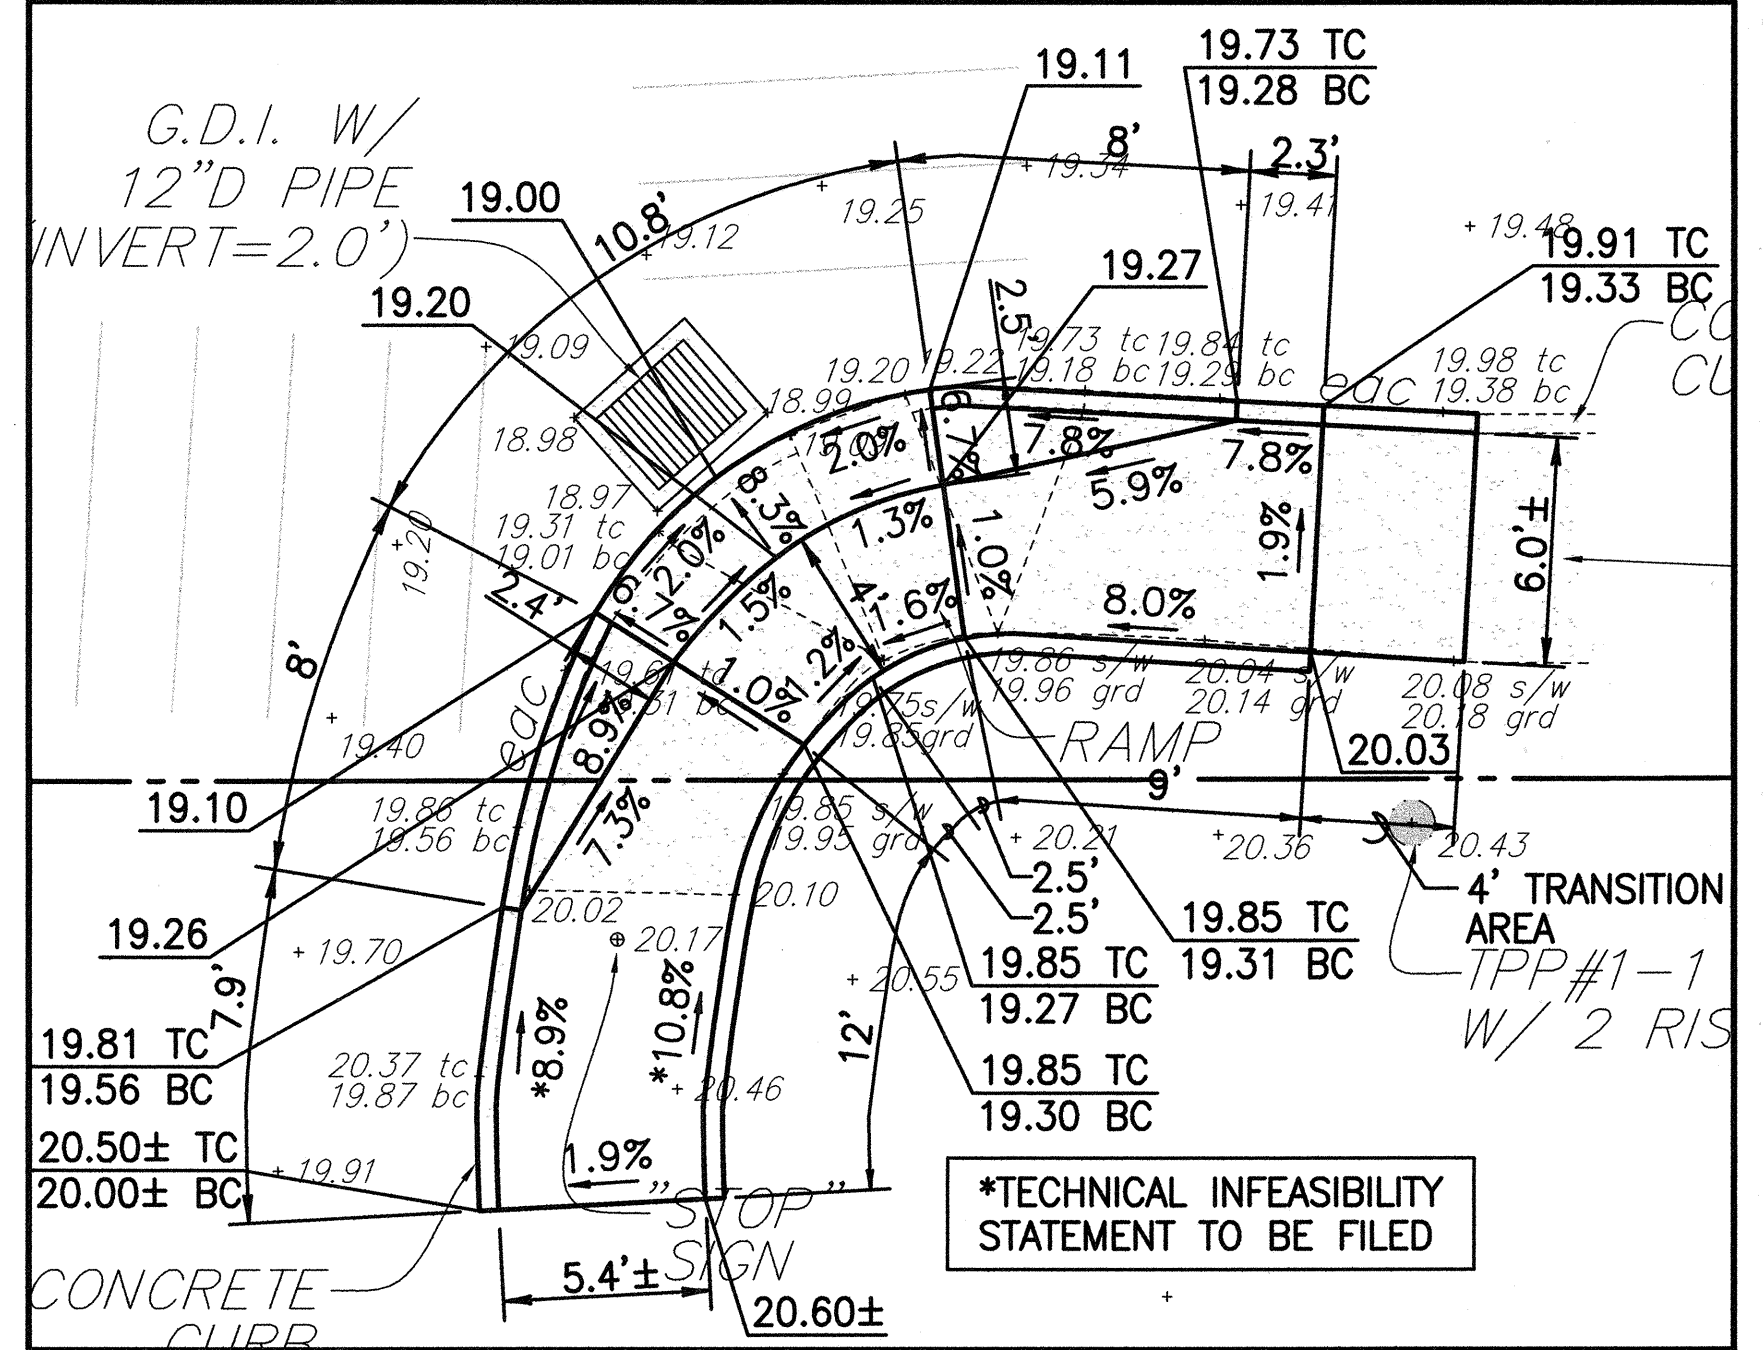

CURB RAMP NO. 62104-3 DETAILS
SCALE: 1"= 5'

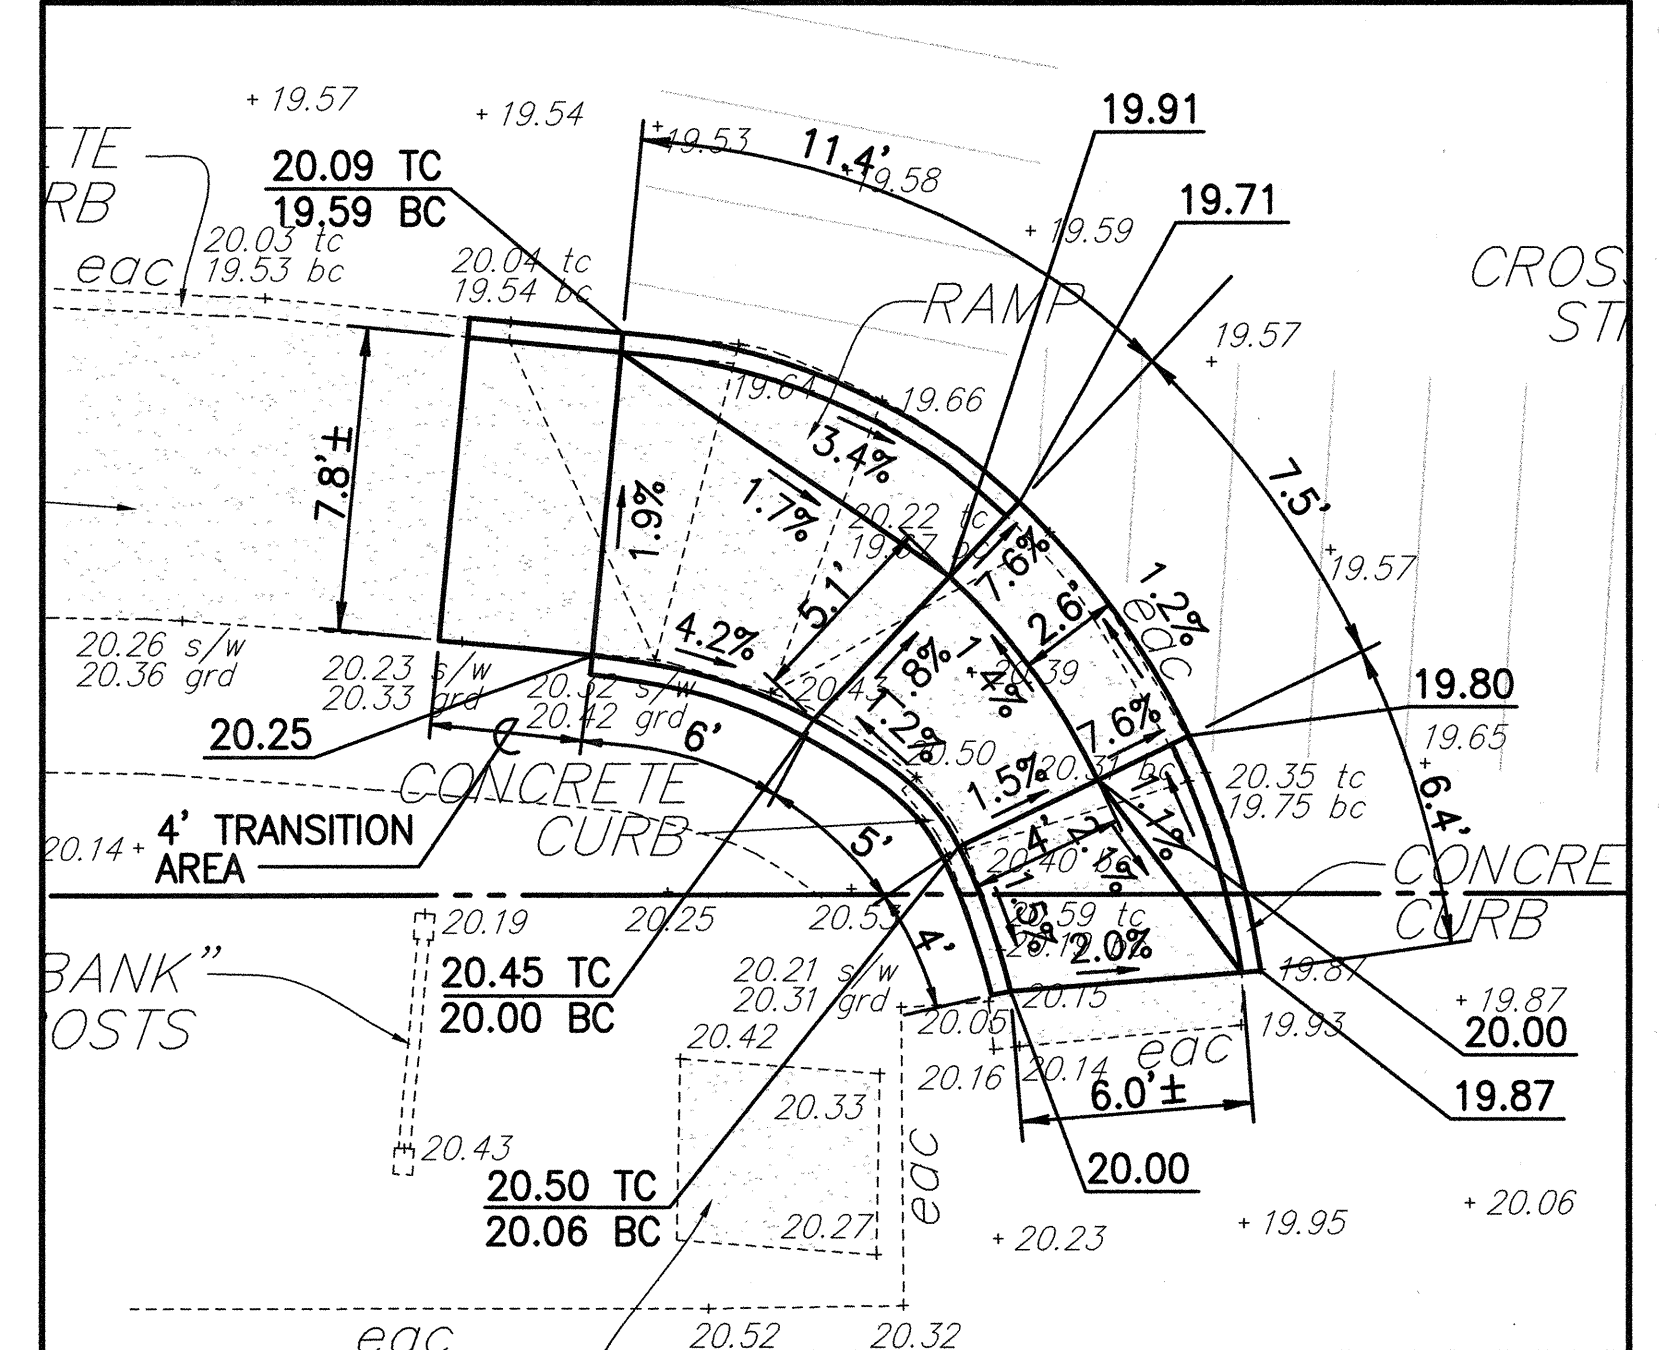

CURB RAMP NO. 62104-4.5 DETAILS
SCALE: 1"= 5'

STATE OF HAWAII
DEPARTMENT OF TRANSPORTATION
HIGHWAYS DIVISION
PUUNENE AVE./HAWAII NATIONAL BANK(62104)
CURB RAMP PLAN
PEDESTRIAN FACILITIES & ADA
COMPLIANCE AT VARIOUS
LOCATIONS ON MAUI
Federal - Aid Project No. CMAQ-0900(67)R
Scale: As Shown Date: August 2004
SHEET No. CC-19 OF 31 SHEETS

PROJ. NO.: 04008-00
5/7/04
R:\Vemp-S\musa\temp\30PUUNENE_INB.dwg

- [illegible]

[illegible]



41

1. SEE SHEETS CB-1 TO CB-10 FOR CURB RAMP, STRIPING, AND MISCELLANEOUS DETAILS.
2. FOR ALL ELECTRICAL WORK, SEE ELECTRICAL PLANS.

ORIGINAL PLAN	SURVEY PLOTTED BY _____ DATE _____
NOTE BOOK	DRAWN BY _____ " _____
	TRACED BY _____ " _____
	DESIGNED BY _____ " _____
	QUANTITIES BY _____ " _____
	CHECKED BY _____
No. _____	

	STATE OF HAWAII
	DEPARTMENT OF TRANSPORTATION
	HIGHWAYS DIVISION
	<u>HONOAPIILANI HWY./ SHAW ST. (32504)</u>
	<u>CURB RAMP PLAN</u>
	<u>PEDESTRIAN FACILITIES & ADA</u>
	<u>COMPLIANCE AT VARIOUS</u>
	<u>LOCATIONS ON MAUI</u>
	<u>Federal - Aid Project No. CMAQ-0900(67)R</u>
THIS WORK WAS PREPARED BY ME OR UNDER MY SUPERVISION	Scale: As Shown Date: August 2004
EXPIRATION DATE OF THIS LICENSE 04/30/06	SHEET NO. CC-21 OF 31 SHEETS

FED. ROAD DIST. NO.	STATE	FEDERAL - AID PROJ. NO.	FISCAL YEAR	SHEET NO.	TOTAL SHEETS
HAWAII	HAW.	CMAQ-0900(67)R	2004	43	109

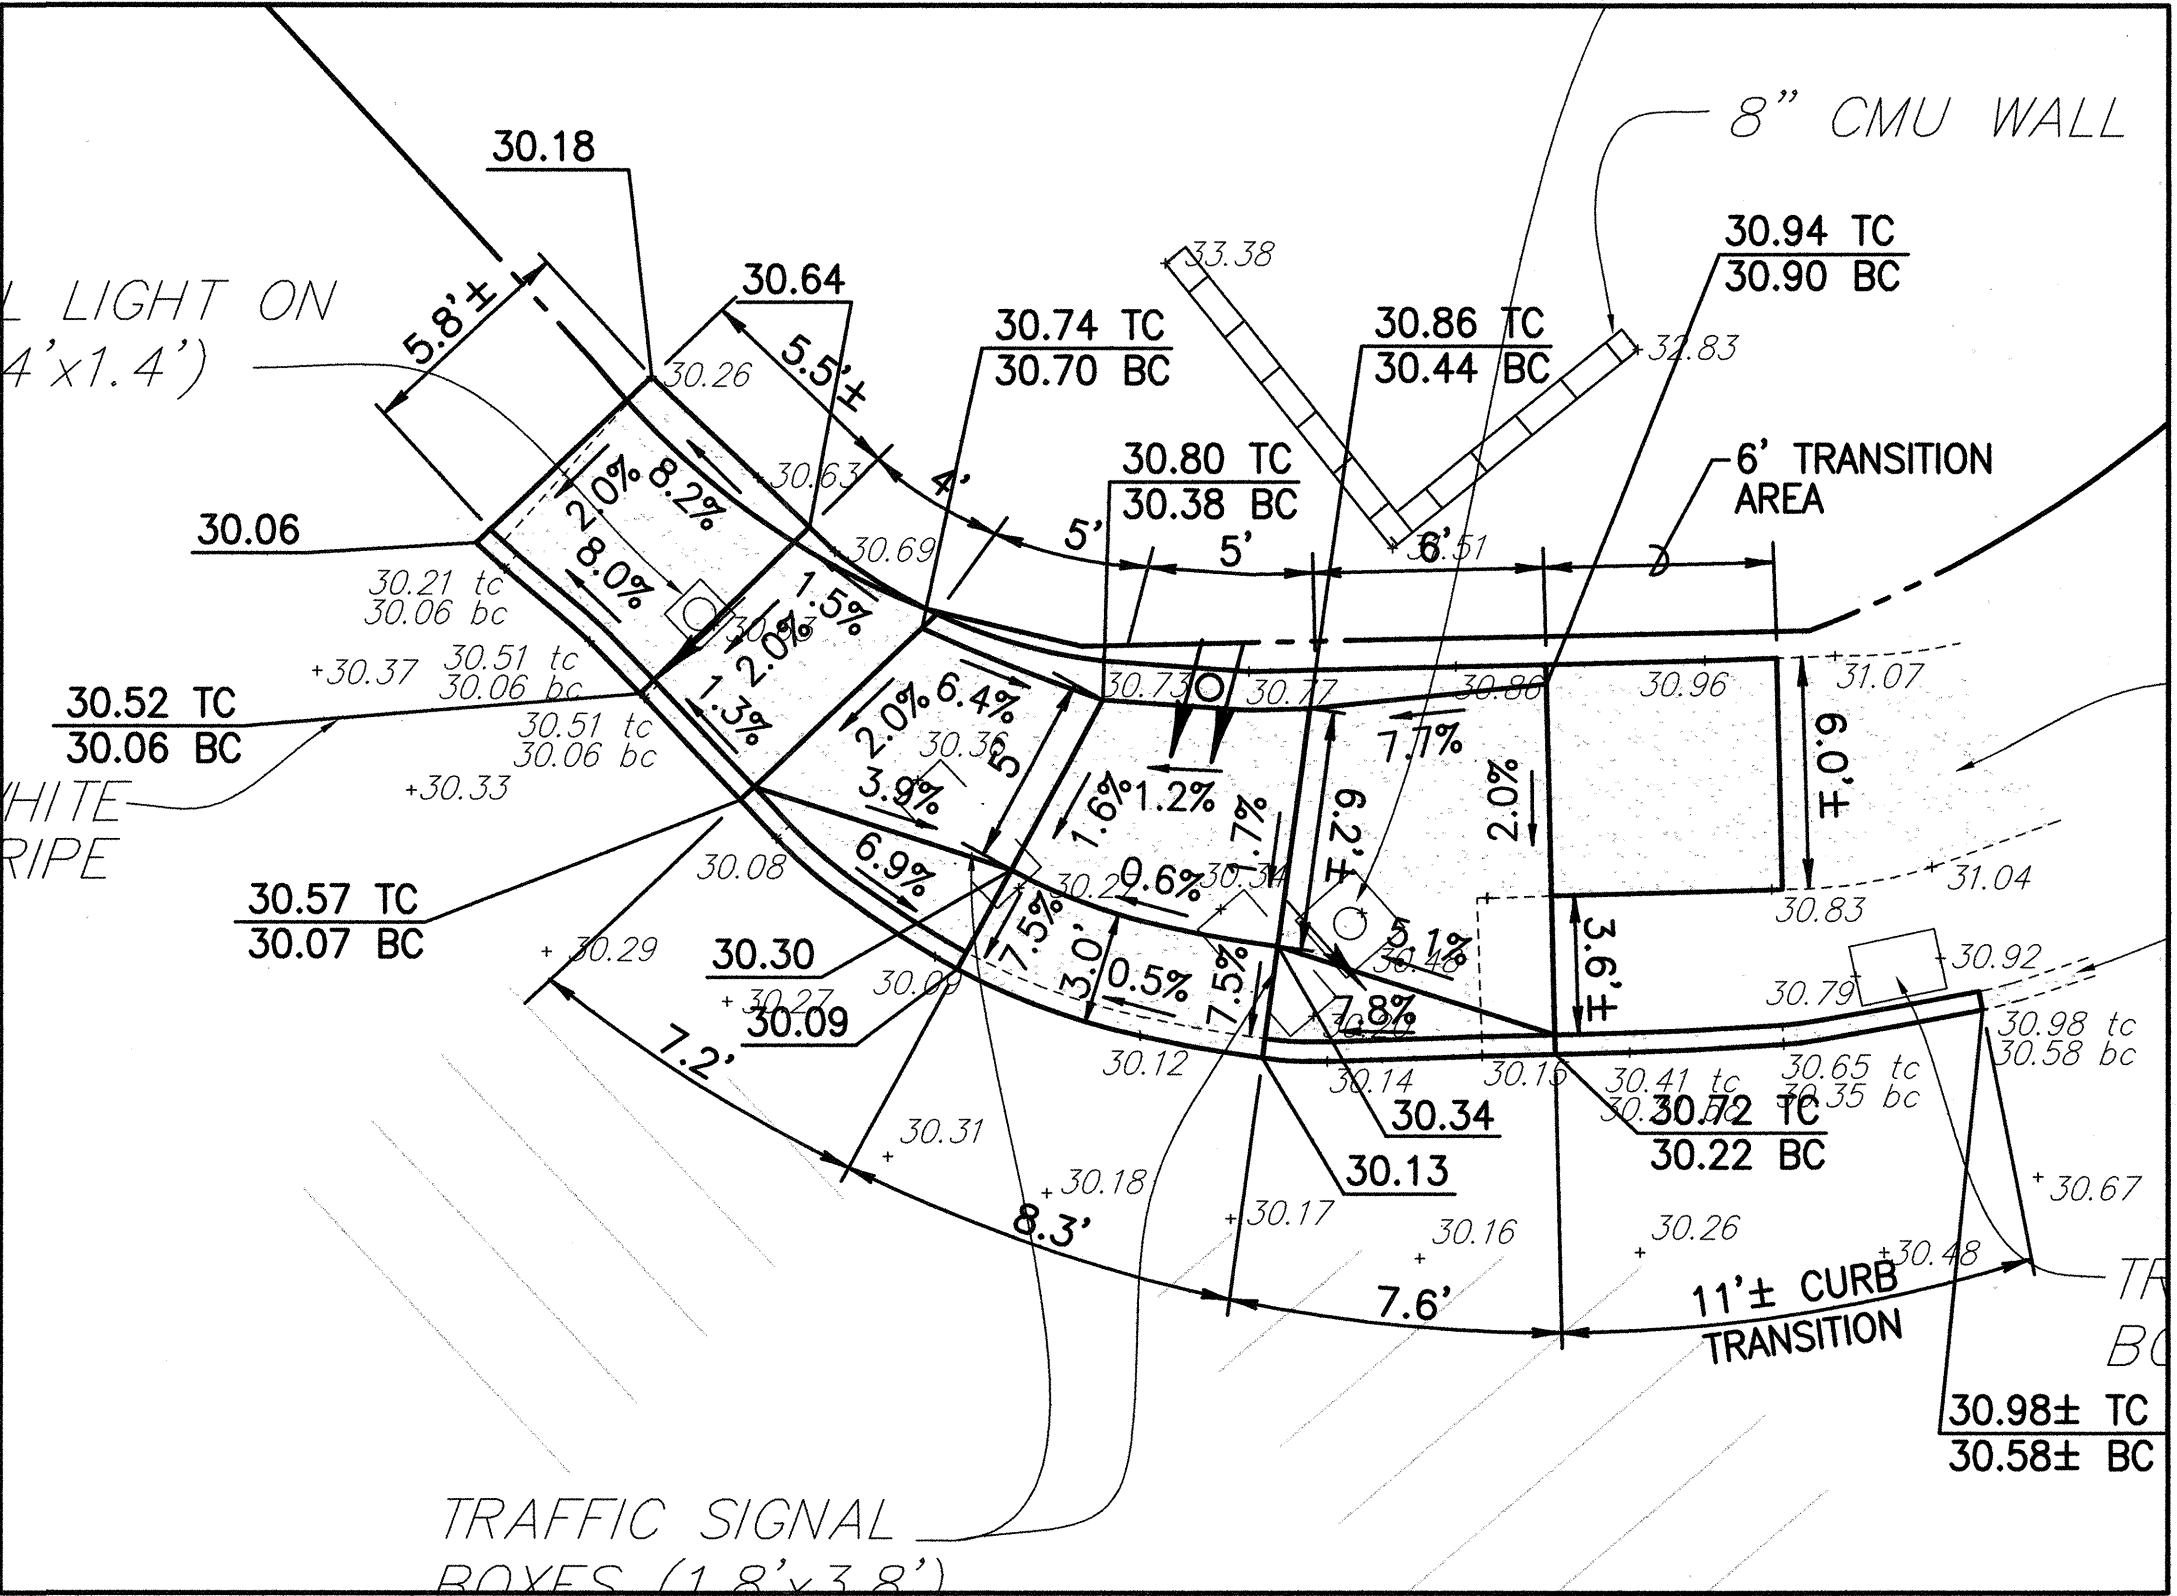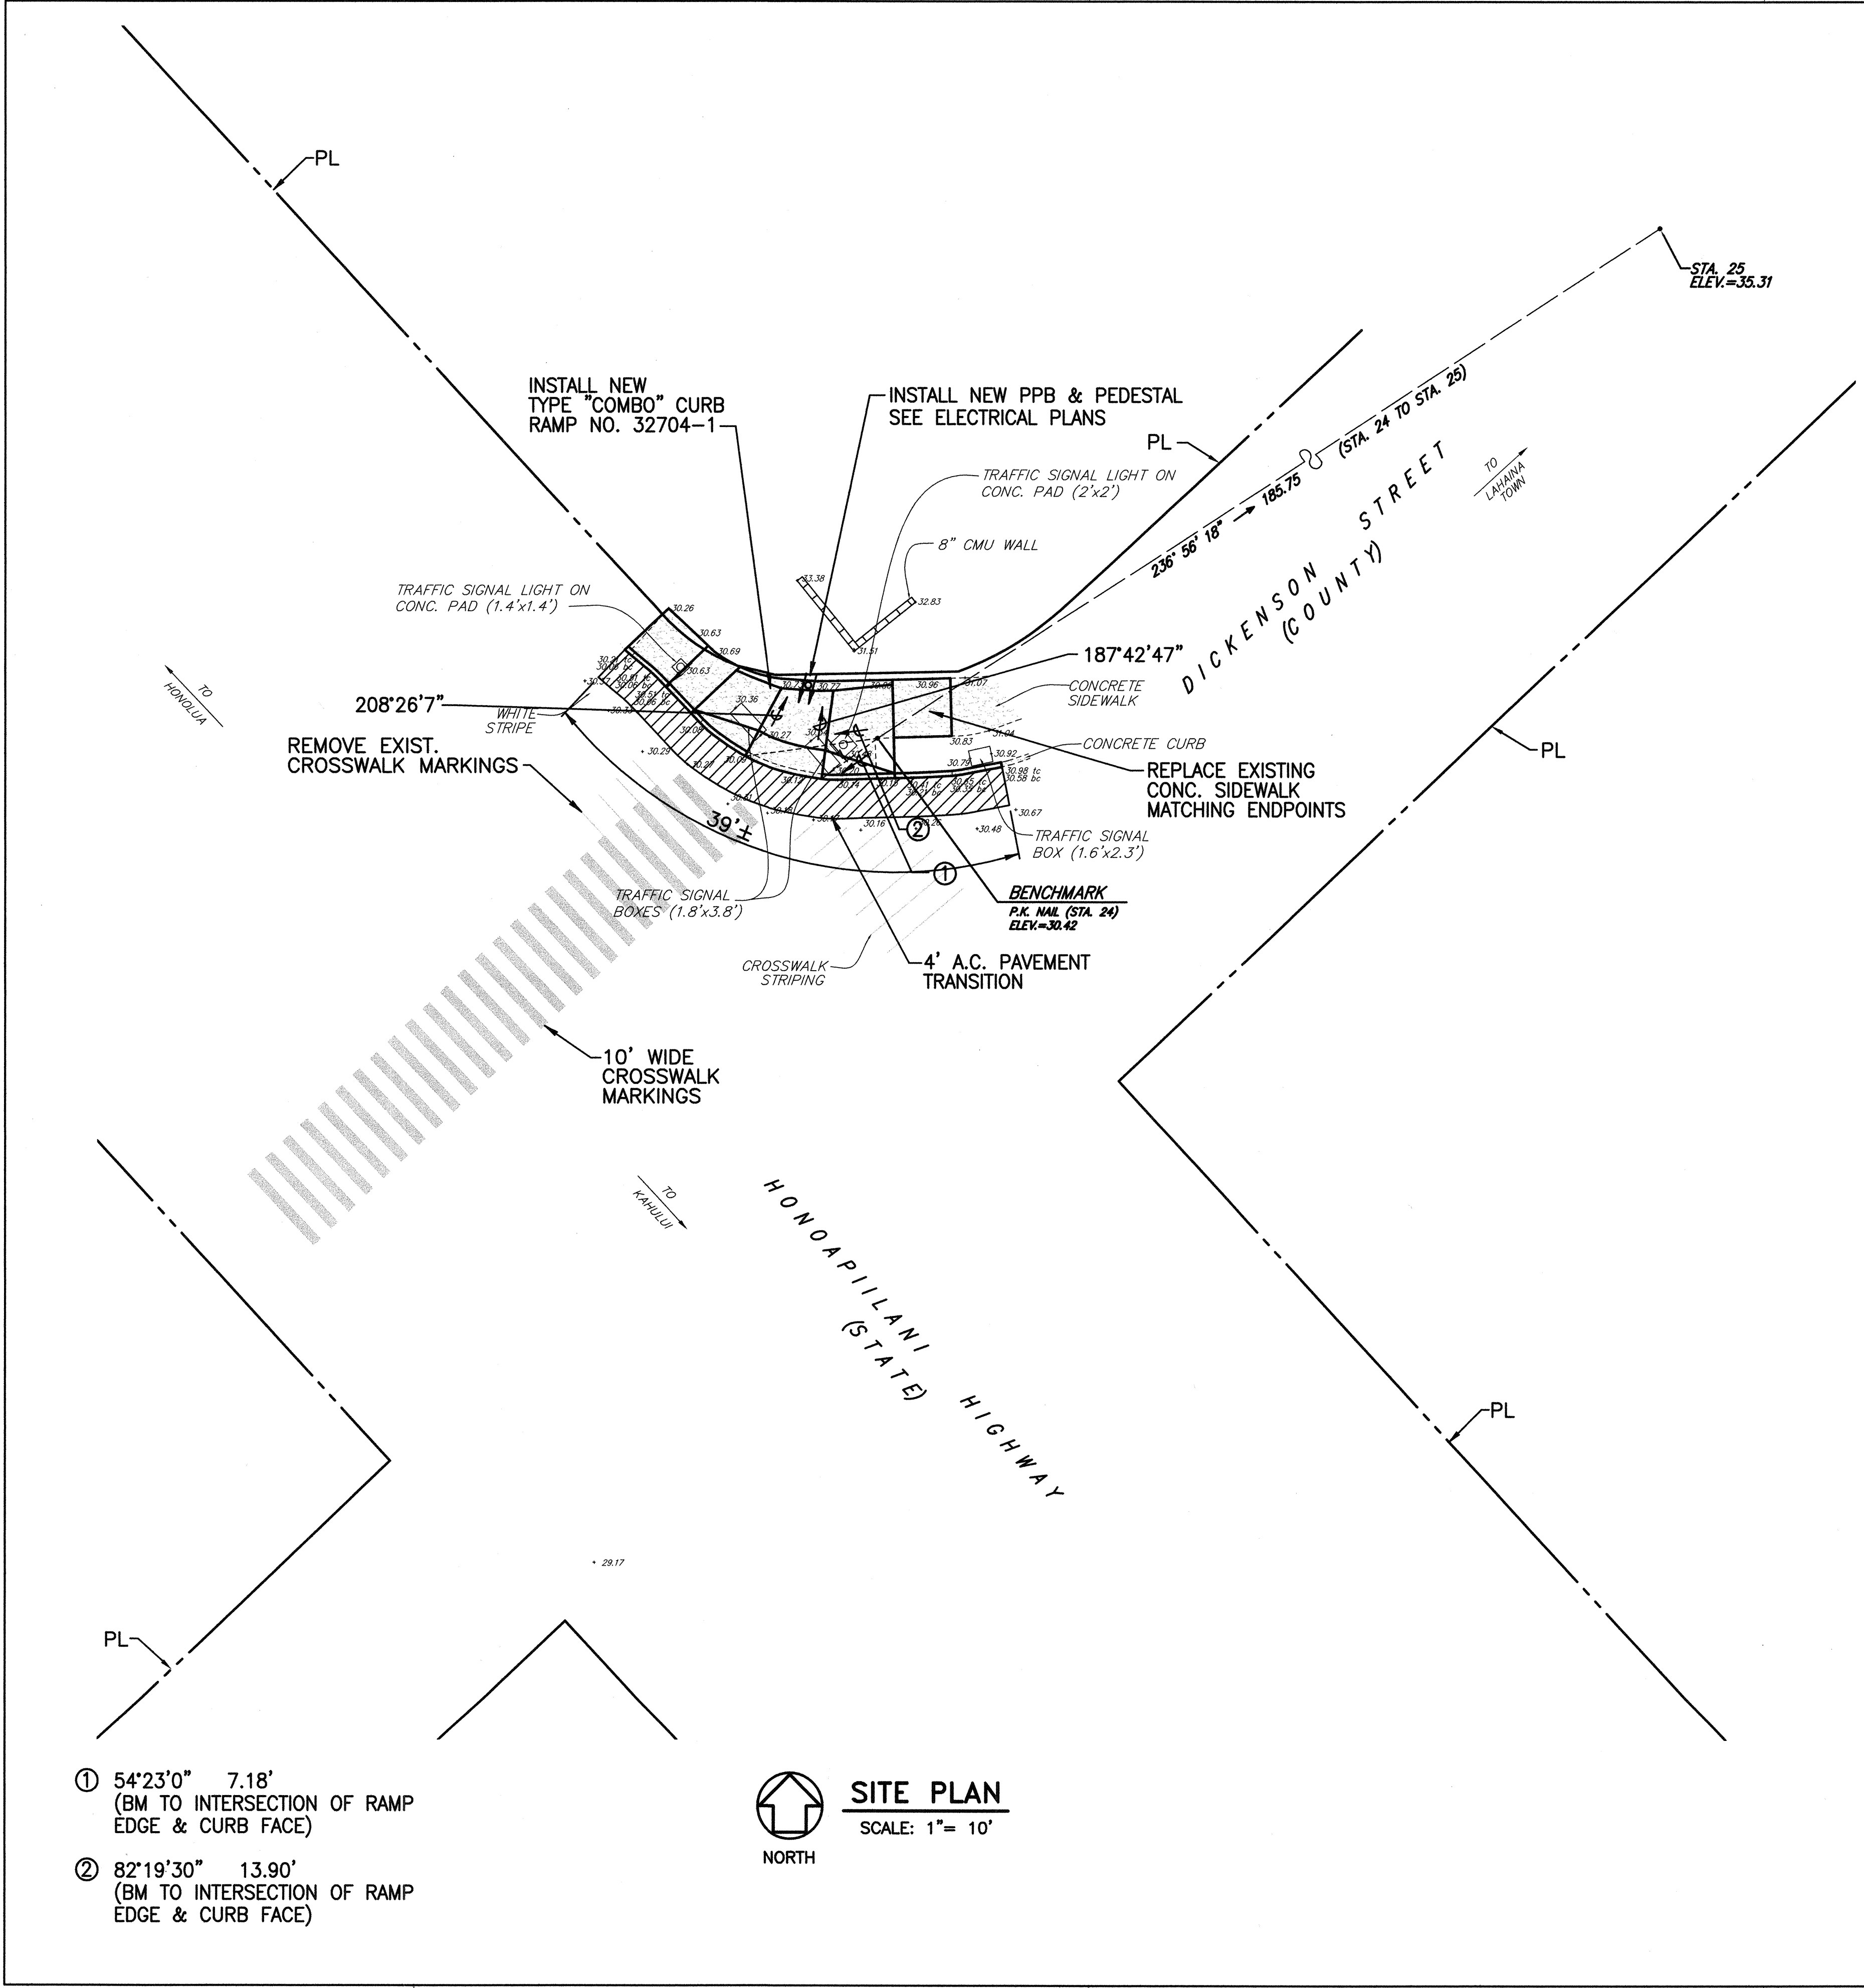


CURB RAMP NO. 32704-1 DETAILS




SCALE: 1"= 5'

NOTES:

1. SEE SHEETS CB-1 TO CB-10 FOR CURB RAMP, STRIPING, AND MISCELLANEOUS DETAILS.
2. FOR ALL ELECTRICAL WORK, SEE ELECTRICAL PLANS.

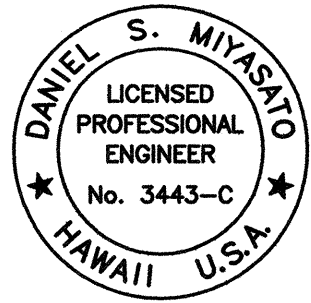  THIS WORK WAS PREPARED BY ME OR UNDER MY SUPERVISION 04/30/06 EXPIRATION DATE OF THE LICENSE 12-9-22-04	STATE OF HAWAII DEPARTMENT OF TRANSPORTATION HIGHWAYS DIVISION HONOAPIILANI HWY./ DICKENSON ST. (32704) CURB RAMP PLAN PEDESTRIAN FACILITIES & ADA COMPLIANCE AT VARIOUS LOCATIONS ON MAUI Federal - Aid Project No. CMAQ-0900(67)R Scale: As Shown Date: August 2004 SHEET No. CC-22 OF 31 SHEETS
--	--

FED. ROAD DIST. NO.	STATE	FEDERAL - AID PROJ. NO.	FISCAL YEAR	SHEET NO.	TOTAL SHEETS
HAWAII	HAW.	CMAQ-0900(67)R	2004	44	109

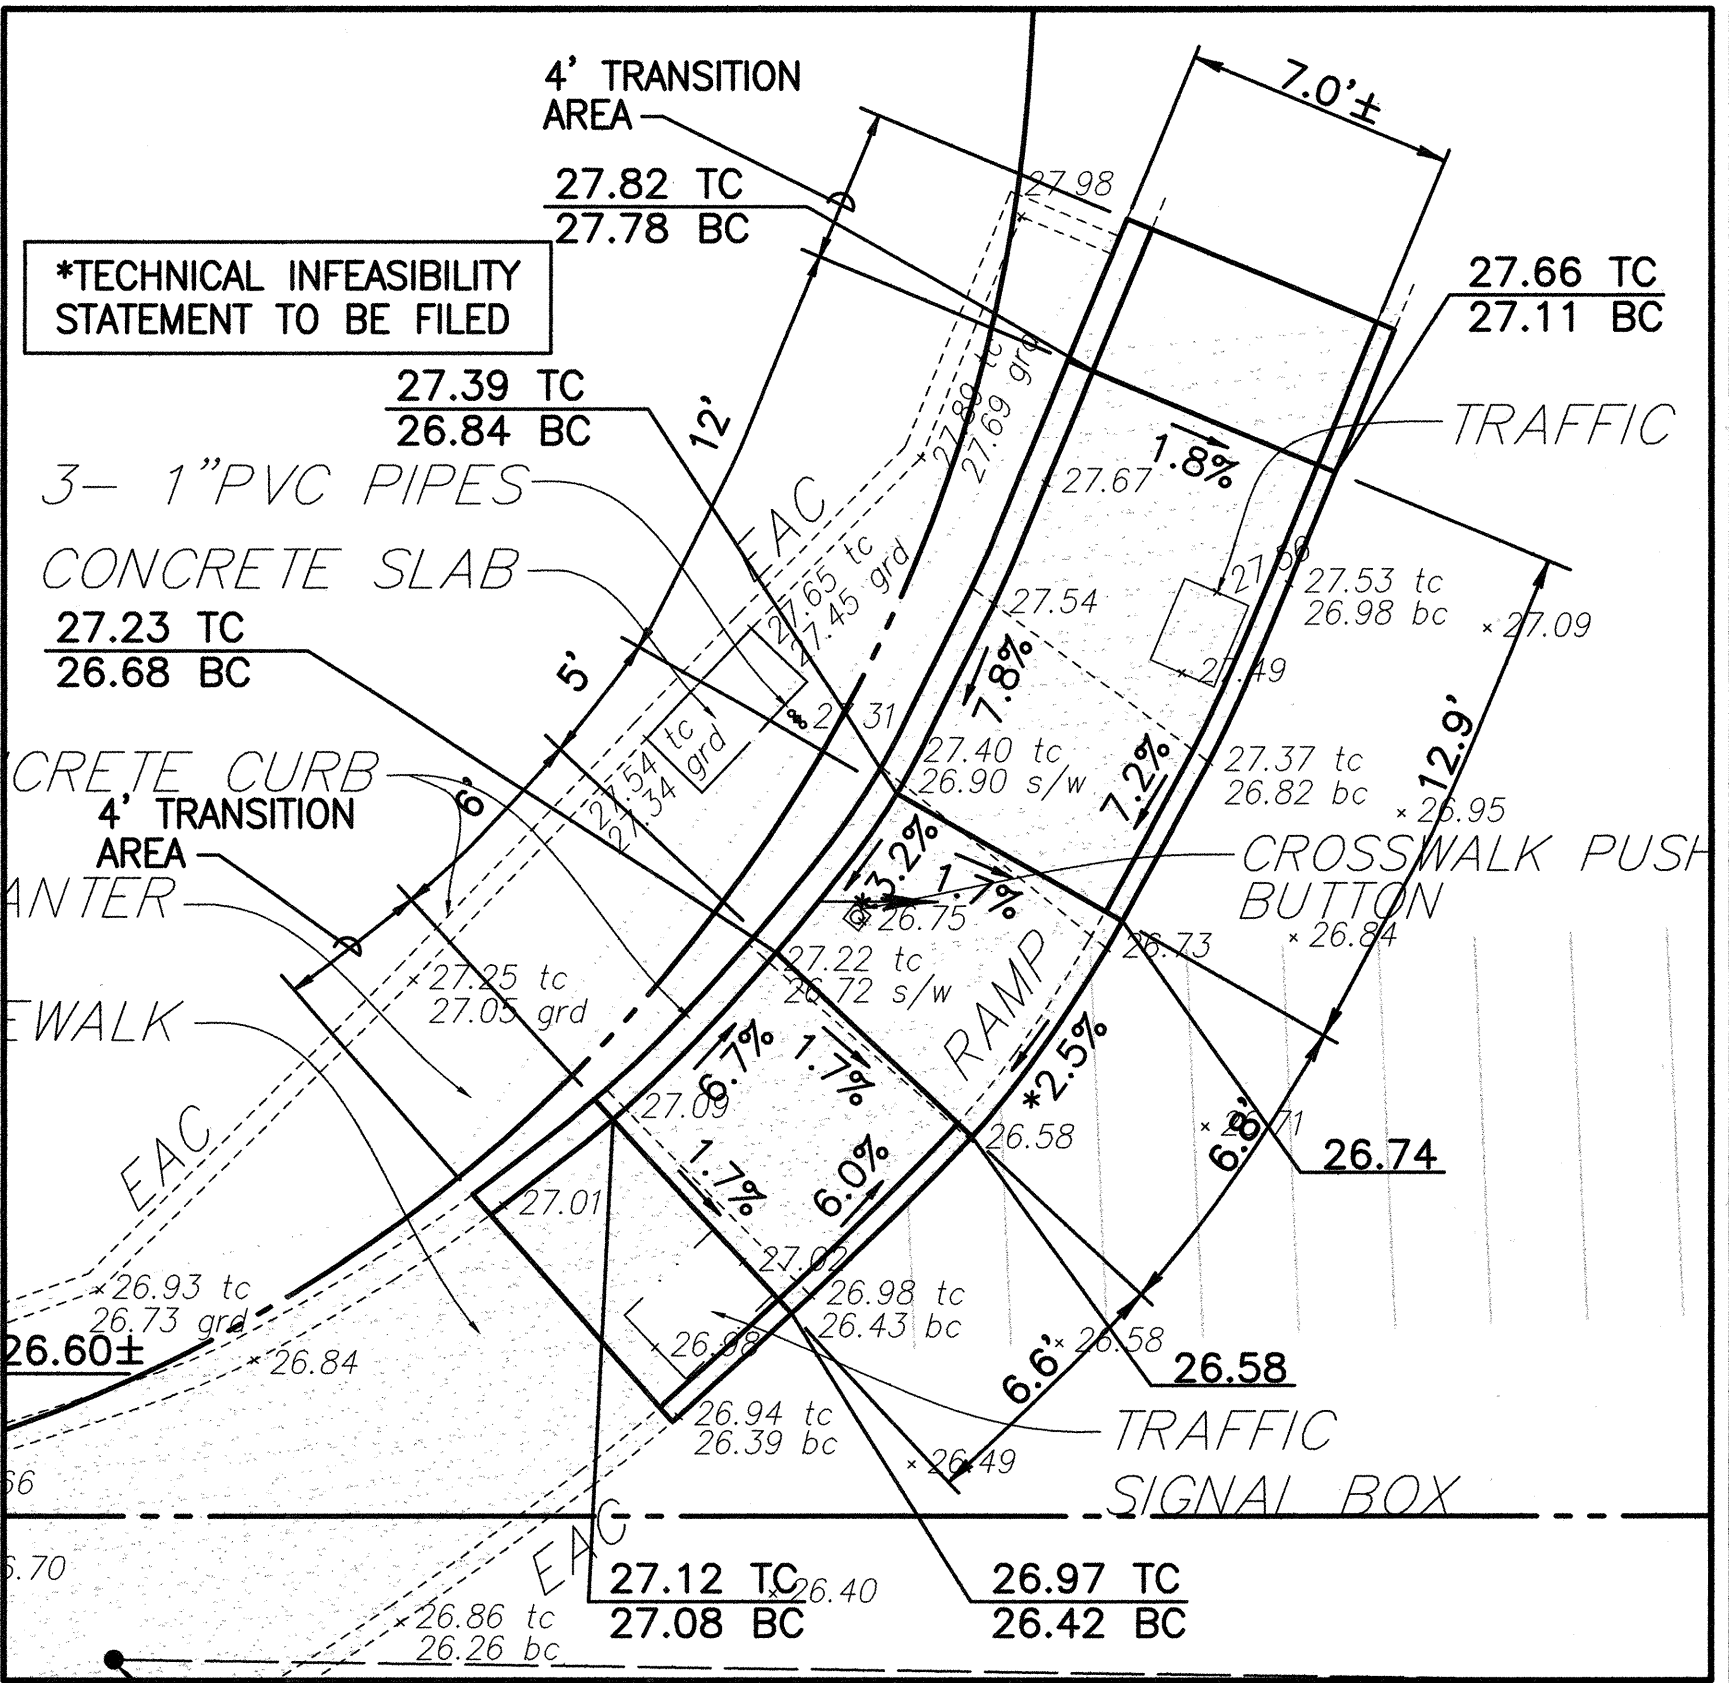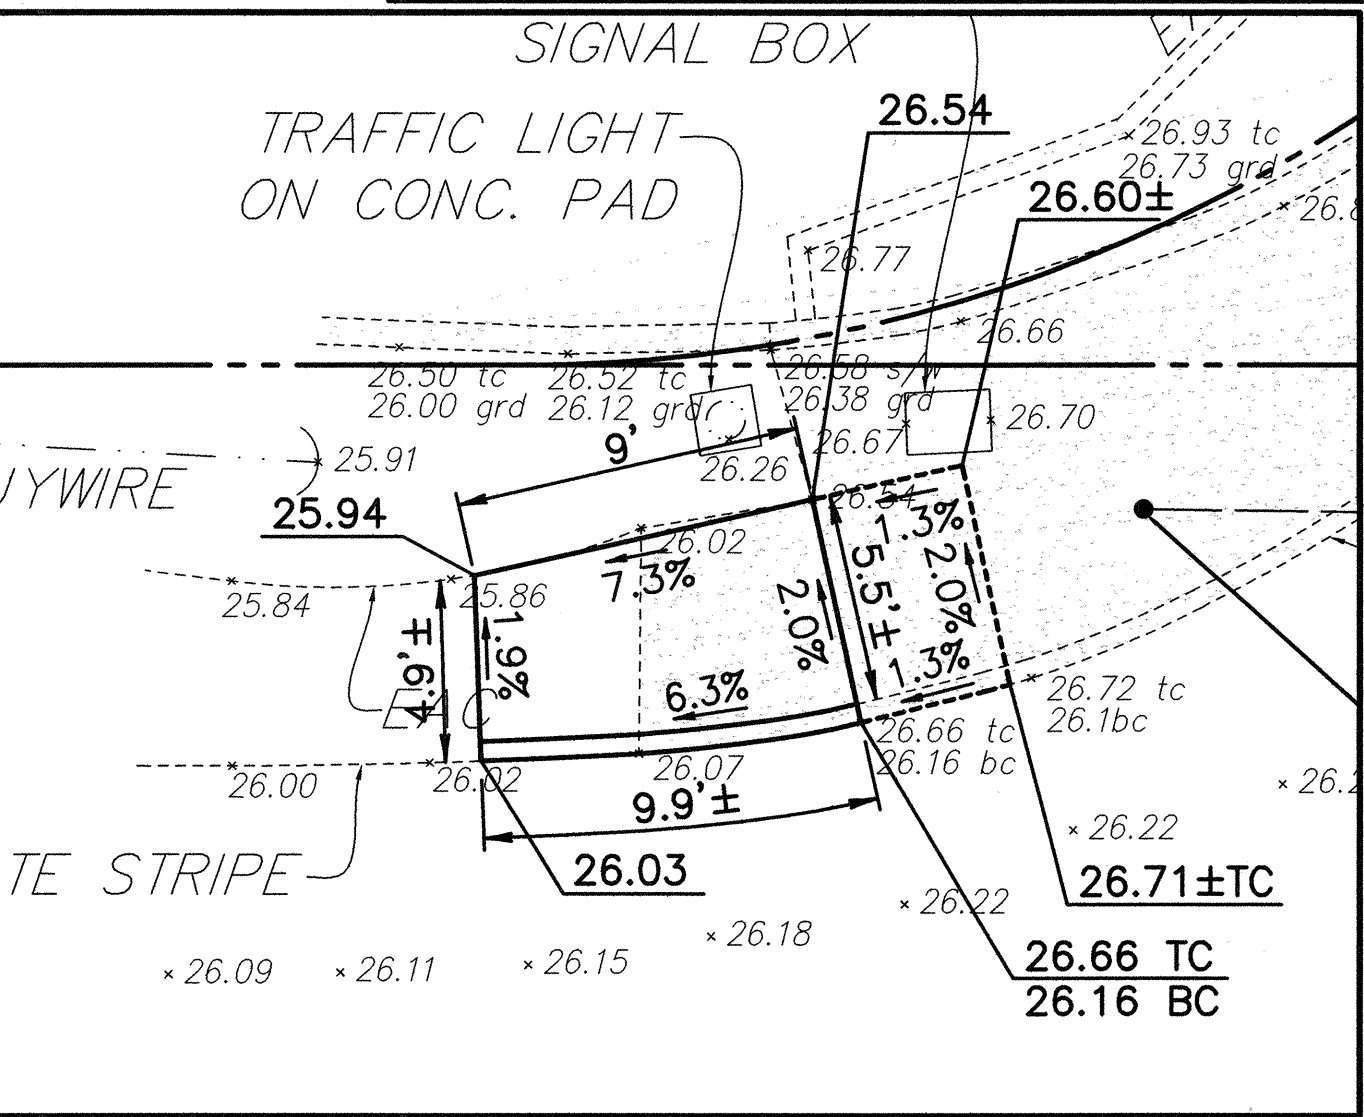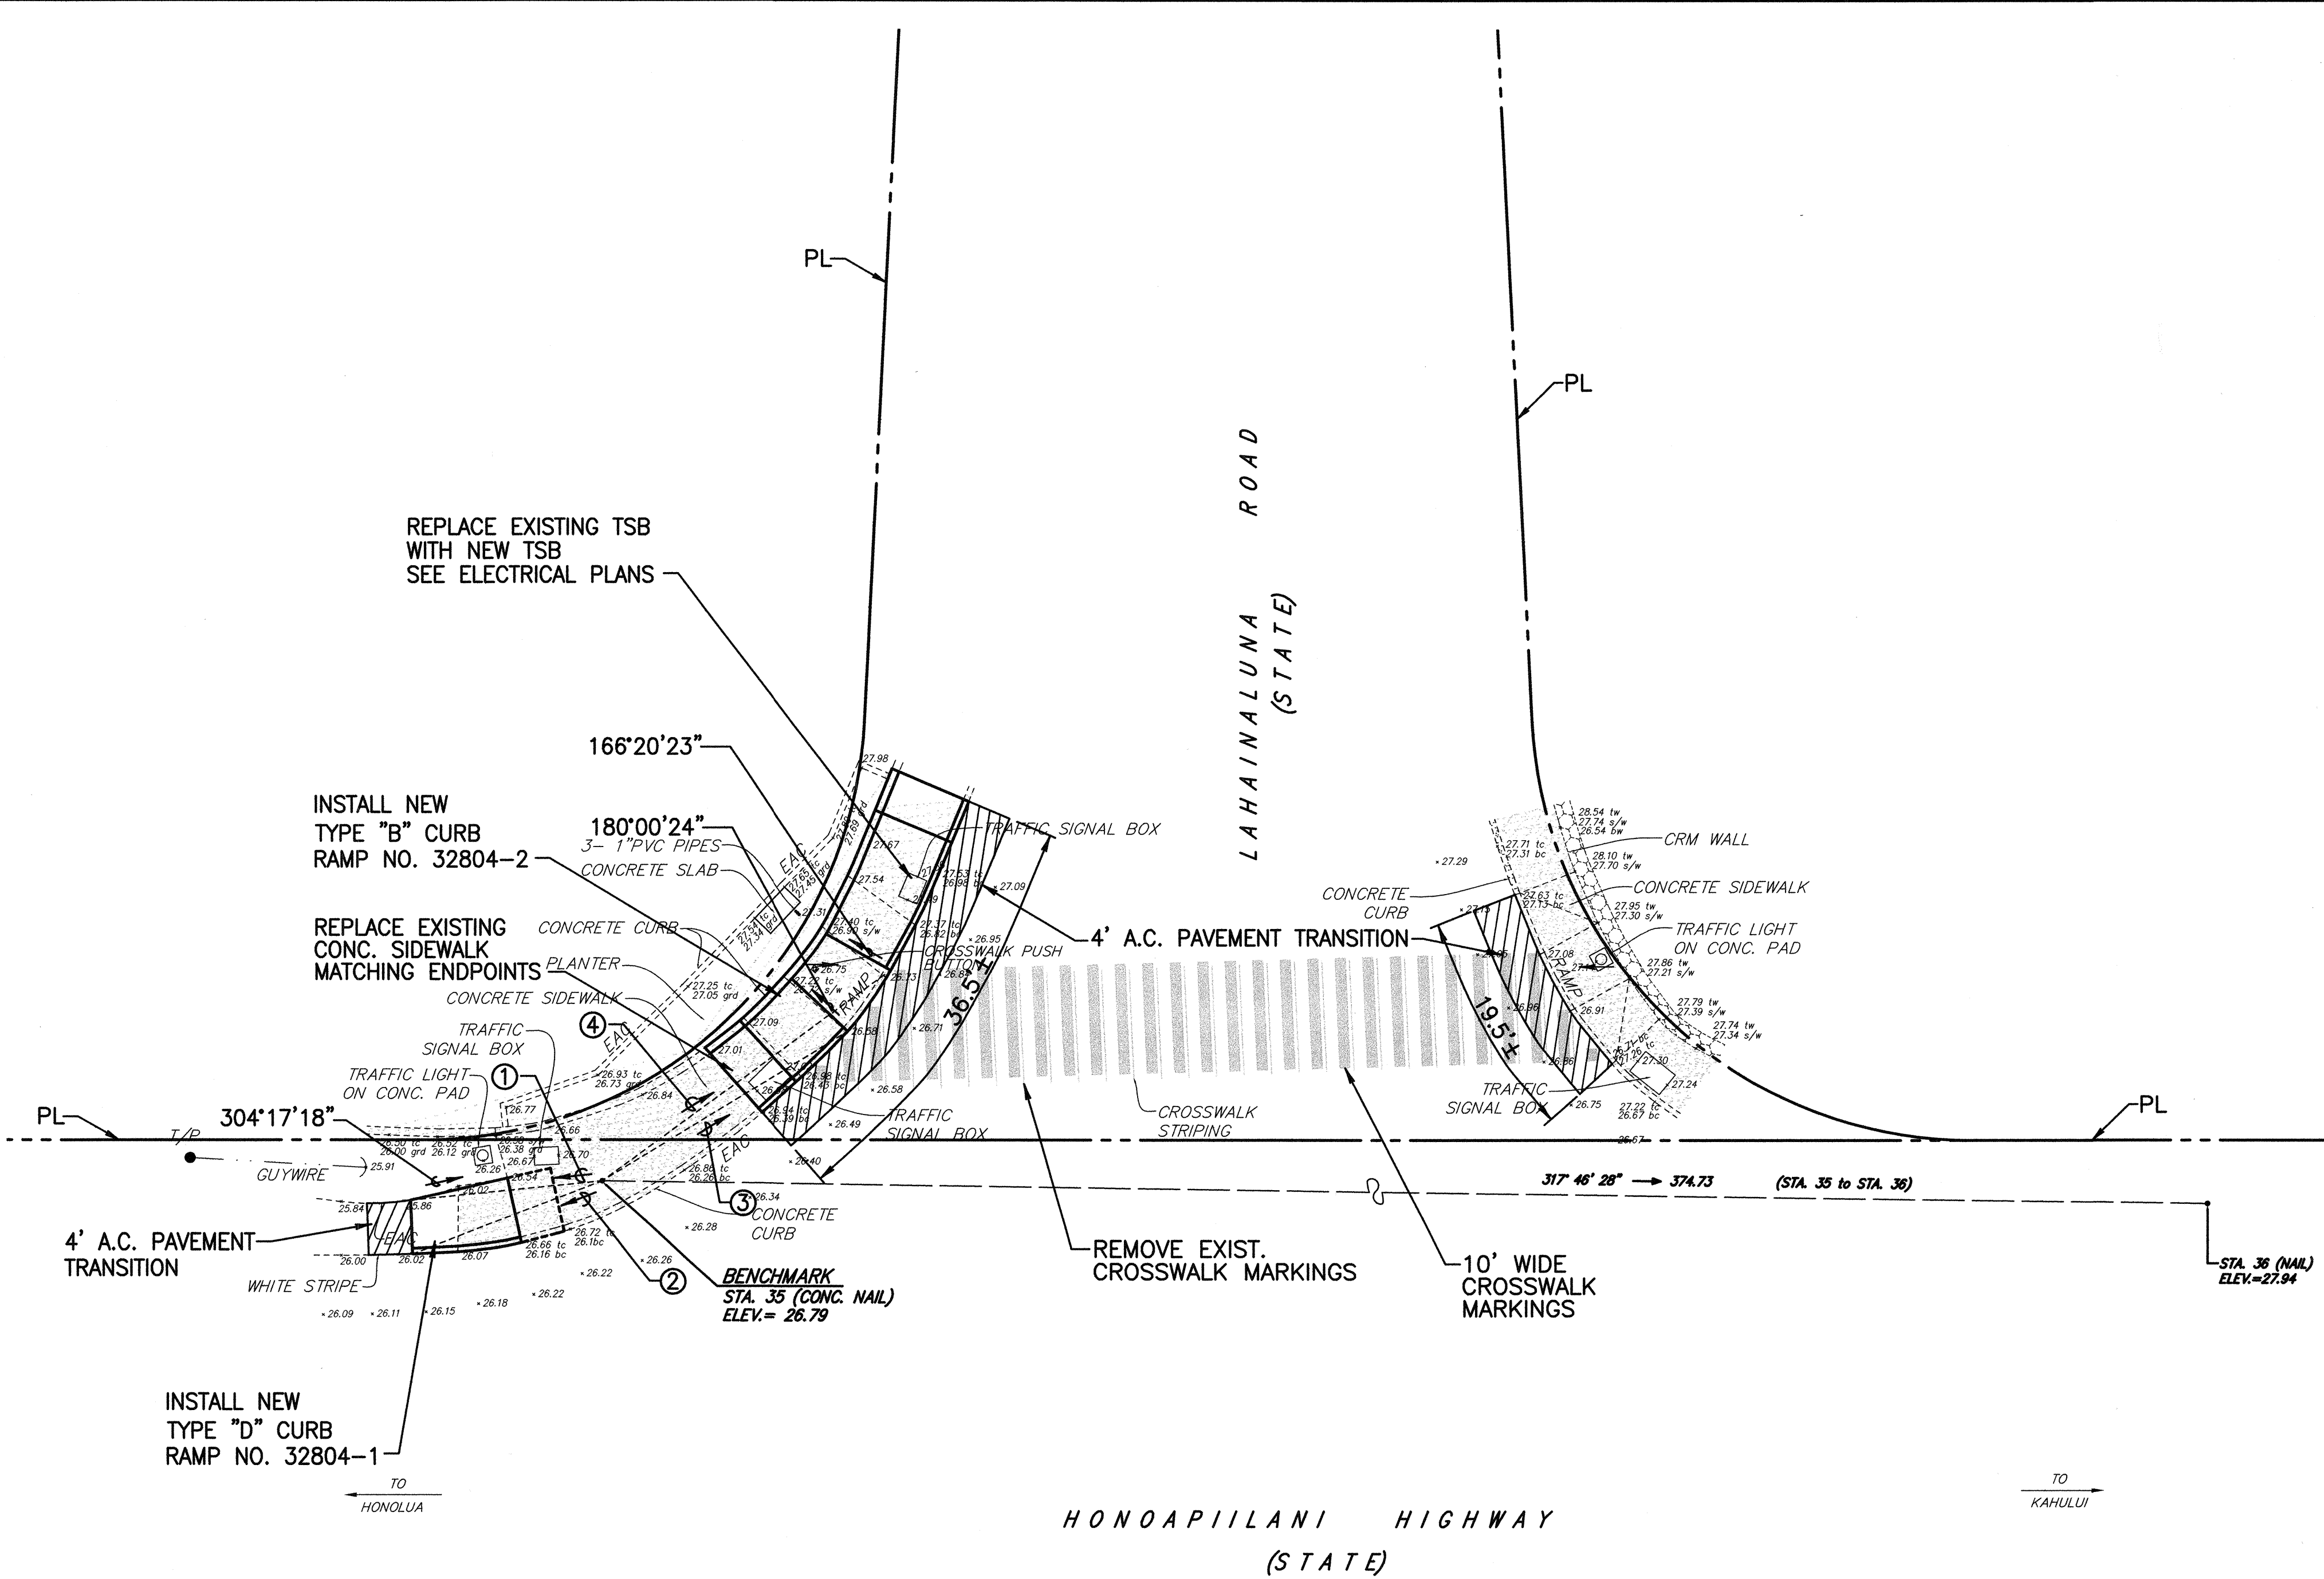


- 123'29'47" 17.80'
(BM TO INTERSECTION OF RAMP
EDGE & BACK OF SIDEWALK)
- 116'5'27" 18.43'
(BM TO INTERSECTION OF RAMP
EDGE & CURB FACE)
- 285'36'36" 26.12'
(BM TO INTERSECTION OF RAMP
EDGE & CURB FACE)
- 280'49'36" 32.46'
(BM TO INTERSECTION OF RAMP
EDGE & CURB FACE)

NOTES:

- SEE SHEETS CB-1 TO CB-10 FOR CURB RAMP, STRIPING, AND MISCELLANEOUS DETAILS.
- FOR ALL ELECTRICAL WORK, SEE ELECTRICAL PLANS.

 **SITE PLAN**
SCALE: 1"= 10'

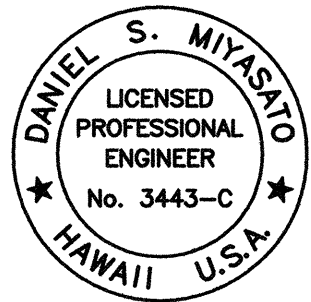

THIS WORK WAS PREPARED BY ME OR UNDER MY SUPERVISION
04/30/06
EXPIRATION DATE OF THE LICENSE 10-22-04

STATE OF HAWAII
DEPARTMENT OF TRANSPORTATION
HIGHWAYS DIVISION
HONOAPIILANI HWY./ LAHAINALUNA RD. (32804)
CURB RAMP PLAN
PEDESTRIAN FACILITIES & ADA
COMPLIANCE AT VARIOUS
LOCATIONS ON MAUI
Federal - Aid Project No. CMAQ-0900(67)R
Scale: As Shown Date: August 2004
SHEET No. CC-23 OF 31 SHEETS


NOTES:

SEE SHEETS CB-1 TO CB-10 FOR CURB RAMP, STRIPING, AND MISCELLANEOUS DETAILS.

FOR ALL ELECTRICAL WORK, SEE ELECTRICAL PLANS.


STATE OF HAWAII
DEPARTMENT OF TRANSPORTATION
HIGHWAYS DIVISION
HONOAPIILANI HWY./ PAPALAU A ST. (32904)
CURB RAMP PLAN
PEDESTRIAN FACILITIES & ADA
COMPLIANCE AT VARIOUS
LOCATIONS ON MAUI
Federal – Aid Project No. CMAQ-0900(67)R
Scale: As Shown Date: August 2004
SHEET No. CC-24 OF 31 SHEETS

45

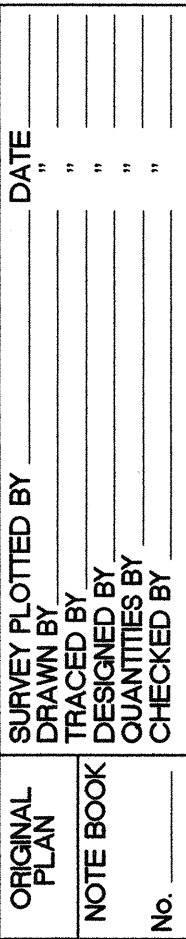

PROJ. NO.: 04008-00
R:\ramp-S\maui\ramp\35HONCAPILLANHWY_PAPALAUAST.dwg 3/10/04


FED. ROAD DIST. NO.	STATE	FEDERAL - AID PROJ. NO.	FISCAL YEAR	SHEET NO.	TOTAL SHEETS
HAWAII	HAW.	CMAQ-0900(67)R	2004	46	109

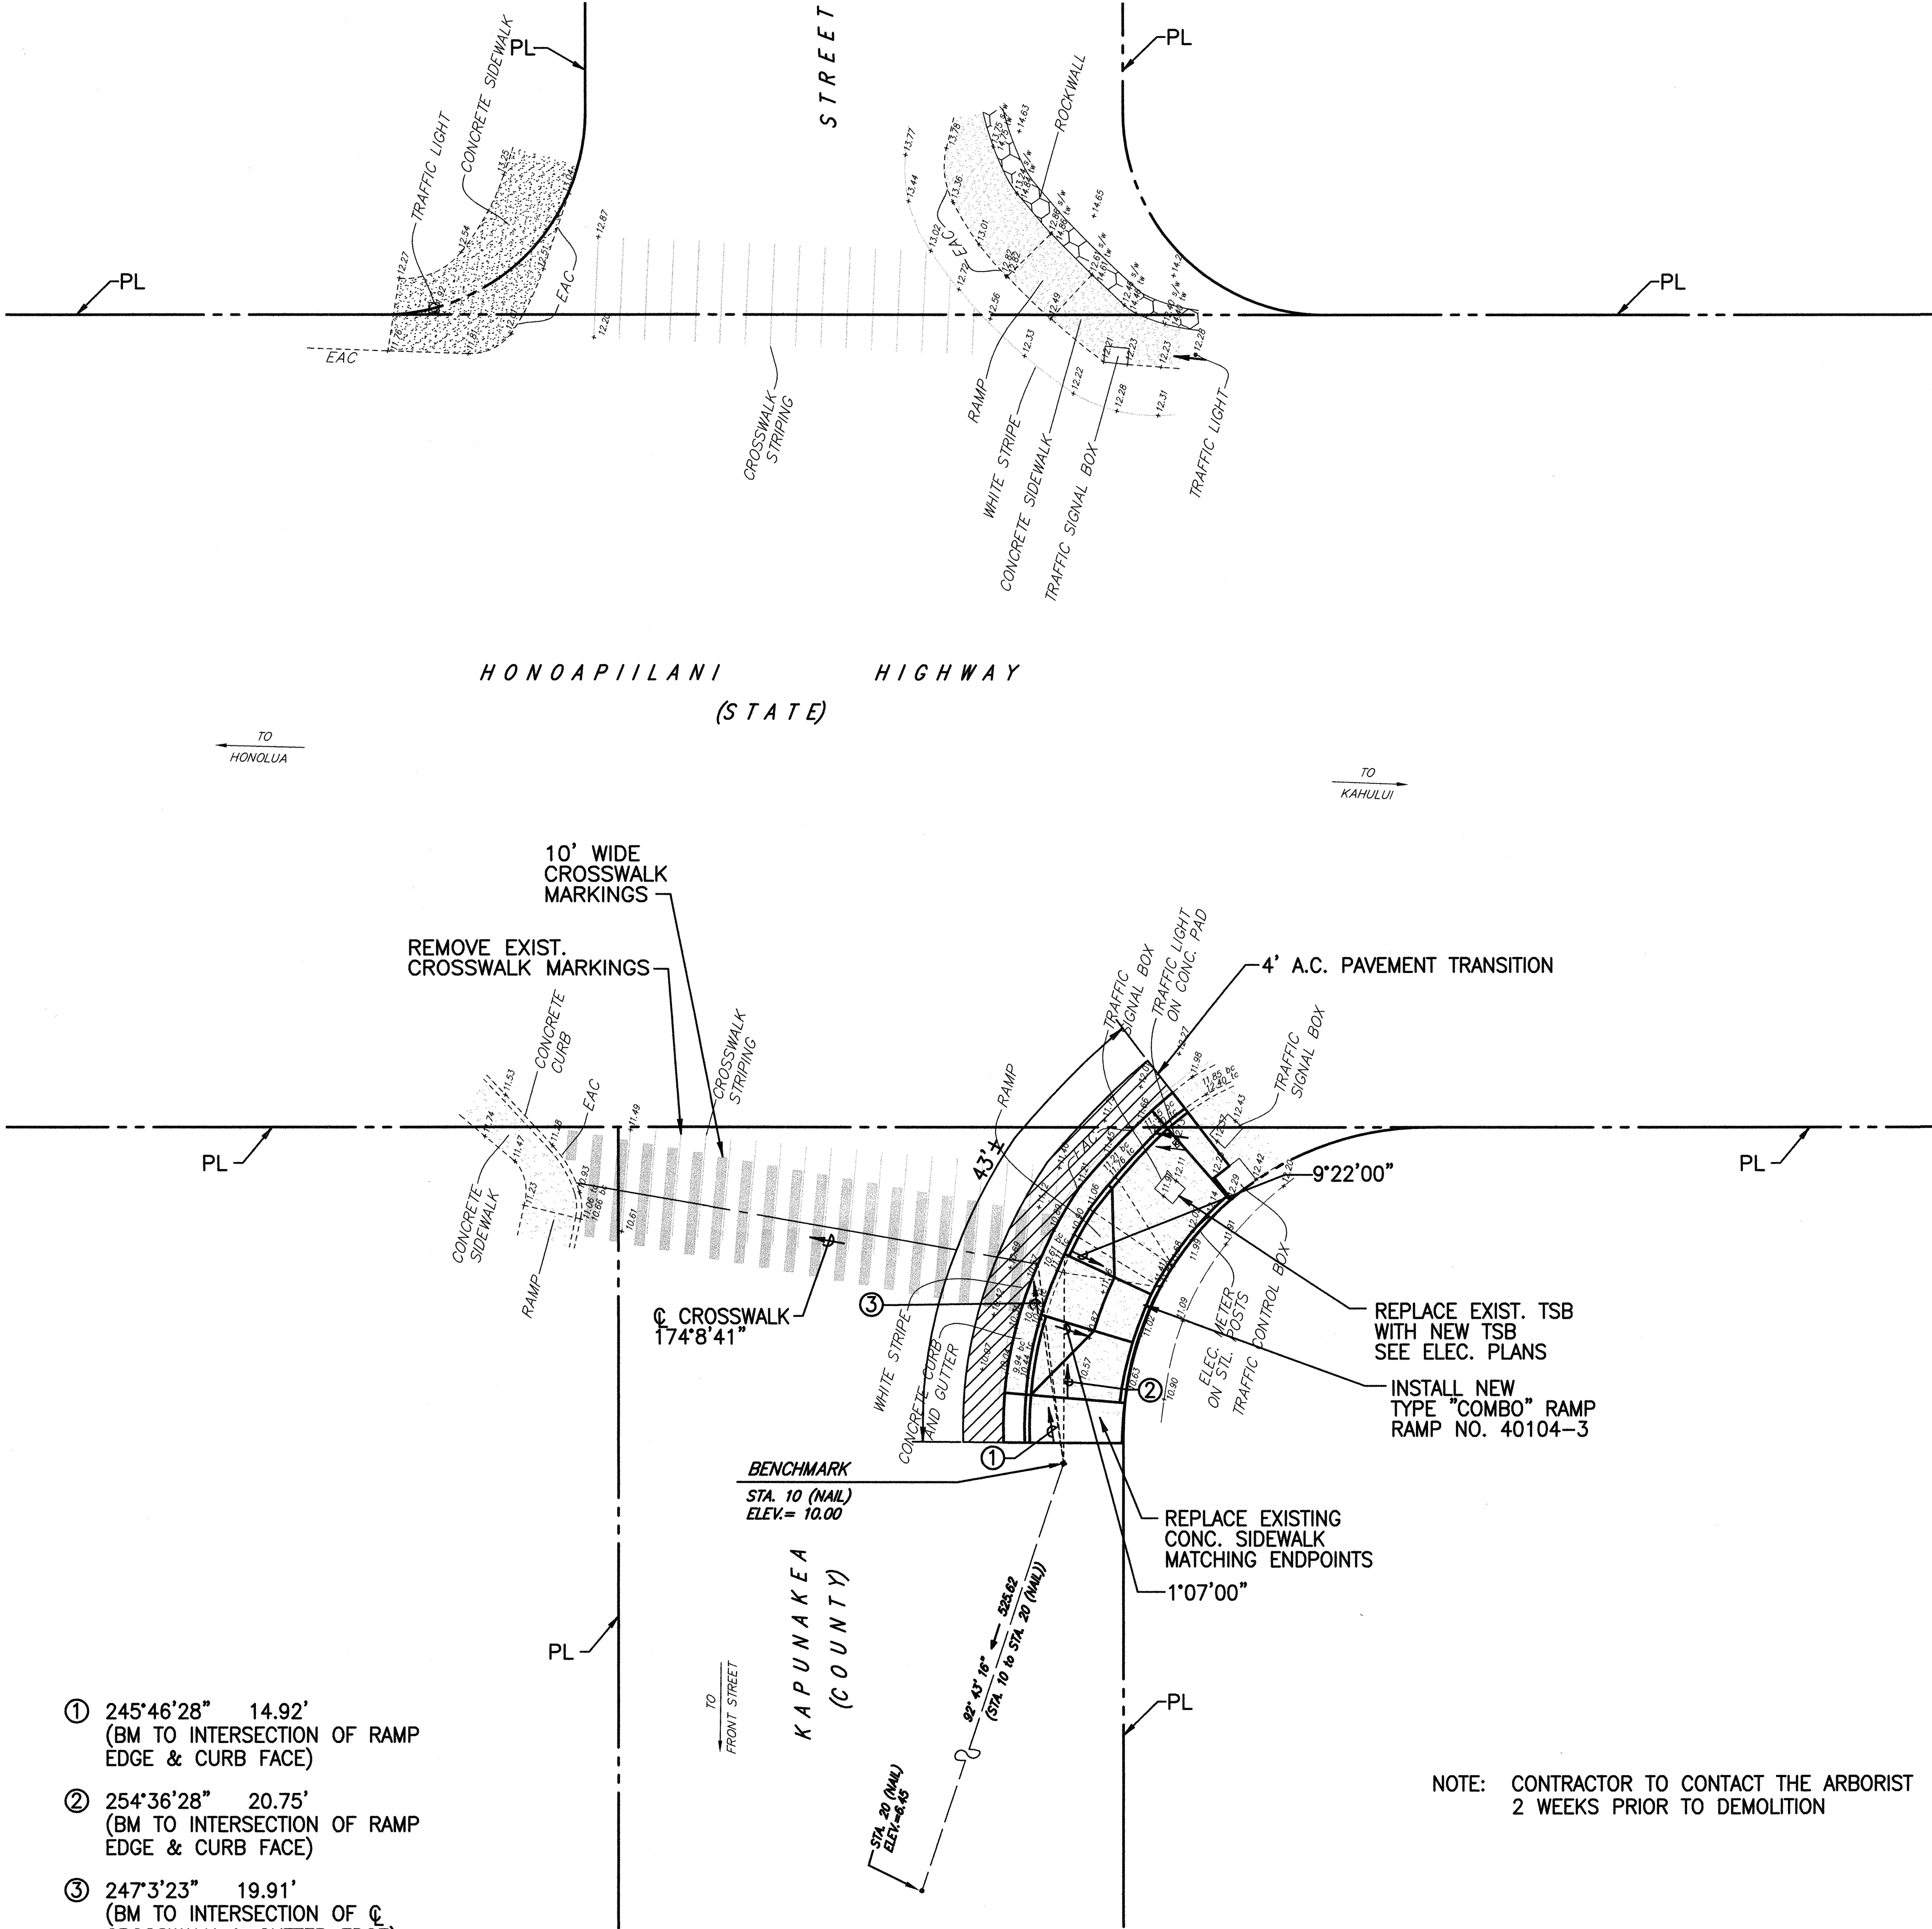

- ① 245°46'28" 14.92'
(BM TO INTERSECTION OF RAMP
EDGE & CURB FACE)
- ② 254°36'28" 20.75'
(BM TO INTERSECTION OF RAMP
EDGE & CURB FACE)
- ③ 247°3'23" 19.91'
(BM TO INTERSECTION OF C
CROSSWALK & GUTTER EDGE)

SITE PLAN
SCALE: 1" = 10'

NOTE: CONTRACTOR TO CONTACT THE ARBORIST
2 WEEKS PRIOR TO DEMOLITION

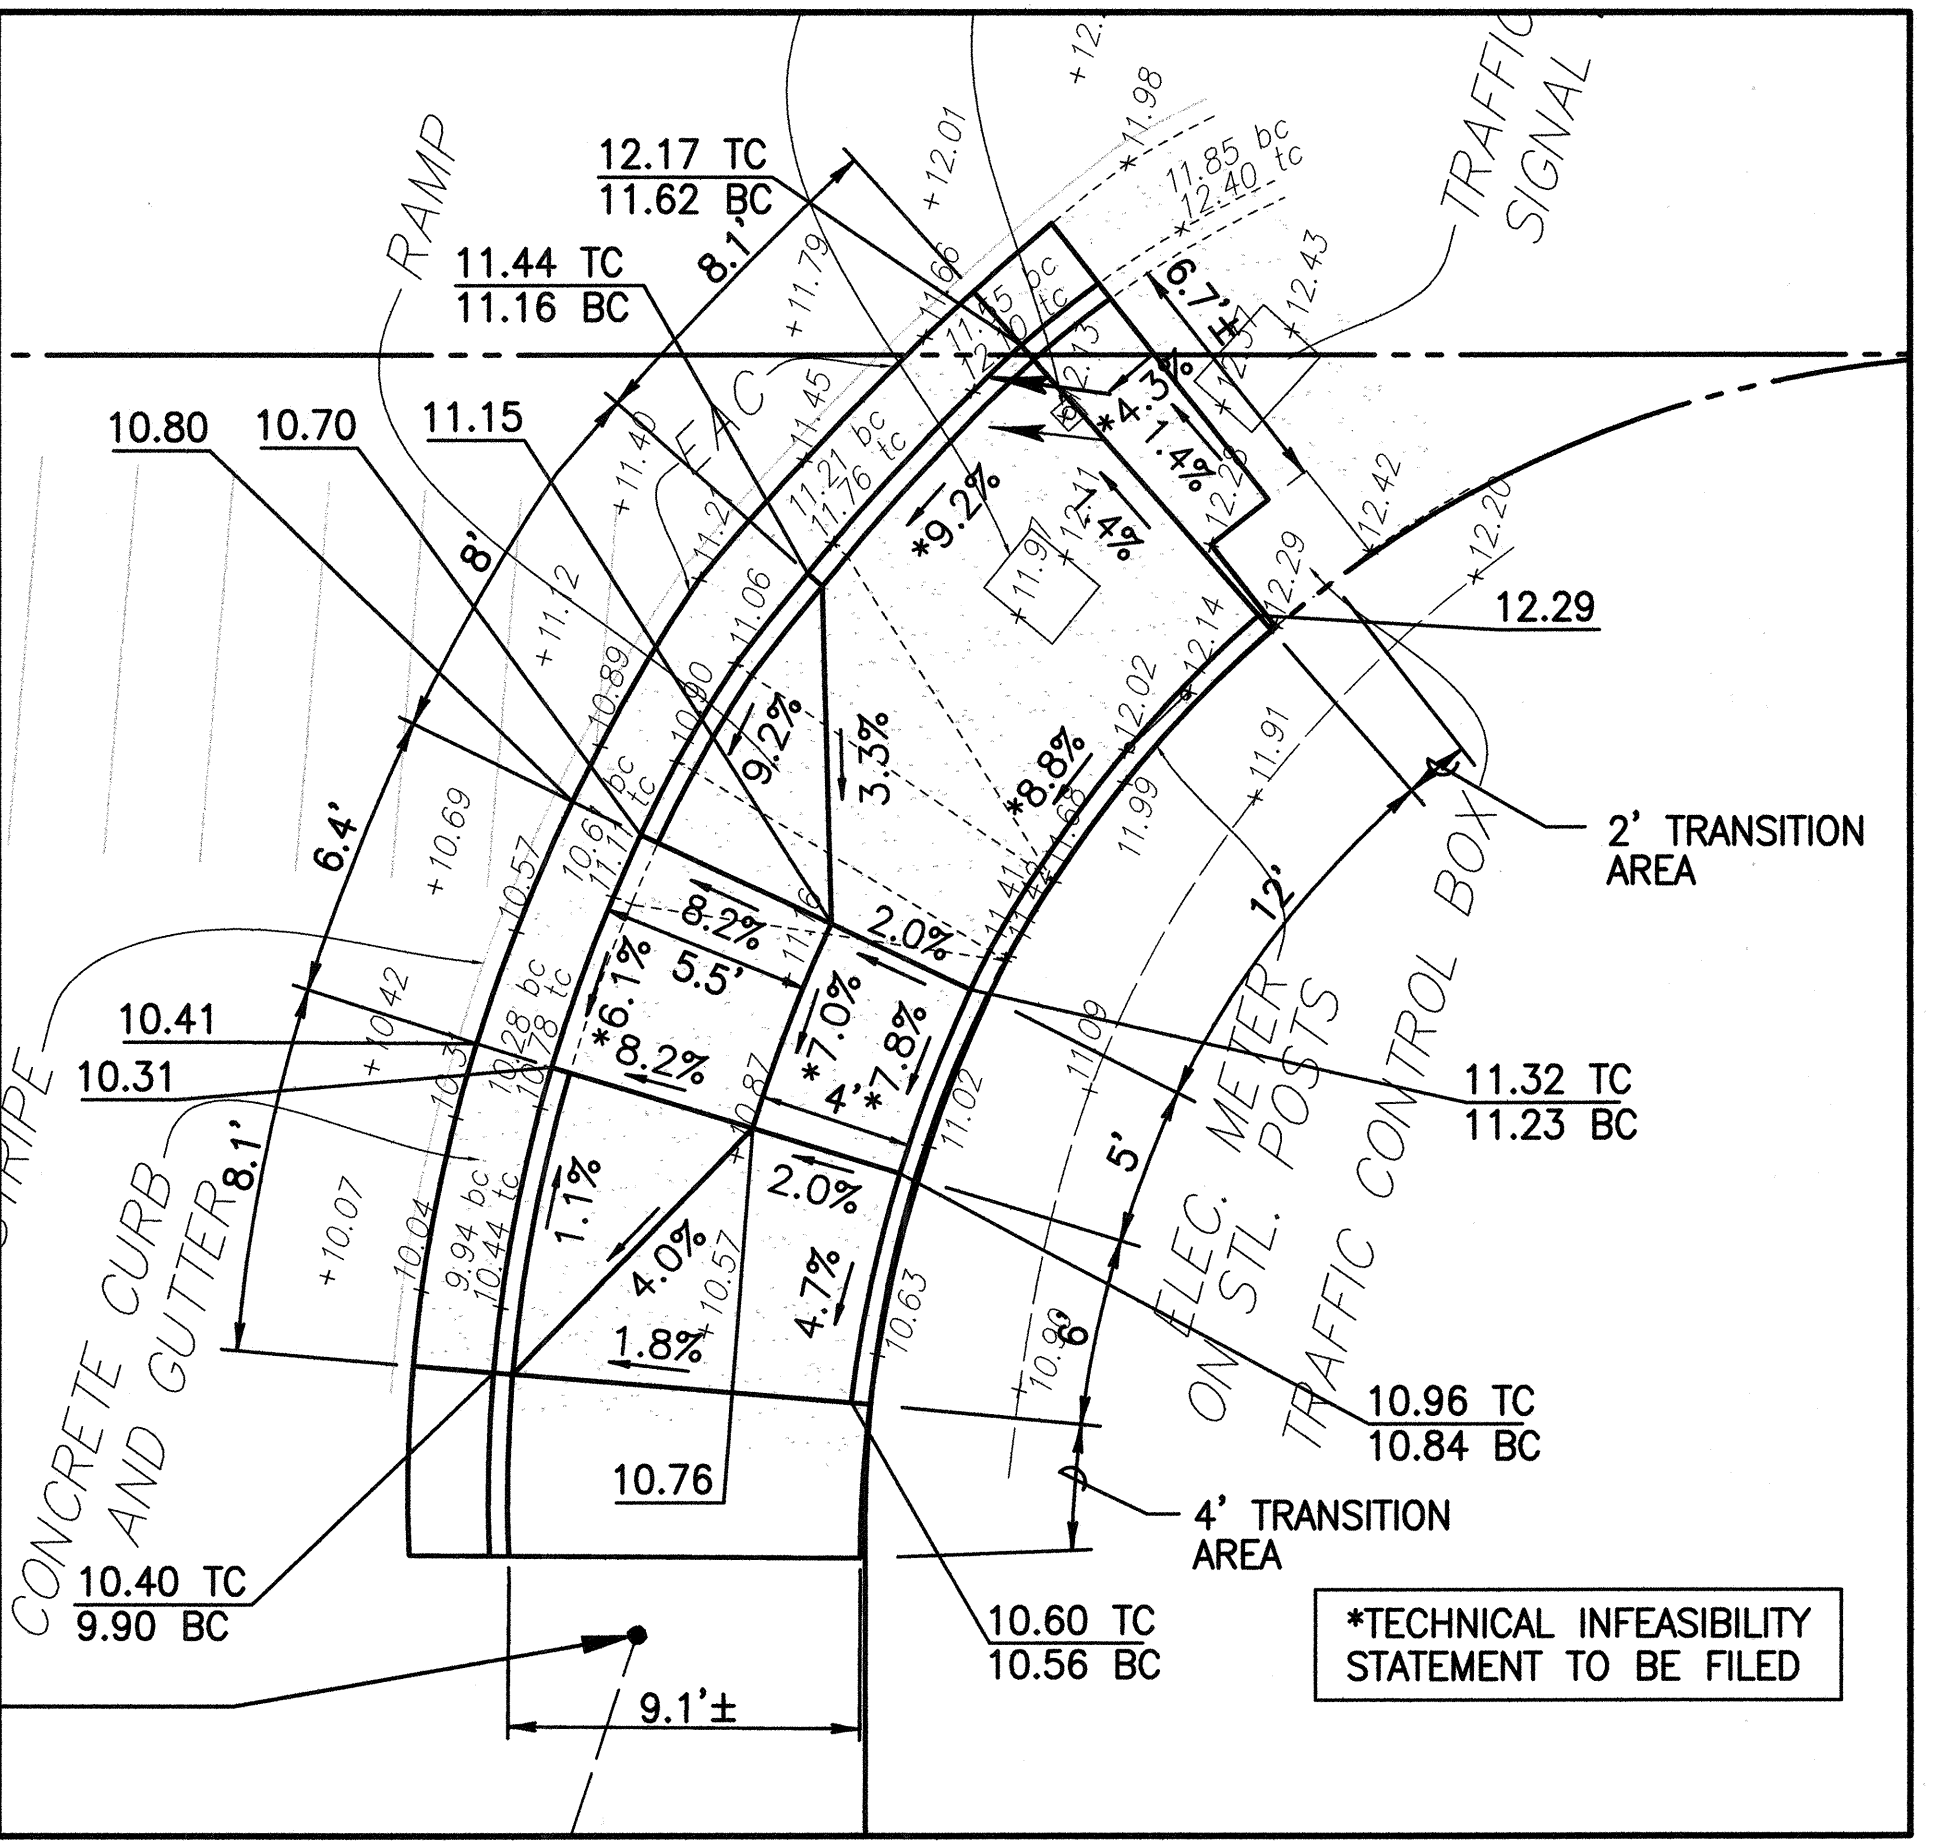

CURB RAMP NO. 40104-3 DETAILS
SCALE: 1" = 5'



- NOTES:**
1. SEE SHEETS CB-1 TO CB-10 FOR CURB RAMP, STRIPING, AND MISCELLANEOUS DETAILS.
 2. FOR ALL ELECTRICAL WORK, SEE ELECTRICAL PLANS.

DANIEL S. MIYASATO
LICENSED PROFESSIONAL ENGINEER
No. 3443-C
HAWAII, U.S.A.

THIS WORK WAS PREPARED BY ME OR UNDER MY SUPERVISION
04/30/06
EXPIRATION DATE OF THE LICENSE
12-31-04

STATE OF HAWAII
DEPARTMENT OF TRANSPORTATION
HIGHWAYS DIVISION
HONOAPIILANI HWY./ KAPUNAKEA ST. (40104)
CURB RAMP PLAN
PEDESTRIAN FACILITIES & ADA
COMPLIANCE AT VARIOUS
LOCATIONS ON MAUI
Federal - Aid Project No. CMAQ-0900(67) R
Scale: As Shown Date: August 2004
SHEET No. CC-25 OF 31 SHEETS

FED. ROAD DIST. NO.	STATE	FEDERAL - AID PROJ. NO.	FISCAL YEAR	SHEET NO.	TOTAL SHEETS
HAWAII	HAW.	CMAQ-0900(67)R	2004	47	109

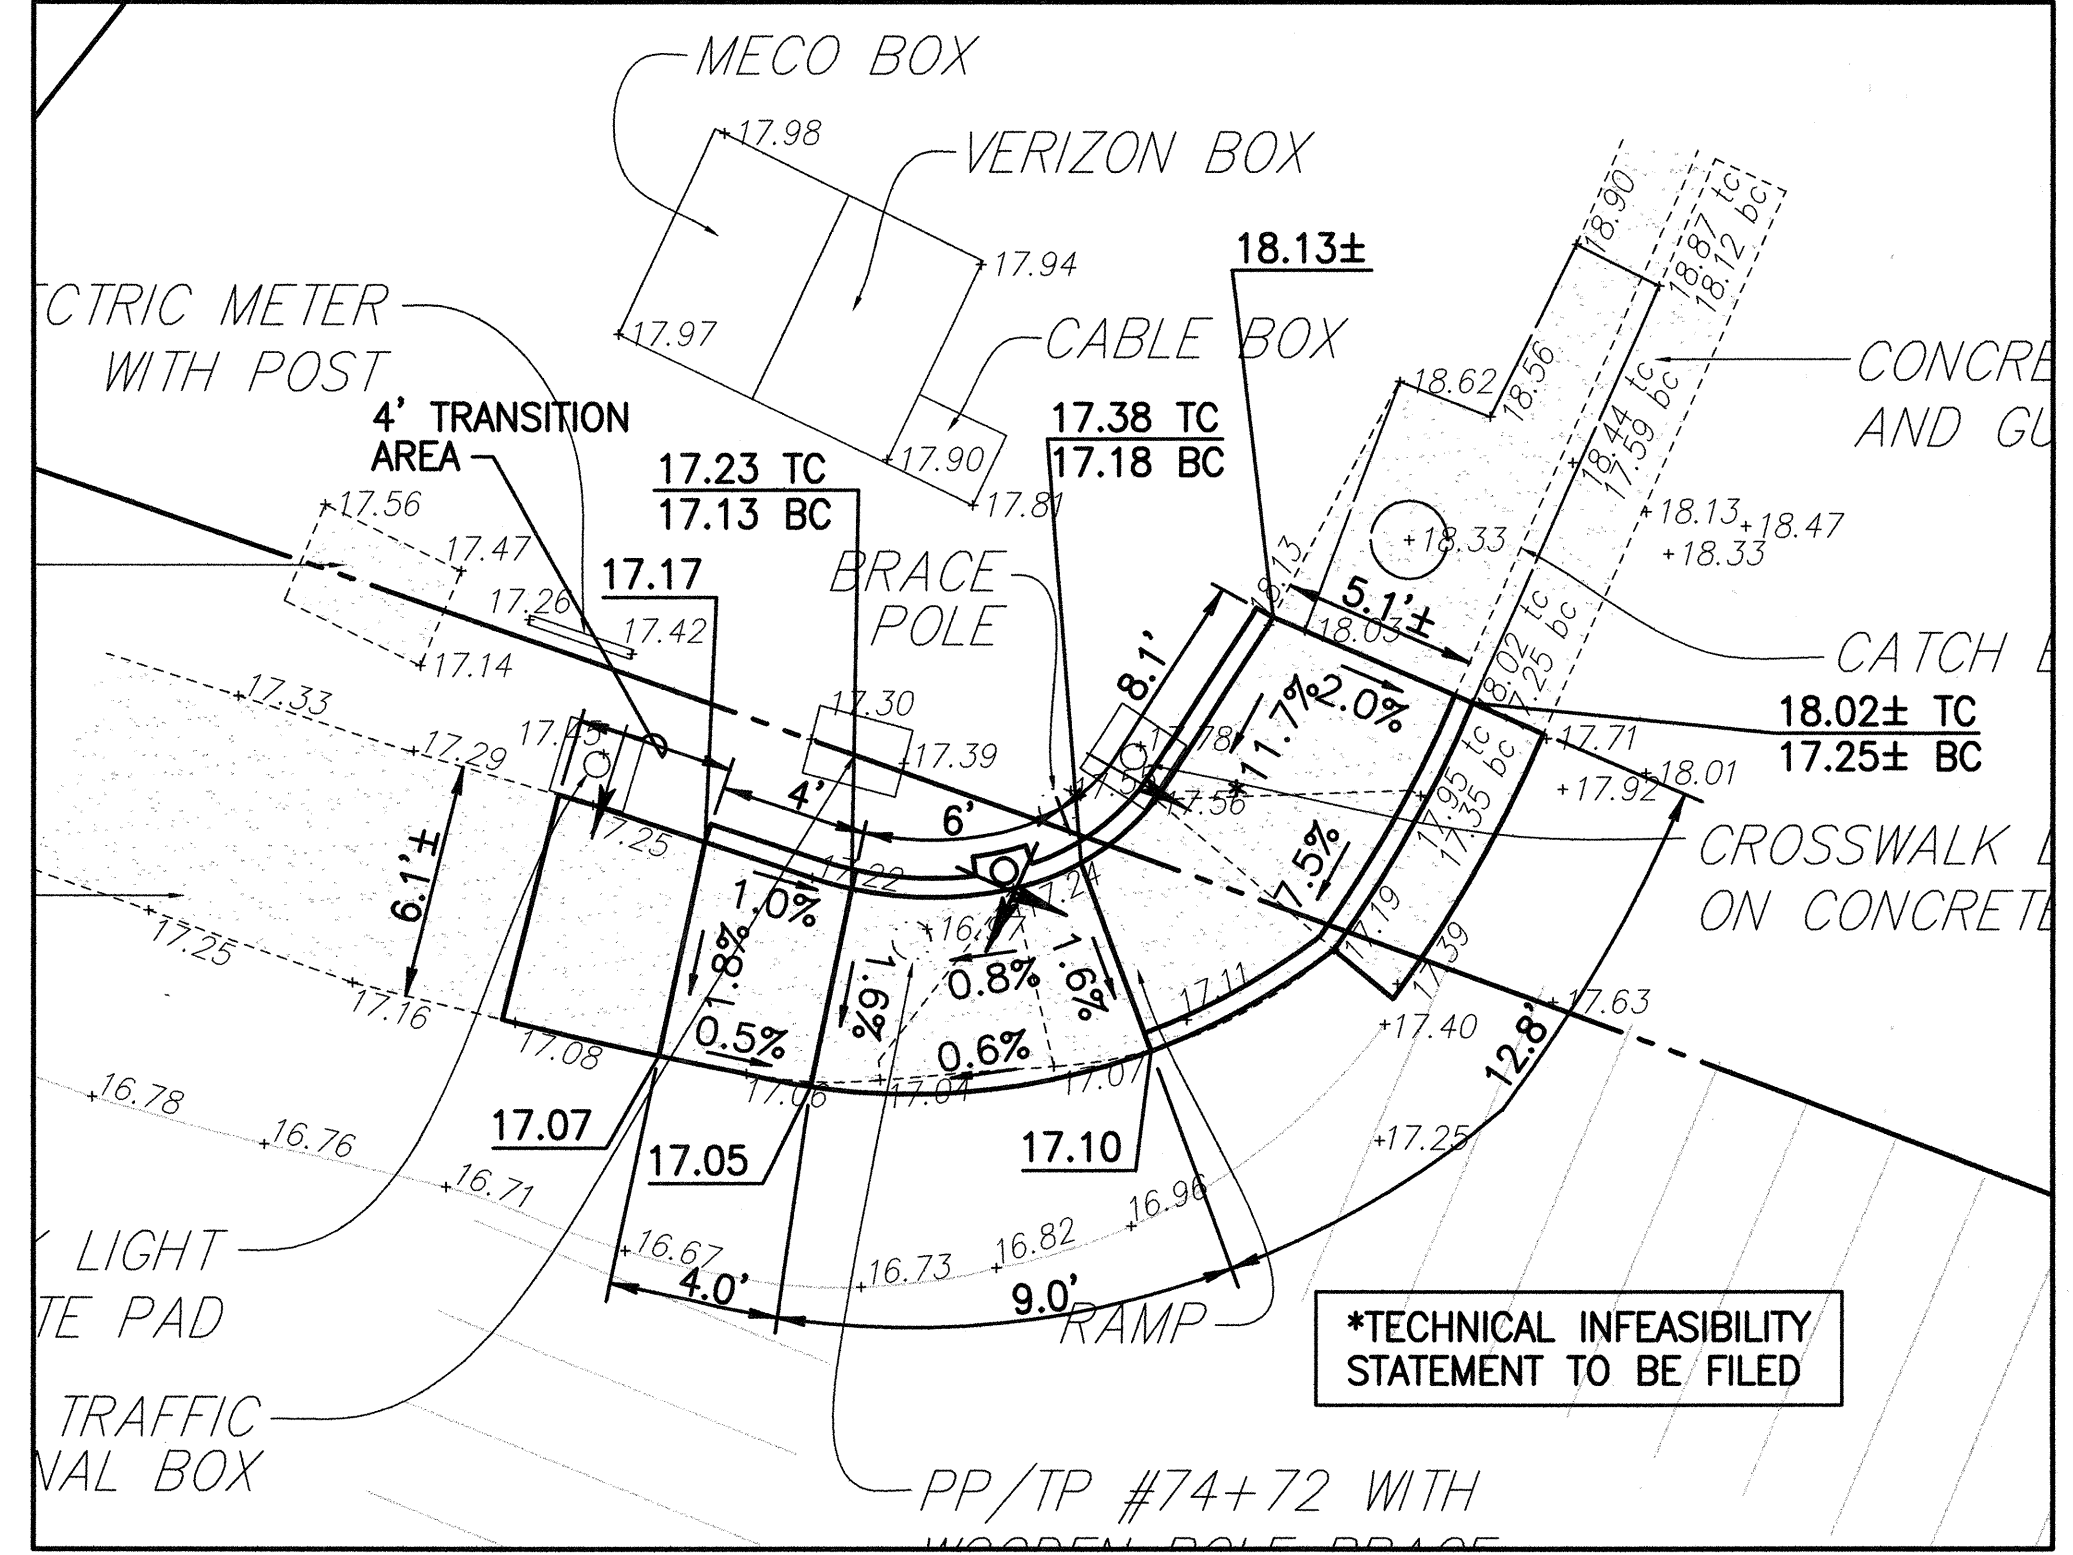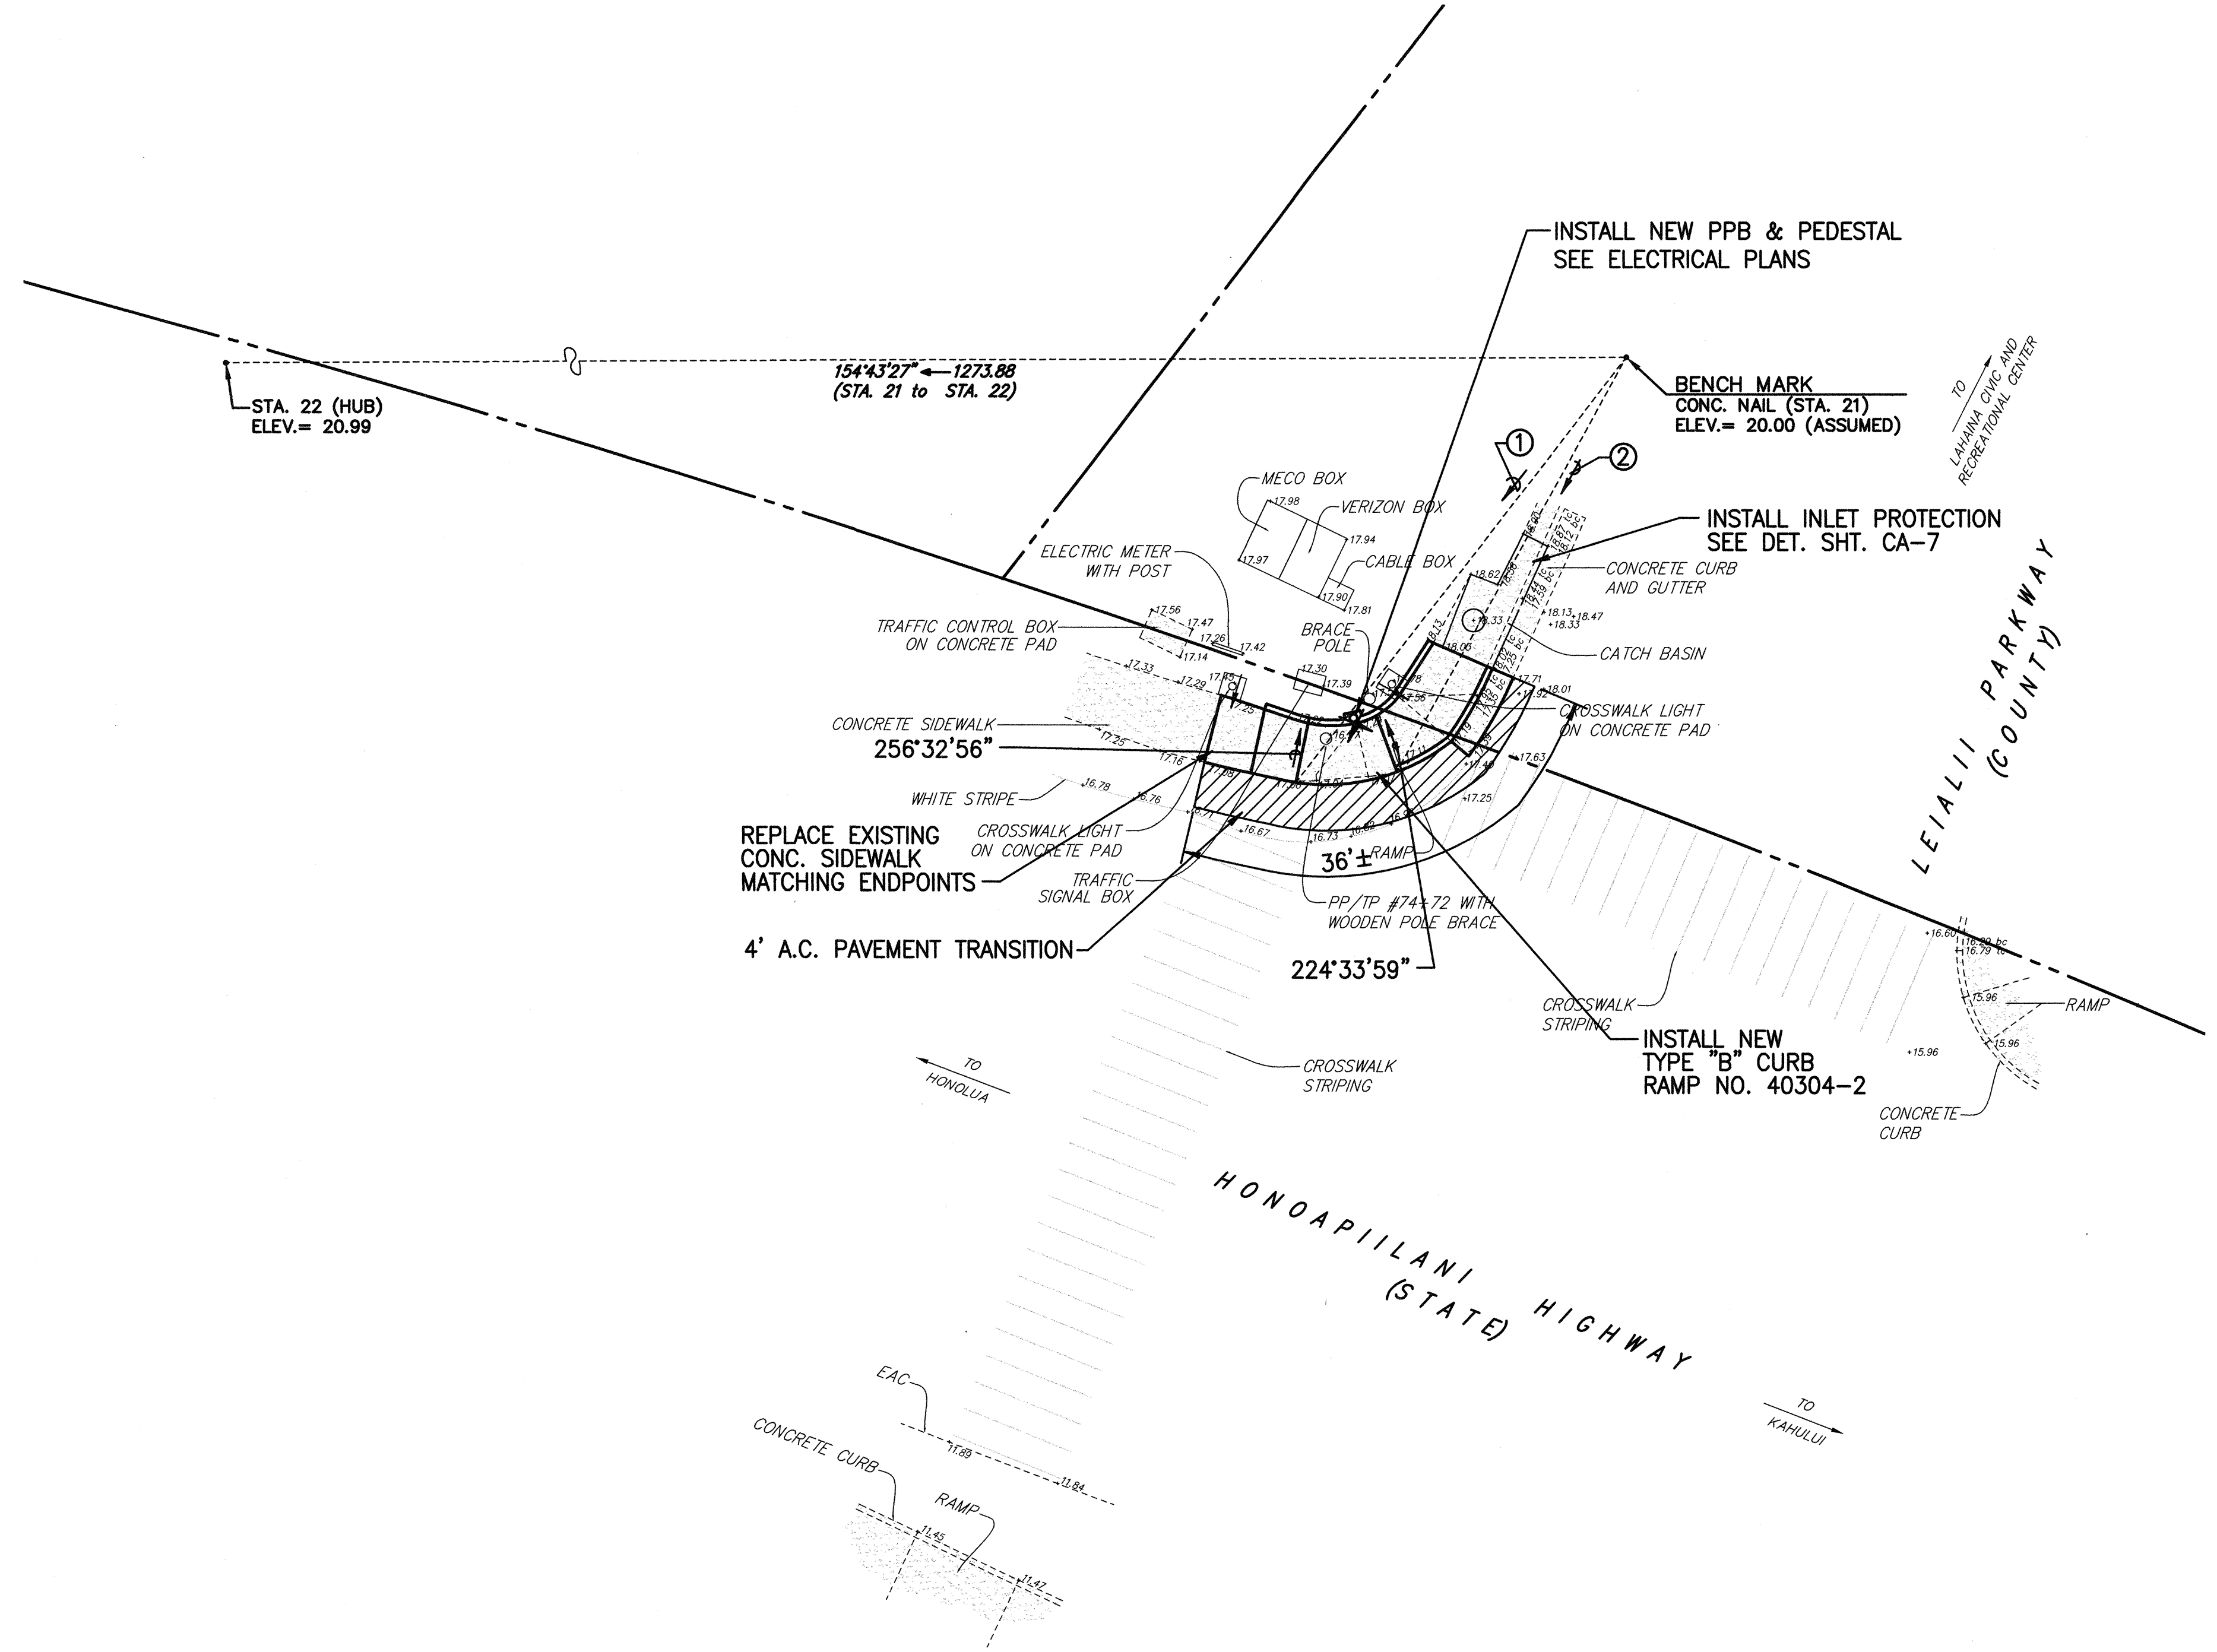

CURB RAMP NO. 40304-2 DETAILS
SCALE: 1"= 5'

- NOTES:**
- SEE SHEETS CB-1 TO CB-10 FOR CURB RAMP, STRIPING, AND MISCELLANEOUS DETAILS.
 - FOR ALL ELECTRICAL WORK, SEE ELECTRICAL PLANS.



- 102°50'45" 47.14'
(BM TO INTERSECTION OF RAMP
EDGE & CURB FACE)
- 93°58'31" 41.45'
(BM TO INTERSECTION OF RAMP
EDGE & CURB FACE)

SITE PLAN
SCALE: 1"= 10'

STATE OF HAWAII
DEPARTMENT OF TRANSPORTATION
HIGHWAYS DIVISION
HONOAPIILANI HWY./LEALII PKWY. (40304)
CURB RAMP PLAN
PEDESTRIAN FACILITIES & ADA
COMPLIANCE AT VARIOUS
LOCATIONS ON MAUI
Federal - Aid Project No. CMAQ-0900(67)R
Scale: As Shown Date: August 2004
SHEET No. CC-26 OF 31 SHEETS

Daniel S. Miyamoto
LICENSED PROFESSIONAL ENGINEER
No. 3443-C
HAWAII U.S.A.
THIS WORK WAS PREPARED BY ME OR UNDER MY SUPERVISION
04/30/06
EXPIRATION DATE OF THE LICENSE
12-9-22-04


FED. ROAD DIST. NO.	STATE	FEDERAL - AID PROJ. NO.	FISCAL YEAR	SHEET NO.	TOTAL SHEETS
HAWAII	HAW.	CMAQ-0900(67)K	2004	48	109

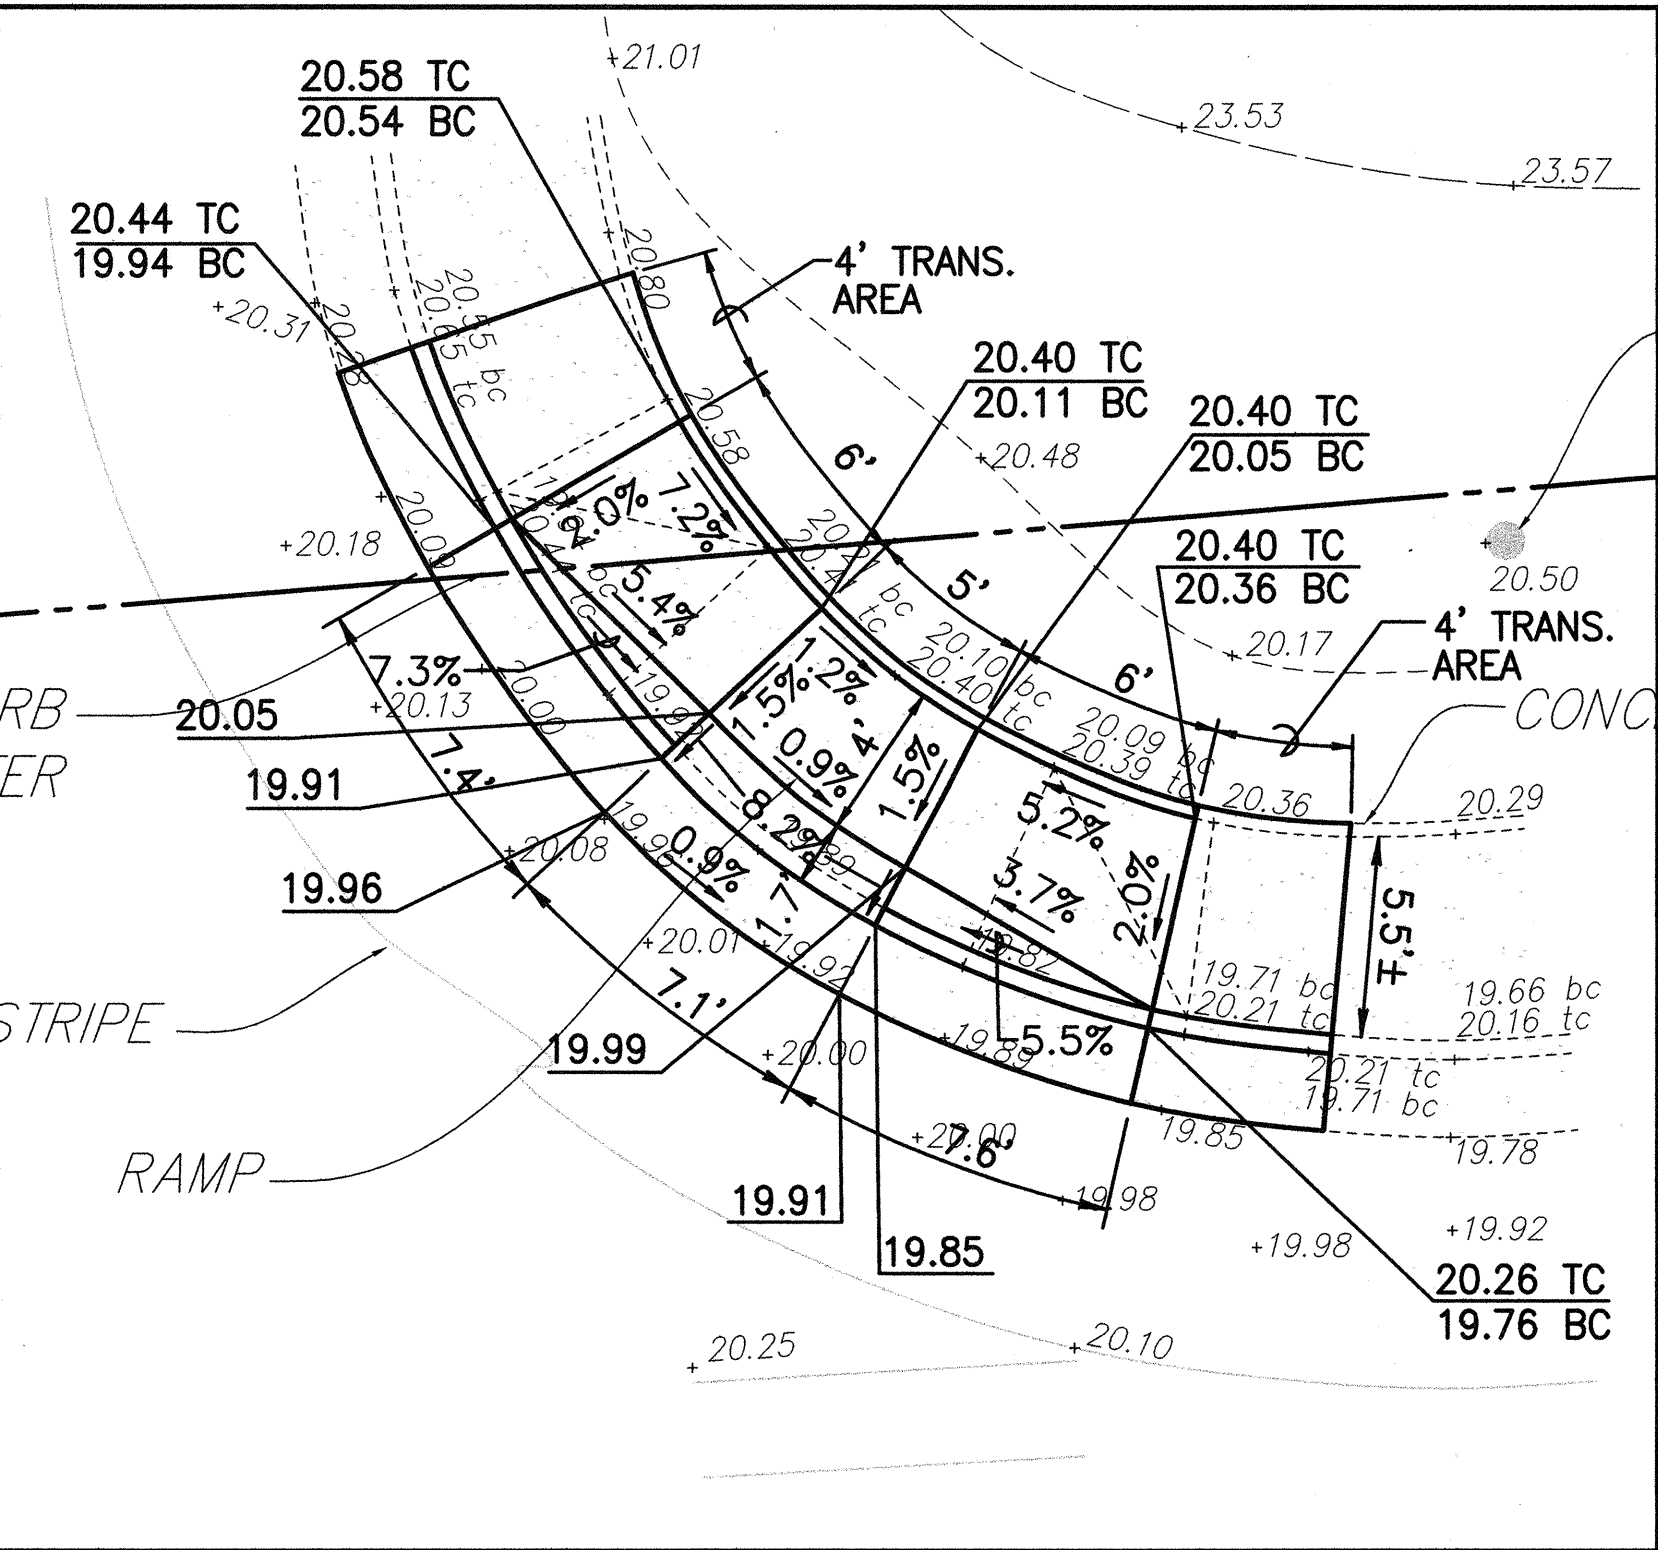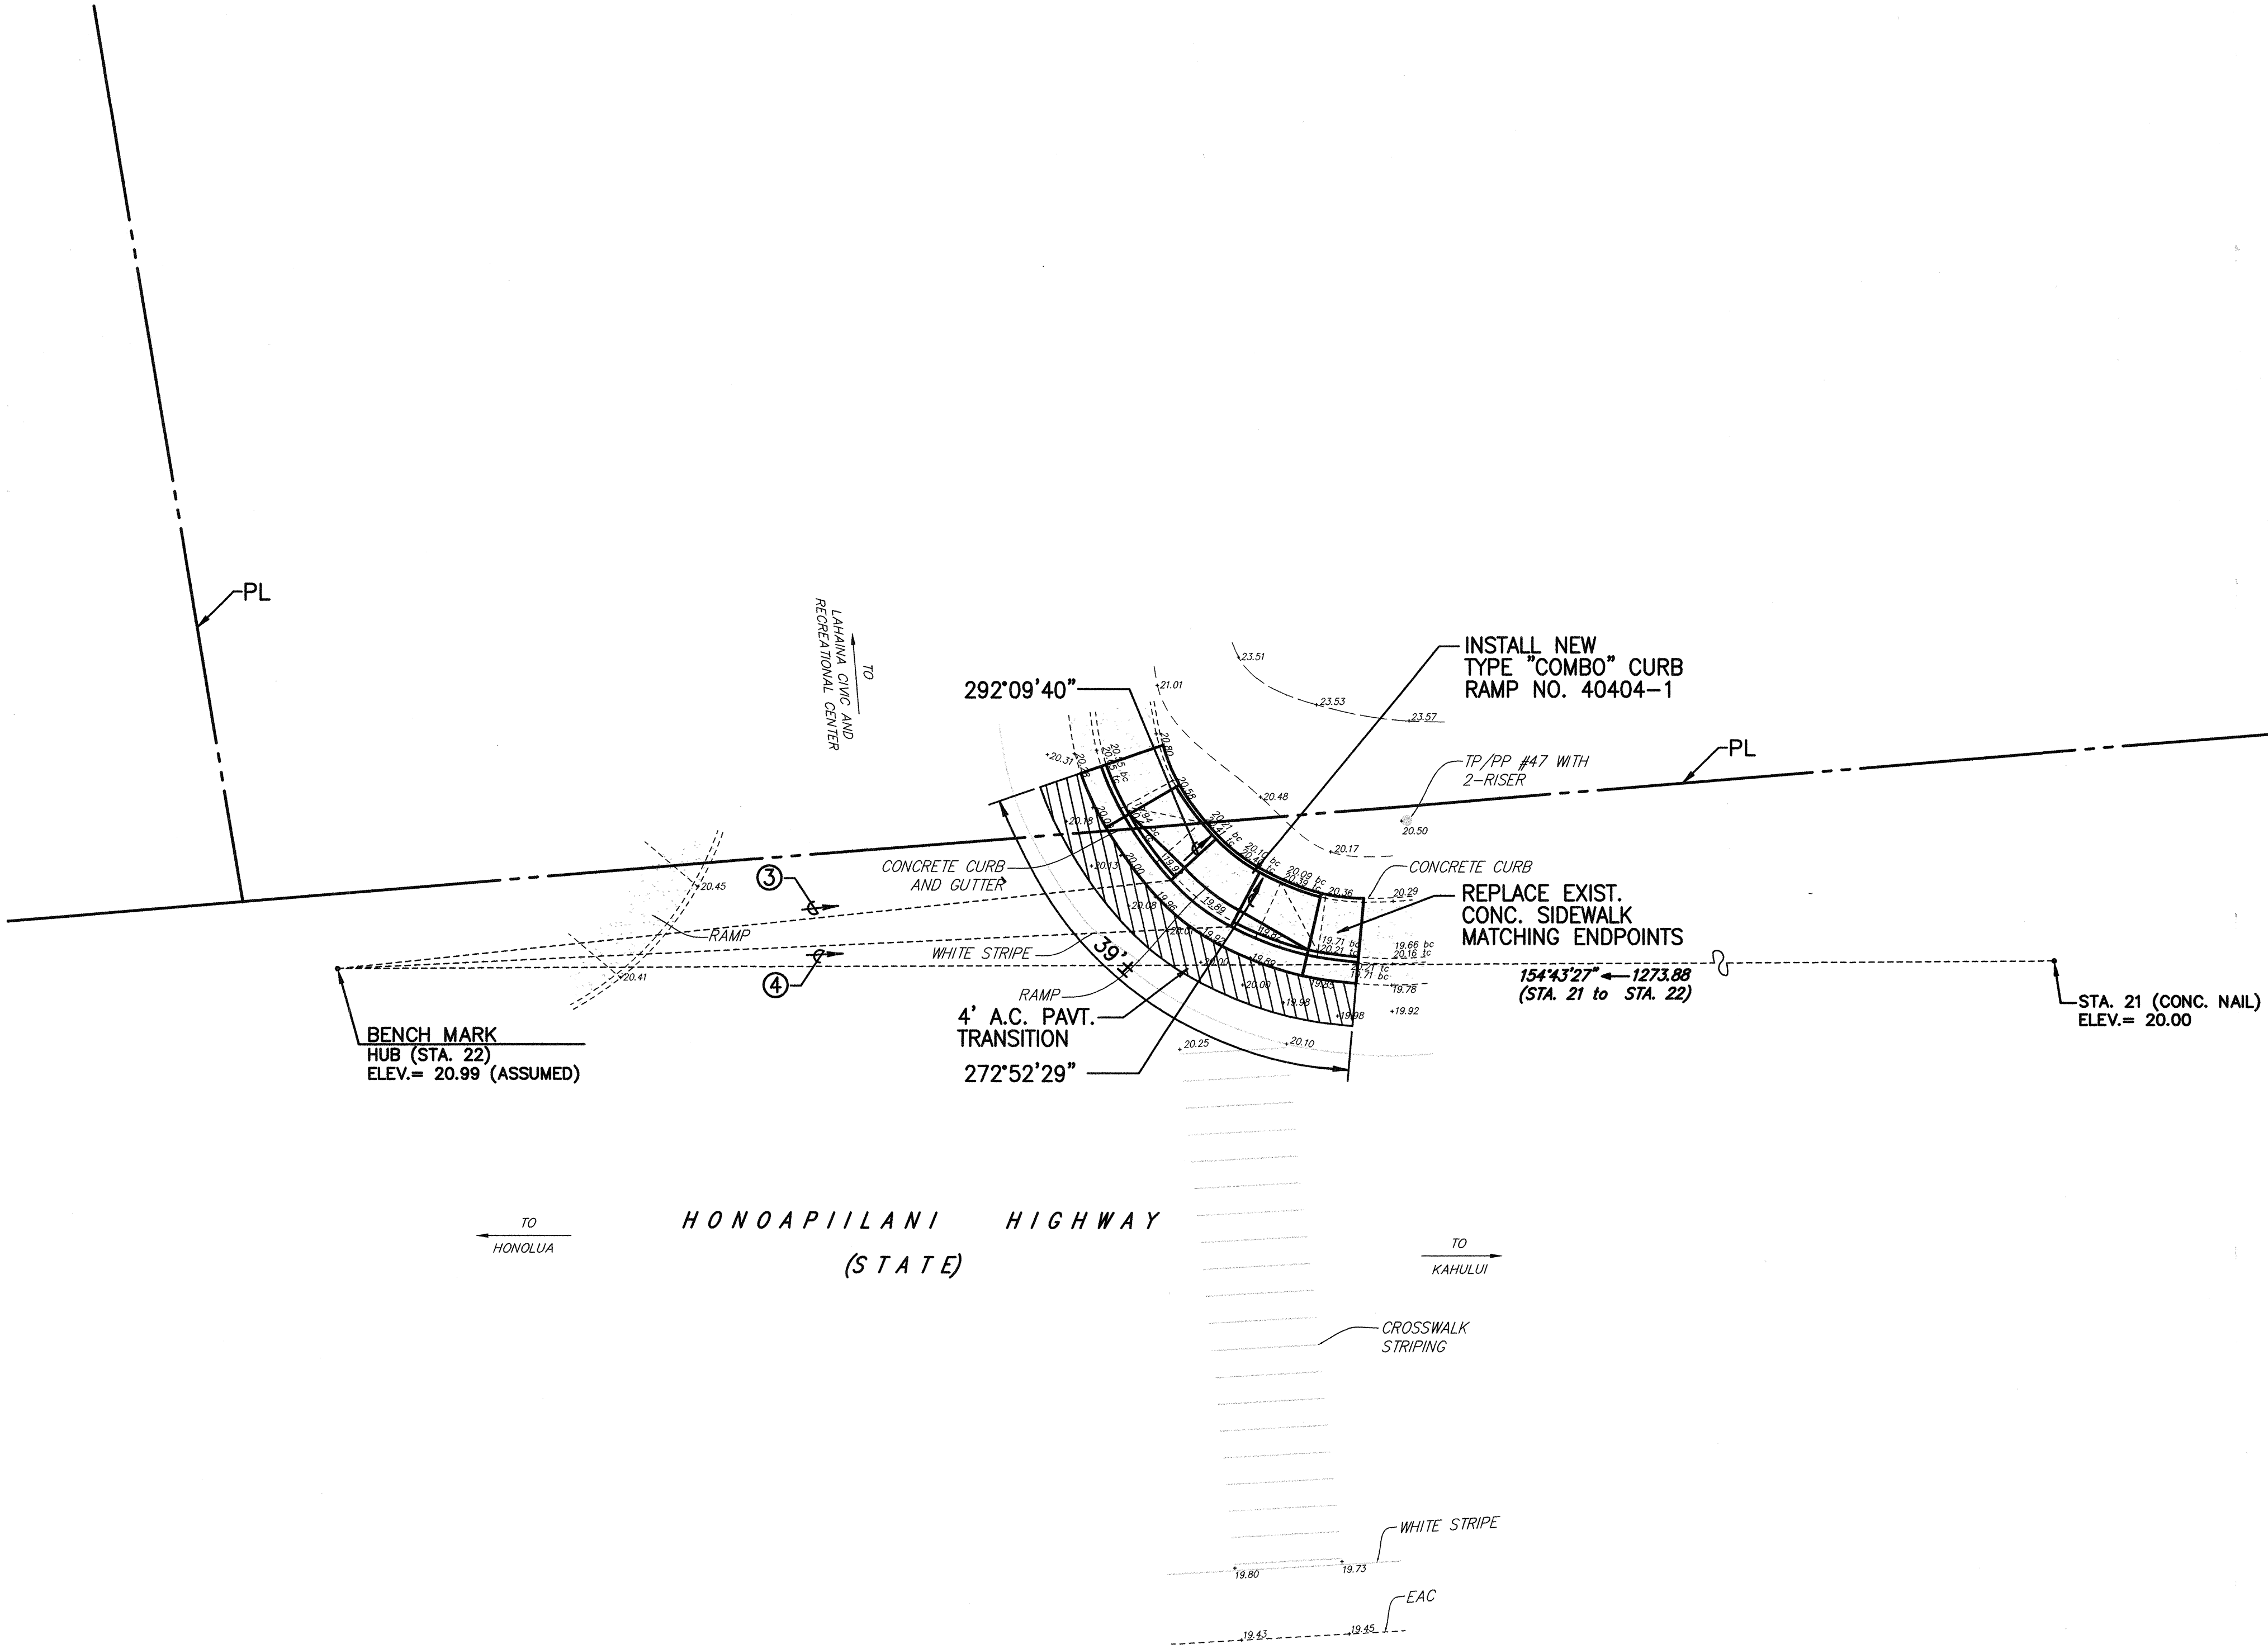


CURB RAMP NO. 40404-1 DETAILS
SCALE: 1"= 5'

- NOTES:
- SEE SHEETS CB-1 TO CB-10 FOR CURB RAMP, STRIPING, AND MISCELLANEOUS DETAILS.
 - FOR ALL ELECTRICAL WORK, SEE ELECTRICAL PLANS.

- ③ 328°53'49" 77.99'
(BM TO INTERSECTION OF RAMP
EDGE & CURB FACE)
- ④ 332°14'07" 83.21'
(BM TO INTERSECTION OF RAMP
EDGE & CURB FACE)

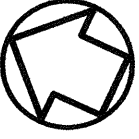
 **SITE PLAN**
SCALE: 1"= 10'

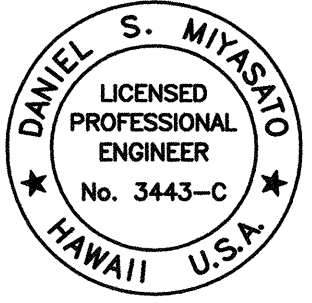

DANIEL S. MIYASATO
LICENSED PROFESSIONAL ENGINEER
No. 3443-C
HAWAII U.S.A.

STATE OF HAWAII
DEPARTMENT OF TRANSPORTATION
HIGHWAYS DIVISION
HONOAPIILANI HWY./BEACH PARK(40404)
CURB RAMP PLAN
PEDESTRIAN FACILITIES & ADA
COMPLIANCE AT VARIOUS
LOCATIONS ON MAUI
Federal - Aid Project No. CMAQ-0900(67)R
Scale: As Shown Date: August 2004
SHEET No. CC-27 OF 31 SHEETS

FED. ROAD DIST. NO.	STATE	FEDERAL - AID PROJ. NO.	FISCAL YEAR	SHEET NO.	TOTAL SHEETS
HAWAII	HAW.	CMAQ-0900(67)R	2004	49	109

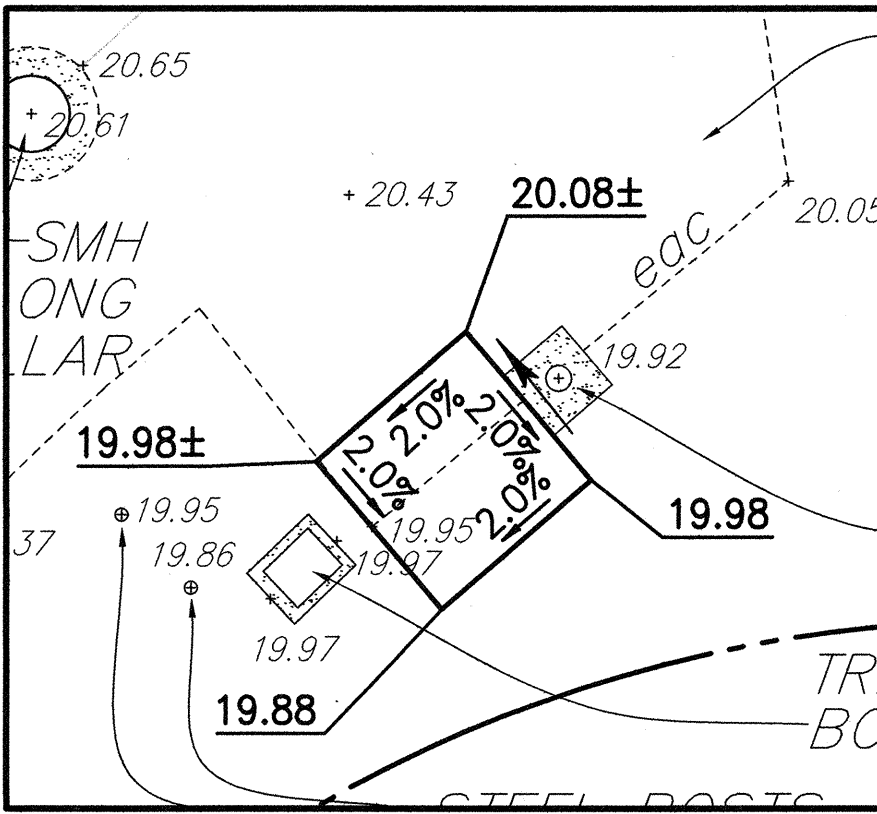

A.C. SIDEWALK NO. 40504-1 DETAILS
SCALE: 1"= 5'

HONOAPIILANI HIGHWAY
(STATE)
F.A.S.P. NO. S-0300-1

TO
HONOLULU

TO
LAHAINA TOWN

NOTES:

- SEE SHEETS CB-1 TO CB-10 FOR CURB RAMP, STRIPING, AND MISCELLANEOUS DETAILS.
- FOR ALL ELECTRICAL WORK, SEE ELECTRICAL PLANS.


DANIEL S. MIYASATO
LICENSED PROFESSIONAL ENGINEER
No. 3443-C
HAWAII U.S.A.

THIS WORK WAS PREPARED BY ME OR UNDER MY SUPERVISION
04/30/06
EXPIRATION DATE OF THE LICENSE
1A 9-22-04

STATE OF HAWAII
DEPARTMENT OF TRANSPORTATION
HIGHWAYS DIVISION
HONOAPIILANI HWY./KAANAPALI PKWY.(40504)
CURB RAMP PLAN
PEDESTRIAN FACILITIES & ADA
COMPLIANCE AT VARIOUS
LOCATIONS ON MAUI
Federal - Aid Project No. CMAQ-0900(67)R
Scale: As Shown Date: August 2004
SHEET No. CC-28 OF 31 SHEETS




SITE PLAN
SCALE: 1"= 10'

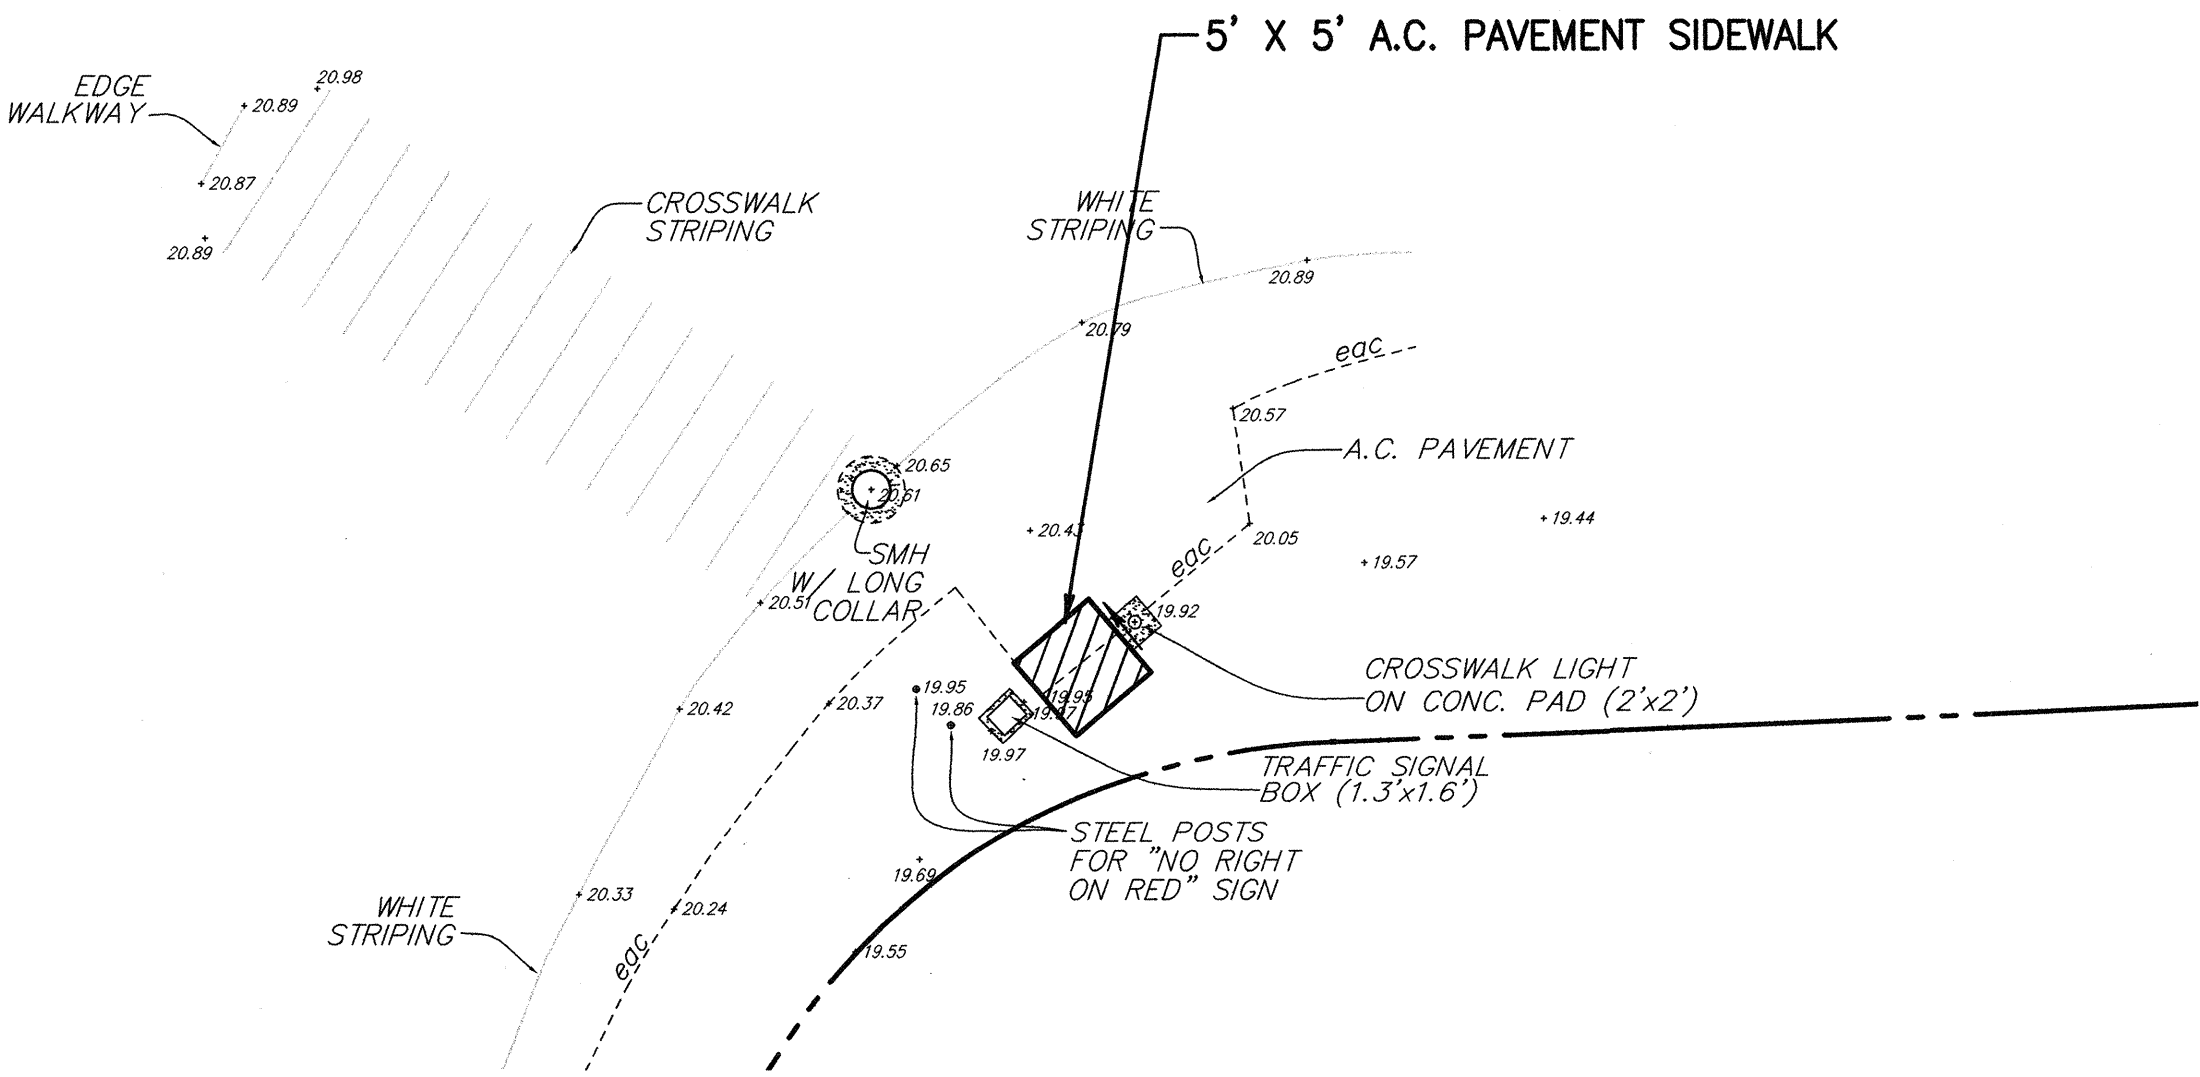

ORIGINAL PLAN	SURVEY PLOTTED BY	DATE
NOTE BOOK	DRAWN BY	DATE
No.	DESIGNED BY	DATE
	QUANTITIES BY	DATE
	CHECKED BY	DATE

FED. ROAD DIST. NO.	STATE	FEDERAL - AID PROJ. NO.	FISCAL YEAR	SHEET NO.	TOTAL SHEETS
HAWAII	HAW.	CMAQ-0900(67)R	2004	50	109

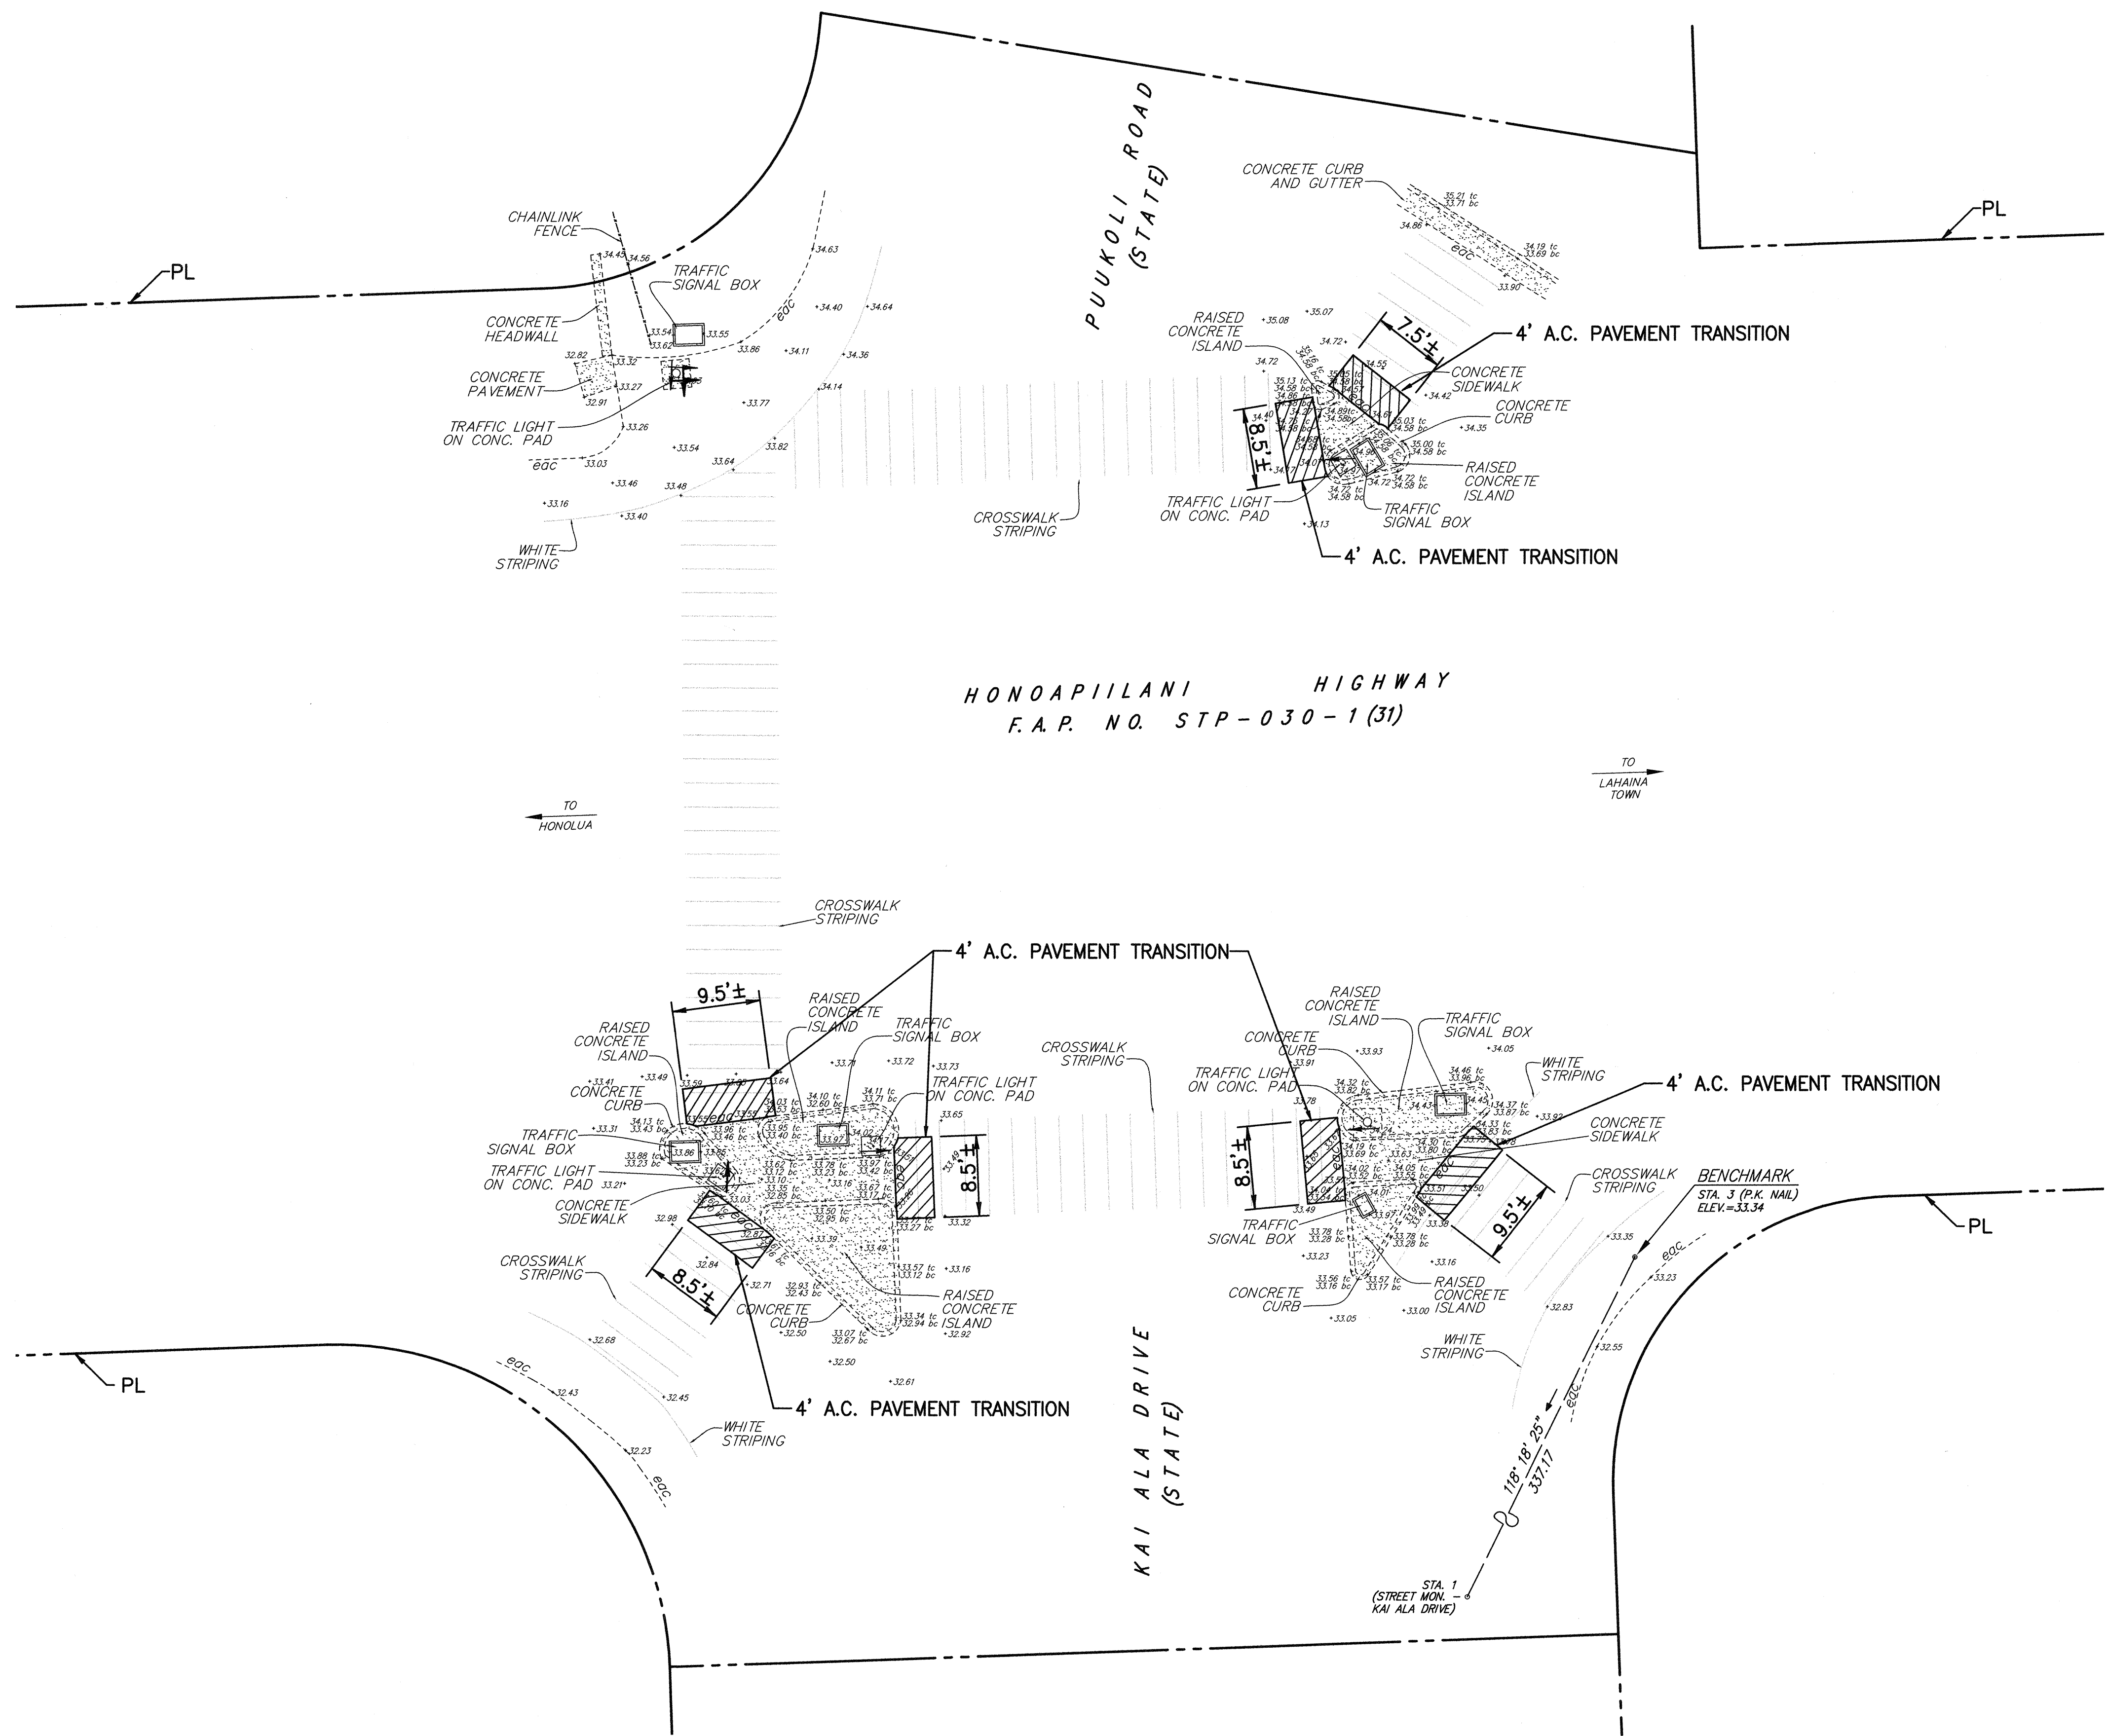

- NOTES:**
- SEE SHEETS CB-1 TO CB-10 FOR CURB RAMP, STRIPING, AND MISCELLANEOUS DETAILS.
 - FOR ALL ELECTRICAL WORK, SEE ELECTRICAL PLANS.



THIS WORK WAS PREPARED BY ME OR UNDER MY SUPERVISION
04/30/06
EXPIRATION DATE OF THE LICENSE
12-9-04

STATE OF HAWAII
DEPARTMENT OF TRANSPORTATION
HIGHWAYS DIVISION
HONOAPIILANI HWY./PUUKOLII RD./KAI ALA DR.
(40604&40704) CURB RAMP PLAN
PEDESTRIAN FACILITIES & ADA
COMPLIANCE AT VARIOUS
LOCATIONS ON MAUI
Federal - Aid Project No. CMAQ-0900(67)R
Scale: As Shown Date: August 2004
SHEET No. CC-29 OF 31 SHEETS

SITE PLAN
SCALE: 1"= 10'
NORTH

DATE	5/2/04
DESIGNED BY	
CHECKED BY	
NOTED BY	
NO.	


This plan view illustrates the proposed intersection improvements. Key features include:

- RAISED CONCRETE ISLANDS:** Two islands are shown, one measuring 10.5' ± and the other 6' ±. They are separated by a 7' ± wide area.
- TRAFFIC SIGNAL BOXES:** Two rectangular signal boxes are located within the concrete islands.
- CONCRETE CURBS:** Curbs are shown along the edges of the islands and signal boxes.
- RAISED CONCRETE ISLAND:** An additional island is shown on the left side of the intersection.
- 4' A.C. PAVEMENT TRANSITION:** Two transition areas are indicated on the right side of the plan.
- TRAFFIC SIGNAL:** A traffic signal is located near the center of the intersection.
- CROSSWALK STRIPING:** Striping is shown for the crosswalks.
- STRAIPING:** Roadway striping is indicated along the main thoroughfare.
- STATIONING:** The main thoroughfare is marked with stationing from 19.40 to 20.52. A secondary road is marked with stationing 356+41'15" and 121.97.
- BENCHMARK:** A benchmark is located at STA. 30 (NAIL IN CONC. SWALE) with an elevation of 20.00.
- TO HONOLUA:** An arrow points towards the direction of travel to Honolua.


- | | |
|------------------|------------------------------------|
| ORIGINAL
PLAN | SURVEY PLOTTED BY _____ DATE _____ |
| NOTE BOOK | DRAWN BY _____ |
| | TRACED BY _____ |
| | DESIGNED BY _____ |
| | QUANTITIES BY _____ |
| No. _____ | CHECKED BY _____ |

	STATE OF HAWAII
	DEPARTMENT OF TRANSPORTATION
	HIGHWAYS DIVISION
	<u>HONOAPIILANI HWY./LOWER HONOAPIILANI HWY.</u>
	<u>(40804) CURB RAMP PLAN</u>
	<u>PEDESTRIAN FACILITIES & ADA</u>
	<u>COMPLIANCE AT VARIOUS</u>
	<u>LOCATIONS ON MAUI</u>
	<u>Federal - Aid Project No. CMAQ-0900(67)R</u>
THIS WORK WAS PREPARED BY ME OR UNDER MY SUPERVISION	Scale: As Shown Date: August 2004
04/30/06	
EXPIRATION DATE OF THE LICENSE 04	
	SHEET NO. CC-30 OF 31 SHEETS

FED. ROAD DIST. NO.	STATE	FEDERAL - AID PROJ. NO.	FISCAL YEAR	SHEET NO.	TOTAL SHEETS
HAWAII	HAW.	CMAQ-0900(67)R	2004	52	109

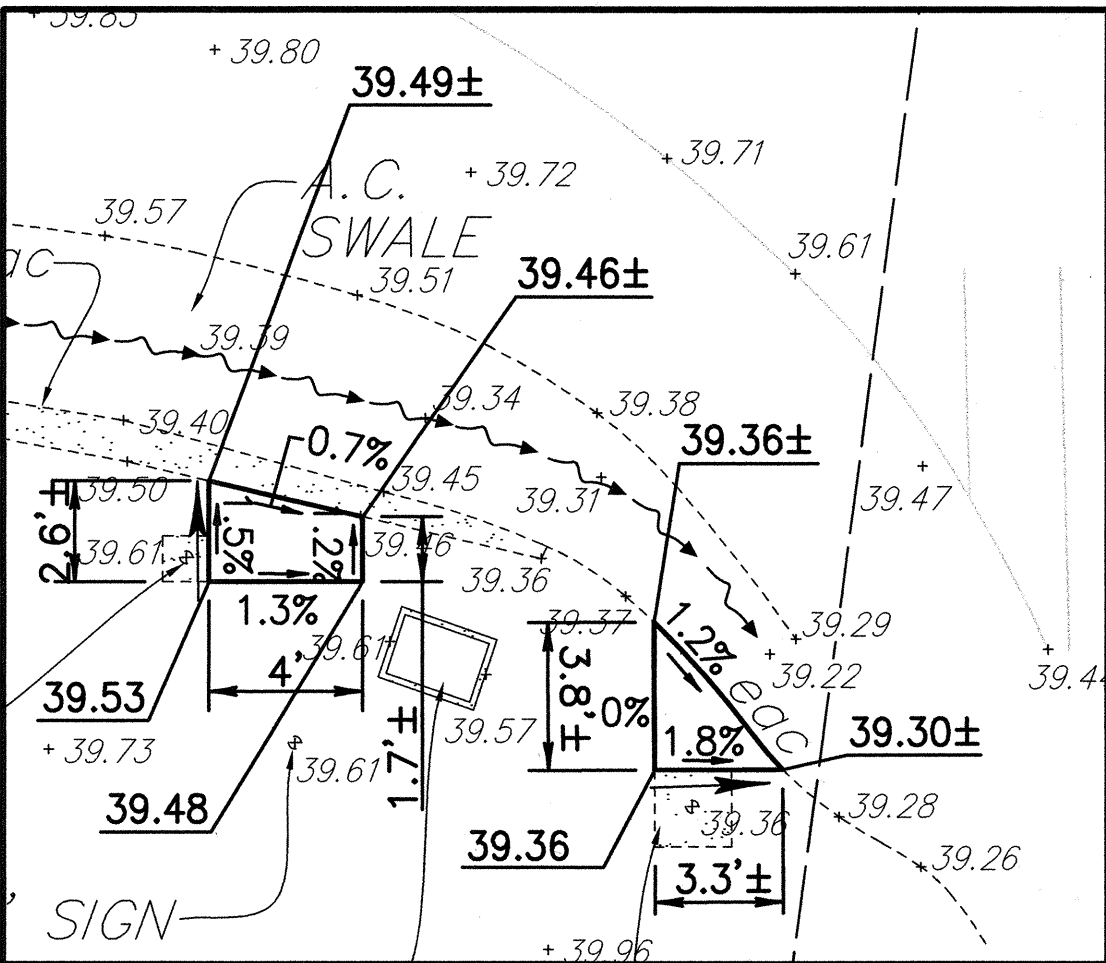

SIDEWALK NO. 40904-4 DETAILS
SCALE: 1"= 5'

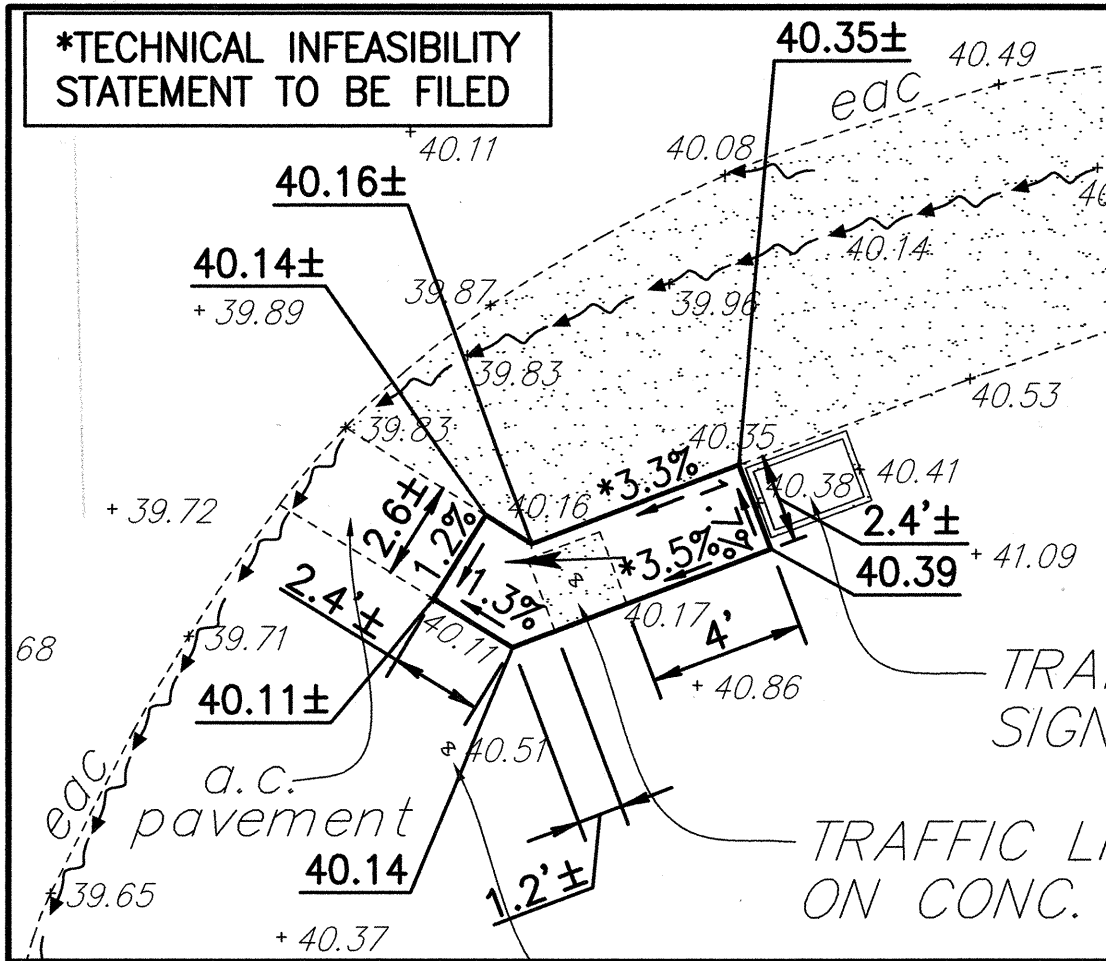

SIDEWALK NO. 40904-3 DETAILS
SCALE: 1"= 5'

NOTES:

- SEE SHEETS CB-1 TO CB-10 FOR CURB RAMP, STRIPING, AND MISCELLANEOUS DETAILS.
- FOR ALL ELECTRICAL WORK, SEE ELECTRICAL PLANS.

DANIEL S. MIYAMOTO
 LICENSED PROFESSIONAL ENGINEER
 No. 3443-C
 HAWAII, USA

STATE OF HAWAII
DEPARTMENT OF TRANSPORTATION
HIGHWAYS DIVISION


HONOAPIILANI HWY./HOOHUI RD.(40904)

CURB RAMP PLAN

PEDESTRIAN FACILITIES & ADA
COMPLIANCE AT VARIOUS
LOCATIONS ON MAUI

Federal - Aid Project No. CMAQ-0900(67)R
Scale: As Shown Date: August 2004

SHEET No. CC-31 OF 31 SHEETS

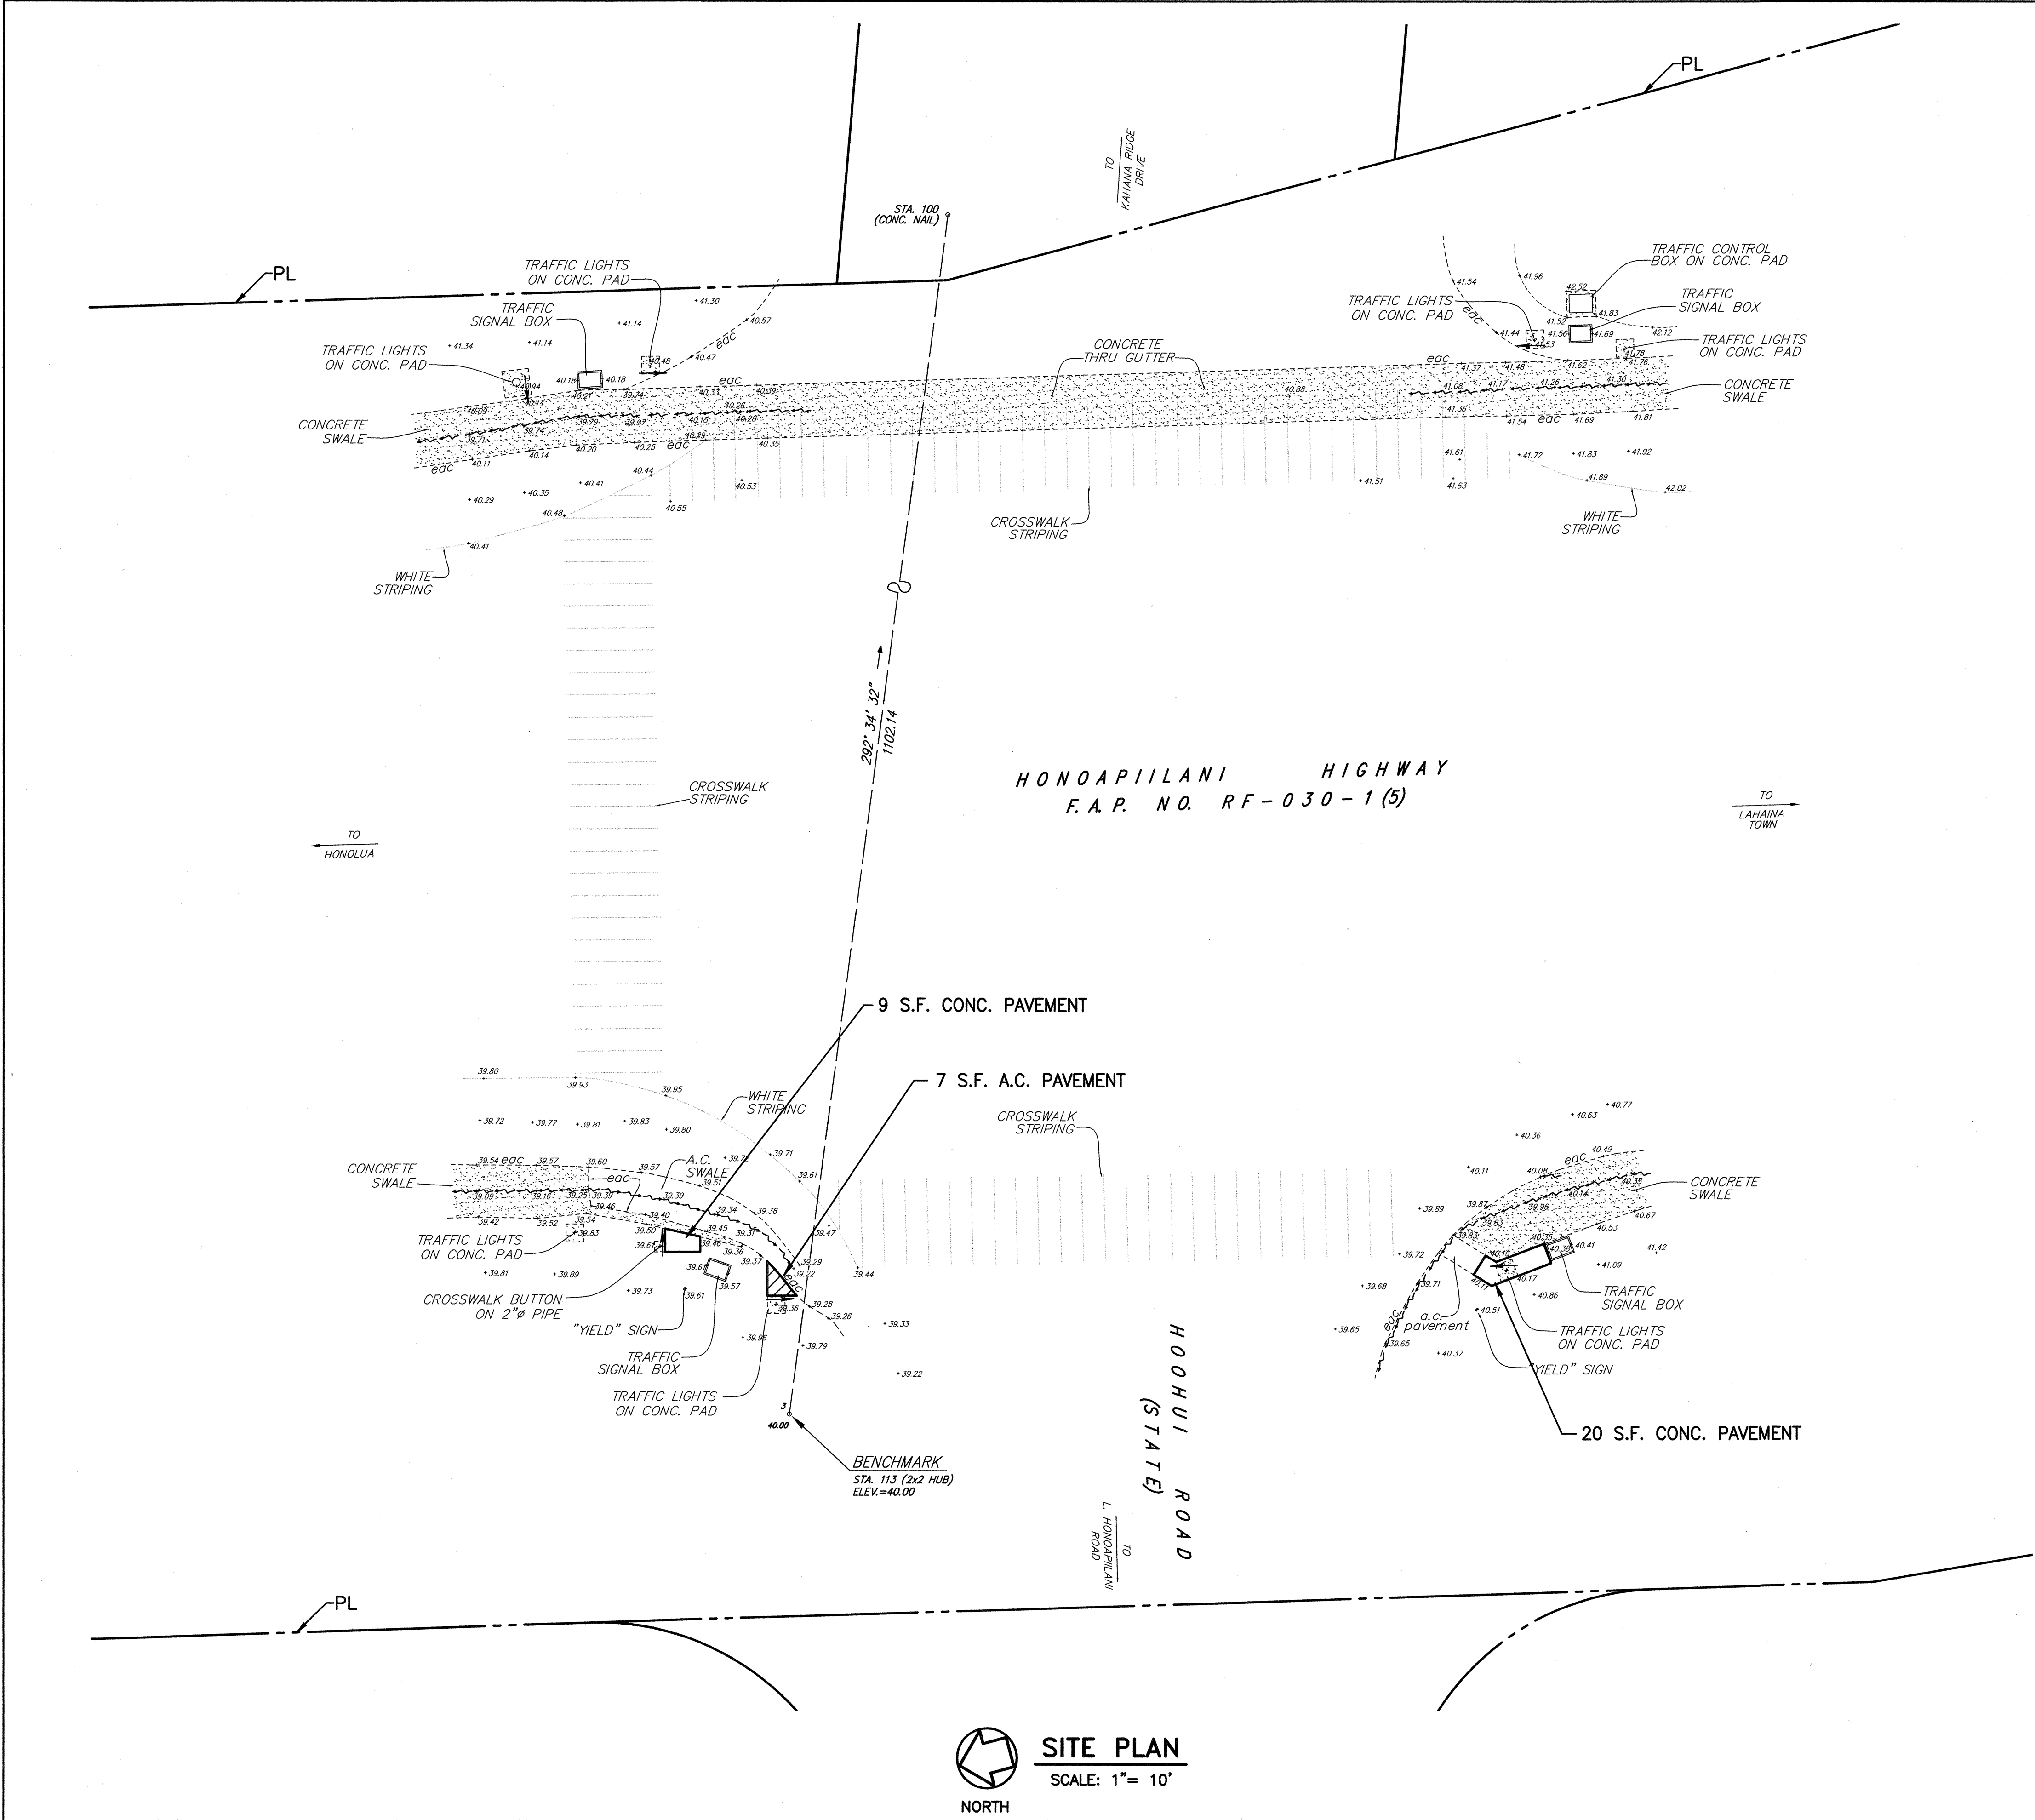

ORIGINAL PLAN	DATE
NOTE BOOK	DESIGNED BY
DESIGNED BY	CHECKED BY
NO.	