
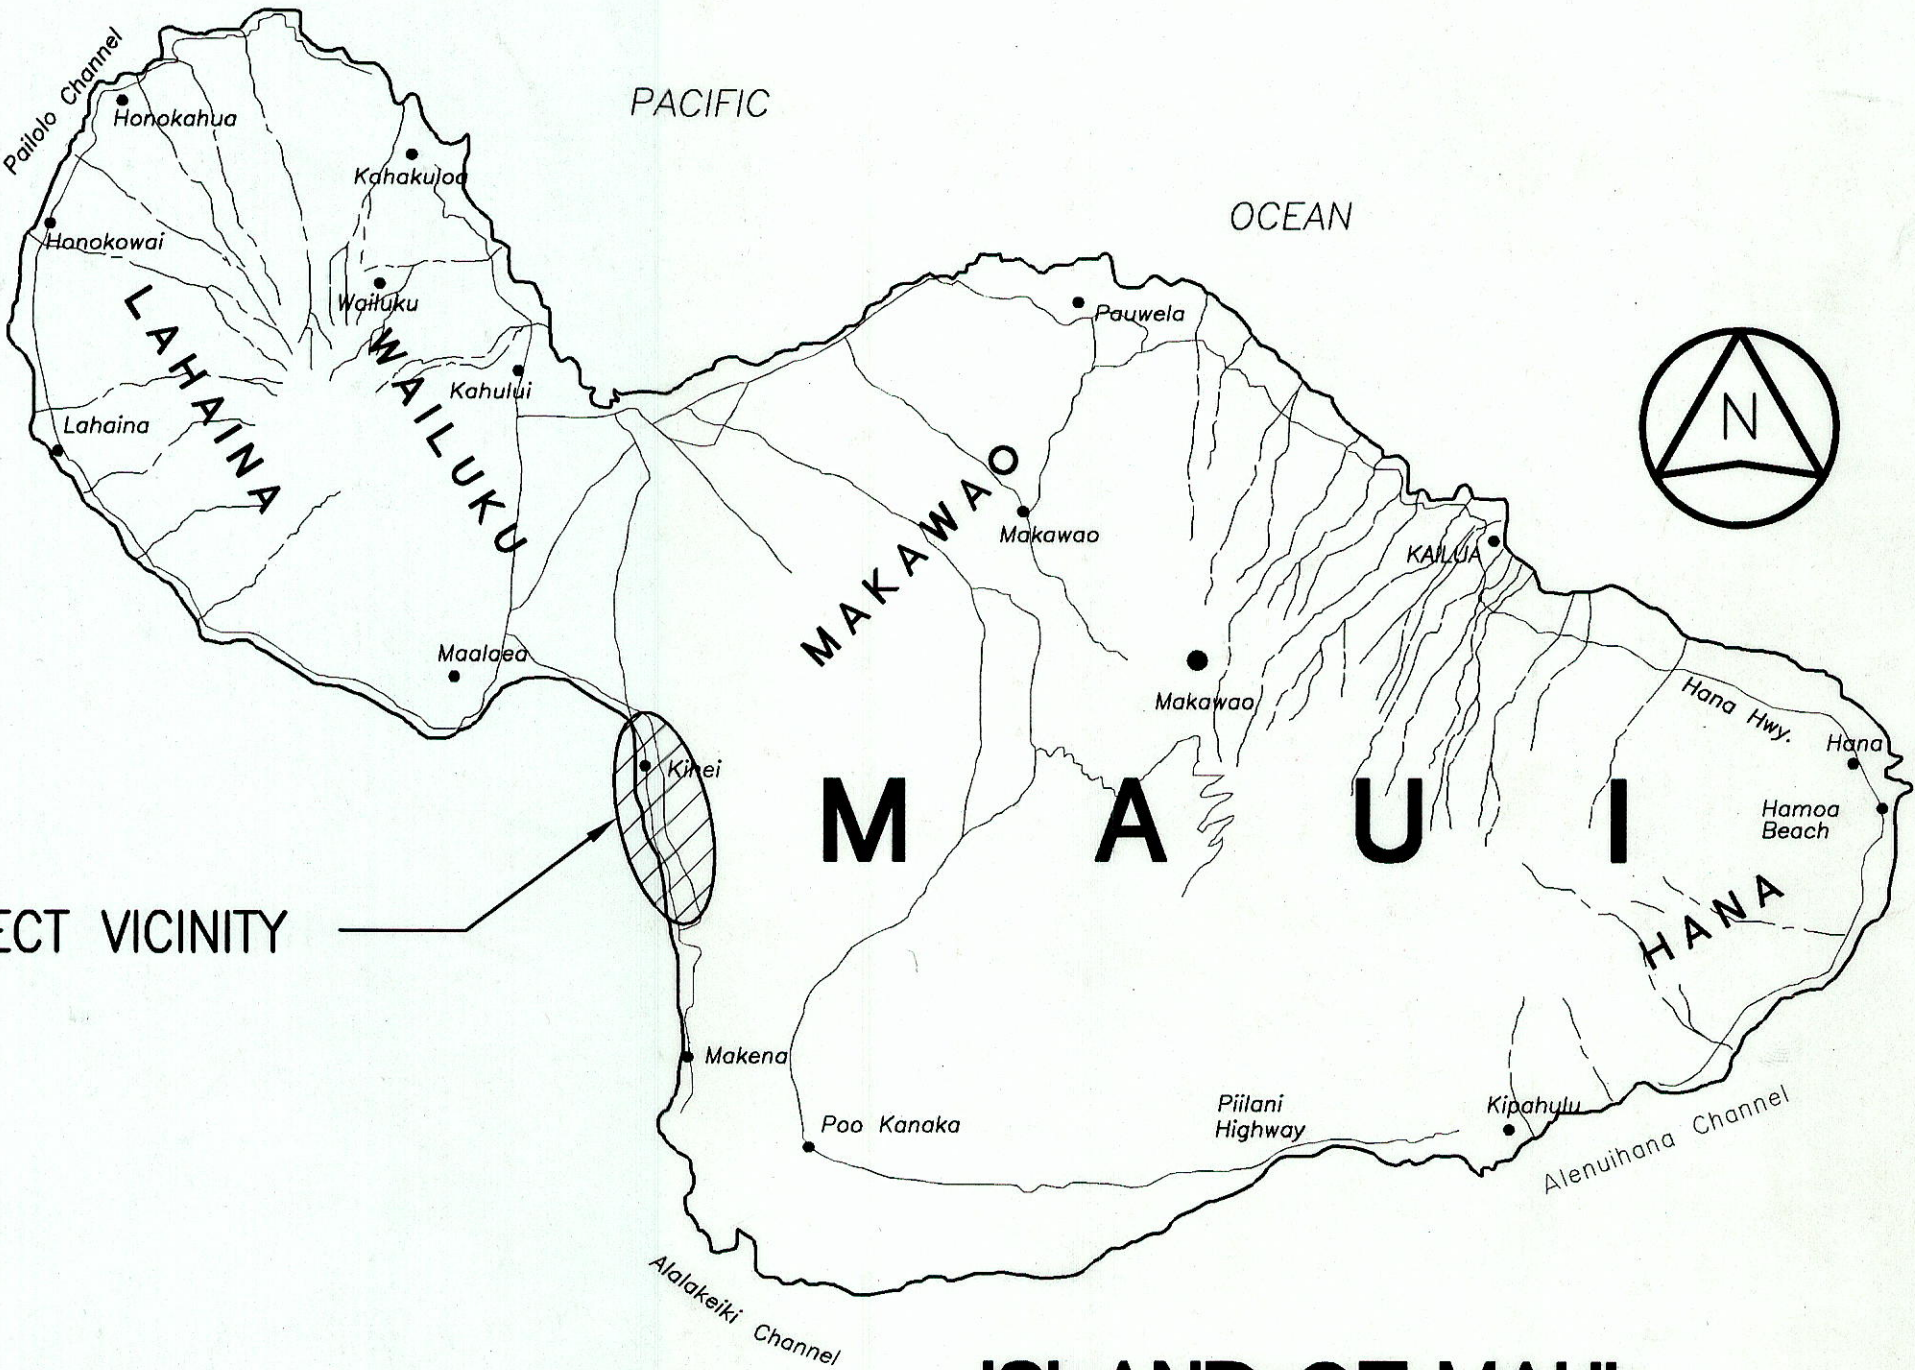


INDEX TO DRAWINGS	
SHEET NO.	DESCRIPTION
1	TITLE SHEET
2	STANDARD PLANS SUMMARY
3-8	GENERAL NOTES, LEGEND, & ABBREVIATION LIST
9-10	GENERAL PLAN
11-21	TYPICAL SECTIONS
22-36	ROADWAY PLANS
37-51	GRADING, DRAINAGE & EROSION CONTROL PLANS
52-53	DRAIN LINE PROFILES
54-56	DRAINAGE DETAILS
57	DRAINAGE SUMMARY SHEET
58-65	SITE & GRADING PLANS - INTERSECTIONS
66-80	SIGNING & STRIPING PLANS
81-87	SIGNING & STRIPING PLANS - INTERSECTIONS
88-89	SIGNING DETAILS
90-91	SIGNING & STRIPING SUMMARY SHEET
92-97	CURB RAMP DETAILS
98	PAVEMENT DETAILS
99-104	GUARDRAIL DETAILS
105-107	TRAFFIC CONTROL PLANS
108-124	ELECTRICAL PLANS

STATE OF HAWAII
DEPARTMENT OF TRANSPORTATION
HIGHWAYS DIVISION
HONOLULU, HAWAII
"AS-BUILT"
PLANS FOR
PIILANI HIGHWAY INTERIM WIDENING
MOKULELE HIGHWAY TO KILOHANA DRIVE
PROJECT NO. 31AB-01-02
DISTRICTS OF WAILUKU AND MAKAWAO
ISLAND OF MAUI

FED. ROAD DIST. NO.	STATE	PROJ. NO.	FISCAL YEAR	SHEET NO.	TOTAL SHEETS
HAWAII	HAW.	31AB-01-02	2002	1	124

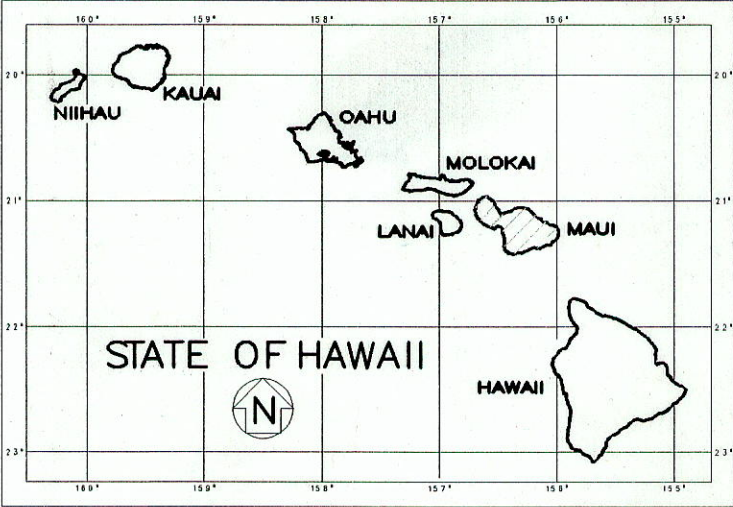


ISLAND OF MAUI
SCALE: 1" = 5 MILES

SCALE IN MILES

DESIGN DESIGNATION

	MOKULELE HWY. TO LIPOA ST.	LIPOA ST. TO KILOHANA DR.
ADT (2001)	27,900	22,400
ADT (2011)	38,100	30,500
DHV	4,100	3,300
D (DESIGN)	55/40	55/40
T (DESIGN)	2.0%	2.0%
T24	2.0%	2.0%
V	40 M.P.H.	40 M.P.H.

MILE POST 27.40 TO MILE POST 34.31

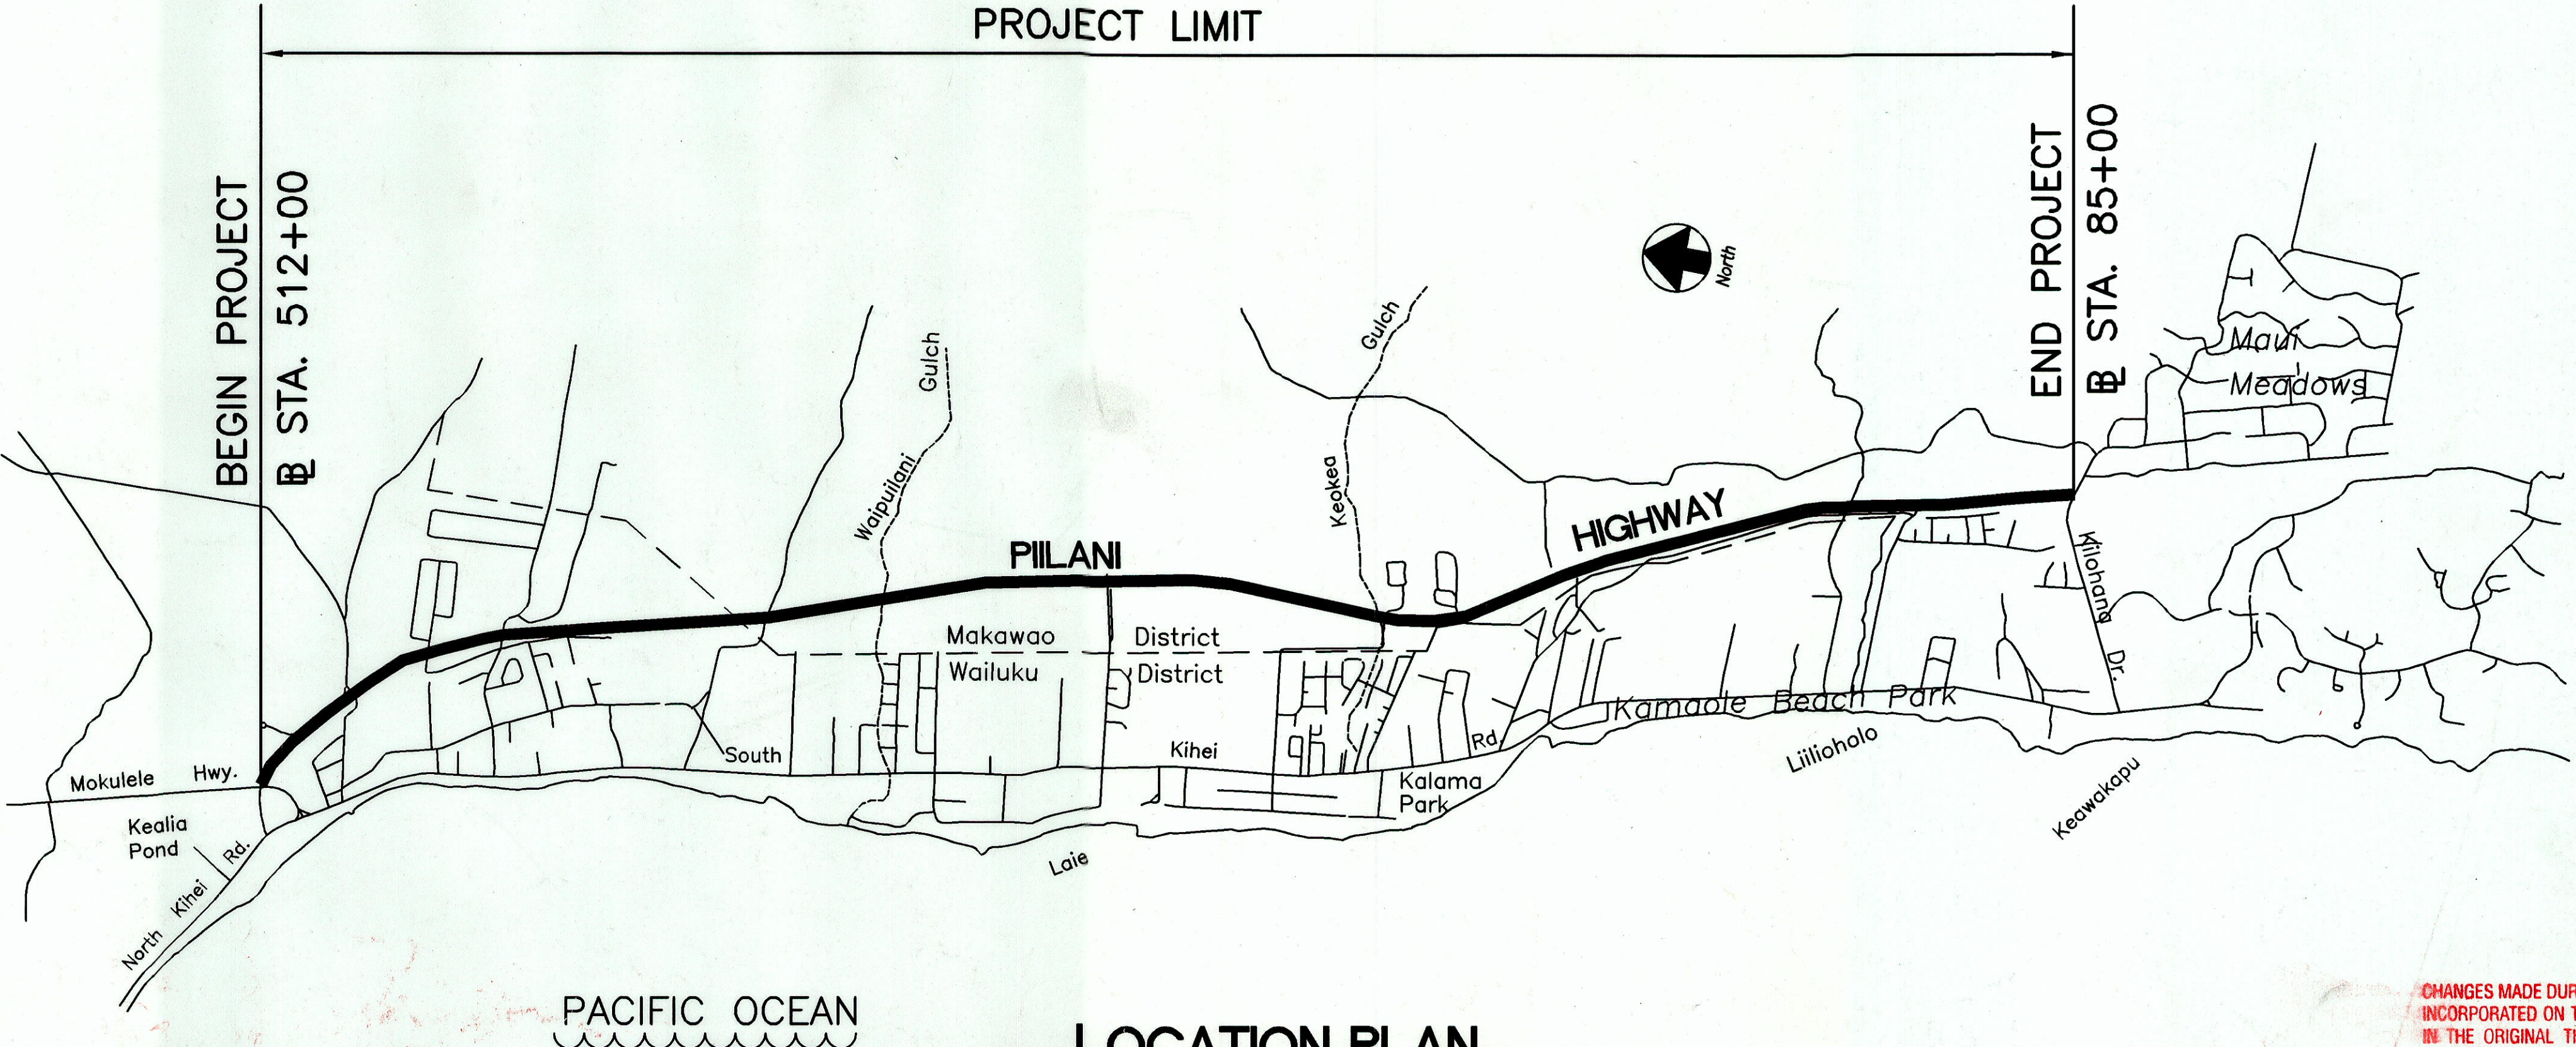

LOCATION PLAN

NOT TO SCALE

LENGTH OF PROJECT = 7.00± MILES

CHANGES MADE DURING CONSTRUCTION HAVE BEEN INCORPORATED ON THESE PLANS EXCEPT CHANGES IN THE ORIGINAL THEORETICAL QUANTITIES. FOR ACTUAL QUANTITIES, REFER TO PROJECT LEDGER AND/OR COMPUTATION BOOK.

3/22/2016
DATE

DEPARTMENT OF TRANSPORTATION
STATE OF HAWAII

APPROVED:

4.26.02
for DIR. OF TRANSPORTATION DATE

SURVEY PLOTTED BY	DATE
DRAWN BY	
DESIGNED BY	
QUANTITIES BY	
CHECKED BY	
NOTE BOOK	
No.	

R.M. TOWILL CORPORATION
DESIGNED BY
BOB SIAROT
P. S. & E. BY
(808)-873-3535
PHONE
MAY 2002
DATE