

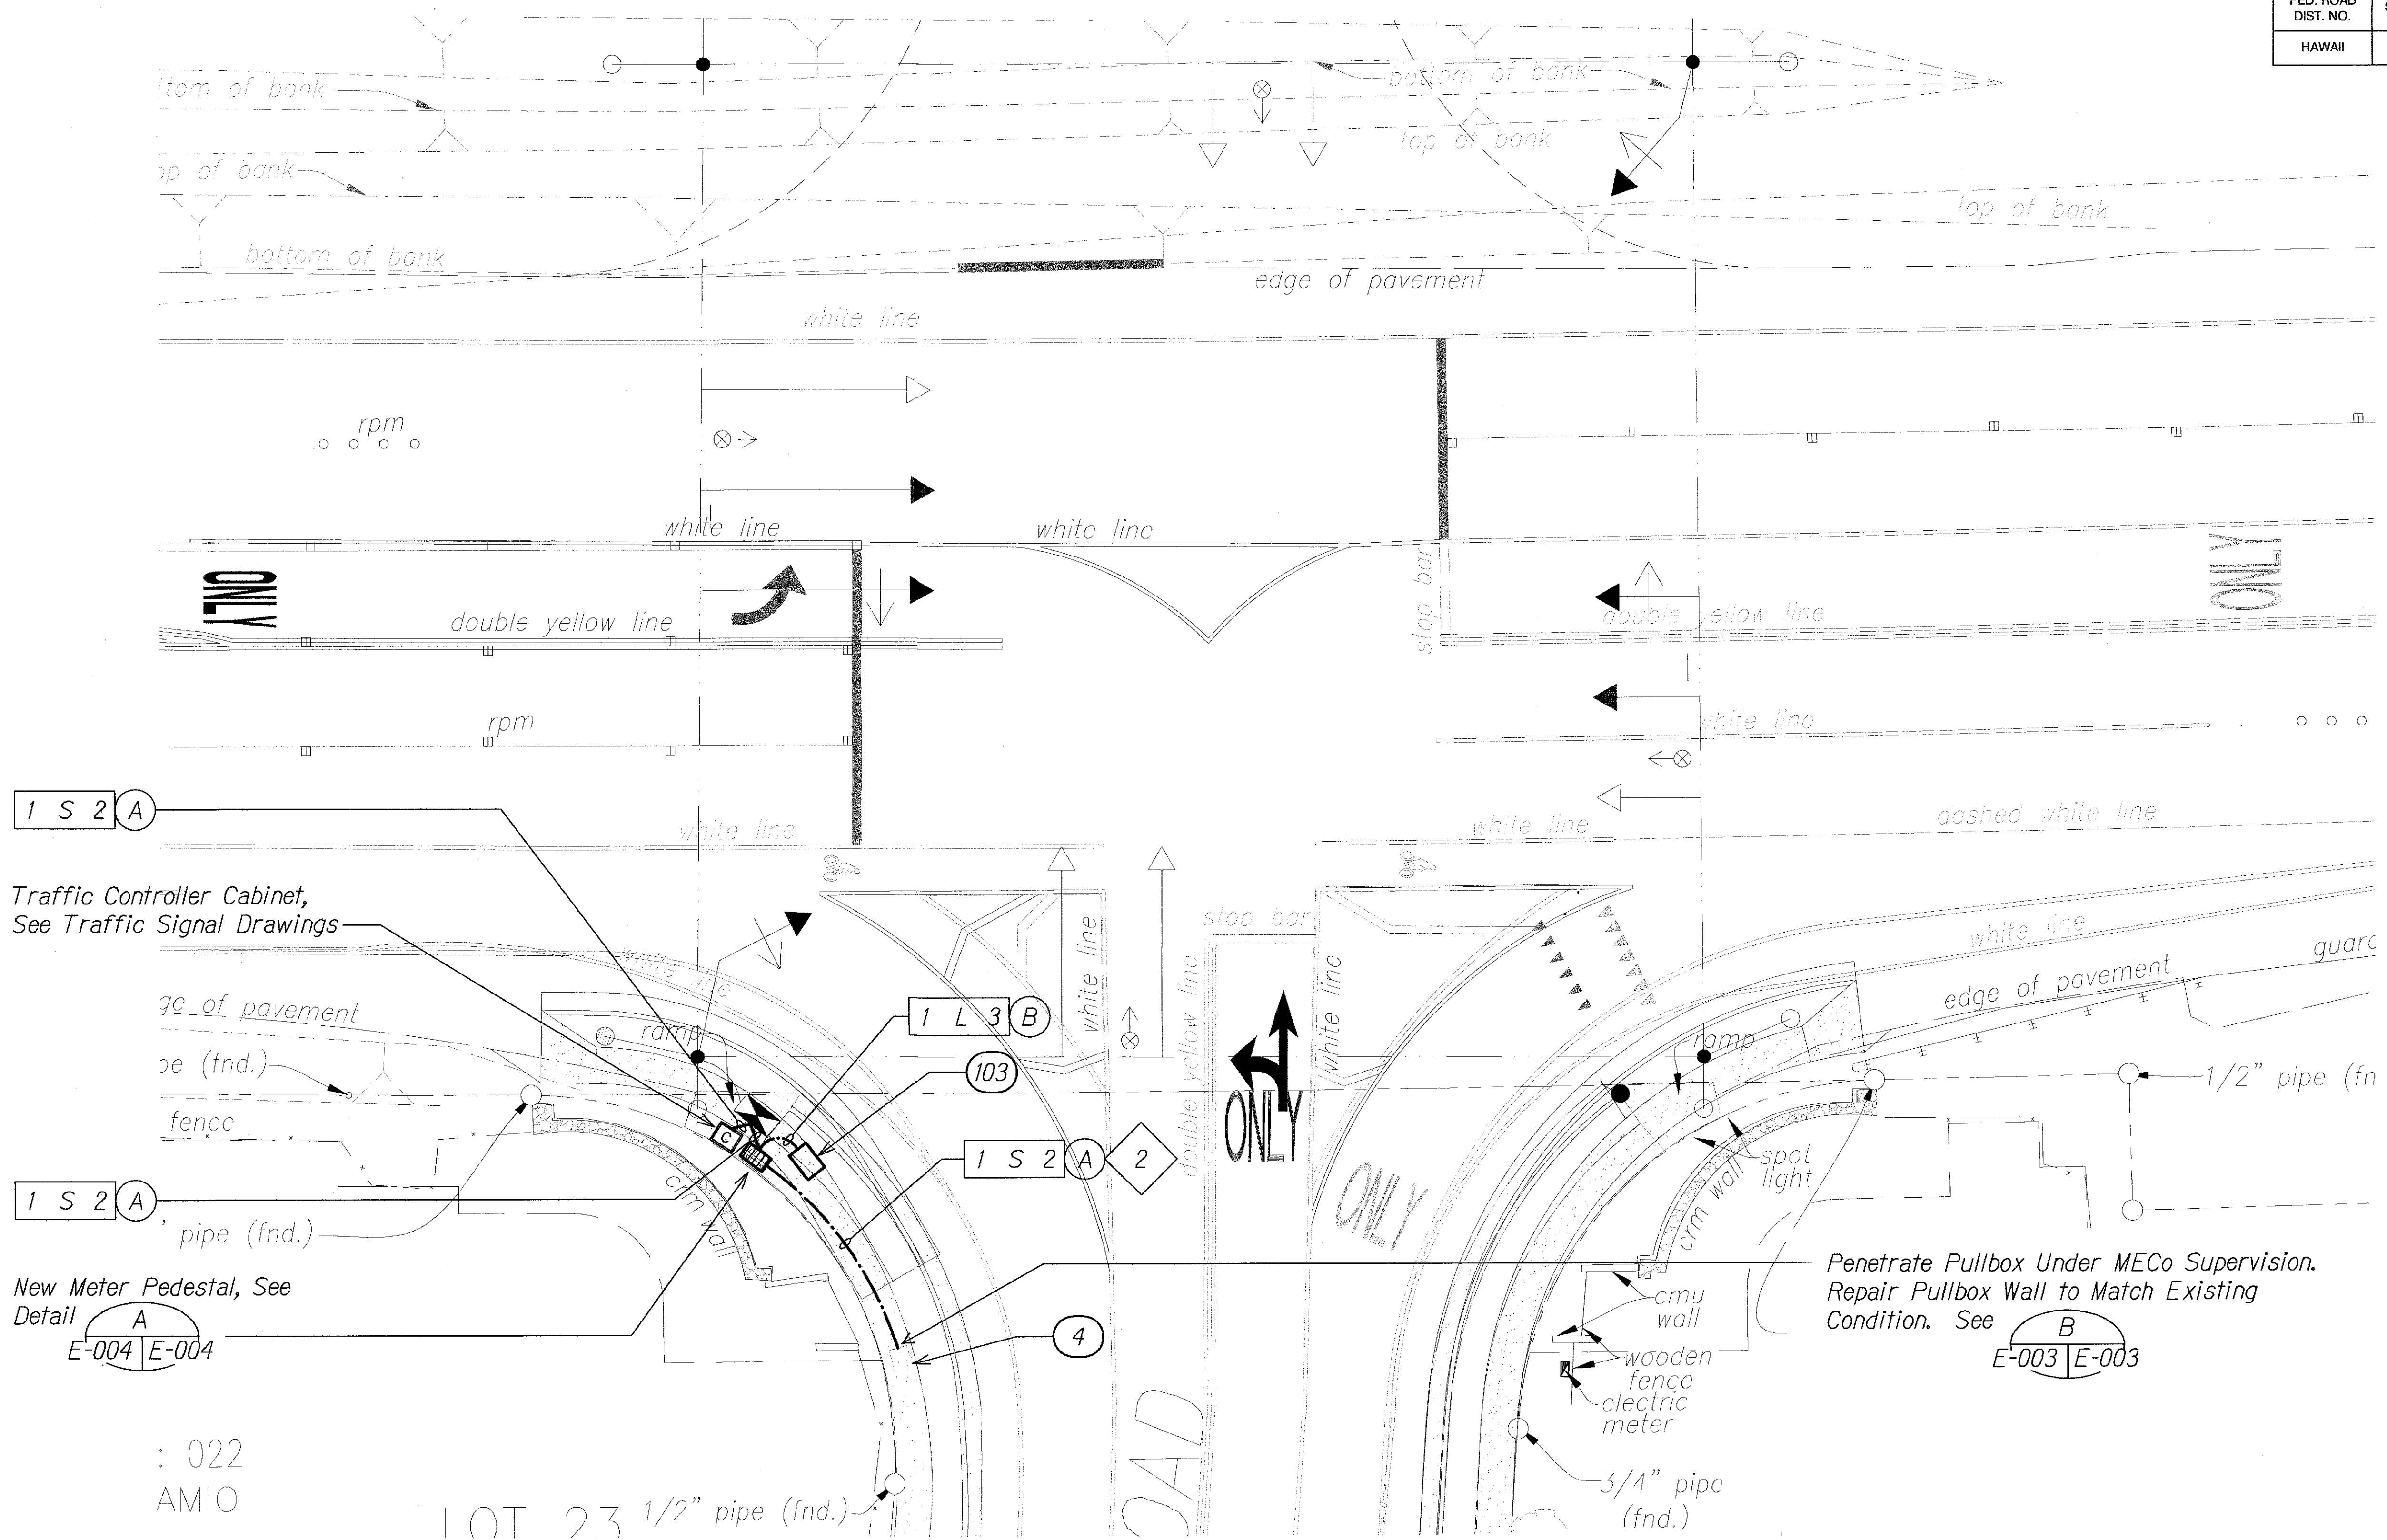


| FED. ROAD DIST. NO. | STATE | PROJ. NO. | FISCAL YEAR | SHEET NO. | TOTAL SHEETS |
|---------------------|-------|-----------|-------------|-----------|--------------|
| HAWAII | HAW. | 31A-02-17 | 2018 | 27 | 29 |

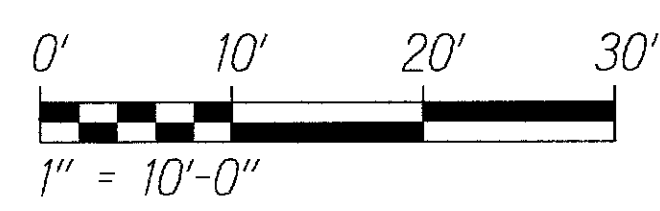

| | |
|-------------------|------|
| SURVEY PLOTTED BY | DATE |
| DRAWN BY | |
| DESIGNED BY | |
| QUANTITIES BY | |
| CHECKED BY | |
| ORIGINAL PLAN | |
| NOTE BOOK | |
| No. | |

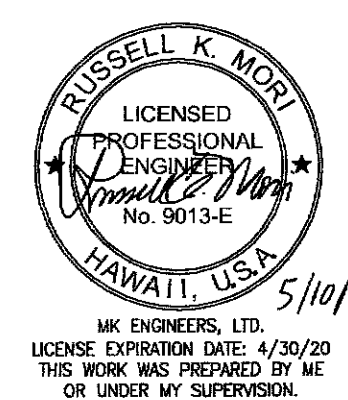

STATE OF HAWAII
DEPARTMENT OF TRANSPORTATION
HIGHWAYS DIVISION

SITE ELECTRICAL PLAN

*Piilani Highway Improvements
Vicinity of Kulanihakai Street
Project No. 31A-02-17*

Scale: As Noted Date: Mar 2018

SHEET No. E-002 OF 04 SHEETS