


NOTE:

The lawn areas shown on sheets 1, 2 and 3 between Sta. 3+85.21 and Sta. 11+00 were planted under Proj. No. F-032-1(2). No grass will be planted in this area unless ordered by the Engineer; planting in this area will consist of coconut, monkey pod and naupaka as shown in the plans and listed in the legend on each sheet.

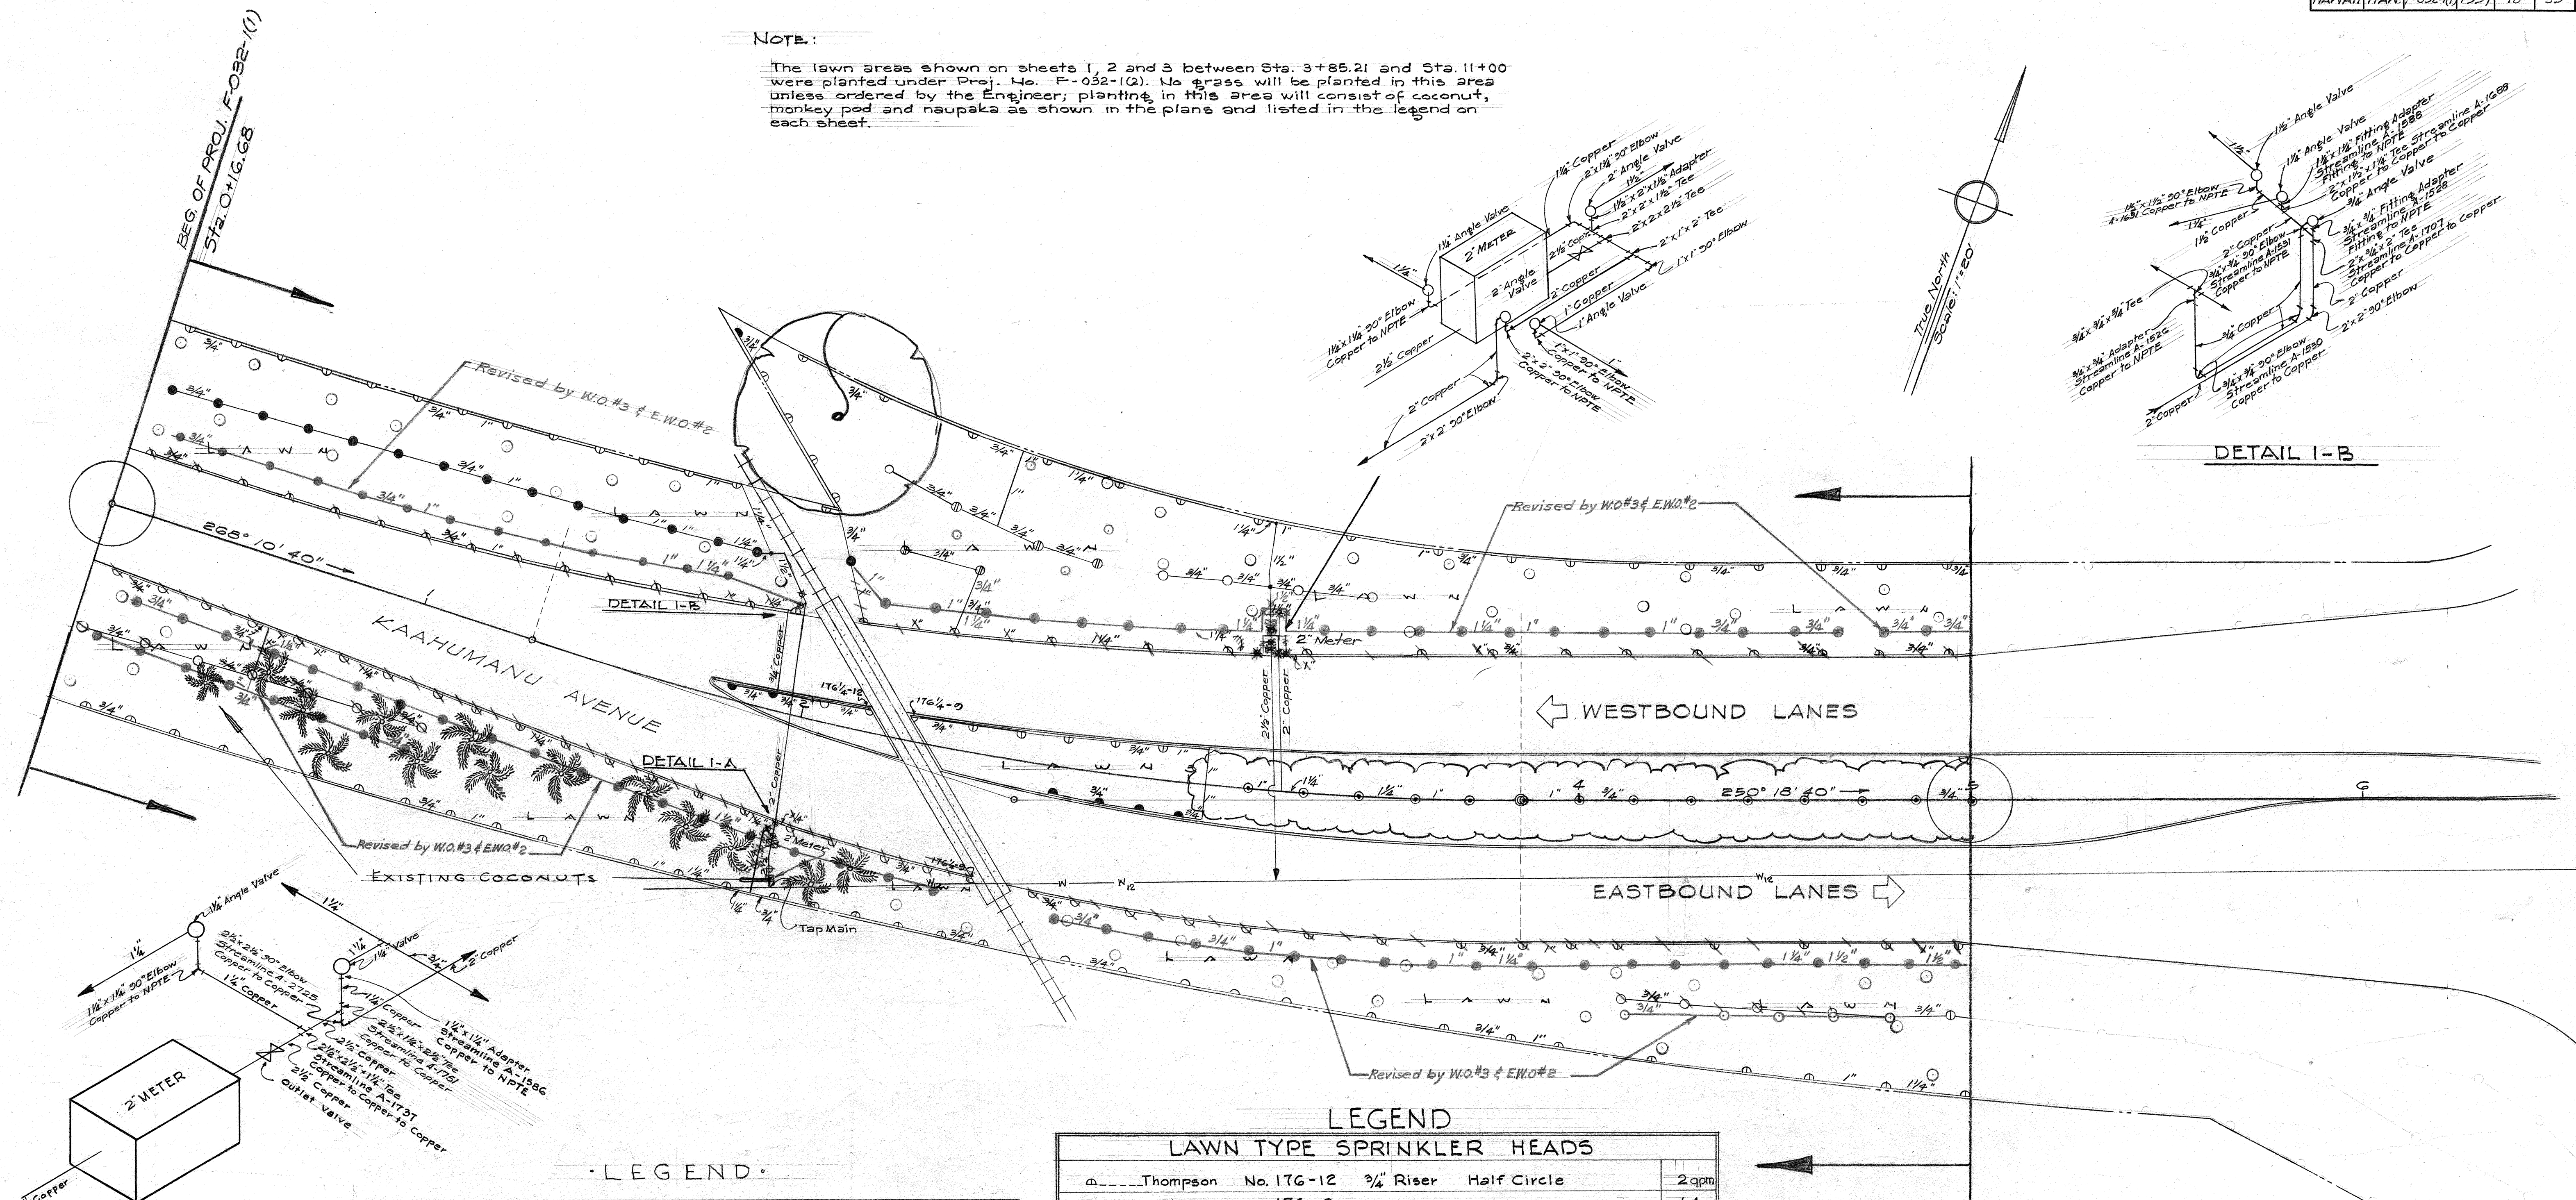

LEGEND

LAWN TYPE SPRINKLER HEADS

SYMBOL	THOMPSON NO.	RISE	CIRCLE	SPACING
○	176-12	3/4"	Half Circle	2' qtr
△	176-9	"	"	1.4'
●	176-6	"	"	1'
◐	176-3	"	"	0.5'
◑	176 1/4-9	"	Quarter Circle	0.7'
◒	176 1/4-6	"	"	0.5'
⊙	171-D	"	Full Circle	5'
⊖	171-C	"	"	3.8'
○	171-B	"	"	3'
●	171-A	"	"	2.5'

SHRUBBERY TYPE SPRINKLER HEADS

SYMBOL	THOMPSON NO.	RISE	CIRCLE	SPACING
○	117-D	1/2"	Full Circle	5'
⊖	117-C	"	"	3.8'
⊙	117-B	"	"	3'
⊗	Angle Control Valve to be of same size as connecting pipe			
⊕	Outlet Valve			
⊞	Water Meter			

LEGEND

SYM	BOTANICAL NAME	COMMON NAME	QUAN.	SPACE
○	COCOS NUCIFERA	COCONUT	55	SHOWN
LAWN	CYNODON DACTYLON	BERMUDA GRASS		COVER
⊗	SAManea SAMAN	MONKEY POD	1	SHOWN
⊞	SCAEVOLA FRUTESCENS	NAUPAKA	155	4' APART

GENERAL NOTES - LANDSCAPING

The sizes of the plants to be furnished by the Contractor are listed below:

1. Coconut - 4 - 6 leaves on each plant; planted in 5 gal. can.
2. Monkey Pod - 4 - 5' high; planted in 5 gal. can.
3. Naupaka - 12 - 24" high; planted in 1 gal. can.

SPRINKLER LAYOUT

TERRITORIAL HIGHWAY DEPARTMENT
TERRITORY OF HAWAII

LANDSCAPE PLAN

MAIN STREET

PROJ. NO. F-032-1(1)


Scale: 1" = 20'

SHEET No. 1 OF 8 SHEETS

5909.18

THOMPSON & THOMPSON
LANDSCAPE ARCHITECTS
HONOLULU - HAWAII

DATE: _____
SURVEY PLOTTED BY: _____
ORIGINAL PLAN: _____
DRAWN BY: _____
NOTE BOOK: _____
QUANTITIES CHECKED BY: _____
No. _____

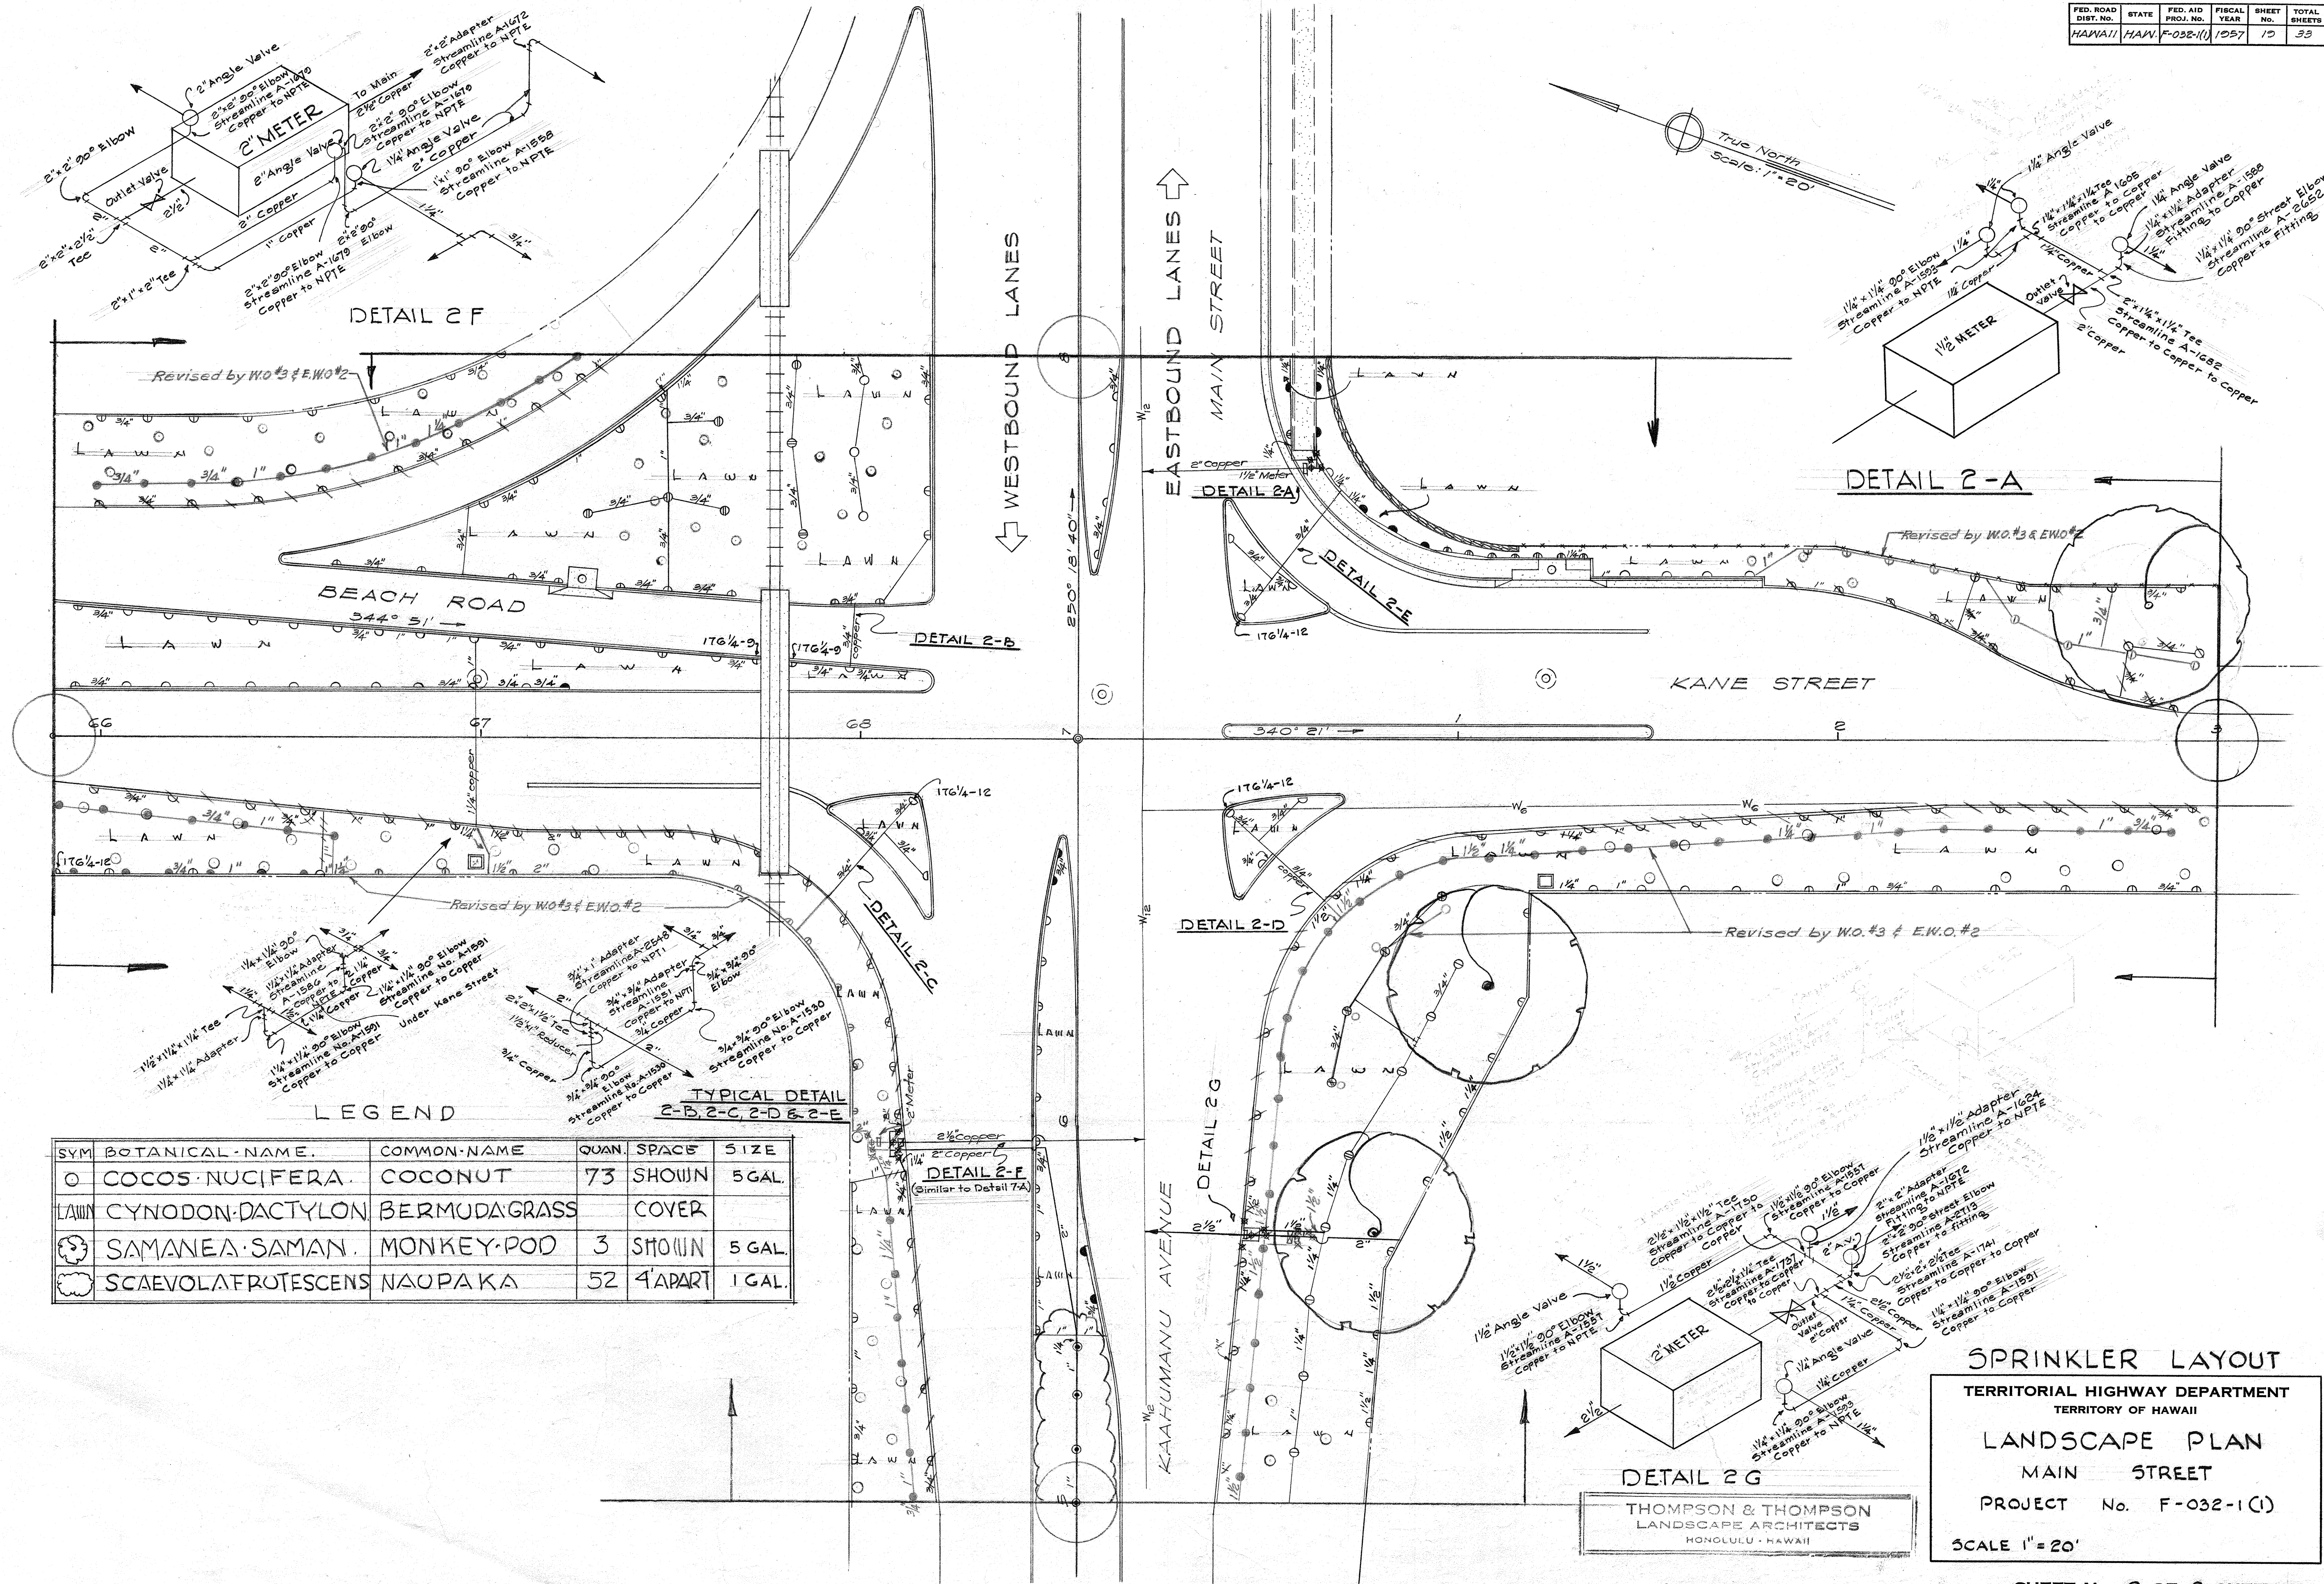

SURVEY PLOTTED BY: _____ DATE: _____




ORIGINAL PLAN: _____

TRACED BY: _____

NOTE BOOK: _____

QUANTITIES CHECKED BY: _____

CHECKED BY: _____

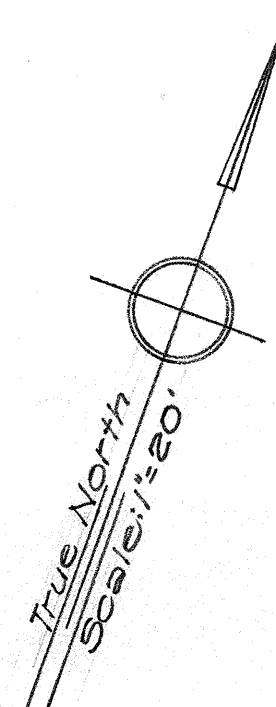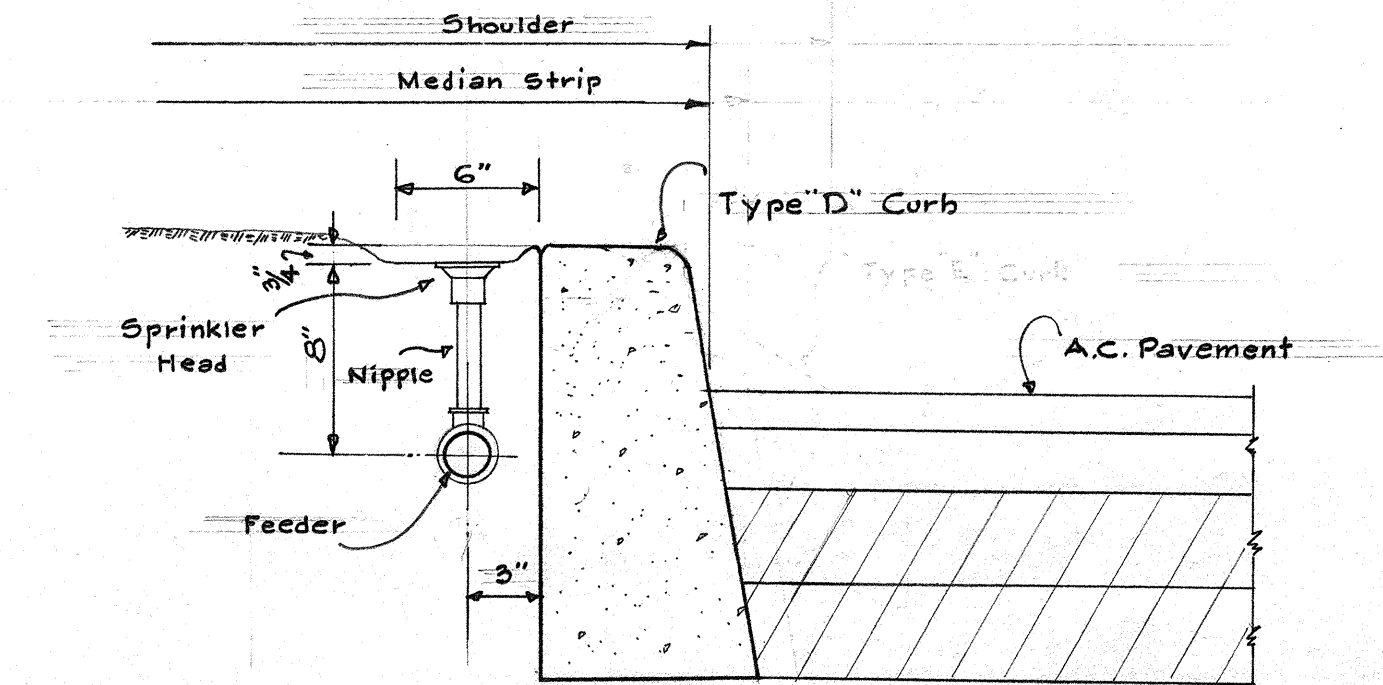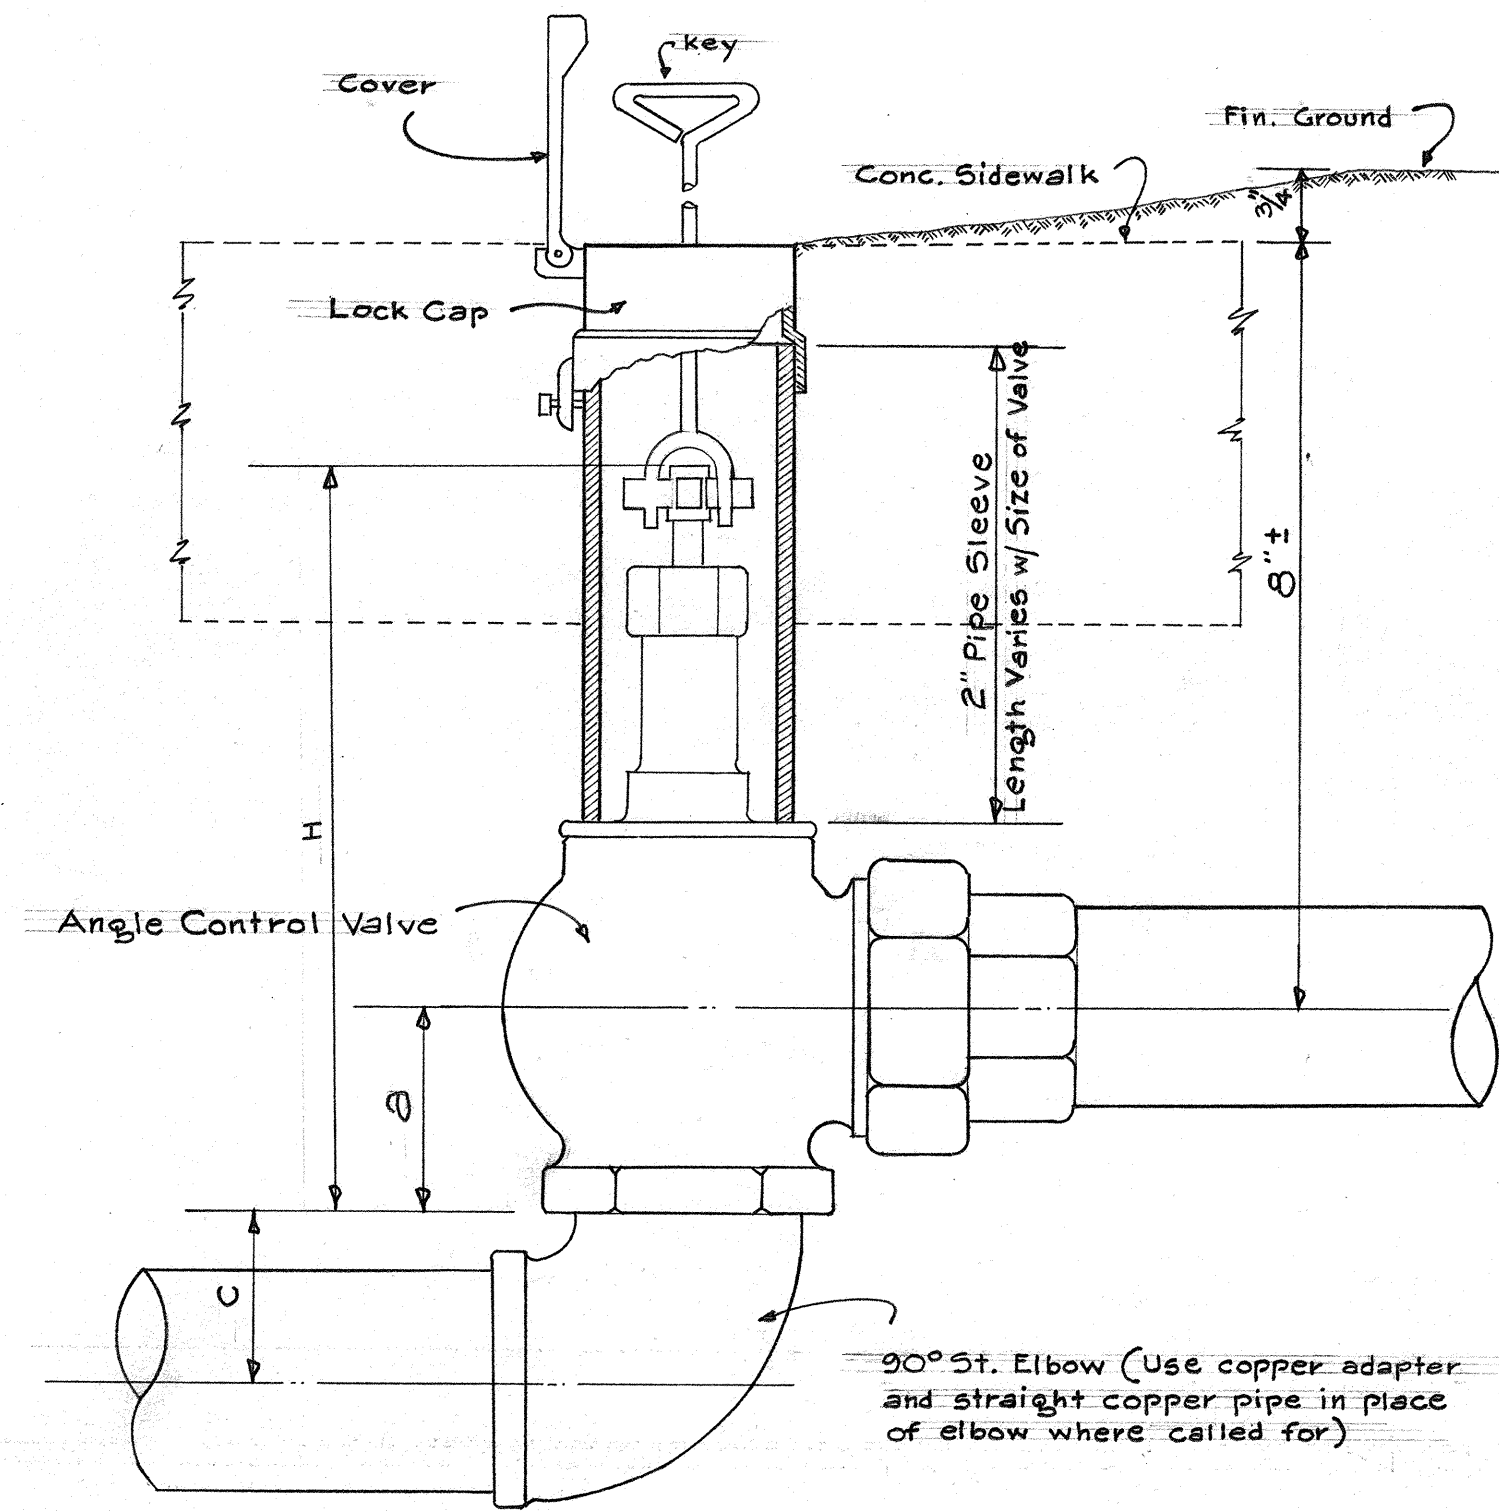


TYPICAL DETAIL OF SPRINKLER @ CONC. CURBS

Scale 1 1/2" = 1'-0"


DETAIL OF ANGLE CONTROL VALVE HOUSING & CAP

Not to Scale

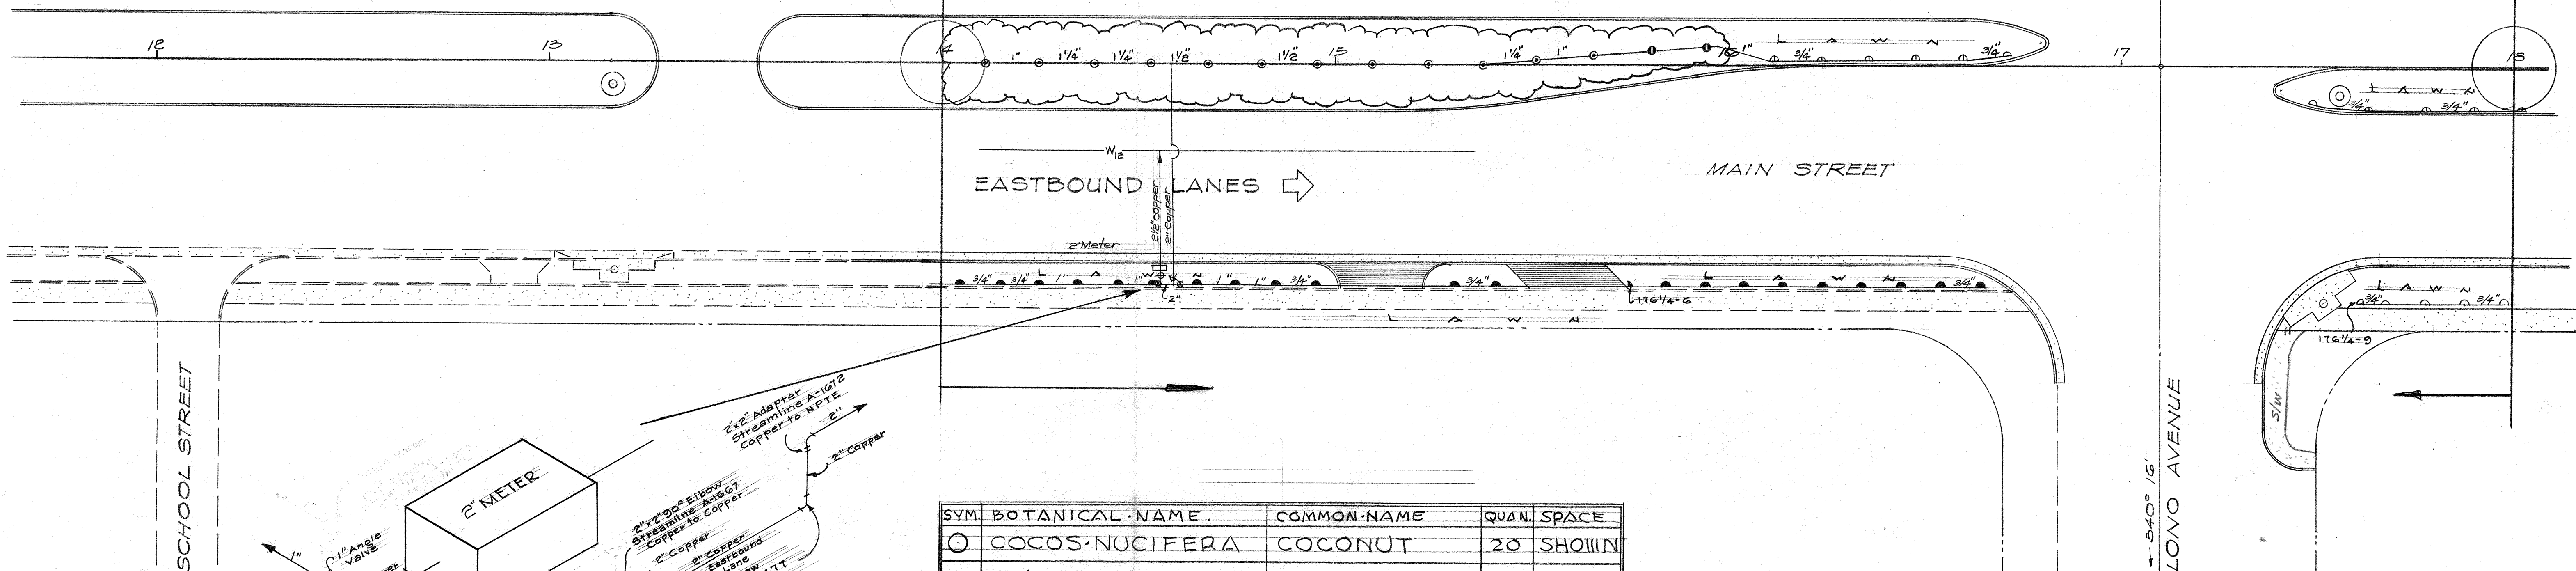


DESIGNED BY	DATE
DRAWN BY	
CHECKED BY	
QUANTITIES CHECKED BY	
NOTE BOOK NO.	

SYM.	BOTANICAL NAME	COMMON NAME	QUAN.	SPACE
○	COCOS-NUCIFERA	COCONUT	20	SHOWIN
LAWN	CYNODON-DACTYLON	BERMUDA GRASS		COVER
■	SCAEVOLA-FRUTESCENS	NAUPAKA	200	4' APART

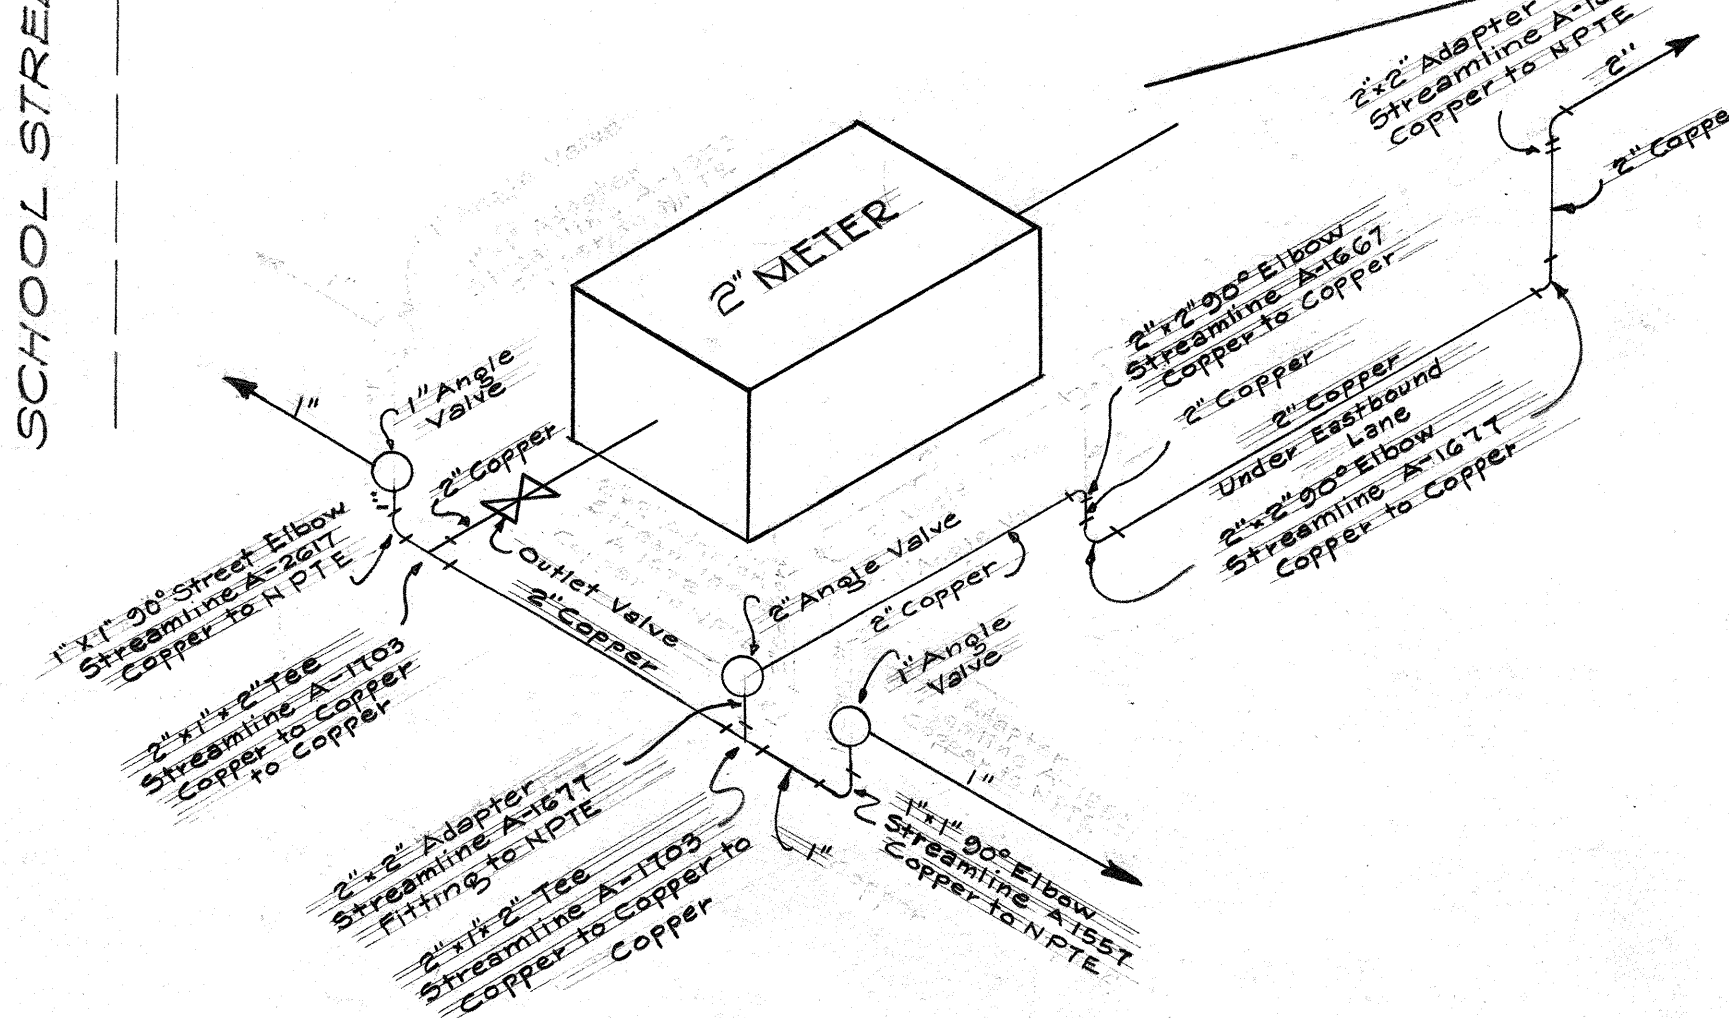


THOMPSON & THOMPSON
LANDSCAPE ARCHITECTS
HONOLULU - HAWAII

SPRINKLER LAYOUT
TERRITORIAL HIGHWAY DEPARTMENT
TERRITORY OF HAWAII
LANDSCAPE PLAN
MAIN STREET
PROJECT No. F-032-1(1)
SCALE 1" = 20'

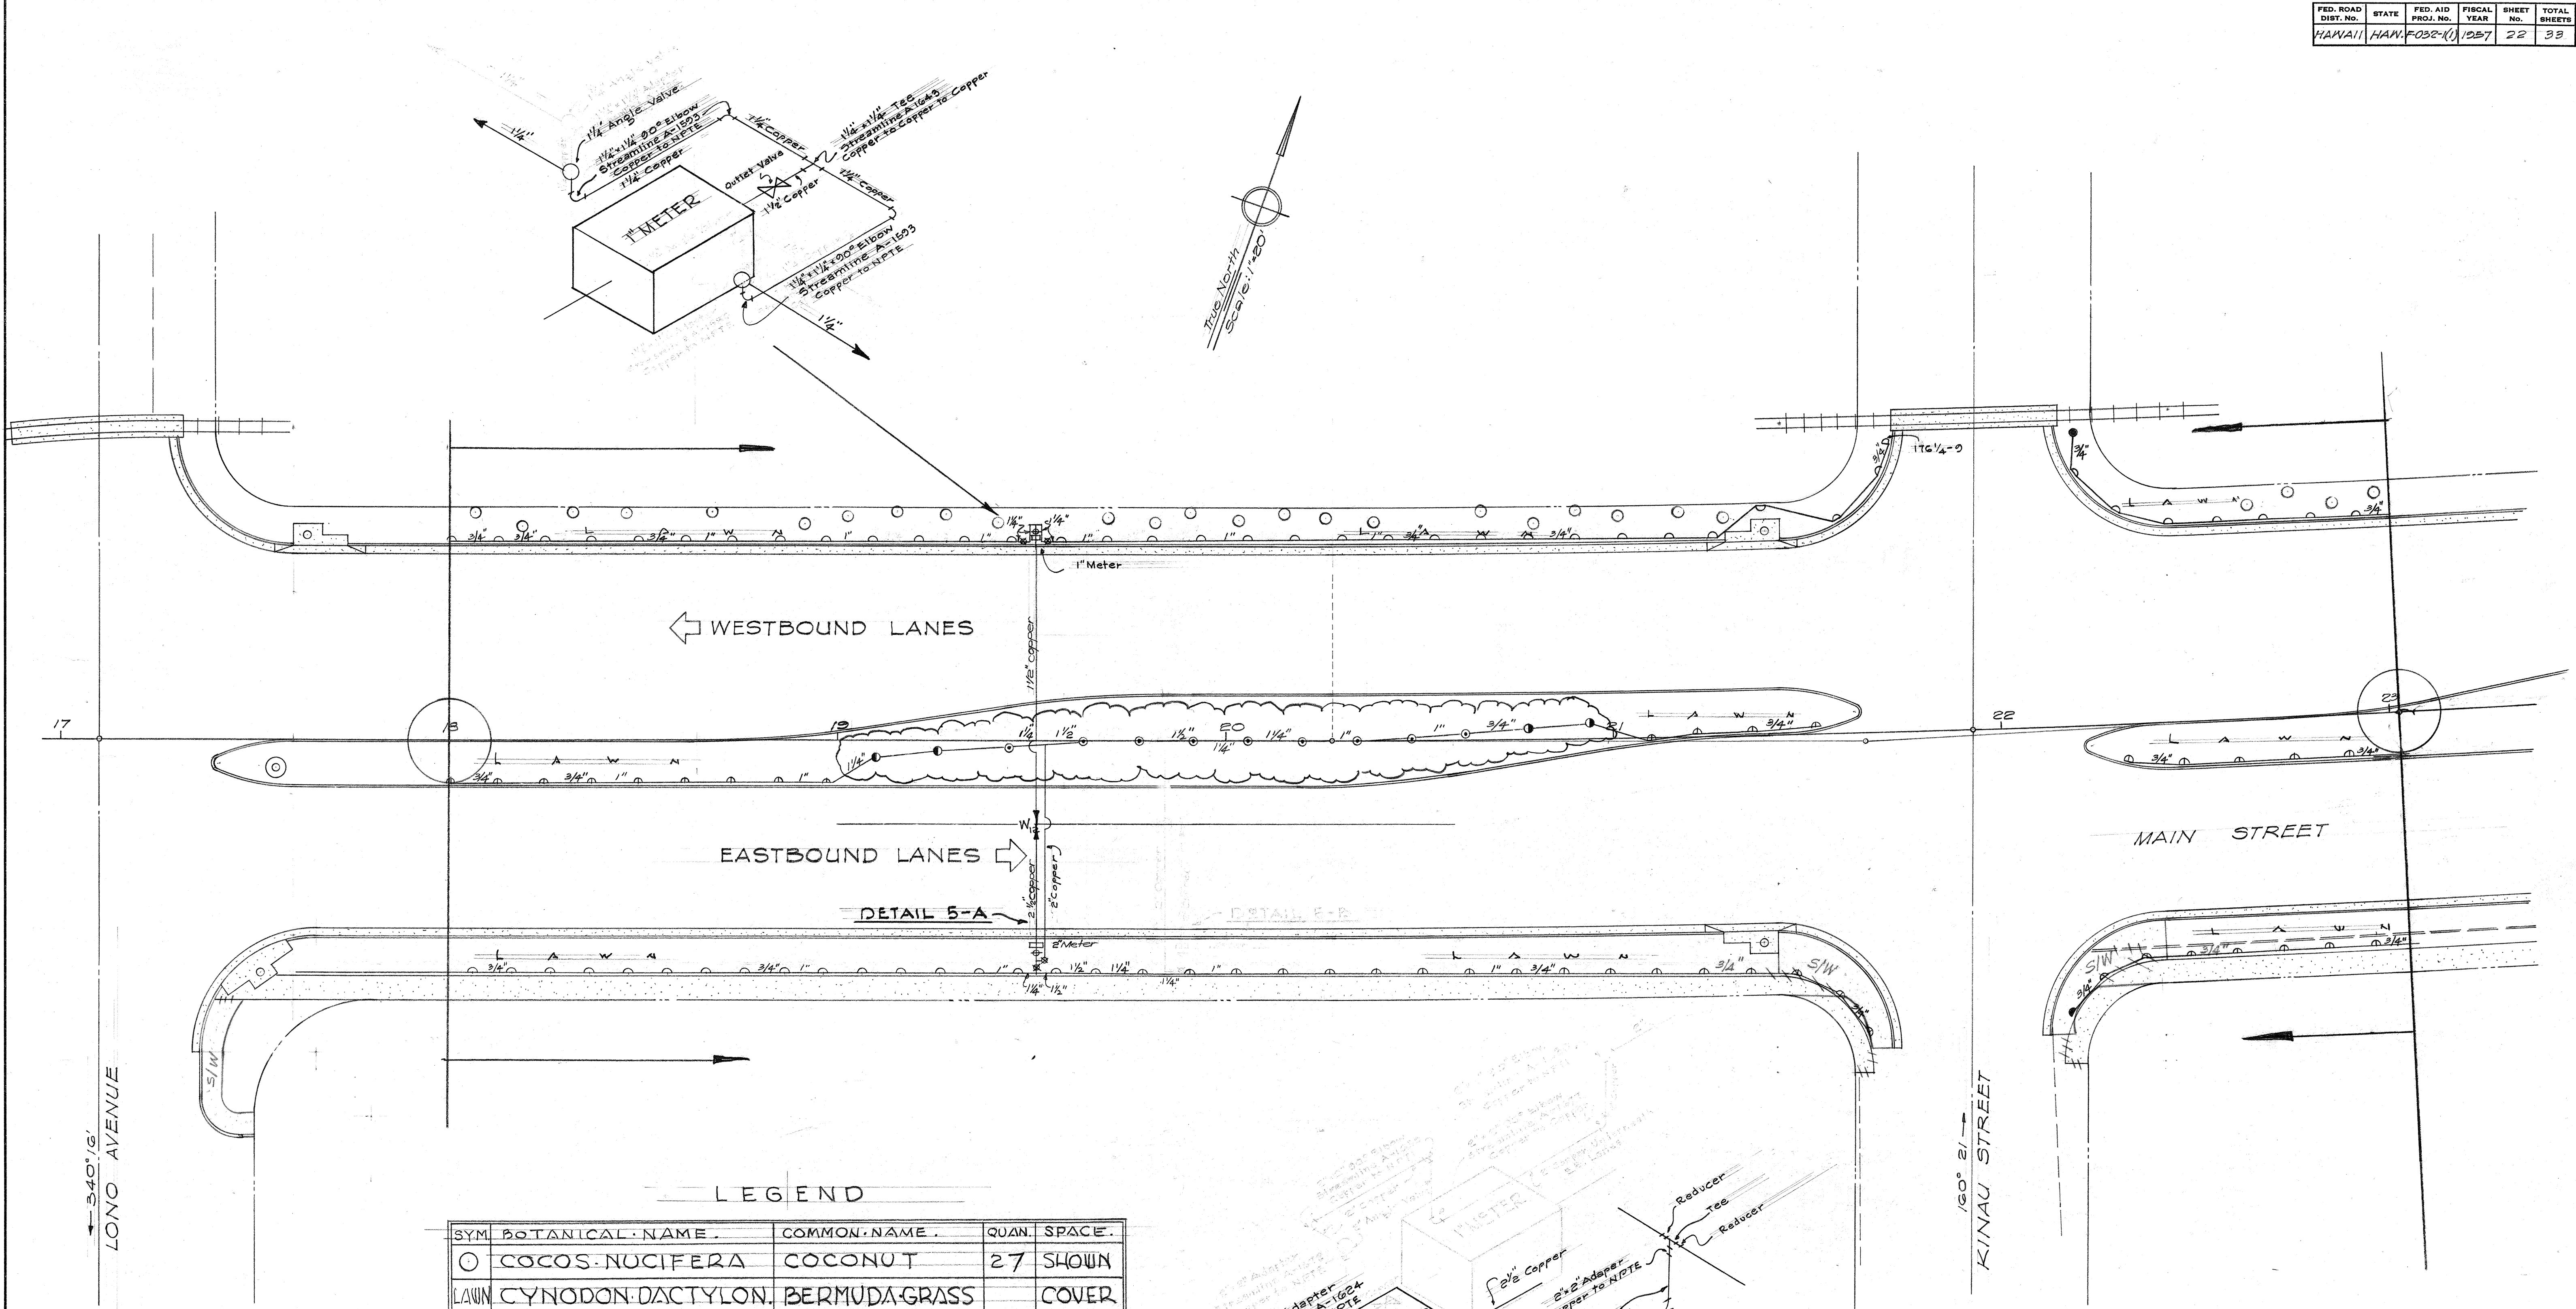

LEGEND

SYM.	BOTANICAL NAME	COMMON NAME	QUAN.	SPACE
○	COCOS-NUCIFERA	COCONUT	27	SHOWN
LAWN	CYNODON-DACTYLON	BERMUDA-GRASS		COVER
□	SCAEVOLA-FRUTESCENS	NAUPAKA	165	4' APART

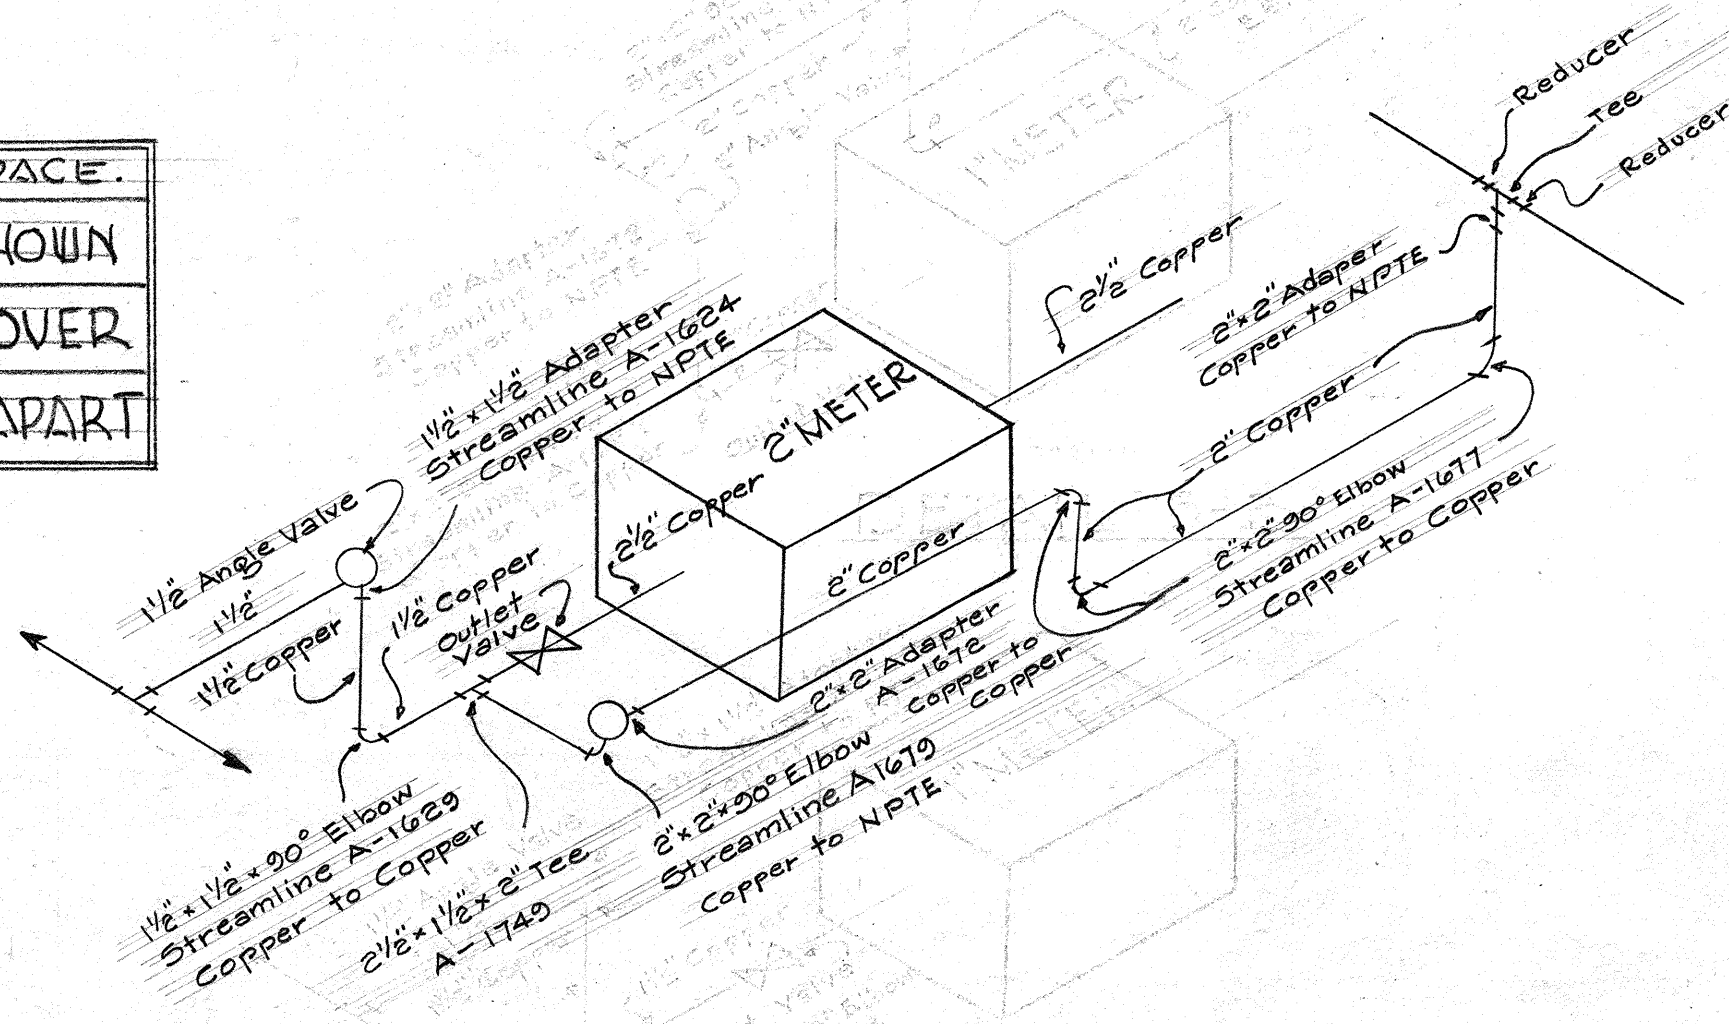

DETAIL 5-A

THOMPSON & THOMPSON
LANDSCAPE ARCHITECTS
HONOLULU - HAWAII

SPRINKLER LAYOUT

TERRITORIAL HIGHWAY DEPARTMENT
TERRITORY OF HAWAII

LANDSCAPE PLAN

MAIN STREET


PROJ. NO. F-032-1(1)

Scale: 1" = 20'



SHEET No. 5 OF 8 SHEETS

5909.22


DATE: _____
DRAWN BY: _____
CHECKED BY: _____
NOTE BOOK NO. _____

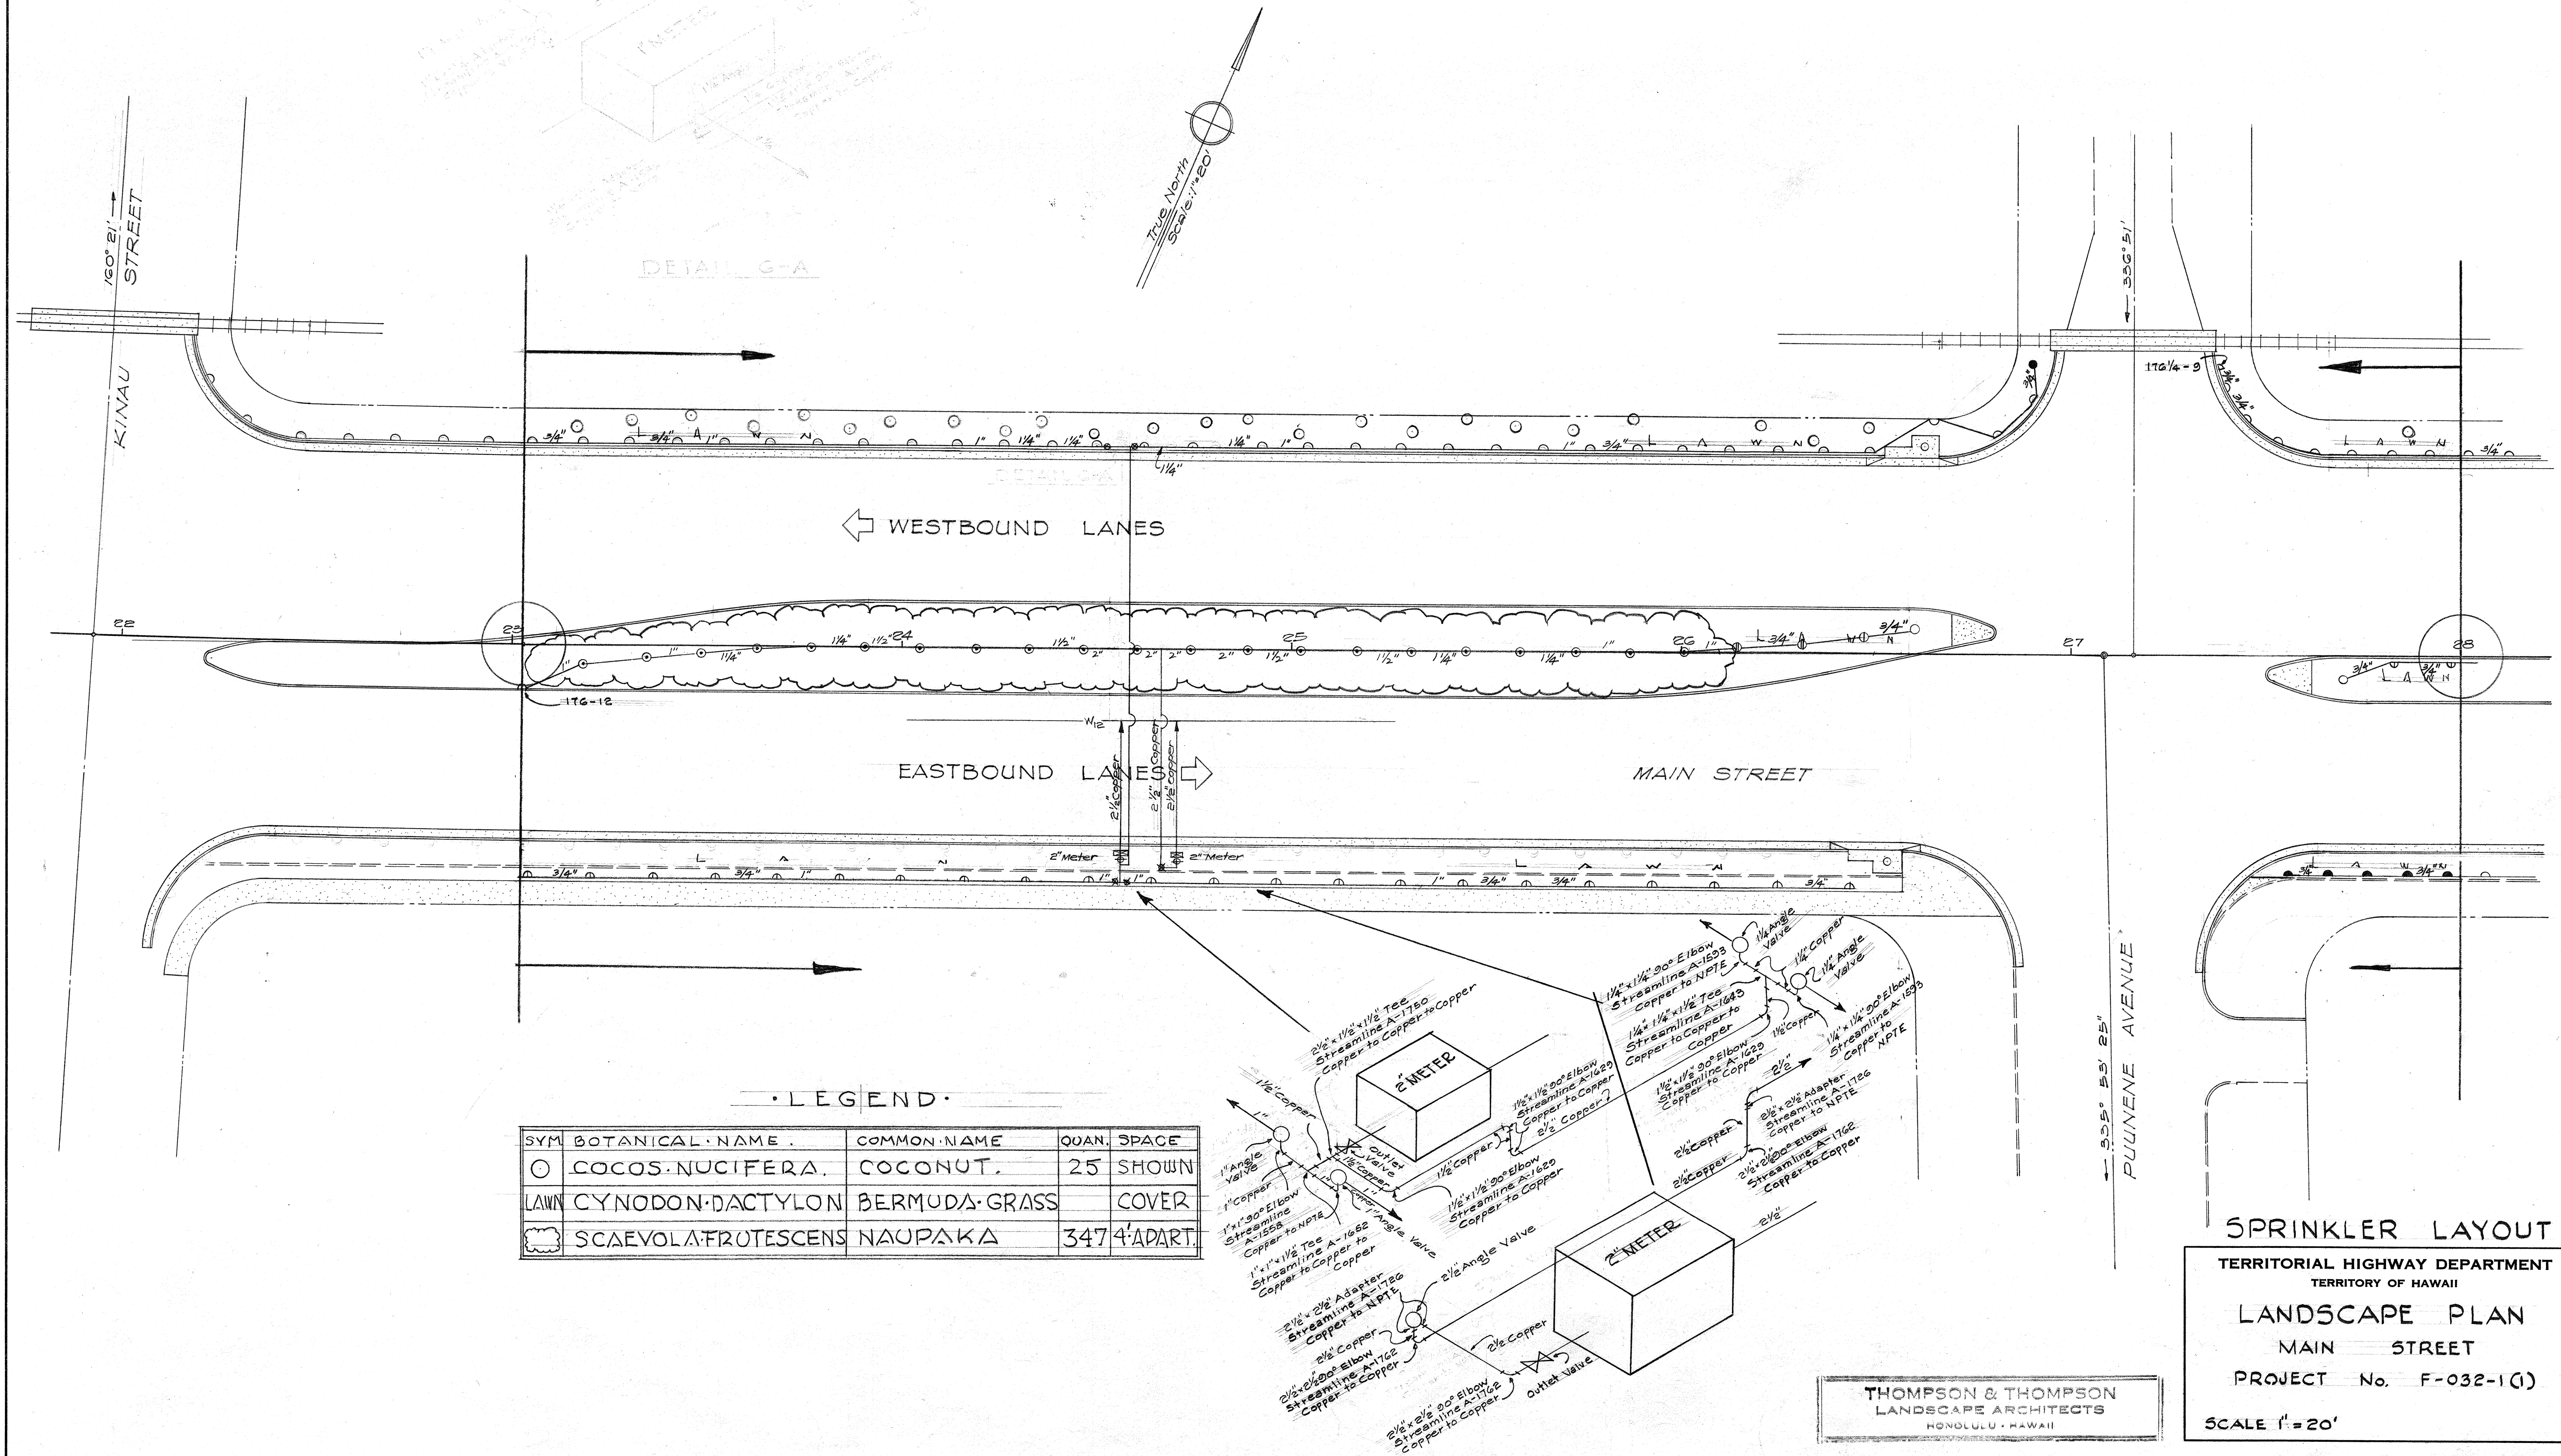

SURVEY PLOTTED BY: DATE: _____
 DRAWN BY: _____
 TRACED BY: _____
 QUANTITIES CHECKED BY: _____
 CHECKED BY: _____
 ORIGINAL PLAN No. _____

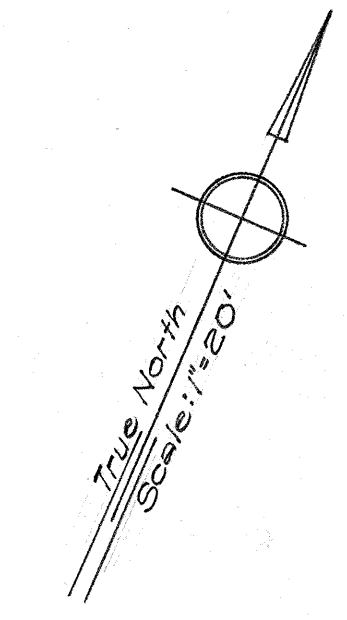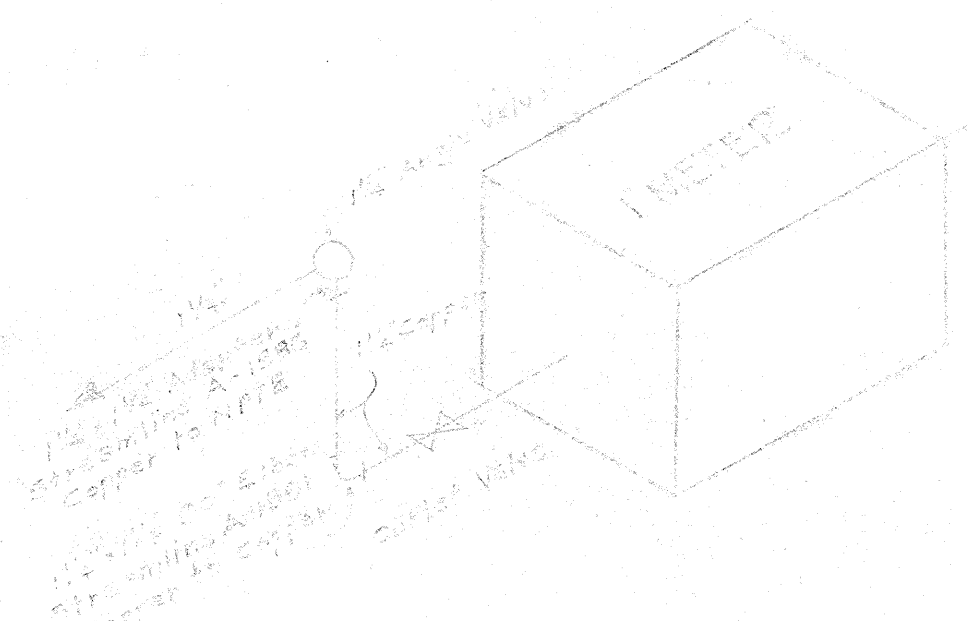


DETAIL 7-A

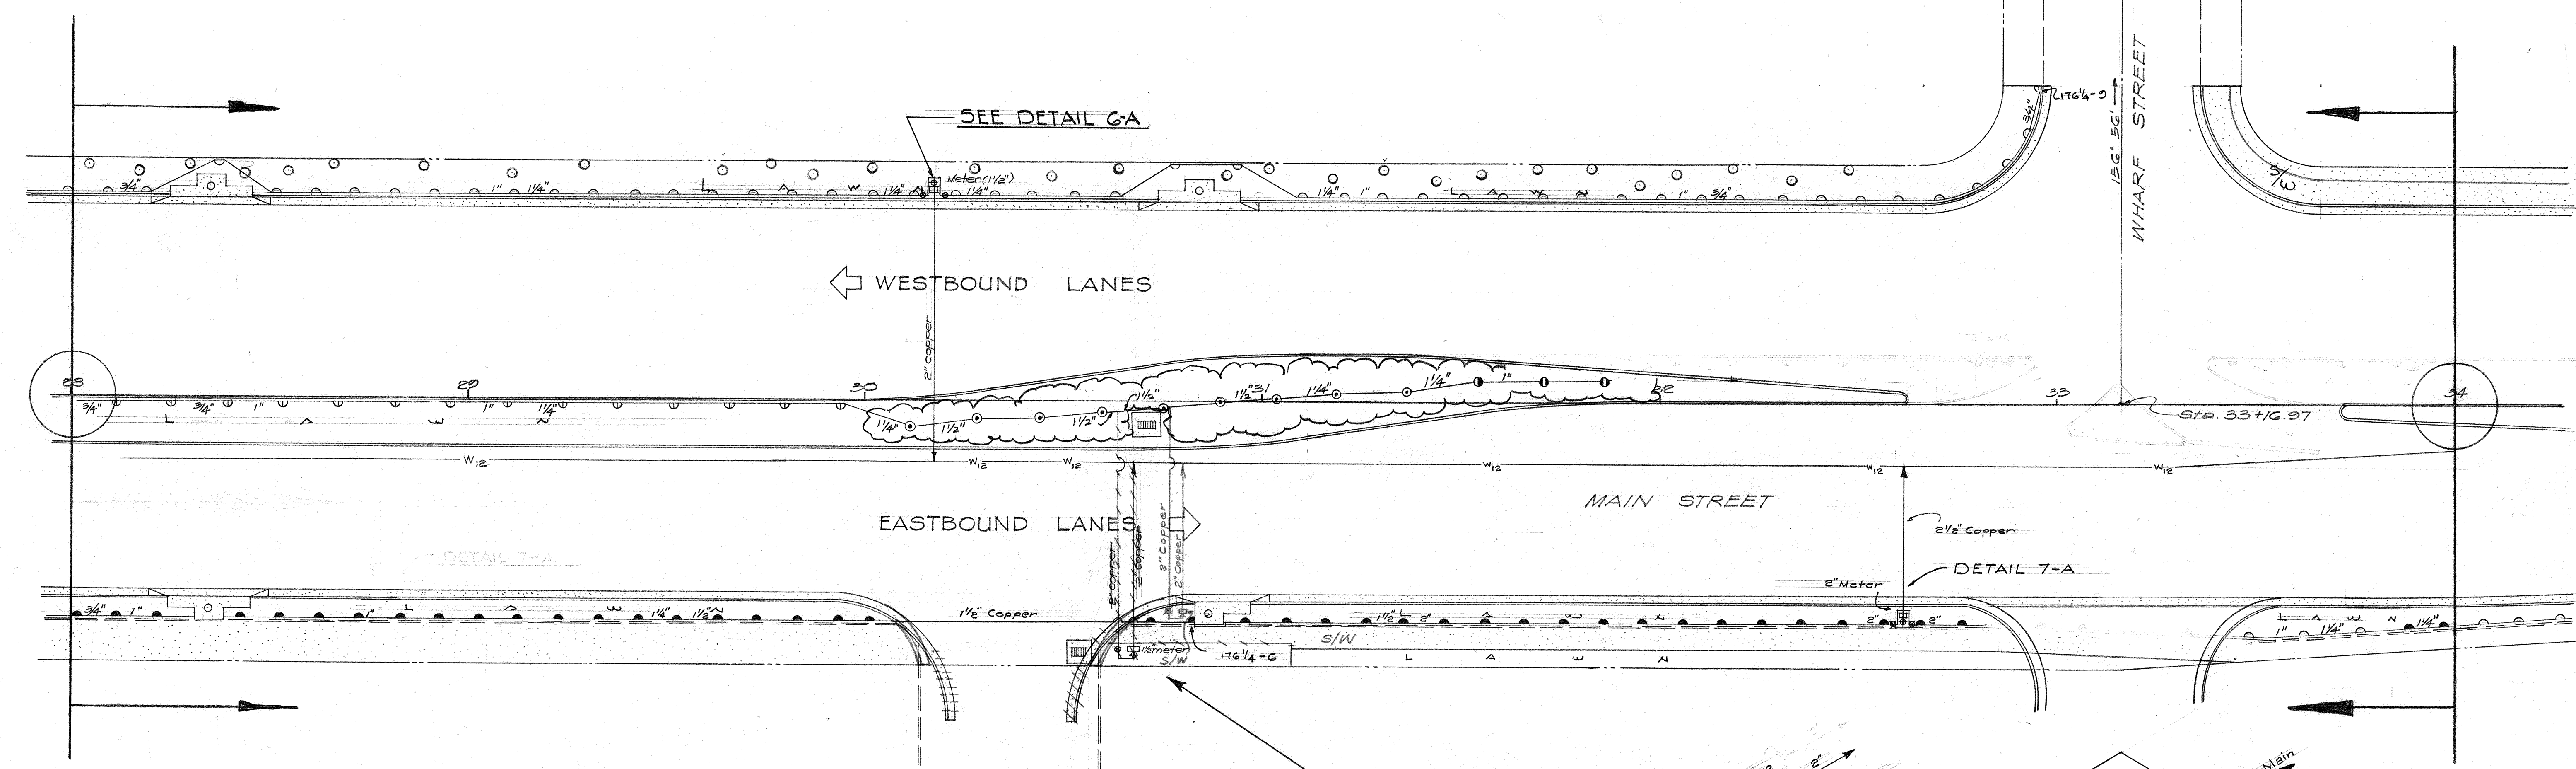

LEGEND

SYM.	BOTANICAL NAME	COMMON NAME	QUAN.	SPACE
○	COCOS-NUCIFERA	COCONUT	29	SHOWN
LAWN	CYNODON-DACTYLON	BERMUDA-GRASS		COVER
■	SCAEVOLA-FRUTESCENS	NAUPAKA	155	4' APART

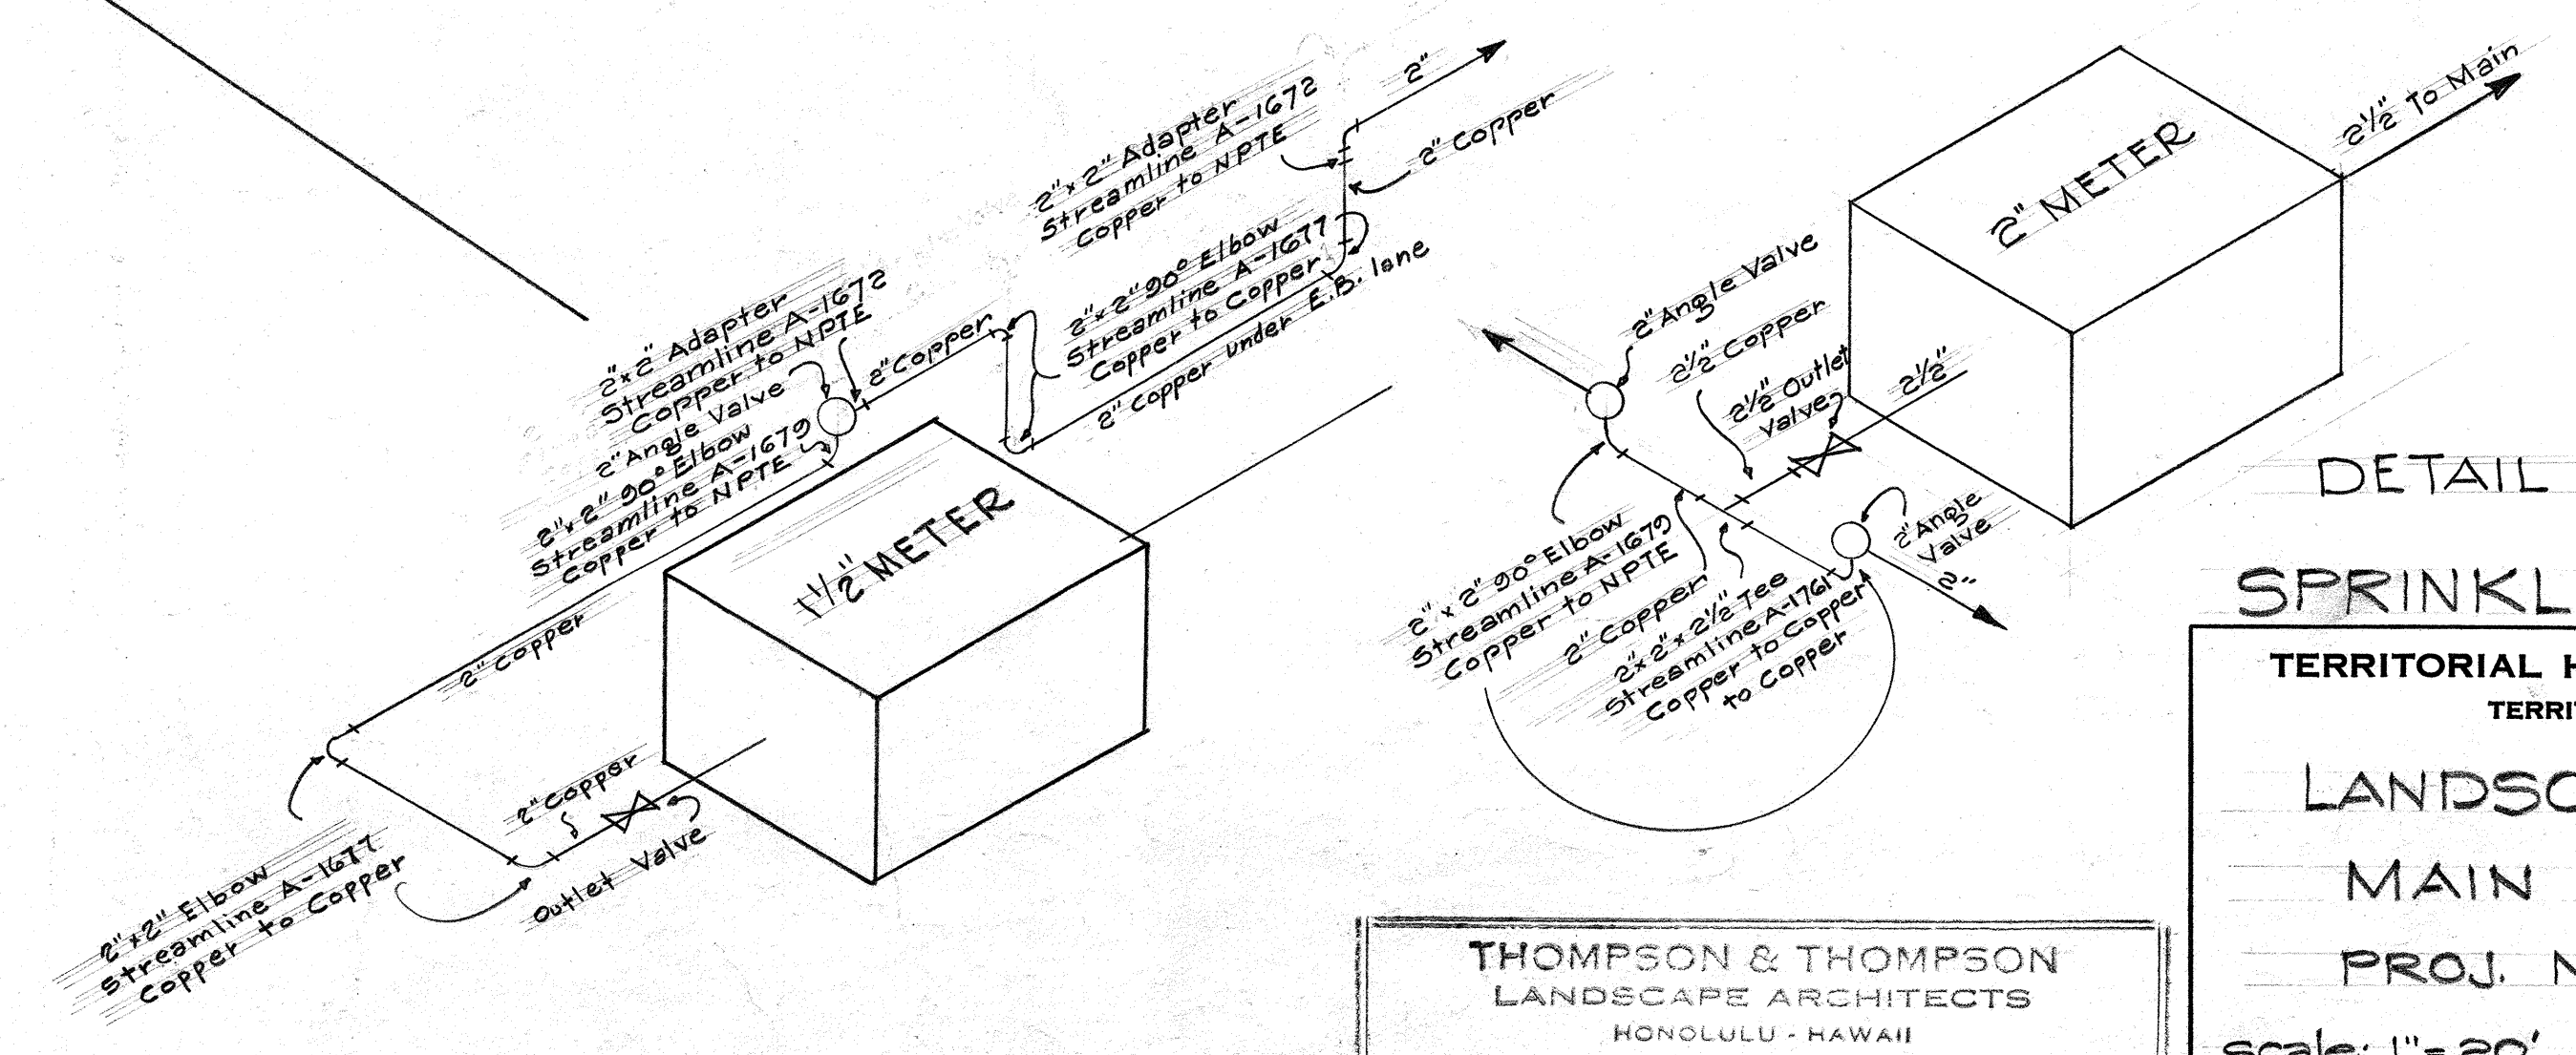

DETAIL 7-A
SPRINKLER LAYOUT

TERRITORIAL HIGHWAY DEPARTMENT
TERRITORY OF HAWAII
LANDSCAPE PLAN
MAIN STREET
PROJ. NO. F-032-10
Scale: 1" = 20'

THOMPSON & THOMPSON
LANDSCAPE ARCHITECTS
HONOLULU - HAWAII

DATE: _____
SURVEY PLOTTED BY: _____
ORIGINAL PLAN NO.: _____
DRAWN BY: _____
NOTE BOOK NO.: _____
QUANTITIES CHECKED BY: _____
CHECKED BY: _____



COCOS-NUCIFERA	COCONUT	278
SCAEVOLA-FRUTESCENS	NAUPAKA	1569
SAMANEA-SAMAN	MONKEY-POD	4

THOMPSON & THOMPSON
LANDSCAPE ARCHITECTS
HONOLULU • HAWAII