



INDEX TO DRAWINGS	
SHEET NO.	DESCRIPTION
1	TITLE SHEET
2	PLANTING PLAN 1
3	PLANTING PLAN 2
4	PLANT LIST, NOTES & DETAILS
5	DRIP IRRIGATION PLAN 1
6	DRIP IRRIGATION PLAN 2
7	BUBBLER IRRIGATION PLAN 1
8	BUBBLER IRRIGATION PLAN 2
9	IRRIGATION DETAILS
10	IRRIGATION LEGEND, NOTES & DETAILS
11	ELECTRICAL PLAN

STATE OF HAWAII
DEPARTMENT OF TRANSPORTATION
HIGHWAYS DIVISION
HONOLULU, HAWAII
"AS-BUILT"
PLANS FOR
KAAHUMANU AVENUE
LANDSCAPE IMPROVEMENTS PHASE I
LONO AVENUE TO HANA HIGHWAY
FEDERAL AID PROJECT NO. STP-032-1(7)
DISTRICT OF WAILUKU
ISLAND OF MAUI

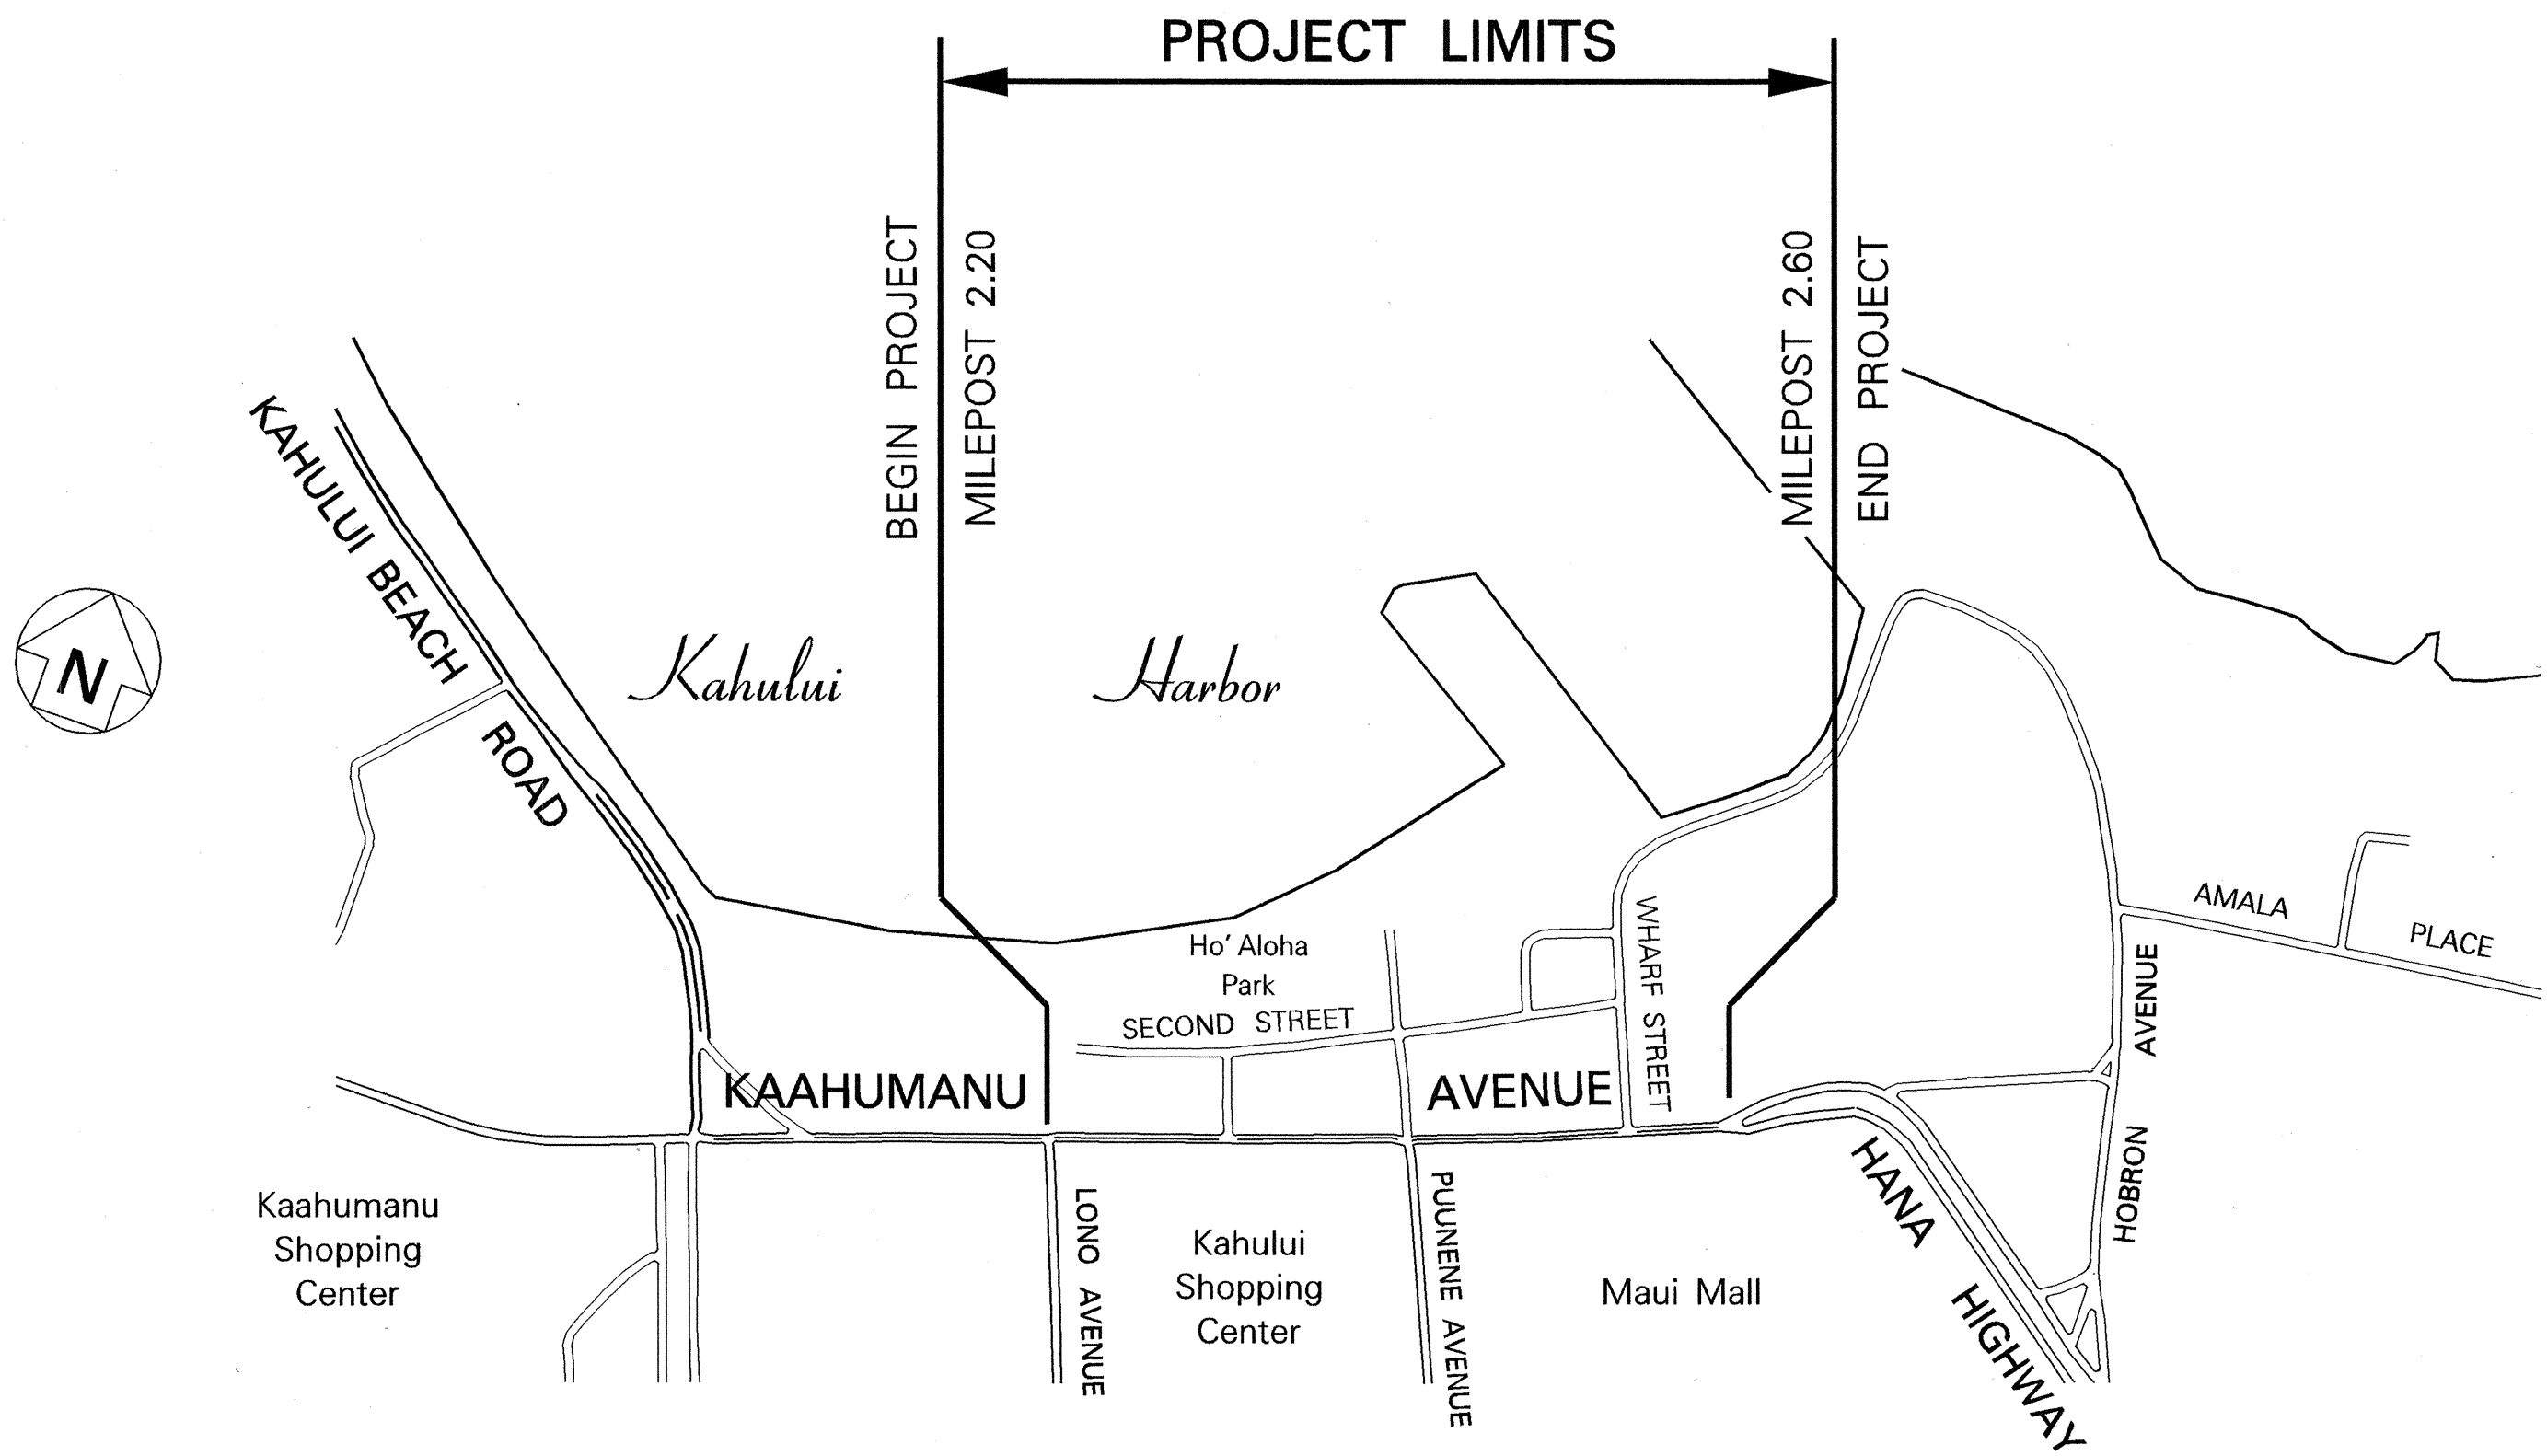


LAYOUT PLAN

GROSS LENGTH OF PROJECT.....0.40 MILES
NET LENGTH OF PROJECT.....0.40 MILES

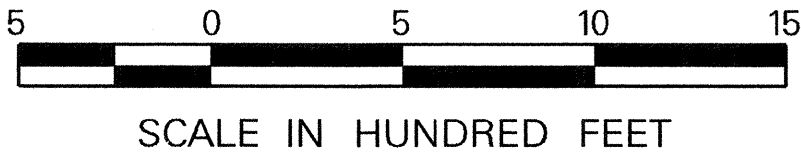

LOCATION OF PROJECT

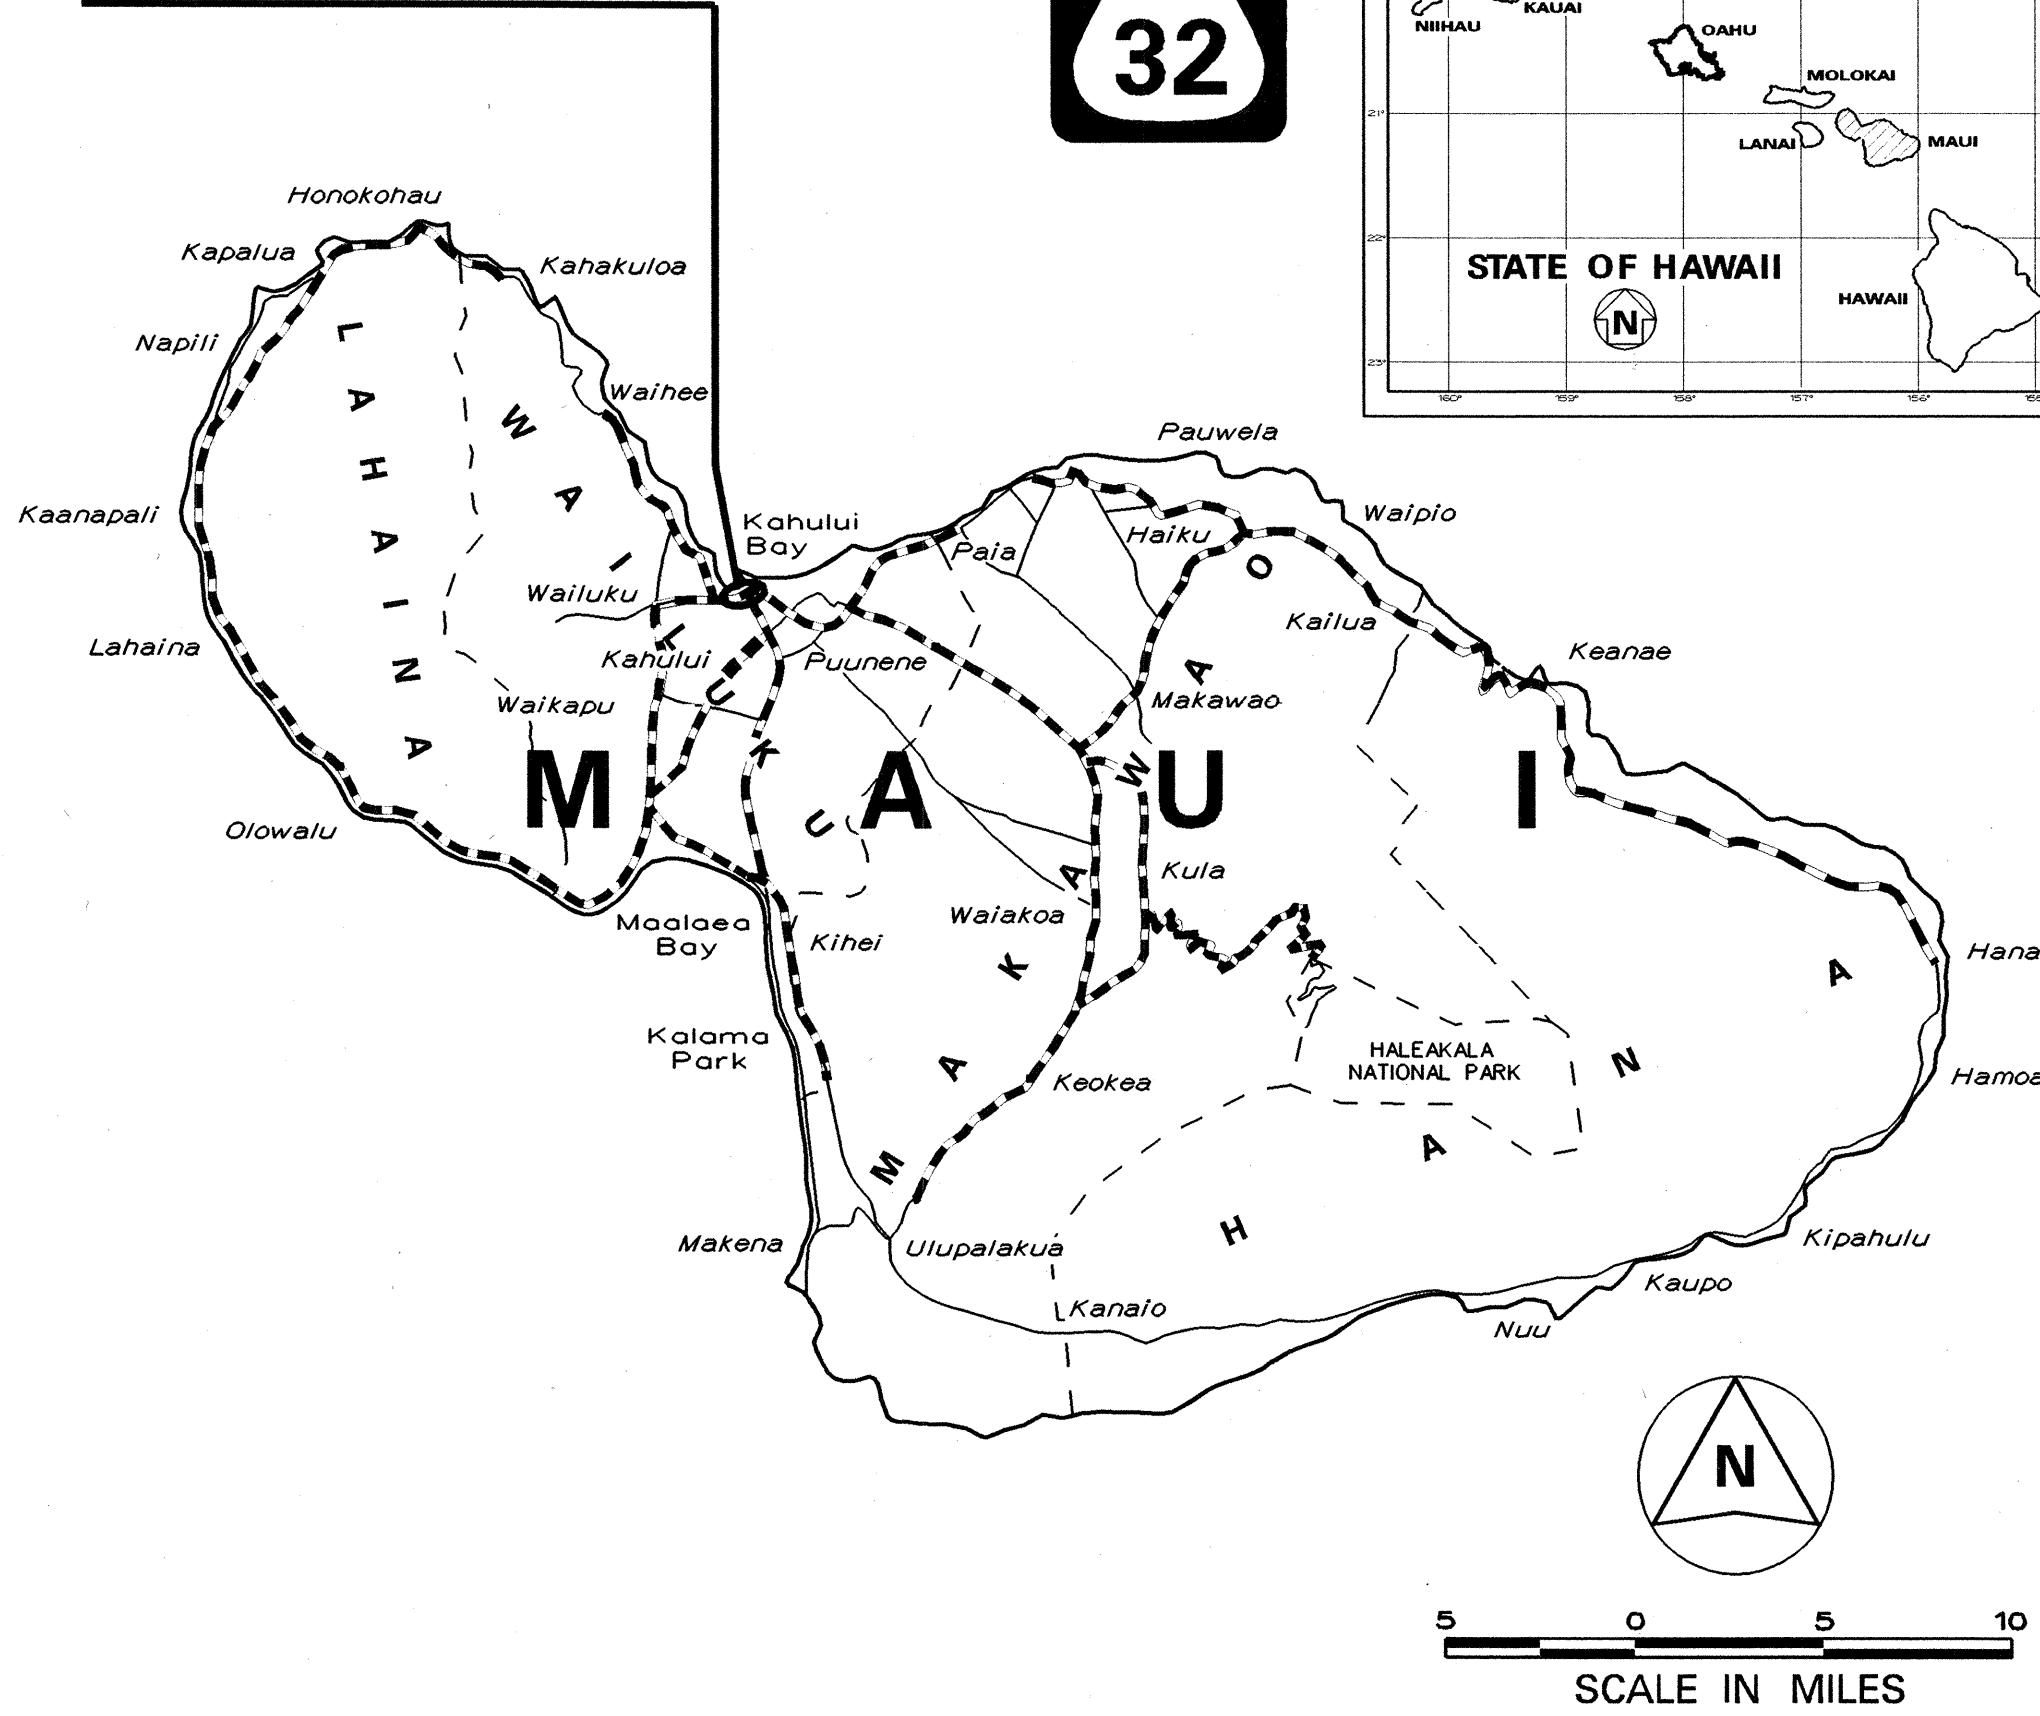

----- FEDERAL AID PROJECTS PREVIOUSLY CONSTRUCTED
OR UNDER CONSTRUCTION

MILE POST 2.20 TO MILE POST 2.60

CHANGES MADE DURING CONSTRUCTION HAVE BEEN
INCORPORATED ON THESE PLANS. CHECK CHANGES
IN THE CROSS SECTIONAL QUANTITIES. FOR
ACTUAL QUANTITIES, REFER TO PROJECT LOGS
AND/OR COMPUTER DATA.
Charles A. Anderson *Charles A. Anderson* *8/25/01*
RESIDENT ENGINEER DATE

DESIGN DESIGNATION

ADT (1998).....48,900
ADT (2018).....62,400
DHV5,370
D60/40
T242.5 %
V45 M.P.H.

DEPARTMENT OF TRANSPORTATION STATE OF HAWAII	
APPROVED:	
<i>Robert M. Kunda</i> for DIR. OF TRANSPORTATION	<i>5-22-01</i> DATE

HVY-M DESIGNED BY ROBERT O. SIAROT 873-3535 MAY, 2001
P.S. & E BY PHONE DATE