

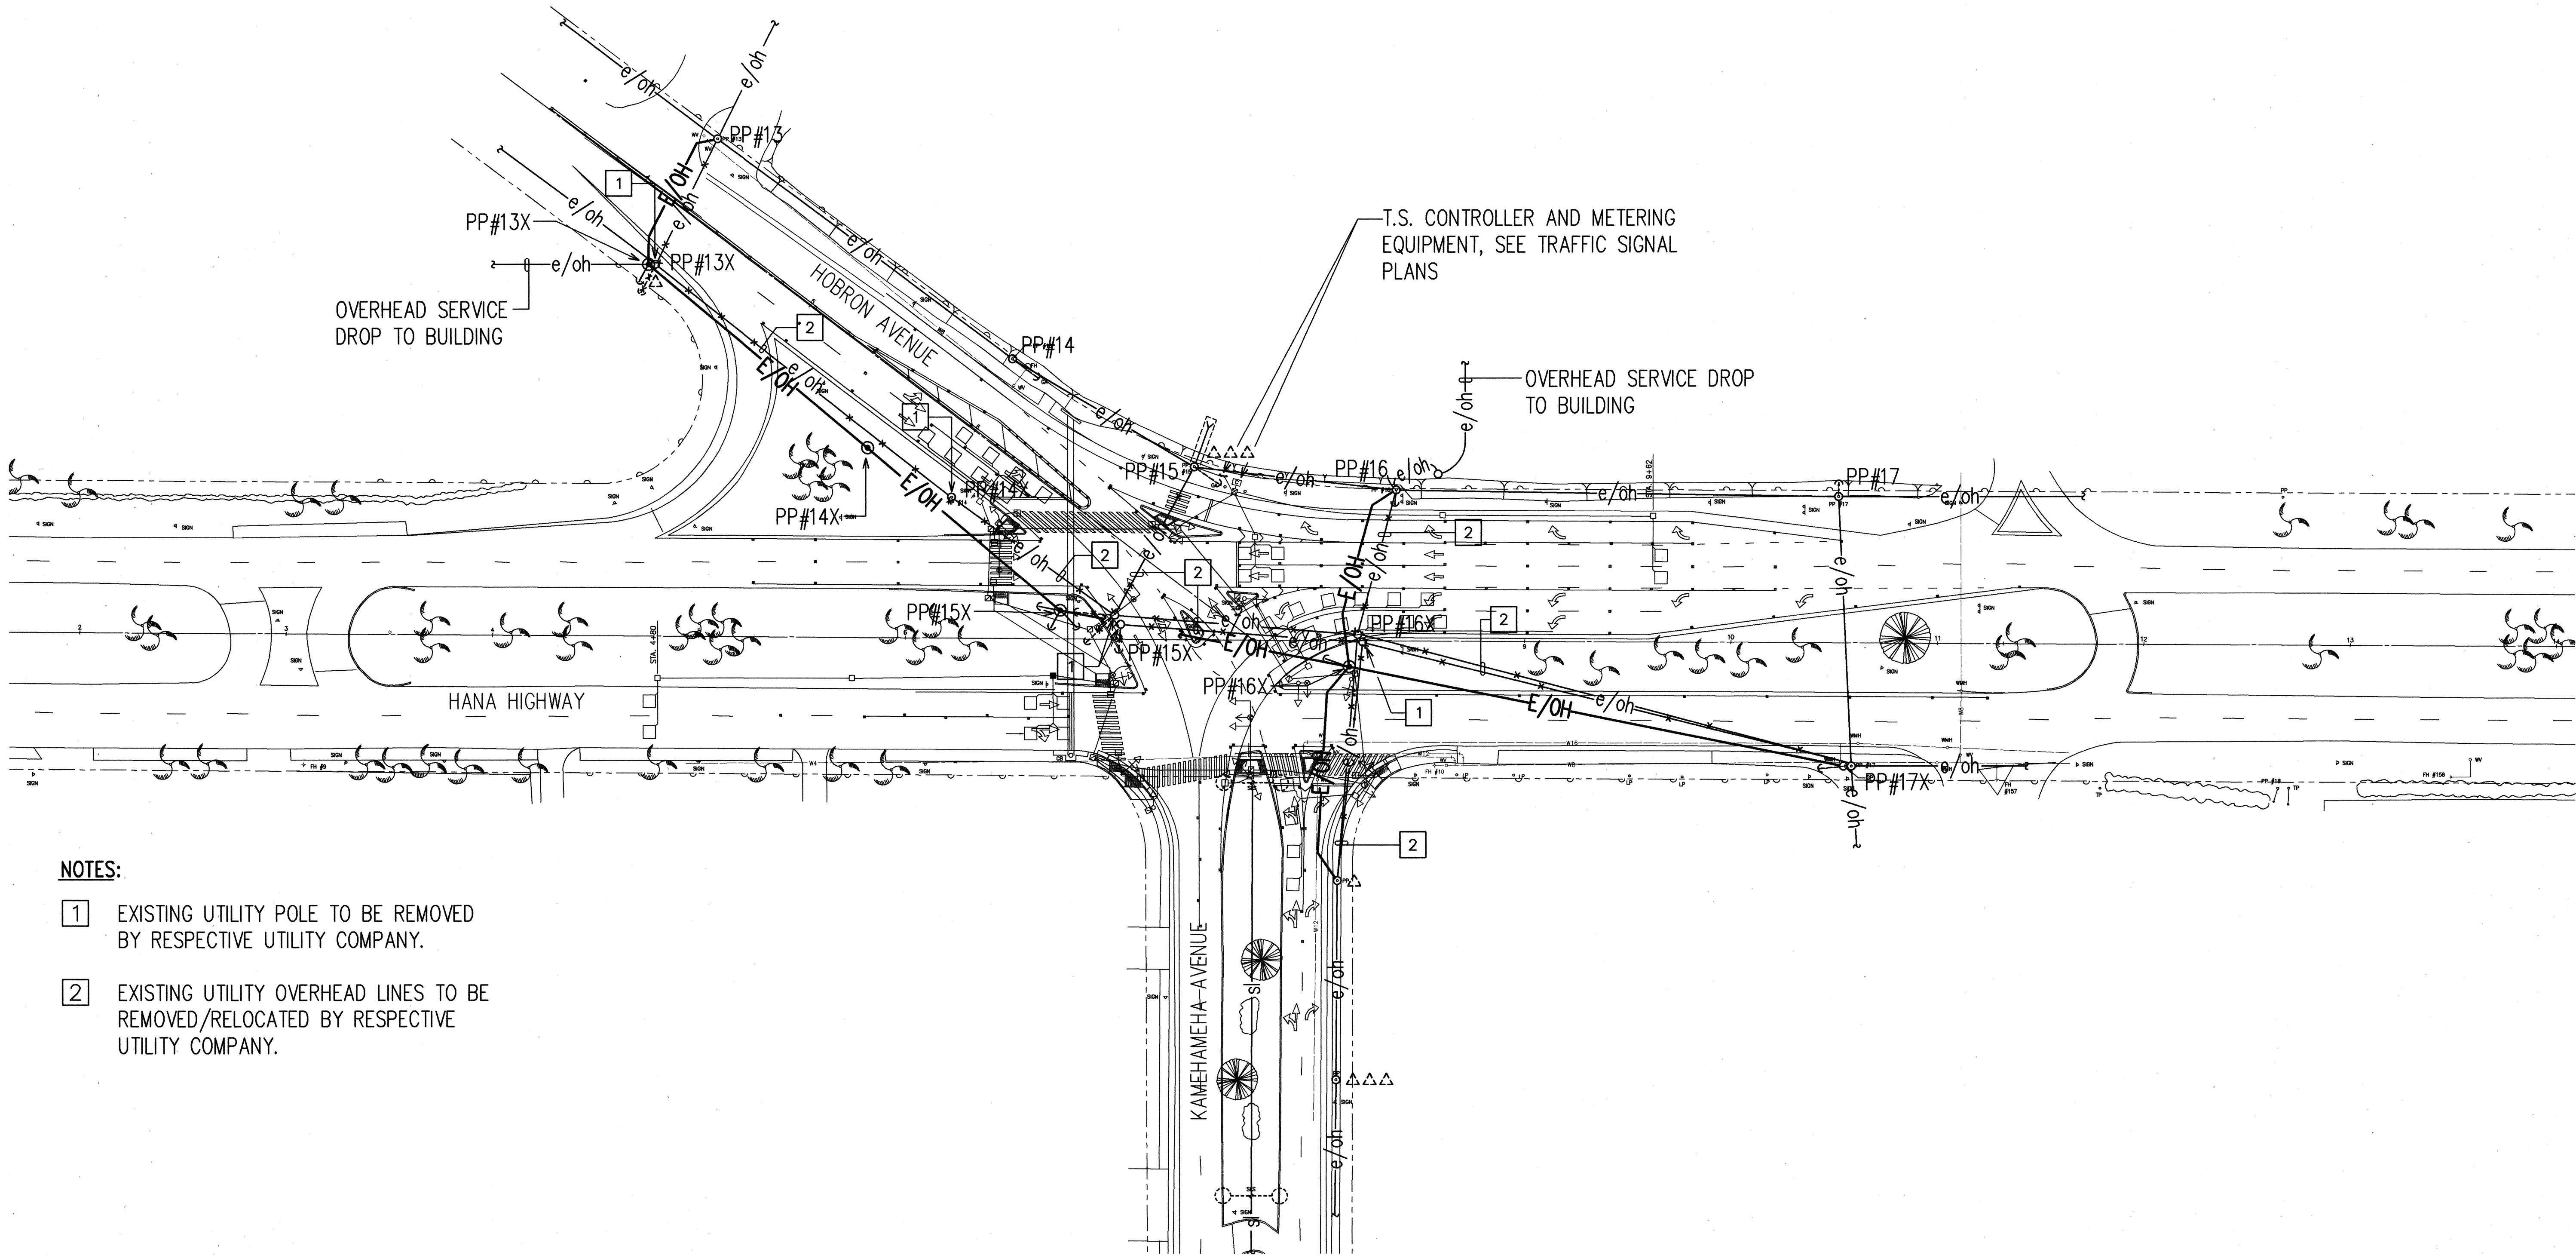


FED. ROAD DIST. NO.	STATE	FED. AID PROJ. NO.	FISCAL YEAR	SHEET NO.	TOTAL SHEETS
HAWAII	HAW.	STP-036-1(12)	2000	27	30

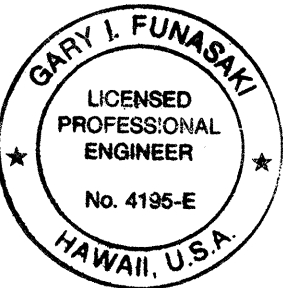

- NOTES:
- 1 EXISTING UTILITY POLE TO BE REMOVED BY RESPECTIVE UTILITY COMPANY.
 - 2 EXISTING UTILITY OVERHEAD LINES TO BE REMOVED/RELOCATED BY RESPECTIVE UTILITY COMPANY.

ELECTRICAL PLAN
SCALE: 1"=40'

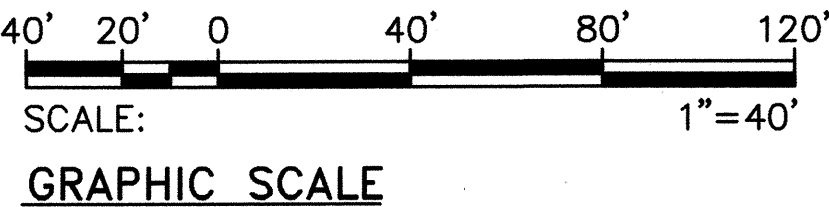

THIS WORK WAS PREPARED BY ME
OR UNDER MY SUPERVISION
21 SEP 1998
Signature

STATE OF HAWAII
DEPARTMENT OF TRANSPORTATION
HIGHWAYS DIVISION
ELECTRICAL PLAN

HANA HIGHWAY
INTERSECTION IMPROVEMENTS
AT HOBRON AVENUE
FAP NO. STP-036-1 (12)

SCALE: AS NOTED DATE: MAR. 1999

SHEET No. E2 OF E5 SHEETS