




FED. ROAD DIST. NO.	STATE	FED. AID PROJ. NO.	FISCAL YEAR	SHEET NO.	TOTAL SHEETS
HAWAII	HAW.	STP-036-1(12)	2000	28	30

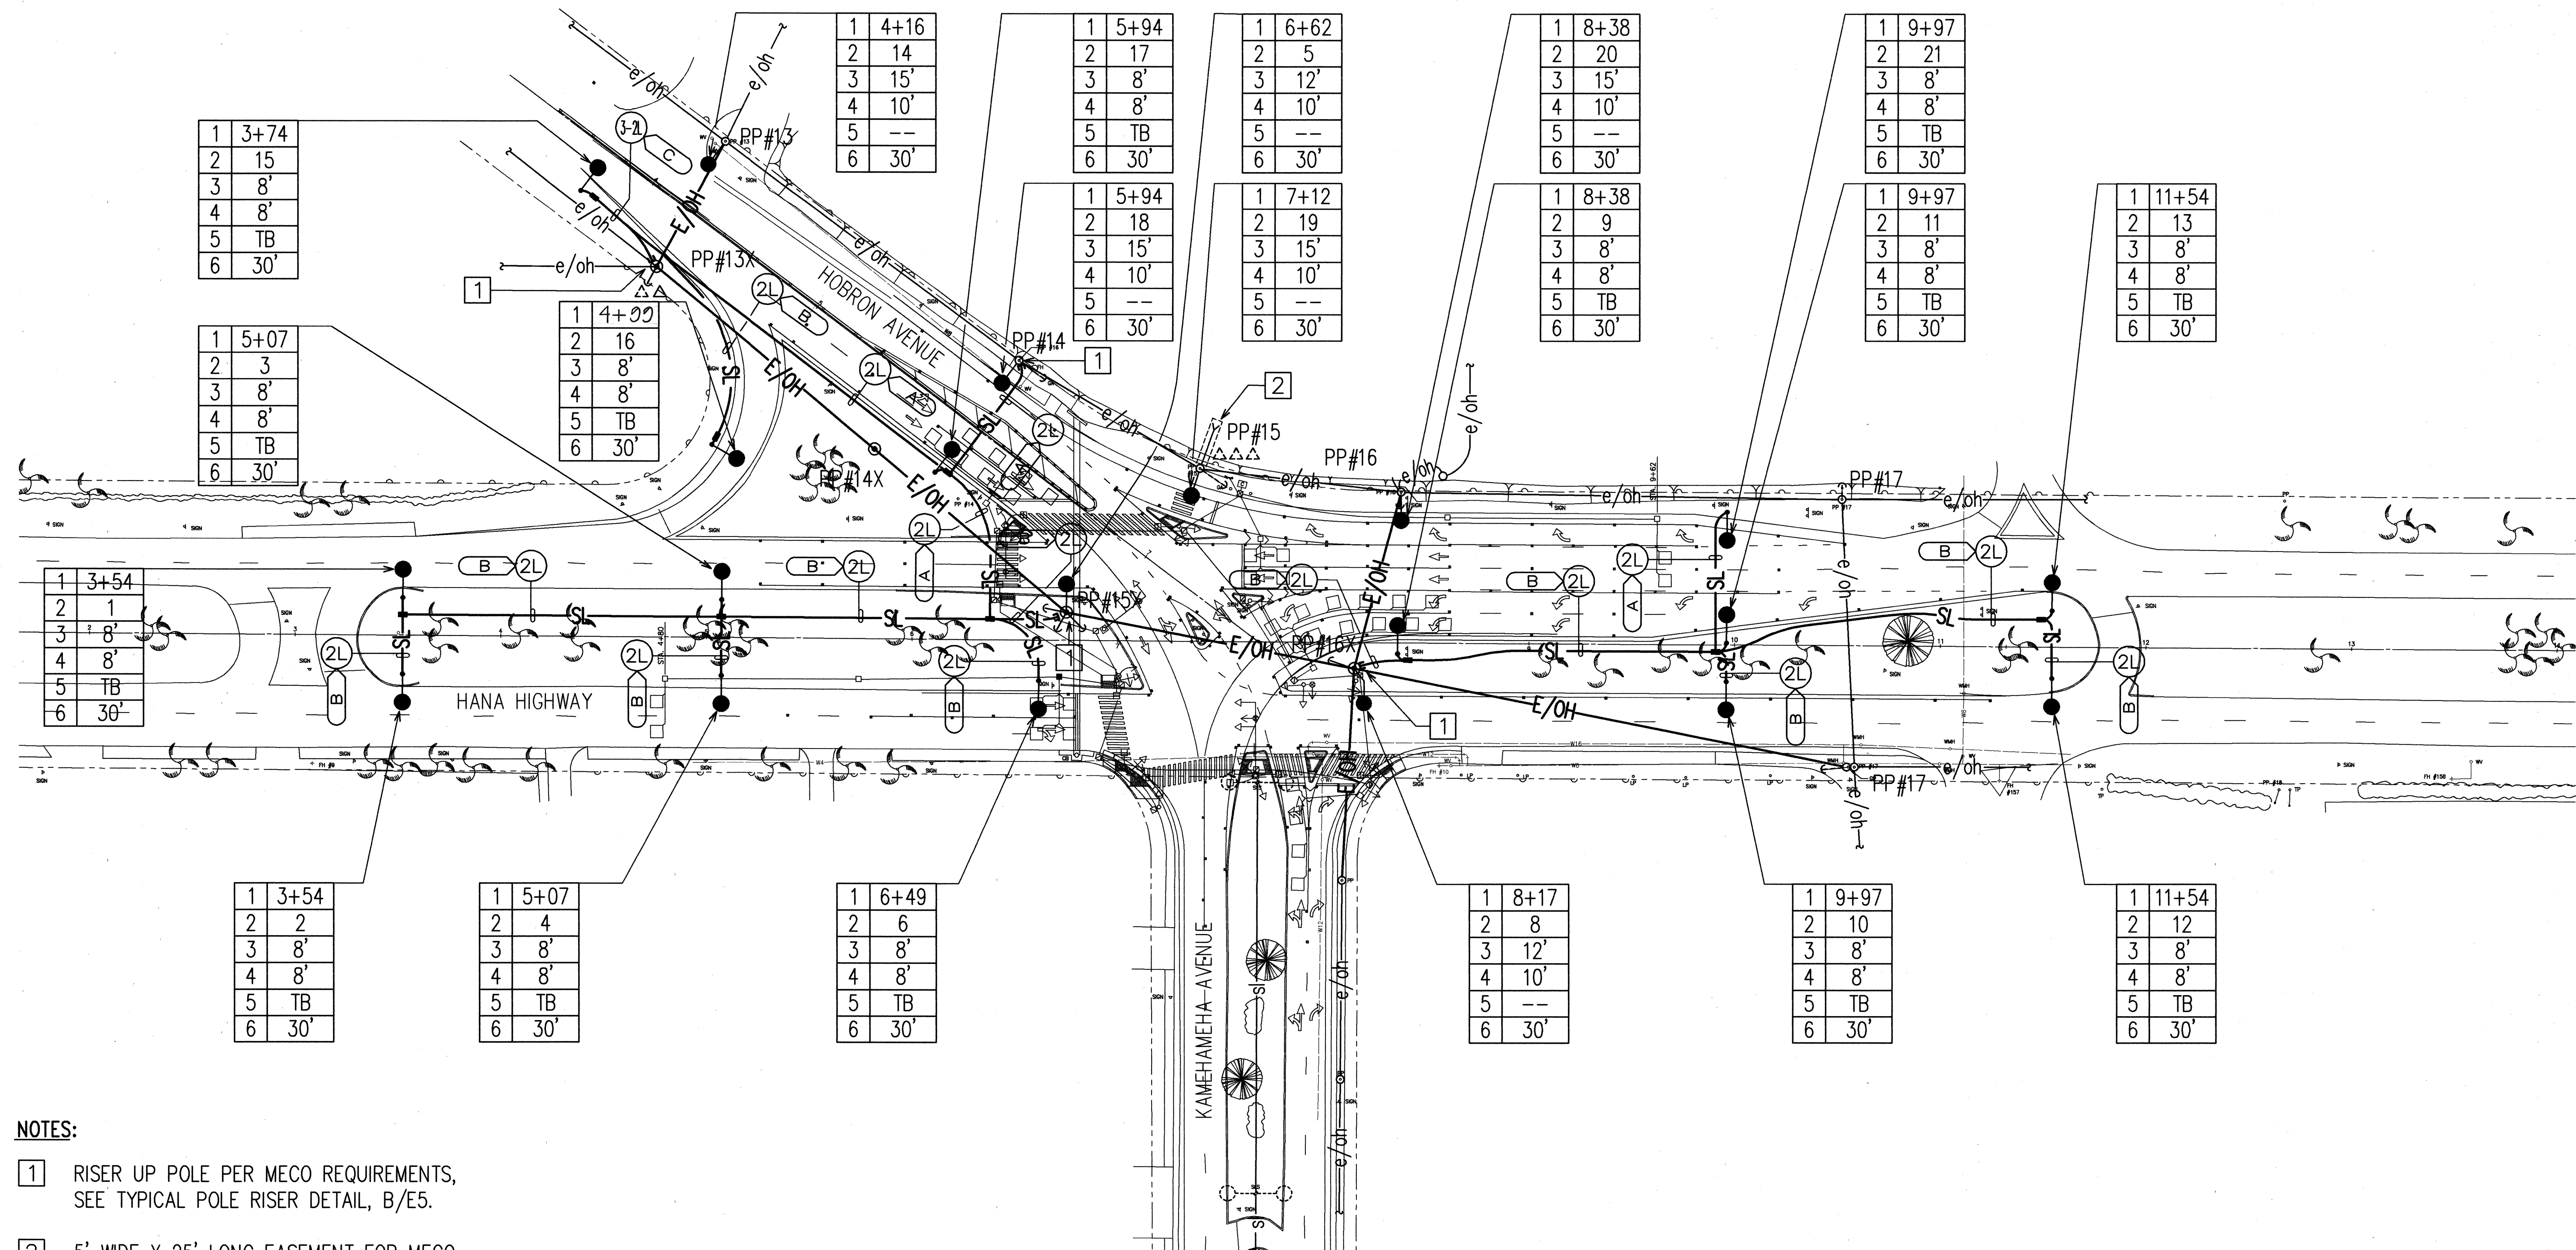

NOTES:

- 1 RISER UP POLE PER MECO REQUIREMENTS, SEE TYPICAL POLE RISER DETAIL, B/E5.
- 2 5' WIDE X 25' LONG EASEMENT FOR MECO PUSH-BRACE POLE.

STREET LIGHTING PLAN
SCALE: 1"=40'

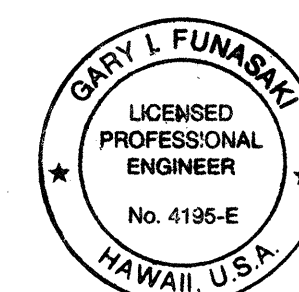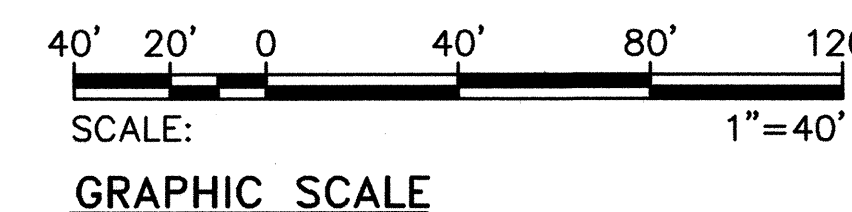

THIS WORK WAS PREPARED BY ME
OR UNDER MY SUPERVISION
[Signature]
21 SEPT 1998
Signature

STATE OF HAWAII
DEPARTMENT OF TRANSPORTATION
HIGHWAYS DIVISION
STREET LIGHTING PLAN

HANA HIGHWAY
INTERSECTION IMPROVEMENTS
AT HOBRON AVENUE
FAP NO. STP-036-1 (12)

SCALE: AS NOTED DATE: MAR. 1999

SHEET No. E3 OF E5 SHEETS