
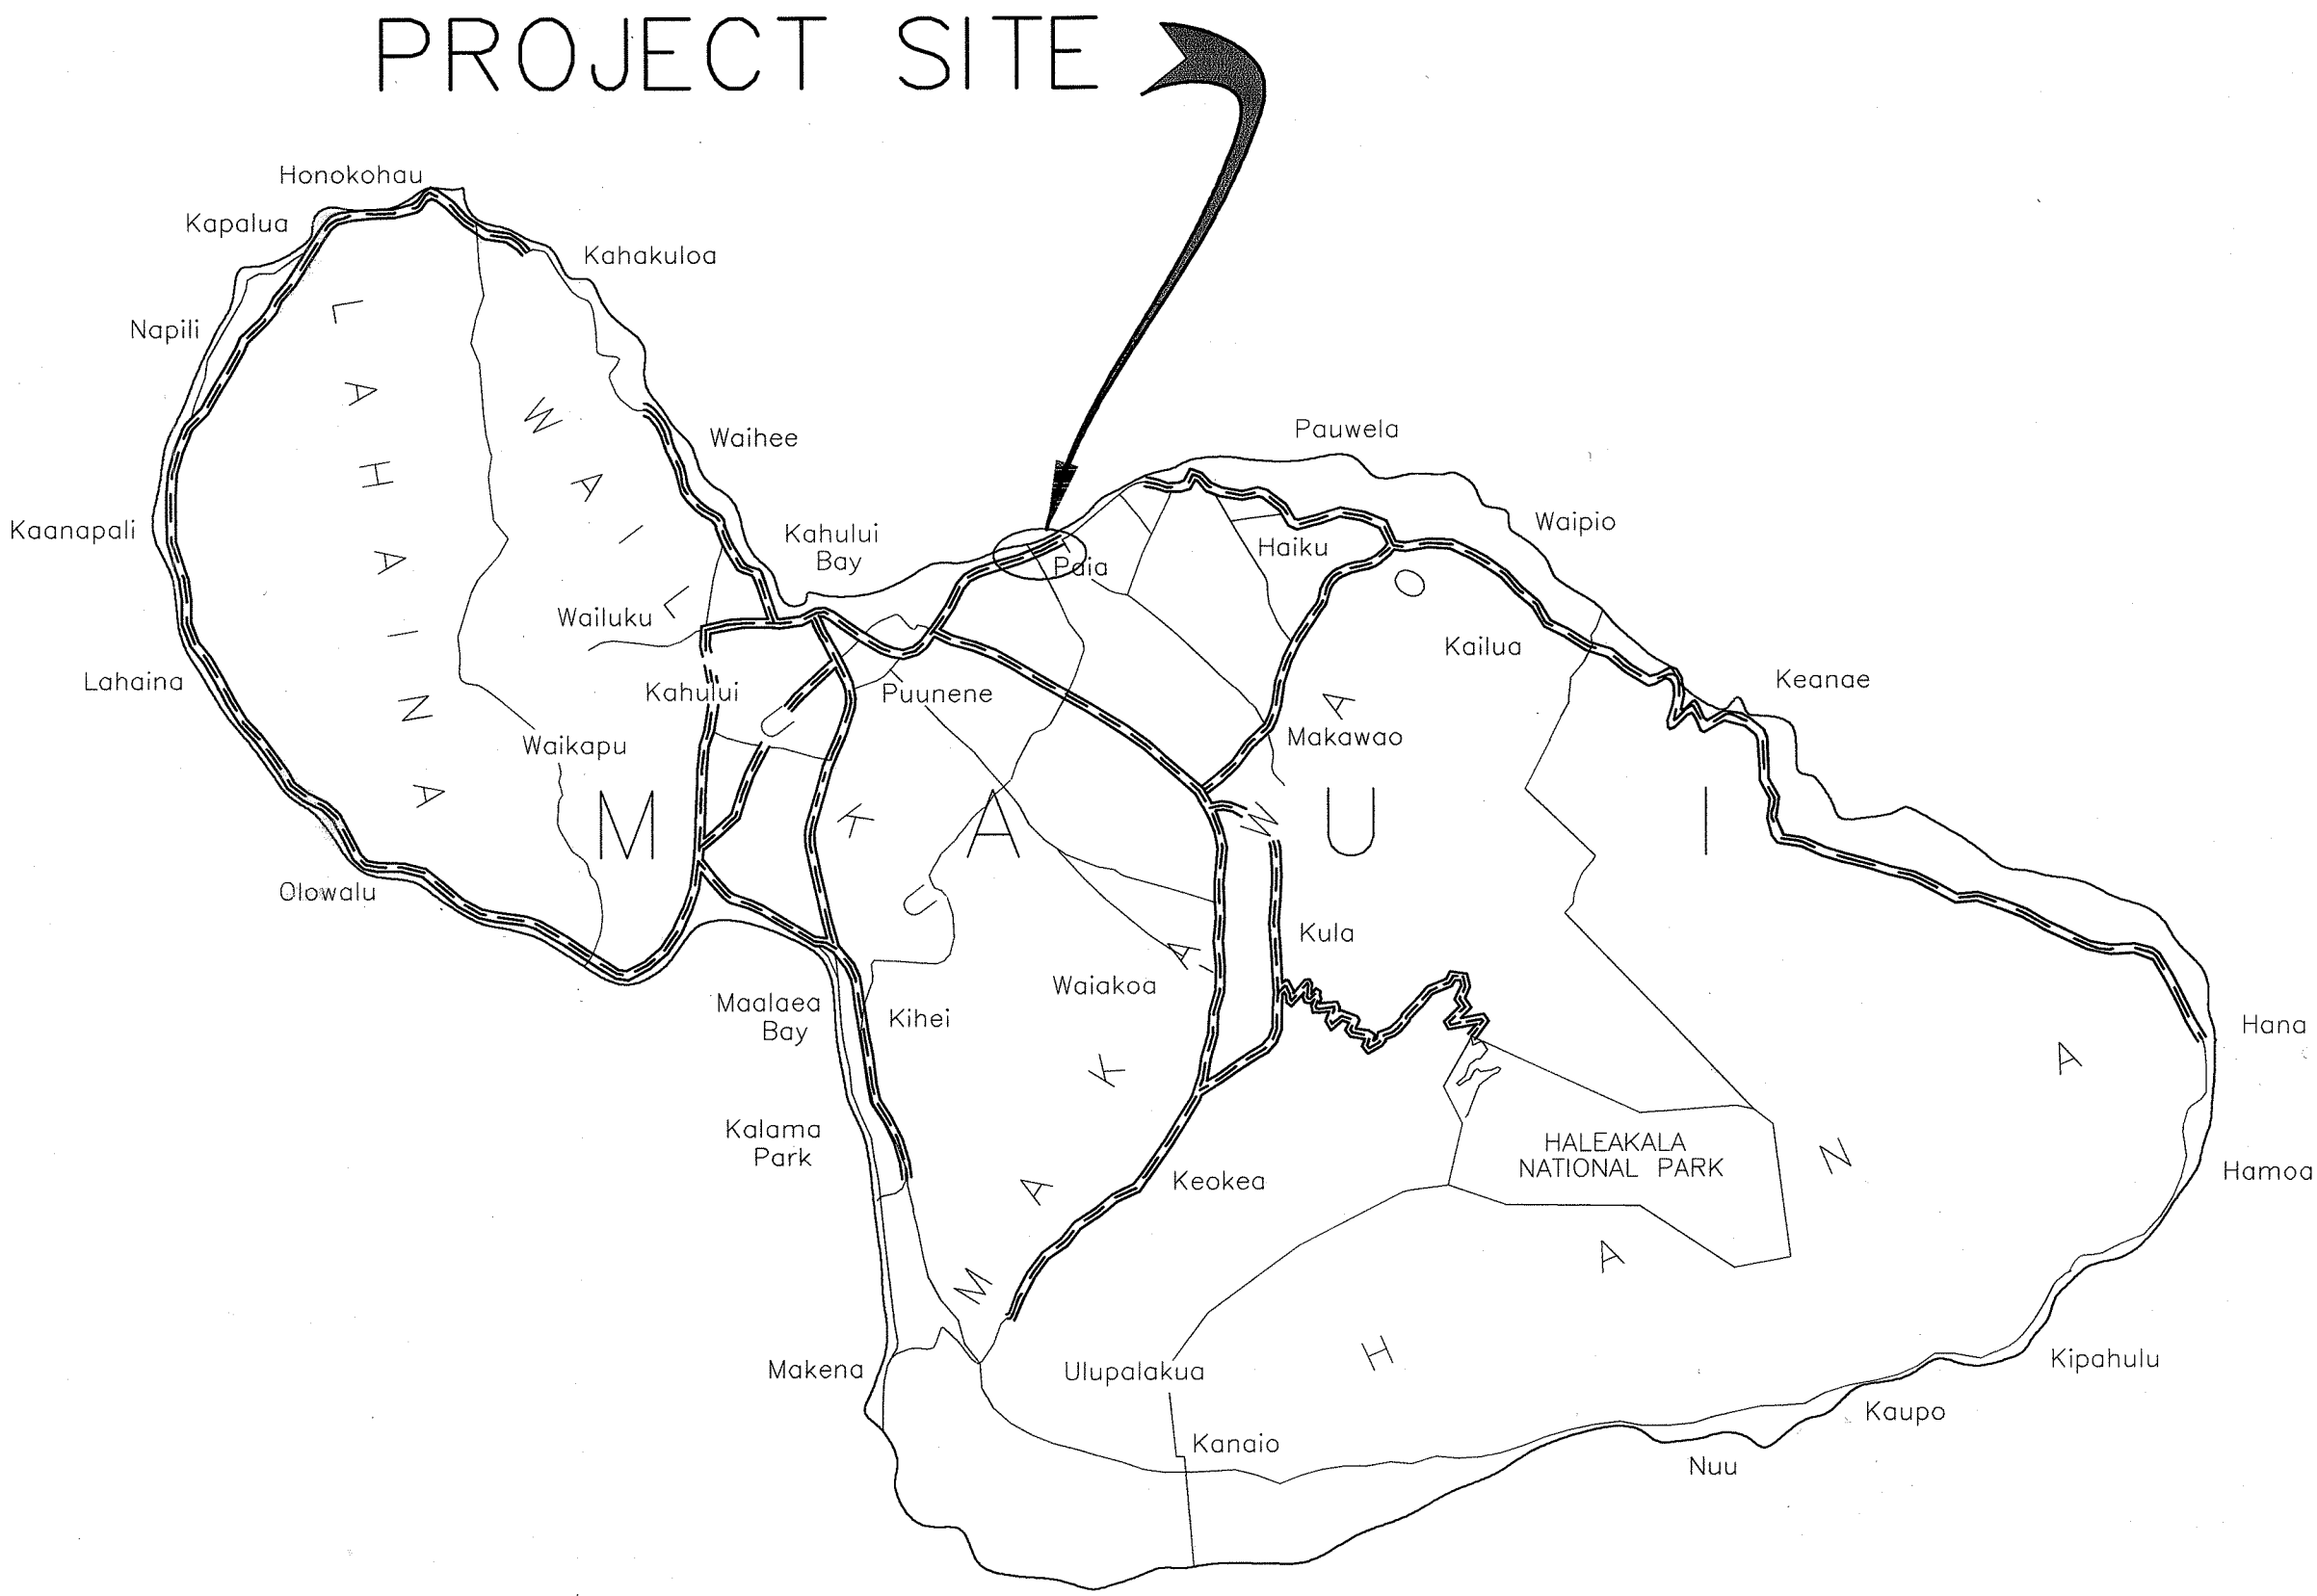
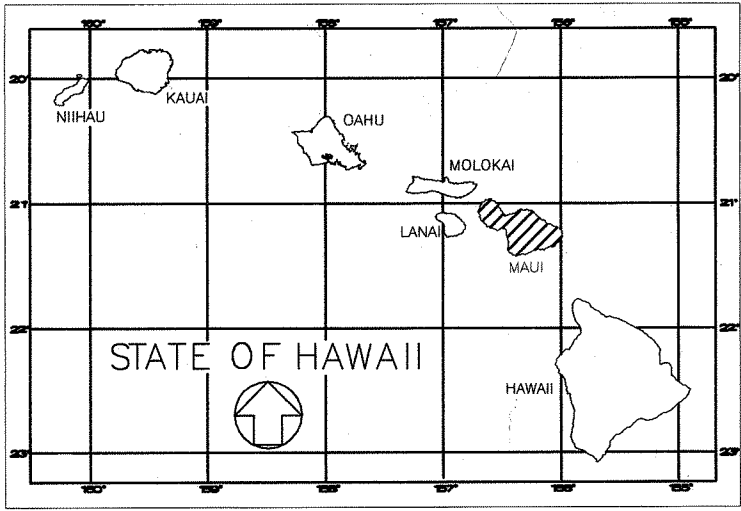


| INDEX TO DRAWINGS |                                 |
|-------------------|---------------------------------|
| SHEET NO.         | DESCRIPTION                     |
| 1                 | TITLE SHEET                     |
| 2                 | STANDARD PLANS SUMMARY          |
| 3-8               | GENERAL NOTES                   |
| 9-10              | TYPICAL SECTIONS                |
| 11                | OVERALL SITE PLAN               |
| 12-18             | DEMOLITION PLANS                |
| 19-25             | SIDEWALK PLANS                  |
| 26                | STRIPING LEGEND & NOTES         |
| 27-33             | STRIPING PLANS                  |
| 34                | PAVEMENT MARKING & SIGN SUMMARY |
| 35-41             | DETAILS                         |
| 42-48             | ELECTRICAL PLANS                |
|                   |                                 |
|                   |                                 |

STATE OF HAWAII  
DEPARTMENT OF TRANSPORTATION  
HIGHWAYS DIVISION  
HONOLULU, HAWAII  
"AS-BUILT"  
PLANS FOR  
ROUTE 36, HANA HIGHWAY RESURFACING  
PAIA TOWN SECTION  
PROJECT NUMBER: 36AB-02-04M


DISTRICT OF WAILUKU  
ISLAND OF MAUI

| FED. ROAD DIST. NO. | STATE | PROJ. NO.    | FISCAL YEAR | SHEET NO. | TOTAL SHEETS |
|---------------------|-------|--------------|-------------|-----------|--------------|
| HAWAII              | HAW.  | 36AB-02-04 M | 2005        | 1         | 48           |

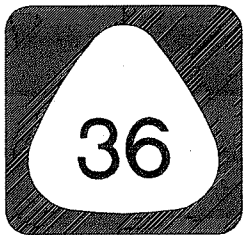

ISLAND OF MAUI  
NORTH

FEDERAL AID PROJECTS PREVIOUSLY CONSTRUCTED  
OR UNDER CONSTRUCTION

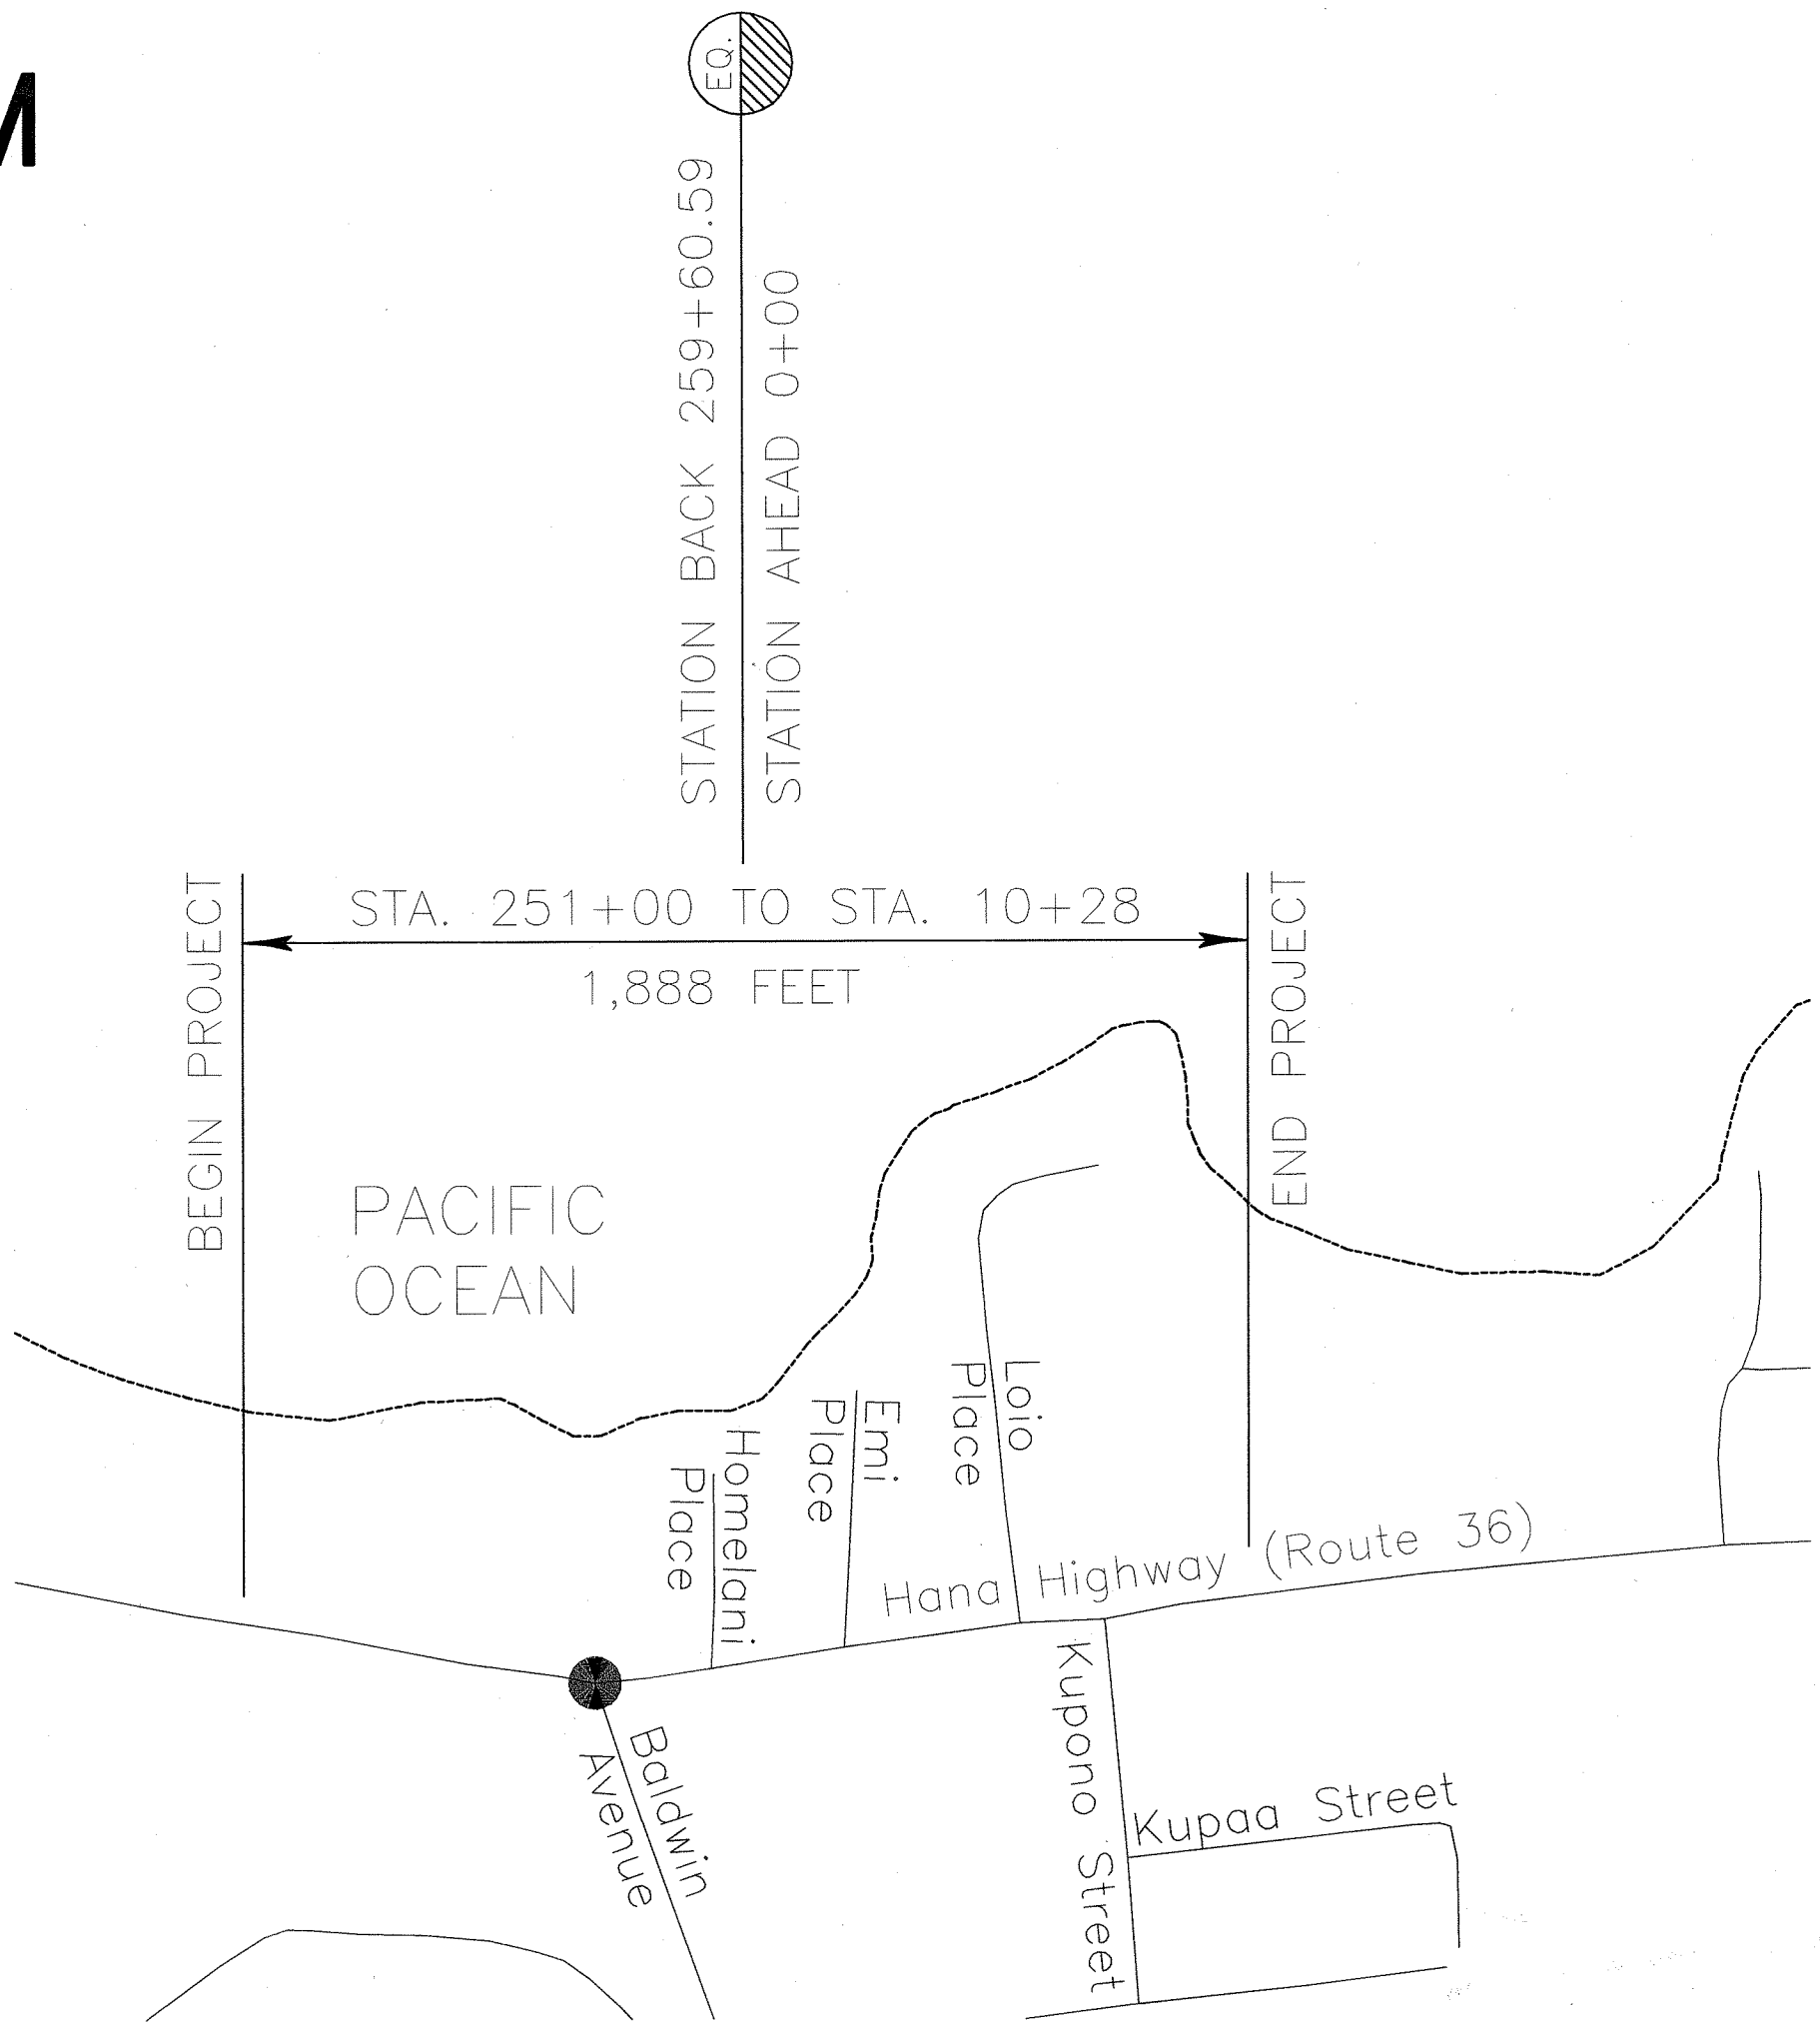

HANA HWY.  
ROUTE 36  
NORTH

CHANGES MADE DURING CONSTRUCTION HAVE BEEN  
INCORPORATED ON THESE PLANS EXCEPT CHANGES  
IN THE ORIGINAL THEORETICAL QUANTITIES. FOR  
ACTUAL QUANTITIES, REFER TO PROJECT LEDGER  
AND/OR COMPUTATION BOOK.

RESIDENT ENGINEER  
DATE

DEPARTMENT OF TRANSPORTATION  
STATE OF HAWAII  
APPROVED:  
DIR. OF TRANSPORTATION  
DATE

ORIGINAL PLAN  
DATE  
DESIGNED BY  
DRAWN BY  
CHECKED BY  
NO.

W. R. SEGAWA & ASSOC.  
DESIGNED BY  
HWY-M  
MANAGED BY  
873-3535  
PHONE  
MAY 2005  
DATE