


FED. ROAD DIST. NO.	STATE	PROJ. NO.	FISCAL YEAR	SHEET NO.	TOTAL SHEETS
HAWAII	HAW.	HWY-M-01-08	2010	13	17

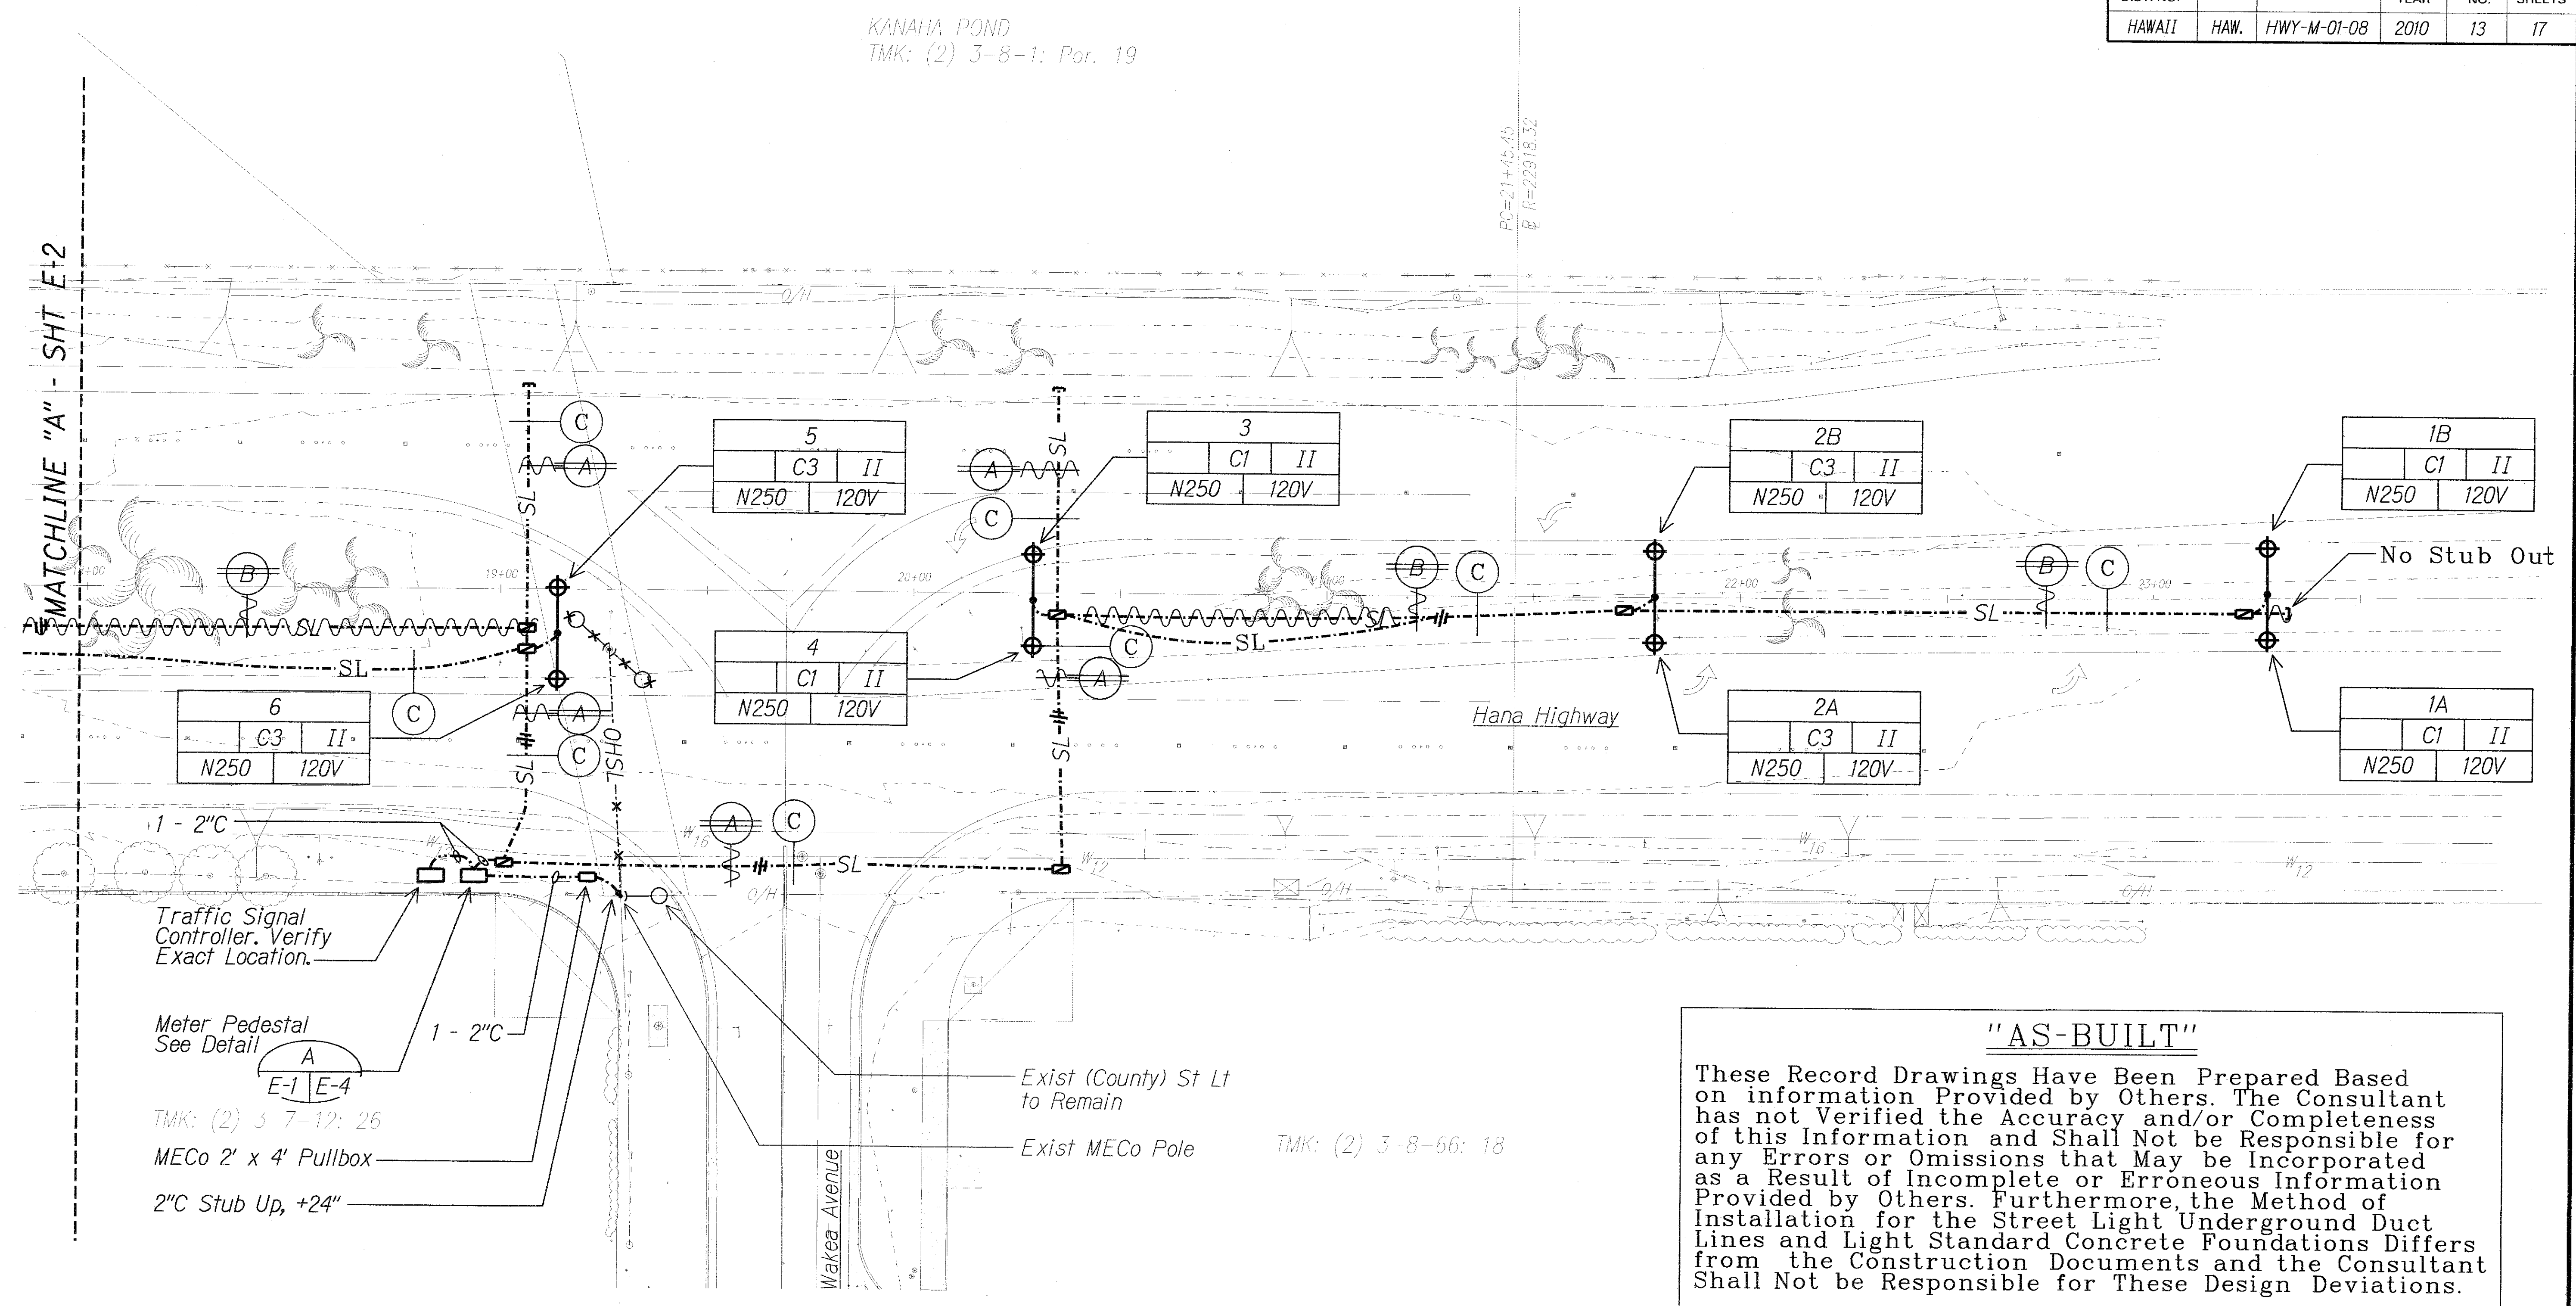

"AS-BUILT"

These Record Drawings Have Been Prepared Based on information Provided by Others. The Consultant has not Verified the Accuracy and/or Completeness of this Information and Shall Not be Responsible for any Errors or Omissions that May be Incorporated as a Result of Incomplete or Erroneous Information Provided by Others. Furthermore, the Method of Installation for the Street Light Underground Duct Lines and Light Standard Concrete Foundations Differs from the Construction Documents and the Consultant Shall Not be Responsible for These Design Deviations.

**LEGEND FOR
AS-BUILT POSTINGS**

	Squiggly line for as-built deletion
	Double line for as-built deletion
Roadway	Text for as-built posting

ROADWAY LIGHTING PLAN - PART A
Scale: 1" = 20'-0"

4/27/10

STATE OF HAWAII
DEPARTMENT OF TRANSPORTATION
HIGHWAYS DIVISION

ROADWAY LIGHTING PLAN - PART A

HANA HIGHWAY
TRAFFIC OPERATIONAL IMPROVEMENTS AT WAKEA AVENUE
Project No. HWY-M-01-08

Scale: As Noted Date: May 2010

DATE	_____
DESIGNED BY	_____
CHECKED BY	_____
NOTED BY	_____
ORIGINAL PLAN	_____