

INDEX TO DRAWINGS	
SHEET NO.	DESCRIPTION
1	TITLE SHEET
2	STANDARD PLANS SUMMARY
3-4	NOTES
5	GENERAL PLAN
6-10	BORING LOGS
11-18	TYPICAL SECTIONS
19-22	GEOMETRIC LAYOUTS
23-27	PLAN AND PROFILES
28-32	DRAINAGE PLAN
33	PROFILE DRAINLINE NO. 2 & 3
34	JOINTING PLAN & DETAILS
35	DRAIN IMPROVEMENTS NEAR STA. 2+80
36	DRYWELL & GRATING DETAILS
37-40	CROSS SECTIONS - HALEAKALA HIGHWAY
41	PAVEMENT MARKING LEGEND AND NOTES
42-43	SIGNING AND STRIPING PLANS
44-50	TRAFFIC CONTROL PLANS
51-52	PORTABLE CONCRETE BARRIER
53	BEST MANAGEMENT PRACTICES
54-56	CONSTRUCTION PHASING PLAN
57	CRM DRAIN OUTLET STRUCTURE AND CROSS SECTIONS N. FIREBREAK ROAD
58	T-STRAINER DETAIL & DRIP IRRIGATION DETAIL
59	STRUCTURAL DETAIL
60-72	ELECTRICAL PLANS

STATE OF HAWAII

DEPARTMENT OF TRANSPORTATION

HIGHWAYS DIVISION

HONOLULU, HAWAII

"AS - BUILT"

PLANS FOR

CONSTRUCTION OF

HALEAKALA HIGHWAY WIDENING

PHASE I




HANA HIGHWAY TO PUKALANI BYPASS

FEDERAL-AID PROJECT NO. NH-037-1(22)

DISTRICTS OF WAILUKU AND MAKAWAO

ISLAND OF MAUI

FED.ROAD DIST.NO.	STATE	FED. AID PROJ. NO.	FISCAL YEAR	SHEET NO.	TOTAL SHEETS
HAWAII	HAW.	NH-037-1(22)	2003	1	72

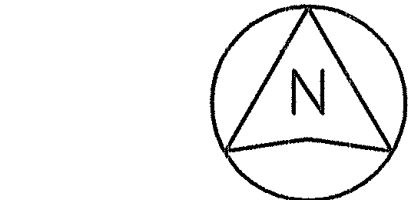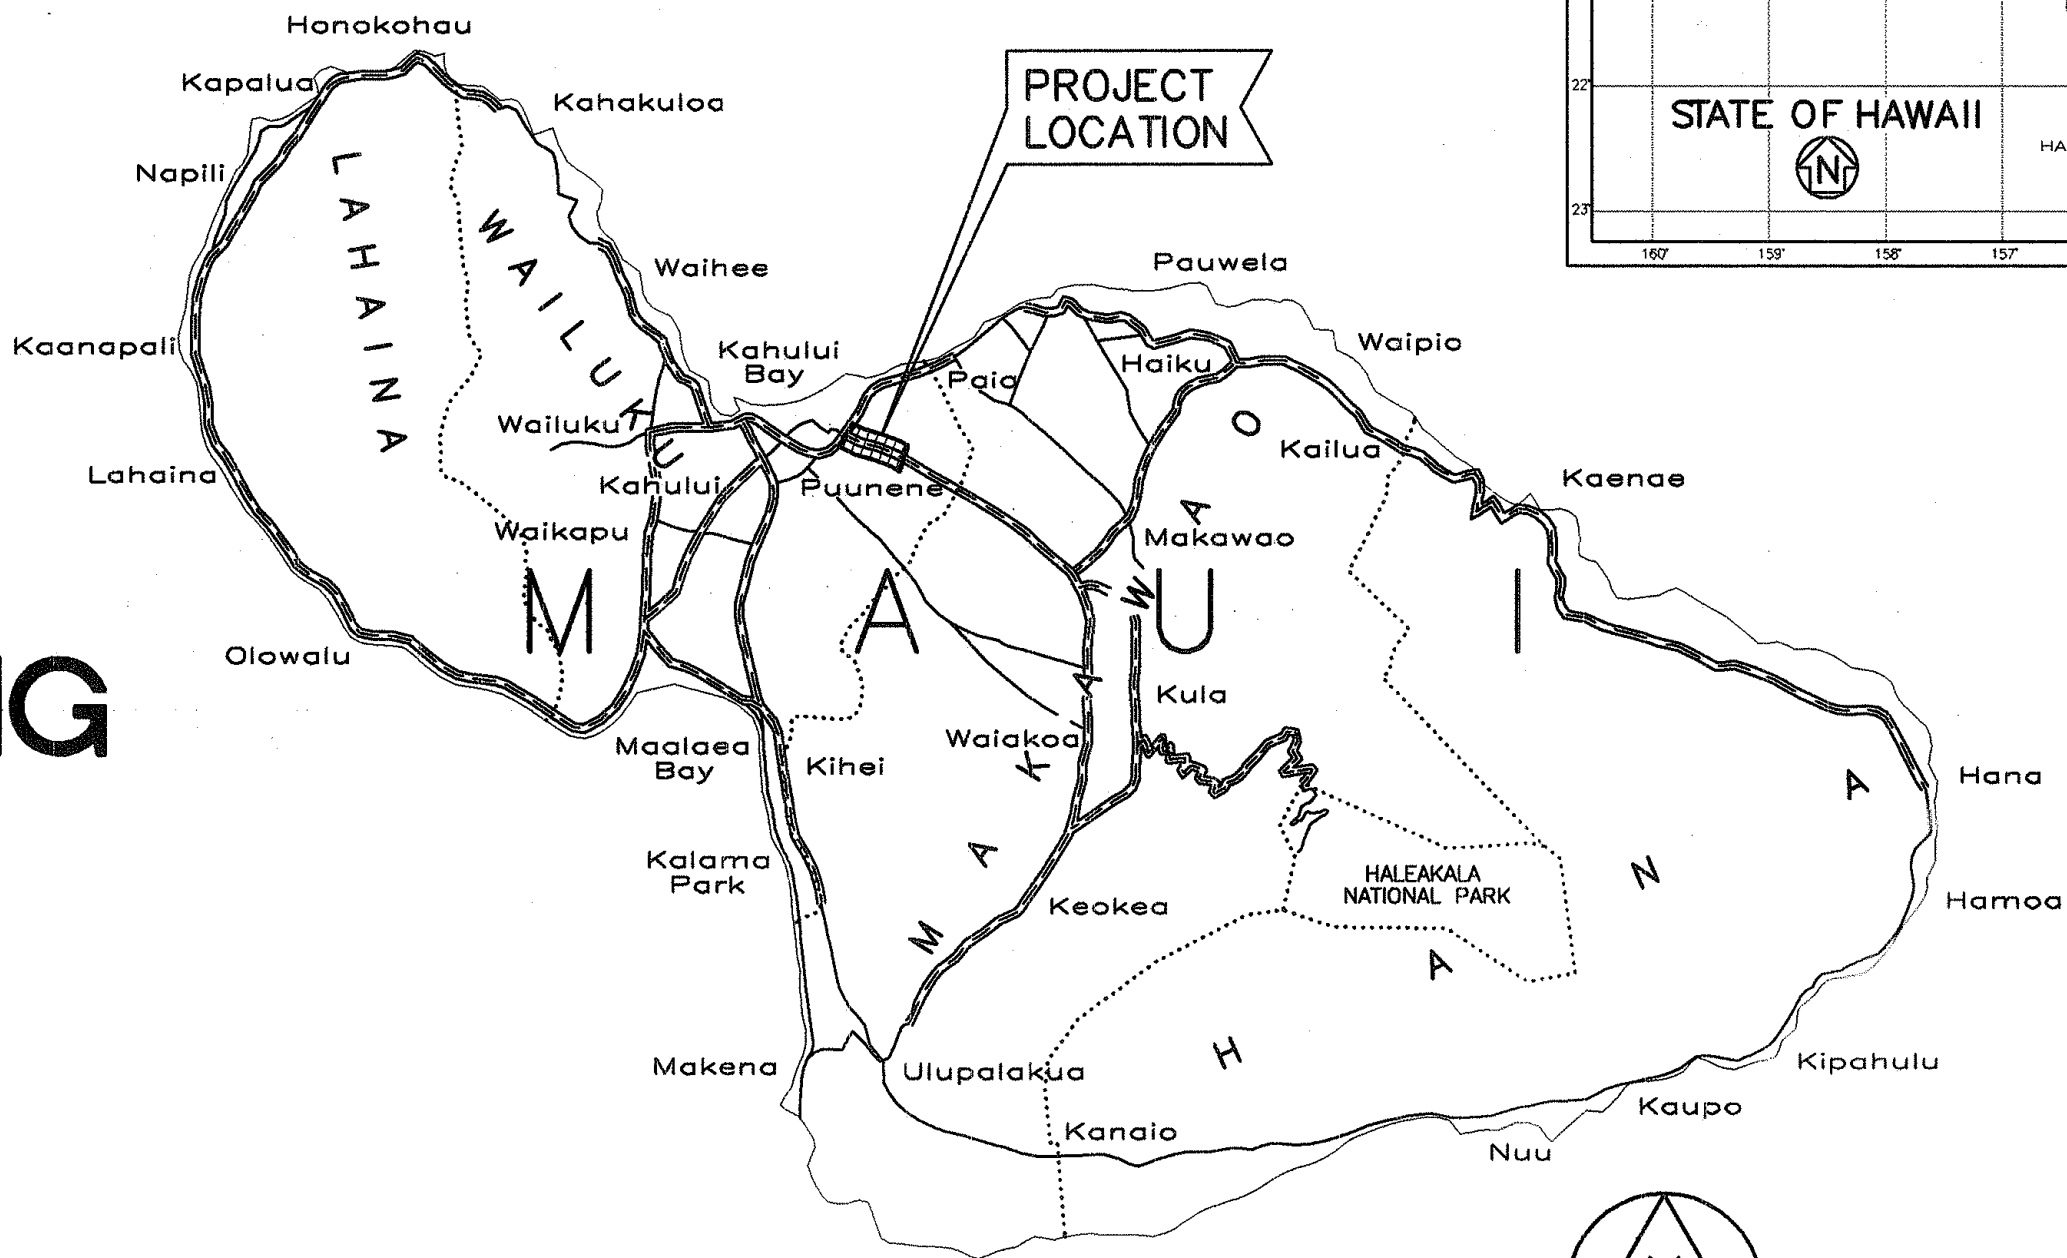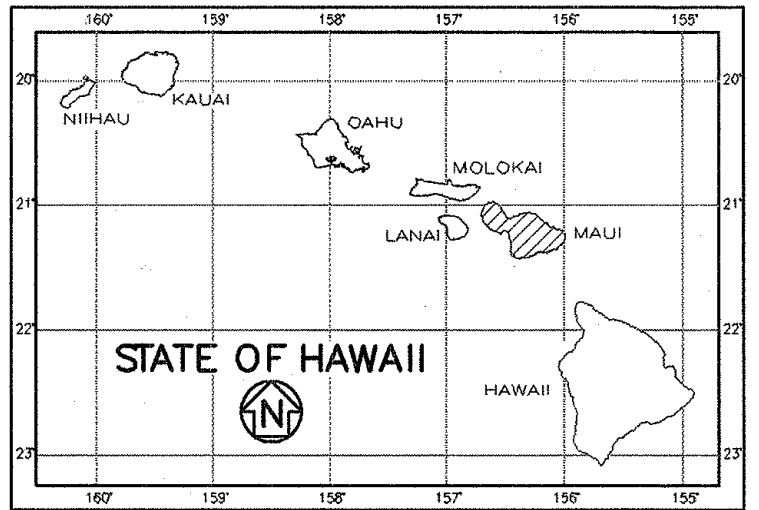

5 0 5 10
SCALE IN MILES

— FEDERAL AID PROJECTS PREVIOUSLY CONSTRUCTED OR UNDER CONSTRUCTION

MILE POST 0.04 TO MILE POST 0.94

VICINITY MAP
T.M.K.'S:


2nd DIVISION - 3-8-01: por 1, 6

CHANGES MADE DURING CONSTRUCTION HAVE BEEN INCORPORATED ON THESE PLANS EXCEPT CHANGES IN THE ORIGINAL THEORETICAL QUANTITIES. FOR ACTUAL QUANTITIES, REFER TO PROJECT LEDGER AND/OR COMPLETION BOOK.

5-22-06
DATE

DESIGN DESIGNATION	HANA HIGHWAY TO HALIMAIL ROAD
ADT (2002)	28,200
ADT (2022)	37,600
DHV	3,450
DESIGN K	9.0
DESIGN D	75/25
DESIGN T	3.0
T ₂₄	3.0
V	50-60 MPH

DEPARTMENT OF TRANSPORTATION
STATE OF HAWAII
APPROVED:
Debra M. Gorman 11-27-02
DIR. OF TRANSPORTATION DATE

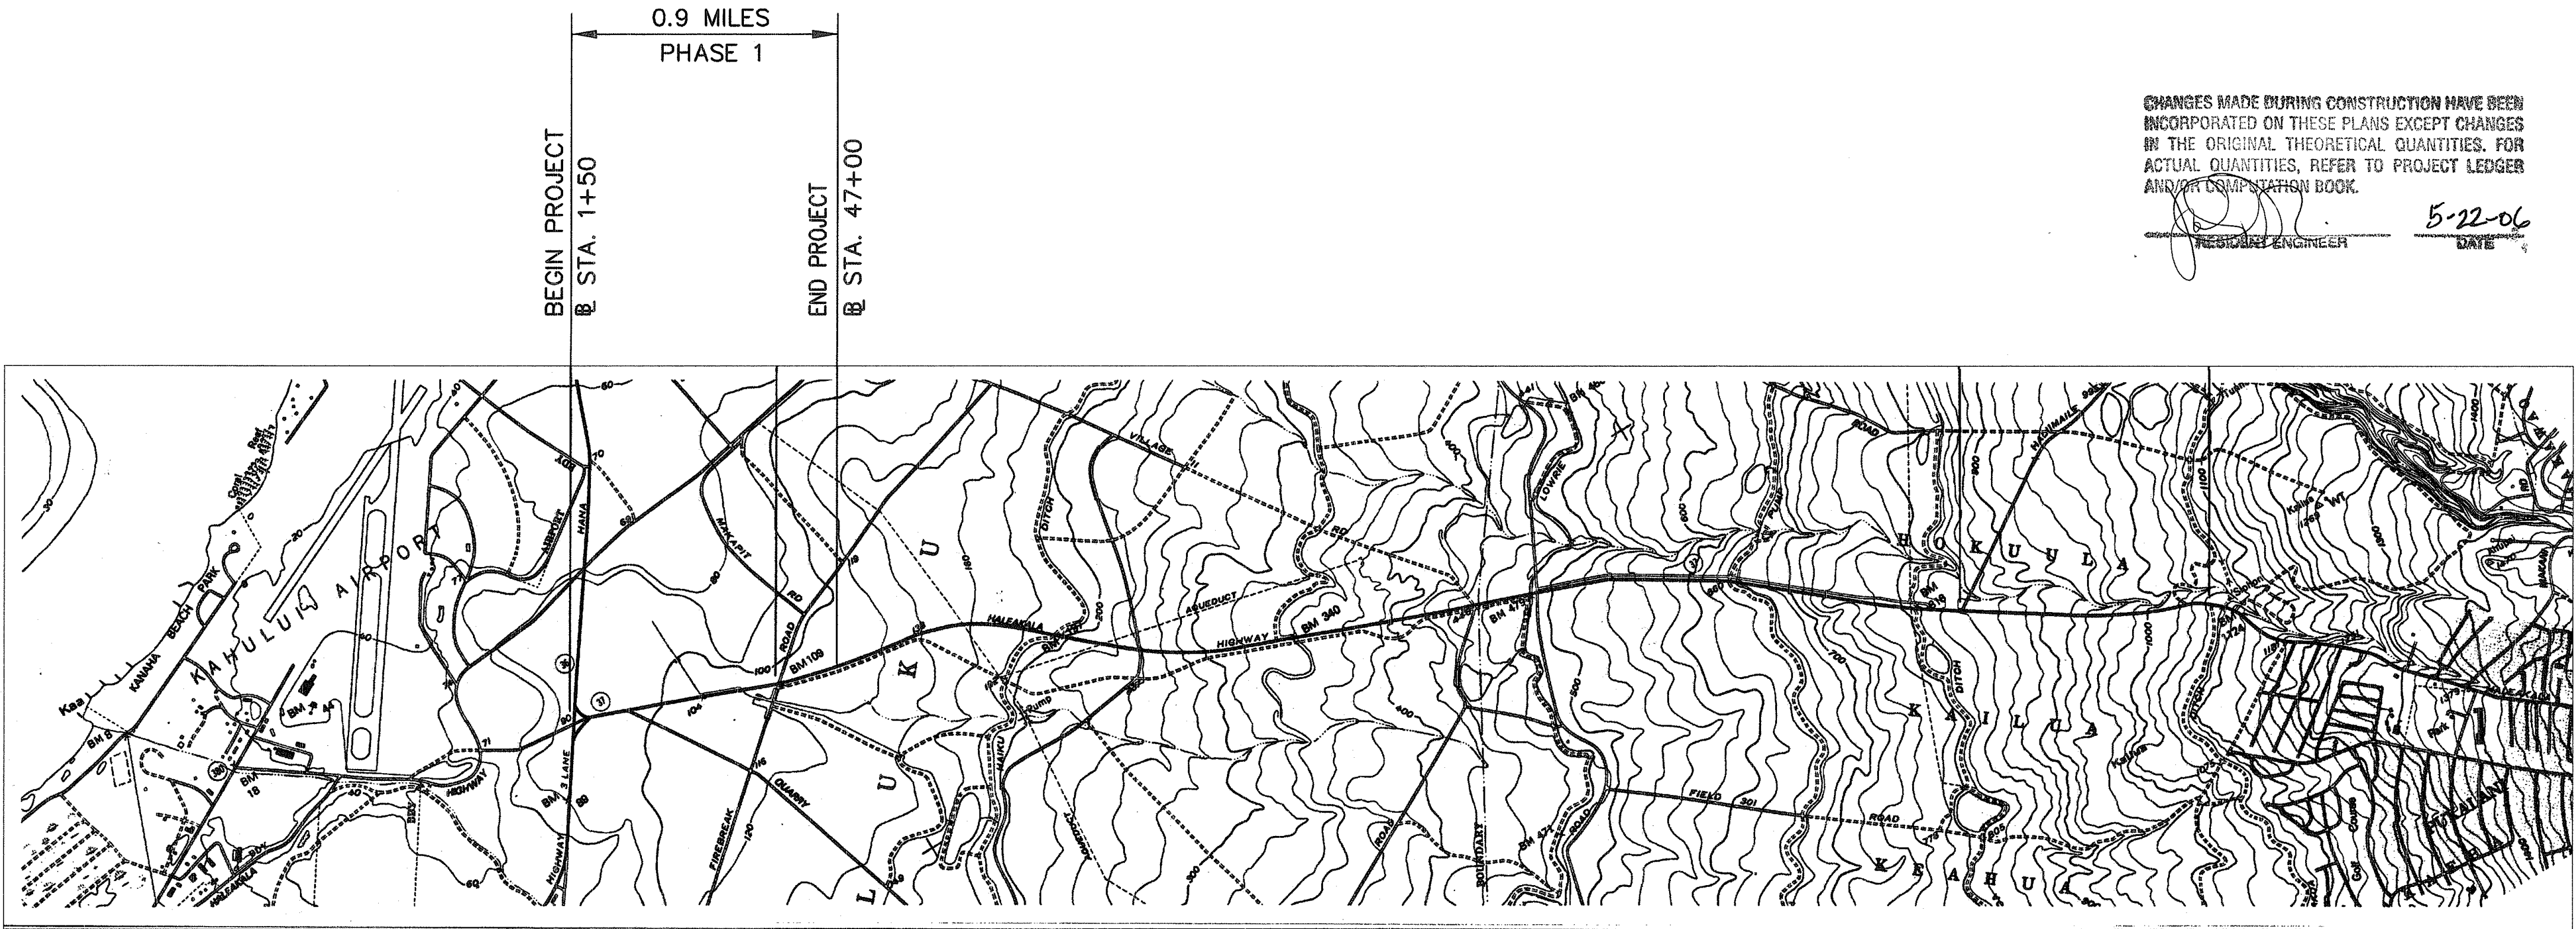

LOCATION PLAN

2 0 2 4 6
SCALE IN THOUSAND FEET

GROSS LENGTH OF PROJECT 0.9 MILES

Job: 94-56 File: TITLE.DWG D:ROAD(ESH-1) 1=1 11/20/2002 AMR
ENGINEERS EMILIO BARROGA, JR. 692-7546 NOV, 2002
SURVEYORS HAWAII, INC. P.S. & E BY PHONE DATE
DESIGNED BY: