


[illegible]

3

FED. ROAD DIST. NO.	STATE	PROJ. NO.	FISCAL YEAR	SHEET NO.	TOTAL SHEETS
HAWAII	HAW.	310A-01-91M	1991	4	14

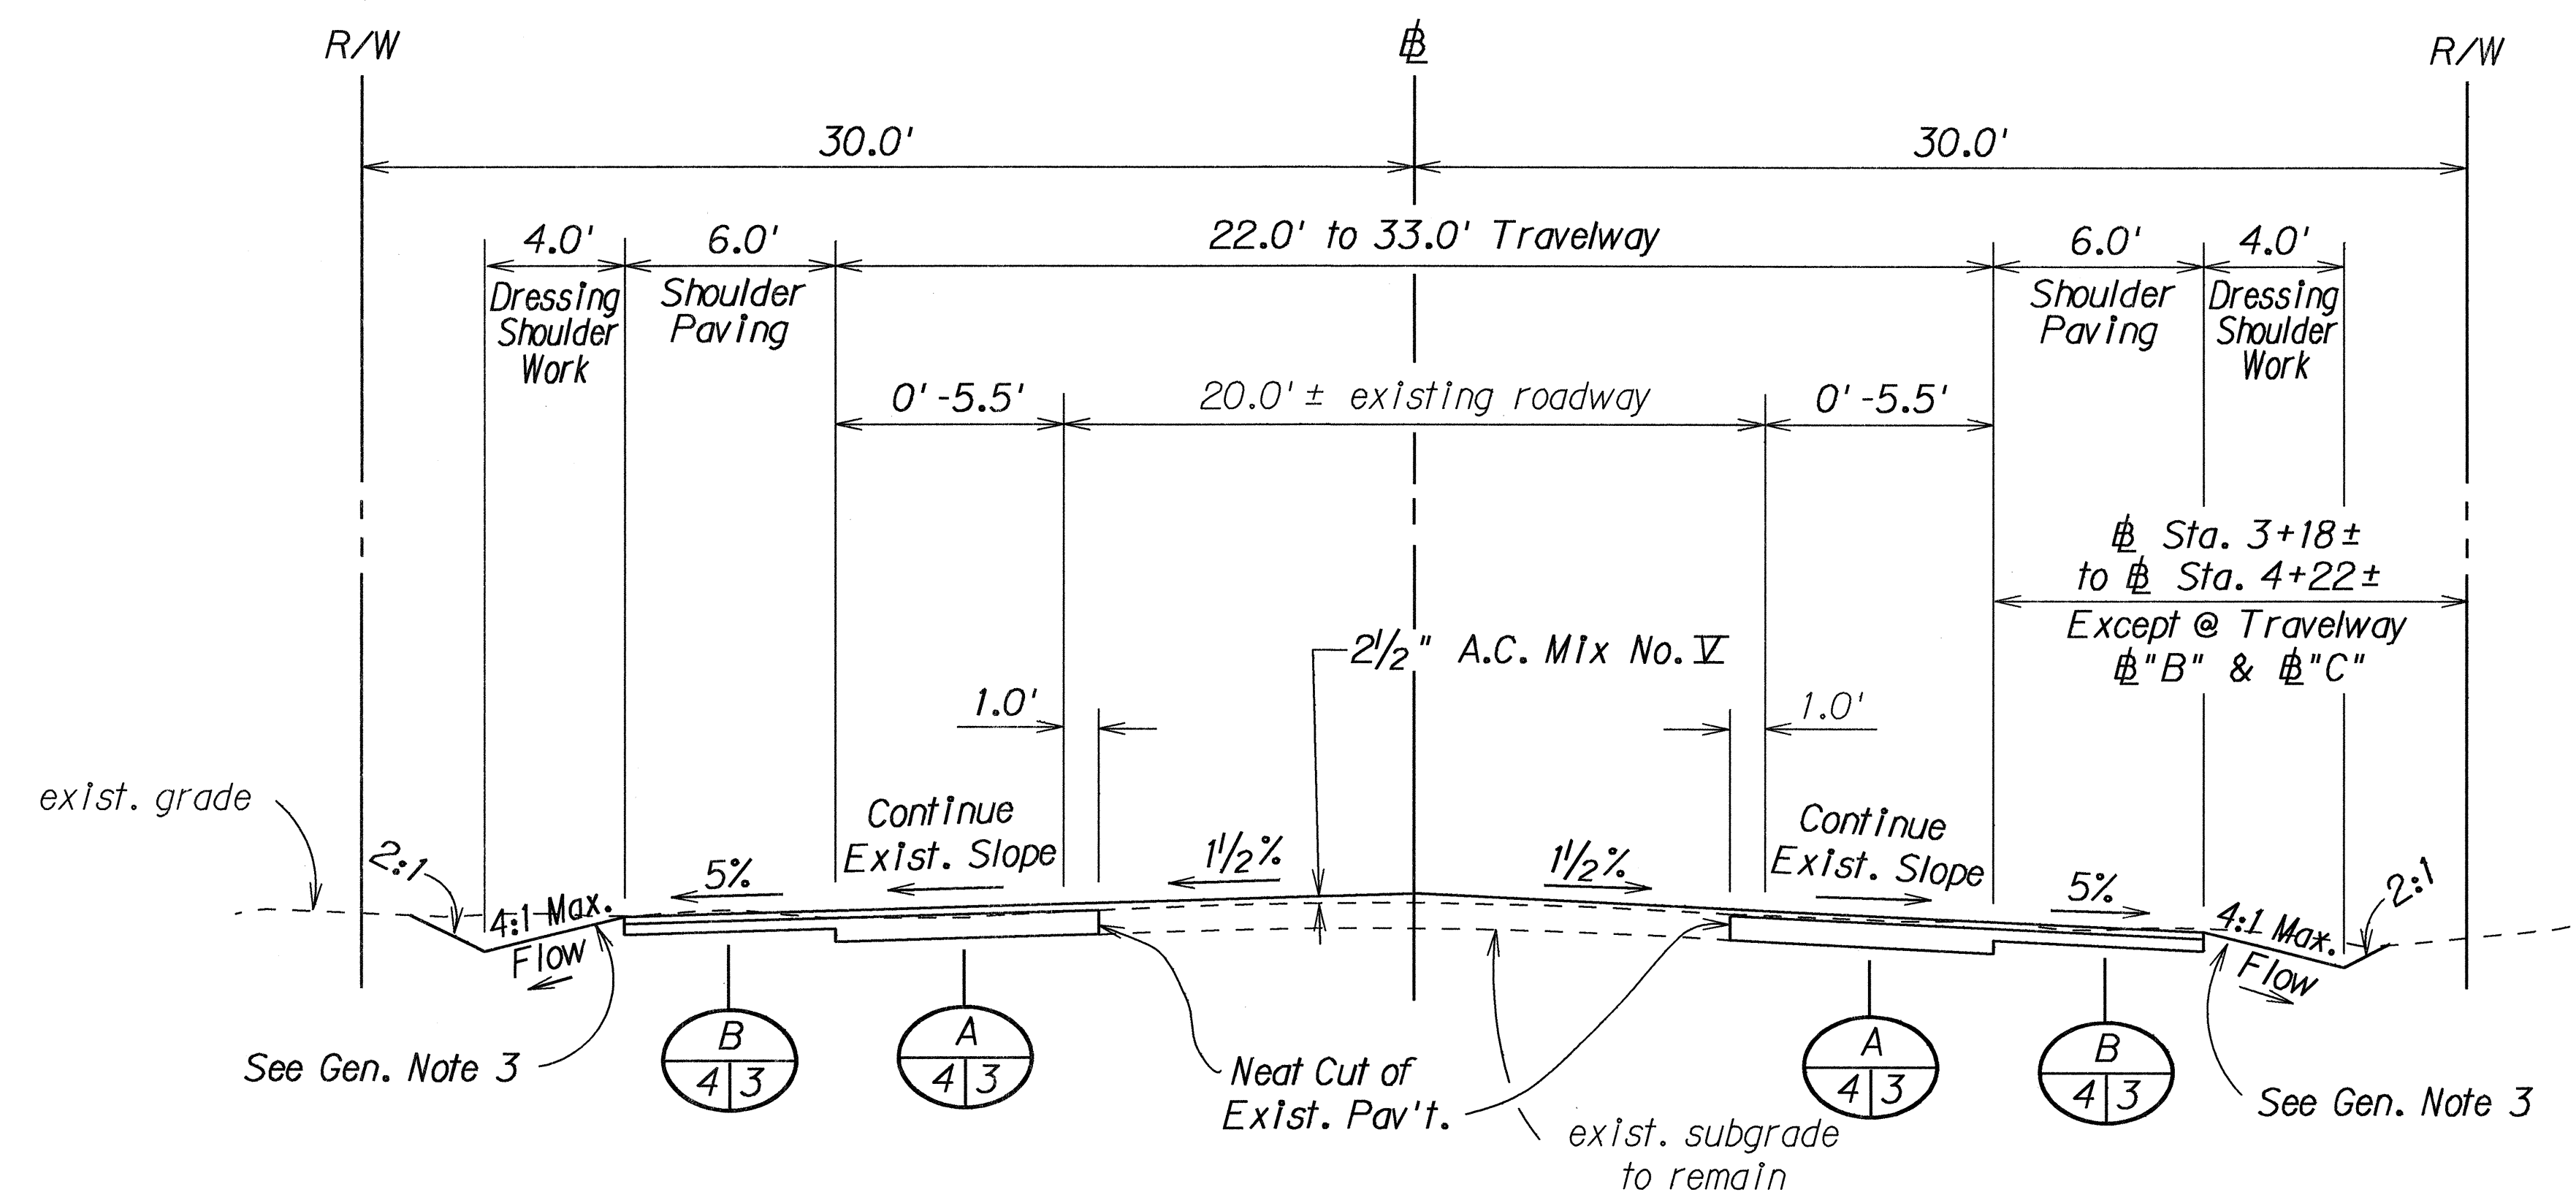


TYPICAL SECTION

Sta. 0+84.96 to Sta. 9+98.75

Scale: 1/4" = 1' - 0"


RECONSTRUCTION AREA TYPICAL DETAIL

Not to Scale

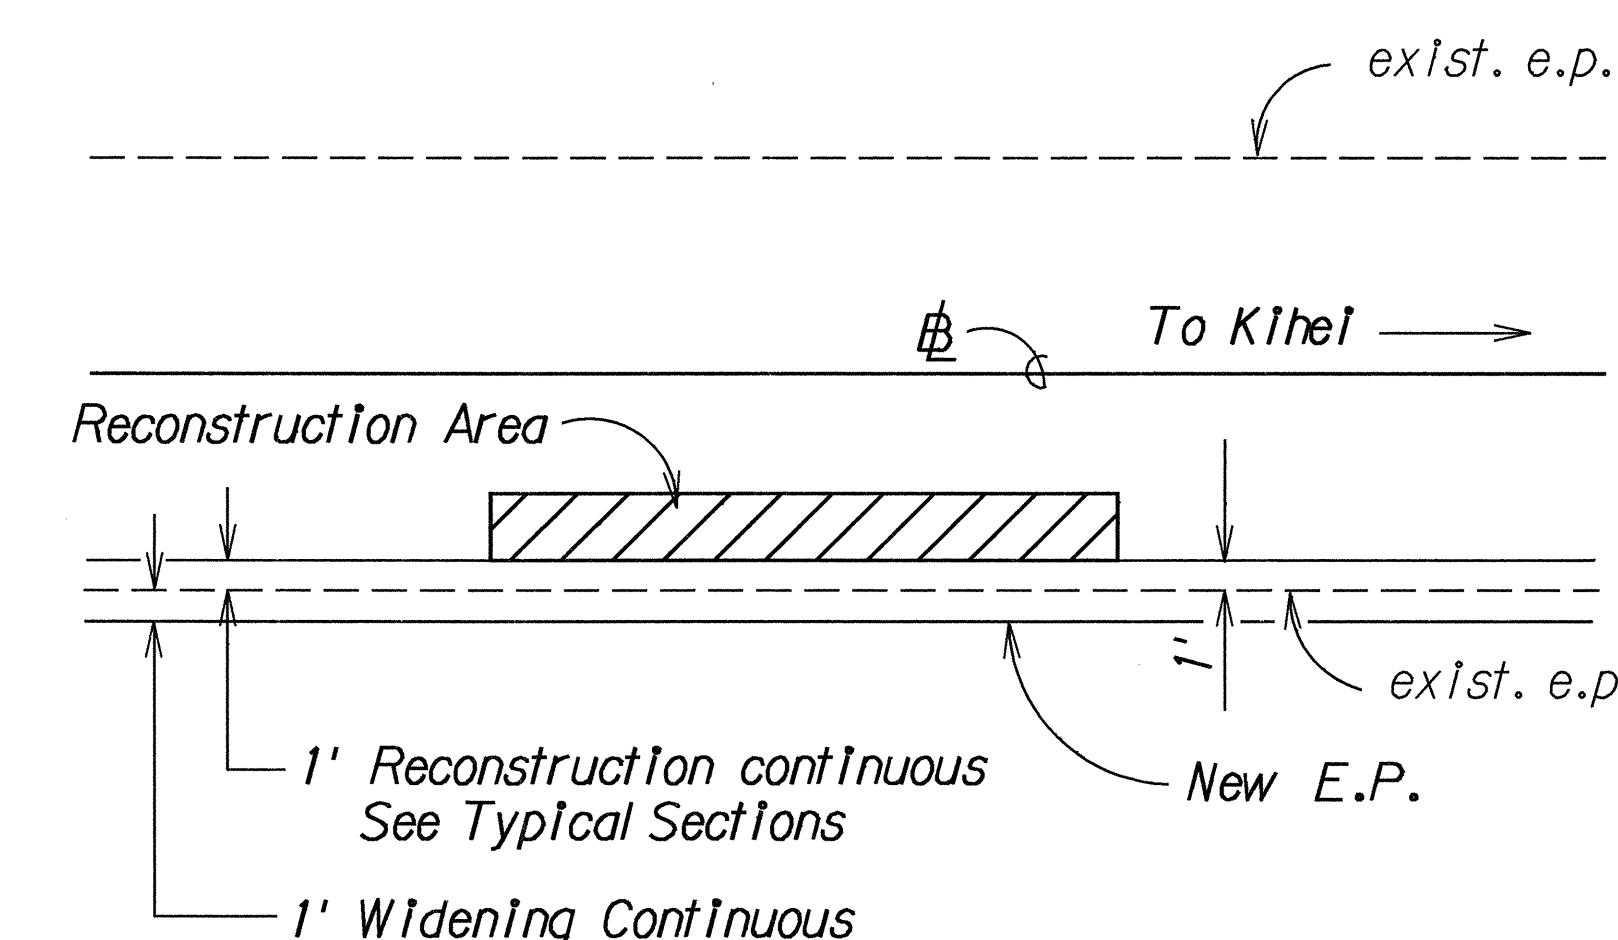

RECONSTRUCTION AREA TYPICAL LOCATION


Not to Scale

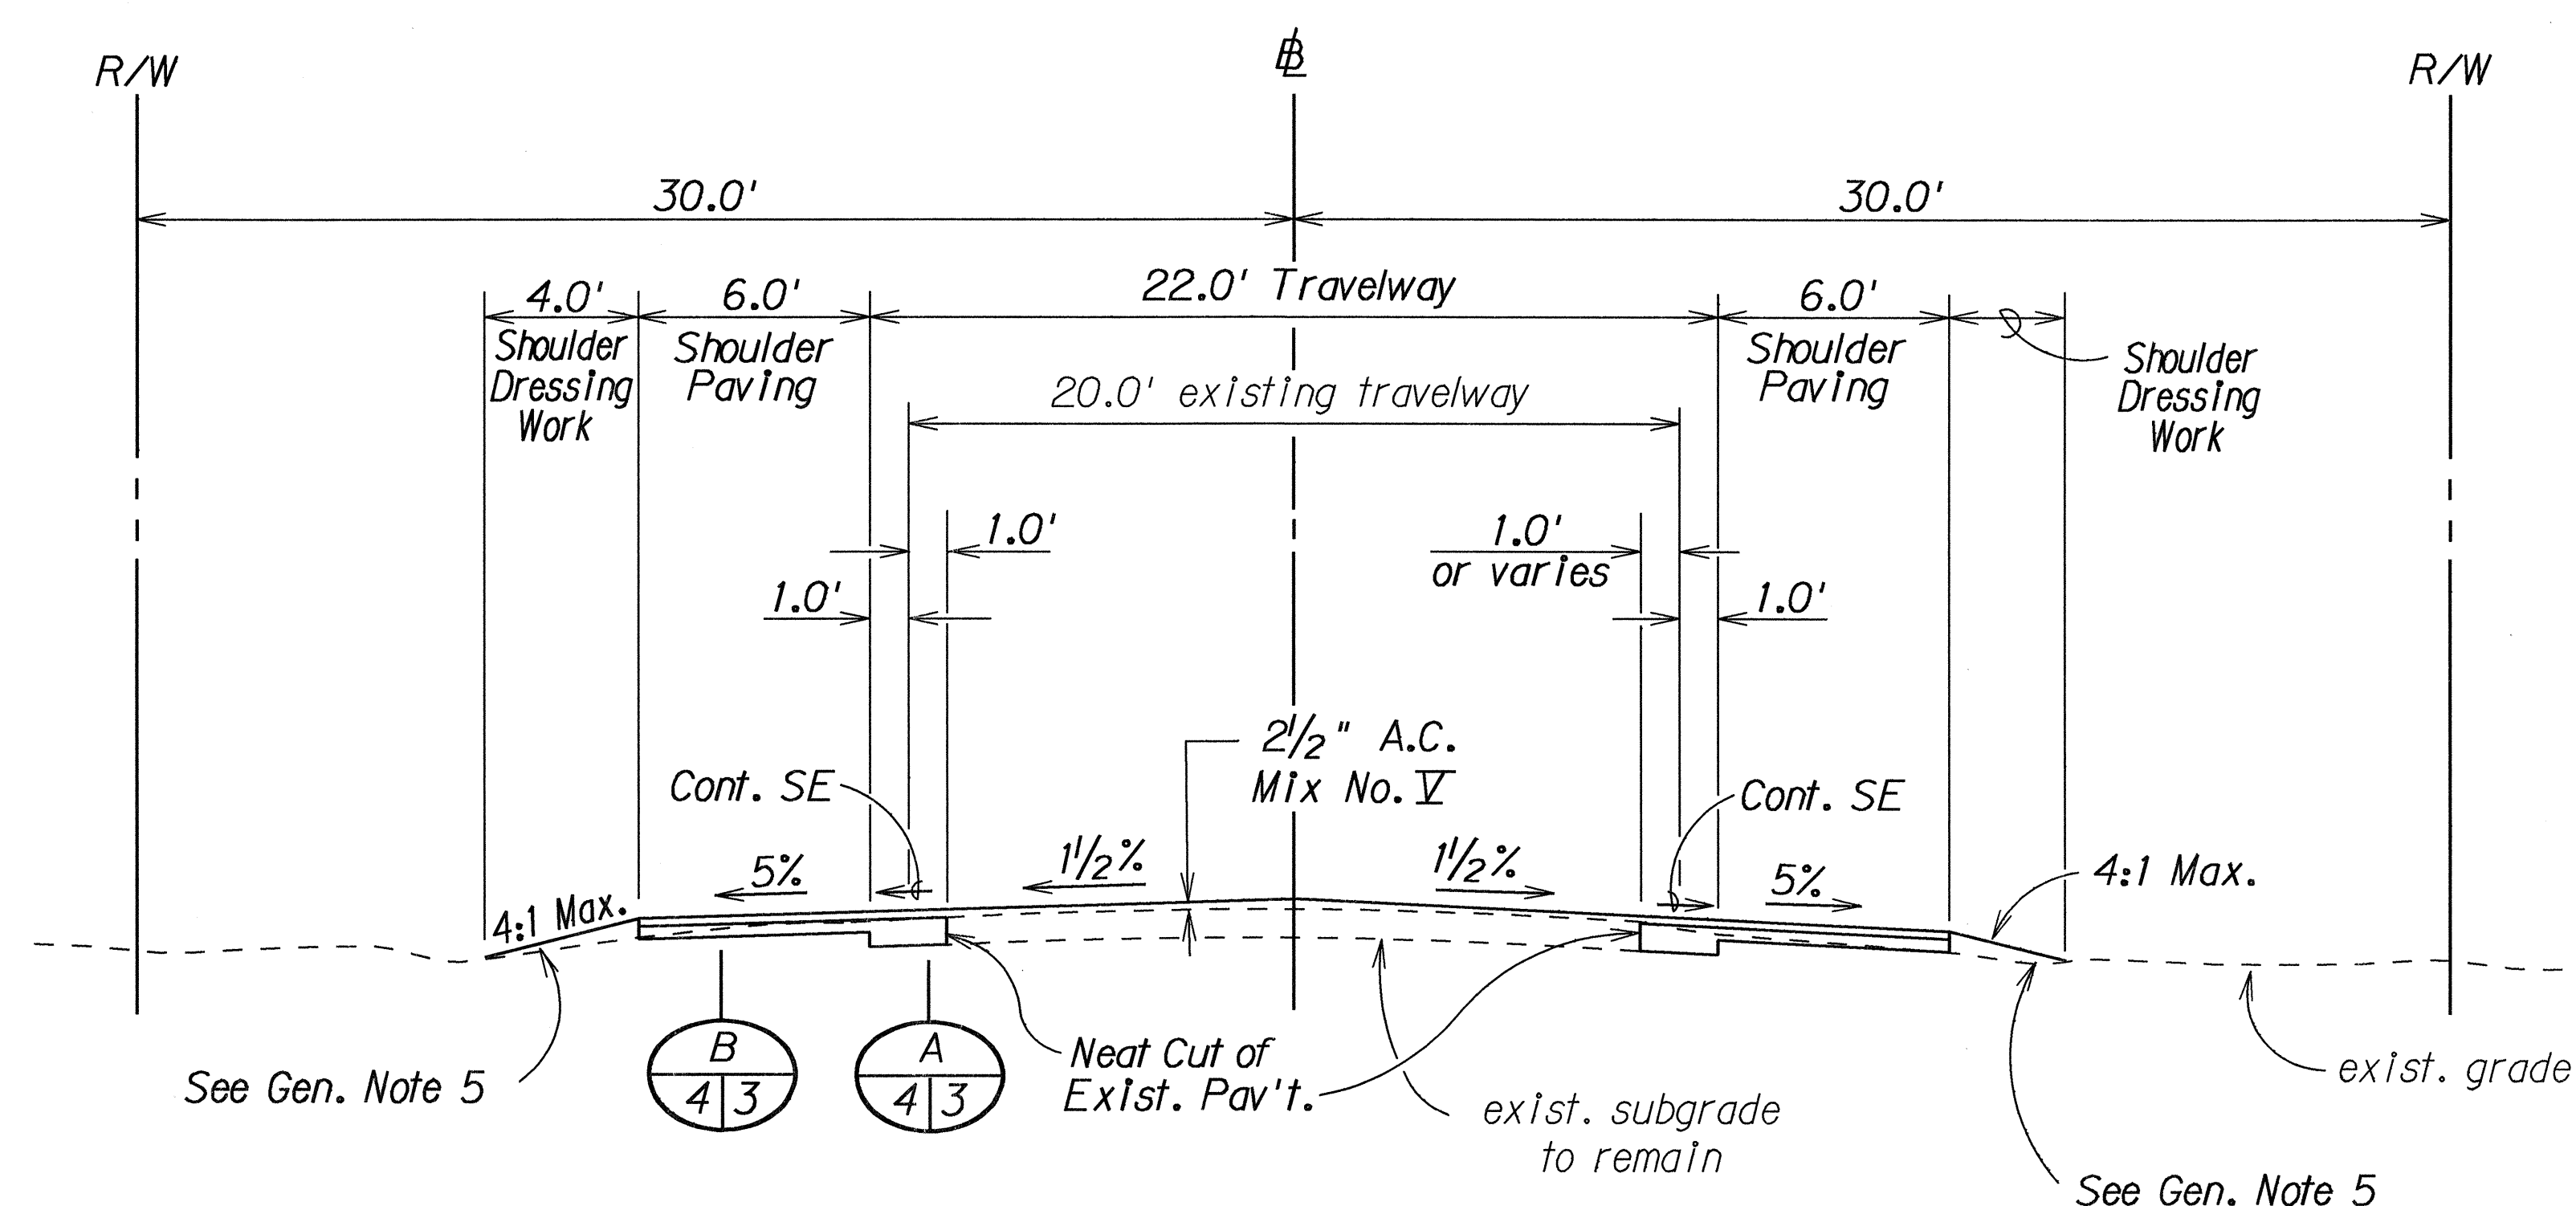

TYPICAL SECTION

Sta. 9+98.75 to Sta. 49+00

Scale: 1/4" = 1' - 0"

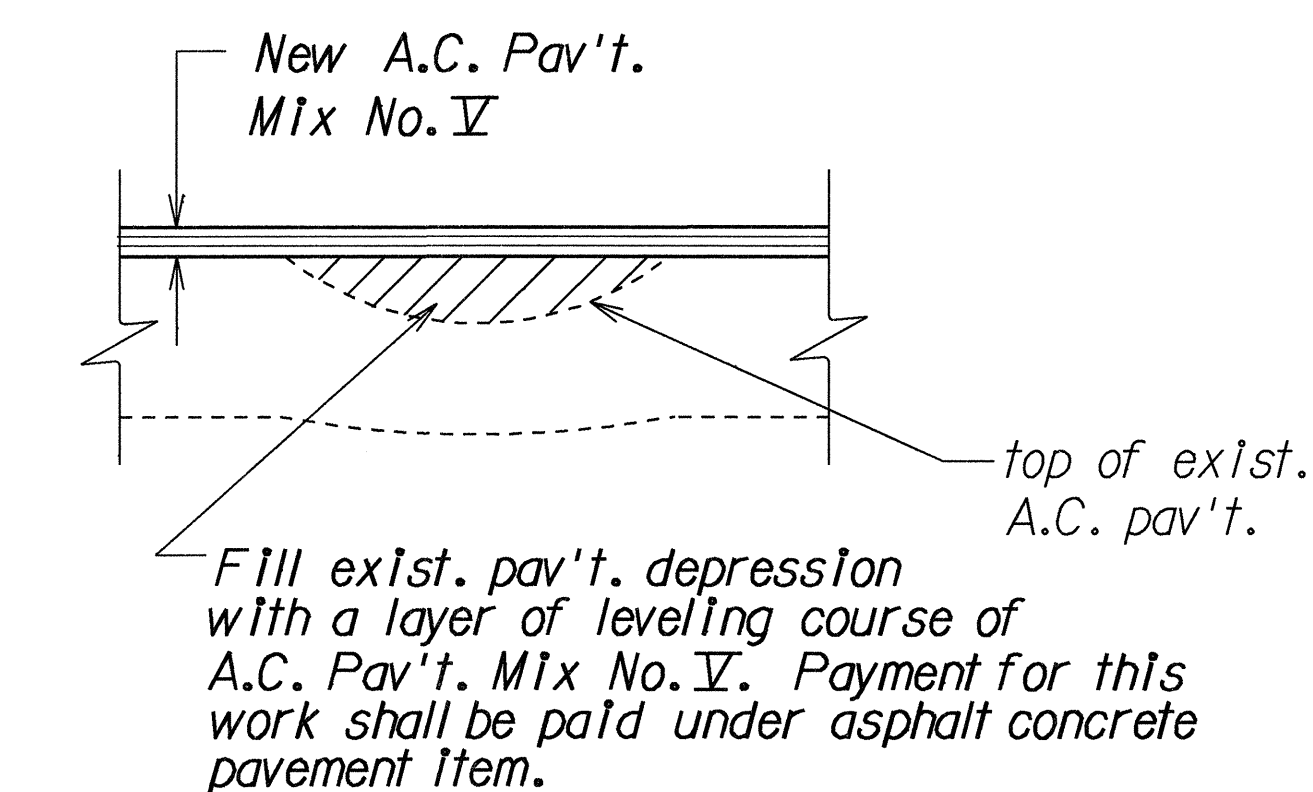

LEVELING COURSE DETAIL

Not To Scale

STATE OF HAWAII DEPARTMENT OF TRANSPORTATION HIGHWAYS DIVISION	
TYPICAL SECTIONS AND DETAILS	
NORTH KIHAI ROAD RESURFACING HONOAPIILANI HIGHWAY TO MECO POWER PLANT PROJECT NO. 310A-01-91M	
Scale: As Shown	Date: Nov, 1990
SHEET No. 2 OF 2 SHEETS	