
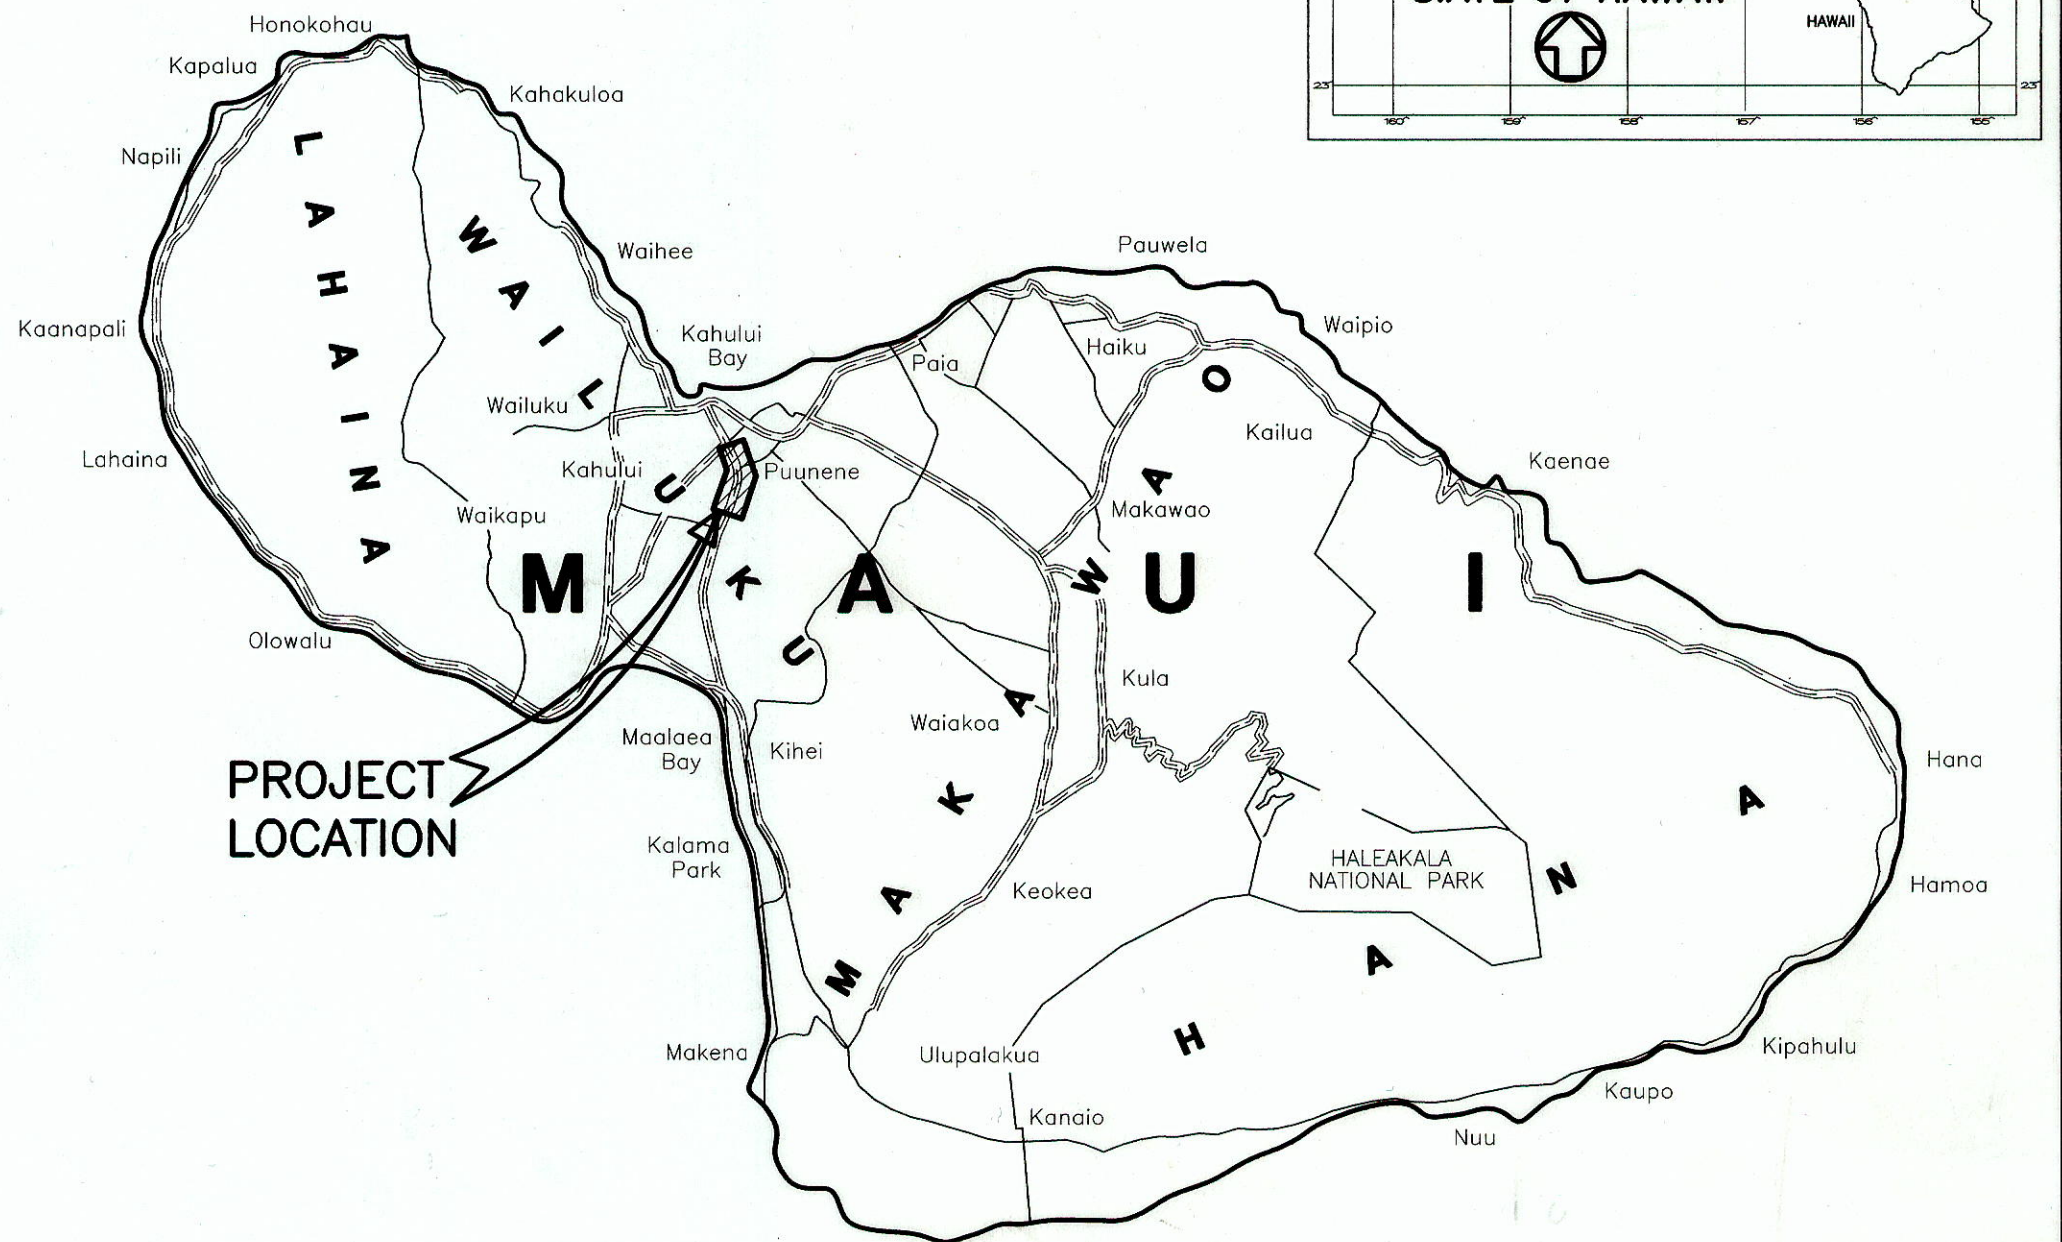


INDEX TO DRAWINGS	
SHEET NO.	DESCRIPTION
1	TITLE SHEET
2	STANDARD PLANS SUMMARY
3-5	CONSTRUCTION NOTES & LEGEND
6-15	TYPICAL ROAD SECTION
16-25	DEMOLITION PLAN
26-35	DETAIL PLAN OF ROADWAY
36-39	PLAN AND PROFILE
40	SUPERELEVATION DIAGRAM
41	DRIVEWAY PROFILE
42-51	UTILITY PLAN
52-60	GRADING AND DRAINAGE PLAN
61-62	DRAINLINE PROFILE
63-64	DRAINAGE SUMMARY
65-68	MISCELLANEOUS DETAILS
69-74	INTERSECTION PLAN
75-76	BORING LOGS
77-78	PAVEMENT MARKINGS & LEGEND
79-89	STRIPING AND SIGNAGE PLAN
90-99	STRIPING AND SIGNAGE SUMMARY
100-101	STRIPING AND SIGNAGE DETAILS
102-109	TRAFFIC SIGNAL PLAN & DETAILS
110-125	TRAFFIC CONTROL PLAN
126-139	CROSS SECTIONS
140-149	LANDSCAPE PLANS
150-157	ELECTRICAL PLANS
158	DUCTLINE TRENCHING DETAILS
159	METERING AND LUMINAIRE DETAILS

STATE OF HAWAII
DEPARTMENT OF TRANSPORTATION
HIGHWAYS DIVISION
HONOLULU, HAWAII
"AS-BUILT"
PLANS FOR
PUUNENE AVENUE WIDENING
KUIHELANI HIGHWAY TO HANSEN ROAD
AND
MOKULELE HIGHWAY WIDENING
HANSEN ROAD TO VICINITY OF
CANE HAUL ROAD CROSSING
FEDERAL-AID PROJECT NO. NH-A311(3)

DISTRICT OF WAILUKU
ISLAND OF MAUI

FED. ROAD DIST. NO.	STATE	FEDERAL - AID PROJ. NO.	FISCAL YEAR	SHEET NO.	TOTAL SHEETS
HAWAII	HAW.	NH-A311(3)	2002	1	159

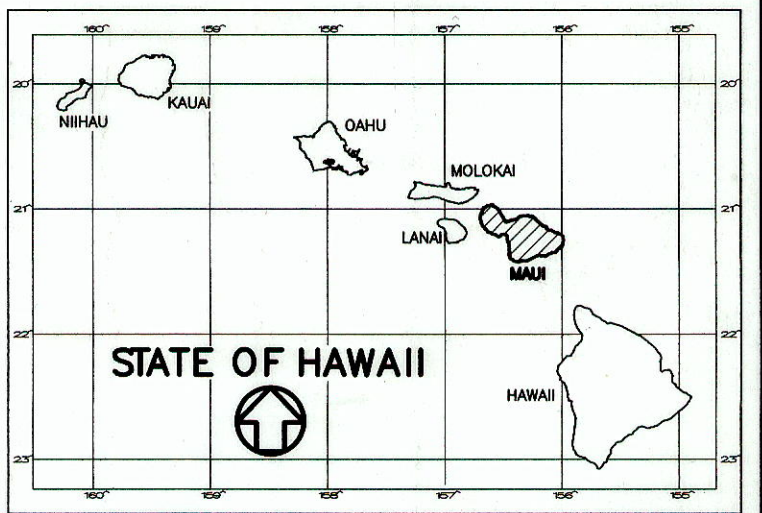

PROJECT LOCATION




ISLAND OF MAUI

5 0 5 10
SCALE IN MILES

FEDERAL AID PROJECTS PREVIOUSLY CONSTRUCTED
OR UNDER CONSTRUCTION

PUUNENE AVENUE/MOKULELE HIGHWAY MILE POST 0.00 TO MILE POST 1.40

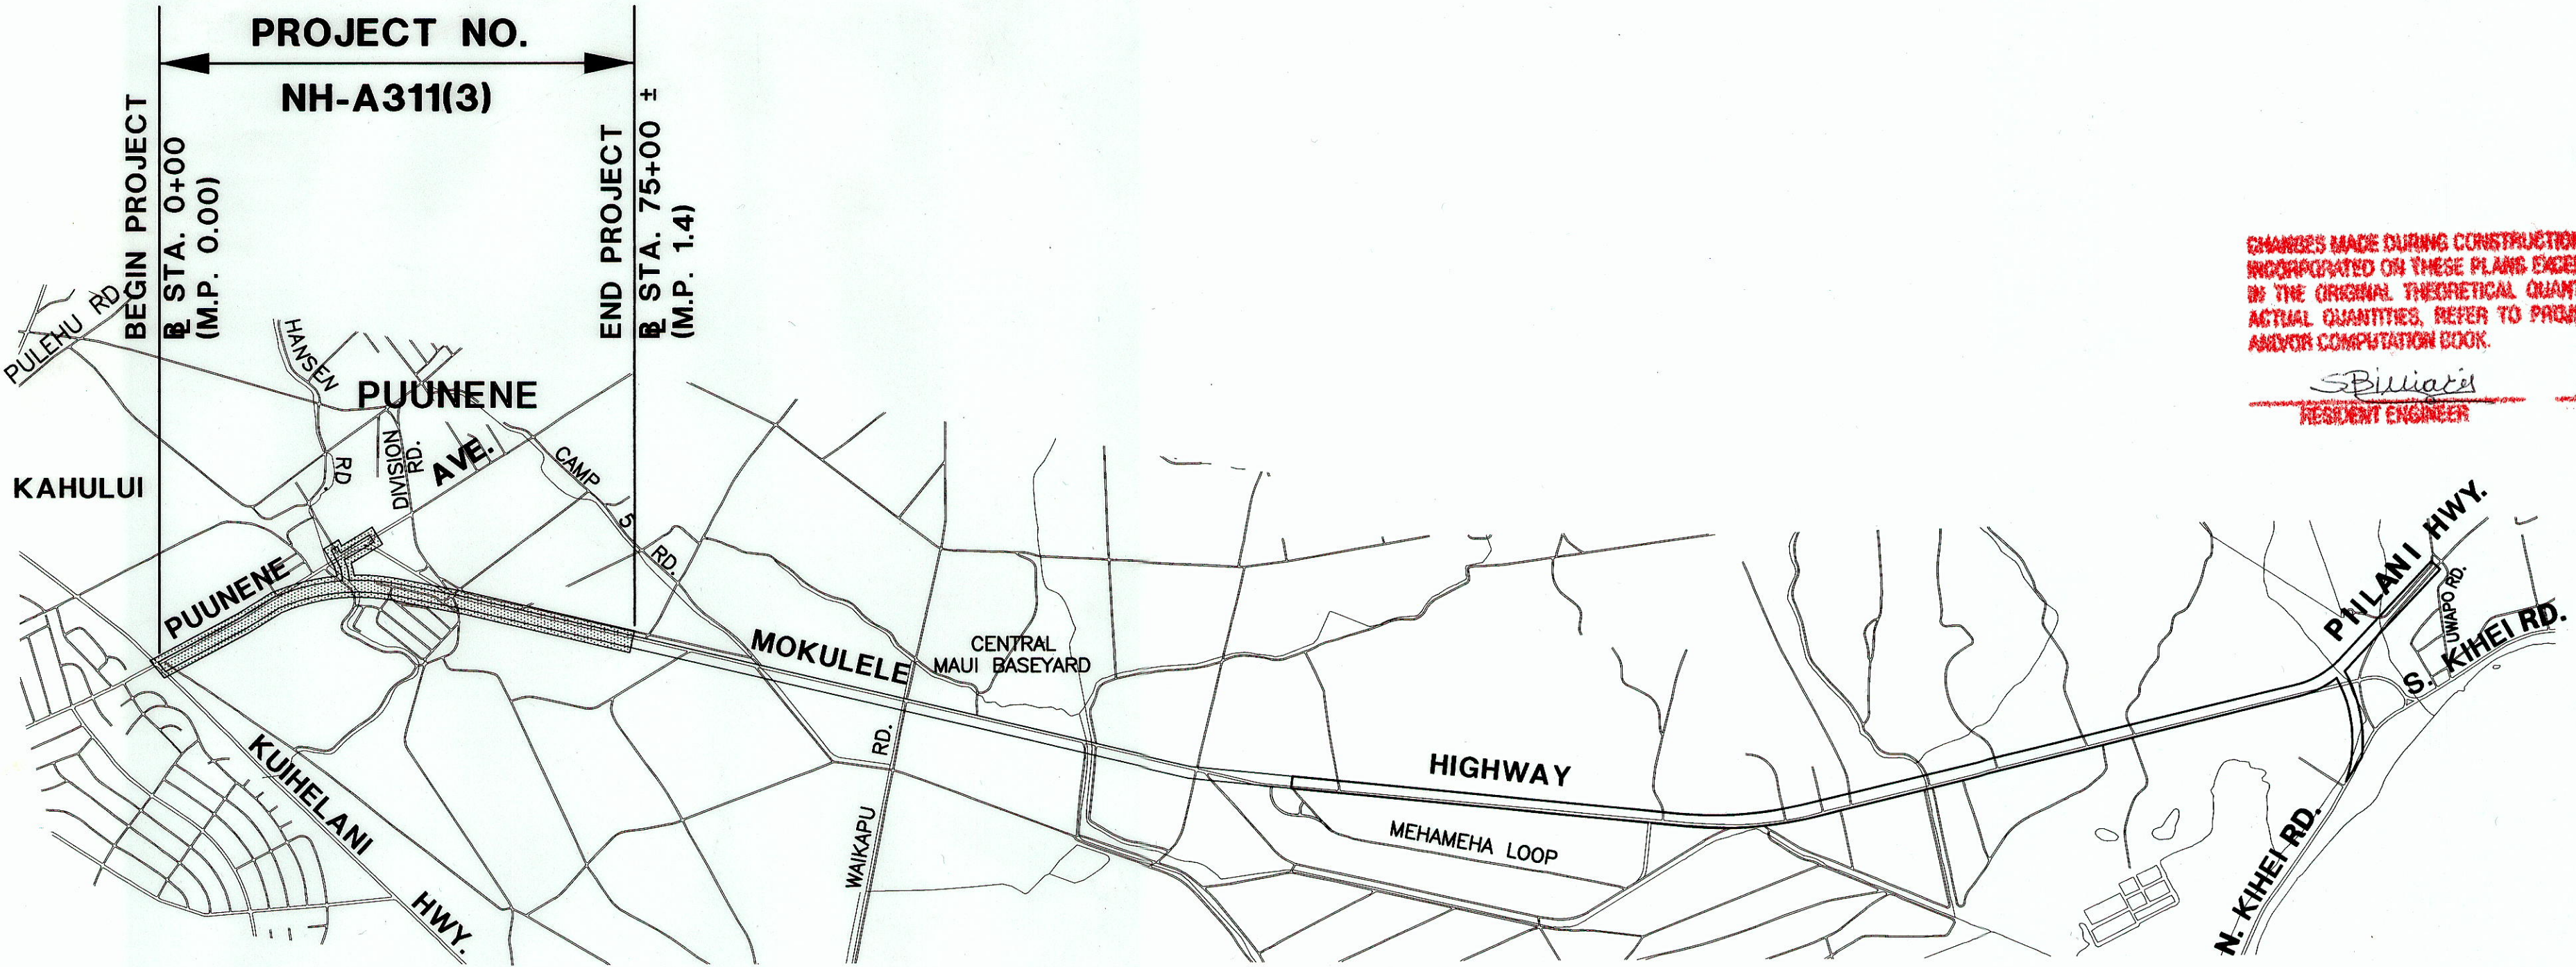

CHANGES MADE DURING CONSTRUCTION HAVE BEEN
INCORPORATED ON THESE PLANS EXCEPT CHANGES
IN THE ORIGINAL THEORETICAL QUANTITIES. FOR
ACTUAL QUANTITIES, REFER TO PROJECT LEDGER
AND/OR COMPUTATION BOOK.

Spiliadis 9/30/2014
RESIDENT ENGINEER DATE

	DESIGN	DESIGNATION
	PUUNENE AVE.	MOKULELE HWY.
ADT(2000)	24,150	25,000
ADT(2020)	33,750	40,650
DHV	2,700	3,250
KDES	8%	8%
D	60/40	52/48
TDES	7.4%	3.2%
T24	4.4%	2.4%
V	55 MPH	55 MPH

2 0 2 4
SCALE IN THOUSAND FEET



LAYOUT PLAN

GROSS LENGTH OF PROJECT 1.52 MILES
NET LENGTH OF PROJECT 1.52 MILES

Philani 10-12-01
for DIRECTOR, DATE
DEPARTMENT OF PUBLIC WORKS AND WASTE MANAGEMENT
COUNTY OF MAUI
(APPROVAL GRANTED FOR WORK WITHIN COUNTY RIGHT-OF-WAY ONLY)

DEPARTMENT OF TRANSPORTATION
STATE OF HAWAII
APPROVED: *Deputy* 11-7-01
for DIR. OF TRANSPORTATION DATE