


FED. ROAD DIST. NO.	STATE	FEDERAL - AID PROJ. NO.	FISCAL YEAR	SHEET NO.	TOTAL SHEETS
HAWAII	HAW.	NH-0311(5)	2003	13	189


True North
Scale: 1 inch = 40 feet

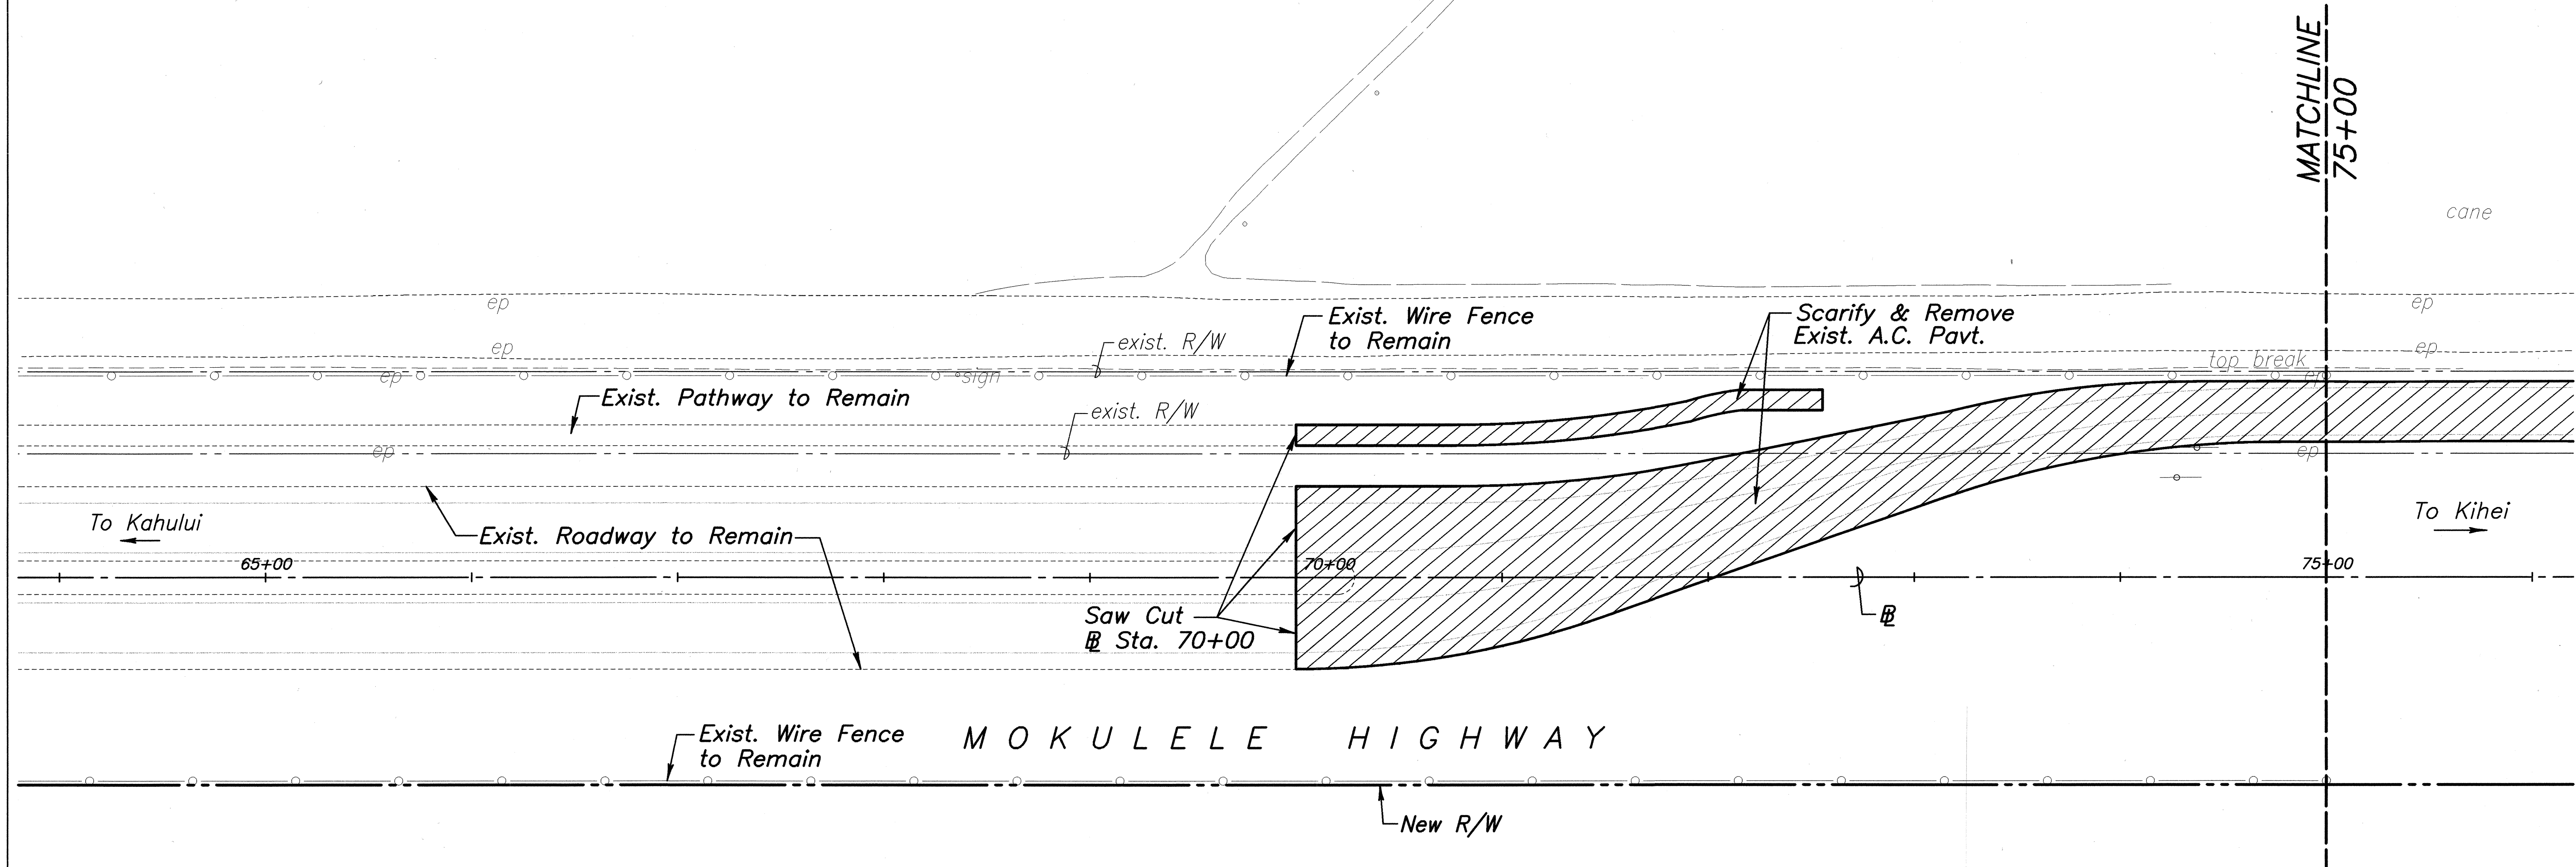

Notes:


1. For Power Pole & Telephone Pole Removal or Relocations, refer to Electrical Plans.
2. For Sign Removals or Relocations, refer to Signing & Pavement Marking Plan.
3. All trees, pavement, structures and obstructions within the project's right of way, shall be removed, unless otherwise noted on the plans. Removal of these items shall be considered incidental to clear and grub pay item.

ORIGINAL PLAN	SURVEY PLOTTED BY	DATE
NOTE BOOK	DRAWN BY	
	REVISIONS BY	
	QUANTITIES BY	
	CHECKED BY	
	No.	

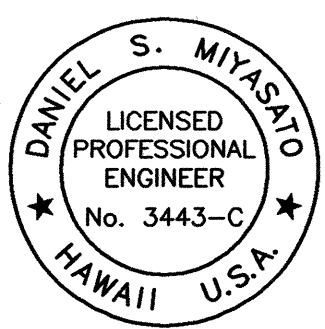 DANIEL S. MIYASATO LICENSED PROFESSIONAL ENGINEER No. 3443-C HAWAII U.S.A.	STATE OF HAWAII DEPARTMENT OF TRANSPORTATION HIGHWAYS DIVISION DEMOLITION PLAN MOKULELE HIGHWAY WIDENING Vicinity of Cane Haul Road To Maui Humane Society Federal - Aid Project No. NH-0311(5) Scale: 1"=40' Date: JUNE 2002	
	THIS WORK WAS PREPARED BY ME OR UNDER MY SUPERVISION	SHEET No. 1 OF 13 SHEETS
	SATO & ASSOCIATES, INC.	
	13	

FED. ROAD DIST. NO.	STATE	FEDERAL - AID PROJ. NO.	FISCAL YEAR	SHEET NO.	TOTAL SHEETS
HAWAII	HAW.	NH-0311(5)	2003	14	189

True North
Scale: 1 inch = 40 feet

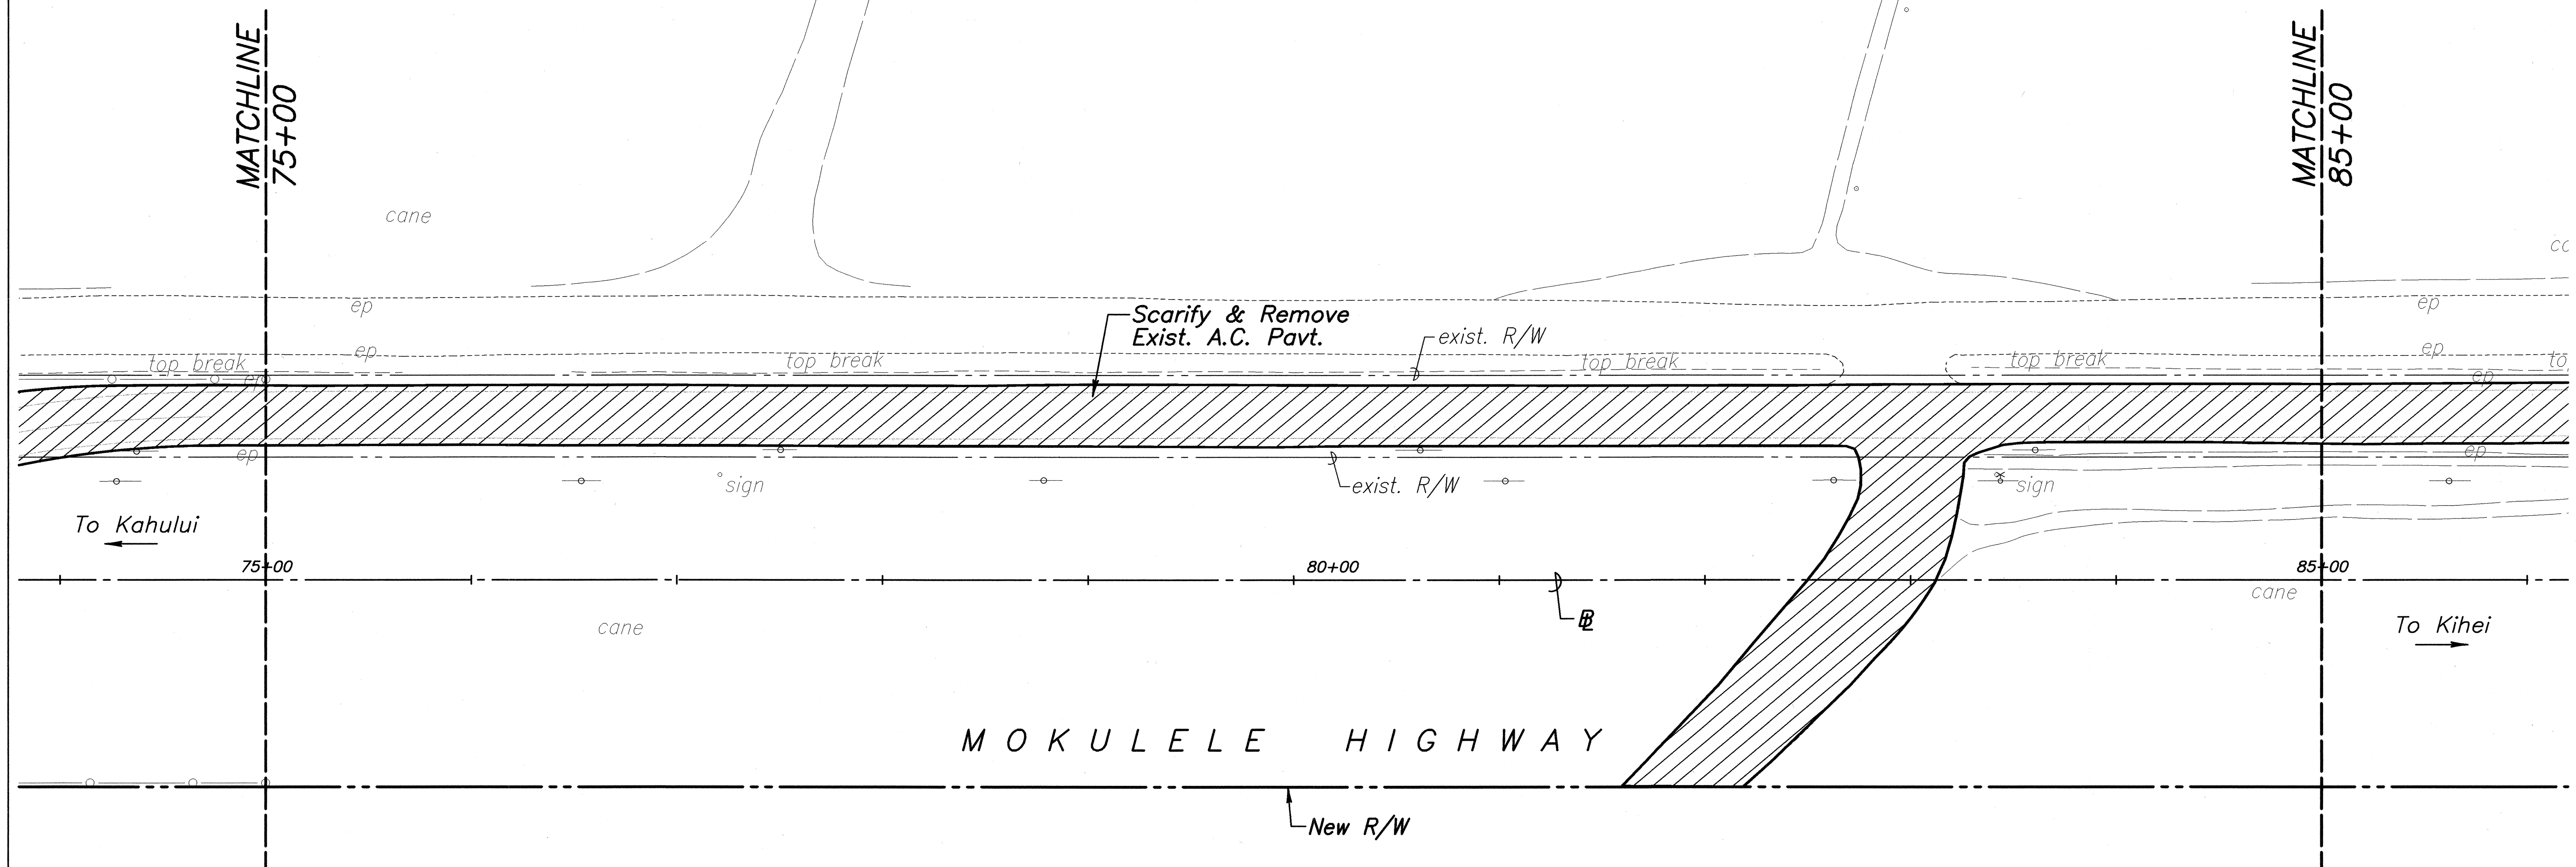

- Notes:**
1. For Power Pole & Telephone Pole Removal or Relocations, refer to Electrical Plans.
 2. For Sign Removals or Relocations, refer to Signing & Pavement Marking Plan.
 3. All trees, pavement, structures and obstructions within the project's right of way, shall be removed, unless otherwise noted on the plans. Removal of these items shall be considered incidental to clear and grub pay item.

ORIGINAL PLAN	SURVEY PLOTTED BY	DATE
NOTE BOOK	DRAWN BY	
	TRACED BY	
	DESIGNED BY	
	QUANTITIES BY	
	CHECKED BY	

DANIEL S. MIYASATO
LICENSED PROFESSIONAL ENGINEER
No. 3443-C
HAWAII U.S.A.

Daniel Miyasato
SATO & ASSOCIATES, INC.

THIS WORK WAS PREPARED BY ME OR UNDER MY SUPERVISION

STATE OF HAWAII
DEPARTMENT OF TRANSPORTATION
HIGHWAYS DIVISION


DEMOLITION PLAN

MOKULELE HIGHWAY WIDENING
Vicinity of Cane Haul Road
To Maui Humane Society
Federal - Aid Project No. NH-0311(5)
Scale: 1"=40' Date: JUNE 2002

SHEET No. 2 OF 13 SHEETS

FED. ROAD DIST. NO.	STATE	FEDERAL - AID PROJ. NO.	FISCAL YEAR	SHEET NO.	TOTAL SHEETS
HAWAII	HAW.	NH-0311(5)	2003	15	189

True North
Scale: 1 inch = 40 feet

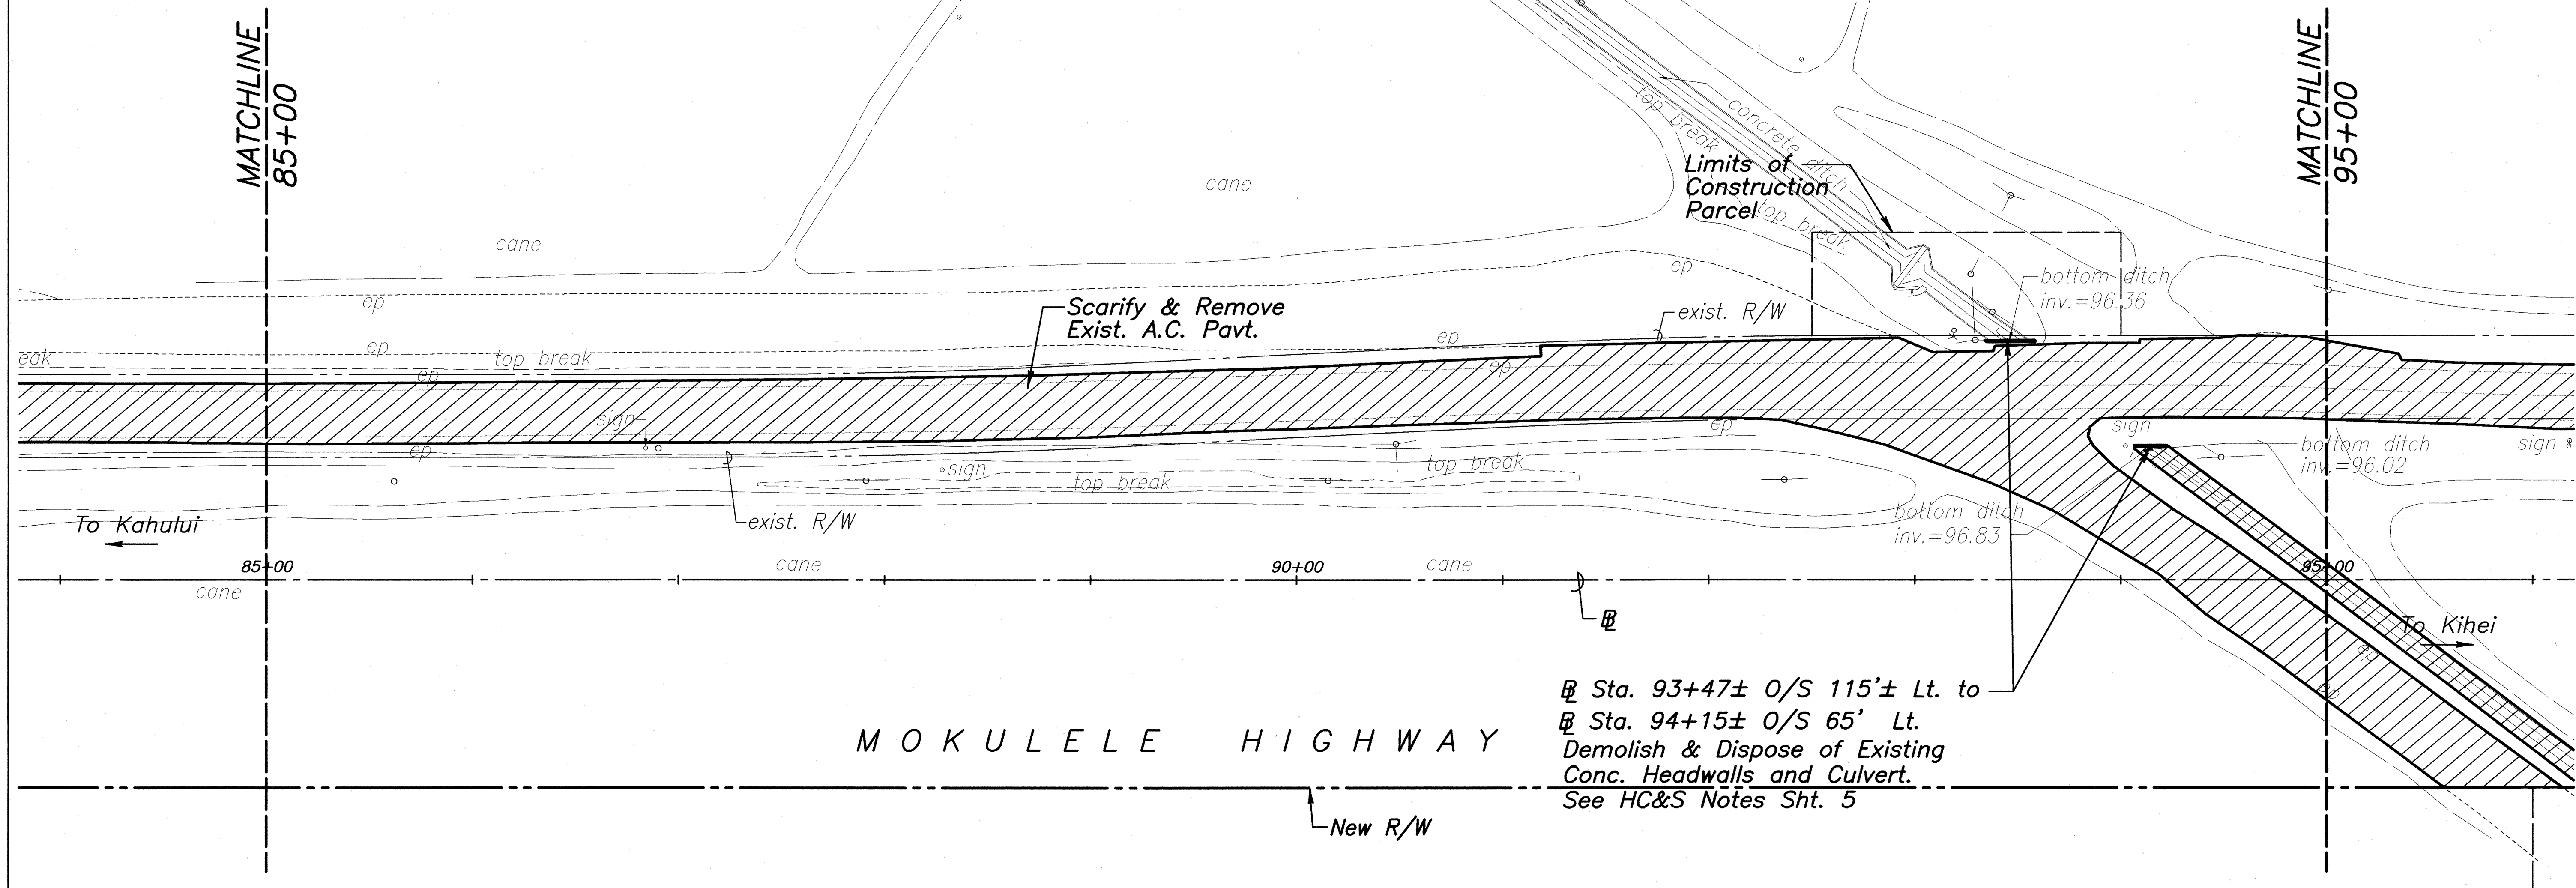

MOKULELE HIGHWAY

Notes:


1. For Power Pole & Telephone Pole Removal or Relocations, refer to Electrical Plans.
2. For Sign Removals or Relocations, refer to Signing & Pavement Marking Plan.
3. All trees, pavement, structures and obstructions within the project's right of way, shall be removed, unless otherwise noted on the plans. Removal of these items shall be considered incidental to clear and grub pay item.

ORIGINAL PLAN	SURVEY PLOTTED BY	DATE
NOTE BOOK	DRAWN BY	
	TRACED BY	
	QUANTITIES BY	
	CHECKED BY	
	No.	

	STATE OF HAWAII DEPARTMENT OF TRANSPORTATION HIGHWAYS DIVISION	
	DEMOLITION PLAN	
	MOKULELE HIGHWAY WIDENING Vicinity of Cane Haul Road To Maui Humane Society Federal - Aid Project No. NH-0311(5) Scale: 1"=40' Date: JUNE 2002	
	SHEET No. 3 OF 13 SHEETS	

FED. ROAD DIST. NO.	STATE	FEDERAL - AID PROJ. NO.	FISCAL YEAR	SHEET NO.	TOTAL SHEETS
HAWAII	HAW.	NH-0311(5)	2003	16	189

True North
Scale: 1 inch = 40 feet

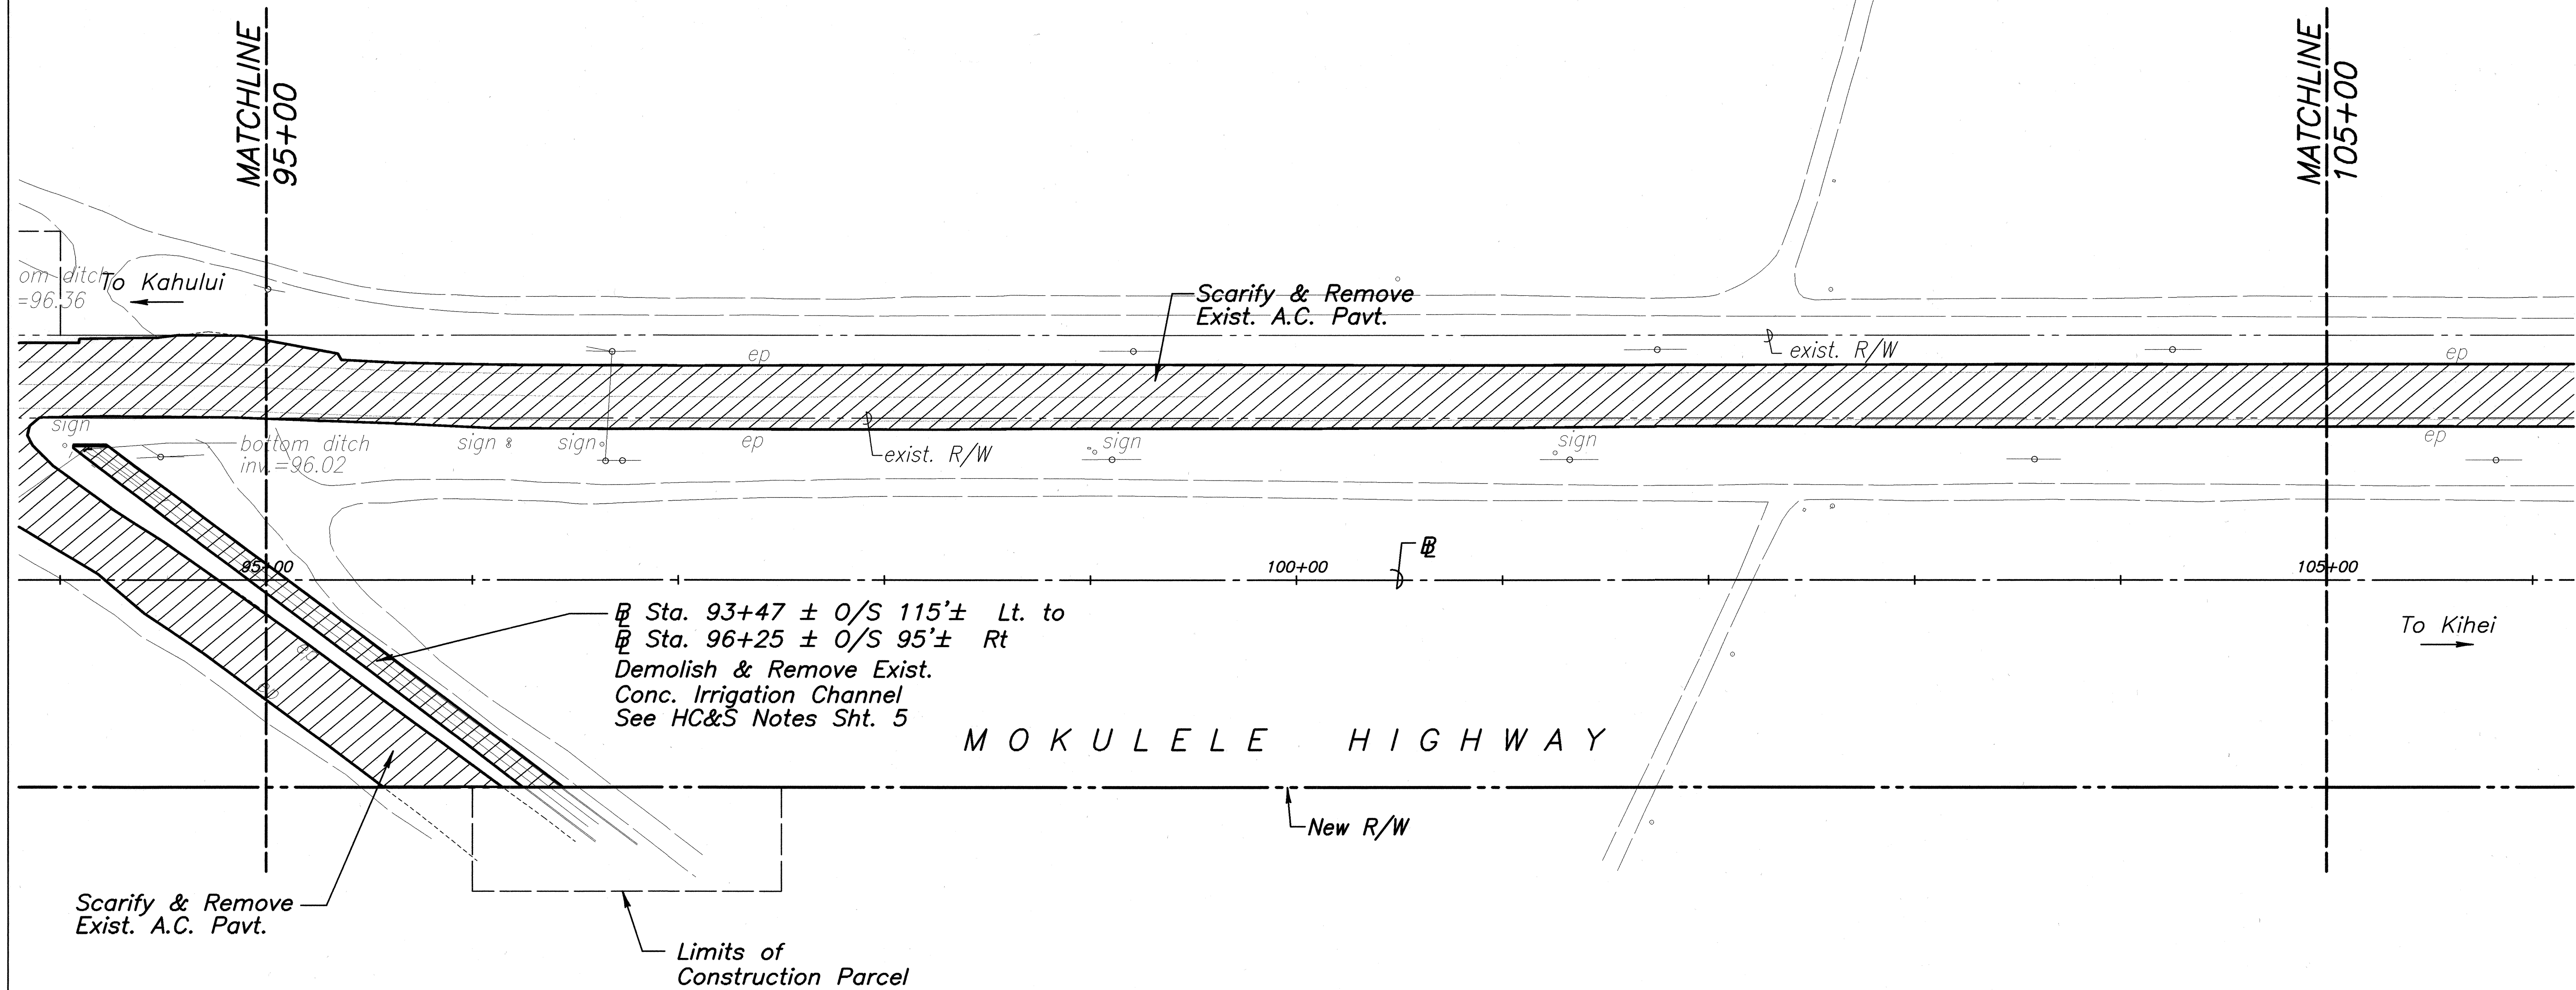

Notes:


1. For Power Pole & Telephone Pole Removal or Relocations, refer to Electrical Plans.
2. For Sign Removals or Relocations, refer to Signing & Pavement Marking Plan.
3. All trees, pavement, structures and obstructions within the project's right of way, shall be removed, unless otherwise noted on the plans. Removal of these items shall be considered incidental to clear and grub pay item.

ORIGINAL PLAN	SURVEY PLOTTED BY	DATE
NOTE BOOK	DRAWN BY	
	TRACED BY	
	QUANTITIES BY	
	CHECKED BY	
	No.	

	STATE OF HAWAII DEPARTMENT OF TRANSPORTATION HIGHWAYS DIVISION	
	DEMOLITION PLAN	
	MOKULELE HIGHWAY WIDENING Vicinity of Cane Haul Road	
	To Maui Humane Society Federal - Aid Project No. NH-0311(5) Scale: 1"=40' Date: JUNE 2002	
THIS WORK WAS PREPARED BY ME OR UNDER MY SUPERVISION		SHEET No. 4 OF 13 SHEETS

FED. ROAD DIST. NO.	STATE	FEDERAL - AID PROJ. NO.	FISCAL YEAR	SHEET NO.	TOTAL SHEETS
HAWAII	HAW.	NH-0311(5)	2003	17	189

True North
Scale: 1 inch = 40 feet

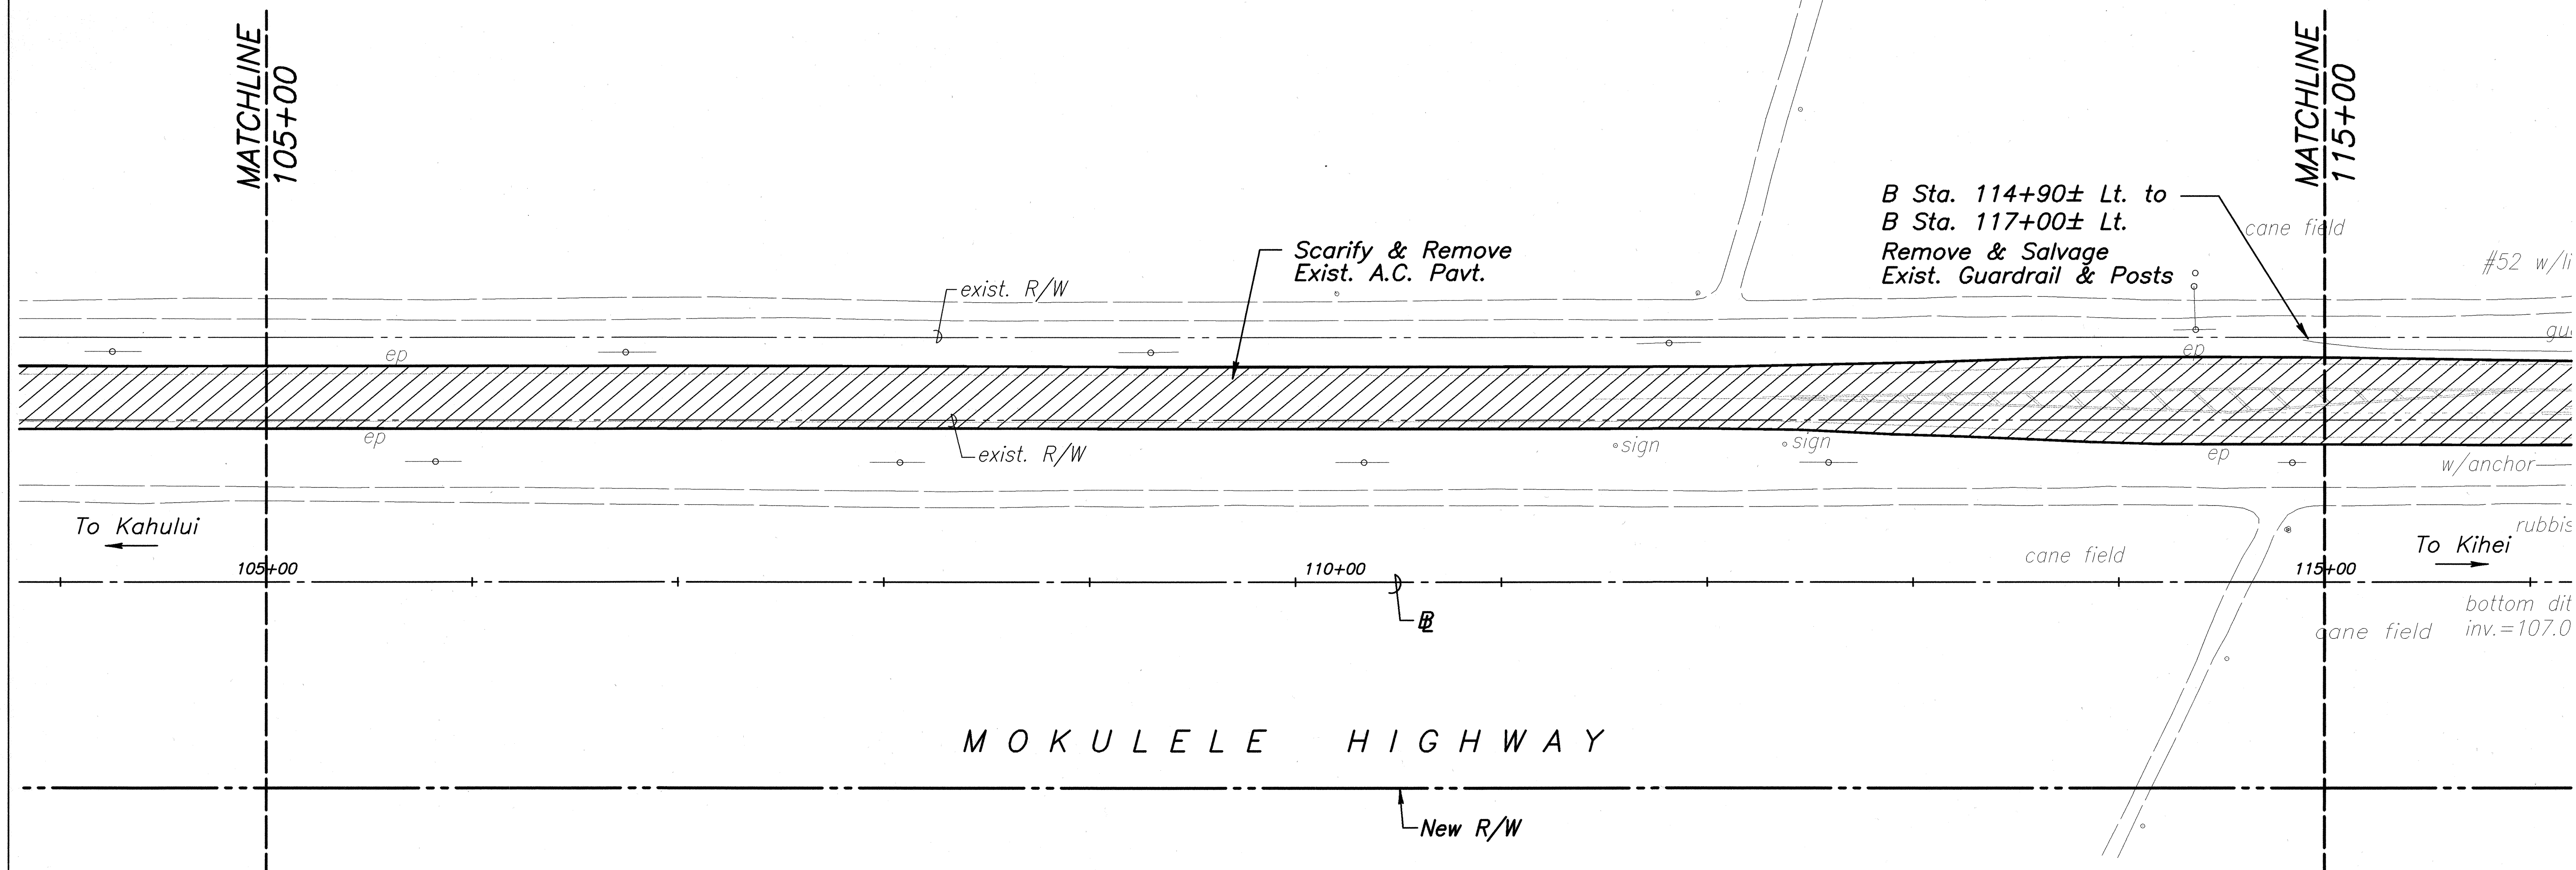


Notes:

1. For Power Pole & Telephone Pole Removal or Relocations, refer to Electrical Plans.
2. For Sign Removals or Relocations, refer to Signing & Pavement Marking Plan.
3. All trees, pavement, structures and obstructions within the project's right of way, shall be removed, unless otherwise noted on the plans. Removal of these items shall be considered incidental to clear and grub pay item.

ORIGINAL PLAN	SURVEY PLOTTED BY	DATE
NOTE BOOK	DRAWN BY	
	TRACED BY	
	DESIGNED BY	
	CHECKED BY	
	NO.	

	STATE OF HAWAII DEPARTMENT OF TRANSPORTATION HIGHWAYS DIVISION
	DEMOLITION PLAN
	MOKULELE HIGHWAY WIDENING
	Vicinity of Cane Haul Road
	To Maui Humane Society
	Federal - Aid Project No. NH-0311(5)
THIS WORK WAS PREPARED BY ME OR UNDER MY SUPERVISION	Scale: 1"=40' Date: JUNE 2002
	SHEET No. 5 OF 13 SHEETS

FED. ROAD DIST. NO.	STATE	FEDERAL - AID PROJ. NO.	FISCAL YEAR	SHEET NO.	TOTAL SHEETS
HAWAII	HAW.	NH-0311(5)	2003	18	189

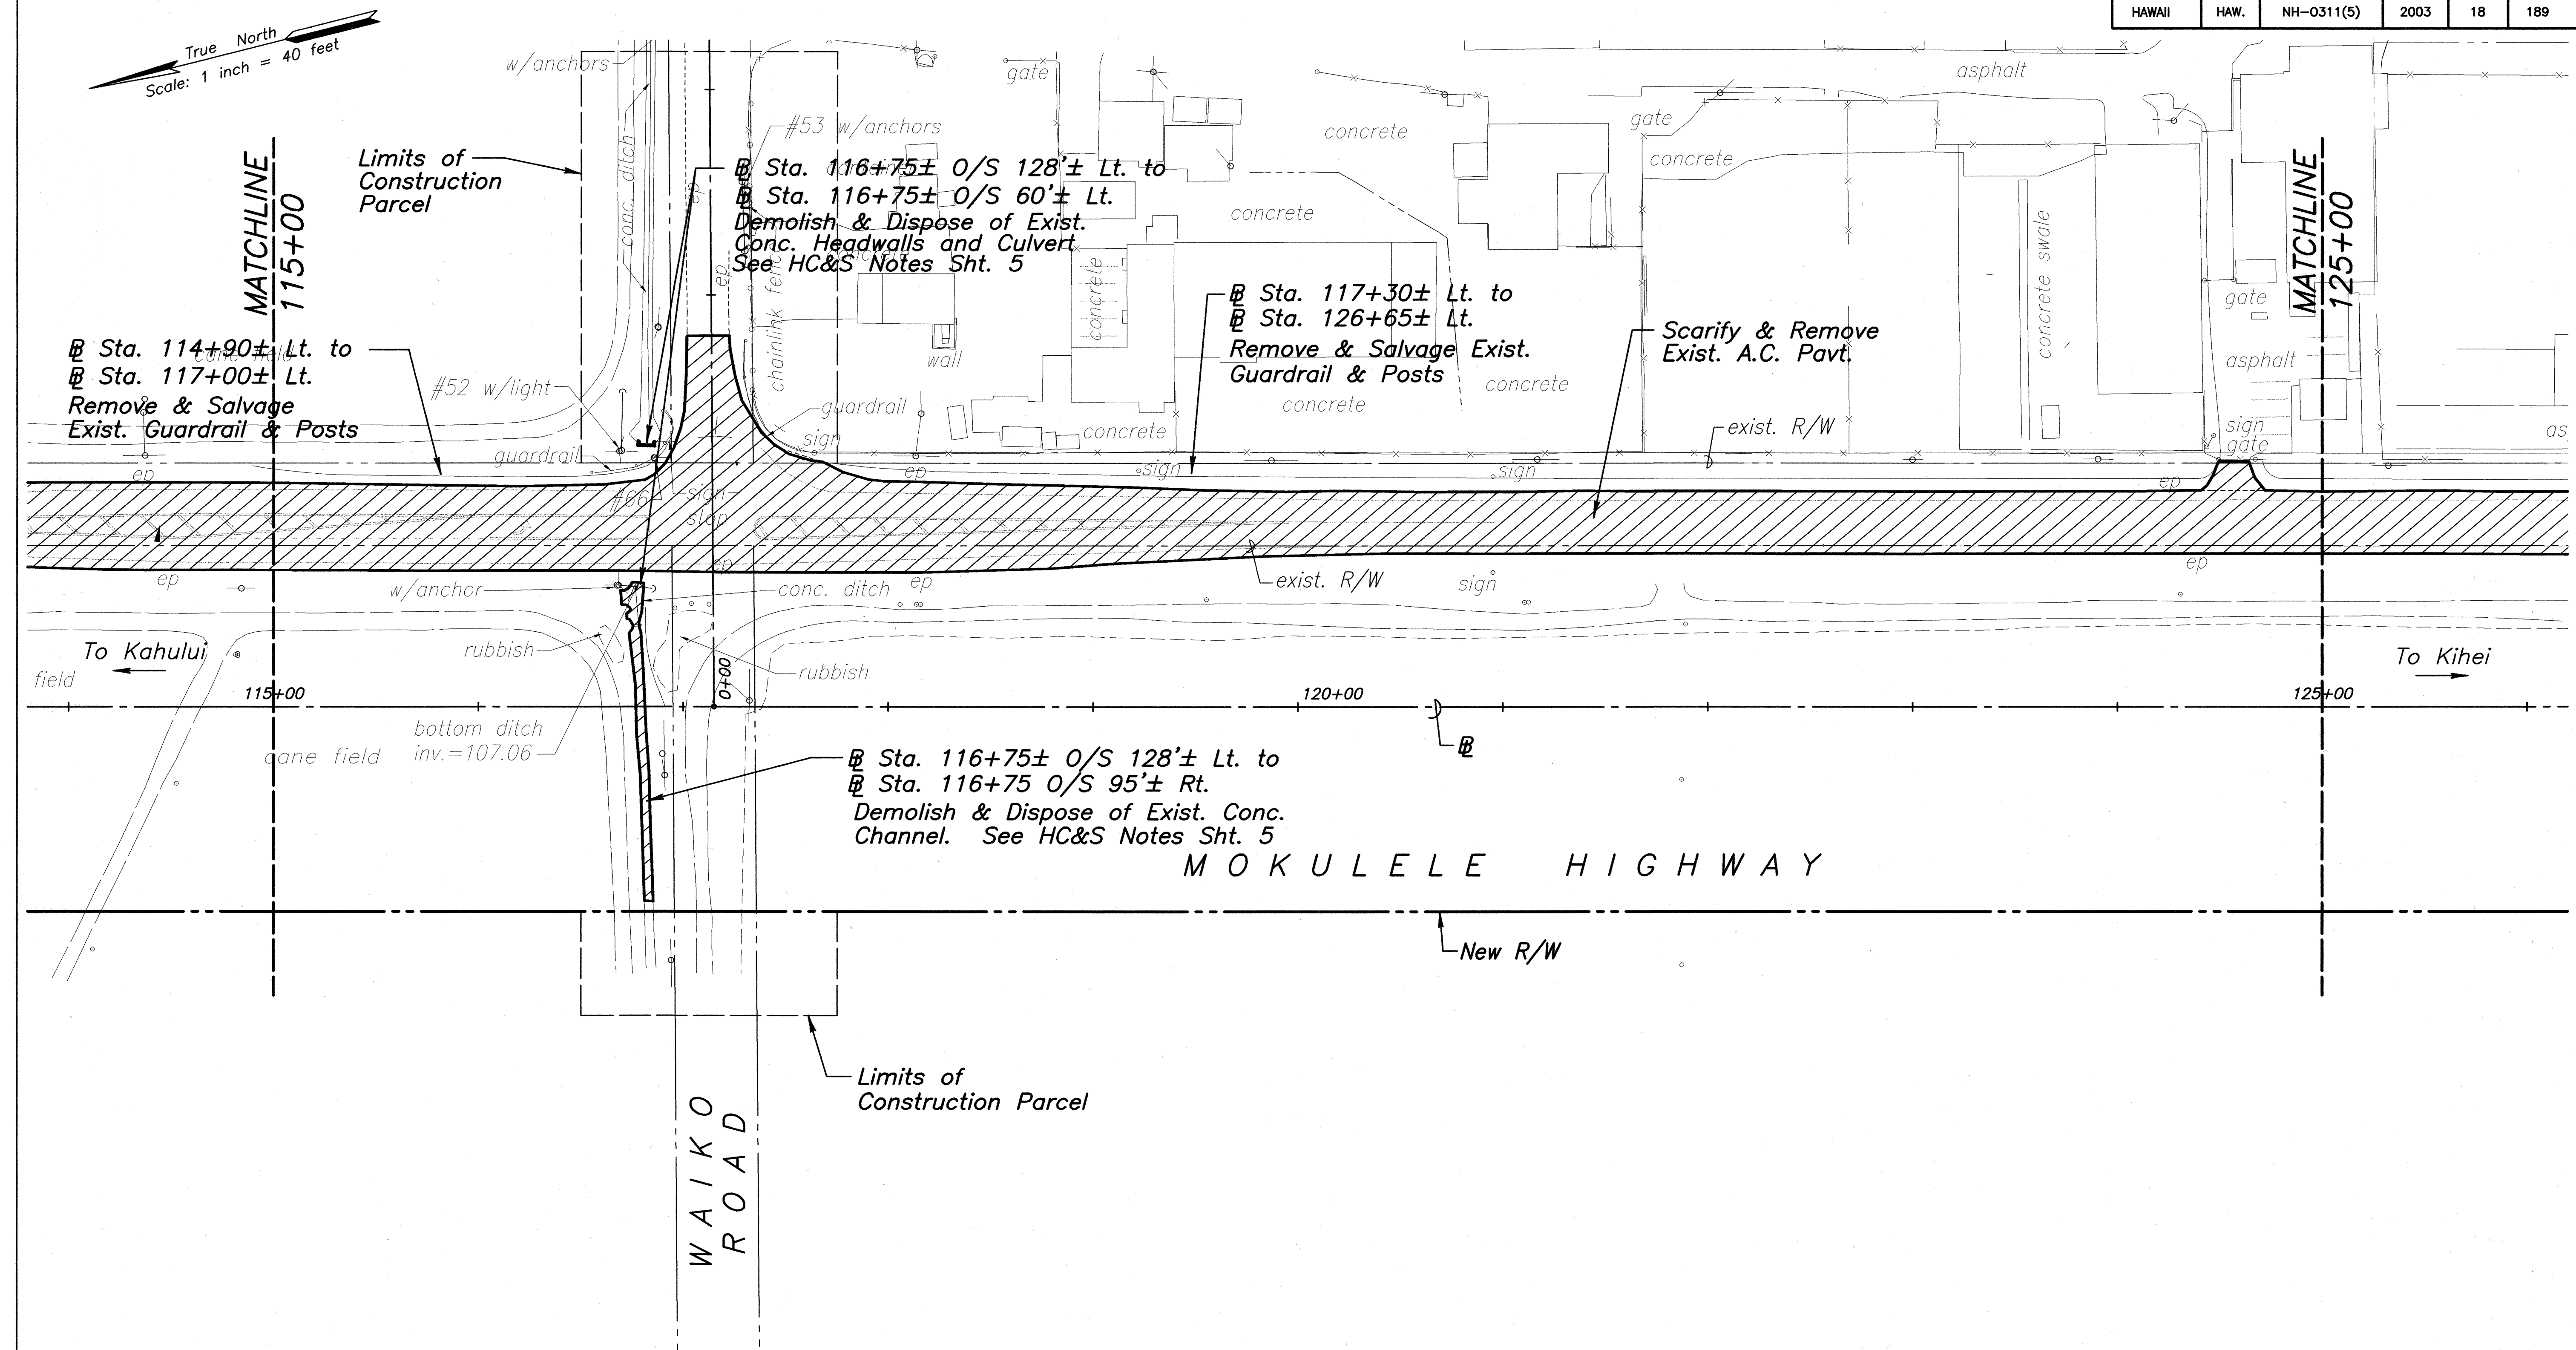

- Notes:**
1. For Power Pole & Telephone Pole Removal or Relocations, refer to Electrical Plans.
 2. For Sign Removals or Relocations, refer to Signing & Pavement Marking Plan.
 3. All trees, pavement, structures and obstructions within the project's right of way, shall be removed, unless otherwise noted on the plans. Removal of these items shall be considered incidental to clear and grub pay item.

ORIGINAL PLAN	SURVEY PLOTTED BY	DATE
NOTE BOOK	DRAWN BY	
	RECEIVED BY	
	QUANTITIES BY	
	CHECKED BY	

DANIEL S. MIYASATO
LICENSED PROFESSIONAL ENGINEER
No. 3443-C
HAWAII U.S.A.

STATE OF HAWAII
DEPARTMENT OF TRANSPORTATION
HIGHWAYS DIVISION

DEMOLITION PLAN

MOKULELE HIGHWAY WIDENING

Vicinity of Cane Haul Road


To
Maui Humane Society

Federal - Aid Project No. NH-0311(5)

Scale: 1"=40' Date: JUNE 2002

SHEET No. 6 OF 13 SHEETS

FED. ROAD DIST. NO.	STATE	FEDERAL - AID PROJ. NO.	FISCAL YEAR	SHEET NO.	TOTAL SHEETS
HAWAII	HAW.	NH-0311(5)	2003	19	189

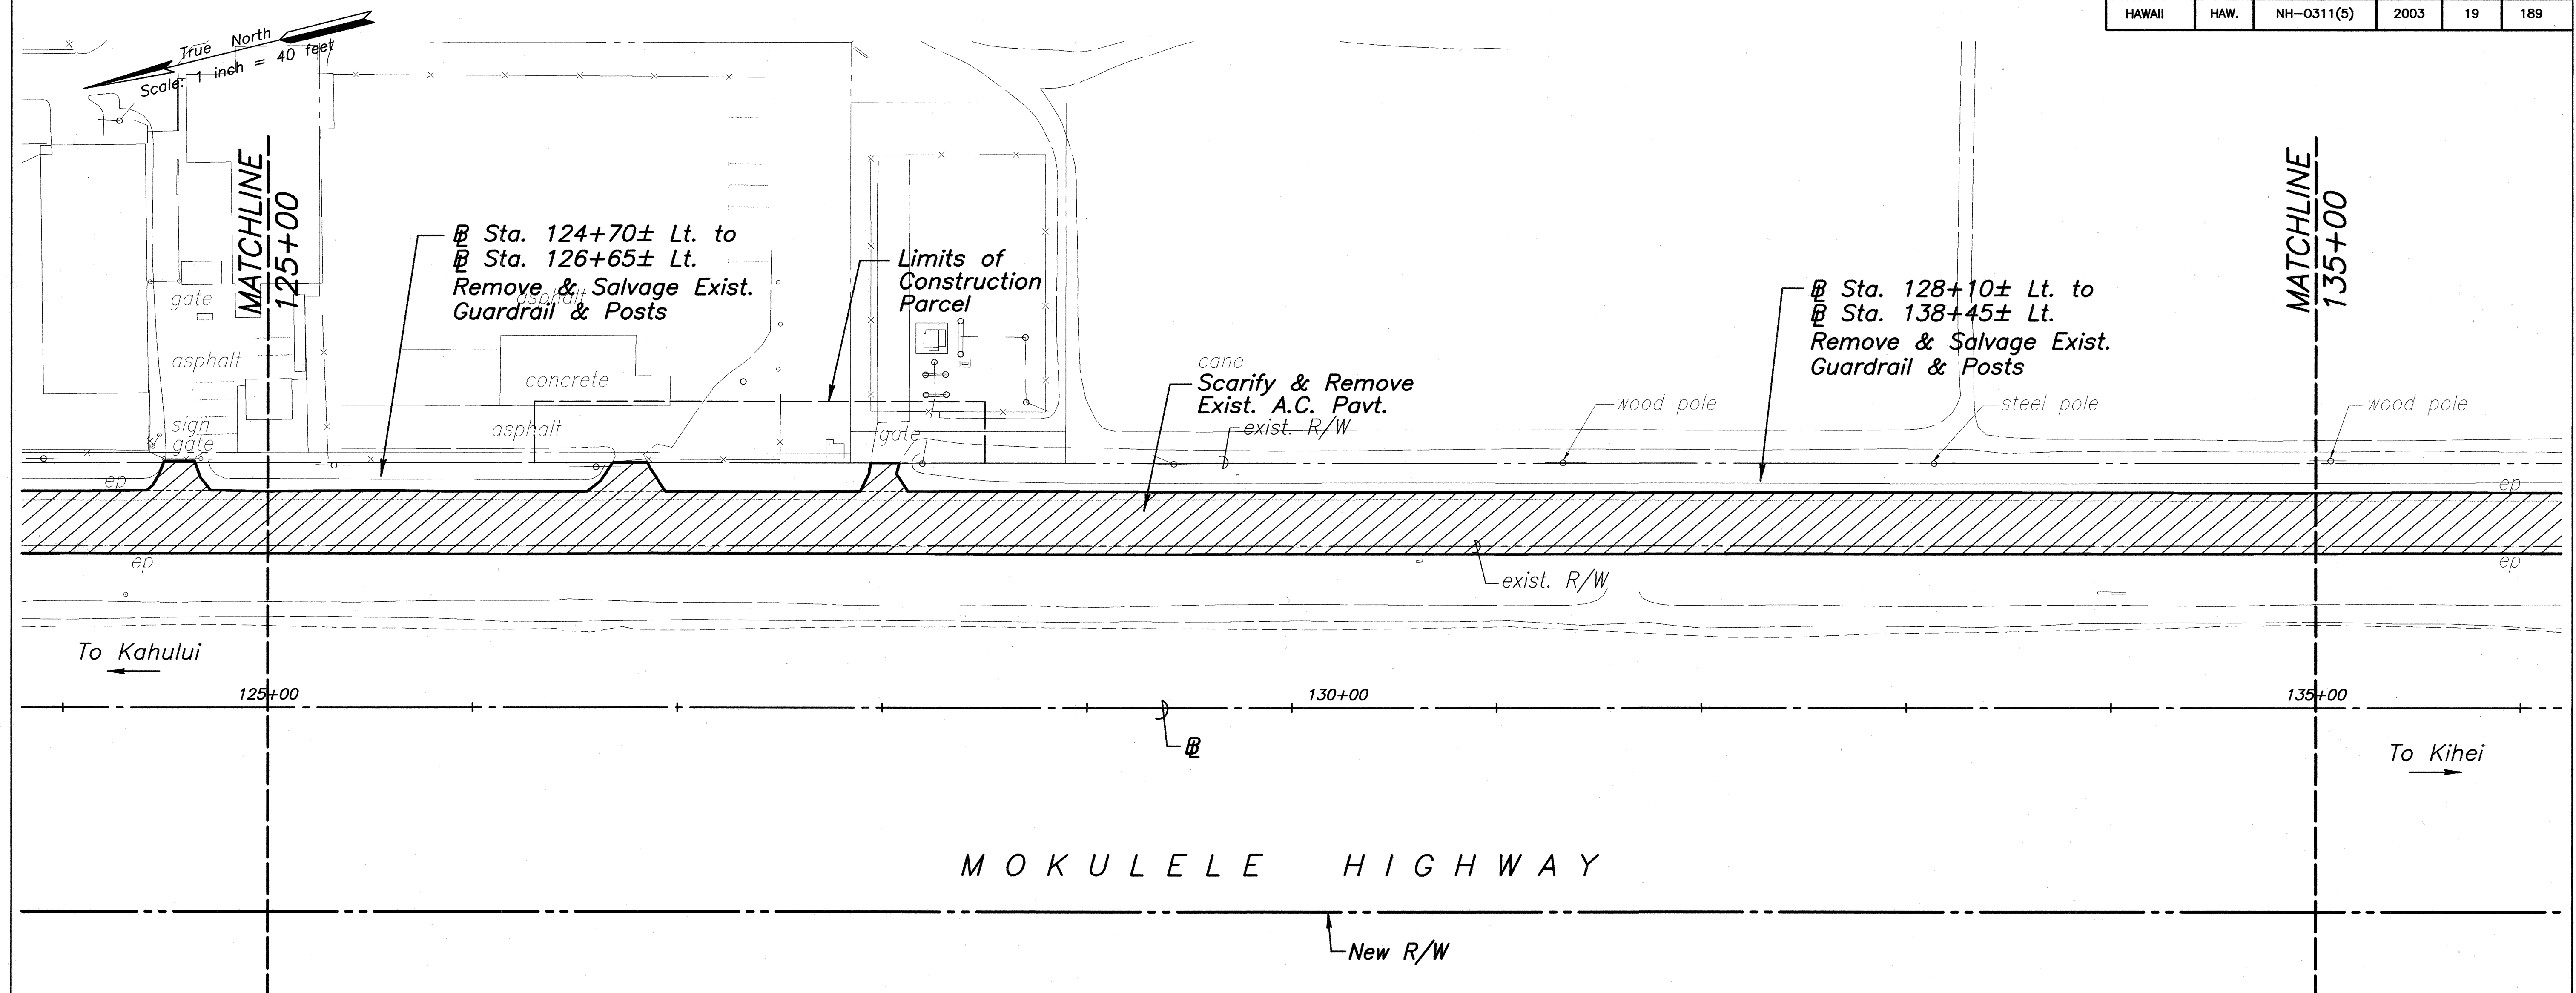

- Notes:**
1. For Power Pole & Telephone Pole Removal or Relocations, refer to Electrical Plans.
 2. For Sign Removals or Relocations, refer to Signing & Pavement Marking Plan.
 3. All trees, pavement, structures and obstructions within the project's right of way, shall be removed, unless otherwise noted on the plans. Removal of these items shall be considered incidental to clear and grub pay item.

STATE OF HAWAII
DEPARTMENT OF TRANSPORTATION
HIGHWAYS DIVISION

DEMOLITION PLAN

MOKULELE HIGHWAY WIDENING

Vicinity of Cane Haul Road

To
Maui Humane Society

Federal - Aid Project No. NH-0311(5)

Scale: 1"=40' Date: JUNE 2002

SHEET No. 7 OF 13 SHEETS

DANIEL S. MIYASHIRO
LICENSED PROFESSIONAL ENGINEER
No. 3443-C
HAWAII U.S.A.

Daniel Miyashiro
SATO & ASSOCIATES, INC.


THIS WORK WAS PREPARED BY ME OR UNDER MY SUPERVISION

THIS WORK WAS PREPARED BY ME OR UNDER MY SUPERVISION

ORIGINAL PLAN	DATE
DESIGNED BY	
TRACED BY	
NOTED BY	
CHECKED BY	
NO.	

FED. ROAD DIST. NO.	STATE	FEDERAL - AID PROJ. NO.	FISCAL YEAR	SHEET NO.	TOTAL SHEETS
HAWAII	HAW.	NH-0311(5)	2003	20	189

True North
Scale: 1 inch = 40 feet

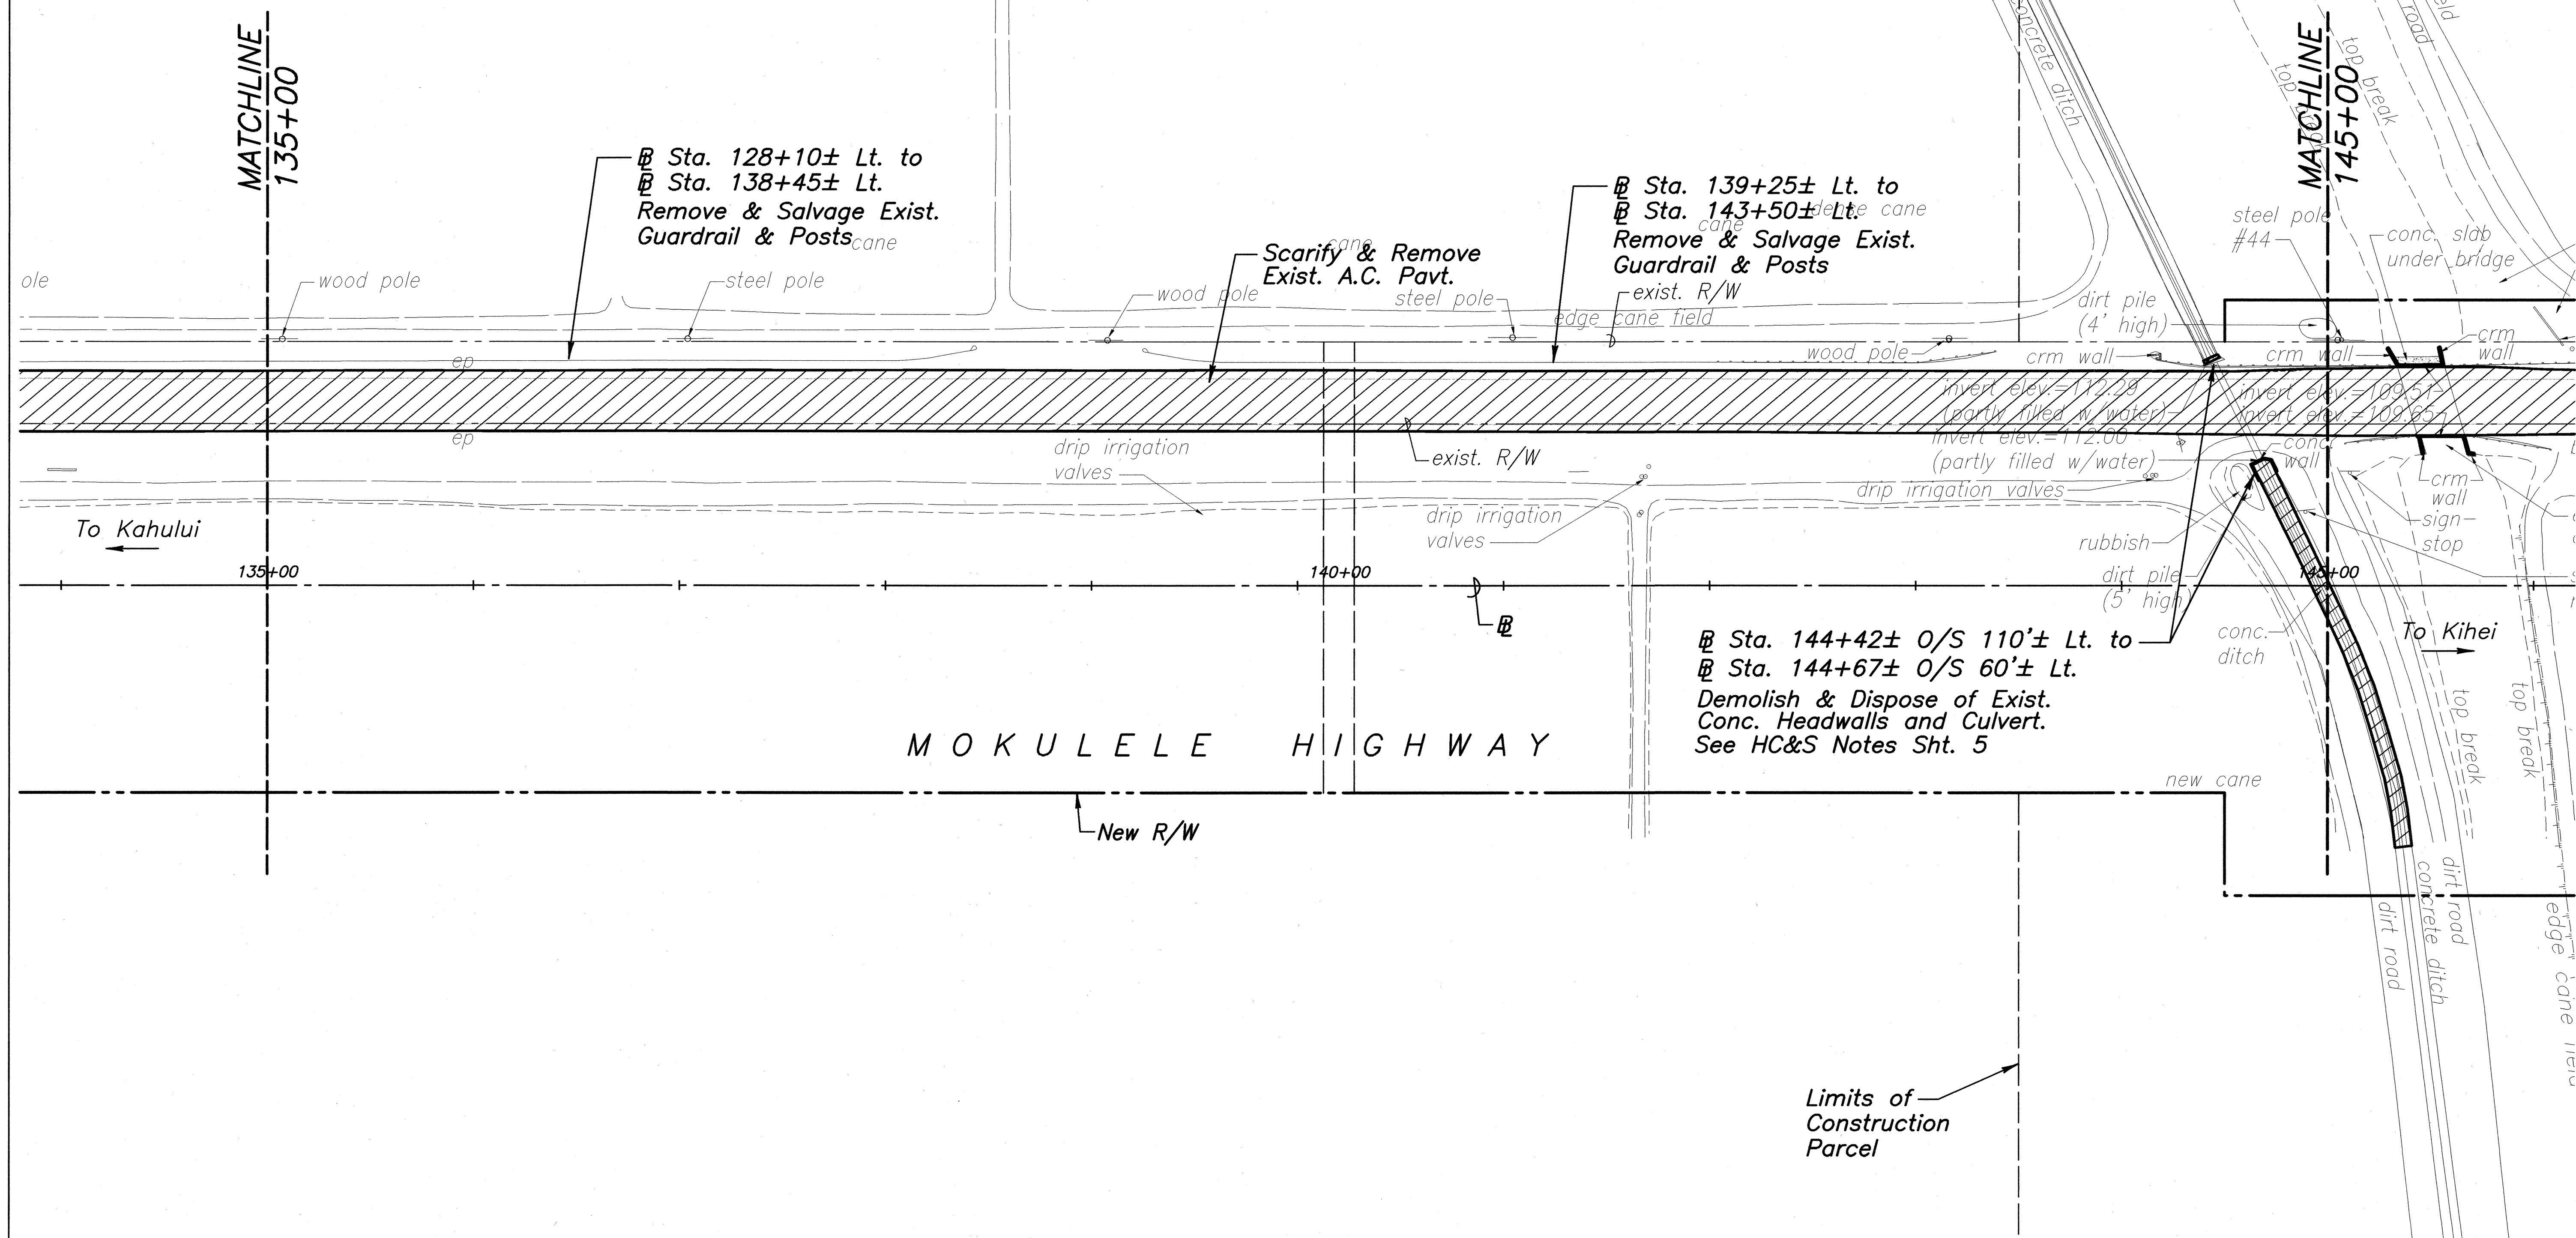

- Notes:**
1. For Power Pole & Telephone Pole Removal or Relocations, refer to Electrical Plans.
 2. For Sign Removals or Relocations, refer to Signing & Pavement Marking Plan.
 3. All trees, pavement, structures and obstructions within the project's right of way, shall be removed, unless otherwise noted on the plans. Removal of these items shall be considered incidental to clear and grub pay item.

ORIGINAL PLAN	SURVEY PLOTTED BY	DATE
NOTED BY	DRAWN BY	
CHECKED BY	REVIEWED BY	
	QUANTITIES BY	
	CHECKED BY	

DANIEL S. MIYASATO
LICENSED PROFESSIONAL ENGINEER
No. 3443-C
HAWAII, U.S.A.

STATE OF HAWAII
DEPARTMENT OF TRANSPORTATION
HIGHWAYS DIVISION

DEMOLITION PLAN

MOKULELE HIGHWAY WIDENING

Vicinity of Cane Haul Road

To
Maui Humane Society


Federal - Aid Project No. NH-0311(5)

Scale: 1"=40' Date: JUNE 2002

THIS WORK WAS PREPARED BY
ME OR UNDER MY SUPERVISION

SHEET No. 8 OF 13 SHEETS

FED. ROAD DIST. NO.	STATE	FEDERAL - AID PROJ. NO.	FISCAL YEAR	SHEET NO.	TOTAL SHEETS
HAWAII	HAW.	NH-0311(5)	2003	21	189

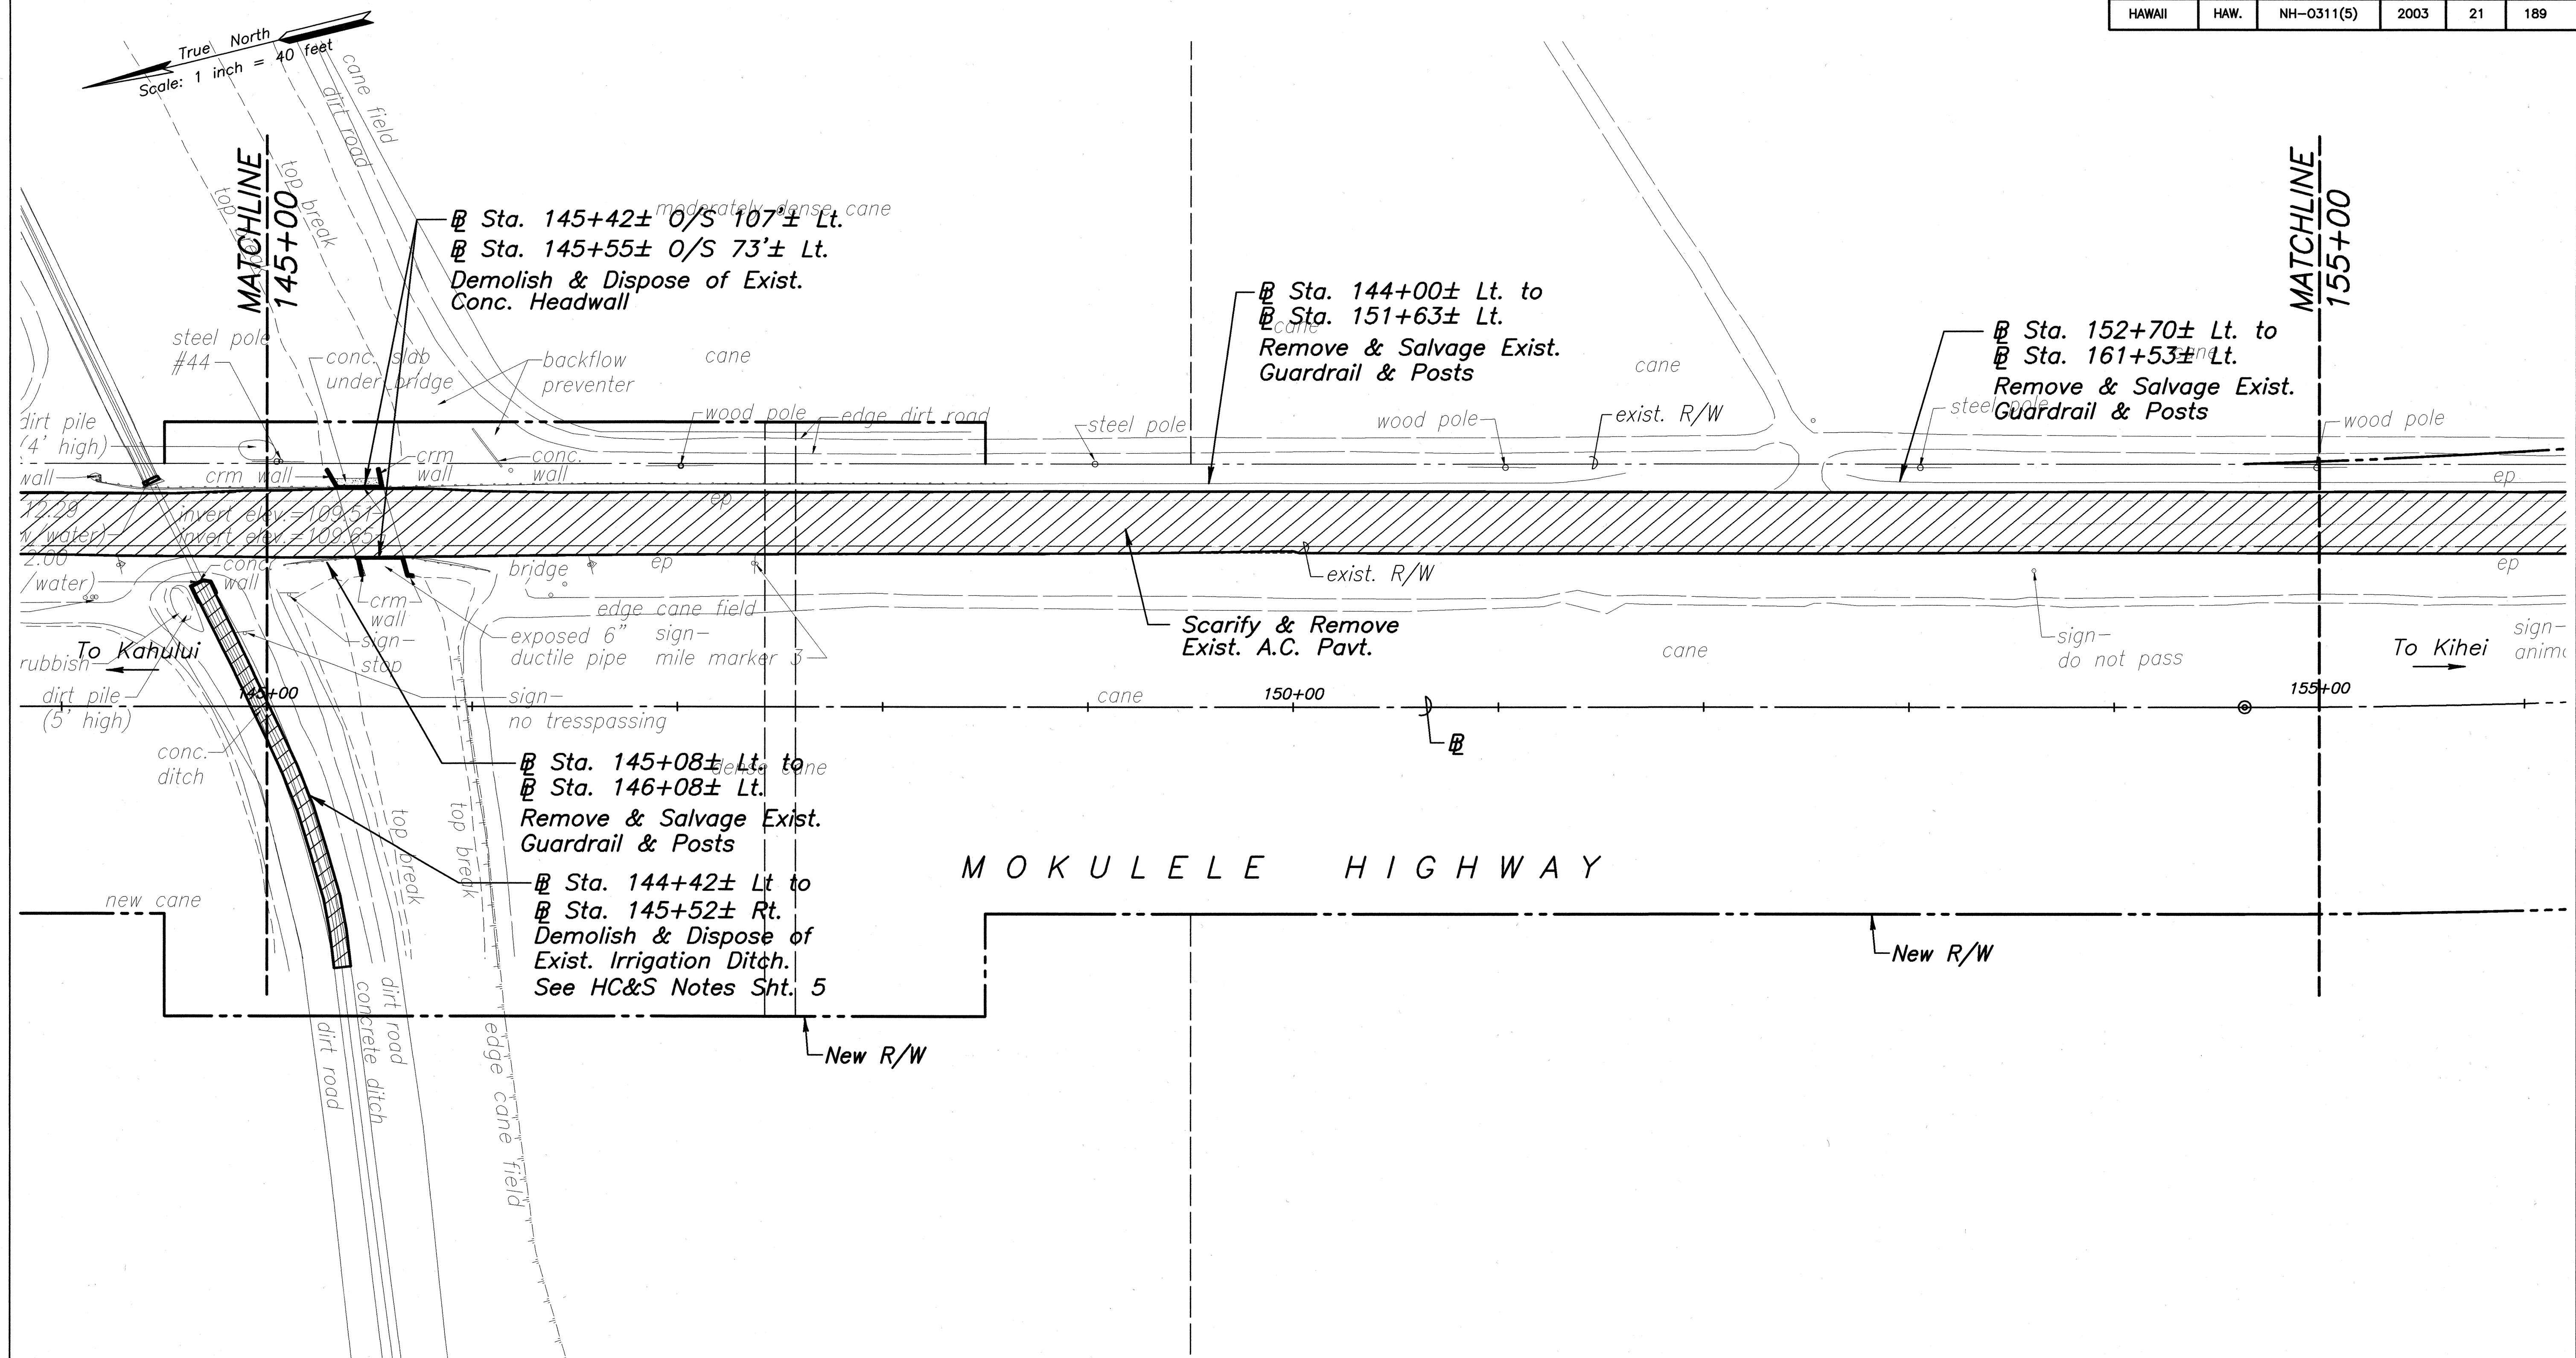

- Notes:**
1. For Power Pole & Telephone Pole Removal or Relocations, refer to Electrical Plans.
 2. For Sign Removals or Relocations, refer to Signing & Pavement Marking Plan.
 3. All trees, pavement, structures and obstructions within the project's right of way, shall be removed, unless otherwise noted on the plans. Removal of these items shall be considered incidental to clear and grub pay item.

THIS WORK WAS PREPARED BY ME OR UNDER MY SUPERVISION

STATE OF HAWAII
DEPARTMENT OF TRANSPORTATION
HIGHWAYS DIVISION

DEMOLITION PLAN

MOKULELE HIGHWAY WIDENING
Vicinity of Cane Haul Road

To
Maui Humane Society
Federal - Aid Project No. NH-0311(5)

Scale: 1"=40' Date: JUNE 2002

SHEET No. 9 OF 13 SHEETS

ORIGINAL PLAN	DATE
DRAWN BY	
TRACED BY	
REVISIONS BY	
QUANTITIES BY	
CHECKED BY	
No.	

FED. ROAD DIST. NO.	STATE	FEDERAL - AID PROJ. NO.	FISCAL YEAR	SHEET NO.	TOTAL SHEETS
HAWAII	HAW.	NH-0311(5)	2003	22	189

True North
Scale: 1 inch = 40 feet

MATCHLINE
155+00

MATCHLINE
165+00

canoe
steel pole
wood pole
ep
sign-do not pass
155+00
To Kahului

Sta. 152+70± Lt. to
Sta. 161+53± Lt.
Remove & Salvage Exist.
Guardrail & Posts
steel pole
wood pole
sign-speed limit 45
minimum 35
Scarify & Remove
Exist. A.C. Pavt.

canoe
sign-hc&s 901
sign-stop
exist. R/W
steel pole
guardrail
#40
sign-pass w/ zone
signs
emergency call box
wood pole w/anchors
#46 wood pole w/anchors
steel pole w/anchors
wood pole w/anchors
a.c. pavement (poor condition)
broken asphalt
#83 w/anchor

Limits of
Construction Parcel
conc. sign
quarry
arm wall
steel pole
w/6 anchors
sign-no right turn
canoe
sign-stop
sign-con
pag
wood po
w/anch
sign-do not enter
yellow line

sign-animal shelter
sign-intersection
exist. R/W
160+00
MOKULELE HIGHWAY
New R/W
dirt road
edge cane field
edge cane field

To Kihei
sign-stop
sign-con
pag
wood po
w/anch
sign-do not enter
yellow line

Notes:

1. For Power Pole & Telephone Pole Removal or Relocations, refer to Electrical Plans.
2. For Sign Removals or Relocations, refer to Signing & Pavement Marking Plan.
3. All trees, pavement, structures and obstructions within the project's right of way, shall be removed, unless otherwise noted on the plans. Removal of these items shall be considered incidental to clear and grub pay item.

DANIEL S. MIYASATO
LICENSED PROFESSIONAL ENGINEER
No. 3443-C
HAWAII U.S.A.

STATE OF HAWAII
DEPARTMENT OF TRANSPORTATION
HIGHWAYS DIVISION

DEMOLITION PLAN

MOKULELE HIGHWAY WIDENING

Vicinity of Cane Haul Road

 
To
Maui Humane Society

Federal - Aid Project No. NH-0311(5)

Scale: 1"=40' Date: JUNE 2002


SHEET No. 10 OF 13 SHEETS

1. *For Power Pole & Telephone Pole Removal or Relocations, refer to Electrical Plans.*
2. *For Sign Removals or Relocations, refer to Signing & Pavement Marking Plan.*
3. *All trees, pavement, structures and obstructions within the project's right of way, shall be removed, unless otherwise noted on the plans. Removal of these items shall be considered incidental to clear and grub pay item.*



FED. ROAD DIST. NO.	STATE	FEDERAL - AID PROJ. NO.	FISCAL YEAR	SHEET NO.	TOTAL SHEETS
HAWAII	HAW.	NH-0311(5)	2003	23	189

True North
Scale: 1 inch = 40 feet

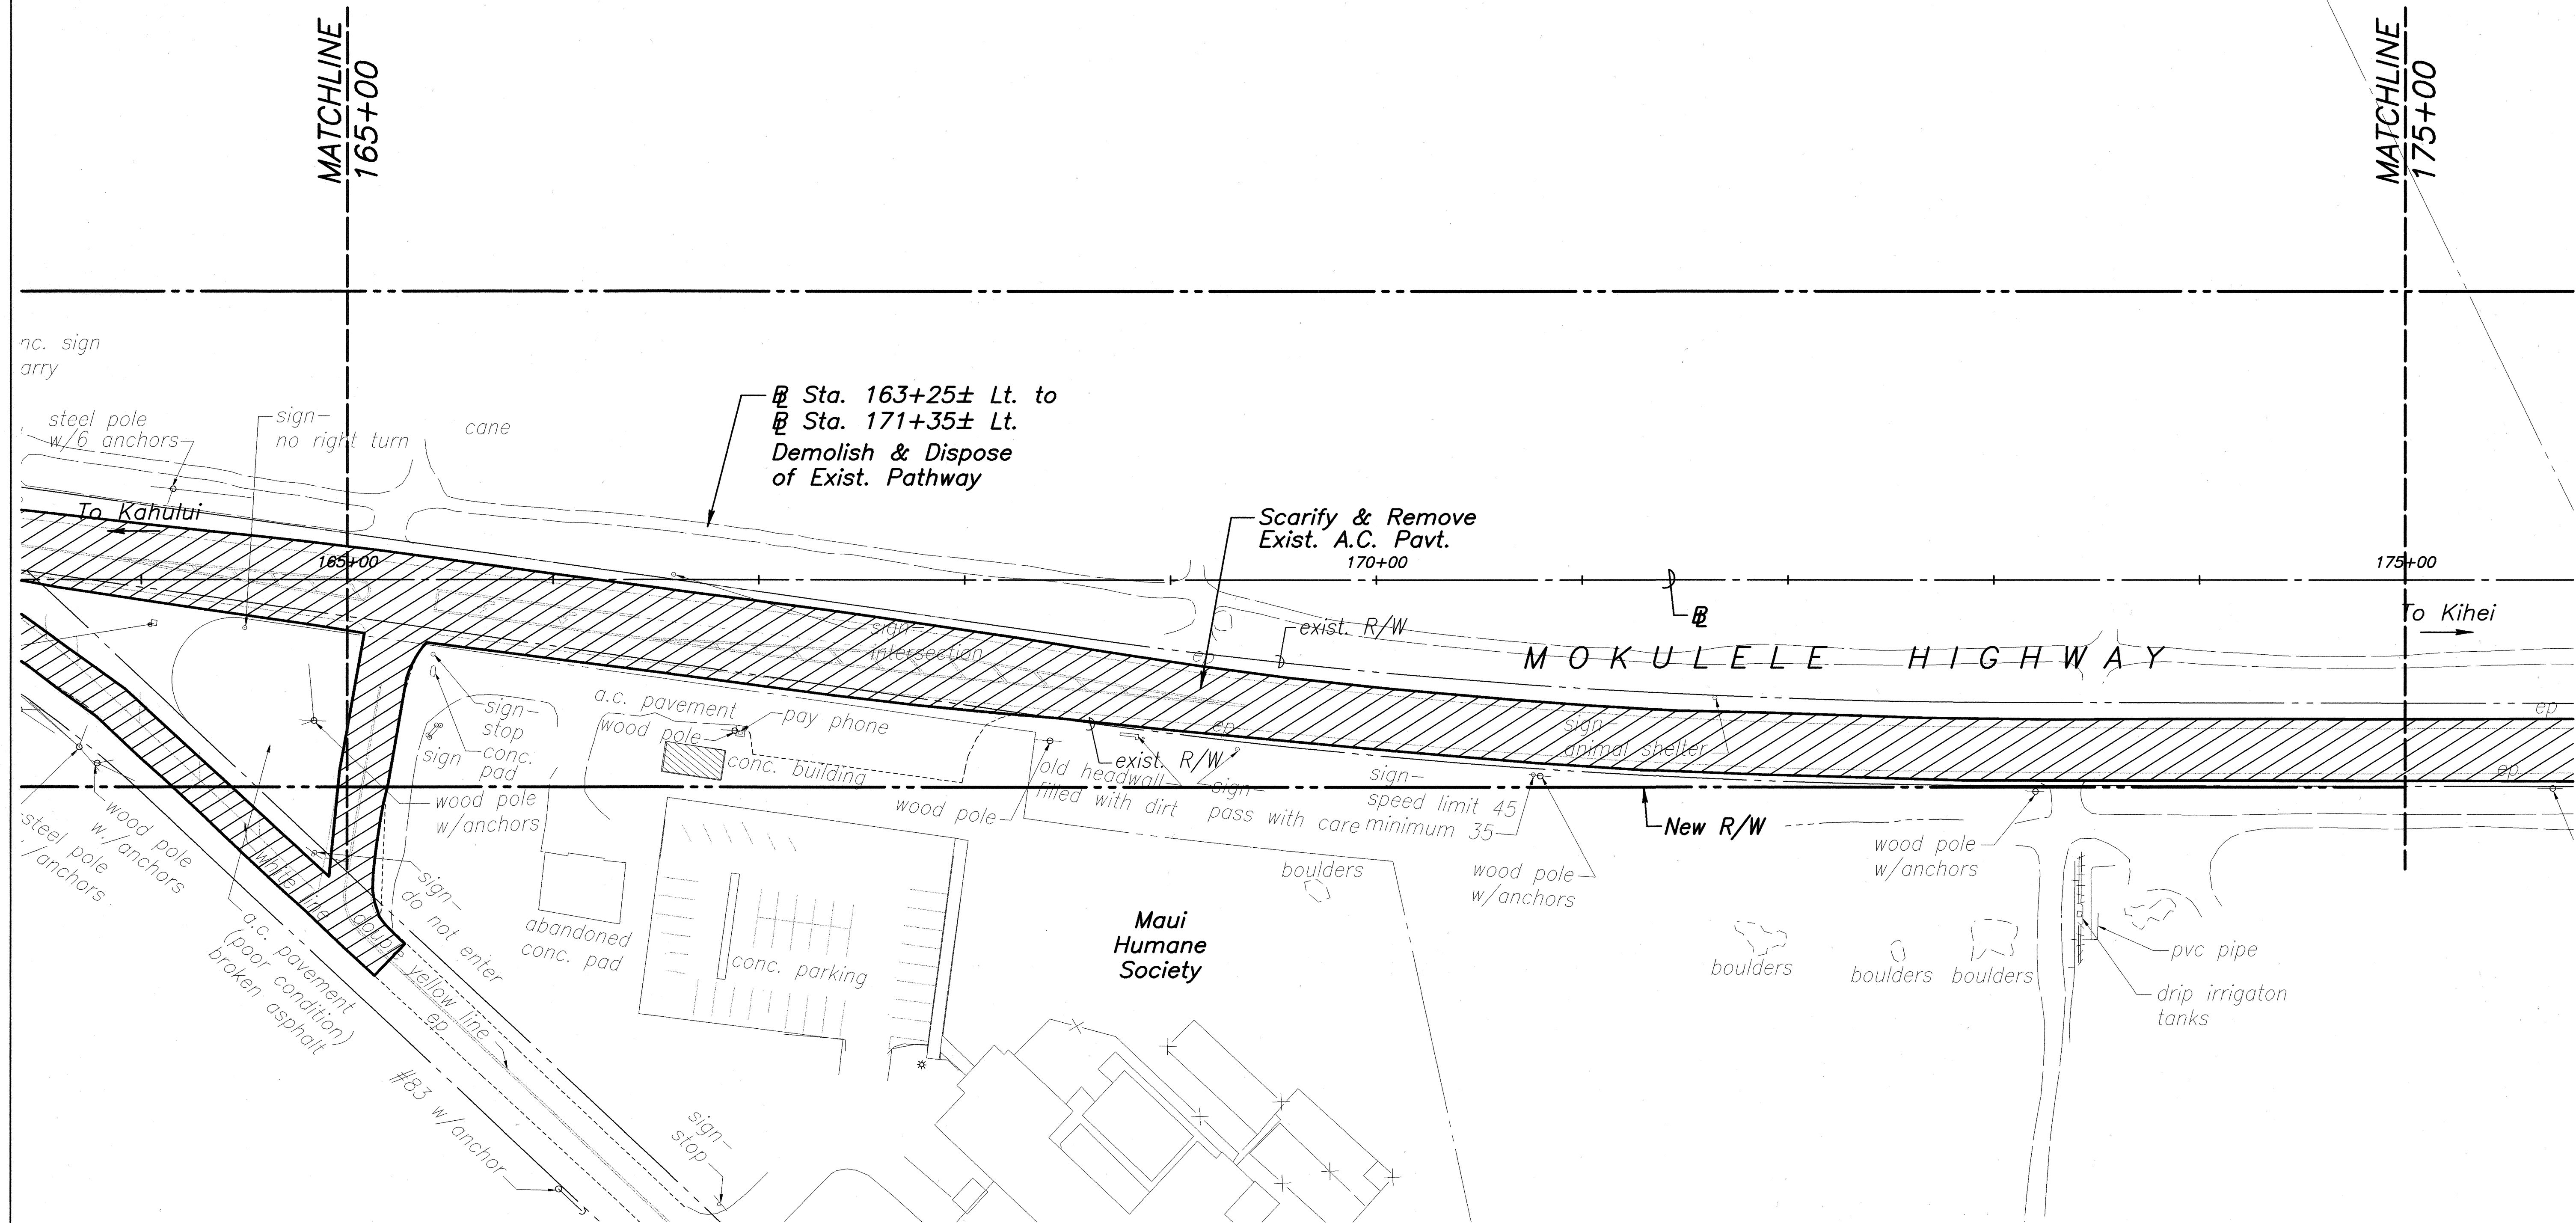


Notes:

1. For Power Pole & Telephone Pole Removal or Relocations, refer to Electrical Plans.
2. For Sign Removals or Relocations, refer to Signing & Pavement Marking Plan.
3. All trees, pavement, structures and obstructions within the project's right of way, shall be removed, unless otherwise noted on the plans. Removal of these items shall be considered incidental to clear and grub pay item.

ORIGINAL PLAN	SURVEY PLOTTED BY	DATE
NOTE BOOK	DRAWN BY	
	DESIGNED BY	
	QUANTITIES BY	
	CHECKED BY	

	STATE OF HAWAII DEPARTMENT OF TRANSPORTATION HIGHWAYS DIVISION	
	DEMOLITION PLAN	
	MOKULELE HIGHWAY WIDENING	
	Vicinity of Cane Haul Road	
	To Maui Humane Society	
Federal - Aid Project No. NH-0311(5)		
Scale: 1"=40'		
Date: JUNE 2002		
SHEET No. 11 OF 13 SHEETS		

FED. ROAD DIST. NO.	STATE	FEDERAL - AID PROJ. NO.	FISCAL YEAR	SHEET NO.	TOTAL SHEETS
HAWAII	HAW.	NH-0311(5)	2003	24	189

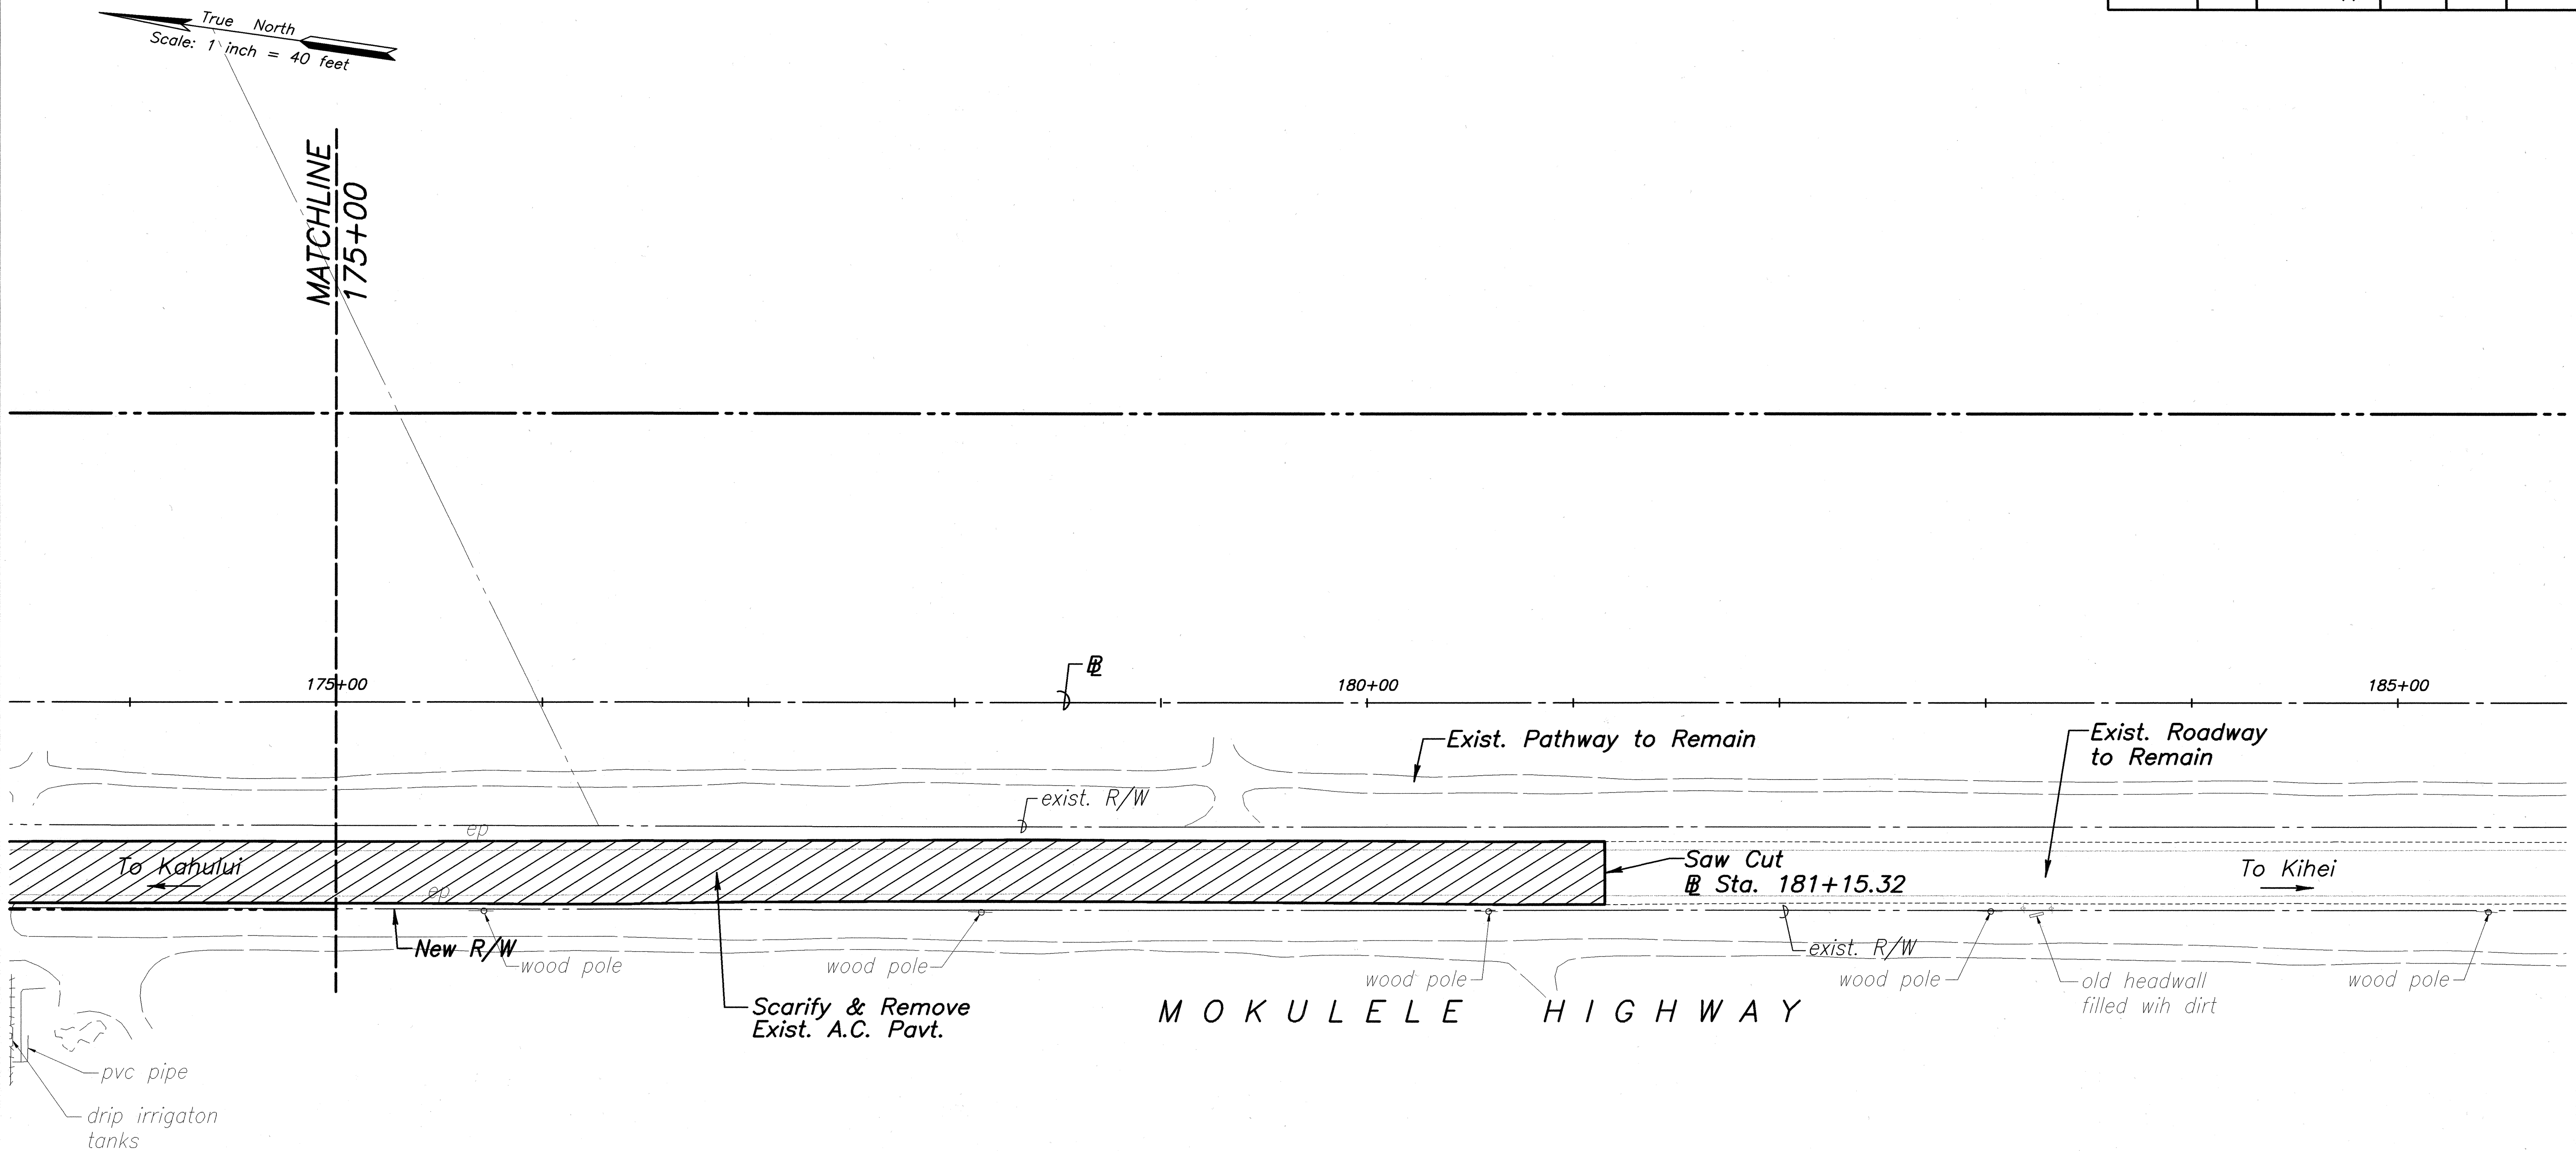

- Notes:
1. For Power Pole & Telephone Pole Removal or Relocations, refer to Electrical Plans.
 2. For Sign Removals or Relocations, refer to Signing & Pavement Marking Plan.
 3. All trees, pavement, structures and obstructions within the project's right of way, shall be removed, unless otherwise noted on the plans. Removal of these items shall be considered incidental to clear and grub pay item.



THIS WORK WAS PREPARED BY
 ME OR UNDER MY SUPERVISION

STATE OF HAWAII
DEPARTMENT OF TRANSPORTATION
HIGHWAYS DIVISION

DEMOLITION PLAN

MOKULELE HIGHWAY WIDENING

Vicinity of Cane Haul Road

To
Maui Humane Society


Federal - Aid Project No. NH-0311(5)

Scale: 1"=40' Date: JUNE 2002

SHEET No. 12 OF 13 SHEETS

ORIGINAL PLAN	SURVEY PLOTTED BY	DATE
NOTE BOOK	DRAWN BY	
No.	DESIGNED BY	
	CHECKED BY	

FED. ROAD DIST. NO.	STATE	FEDERAL - AID PROJ. NO.	FISCAL YEAR	SHEET NO.	TOTAL SHEETS
HAWAII	HAW.	NH-0311(5)	2003	25	189

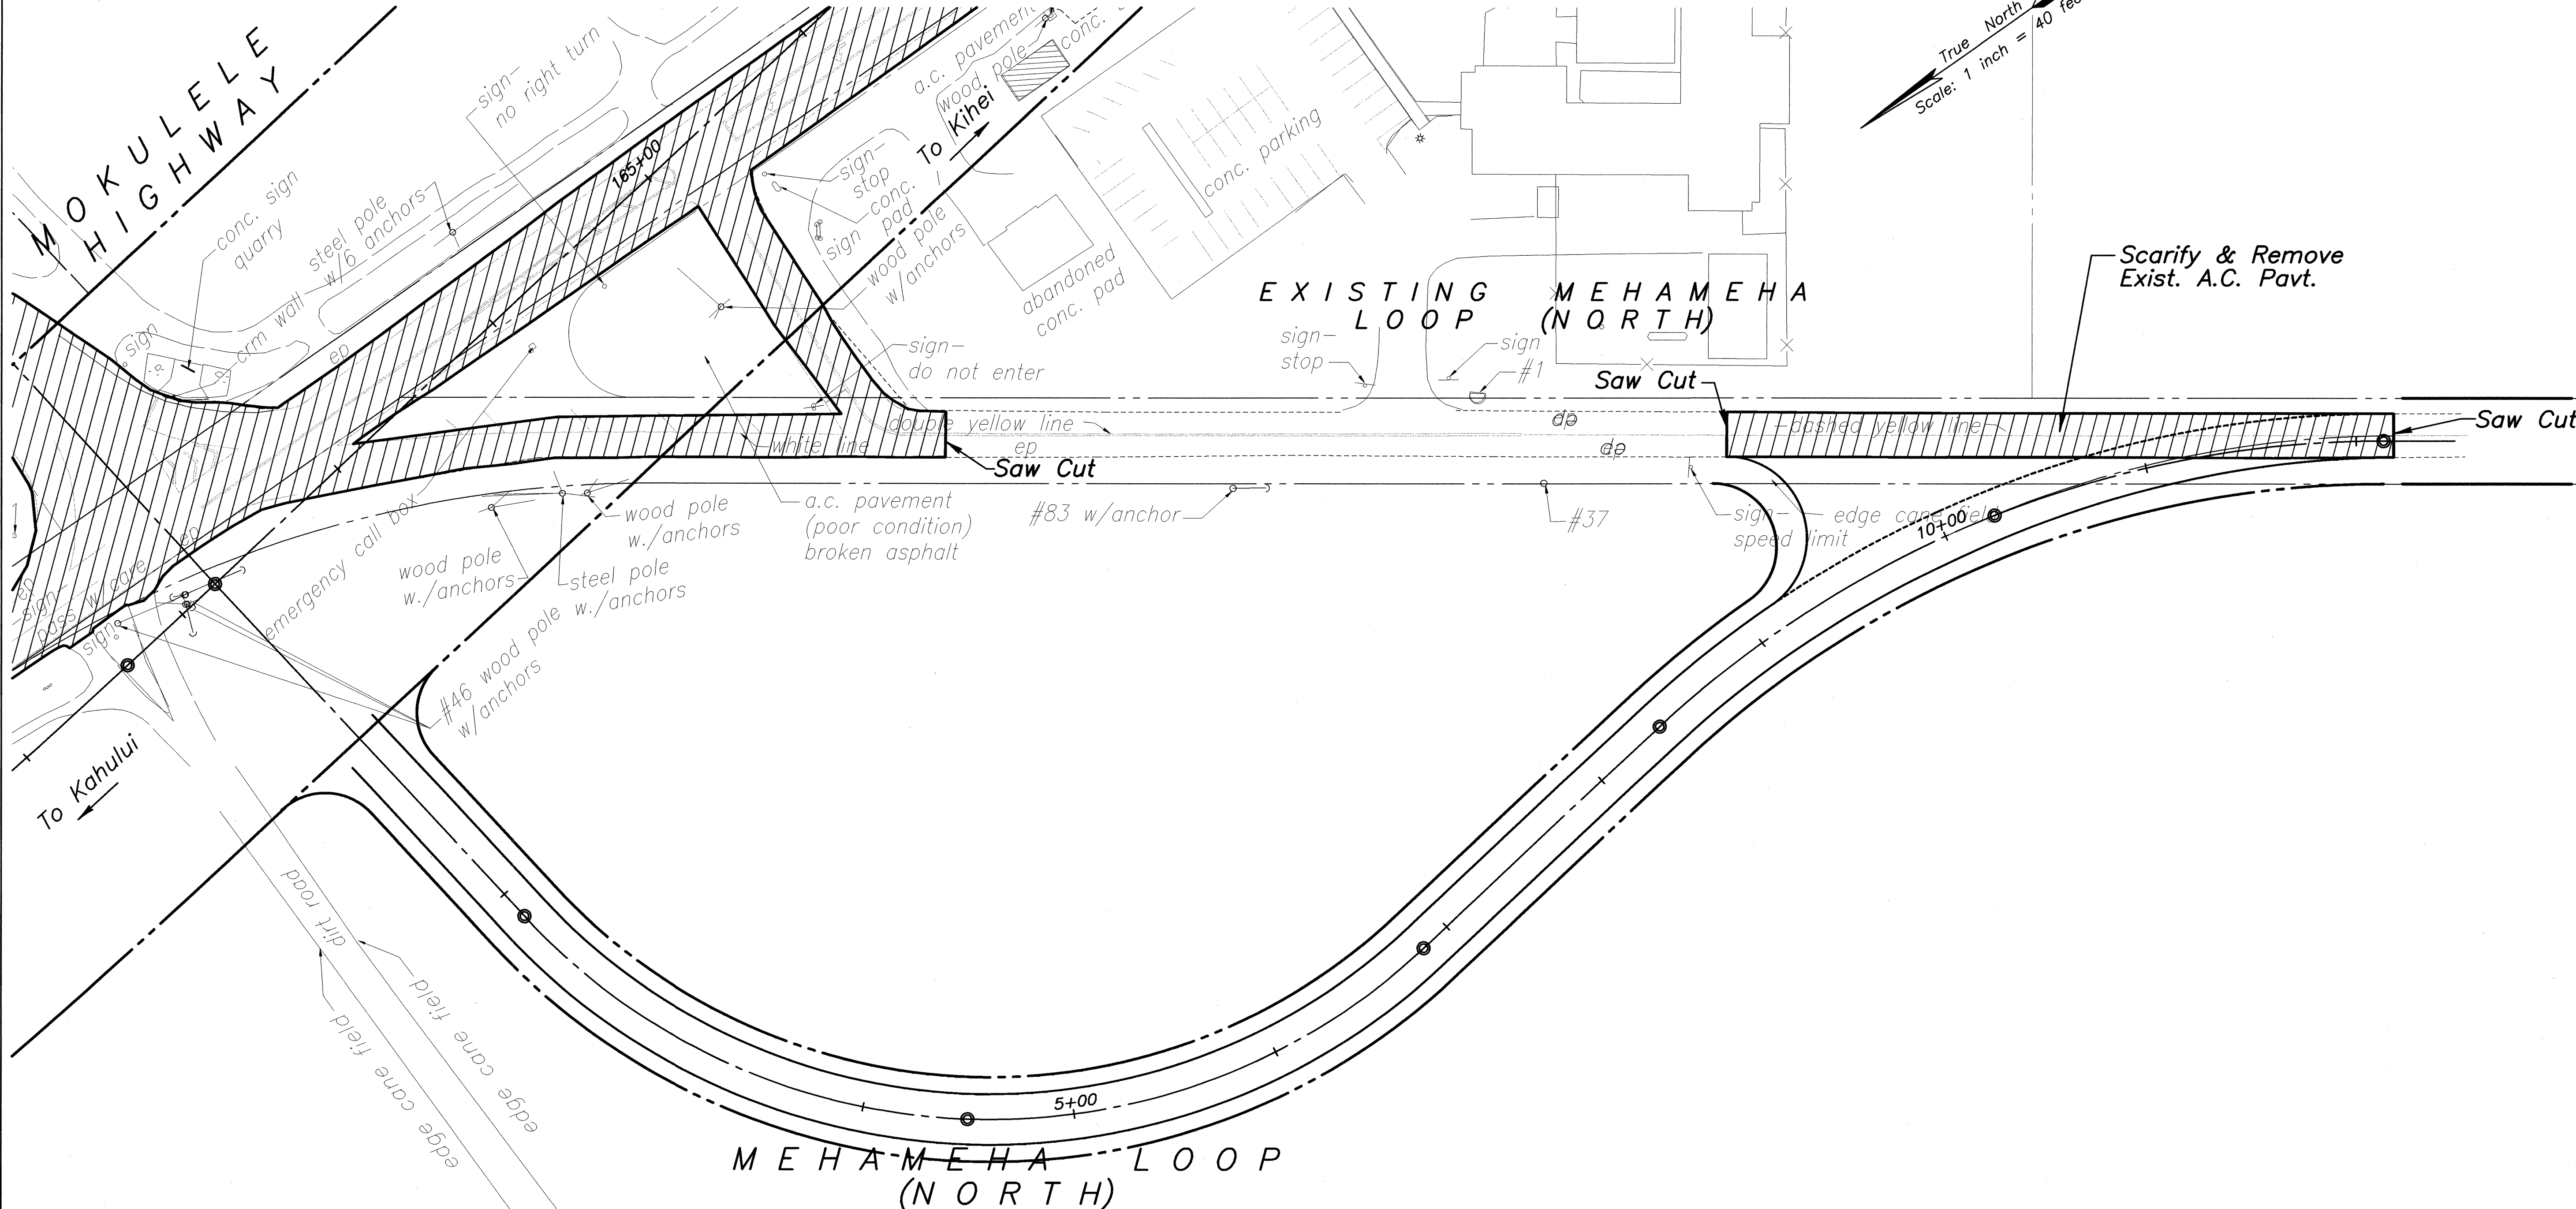

- Notes:*

1. *For Power Pole & Telephone Pole Removal or Relocations, refer to Electrical Plans.*
2. *For Sign Removals or Relocations, refer to Signing & Pavement Marking Plan.*
3. *All trees, pavement, structures and obstructions within the project's right of way, shall be removed, unless otherwise noted on the plans. Removal of these items shall be considered incidental to clear and grub pay item.*

ORIGINAL PLAN	SURVEY PLOTTED BY _____	DATE _____
NOTE BOOK	DRAWN BY _____	"
	TRACED BY _____	"
	DESIGNED BY _____	"
	QUANTITIES BY _____	"
No. _____	CHECKED BY _____	"

