


FED. ROAD DIST. NO.	STATE	FEDERAL - AID PROJ. NO.	FISCAL YEAR	SHEET NO.	TOTAL SHEETS
HAWAII	HAW.	NH-A311(6)R	2006	14	173

True North
Scale: 1 inch = 40 feet

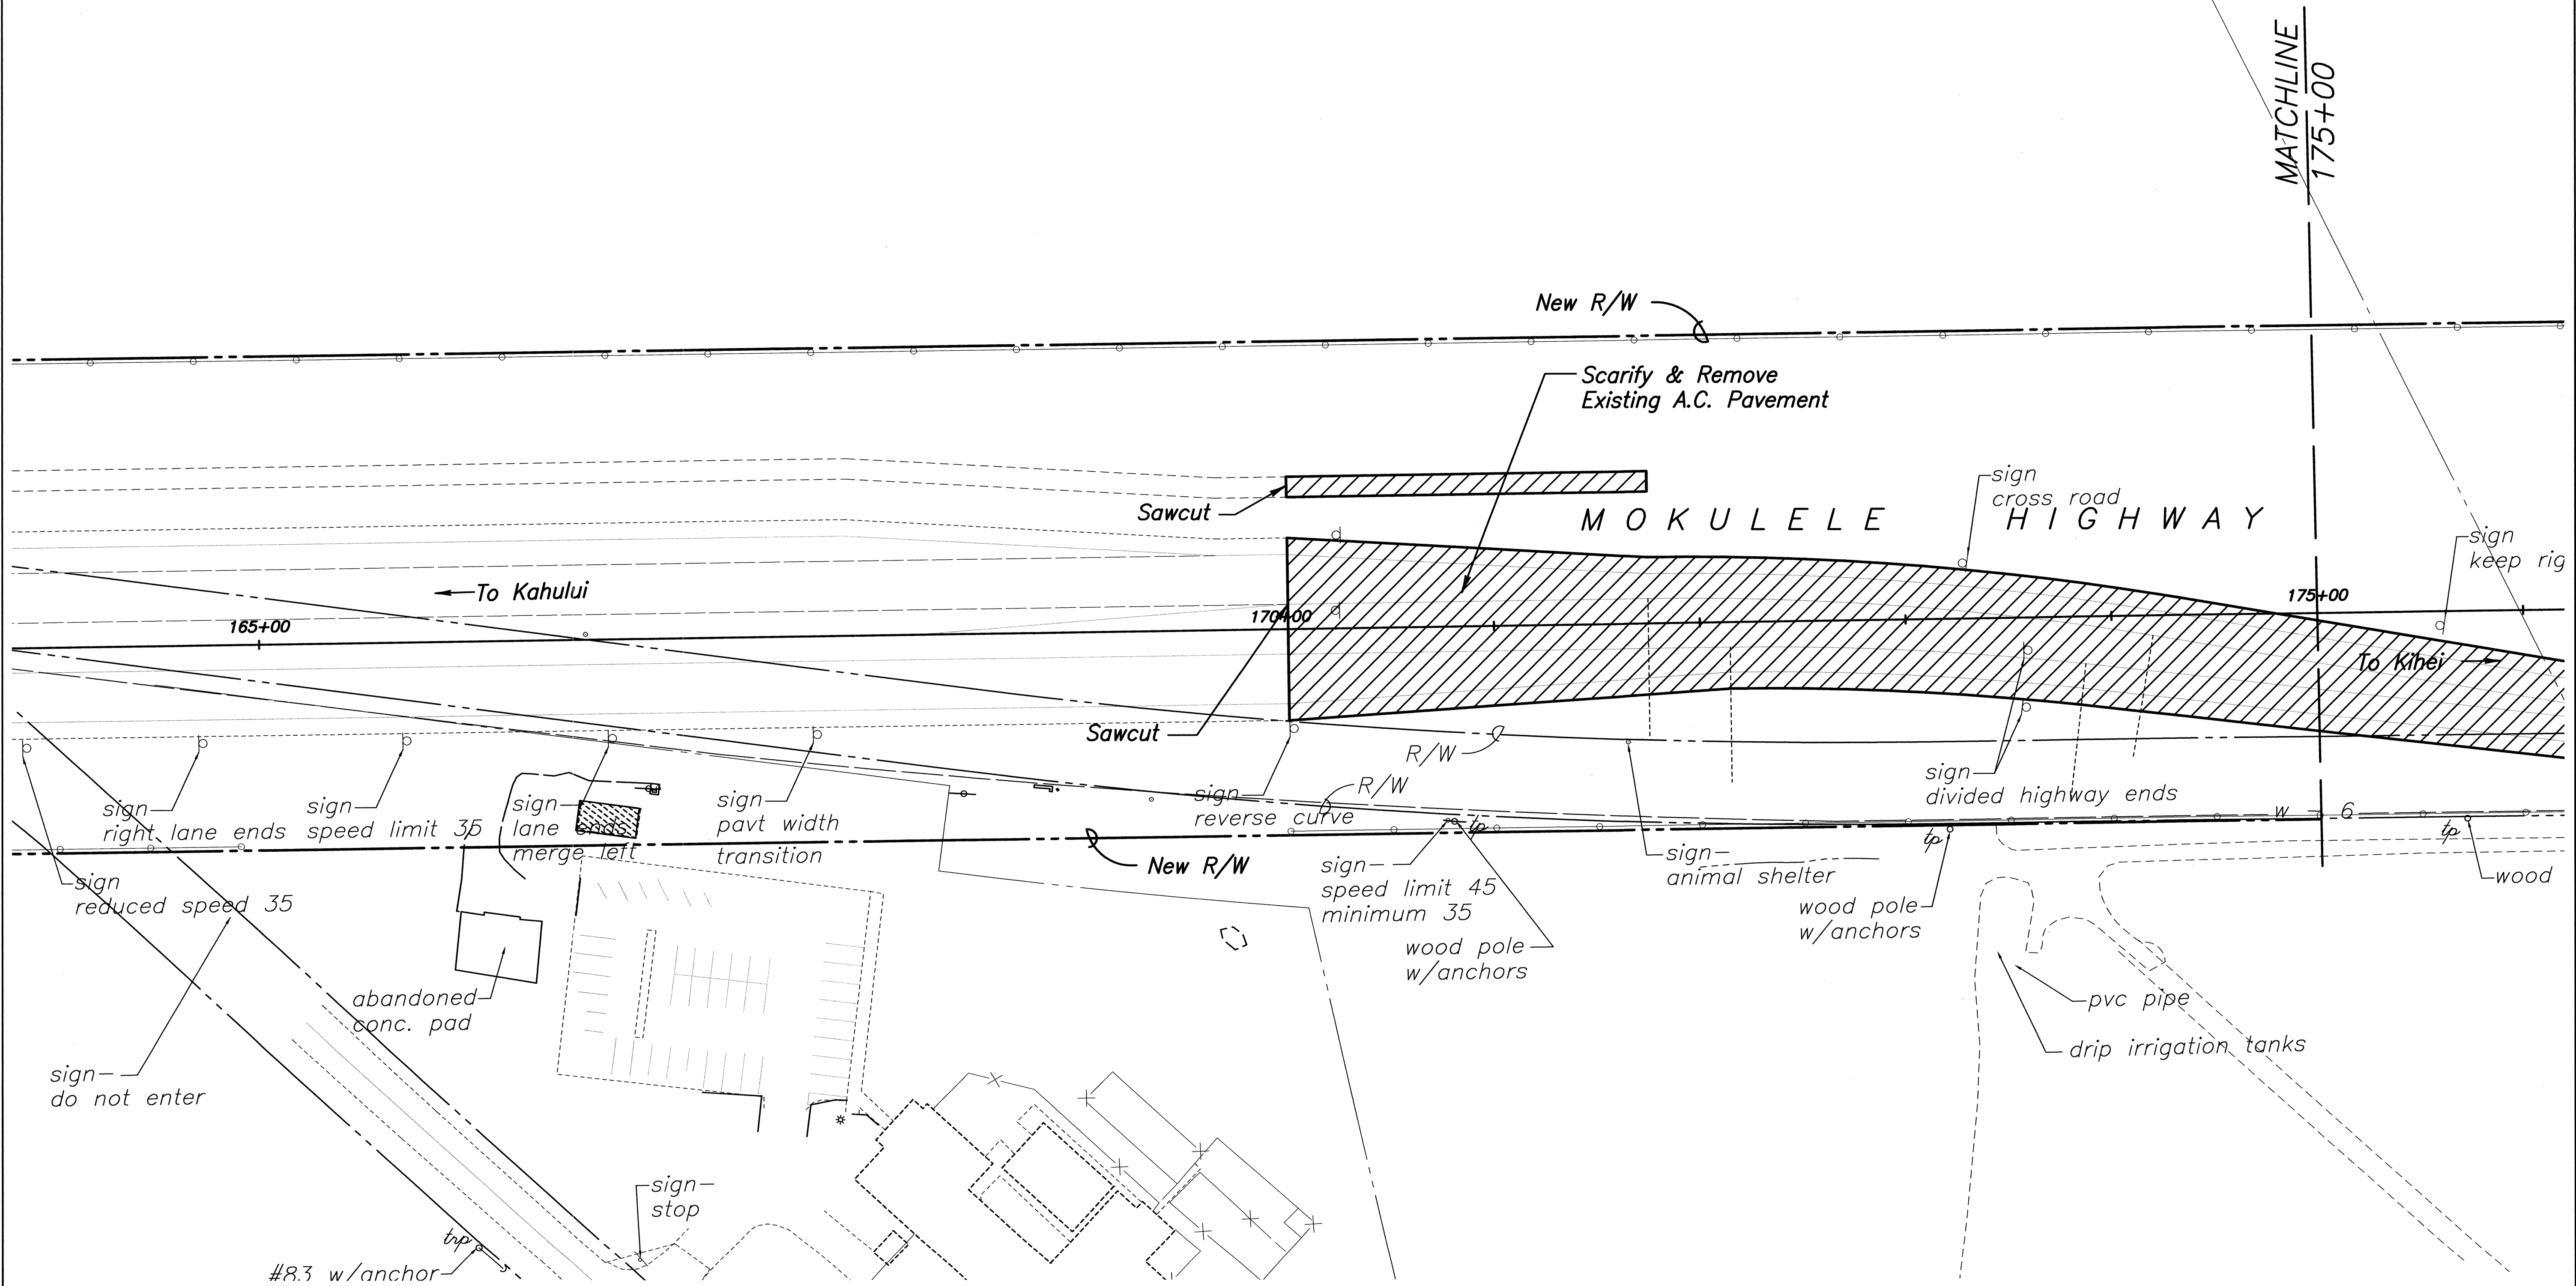

- Notes:
1. For Power Pole & Telephone Pole Removal or Relocations, refer to Electrical Plans.
 2. For Sign Removals or Relocations, refer to Signing & Pavement Marking Plan.
 3. All trees, pavement, structures and obstructions within the project's right of way, shall be removed, unless otherwise noted on the plans. Removal of these items shall be considered incidental to clearing and grubbing pay item.

DATE	
SURVEY PLOTTED BY	
ORIGINAL PLAN	
NOTE BOOK	
DESIGNED BY	
CHECKED BY	
No.	

CLIFFORD M. ARAKAWA
LICENSED PROFESSIONAL ENGINEER
No. 1884-C
HAWAII U.S.A.

THIS WORK WAS PREPARED BY ME OR UNDER MY SUPERVISION
04/30/06
EXPIRATION DATE OF THE LICENSE

STATE OF HAWAII
DEPARTMENT OF TRANSPORTATION
HIGHWAYS DIVISION


DEMOLITION PLAN

MOKULELE HIGHWAY WIDENING

Maui Humane Society
To
Vicinity of Kolaloa Bridge
Federal - Aid Project No. NH-A311(6)R
Scale: 1"=40' Date: JUNE 2005

SHEET No. 1 OF 11 SHEETS

FED. ROAD DIST. NO.	STATE	FEDERAL - AID PROJ. NO.	FISCAL YEAR	SHEET NO.	TOTAL SHEETS
HAWAII	HAW.	NH-A311(6)R	2006	15	173

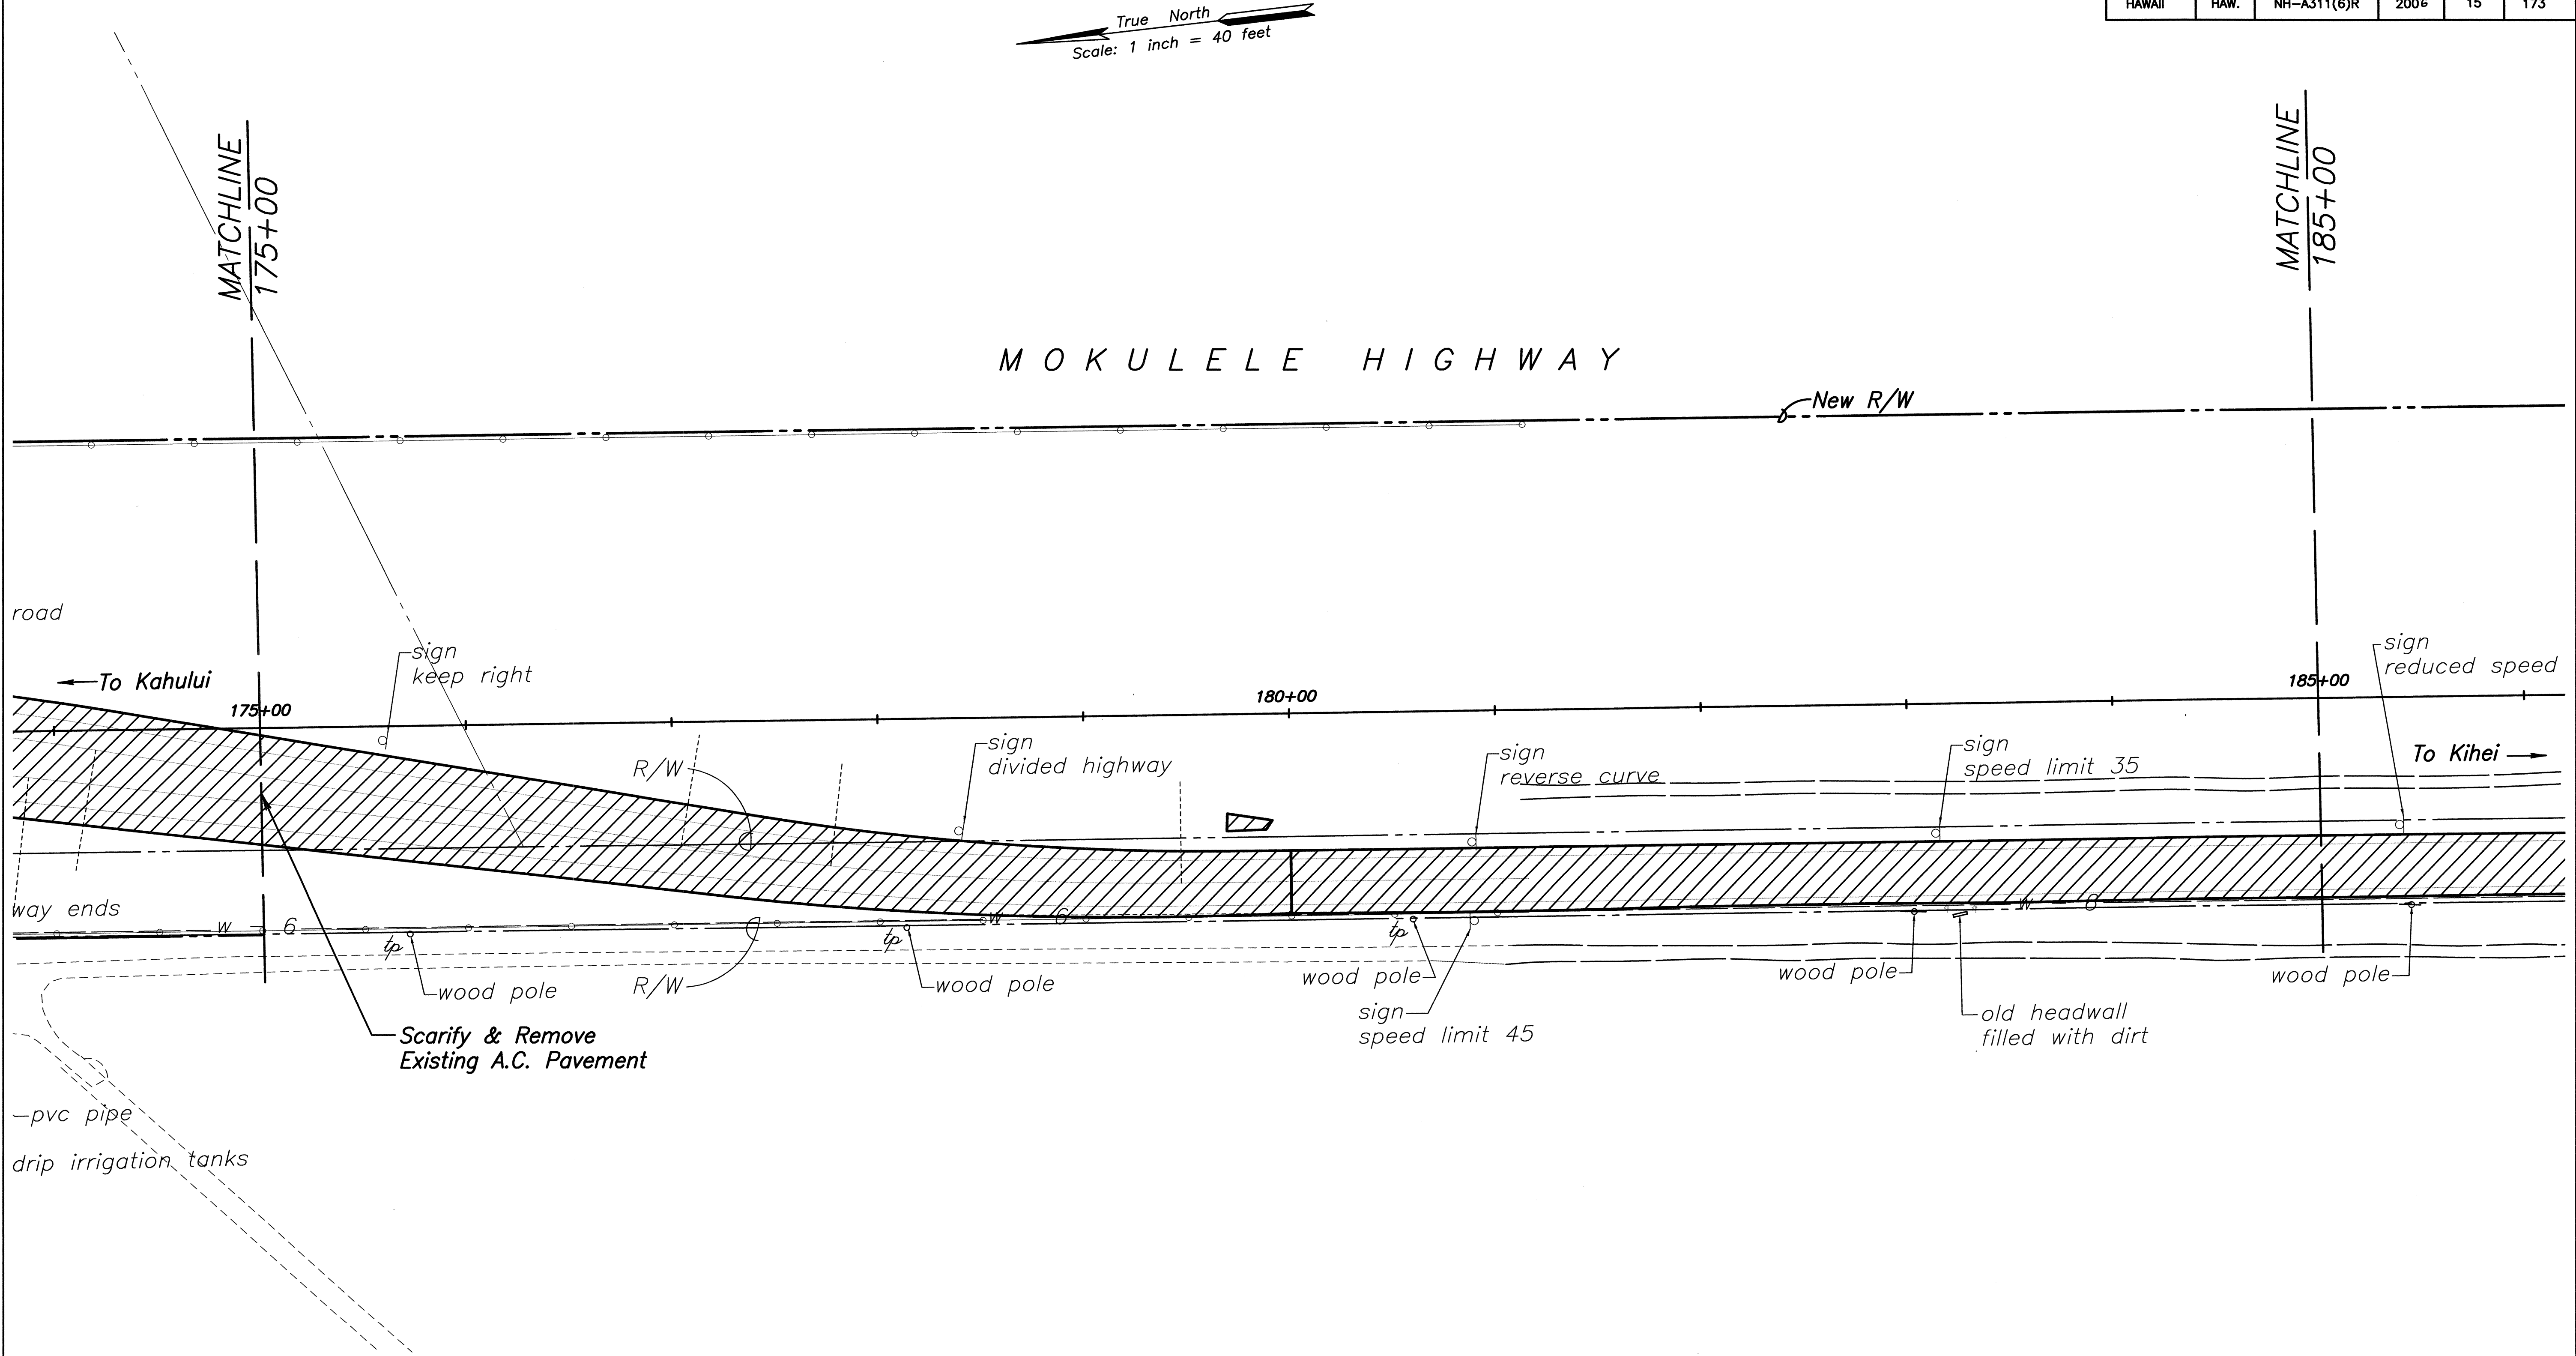

- Notes:
1. For Power Pole & Telephone Pole Removal or Relocations, refer to Electrical Plans.
 2. For Sign Removals or Relocations, refer to Signing & Pavement Marking Plan.
 3. All trees, pavement, structures and obstructions within the project's right of way, shall be removed, unless otherwise noted on the plans. Removal of these items shall be considered incidental to clearing and grubbing pay item.

ORIGINAL PLAN	DATE
SURVEY PLOTTED BY	
DRAWN BY	
TRACED BY	
DESIGNED BY	
CHECKED BY	
NOTE BOOK	
No.	

CLIFFORD M. ARAKAWA
LICENSED PROFESSIONAL ENGINEER
No. 1864-C
HAWAII, U.S.A.

Clifford M. Arakawa
THIS WORK WAS PREPARED BY ME OR UNDER MY SUPERVISION
04/30/06
EXPIRATION DATE OF THE LICENSE

STATE OF HAWAII
DEPARTMENT OF TRANSPORTATION
HIGHWAYS DIVISION


DEMOLITION PLAN

MOKULELE HIGHWAY WIDENING

Maui Humane Society
To
Vicinity of Kolaloa Bridge
Federal - Aid Project No. NH-A311(6)R
Scale: 1"=40' Date: JUNE 2005

SHEET No. 2 OF 11 SHEETS

FED. ROAD DIST. NO.	STATE	FEDERAL - AID PROJ. NO.	FISCAL YEAR	SHEET NO.	TOTAL SHEETS
HAWAII	HAW.	NH-A311(6)R	2006	16	173

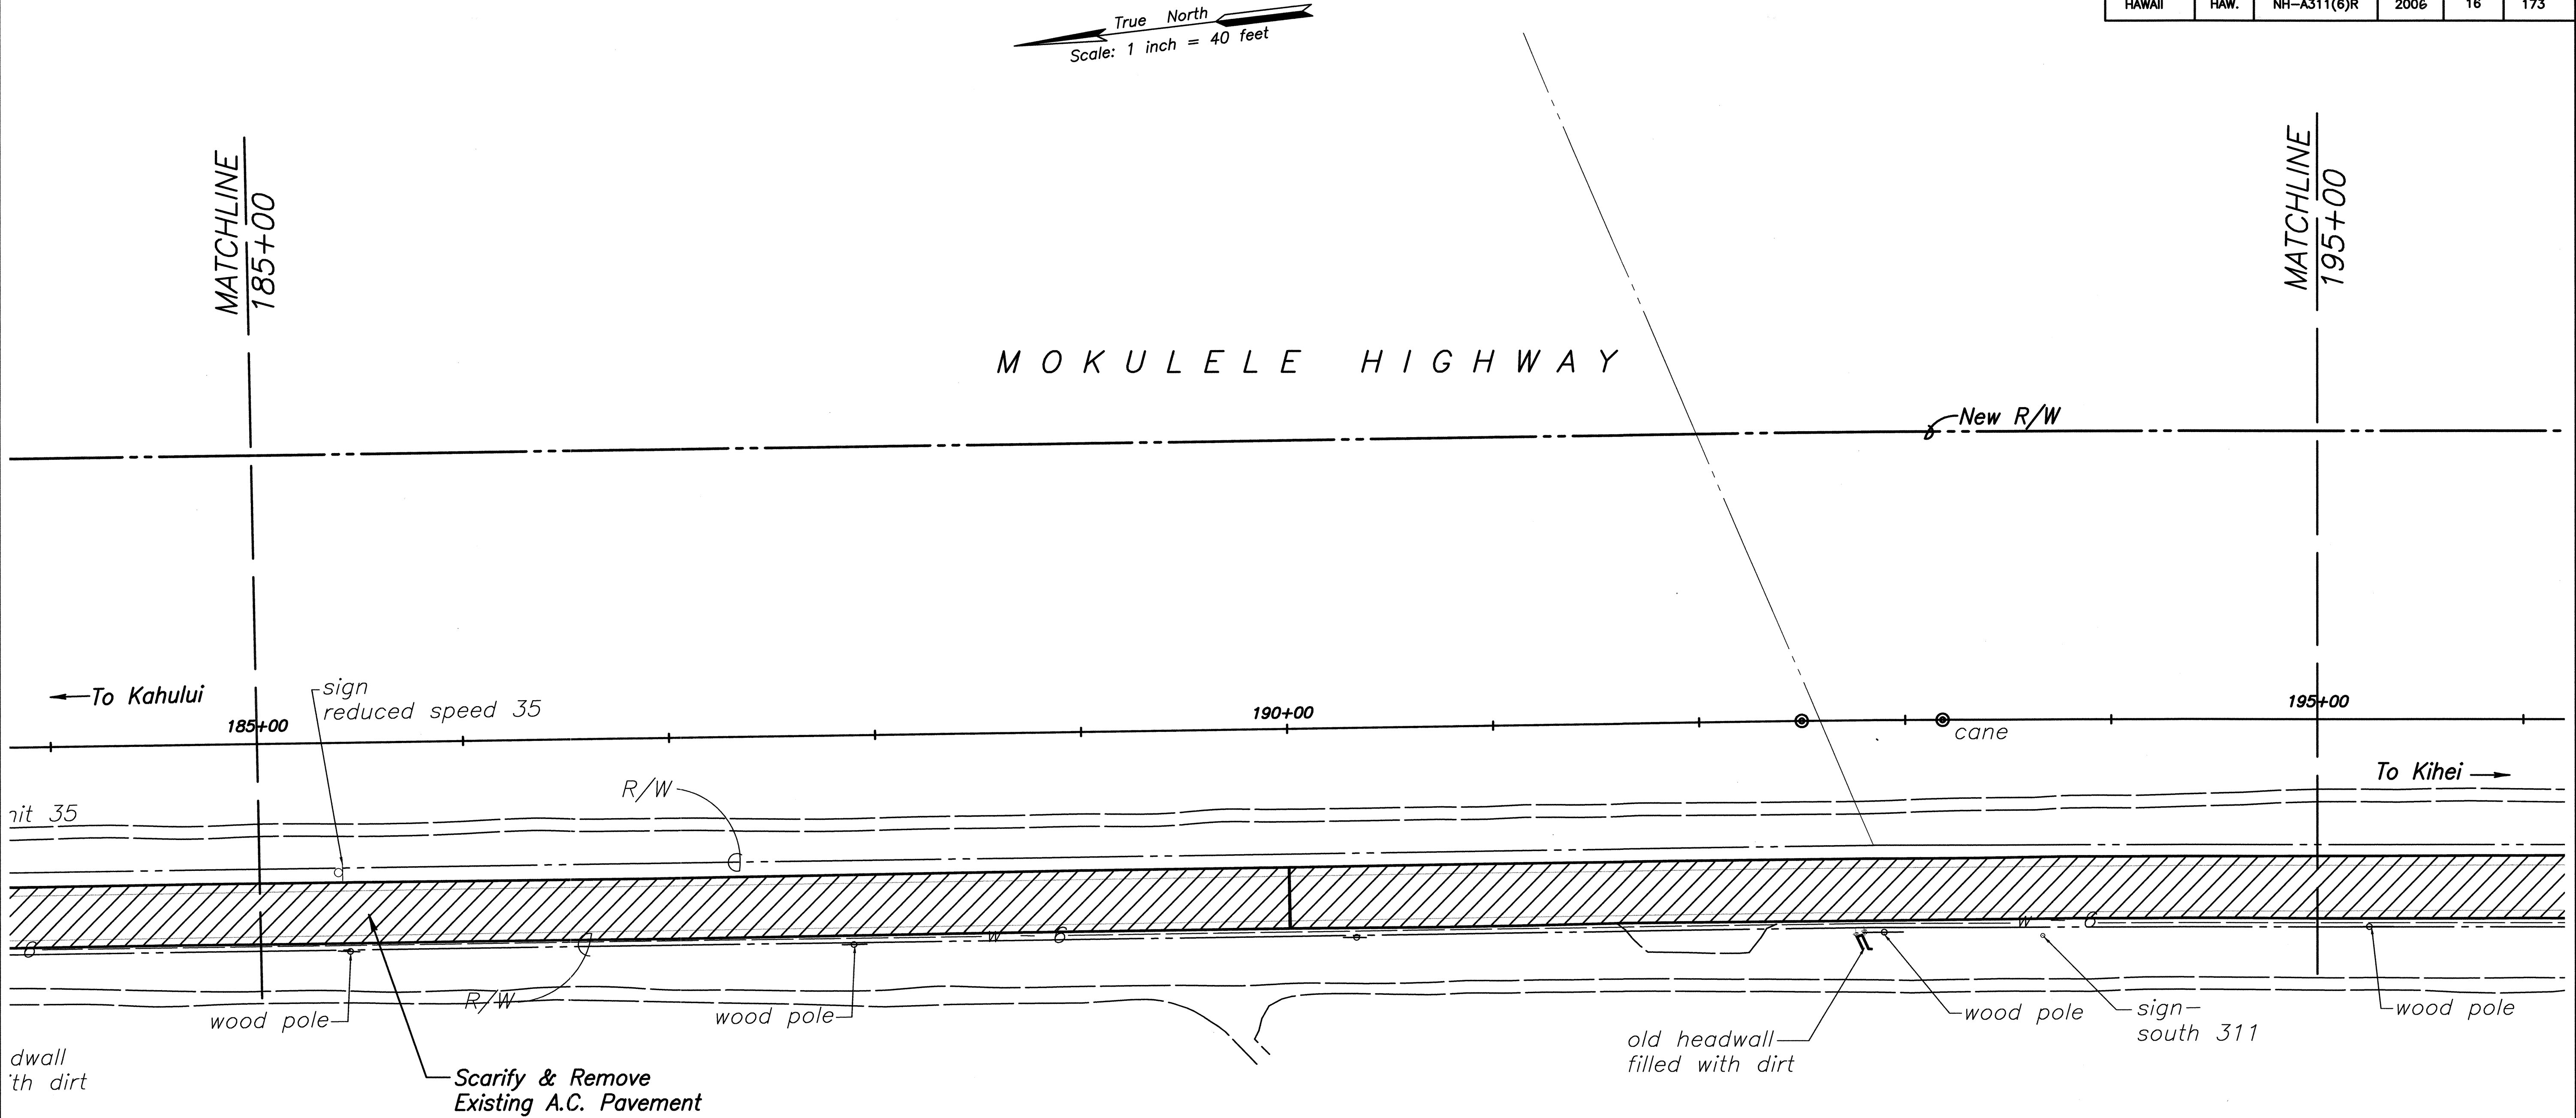

- Notes:
1. For Power Pole & Telephone Pole Removal or Relocations, refer to Electrical Plans.
 2. For Sign Removals or Relocations, refer to Signing & Pavement Marking Plan.
 3. All trees, pavement, structures and obstructions within the project's right of way, shall be removed, unless otherwise noted on the plans. Removal of these items shall be considered incidental to clearing and grubbing pay item.

DATE	
SURVEY PLOTTED BY	
ORIGINAL PLAN	
NOTE BOOK	
DESIGNED BY	
CHECKED BY	
No.	

CLIFFORD M. ARAKAWA
LICENSED PROFESSIONAL ENGINEER
No. 1864-C
HAWAII U.S.A.

Clifford M. Arakawa
THIS WORK WAS PREPARED BY ME OR UNDER MY SUPERVISION
04/30/06
EXPIRATION DATE OF THE LICENSE

STATE OF HAWAII
DEPARTMENT OF TRANSPORTATION
HIGHWAYS DIVISION


DEMOLITION PLAN

MOKULELE HIGHWAY WIDENING

Maui Humane Society
To
Vicinity of Kolaloa Bridge
Federal - Aid Project No. NH-A311(6)R
Scale: 1"=40' Date: JUNE 2005

SHEET No. 3 OF 11 SHEETS

FED. ROAD DIST. NO.	STATE	FEDERAL - AID PROJ. NO.	FISCAL YEAR	SHEET NO.	TOTAL SHEETS
HAWAII	HAW.	NH-A311(6)R	2006	17	173

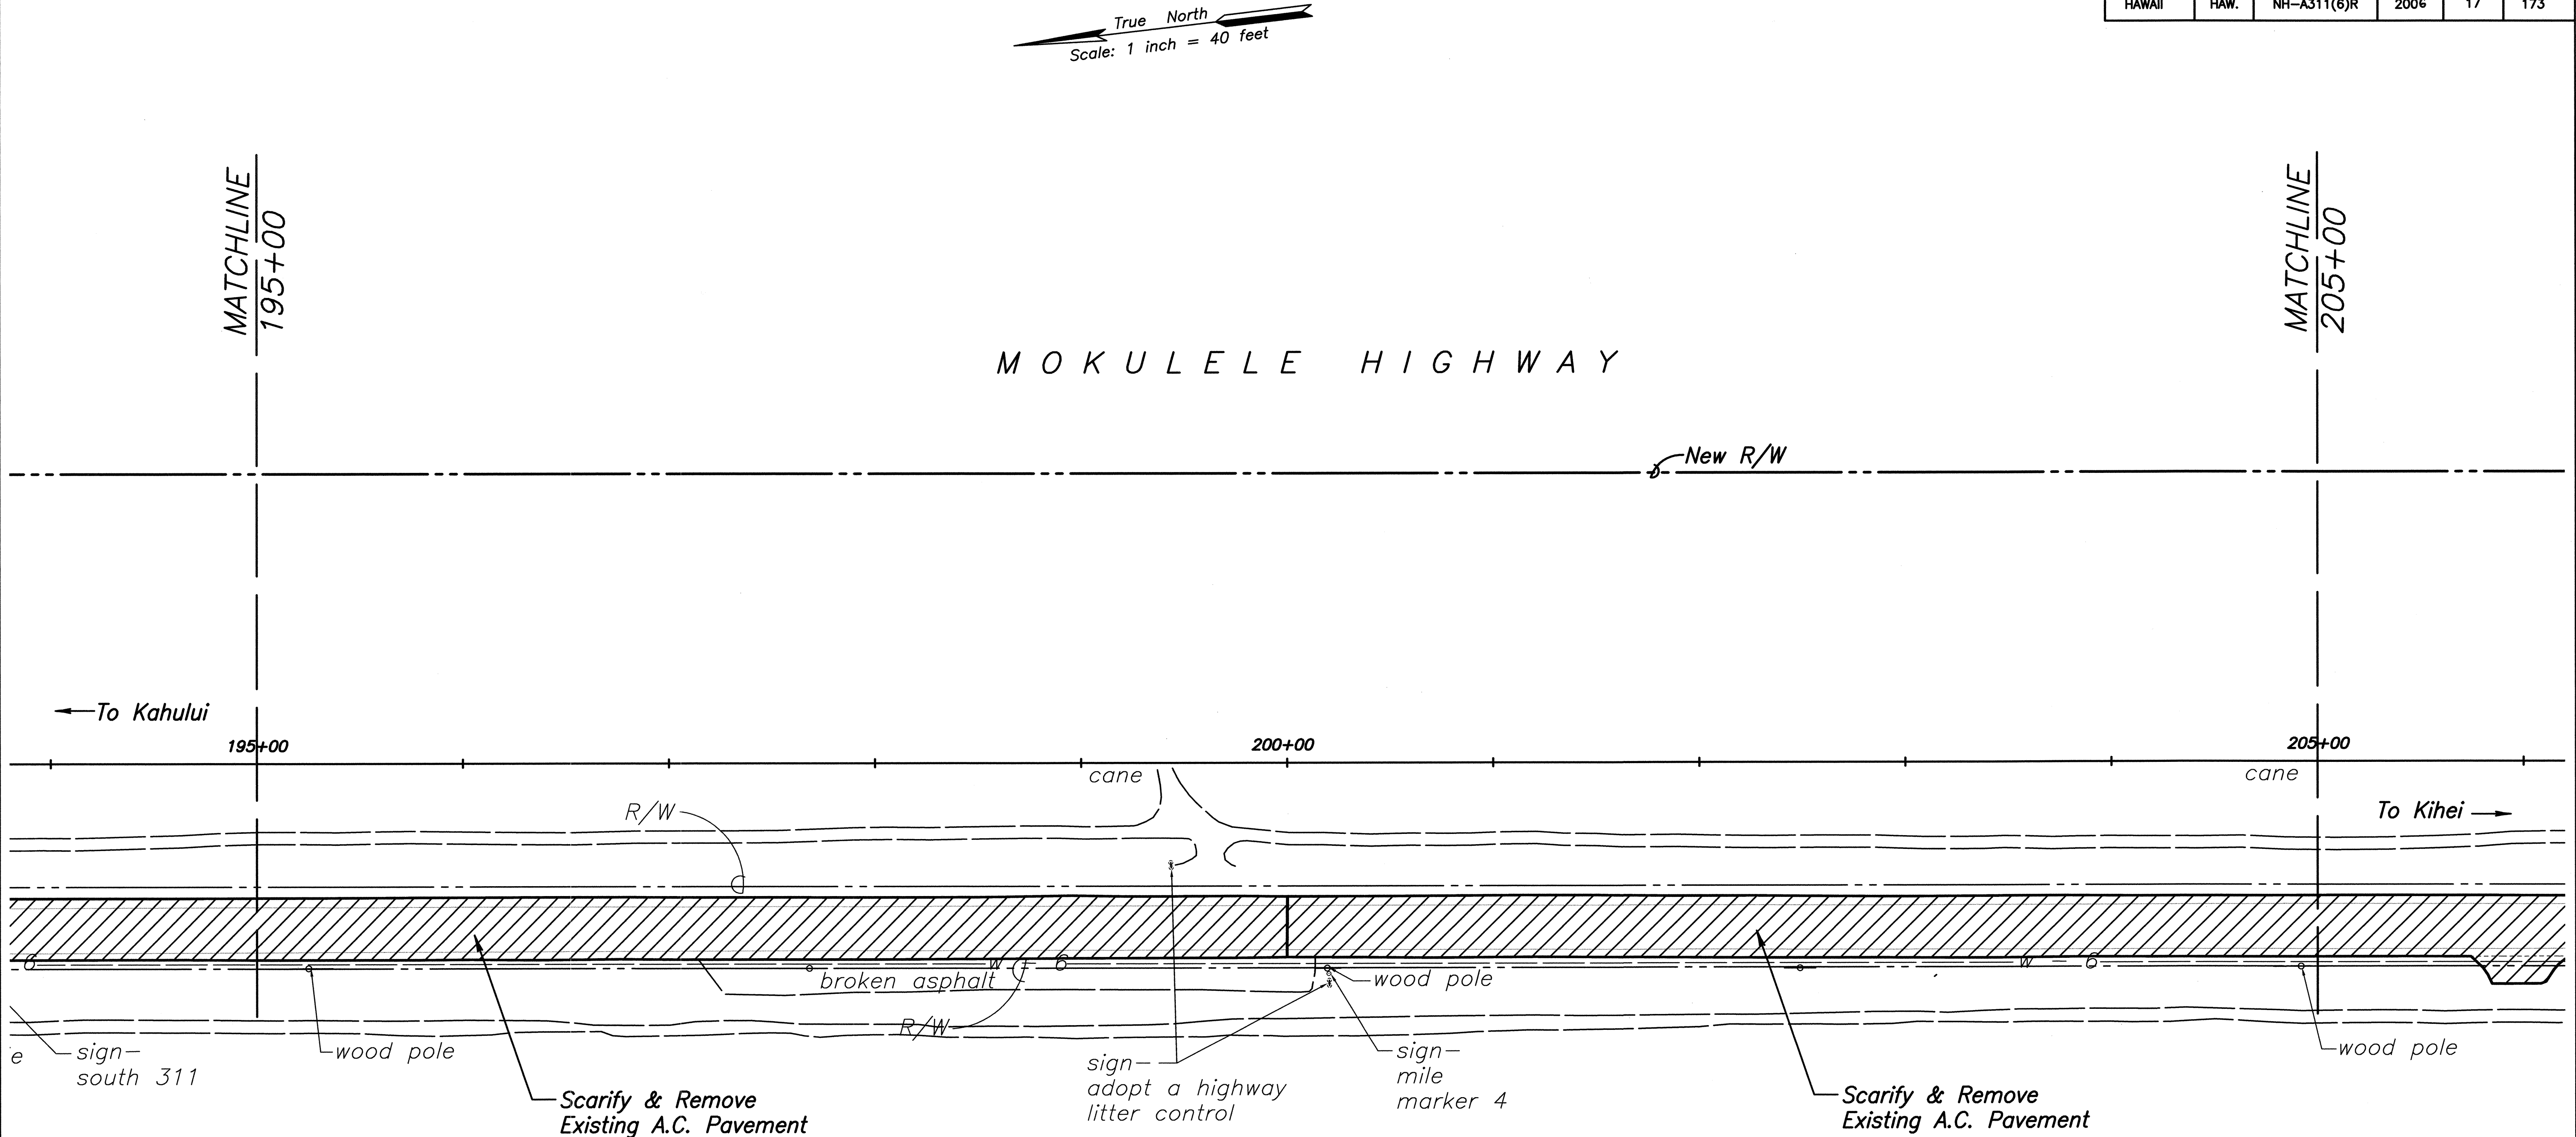

- Notes:
1. For Power Pole & Telephone Pole Removal or Relocations, refer to Electrical Plans.
 2. For Sign Removals or Relocations, refer to Signing & Pavement Marking Plan.
 3. All trees, pavement, structures and obstructions within the project's right of way, shall be removed, unless otherwise noted on the plans. Removal of these items shall be considered incidental to clearing and grubbing pay item.

SURVEY PLOTTED BY	DATE
DRAWN BY	
DESIGNED BY	
CHECKED BY	
NOTE BOOK	
No.	

CLIFFORD M. ARAKAWA
LICENSED PROFESSIONAL ENGINEER
No. 1864-C
HAWAII U.S.A.

Clifford M. Arakawa
THE WORK WAS PREPARED BY ME OR UNDER MY SUPERVISION
04/30/06
EXPIRATION DATE OF THE LICENSE

STATE OF HAWAII
DEPARTMENT OF TRANSPORTATION
HIGHWAYS DIVISION

DEMOLITION PLAN


MOKULELE HIGHWAY WIDENING

Maui Humane Society
To
Vicinity of Kolaloa Bridge
Federal - Aid Project No. NH-A311(6)R
Scale: 1"=40' Date: JUNE 2005

SHEET No. 4 OF 11 SHEETS

FED. ROAD DIST. NO.	STATE	FEDERAL - AID PROJ. NO.	FISCAL YEAR	SHEET NO.	TOTAL SHEETS
HAWAII	HAW.	NH-A311(6)R	2006	18	173

True North
Scale: 1 inch = 40 feet

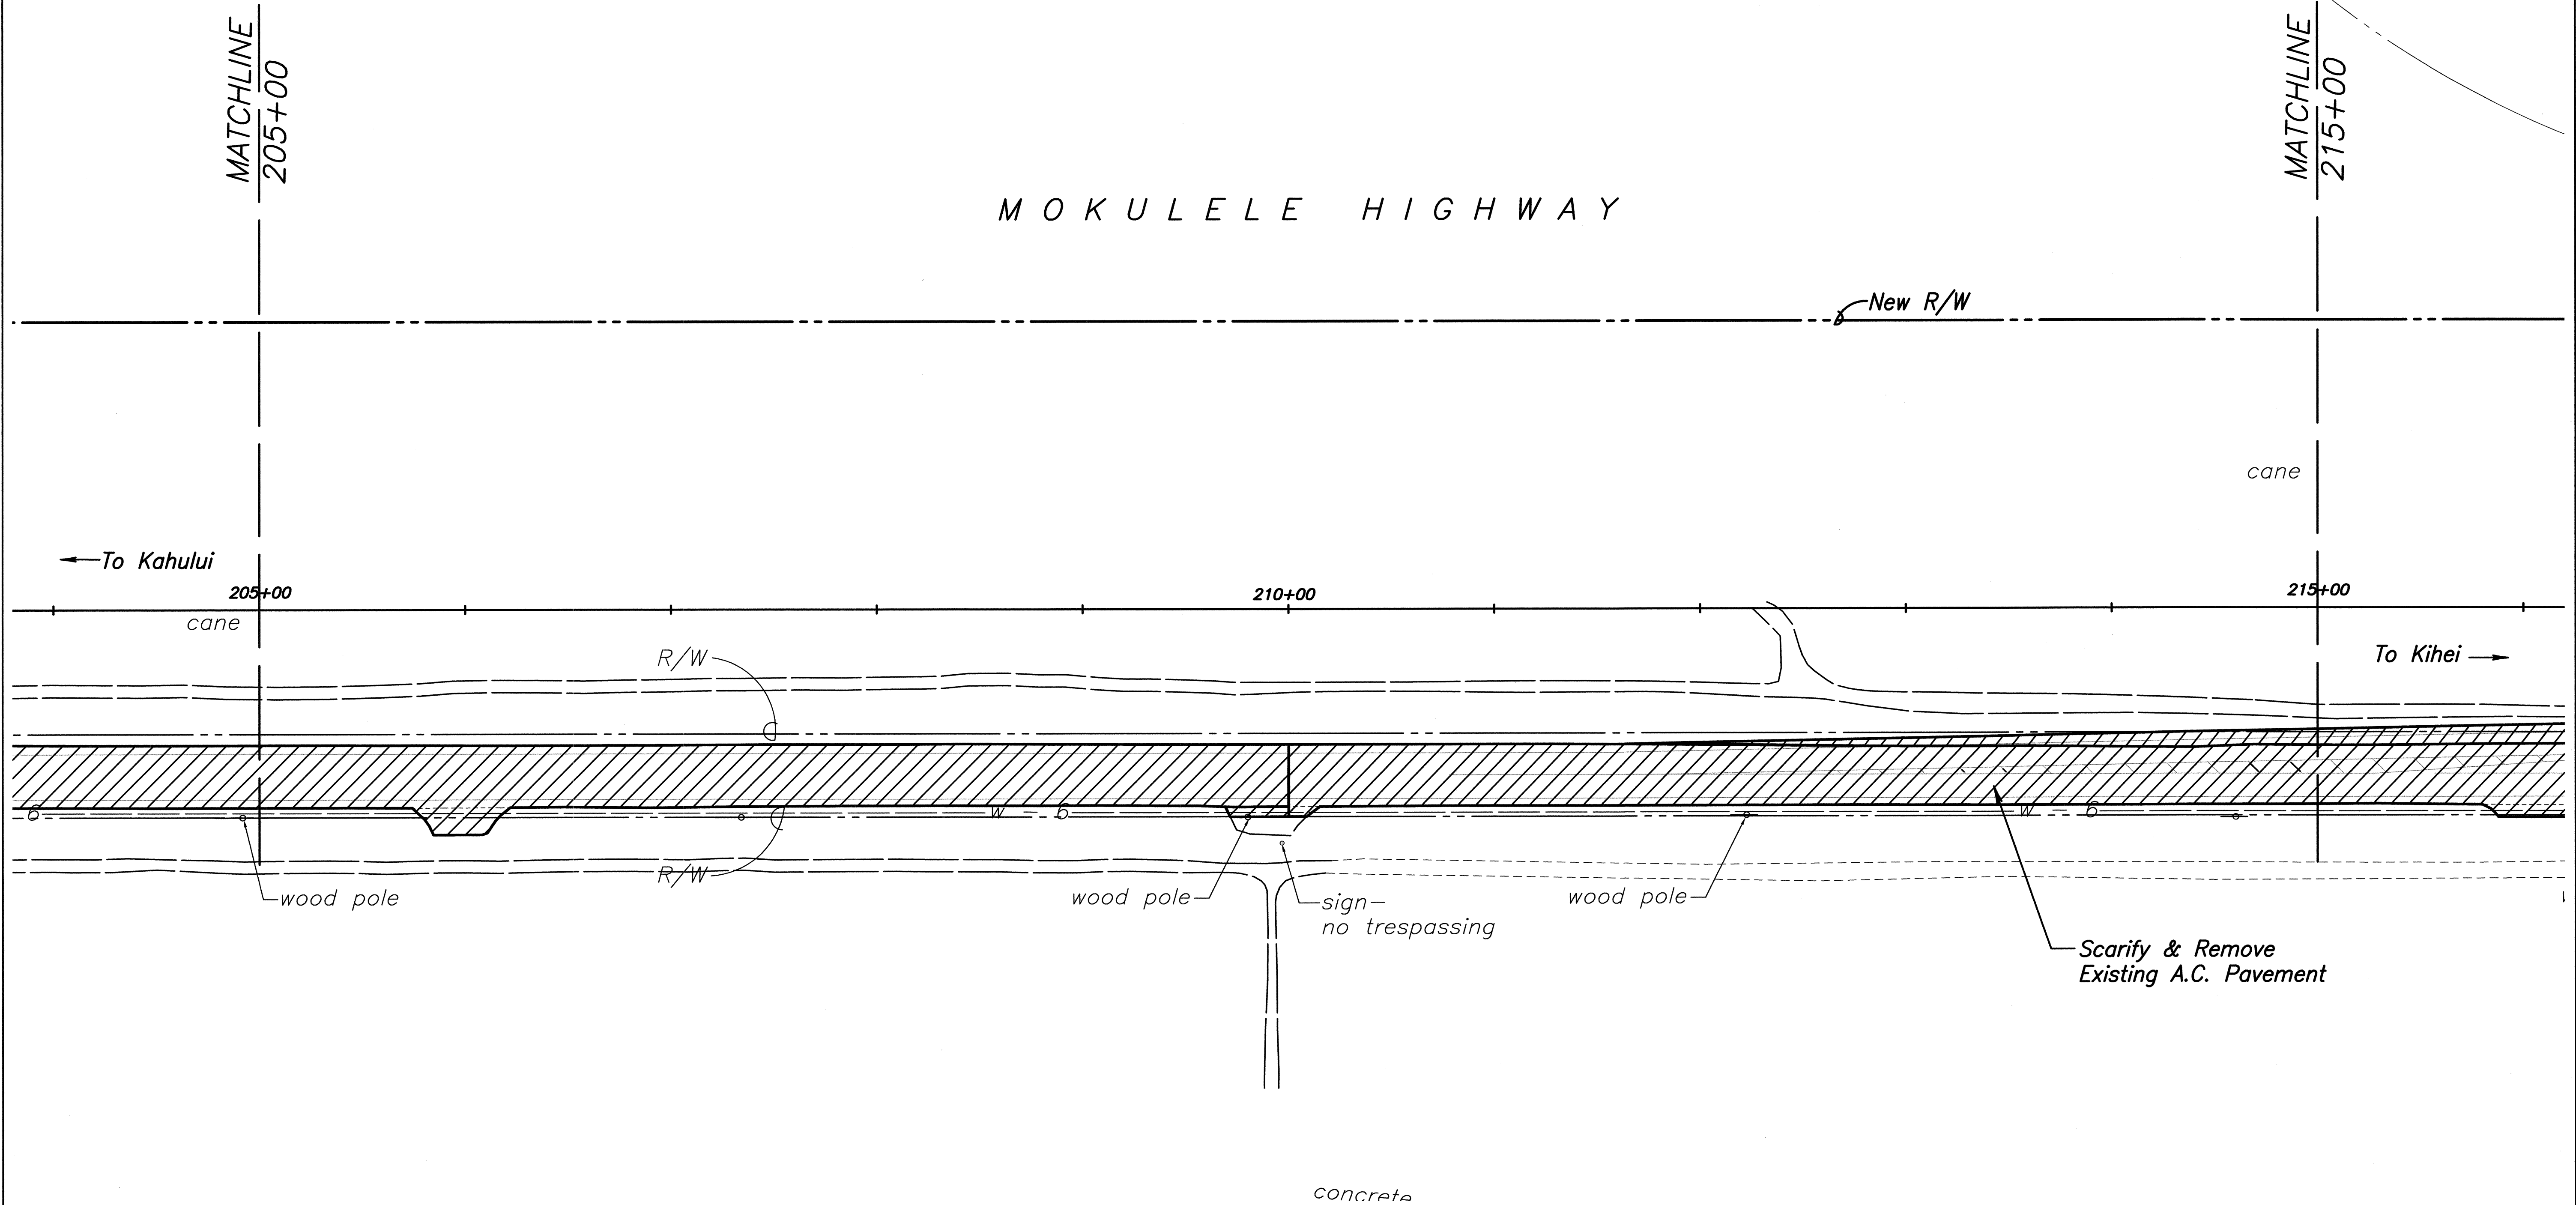

- Notes:
1. For Power Pole & Telephone Pole Removal or Relocations, refer to Electrical Plans.
 2. For Sign Removals or Relocations, refer to Signing & Pavement Marking Plan.
 3. All trees, pavement, structures and obstructions within the project's right of way, shall be removed, unless otherwise noted on the plans. Removal of these items shall be considered incidental to clearing and grubbing pay item.

SURVEY PLOTTED BY	DATE
DRAWN BY	
TRACED BY	
DESIGNED BY	
CHECKED BY	
ORIGINAL PLAN	
NOTE BOOK	
No.	

CLIFFORD M. ARAKAWA
LICENSED PROFESSIONAL ENGINEER
No. 1884-C
HAWAII U.S.A.

Clifford M. Arakawa
THIS WORK WAS PREPARED BY ME OR UNDER MY SUPERVISION
04/30/06
EXPIRATION DATE OF THE LICENSE

STATE OF HAWAII
DEPARTMENT OF TRANSPORTATION
HIGHWAYS DIVISION


DEMOLITION PLAN

MOKULELE HIGHWAY WIDENING

Maui Humane Society
To
Vicinity of Kolaloa Bridge
Federal - Aid Project No. NH-A311(6)R
Scale: 1"=40' Date: JUNE 2005

SHEET No. 5 OF 11 SHEETS


FED. ROAD DIST. NO.	STATE	FEDERAL - AID PROJ. NO.	FISCAL YEAR	SHEET NO.	TOTAL SHEETS
HAWAII	HAW.	NH-A311(6)R	2006	19	173

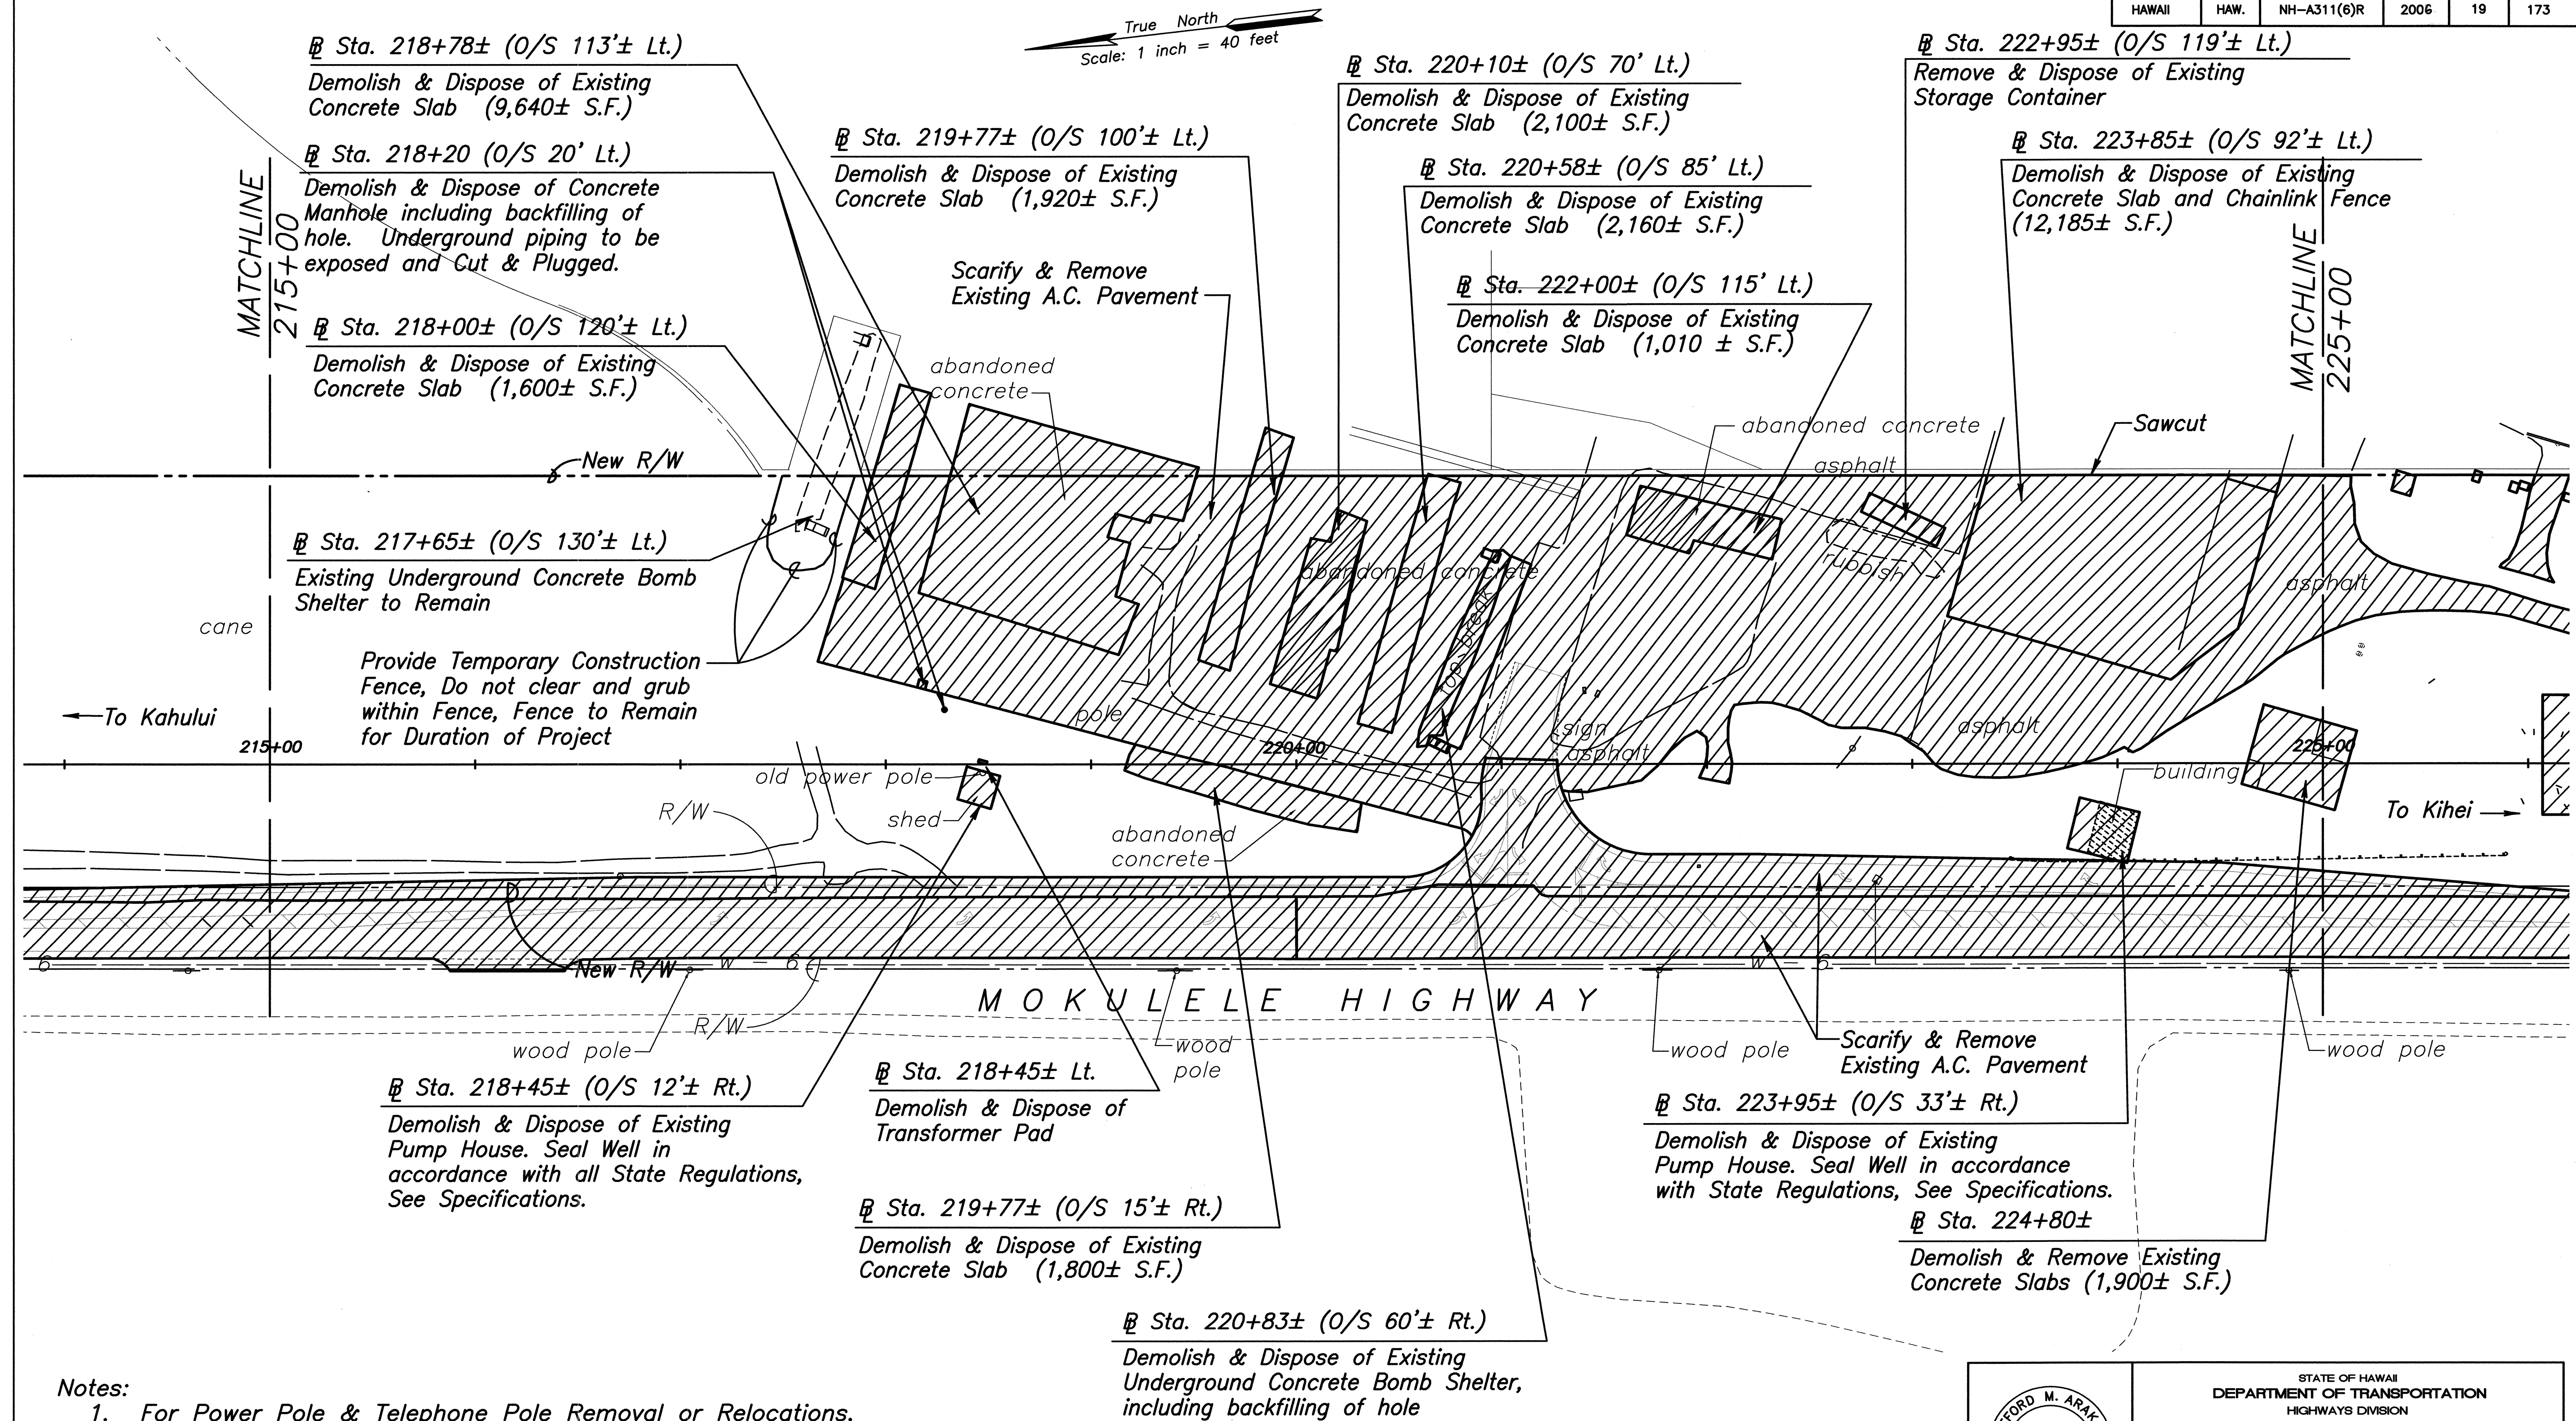

Notes:

1. For Power Pole & Telephone Pole Removal or Relocations, refer to Electrical Plans.
2. For Sign Removals or Relocations, refer to Signing & Pavement Marking Plan.
3. All trees, pavement, structures and obstructions within the project's right of way, shall be removed, unless otherwise noted on the plans. Removal of these items shall be considered incidental to clearing and grubbing pay item.

SURVEY PLOTTED BY	DATE
DRAWN BY	
DESIGNED BY	
QUANTITIES BY	
CHECKED BY	
NOTE BOOK	
No.	

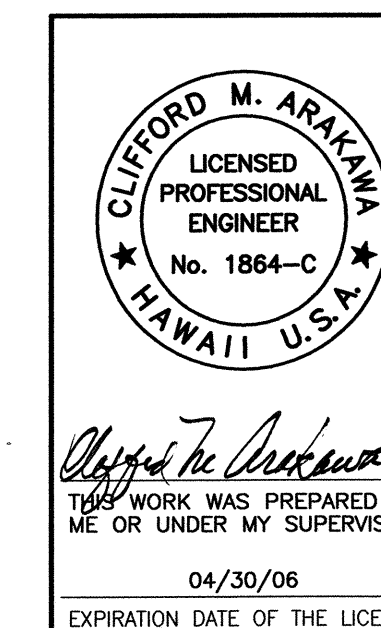

STATE OF HAWAII
DEPARTMENT OF TRANSPORTATION
HIGHWAYS DIVISION

DEMOLITION PLAN

MOKULELE HIGHWAY WIDENING

Maui Humane Society

To
Vicinity of Kolaloa Bridge

Federal - Aid Project No. NH-A311(6)R

Scale: 1"=40' Date: JUNE 2005

SHEET No. 6 OF 11 SHEETS

FED. ROAD DIST. NO.	STATE	FEDERAL - AID PROJ. NO.	FISCAL YEAR	SHEET NO.	TOTAL SHEETS
HAWAII	HAW.	NH-A311(6)R	2006	20	173

Sta. 225+40± Lt. to
Sta. 226+43± Lt.

Existing Fuel Storage Tanks to be
Removed and Disposed
(By Others)

Sta. 228+10± (O/S 115'± Rt.)

Existing Underground Concrete Bomb
Shelter to Remain

Sta. 230+40± (O/S 25'± Lt.)

Demolish & Dispose of Existing
Underground Concrete Bomb Shelter,
including backfilling of hole

Sta. 231+40± (O/S 58' Lt.)

Demolish & Dispose of Existing
Concrete Slab (2,160± S.F.)

Sta. 231+95± (O/S 20' Rt.)

Remove & Dispose of Railroad
Tracks

Sta. 229+42± (O/S 80'± Rt.)

Demolish & Dispose of Existing
Concrete Slabs and Transformer
Pad (6,900± S.F.)

Sta. 226+20±

Close Existing Septic Tanks
in accordance with State
Dept. of Health Regulations
(3 ea.) See Specifications.

Notes:

- For Power Pole & Telephone Pole Removal or Relocations, refer to Electrical Plans.
- For Sign Removals or Relocations, refer to Signing & Pavement Marking Plan.
- All trees, pavement, structures and obstructions within the project's right of way, shall be removed, unless otherwise noted on the plans. Removal of these items shall be considered incidental to clearing and grubbing pay item.

SURVEY PLOTTED BY	DATE
DRAWN BY	
TRACED BY	
DESIGNED BY	
CHECKED BY	
ORIGINAL PLAN	No.
NOTE BOOK	

True North
Scale: 1 inch = 40 feet

STA 3913-3 (PK
23,923.95 FT. S
10,094.47 FT. E

Limits of
Construction
Parcel

Provide Temporary Construction
Fence, Do not clear and grub
within Fence, Fence to Remain
for Duration of Project

rubbish

STA 3913-7 (PK
24,005.6 FT. SOUTH
9,742.1 FT. EAST
EL. = 38.5

ACCESS EASEMENT "A"

New R/W

sign-
no dumping
sign-
no trespassing

railroad tracks

pipe

sign

sign

STA 3913-21 (PK
24,017.85 FT. SOUTH
8,443.3 FT. EAST
EL. = 38.67

MEHAMEHA LOOP
(SOUTH)



WORK WAS PREPARED BY
ME OR UNDER MY SUPERVISION
04/30/06
EXPIRATION DATE OF THE LICENSE

STATE OF HAWAII
DEPARTMENT OF TRANSPORTATION
HIGHWAYS DIVISION

DEMOLITION PLAN

MOKULELE HIGHWAY WIDENING

Maui Humane Society


To
Vicinity of Kolaloa Bridge

Federal - Aid Project No. NH-A311(6)R

Scale: 1"=40' Date: JUNE 2005

SHEET No. 7 OF 11 SHEETS

FED. ROAD DIST. NO.	STATE	FEDERAL - AID PROJ. NO.	FISCAL YEAR	SHEET NO.	TOTAL SHEETS
HAWAII	HAW.	NH-A311(6)R	2006	21	173

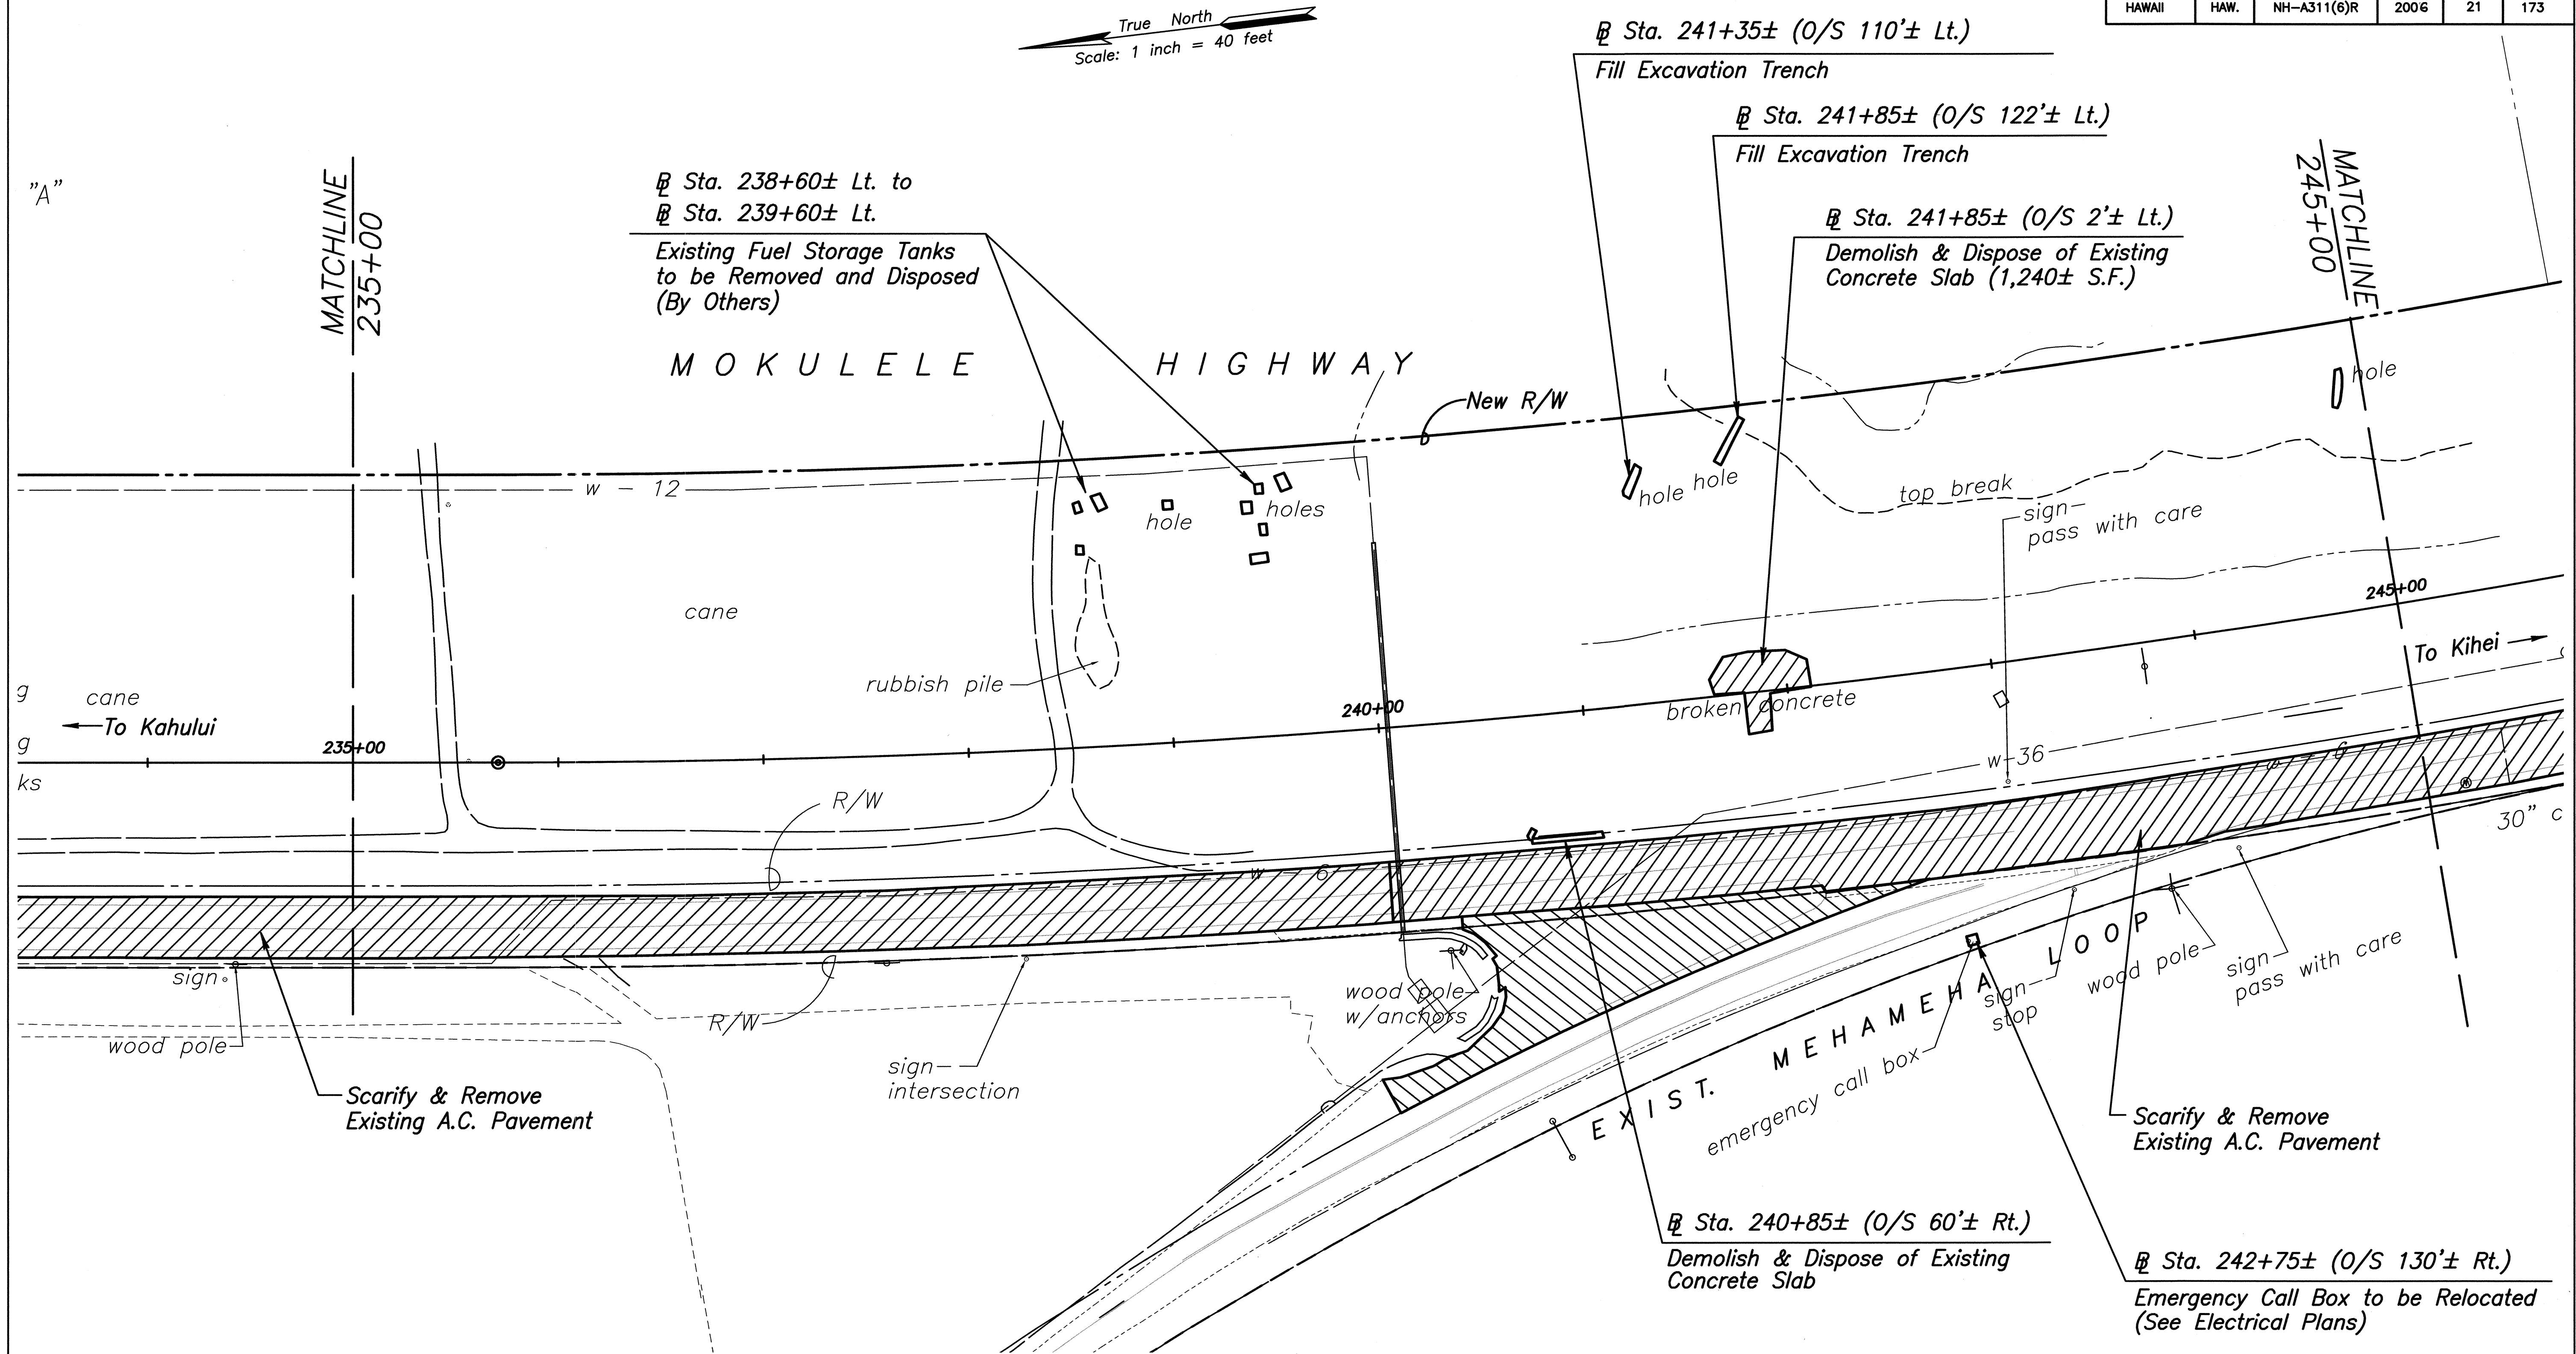

- Notes:
1. For Power Pole & Telephone Pole Removal or Relocations, refer to Electrical Plans.
 2. For Sign Removals or Relocations, refer to Signing & Pavement Marking Plan.
 3. All trees, pavement, structures and obstructions within the project's right of way, shall be removed, unless otherwise noted on the plans. Removal of these items shall be considered incidental to clearing and grubbing pay item.

SURVEY PLOTTED BY	DATE
DRAWN BY	
DESIGNED BY	
CHECKED BY	
ORIGINAL PLAN	
NOTE BOOK	
No.	

CLIFFORD M. ARAKAWA
LICENSED PROFESSIONAL ENGINEER
No. 1864-C
HAWAII U.S.A.

THIS WORK WAS PREPARED BY ME OR UNDER MY SUPERVISION
04/30/06
EXPIRATION DATE OF THE LICENSE

STATE OF HAWAII
DEPARTMENT OF TRANSPORTATION
HIGHWAYS DIVISION

DEMOLITION PLAN


MOKULELE HIGHWAY WIDENING

Maui Humane Society
To
Vicinity of Kolaloa Bridge
Federal - Aid Project No. NH-A311(6)R
Scale: 1"=40' Date: JUNE 2005

SHEET No. 8 OF 11 SHEETS

FED. ROAD DIST. NO.	STATE	FEDERAL - AID PROJ. NO.	FISCAL YEAR	SHEET NO.	TOTAL SHEETS
HAWAII	HAW.	NH-A311(6)R	2006	23	173

True North
Scale: 1 inch = 40 feet

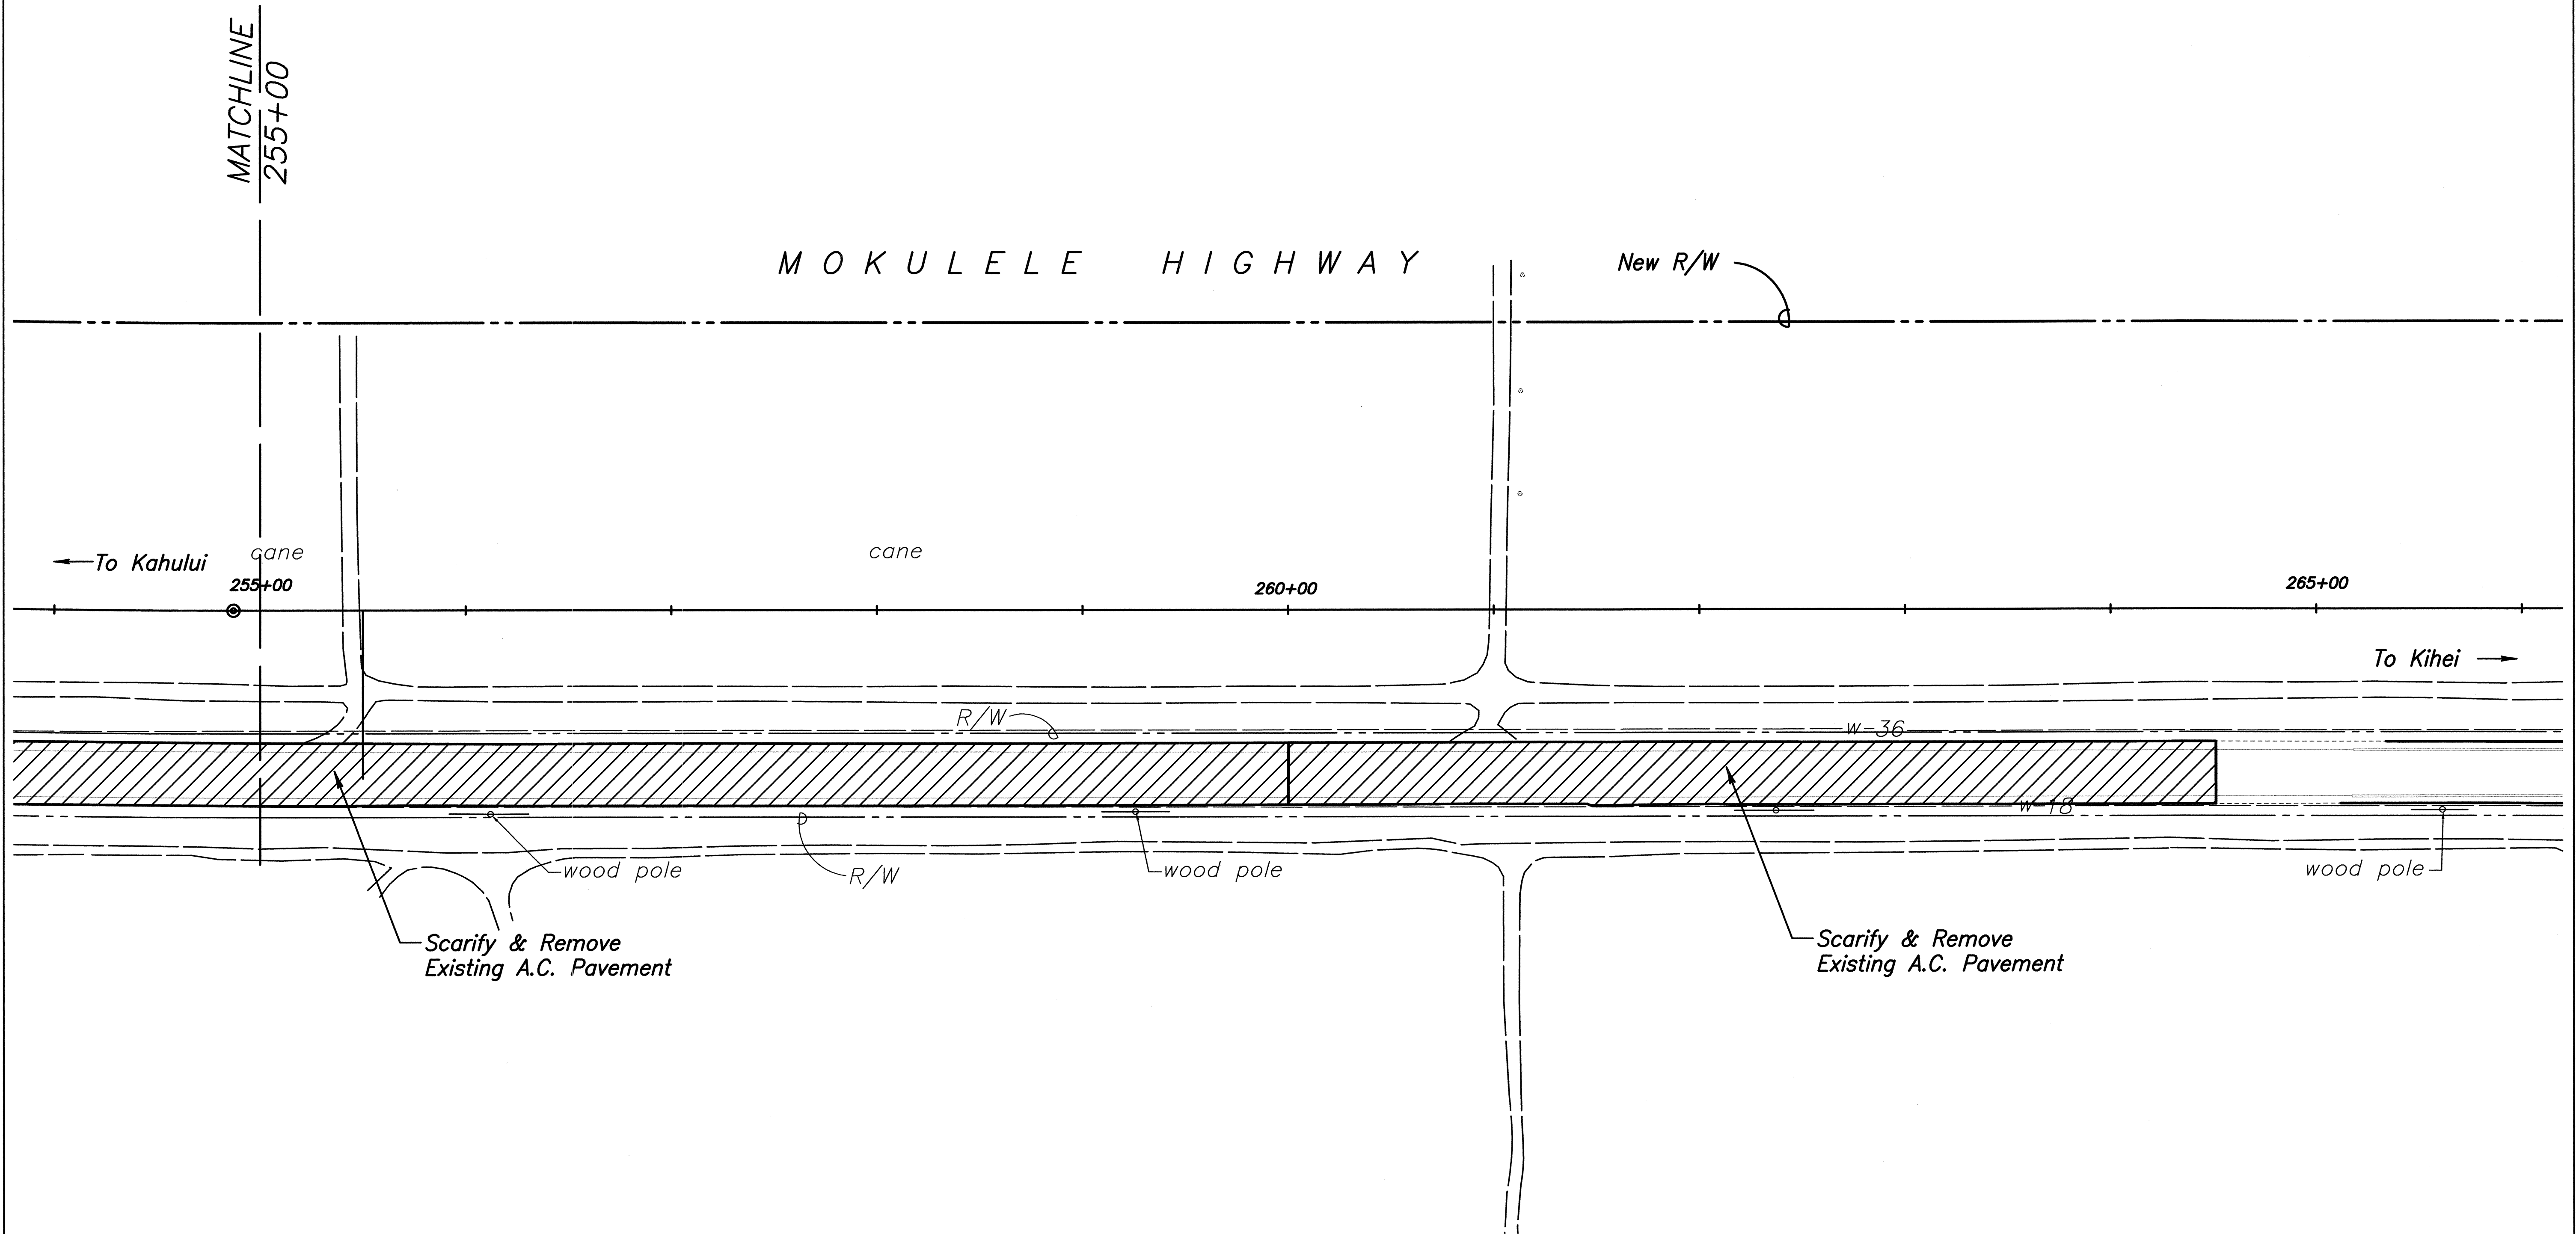

Notes:

1. For Power Pole & Telephone Pole Removal or Relocations, refer to Electrical Plans.
2. For Sign Removals or Relocations, refer to Signing & Pavement Marking Plan.
3. All trees, pavement, structures and obstructions within the project's right of way, shall be removed, unless otherwise noted on the plans. Removal of these items shall be considered incidental to clearing and grubbing pay item.

ORIGINAL PLAN	SURVEY PLOTTED BY	DATE
NOTE BOOK	DRAWN BY	
DESIGNED BY	TRACED BY	
CHECKED BY	DESIGNED BY	
No.	CHECKED BY	

STATE OF HAWAII
DEPARTMENT OF TRANSPORTATION
HIGHWAYS DIVISION

DEMOLITION PLAN

MOKULELE HIGHWAY WIDENING

Maui Humane Society
To
Vicinity of Kolaloa Bridge
Federal - Aid Project No. NH-A311(6)R
Scale: 1"=40' Date: JUNE 2005


SHEET No. 10 OF 11 SHEETS

CLIFFORD M. ARAKAWA
LICENSED PROFESSIONAL ENGINEER
No. 1864-C
HAWAII U.S.A.

Clifford M. Arakawa
THE WORK WAS PREPARED BY
ME OR UNDER MY SUPERVISION
04/30/06
EXPIRATION DATE OF THE LICENSE

FED. ROAD DIST. NO.	STATE	FEDERAL - AID PROJ. NO.	FISCAL YEAR	SHEET NO.	TOTAL SHEETS
HAWAII	HAW.	NH-A311(6)R	2006	24	173

Scale: 1 inch = 40 feet
True North

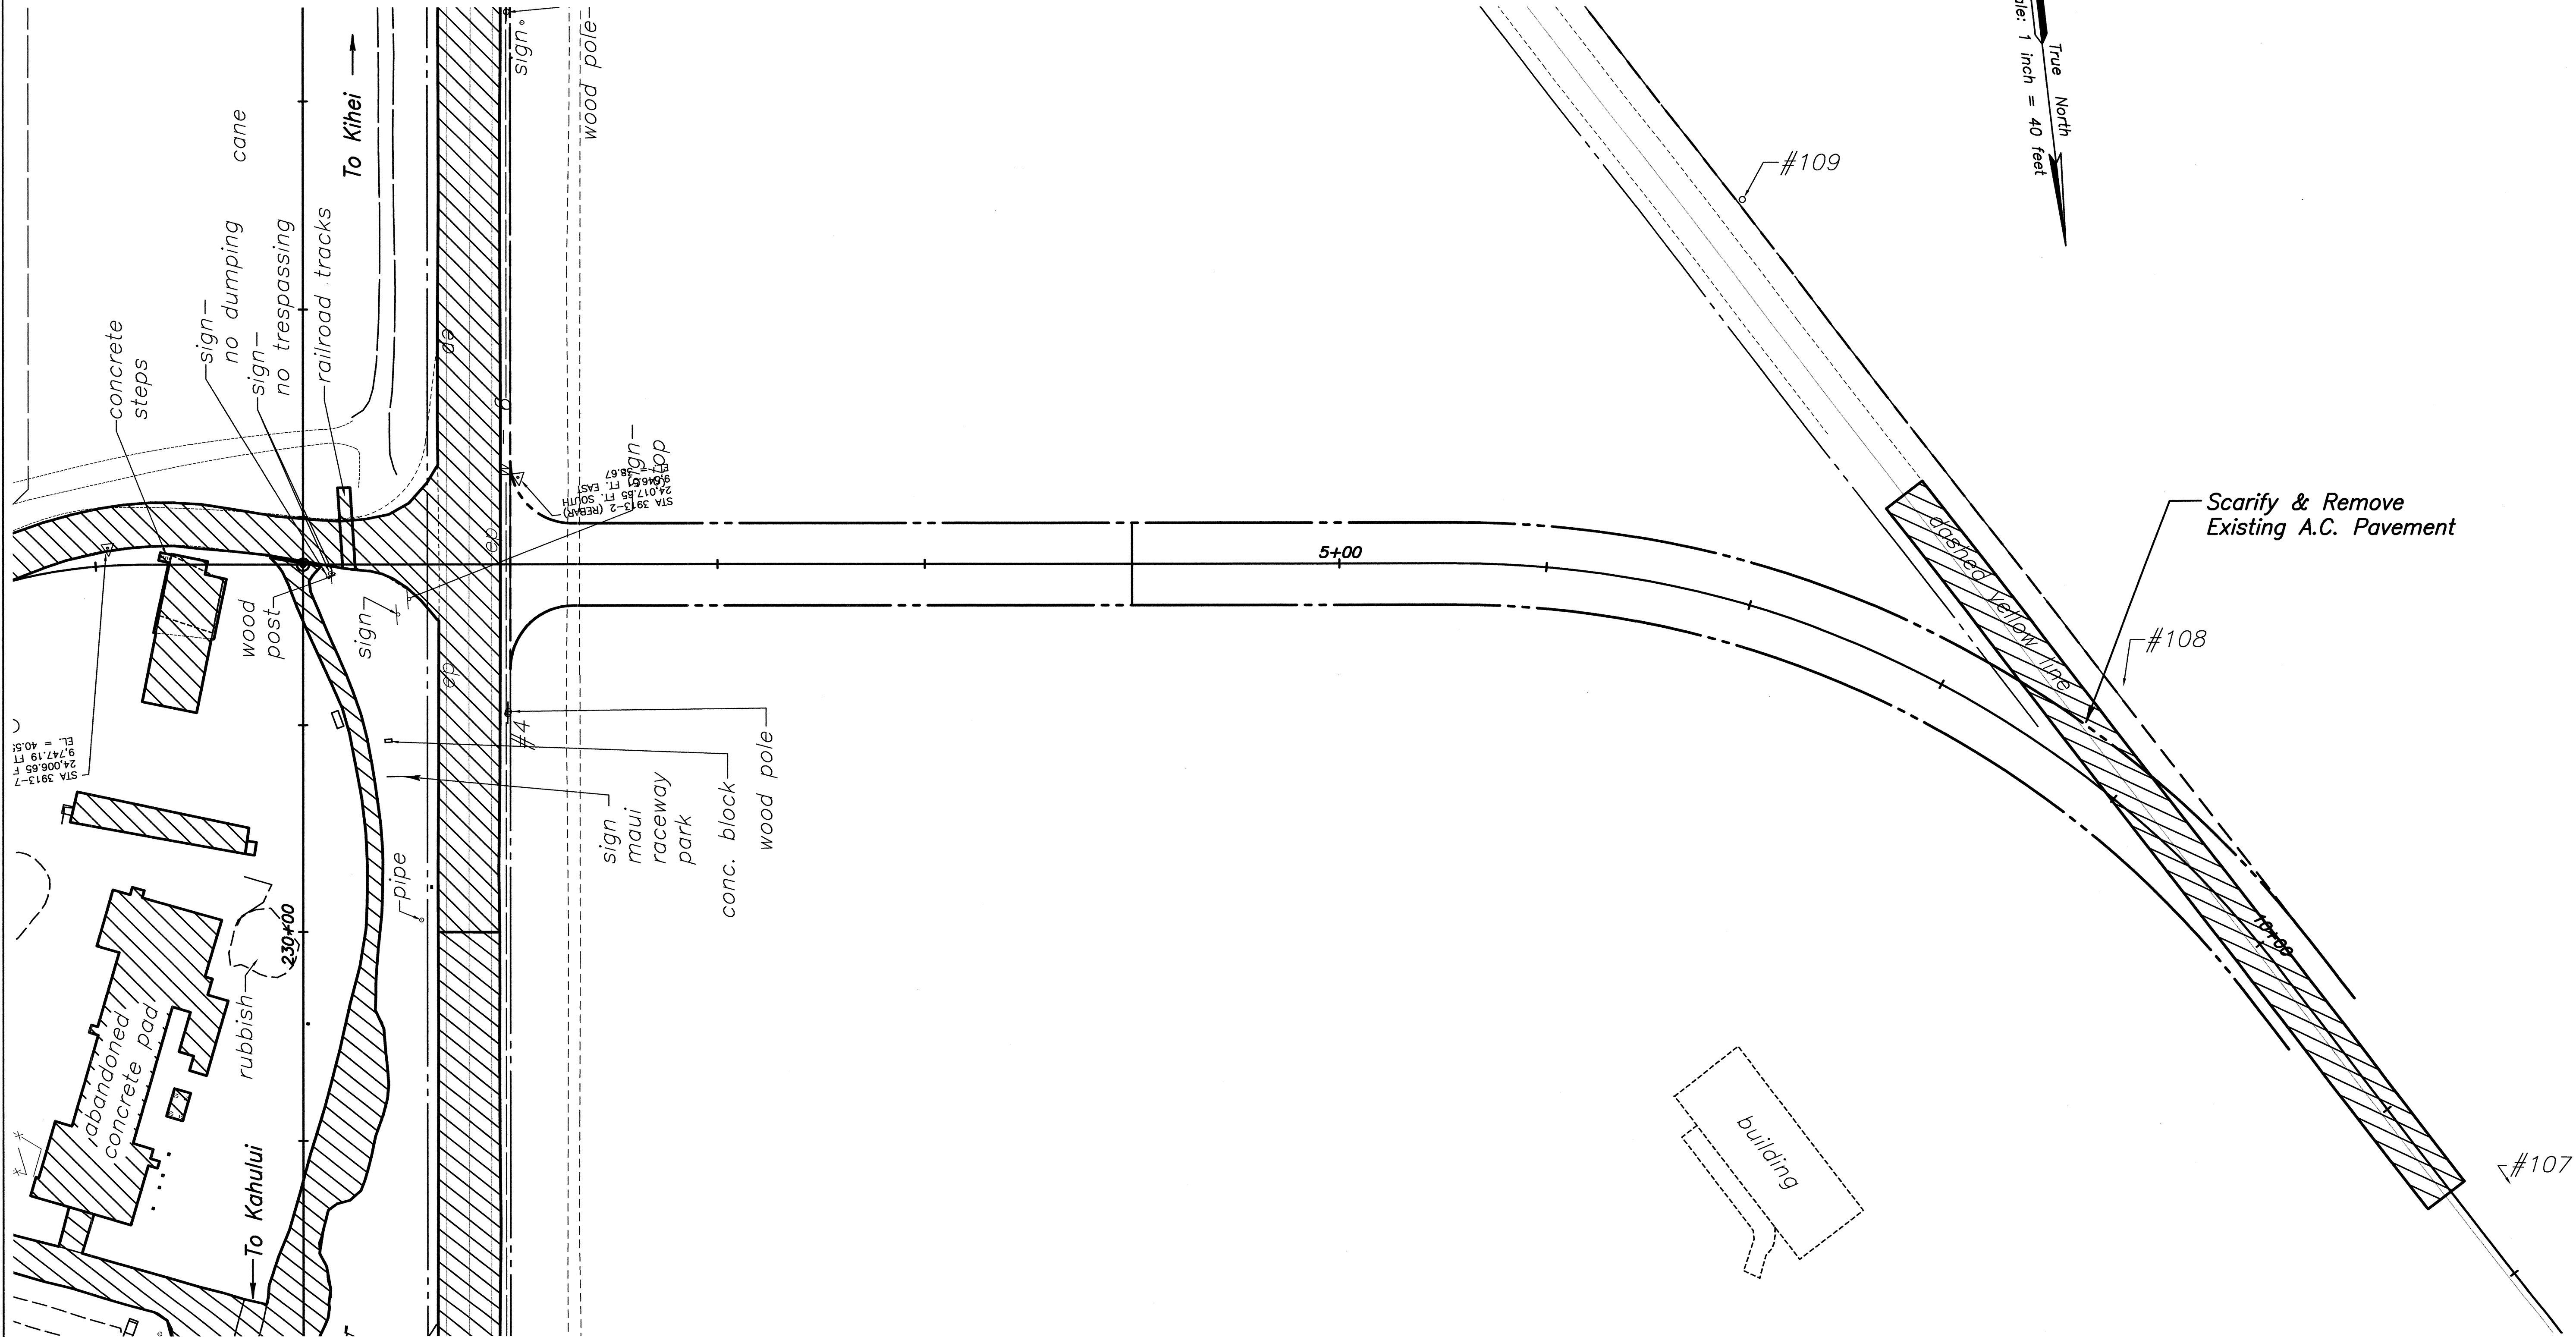

Notes:

1. For Power Pole & Telephone Pole Removal or Relocations, refer to Electrical Plans.
2. For Sign Removals or Relocations, refer to Signing & Pavement Marking Plan.
3. All trees, pavement, structures and obstructions within the project's right of way, shall be removed, unless otherwise noted on the plans. Removal of these items shall be considered incidental to clearing and grubbing pay item.

ORIGINAL PLAN	SURVEY PLOTTED BY	DATE
NOTE BOOK	DRAWN BY	
	DESIGNED BY	
	CHECKED BY	

CLIFFORD M. ARAKAWA
LICENSED PROFESSIONAL ENGINEER
No. 1864-C
HAWAII, U.S.A.

Clifford M. Arakawa
THE WORK WAS PREPARED BY ME OR UNDER MY SUPERVISION
04/30/06
EXPIRATION DATE OF THE LICENSE

STATE OF HAWAII
DEPARTMENT OF TRANSPORTATION
HIGHWAYS DIVISION

DEMOLITION PLAN

MOKULELE HIGHWAY WIDENING

Maui Humane Society
To
Vicinity of Kolaloa Bridge
Federal - Aid Project No. NH-A311(6)R
Scale: 1"=40' Date: JUNE 2005

SHEET No. 11 OF 11 SHEETS