
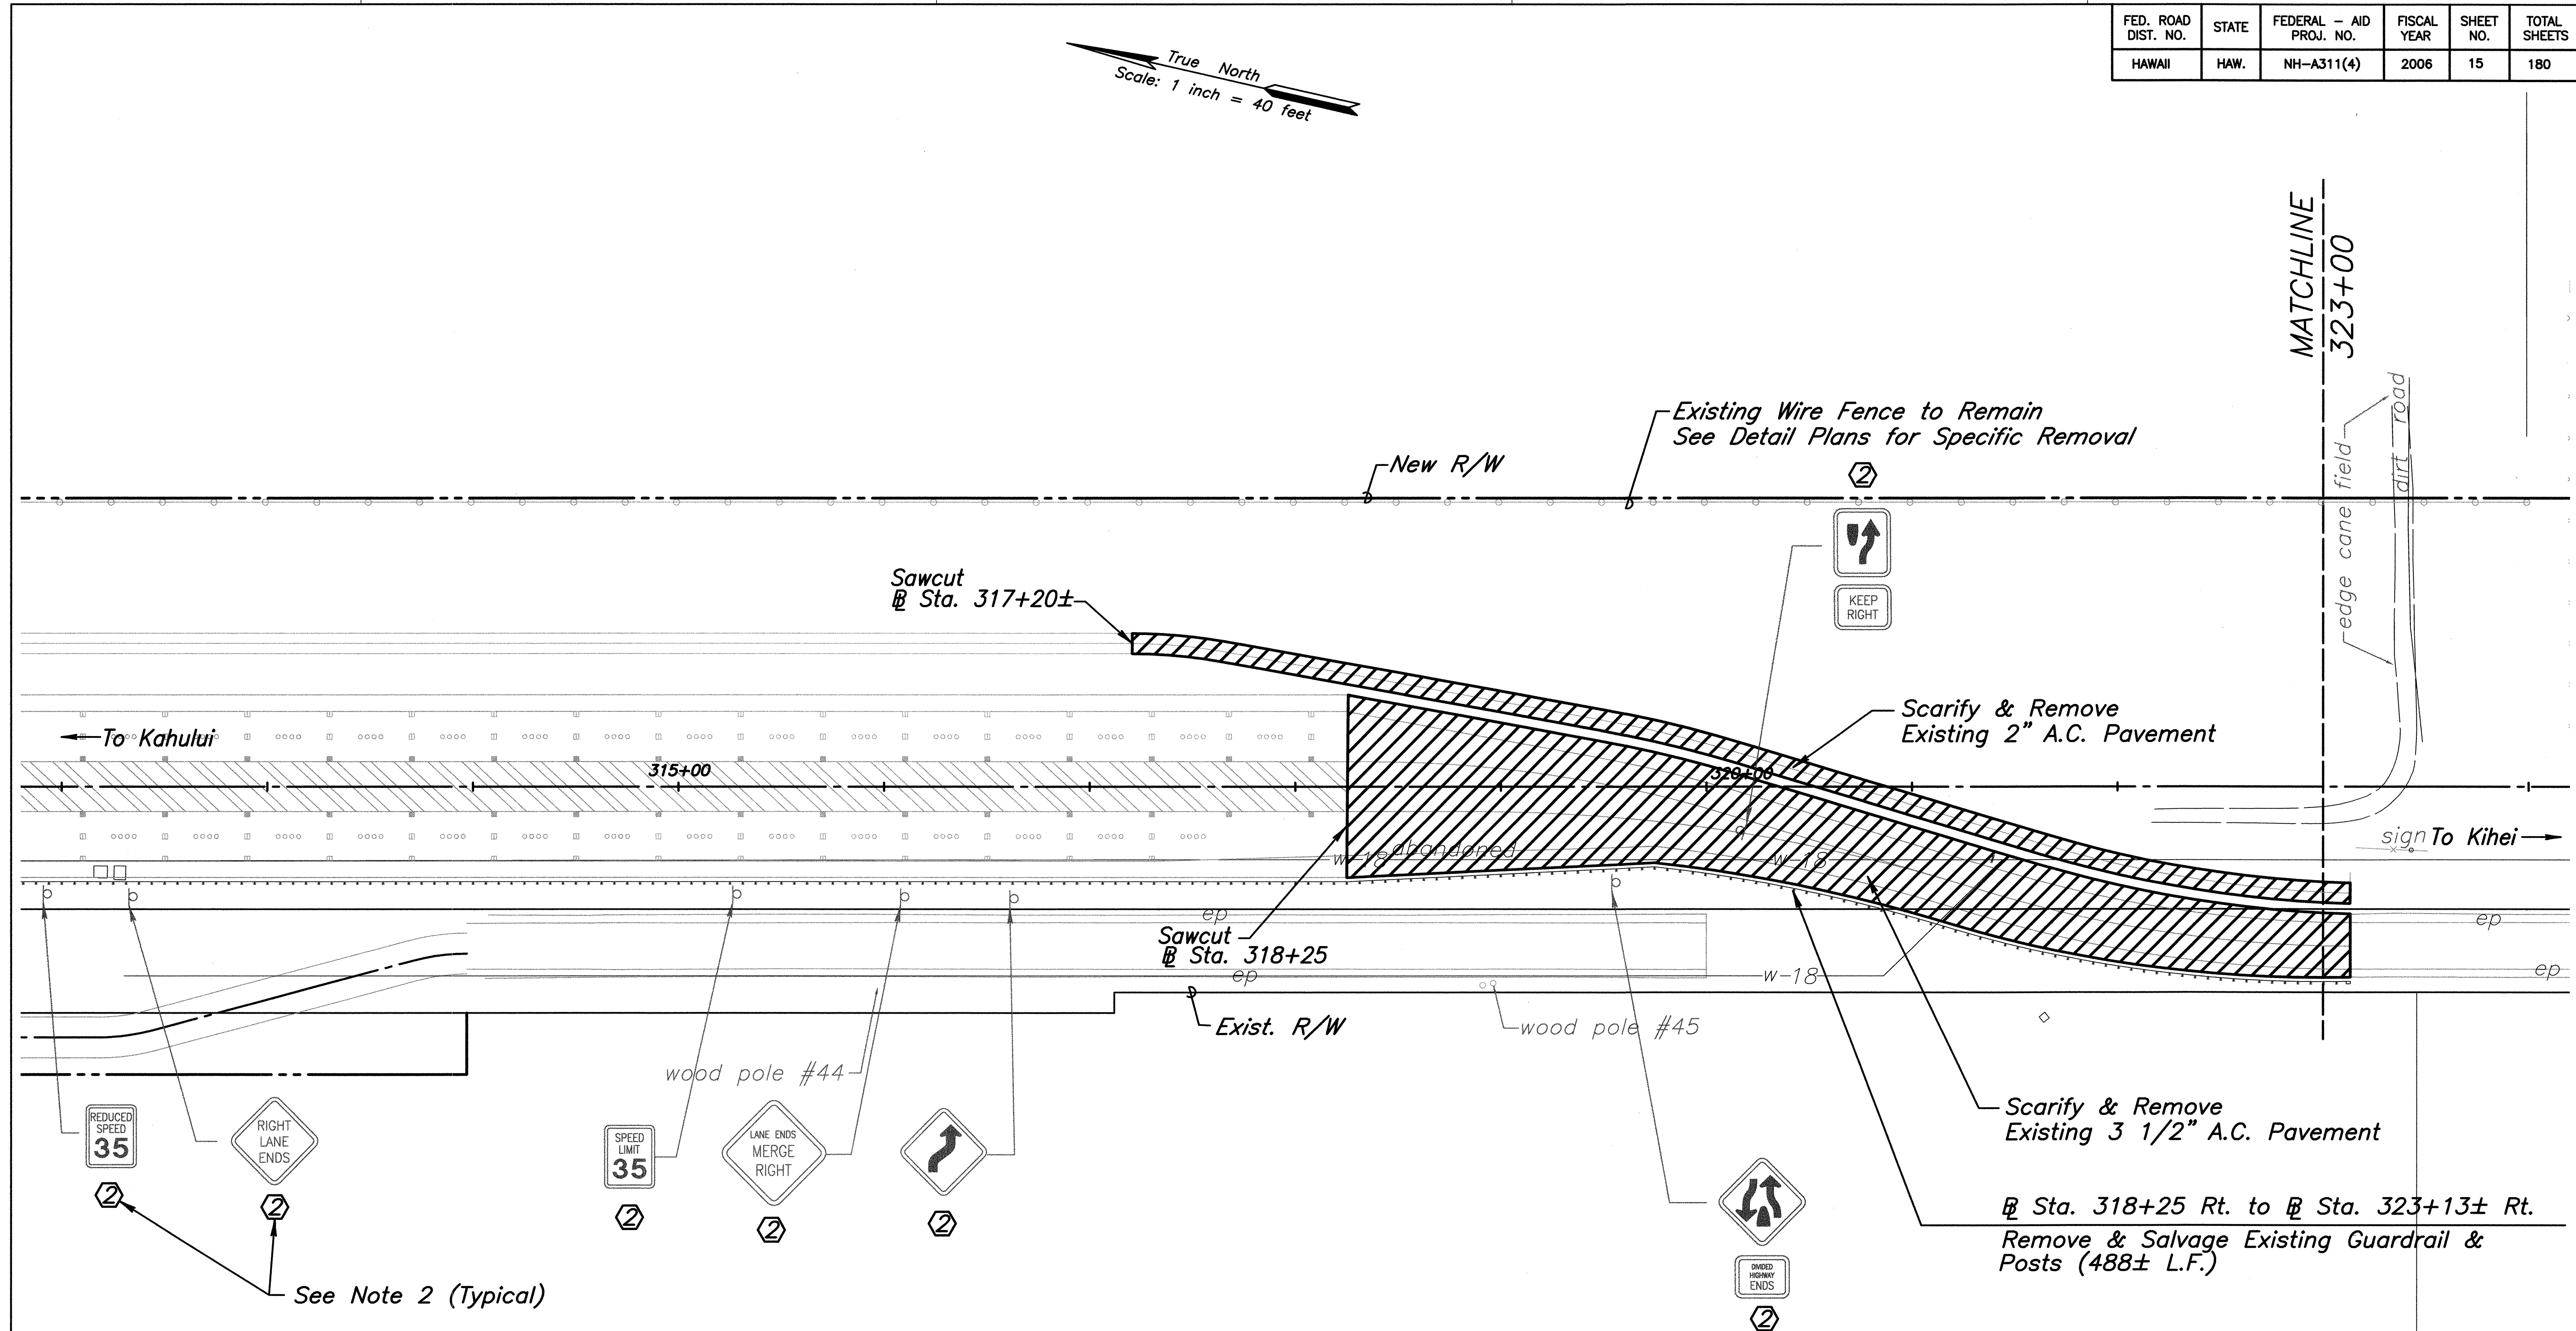


FED. ROAD DIST. NO.	STATE	FEDERAL - AID PROJ. NO.	FISCAL YEAR	SHEET NO.	TOTAL SHEETS
HAWAII	HAW.	NH-A311(4)	2006	15	180

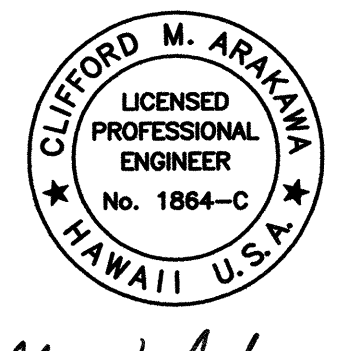


Notes:

1. For Power Pole & Telephone Pole Removal or Relocations, refer to Electrical Plans.
2. Remove existing sign(s) & post(s).
3. All trees, pavement, structures and obstructions within the project's right of way, shall be removed, unless otherwise noted on the plans. Removal of these items shall be considered incidental to clear and grub pay item.

 THE WORK WAS PREPARED BY ME OR UNDER MY SUPERVISION 04/30/06 EXPIRATION DATE OF THE LICENSE	STATE OF HAWAII DEPARTMENT OF TRANSPORTATION HIGHWAYS DIVISION DEMOLITION PLAN MOKULELE HIGHWAY WIDENING Vicinity of Kealia Pond Driveway To Piilani Highway Federal - Aid Project No. NH-A311(4) Scale: 1"=40' Date: July 2005
	SHEET No. 1 OF 8 SHEETS
	15

SURVEY PLOTTED BY	DATE
DRAWN BY	
DESIGNED BY	
CHECKED BY	
NOTE BOOK	
No.	

FED. ROAD DIST. NO.	STATE	FEDERAL - AID PROJ. NO.	FISCAL YEAR	SHEET NO.	TOTAL SHEETS
HAWAII	HAW.	NH-A311(4)	2006	16	180

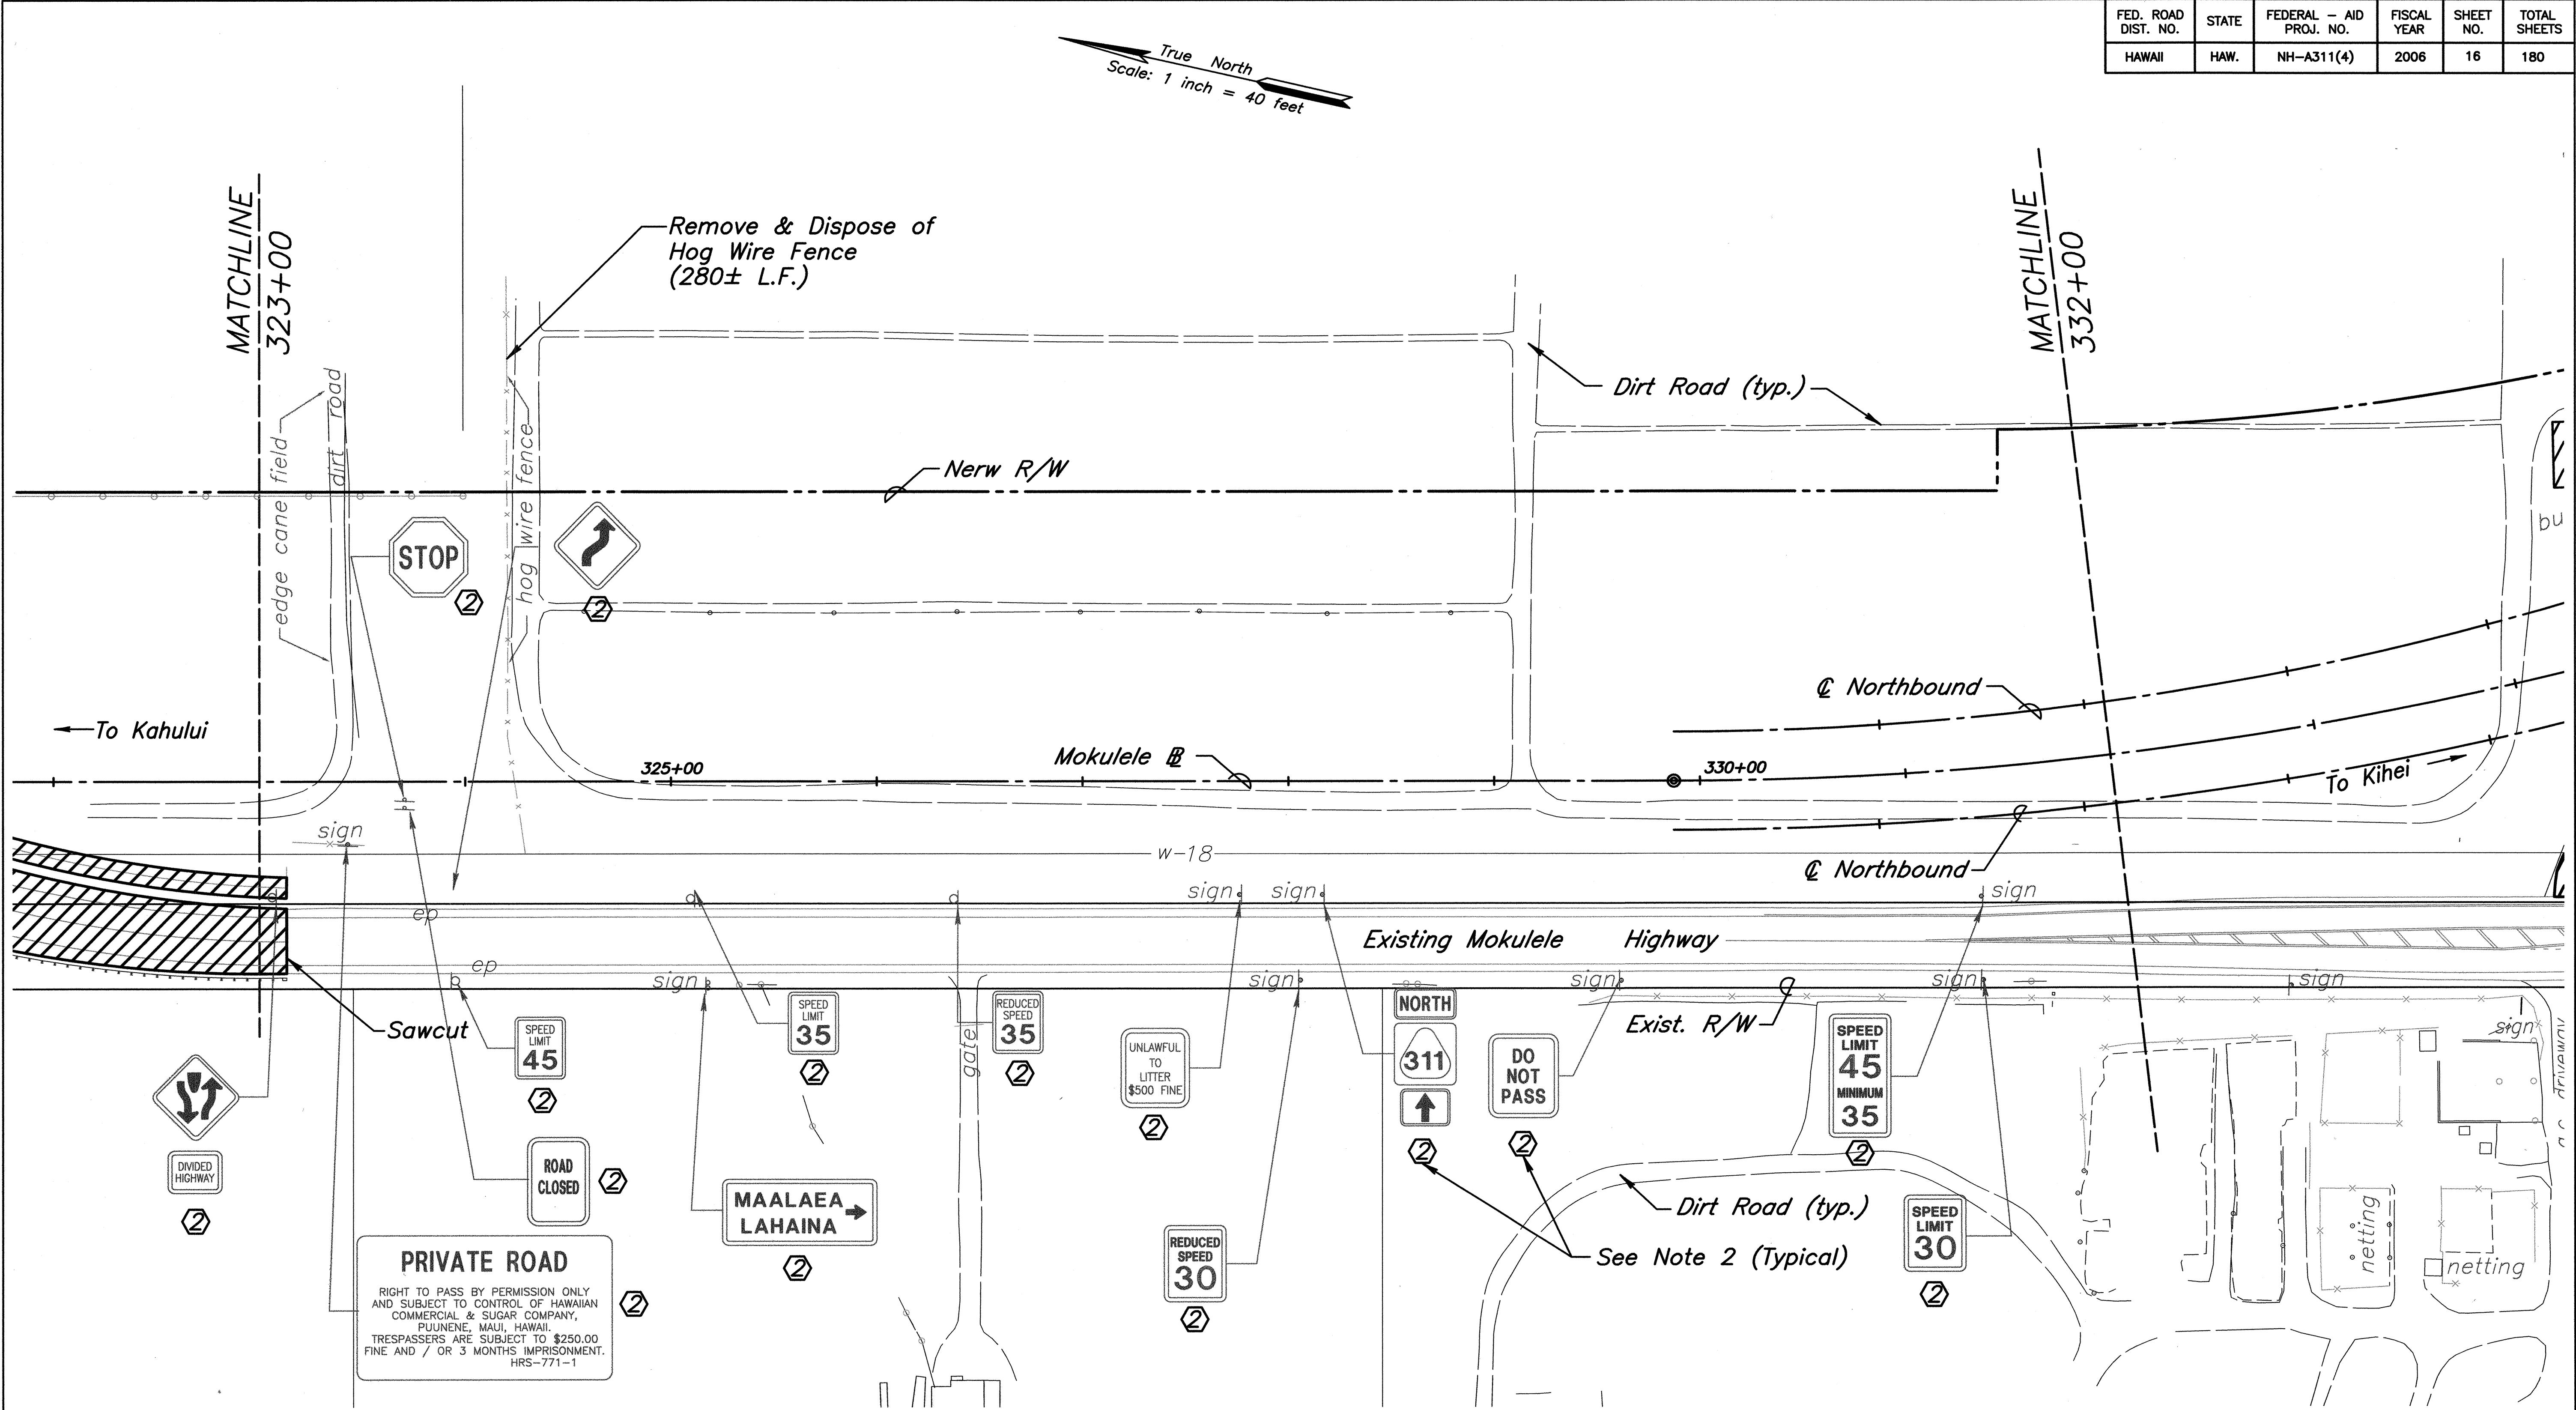

- Notes:**
1. For Power Pole & Telephone Pole Removal or Relocations, refer to Electrical Plans.
 2. Remove existing sign(s) & post(s).
 3. All trees, pavement, structures and obstructions within the project's right of way, shall be removed, unless otherwise noted on the plans. Removal of these items shall be considered incidental to clear and grub pay item.

ORIGINAL PLAN	DATE
SURVEY PLOTTED BY	
DRAWN BY	
DESIGNED BY	
CHECKED BY	
NO.	

THIS WORK WAS PREPARED BY ME OR UNDER MY SUPERVISION
04/30/06
EXPIRATION DATE OF THE LICENSE


STATE OF HAWAII
DEPARTMENT OF TRANSPORTATION
HIGHWAYS DIVISION

DEMOLITION PLAN

MOKULELE HIGHWAY WIDENING
Vicinity of Kealia Pond Driveway
To
Piilani Highway
Federal - Aid Project No. NH-A311(4)
Scale: 1"=40' Date: July 2005

SHEET No. 2 OF 8 SHEETS

FED. ROAD DIST. NO.	STATE	FEDERAL - AID PROJ. NO.	FISCAL YEAR	SHEET NO.	TOTAL SHEETS
HAWAII	HAW.	NH-A311(4)	2006	19	180

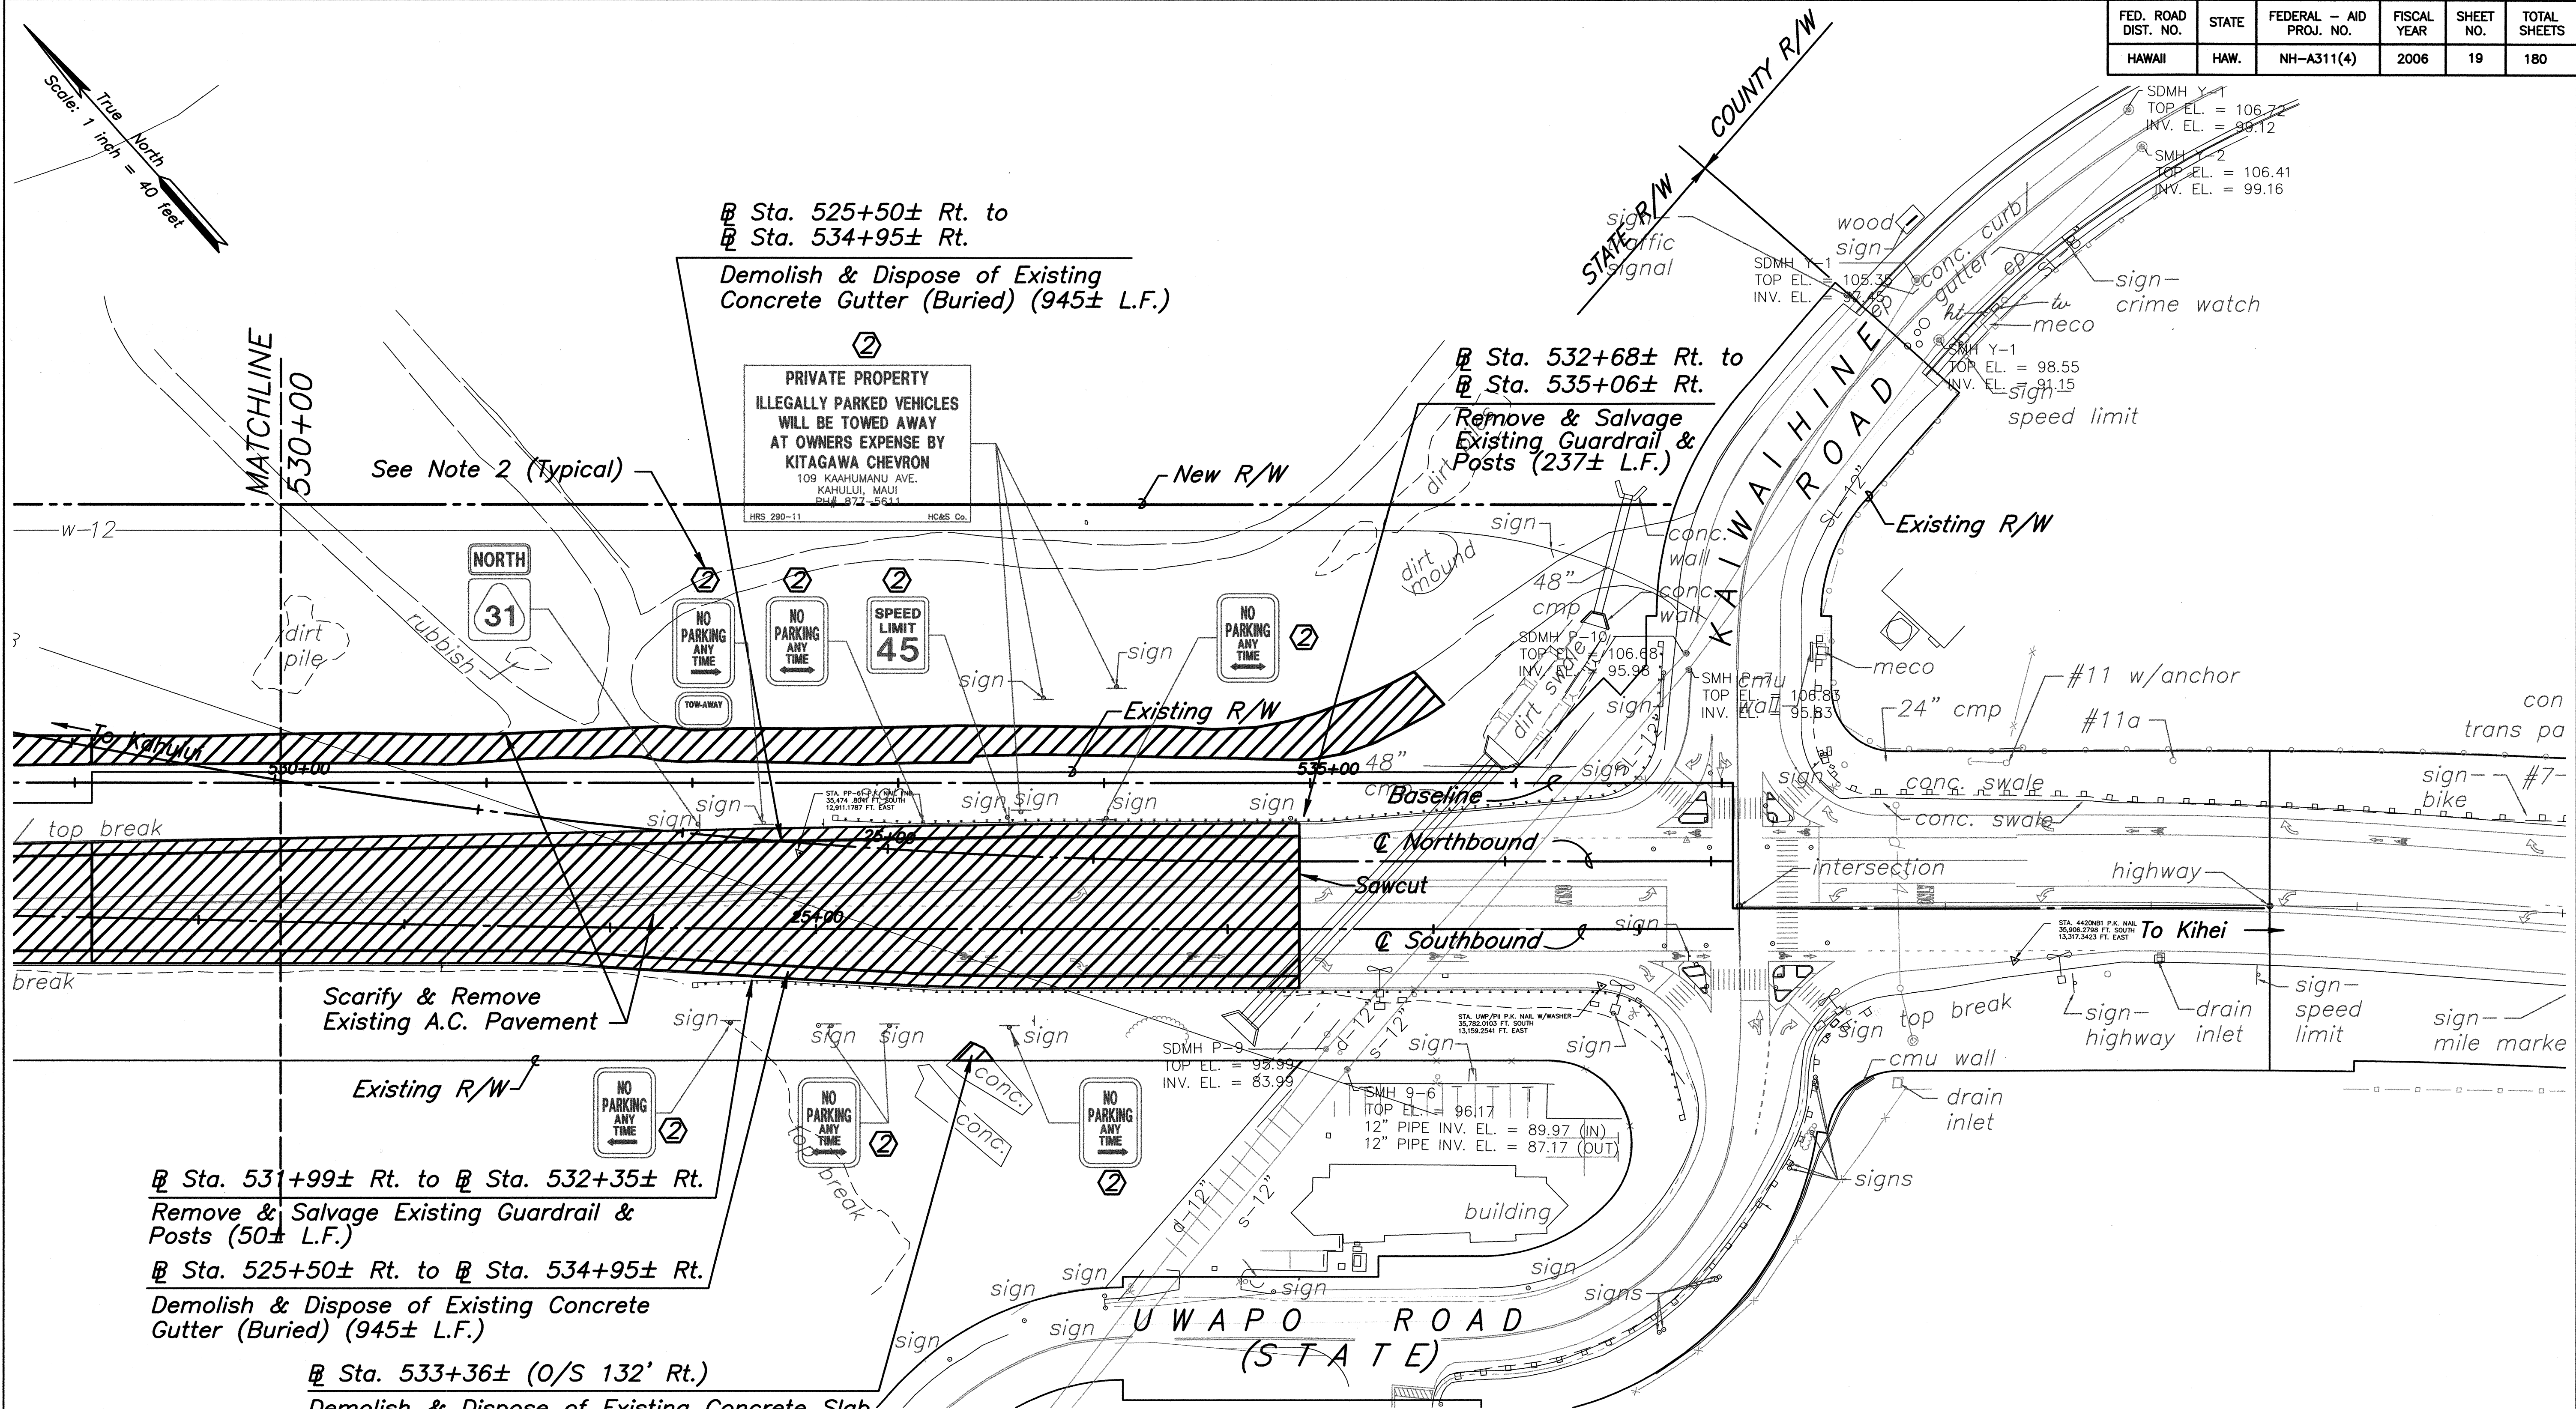

Notes:

- For Power Pole & Telephone Pole Removal or Relocations, refer to Electrical Plans.
- Remove existing sign(s) & post(s).
- All trees, pavement, structures and obstructions within the project's right of way, shall be removed, unless otherwise noted on the plans. Removal of these items shall be considered incidental to clear and grub pay item.

DATE	12/19/03
SURVEY PLOTTED BY	
DRAWN BY	
TRACED BY	
DESIGNED BY	
CHECKED BY	
NOTE BOOK	
QUANTITIES BY	
CHECKED BY	
No.	

CLIFFORD M. ARAKAWA
LICENSED PROFESSIONAL ENGINEER
No. 1864-C
HAWAII, U.S.A.

WORK WAS PREPARED BY ME OR UNDER MY SUPERVISION
04/30/06
EXPIRATION DATE OF THE LICENSE


STATE OF HAWAII
DEPARTMENT OF TRANSPORTATION
HIGHWAYS DIVISION

DEMOLITION PLAN

MOKULELE HIGHWAY WIDENING
Vicinity of Kealia Pond Driveway
To
Piilani Highway
Federal - Aid Project No. NH-A311(4)
Scale: 1"=40' Date: July 2005


SHEET No. 5 OF 8 SHEETS

FED. ROAD DIST. NO.	STATE	FEDERAL - AID PROJ. NO.	FISCAL YEAR	SHEET NO.	TOTAL SHEETS
HAWAII	HAW.	NH-A311(4)	2006	20	180

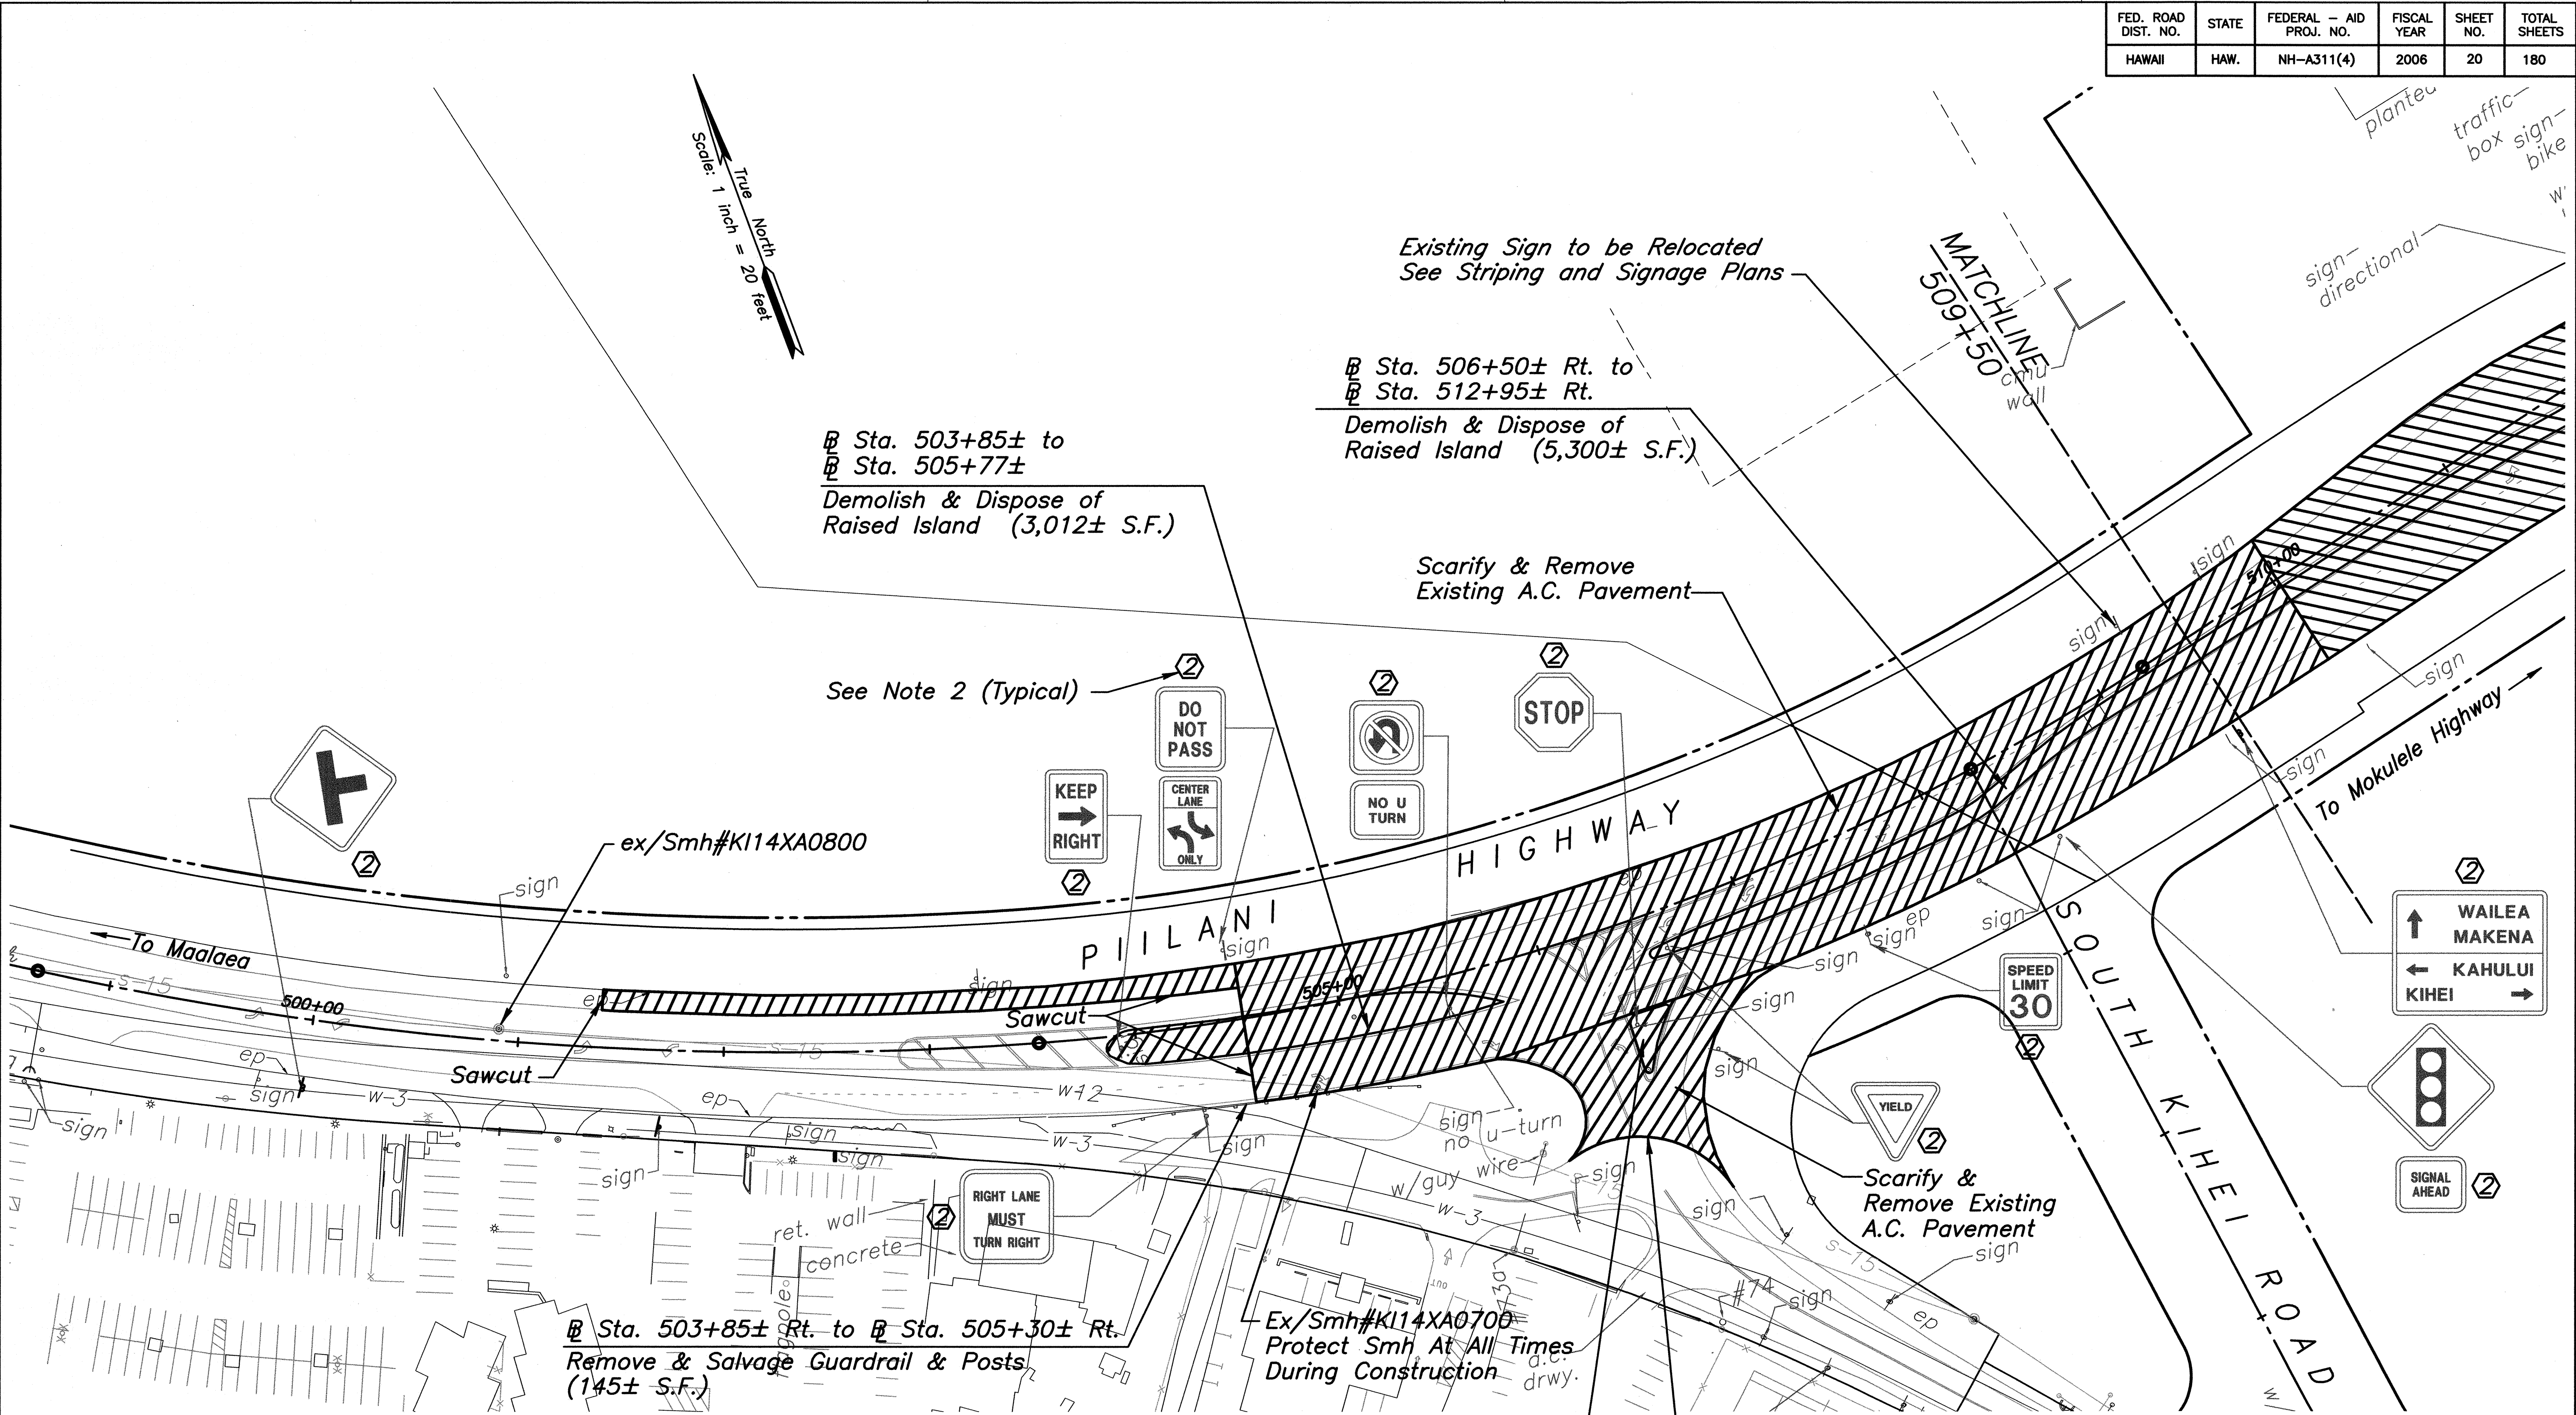

- Notes:
- For Power Pole & Telephone Pole Removal or Relocations, refer to Electrical Plans.
 - Remove existing sign(s) & post(s).
 - All trees, pavement, structures and obstructions within the project's right of way, shall be removed, unless otherwise noted on the plans. Removal of these items shall be considered incidental to clear and grub pay item.

Sta. 506+40± (O/S 50'± Rt.)
Demolish & Dispose of Existing Concrete Island (300± S.F.)

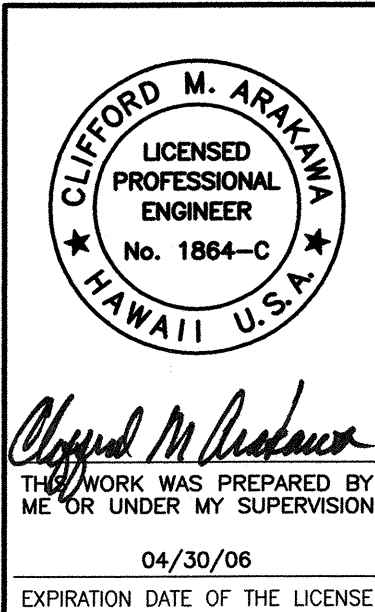

STATE OF HAWAII
DEPARTMENT OF TRANSPORTATION
HIGHWAYS DIVISION

DEMOLITION PLAN

MOKULELE HIGHWAY WIDENING
Vicinity of Kealia Pond Driveway
To
Piilani Highway
Federal - Aid Project No. NH-A311(4)
Scale: 1"=20' Date: July 2005

SHEET No. 6 OF 8 SHEETS

FED. ROAD DIST. NO.	STATE	FEDERAL - AID PROJ. NO.	FISCAL YEAR	SHEET NO.	TOTAL SHEETS
HAWAII	HAW.	NH-A311(4)	2006	21	180

