

FED. ROAD DIST. NO.	STATE	FED. AID PROJ. NO.	FISCAL YEAR	SHEET NO.	TOTAL SHEETS
HAWAII	HAW.	5-0380(5)	1970	24	44

- UTILITY SYMBOLS
- EP EXISTING ELEC. OR TEL. POLE
 - EXISTING POLE WITH EXISTING ANCHOR
 - EXISTING PULL BOX OR SERVICE BOX
 - ⊕ NEW LIGHT STANDARD ON EXISTING FOOTING
 - EXIST. 2" PVC SCH. 40 DIRECT BURIAL
 - ==== EXIST. 2" PVC SCH. 40 CONC. ENCASED

- GENERAL NOTES
- CONTRACTOR SHALL FURNISH AND INSTALL CABLES, LIGHT STANDARDS, LUMINAIRES WITH INTEGRAL BALLAST AND PHOTOCELL AND CONNECTOR KITS.
 - CONTRACTOR SHALL VERIFY ANCHOR BOLT LAYOUT DIMENSIONS TO INSURE PROPER TRANSFORMER BASE FIT.


STATE OF HAWAII
DEPARTMENT OF TRANSPORTATION
HIGHWAYS DIVISION

HIGHWAY LIGHTING


KAHULUI AIRPORT - MAALAE HWY.
(PUUNENE AVE. TO MAALAE)
PROJ. NO. 5-0380(5)

SCALE AS NOTED


SHEET No. 1 OF 1 SHEETS

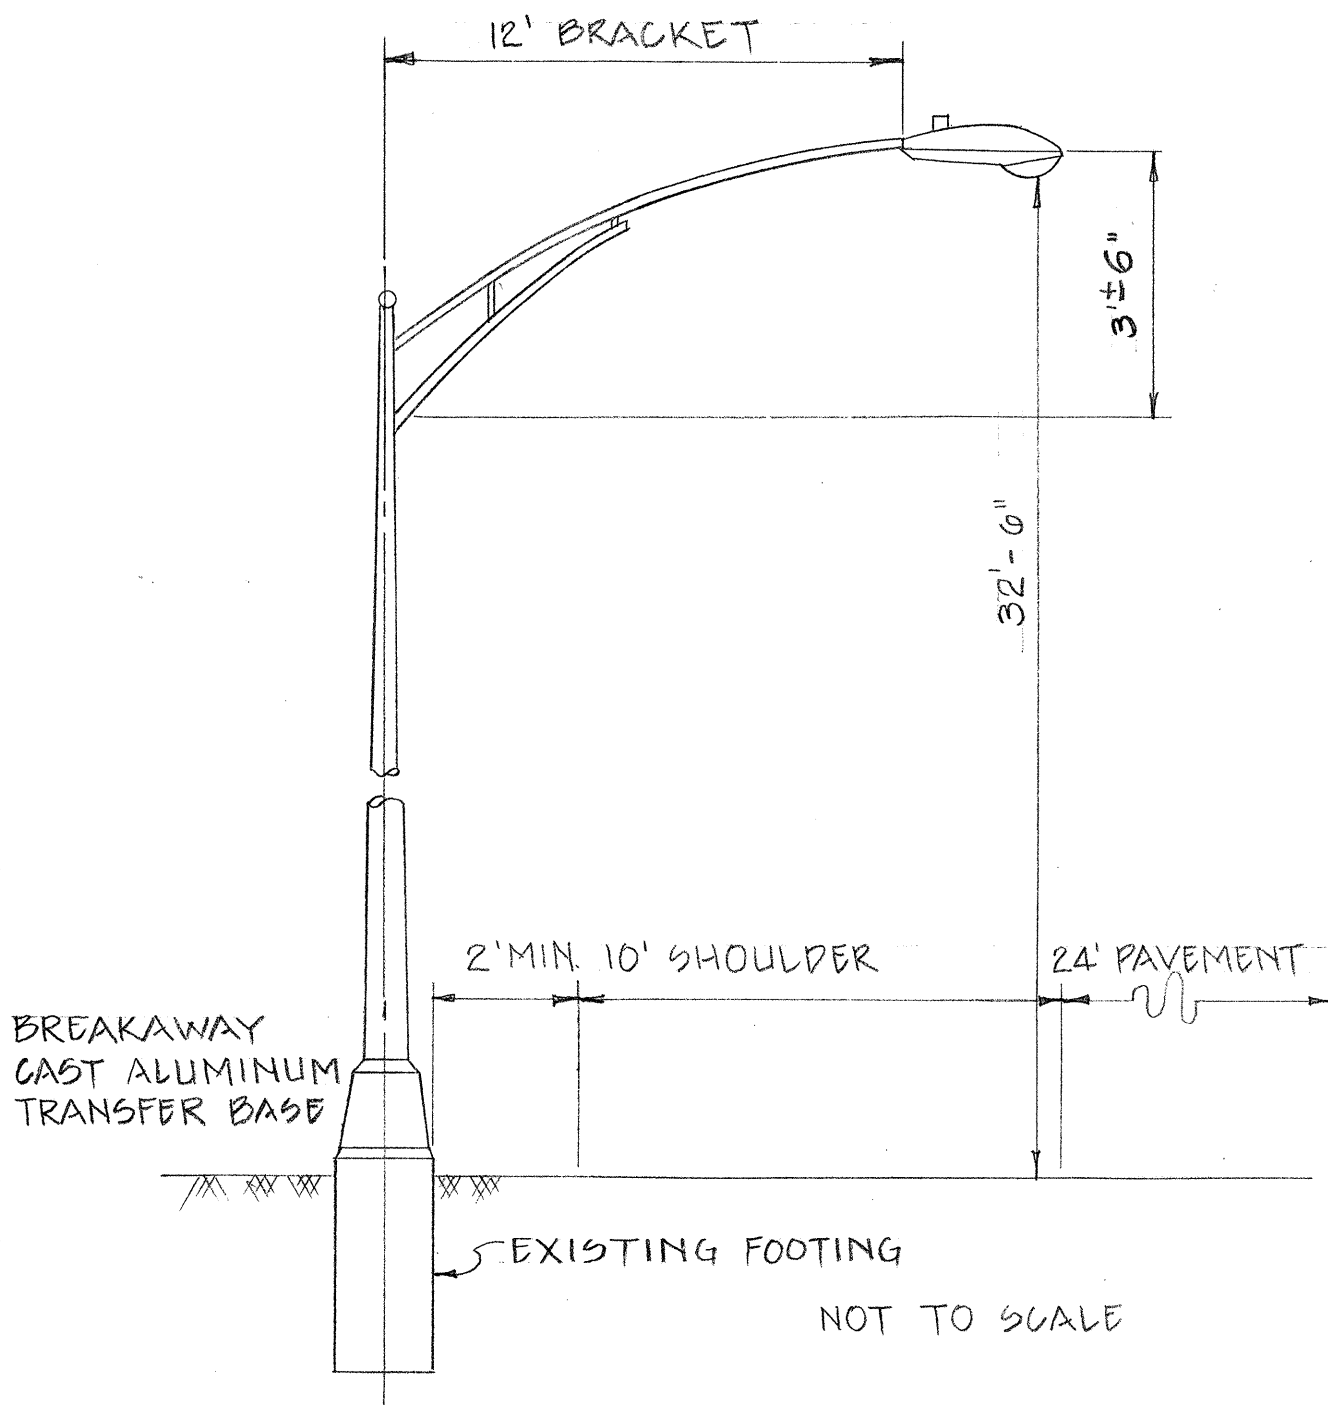



TYPICAL STREET LIGHT STANDARD

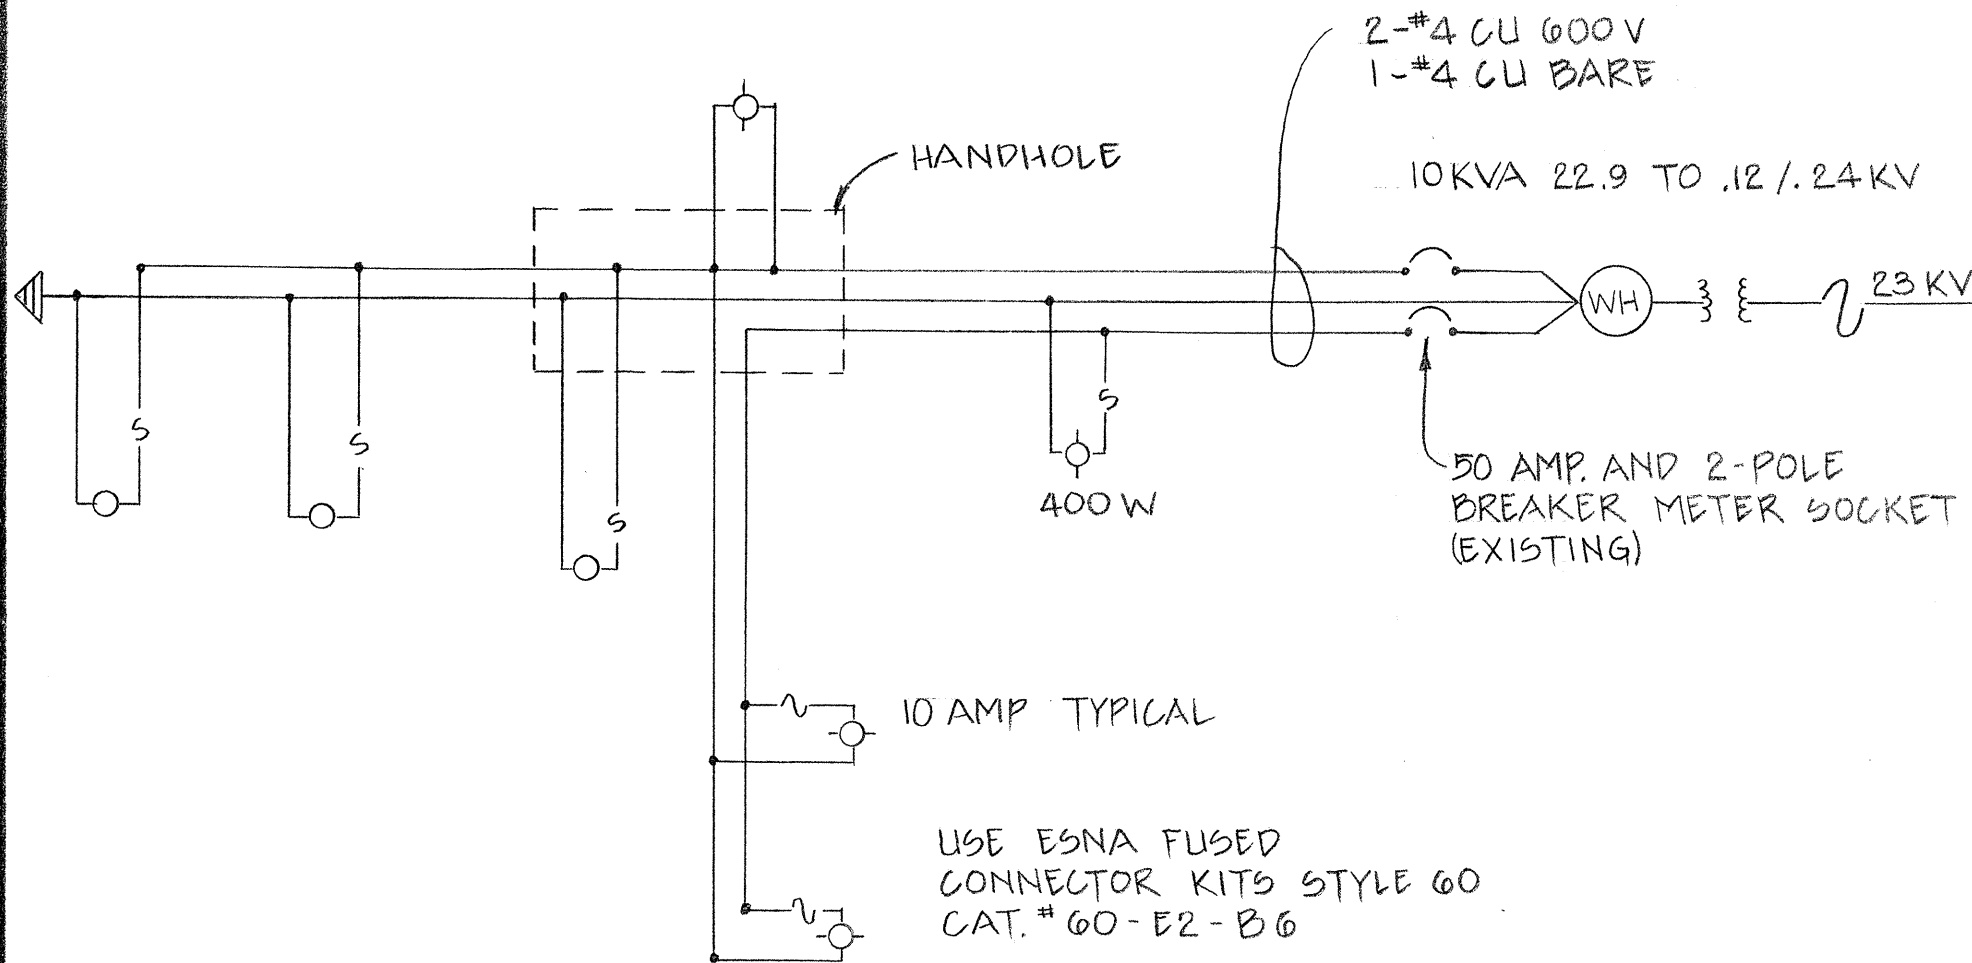


ONE LINE DIAGRAM ST. LIGHTING
HONOAPIILANI & NEW HIGHWAY INTERSECTION
7-400 WATT

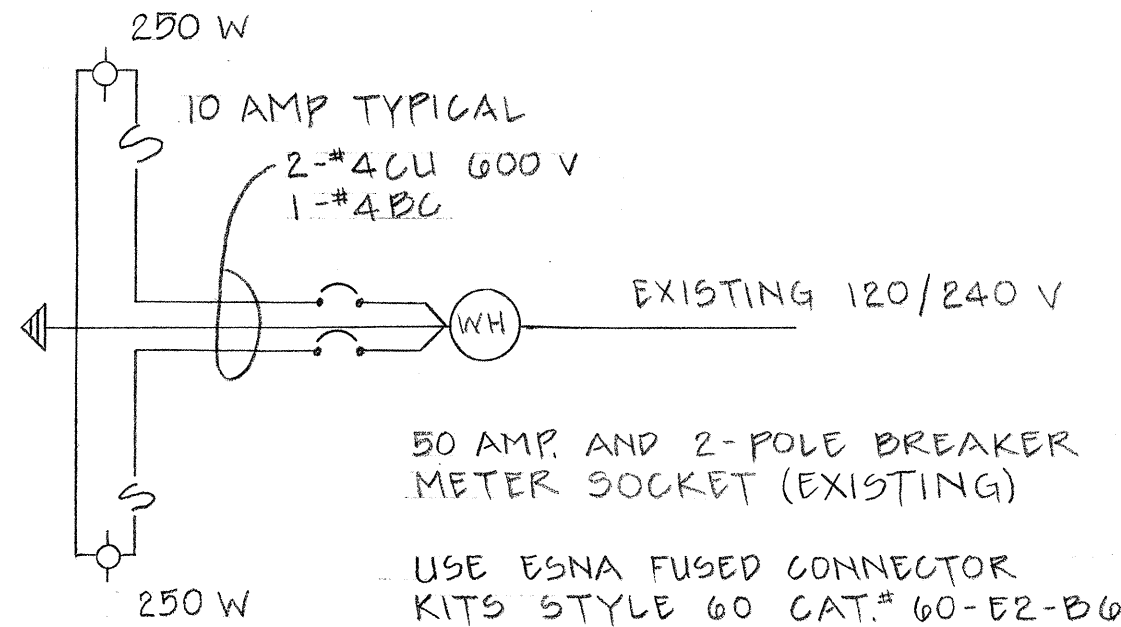

ONE LINE DIAGRAM ST. LIGHTING
NEW HIGHWAY & PUUNENE AVE. INTERSECTION
2-250 WATT

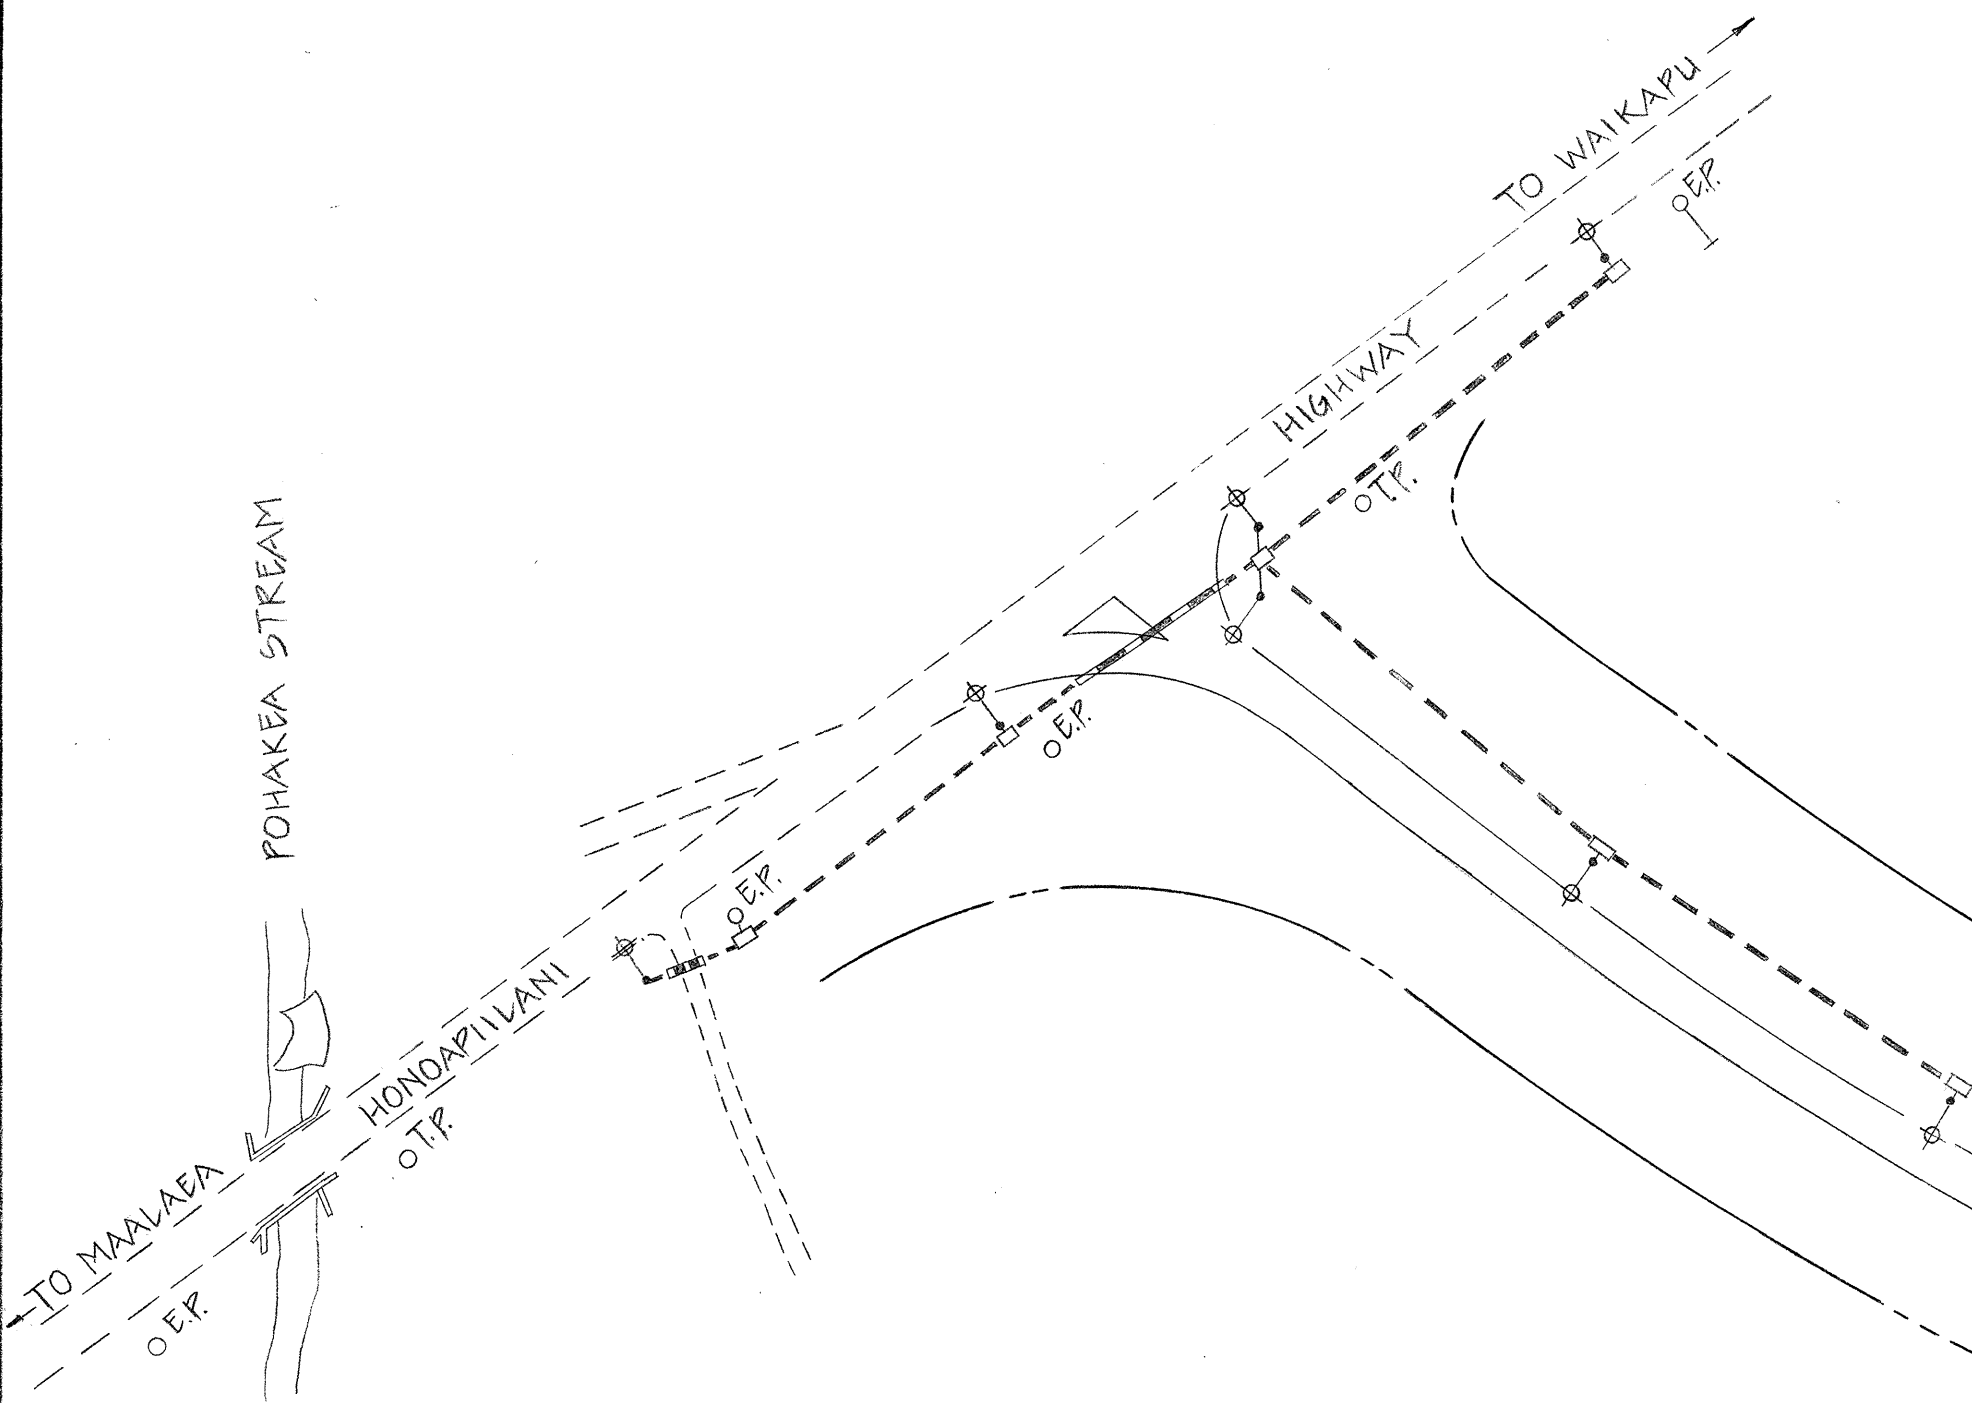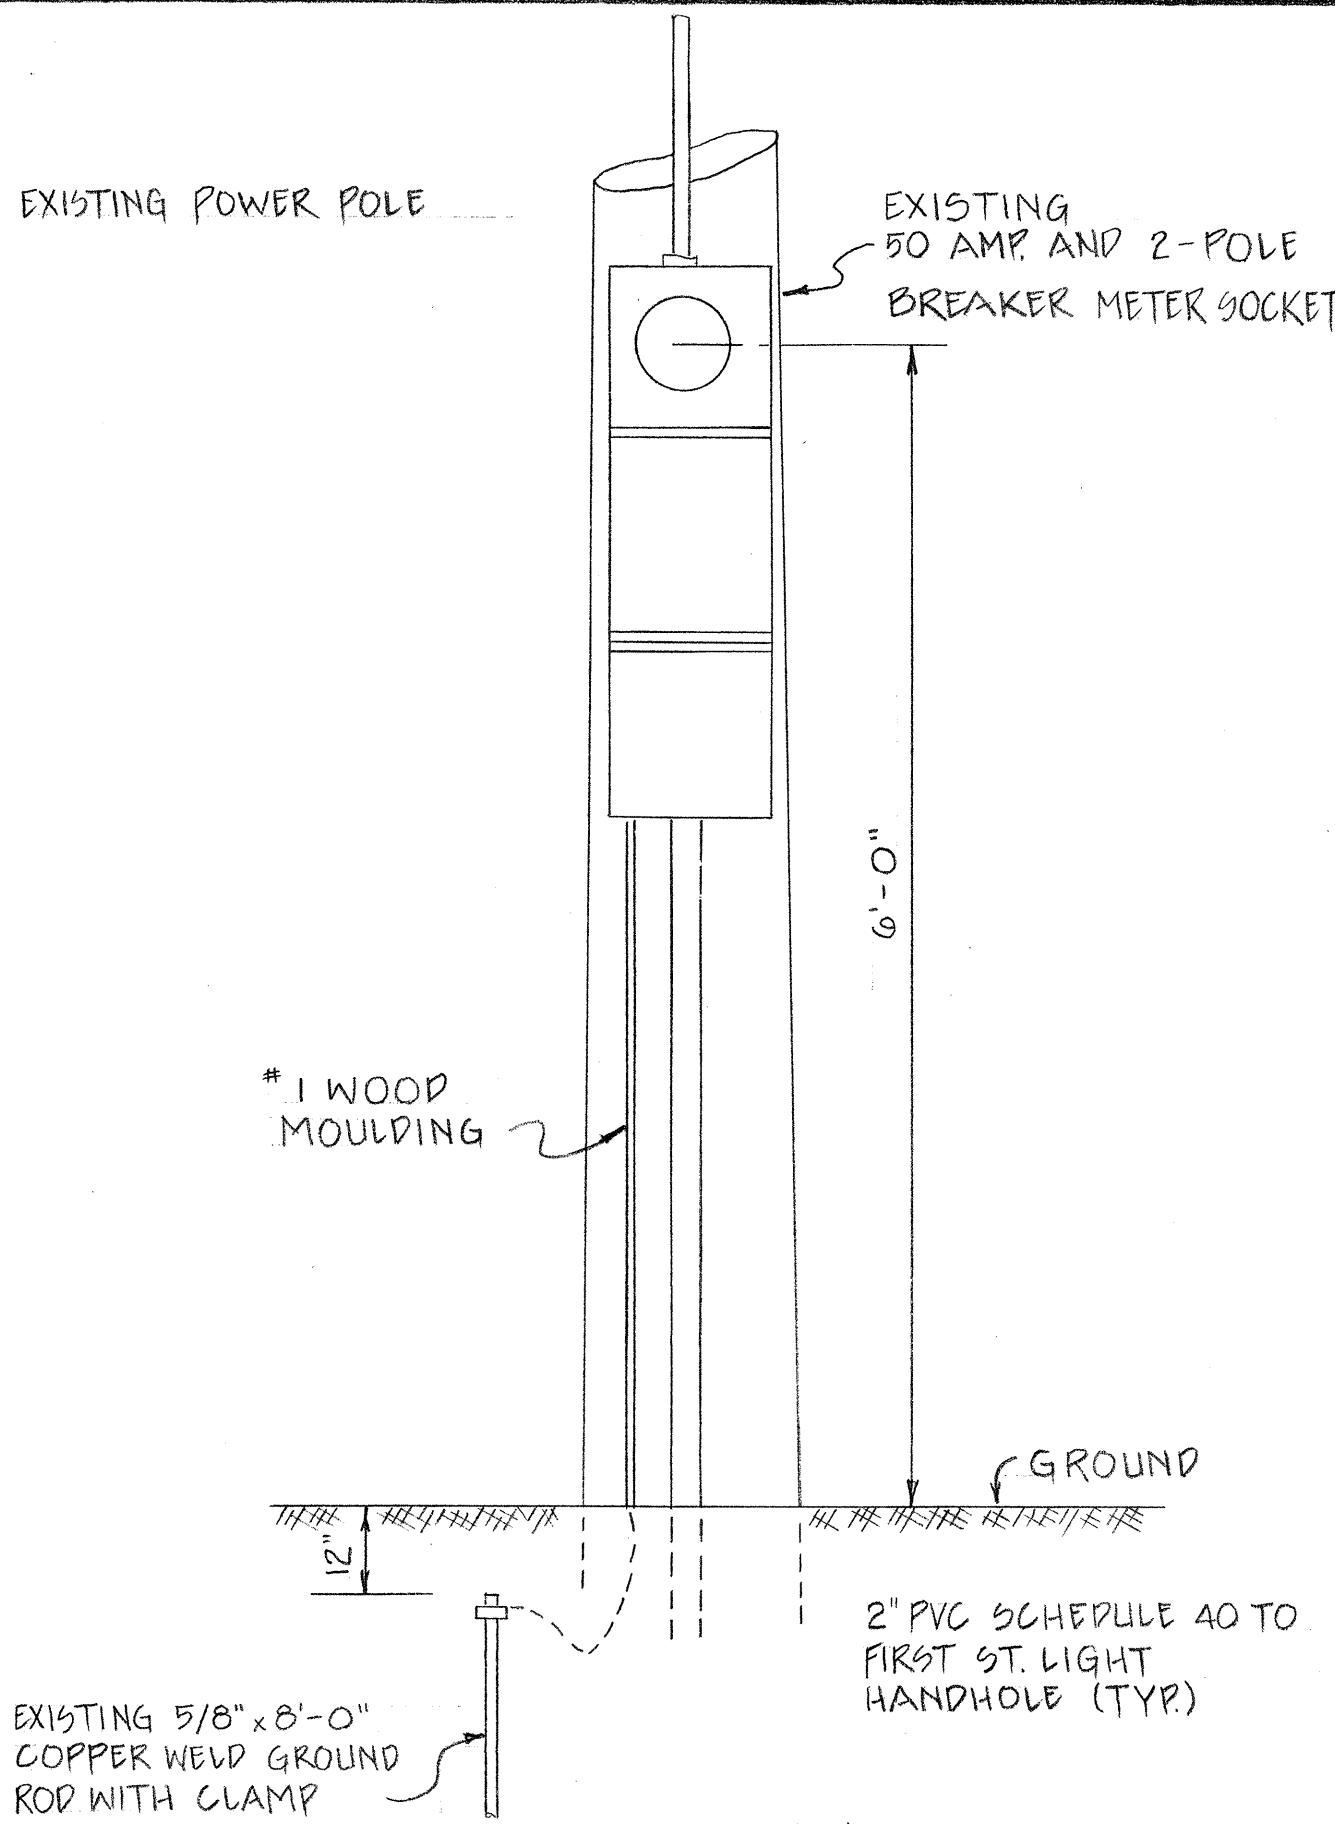

HONOAPIILANI & NEW HIGHWAY INTERSECTION

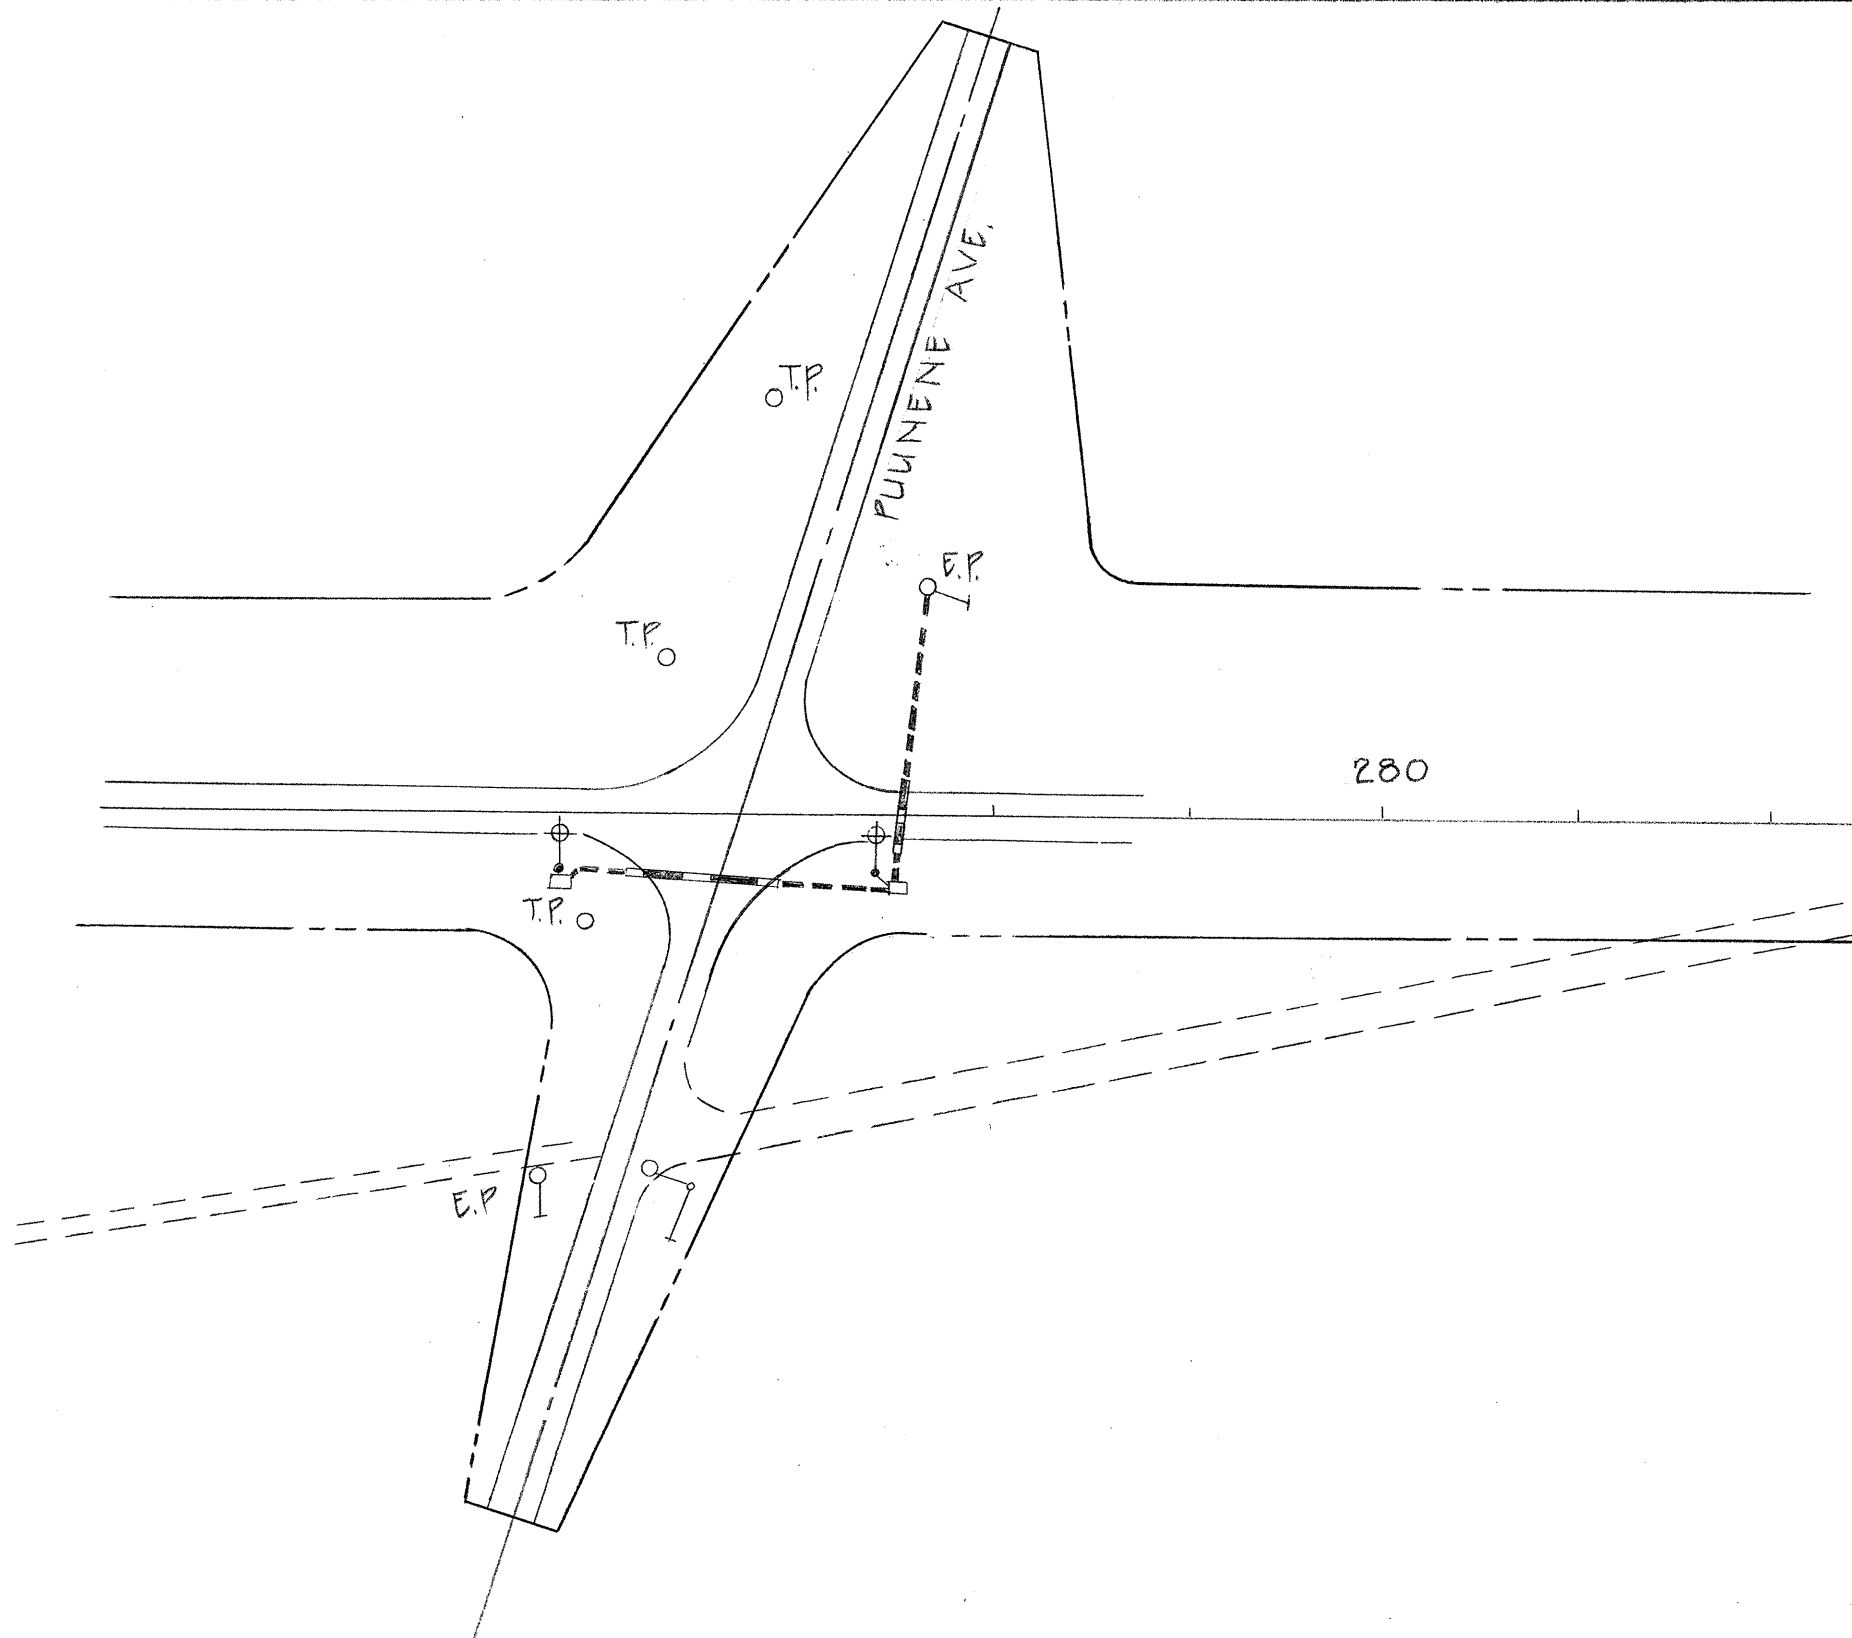

NEW HIGHWAY & PUUNENE AVE. INTERSECTION

ORIGINAL PLAN	DATE
SURVEY PLOTTED BY	
DRAWN BY	
DESIGNED BY	
CHECKED BY	
NOTE BOOK	
No.	