
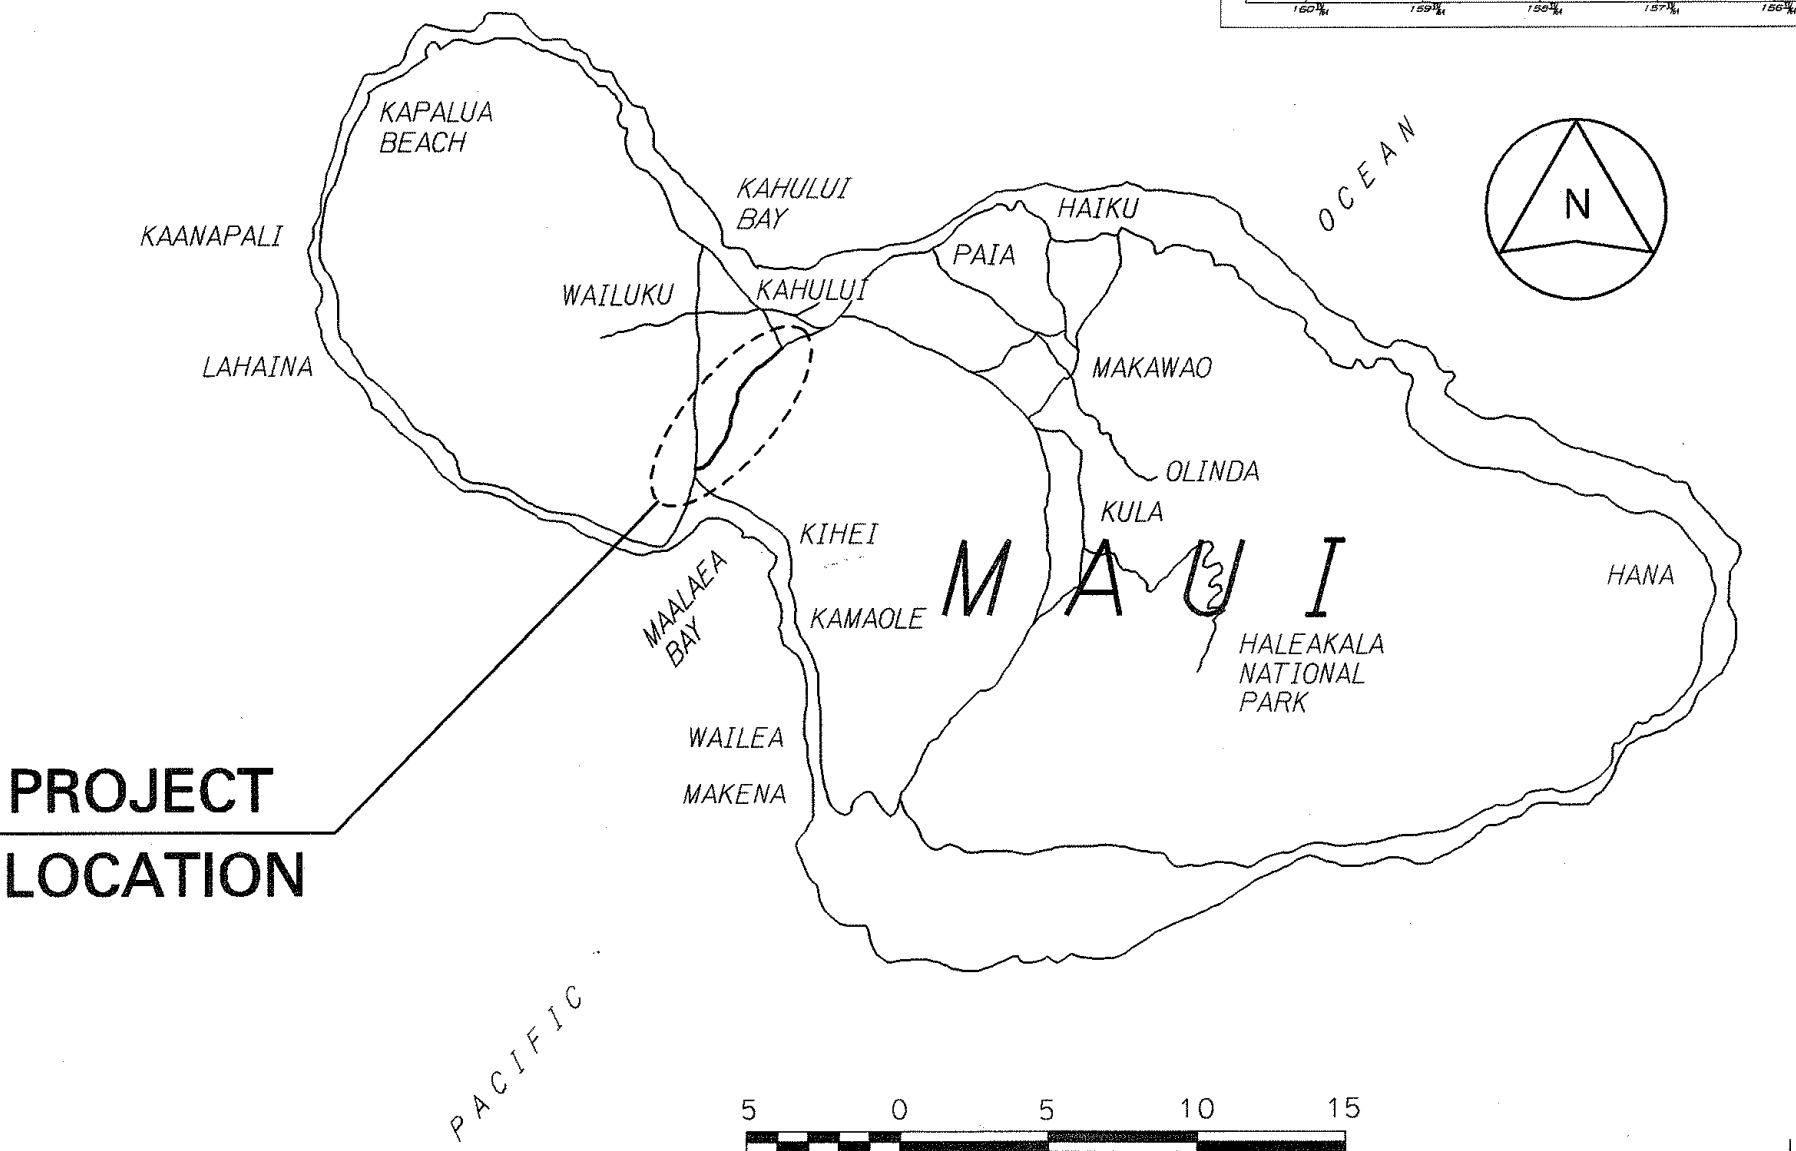


INDEX TO DRAWINGS	
SHEET NO.	DESCRIPTION
1	TITLE SHEET
2	STANDARD PLANS SUMMARY
3	GENERAL NOTES, LEGEND AND ABBREVIATIONS
4-10	TYPICAL SECTIONS
11-54	ALIGNMENT PLANS
55	CONSTRUCTION PHASING
56-108	ROADWAY CONSTRUCTION PLANS
109	DRAINAGE & GRADING NOTES
110	NPDES GENERAL NOTES
111-158	DRAINAGE & GRADING PLANS
159-162	PARK-AND-RIDE PLANS
163-216	STRUCTURAL PLANS
217-223	ELECTRICAL PLANS
224-234	TRAFFIC SIGNAL PLANS
235-253	SIGNING AND PAVEMENT MARKINGS PLANS
254-255	TRAFFIC CONTROL PLANS
256-267	BORING LOGS
268-380	CROSS SECTIONS

STATE OF HAWAII
DEPARTMENT OF TRANSPORTATION
HIGHWAYS DIVISION
HONOLULU, HAWAII
"AS-BUILT"
PLANS FOR
KUIHELANI HIGHWAY WIDENING
HONOAPIILANI HIGHWAY
TO PUUNENE AVENUE
FEDERAL-AID PROJECT NO. NH-0380(9)

DISTRICT OF WAILUKU
ISLAND OF MAUI

FED. ROAD DIST. NO.	STATE	FED. AID PROJ. NO.	FISCAL YEAR	SHEET NO.	TOTAL SHEETS
HAWAII	HAW.	NH-0380(9)	2000	1	380

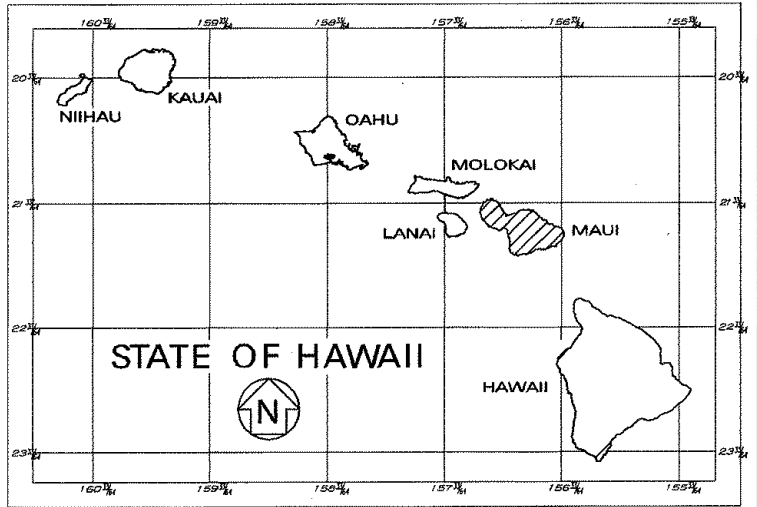


PROJECT
LOCATION

SCALE IN MILES
0 5 10 15

MILE POST 1.08 TO MILE POST 6.24

END PROJECT
K STA. 286+63
= EXIST. KUIHELANI # STA. 287+00

DATE: 1 = 1
SCALE: 1 = 1
FILE: J:\KUIHELANI\MISC\GP-Tidgn
DESIGNED BY
PARSONS BRINCKERHOFF QUADE & DOUGLAS
P. S. & E. BY
Kevin Ito
PHONE 692-7548
DATE Sept. 14, 2001

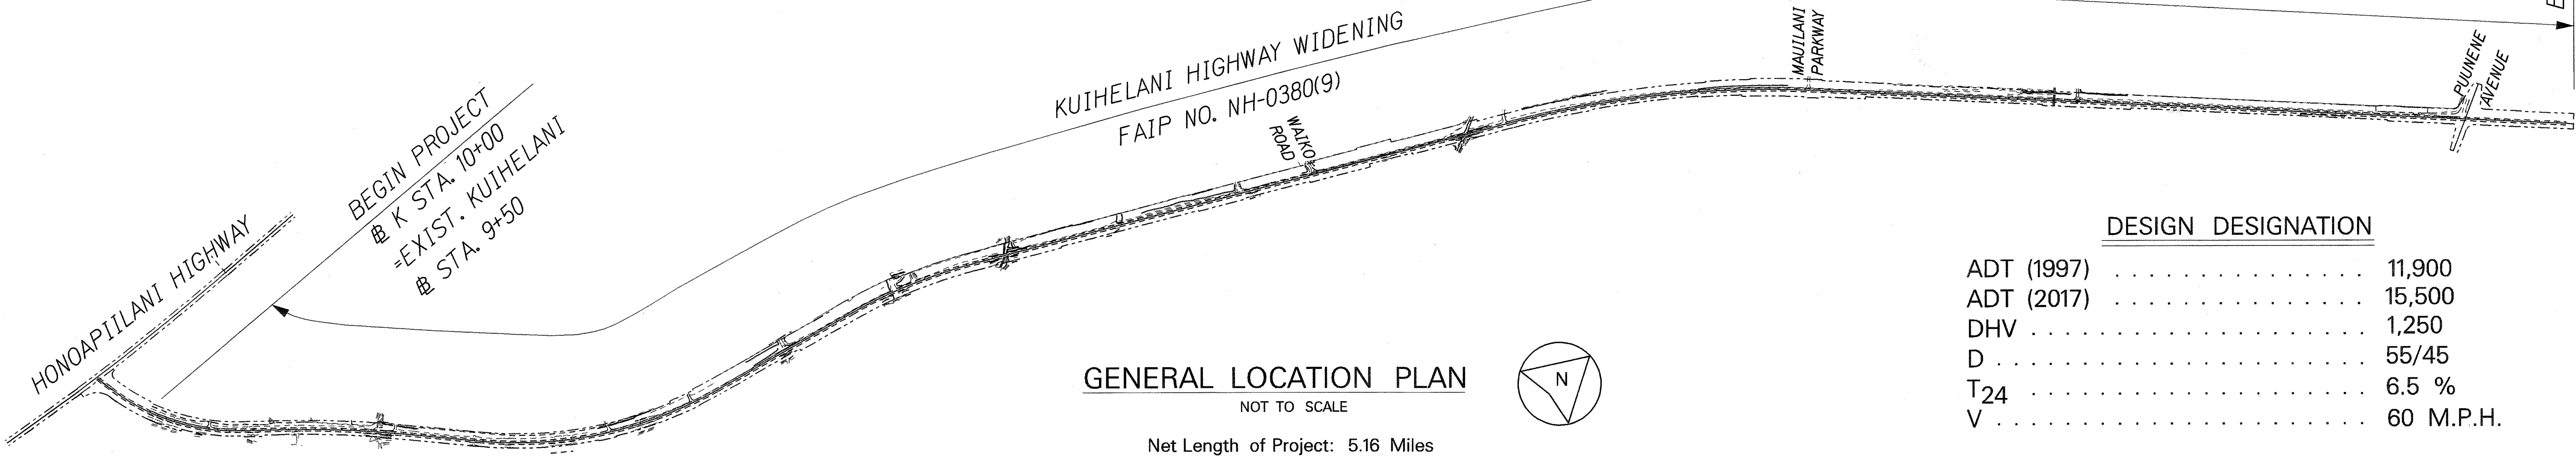

GENERAL LOCATION PLAN
NOT TO SCALE

Net Length of Project: 5.16 Miles

DESIGN DESIGNATION

ADT (1997)	11,900
ADT (2017)	15,500
DHV	1,250
D	55/45
T24	6.5 %
V	60 M.P.H.

CHANGES MADE DURING CONSTRUCTION HAVE BEEN INCORPORATED ON THESE PLANS EXCEPT CHANGES IN THE ORIGINAL THEORETICAL QUANTITIES. FOR ACTUAL QUANTITIES, REFER TO PROJECT LEDGER AND/OR COMPUTATION BOOK.
RESIDENT ENGINEER
DATE 7/31/07

DEPARTMENT OF TRANSPORTATION
STATE OF HAWAII

APPROVED:

9-19-01
DATE