

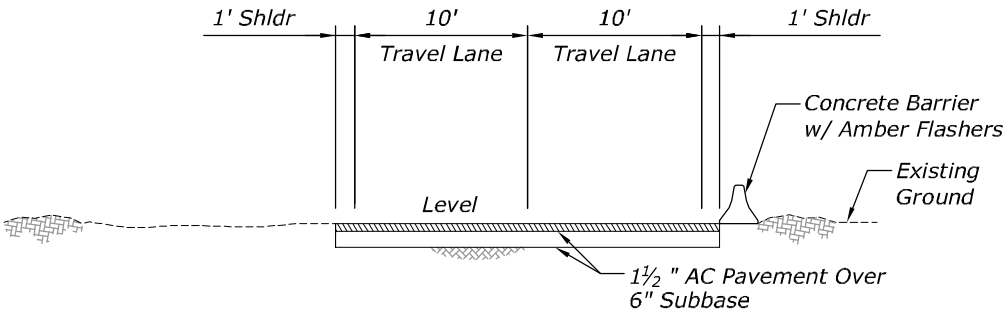



STATE	PROJECT	SHEET NO.
HI	HI STP SR 30(1)	U26

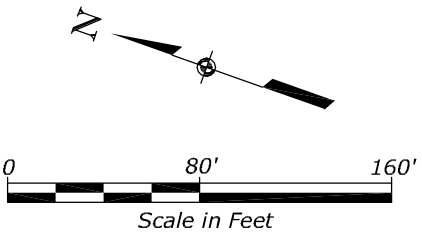

**TYPICAL SECTION
(ALONG LAHAINA BYPASS)**

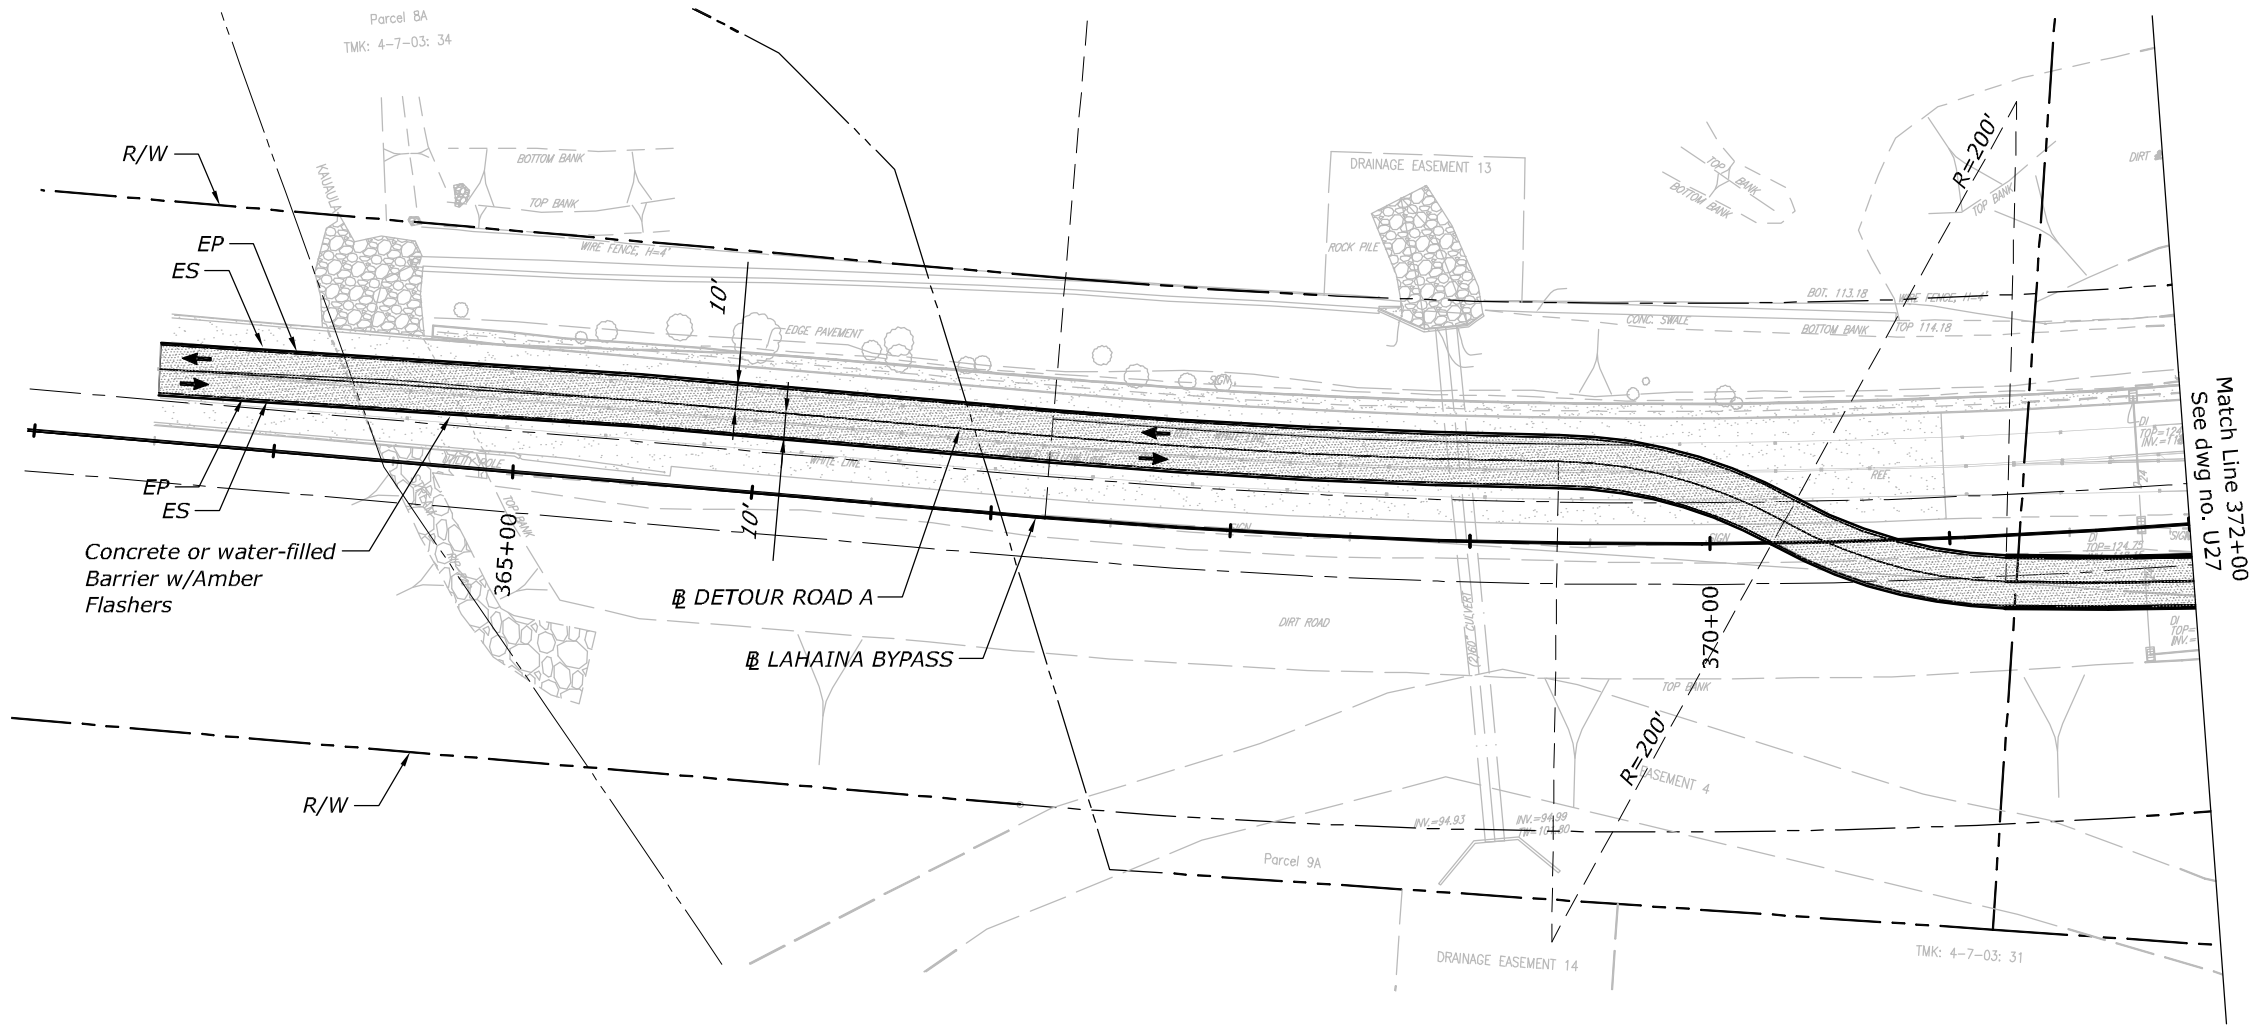

Match Line 372+00
See dwg no. U27

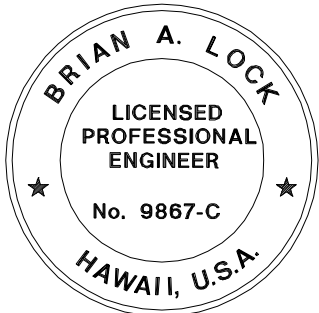

THIS WORK WAS PREPARED BY ME
OR UNDER MY SUPERVISION.

WILSON OKAMOTO CORPORATION APRIL 30, 2020
LIC. EXP. DATE

U.S. DEPARTMENT OF TRANSPORTATION
FEDERAL HIGHWAY ADMINISTRATION
CENTRAL FEDERAL LANDS HIGHWAY DIVISION

U.S. CUSTOMARY



**DETOUR ROADWAY PLAN
HOKIOKIO PLACE**

LEGEND
AC Pavement


- NOTES:**
- See V Series Plans for temporary traffic control plans.
 - See Electrical Sheets for Temporary Electrical Plan.

PHASE 1


STATE	PROJECT	SHEET NO.
HI	HI STP SR 30(1)	U27

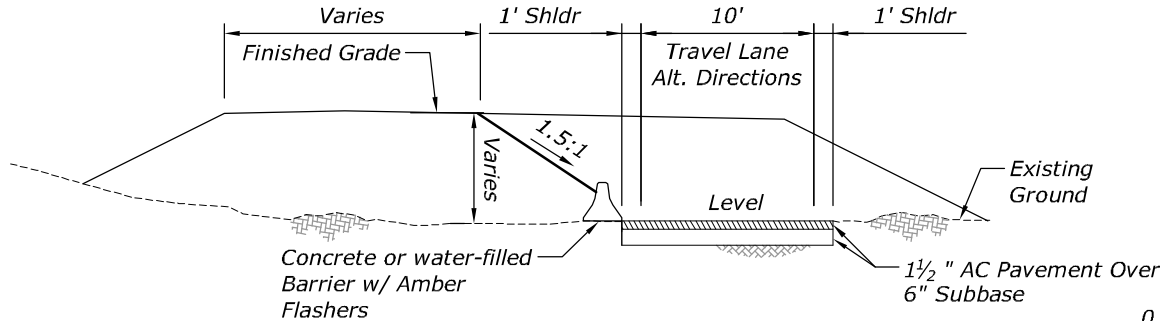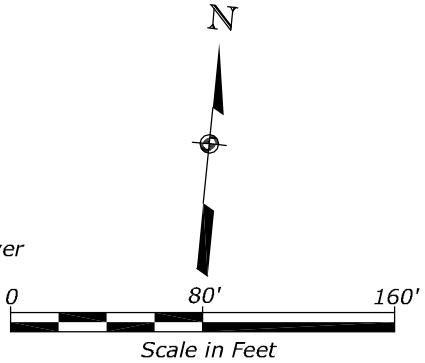

**TYPICAL SECTION - FILL
(ALONG HOKIOKIO)**

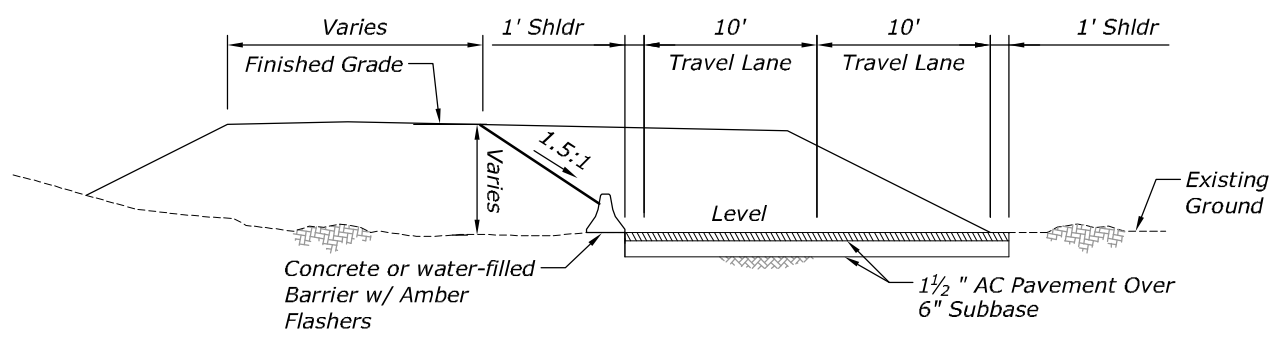


**TYPICAL SECTION - FILL
(ALONG LAHAINA BYPASS)**

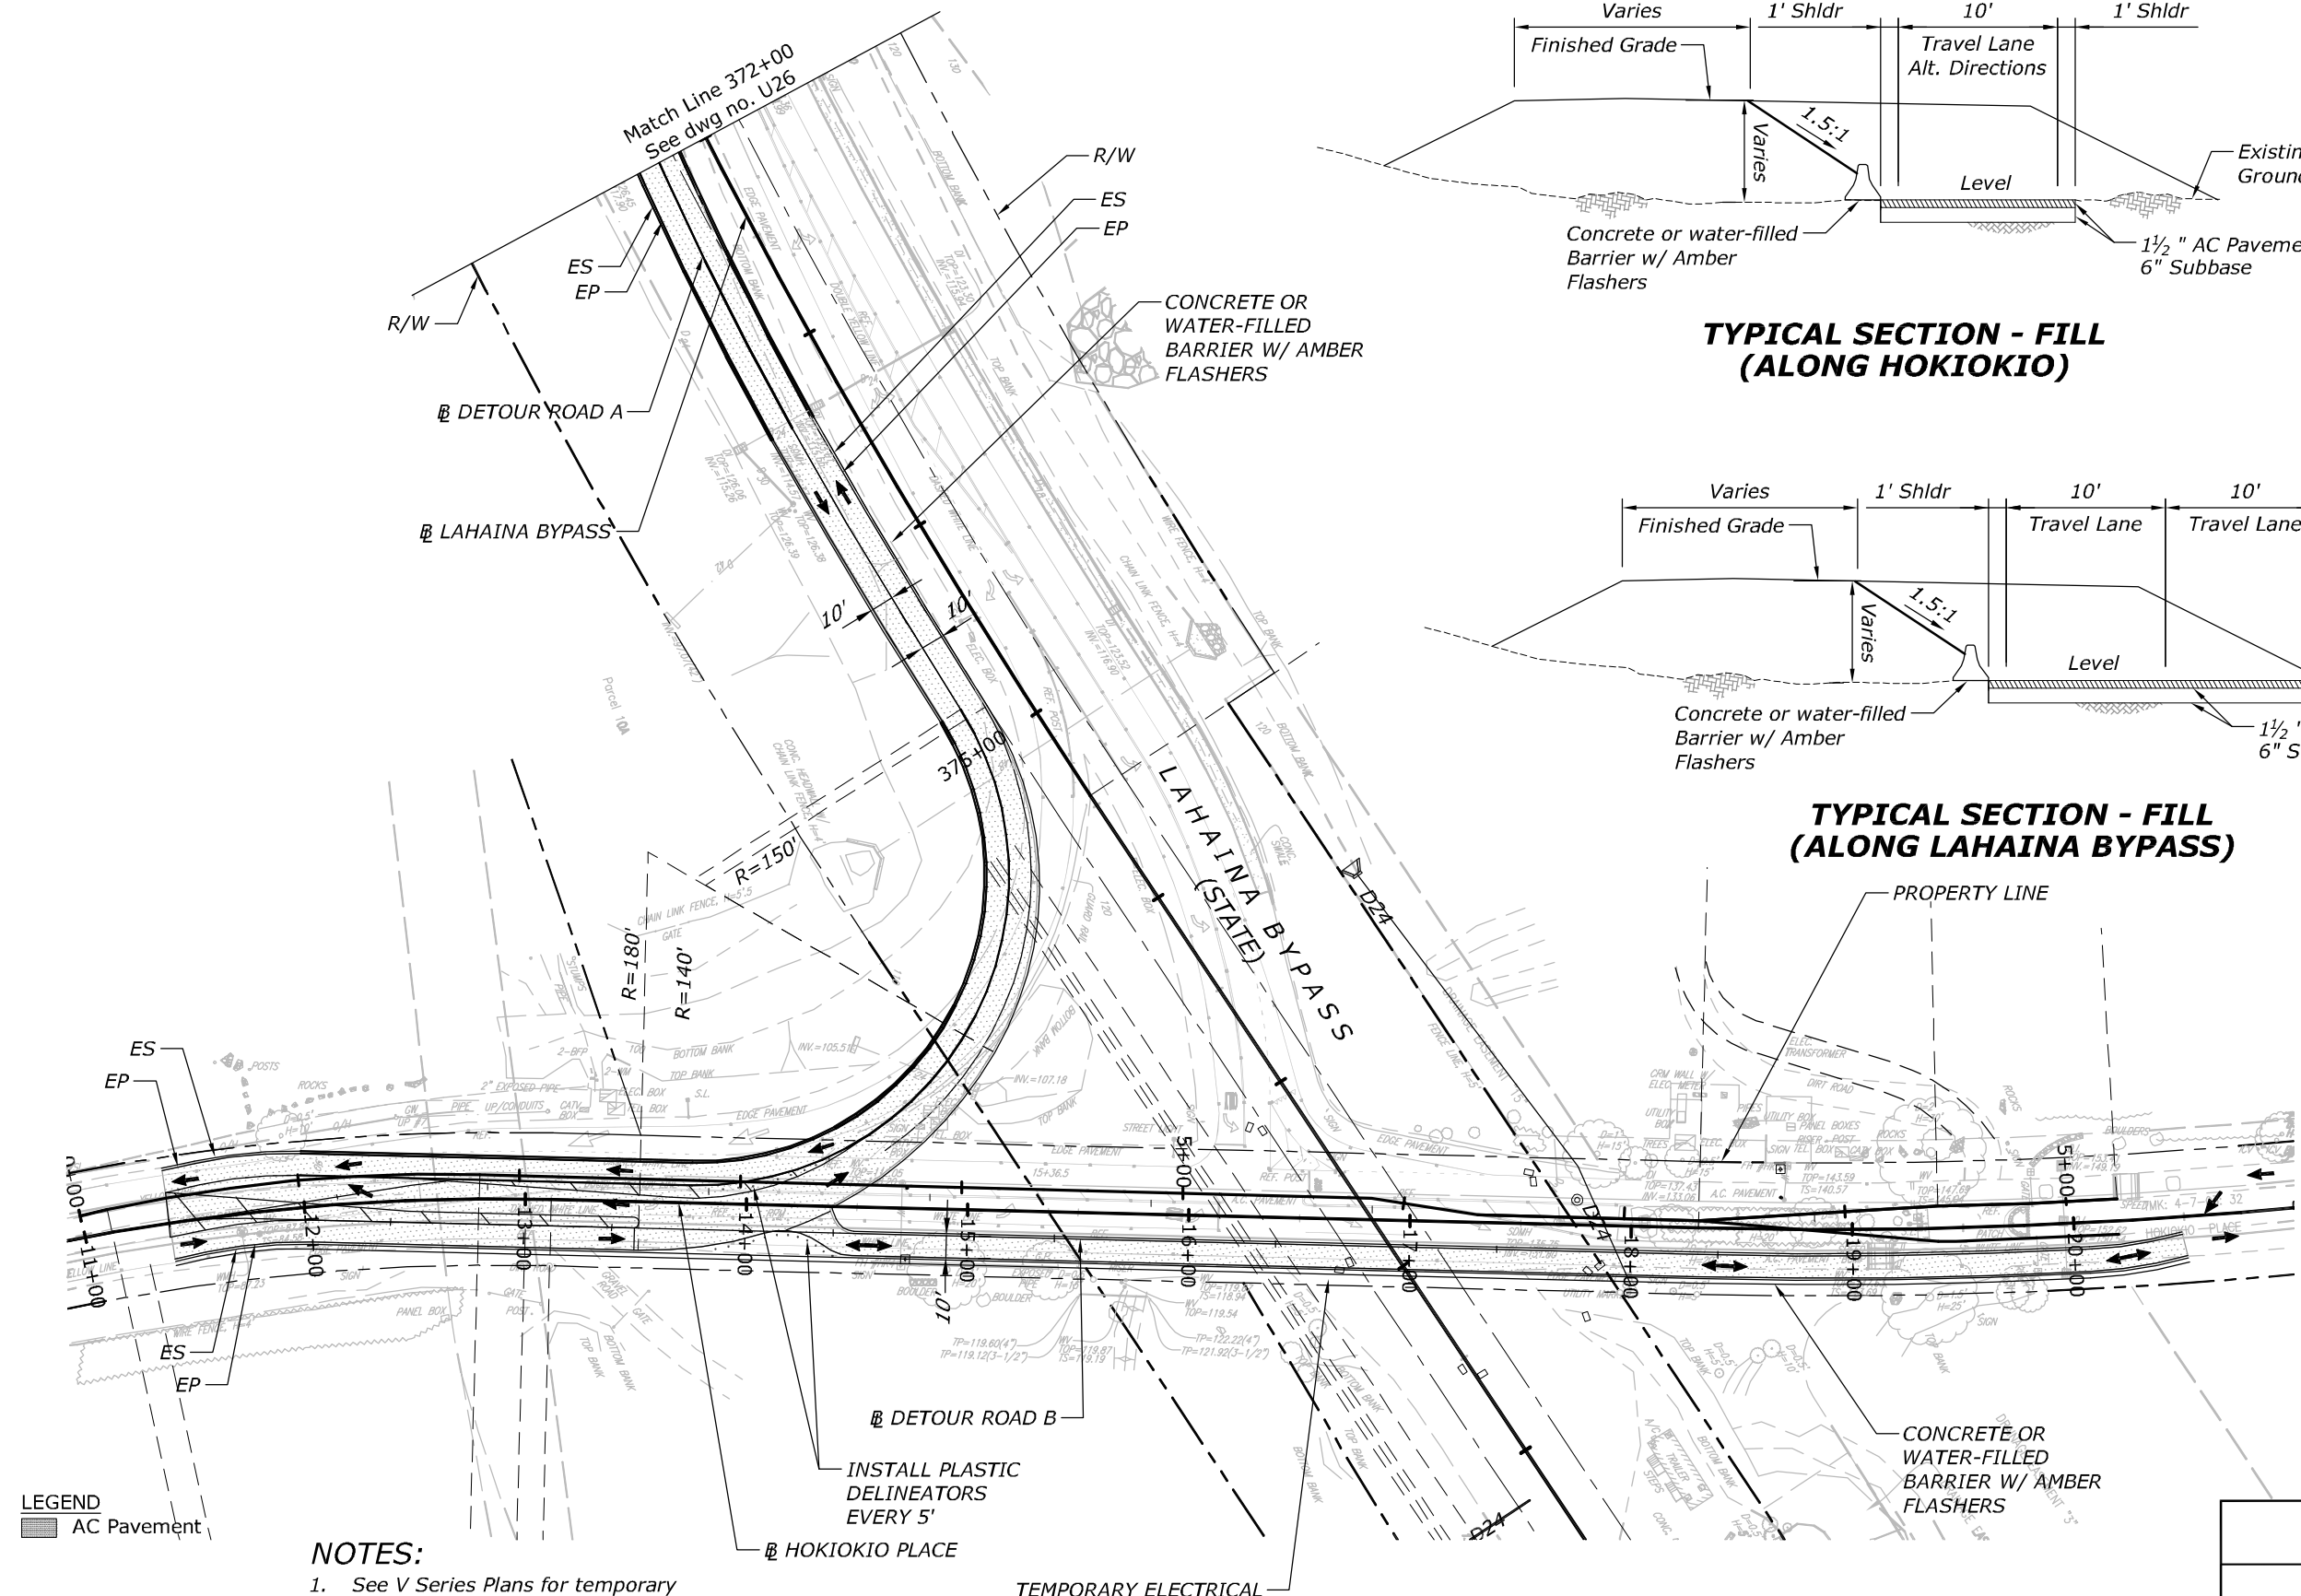

LEGEND
AC Pavement

- NOTES:**
1. See V Series Plans for temporary traffic control plans.
 2. See Electrical Sheets for Temporary Electrical Plan.

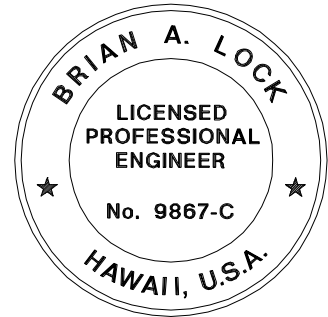


THIS WORK WAS PREPARED BY ME
OR UNDER MY SUPERVISION.
WILSON OKAMOTO CORPORATION APRIL 30, 2020
LIC. EXP. DATE

U.S. DEPARTMENT OF TRANSPORTATION
FEDERAL HIGHWAY ADMINISTRATION
CENTRAL FEDERAL LANDS HIGHWAY DIVISION


U.S. CUSTOMARY

**DETOUR ROADWAY PLAN
HOKIOKIO PLACE**



PHASE 1

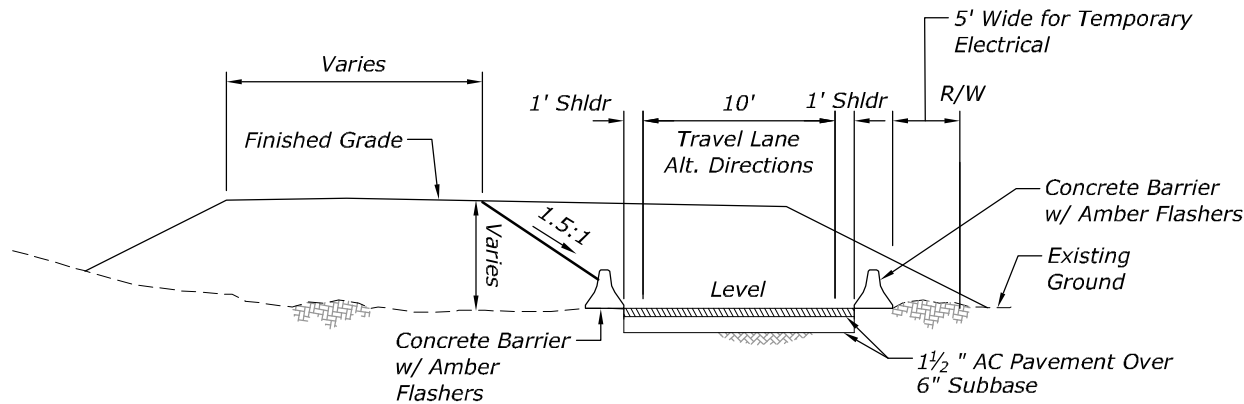

TYPICAL SECTION - FILL

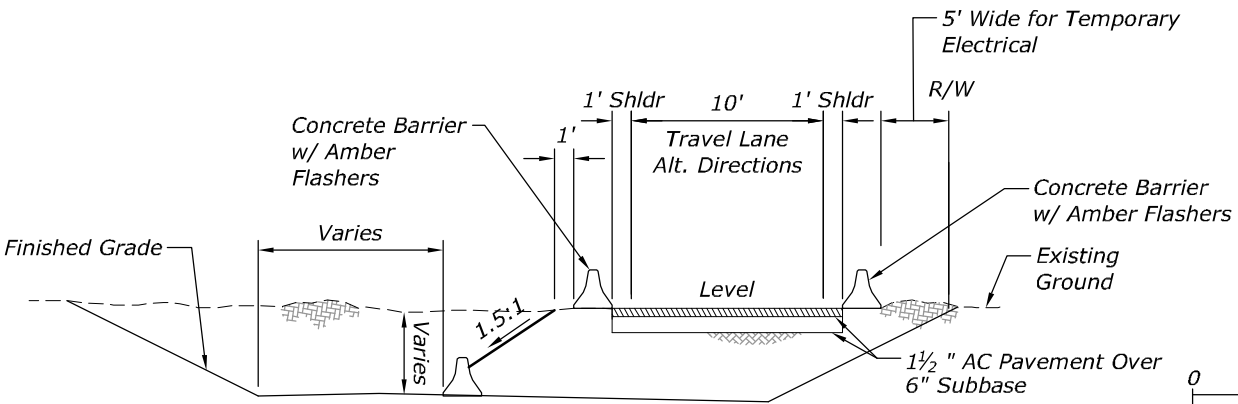


TYPICAL SECTION - CUT

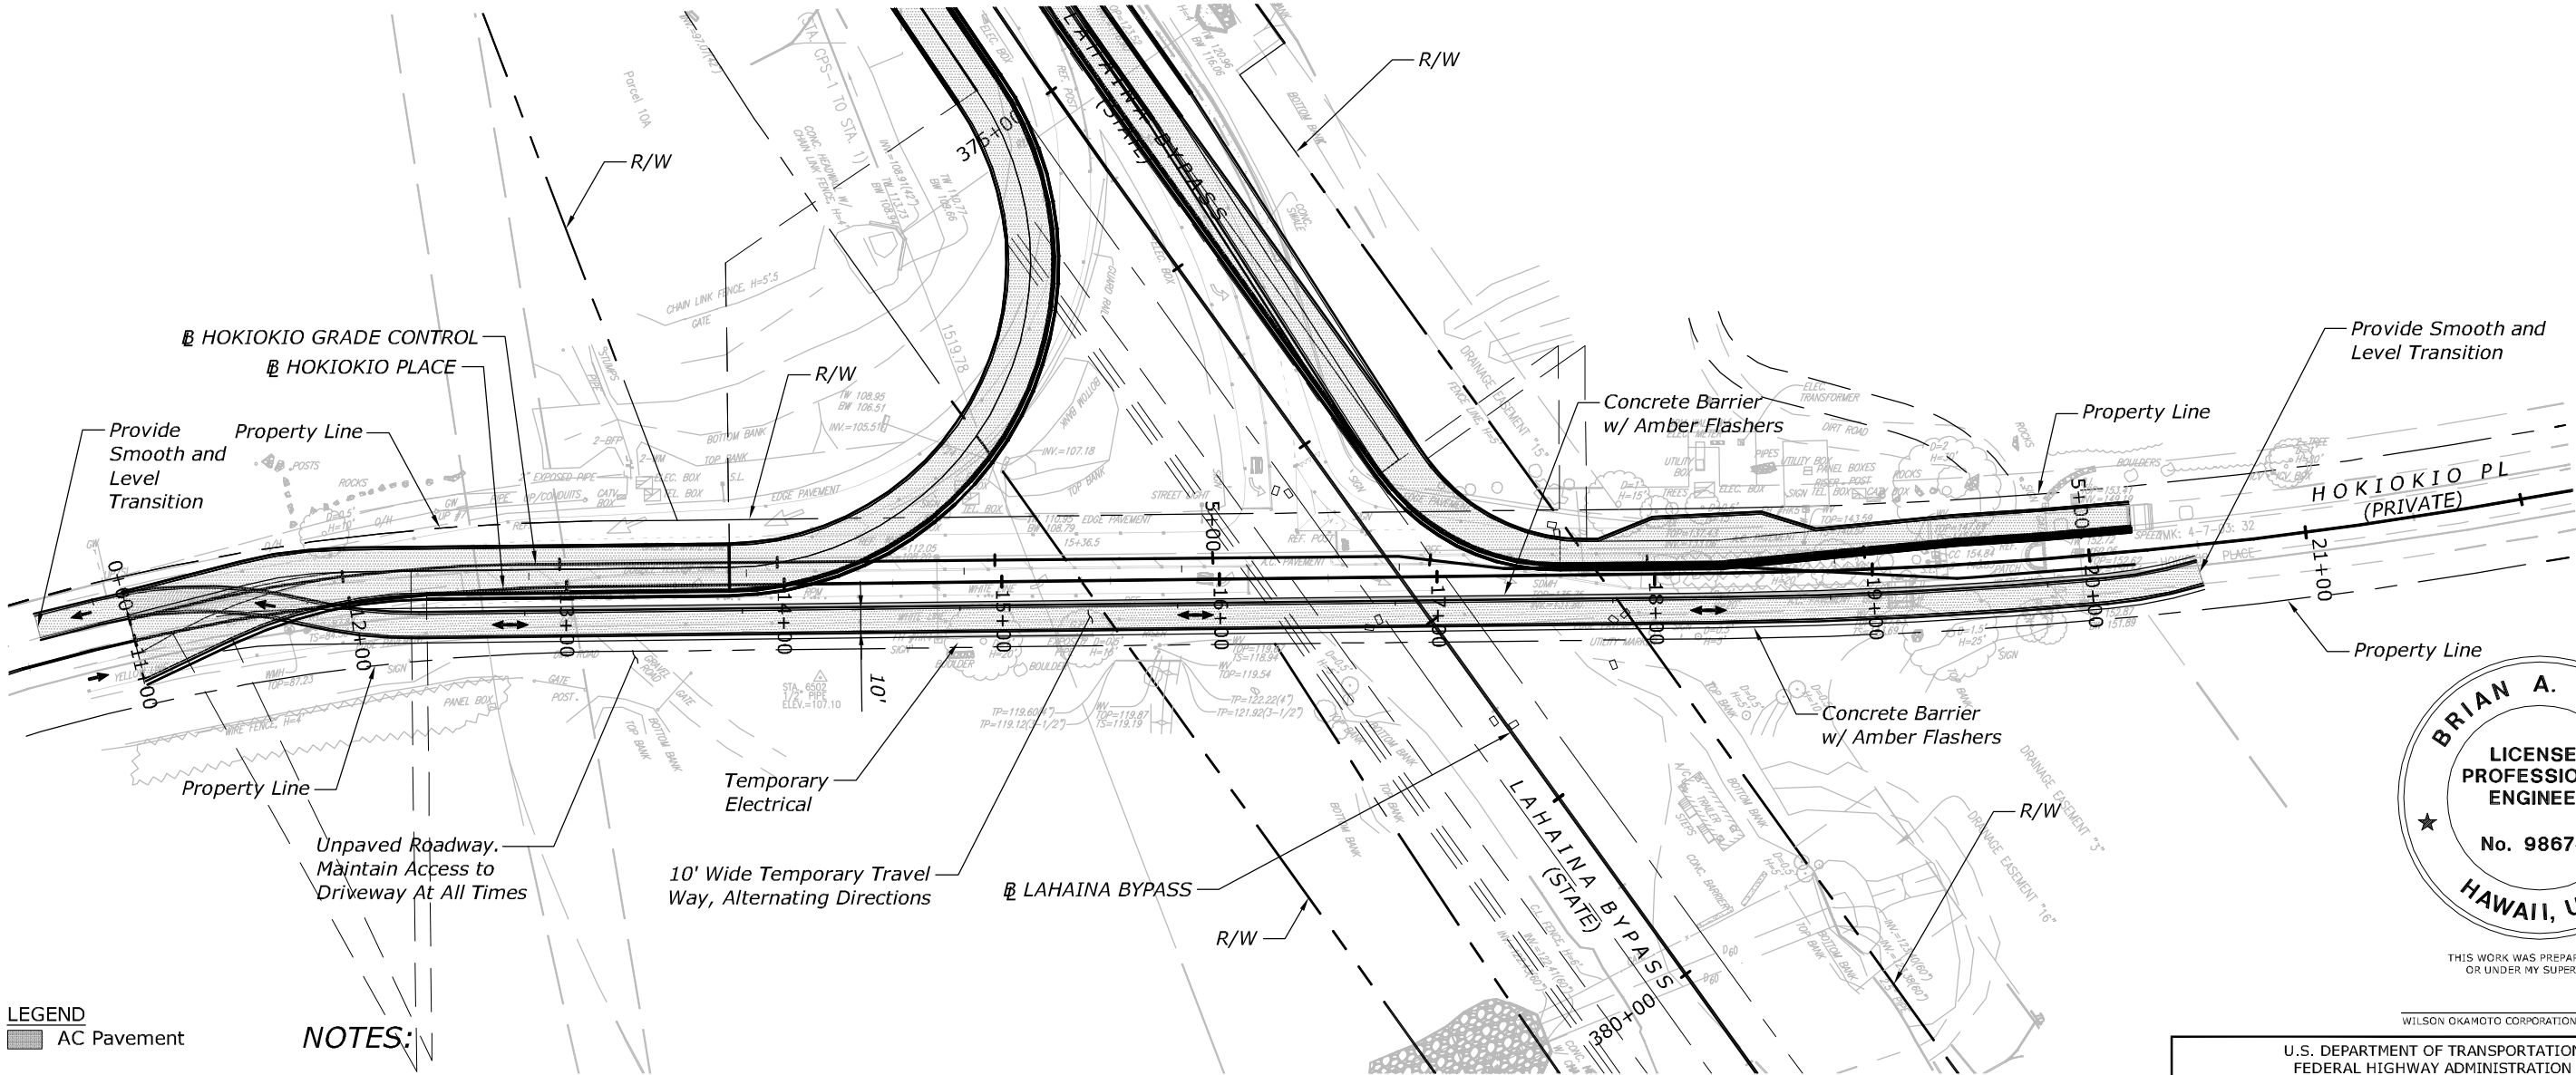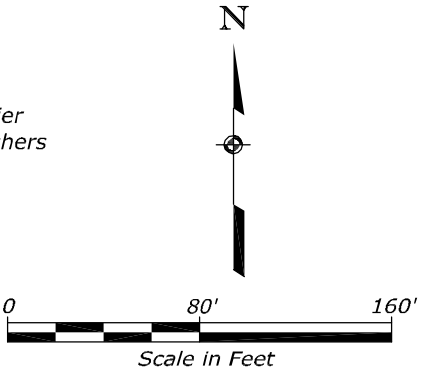

- LEGEND
- AC Pavement
 - Unpaved Roadway

- NOTES:
- See V Series Plans for temporary traffic control plans.
 - See Electrical Sheets for Temporary Electrical Plan.
 - Detour Plan to be Placed for One Weekend Only and Will Be Coordinated With CFL.

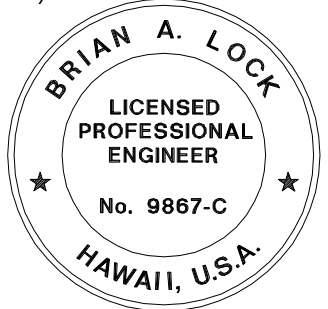



U.S. DEPARTMENT OF TRANSPORTATION
FEDERAL HIGHWAY ADMINISTRATION
CENTRAL FEDERAL LANDS HIGHWAY DIVISION

U.S. CUSTOMARY


DETOUR ROADWAY PLAN
HOKIOKIO PLACE

PHASE 2

STATE	PROJECT	SHEET NO.
HI	HI STP SR 30(1)	U30

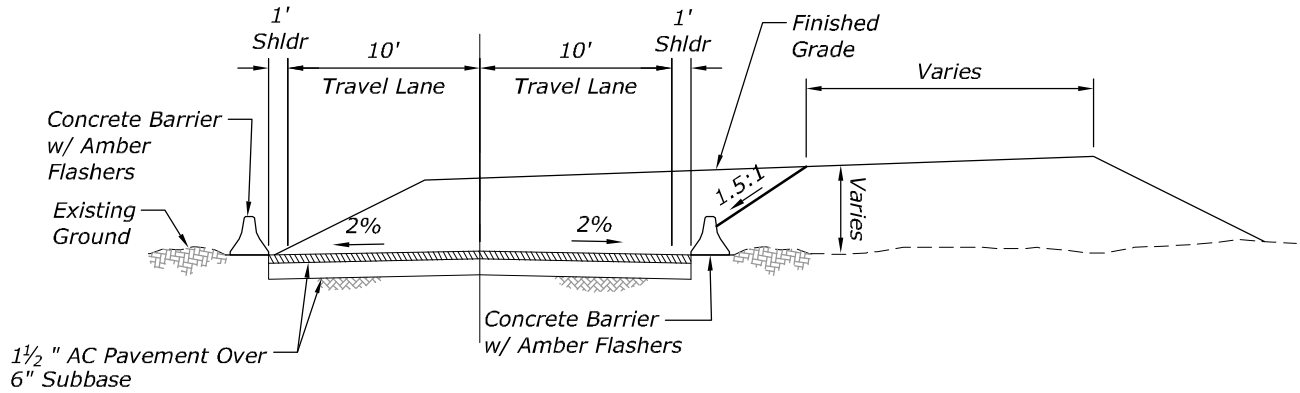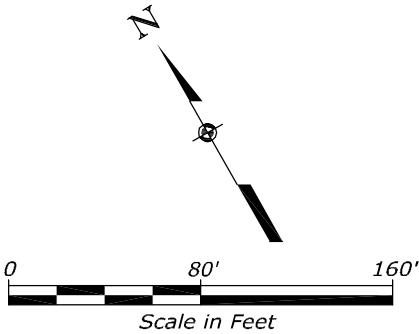

TYPICAL SECTION - FILL

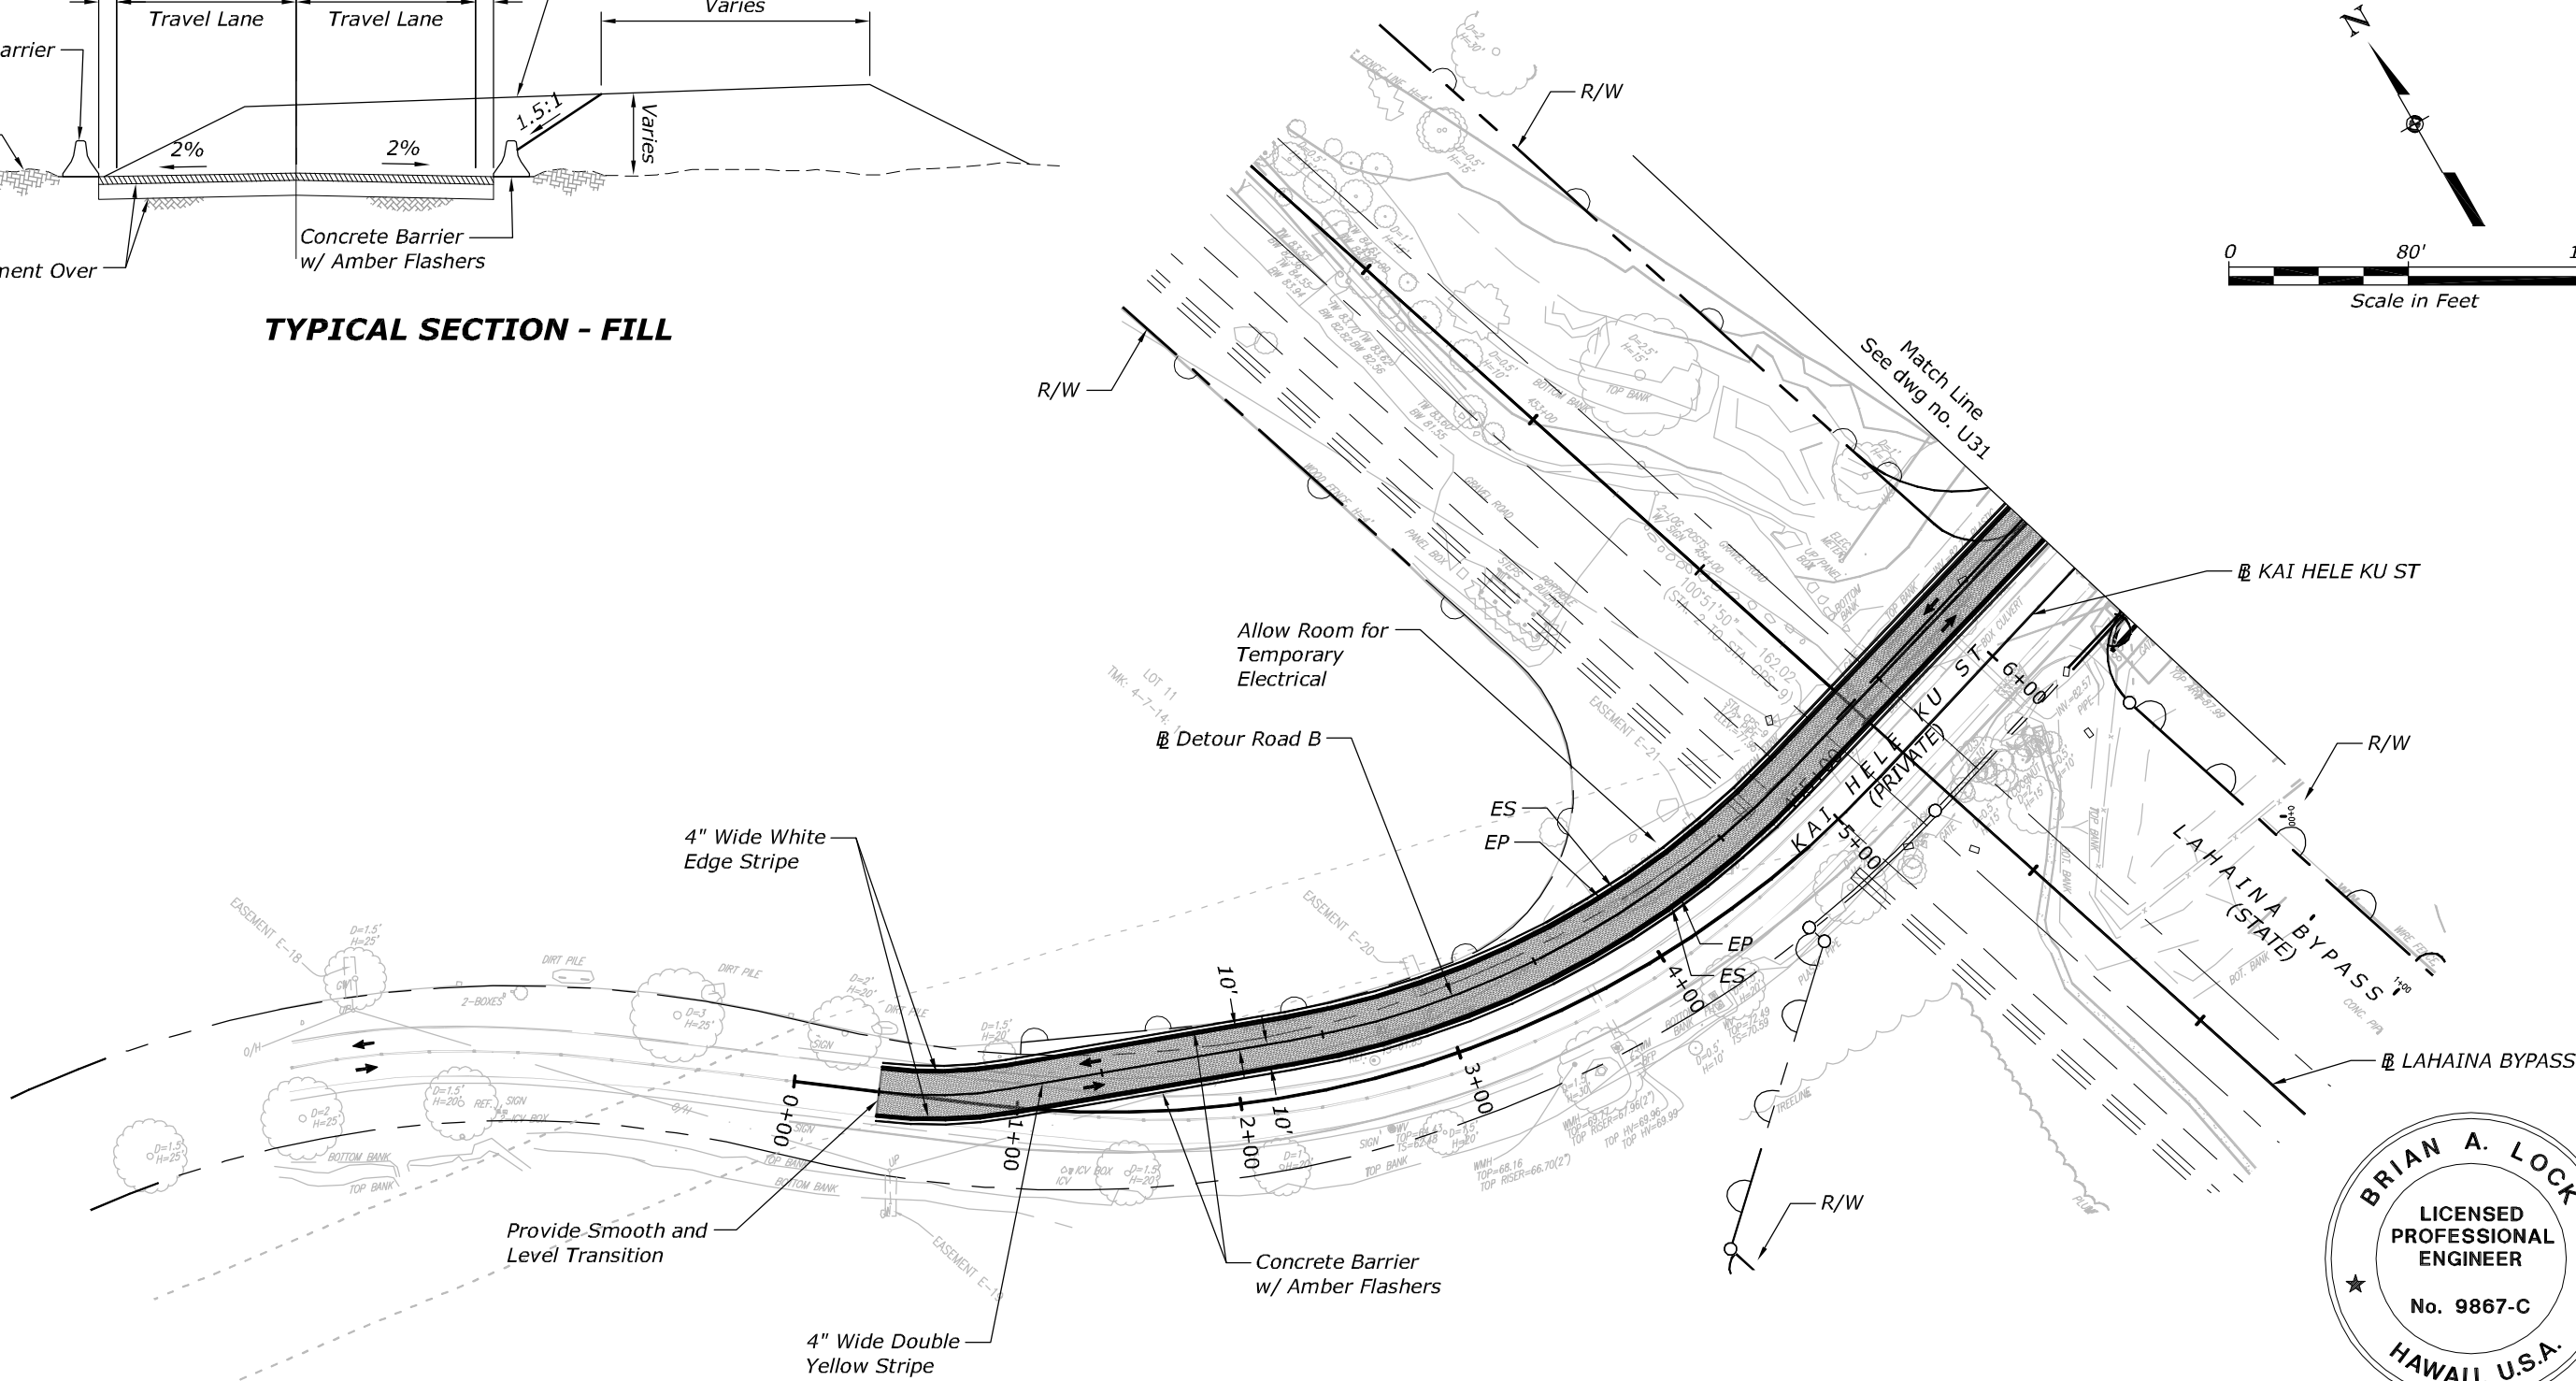

LEGEND
AC Pavement

- NOTES:
- See V Series plans for temporary traffic control plans.
 - See Electrical sheets for Temporary Electrical Plans



THIS WORK WAS PREPARED BY ME
OR UNDER MY SUPERVISION.



WILSON OKAMOTO CORPORATION
APRIL 30, 2020
LIC. EXP. DATE

U.S. DEPARTMENT OF TRANSPORTATION
FEDERAL HIGHWAY ADMINISTRATION
CENTRAL FEDERAL LANDS HIGHWAY DIVISION


U.S. CUSTOMARY

DETOUR ROADWAY PLAN
KAI HELE KU STREET

STATE	PROJECT	SHEET NO.
HI	HI STP SR 30(1)	U31

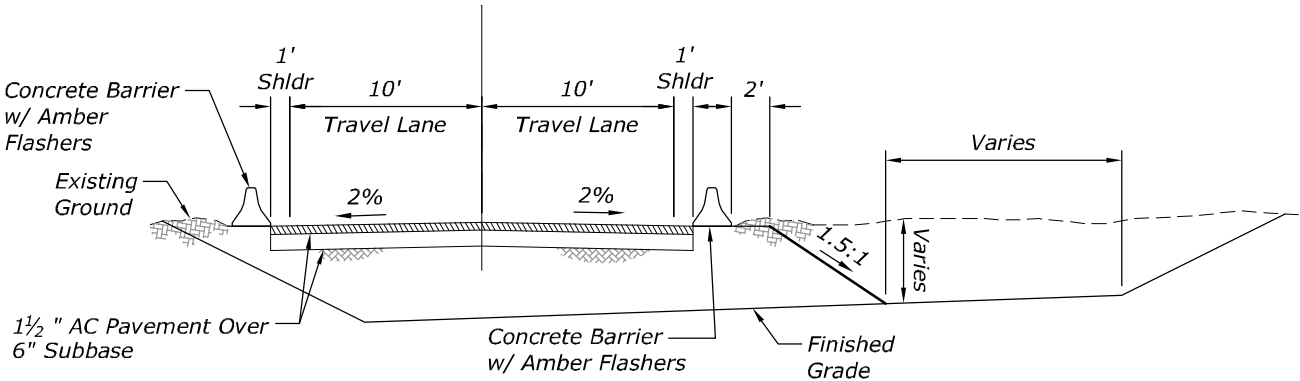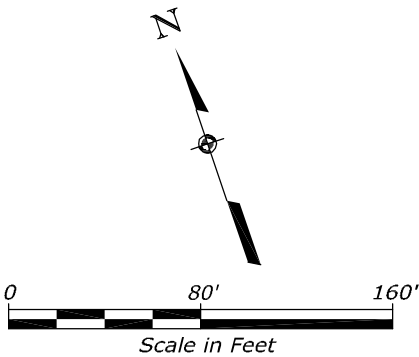


TYPICAL SECTION - CUT

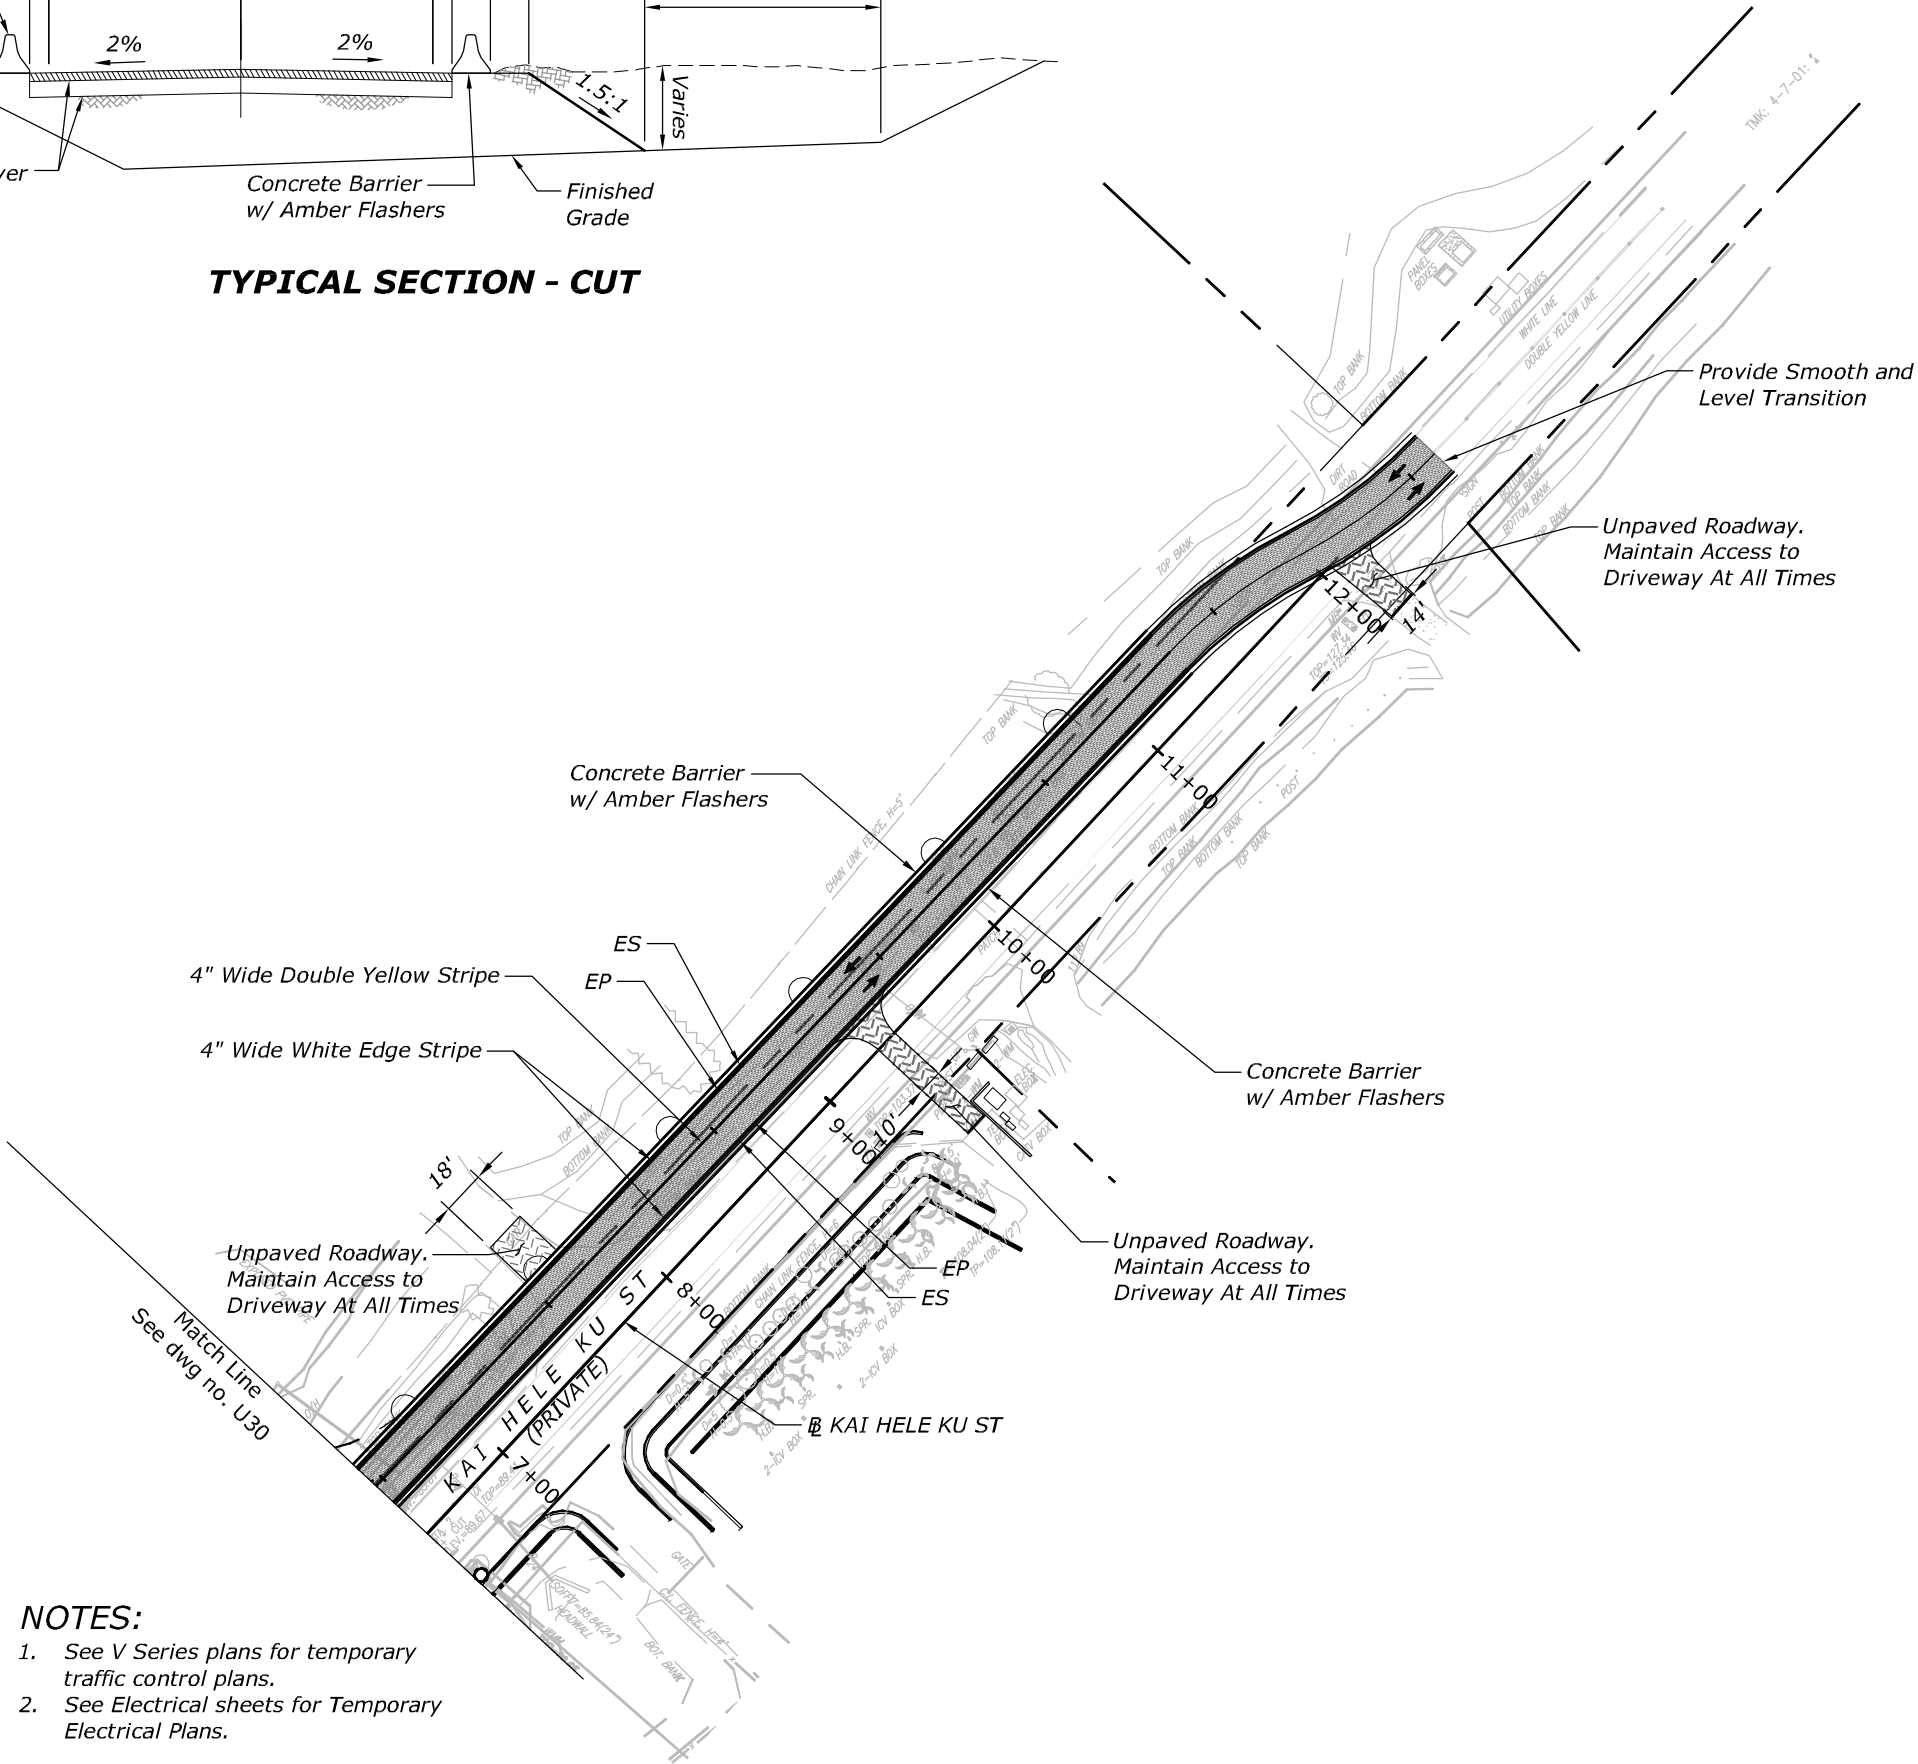

- LEGEND
- AC Pavement
 - Unpaved Roadway

- NOTES:
- See V Series plans for temporary traffic control plans.
 - See Electrical sheets for Temporary Electrical Plans.

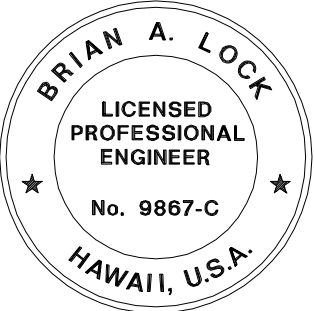

THIS WORK WAS PREPARED BY ME
OR UNDER MY SUPERVISION.



WILSON OKAMOTO CORPORATION APRIL 30, 2020
LIC. EXP. DATE

U.S. DEPARTMENT OF TRANSPORTATION
FEDERAL HIGHWAY ADMINISTRATION
CENTRAL FEDERAL LANDS HIGHWAY DIVISION



U.S. CUSTOMARY

DETOUR ROADWAY PLAN
KAI HELE KU STREET

STATE	PROJECT	SHEET NO.
HI	HI STP SR 30(1)	U32

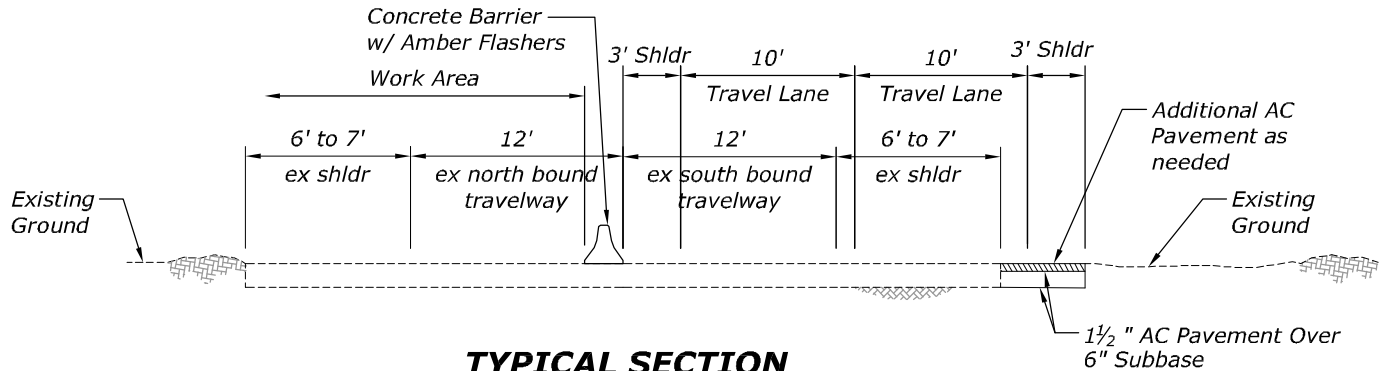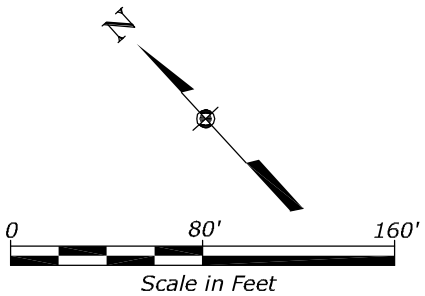

**TYPICAL SECTION
(HONOAPIILANI HIGHWAY)**

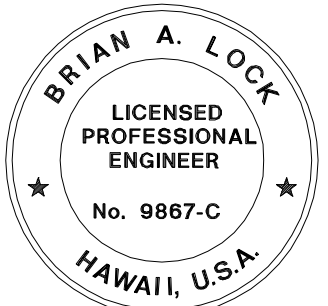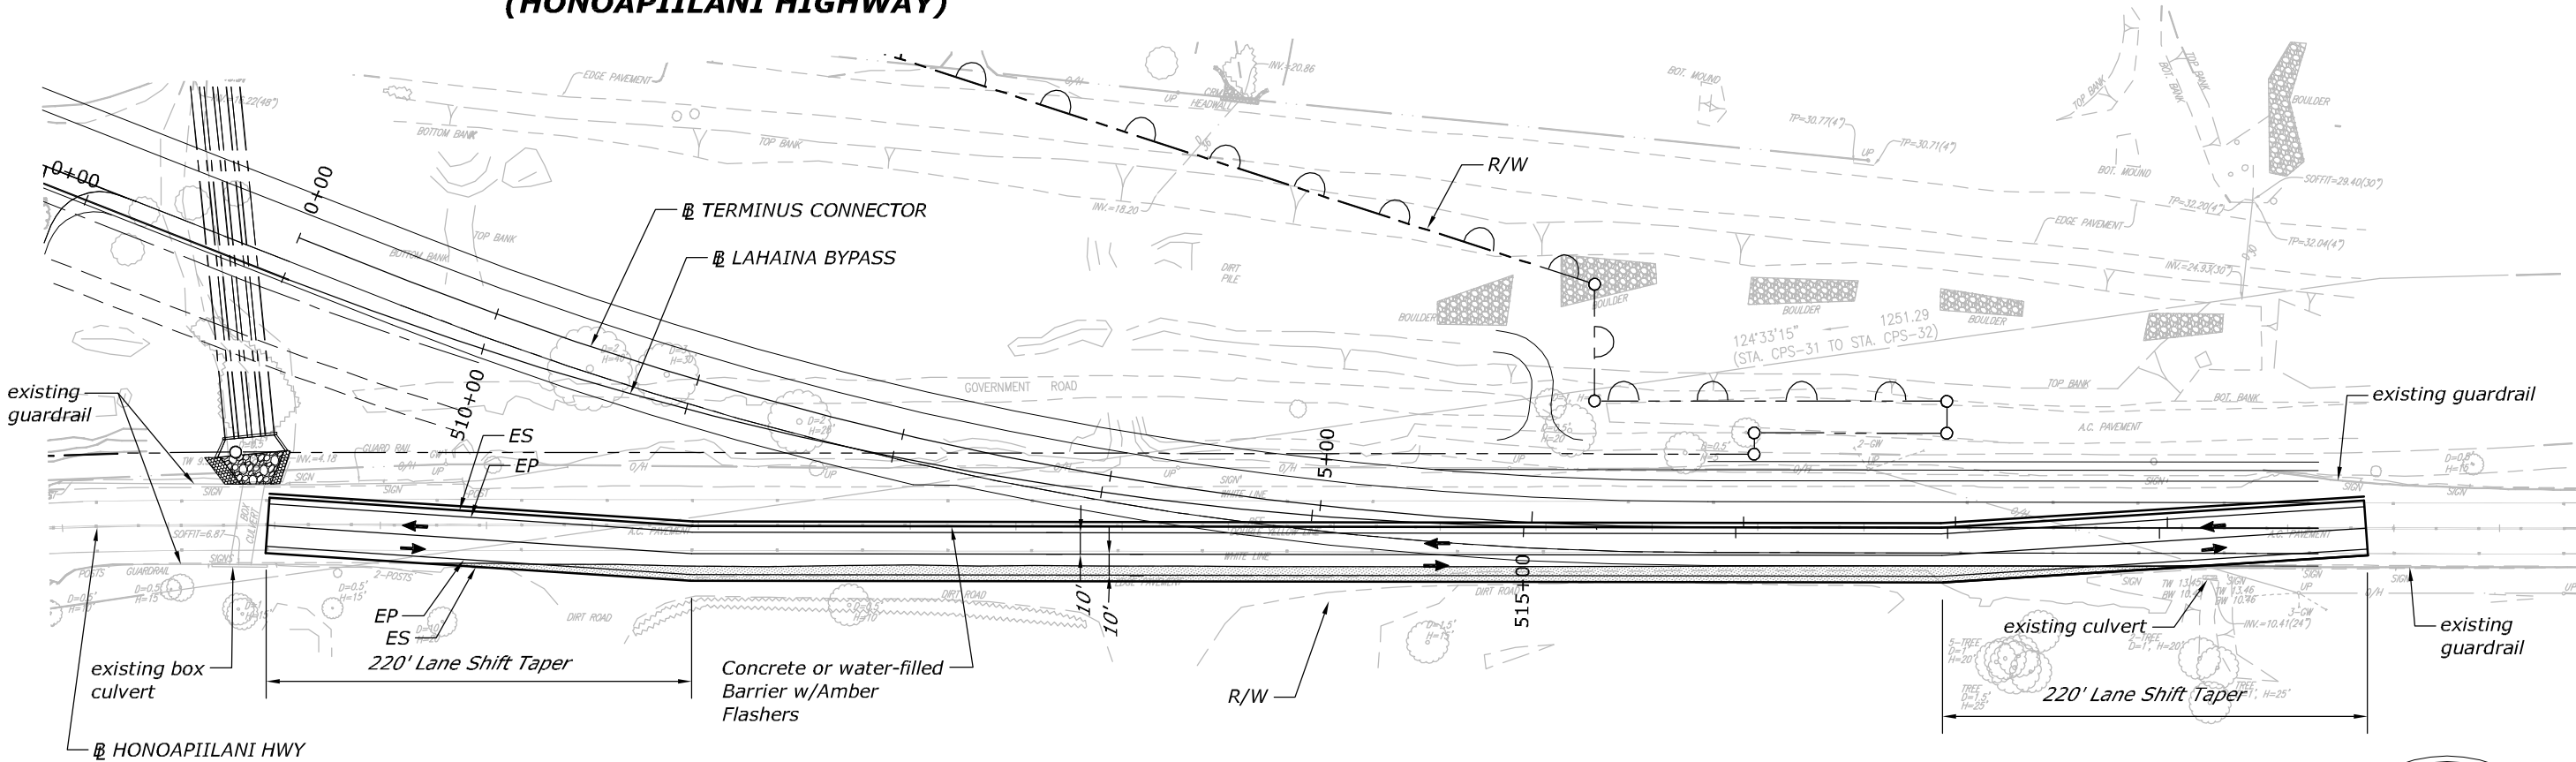

THIS WORK WAS PREPARED BY ME
OR UNDER MY SUPERVISION.

WILSON OKAMOTO CORPORATION APRIL 30, 2020
LIC. EXP. DATE

LEGEND
Added AC Pavement

- NOTES:**
1. See V Series Plans for temporary traffic control plans.
 2. See Electrical Sheets for Temporary Electrical Plan.



PHASE 1

U.S. DEPARTMENT OF TRANSPORTATION
FEDERAL HIGHWAY ADMINISTRATION
CENTRAL FEDERAL LANDS HIGHWAY DIVISION



U.S. CUSTOMARY

**DETOUR ROADWAY PLAN
SOUTHERN TERMINUS**

STATE	PROJECT	SHEET NO.
HI	HI STP SR 30(1)	U33

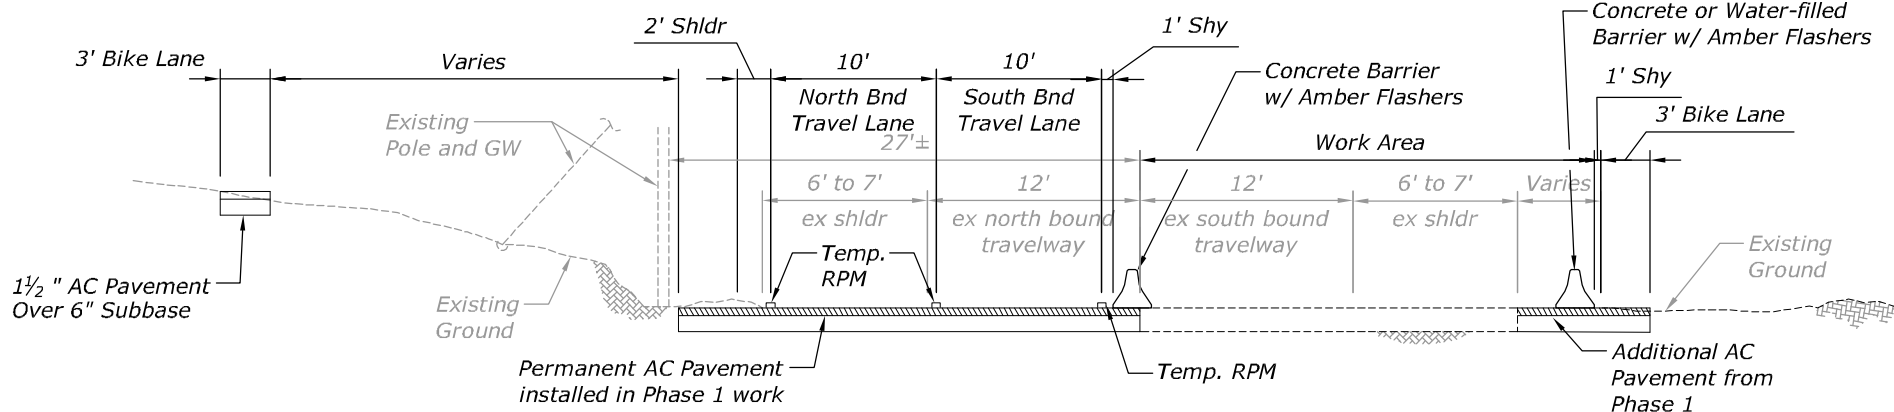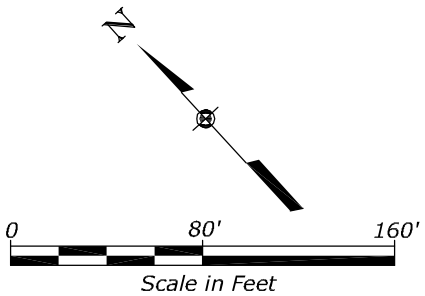

TYPICAL SECTION

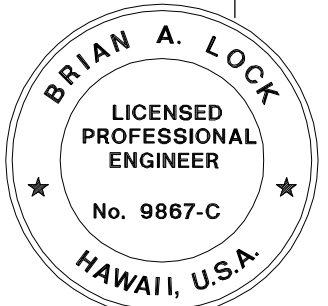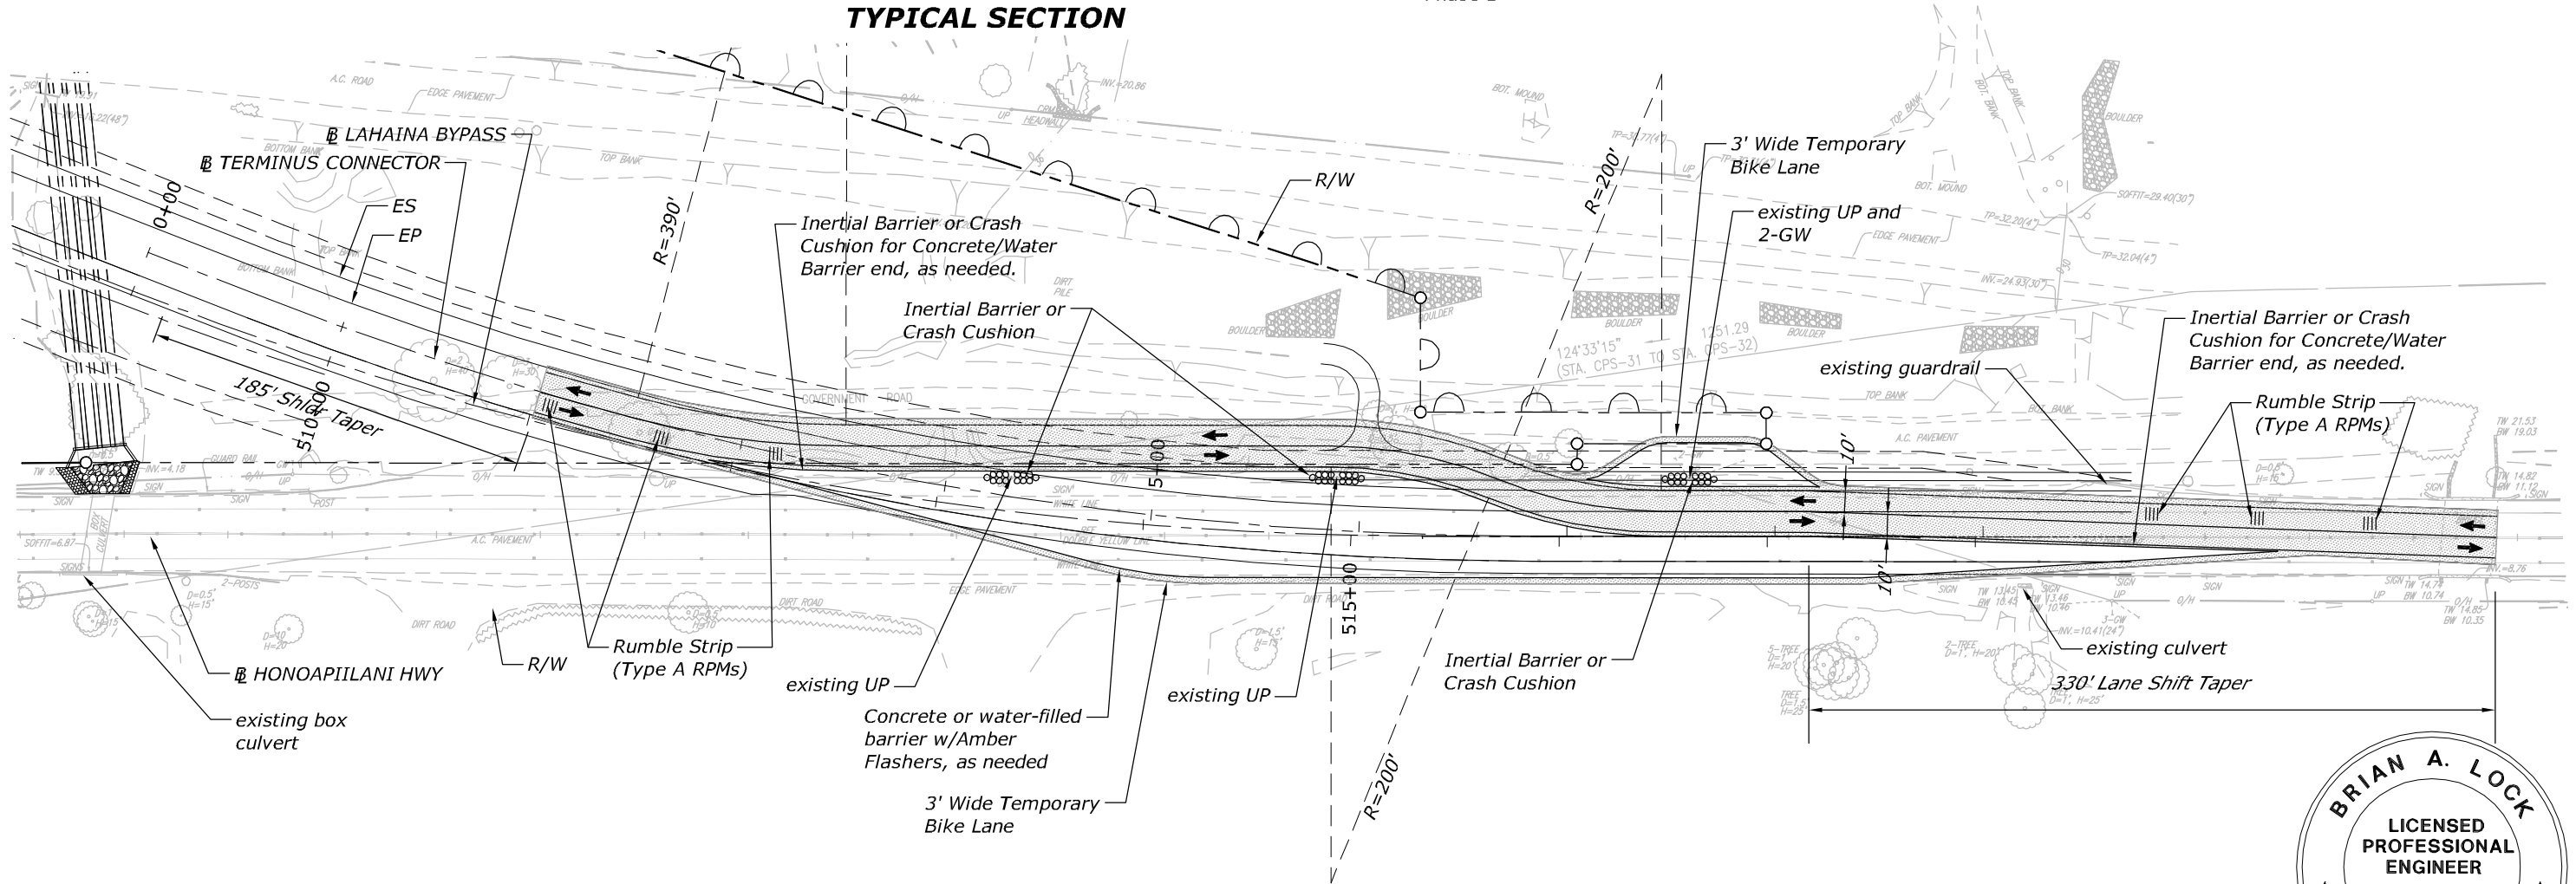

THIS WORK WAS PREPARED BY ME OR UNDER MY SUPERVISION.

WILSON OKAMOTO CORPORATION APRIL 30, 2020
LIC. EXP. DATE

U.S. DEPARTMENT OF TRANSPORTATION
FEDERAL HIGHWAY ADMINISTRATION
CENTRAL FEDERAL LANDS HIGHWAY DIVISION

U.S. CUSTOMARY

DETOUR ROADWAY PLAN
SOUTHERN TERMINUS

LEGEND
Detour Road

- NOTES:
- See V Series Plans for temporary traffic control plans.
 - See Electrical Sheets for Temporary Electrical Plan.

PHASE 2