

INDEX TO DRAWINGS	
SHEET NO.	DESCRIPTION
1	TITLE SHEET
2	STANDARD PLANS SUMMARY
3	GENERAL NOTES
4-5	WATER POLLUTION & EROSION CONTROL NOTES
6	CONSTRUCTION & UTILITY NOTES
7	SYMBOLS & ABBREVIATIONS
8-9	TYPICAL ROADWAY SECTIONS
10-12	EROSION CONTROL PLAN & DETAILS
13-15	ROADWAY PLANS
16	ACCESS ROAD PLAN
17-18	MISCELLANEOUS DETAILS
19-20	ENDPOST DETAILS
21	METAL GUARDRAIL TYPE "3" THRIE BEAM & APPURTENANCE DETAIL
22-23	GUARDRAIL DETAILS
24	GUARDRAIL TERMINAL CONNECTORS & END SECTIONS DETAILS
25	FLEAT 350
26-27	ET-2000 PLUS
28	TYPE "G" FLARE END TERMINAL
29-41	ROADWAY CROSS SECTIONS
42-44	STRIPING PLAN
45-47	TRAFFIC CONTROL PLAN
48-54	BORING LOGS
55-106①	STRUCTURAL PLANS
107-108	ELECTRICAL PLANS

Sept. 2012

DATE

692-7587

PHONE

HWY-DD



MANAGED BY

WILSON OKAMOTO CORPORATION

DESIGNED BY

Sheet No. ① 100S-1 is a Supplementary Sheet to this project. Total Sheet Count After "AS-BUILT" posting 109 sheets.

CHANGES MADE DURING CONSTRUCTION HAVE BEEN INCORPORATED ON THESE PLANS EXCEPT CHANGES IN THE ORIGINAL THEORETICAL QUANTITIES. FOR ACTUAL QUANTITIES, REFER TO PROJECT LEDGER AND/OR COMPUTATION BOOK.


  
 RESIDENT ENGINEER
   

  
 DATE

STATE OF HAWAII

DEPARTMENT OF TRANSPORTATION

HIGHWAYS DIVISION

HONOLULU, HAWAII

"AS-BUILT"

PLANS FOR



WAIEHU BEACH ROAD

REHABILITATION OF IAO STREAM BRIDGE

FEDERAL AID PROJECT NO. BR-STP-3400(5)

DISTRICT OF WAILUKU

ISLAND OF MAUI

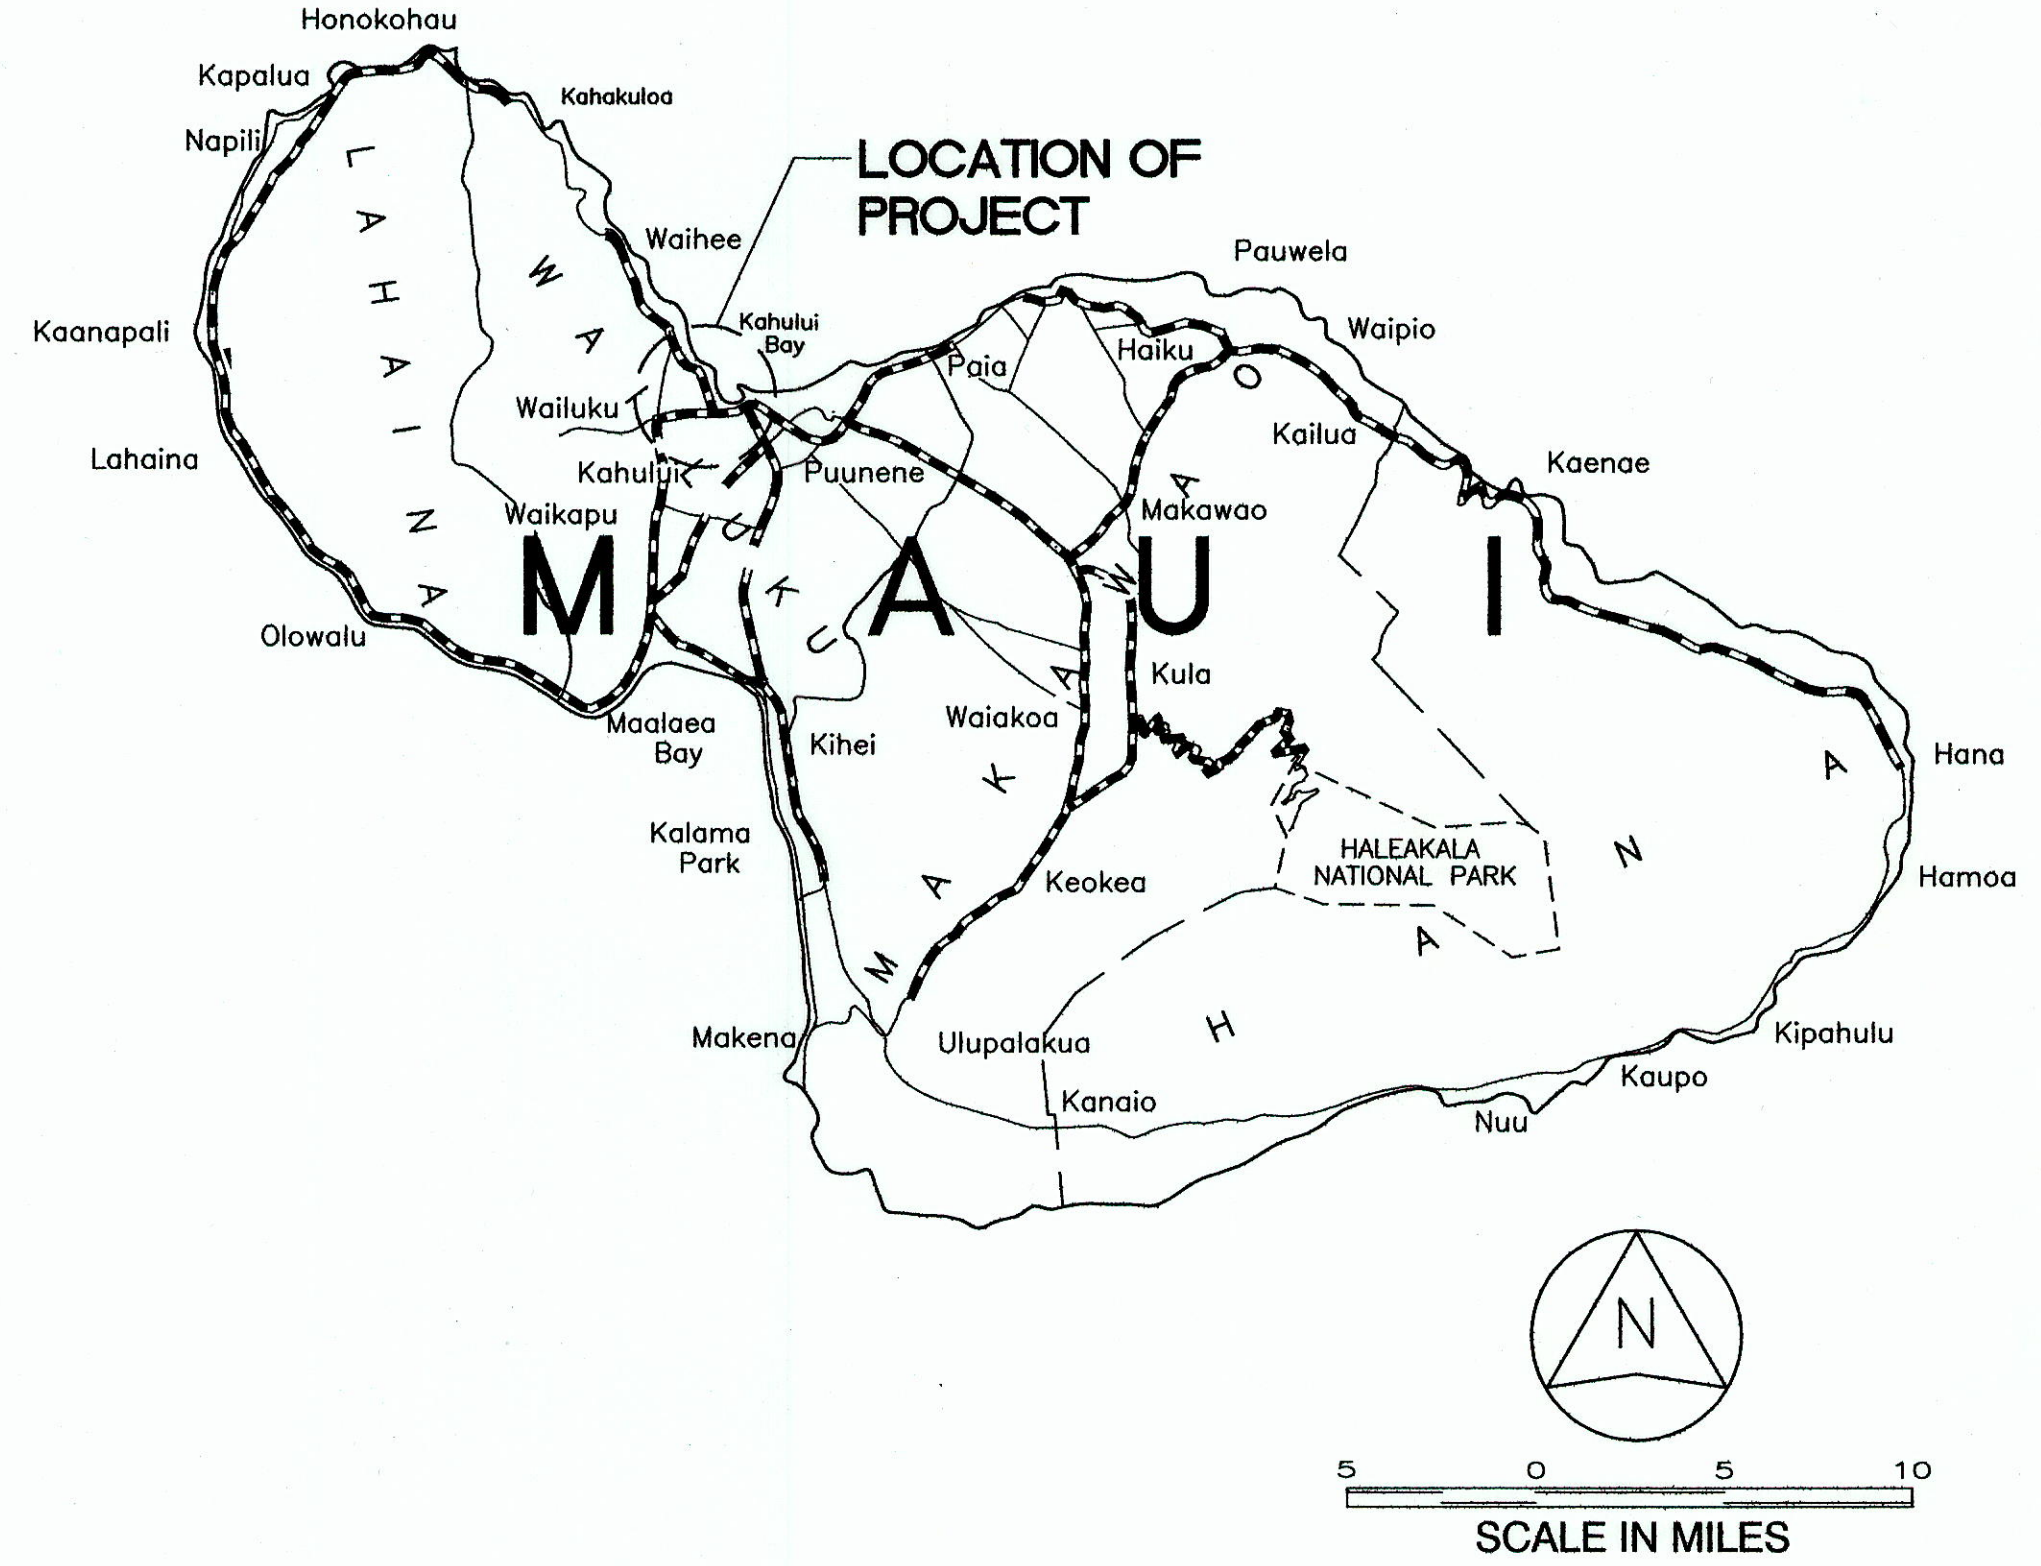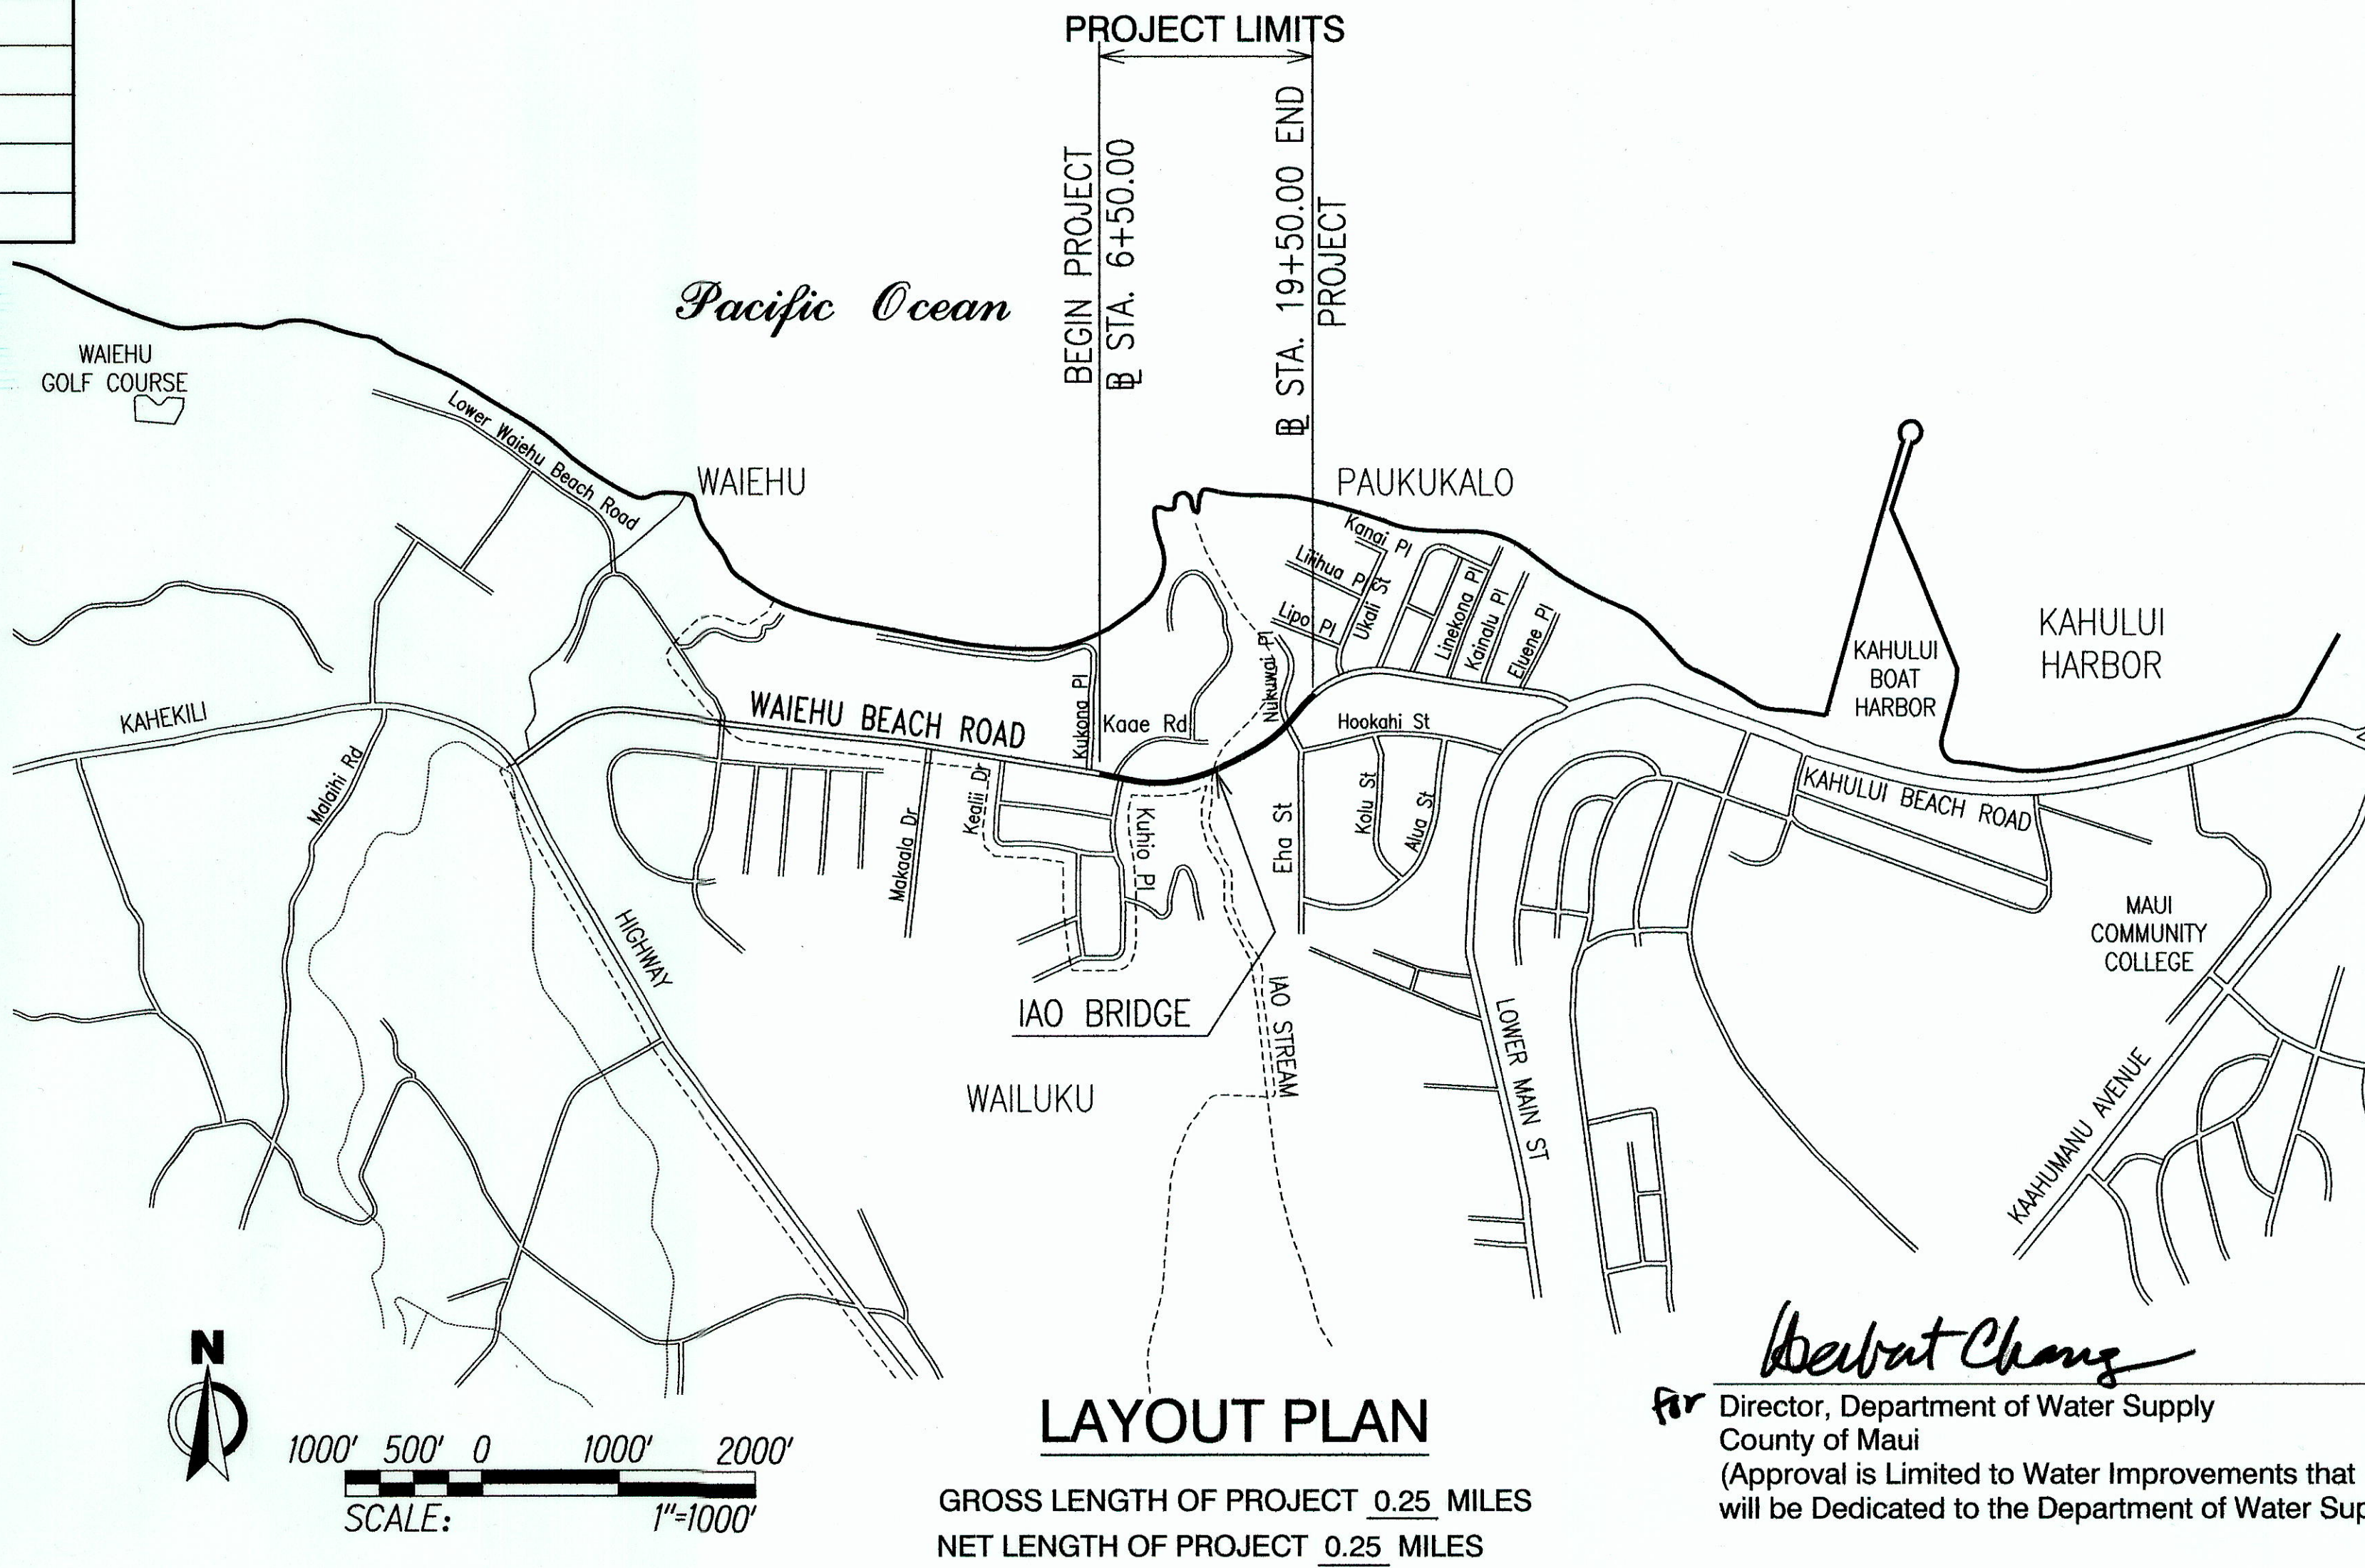


FEDERAL AID PROJECTS PREVIOUSLY CONSTRUCTED OR UNDER CONSTRUCTION

 
MILE POST 1.54 TO MILE POST 1.79

DESIGN DESIGNATION	
CURRENT ADT (2006)	18,300
DESIGN ADT (2026)	26,800
DHV	2,300
D	55/45
T	30.0%
T <sub>24</sub>	3.5%
V	45 MPH

LOAD RATING	
HL-93	INVENTORY
HL-93	OPERATING

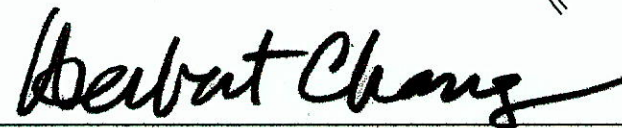  
 Director, Department of Water Supply  
 County of Maui  
 (Approval is Limited to Water Improvements that will be Dedicated to the Department of Water Supply)

9/26/2012  
 Date

1/30/13	Revised Sheet Number and Grid Lines for Atlas
DATE	REVISION
DEPARTMENT OF TRANSPORTATION STATE OF HAWAII	
APPROVED:	
	10/02/12
DIRECTOR OF TRANSPORTATION	DATE

FED. ROAD DIST. NO.	STATE	FED. AID PROJ. NO.	FISCAL YEAR	SHEET NO.	TOTAL SHEETS
HAWAII	HAW.	BR-STP-3400(5)	2012	ADD.1	108

