


FED. ROAD DIST. NO.	STATE	PROJ. NO.	FISCAL YEAR	SHEET NO.	TOTAL SHEETS
HAWAII	HAW.	HWY-0-01-86	1987	3	12

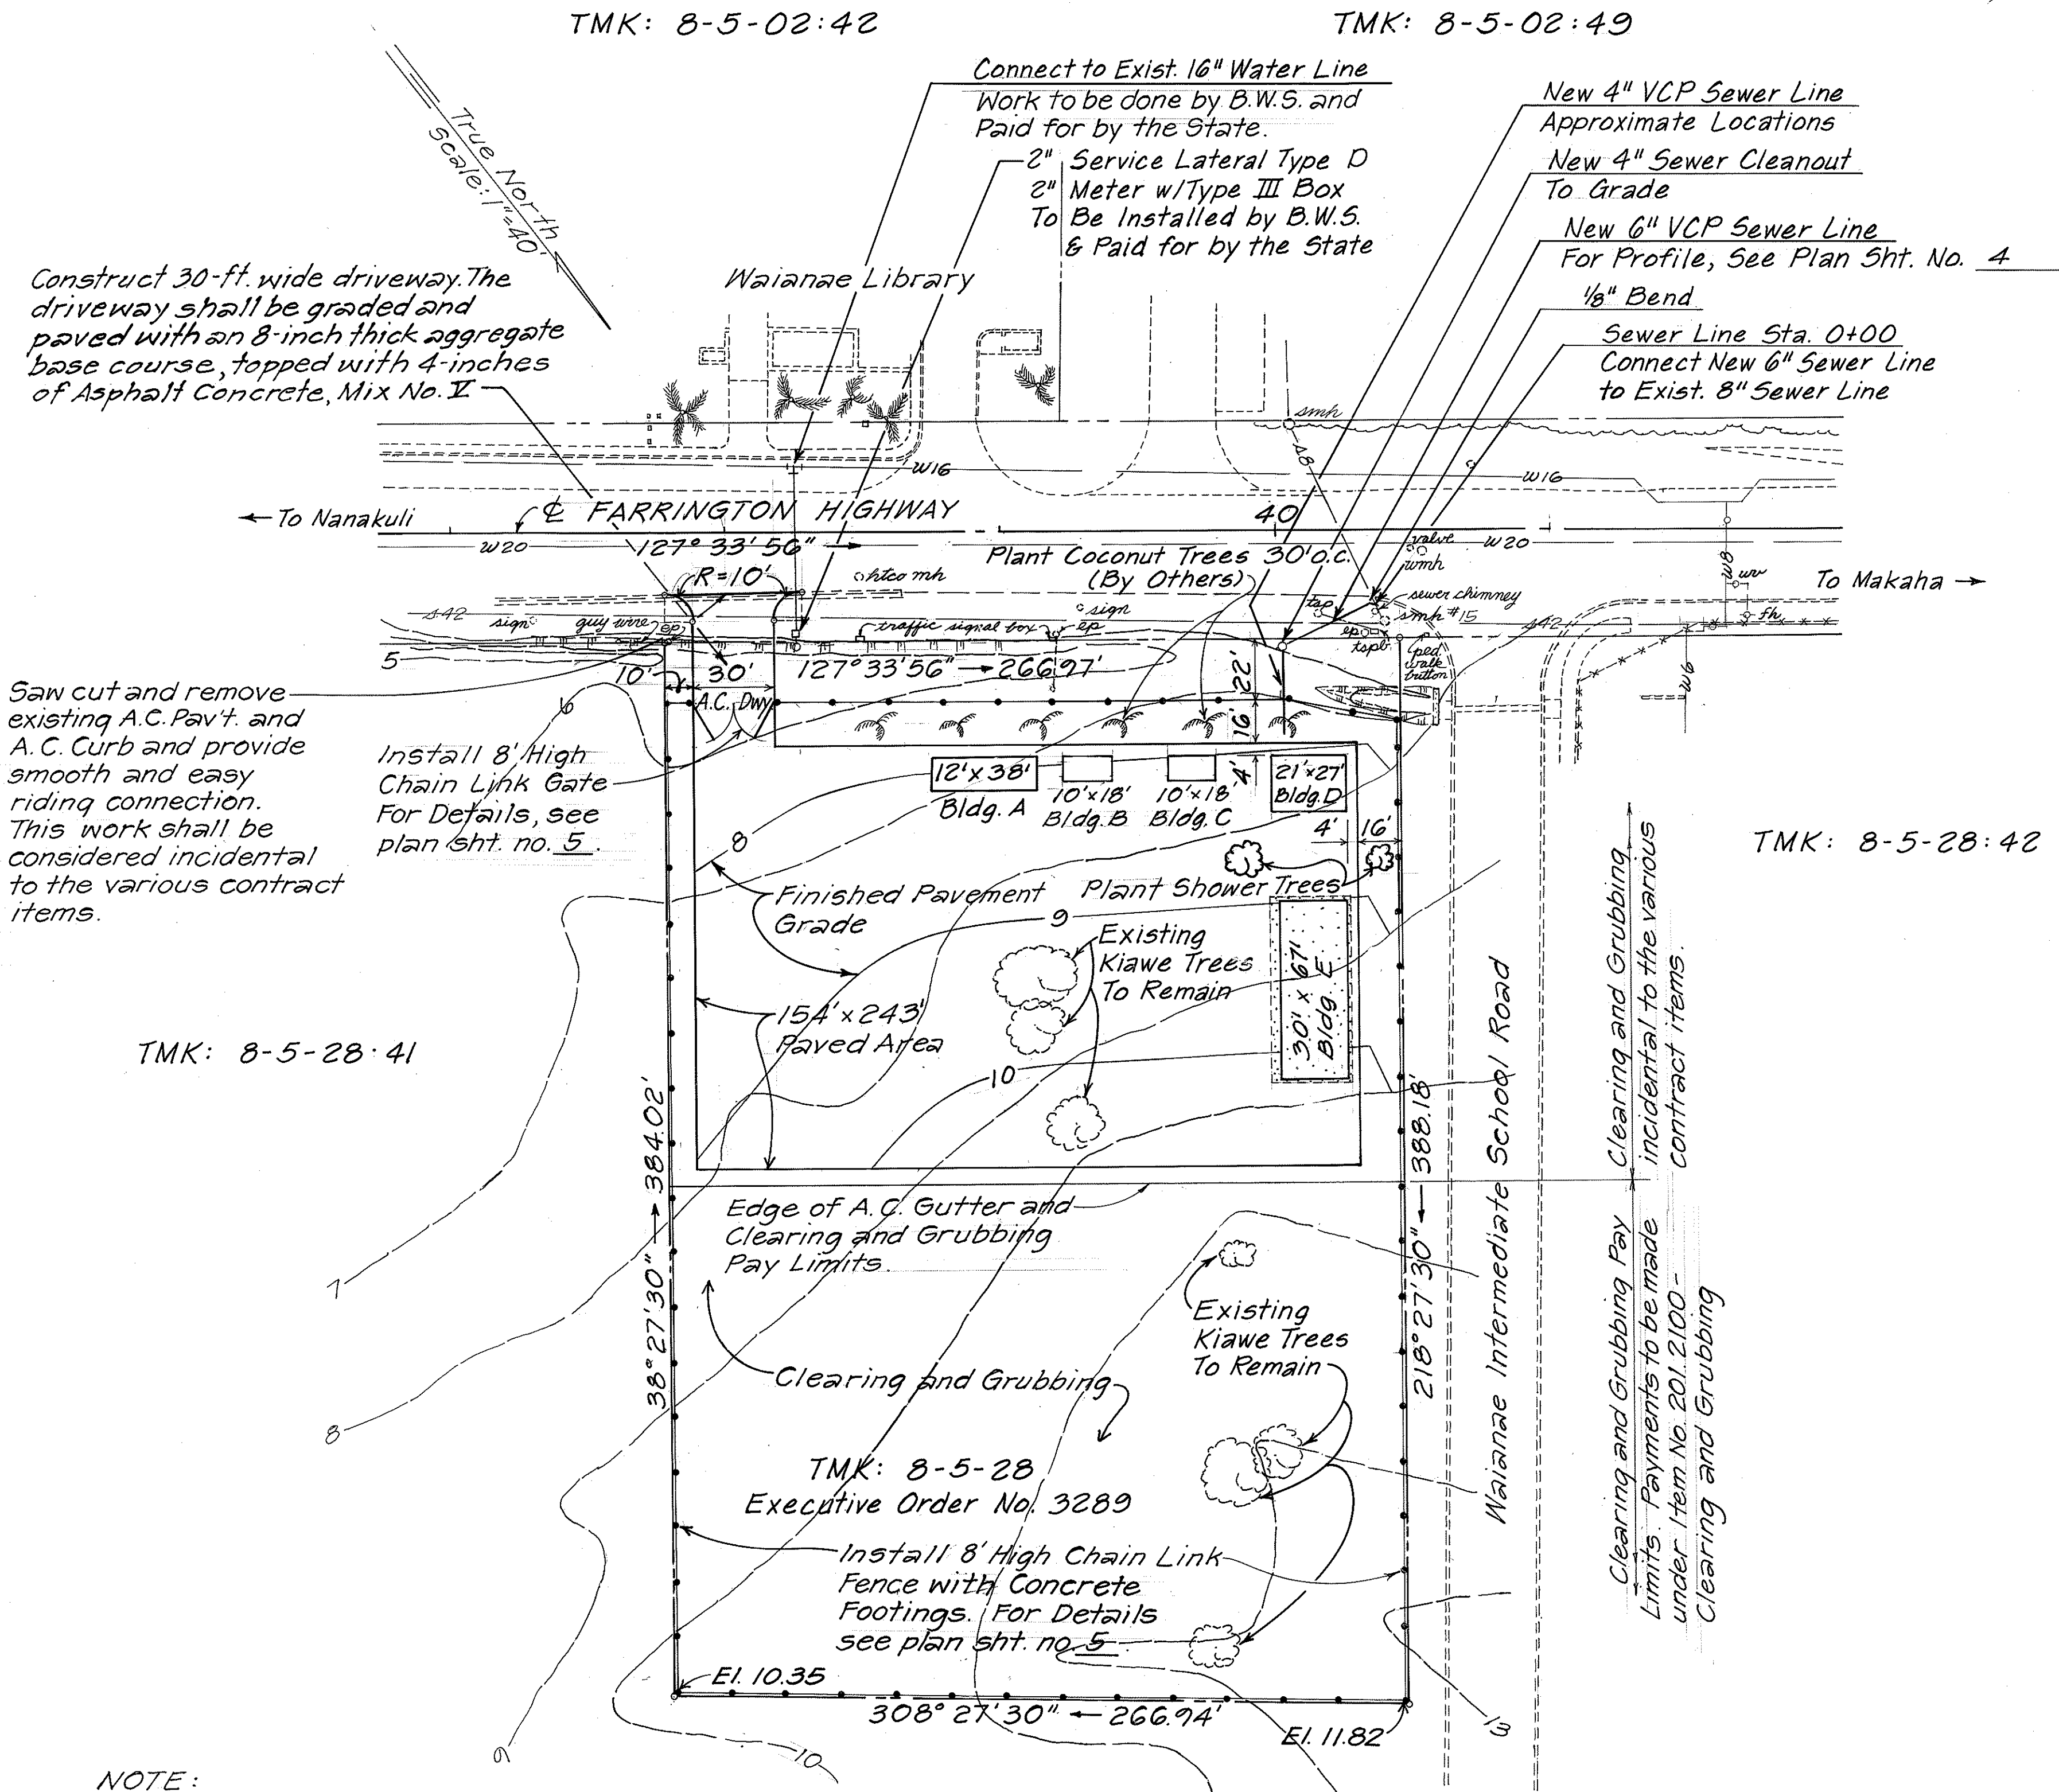

LEGEND:

— 8 —	Finish Contours
- - - 8 - - -	Existing Contours
smh	Existing Sewer Manhole
wmh	Existing Water Manhole
ep	Existing Electric Pole
ep —	Existing Electric Pole with Guy Wire
tp	Existing Traffic Signal Pole
tpb	Existing Traffic Signal Pullbox
wig	Existing Water Line
— 8 —	Existing Sewer Line

NOTE:

- Building A - Relocated Engineer's Field Office
- Building B - Relocated Project Site Laboratory (By Others)
- Building C - Relocated Crew Building (By Others)
- Building D - Relocated Supervisor's Office
- Building E - New Equipment Shed

SITE LAYOUT & UTILITY PLAN

Scale: 1" = 40'

APPROVED:

George M. Luper 6/16/86
CHIEF, DIV. OF WASTEWATER MANAGEMENT DATE

10/20/86 Deleted the 6-Strand Barbed Wire

DATE REVISION

STATE OF HAWAII
DEPARTMENT OF TRANSPORTATION
HIGHWAYS DIVISION

**SITE LAYOUT, UTILITY PLAN AND
LEGEND**

RELOCATION OF WAIANAE BASEYARD
PROJECT NO. HWY-0-01-86

Scale: As Shown Date: June, 1986

SHEET NO. 1 OF 1 SHEETS