




FED. ROAD DIST. NO.	STATE	FED. AID PROJ. NO.	FISCAL YEAR	SHEET NO.	TOTAL SHEETS
HAWAII	HAW.				

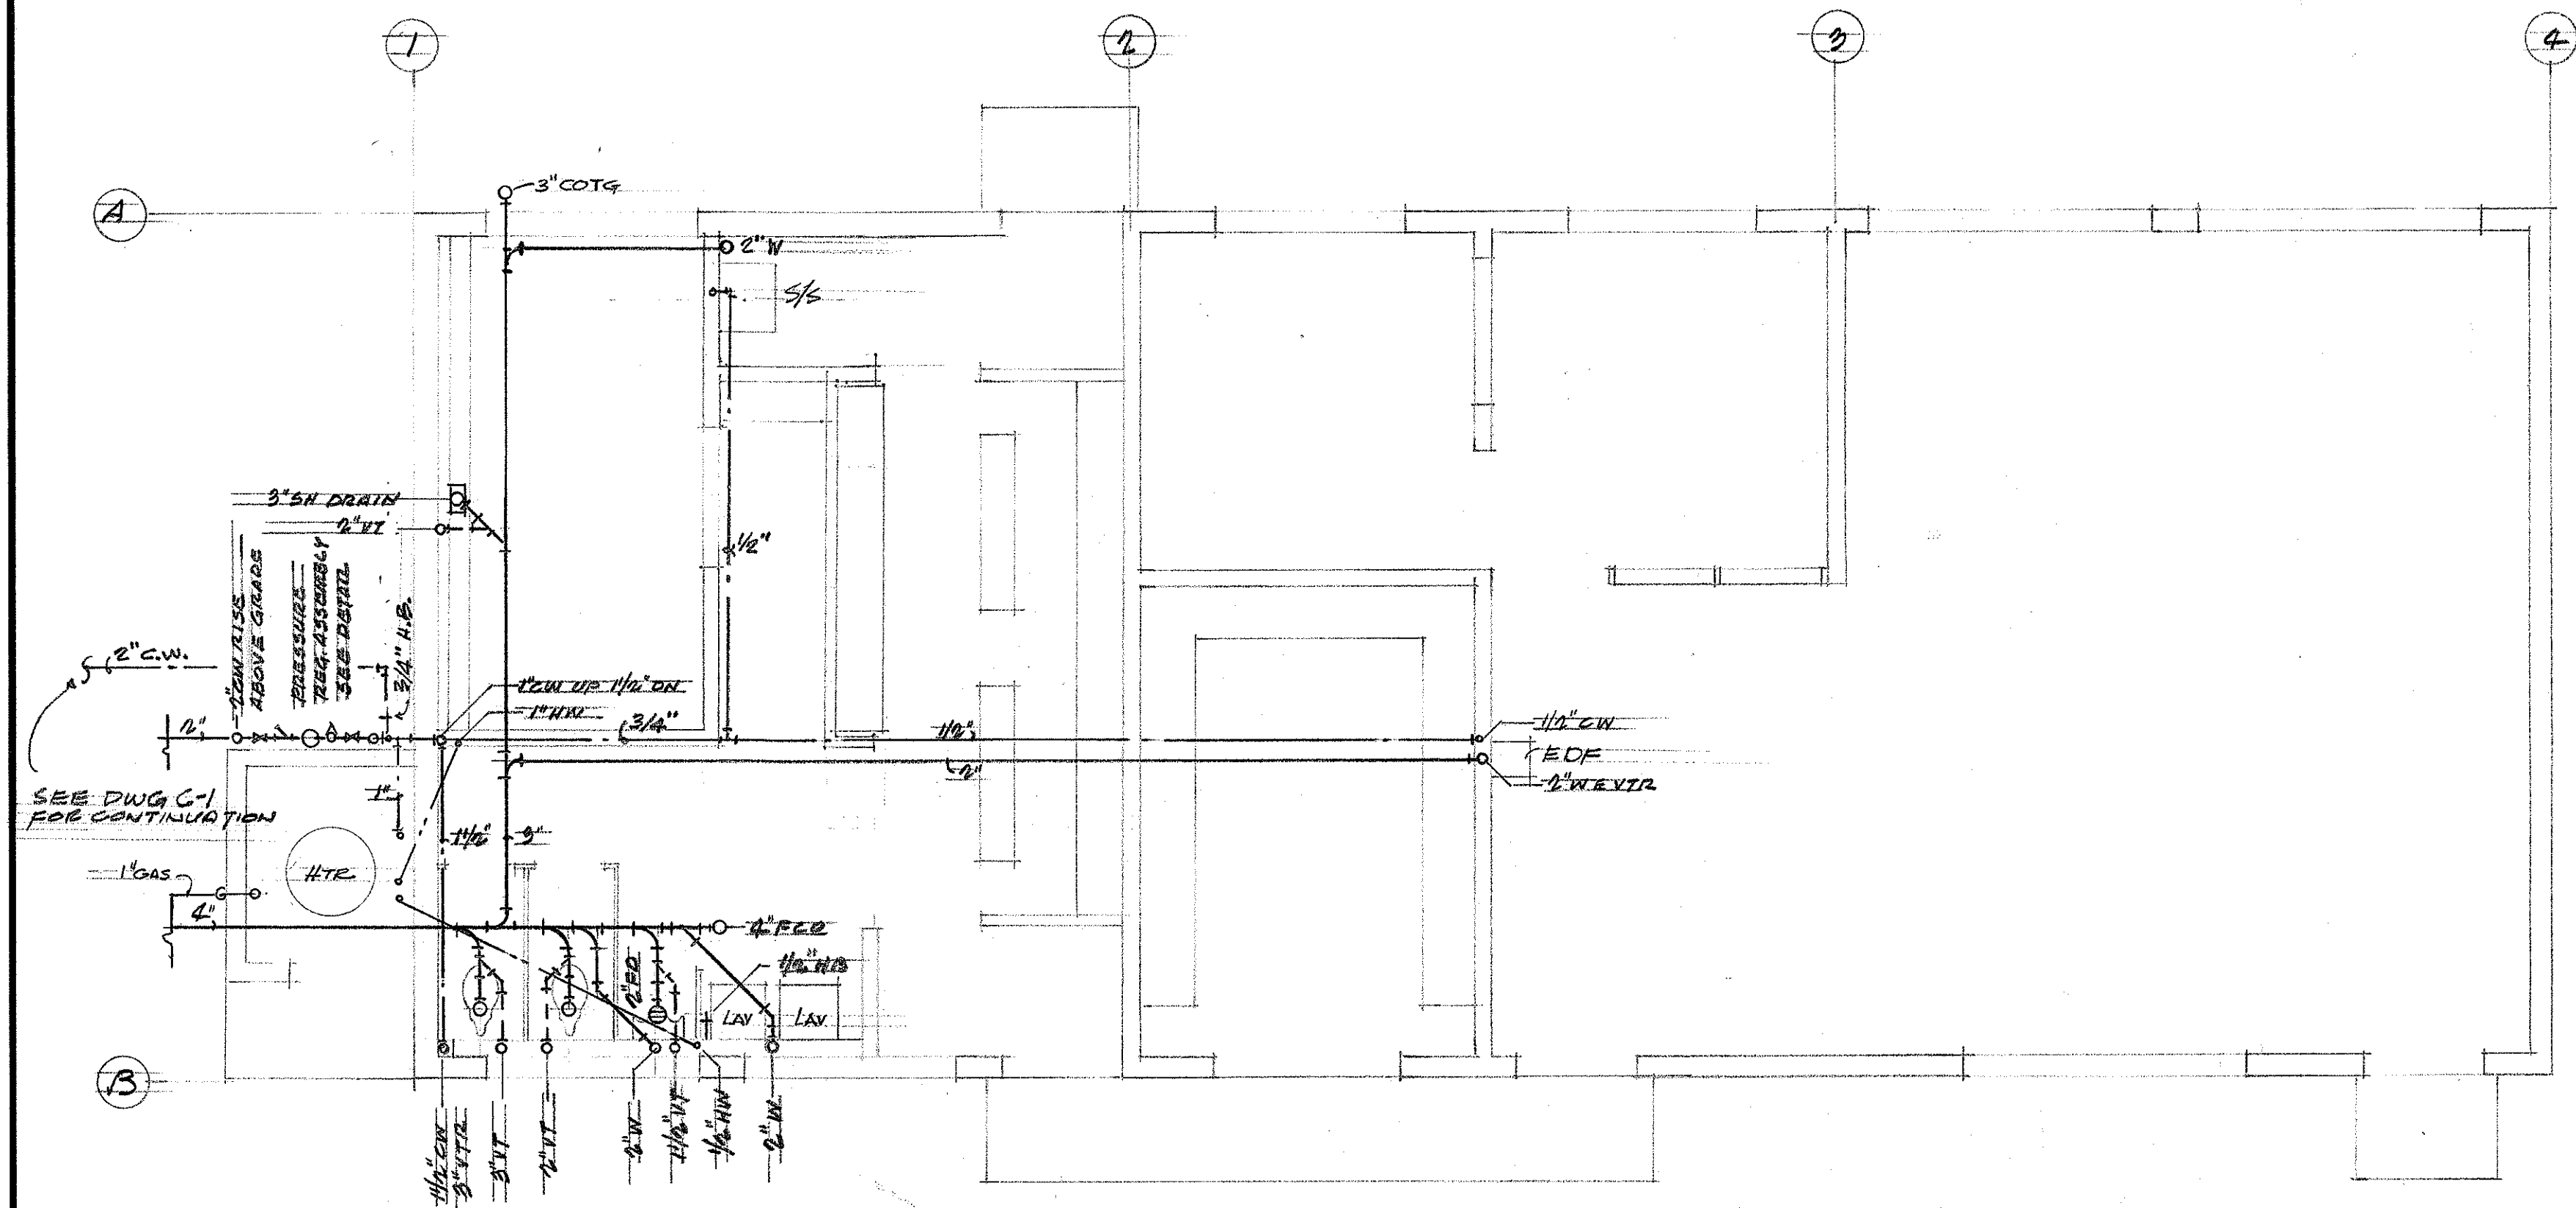

FLOOR PLAN
SCALE: 1/4" = 1'-0"

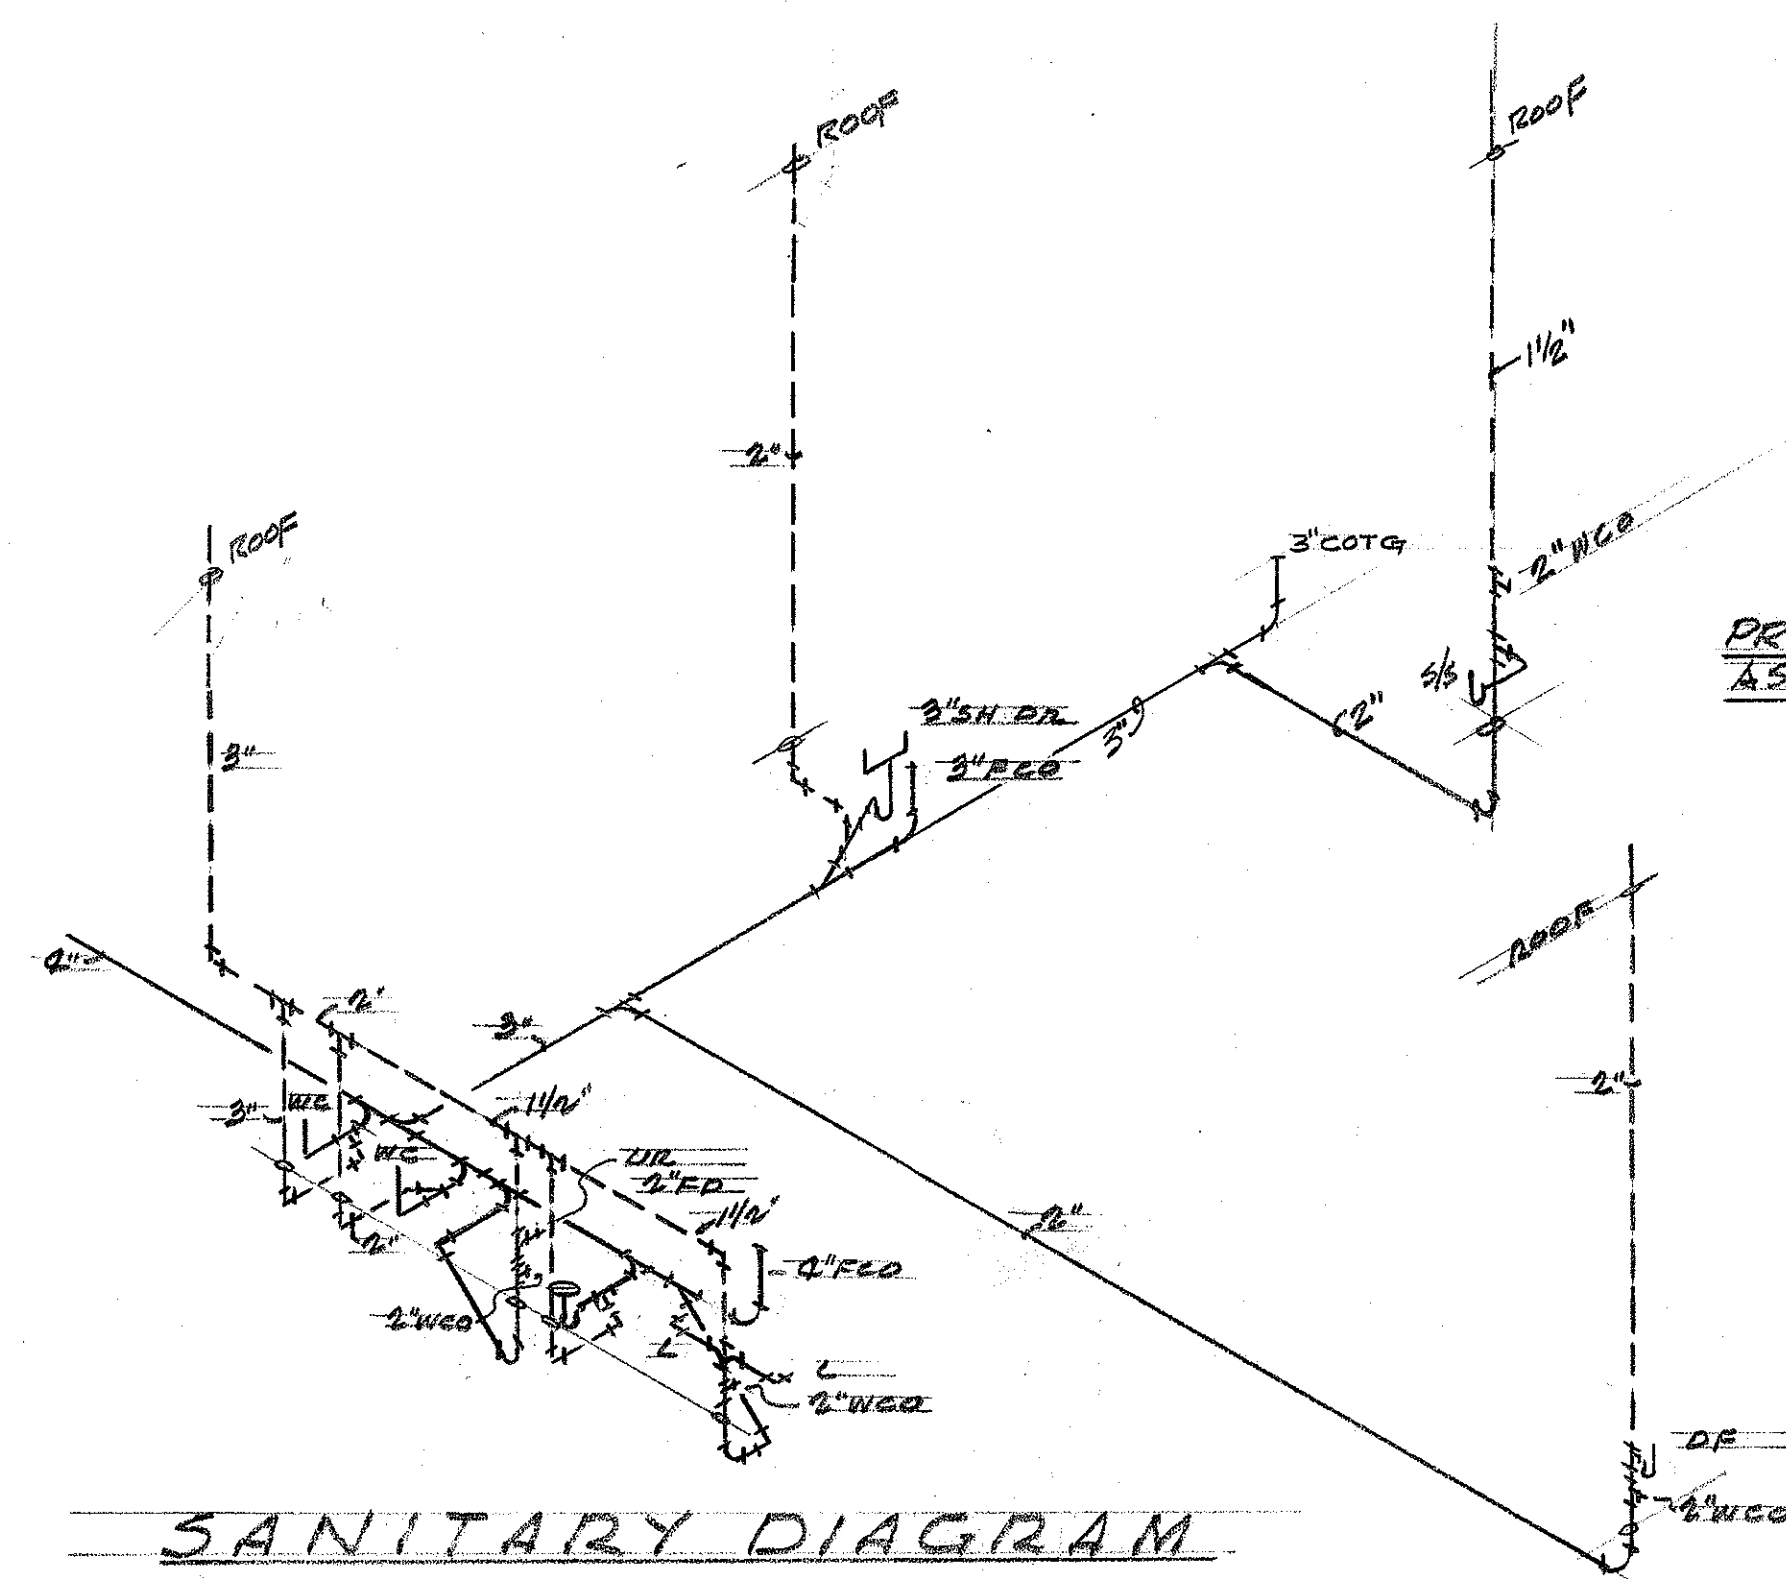

SANITARY DIAGRAM
NO SCALE

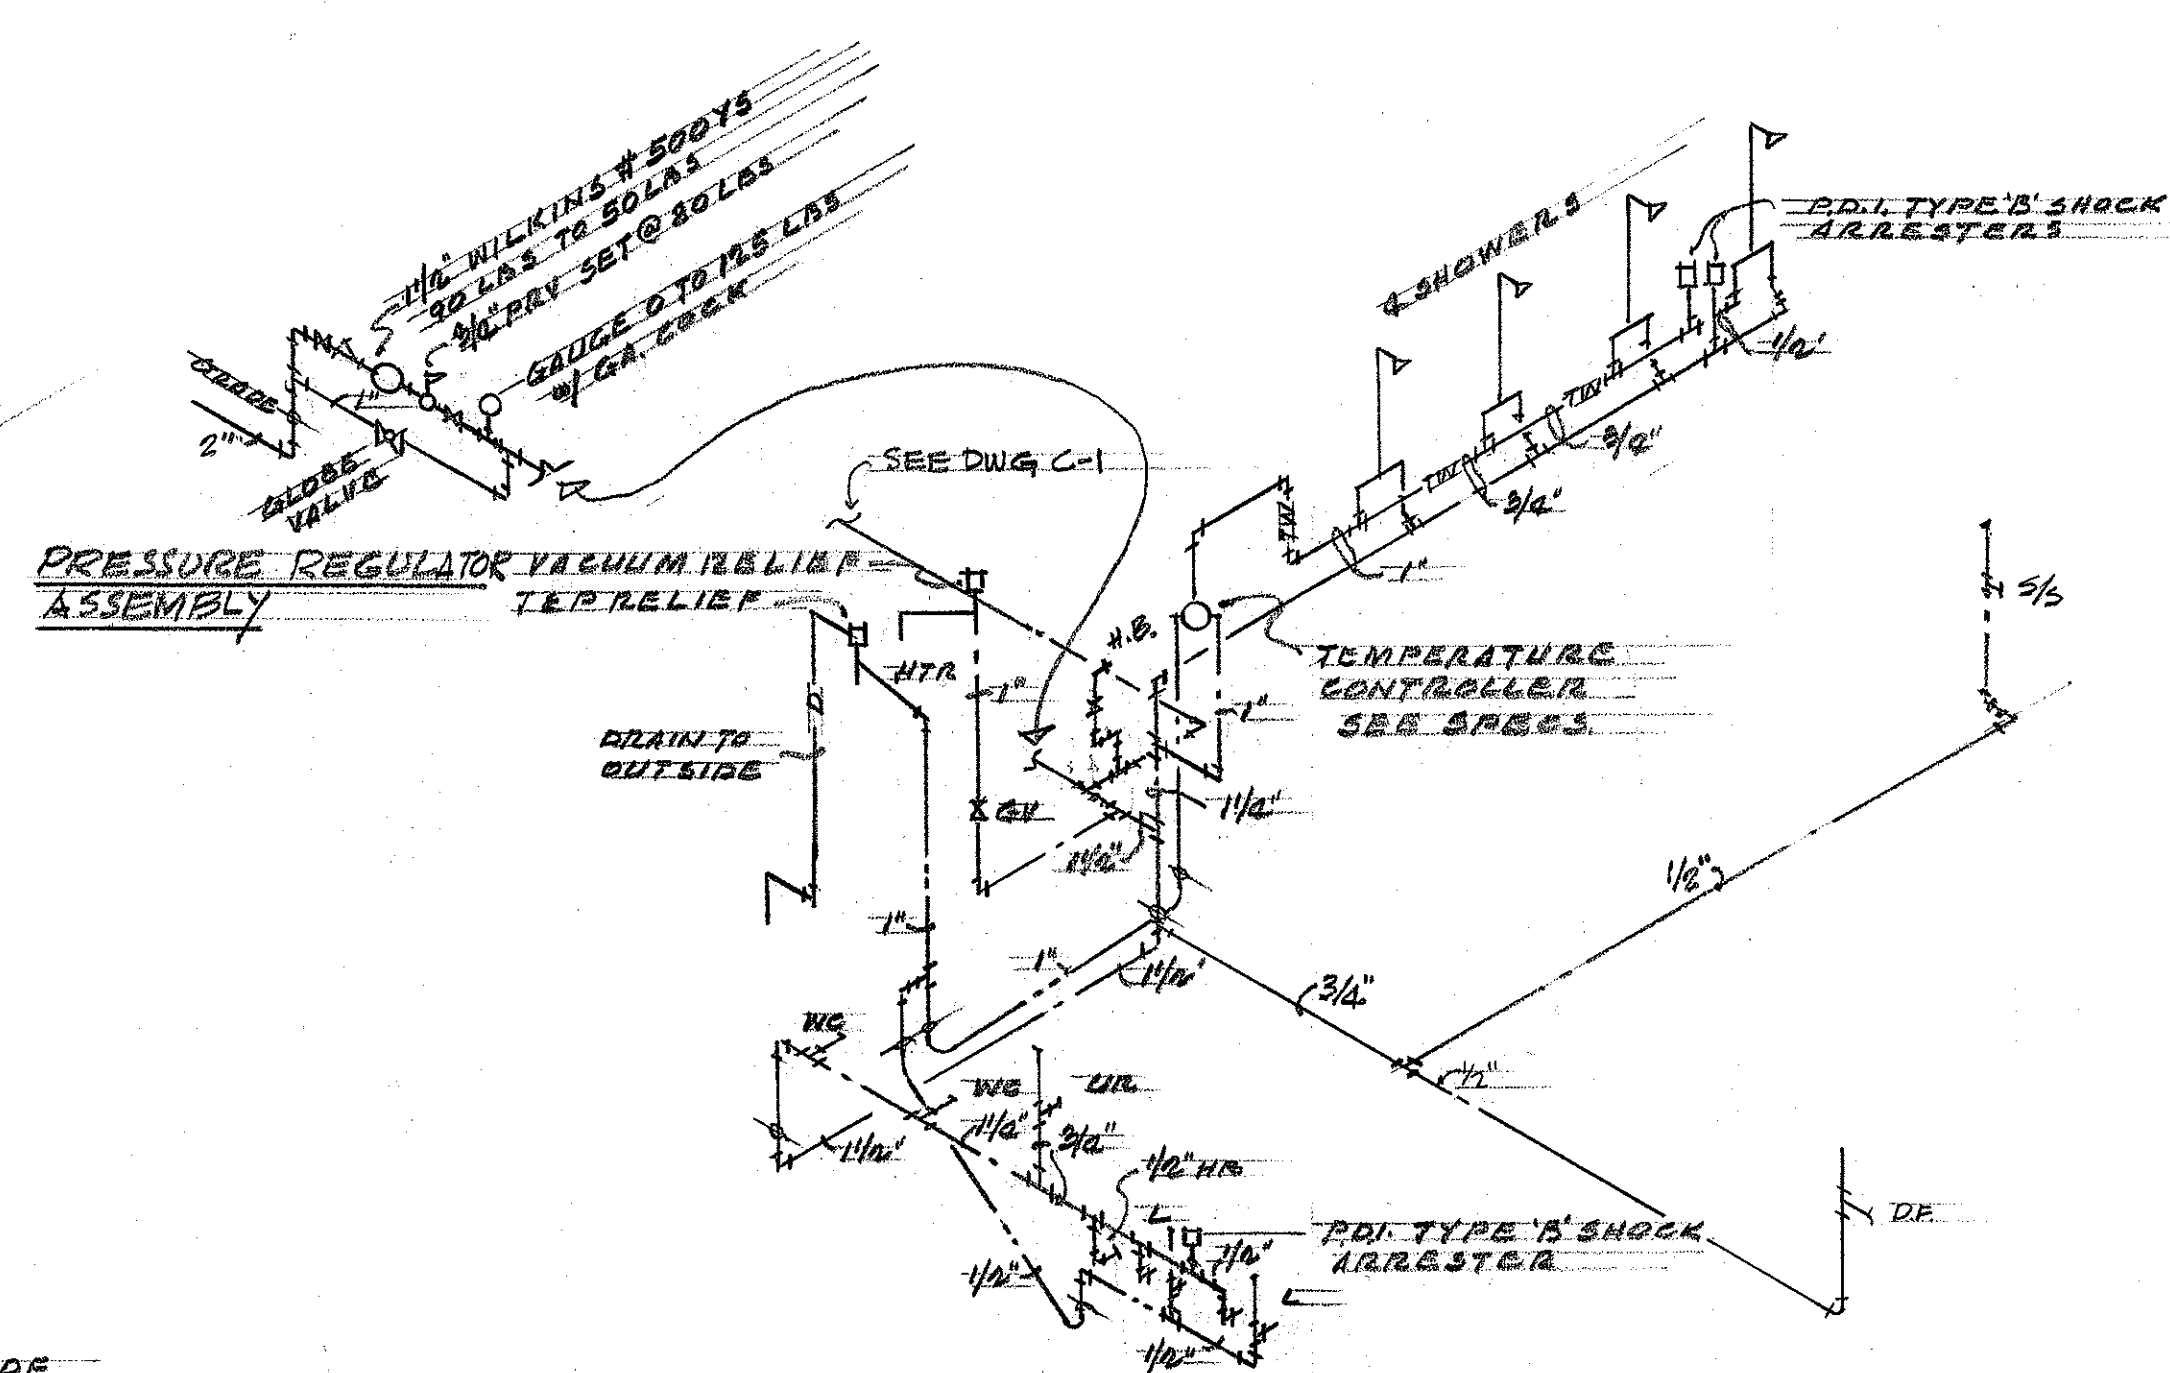

WATER DIAGRAM
NO SCALE

DATE	_____
DESIGNED BY	_____
TRACED BY	_____
NOTED BY	_____
CHECKED BY	_____
ORIGINAL PLAN	_____
NOTE BOOK	_____
NO.	_____



THIS WORK WAS PREPARED BY
ME OR UNDER MY SUPERVISION.

Herbert Y. Matsumura

STATE OF HAWAII
DEPARTMENT OF TRANSPORTATION
HIGHWAYS DIVISION

PEARL CITY BASEYARD
PEARL CITY HAWAII

PLUMBING FLOOR PLAN
SANITARY & WATER DIAGRAM

HERBERT Y. MATSUMURA & ASSOC., INC.
871 KAPIOLAN BLVD. HONOLULU, HAWAII

SHEET No. P-1 OF 11 SHEETS