

FED. ROAD DIST. NO.	STATE	FED. AID PROJ. NO.	FISCAL YEAR	SHEET NO.	TOTAL SHEETS
HAWAII	HAW.				

PEARL CITY BASEYARD

AT

PEARL CITY

OAHU, HAWAII

FOR THE

STATE OF HAWAII

DEPARTMENT OF TRANSPORTATION

HIGHWAYS DIVISION

HONOLULU, HAWAII

PROJECT NO. BD 68-315

HERBERT Y. MATSUMURA & ASSOC., INC.
 NISHIMURA & OKI ENGINEERS, INC
 ALBERT S.C. CHONG ASSOC., INC.
 HENRY M. HOWETT

ARCHITECT
 STRUCTURAL ENGINEER
 ELECTRICAL ENGINEER
 PLUMBING CONSULTANT

APPROVED BY:

For Murray Lee
 DIRECTOR, DEPARTMENT OF TRANSPORTATION
 STATE OF HAWAII


9/21/73
 DATE

Thingy Kohn
 EXECUTIVE OFFICER, ENVIRONMENTAL HEALTH DIVISION
 STATE OF HAWAII

4-23-73
 DATE

John S. Dunbar acting
 CHIEF DEPUTY FIRE MARSHAL
 STATE OF HAWAII

4-18-73
 DATE

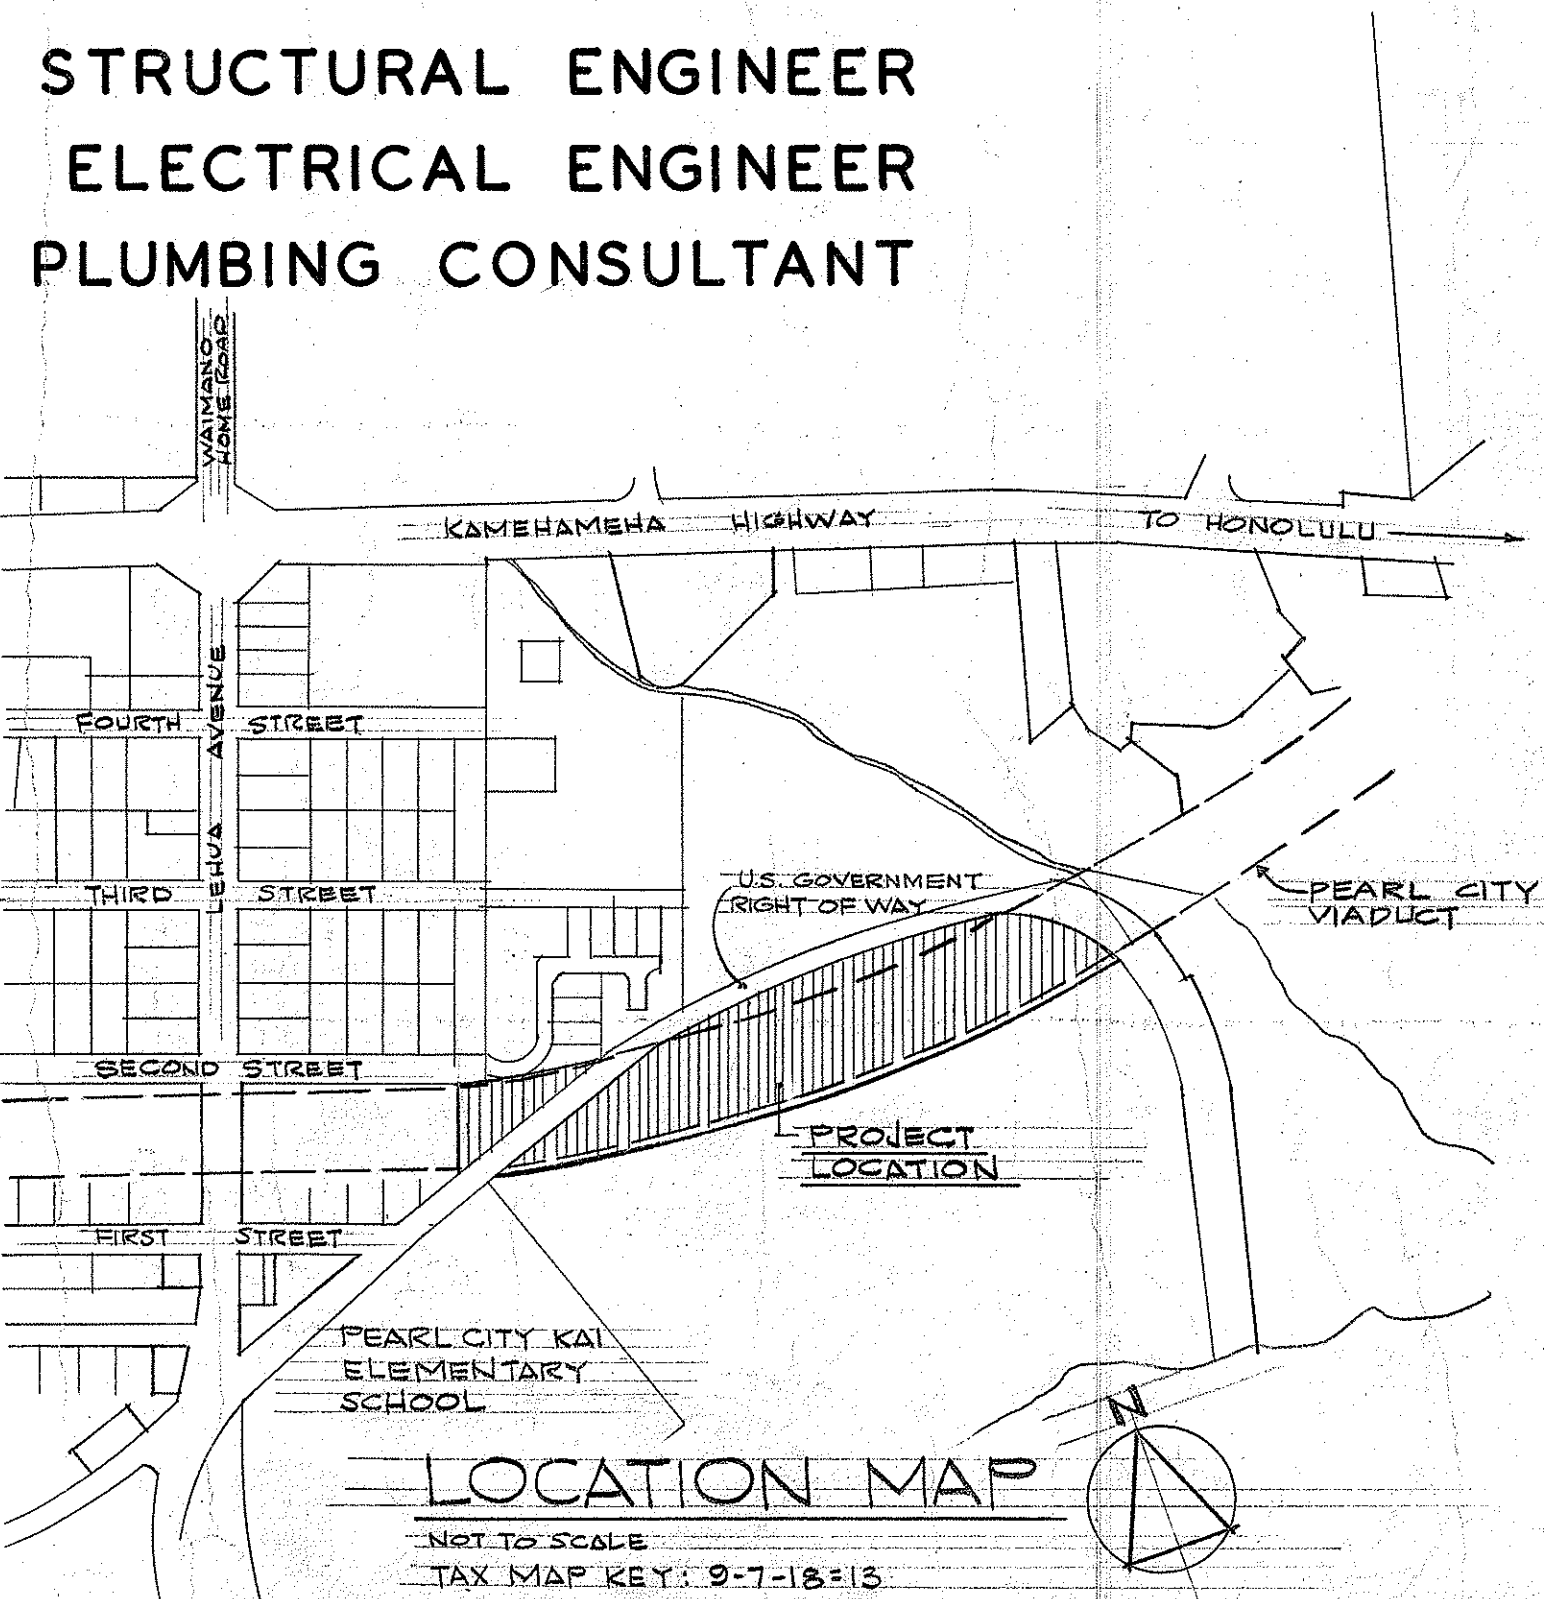

INDEX TO DRAWINGS	
SHT. No.	DESCRIPTION
T-1	TITLE SHEET, LOCATION MAP, & INDEX TO DRAWINGS
C-1	SITE & UTILITY PLAN & DETAILS
C-2	GRADING PLAN & DETAILS
A-1	FLOOR PLAN, EXT. ELEVS., SECTIONS, & ROOM FINISH SCHED.
A-2	ROOF PLAN, SECTIONS, & DETAILS
A-3	INTERIOR ELEVATIONS
A-4	INTERIOR ELEVS., DOOR & WINDOW SCHEDULES, & DETAILS
S-1	FOUNDATION & ROOF FRAMING, PLANS, SECTIONS & DETAILS
P-1	PLUMBING FLOOR PLAN SANITARY & WATER DIAGRAM
E-1	ELECTRICAL SITE PLAN, SYMBOLS
E-2	ELECTRICAL PLAN, ELEVATION, SINGLE LINE DIAGRAM & SCHEDULES

DATE	DATE
DESIGNED BY	DESIGNED BY
TRACED BY	TRACED BY
NOTED BY	NOTED BY
QUANTITIES BY	QUANTITIES BY
REVISIONS	REVISIONS

HERBERT Y. MATSUMURA
 REGISTERED PROFESSIONAL ARCHITECT
 No. 1356
 HAWAII, U.S.A.

STATE OF HAWAII
 DEPARTMENT OF TRANSPORTATION
 HIGHWAYS DIVISION

PEARL CITY BASEYARD

PEARL CITY OAHU, HAWAII

TITLE SHEET, LOCATION MAP,
 & INDEX TO DRAWINGS

HERBERT Y. MATSUMURA & ASSOC., INC.
 271 KAPIOLANI BLVD. HONOLULU, HAWAII

SHEET No. T-1 OF 11 SHEETS

THIS WORK WAS PREPARED BY
 ME OR UNDER MY SUPERVISION.

Herbert Y. Matsumura