


NAME: C.O.ADD. \BASEYARD\13-FLOORING DATE: MAY 10, 1994 TIME: 12:28 PM


FED. ROAD DIST. NO.	STATE	PROJ. NO.	FISCAL YEAR	SHEET NO.	TOTAL SHEETS
HAWAII	HAW.	HWY-0-03-92	1994	13	35

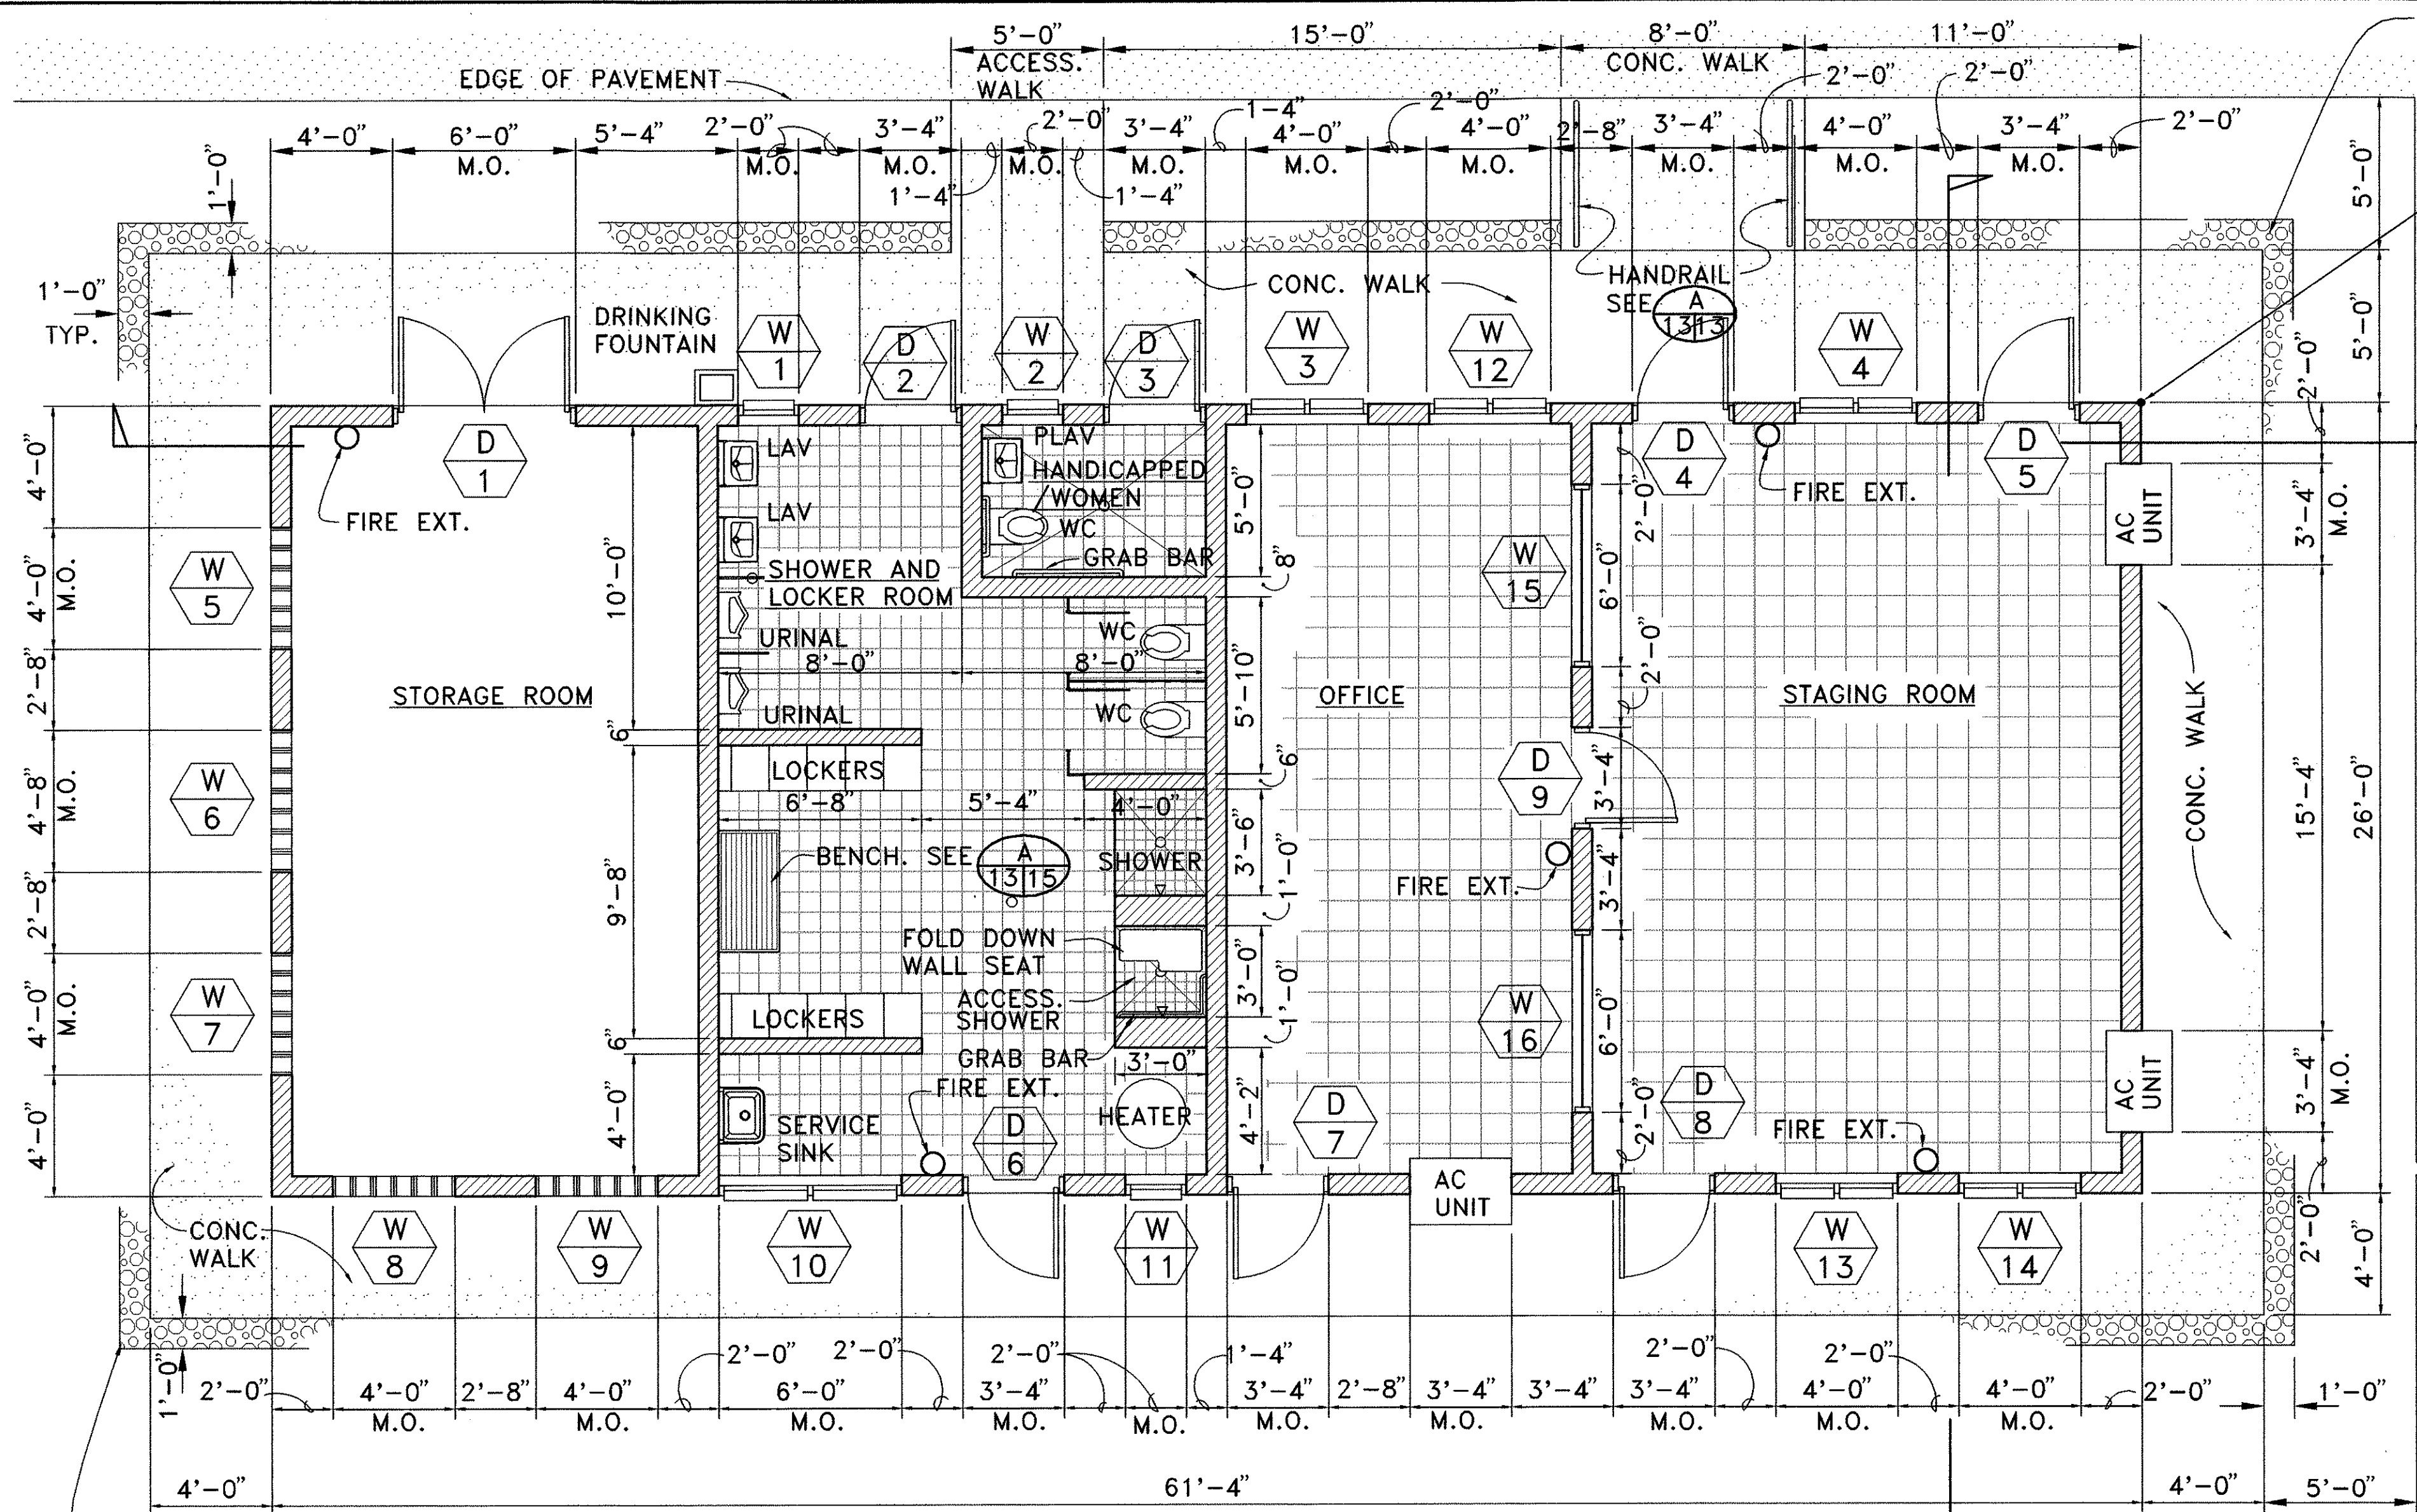

ROOM FINISH SCHEDULE						
	FLOOR	CEILING	WALL	BASE	WNSCT	REMARKS
OFFICE	CONCRETE	VINYL TILE	ACOUSTICAL TILE	EXPOSED CONC.	CMU	
SHOWER/LOCKER ROOM	CONCRETE	VINYL TILE	ACOUSTICAL TILE	EXPOSED CONC.	CMU	
WOMEN'S/HANDICAPPED	CONCRETE	VINYL TILE	ACOUSTICAL TILE	EXPOSED CONC.	CMU	
STAGING ROOM	CONCRETE	VINYL TILE	ACOUSTICAL TILE	EXPOSED CONC.	CMU	
STORAGE	CONCRETE	VINYL TILE	ACOUSTICAL TILE	EXPOSED CONC.	CMU	


OIN DESIGNATED AREAS ONLY.

1/4" N.D.
SCHEDULE 40
PIPE RAILING.
GALVANIZE AFTER
FABRICATION.

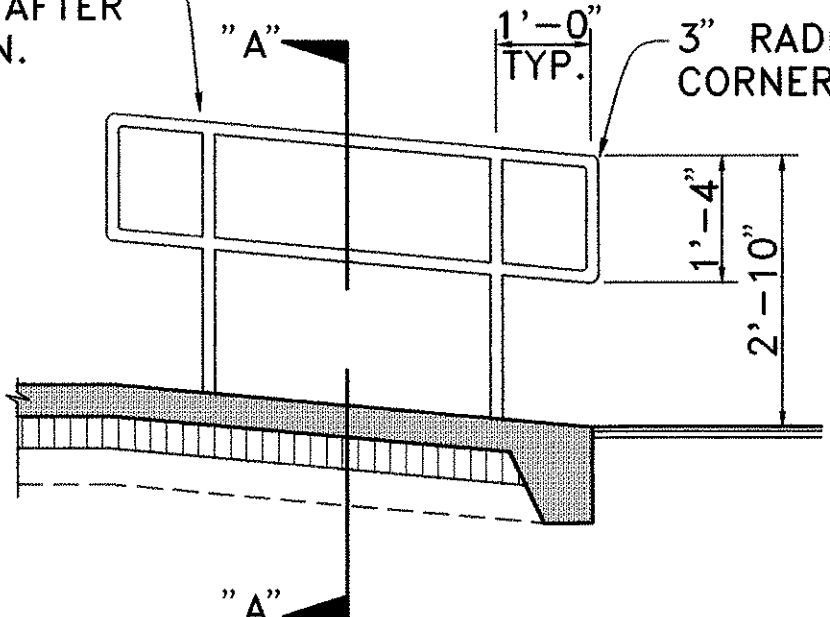

NOTE:
PAINT ALL FIELD
WELDS AND ANY
DAMAGED GALVANIZED
SURFACES WITH
2-COATS OF ZRC
COLD GALVANIZING
COMPOUND.

SECTION "A-A"

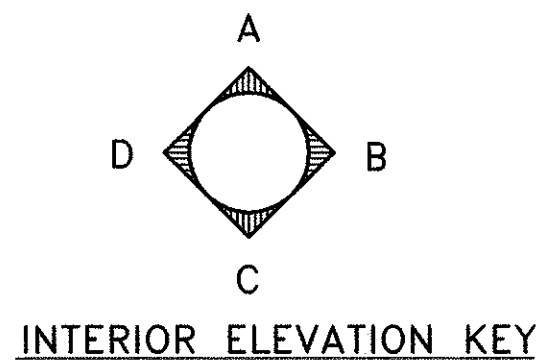

DETAIL
SCALE: 1/2" = 1'-0"





A
1313

BASE COURSE
ALL AROUND
CONC. WALK


NOTE: SEE PLUMBING PLAN FOR LOCATION
OF FLOOR DRAINS.

PLAN OF ADMINISTRATION BUILDING

SCALE: 1/4" = 1' 0"

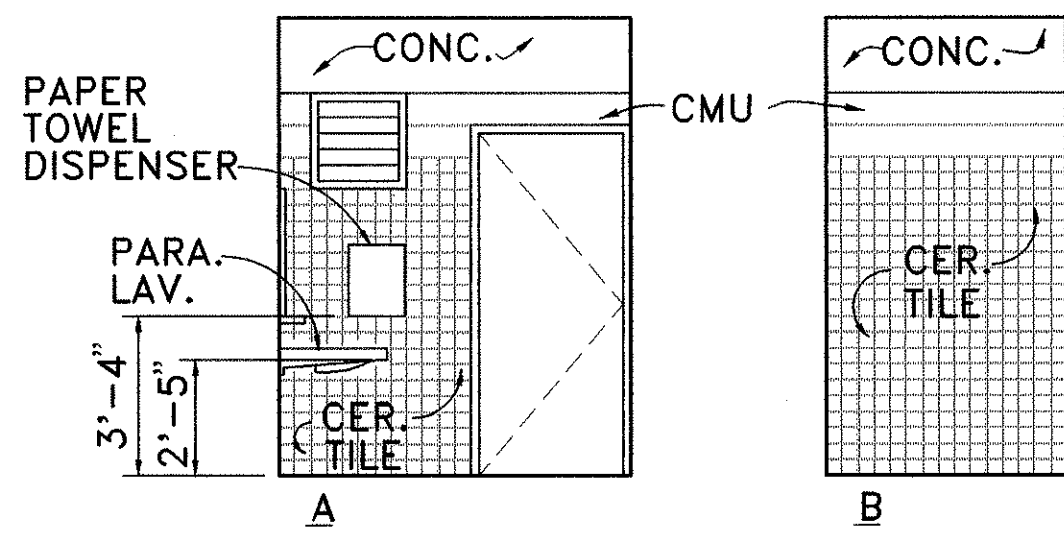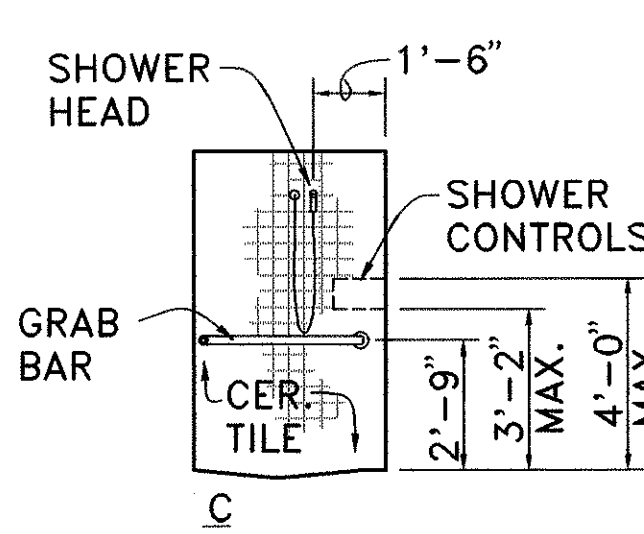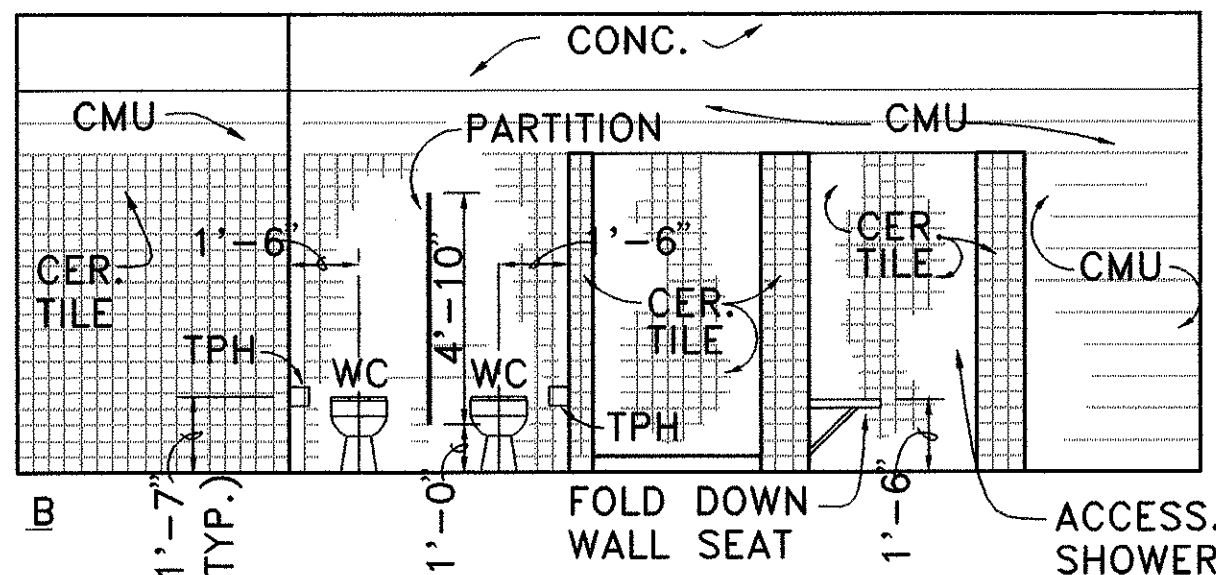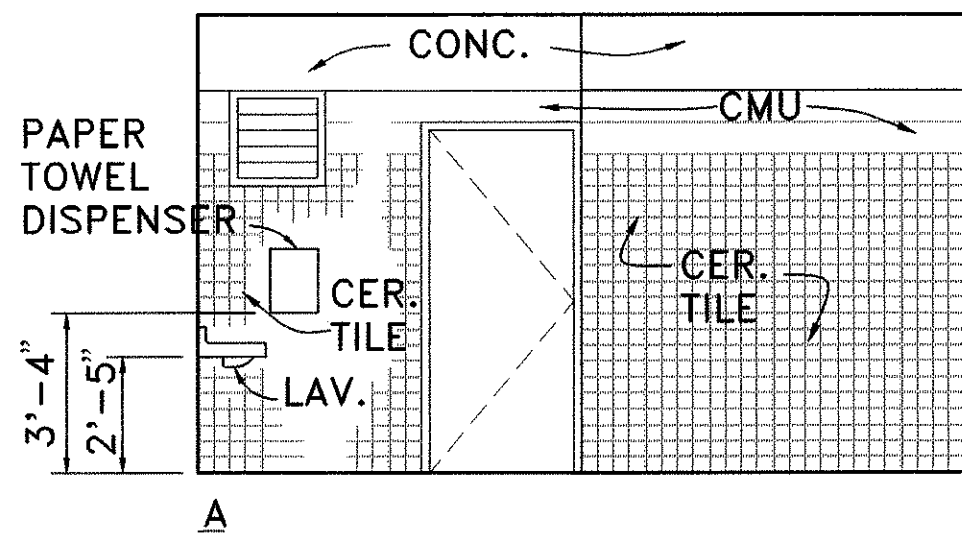


ACCESSIBLE SHOWER

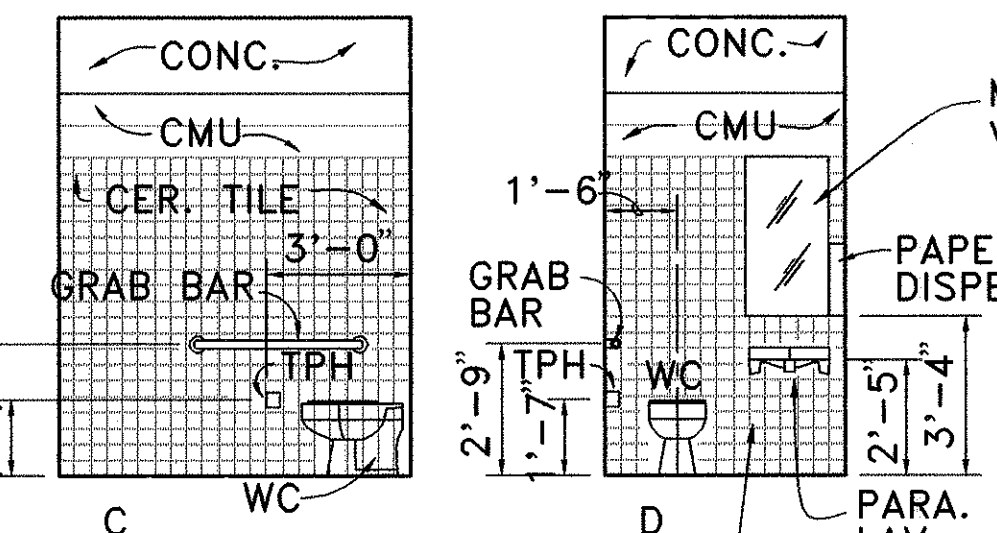


HANDICAPPED/WOMEN


(VIEW A SIM. OPP. HAND)

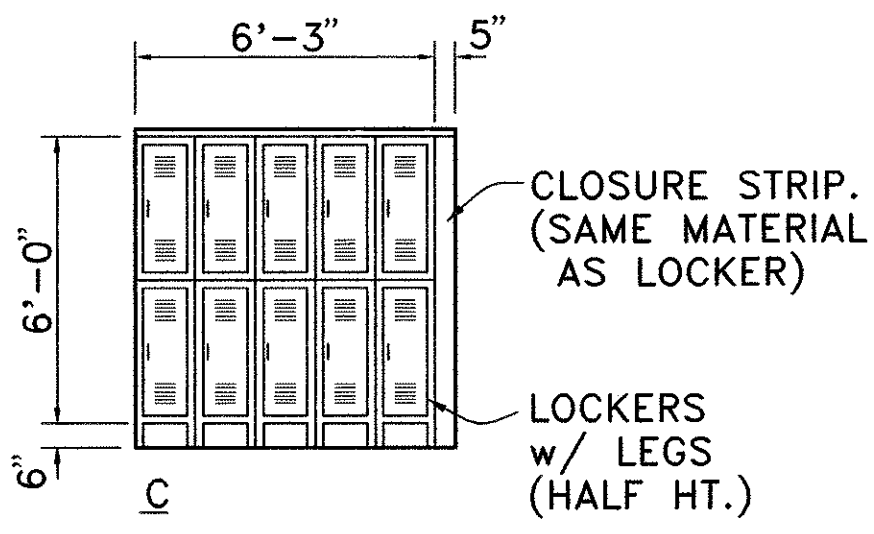


AT LOCKERS

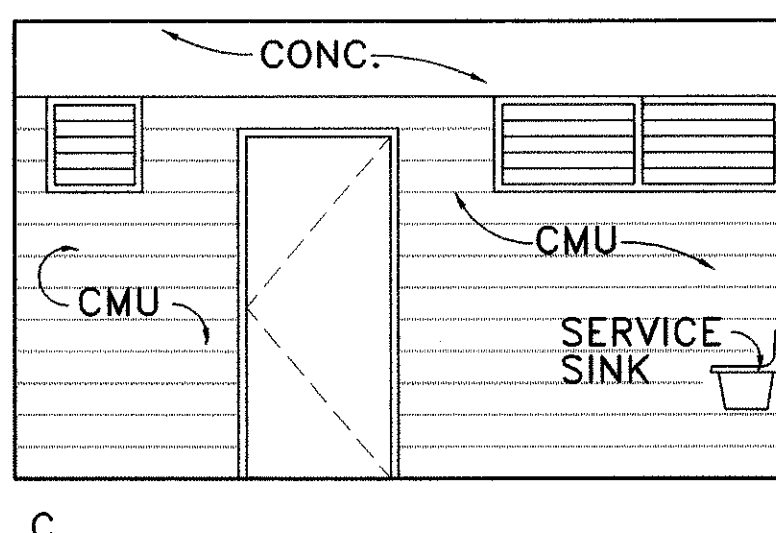

SHOWER/LOCKER ROOM

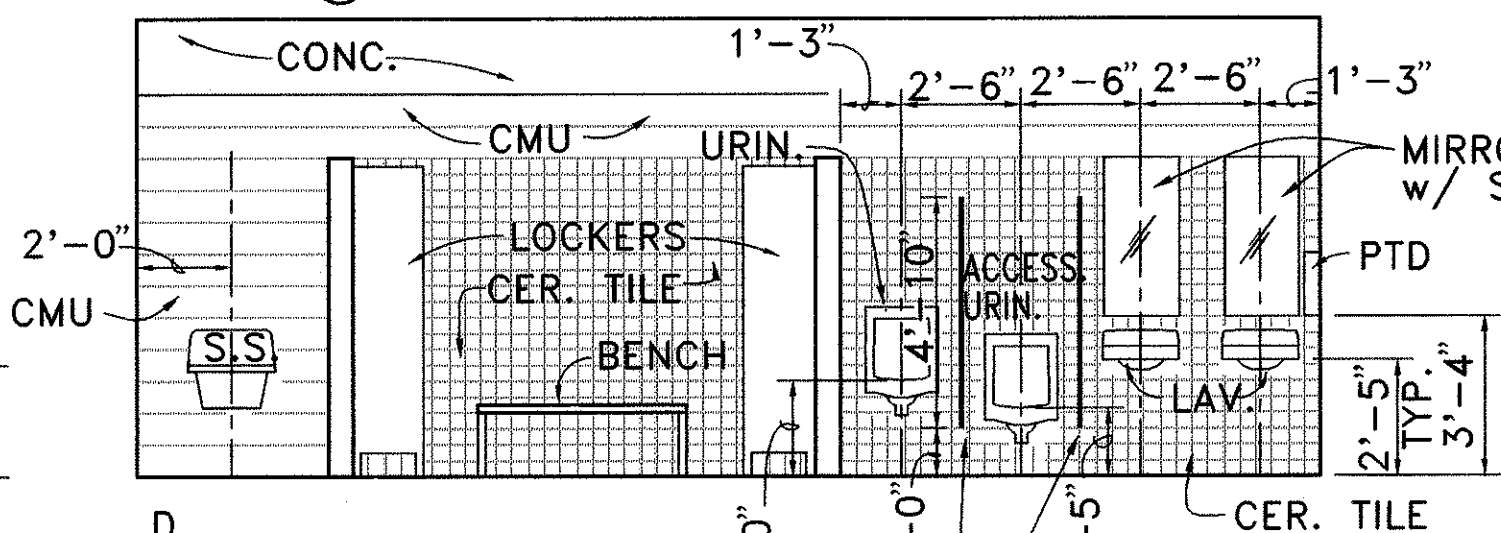

DATE	REVISION
9/15/94	REVISED SHOWER STALLS. REVISED DOOR SWINGS FOR D/2, D/3 D/7 & D/8. ADDED HANDRAIL DETAIL.
6/17/94	ADDED CERAMIC TILE WAINSCOT TO SHOWER/LOCKER & HANDICAP/WOMEN ROOMS. ADDED ADDITIONAL FIRE EXTINGUISHERS.

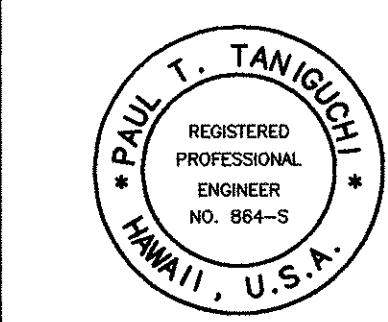

STATE OF HAWAII
DEPARTMENT OF TRANSPORTATION
HIGHWAYS DIVISION

FLOOR PLAN, ELEVATIONS ROOM FINISH SCHEDULE

KANE OHE BASE YARD, PHASE II

ADMINISTRATION BUILDING

PROJECT NO. HWY-0-03-92

SCALE: AS NOTED DATE: 4/15/94


SHEET NO. 13 OF 35 SHEETS

C.O.ADD. 13


DATE	_____
SURVEY PLOTTED BY	_____
DRAWN BY	_____
DESIGNED BY	_____
CHECKED BY	_____
ORIGINAL PLAN	_____
NOTE BOOK	_____
NO.	_____

NAME: C:\CD\11\BASEYARD\14-BSECTION.DWG DATE: MAY 18, 1994 TIME: 12:44 PM


FED. ROAD DIST. NO.	STATE	PROJ. NO.	FISCAL YEAR	SHEET NO.	TOTAL SHEETS
HAWAII	HAW.	HWY-0-03-92	1994	14	35

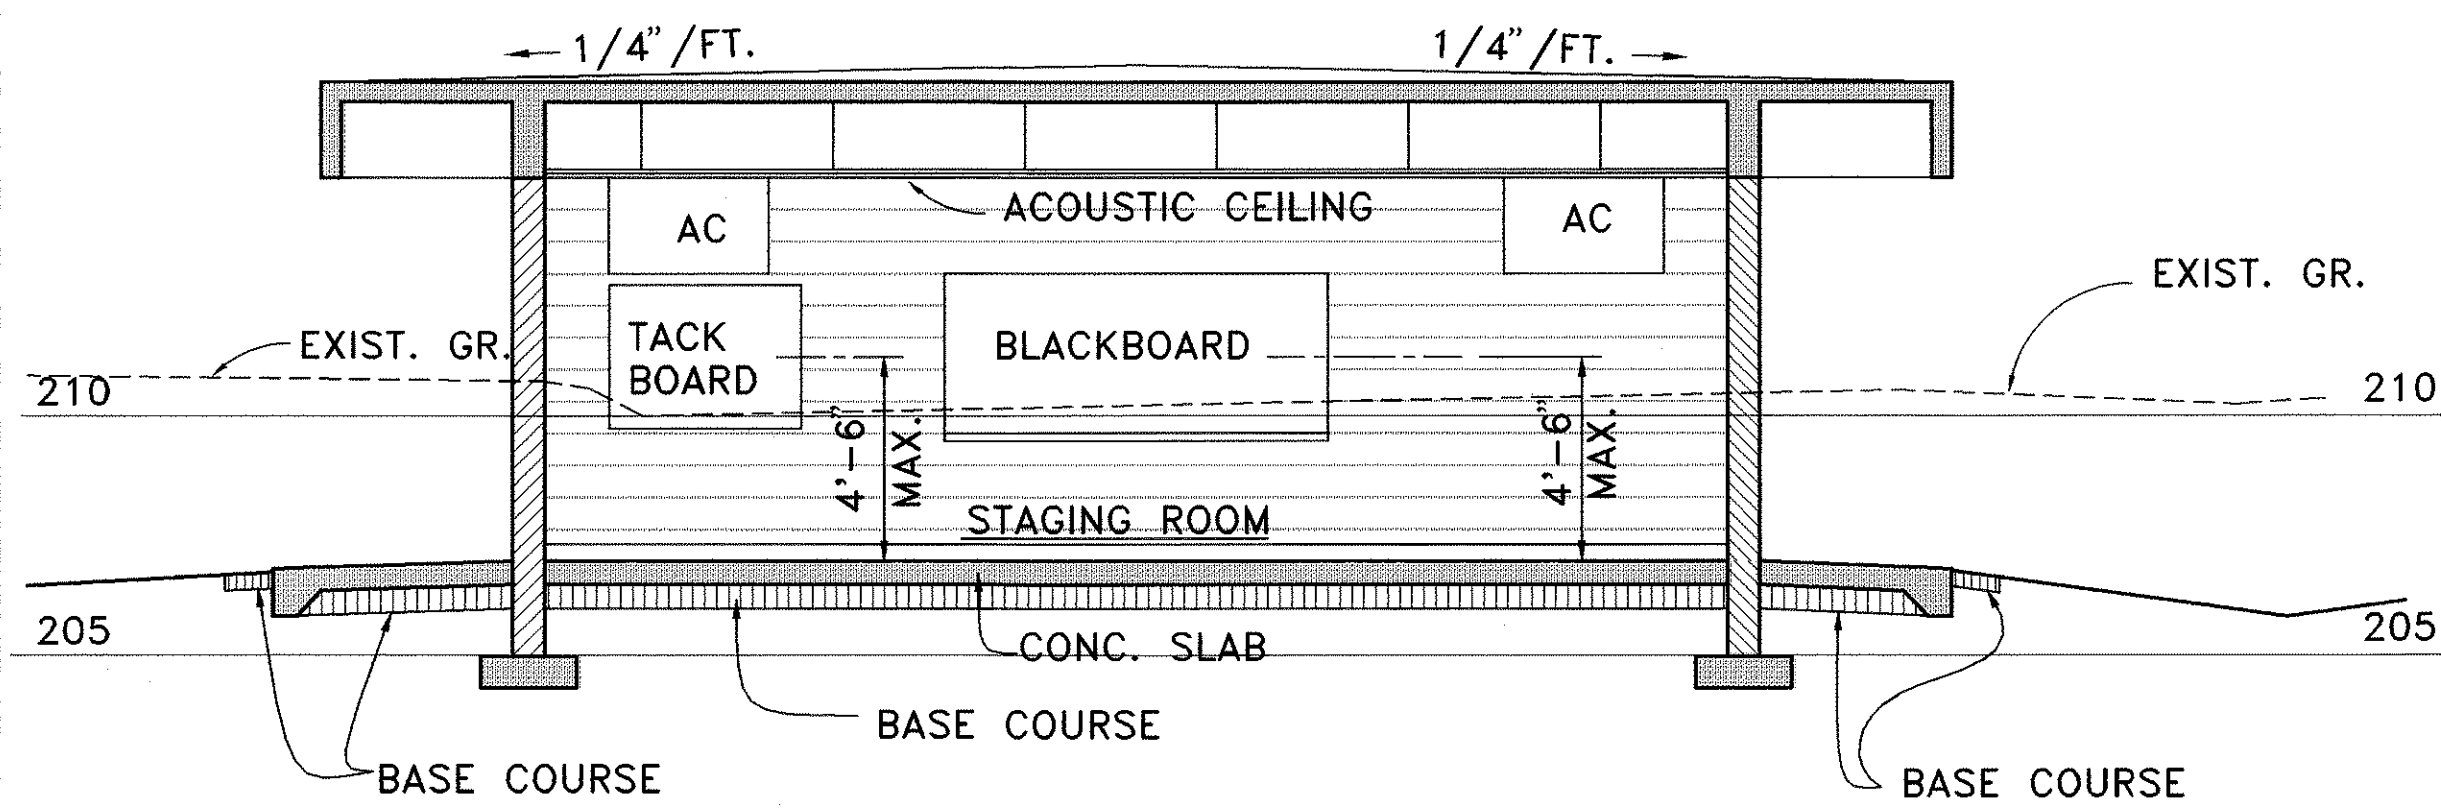


TRANSVERSE SECTION THROUGH ADMINISTRATION BUILDING A
SCALE: 1/4" = 1' 0"

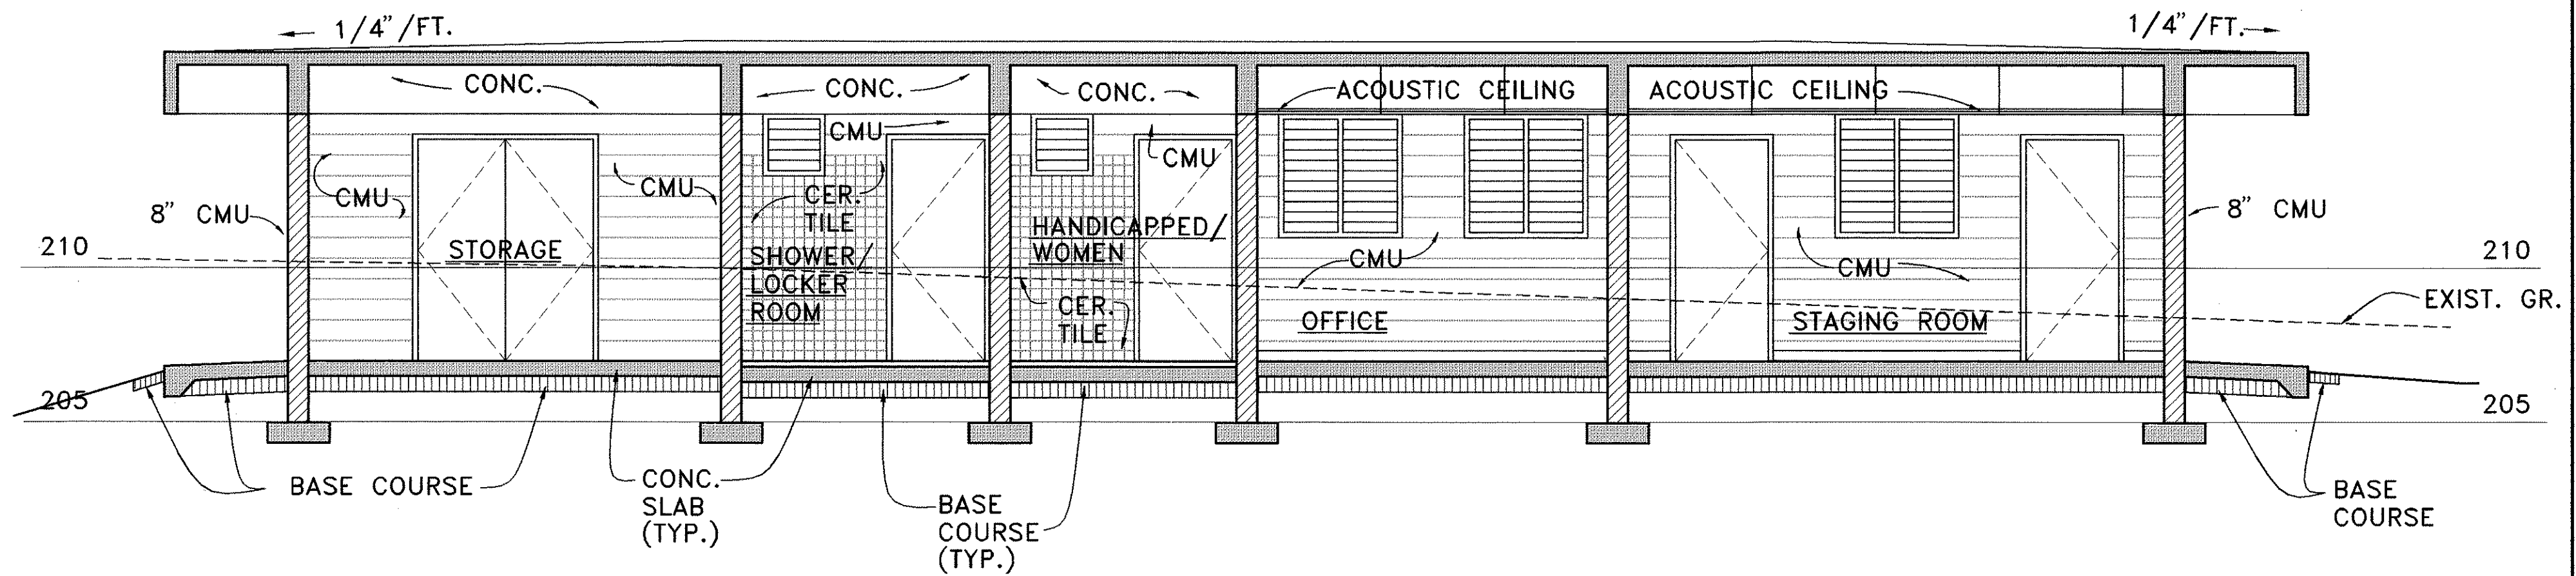

LONGITUDINAL SECTION THROUGH ADMINISTRATION BUILDING B
SCALE: 1/4" = 1' 0"

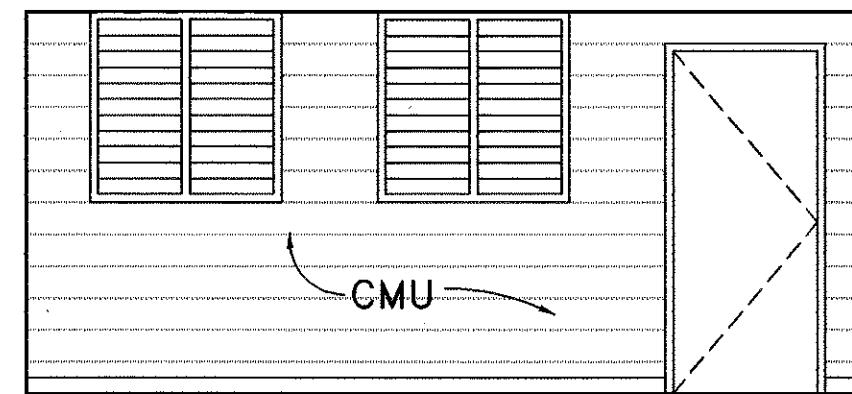


C

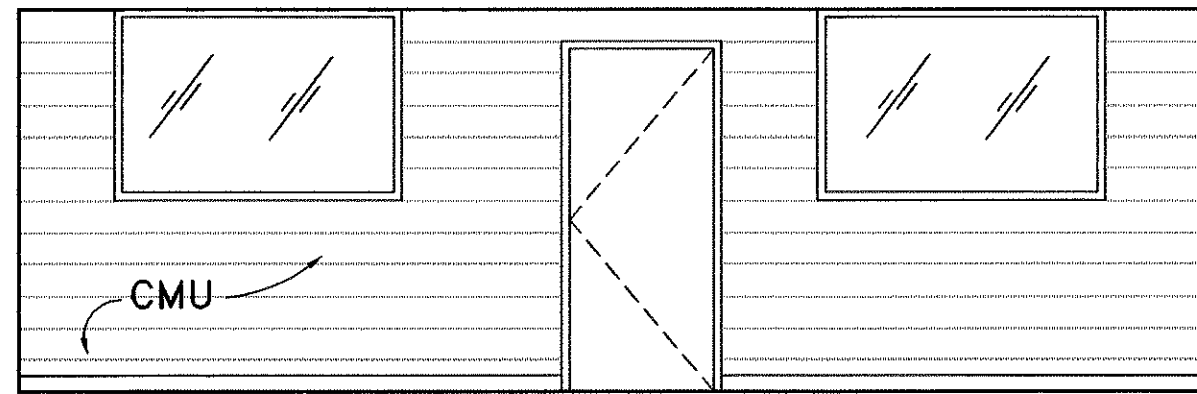


D


STAGING ROOM

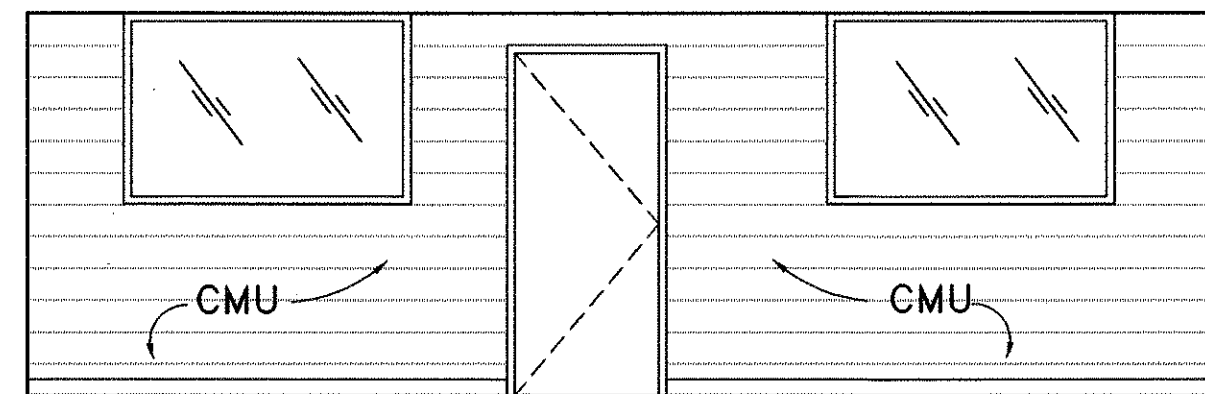

B

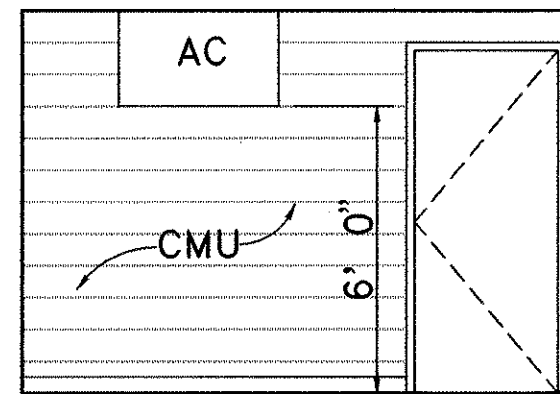


C

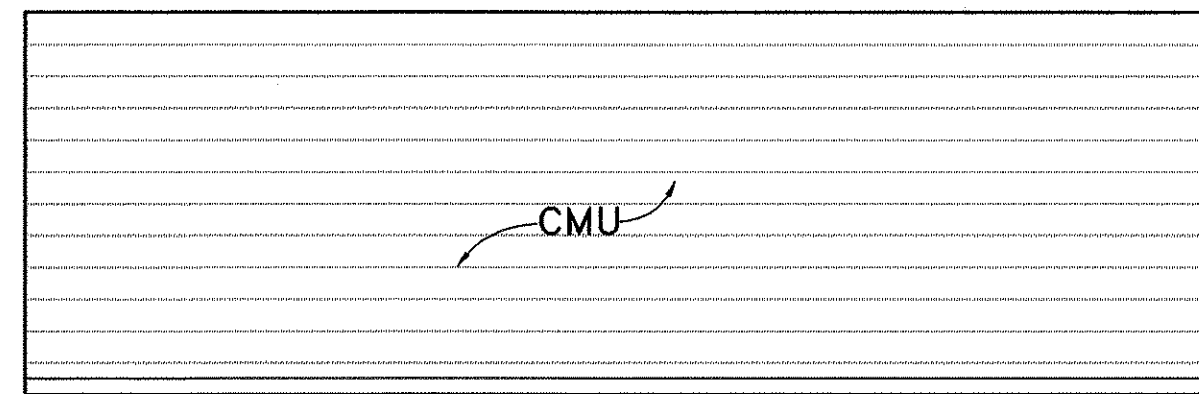


D


OFFICE

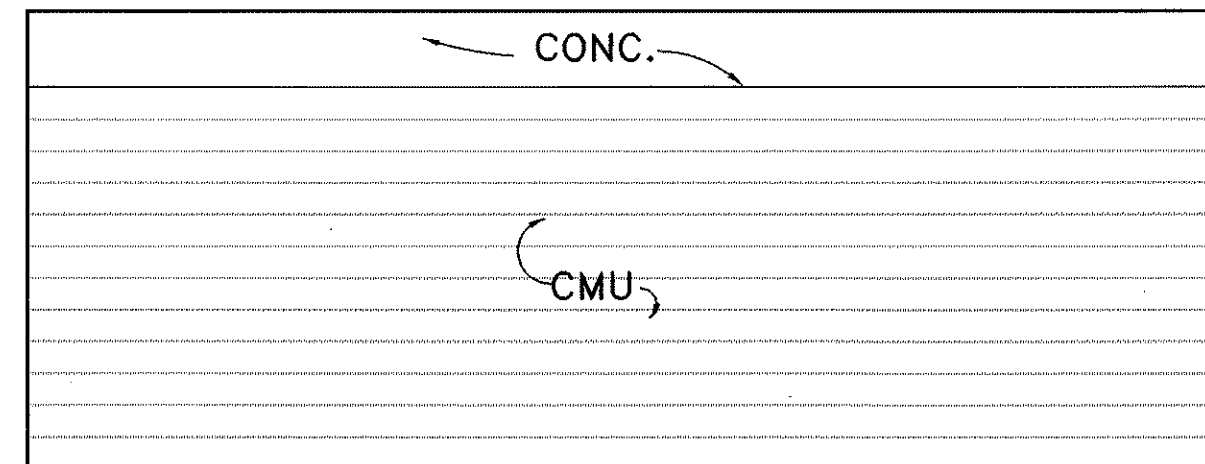

B

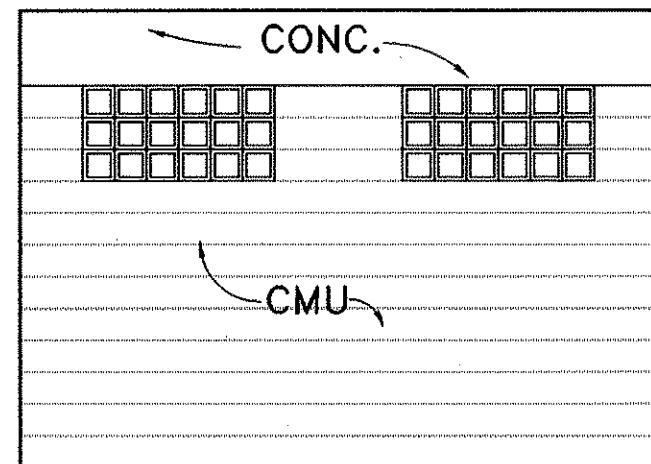

C

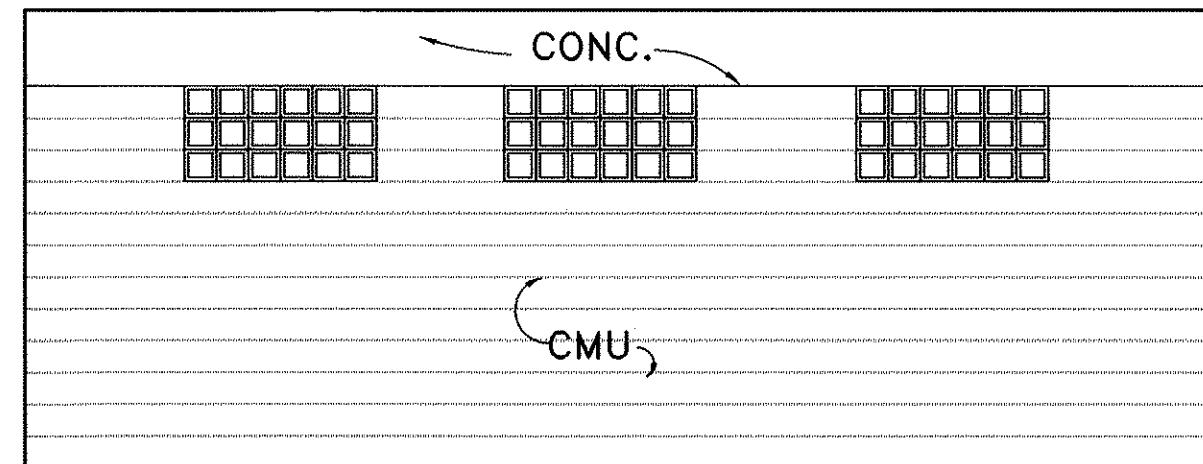

D

STORAGE

6/17/94	REVISED SECTION A/14. ADDED CERAMIC TILE WAINSCOT TO SHOWER/LOCKER & HANDICAPPED/ WOMEN'S ROOMS.
---------	---

DATE REVISION

STATE OF HAWAII
DEPARTMENT OF TRANSPORTATION
HIGHWAYS DIVISION

SECTIONS, ELEVATIONS

KANEHOE BASE YARD, PHASE II


ADMINISTRATION BUILDING

PROJECT NO. HWY-0-03-92

SCALE: AS NOTED


DATE: 4/15/94

SHEET NO. 14 OF 35 SHEETS

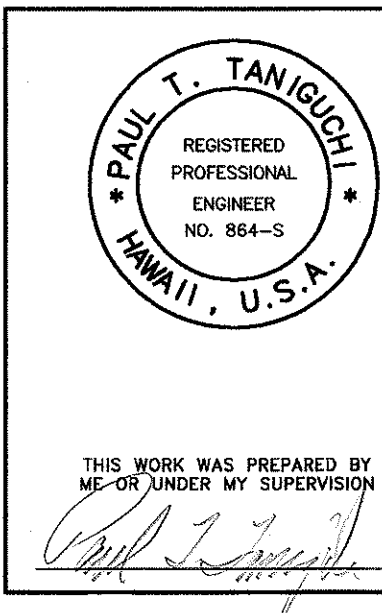


NAME: C:\CADD\1\BASE\WYD\15-ELEV.DWG DATE: MAY 18, 1994 TIME: 2:20 PM

FED. ROAD DIST. NO.	STATE	PROJ. NO.	FISCAL YEAR	SHEET NO.	TOTAL SHEETS
HAWAII	HAW.	HWY-0-03-92	1994	15	35

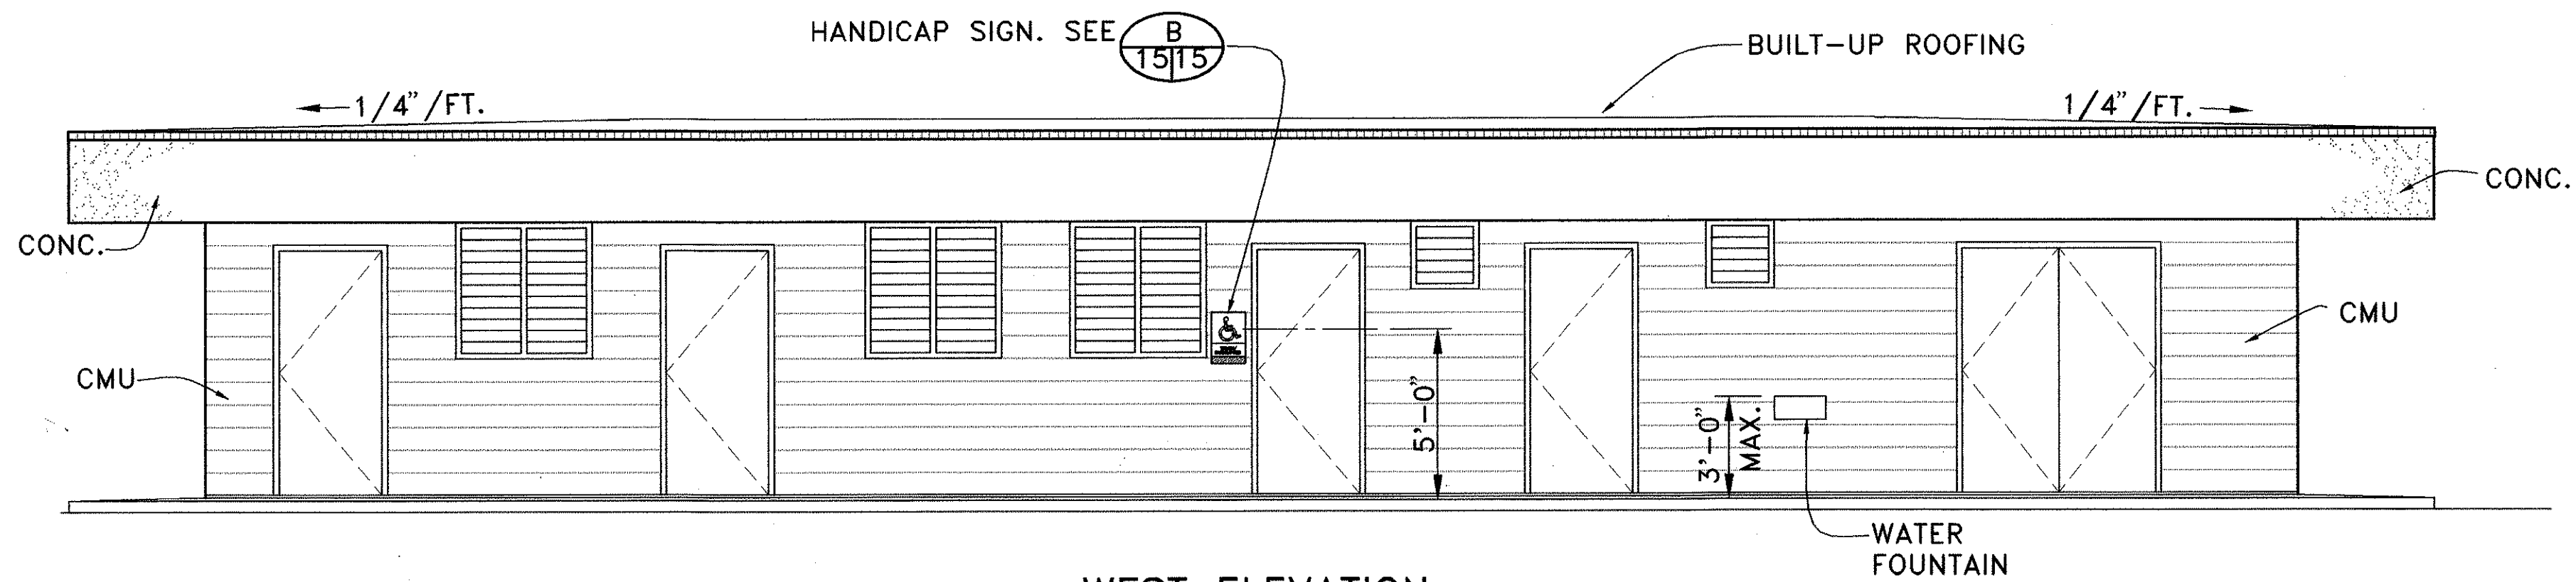


WEST ELEVATION

SCALE: 1/4" = 1' 0"

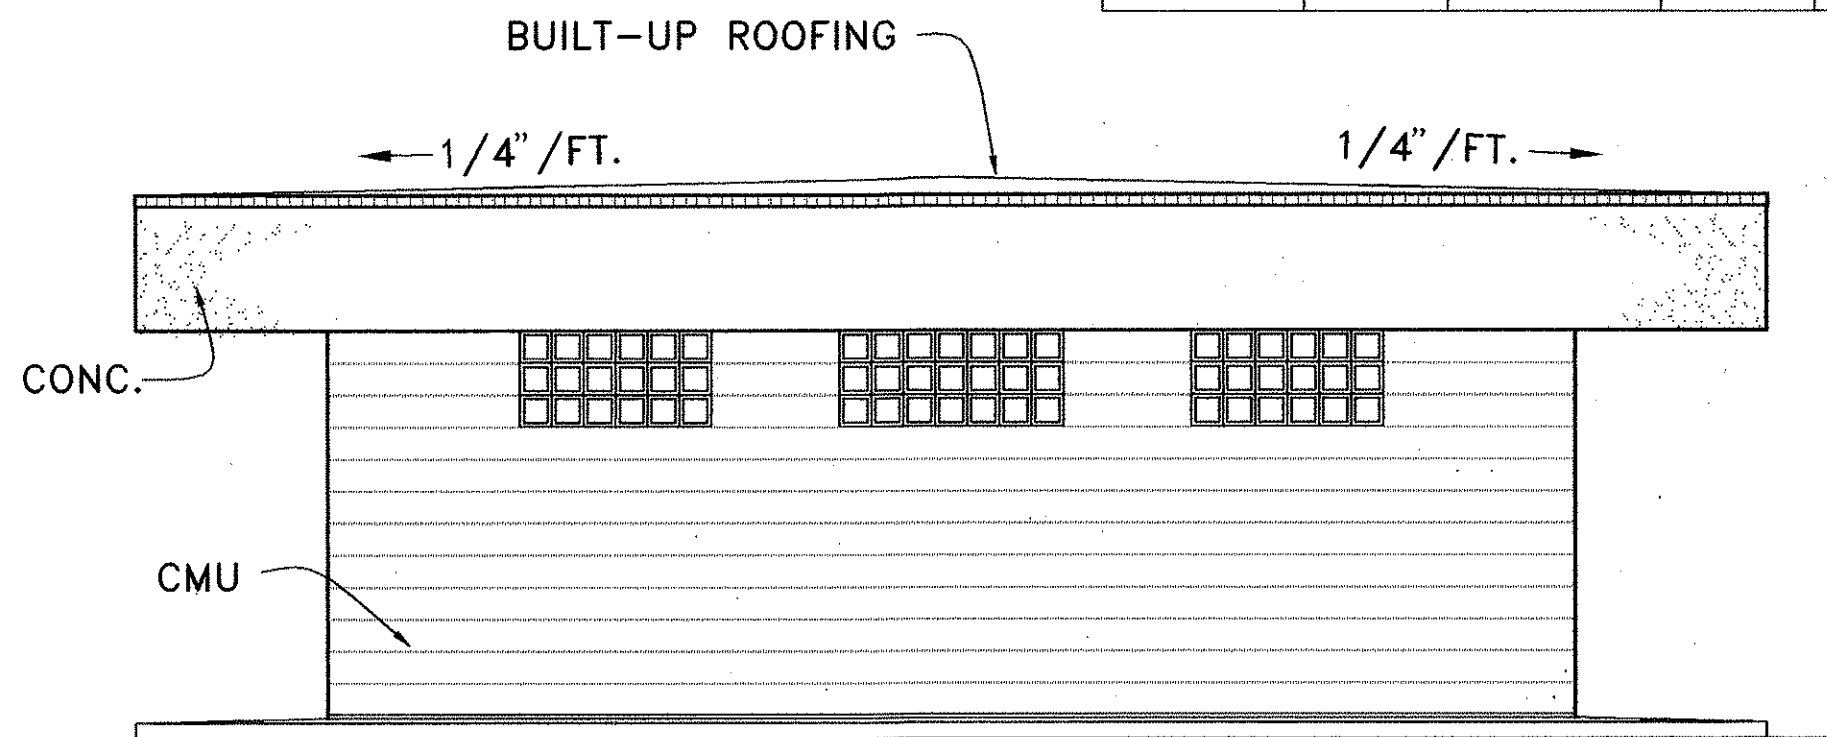


SOUTH ELEVATION

SCALE: 1/4" = 1' 0"

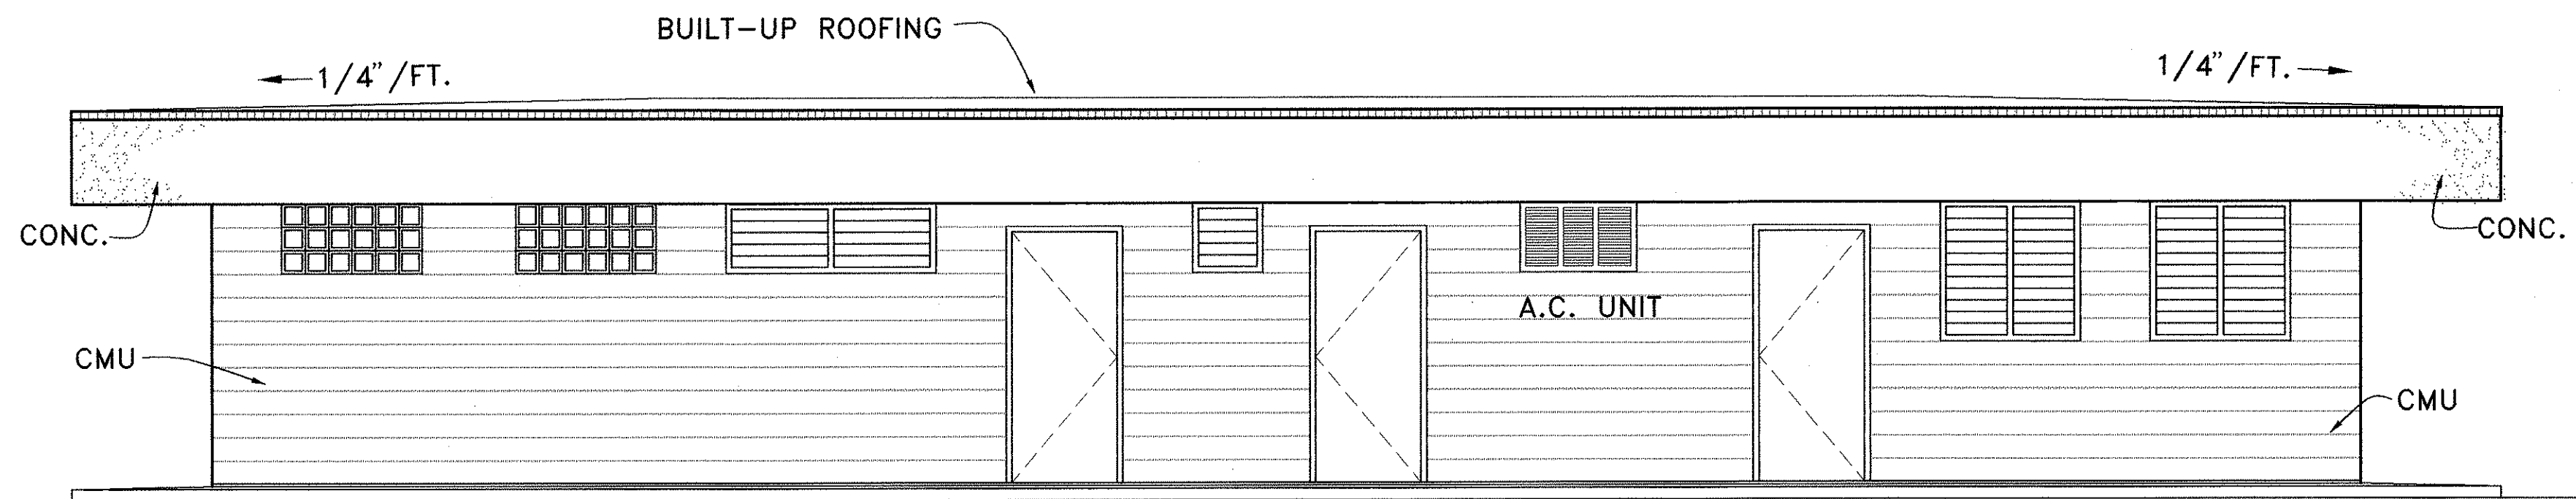


EAST ELEVATION

SCALE: 1/4" = 1' 0"

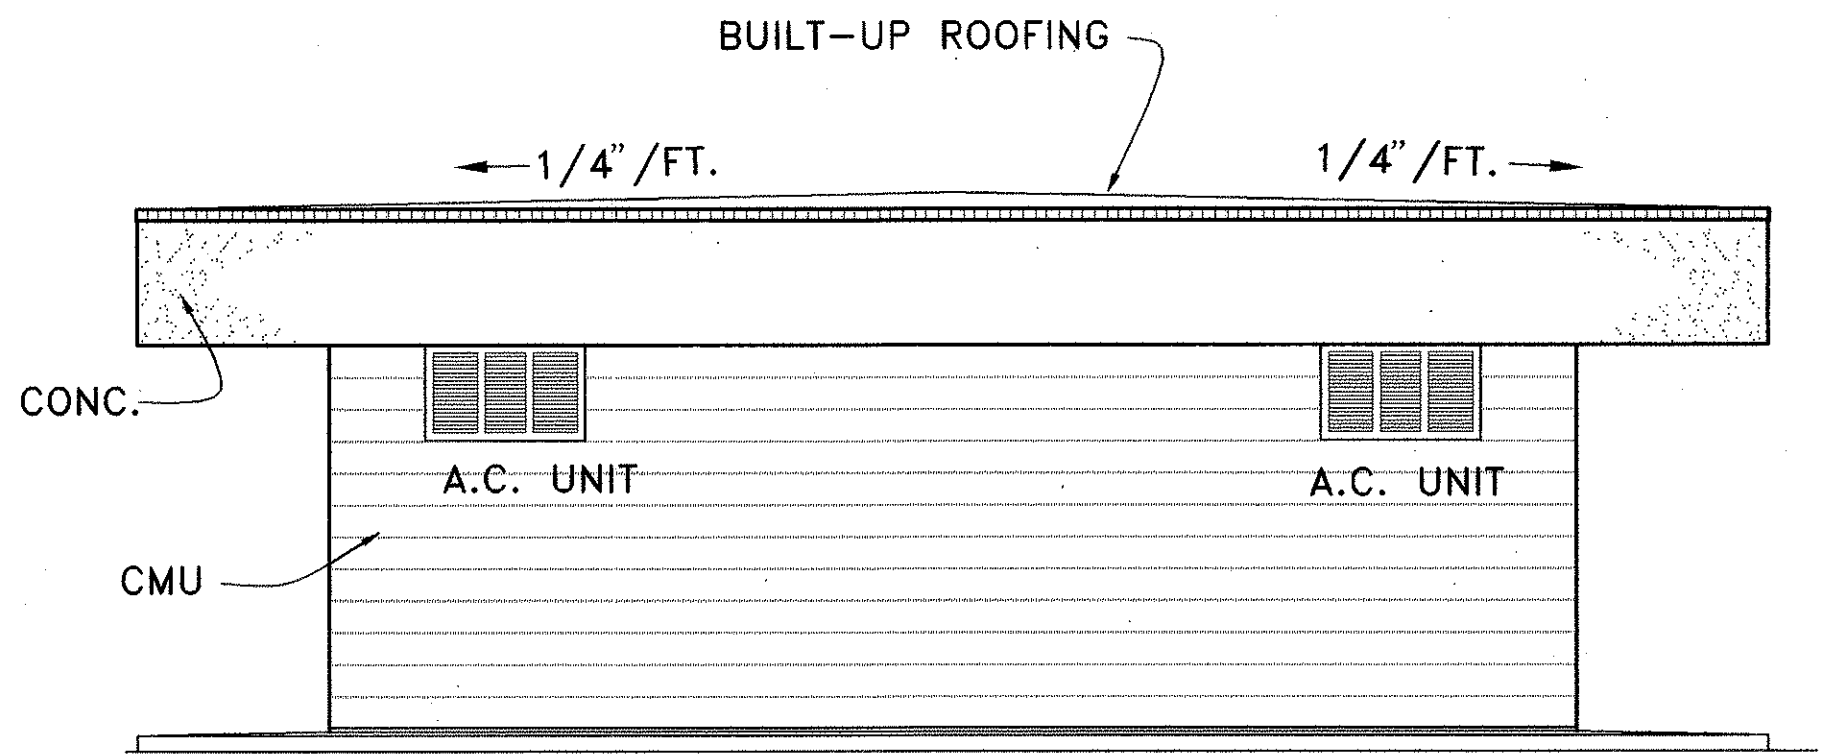


NORTH ELEVATION


SCALE: 1/4" = 1' 0"

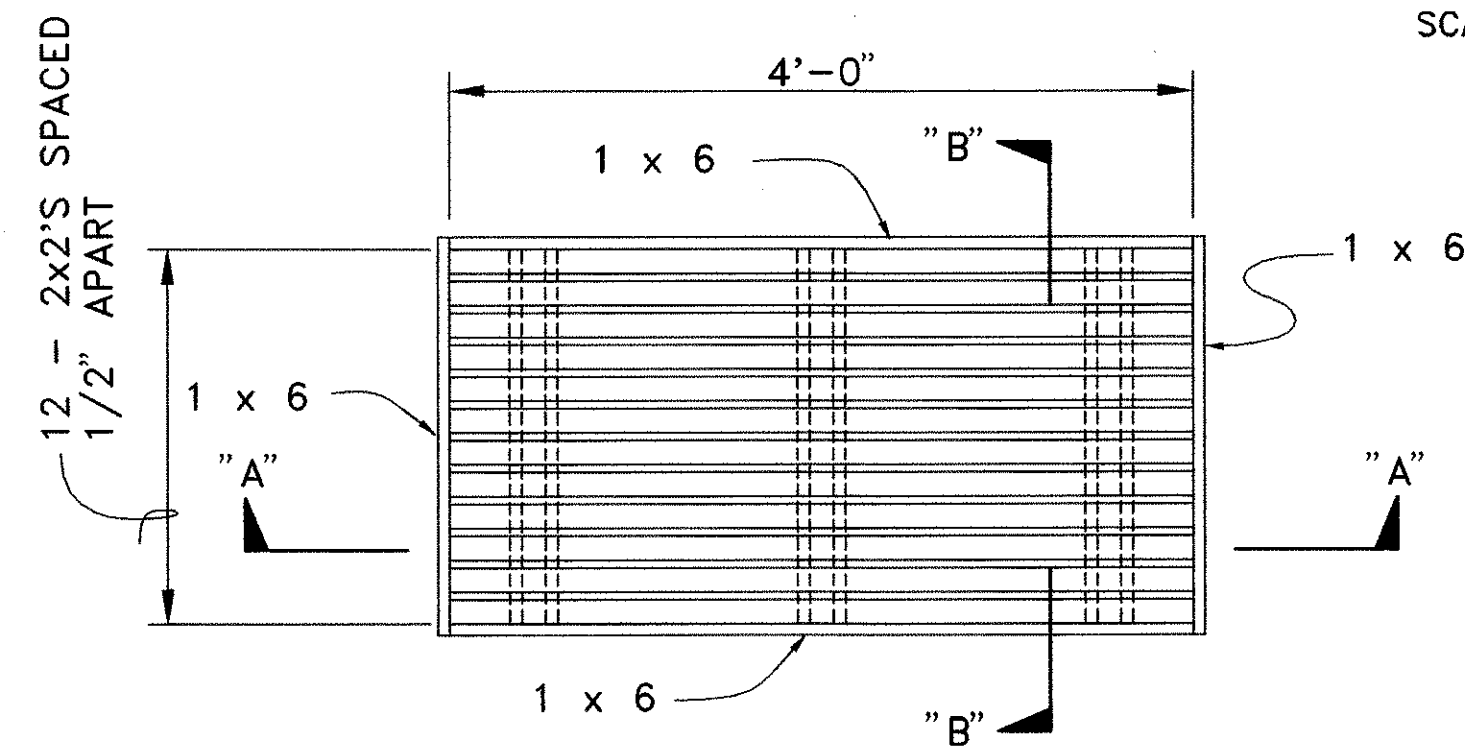

PLAN

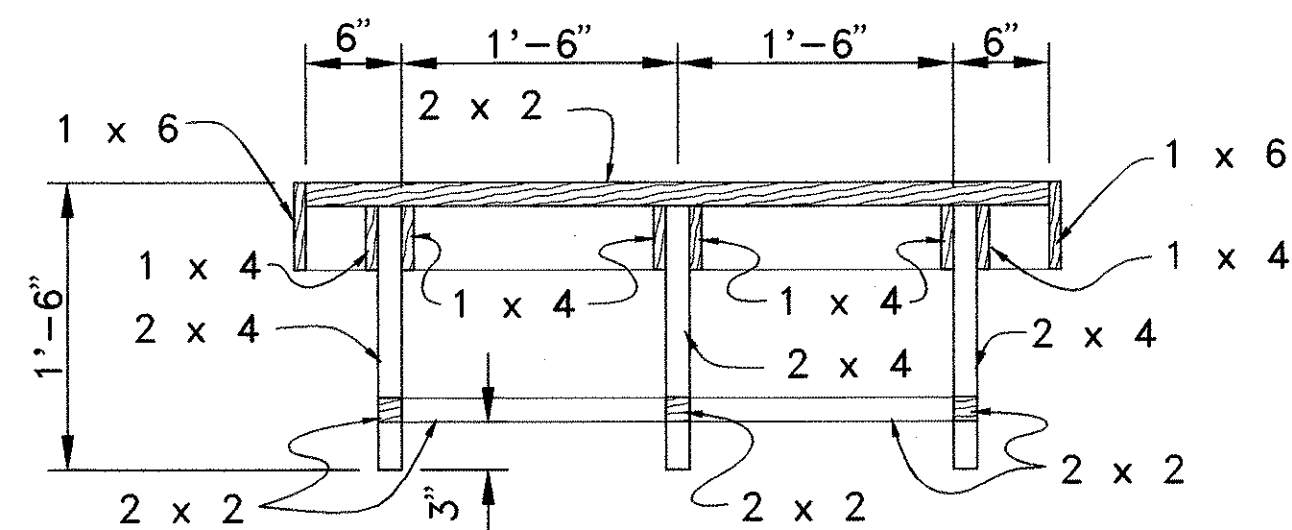

SECTION "A-A"

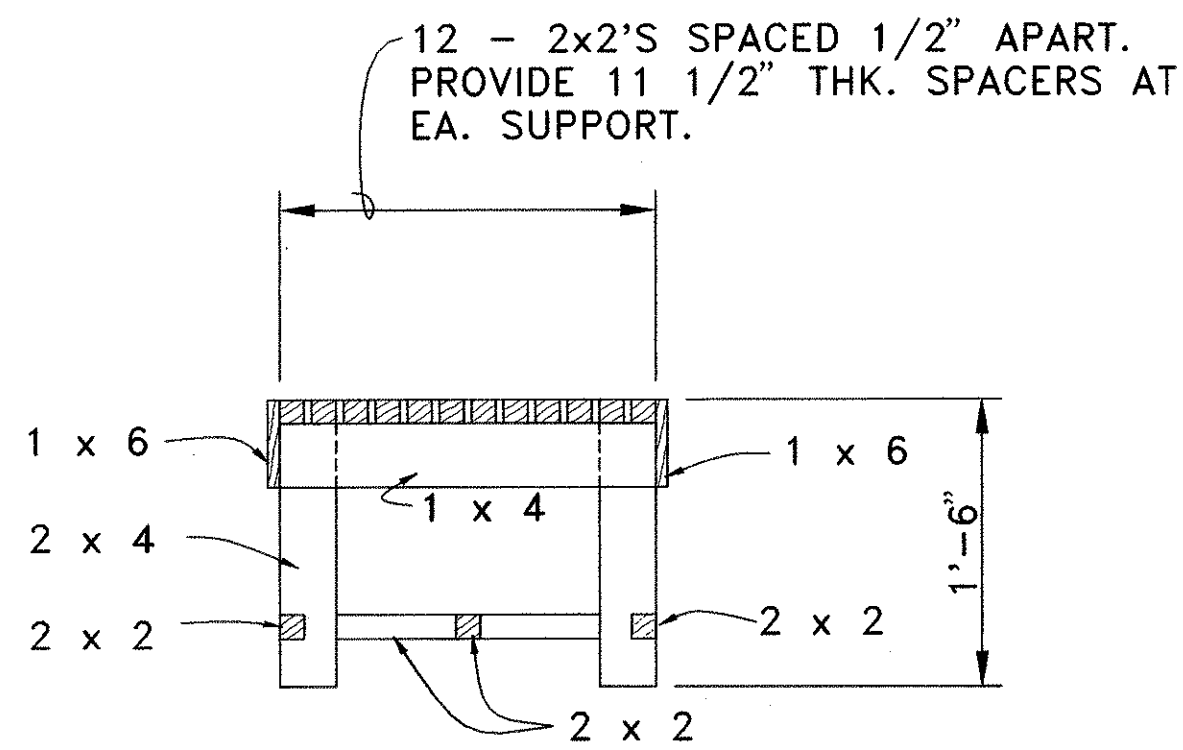


SECTION "B-B"

BENCH DETAILS

SCALE: 1" = 1'-0"

A
13/15

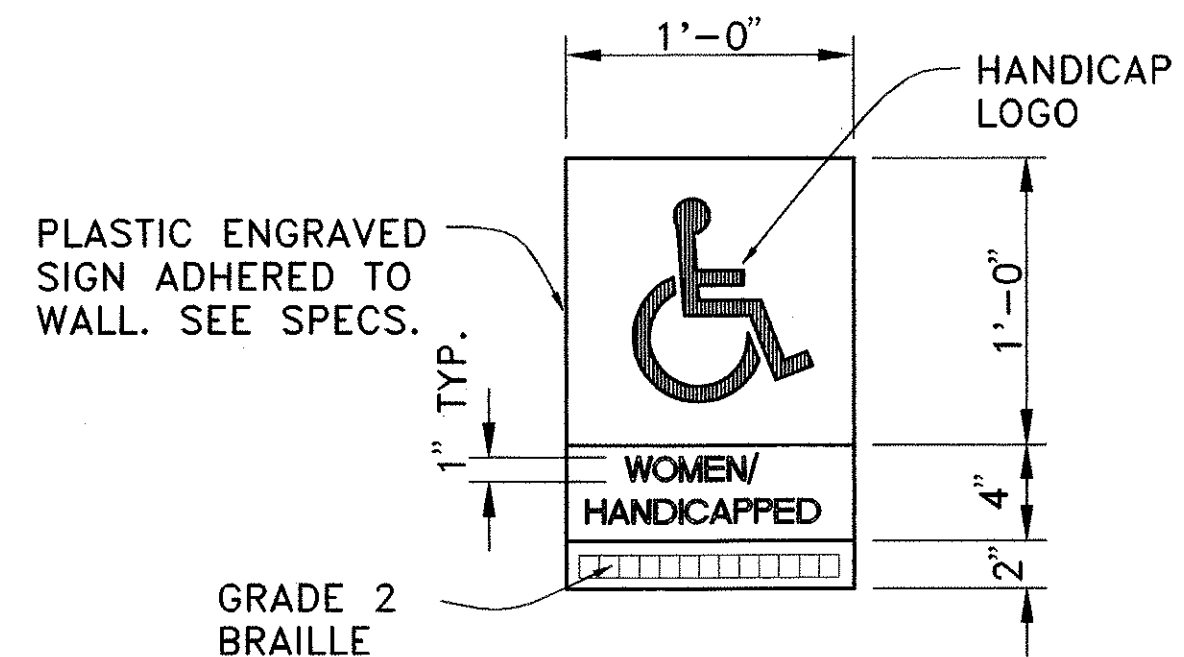


HANDICAP SIGN DETAIL

NO TO SCALE

B
15/15


NOTE: ALL CHARACTERS SHALL BE RAISED 1/32".

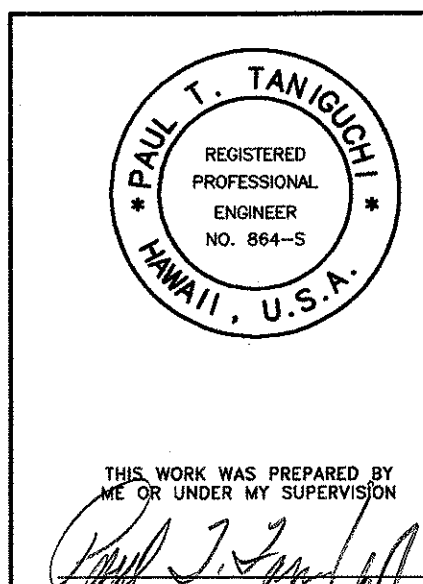

9/15/94	REVISED HANDICAPPED SIGN. REVISED DRINKING FOUNTAIN. REVISED DOOR SWINGS.
DATE	REVISION
STATE OF HAWAII DEPARTMENT OF TRANSPORTATION HIGHWAYS DIVISION	
EXTERIOR ELEVATIONS	
KANEIHOE BASE YARD, PHASE II	
ADMINISTRATION BUILDING	
PROJECT NO. HWY-0-03-92	
SCALE: AS NOTED	DATE: 4/15/94
SHEET NO. 15 OF 35 SHEETS	


NAME: C:\ADD\16\BASEYARD\16-WALL.DWG DATE: MAY 16, 1994 TIME: 2:49 PM

FED. ROAD DIST. NO.	STATE	PROJ. NO.	FISCAL YEAR	SHEET NO.	TOTAL SHEETS
HAWAII	HAW.	HWY-0-03-92	1994	16	35

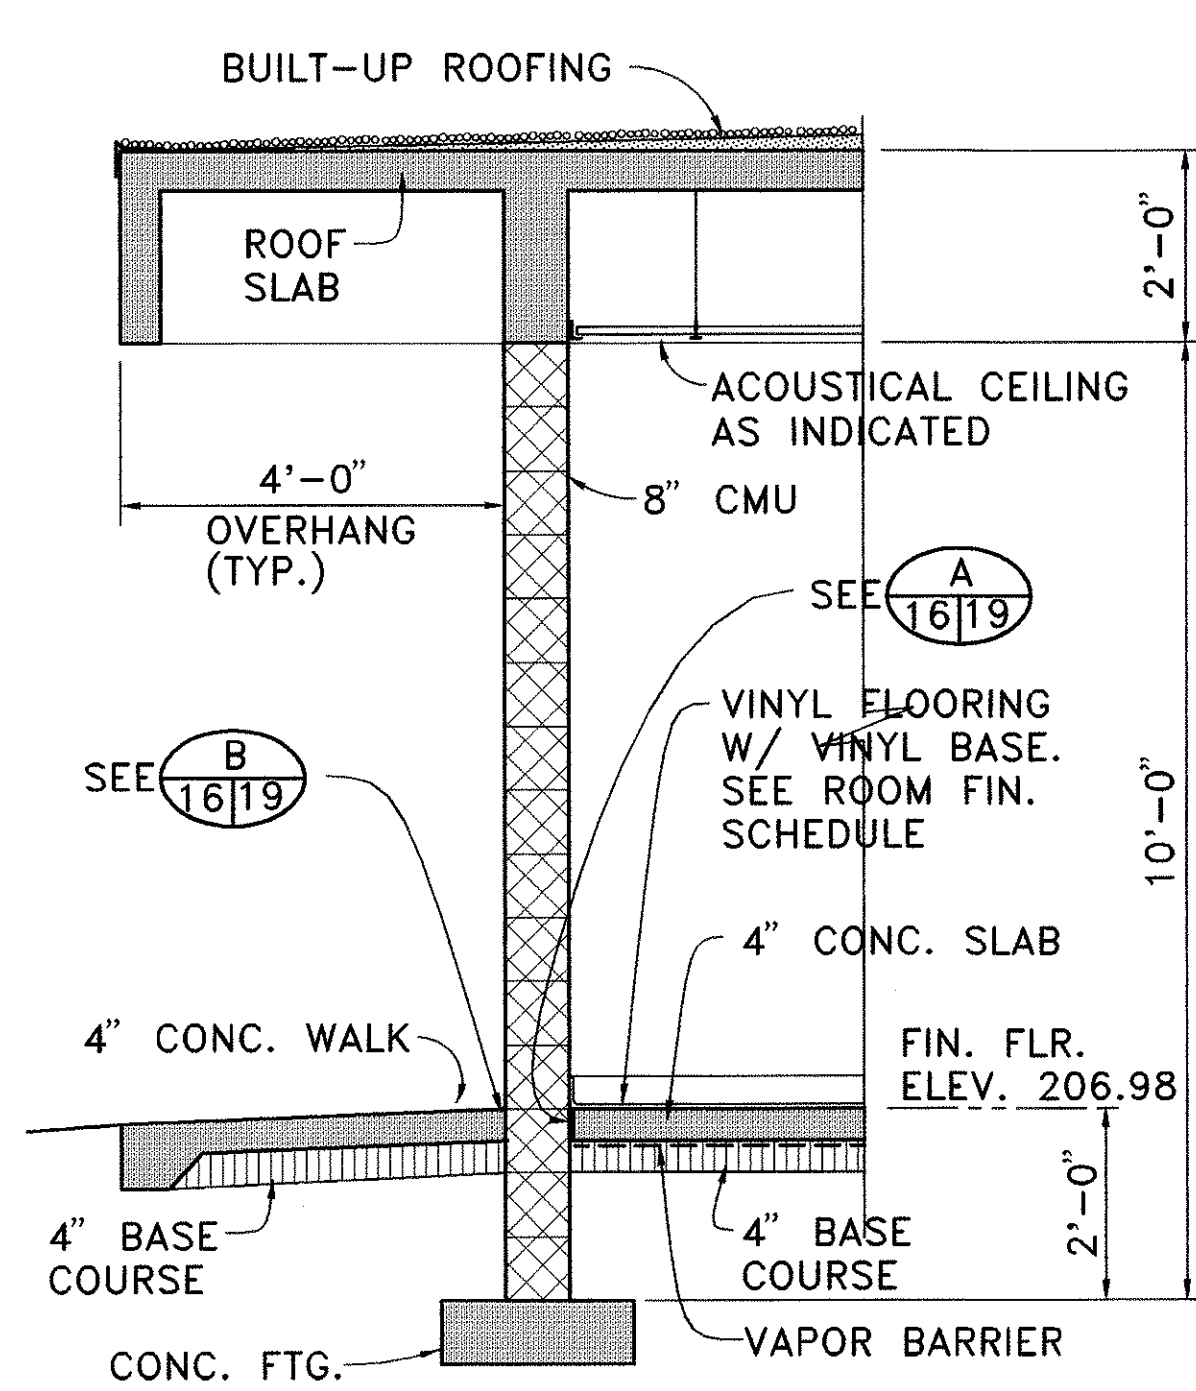


TYPICAL EXTERIOR WALL

SECTION **A**
SCALE: 1/2"=1'-0" **16/16**

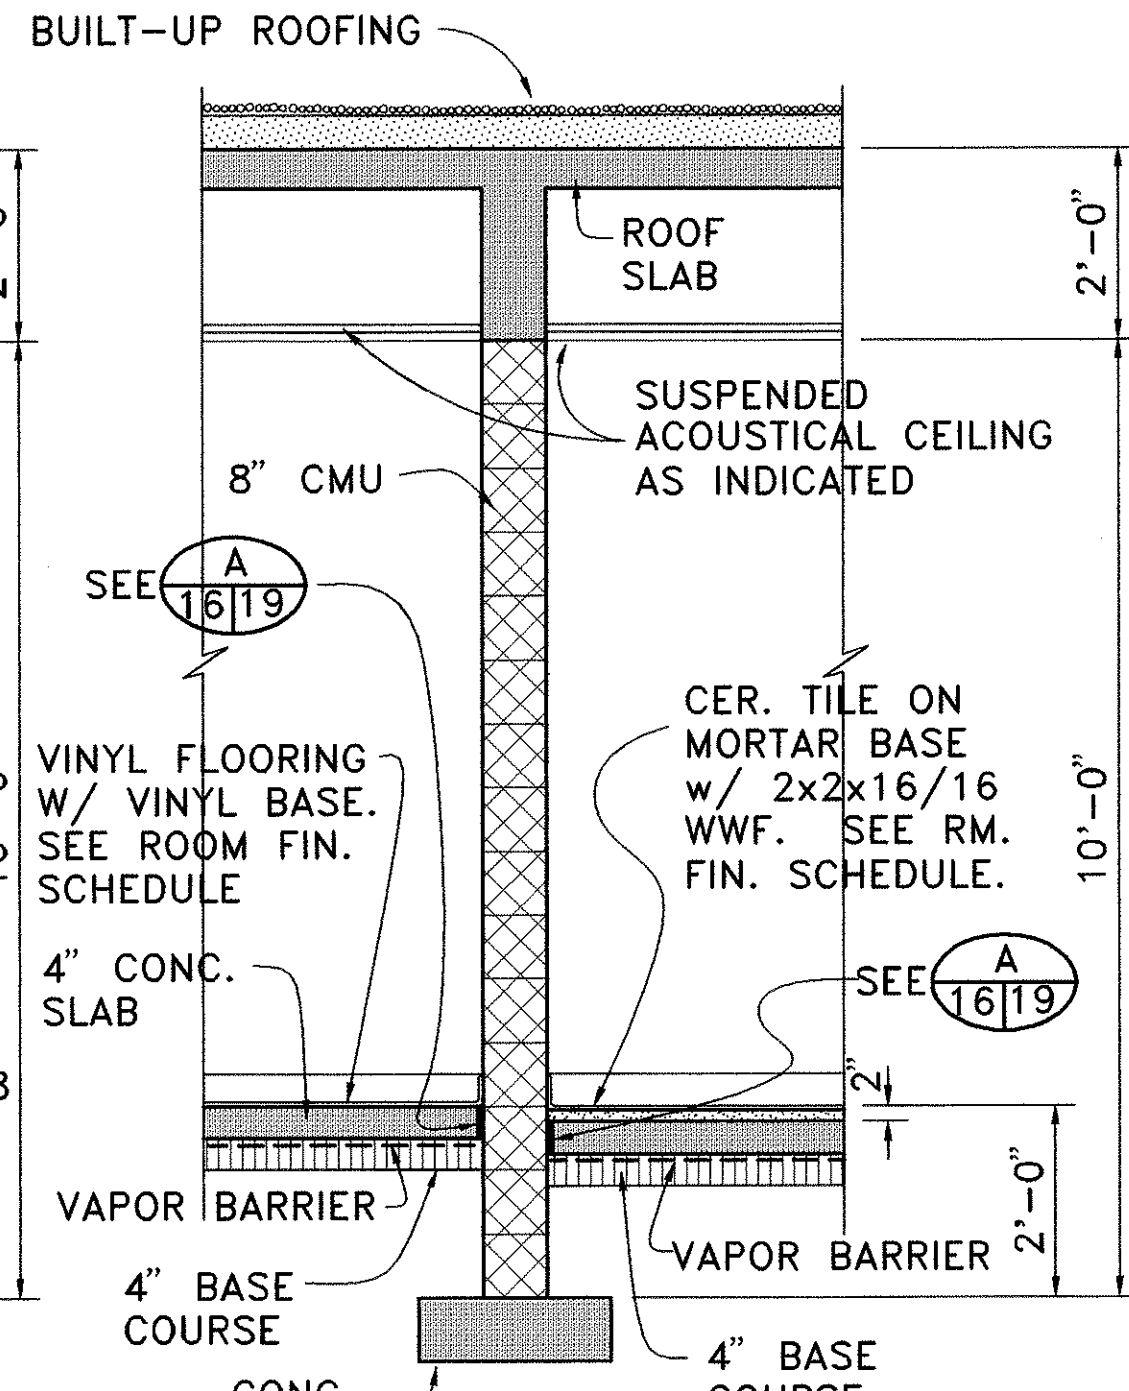


TYPICAL INTERIOR WALL

SECTION **B**
SCALE: 1/2"=1'-0" **16/16**

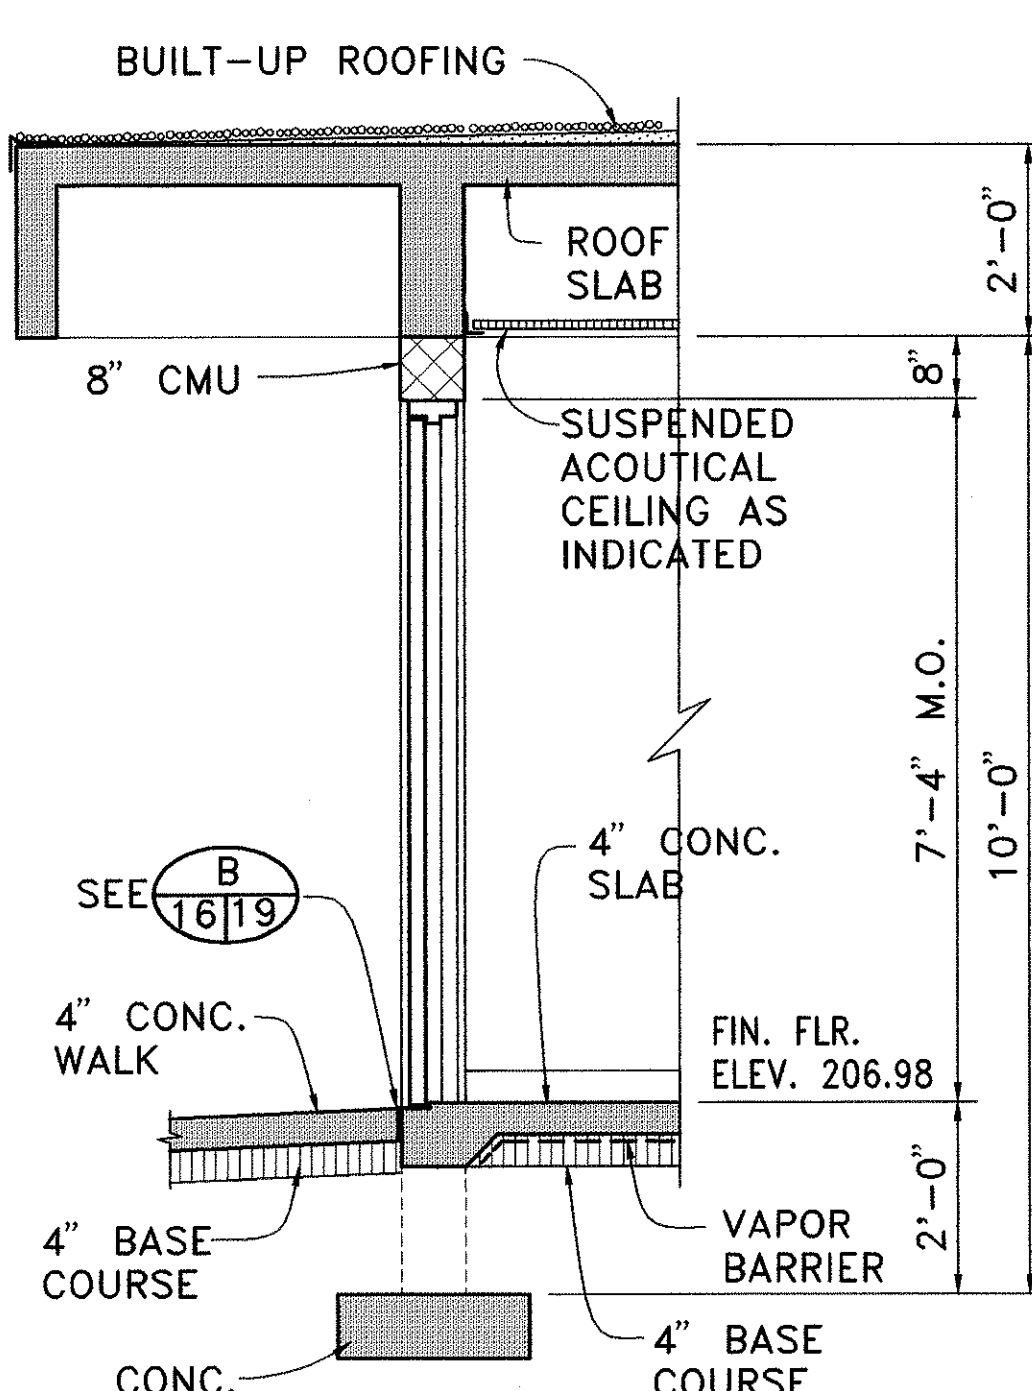


AT EXTERIOR DOOR OPENING

SECTION **C**
SCALE: 1/2"=1'-0" **16/16**

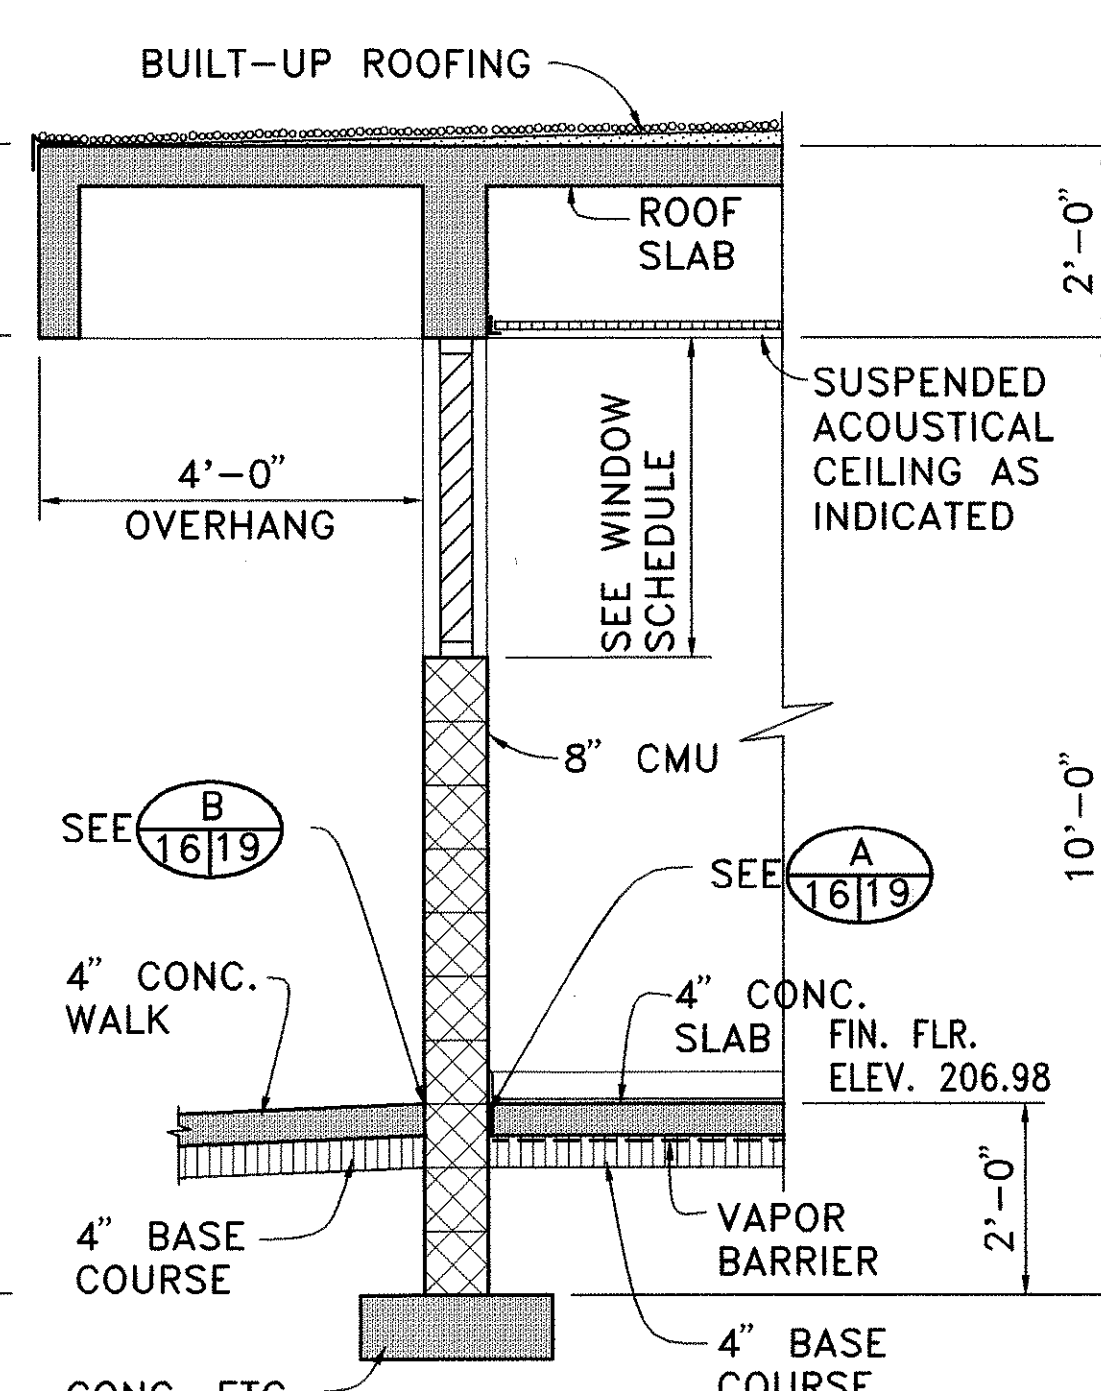


AT EXTERIOR WINDOW OPENING
(OPENING FOR A.C. UNIT SIMILAR)

SECTION **D**
SCALE: 1/2"=1'-0" **16/16**

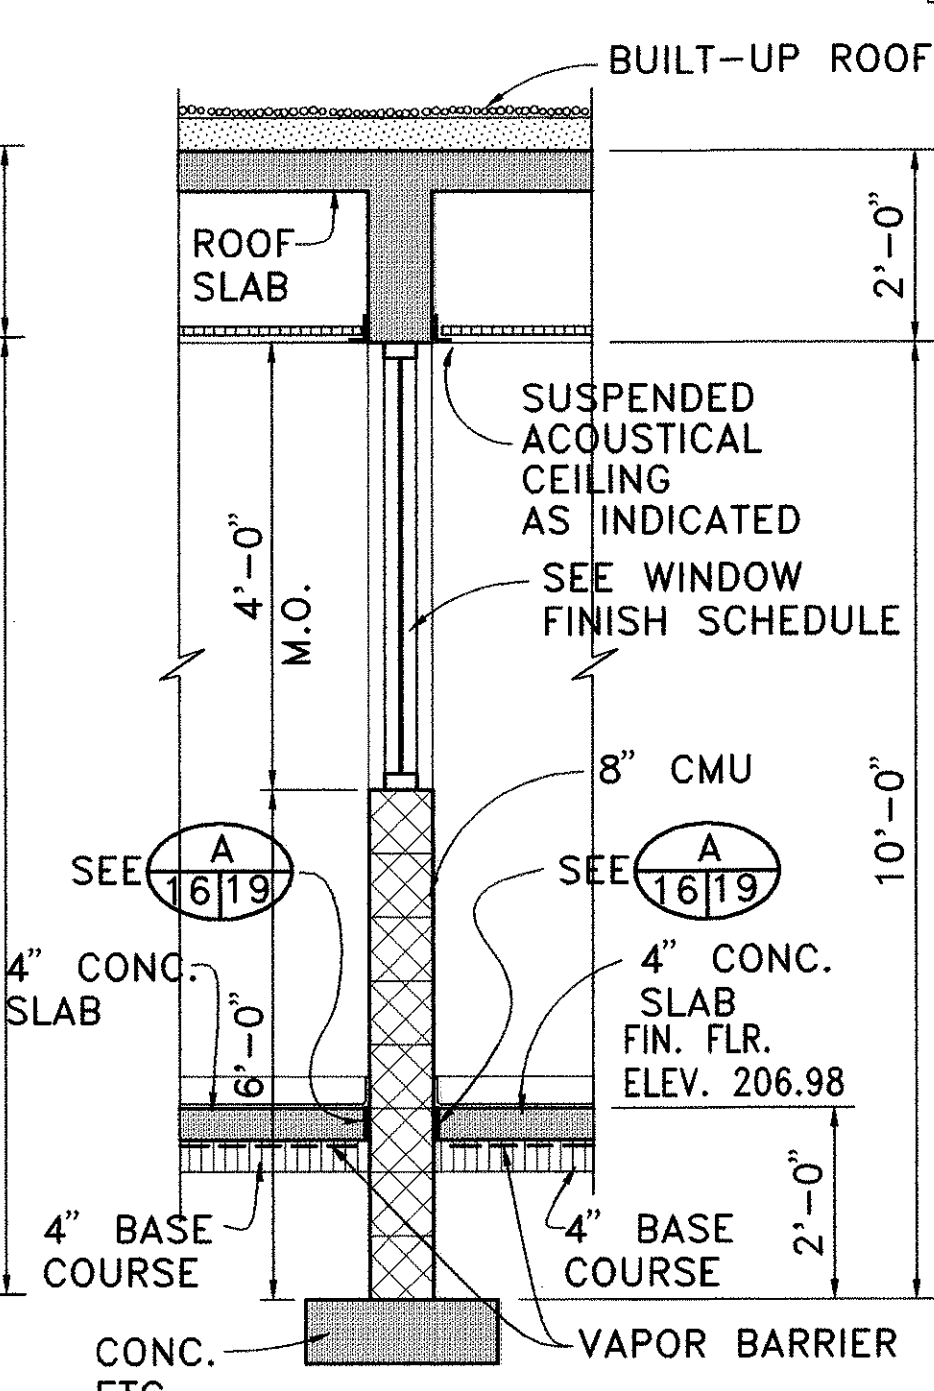

AT INTERIOR WINDOW OPENING

SECTION **E**
SCALE: 1/2"=1'-0" **16/16**

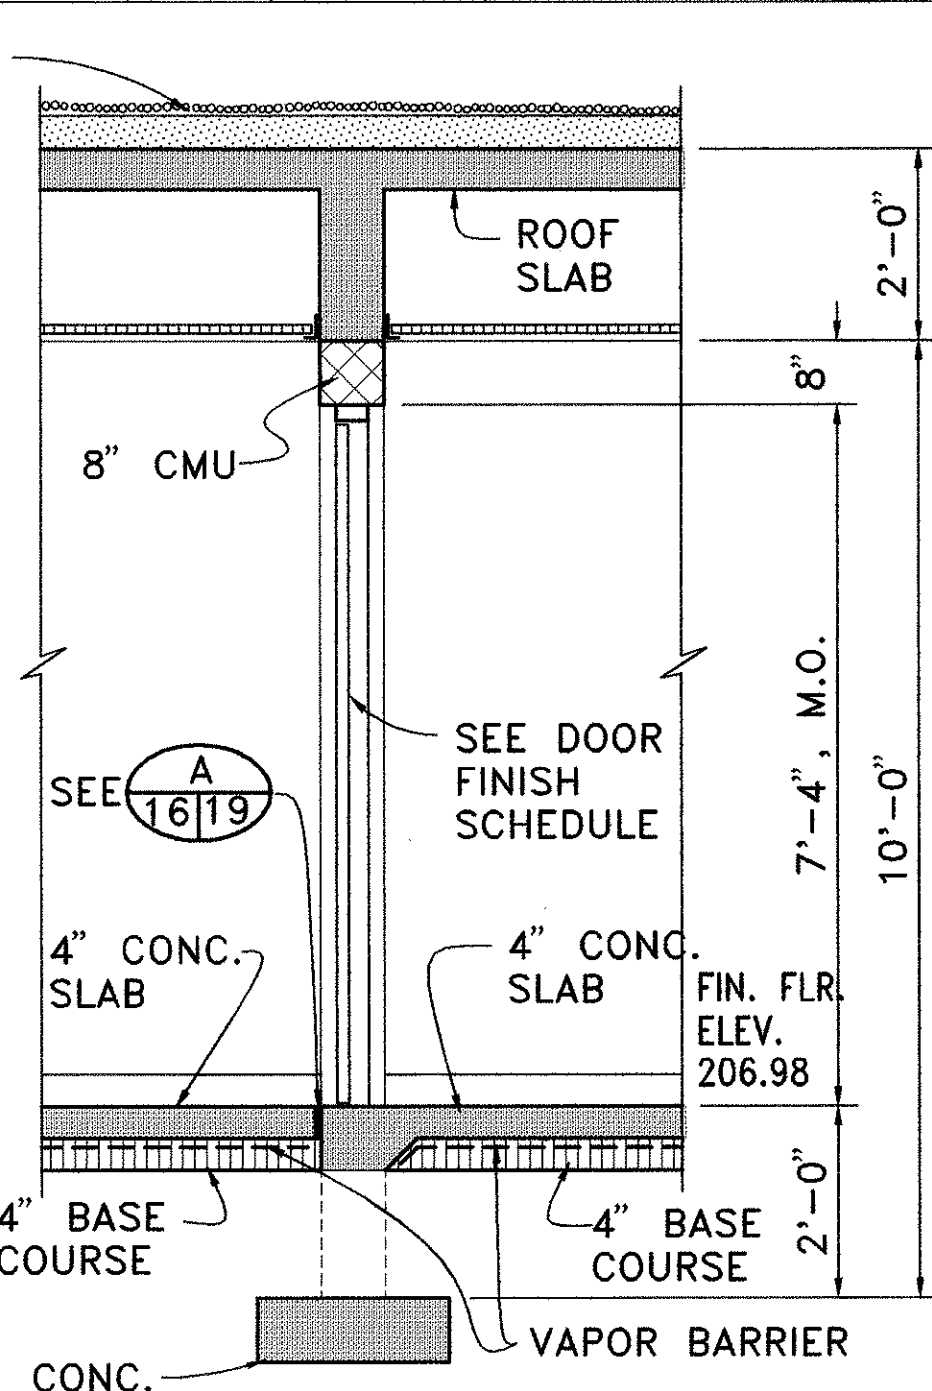


AT INTERIOR DOOR OPENING

SECTION **F**
SCALE: 1/2"=1'-0" **16/16**


NOTE: FINISH FLOOR ELEVATION INDICATED IS TO THE TOP OF THE FINISHED CONCRETE SLAB EXCEPT IN AREAS WHERE THE SLAB IS DEPRESSED.

NOTE: VAPOR BARRIER SHALL BE 6 MIL POLYETHYLENE.

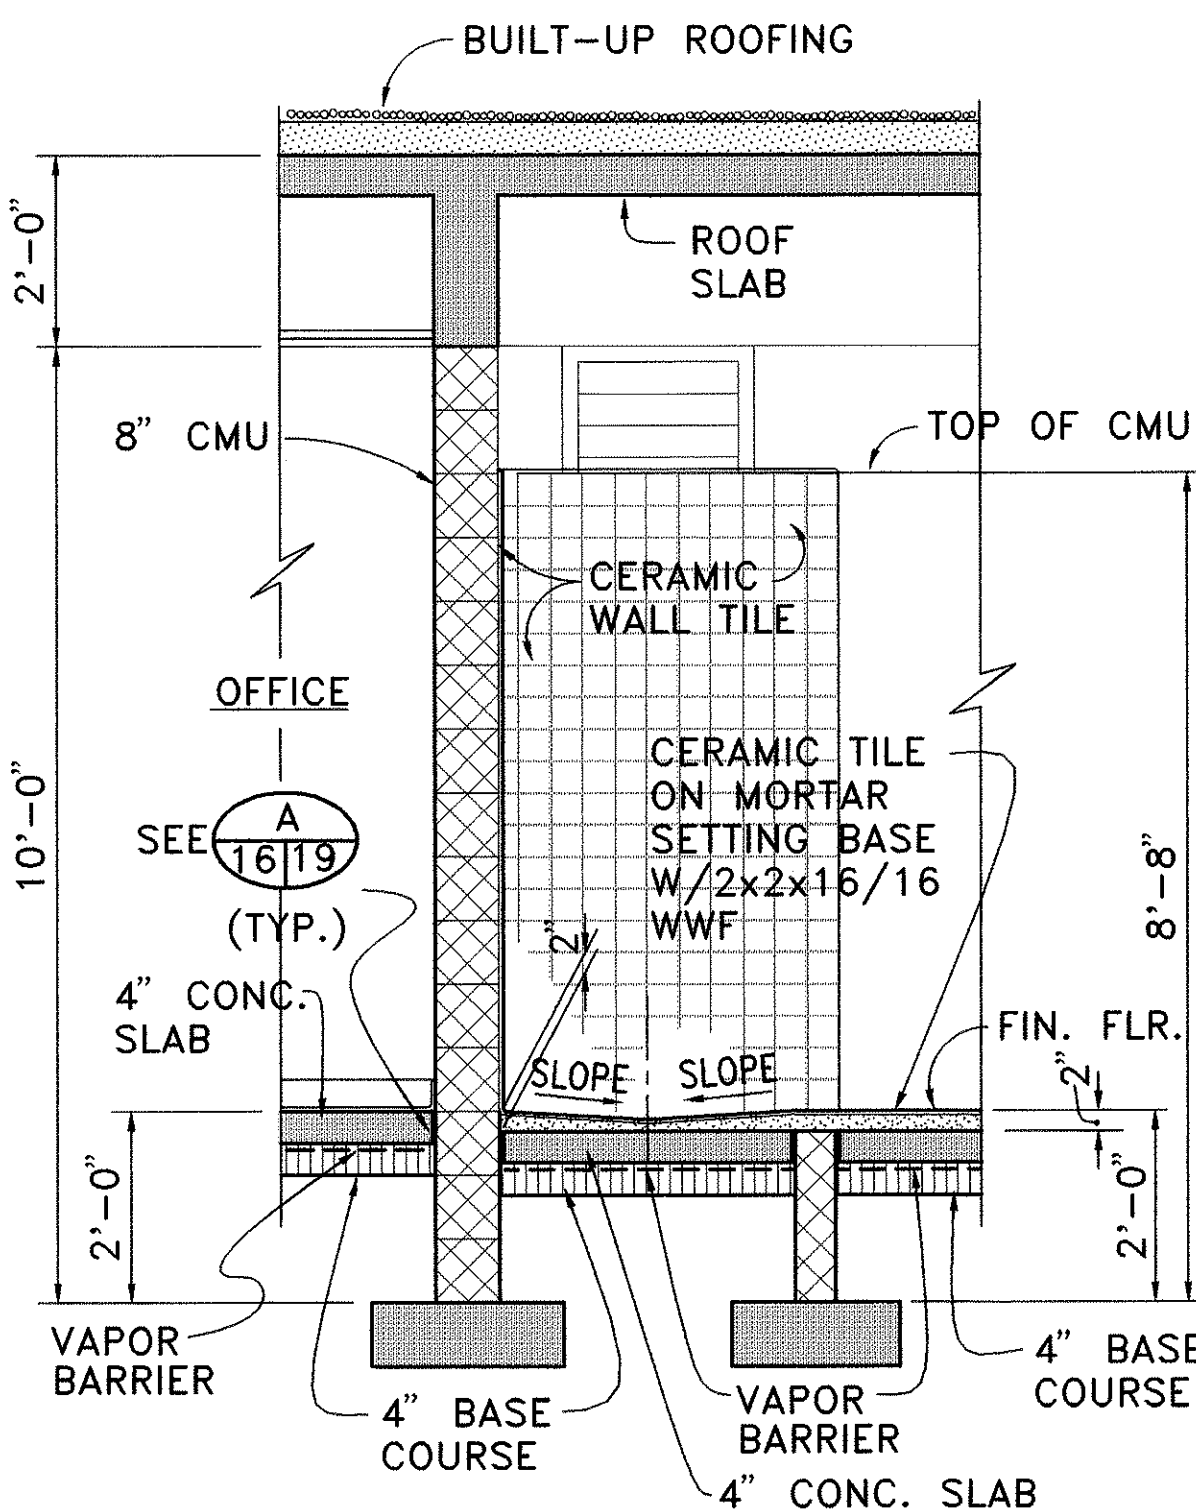


AT SHOWER

SECTION **G**
SCALE: 1/2"=1'-0" **16/16**

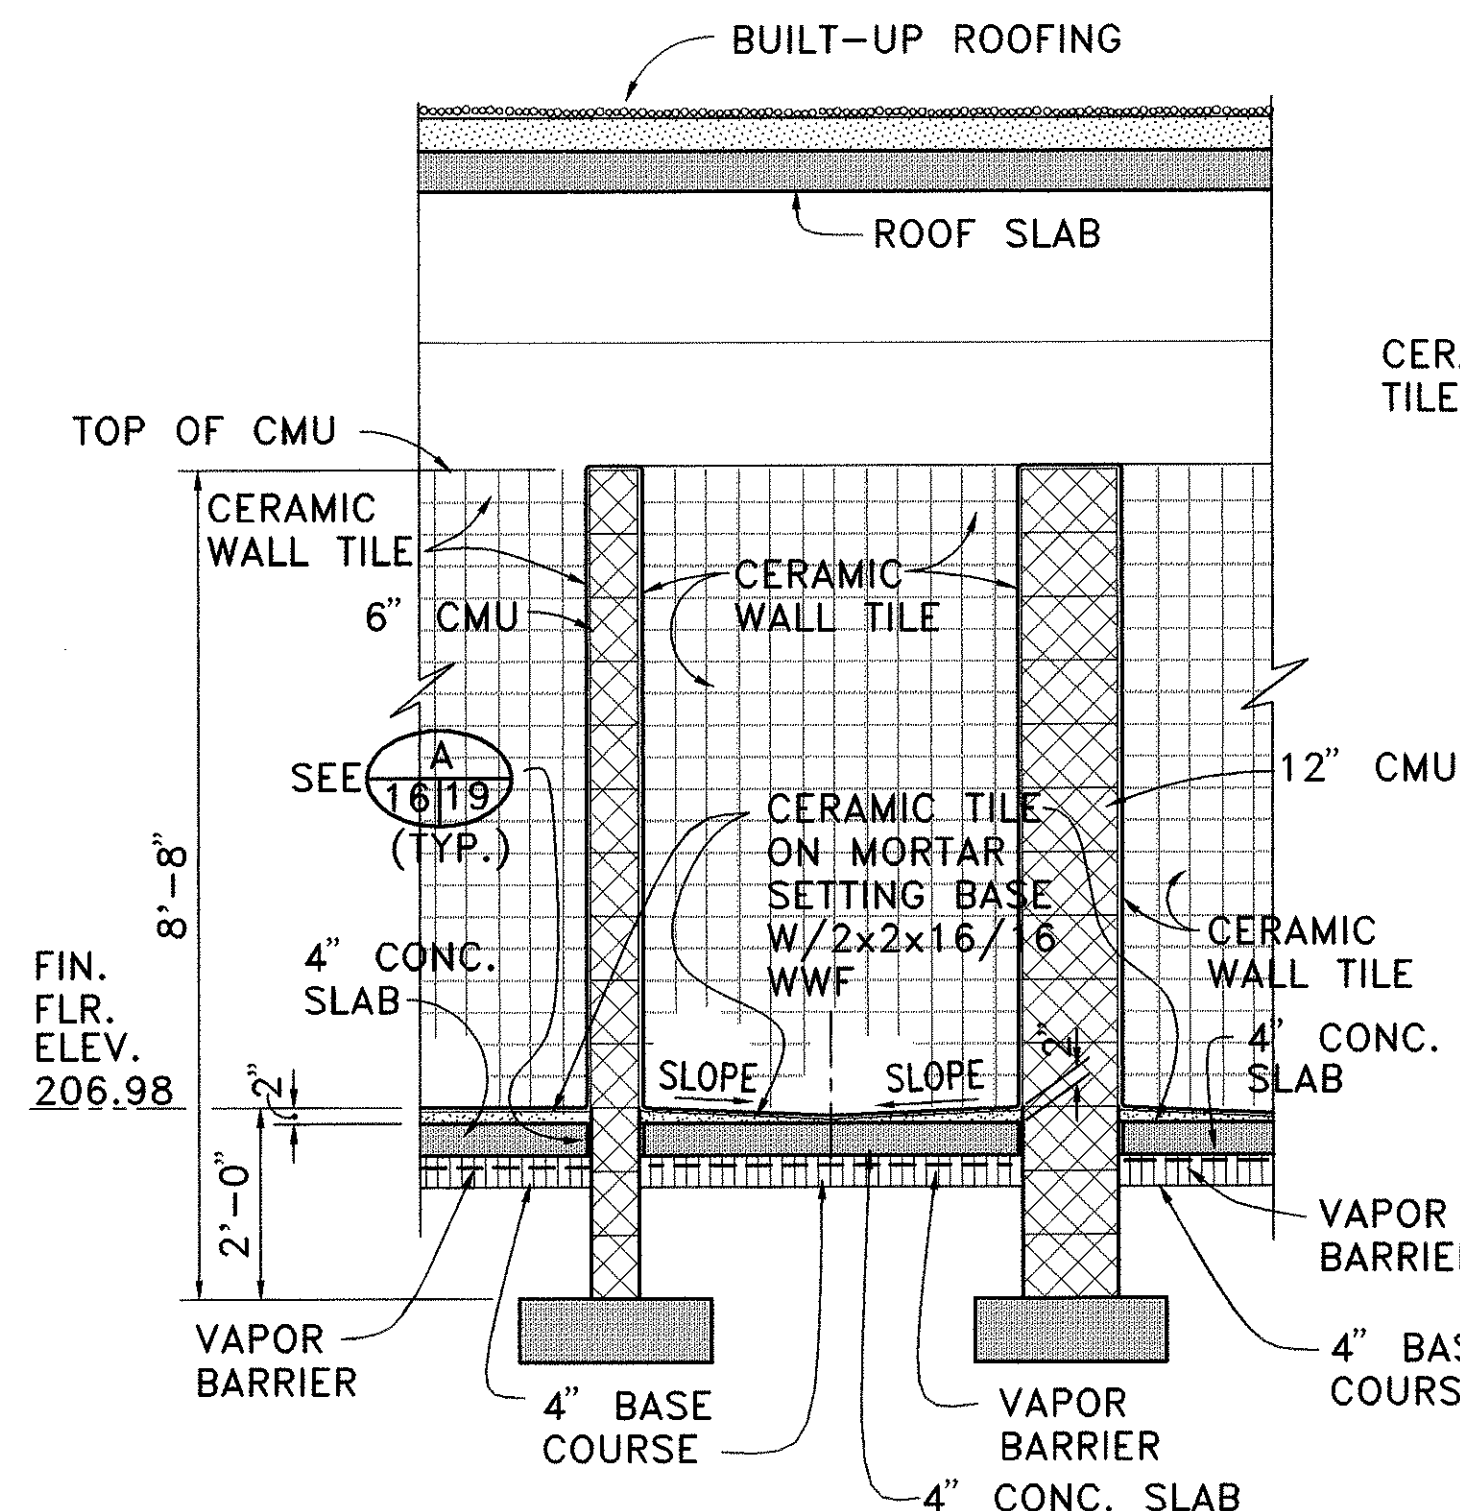


AT SHOWER

SECTION **H**
SCALE: 1/2"=1'-0" **16/16**

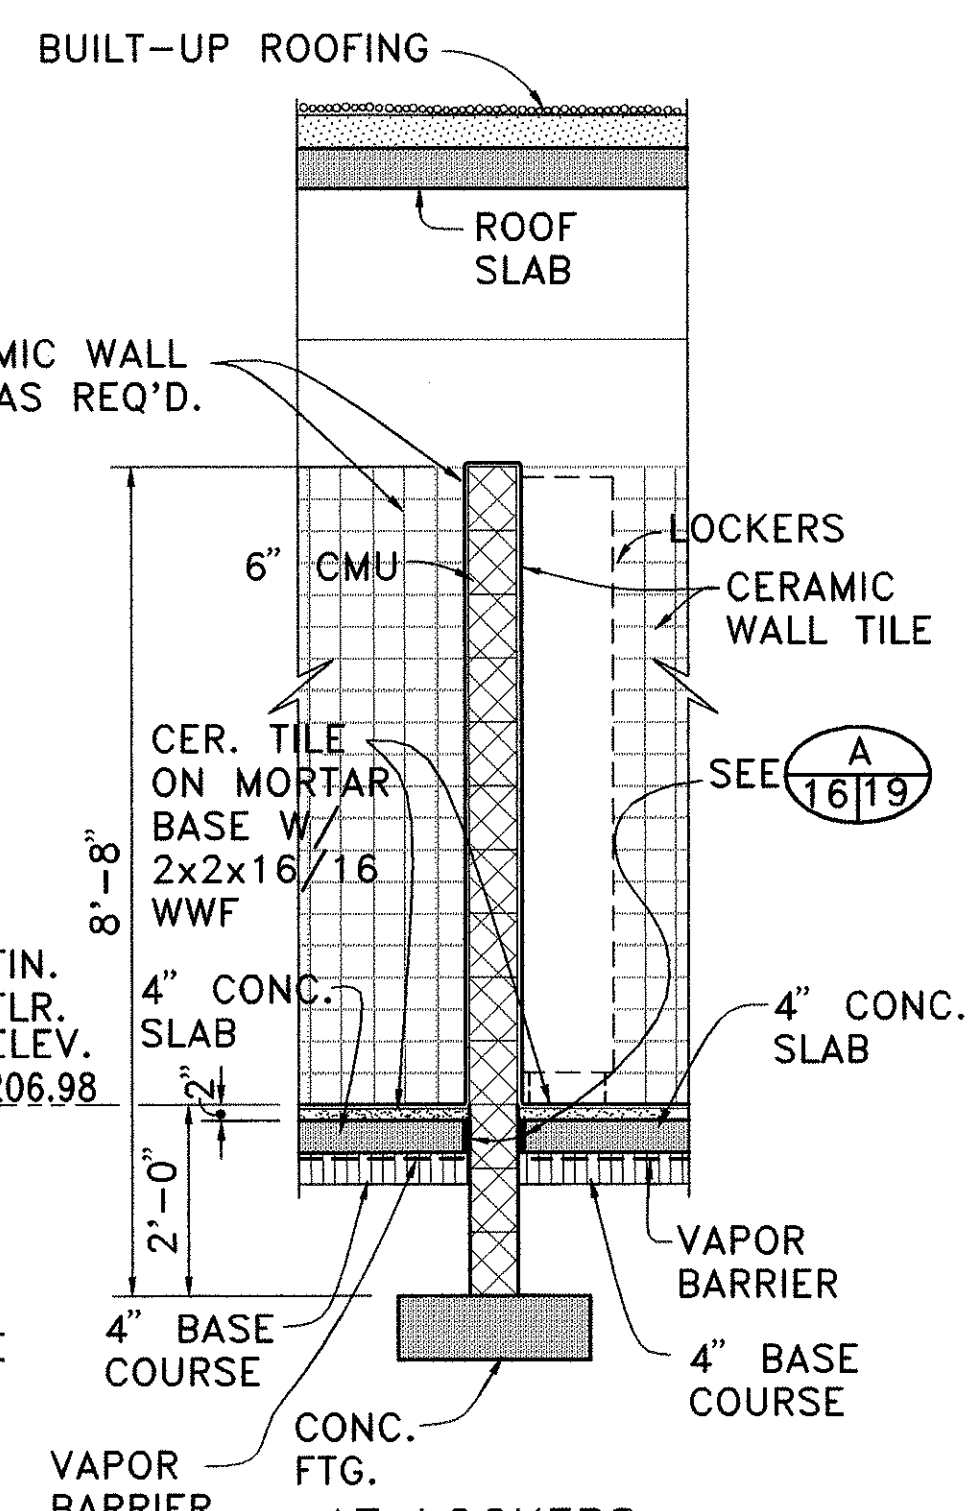


AT LOCKERS

SECTION **I**
SCALE: 1/2"=1'-0" **16/16**

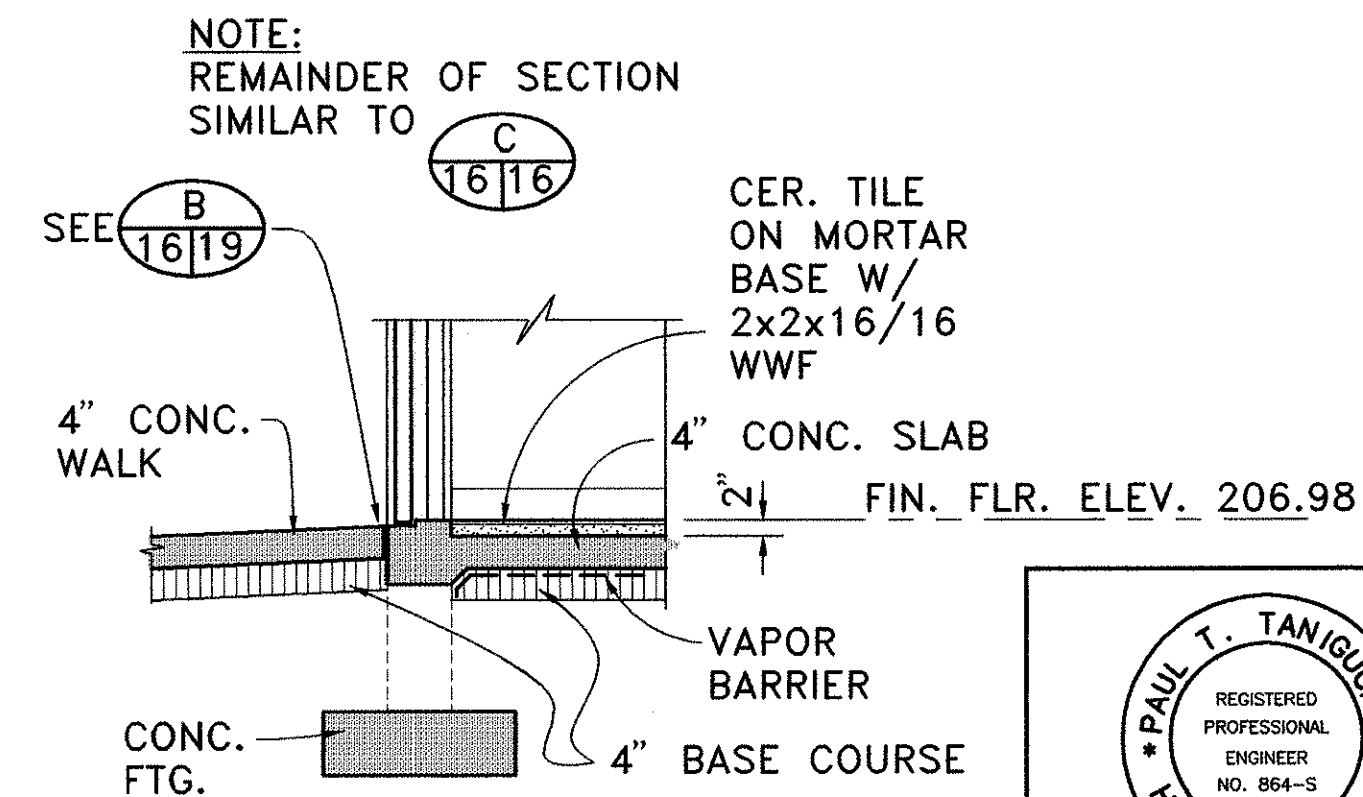

EXTERIOR DOOR OPENING
AT RESTROOMS

SECTION **J**
SCALE: 1/2"=1'-0" **16/16**

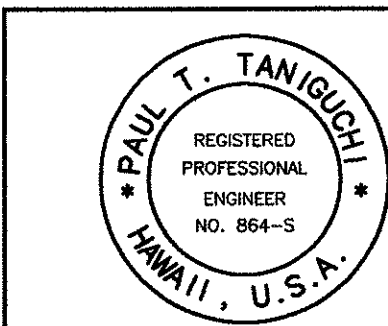

9/15/94	REVISED SECT. G/16 (SHOWER STALL)
6/17/94	REVISED NOTES ON SECT. D/16,E/16 & F/16. ADDED CERAMIC TILE ON SECT. H/16 & I/16.
DATE	REVISION

WALL SECTIONS

KANELOE BASE YARD, PHASE II


ADMINISTRATION BUILDING

PROJECT NO. HWY-0-03-92


SCALE: AS NOTED DATE: 4/15/94

SHEET NO. 16 OF 35 SHEETS



C.O.ADD. 16

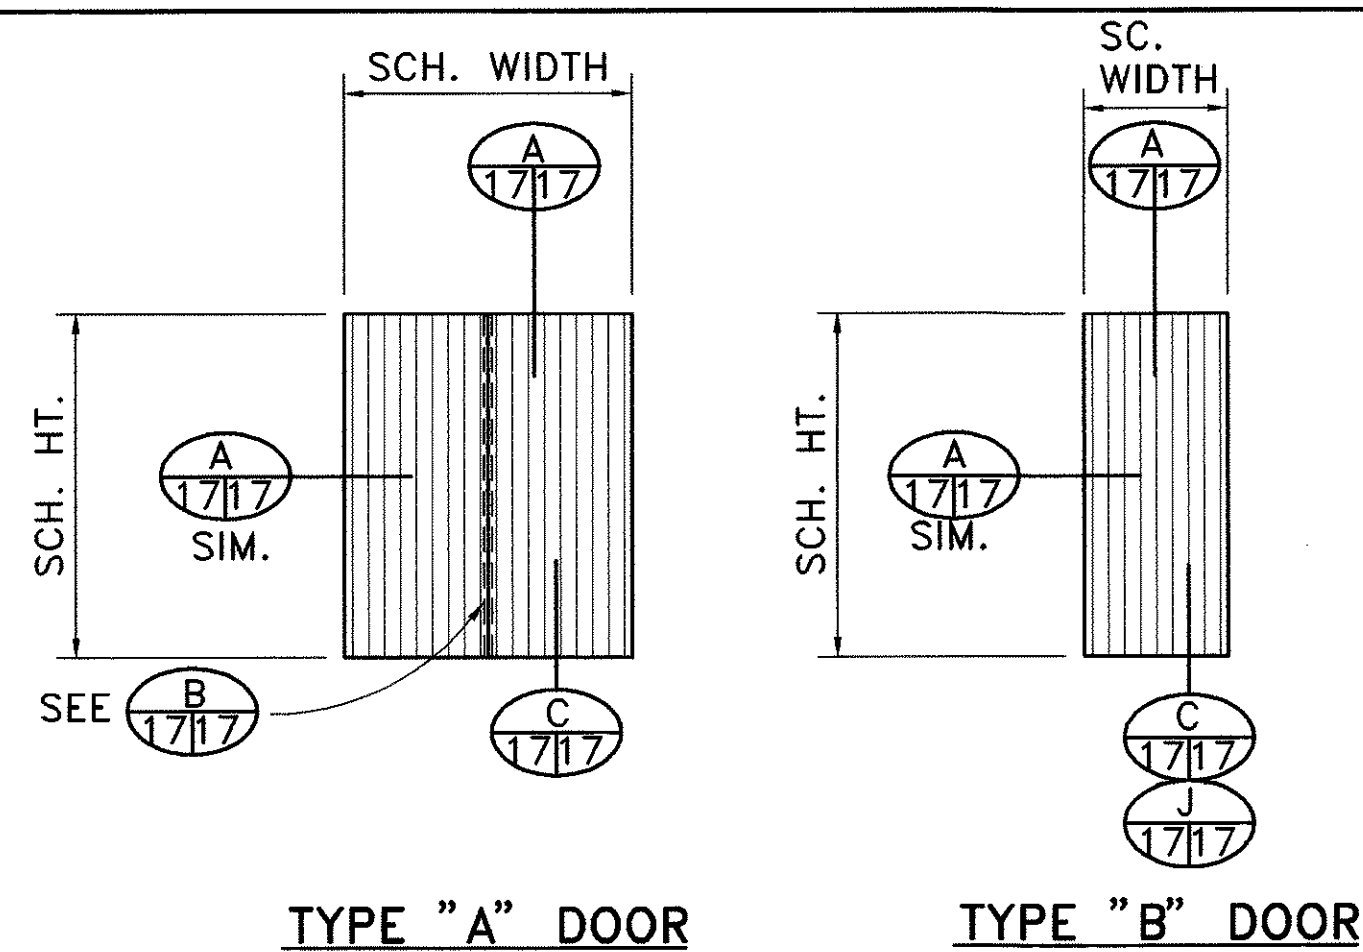


DOOR SCHEDULE						
NO.	SIZE	THK	TYPE	CORE	MATERIAL	REMARKS
D 1	5'-8" x 7'-2"	1-3/4"	A	MINERAL WOOL	METAL	
D 2	3'-0" x 7'-2"	1-3/4"	B	MINERAL WOOL	METAL	
D 3	3'-0" x 7'-2"	1-3/4"	B	MINERAL WOOL	METAL	
D 4	3'-0" x 7'-2"	1-3/4"	B	MINERAL WOOL	METAL	
D 5	3'-0" x 7'-2"	1-3/4"	B	MINERAL WOOL	METAL	
D 6	3'-0" x 7'-2"	1-3/4"	B	MINERAL WOOL	METAL	
D 7	3'-0" x 7'-2"	1-3/4"	B	MINERAL WOOL	METAL	
D 8	3'-0" x 7'-2"	1-3/4"	B	MINERAL WOOL	METAL	
D 9	3'-0" x 7'-2"	1-3/4"	B	MINERAL WOOL	METAL	INTERIOR DOOR

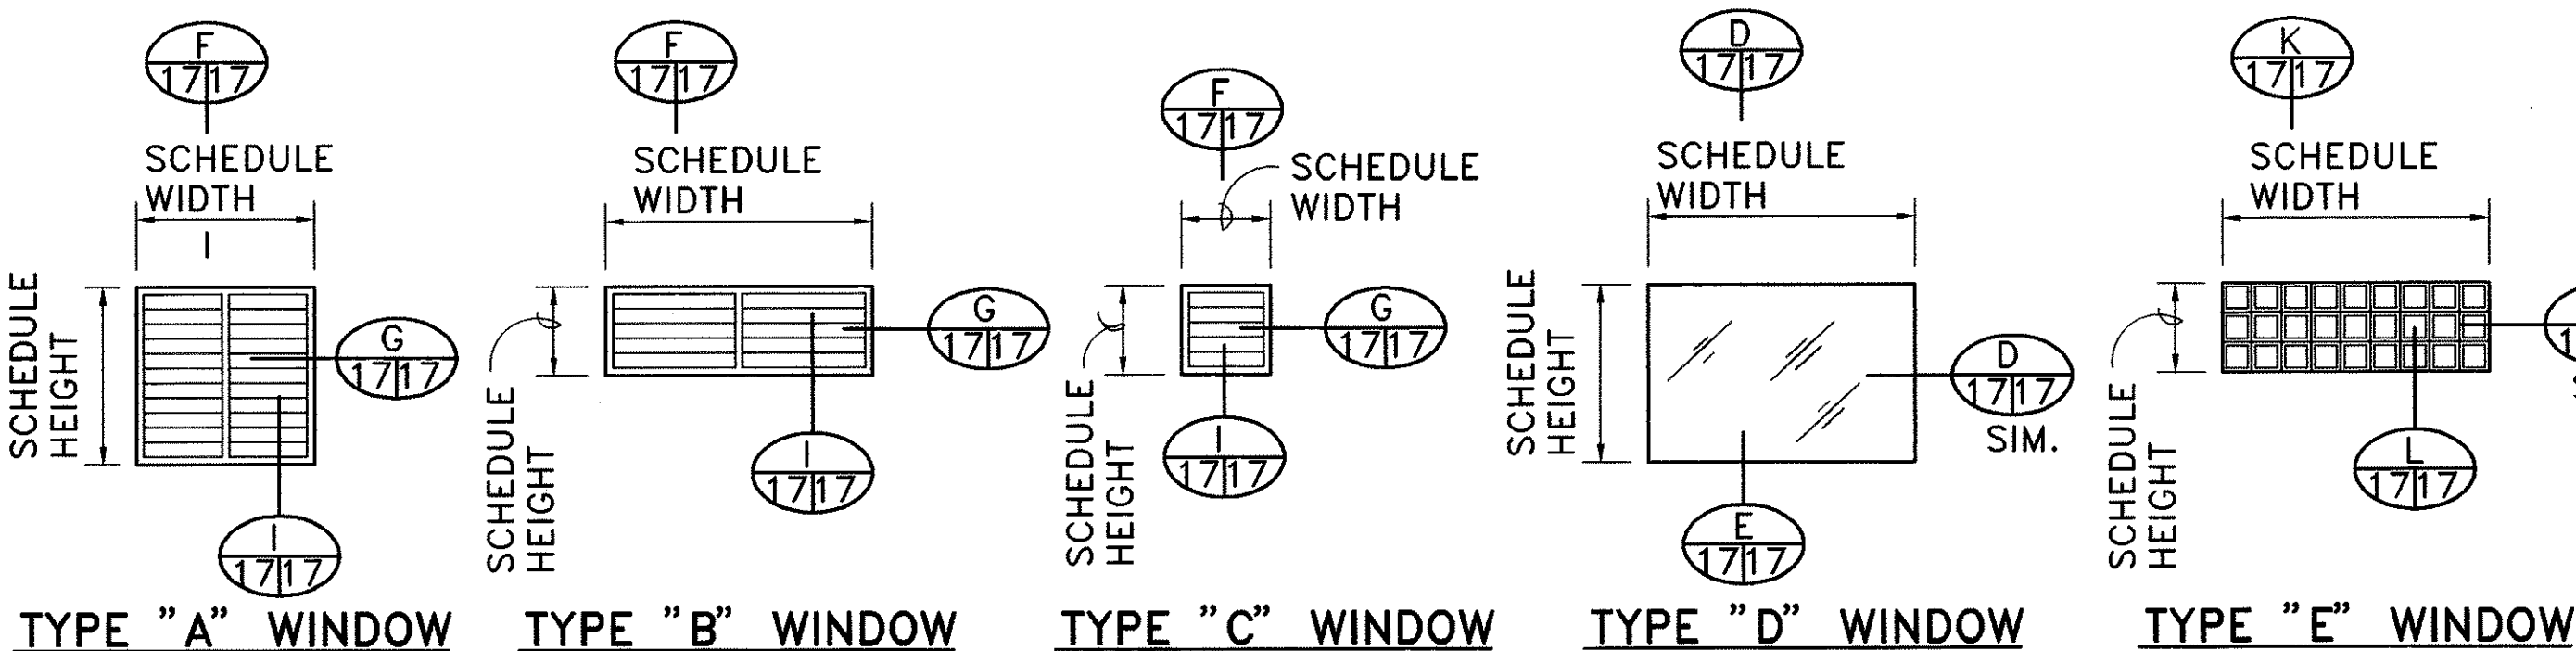


WINDOW SCHEDULE				
NO.	SIZE (W x H)	TYPE	MATERIAL	REMARKS
W 1	2'-0" x 1'-7 5/8"	C	ALUMINUM FRAME w/ OBS. GLASS JALOUSIE	
W 2	2'-0" x 1'-7 5/8"	C	ALUMINUM FRAME w/ OBS. GLASS JALOUSIE	
W 3	4'-0" x 3'-7 5/8"	A	ALUMINUM FRAME w/ OBS. GLASS JALOUSIE	MULLION REQUIRED. SEE H-1717
W 4	4'-0" x 3'-7 5/8"	A	ALUMINUM FRAME w/ OBS. GLASS JALOUSIE	MULLION REQUIRED. SEE H-1717
W 5	4'-0" x 2'-0"	E	CONC. MASONRY BLOCK	8"x 8"x 8" CMU BLK TURNED SIDWAYS
W 6	4'-0" x 2'-0"	E	CONC. MASONRY BLOCK	8"x 8"x 8" CMU BLK TURNED SIDWAYS
W 7	4'-0" x 2'-0"	E	CONC. MASONRY BLOCK	8"x 8"x 8" CMU BLK TURNED SIDWAYS
W 8	4'-0" x 2'-0"	E	CONC. MASONRY BLOCK	8"x 8"x 8" CMU BLK TURNED SIDWAYS
W 9	4'-0" x 2'-0"	E	CONC. MASONRY BLOCK	8"x 8"x 8" CMU BLK TURNED SIDWAYS
W 10	6'-0" x 1'-7 5/8"	B	ALUMINUM FRAME w/ OBS. GLASS JALOUSIE	MULLION REQUIRED. SEE H-1717
W 11	2'-0" x 1'-7 5/8"	C	ALUMINUM FRAME w/ OBS. GLASS JALOUSIE	
W 12	4'-0" x 3'-7 5/8"	A	ALUMINUM FRAME w/ OBS. GLASS JALOUSIE	MULLION REQUIRED. SEE H-1717
W 13	4'-0" x 3'-7 5/8"	A	ALUMINUM FRAME w/ OBS. GLASS JALOUSIE	MULLION REQUIRED. SEE H-1717
W 14	4'-0" x 3'-7 5/8"	A	ALUMINUM FRAME w/ OBS. GLASS JALOUSIE	MULLION REQUIRED. SEE H-1717
W 15	5'-8" x 3'-8"	D	WOOD FRAME w/ FIXED GLASS	
W 16	5'-8" x 3'-8"	D	WOOD FRAME w/ FIXED GLASS	

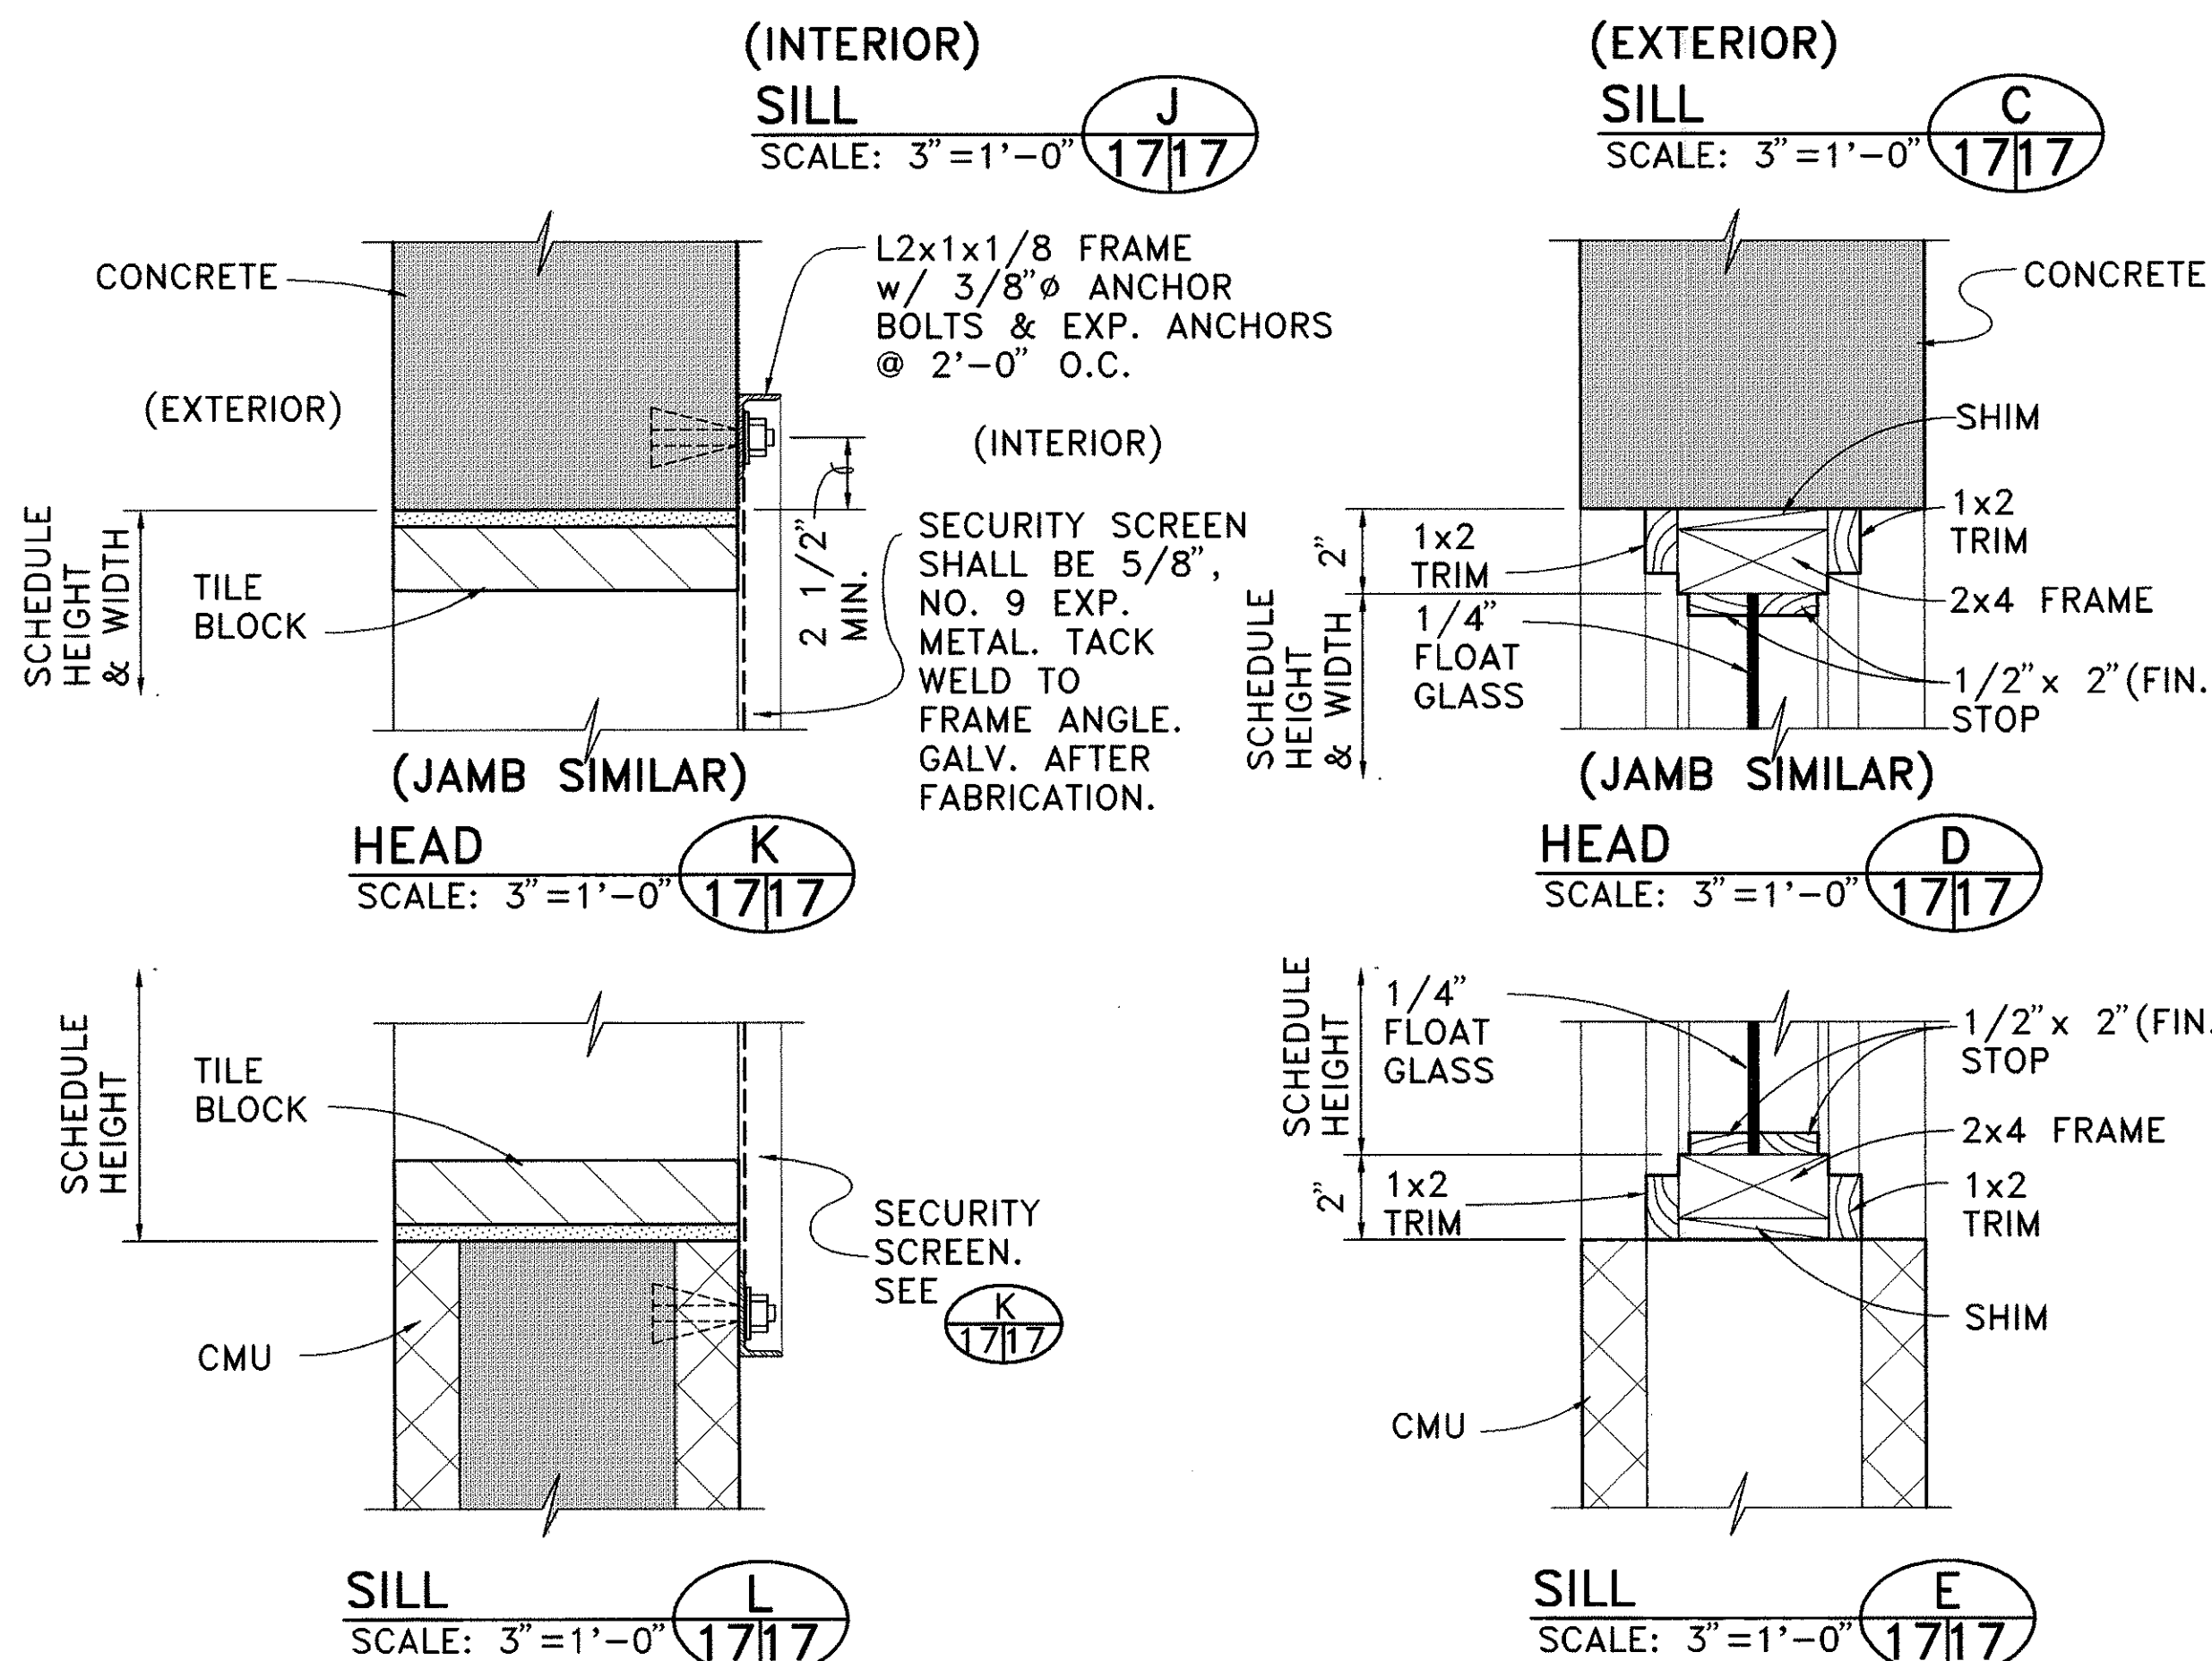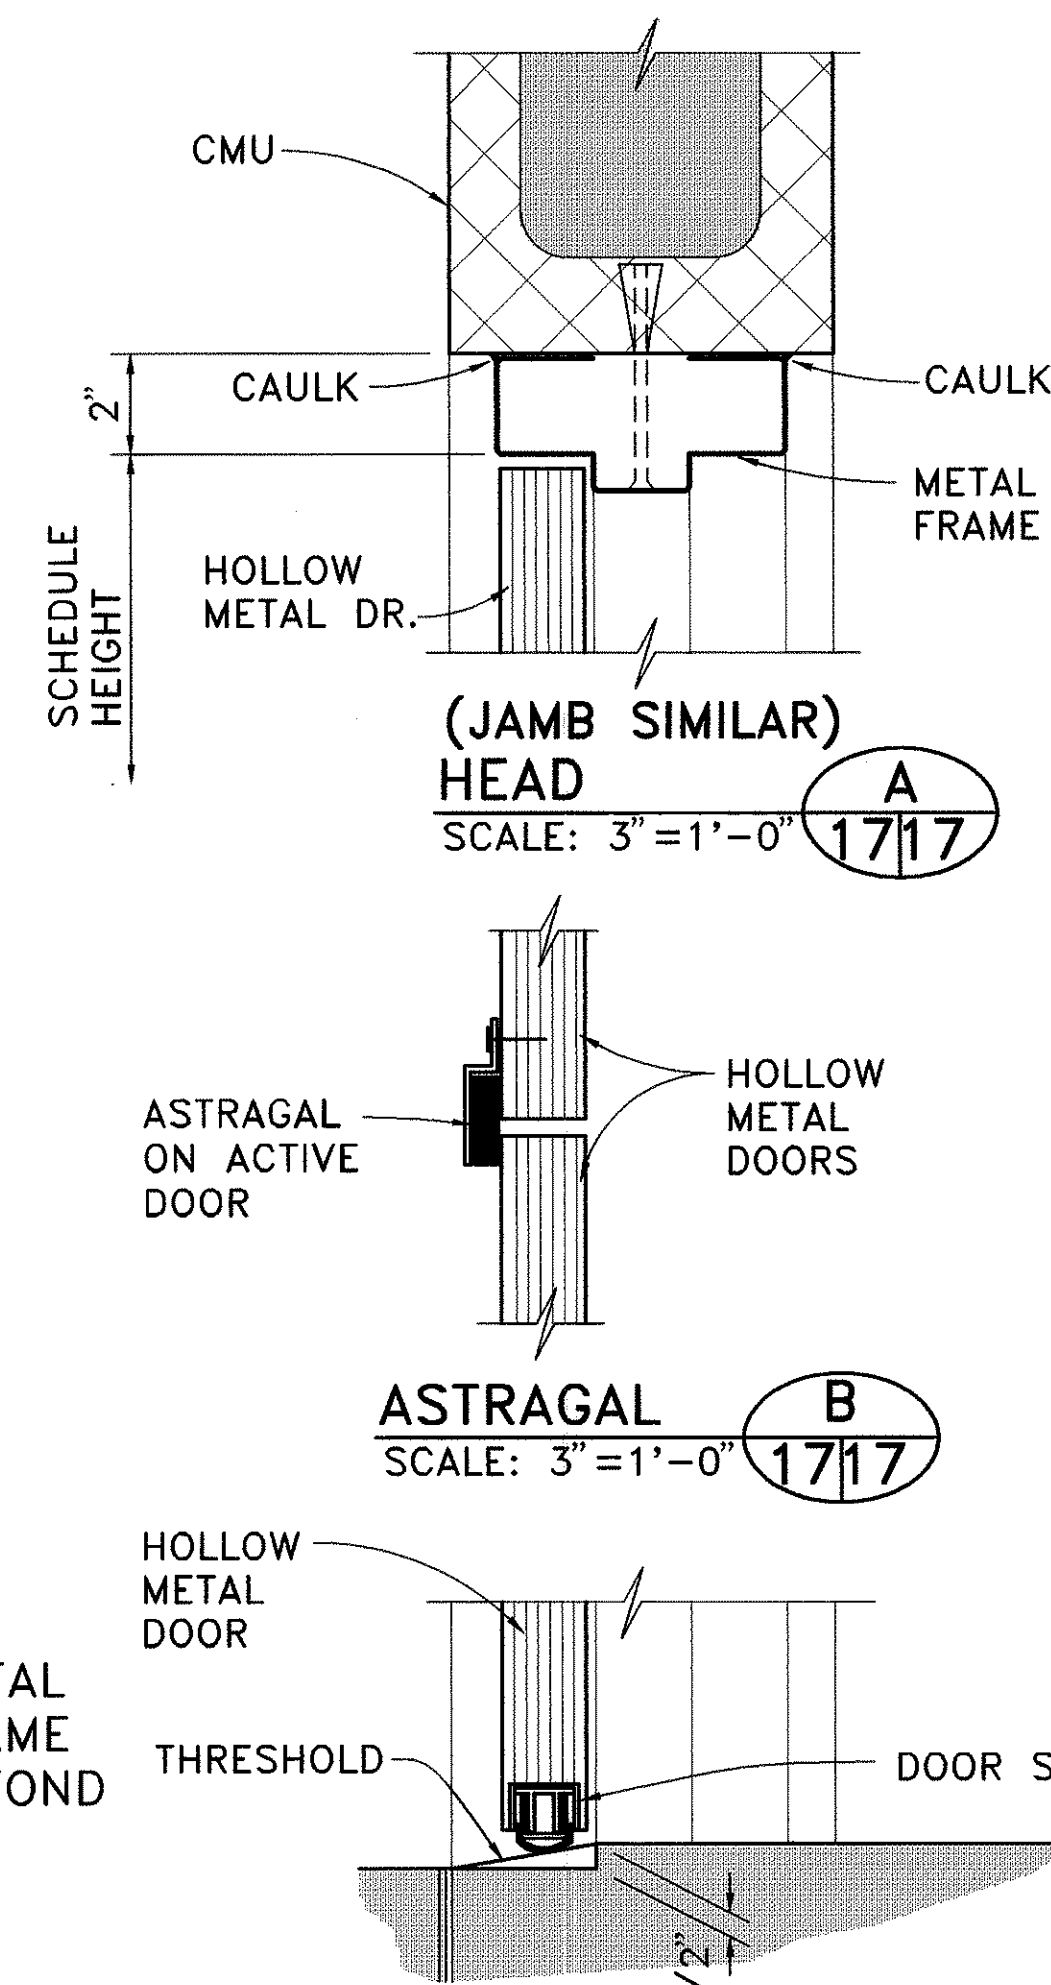

FED. ROAD DIST. NO.	STATE	PROJ. NO.	FISCAL YEAR	SHEET NO.	TOTAL SHEETS
HAWAII	HAW.	HWY-0-03-92	1994	17	35

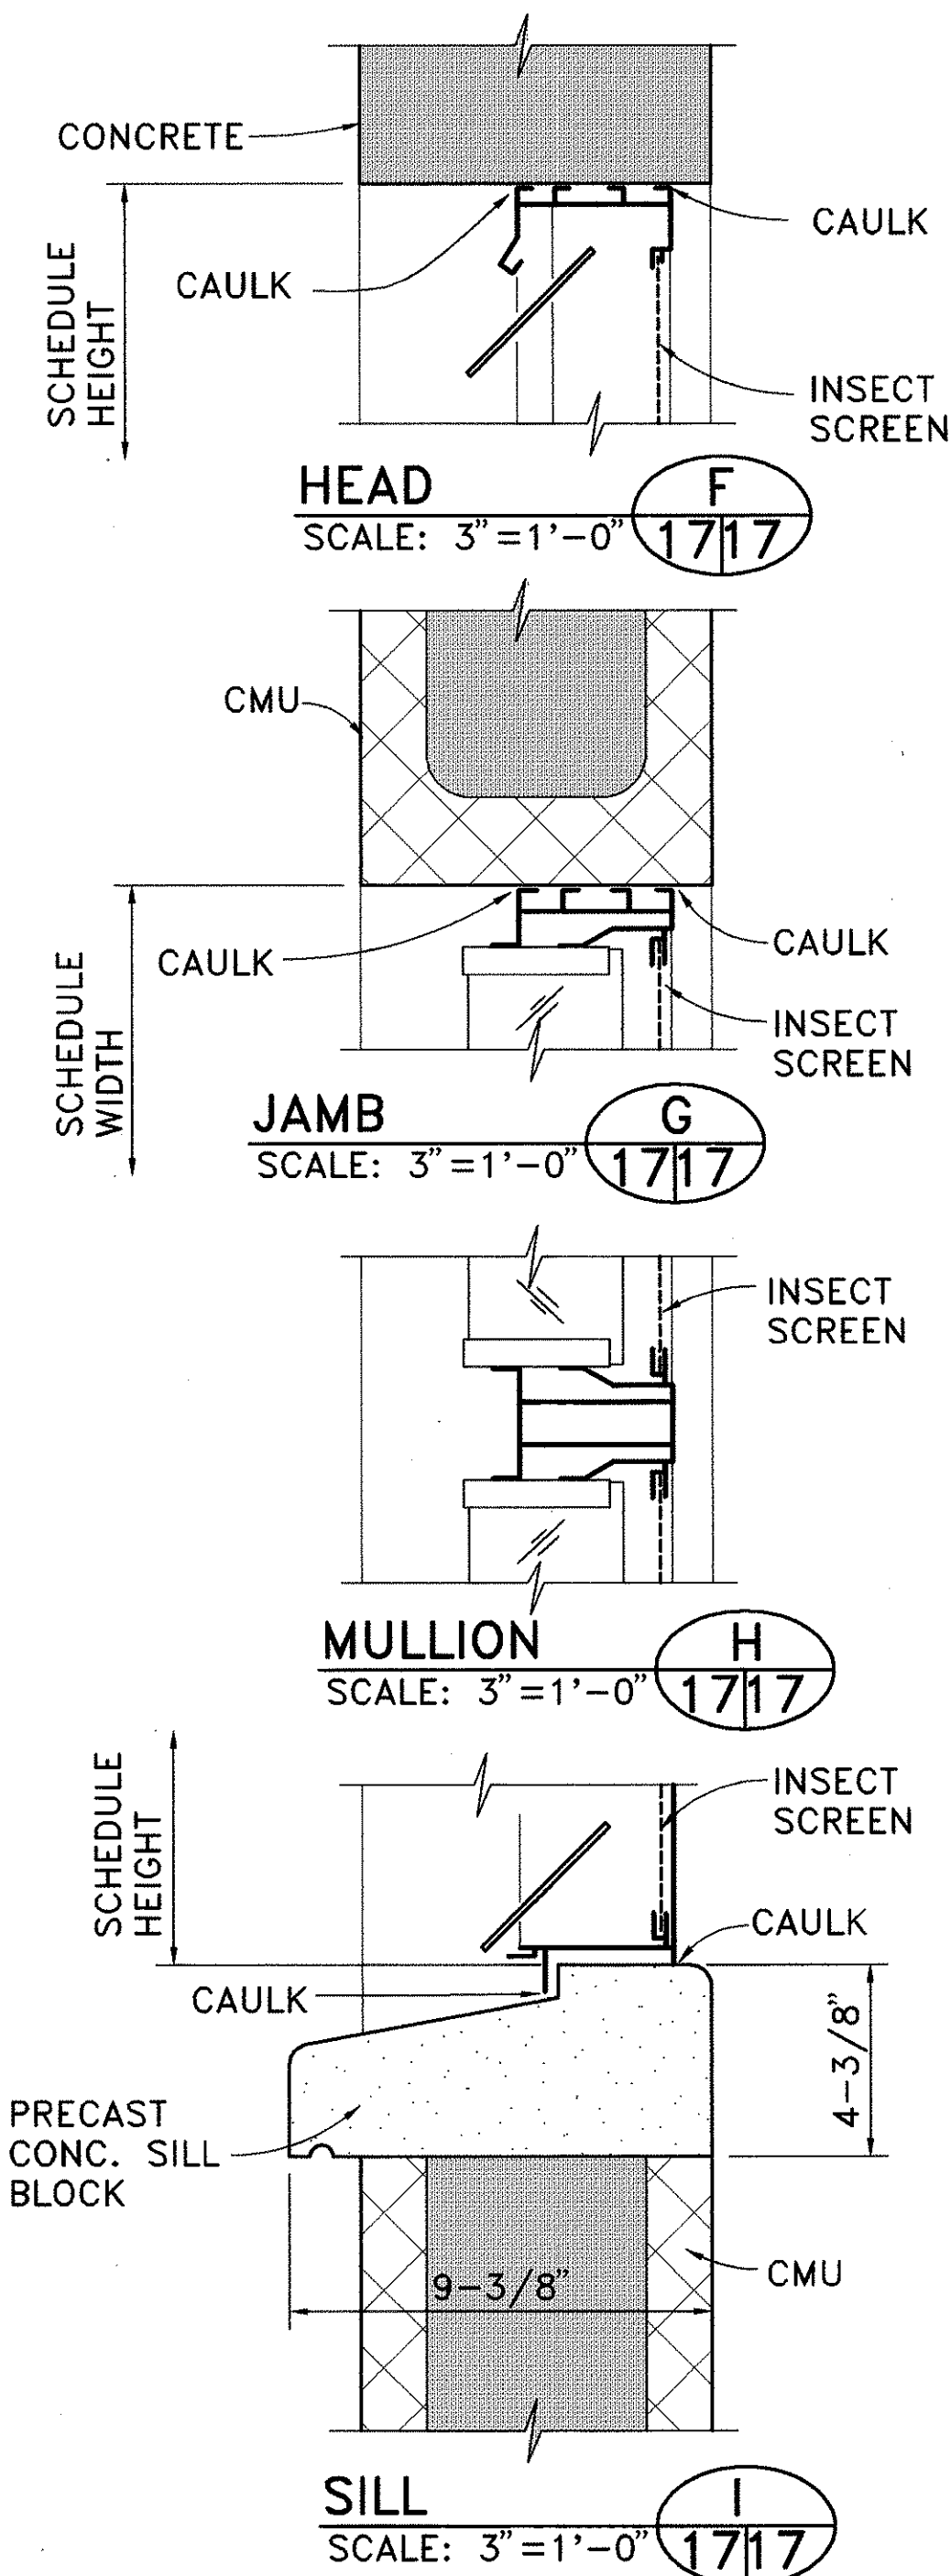


6/17/94	REVISED SILL DETAIL C/17. REVISED WINDOW SIZE FOR W/15 & W/16 IN WINDOW SCHEDULE.
DATE	REVISION
STATE OF HAWAII DEPARTMENT OF TRANSPORTATION HIGHWAYS DIVISION	
DOOR AND WINDOW SCHEDULE	
KANEHOE BASE YARD, PHASE II ADMINISTRATION BUILDING PROJECT NO. HWY-0-03-92	
SCALE: AS NOTED	DATE: 4/15/94
SHEET NO. 17 OF 35 SHEETS	

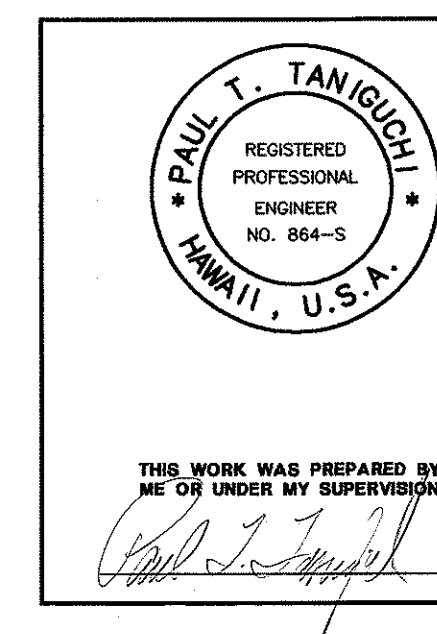


NAME: C:\CADD\BASE\HAWAII\18-ROOF.DWG DATE: MAY 12, 1994 TIME: 10:24 AM


FED. ROAD DIST. NO.	STATE	PROJ. NO.	FISCAL YEAR	SHEET NO.	TOTAL SHEETS
HAWAII	HAW.	HWY-0-03-92	1994	18	35

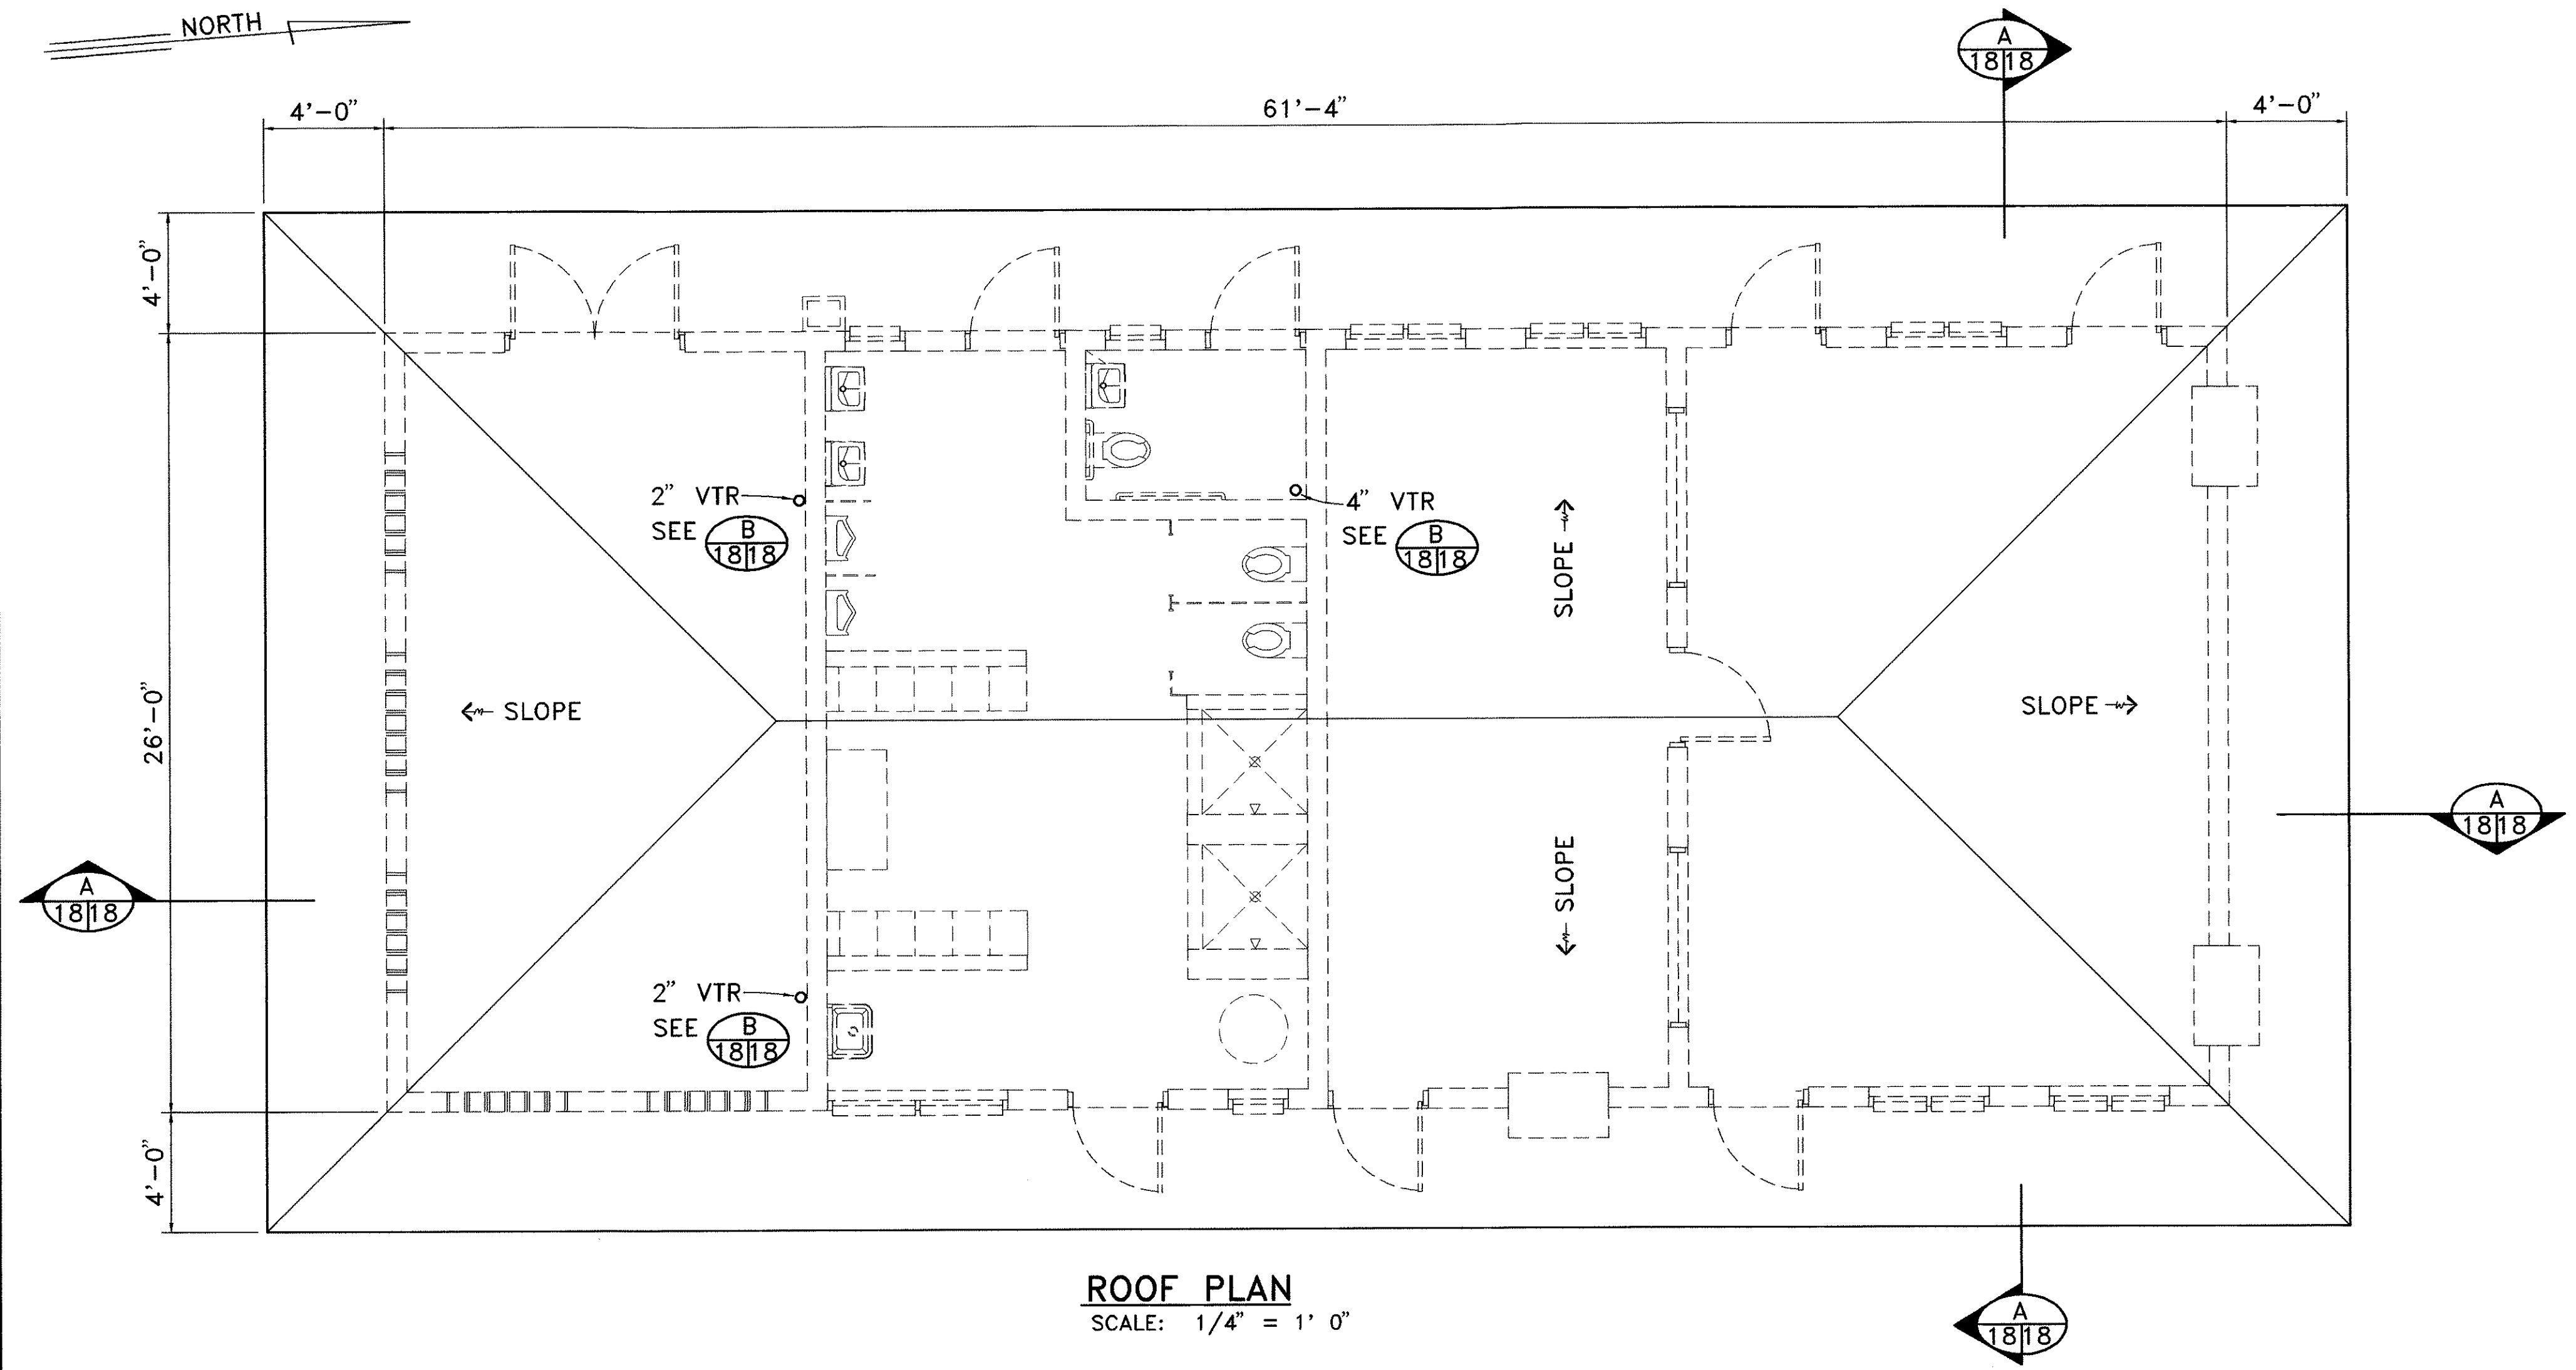


ROOF PLAN
SCALE: 1/4" = 1' 0"

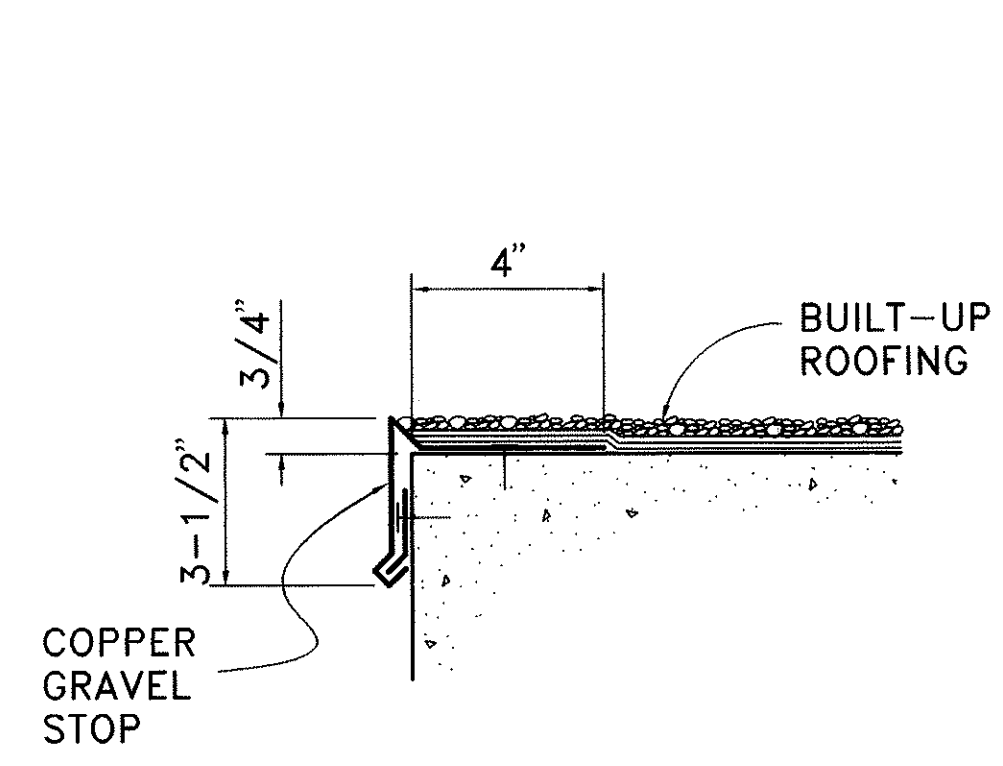

EAVE FLASHING DETAIL A 1818
NOT TO SCALE

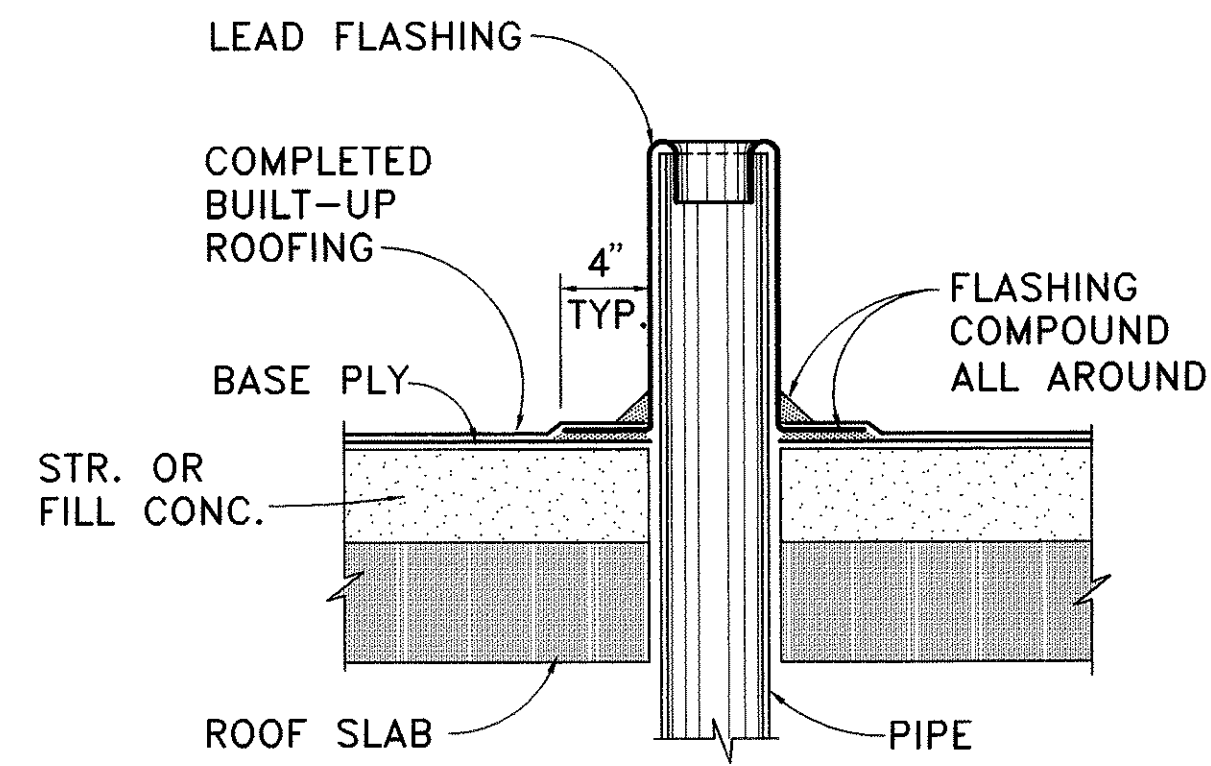


PIPE FLASHING DETAIL B 1818
NOT TO SCALE

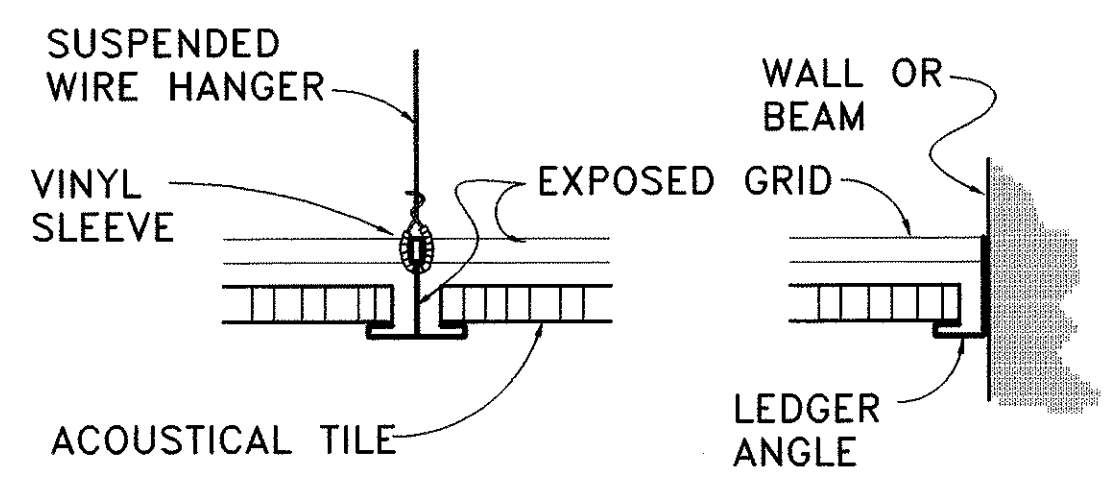

AT HANGERS AT WALLS

SUSPENDED CEILING DETAIL C 1818
NOT TO SCALE

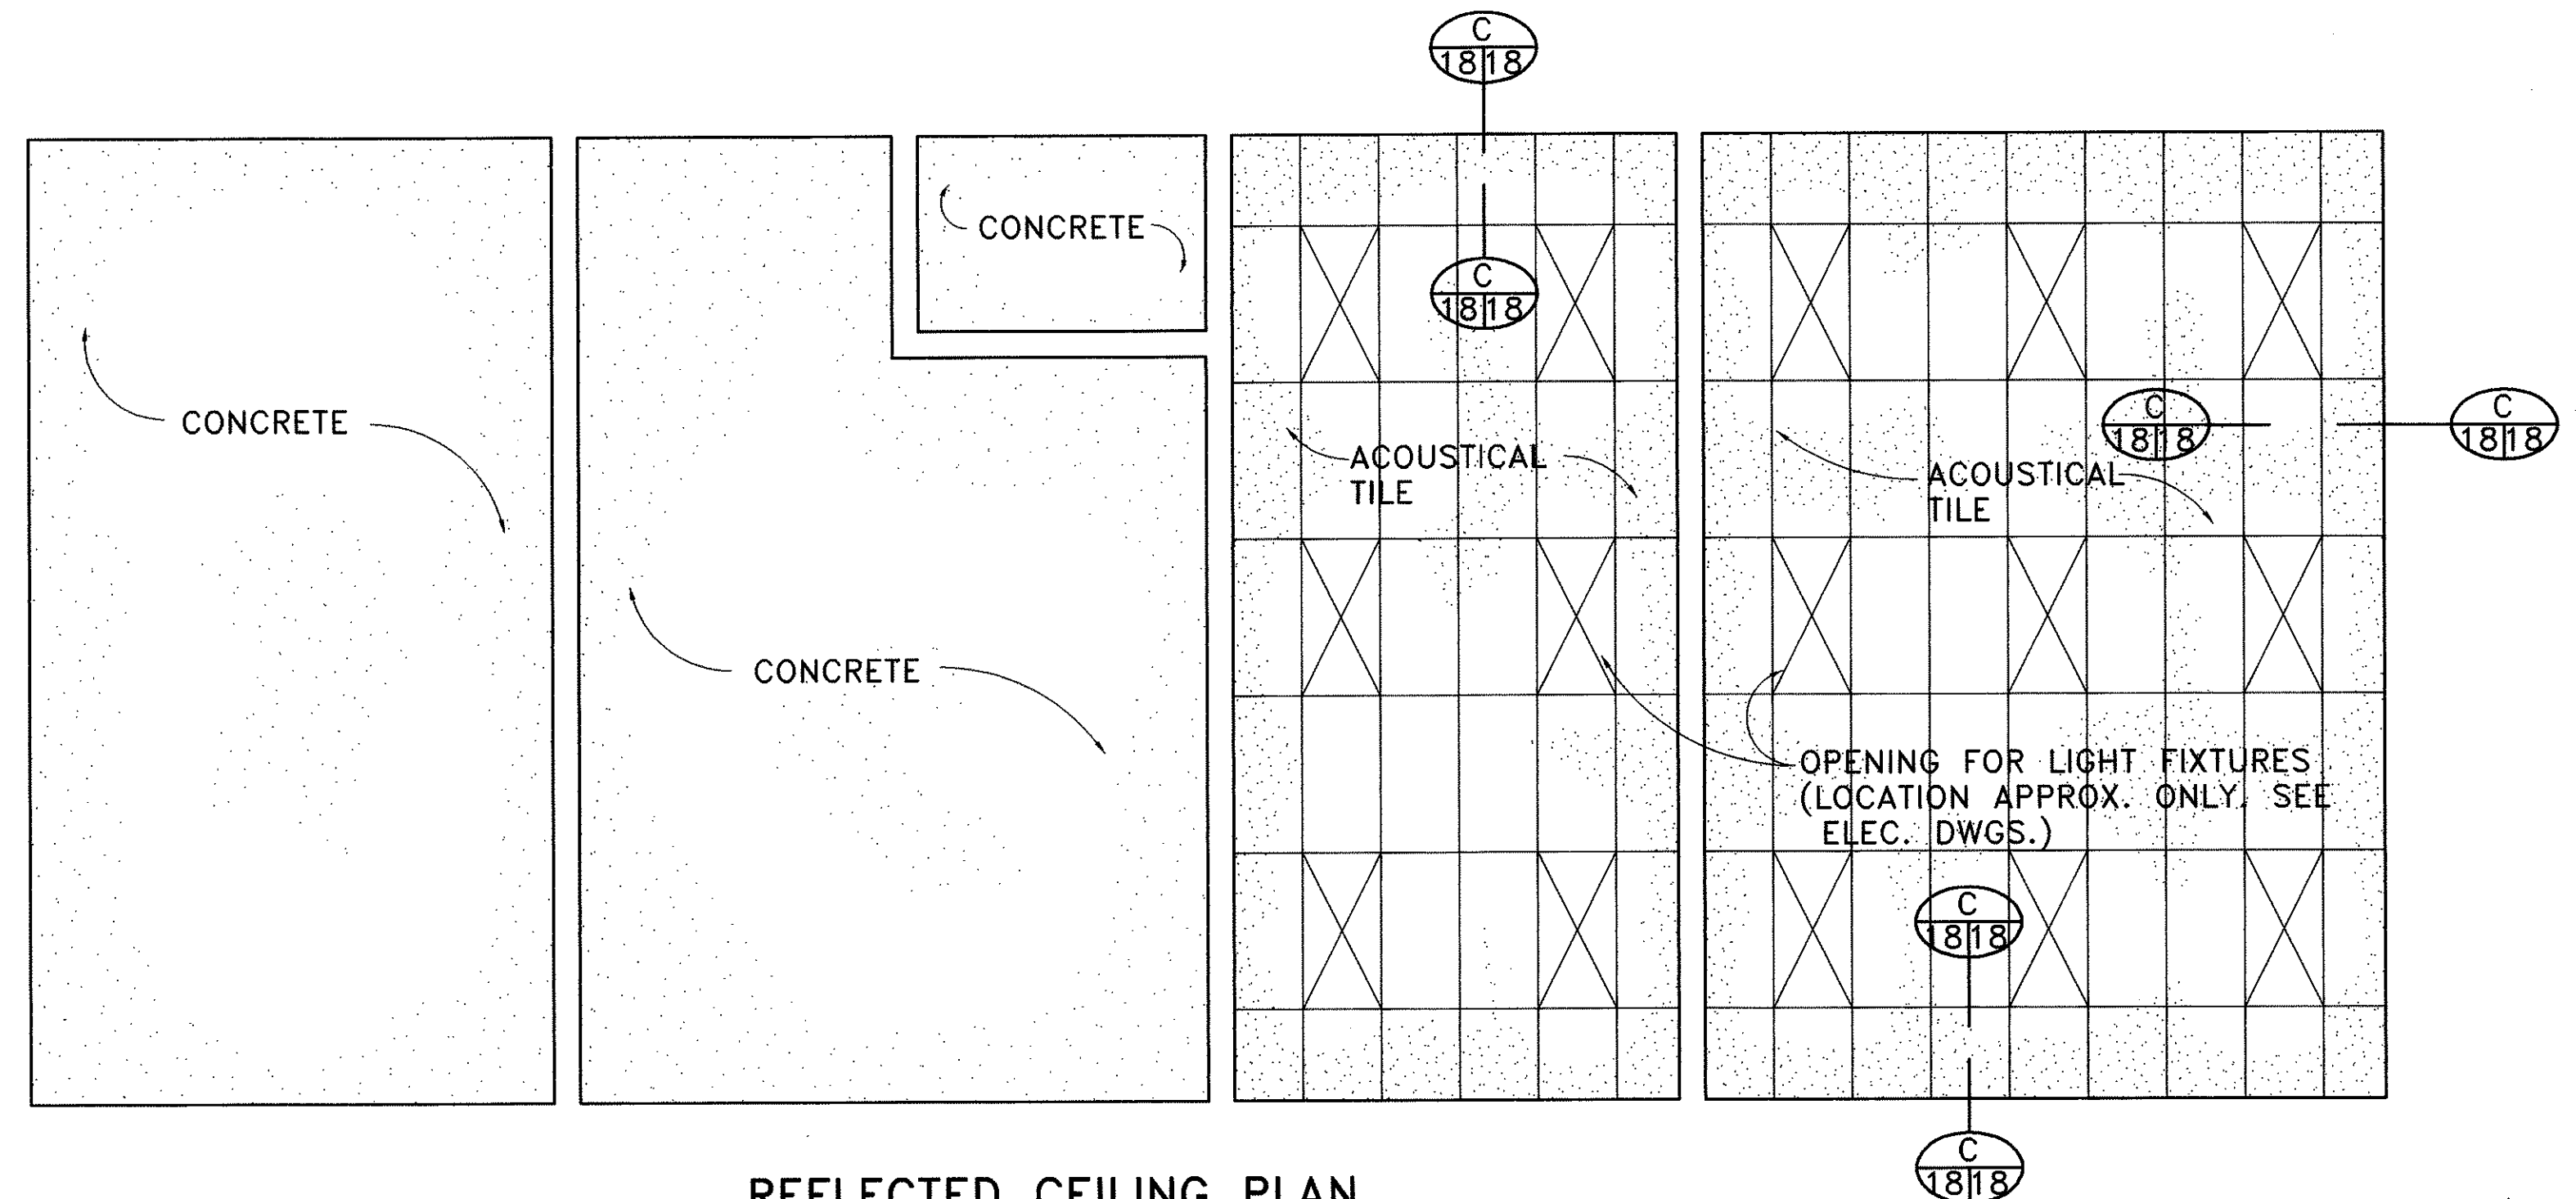

REFLECTED CEILING PLAN
SCALE: 1/4" = 1' 0"

SURVEY PLOTTED BY	DATE
DRAWN BY	
TRACED BY	
QUANTITIES BY	
CHECKED BY	
NO.	

THIS WORK WAS PREPARED BY ME OR UNDER MY SUPERVISION

STATE OF HAWAII
DEPARTMENT OF TRANSPORTATION
HIGHWAYS DIVISION


ROOF DETAILS

KANEHOE BASE YARD, PHASE II
ADMINISTRATION BUILDING
PROJECT NO. HWY-0-03-92

SCALE: AS NOTED DATE: 4/15/94

SHEET NO. 18 OF 35 SHEETS

FED. ROAD DIST. NO.	STATE	PROJ. NO.	FISCAL YEAR	SHEET NO.	TOTAL SHEETS
HAWAII	HAW.	HWY-0-03-92	1994	19	35

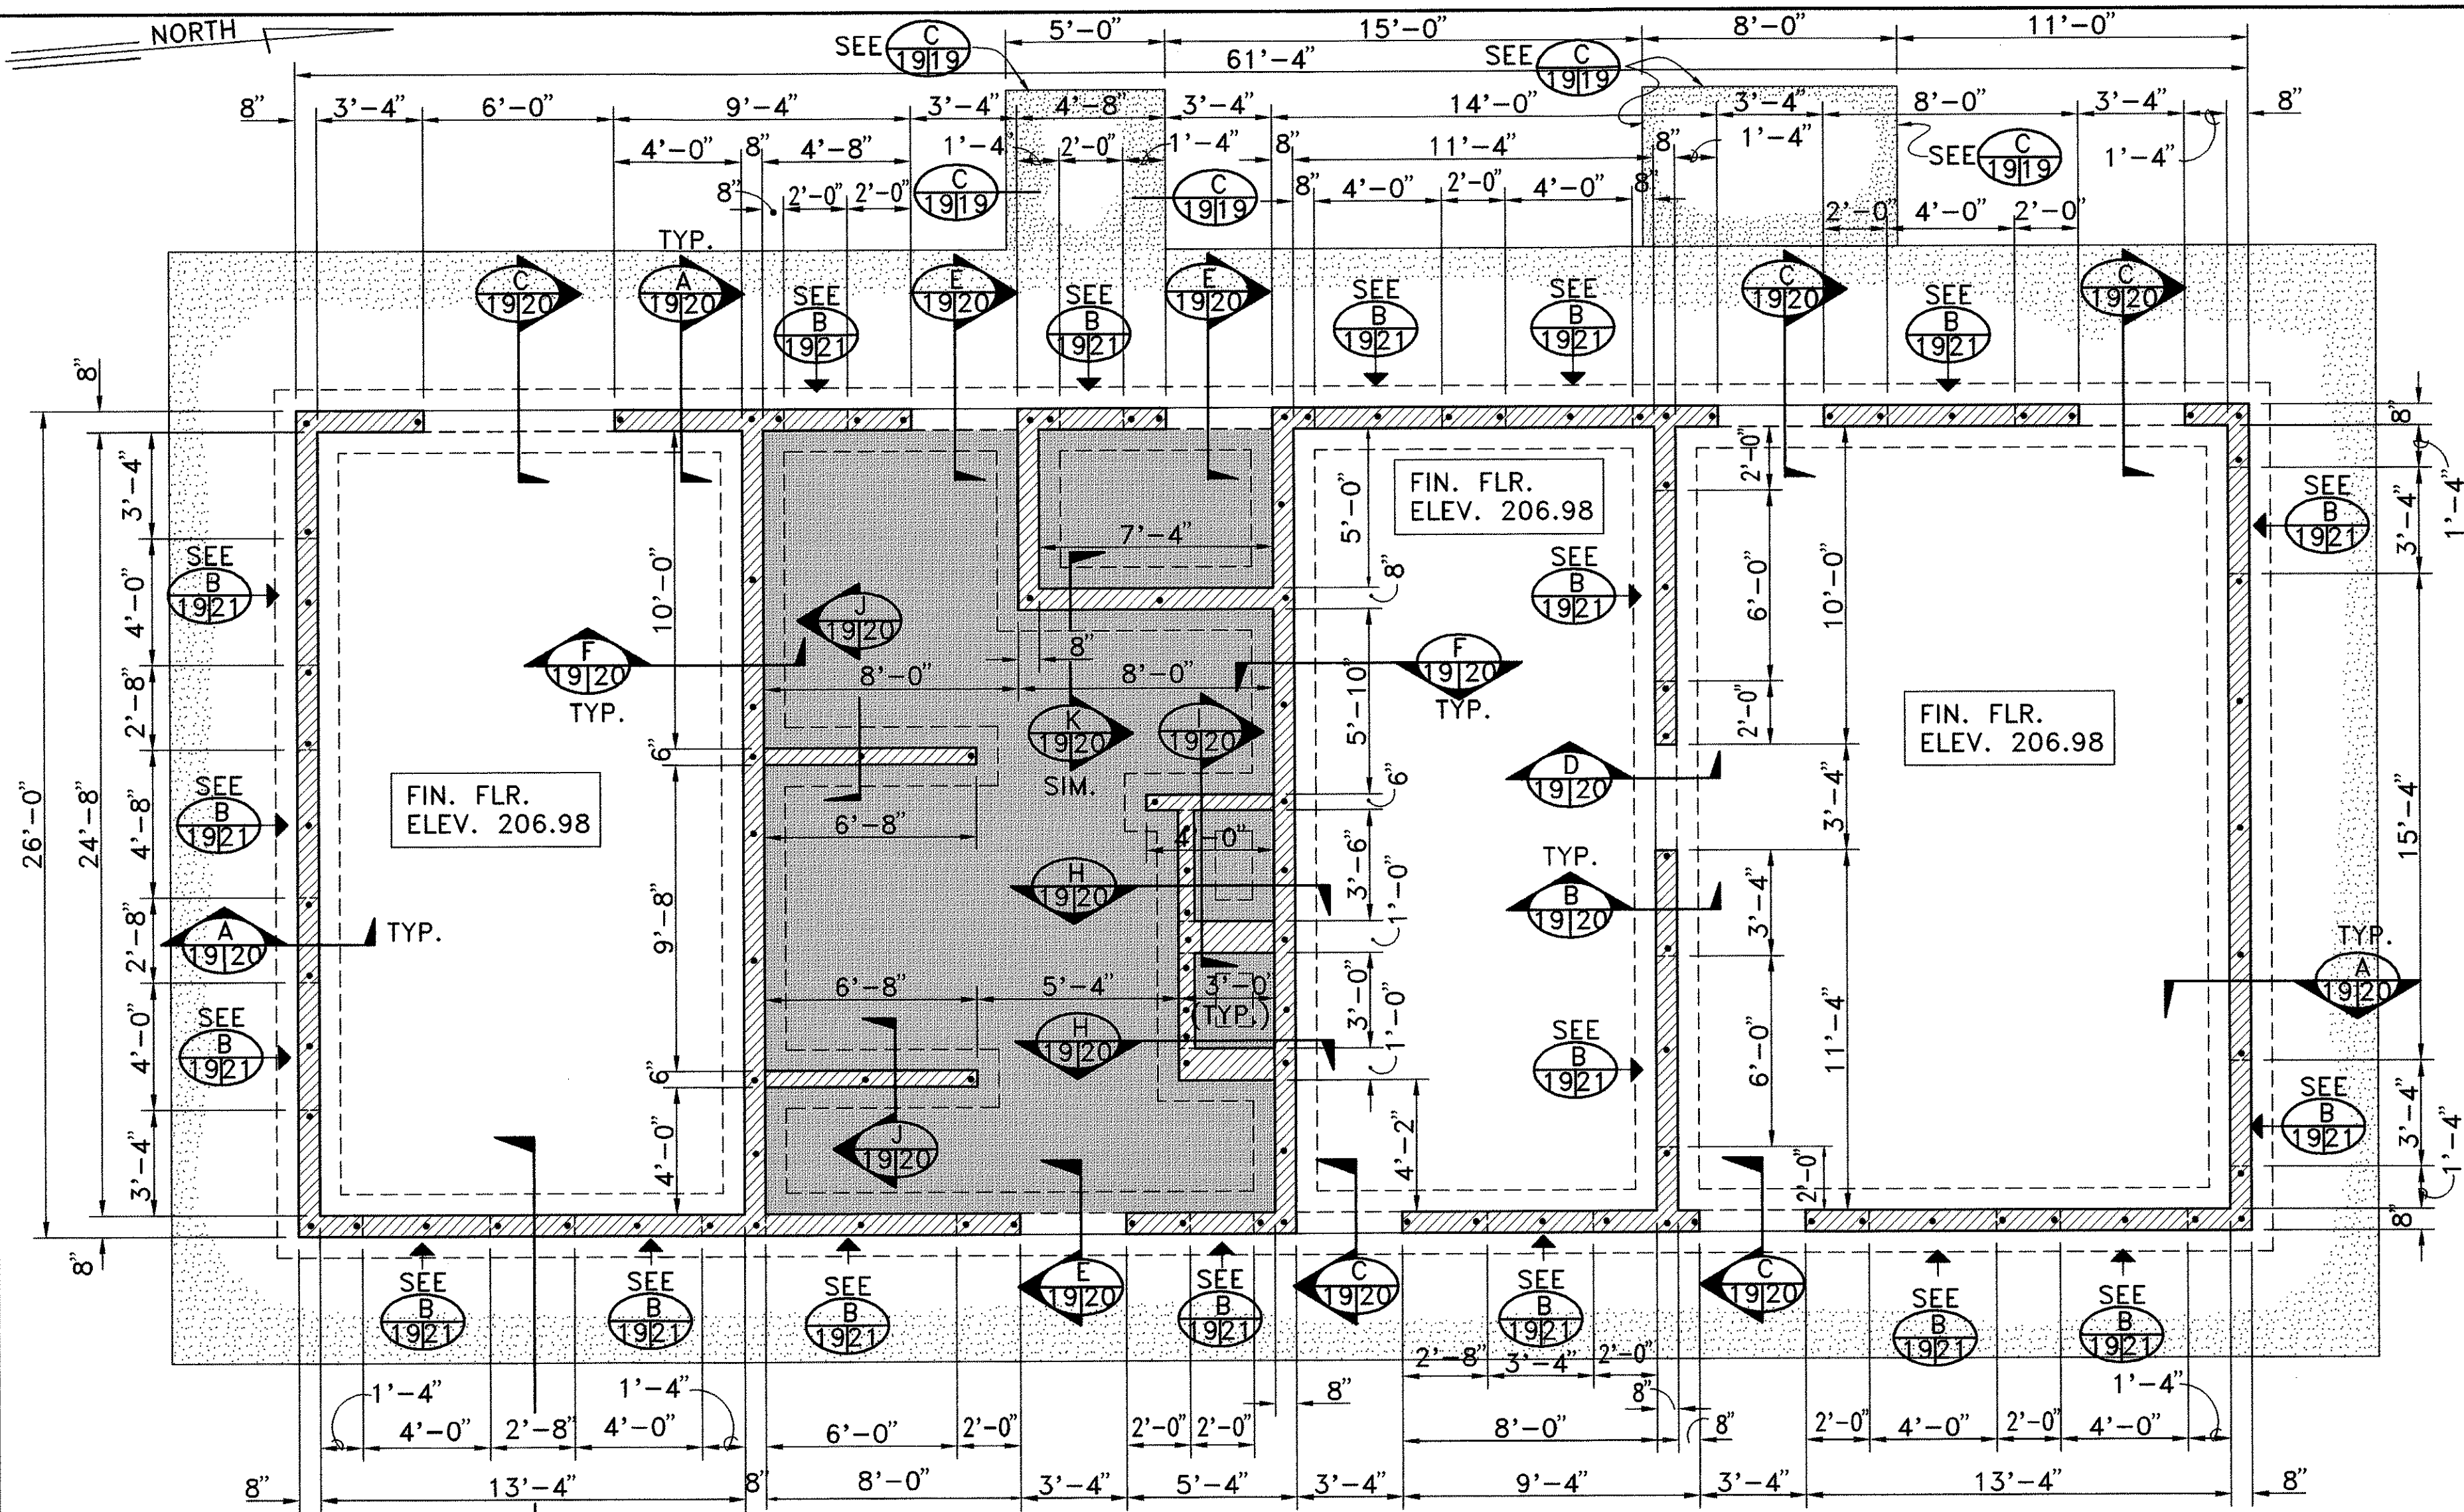

FOUNDATION PLAN
SCALE: 1/4" = 1' 0"


SHADED AREA INDICATES DEPRESSED SLAB AREA.

NOTE: FINISHED FLOOR ELEVATION INDICATED IS TO THE TOP OF THE FINISHED CONCRETE EXCEPT IN AREAS WHERE THE CONCRETE SLAB IS DEPRESSED.


GENERAL STRUCTURAL NOTES

- ALL CONCRETE MASONRY UNITS (CMU) SHALL CONFORM TO ASTM C90 FOR GRADE N, TYPE II UNITS. MORTAR SHALL BE TYPE M, $f'_c = 2,000$ PSI. GROUT SHALL HAVE AN ULTIMATE COMPRESSIVE STRENGTH OF 2,500 PSI. ALL UNITS SHALL BE LAID IN COMMON BOND.
- HORIZONTAL MASONRY JOINT REINFORCING SHALL BE "DUR-O-WALL" OR APPROVED EQUAL. SIDE RODS AND CROSS RODS SHALL BE 9 GAUGE. JOINT REINFORCING SHALL BE INSTALLED AT 16" O.C. IN ALL CMU WALLS.
- CLASSES OF CONCRETE:
A. ROOF FILL: CLASS "C".
B. ALL OTHERS: CLASS "A".
- REINFORCING STEEL: ASTM A 615, GRADE 40.
- 1 - #4 BAR SHALL BE PLACED AT ALL WINDOW AND DOOR JAMBS, WALL CORNERS, ENDS AND INTERSECTIONS.
- INTERIOR FLOOR SLABS AND EXTERIOR WALKWAY SLABS SHALL BE OF 4" THICK CONCRETE REINFORCED WITH 6 X 6 X W1.4 X W1.4 WELDED WIRE FABRIC AND AND SHALL BE UNDERLAIN WITH 4" OF BASE COURSE. ADDITIONALLY, ALL INTERIOR FLOOR SLABS SHALL BE UNDERLAIN WITH VAPOR BARRIER.
- A BOND BREAKER CONSISTING OF 2 LAYERS OF 30# ASPHALT ROOFING FELT, CONFORMING TO ASTM D 226, TYPE II, SHALL BE PROVIDED WHEREVER INTERIOR FLOOR SLABS ABUT VERTICAL SURFACES.
- A 1/2" WIDE EXPANSION JOINT SHALL BE PROVIDED WHEREVER EXTERIOR WALKWAY SLABS ABUT VERTICAL SURFACES.


- DESIGN LOADS:
ROOF LIVE LOAD: 20 PSF.
WIND SPEED: 80 MPH.
EARTHQUAKE INTENSITY: ZONE 2A.
- ALLOWABLE SOIL BEARING PRESSURE: 3,000 PSF.
- SEE SHEET 24 FOR ADDITIONAL NOTES ON STRUCTURAL STEEL CONSTRUCTION.
- ENTIRE AREA WITHIN EXTERIOR WALL LINES SHALL BE TREATED FOR TERMITES.

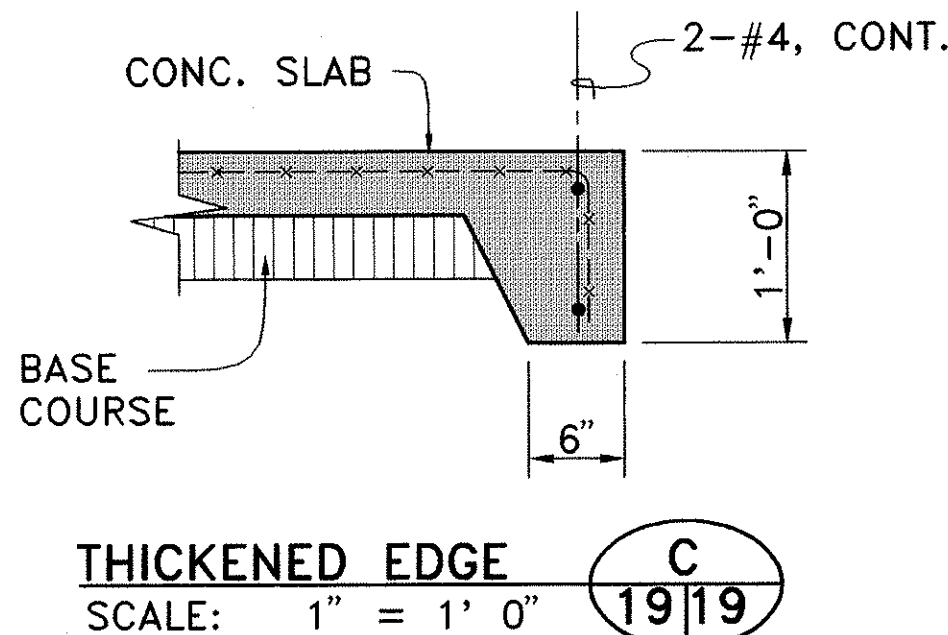


THICKENED EDGE
SCALE: 1" = 1' 0"

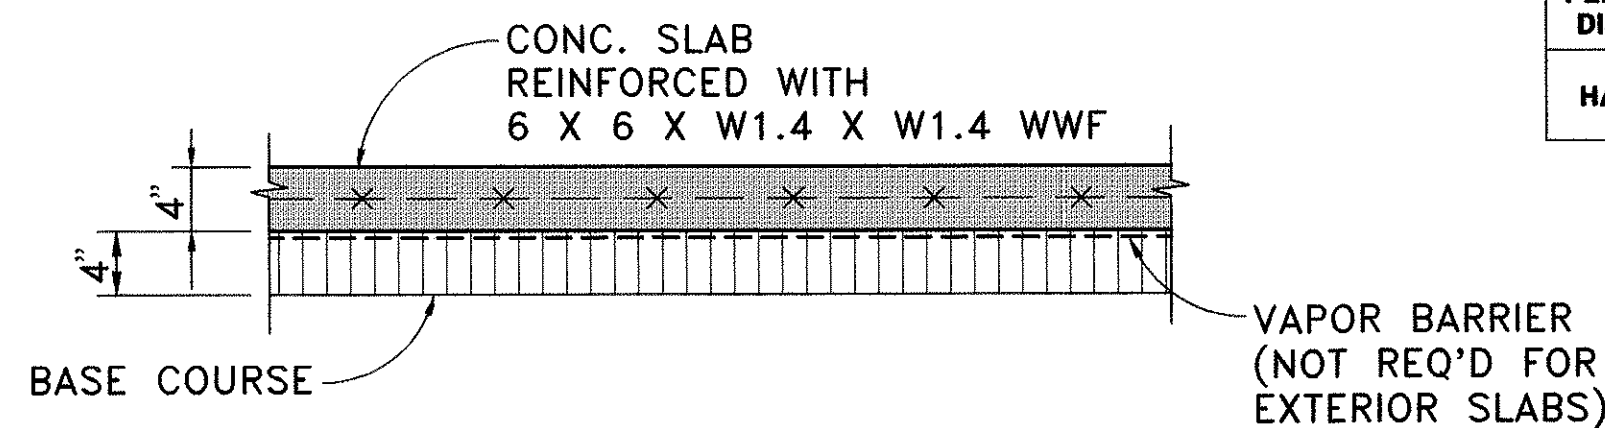


TYPICAL CONCRETE SLAB
SCALE: 1" = 1' 0"

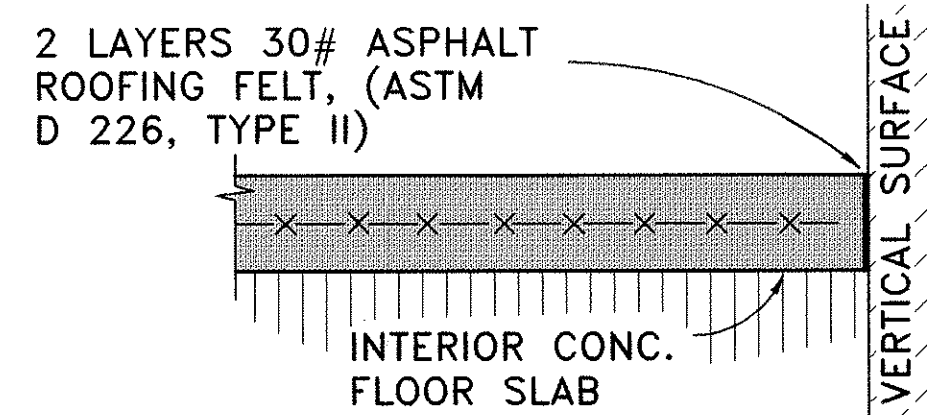


INTERIOR FLOOR JOINT
SCALE: 1" = 1' 0"

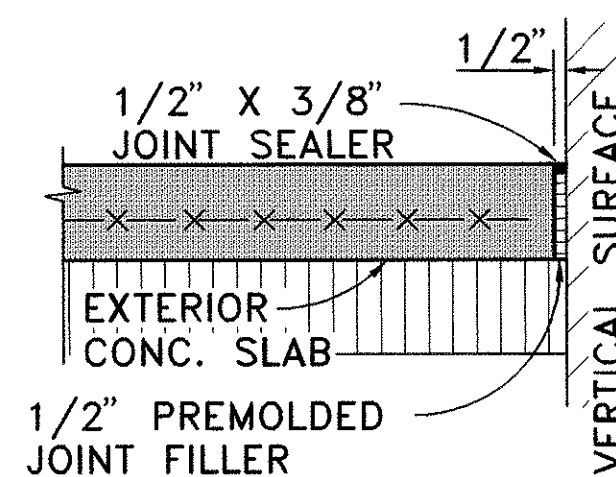

EXTERIOR SLAB
EXPANSION JOINT
SCALE: 1" = 1' 0"

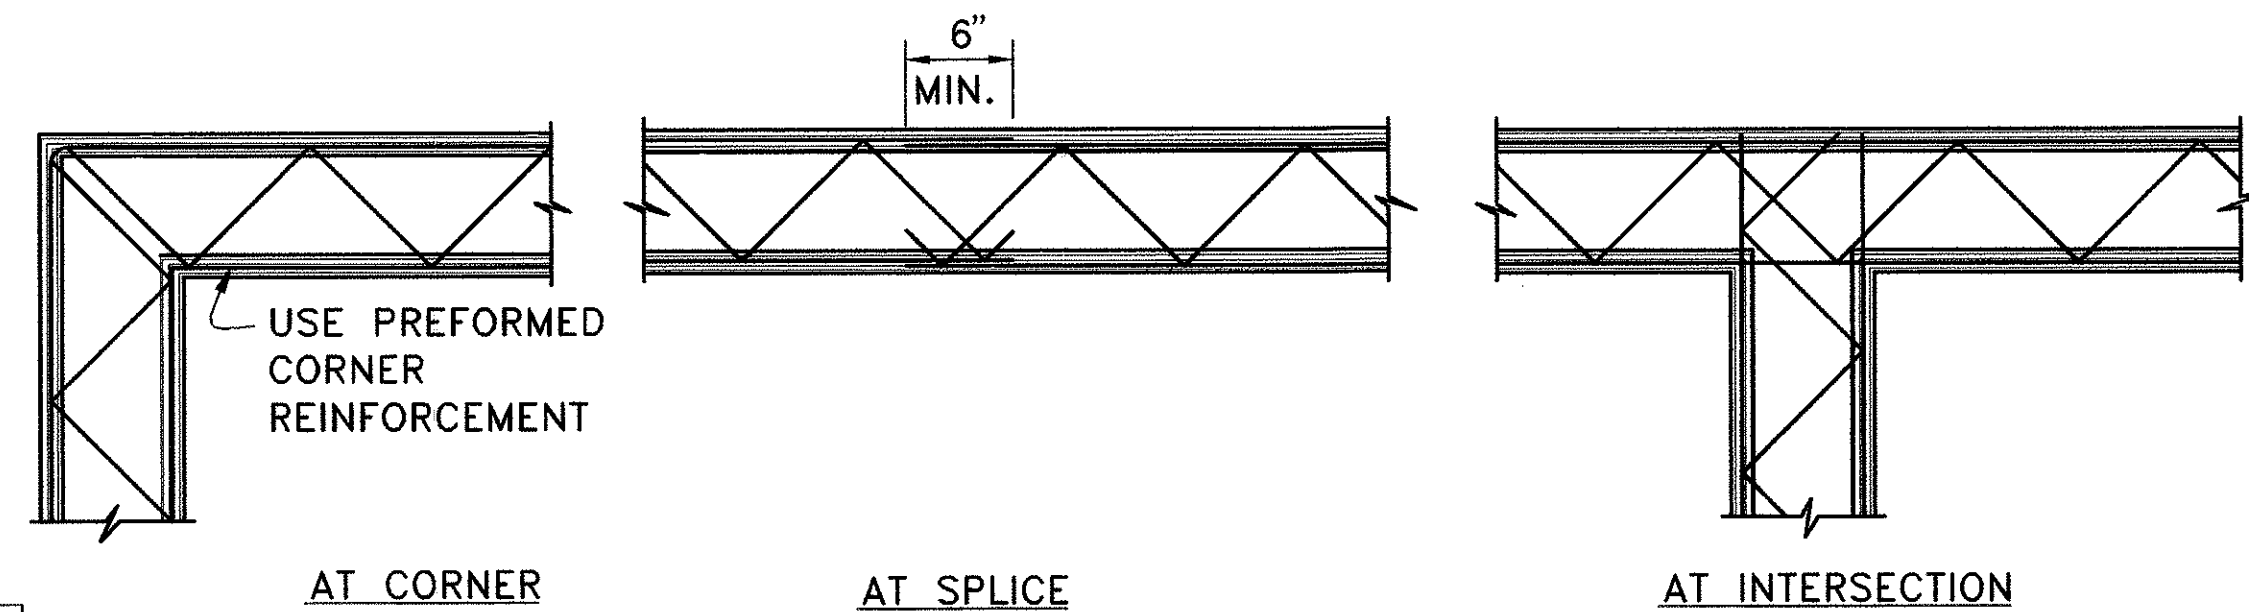


HORIZONTAL MASONRY JOINT REINFORCING DETAILS
NOT TO SCALE

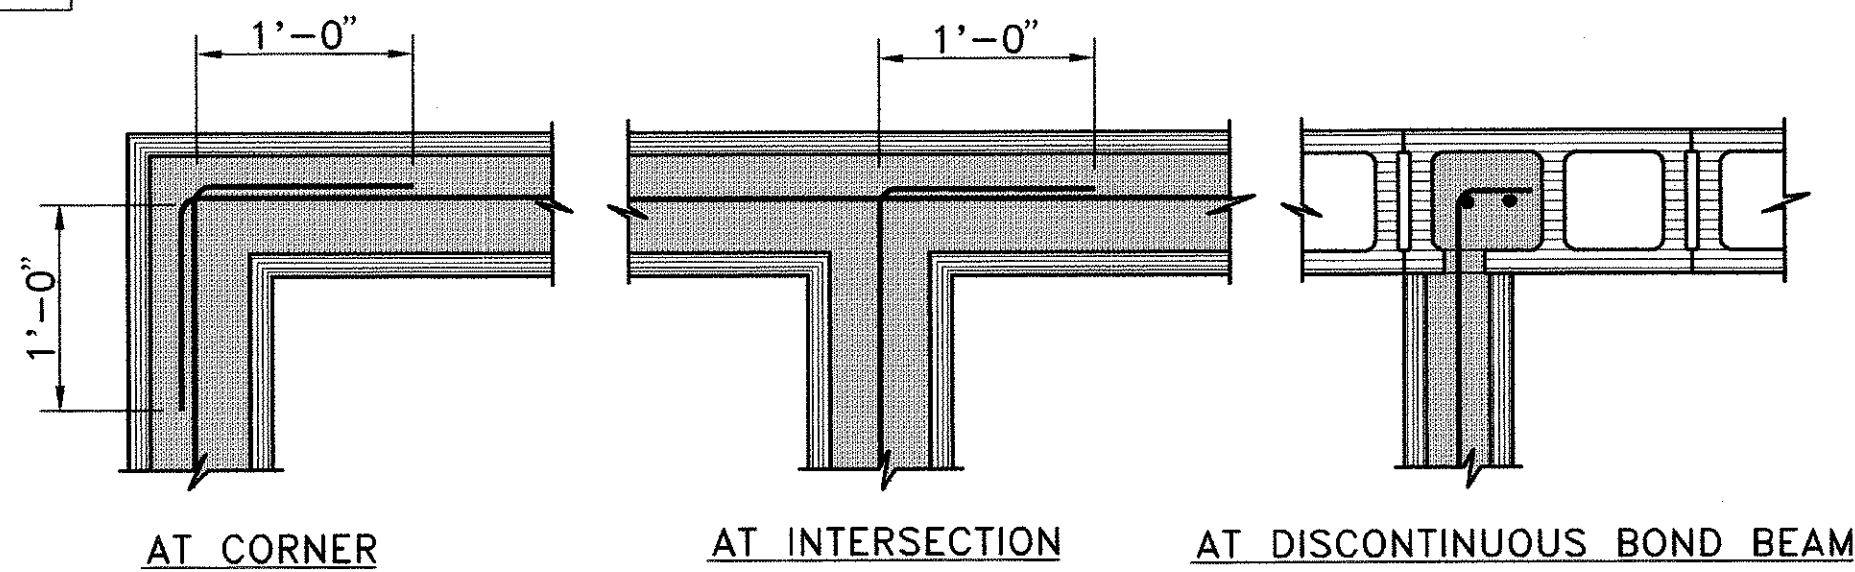

HORIZONTAL REINFORCING STEEL SPLICE
NOT TO SCALE

9/15/94	REVISED SHOWER STALLS. ADDED ACCESS. WALK.
6/17/94	ADDED THICKENED EDGE DETAIL. REVISED FOUNDATION PLAN TO SHOW CONC. WALK AROUND BLDG. ADDED NOTE NO. 12. REVISED SECTION ARROWS ON FDN PLAN.
DATE	REVISION

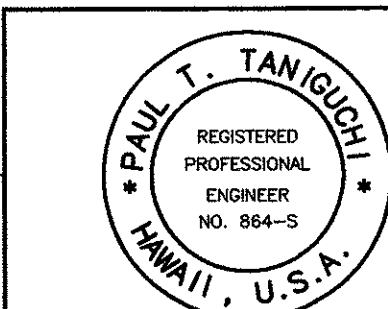

THIS WORK WAS PREPARED BY
ME OR UNDER MY SUPERVISION
Paul T. Taniguchi

STATE OF HAWAII
DEPARTMENT OF TRANSPORTATION
HIGHWAYS DIVISION

FOUNDATION PLAN

KANEHOE BASE YARD, PHASE II


ADMINISTRATION BUILDING

PROJECT NO. HWY-0-03-92

SCALE: AS NOTED DATE: 4/15/94


SHEET NO. 19 OF 35 SHEETS

FED. ROAD DIST. NO.	STATE	PROJ. NO.	FISCAL YEAR	SHEET NO.	TOTAL SHEETS
HAWAII	HAW.	HWY-0-03-92	1994	20	35

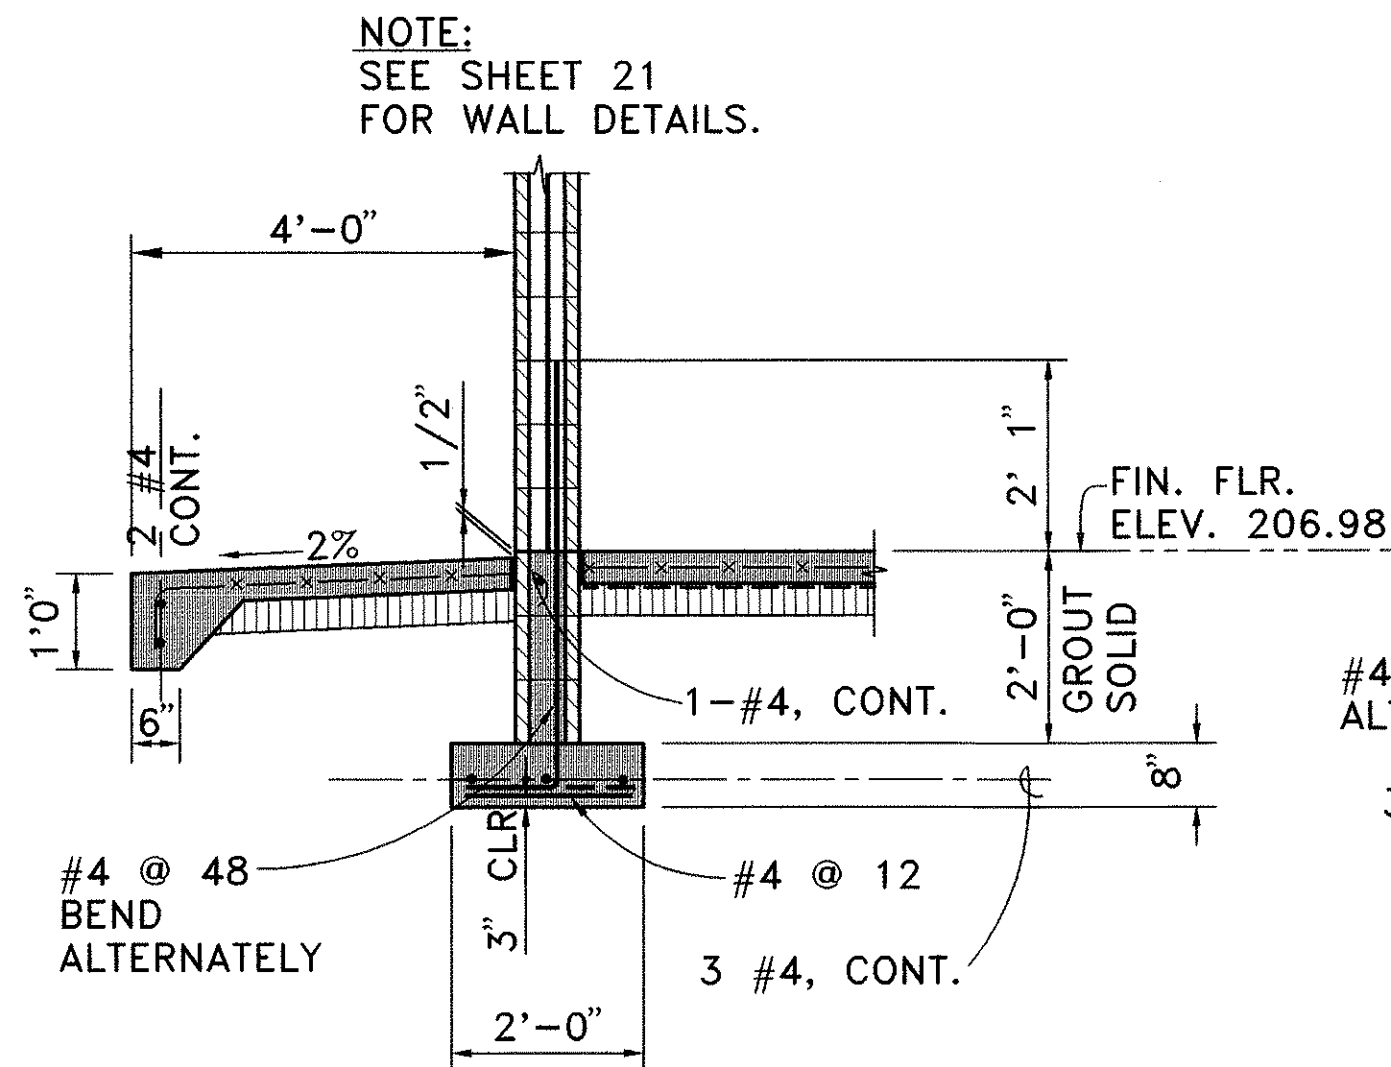


AT EXTERIOR WALL

SECTION **A**
SCALE: 1/2" = 1' 0"
19/20

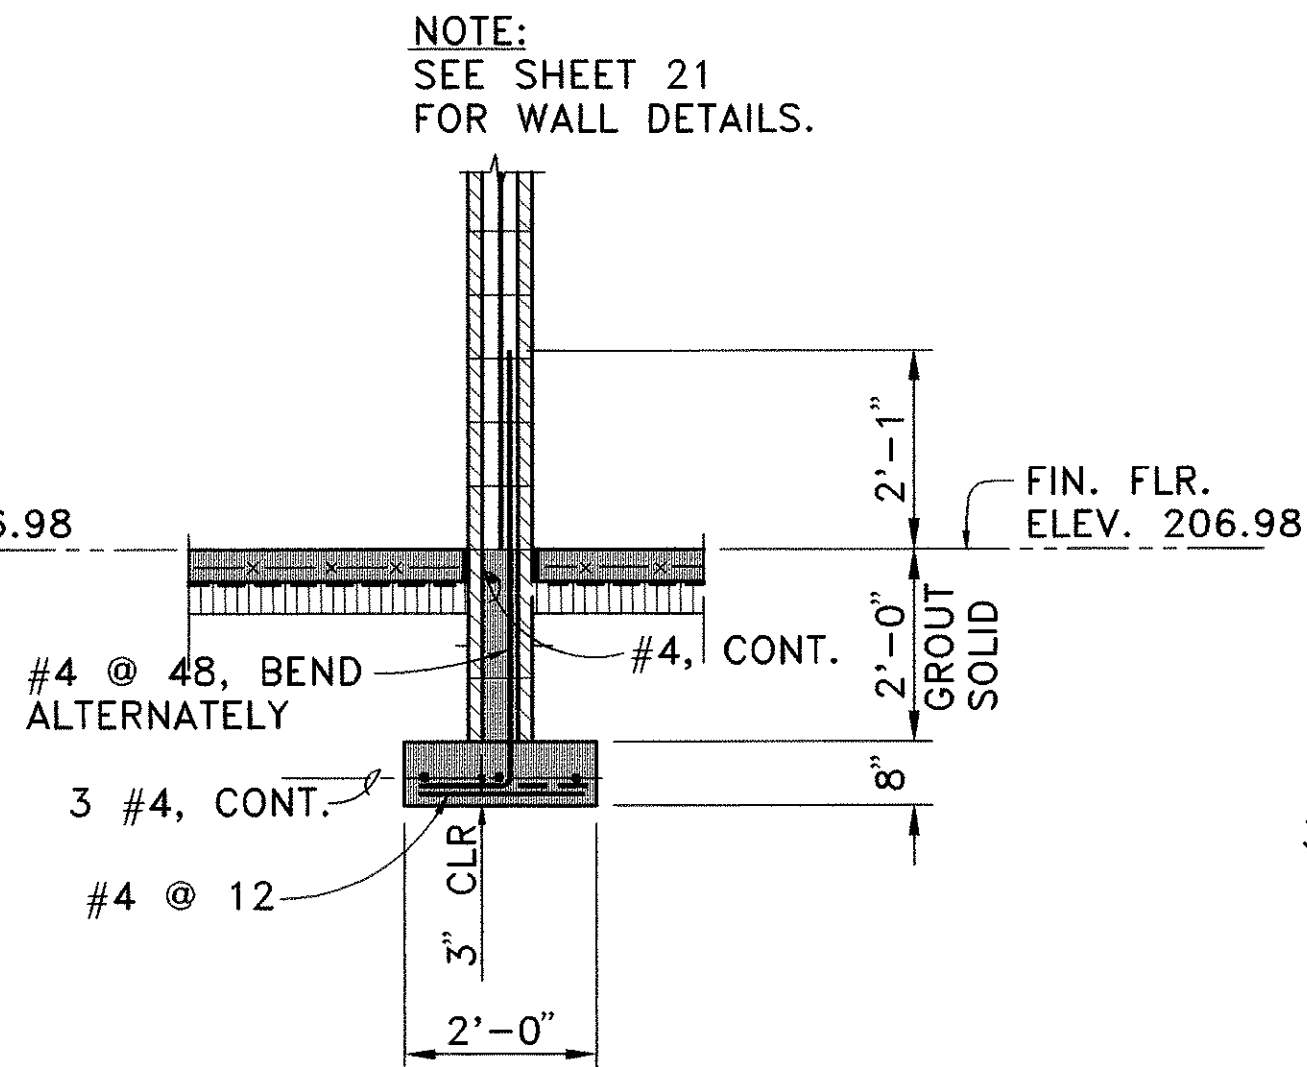


AT INTERIOR WALL

SECTION **B**
SCALE: 1/2" = 1' 0"
19/20

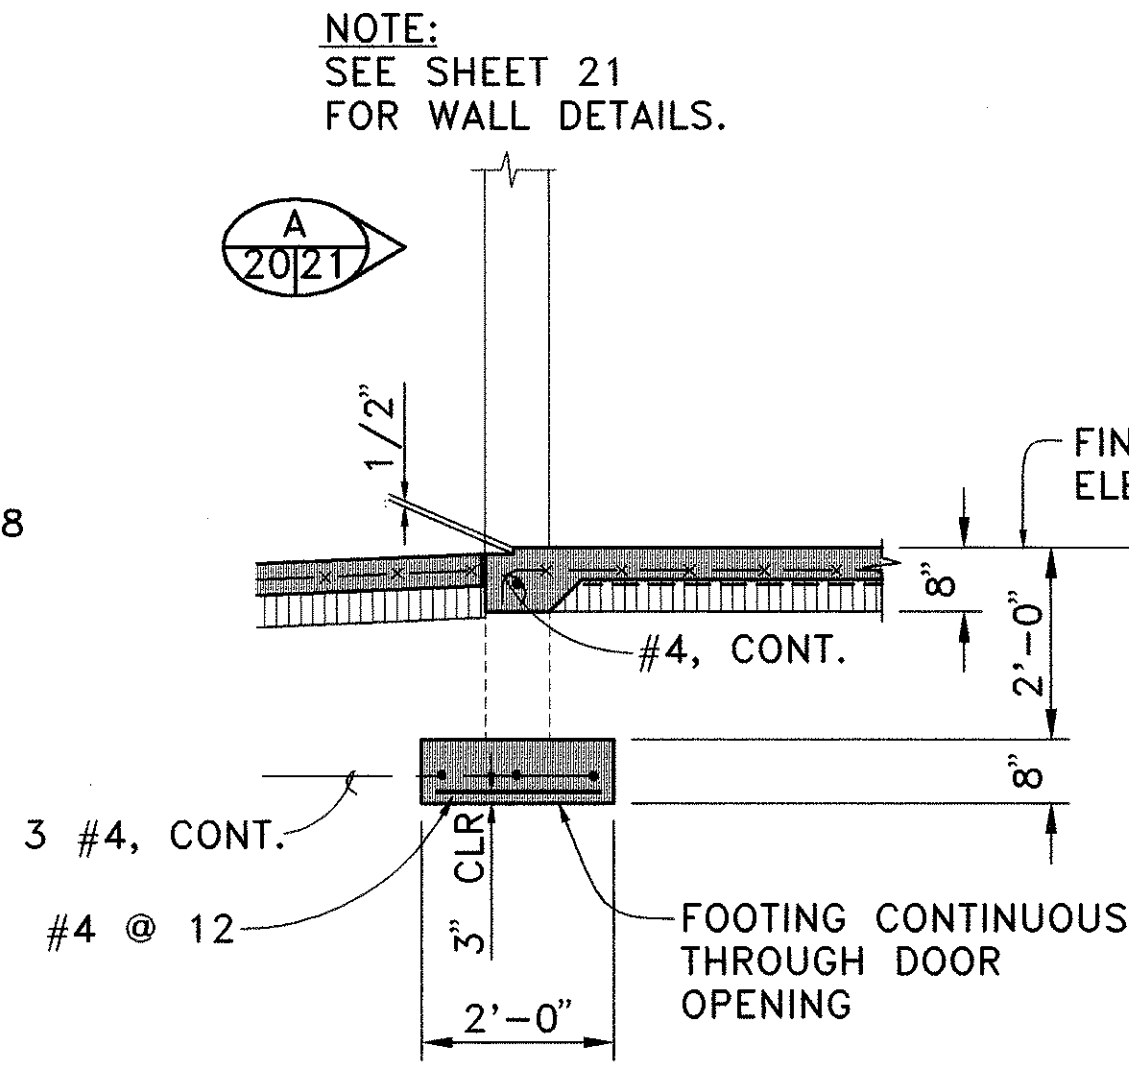


AT EXTERIOR DOOR OPENING

SECTION **C**
SCALE: 1/2" = 1' 0"
19/20

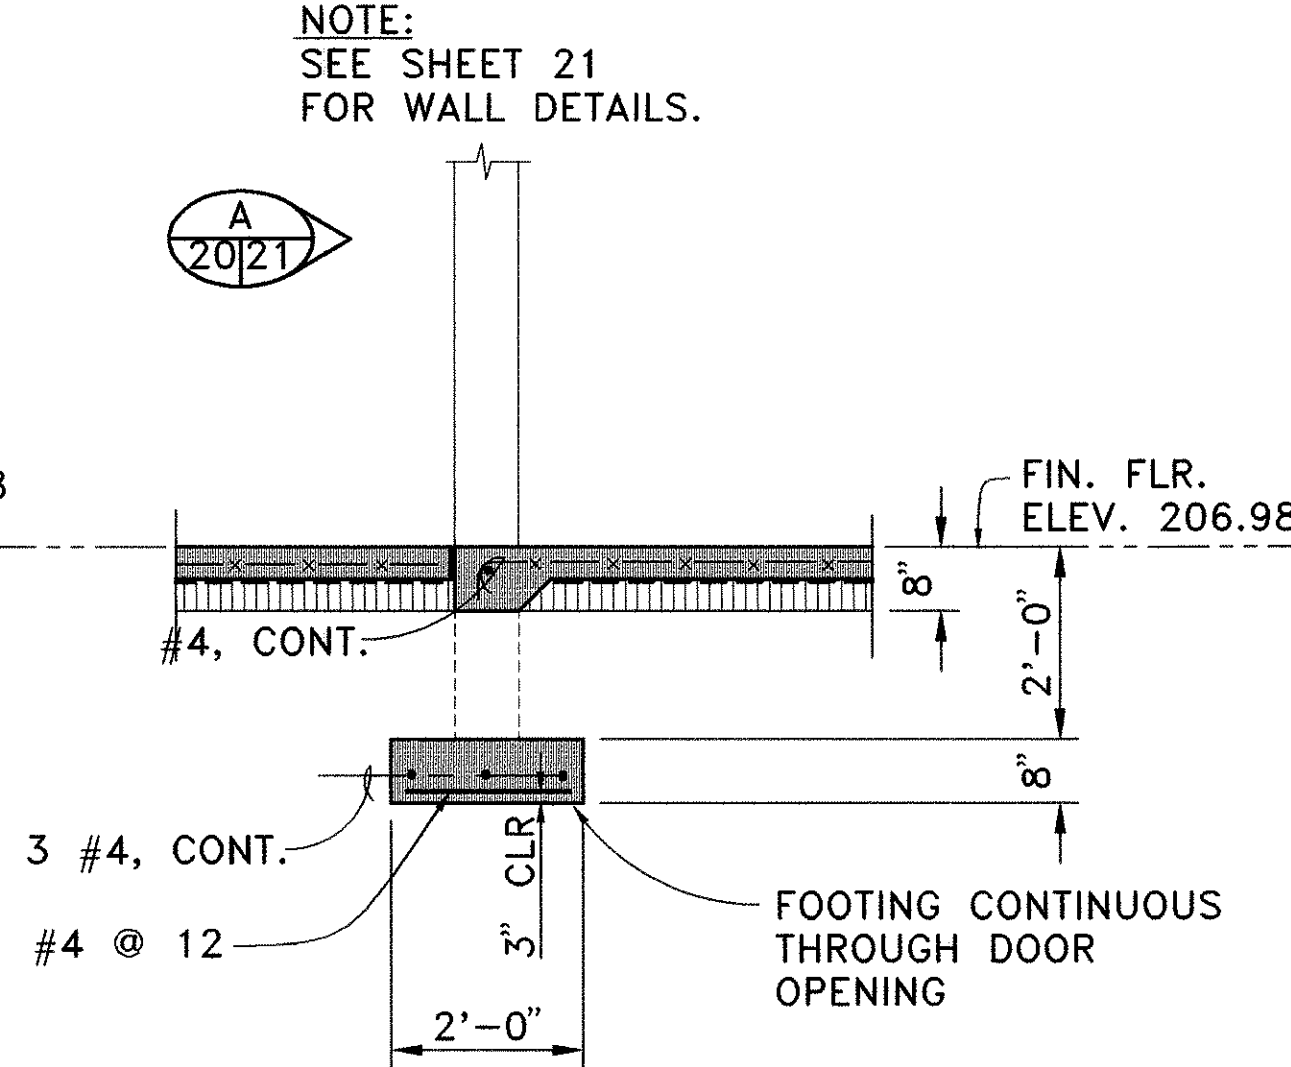


AT INTERIOR DOOR OPENING

SECTION **D**
SCALE: 1/2" = 1' 0"
19/20

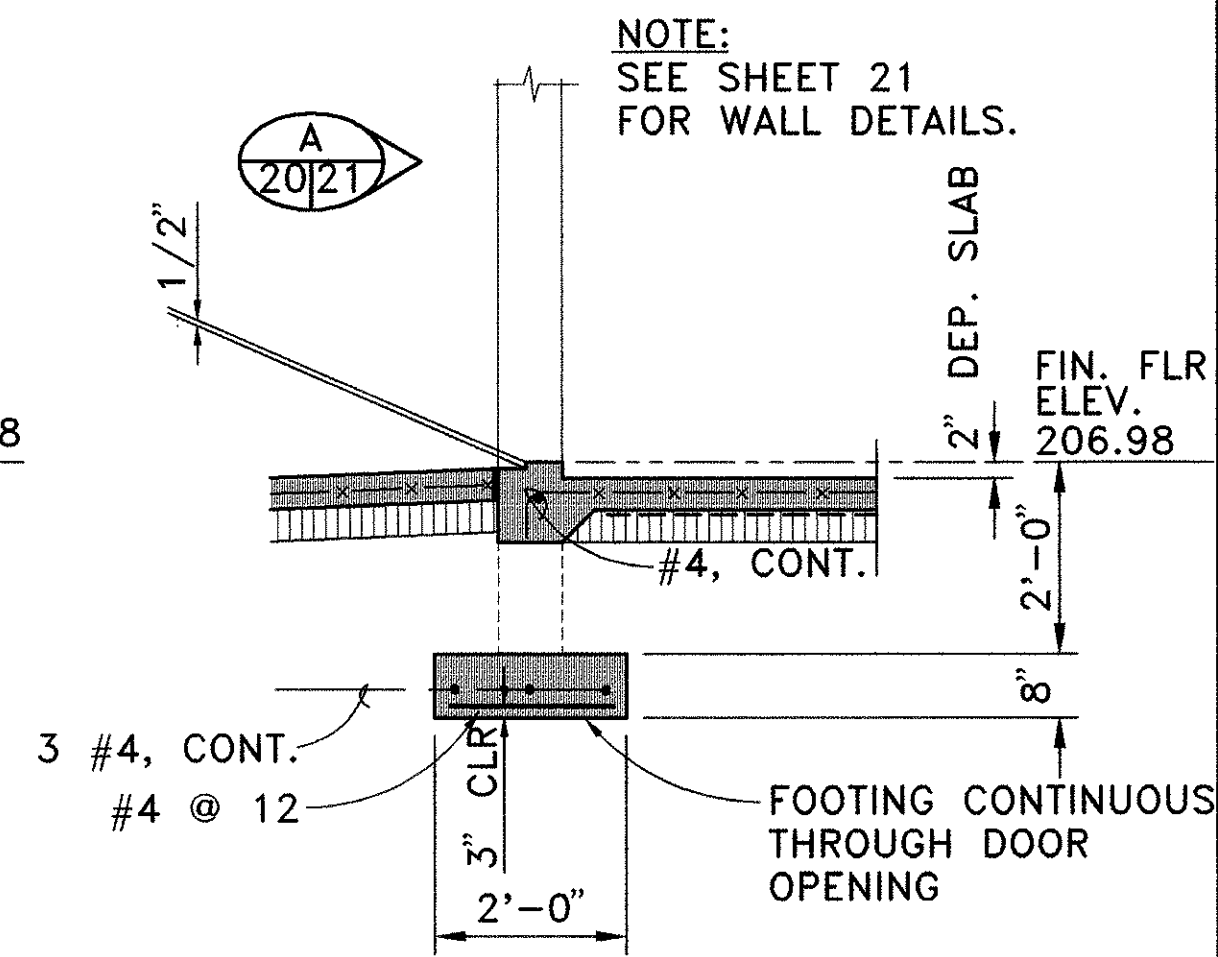


EXTERIOR DOOR OPENING
AT DEPRESSED SLAB

SECTION **E**
SCALE: 1/2" = 1' 0"
19/20

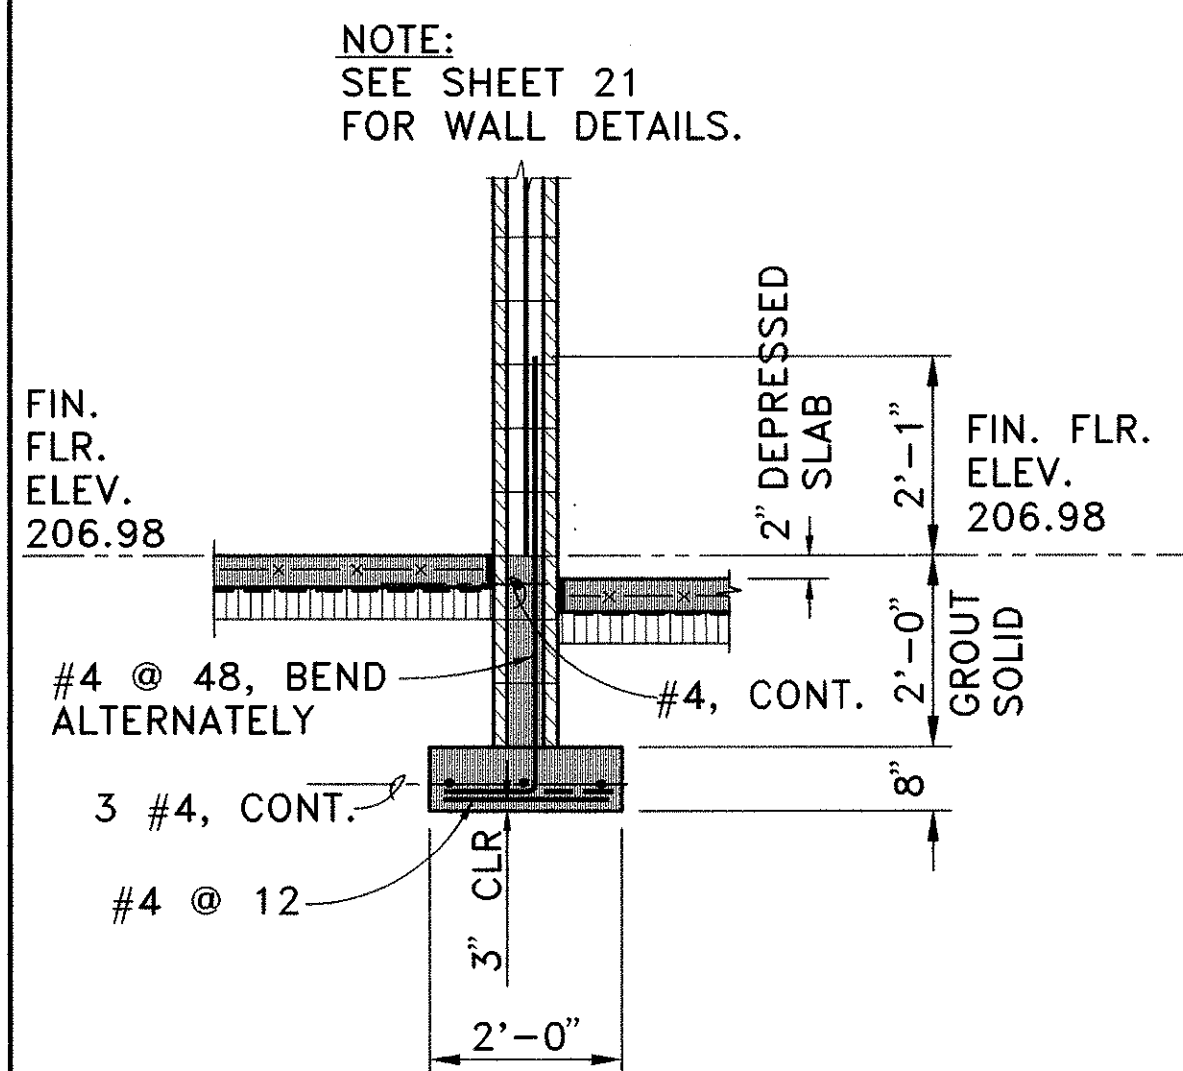


AT DEPRESSED SLAB

SECTION **F**
SCALE: 1/2" = 1' 0"
19/20

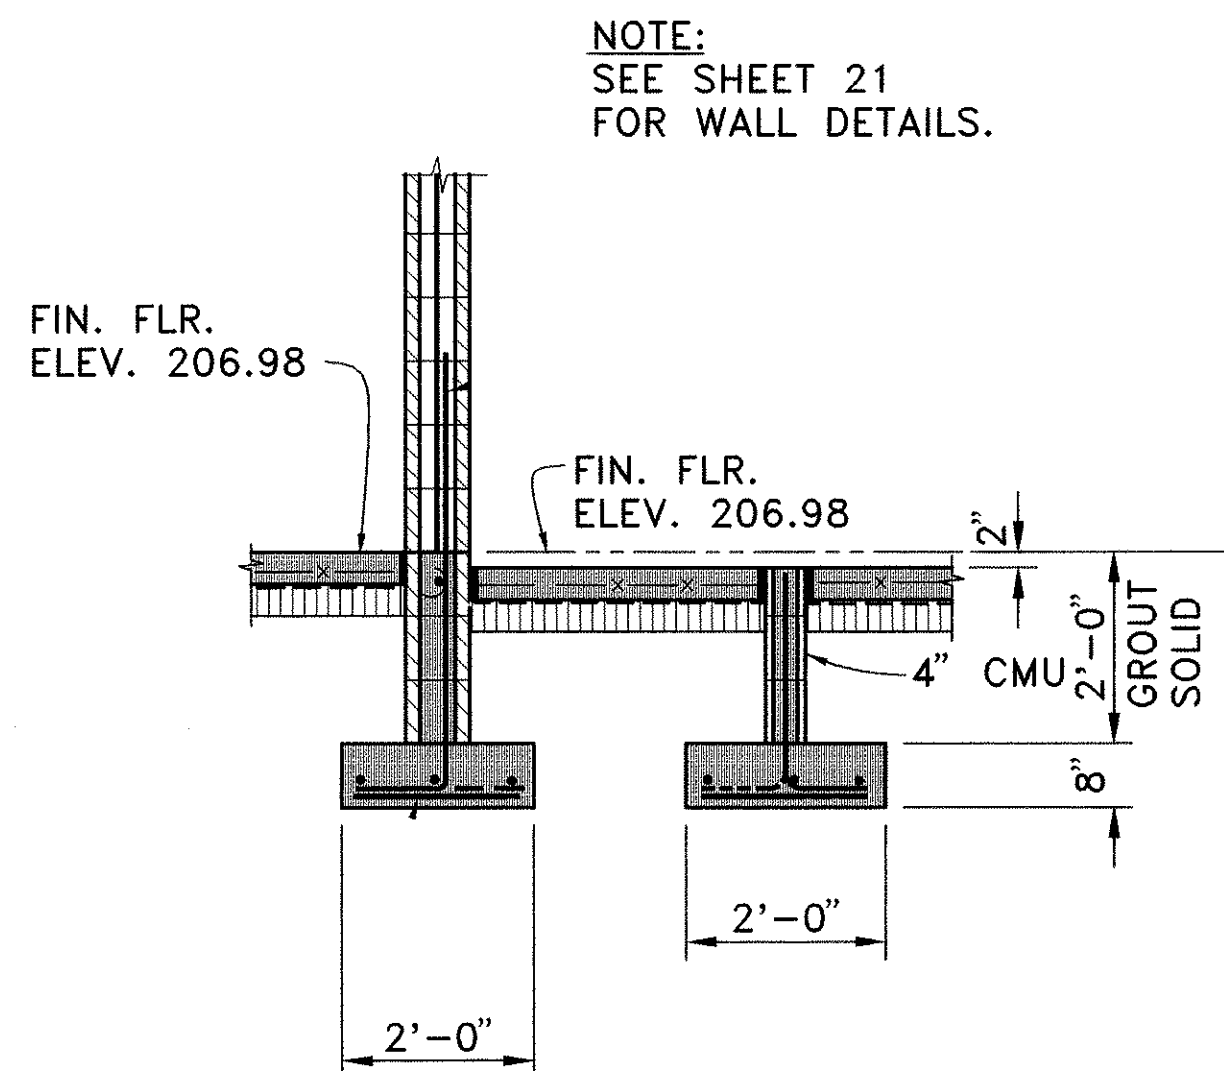


AT SHOWER

SECTION **H**
SCALE: 1/2" = 1' 0"
19/20

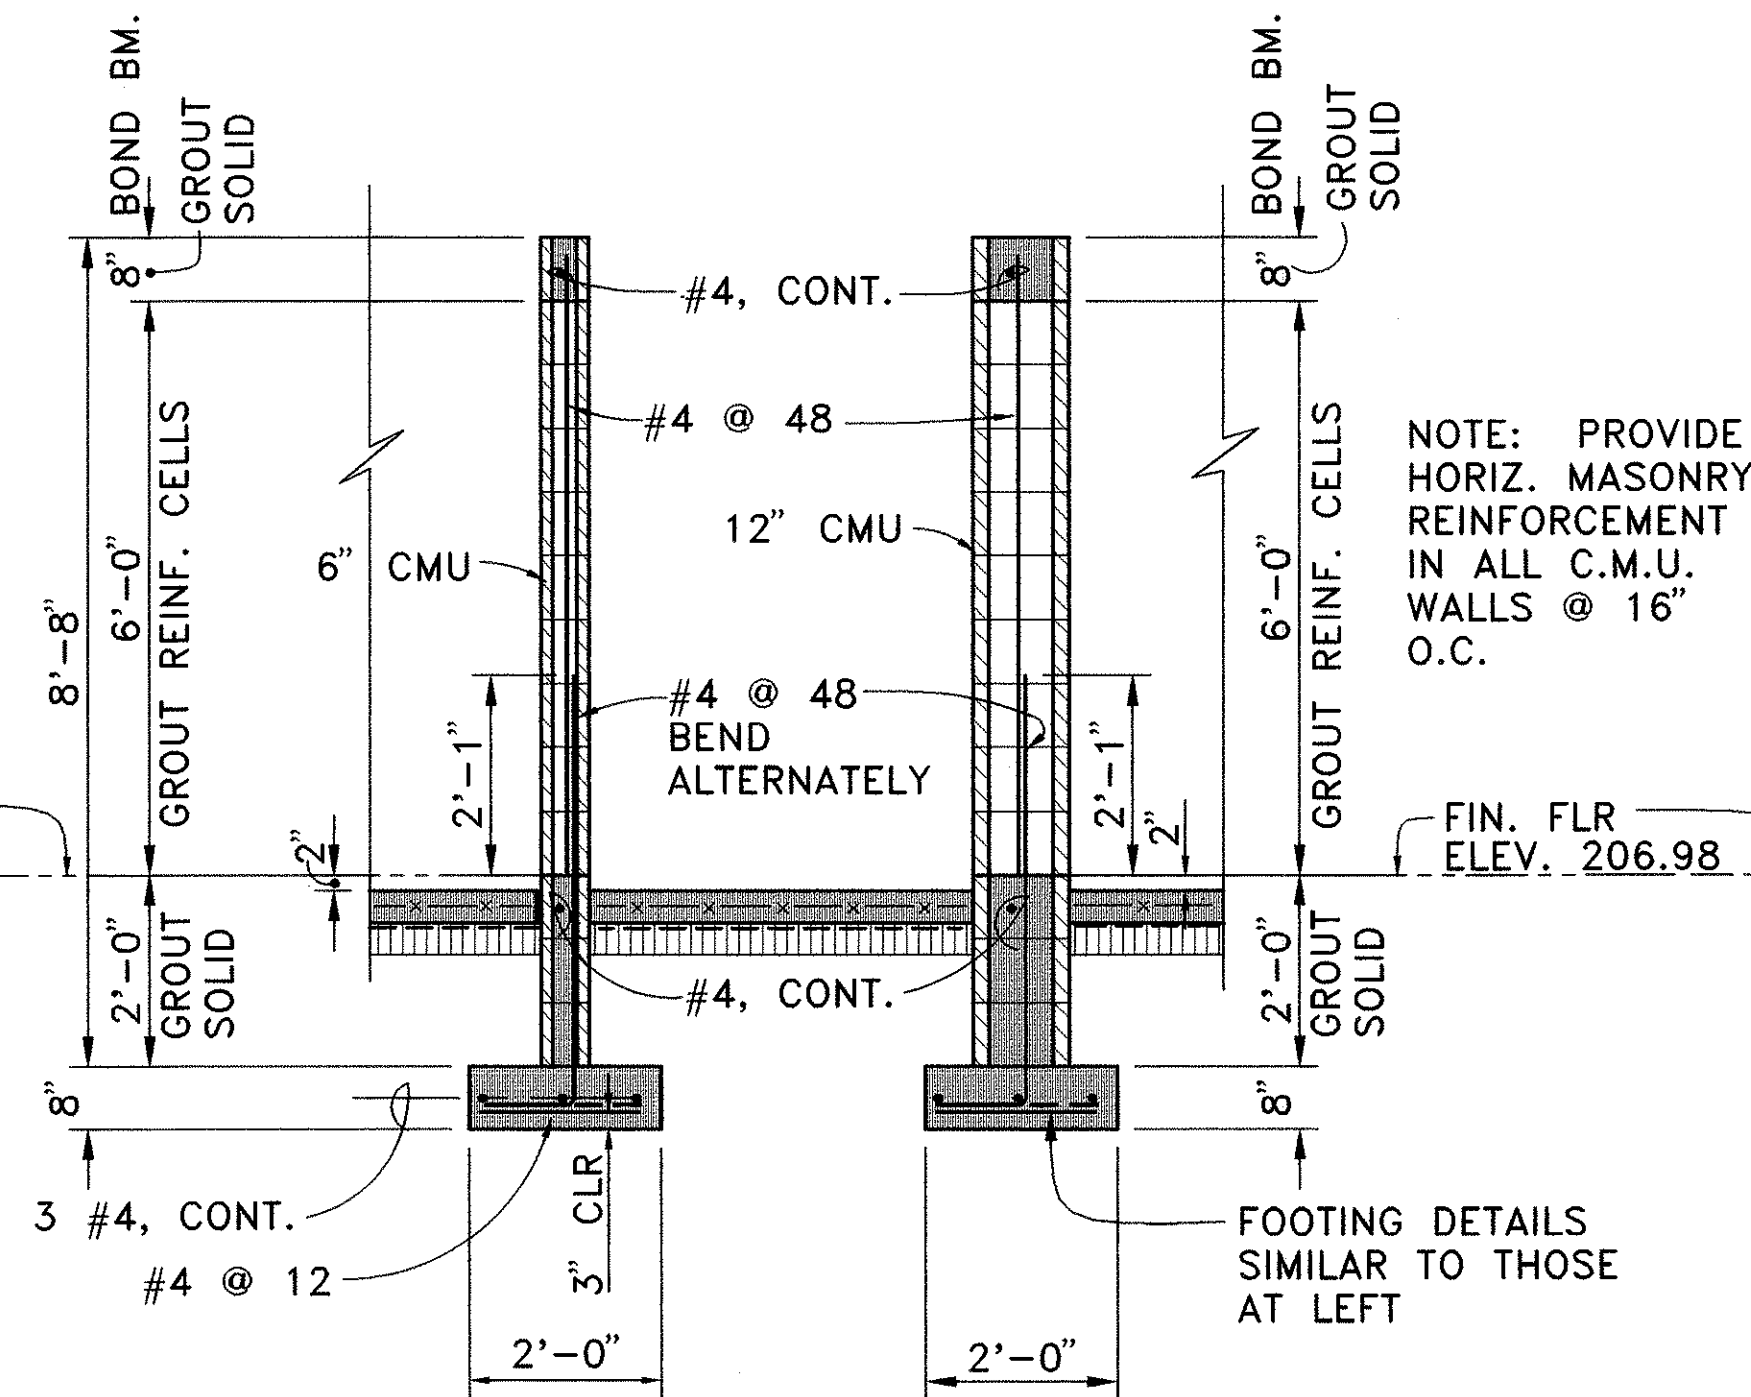


AT SHOWER

SECTION **I**
SCALE: 1/2" = 1' 0"
19/20

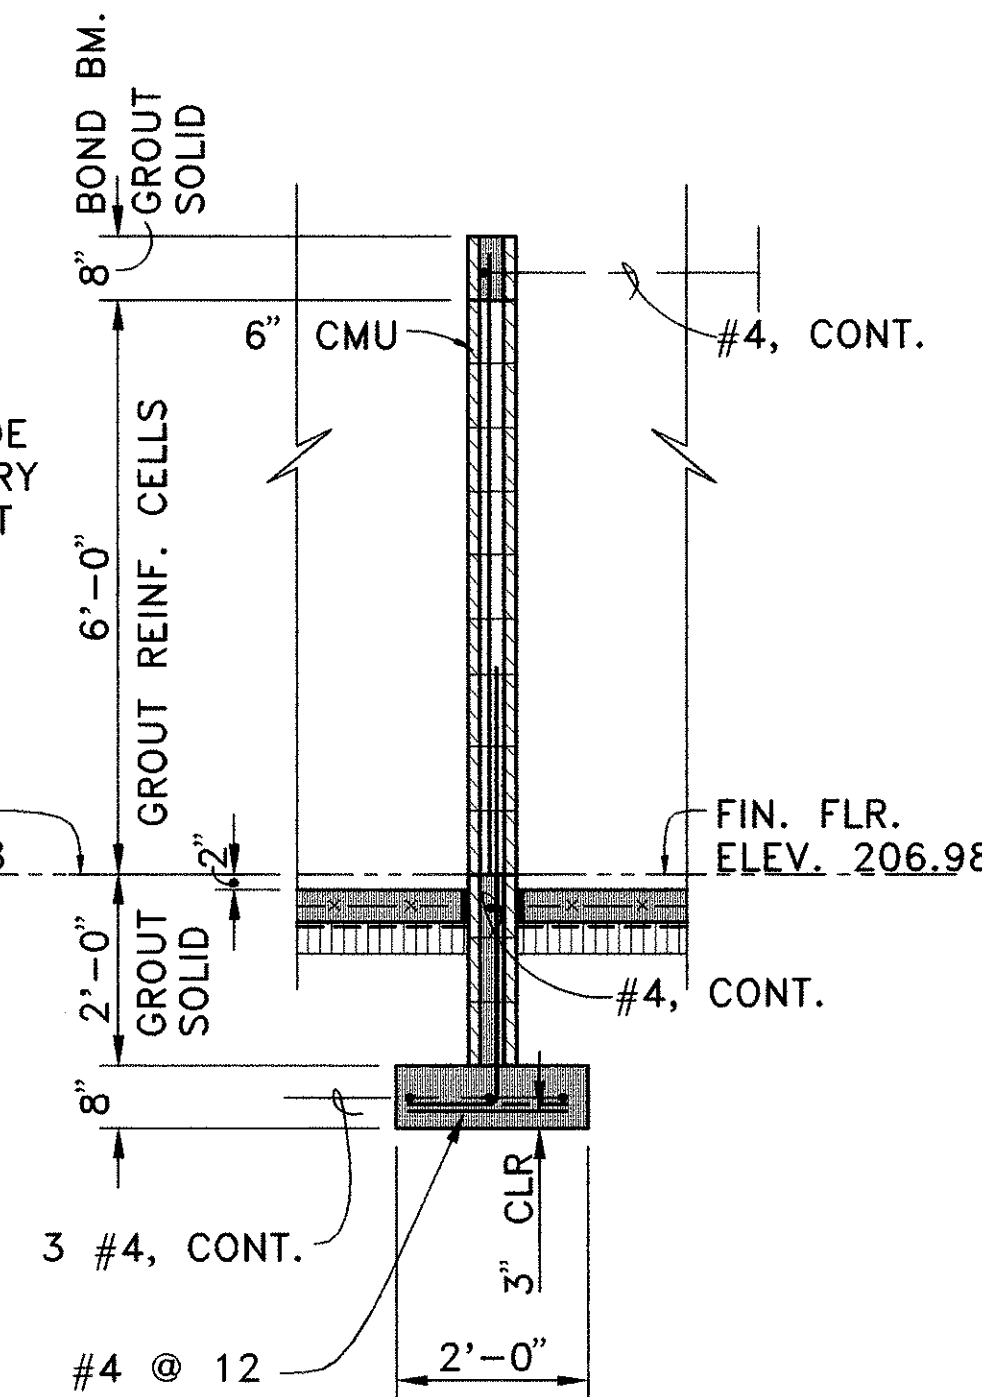

6" CMU WALL
AT LOCKERS

SECTION **J**
SCALE: 1/2" = 1' 0"
19/20

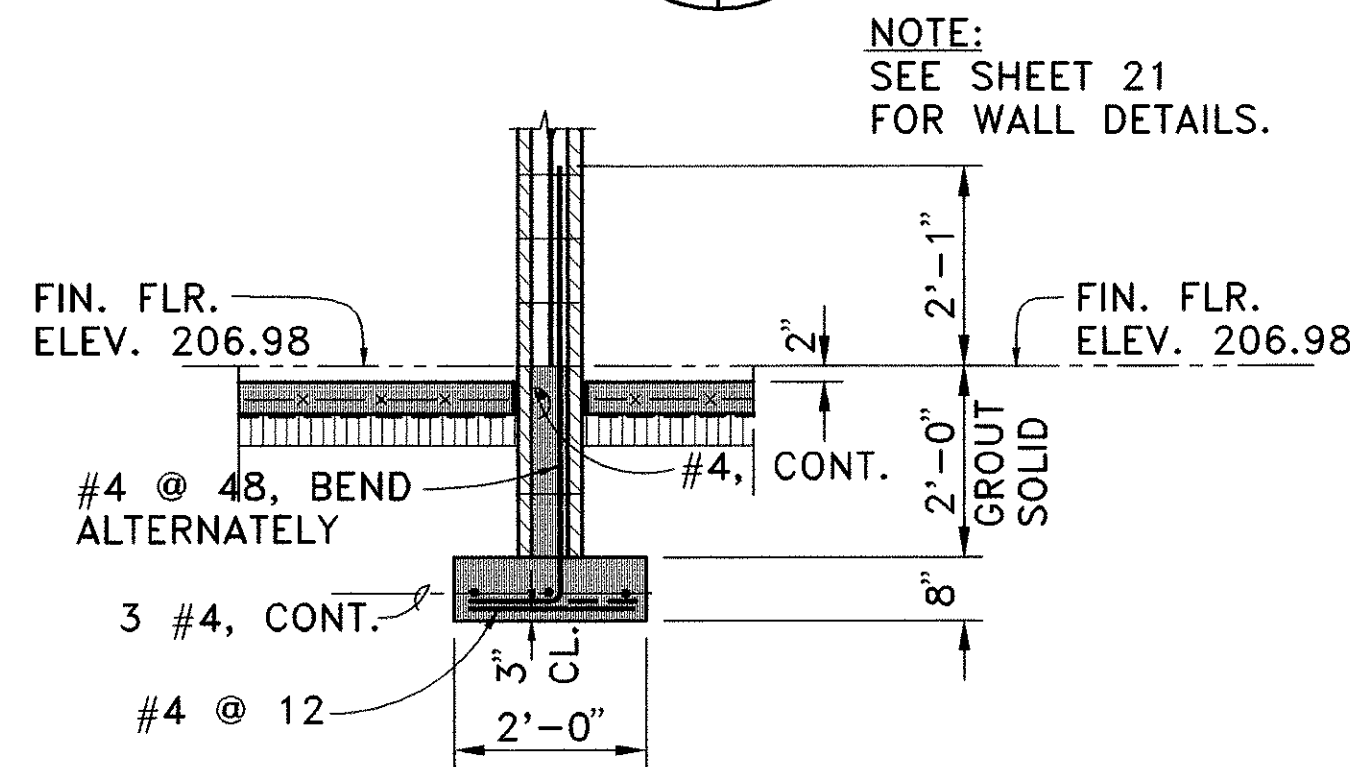


AT INTERIOR WALL

SECTION **K**
SCALE: 1/2" = 1' 0"
19/20

NOTE: THE FINISH FLOOR ELEVATION INDICATED IS TO THE TOP OF THE FINISHED CONCRETE FLOOR EXCEPT FOR AREAS WHERE THE SLAB IS DEPRESSED.

9/15/94	DELETED SECT. G/20.
6/17/94	REVISED SILL DIM. ON SECT. A/20 & C/20. ADDED SECT. K/20.
DATE	REVISION

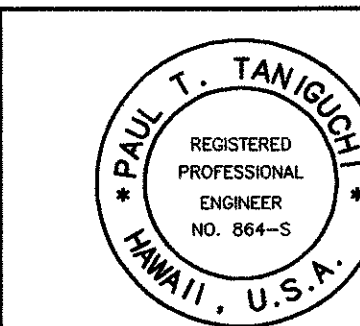

STATE OF HAWAII
DEPARTMENT OF TRANSPORTATION
HIGHWAYS DIVISION

FOOTING DETAILS

KANEOHE BASE YARD, PHASE II

ADMINISTRATION BUILDING

PROJECT NO. HWY-0-03-92

SCALE: AS NOTED DATE: 4/15/94


SHEET NO. 20 OF 35 SHEETS

C.O.ADD. 20

SURVEY PLOTTED BY	DATE
DRAWN BY	
DESIGNED BY	
NOTED BY	
CHECKED BY	
ORIGINAL PLAN NO.	

NAME: C:\G001\BSE\HWY-03-92\DWG DATE: MAY 18, 1994 TIME: 3:48 PM

FED. ROAD DIST. NO.	STATE	PROJ. NO.	FISCAL YEAR	SHEET NO.	TOTAL SHEETS
HAWAII	HAW.	HWY-0-03-92	1994	21	35

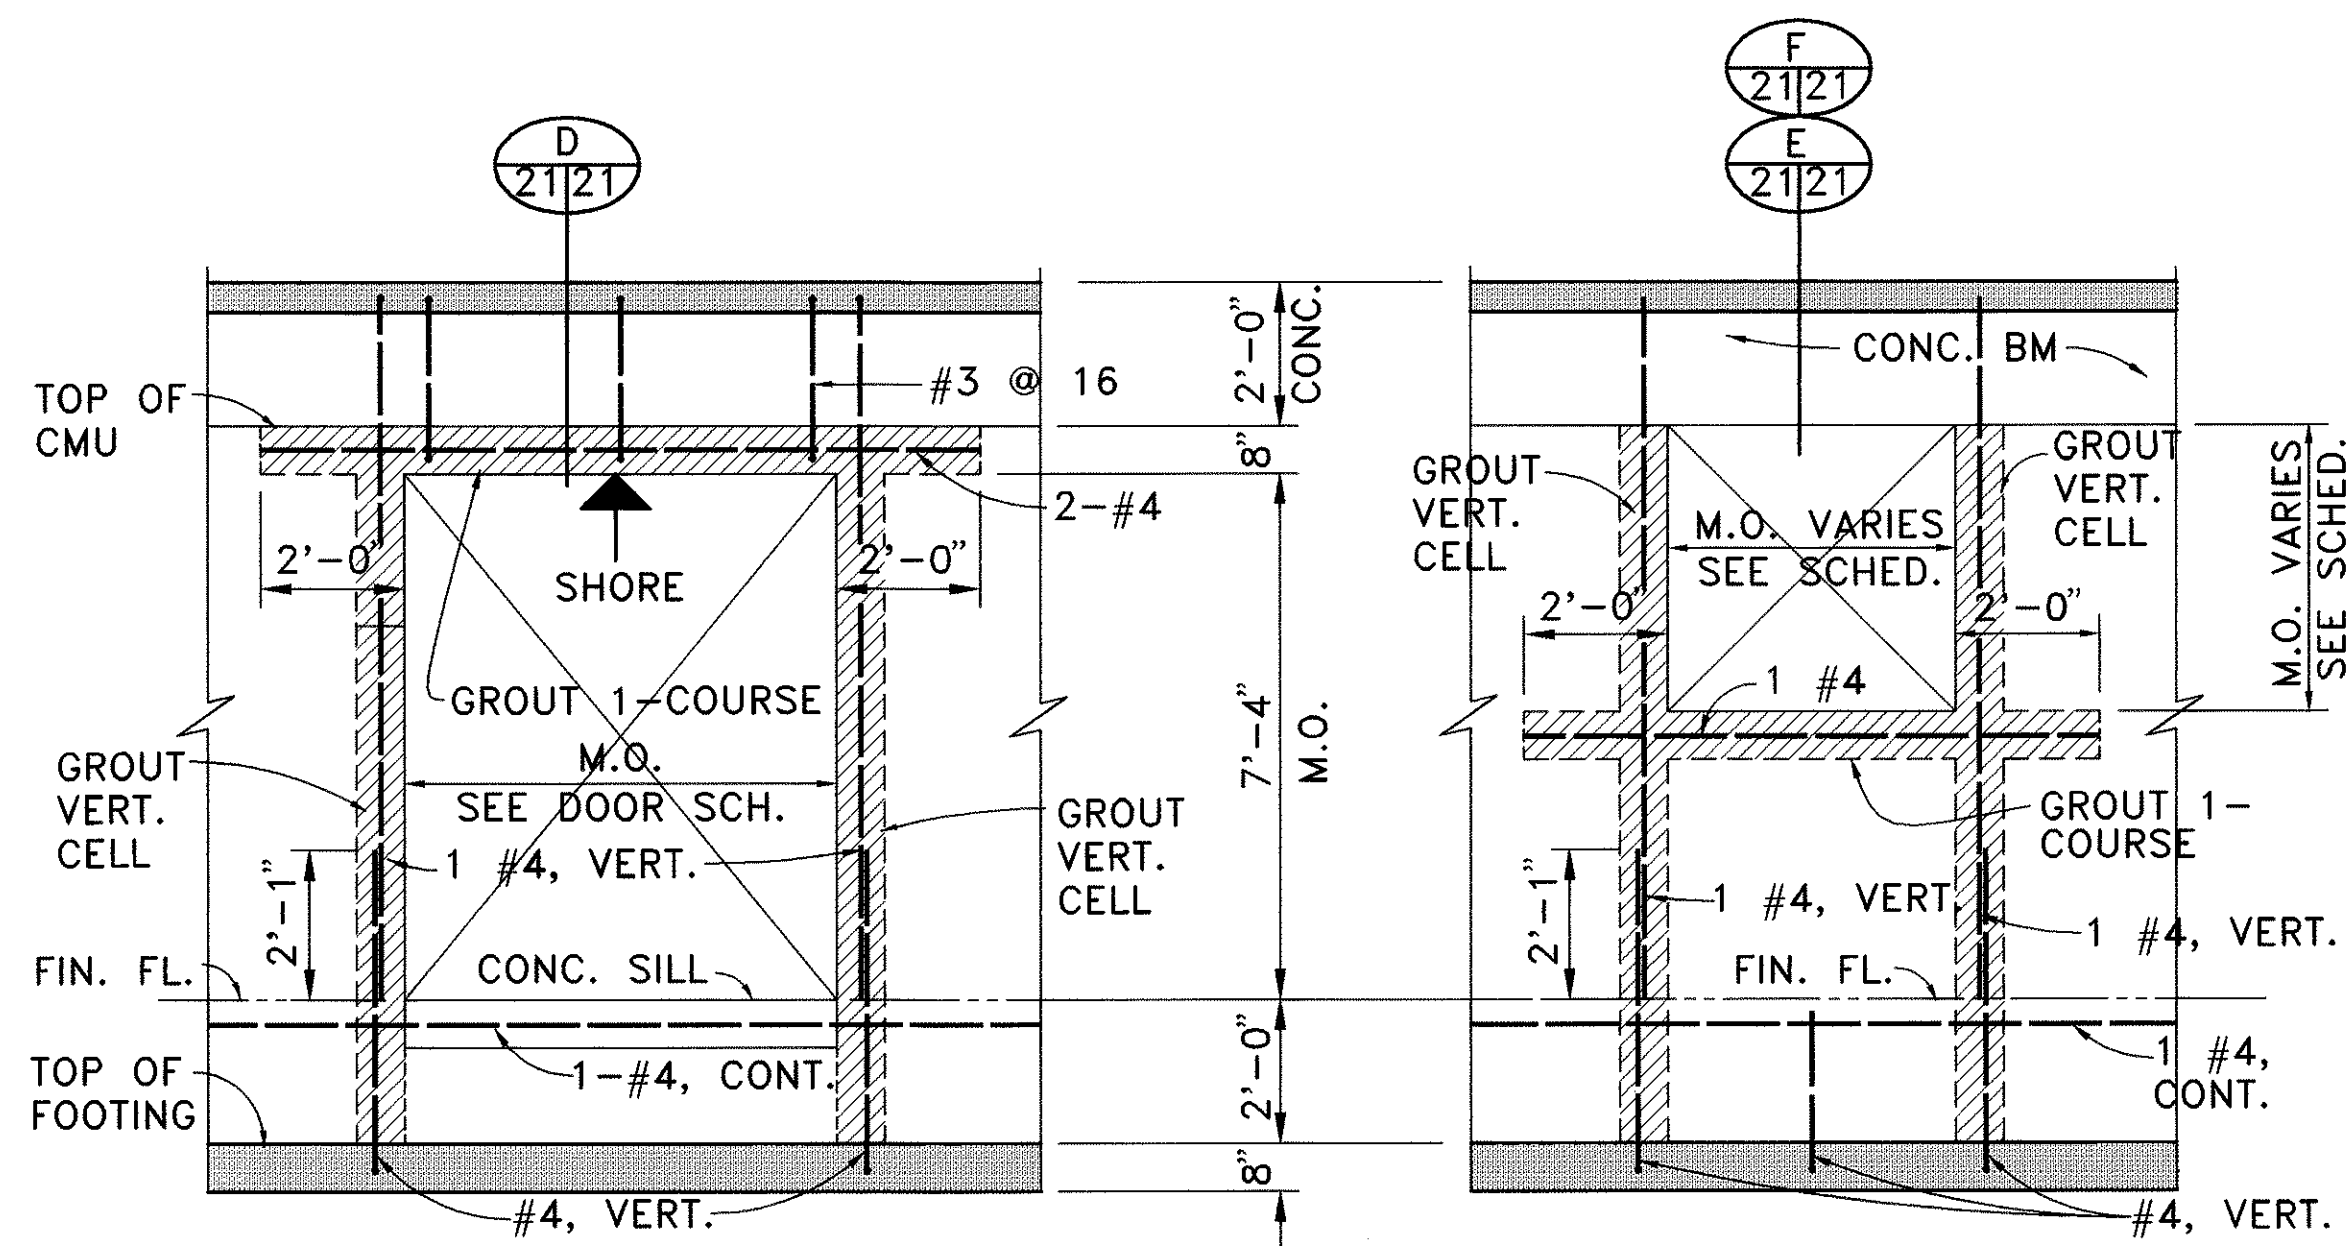


TYPICAL DOOR OPENING

DETAIL A
SCALE: 3/8" = 1' 0"

TYPICAL WINDOW OPENING
(OPENING FOR A.C. UNIT
& GRILL BLOCKS SIMILAR)

DETAIL B
SCALE: 3/8" = 1' 0"

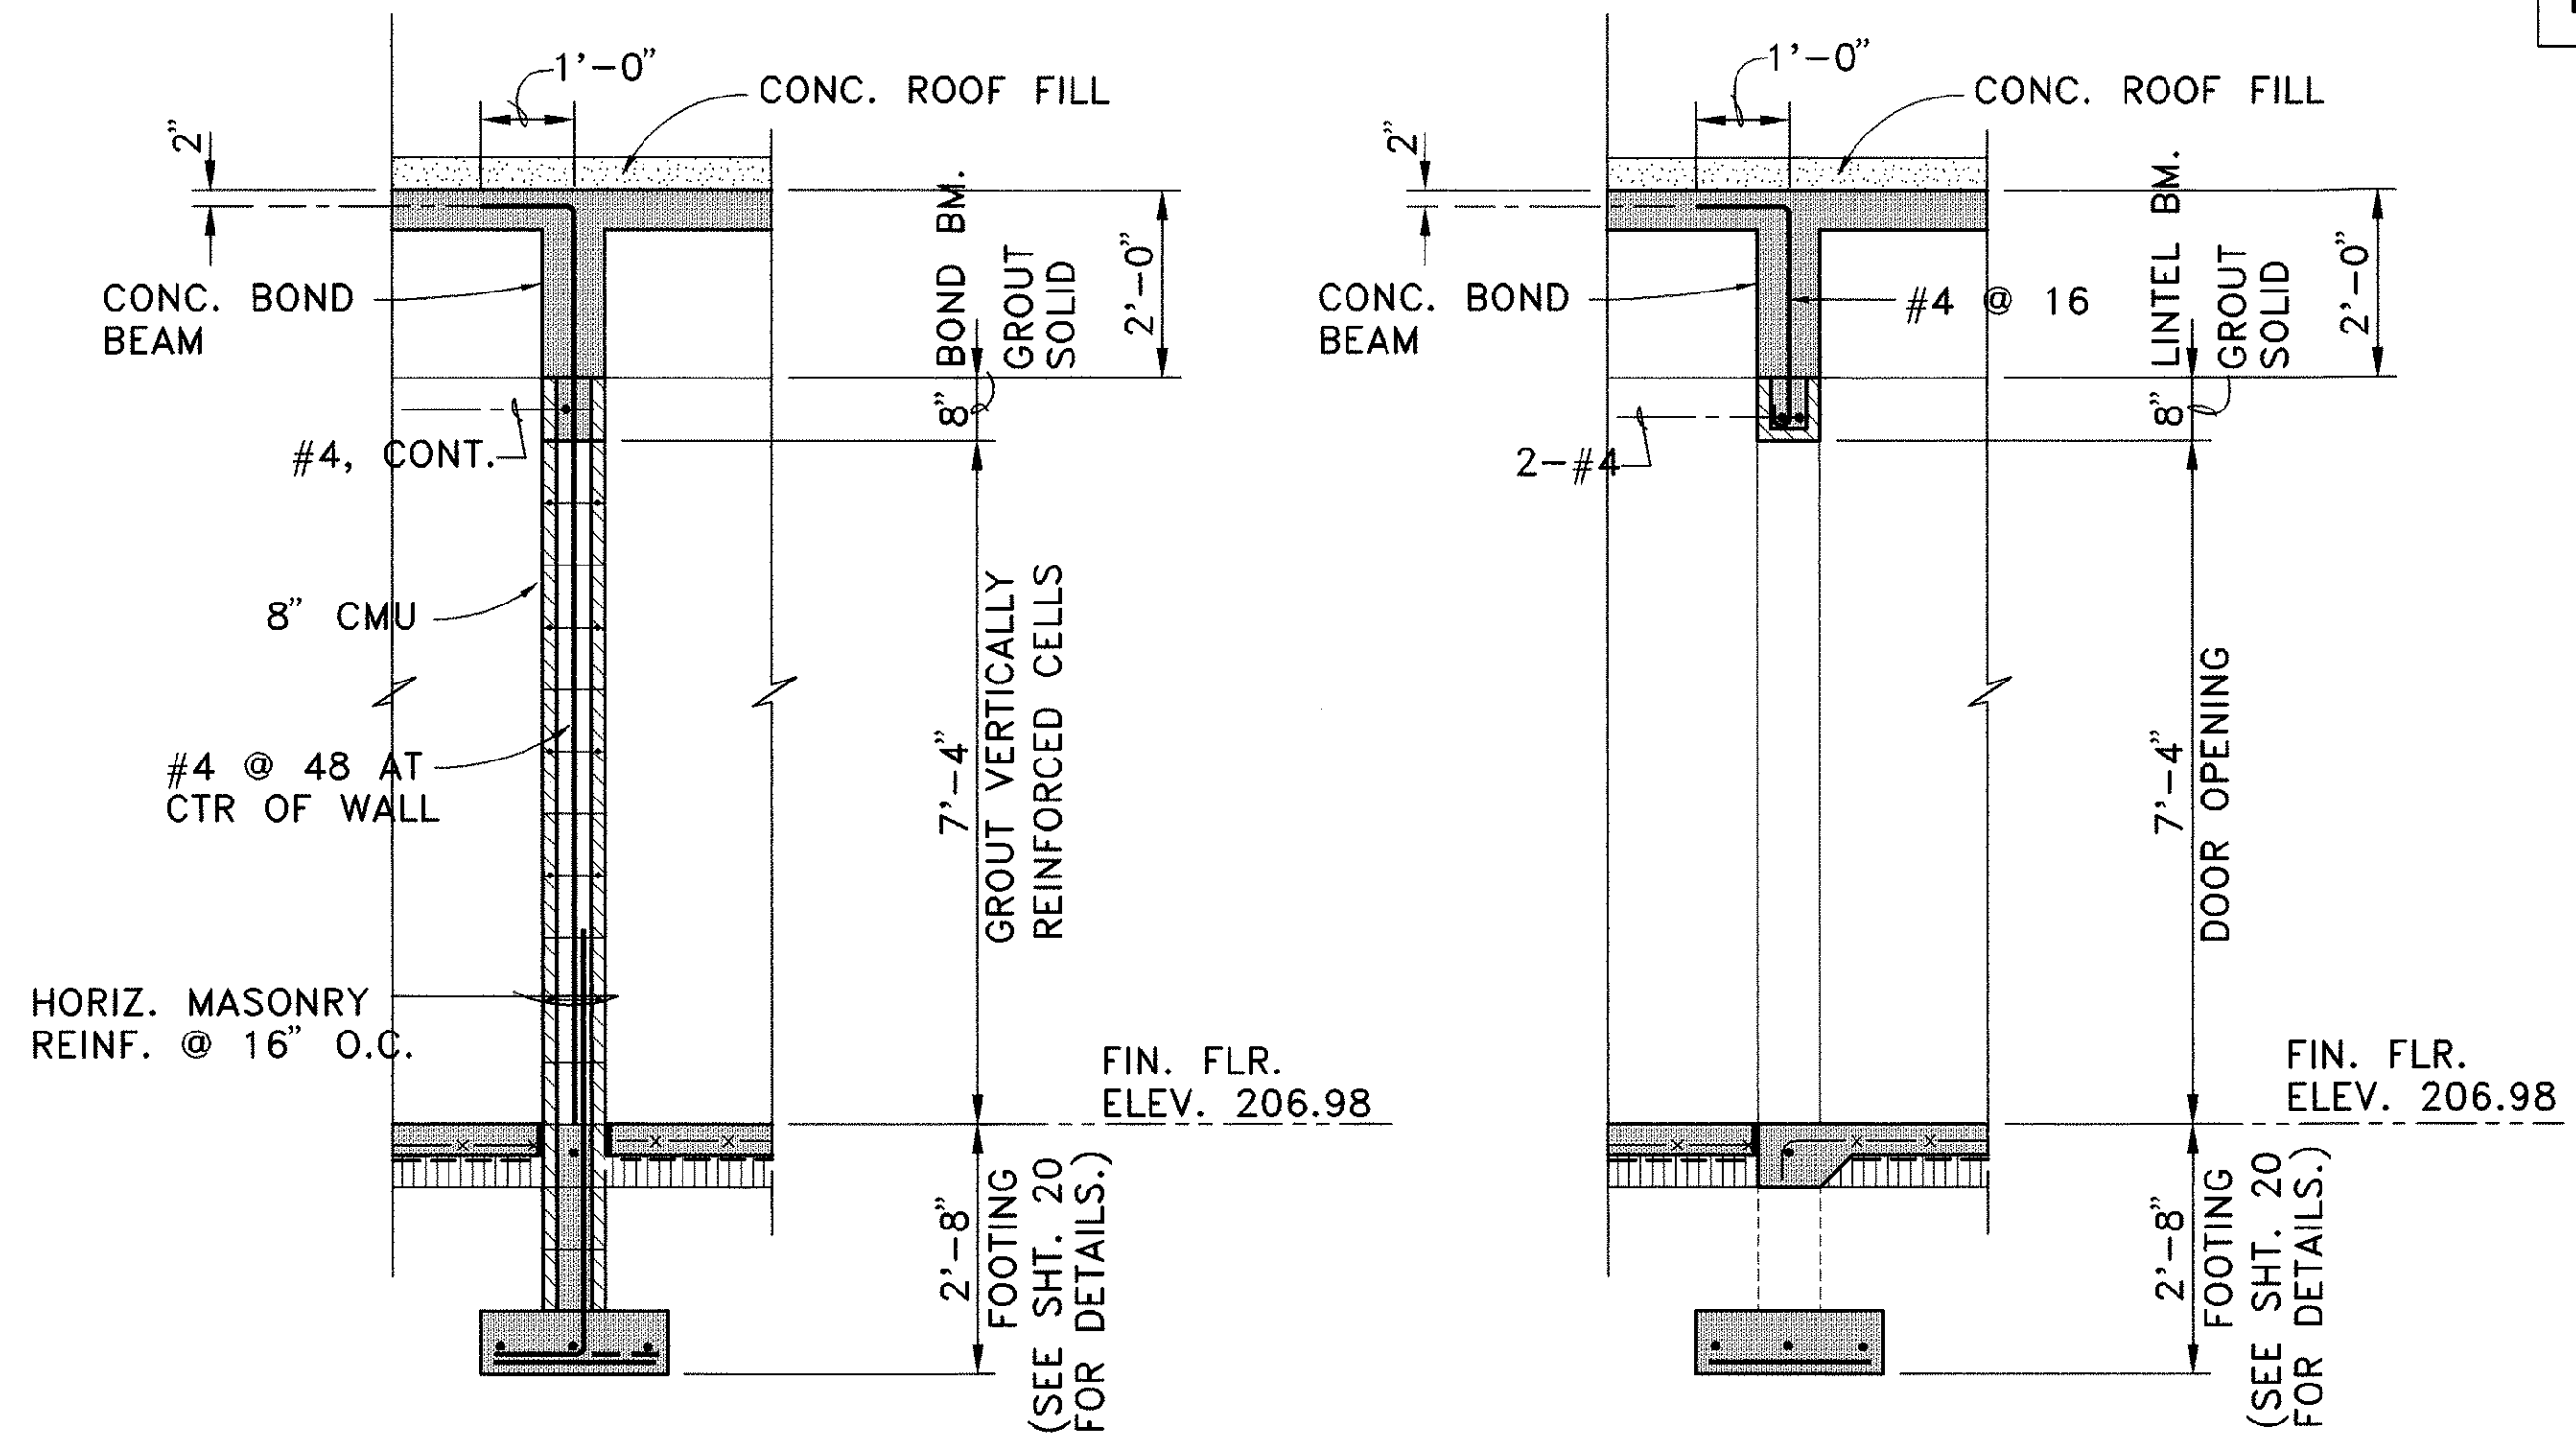


TYPICAL CMU WALL SECTION

DETAIL C
SCALE: 1/2" = 1' 0"

TYPICAL CMU WALL SECTION
AT DOOR OPENINGS

DETAIL D
SCALE: 1/2" = 1' 0"

NOTE: FINISH FLOOR ELEVATION INDICATED IS TO THE TOP OF THE FINISHED CONCRETE FLOOR EXCEPT IN AREAS WHERE SLAB IS DEPRESSED.

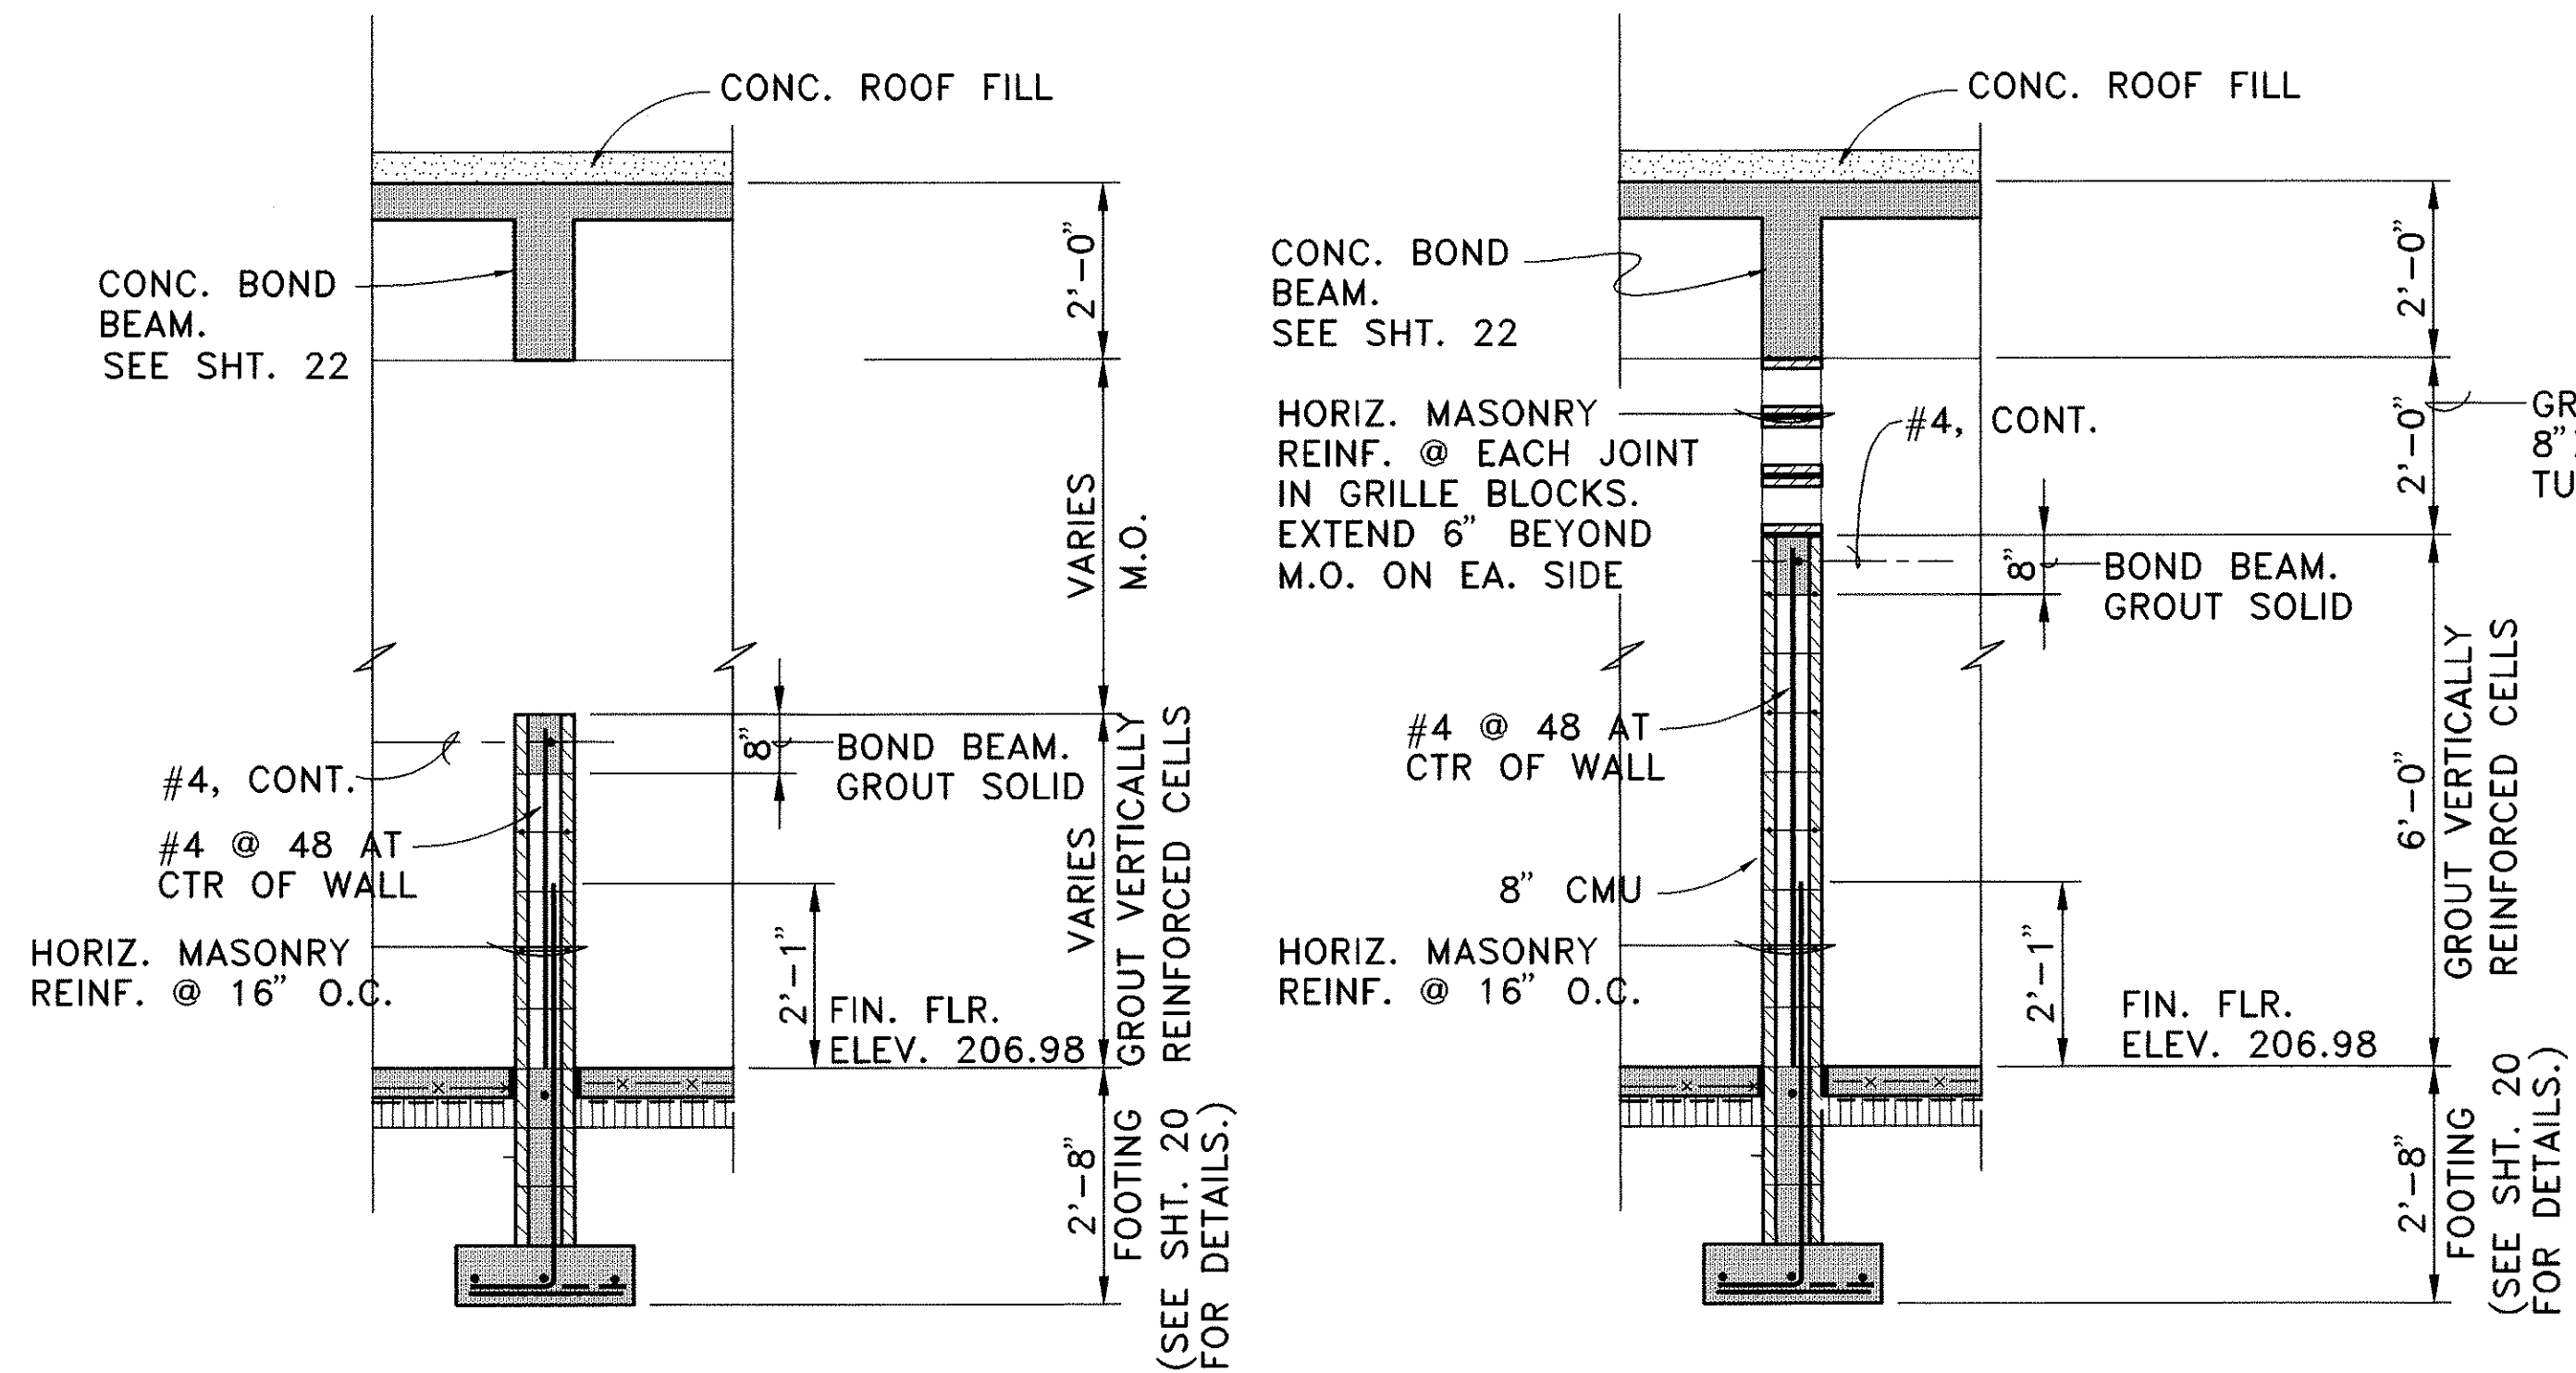

AT WINDOWS & OTHER
MASONRY OPENINGS (M.O.)

SECTION E
SCALE: 1/2" = 1' 0"

AT GRILLE BLOCKS

SECTION F
SCALE: 1/2" = 1' 0"

SURVEY PLOTTED BY	DATE
DRAWN BY	
DESIGNED BY	
CHECKED BY	
NO.	

STATE OF HAWAII
DEPARTMENT OF TRANSPORTATION
HIGHWAYS DIVISION

WALL SECTIONS

KANELOE BASE YARD, PHASE II

ADMINISTRATION BUILDING

PROJECT NO. HWY-0-03-92

SCALE: AS NOTED DATE: 4/15/94


SHEET NO. 21 OF 35 SHEETS

THIS WORK WAS PREPARED BY ME OR UNDER MY SUPERVISION


PAUL T. TANIGUCHI
REGISTERED PROFESSIONAL ENGINEER
NO. 864-S
HAWAII, U.S.A.

NAME: C:\C001\BASEYARD\22-SUBDIVING DATE: MAY 12, 1994 TIME: 10:55 AM


FED. ROAD DIST. NO.	STATE	PROJ. NO.	FISCAL YEAR	SHEET NO.	TOTAL SHEETS
HAWAII	HAW.	HWY-0-03-92	1994	22	35

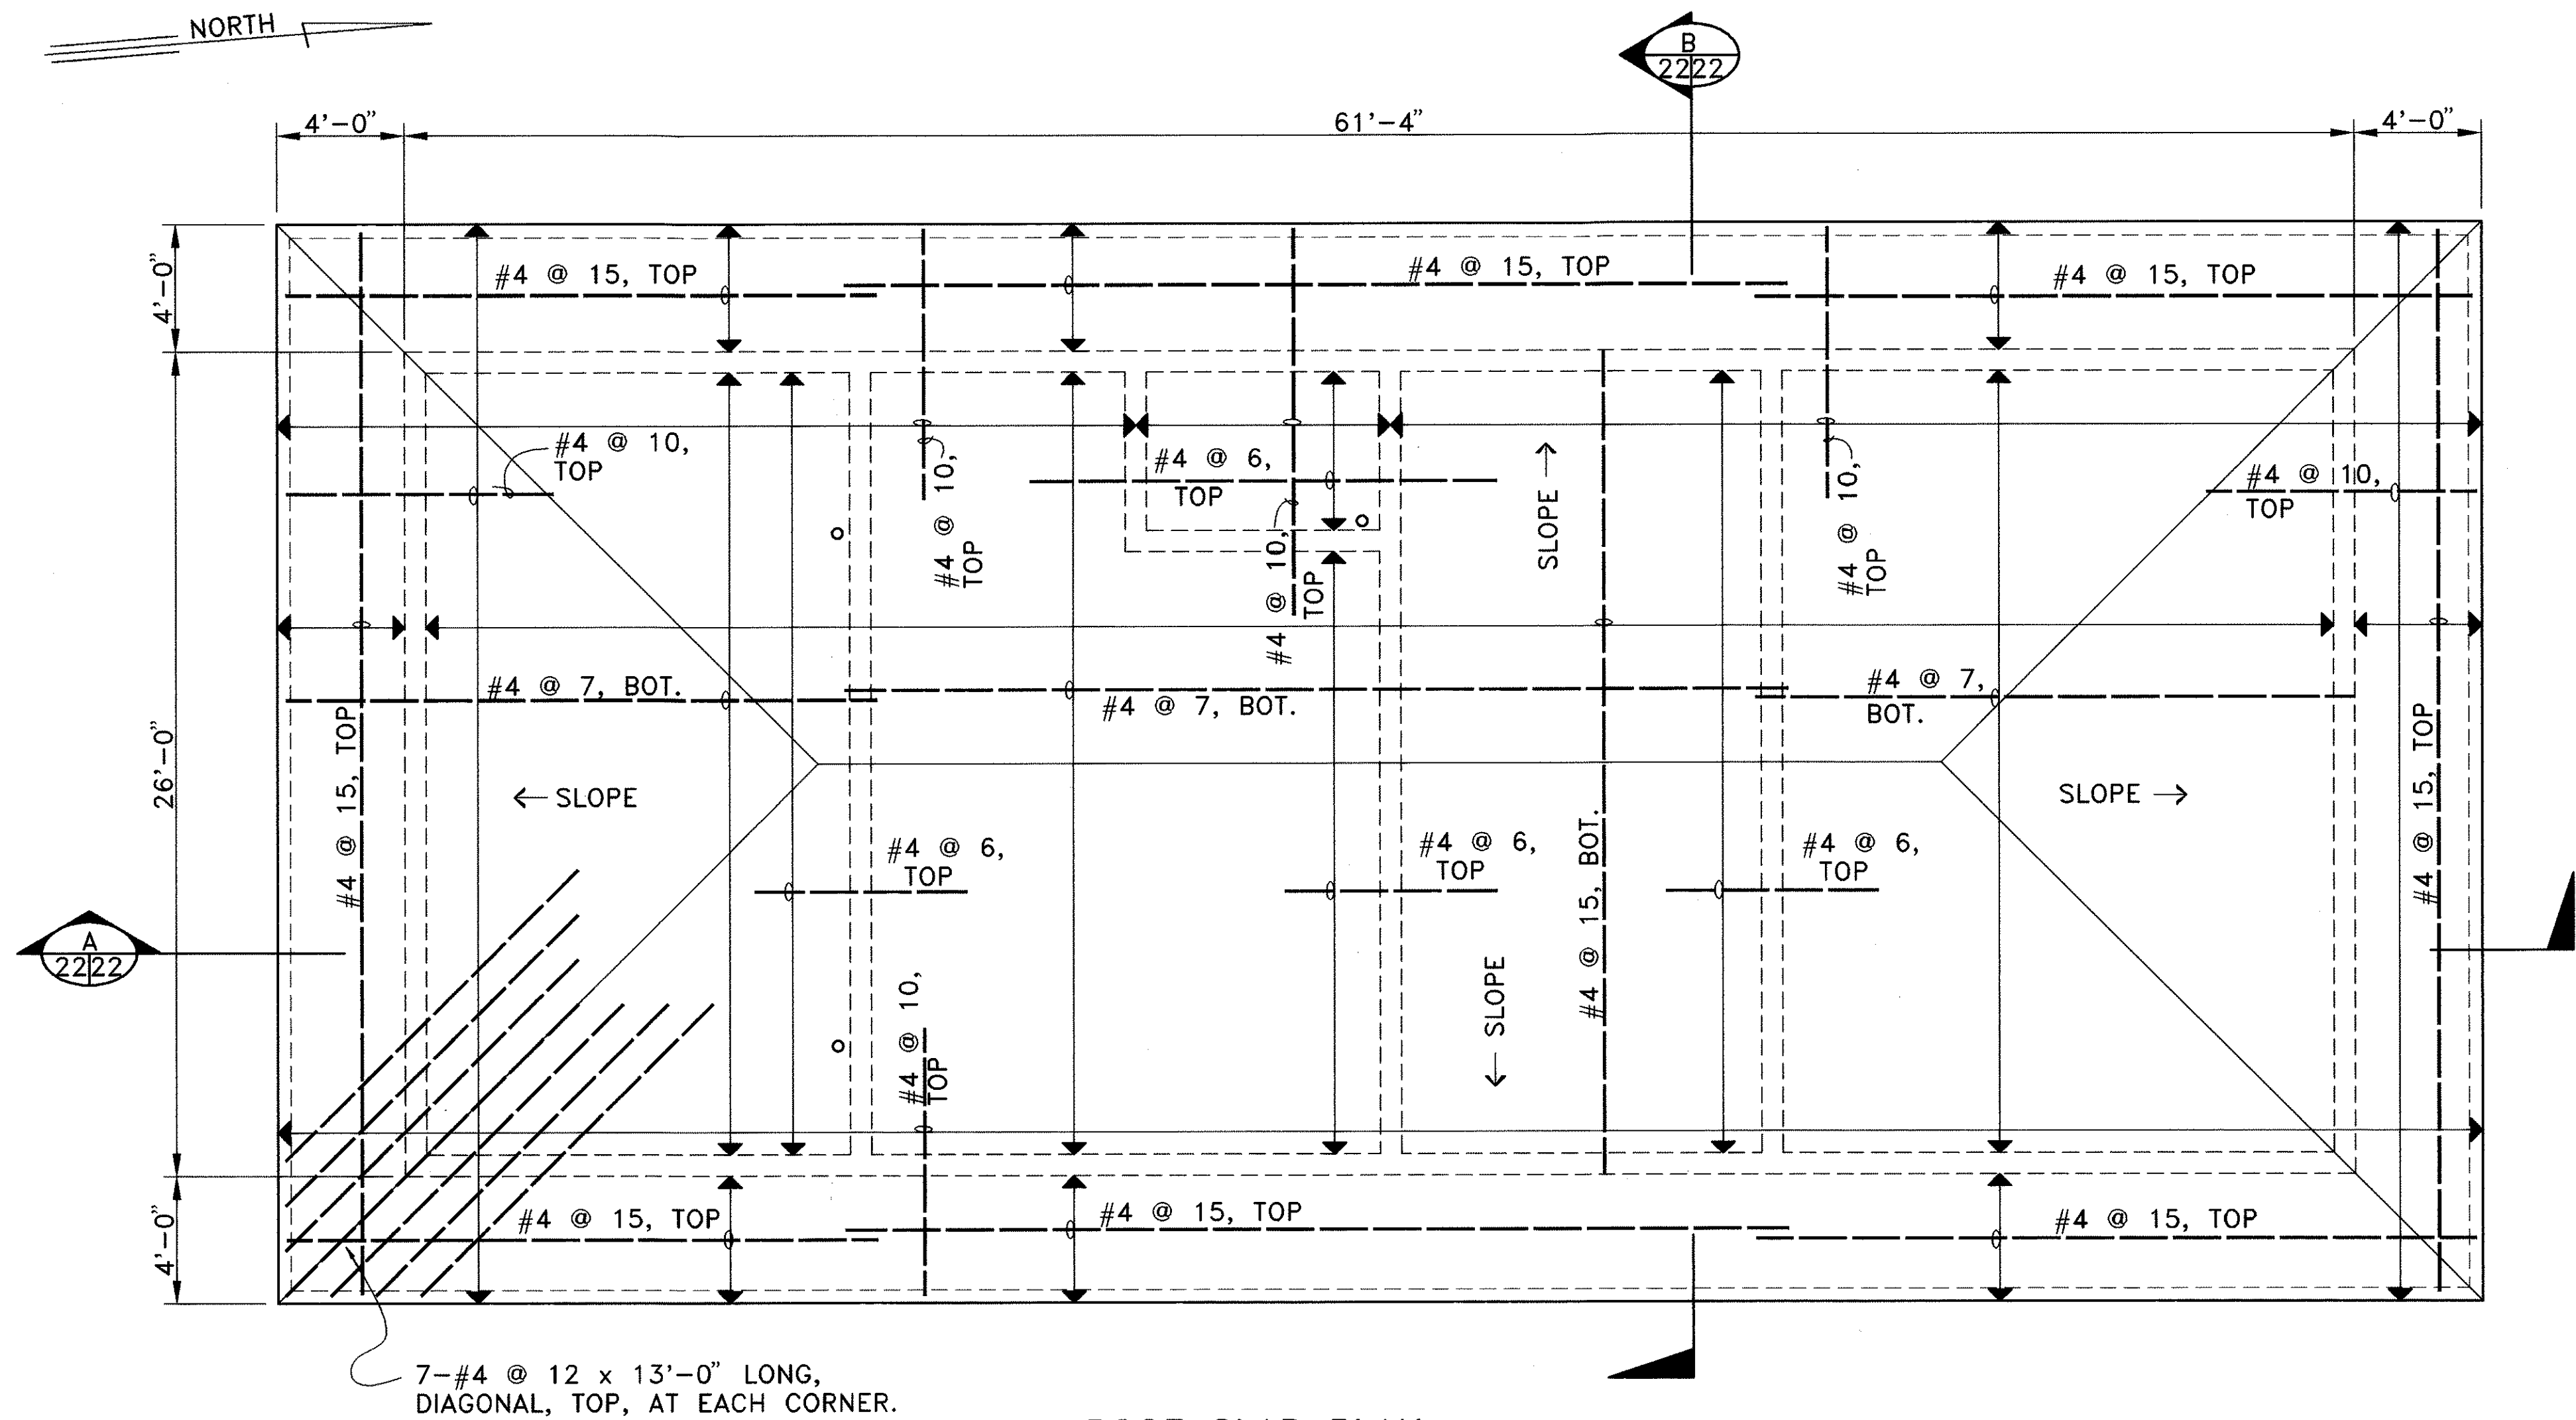


ROOF SLAB PLAN
SCALE: 1/4" = 1' 0"

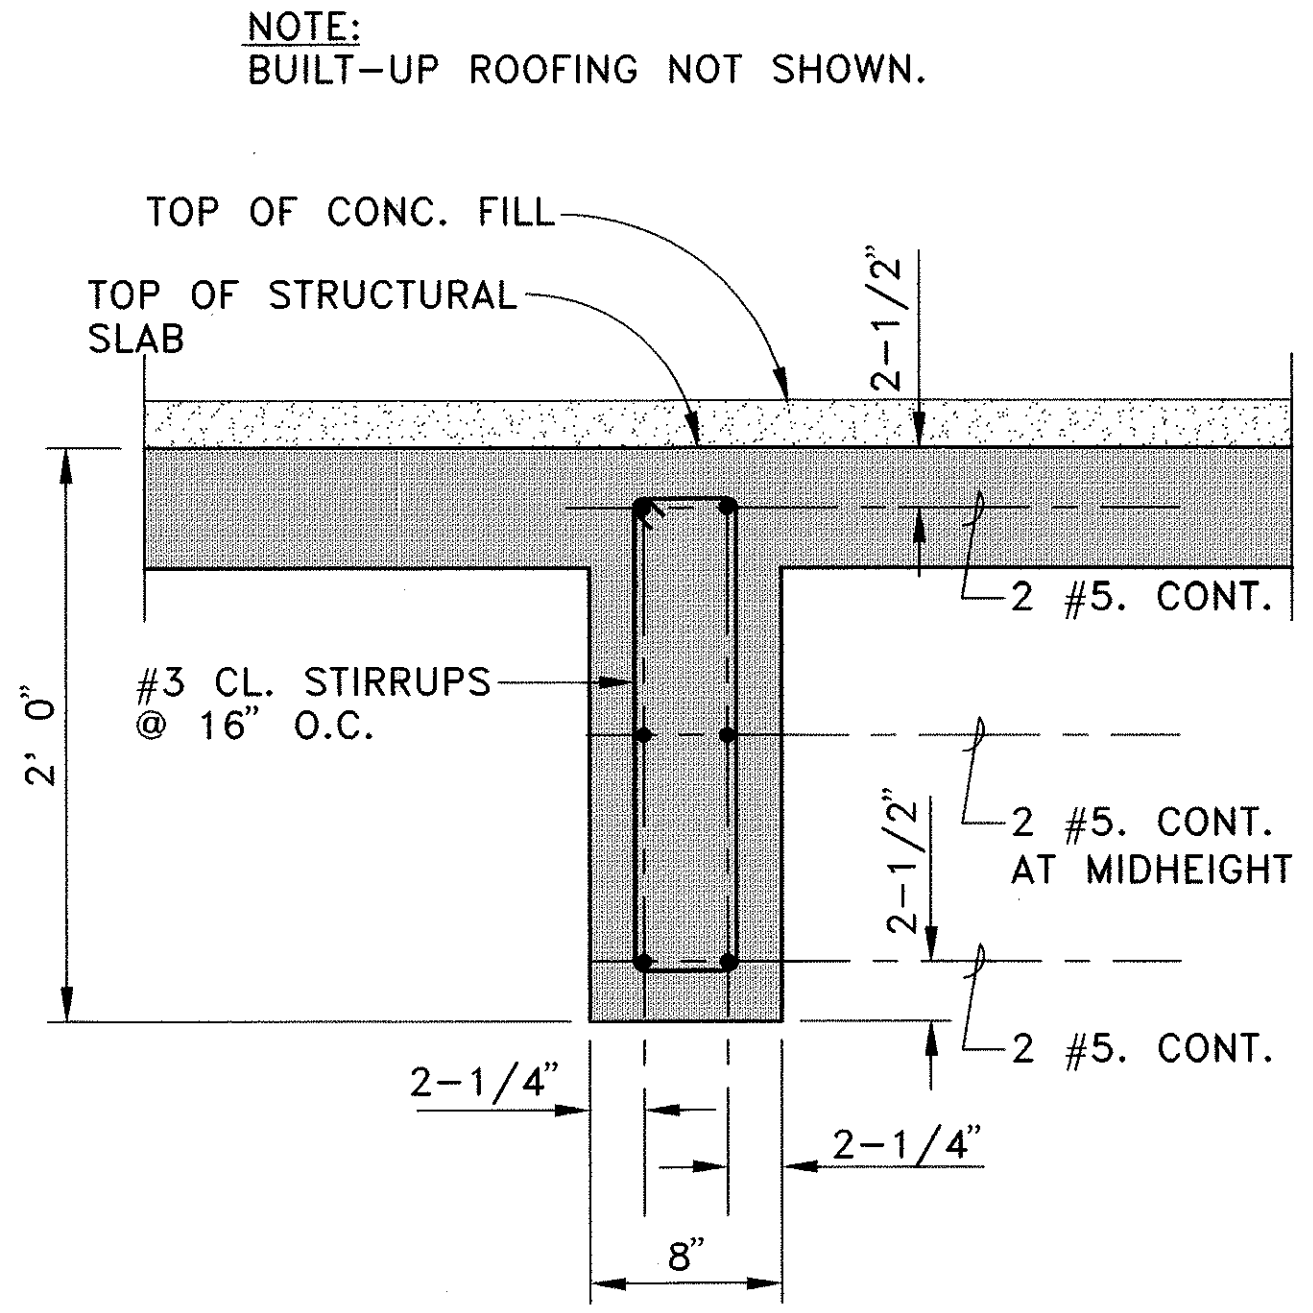

TYPICAL BOND BEAM DETAIL
SCALE: 1-1/2" = 1' 0"

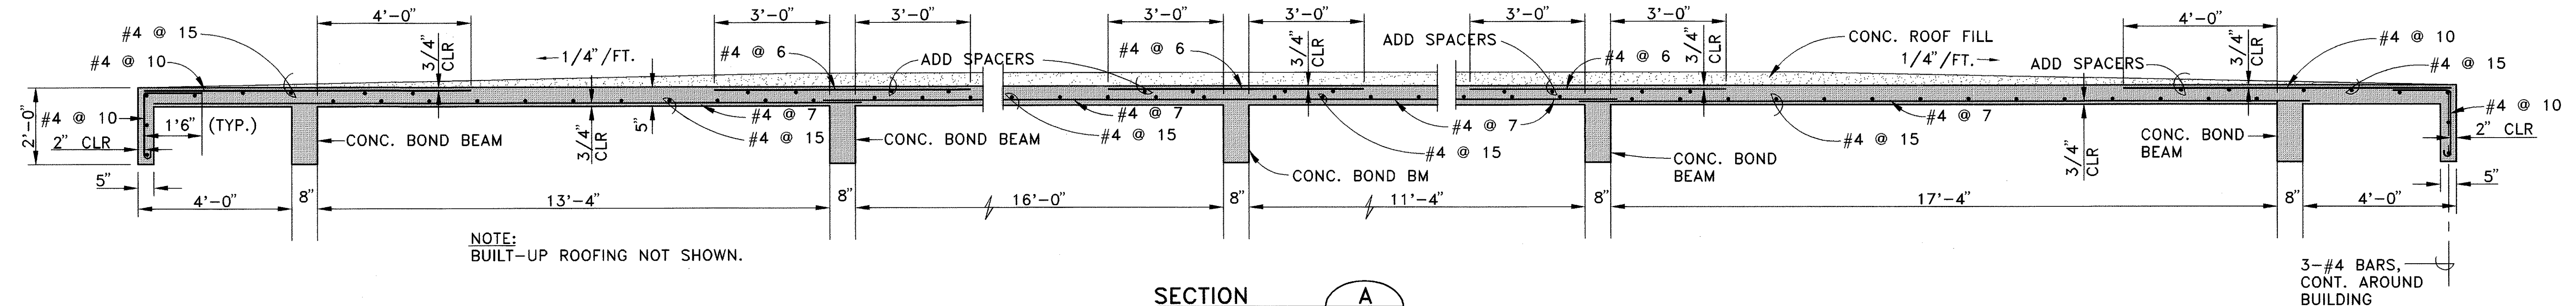

SECTION A
SCALE: 1/2" = 1' 0"

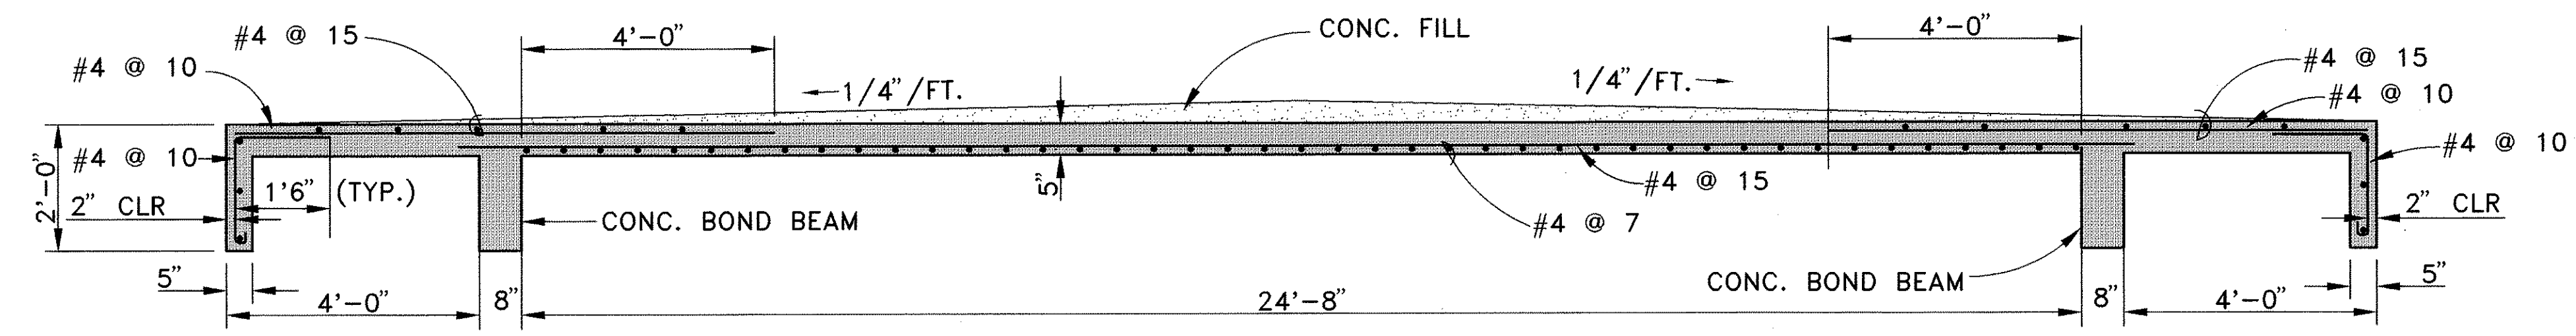

SECTION B
SCALE: 1/2" = 1' 0"

DATE	
DESIGNED BY	
CHECKED BY	
NO.	

6/17/94	REVISED NOTE FOR DIAG. BARS ON ROOF SLAB PLAN.
DATE	REVISION
STATE OF HAWAII DEPARTMENT OF TRANSPORTATION HIGHWAYS DIVISION	
ROOF SLAB DETAILS	
KANEHOE BASE YARD, PHASE II	
ADMINISTRATION BUILDING	
PROJECT NO. HWY-0-03-92	
SCALE: AS NOTED	DATE: 4/15/94
SHEET NO. 22 OF 35 SHEETS	

