



FED. ROAD DIST. NO.	STATE	FED. AID PROJ. NO.	FISCAL YEAR	SHEET NO.	TOTAL SHEETS
HAWAII	HAW.				

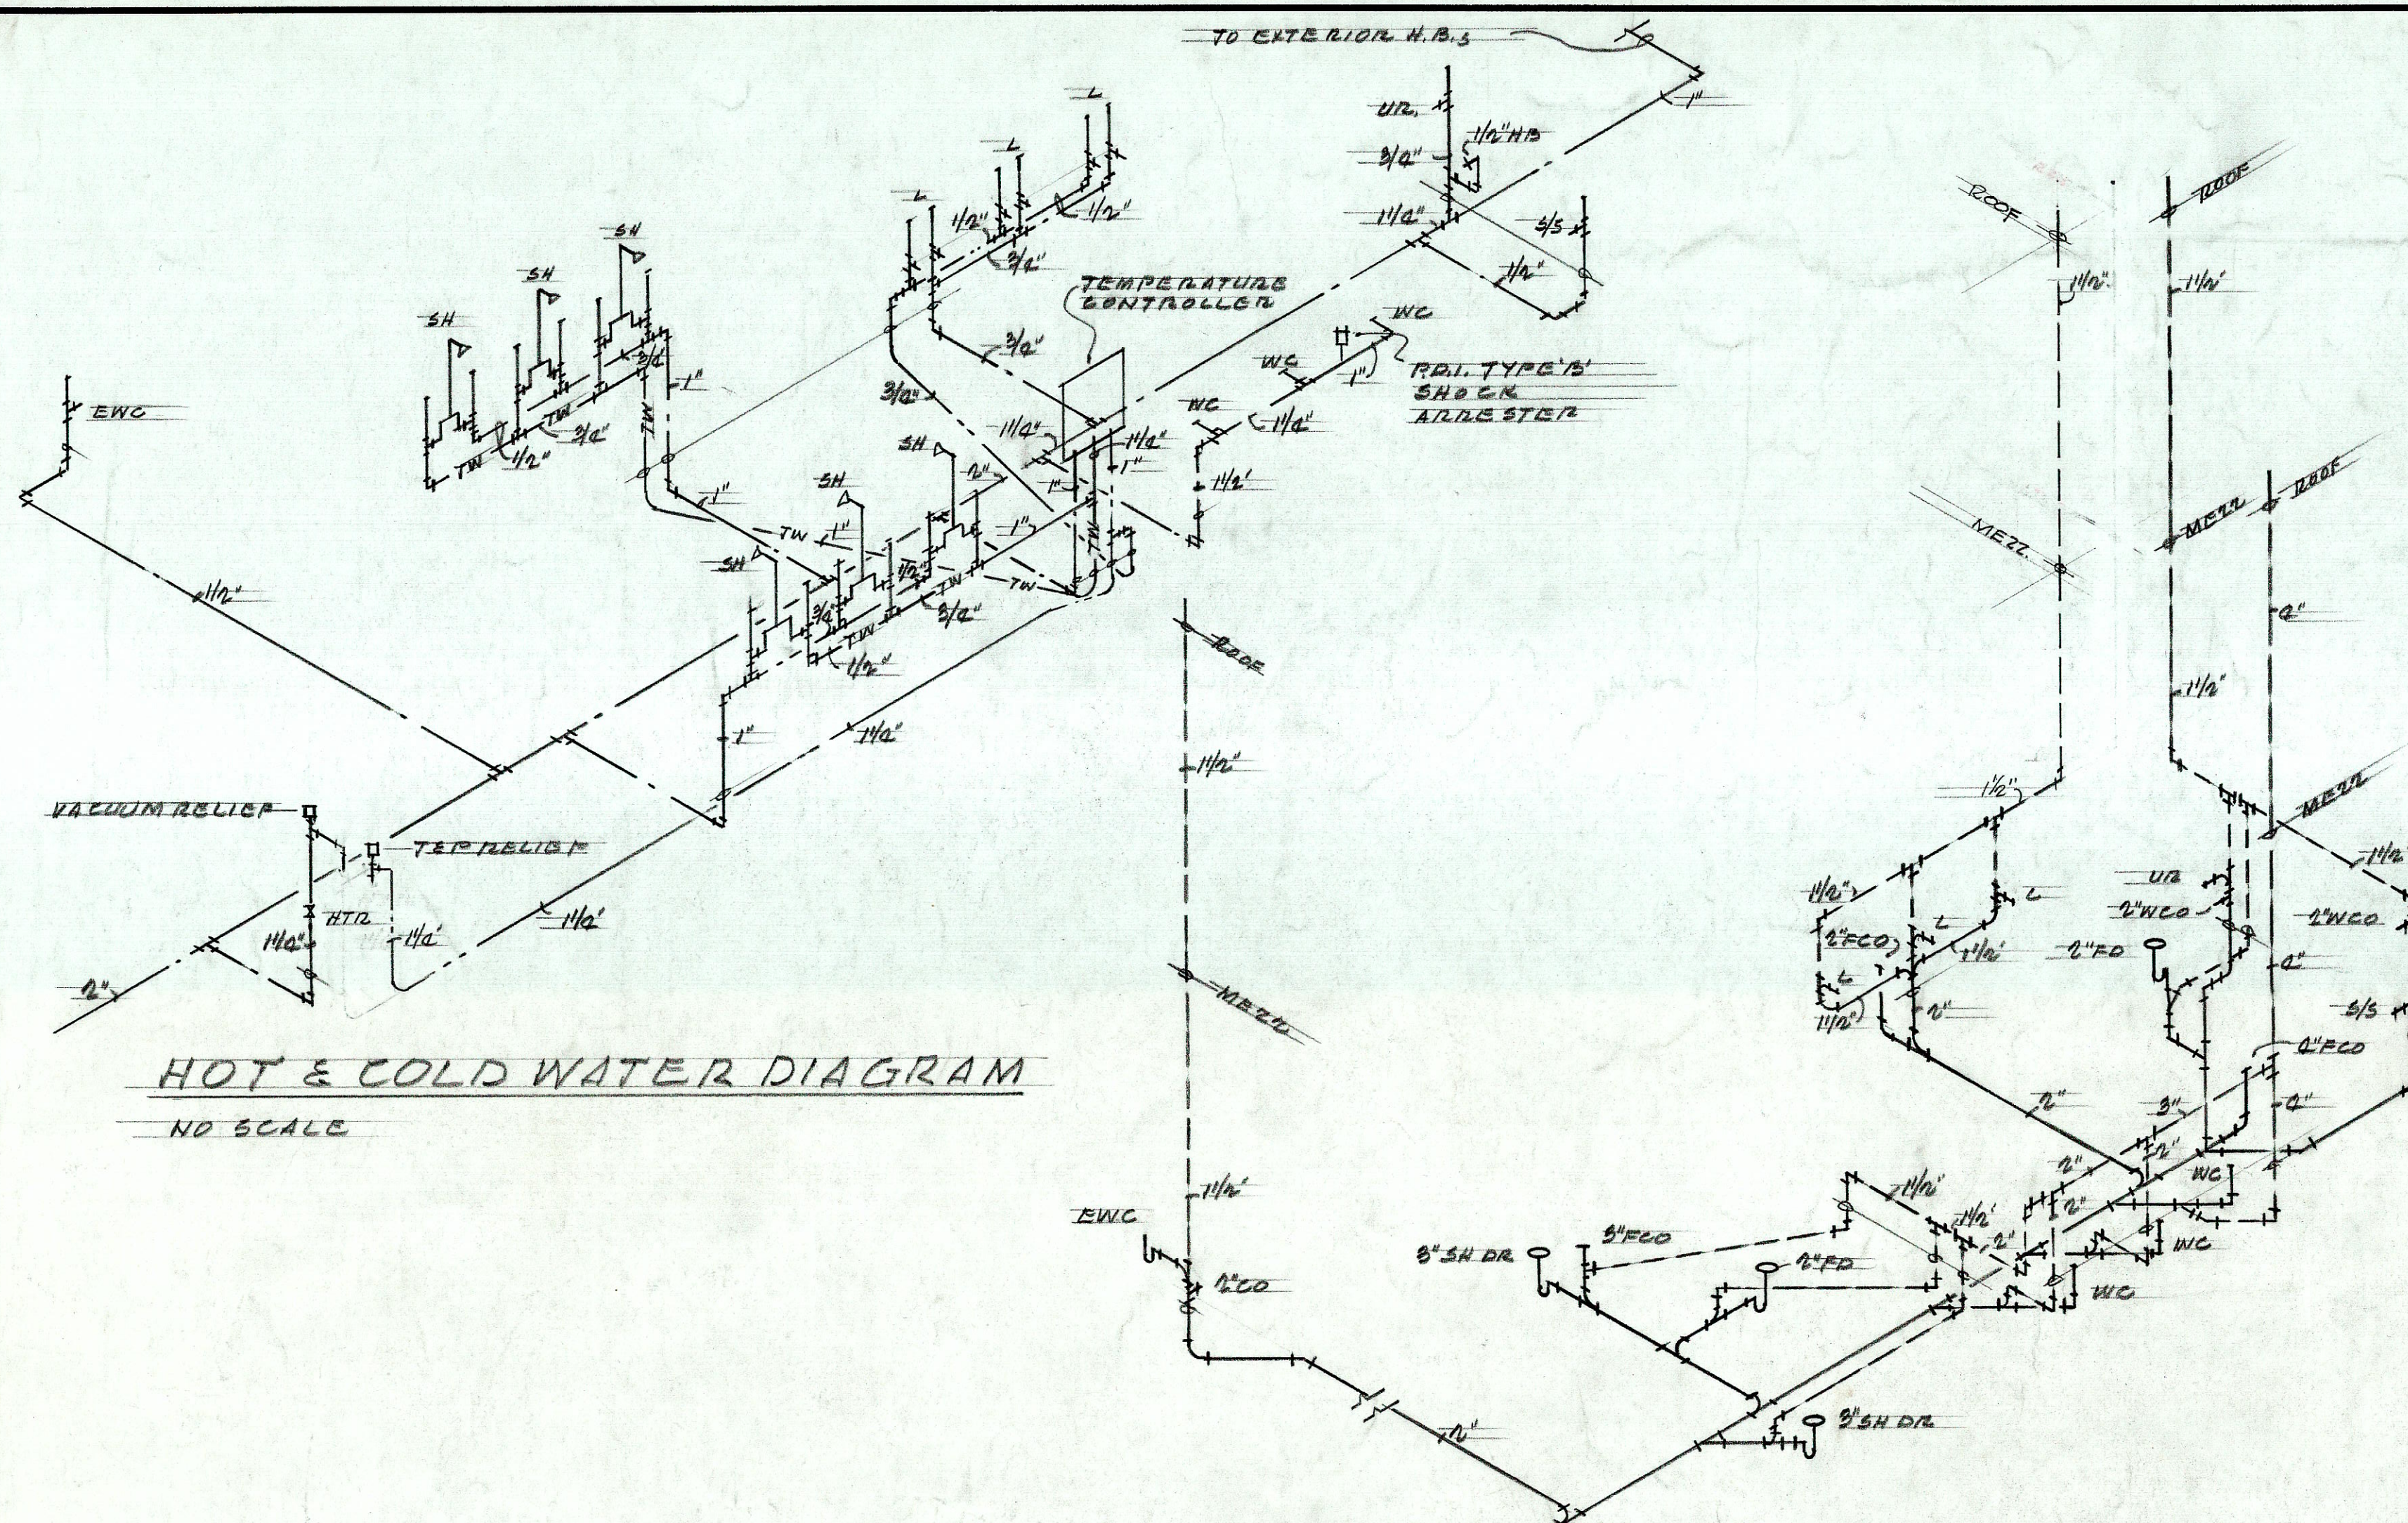


HOT & COLD WATER DIAGRAM
NO SCALE

SANITARY DIAGRAM
NO SCALE

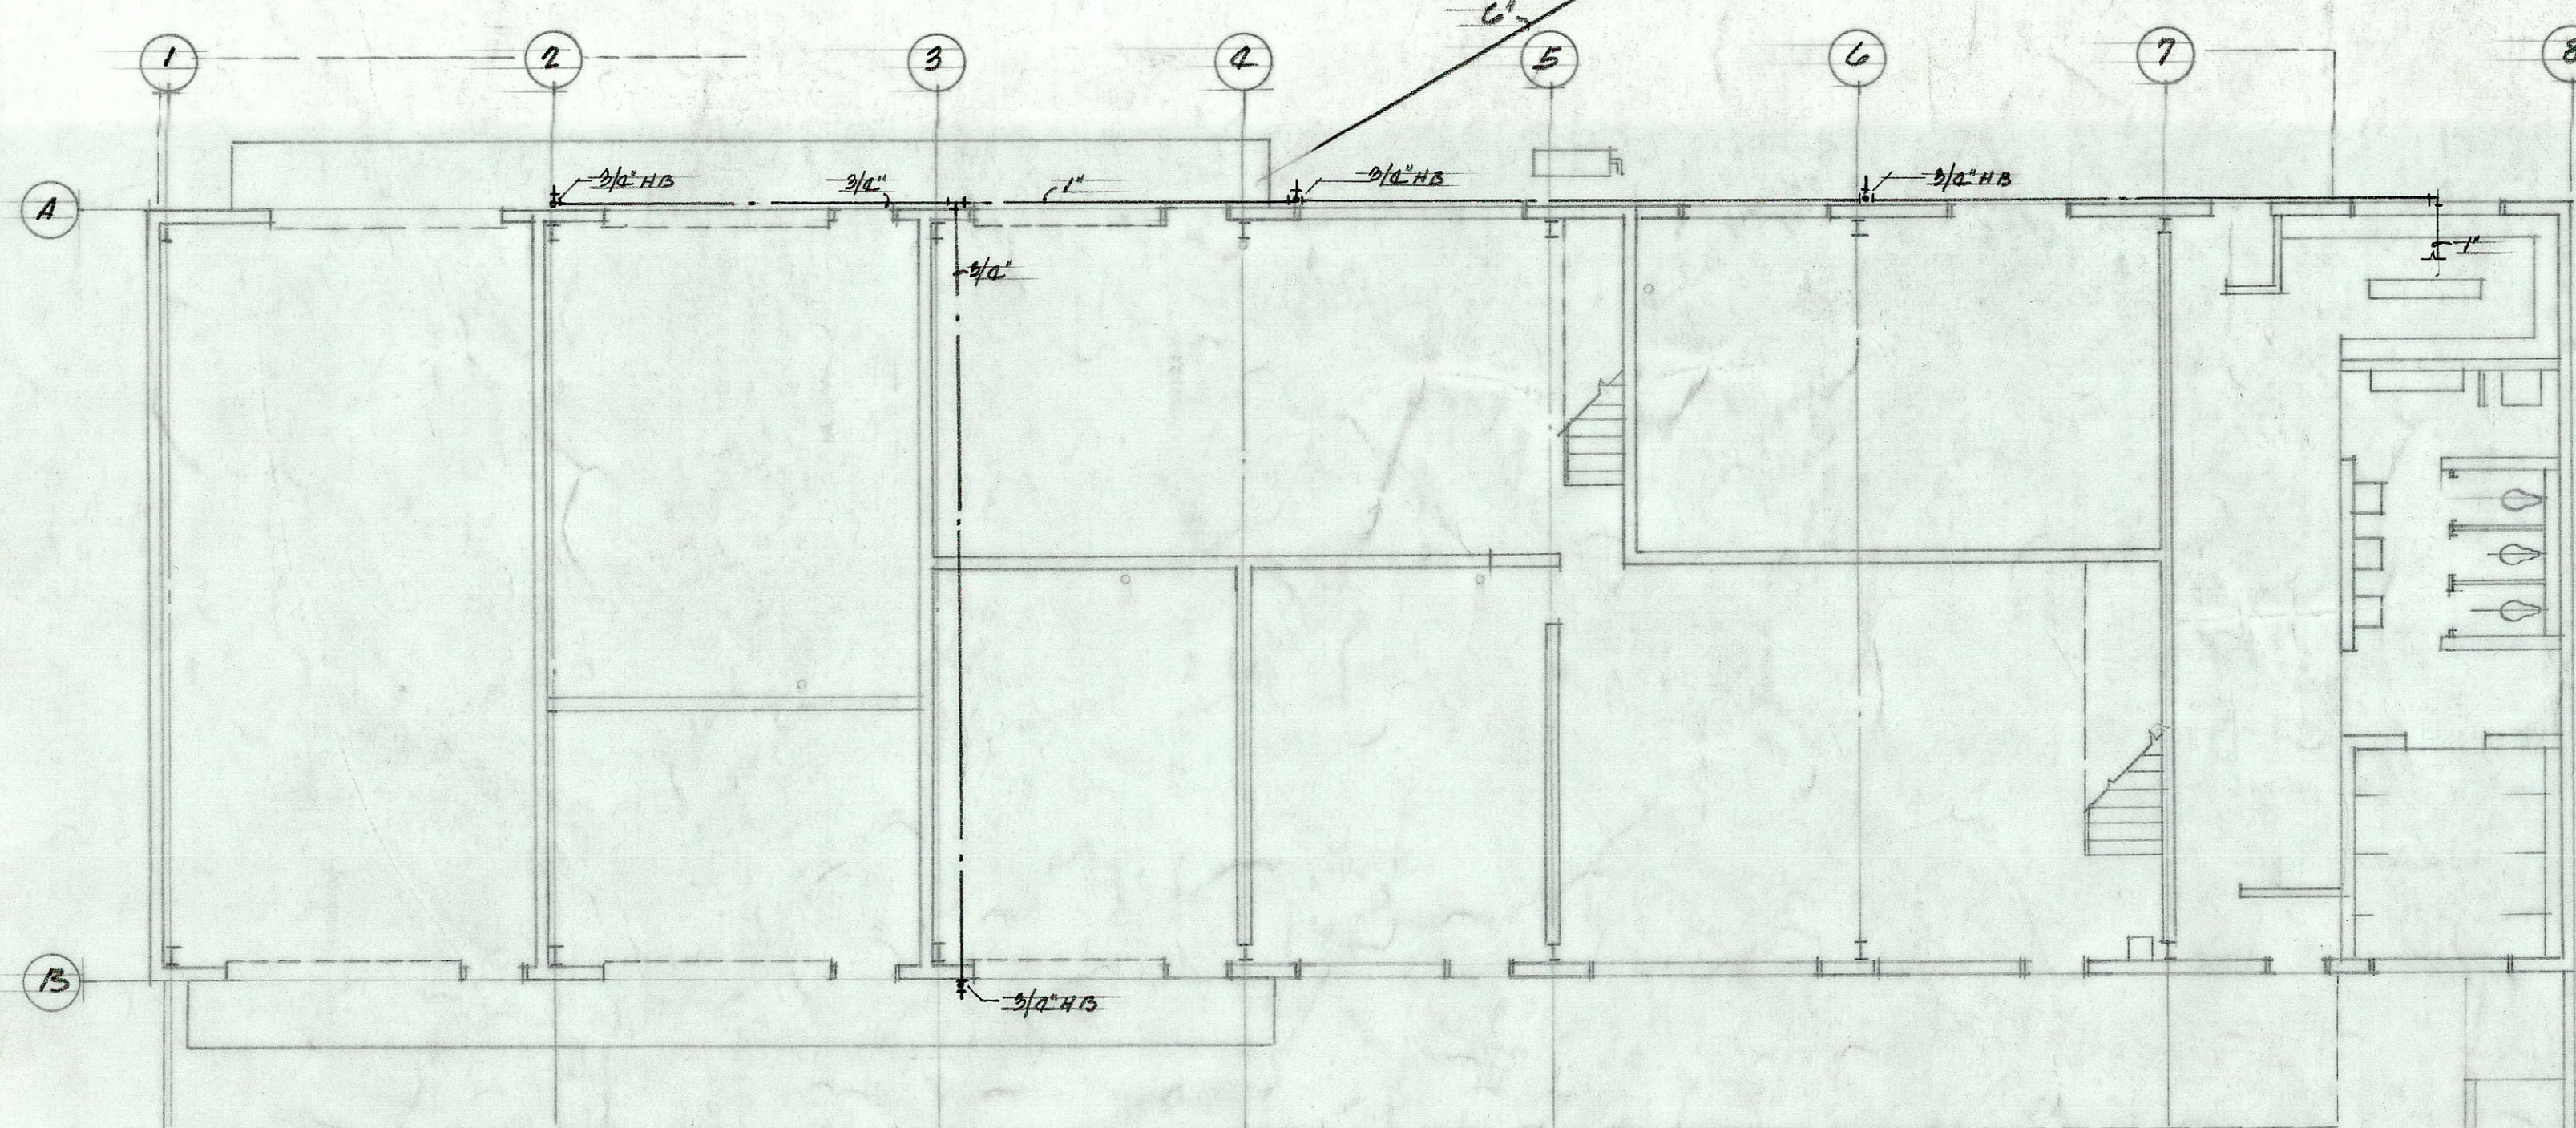

FIRST FLOOR PLAN
SCALE: 1/8" = 1'-0"

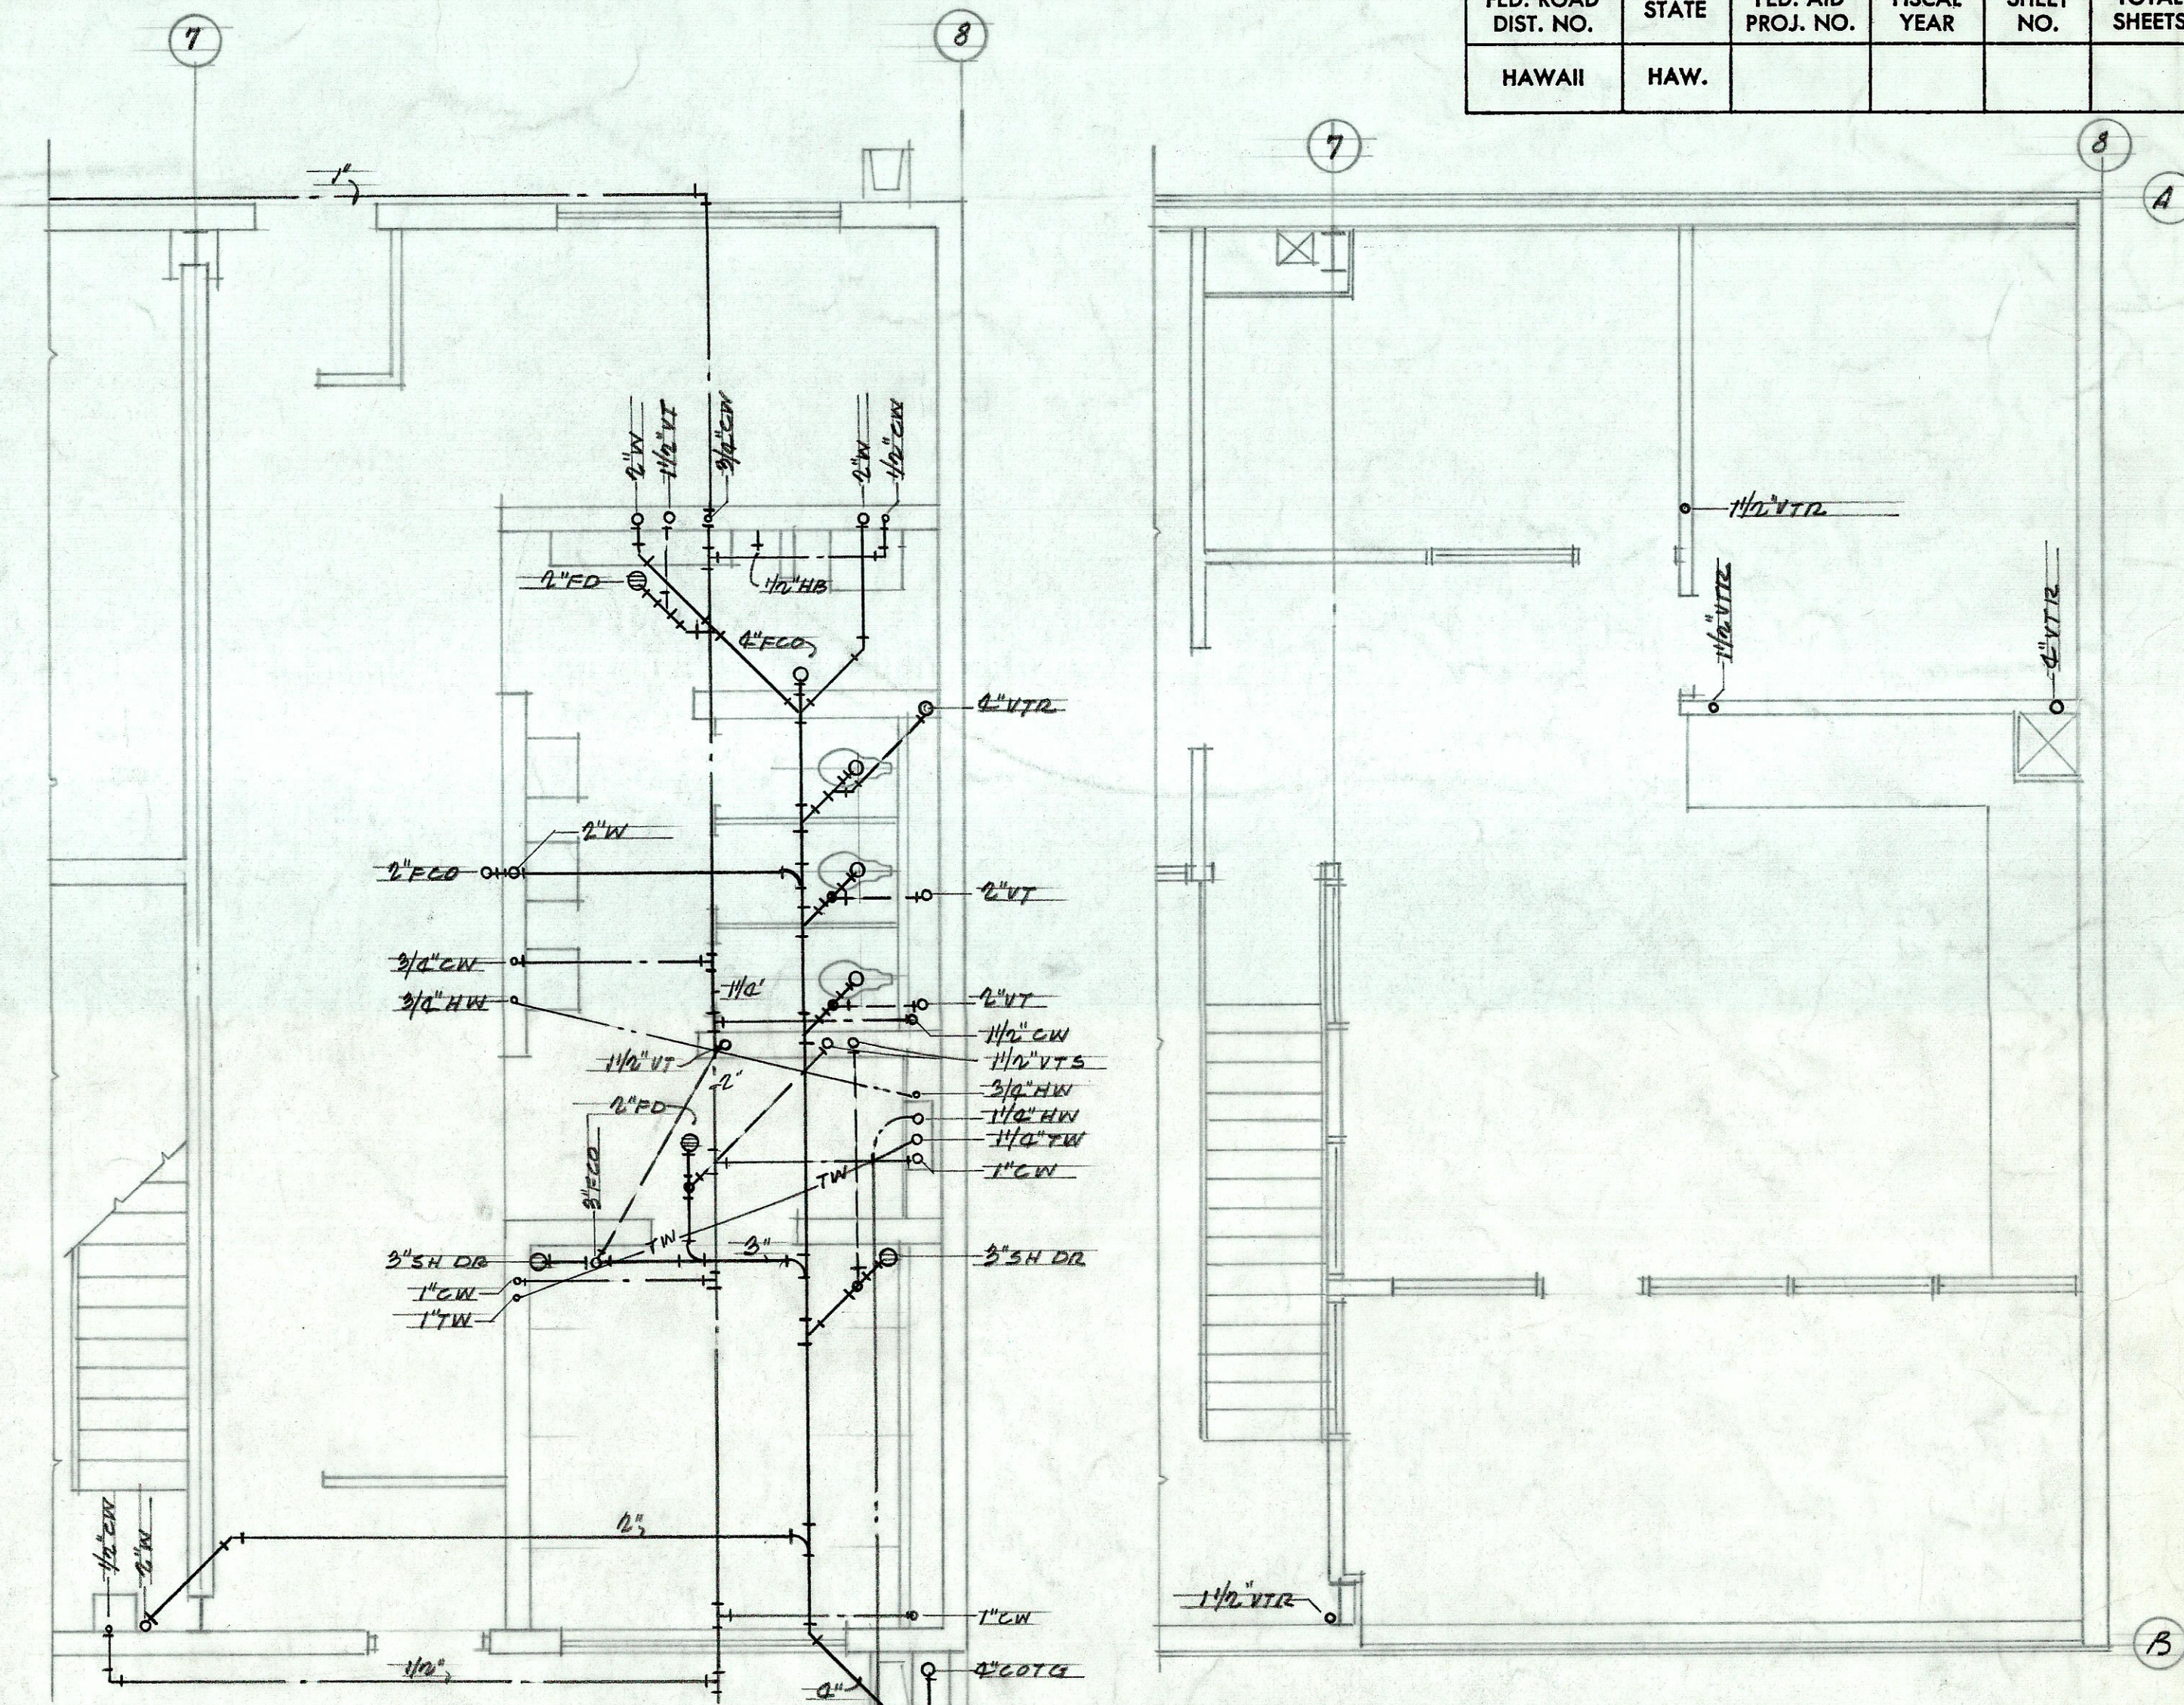


PARTIAL PLAN 1ST FLOOR
SCALE: 1/4" = 1'-0"

PARTIAL PLAN MEZZANINE
SCALE: 1/4" = 1'-0"

LEGEND & ABBREVIATIONS

- SOIL OR WASTE
- VENT
- COLD WATER
- HOT WATER
- TW --- TEMPERED WATER
- WC --- WATER CLOSET
- L --- LAVATORY
- UR --- URINAL
- S/S --- SERVICE SINK
- EWG --- ELECTRIC WATER COOLER
- FD --- FLOOR DRAIN
- SH --- SHOWER
- HB --- HOSE BIB
- FCO --- FLOOR CLEANOUT
- WCO --- WALL CLEANOUT
- COTG --- CLEANOUT TO GRADE

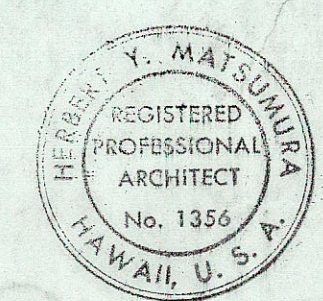

THIS WORK WAS PREPARED BY
ME OR UNDER MY SUPERVISION.

Herbert Y. Matsumura

DATE: OCT. 12, 1971

STATE OF HAWAII
DEPARTMENT OF TRANSPORTATION
HIGHWAYS DIVISION

DAHU DISTRICT BASEYARD MAINTENANCE BUILDING
SHAFTER FLATS INDUSTRIAL DEVELOPMENT
AT MOANALO, HONOLULU, OAHU, HAWAII

PLUMBING PLANS & DETAILS

HERBERT Y. MATSUMURA & ASSOCIATES, INC.
871 KAPIOLANI BLVD. HONOLULU, HAWAII

SHEET No. P.1 OF 21 SHEETS

DESIGNED BY	DATE
DRAWN BY	
CHECKED BY	
NOTED BY	
NO.	