

FED. ROAD DIST. NO.	STATE	FED. AID PROJ. NO.	FISCAL YEAR	SHEET NO.	TOTAL SHEETS
HAWAII	HAW.				

# OAHU DISTRICT BASEYARD MAINTENANCE BUILDING AT SHAFTER FLATS INDUSTRIAL DEVELOPMENT MOANALUA HONOLULU, OAHU, HAWAII

"AS BUILT" FOR THE  
STATE OF HAWAII  
DEPARTMENT OF TRANSPORTATION  
HIGHWAYS DIVISION  
HONOLULU, HAWAII

PROJECT NO. BD 70 - 421

HERBERT Y. MATSUMURA A.I.A.  
HAROLD T. MIYAMOTO  
ALBERT S.C. CHONG ASSOCIATES, INC.  
PHILIP S. WU & ASSOCIATES, INC.  
HENRY M. HOWETT

ARCHITECT  
STRUCTURAL ENGINEER  
ELECTRICAL ENGINEER  
MECHANICAL ENGINEER  
PLUMBING CONSULTANT

NOTE:  
ALL CHANGES MADE DURING CONSTRUCTION  
HAVE BEEN NOTED IN RED ON THESE TRACINGS  
AND CHECKED BY

*George K. Chong*  
PROJECT ENGINEER  
7-29-73  
DATE




THIS WORK WAS PREPARED BY  
ME OR UNDER MY SUPERVISION.  
*Herbert Y. Matsumura*  
DATE: OCT. 1971

STATE OF HAWAII DEPARTMENT OF TRANSPORTATION HIGHWAYS DIVISION
OAHU DISTRICT BASEYARD MAINTENANCE BUILDING SHAFTER FLATS INDUSTRIAL DEVELOPMENT AT MOANALUA, HONOLULU, OAHU, HAWAII
TITLE SHEET, INDEX TO DRAWINGS
HERBERT Y. MATSUMURA & ASSOCIATES, INC. 871 KAPOLANI BLVD. HONOLULU, HAWAII
SHEET No. 1 OF 21 SHEETS

SHT. No.	DESCRIPTION
T-1	TITLE SHEET, INDEX TO DRAWINGS
C-1	PLOT PLAN & DETAILS
A-1	FIRST, MEZZANINE, & ROOF PLAN, RM. FIN.
A-2	EXTERIOR ELEVATIONS & LONGITUDINAL SECTION
A-3	CROSS SECTIONS & DETAILS
A-4	PARTIAL FIRST FLOOR PLAN & INTERIOR ELEV.
A-5	MEZZANINE FLOOR PLAN & INTERIOR ELEVATIONS
A-6	WALL SECTIONS & DETAILS
A-7	STEEL STAIR #1 & #2 & DETAILS
A-8	INTERIOR ELEVATIONS OF STAGING RM & DETAILS
A-9	REFLECTED CLG PLANS & DETS., DOOR SCHED. & DETAILS
A-10	WINDOW SCHEDULE & DETAILS
S-1	FOUNDATION PLAN & SECTIONS
S-2	MEZZANINE PLAN & SECTIONS
S-3	ROOF PLAN & ELEVATIONS
E-1	ELECTRICAL SITE PLAN, SYMBOLS
E-2	LIGHTING PLANS AND LUMINAIRE SCHEDULE
E-3	FIRST FLR. POWER & SIGNAL PLAN, PANEL SCHEDS, DETAIL
E-4	SINGLE LINE DIAGRAM, SECTIONS, DETAILS.
P-1	PLUMBING PLANS & DETAILS.
M-1	AIR CONDITION PLAN-DIAGRAMS & MISC. DETAILS.

Changes in Red

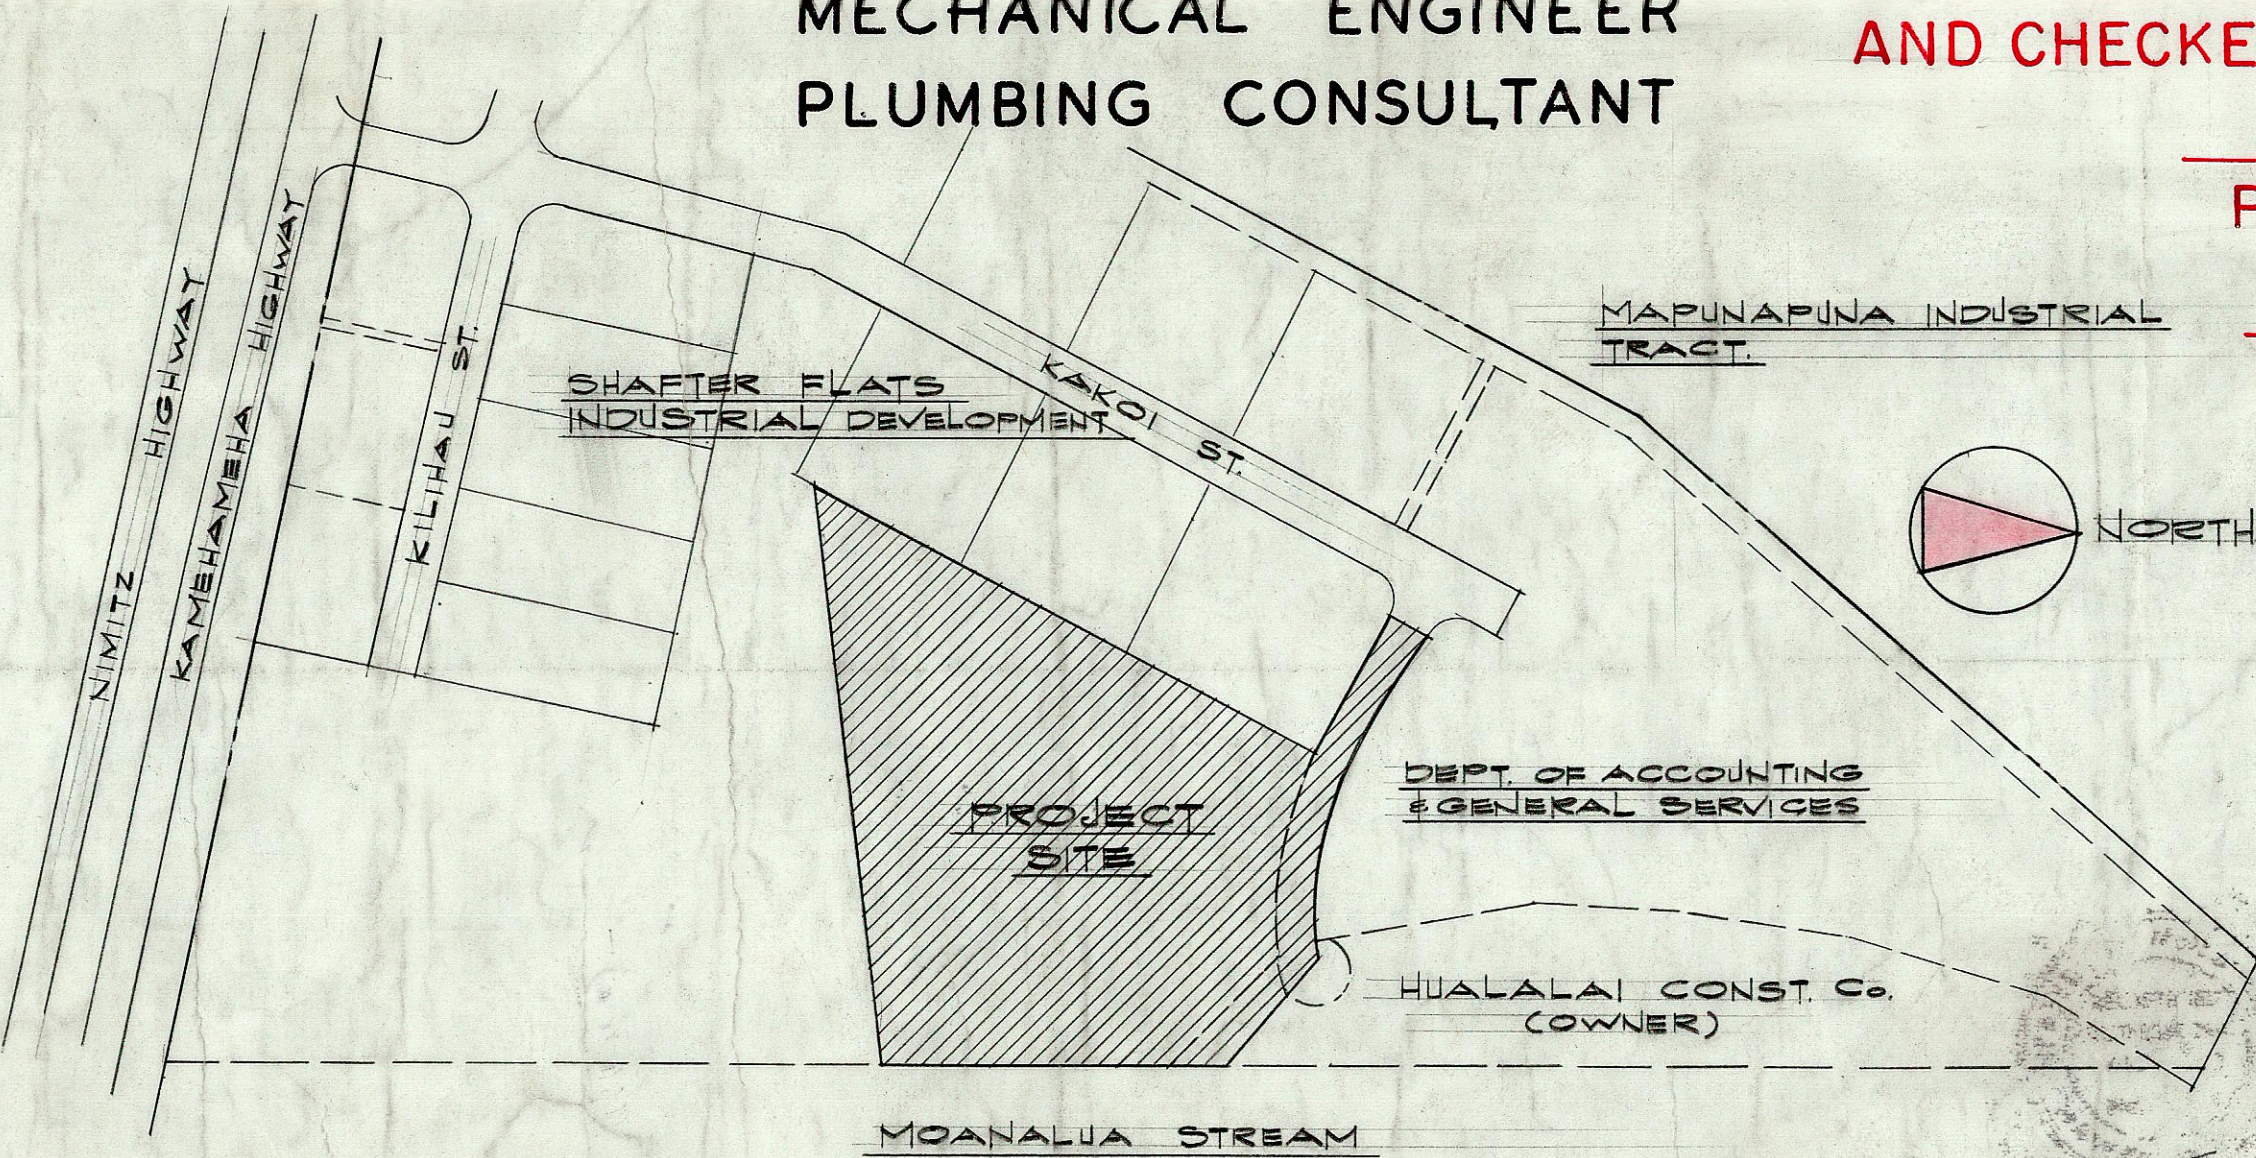

LOCATION MAP  
SCALE: 1"=200'-0"  
TAX MAP KEY 11-64-2

APPROVED BY:

*Murray Lee*  
DIRECTOR, DEPARTMENT OF TRANSPORTATION  
STATE OF HAWAII  
*Henry M. Howett*  
EXECUTIVE OFFICER, ENVIRONMENTAL HEALTH DIVISION  
STATE OF HAWAII  
*Albert S.C. Chong*  
CHIEF DEPUTY FIRE MARSHALL  
STATE OF HAWAII

12/14/71  
DATE  
10/14/71  
DATE  
10-19-71  
DATE

DATE	
SURVEY PLATTED BY	
DESIGNED BY	
TRACED BY	
NOTE BOOK	
CHECKED BY	
No.	