


FED. ROAD DIST. NO.	STATE	PROJ. NO.	FISCAL YEAR	SHEET NO.	TOTAL SHEETS
HAWAII	HAW.	HWY-0-09-06	2008	13	46

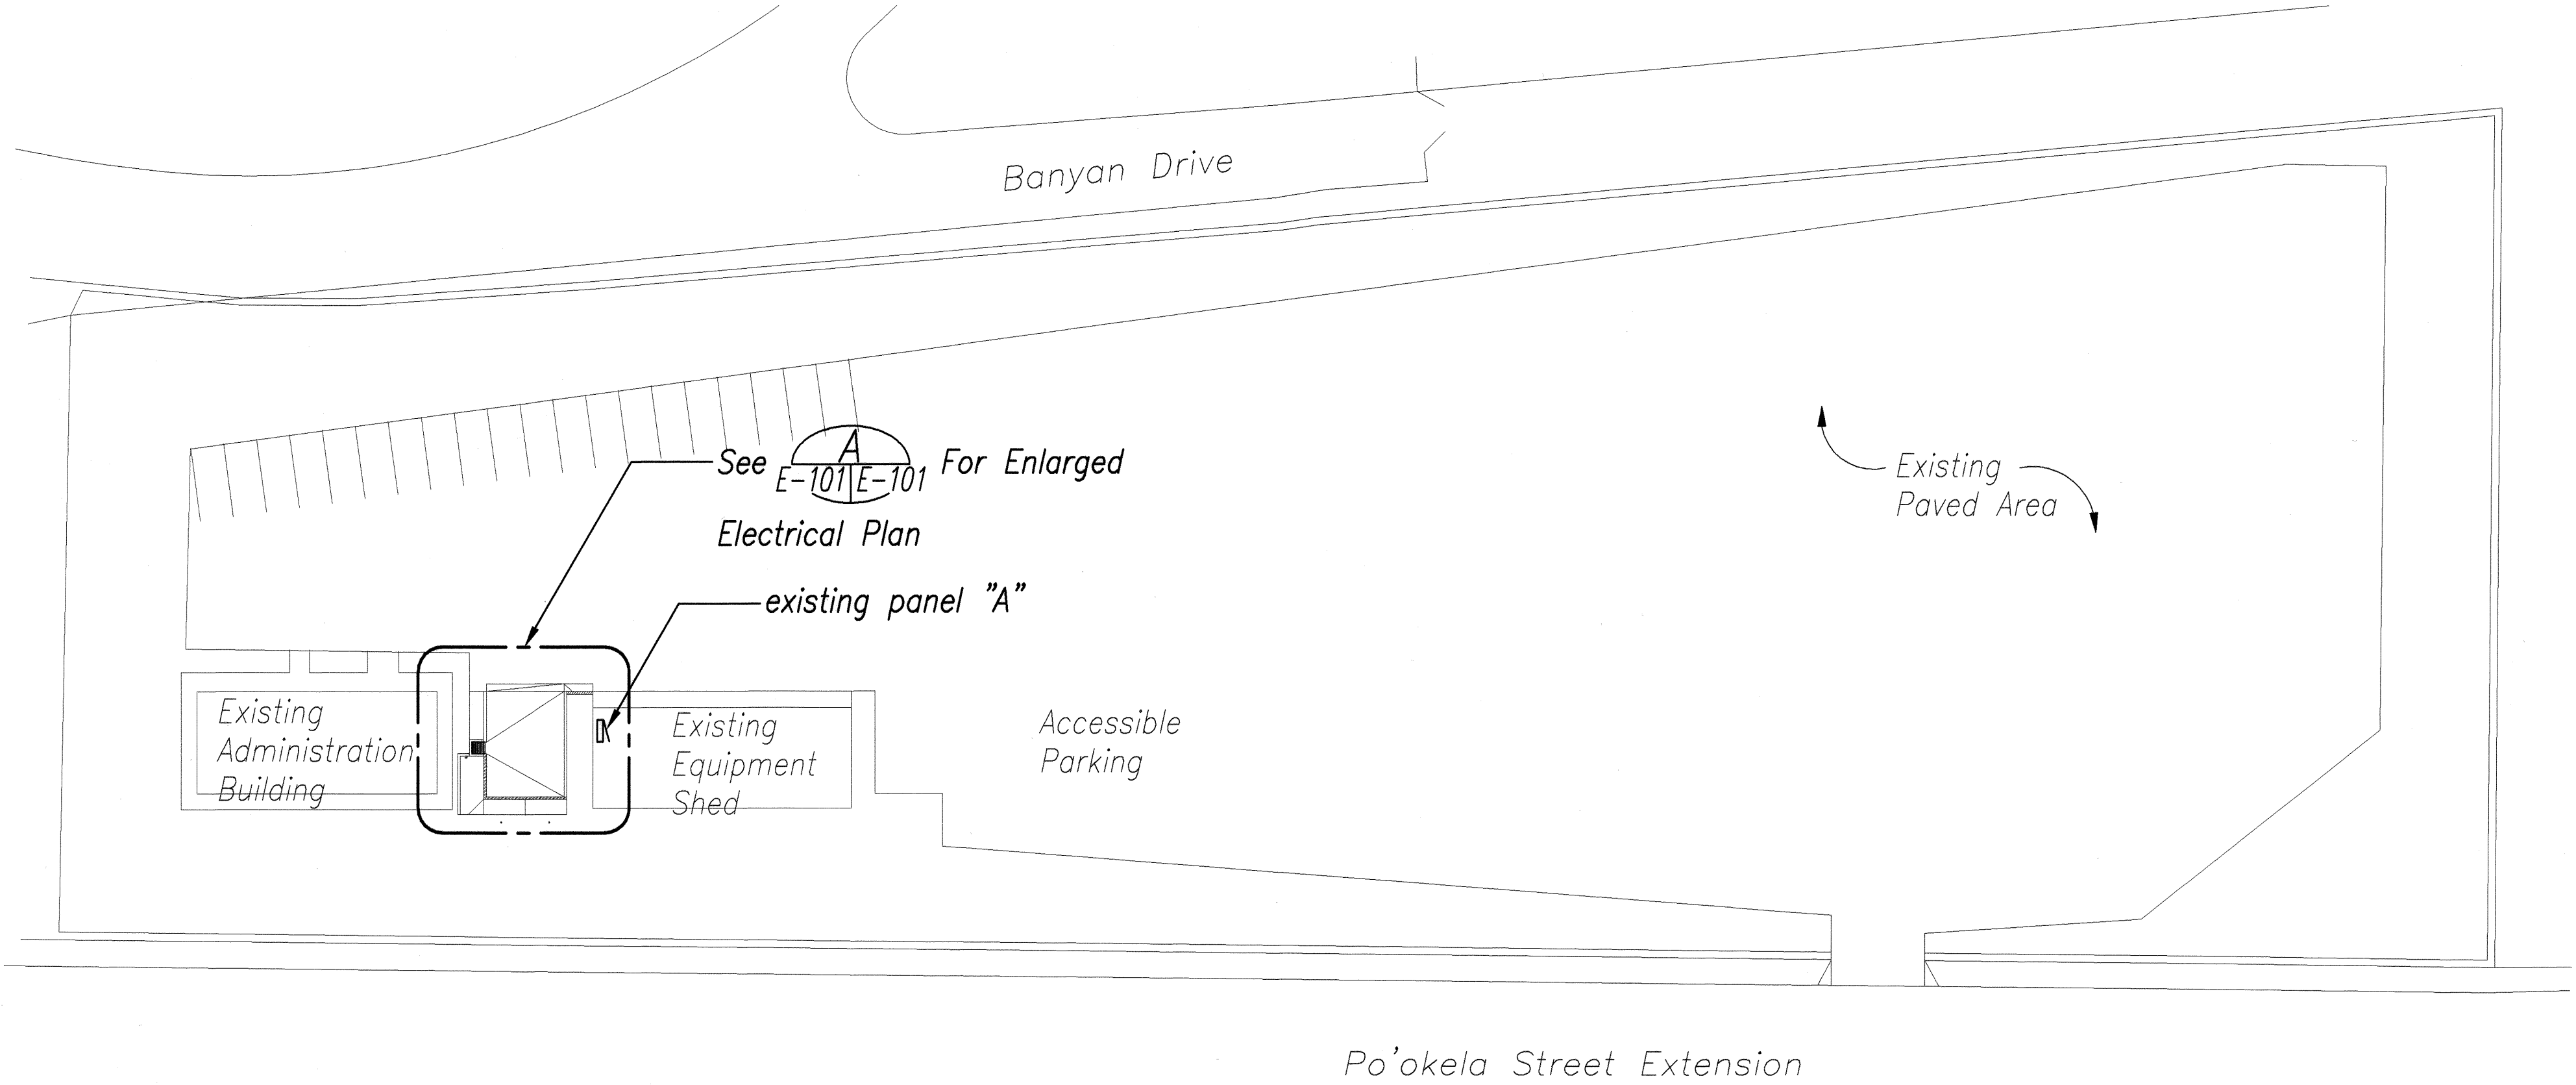

# ELECTRICAL SYMBOLS

- Duplex Convenience Outlet, 3W20A, Ground Fault Interrupter Type, +16" Unless Otherwise Noted
- Wall Junction box, 4-11/16" Square Minimum
- Large Junction Box
- existing panelboard
- Equipment Connection
- Safety Switch
- WP Weatherproof

- Wiring In Raceway Concealed In Floor Or Below Grade
- Wiring In Exposed Raceway

- Notes:**
- Any Circuit With No Further Designation Indicates A Two Wire Circuit. Circuits With Additional Wires Are Indicates As Follows: , 3 Wires: , 4 Wires, Etc.
  - Ground Wire Per National Electrical Code Indicated As Follows:
  - All Exposed Conduit And Boxes Shall Be Painted To Match Adjacent Wall Or Ceiling Surrounding

**ELECTRICAL SITE PLAN (Kaneohe Baseyard)**  
 SCALE : 1/32" = 1'-0"

ORIGINAL PLAN	SURVEY PLOTTED BY	DATE
NOTE BOOK	DRAWN BY	
No.	DESIGNED BY	
	CHECKED BY	



EXPIRATION DATE OF THE LICENSE 4/30/2010  
 THIS WORK WAS PREPARED BY  
 ME OR UNDER MY SUPERVISION

STATE OF HAWAII  
DEPARTMENT OF TRANSPORTATION  
HIGHWAYS DIVISION

**ELECTRICAL SITE PLAN  
(Kaneohe Baseyard)**


Kaneohe, Pearl City and Waianae  
Baseyard Washdown Racks  
Project No. HWY-0-09-06

Scale: 1/32" = 1'-0"      Date: MAY 2008

SHEET No. E-100 OF 46 SHEETS

13


FED. ROAD DIST. NO.	STATE	PROJ. NO.	FISCAL YEAR	SHEET NO.	TOTAL SHEETS
HAWAII	HAW.	HWY-0-09-06	2008	14	46

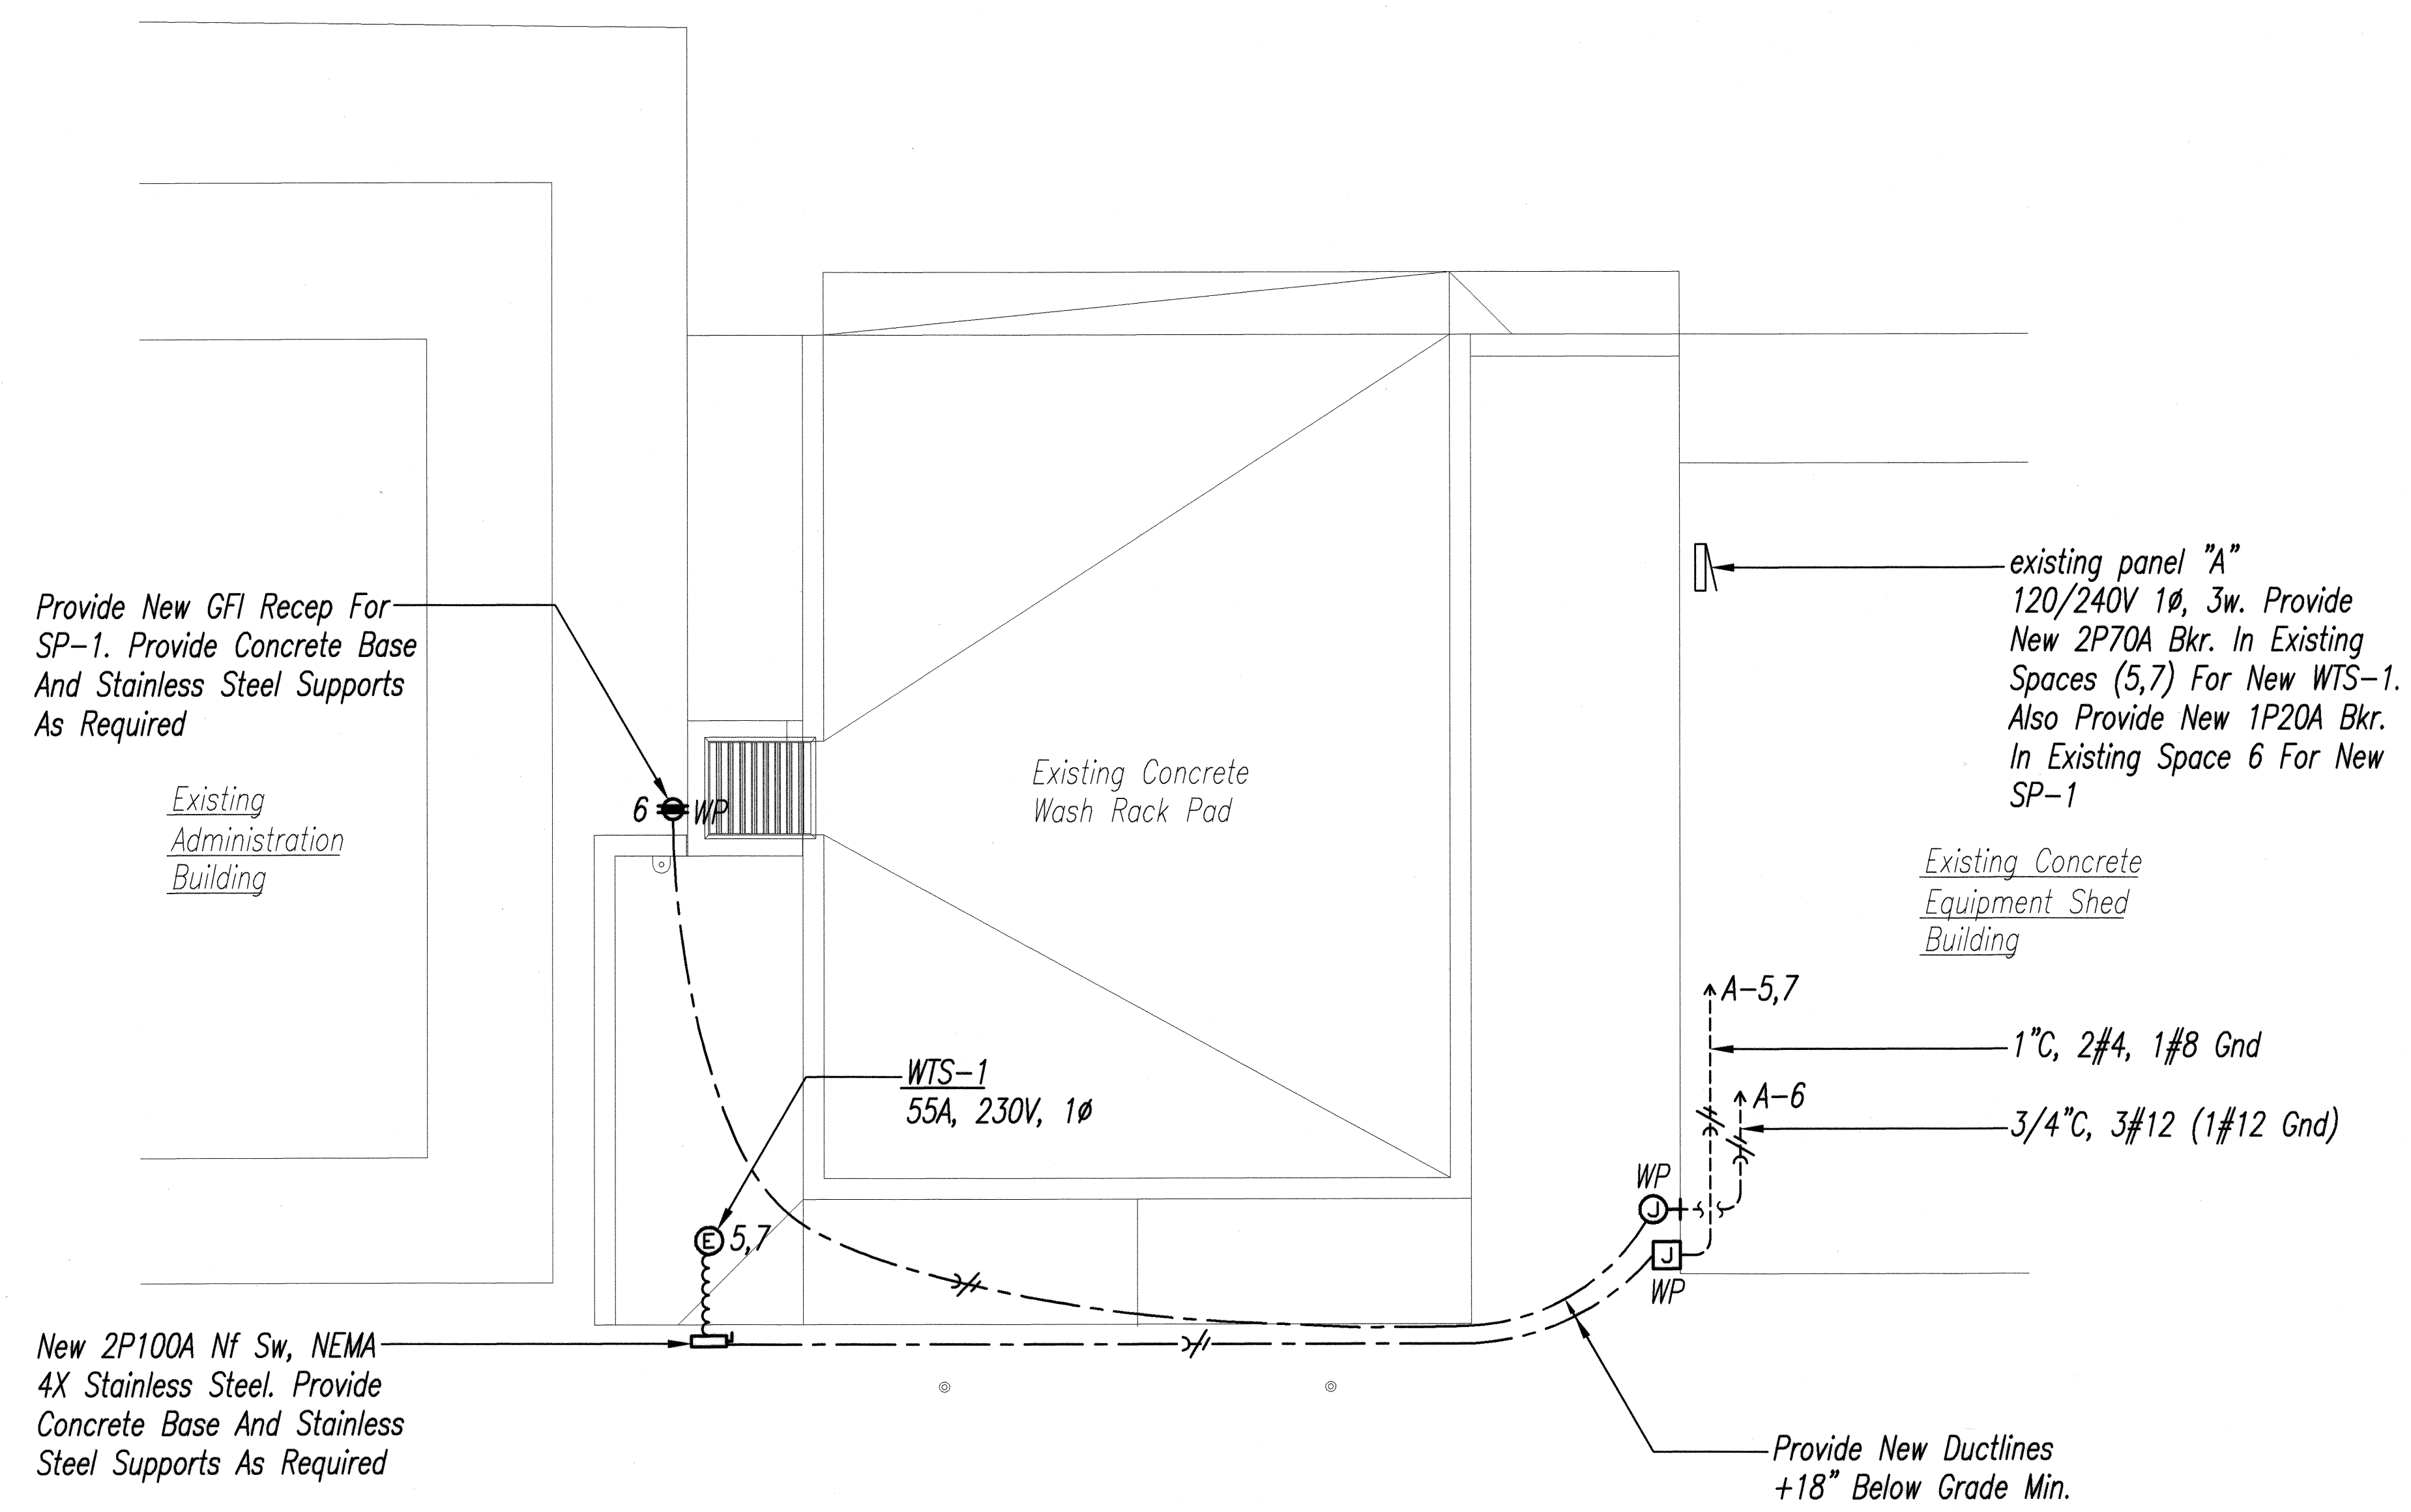

ORIGINAL PLAN	DATE
DESIGNED BY	
TRACED BY	
NOTE BOOK	
QUANTITIES BY	
CHECKED BY	
No.	



**ENLARGED ELECTRICAL PLAN (Kaneohe Baseyard)**  
 SCALE : 1/4" = 1'- 0"

  
 EXPIRATION DATE OF THE LICENSE 4/30/2010  
 THIS WORK WAS PREPARED BY  
 ME OR UNDER MY SUPERVISION

STATE OF HAWAII  
 DEPARTMENT OF TRANSPORTATION  
 HIGHWAYS DIVISION

**ENLARGED ELECTRICAL PLAN**  
**(Kaneohe Baseyard)**  
 KANEOHE, PEARL CITY AND WAIANAE  
 BASEYARD WASHDOWN RACKS  
 Project No. HWY-0-09-06

Scale: 1/4" = 1'-0"      Date: MAY 2008

SHEET No. E-101 OF 46 SHEETS