


FED. ROAD DIST. NO.	STATE	PROJ. NO.	FISCAL YEAR	SHEET NO.	TOTAL SHEETS
HAWAII	HAW.	HWY-0-09-06	2008	ADD.16	46

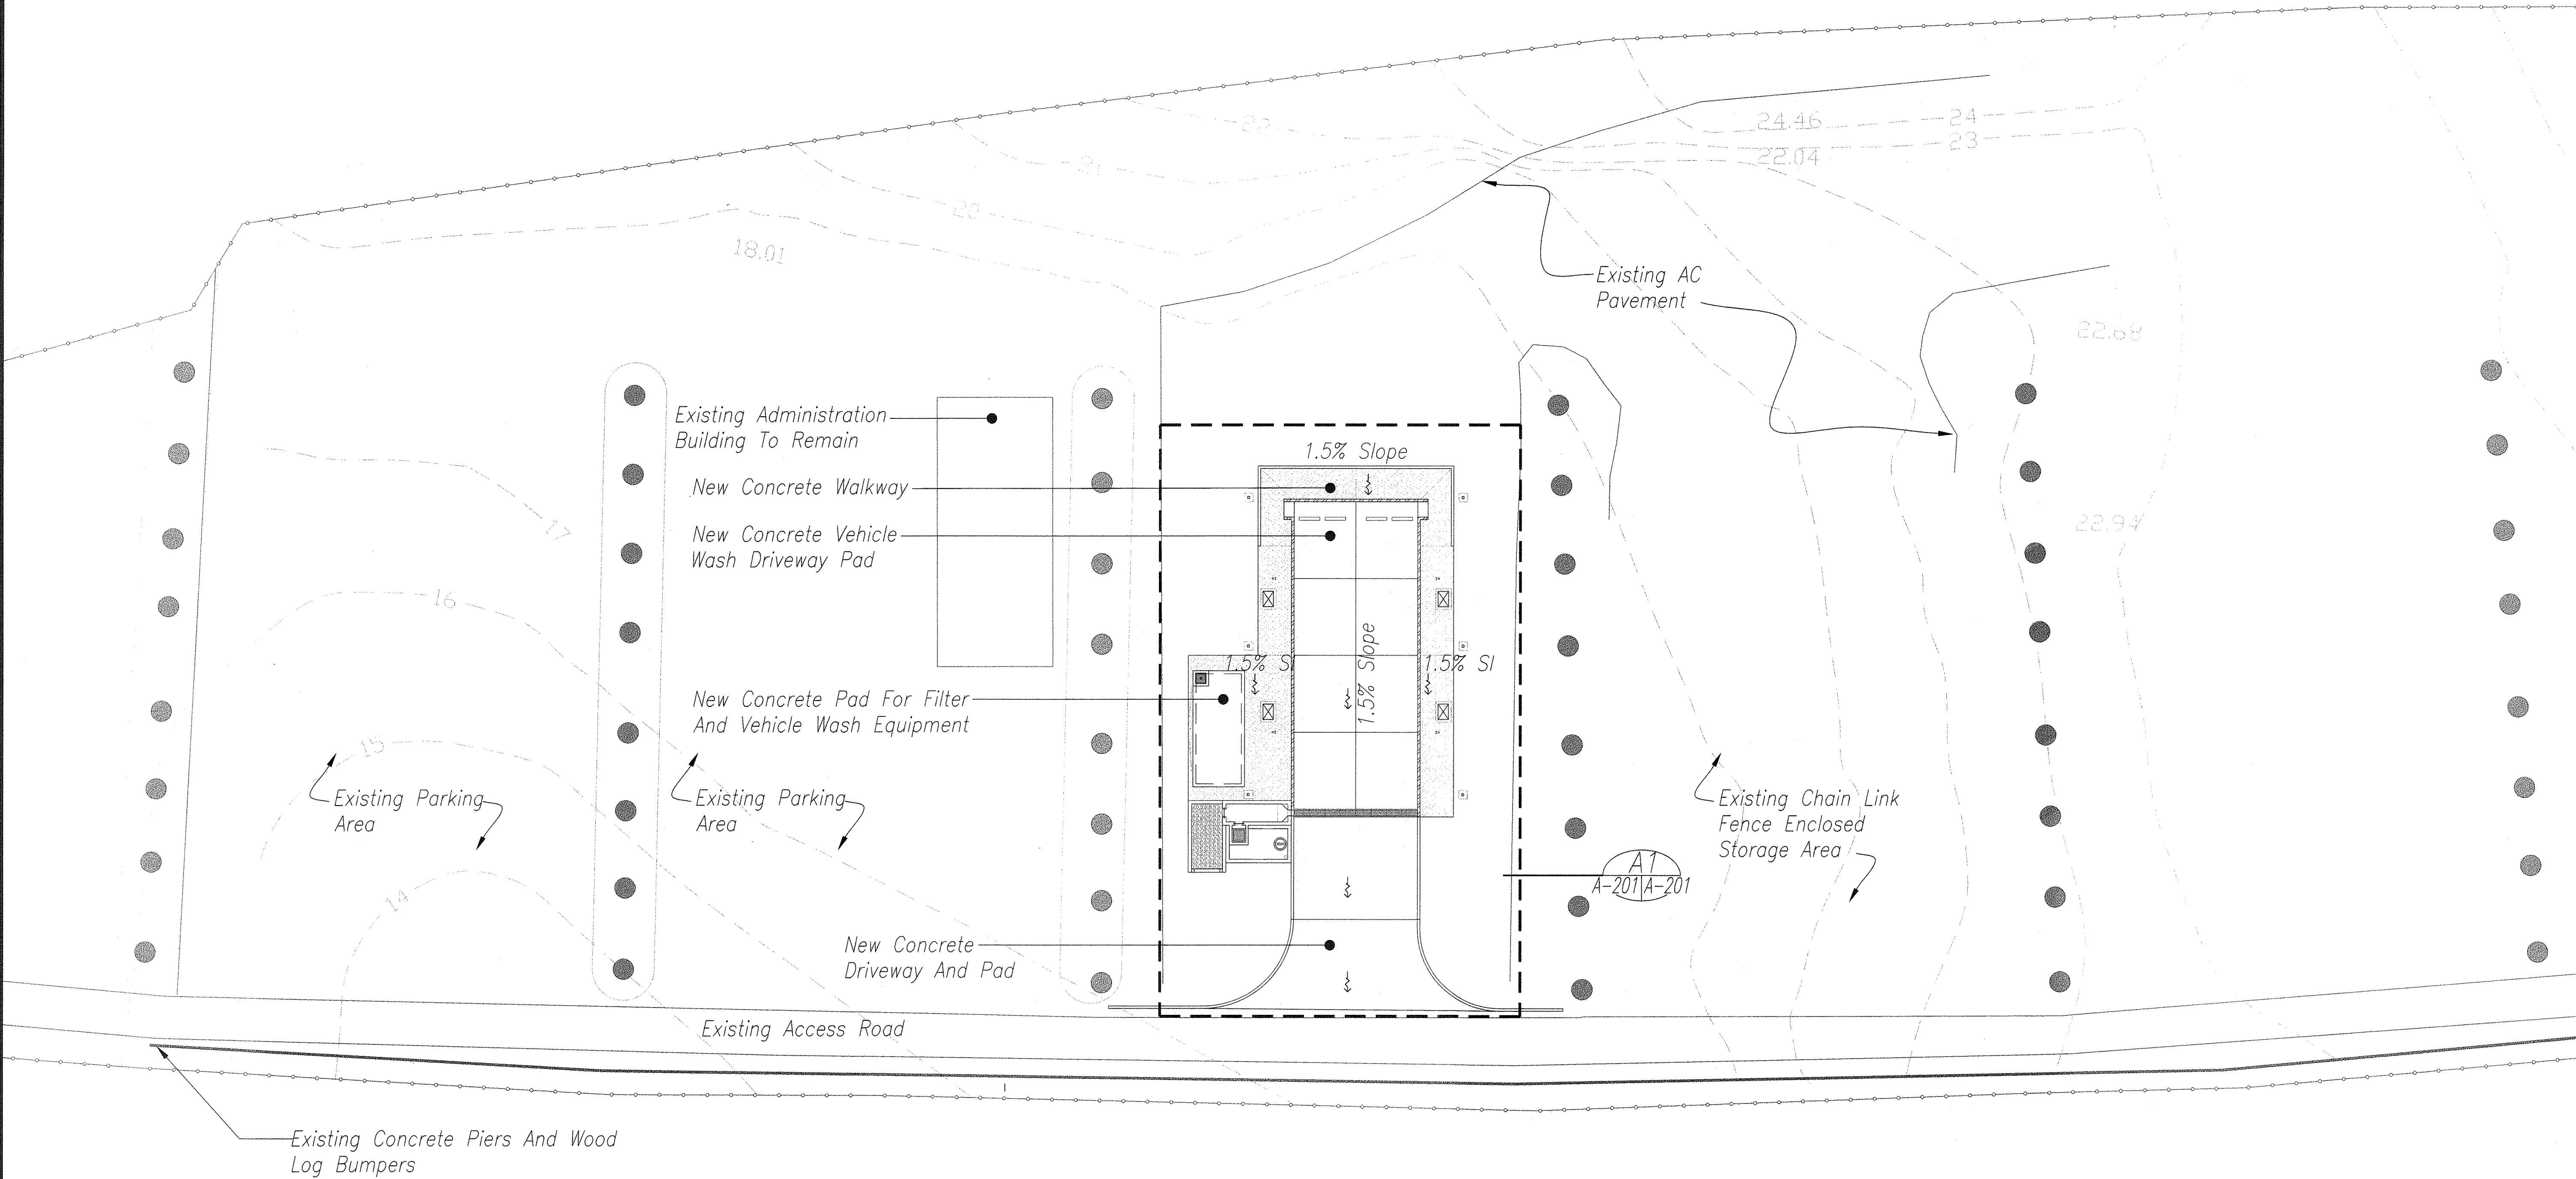

DATE	_____
SURVEY PLOTTED BY	_____
DRAWN BY	_____
DESIGNED BY	_____
CHECKED BY	_____
NOTED BY	_____
NO.	_____


OVERALL SITE PLAN 
 1/16" = 1'-0"



EXPIRATION DATE OF THE LICENSE 4/30/2010
 THIS WORK WAS PREPARED BY
 ME OR UNDER MY SUPERVISION

6/10/08	 Revised Overall Site Plan
DATE	REVISION
STATE OF HAWAII DEPARTMENT OF TRANSPORTATION HIGHWAYS DIVISION PEARL CITY BASEYARD PLAN KANEOHE, PEARL CITY AND WAIANAE BASEYARD WASHDOWN RACKS Project No. HWY-0-09-06 Scale: 1/16" = 1'-0" Date: MAY 2008	
SHEET No. A-200 OF 46 SHEETS	

FED. ROAD DIST. NO.	STATE	PROJ. NO.	FISCAL YEAR	SHEET NO.	TOTAL SHEETS
HAWAII	HAW.	HWY-0-09-06	2008	ADD.17	46

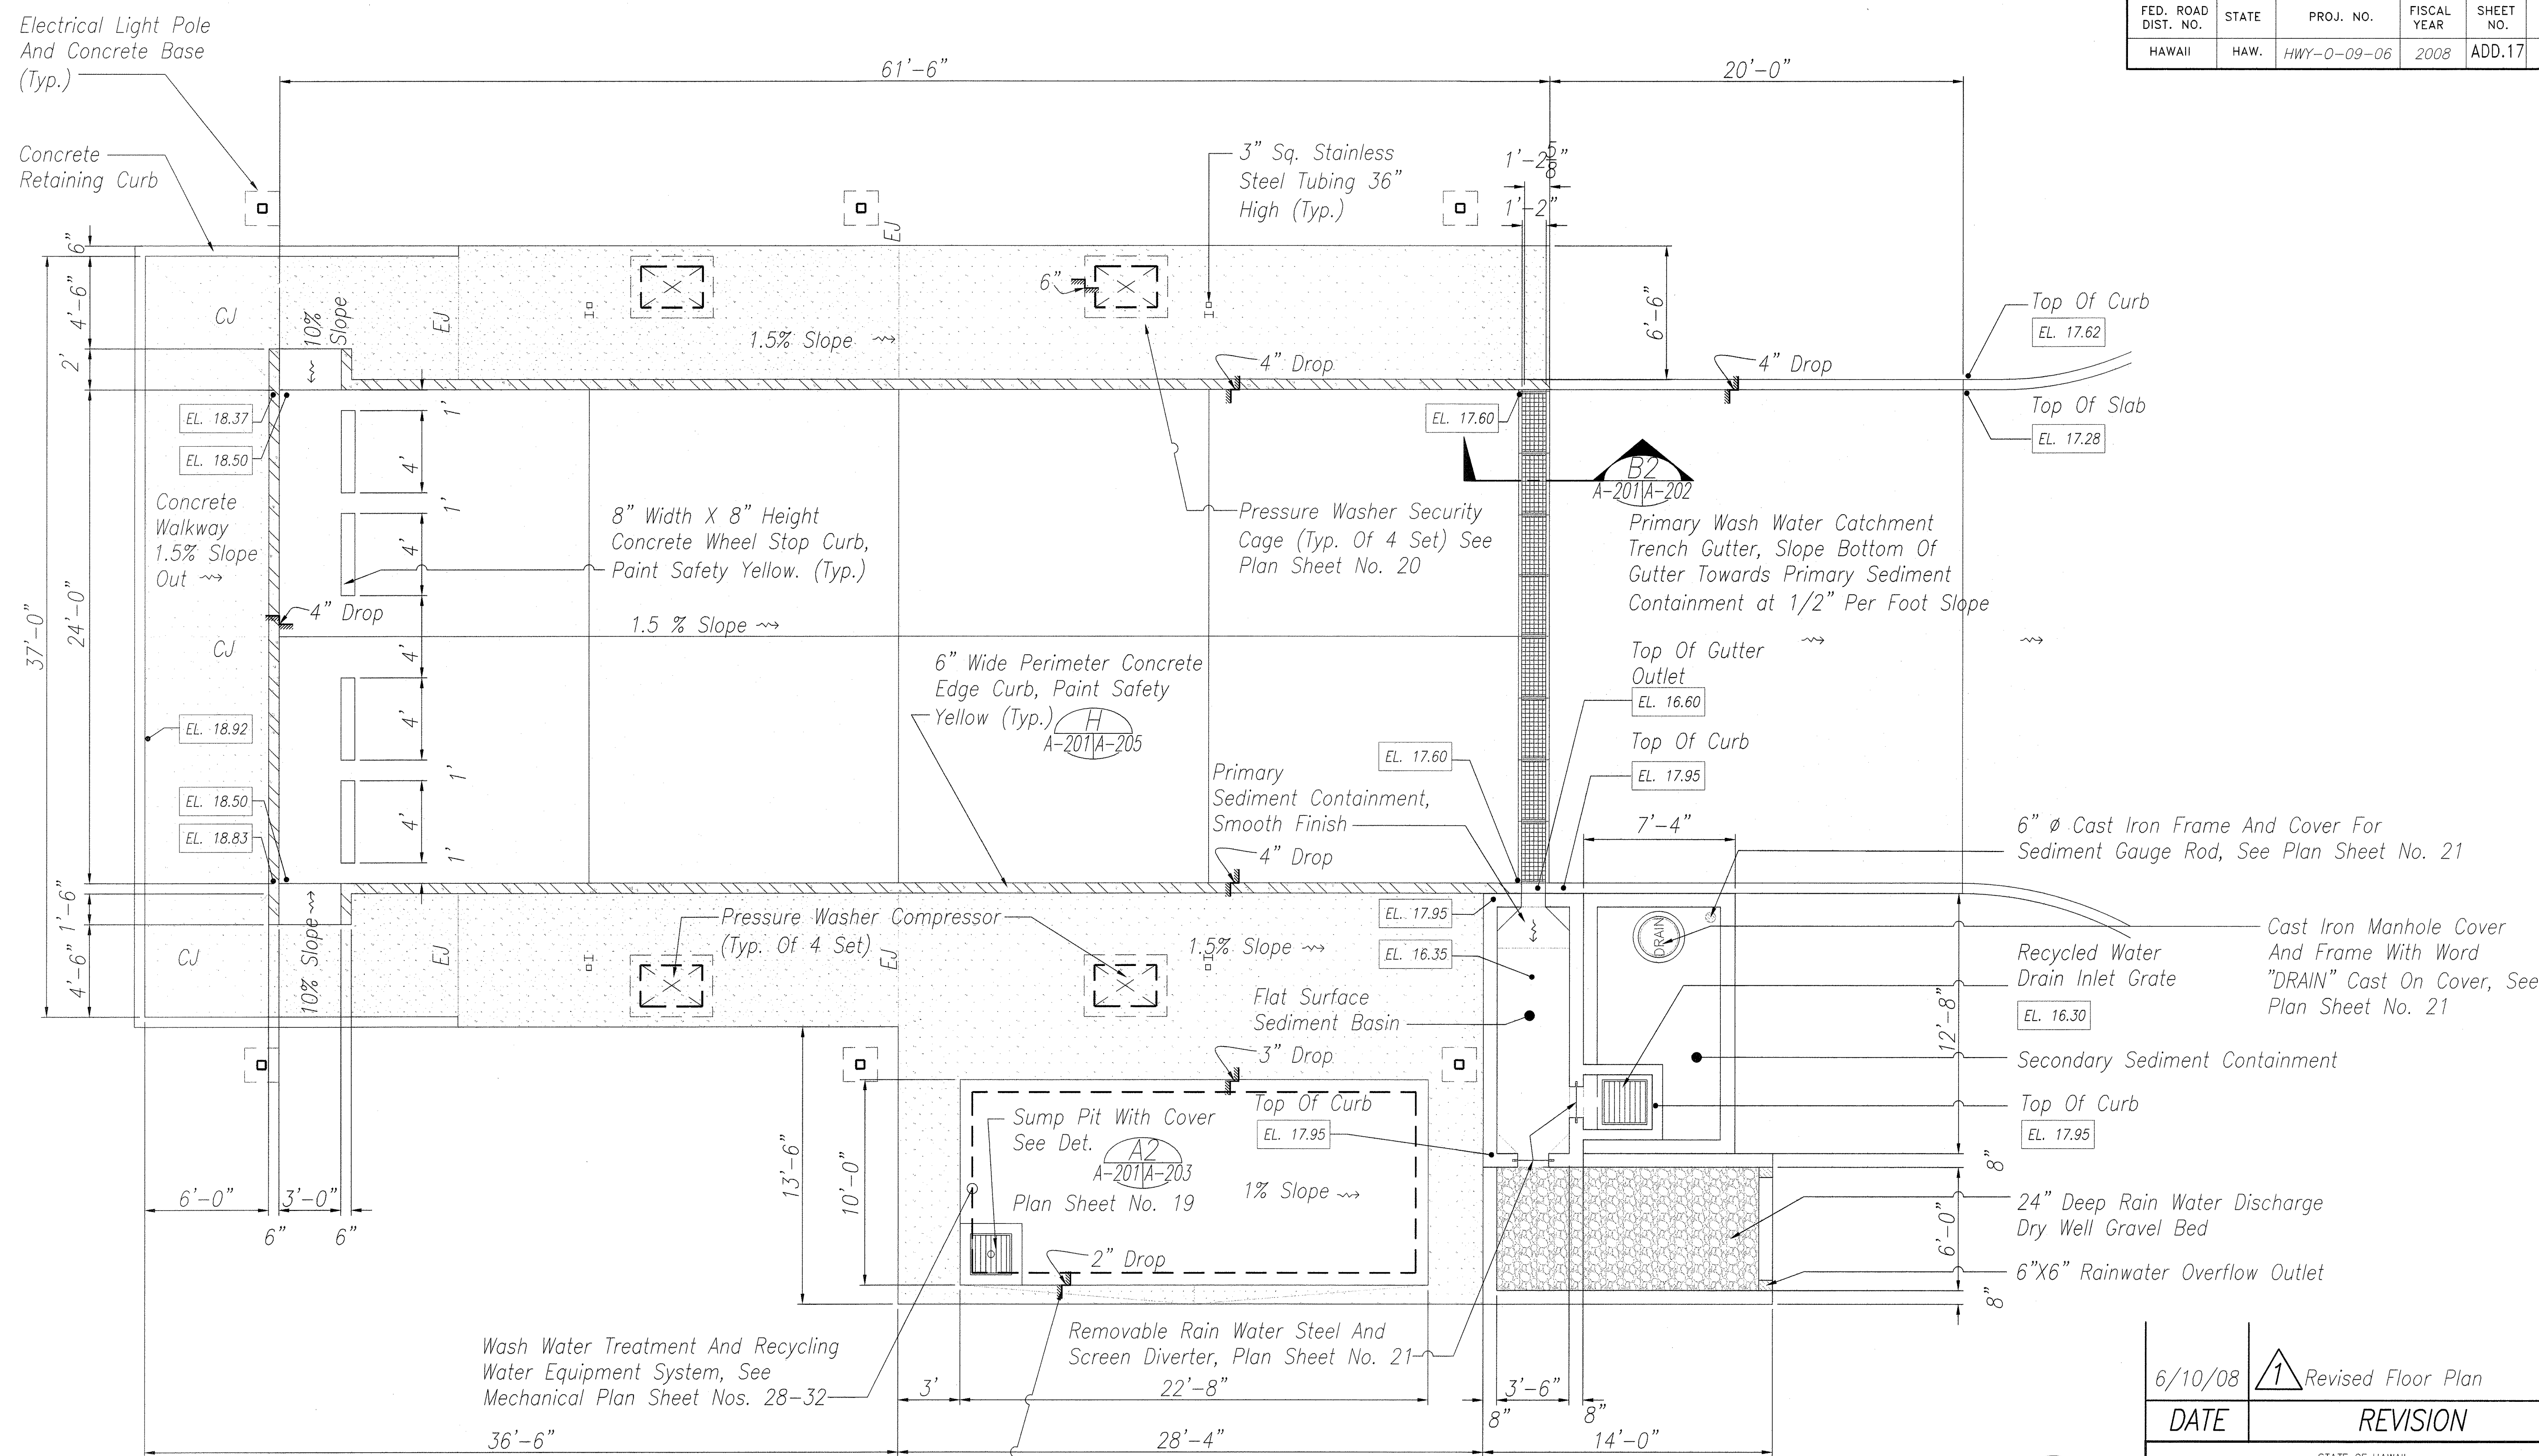

SURVEY PLOTTED BY	DATE
DRAWN BY	
TRACED BY	
NOTED BY	
CHECKED BY	
ORIGINAL PLAN	
NOTE BOOK	
No.	


FLOOR PLAN
A-2001A-201 1/4" = 1'-0"



Wash Water Treatment And Recycling Water Equipment System, See Mechanical Plan Sheet Nos. 28-32

2" Raised Concrete Pad For Wash Water Treatment And Recycling Equipment, Verify Mechanical Equipment Size. Set Top Of Concrete Pad At 1% Slope Out To Edges.

Note:
Except Stainless Steel, Manholes And Galvanized Grating, All Exposed Steel Components Shall Be Hot Dipped Galvanized After Fabrication. Grind And Smooth All Surfaces Painted After Installation.

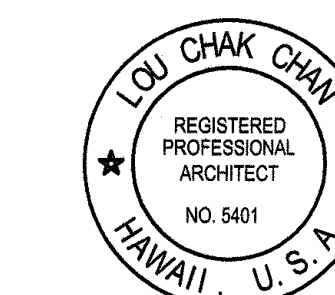



EXPIRATION DATE OF THE LICENSE 4/30/2010
THIS WORK WAS PREPARED BY ME OR UNDER MY SUPERVISION

6/10/08	1 Revised Floor Plan
DATE	REVISION
STATE OF HAWAII DEPARTMENT OF TRANSPORTATION HIGHWAYS DIVISION PEARL CITY BASEYARD PLAN KANEOHE, PEARL CITY AND WAIANAE BASEYARD WASHDOWN RACKS Project No. HWY-0-09-06	
Scale: 1/4" = 1'-0"	Date: MAY 2008

SHEET No. A-201 OF 46 SHEETS


ADD.17

FED. ROAD DIST. NO.	STATE	PROJ. NO.	FISCAL YEAR	SHEET NO.	TOTAL SHEETS
HAWAII	HAW.	HWY-0-09-06	2008	19	46

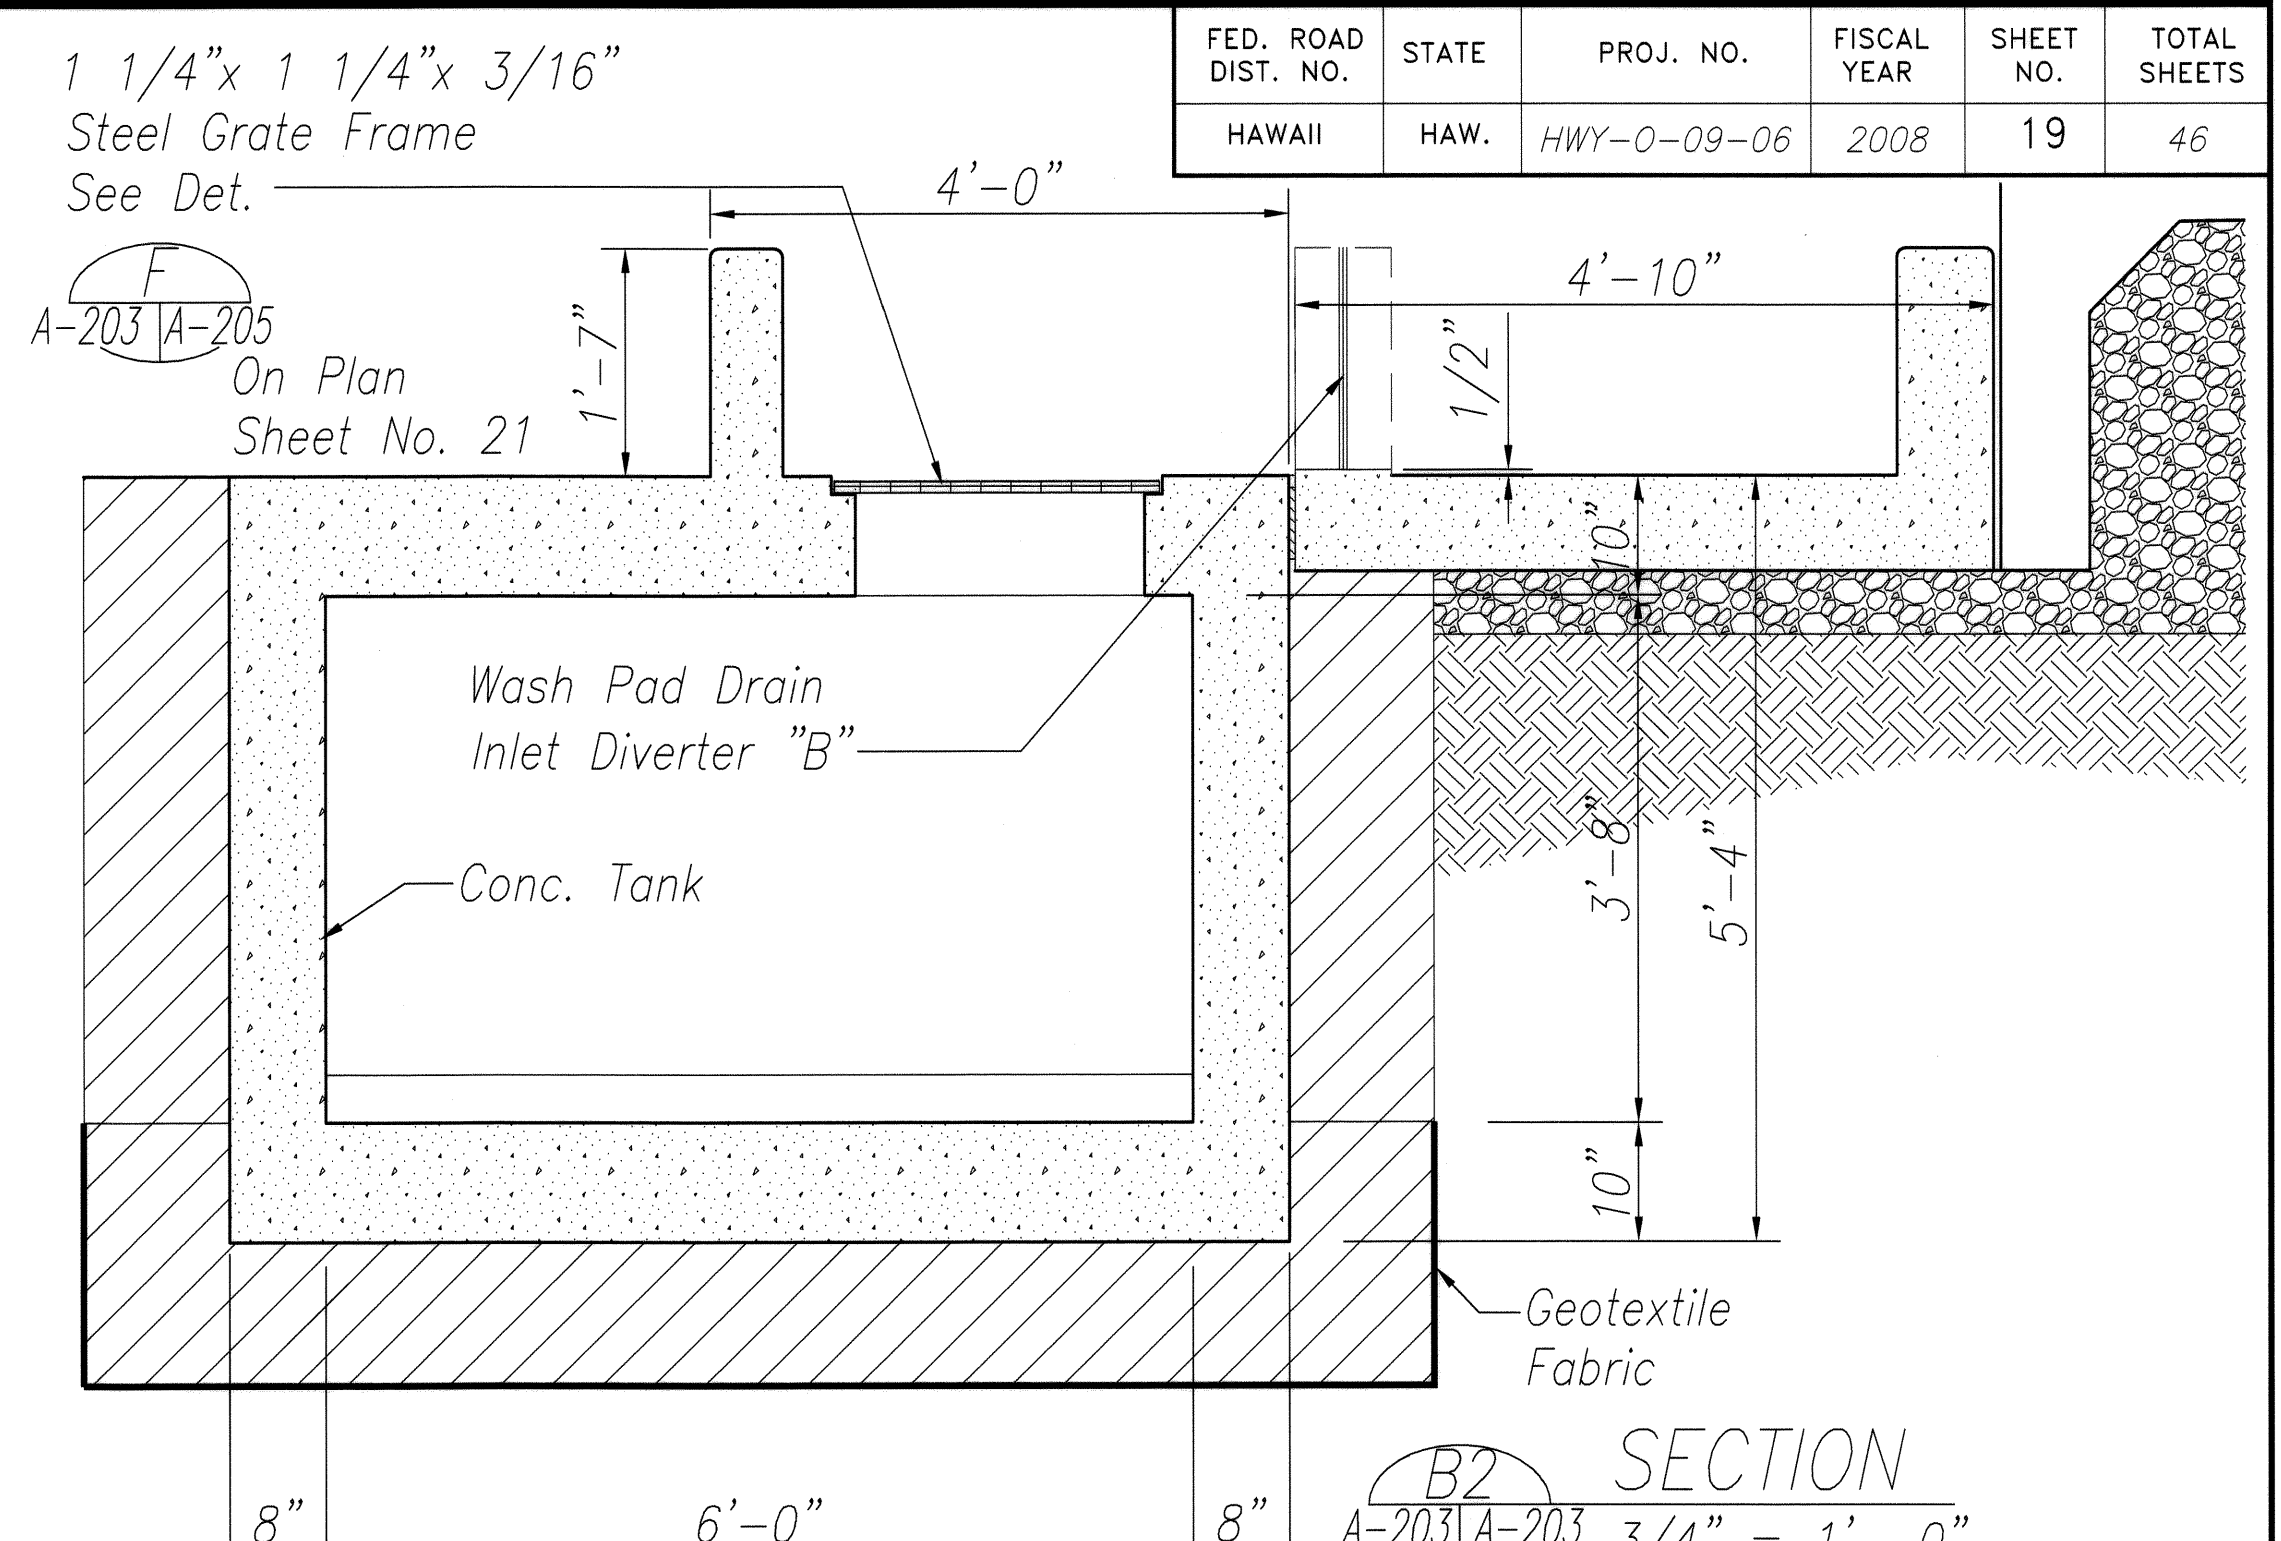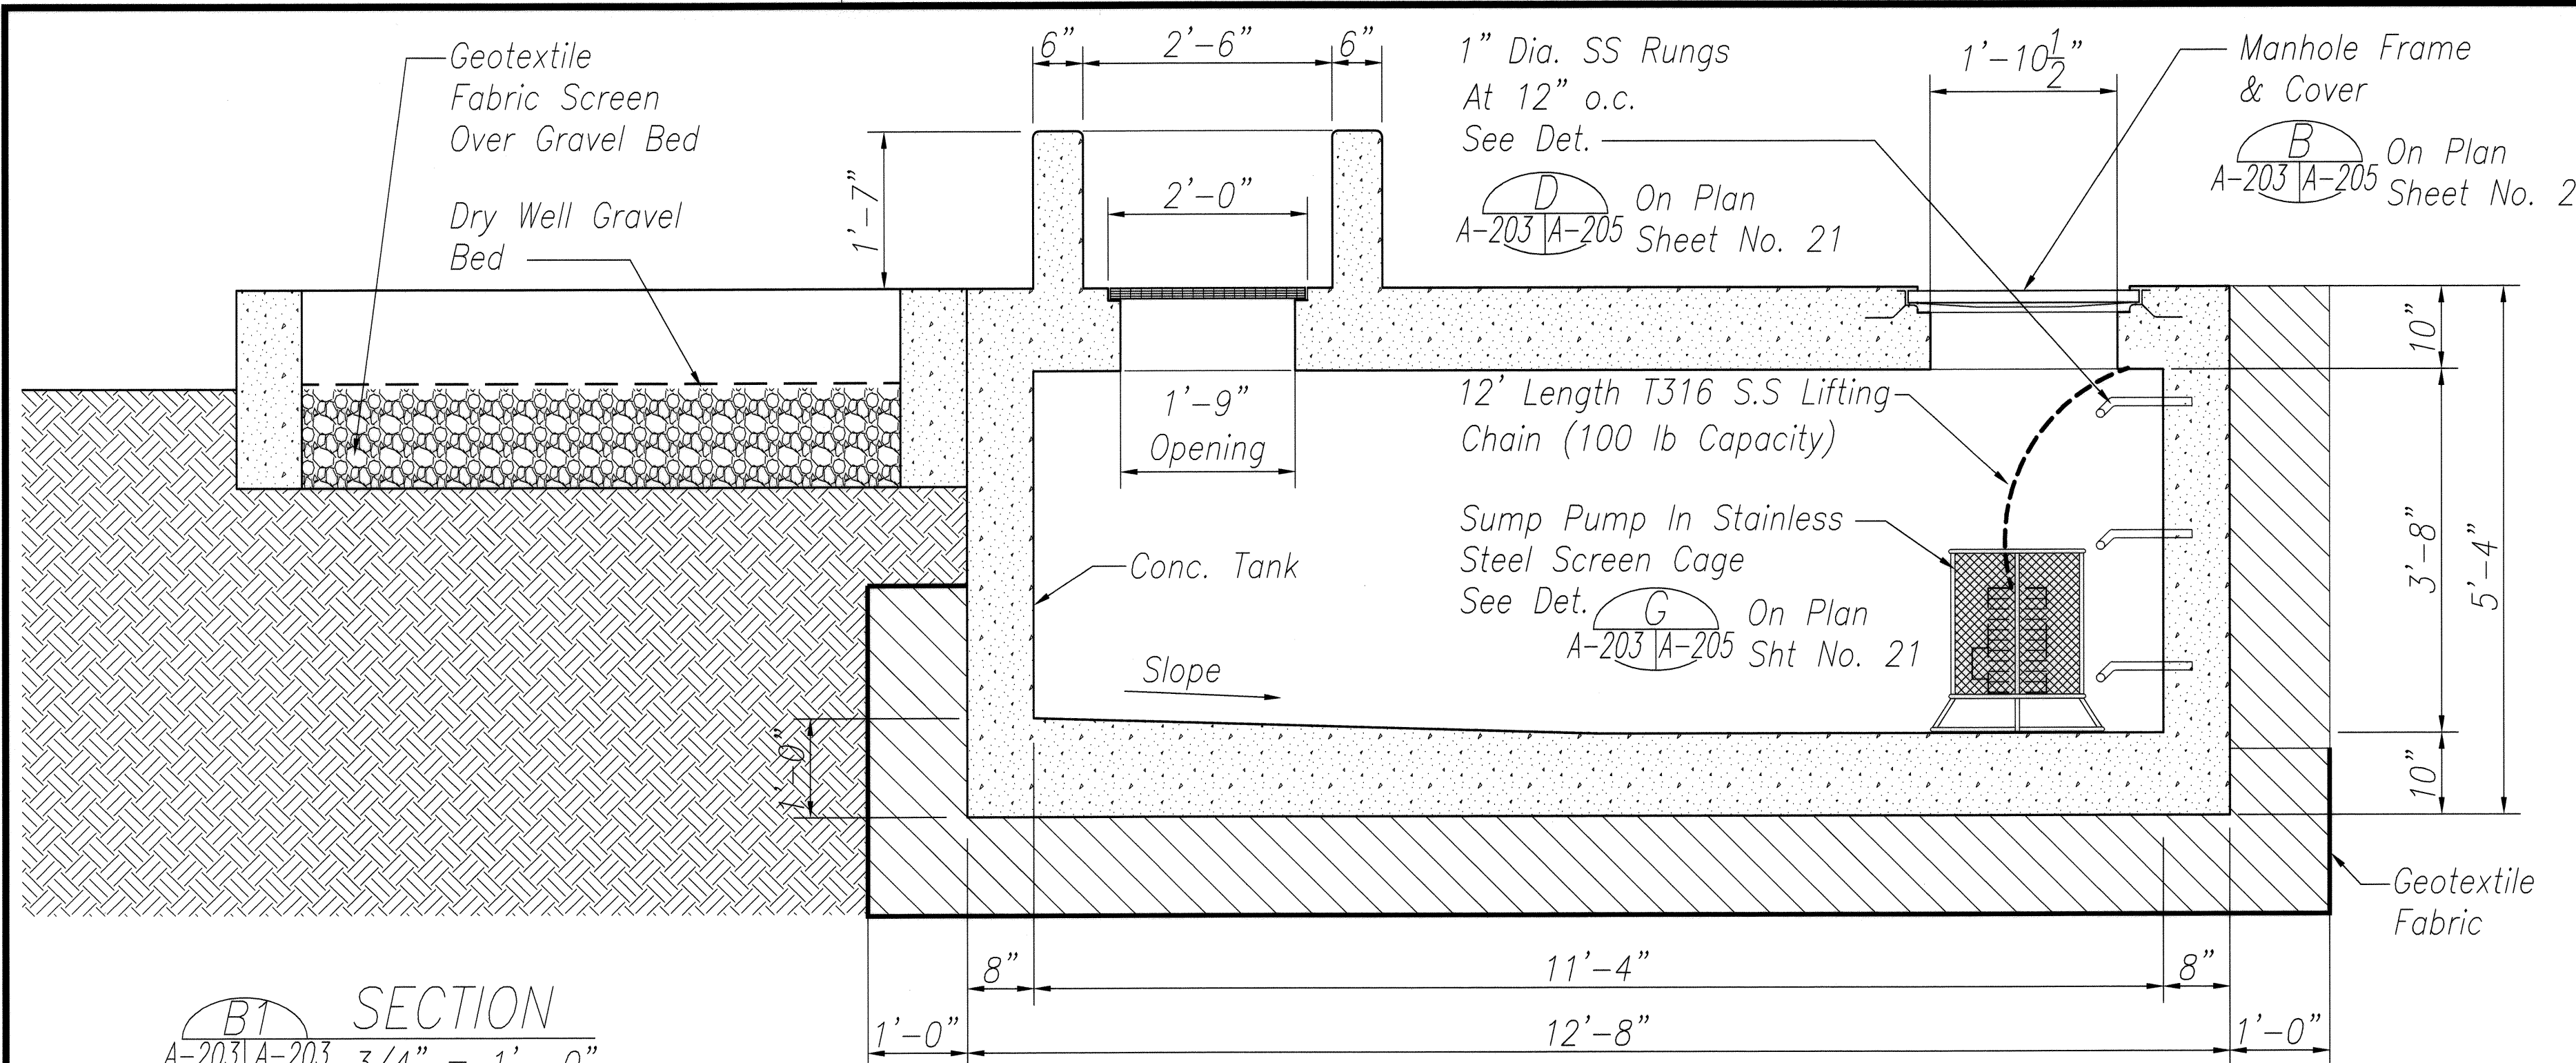


B1 SECTION
A-203/A-203 3/4" = 1'-0"

B2 SECTION
A-203/A-203 3/4" = 1'-0"

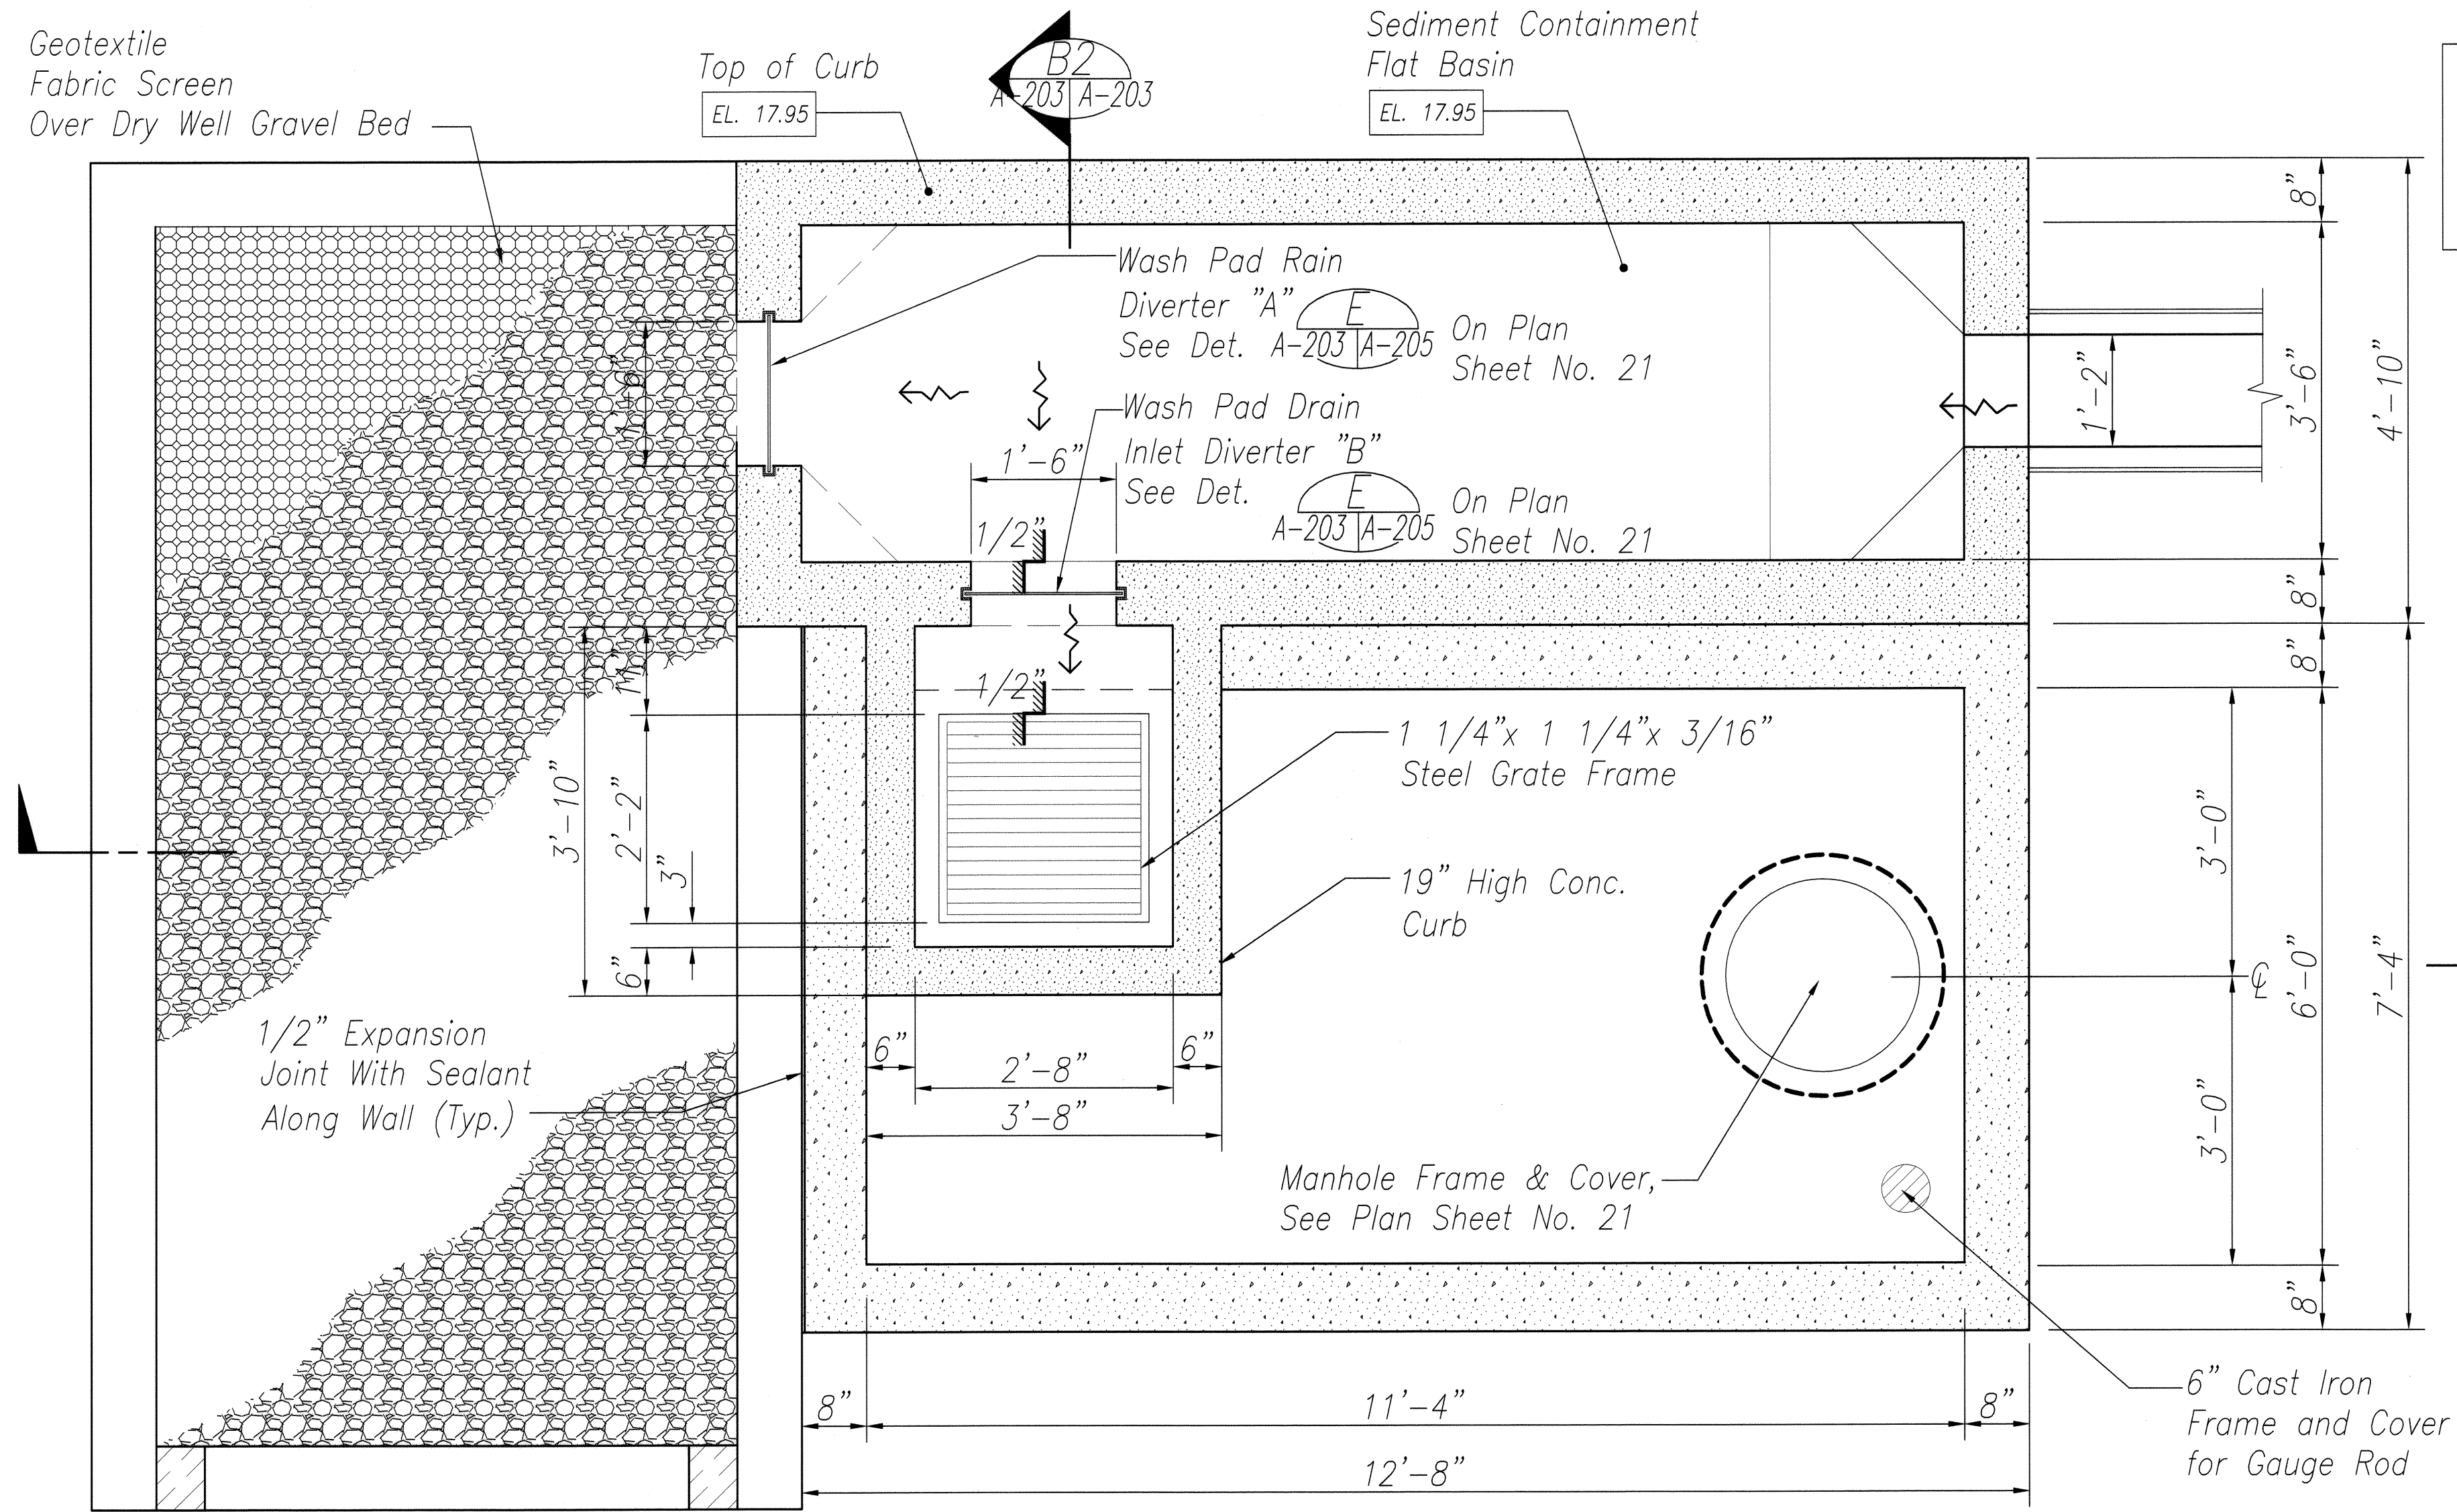


Note:
See Structural,
Mechanical, Electrical,
For Balance Of Work

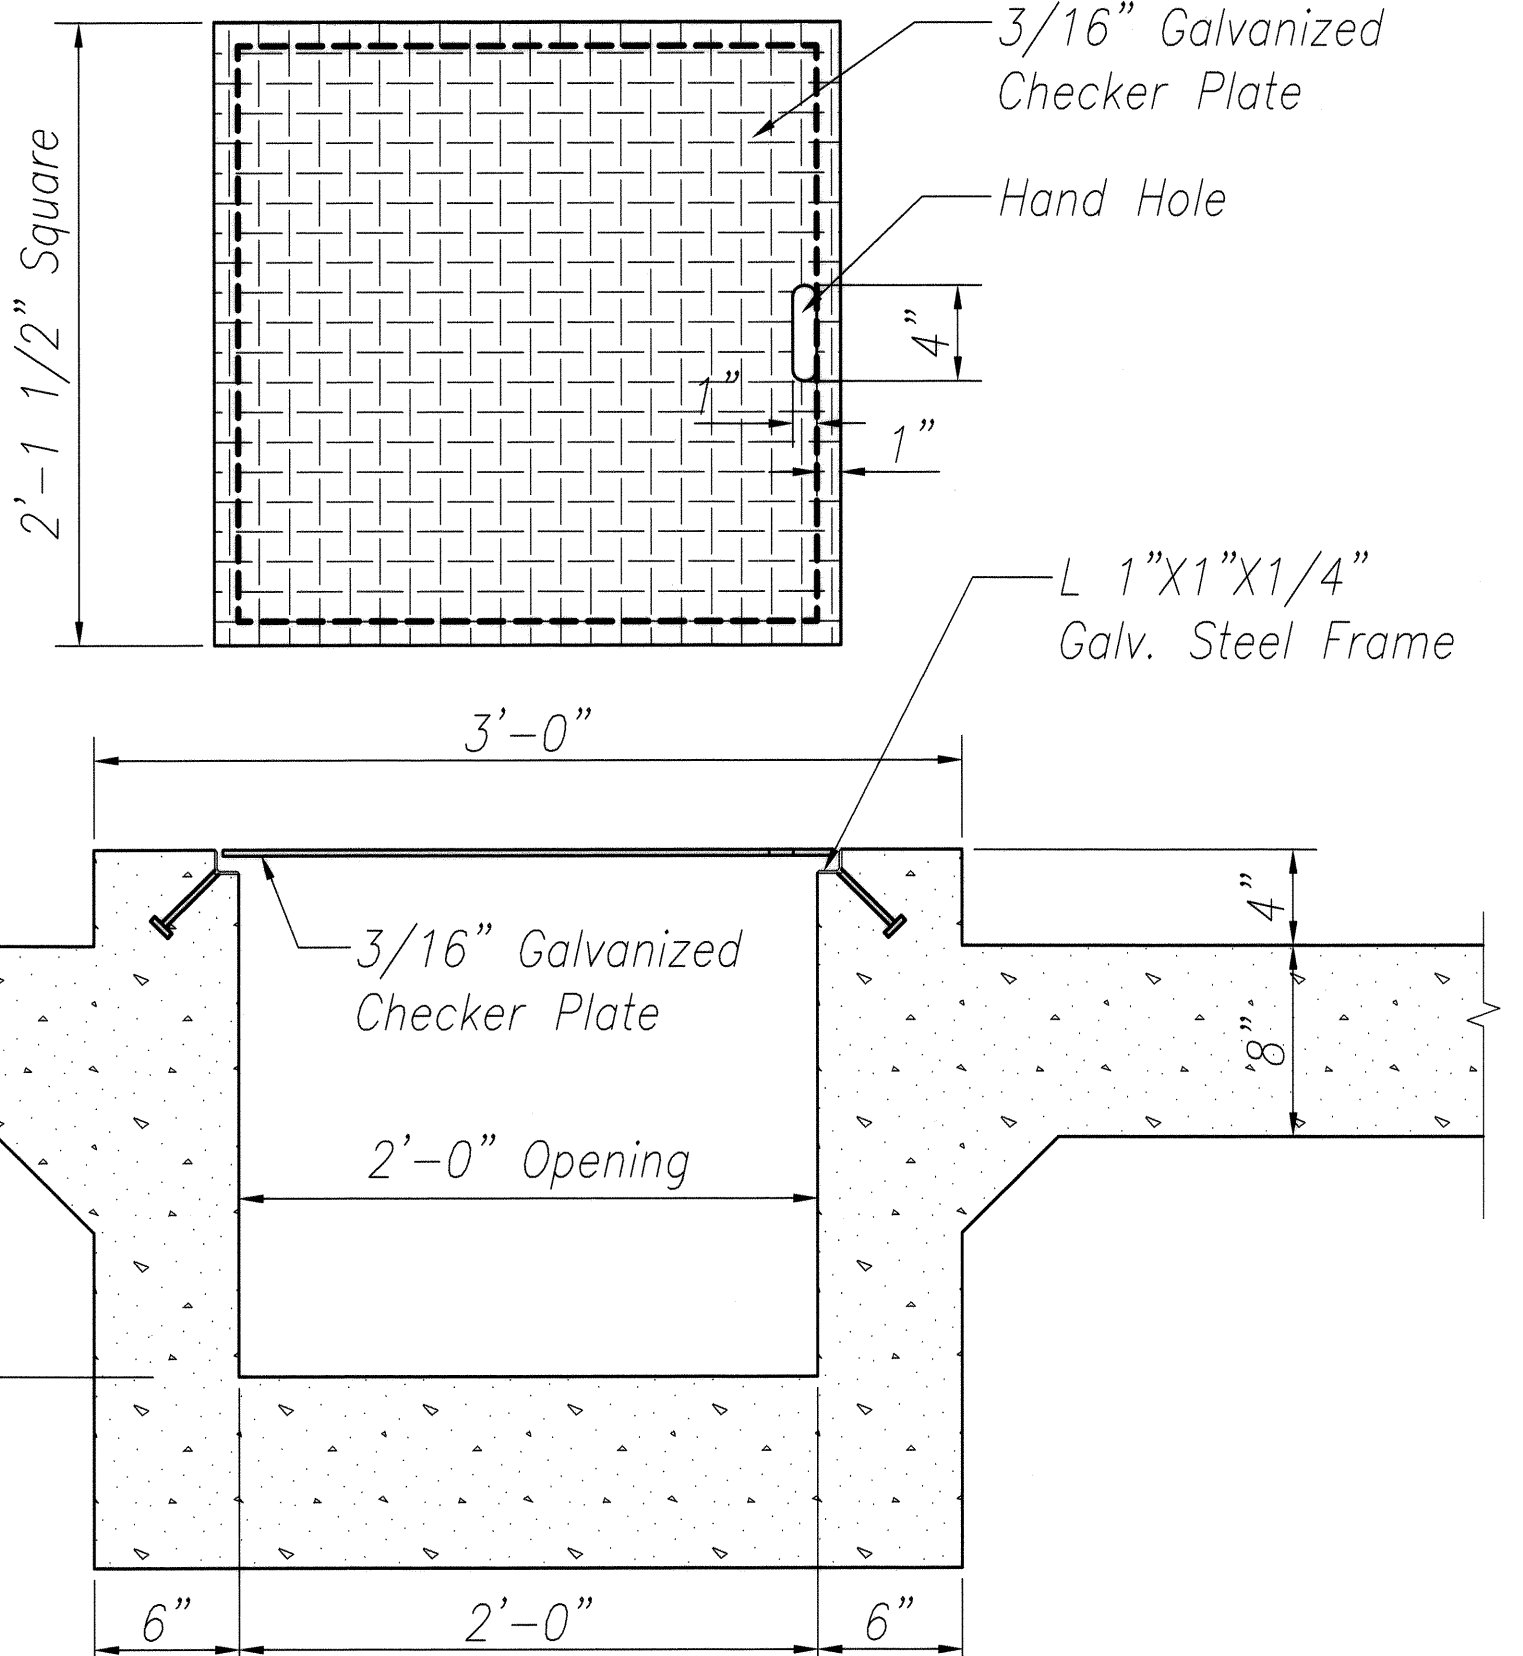

A2 SUMP PIT SECTIONS
A-201/A-203 3/4" = 1'-0"

A1 SEDIMENT CONTAINMENT BASIN AND WASH DOWN WATER HOLDING TANK PLAN
A-203/A-203 3/4" = 1'-0"

ORIGINAL PLAN	DATE
DRAWN BY	
DESIGNED BY	
CHECKED BY	
NO.	

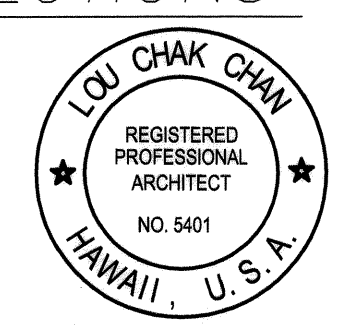

STATE OF HAWAII
DEPARTMENT OF TRANSPORTATION
HIGHWAYS DIVISION


**PEARL CITY BASEYARD
PLAN AND SECTIONS**

KANEOHE, PEARL CITY AND WAIANAE
BASEYARD WASHDOWN RACKS
Project No. HWY-0-09-06

Scale: 3/4" = 1'-0" Date: MAY 2008

SHEET No. A-203 OF 46 SHEETS

FED. ROAD DIST. NO.	STATE	PROJ. NO.	FISCAL YEAR	SHEET NO.	TOTAL SHEETS
HAWAII	HAW.	HWY-0-09-06	2008	ADD.20	46

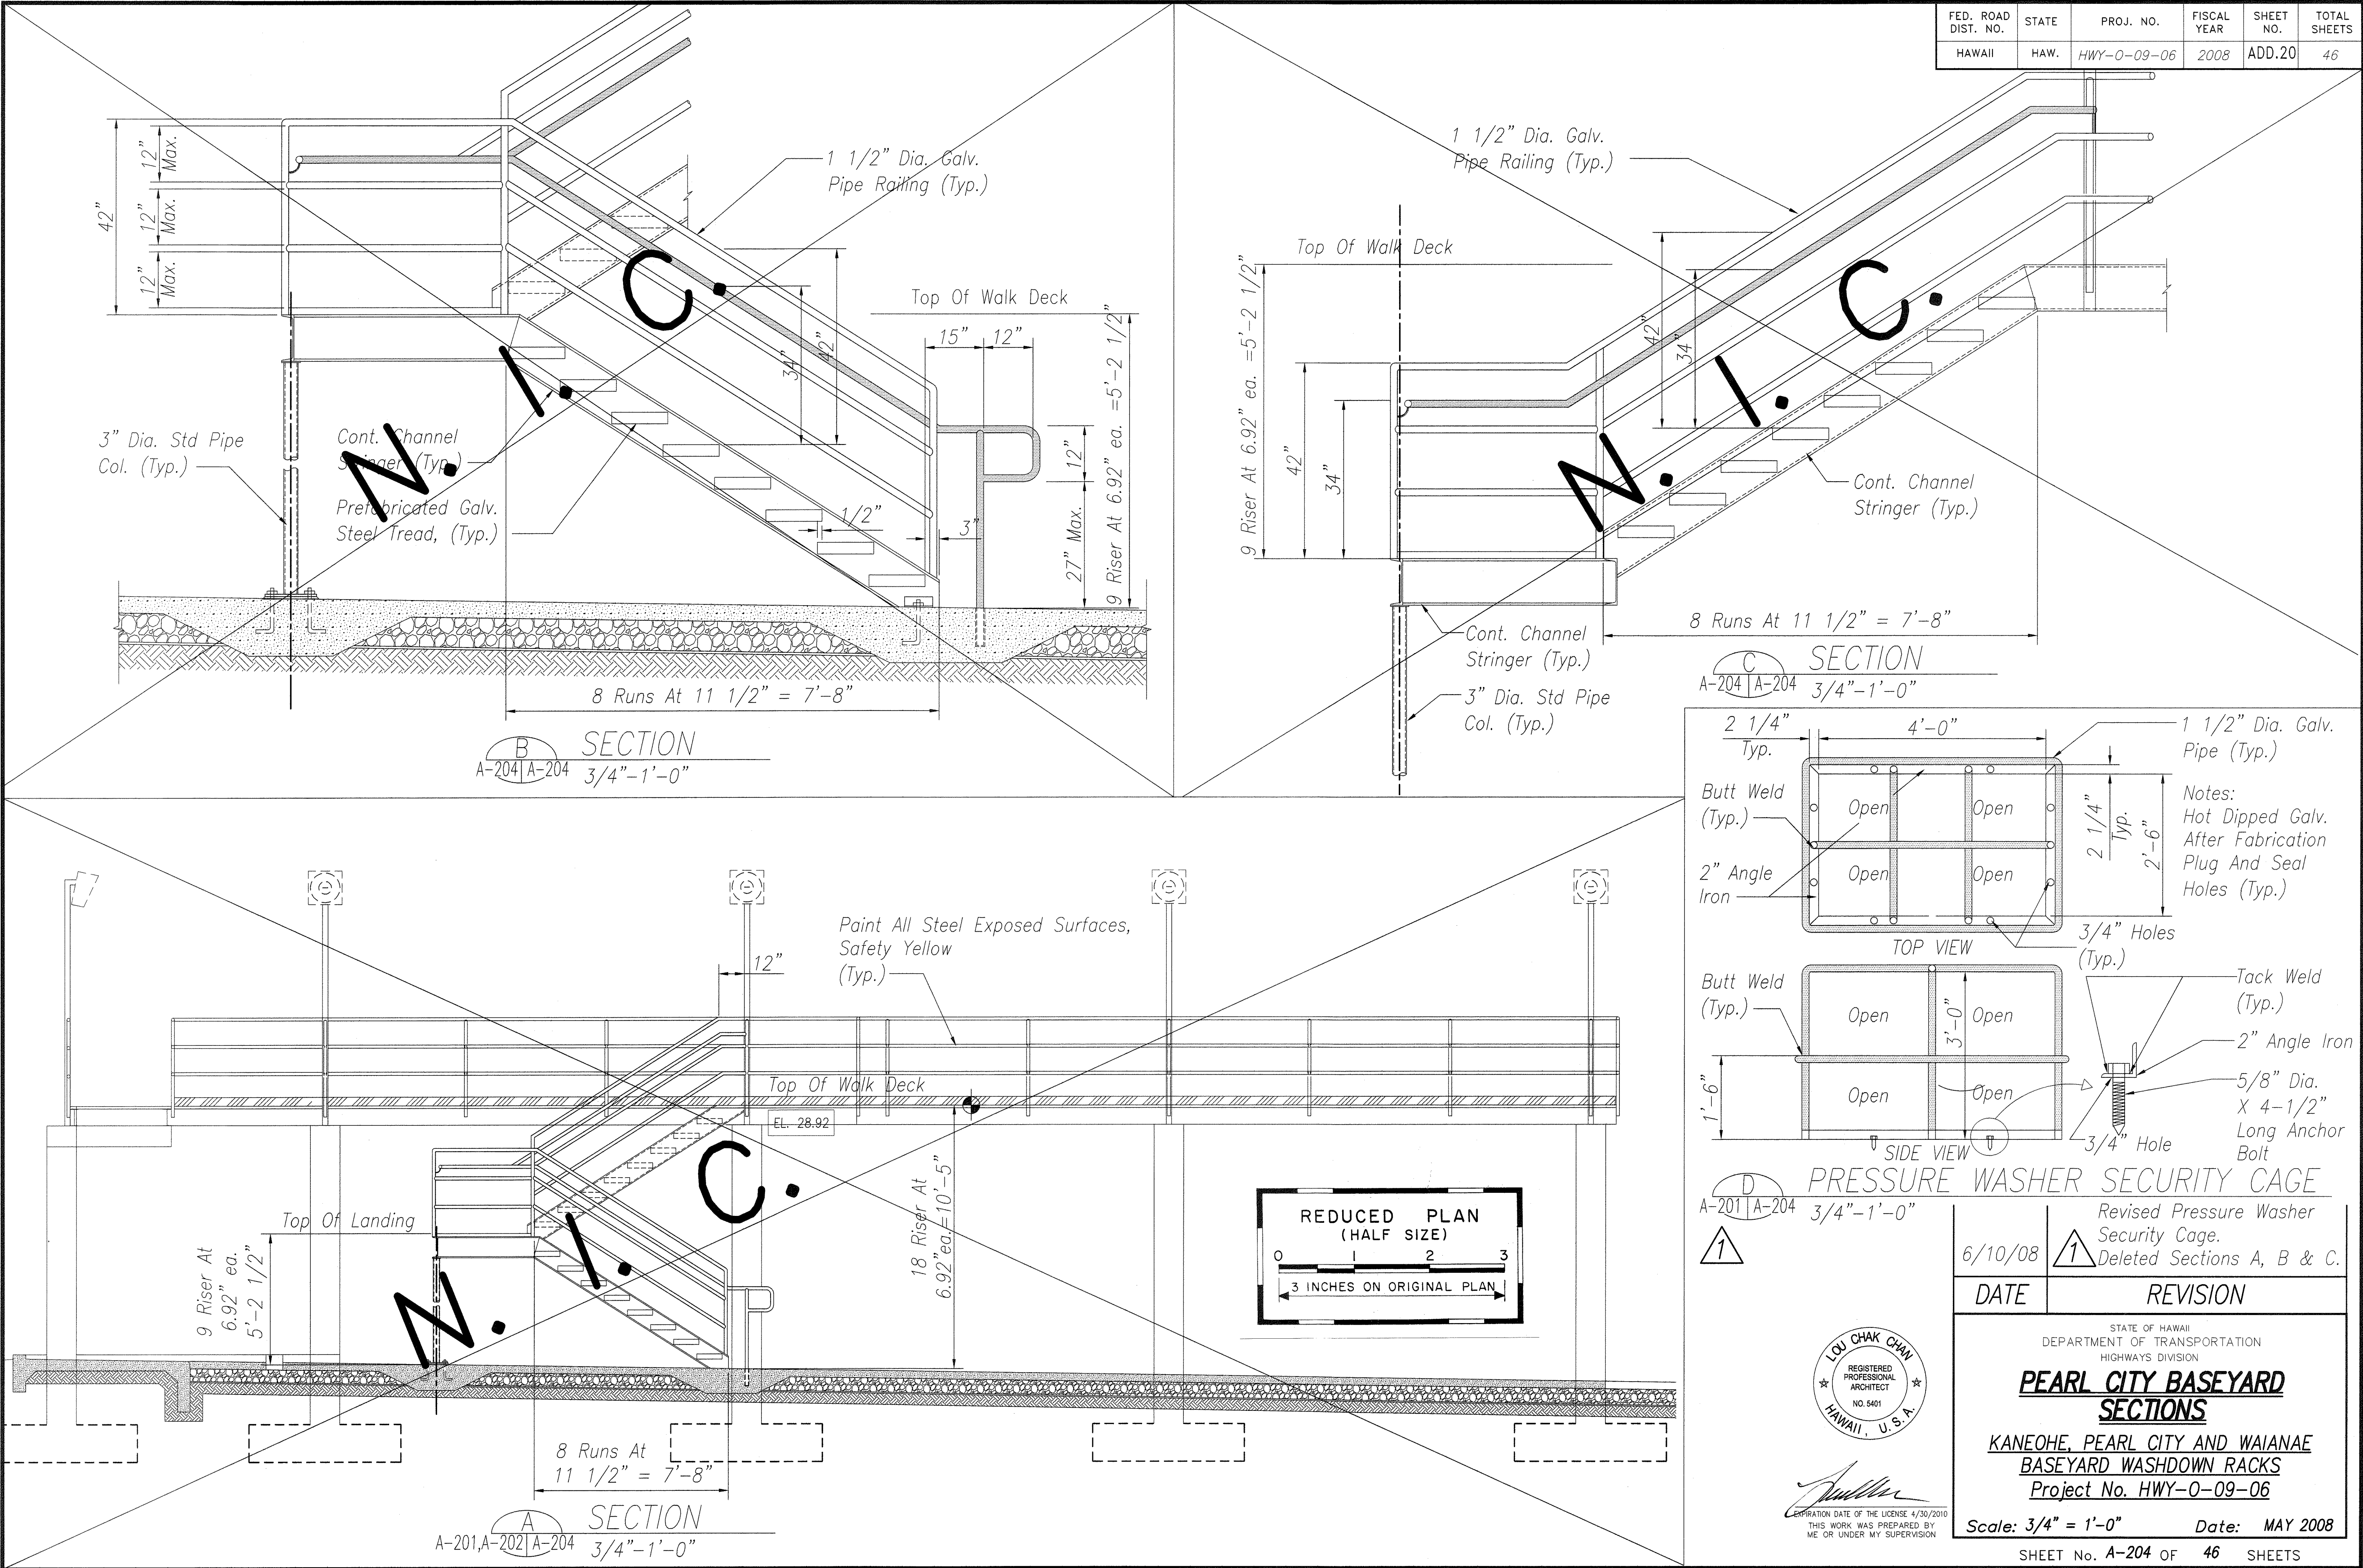

ORIGINAL PLAN	DATE
NOTE BOOK	DESIGNED BY
	QUANTITIES BY
	CHECKED BY
No.	

