

FED. ROAD DIST. NO.	STATE	FED. AID PROJ. NO.	FISCAL YEAR	SHEET NO.	TOTAL SHEETS
HAWAII	HAW.				

FLOOR PLAN - ADMINISTRATION BLDG.
SCALE: 1/2" = 1'-0"

SANITARY DIAGRAM
NO SCALE





THIS WORK WAS PREPARED BY
ME OR UNDER MY SUPERVISION.

Herbert Y. Matsumura

STATE OF HAWAII
DEPARTMENT OF TRANSPORTATION
HIGHWAYS DIVISION
OAHU DISTRICT BASEYARD FACILITIES
SHAFTER FLATS INDUSTRIAL DEVELOPMENT
AT MOANALUA, HONOLULU, OAHU, HAWAII
ADMINISTRATION BLDG.
PLUMBING PLAN & DIAGRAMS
HERBERT Y. MATSUMURA ARCHITECT A.I.A.
871 KAPIOLANI BLVD. HONOLULU, HAWAII


SHEET No. P-2 OF 42 SHEETS

ORIGINAL PLAN	DATE
DRAWN BY	
DESIGNED BY	
NOTED BY	
CHECKED BY	
NO.	

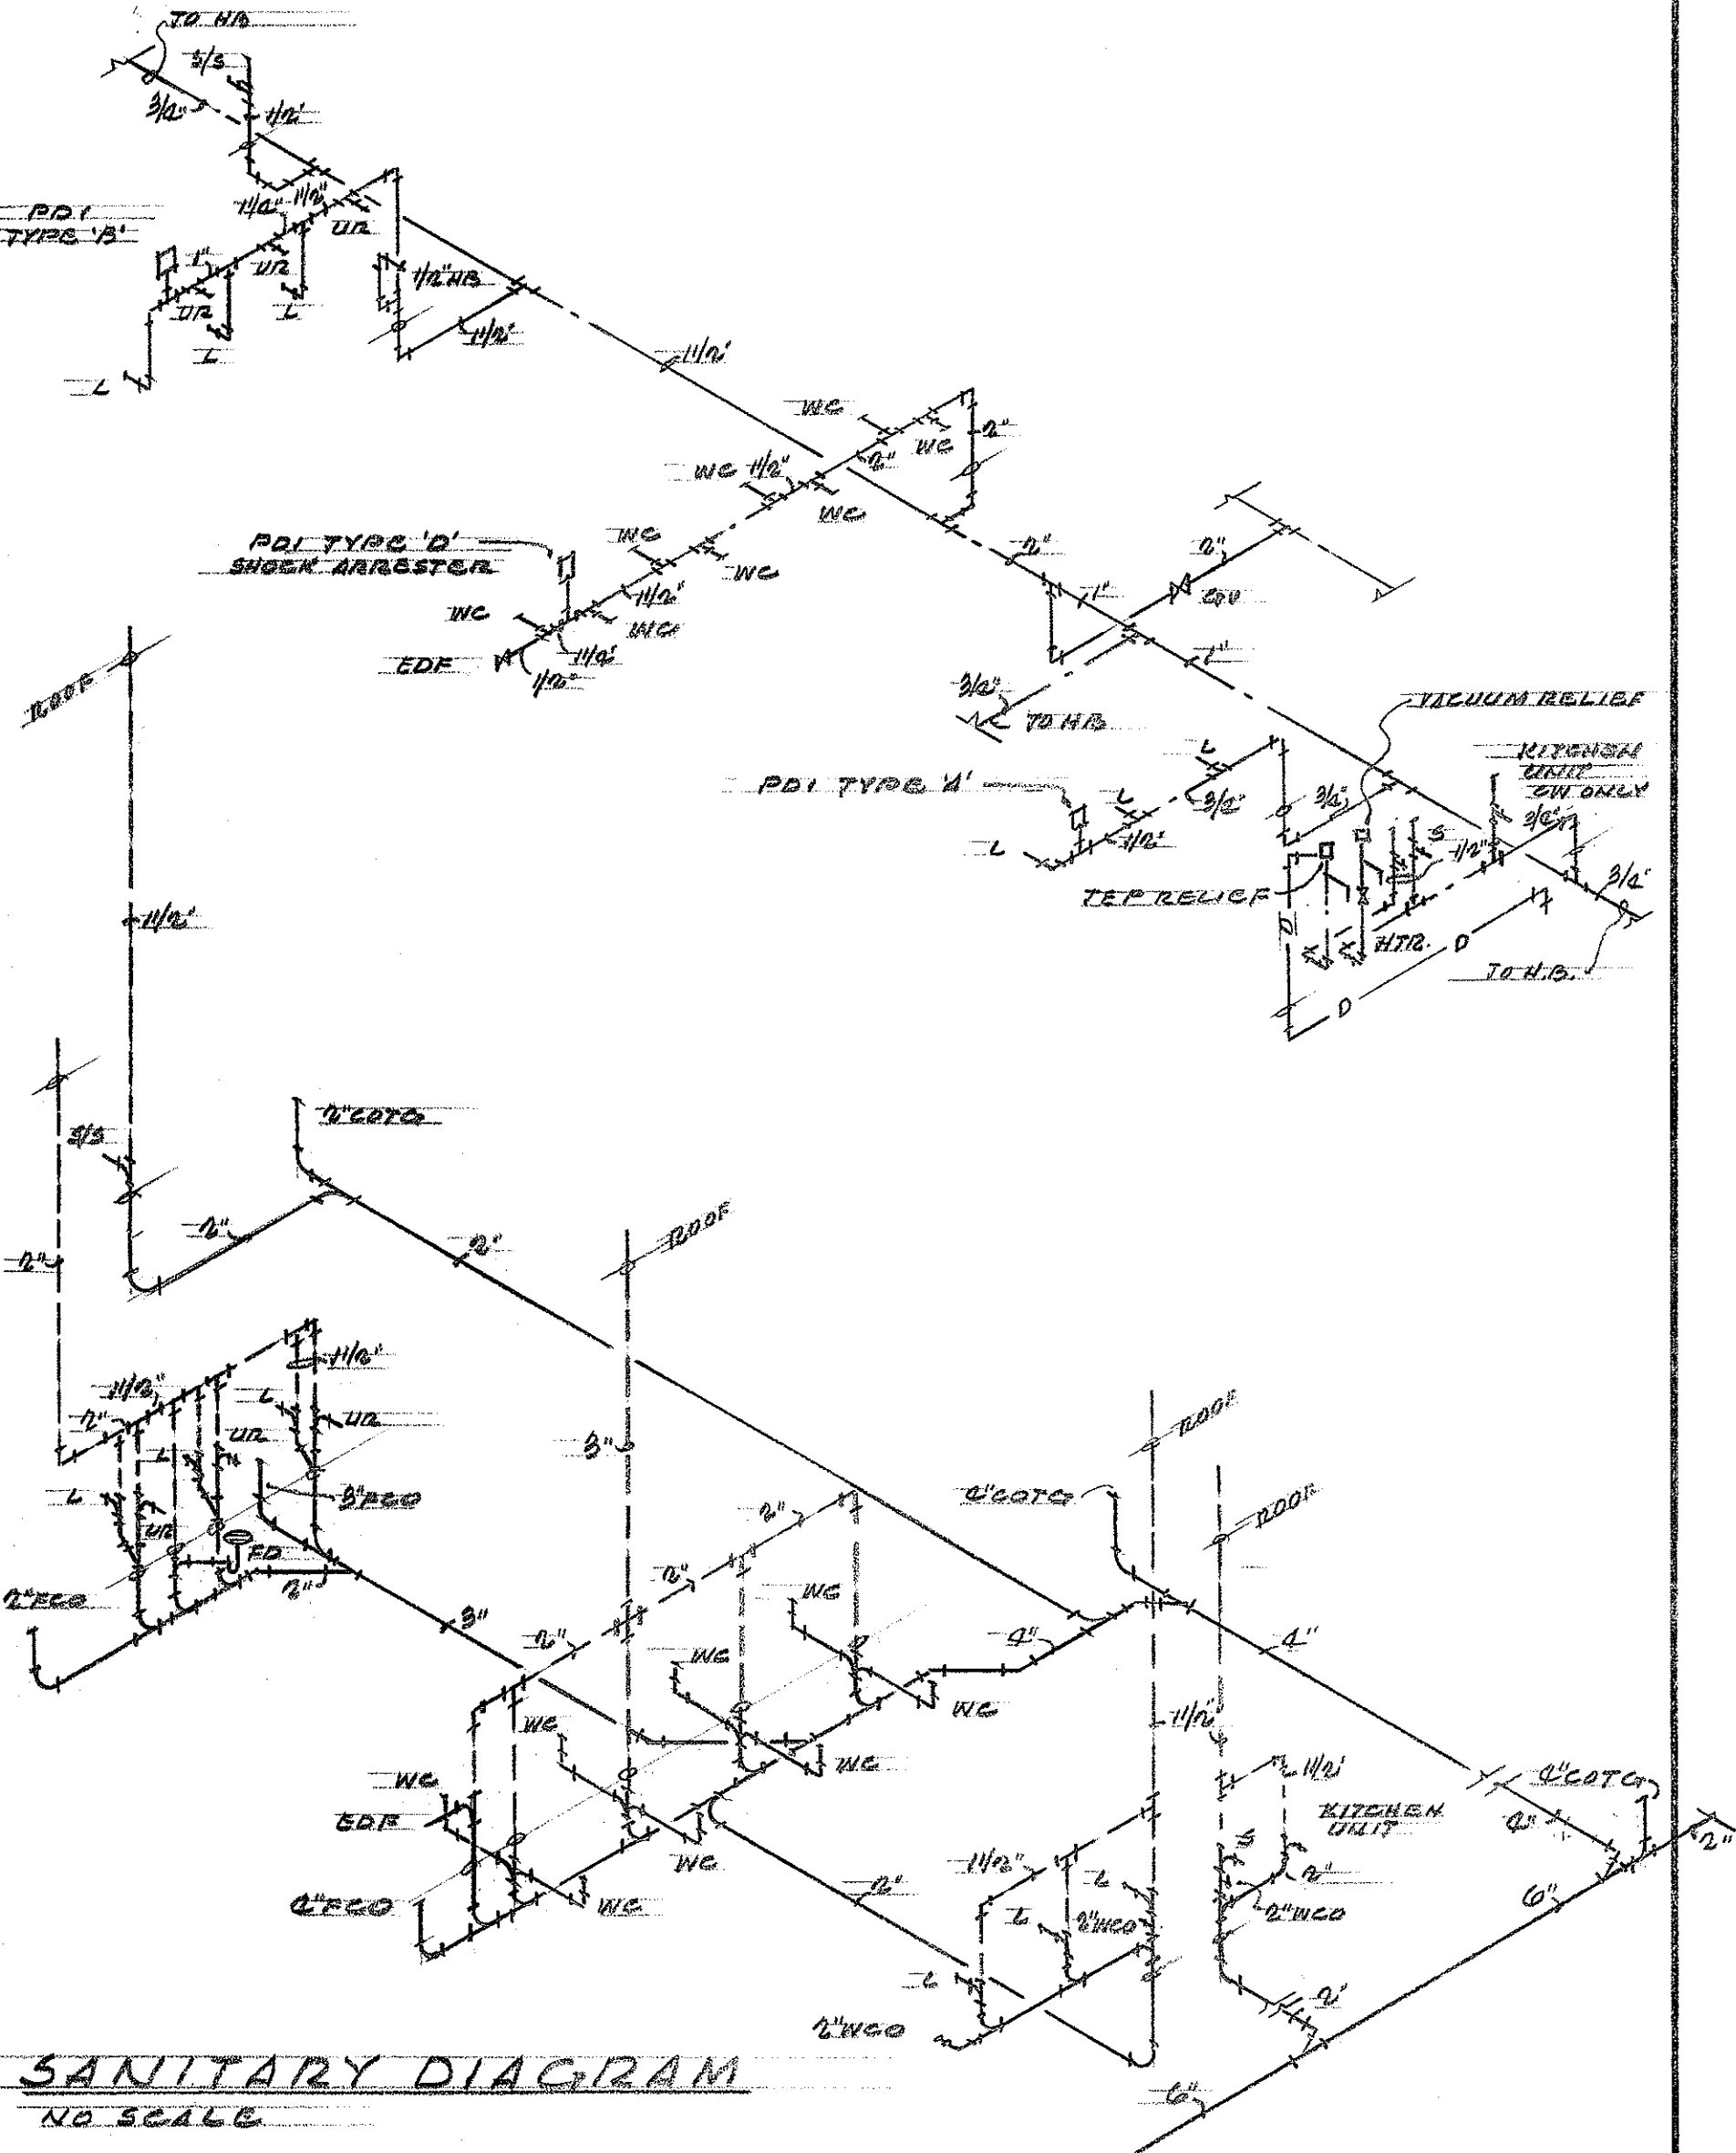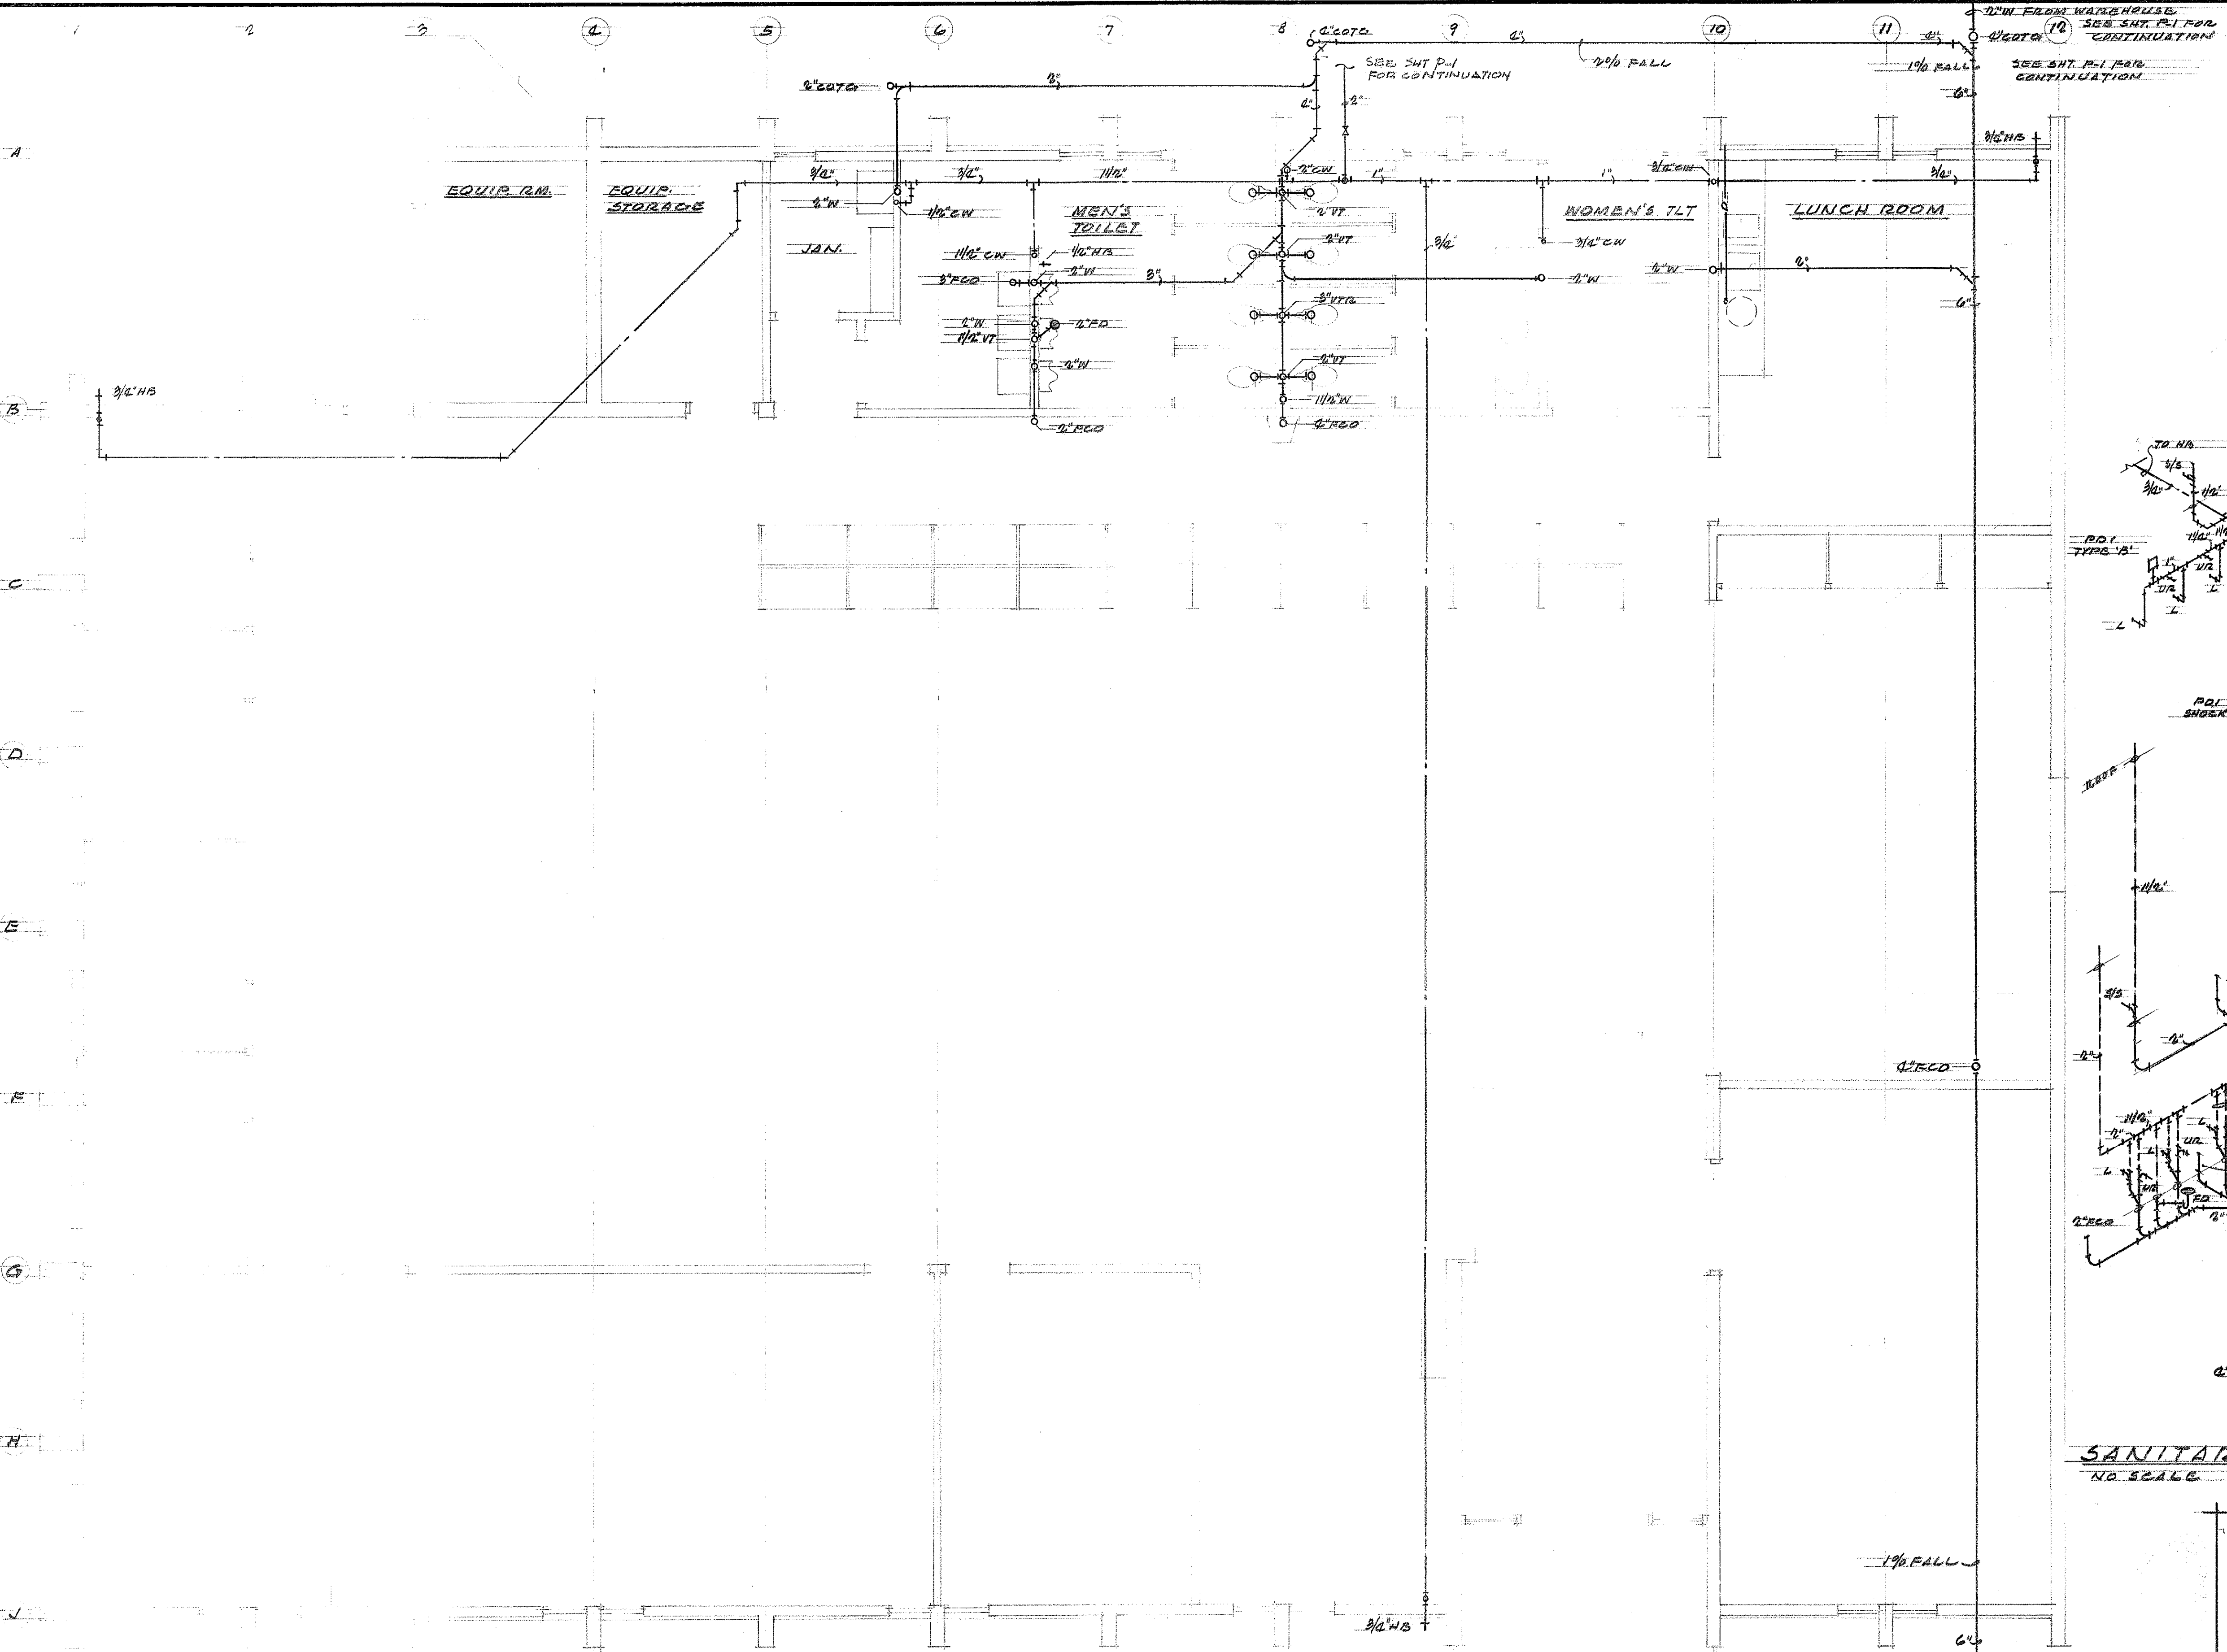


[illegible]


SCALE: $1/8" = 1'-0"$

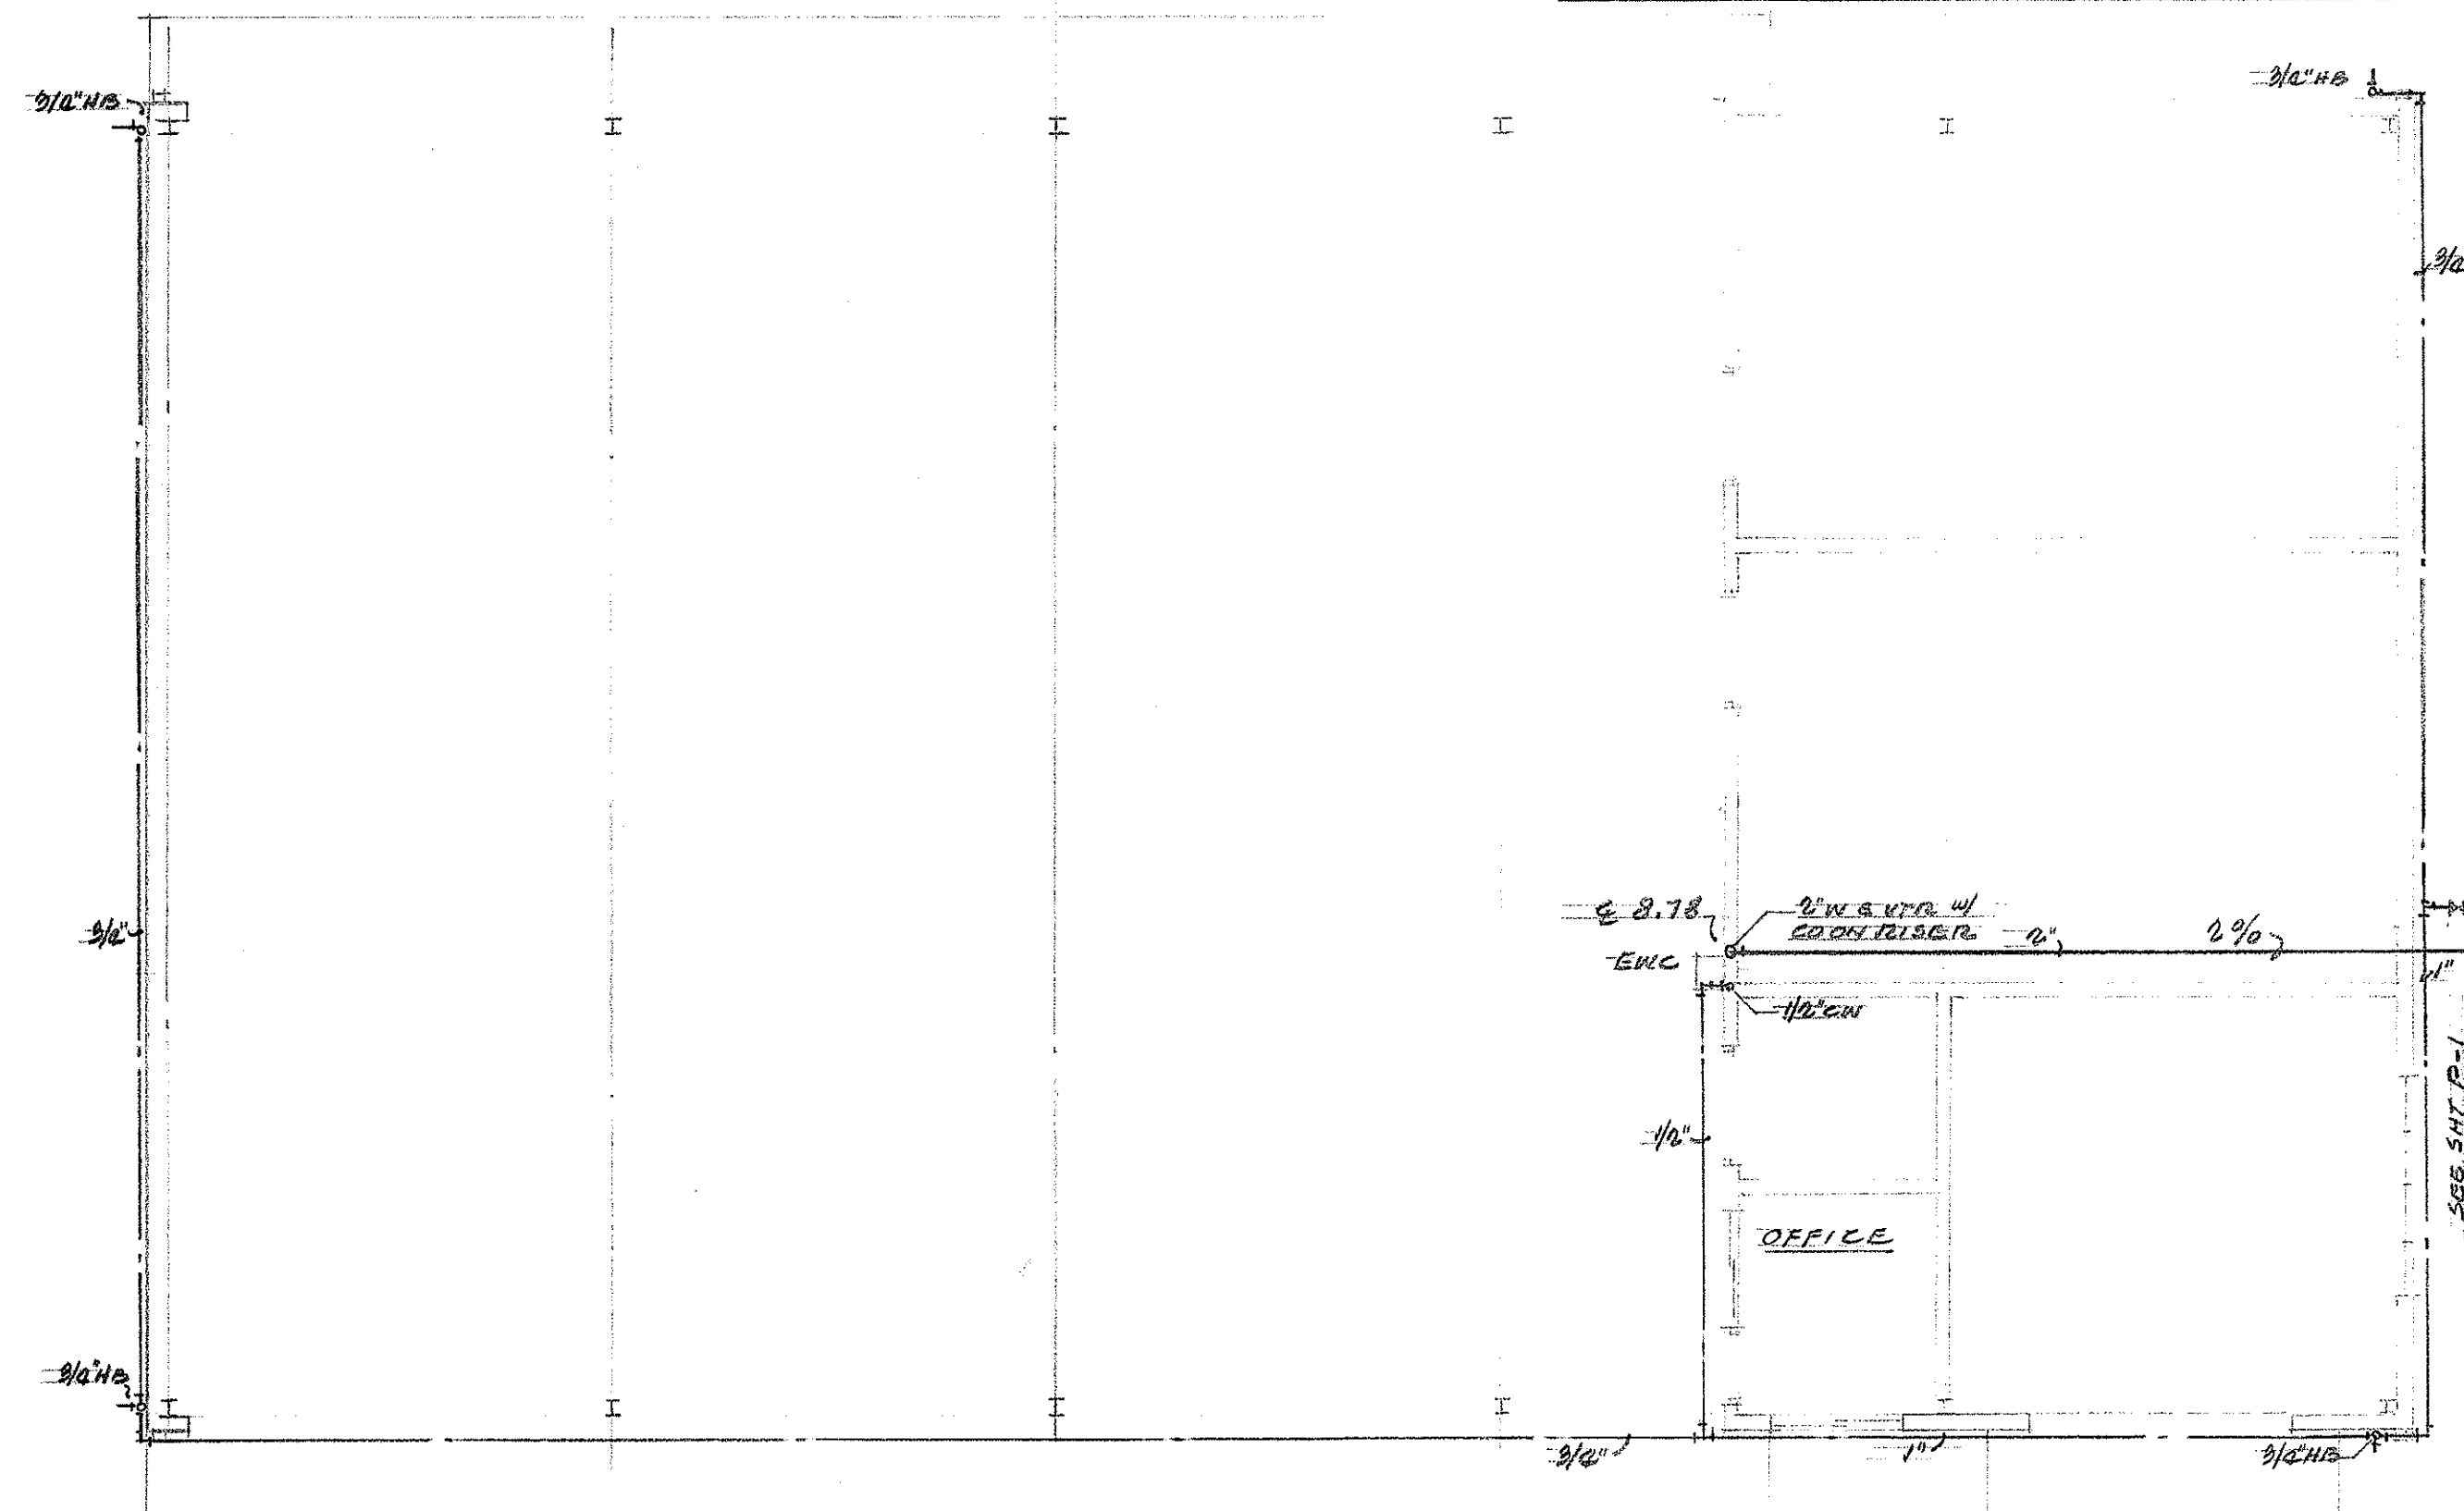


SCALE: 1/8" = 1'-0"

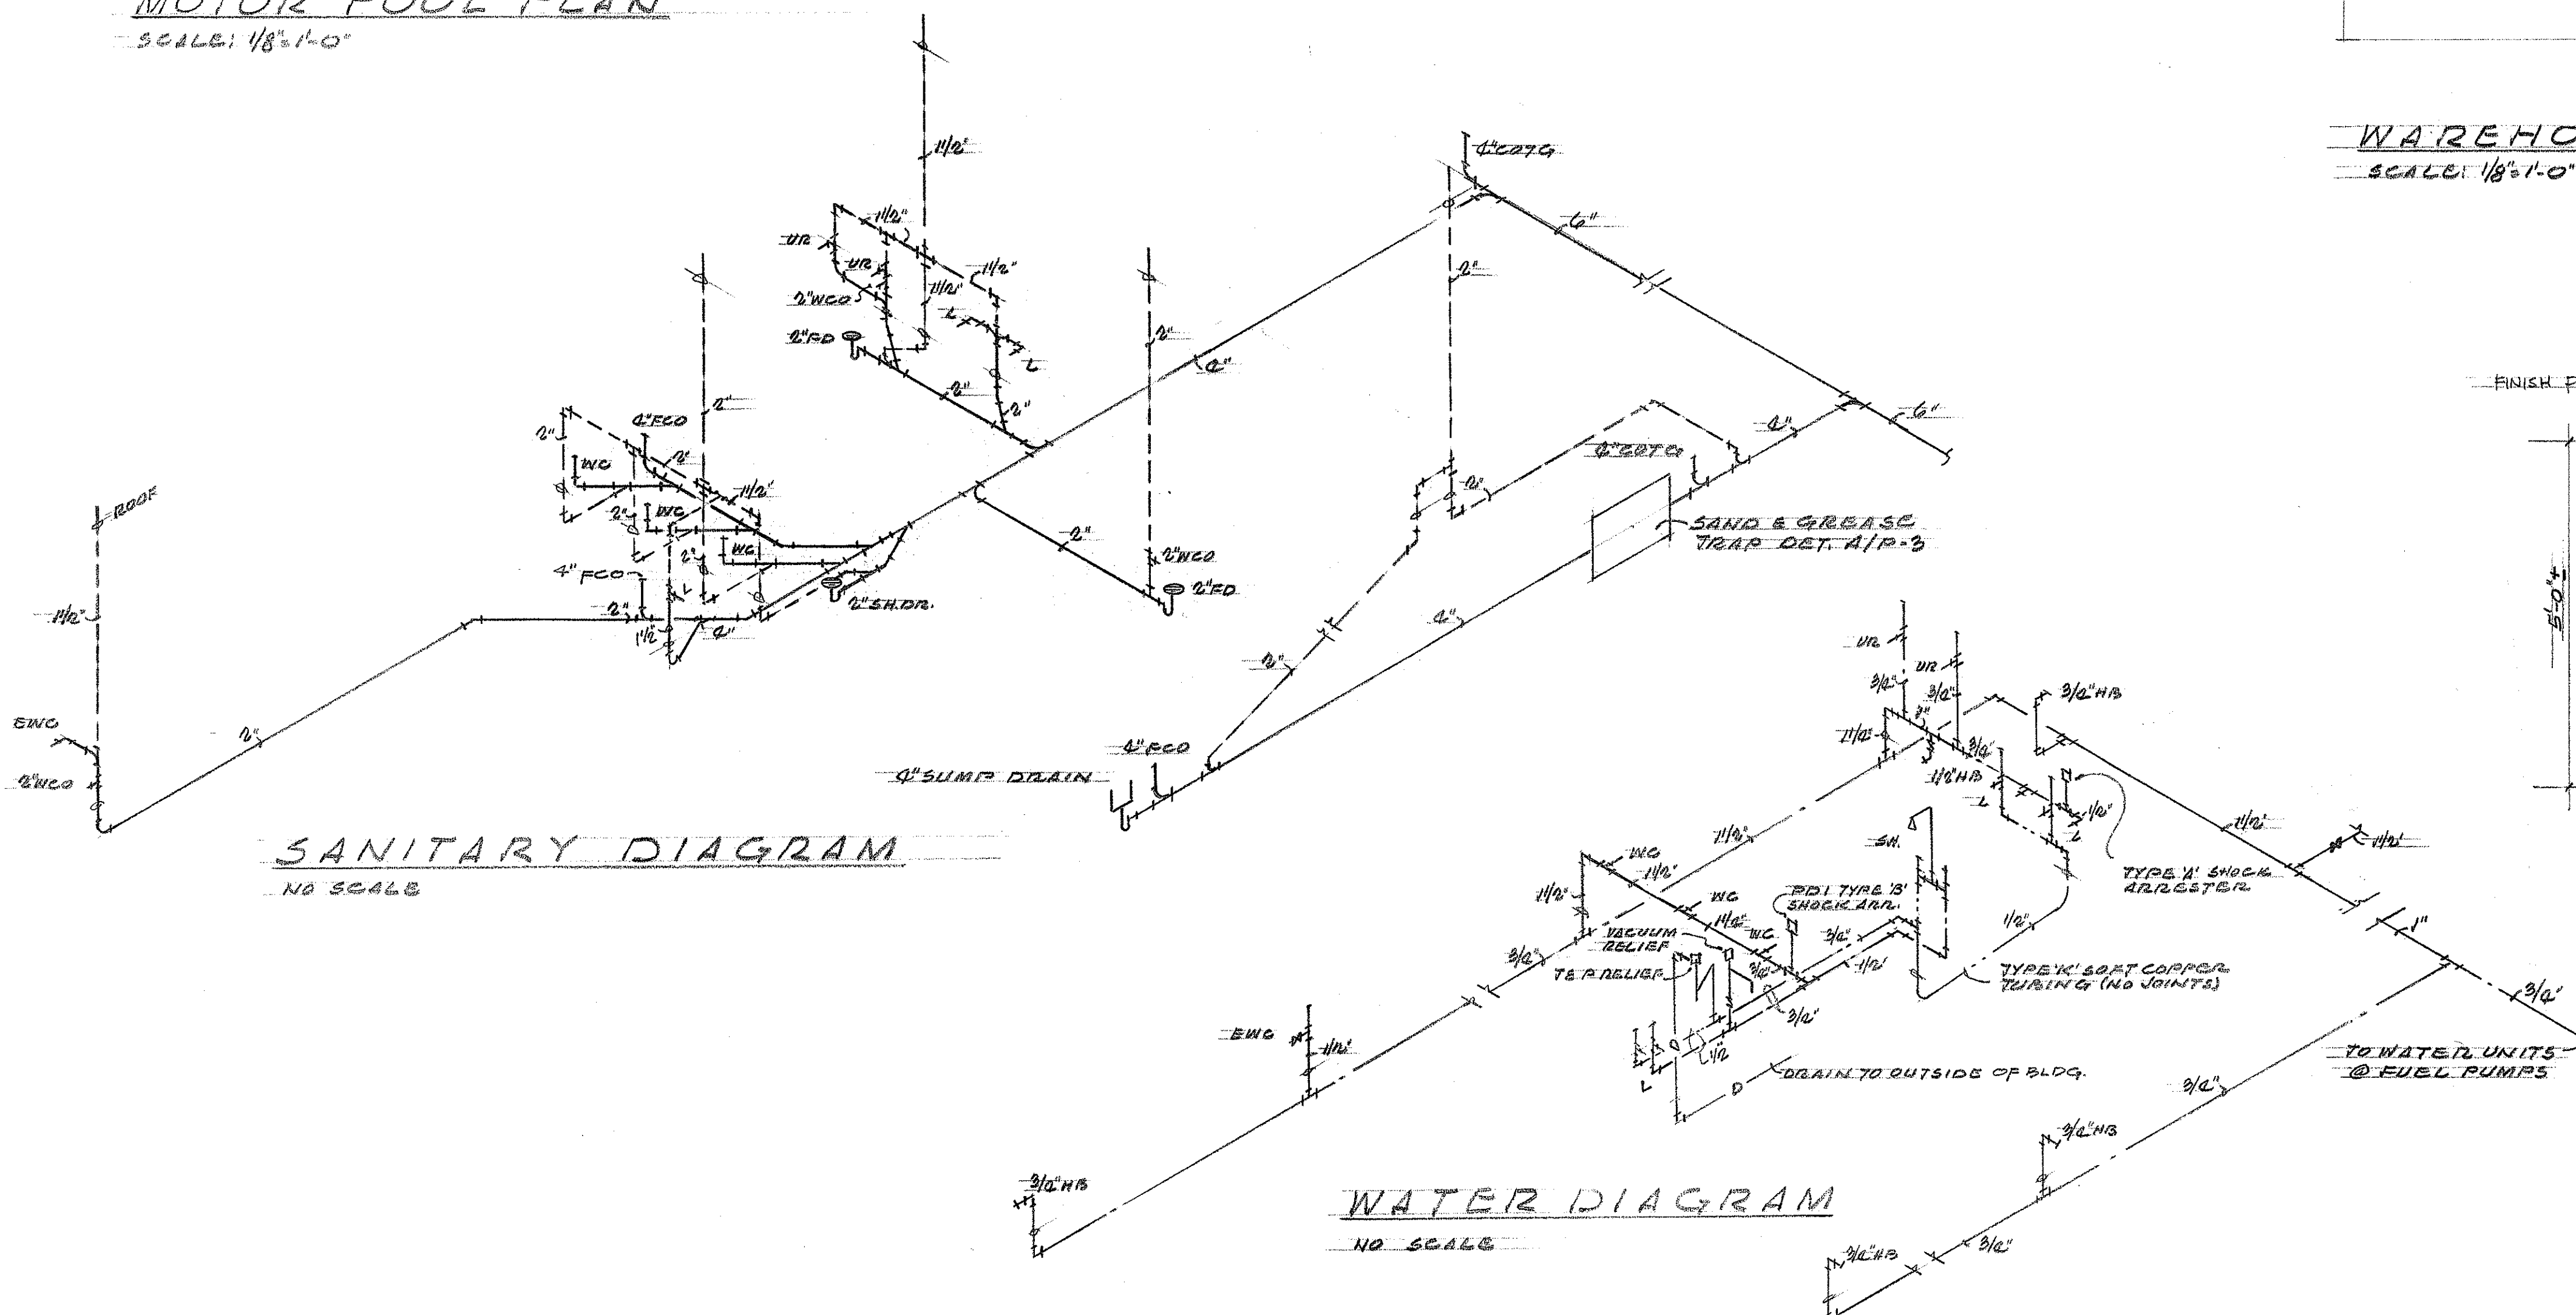

NO SCALE

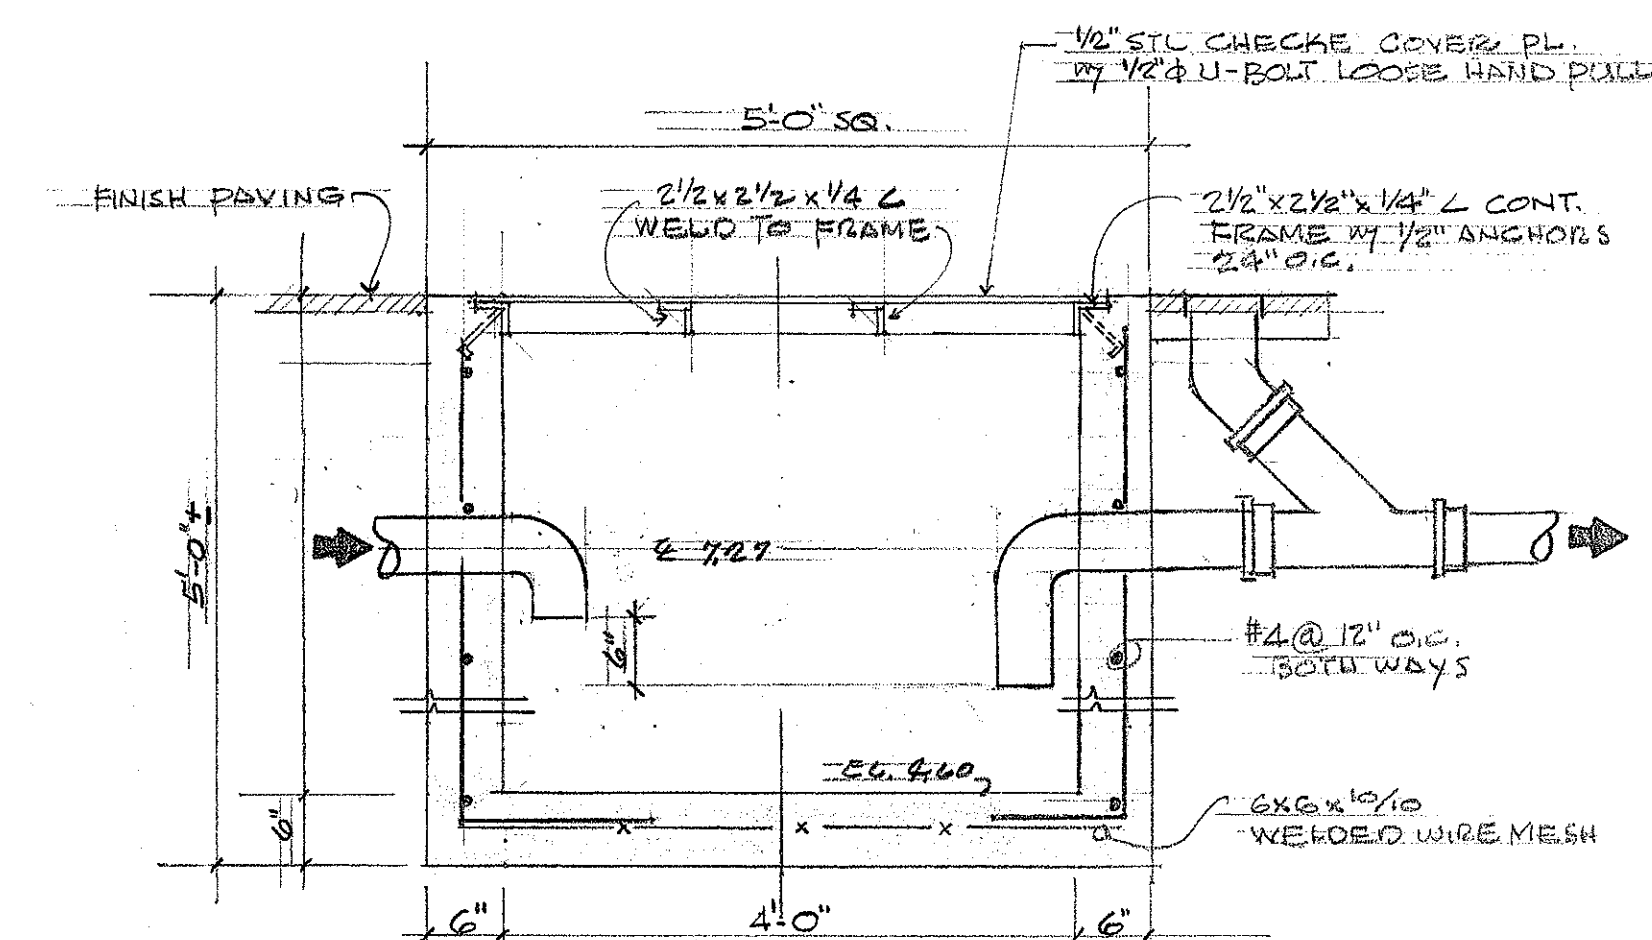

$\frac{A}{P.3}$ SAND & GREASE TRAP DET.
SC. 3/4" = 1'-0"

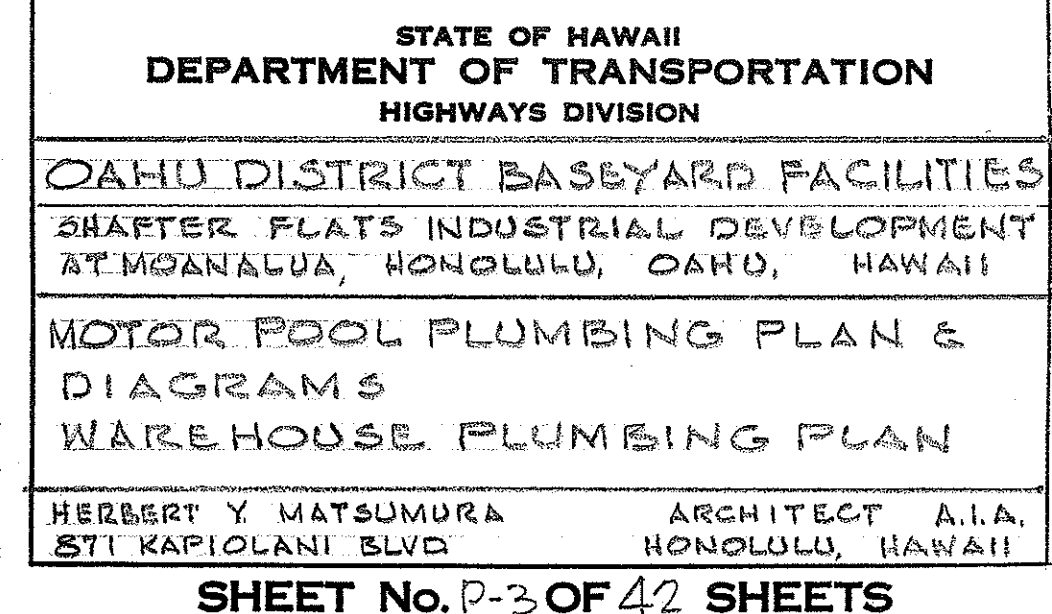

Richard G. Whitman