


FED. ROAD DIST. NO.	STATE	PROJ. NO.	FISCAL YEAR	SHEET NO.	TOTAL SHEETS
HAWAII	HAW.	HWY-O-02-83M	1983	1	23

IMPROVEMENT TO FACILITIES TO  
ACCOMMODATE NUCLEAR GAUGE EQUIPMENT  
AT OAHU DISTRICT BASEYARD

MOANALUA, HONOLULU, HAWAII  
"AS-BUILT" PLANS  
FOR THE

STATE OF HAWAII  
DEPARTMENT OF TRANSPORTATION  
HIGHWAYS DIVISION

HONOLULU, HAWAII  
PROJECT NO. HWY-O-02-83M

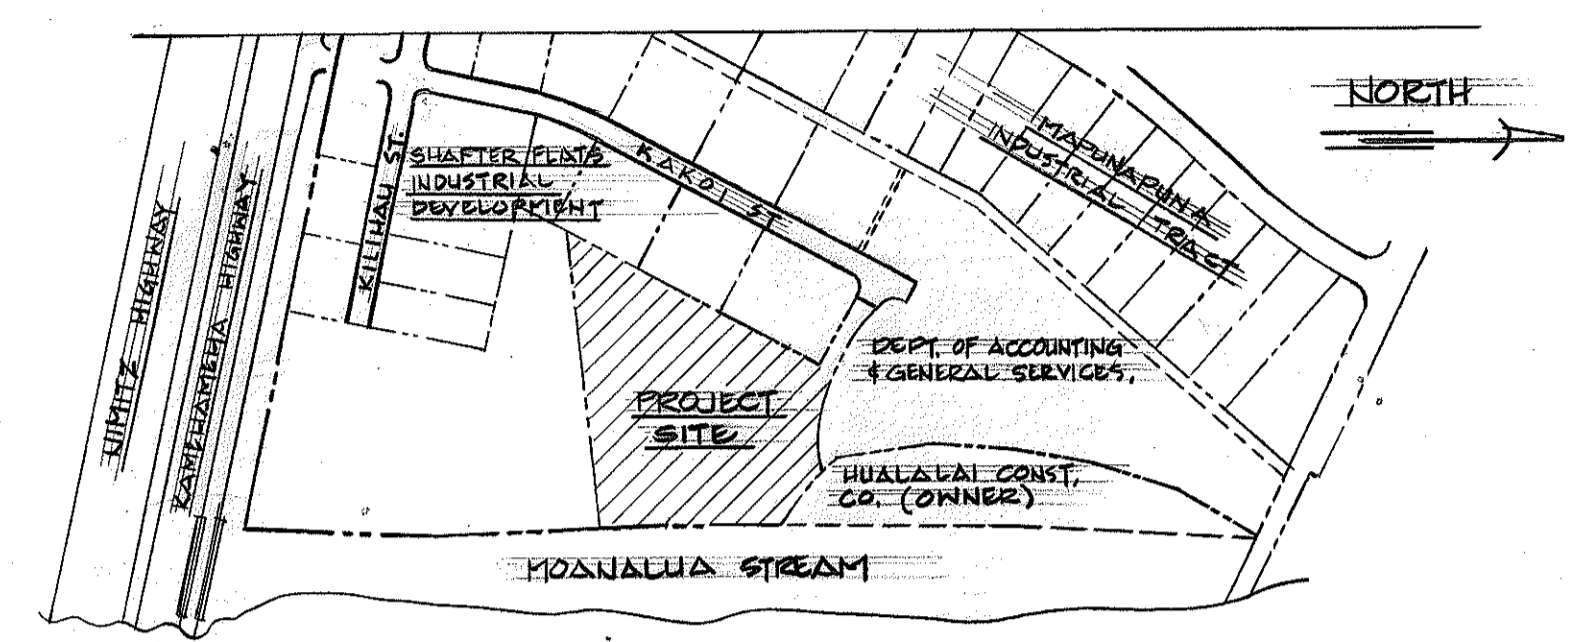

LOCATION MAP  
TAX MAP KEY: 1-1-64-2  
SCALE: 1" = 400'

NO CHANGES WERE MADE DURING CONSTRUCTION  
ON THESE PLANS EXCEPT FOR THE ADDITION OF  
ELECTRICAL PLAN SHEET NO. 2S-1.

*[Signature]* 9-15-83  
RESIDENT ENGINEER DATE

DEPARTMENT OF TRANSPORTATION STATE OF HAWAII	
APPROVED: <i>[Signature]</i> DIR. OF TRANSPORTATION	DATE 9/15/83

ORIGINAL PLAN	SURVEY PLOTTED BY	DATE
NOTE BOOK	DRAWN BY	
No.	DESIGNED BY	
	QUANTITIES BY	
	CHECKED BY	

HWY DESIGN UNIT A R. MIKAMI 548-7494 DEC. 1982  
DESIGNED BY P. S. & E. BY PHONE DATE