


Airports Division  
DEPARTMENT OF TRANSPORTATION  
STATE OF HAWAII

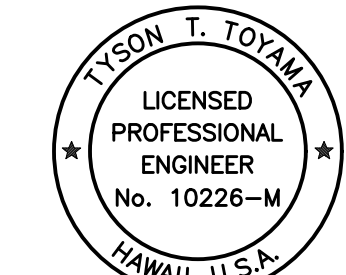


THIS WORK WAS PREPARED BY ME OR UNDER MY SUPERVISION  
AND CONSTRUCTION OF THIS PROJECT WILL BE UNDER MY  
OBSERVATION.

*Tyson T. Toyama*  
SIGNATURE

04/30/2024  
EXPIRATION DATE OF THE LICENSE

DSGN.	DRWN.	CHKD.	APPD.
JS/KT	KT/TJ	TTT	TTT

### KEY PLAN / NOTES:

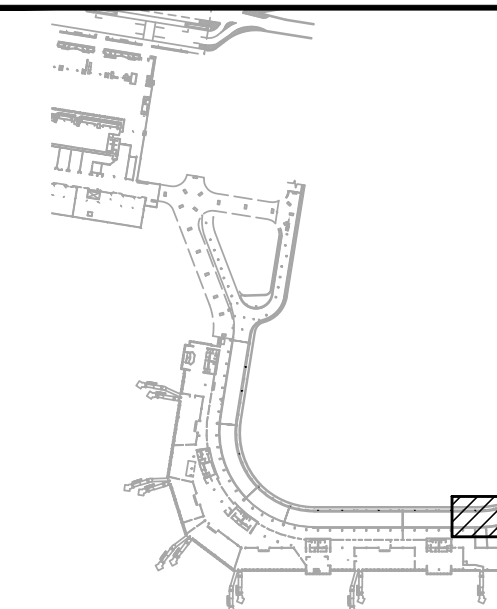

NO.	DATE	REVISIONS

## CONSTRUCTION DOCUMENTS

SEPTEMBER, 2022  
DATE

### PROJECT TITLE :

**EWA AND DH CONCOURSE  
ROADWAY IMPROVEMENTS  
PHASE 1**

AT  
DANIEL K. INOUE INTERNATIONAL AIRPORT  
HONOLULU, OAHU, HAWAII


### PROJECT NO.:

**AO1043-32**

### SHEET TITLE:

**2ND FLOOR DH  
MECHANICAL DEMOLITION  
PARTIAL PLAN A**

 DATE :	DWG. NO.  <b>M-D-20</b>
SEPTEMBER, 2022	
SHEET :	
183 OF 247 SHEETS	





**1**  
M-D-201


## 2ND FLOOR DH MECHANICAL DEMOLITION PARTIAL PLAN A

SCALE: 3/16" = 1' - 0"

2' 0' 4' 8' 12' 16'  
SCALE: 3/16"=1'-0"

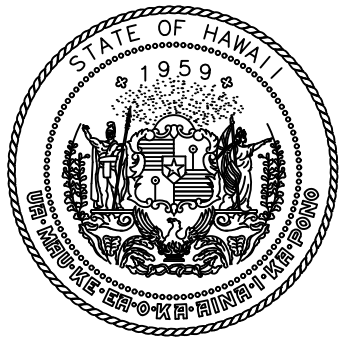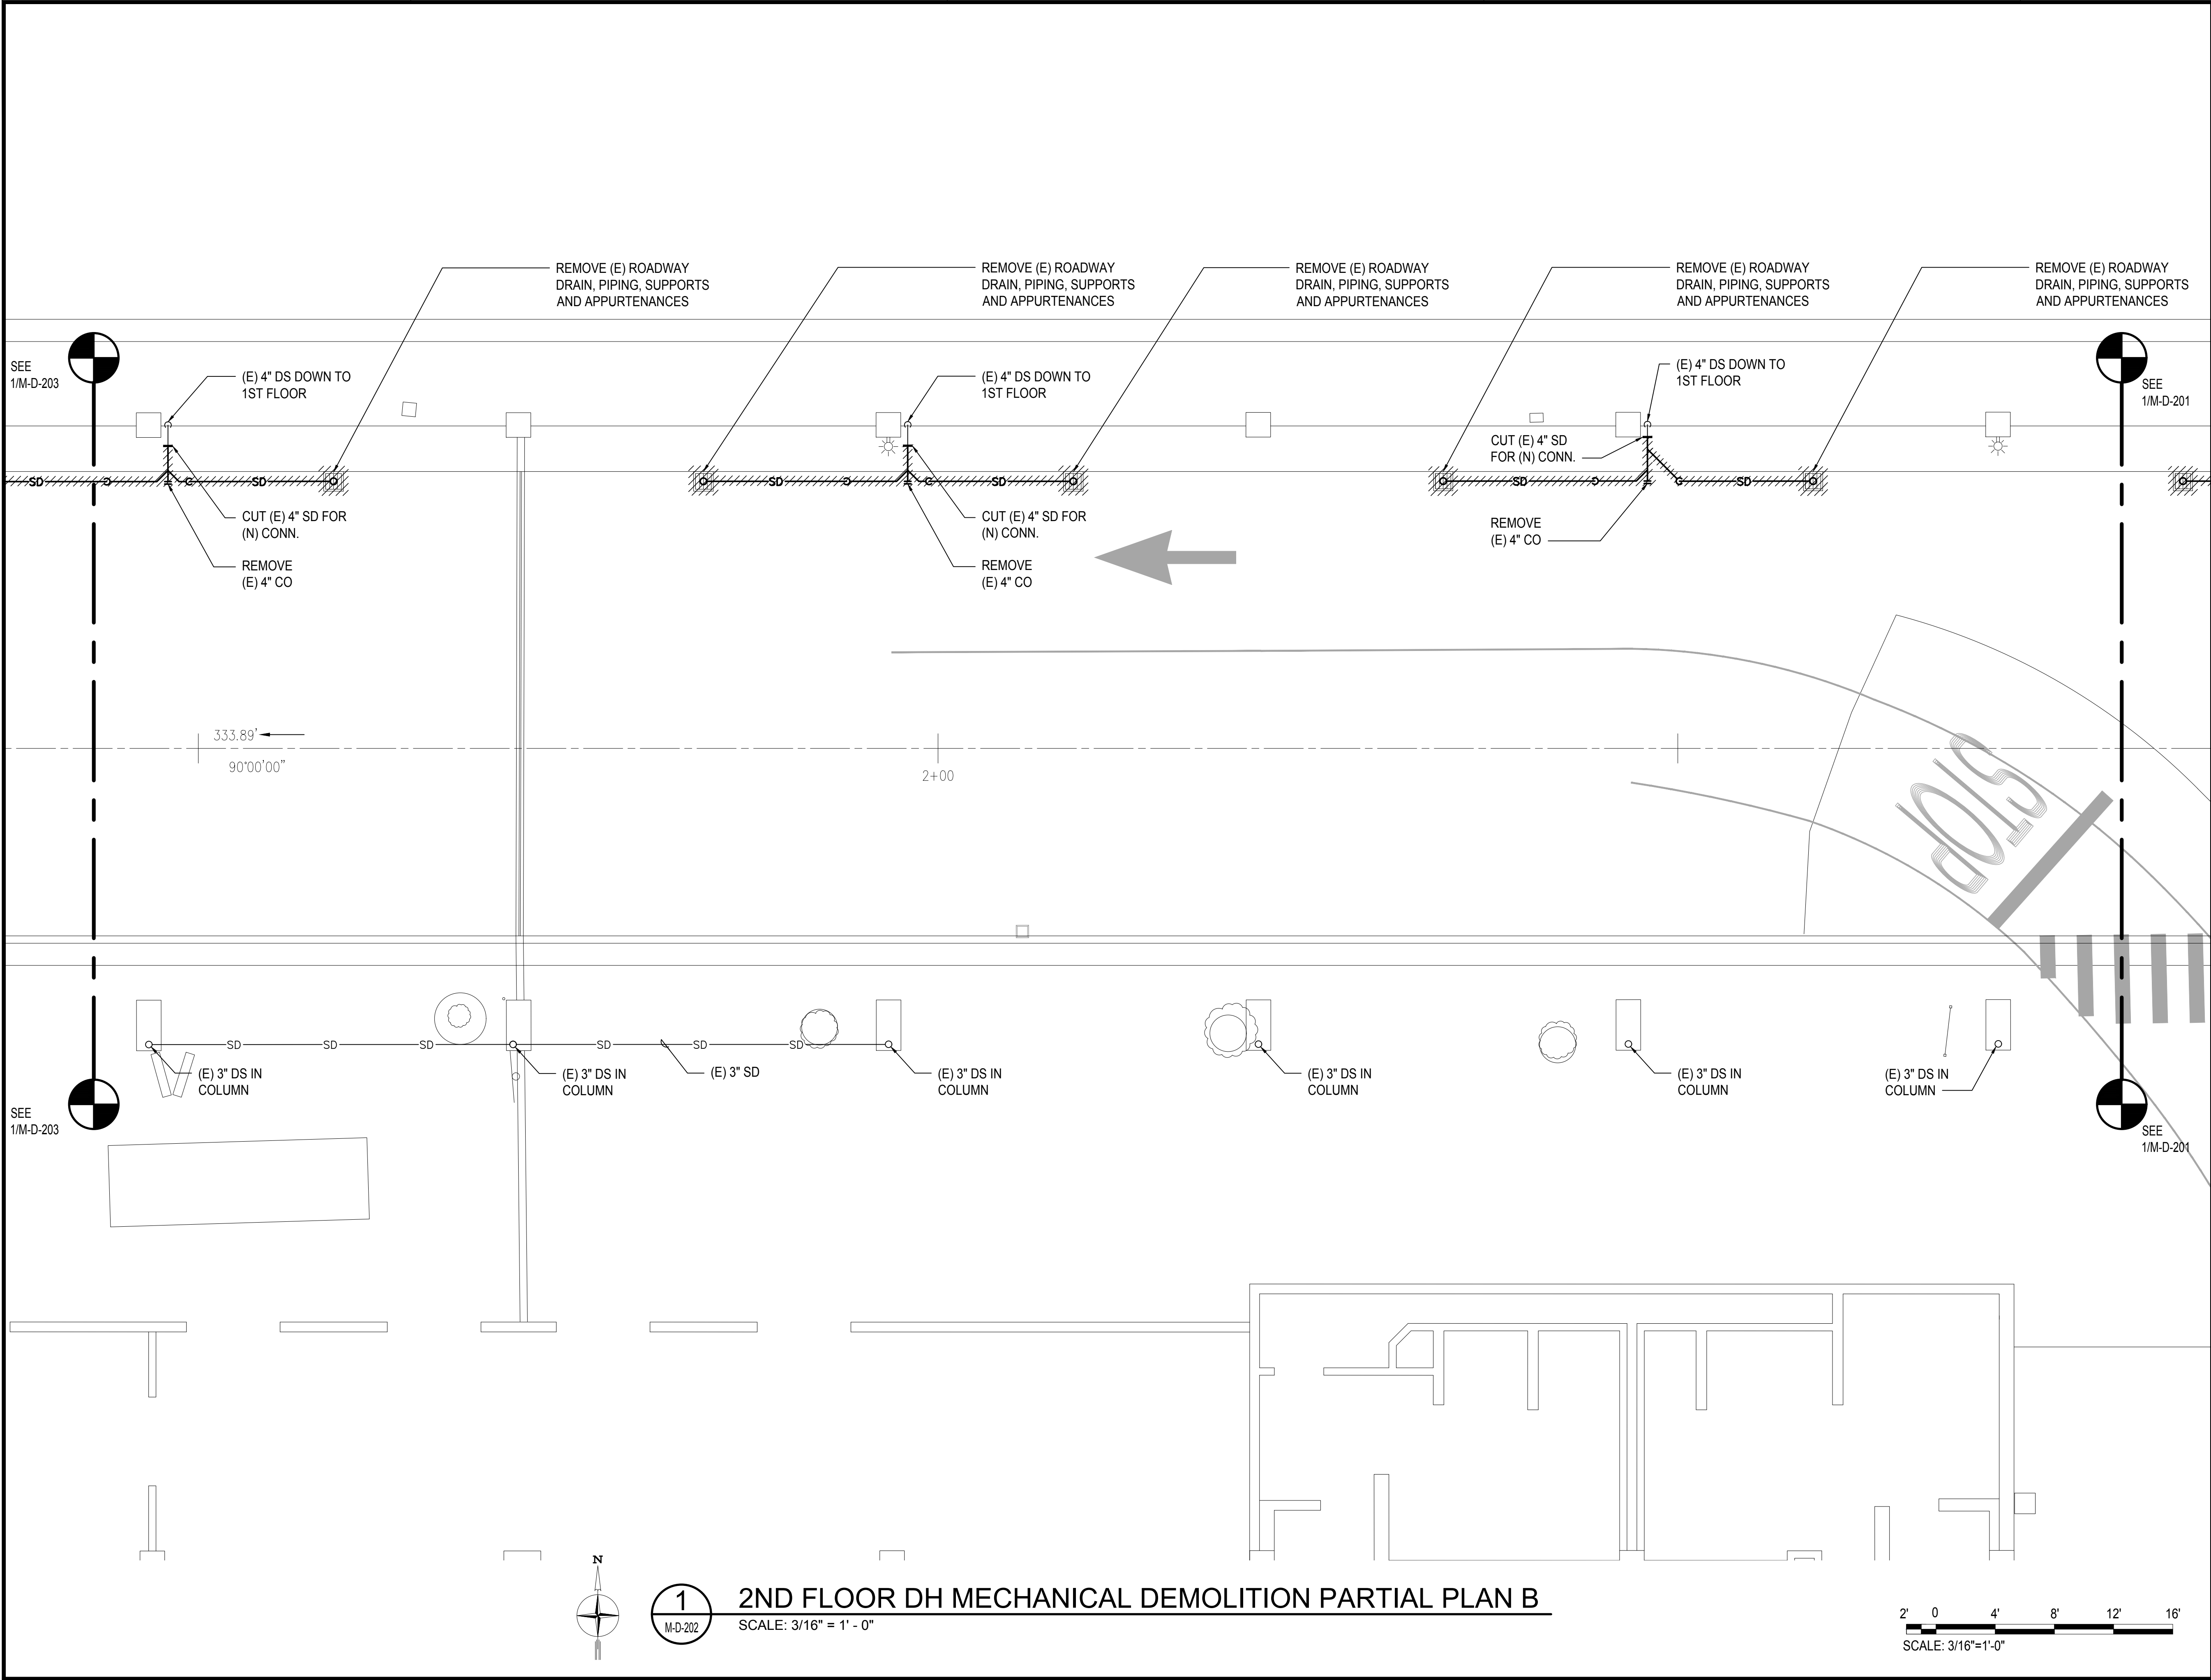

Airports Division  
DEPARTMENT OF TRANSPORTATION  
STATE OF HAWAII

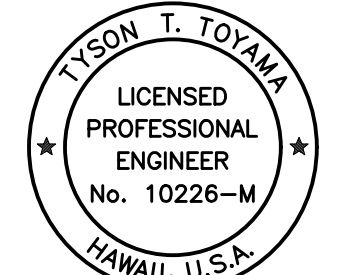

THIS WORK WAS PREPARED BY ME OR UNDER MY SUPERVISION AND CONSTRUCTION OF THIS PROJECT WILL BE UNDER MY OBSERVATION.


*Tyson T. Toyama*  
SIGNATURE

04/30/2024

EXPIRATION DATE OF THE LICENSE

DSGN.	DRWN.	CHKD.	APPD.
JS/KT	KT/TJ	TTT	TTT

KEY PLAN / NOTES:

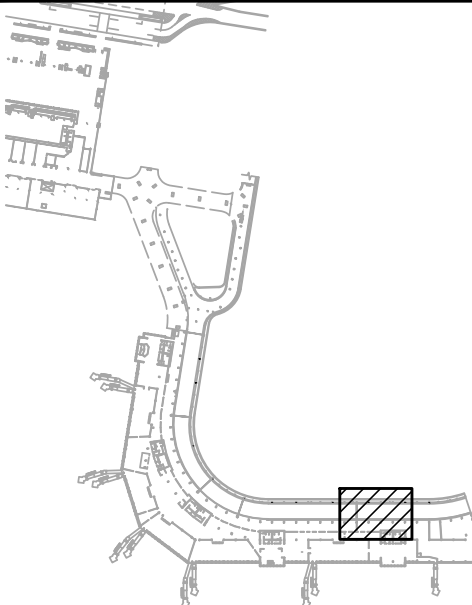

NO.	DATE	REVISIONS
-----	------	-----------

CONSTRUCTION DOCUMENTS

SEPTEMBER, 2022  
DATE

PROJECT TITLE :

EWA AND DH CONCOURSE  
ROADWAY IMPROVEMENTS  
PHASE 1

AT  
DANIEL K. INOUE INTERNATIONAL AIRPORT  
HONOLULU, OAHU, HAWAII

PROJECT NO.:

AO1043-32

SHEET TITLE:

2ND FLOOR DH  
MECHANICAL DEMOLITION  
PARTIAL PLAN B

DATE :



SEPTEMBER, 2022

SHEET :

184 OF 247 SHEETS

DWG. NO.

M-D-202

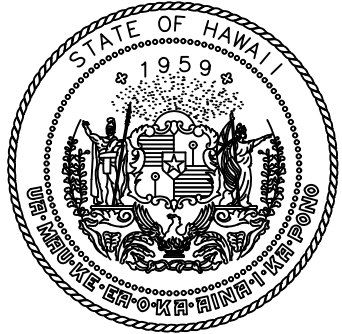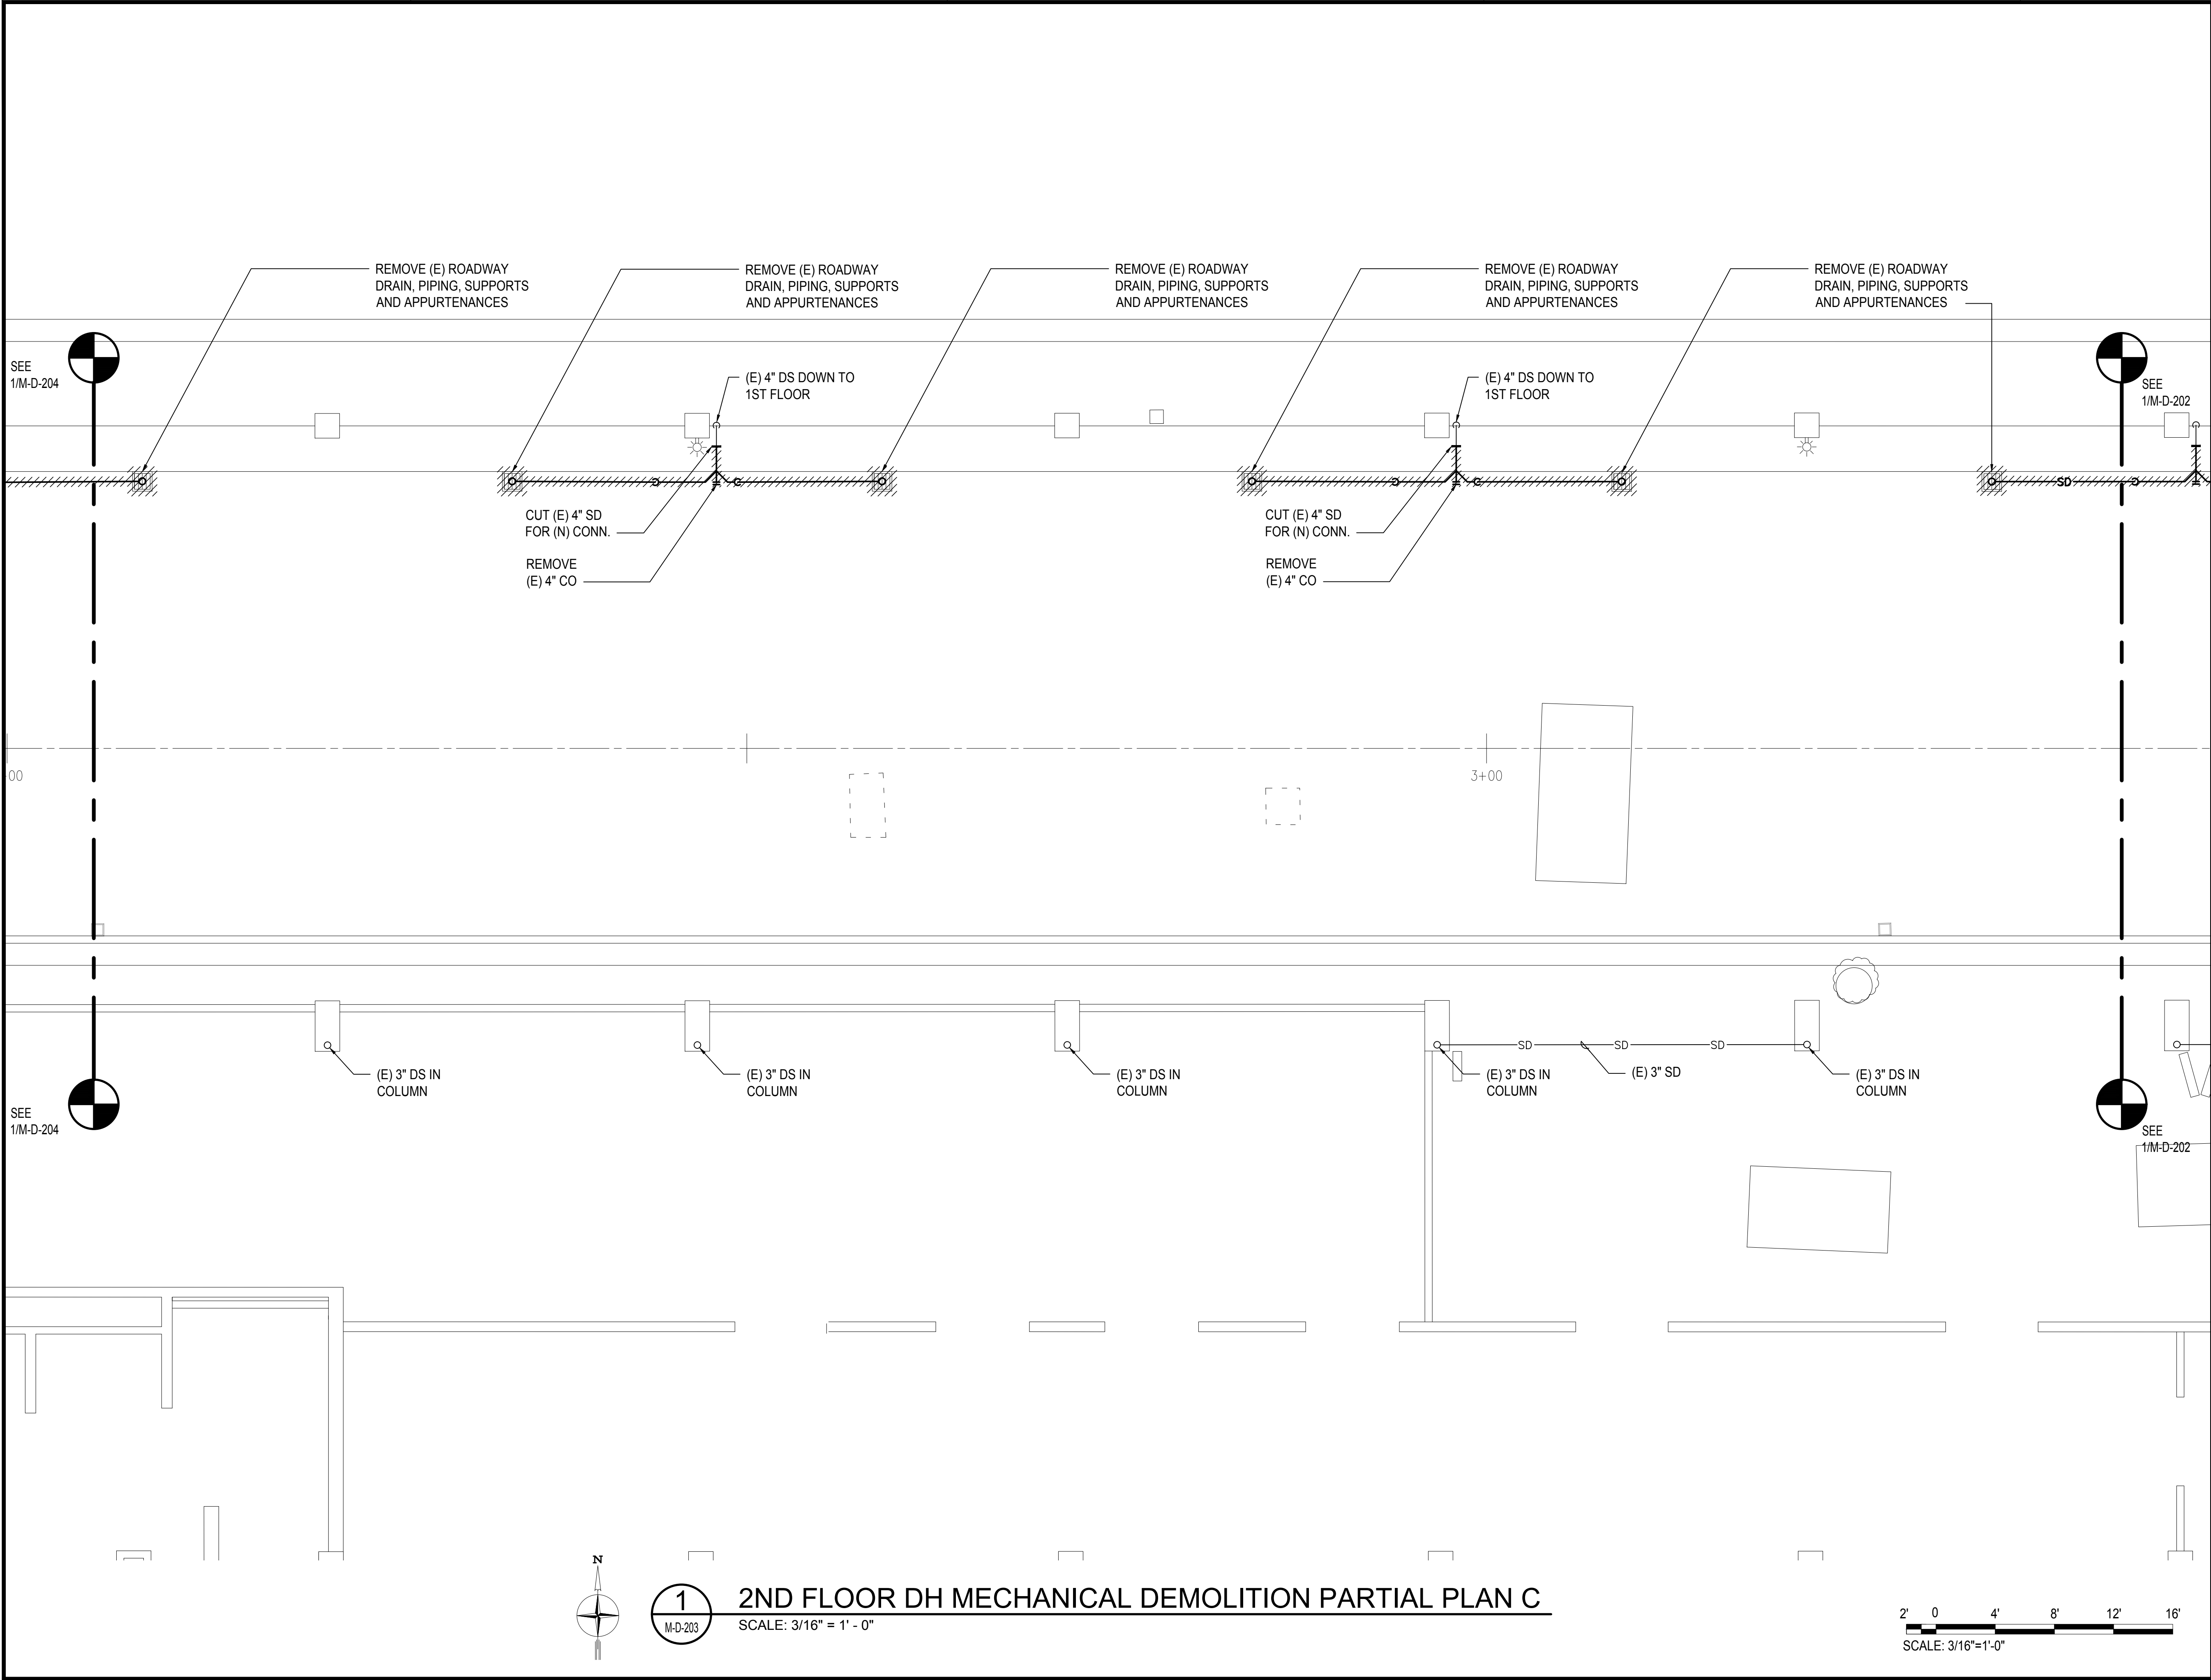

Airports Division  
DEPARTMENT OF TRANSPORTATION  
STATE OF HAWAII




THIS WORK WAS PREPARED BY ME OR UNDER MY SUPERVISION AND CONSTRUCTION OF THIS PROJECT WILL BE UNDER MY OBSERVATION.

SIGNATURE: *Tyson T. Toyama* EXPIRATION DATE OF THE LICENSE: 04/30/2024

DSGN.	DRWN.	CHKD.	APPD.
JS/KT	KT/TJ	TTT	TTT

KEY PLAN / NOTES:

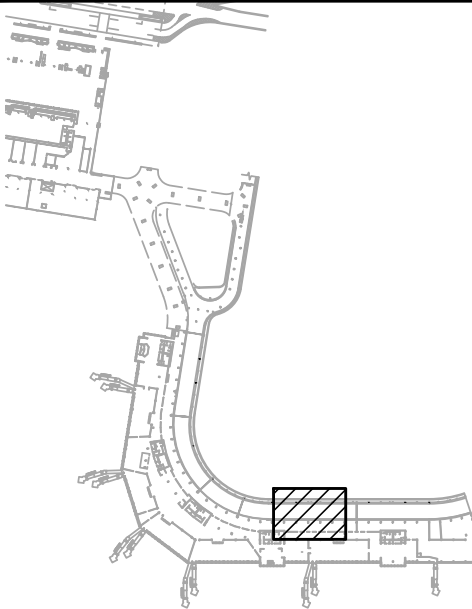

NO.	DATE	REVISIONS
-----	------	-----------

CONSTRUCTION DOCUMENTS

SEPTEMBER, 2022  
DATE

PROJECT TITLE :

EWA AND DH CONCOURSE  
ROADWAY IMPROVEMENTS  
PHASE 1

AT  
DANIEL K. INOUE INTERNATIONAL AIRPORT  
HONOLULU, OAHU, HAWAII

PROJECT NO.:

AO1043-32

SHEET TITLE:

2ND FLOOR DH  
MECHANICAL DEMOLITION  
PARTIAL PLAN C

DATE :

 
SEPTEMBER, 2022

SHEET :

185 OF 247 SHEETS

DWG. NO.

M-D-203





1  
M-D-203

2ND FLOOR DH MECHANICAL DEMOLITION PARTIAL PLAN C


SCALE: 3/16" = 1' - 0"

2' 0' 4' 8' 12' 16'  
SCALE: 3/16"=1'-0"

M:\PROJECTS\2022\219-000\219-076.DWG EWA DH ROADWAY IMPROVEMENTS PHASE 1 - MECHANICAL PLANS DH.DWG

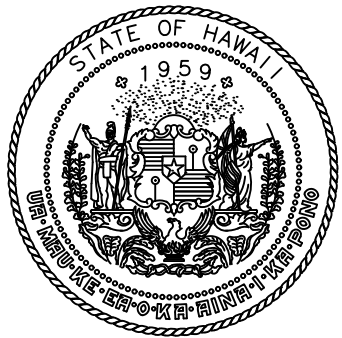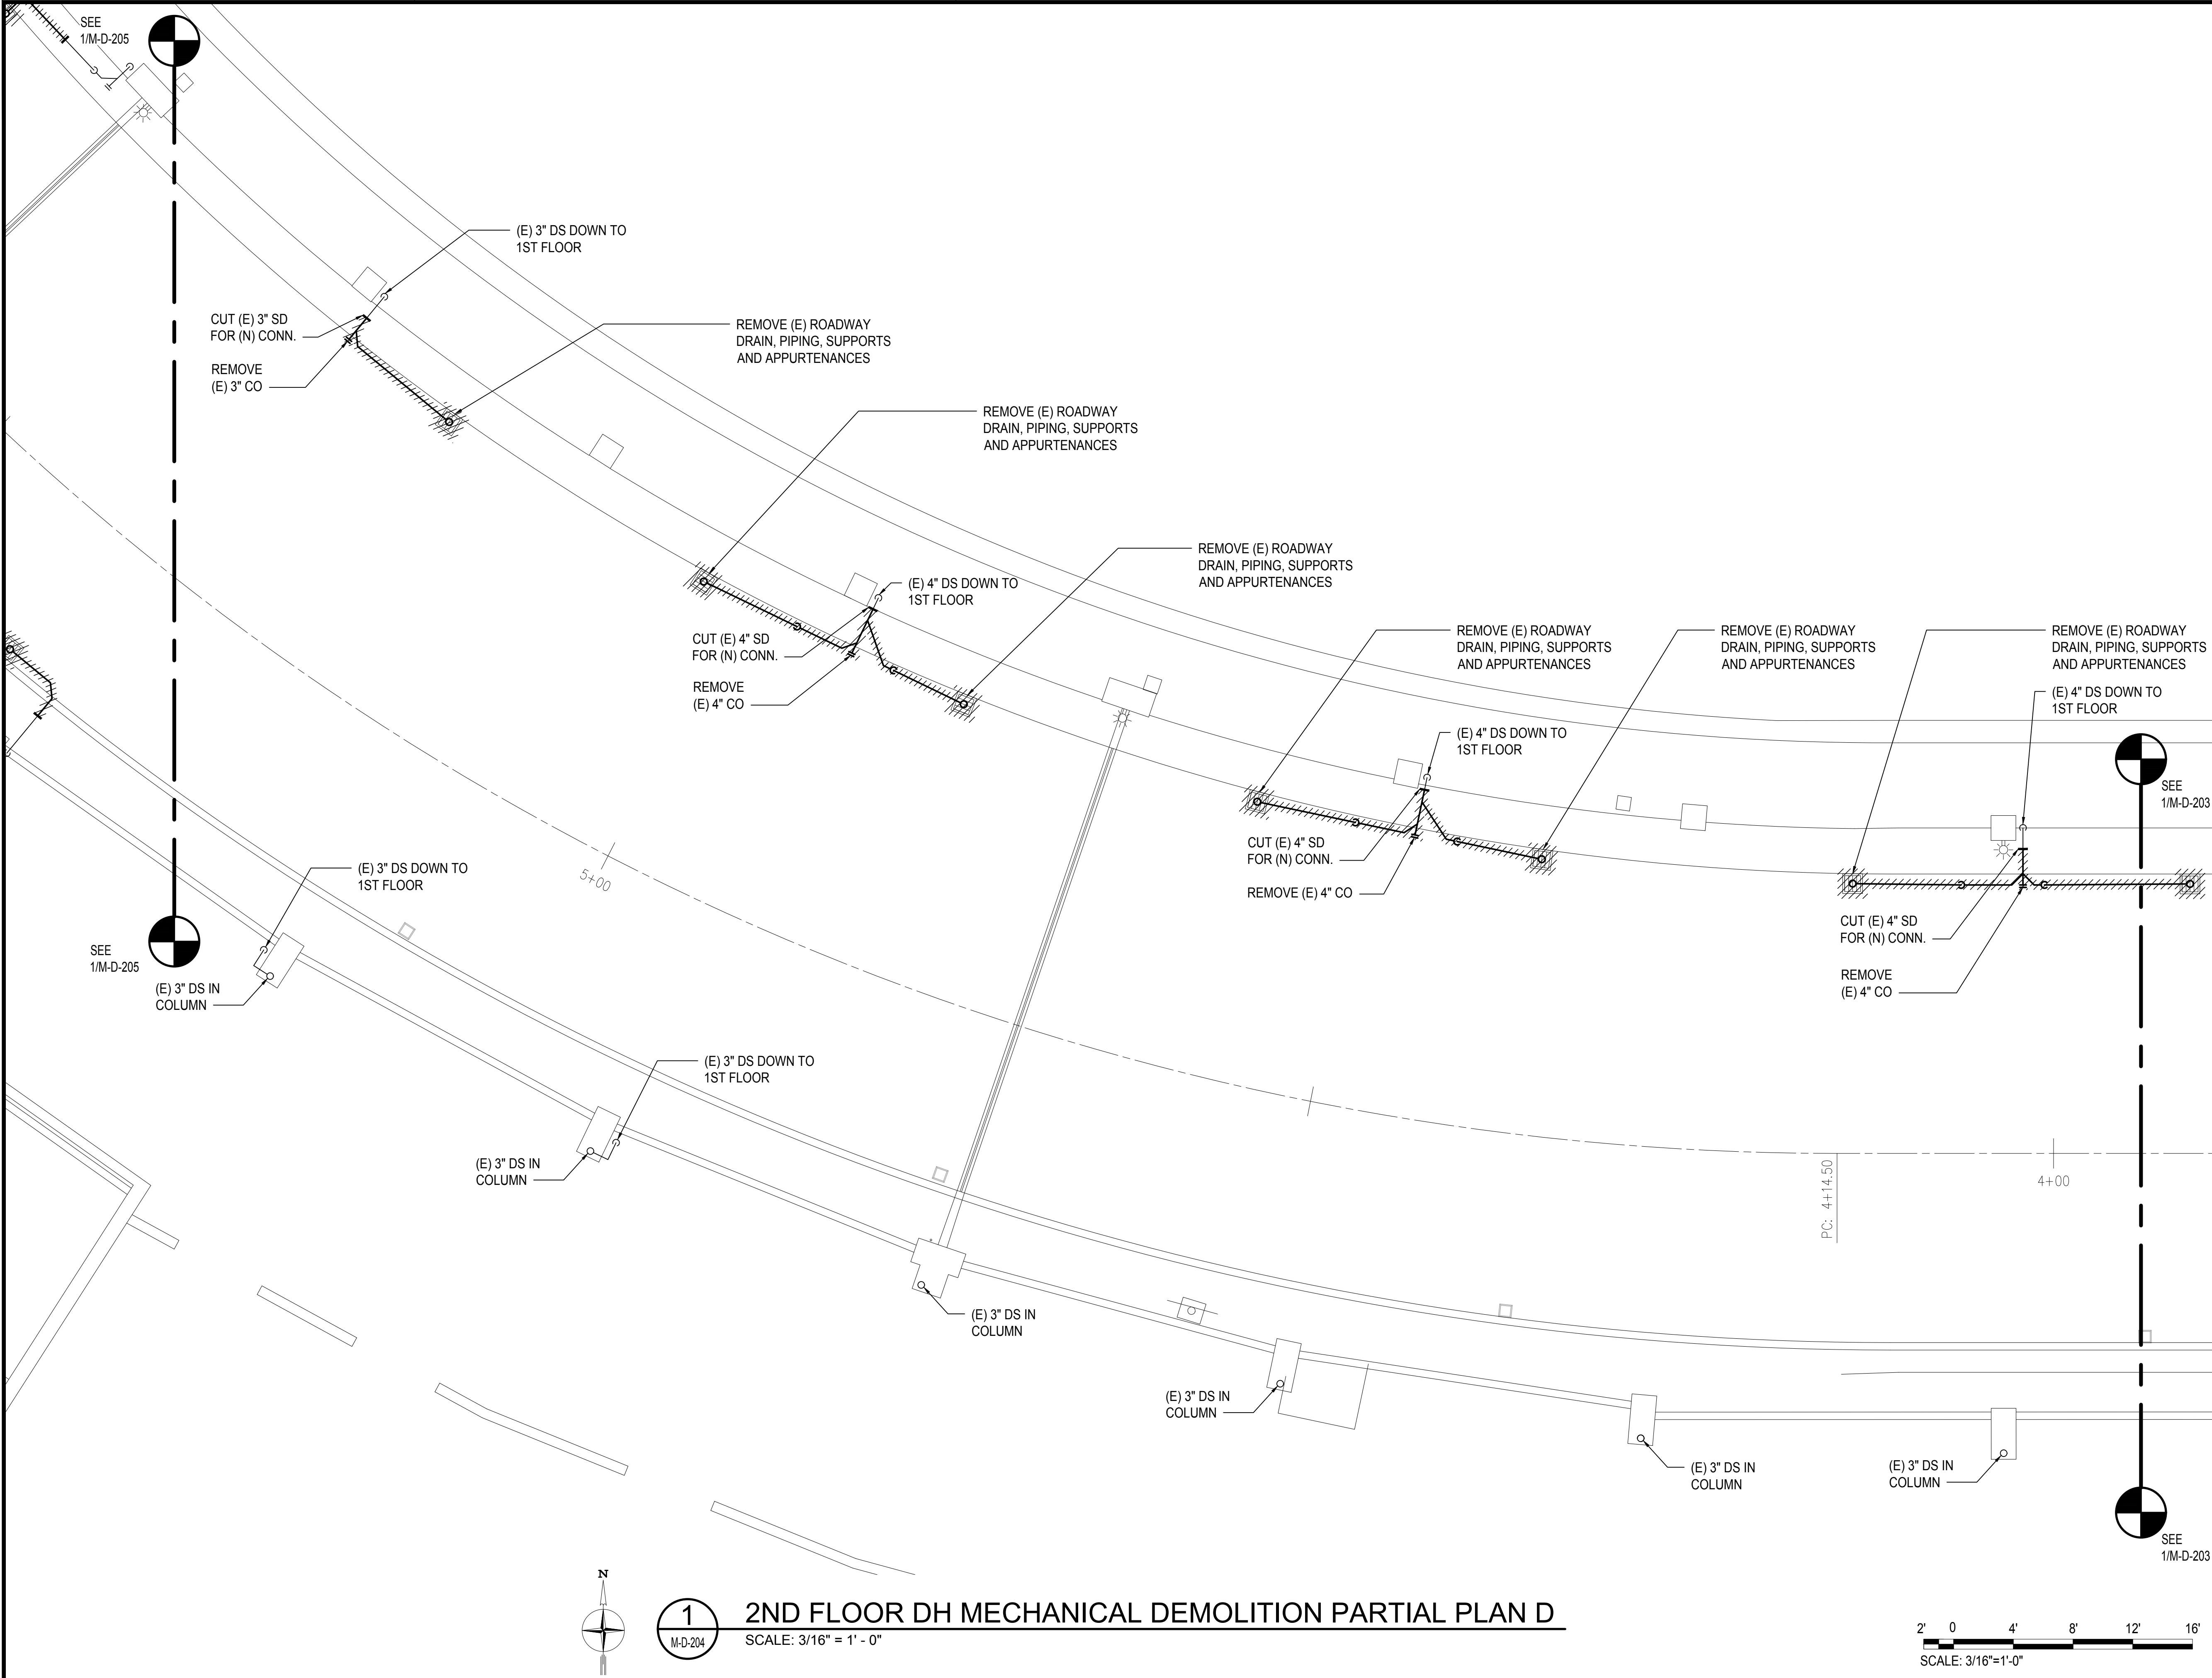

Airports Division  
DEPARTMENT OF TRANSPORTATION  
STATE OF HAWAII

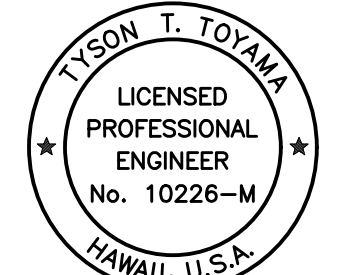


THIS WORK WAS PREPARED BY ME OR UNDER MY SUPERVISION AND CONSTRUCTION OF THIS PROJECT WILL BE UNDER MY OBSERVATION.

*Tyson T. Toyama*  
SIGNATURE

04/30/2024  
EXPIRATION DATE OF THE LICENSE

DSGN.	DRWN.	CHKD.	APPD.
JS/KT	KT/TJ	TTT	TTT

KEY PLAN / NOTES:

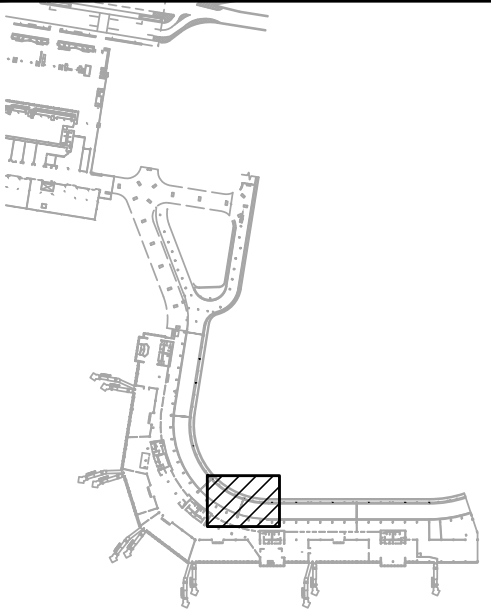

NO.	DATE	REVISIONS
-----	------	-----------

CONSTRUCTION DOCUMENTS

SEPTEMBER, 2022  
DATE

PROJECT TITLE :

EWA AND DH CONCOURSE  
ROADWAY IMPROVEMENTS  
PHASE 1

AT  
DANIEL K. INOUE INTERNATIONAL AIRPORT  
HONOLULU, OAHU, HAWAII

PROJECT NO.:

AO1043-32

SHEET TITLE:

2ND FLOOR DH  
MECHANICAL DEMOLITION  
PARTIAL PLAN D

DATE :


SEPTEMBER, 2022

SHEET :

186 OF 247 SHEETS



DWG. NO.

M-D-204

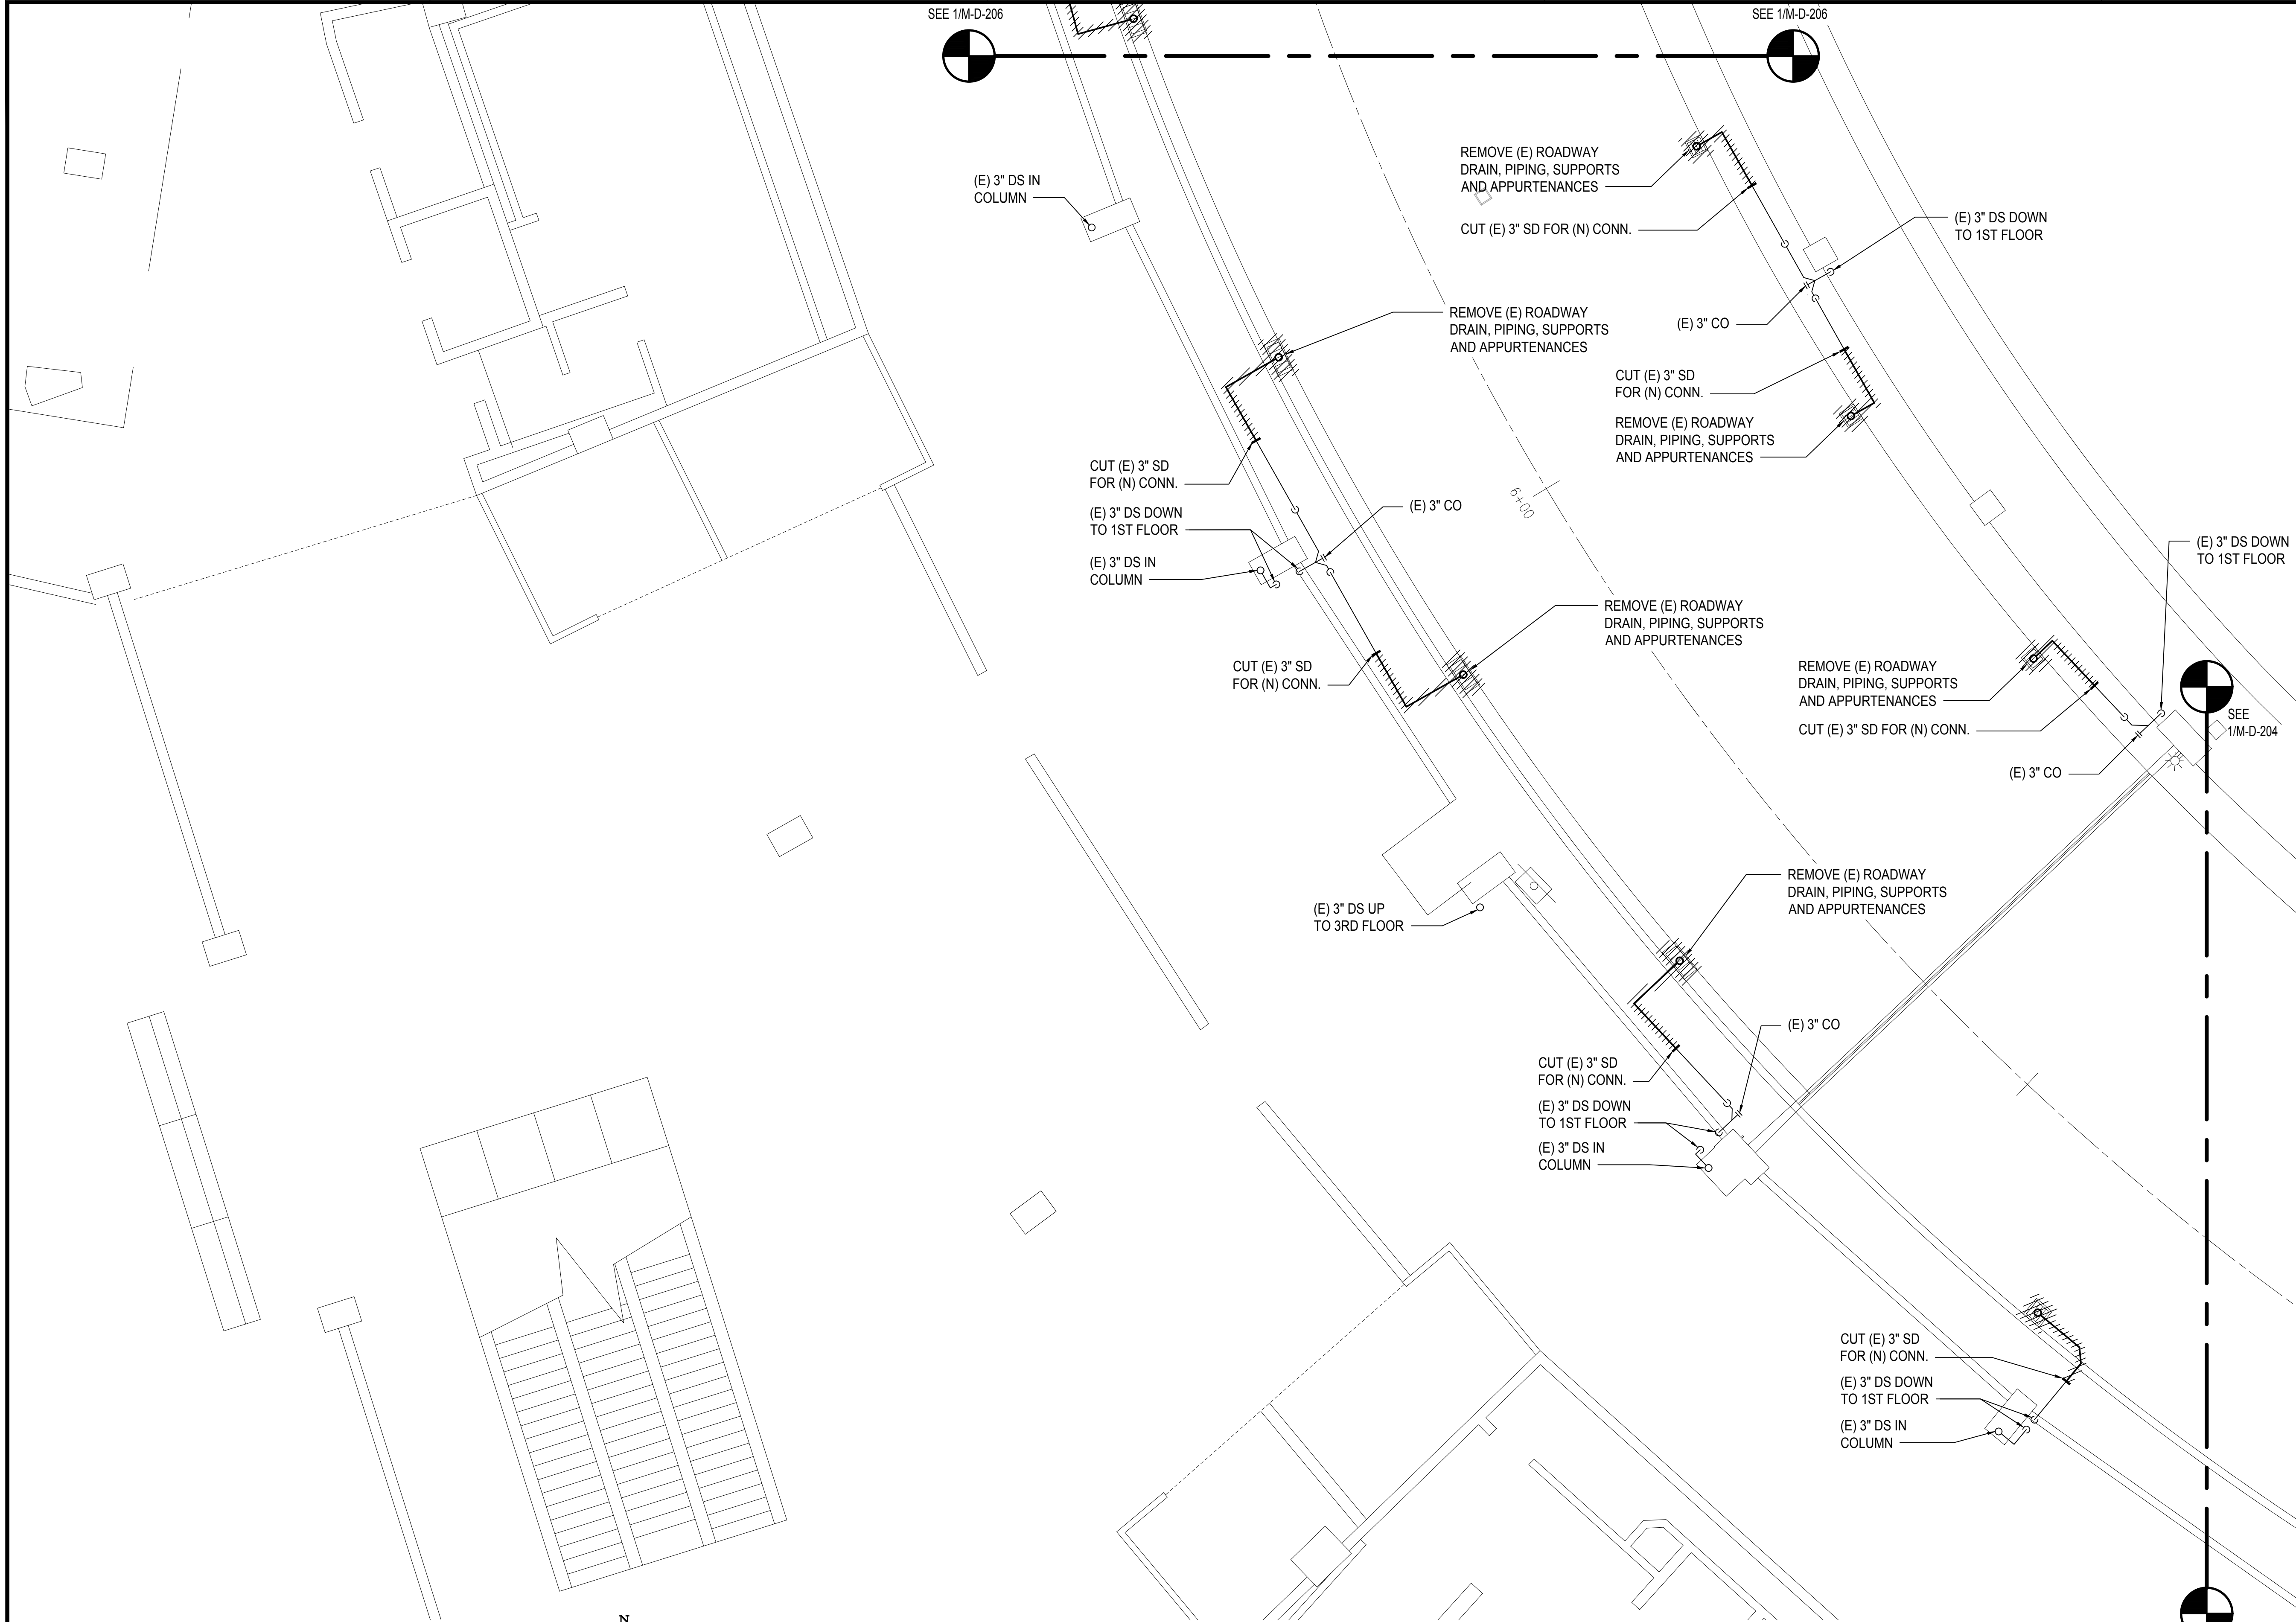


1  
M-D-205

2ND FLOOR DH MECHANICAL DEMOLITION PARTIAL PLAN E  
SCALE: 3/16" = 1' - 0"

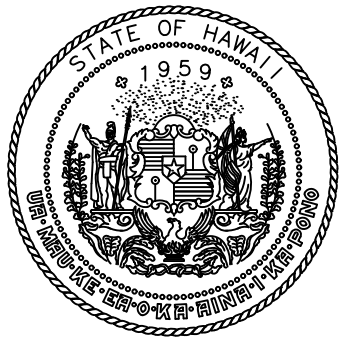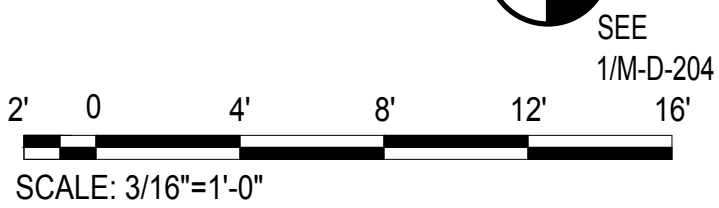

Airports Division  
DEPARTMENT OF TRANSPORTATION  
STATE OF HAWAII

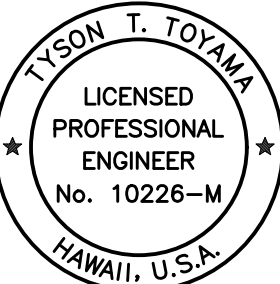


THIS WORK WAS PREPARED BY ME OR UNDER MY SUPERVISION  
AND CONSTRUCTION OF THIS PROJECT WILL BE UNDER MY  
OBSERVATION.

*Tyson T. Toyama*  
SIGNATURE

04/30/2024  
EXPIRATION DATE OF THE LICENSE

DSGN.	DRWN.	CHKD.	APPD.
JS/KT	KT/TJ	TTT	TTT

KEY PLAN / NOTES:

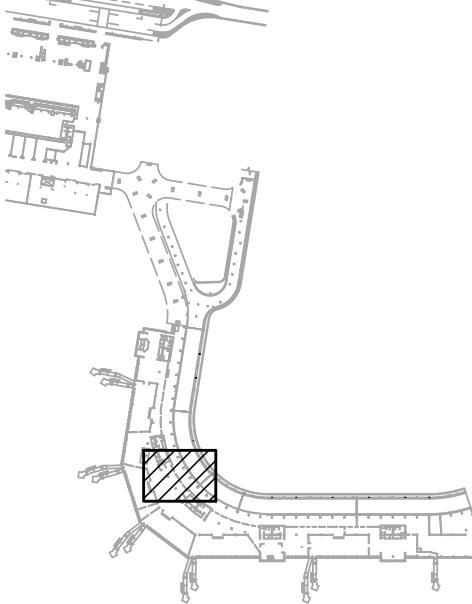

NO.	DATE	REVISIONS
-----	------	-----------

CONSTRUCTION  
DOCUMENTS

SEPTEMBER, 2022  
DATE

PROJECT TITLE :

EWA AND DH CONCOURSE  
ROADWAY IMPROVEMENTS  
PHASE 1

AT  
DANIEL K. INOUE INTERNATIONAL AIRPORT  
HONOLULU, OAHU, HAWAII

PROJECT NO.:

AO1043-32

SHEET TITLE:

2ND FLOOR DH  
MECHANICAL DEMOLITION  
PARTIAL PLAN E

DATE :

SEPTEMBER, 2022

SHEET :


187 OF 247 SHEETS

DWG. NO.

M-D-205

M:\PROJECTS\2024\DOTA EWA DH ROADWAY IMPROVEMENTS\2ND LEVEL - MECHANICAL PLANS DH.DWG




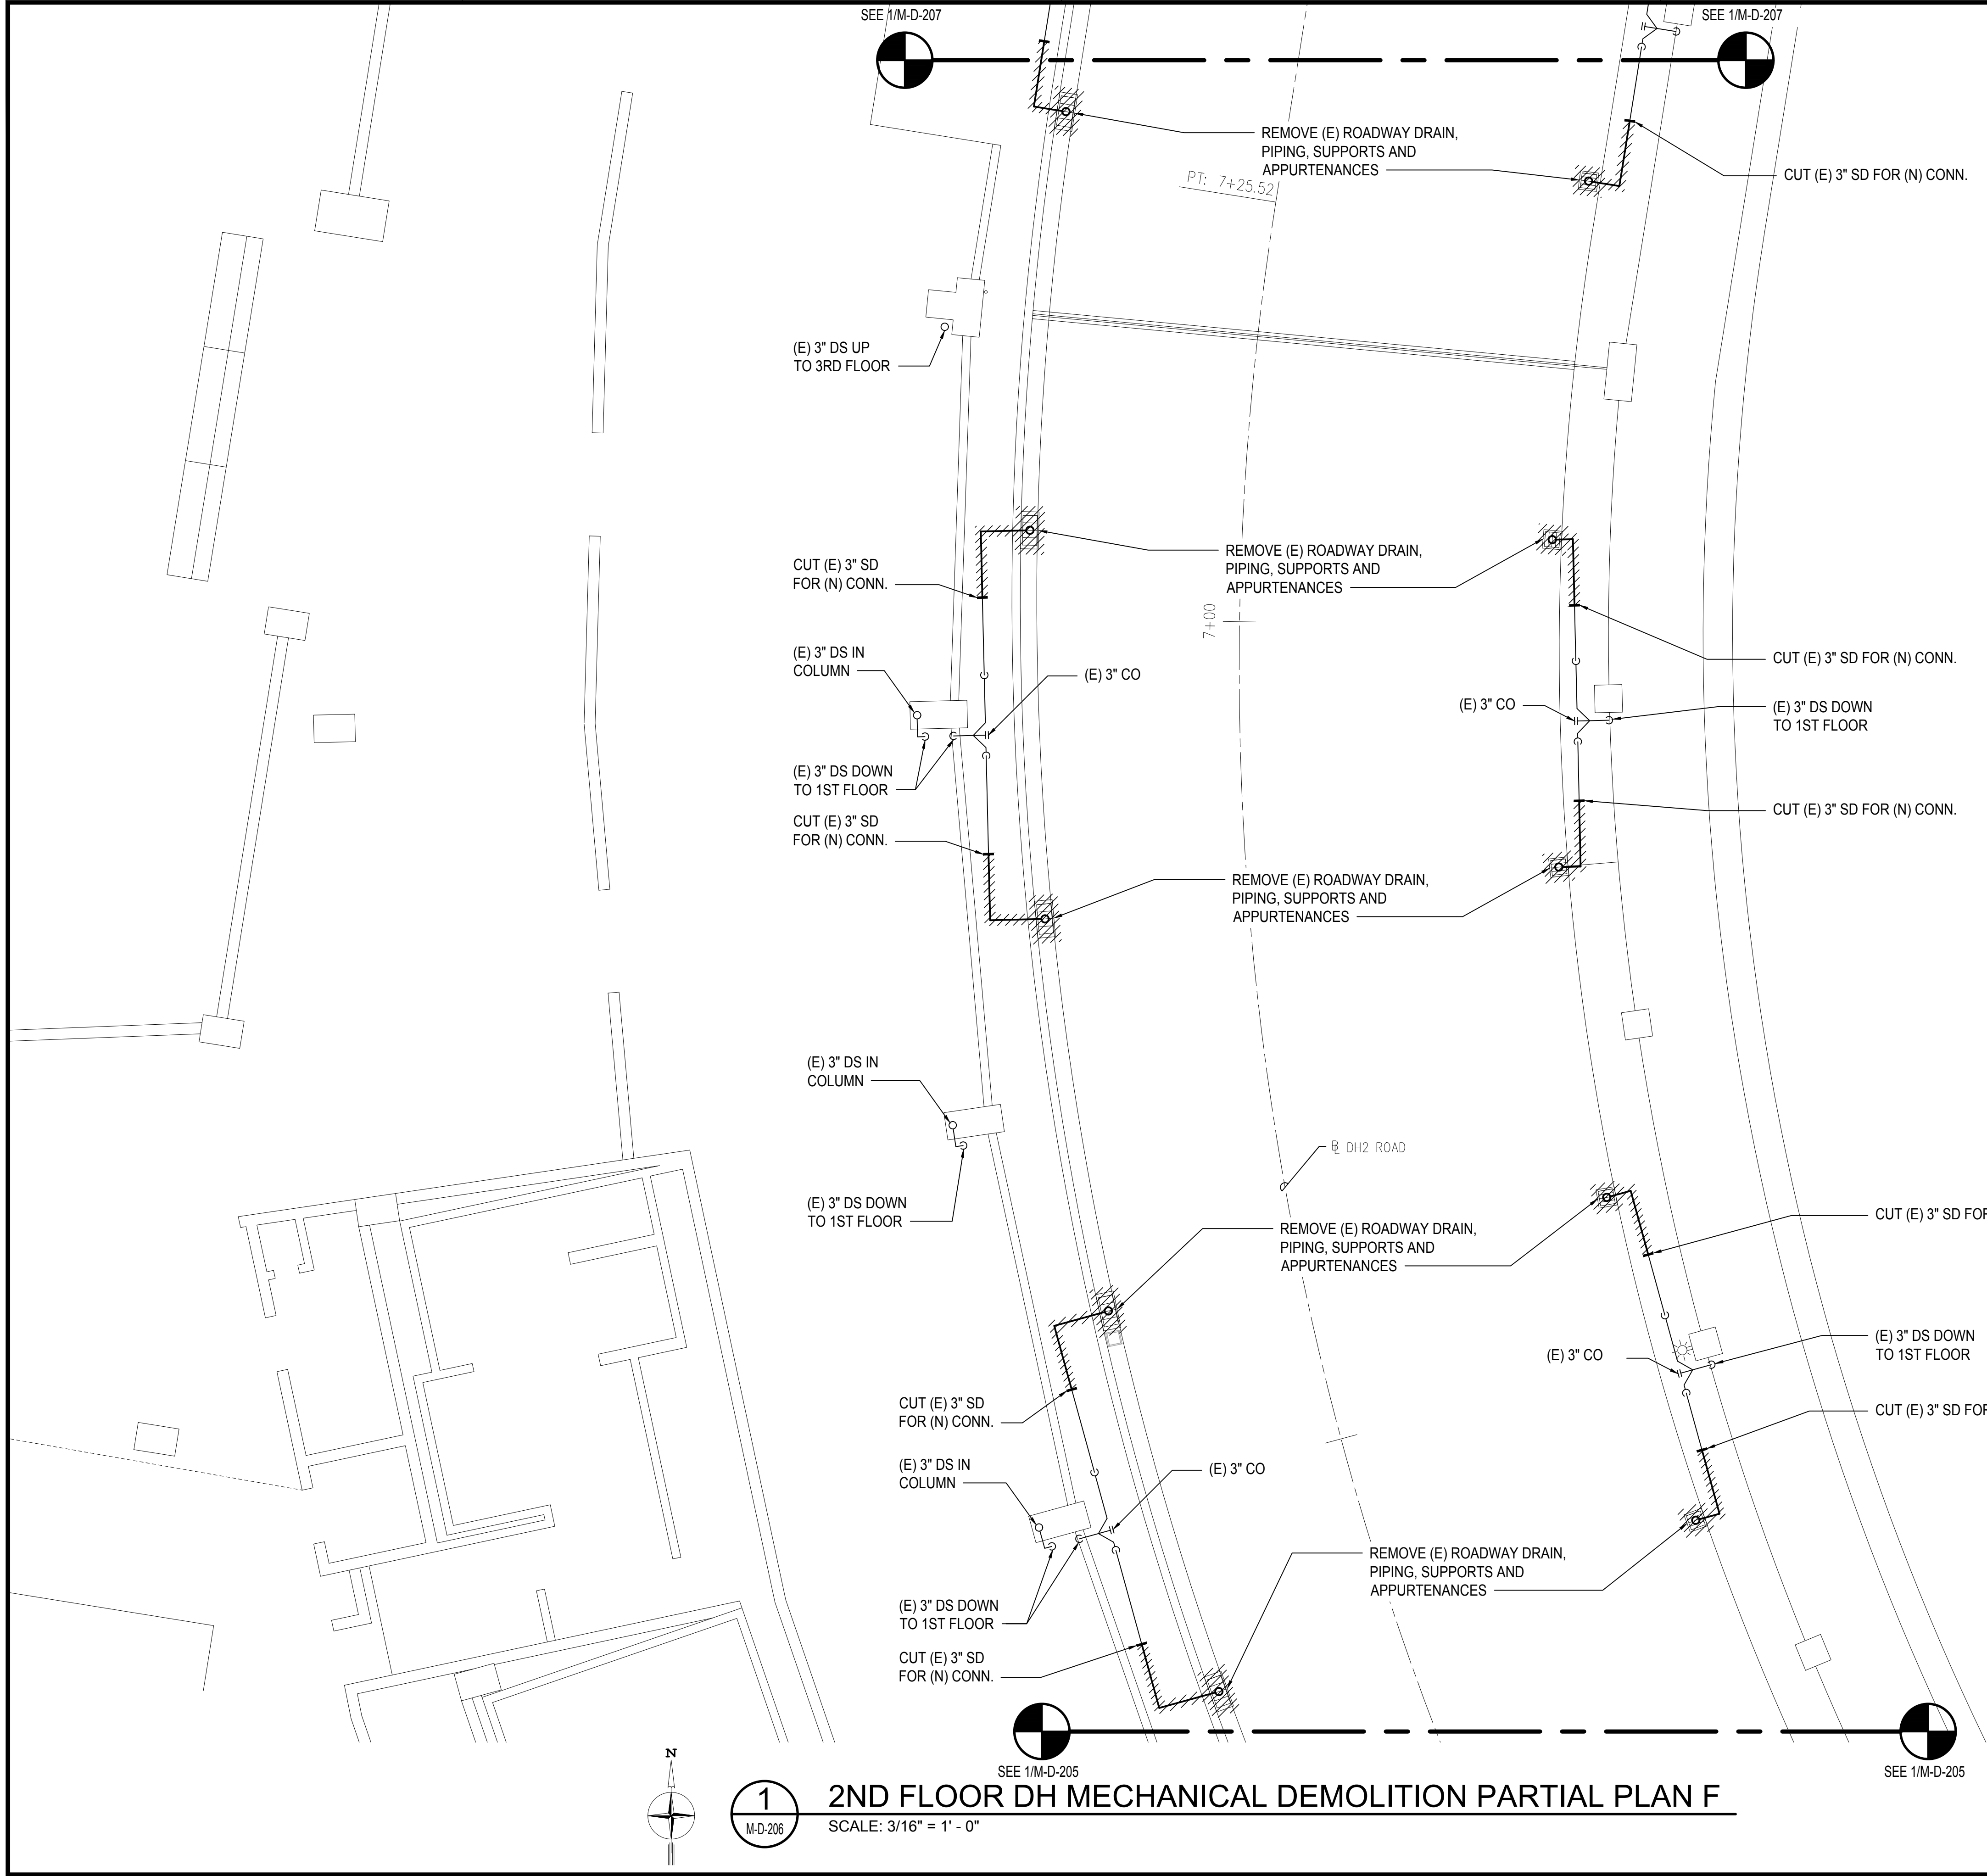


1  
M-D-206

2ND FLOOR DH MECHANICAL DEMOLITION PARTIAL PLAN F  
SCALE: 3/16" = 1' - 0"

2' 0' 4' 8' 12' 16'  
SCALE: 3/16"=1'-0"

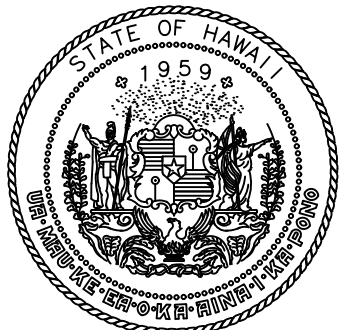

Airports Division  
DEPARTMENT OF TRANSPORTATION  
STATE OF HAWAII

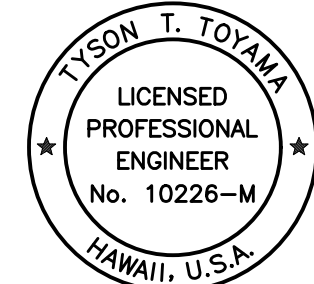


THIS WORK WAS PREPARED BY ME OR UNDER MY SUPERVISION  
AND CONSTRUCTION OF THIS PROJECT WILL BE UNDER MY  
OBSERVATION.

*Tyson T. Toyama*  
SIGNATURE

04/30/2024  
EXPIRATION DATE OF THE LICENSE

DSGN.	DRWN.	CHKD.	APPD.
JS/KT	KT/TJ	TTT	TTT

KEY PLAN / NOTES:

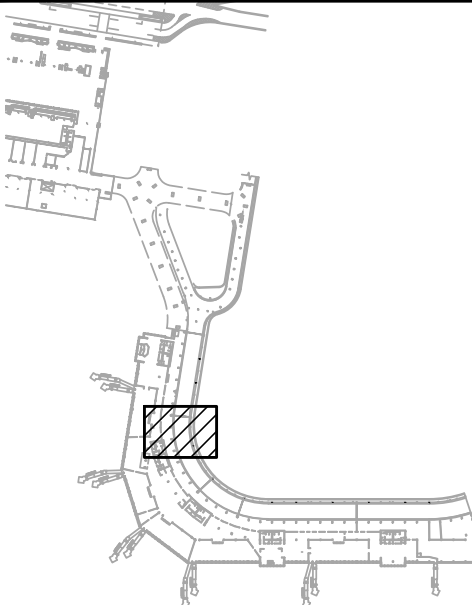

NO.	DATE	REVISIONS
-----	------	-----------

CONSTRUCTION  
DOCUMENTS

SEPTEMBER, 2022  
DATE

PROJECT TITLE :

EWA AND DH CONCOURSE  
ROADWAY IMPROVEMENTS  
PHASE 1

AT  
DANIEL K. INOUE INTERNATIONAL AIRPORT  
HONOLULU, OAHU, HAWAII

PROJECT NO.:

AO1043-32

SHEET TITLE:

2ND FLOOR DH  
MECHANICAL DEMOLITION  
PARTIAL PLAN F

DATE :

SEPTEMBER, 2022

 

SHEET :

188 OF 247 SHEETS

DWG. NO.

M-D-206

M:\PRJ\219-000\219-076 DOTA EWA DH ROADWAY\DRAWINGS\HNL 2ND LEVEL - MECHANICAL PLANS DH.DWG

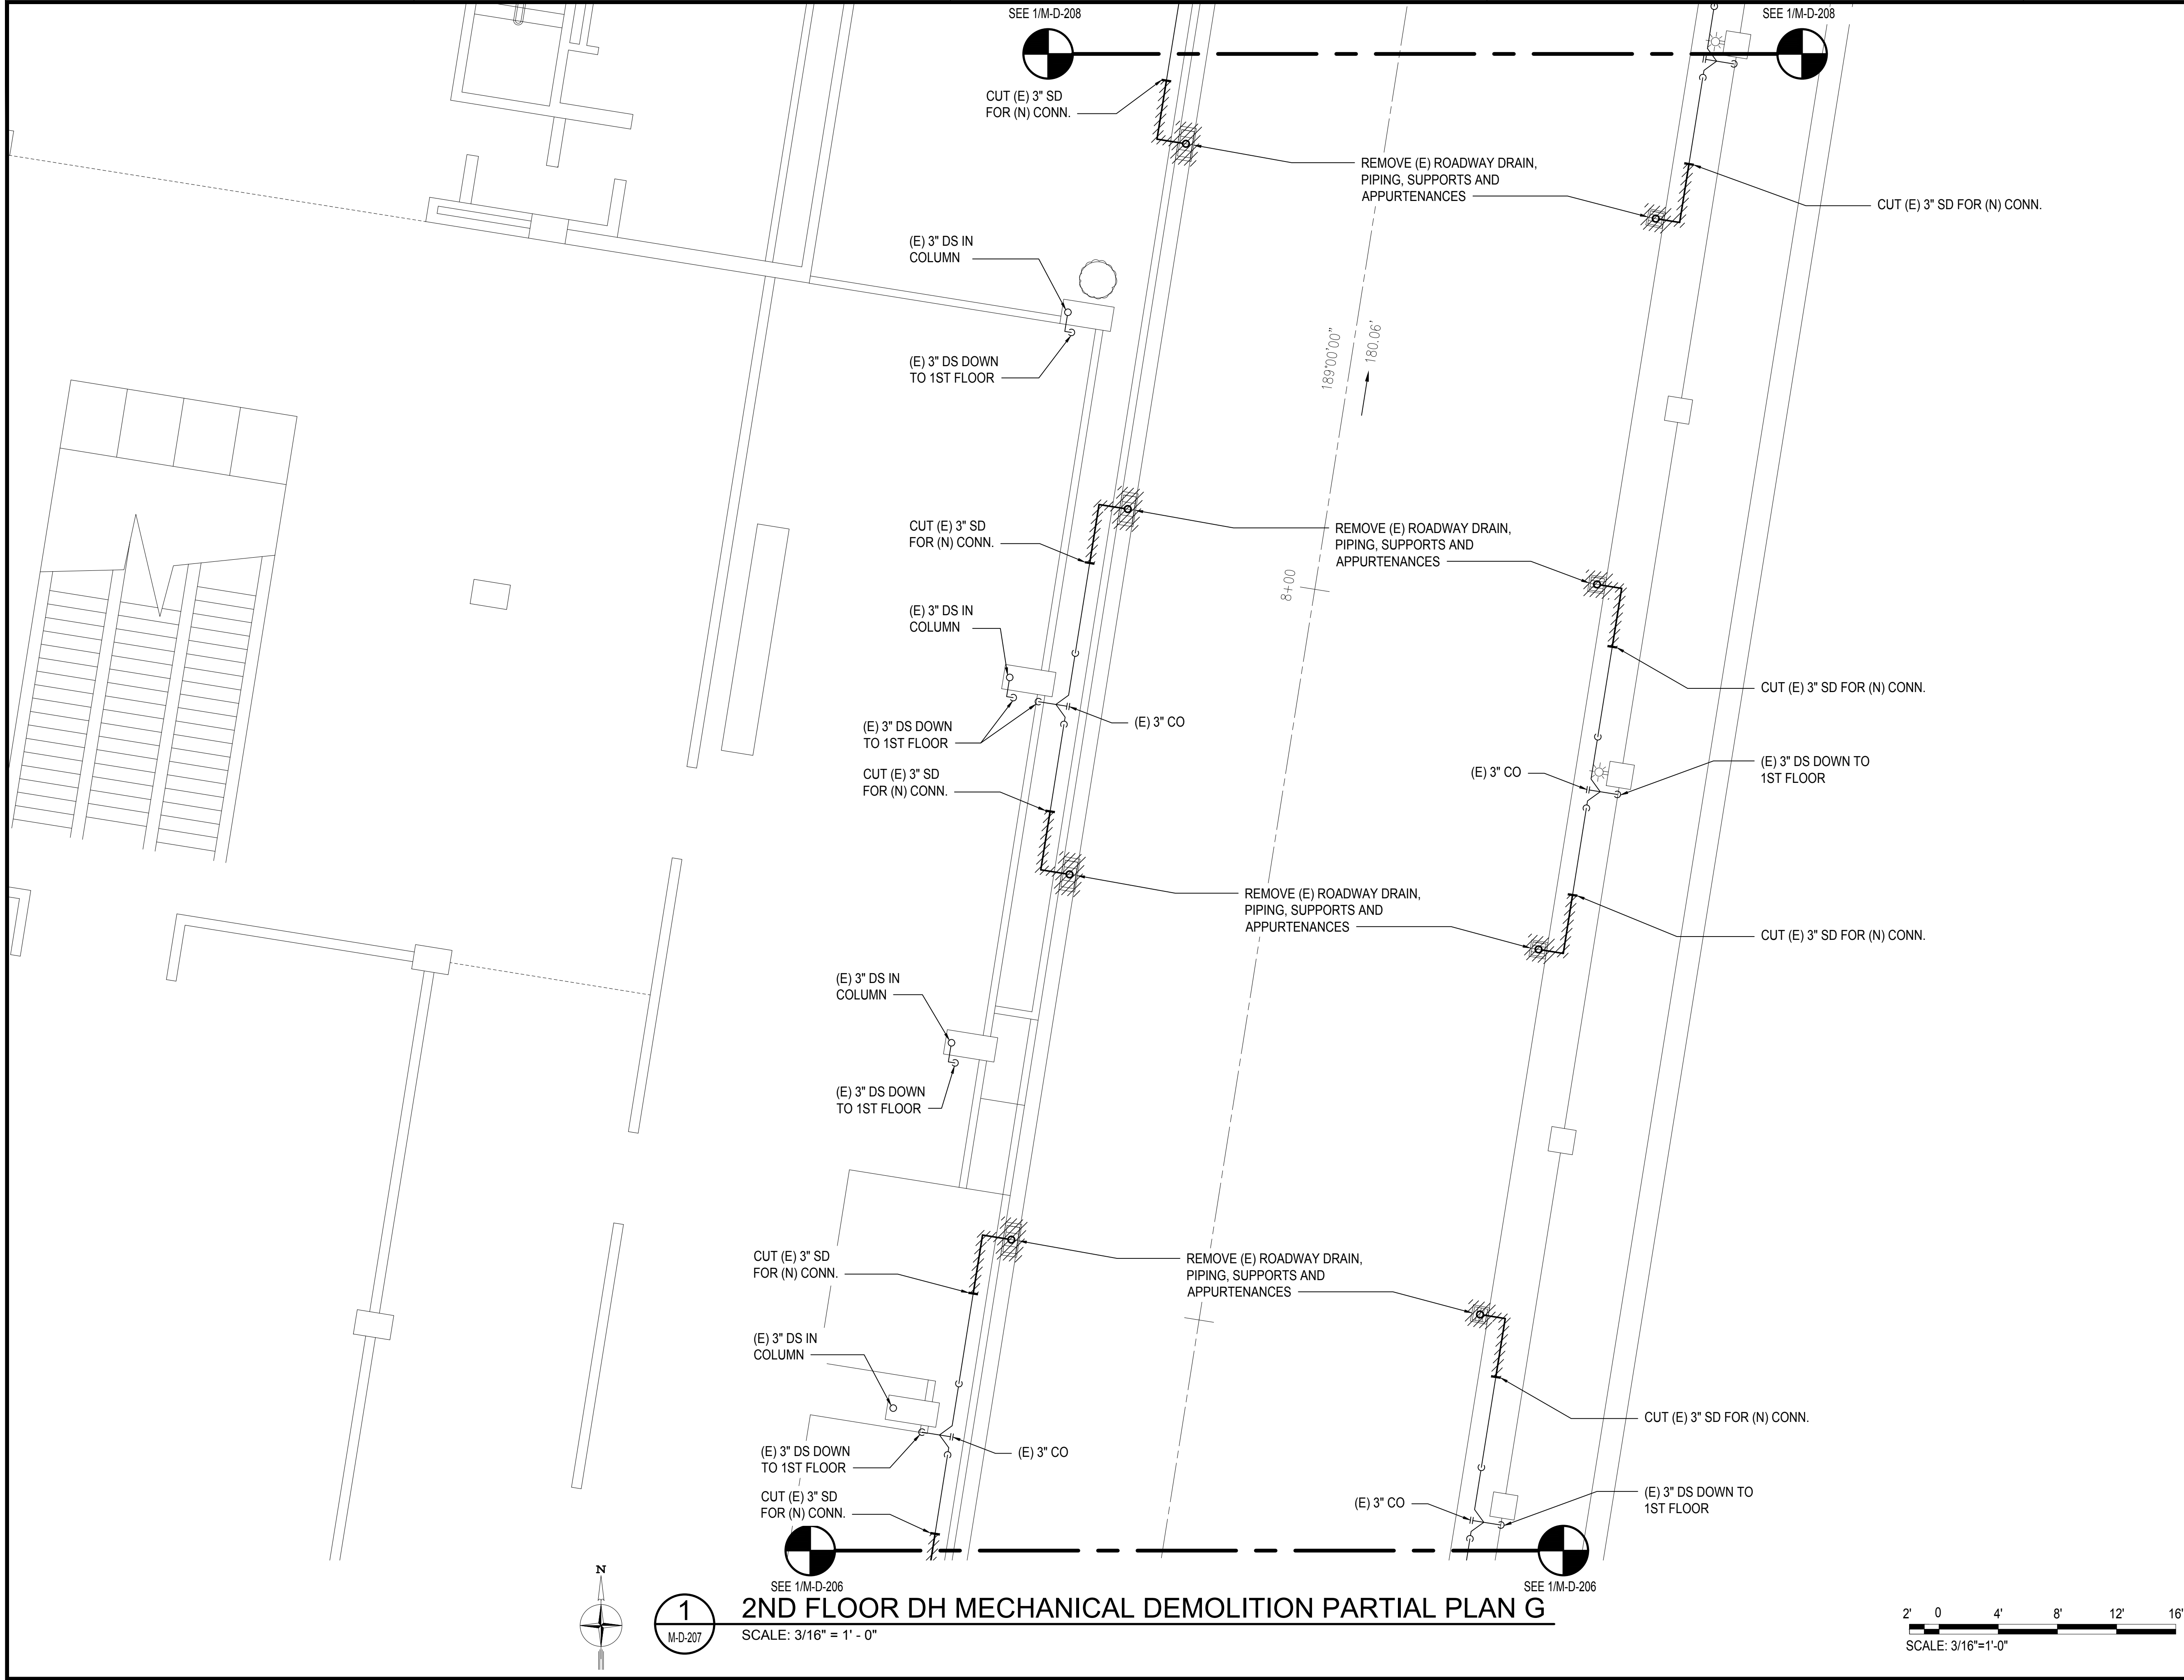



1  
M-D-207

SEE 1/M-D-206


2ND FLOOR DH MECHANICAL DEMOLITION PARTIAL PLAN G

SCALE: 3/16" = 1' - 0"

SEE 1/M-D-208

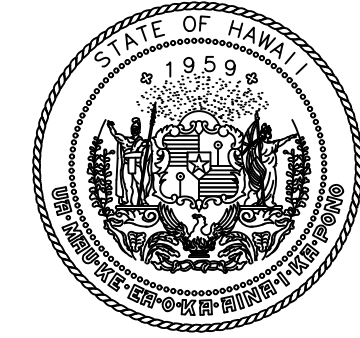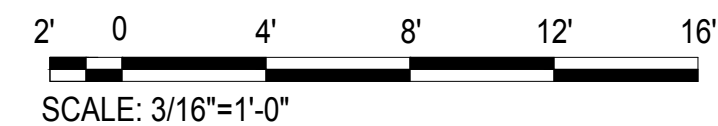

Airports Division  
DEPARTMENT OF TRANSPORTATION  
STATE OF HAWAII

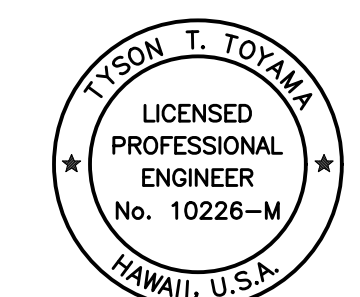


THIS WORK WAS PREPARED BY ME OR UNDER MY SUPERVISION  
AND CONSTRUCTION OF THIS PROJECT WILL BE UNDER MY  
OBSERVATION.

SIGNATURE: *Tyson T. Toyama* EXPIRATION DATE OF THE LICENSE: 04/30/2024

DSGN.	DRWN.	CHKD.	APPD.
JS/KT	KT/TJ	TTT	TTT

KEY PLAN / NOTES:

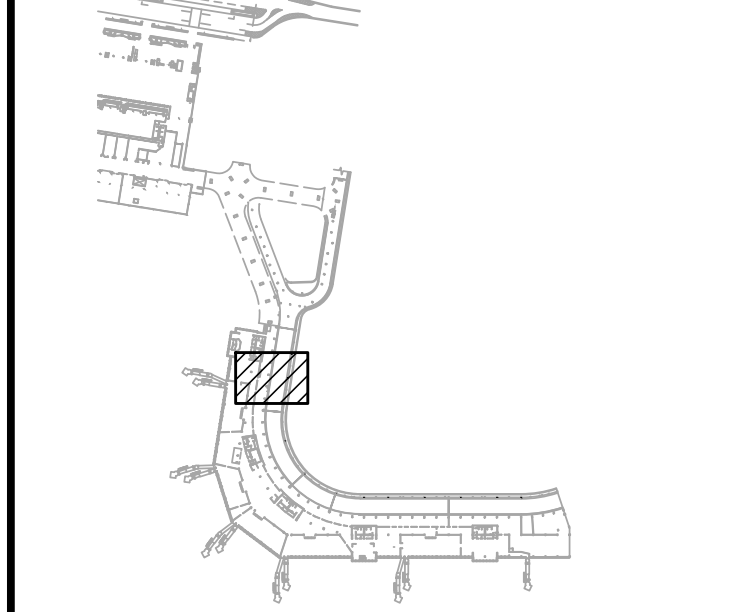

NO.	DATE	REVISIONS

CONSTRUCTION DOCUMENTS  
SEPTEMBER, 2022  
DATE

PROJECT TITLE :  
EWA AND DH CONCOURSE  
ROADWAY IMPROVEMENTS  
PHASE 1

AT  
DANIEL K. INOUE INTERNATIONAL AIRPORT  
HONOLULU, OAHU, HAWAII

PROJECT NO.:



AO1043-32

SHEET TITLE:


2ND FLOOR DH  
MECHANICAL DEMOLITION  
PARTIAL PLAN G

DATE : SEPTEMBER, 2022	DWG. NO. M-D-207
SHEET : 189 OF 247 SHEETS	

M:\PRJ\219-000\219-076 DOT A EWA DH ROADWAY\DRAWINGS\HNL 2ND LEVEL - MECHANICAL PLANS DH.DWG

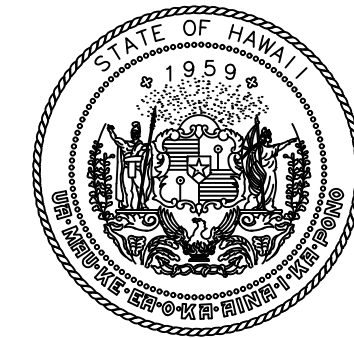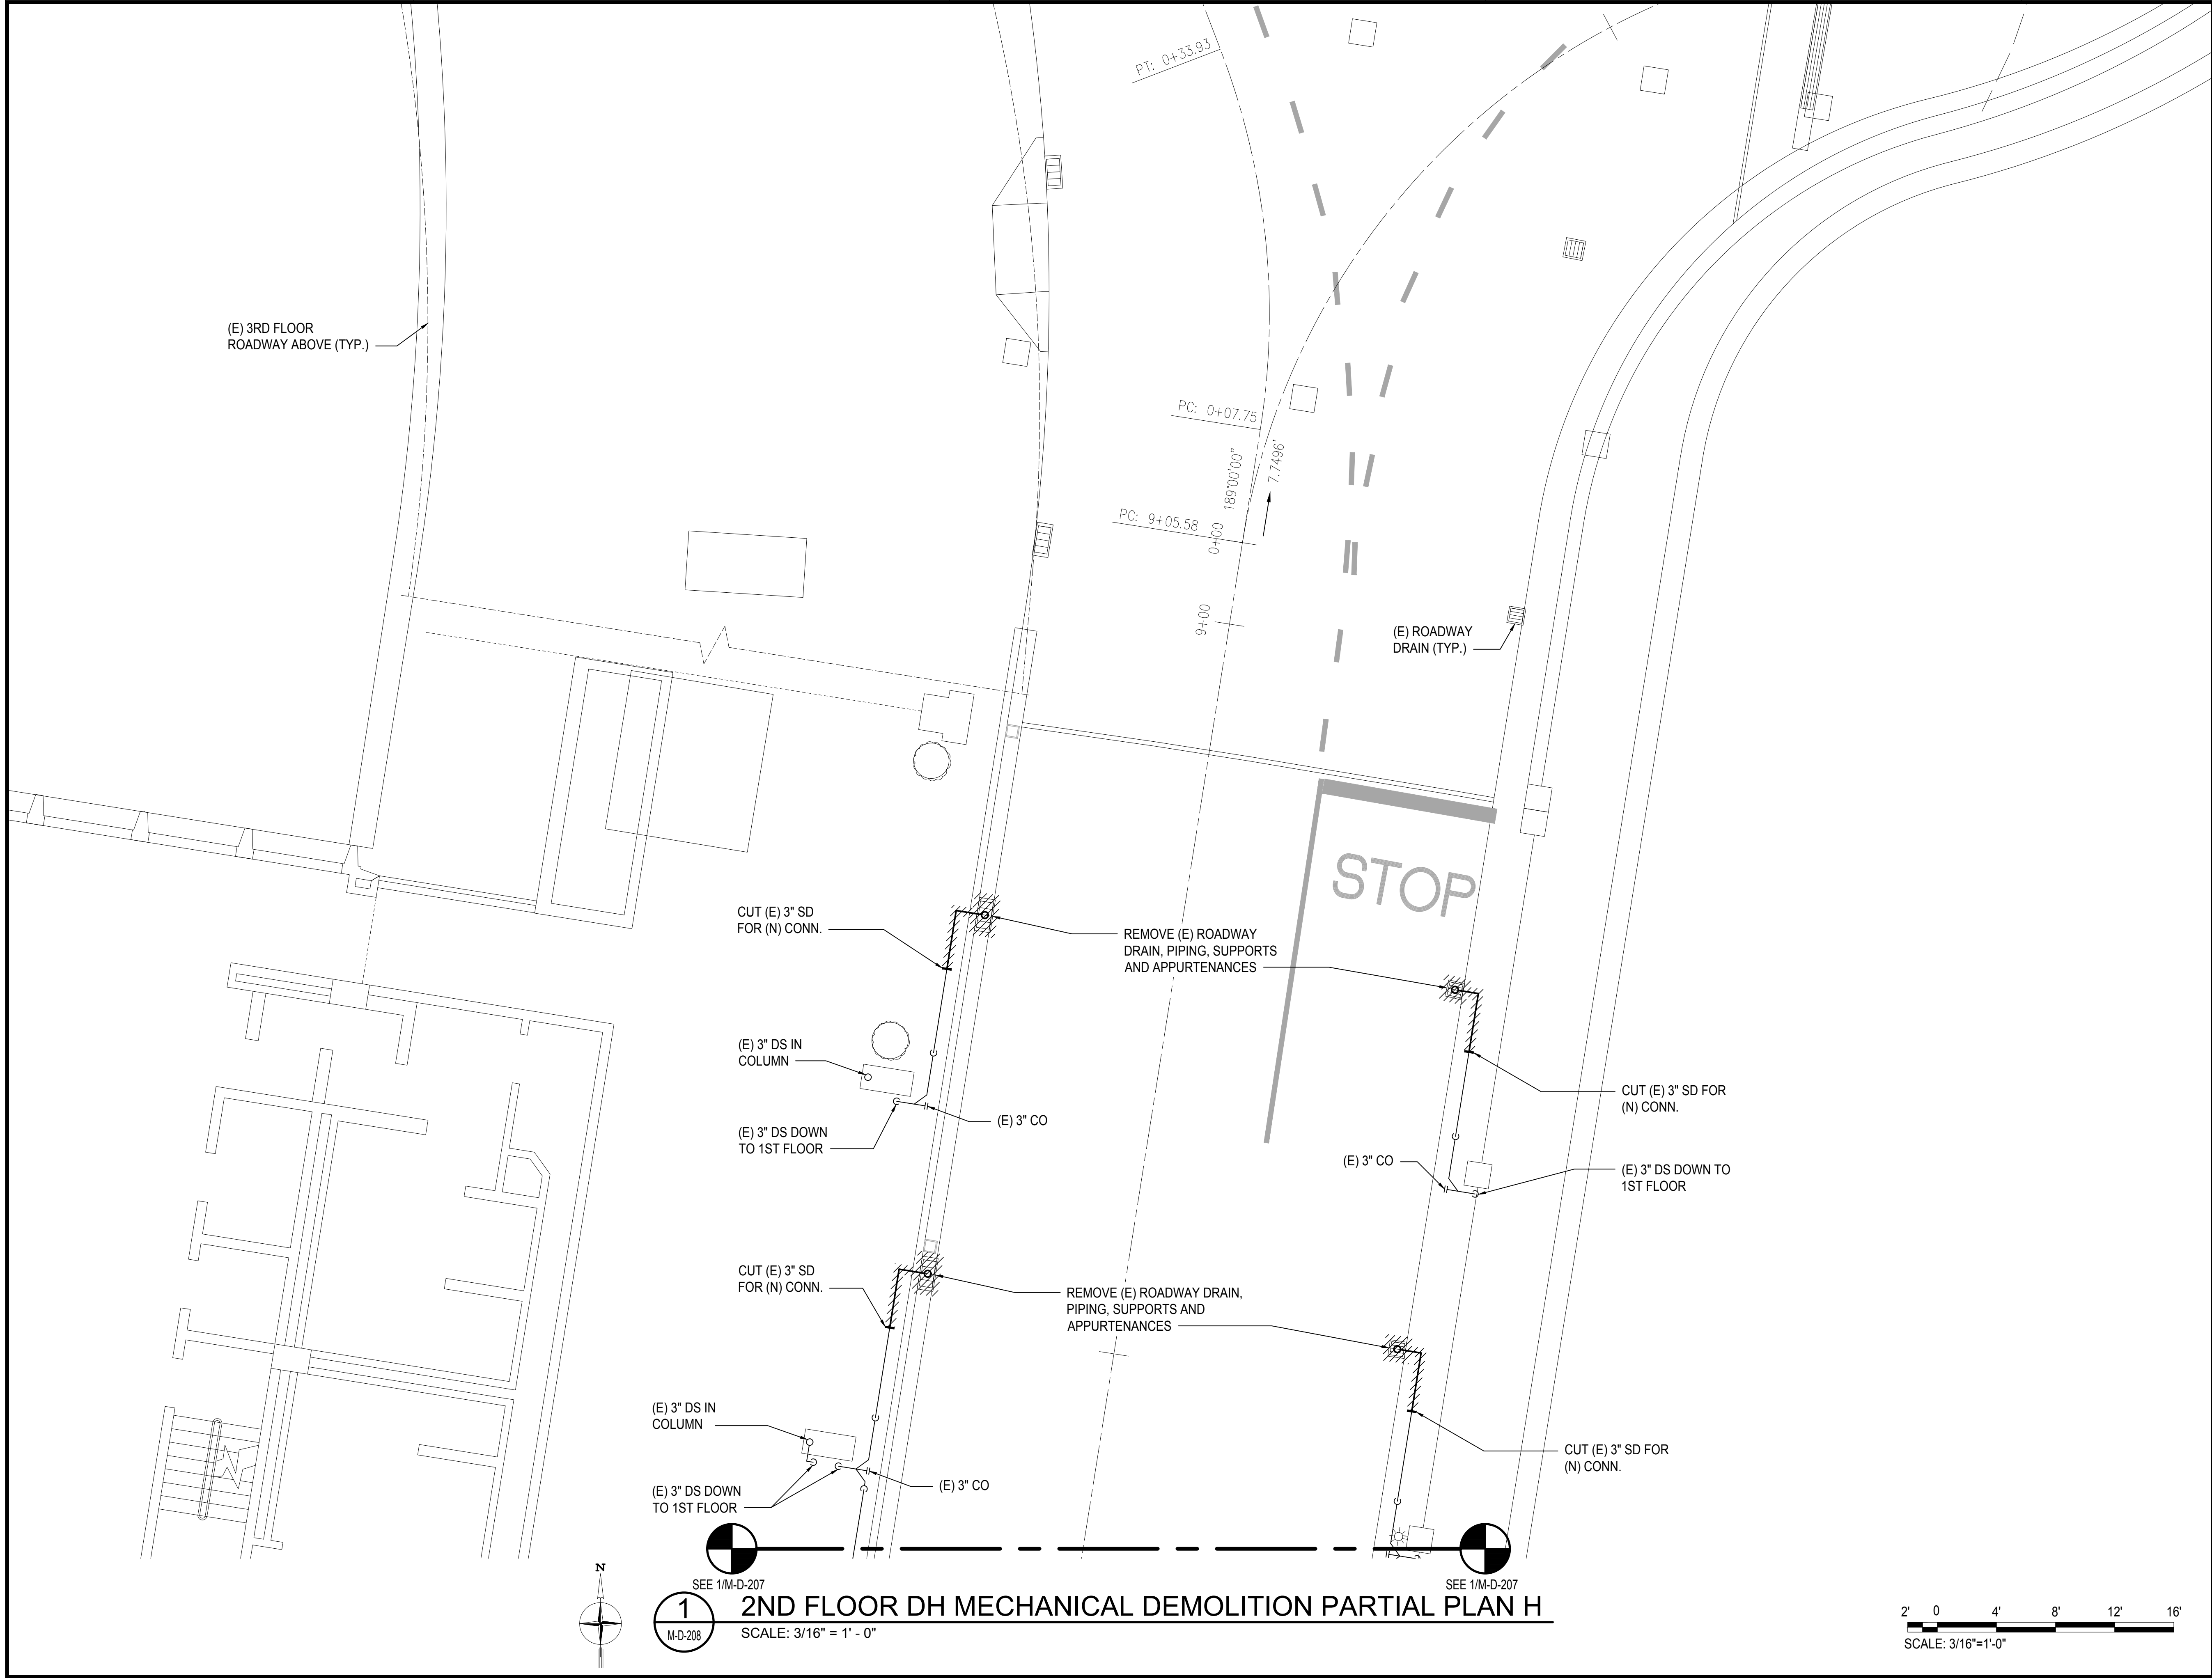

Airports Division  
DEPARTMENT OF TRANSPORTATION  
STATE OF HAWAII

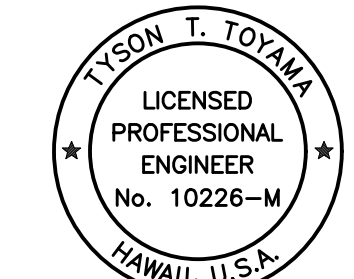


THIS WORK WAS PREPARED BY ME OR UNDER MY SUPERVISION  
AND CONSTRUCTION OF THIS PROJECT WILL BE UNDER MY  
OBSERVATION.

SIGNATURE: *Tyson T. Toyama* EXPIRATION DATE OF THE LICENSE: 04/30/2024

DSGN.	DRWN.	CHKD.	APPD.
JS/KT	KT/TJ	TTT	TTT

### KEY PLAN / NOTES:

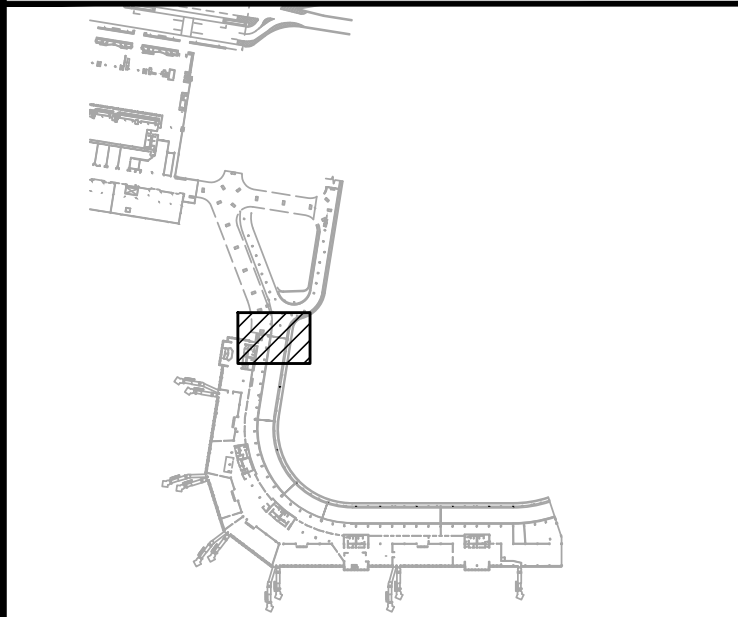

NO.	DATE	REVISIONS

## CONSTRUCTION DOCUMENTS

SEPTEMBER, 2022  
DATE

### PROJECT TITLE :

**EWA AND DH CONCOURSE  
ROADWAY IMPROVEMENTS  
PHASE 1**

AT  
DANIEL K. INOUE INTERNATIONAL AIRPORT  
HONOLULU, OAHU, HAWAII

### PROJECT NO.:

**AO1043-32**

### SHEET TITLE:

## 2ND FLOOR DH MECHANICAL DEMOLITION PARTIAL PLAN H

DATE :	DWG. NO.
SEPTEMBER, 2022	<b>M-D-208</b>
SHEET :	
190 OF 247 SHEETS	