 



1
M-E-301

3RD FLOOR EWA MECHANICAL DEMOLITION PARTIAL PLAN A


SCALE: 3/16" = 1' - 0"



SCALE: 3/16"=1'-0"

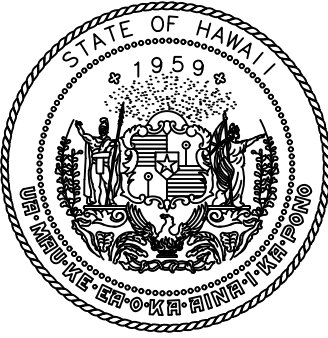

Airports Division
DEPARTMENT OF TRANSPORTATION
STATE OF HAWAII

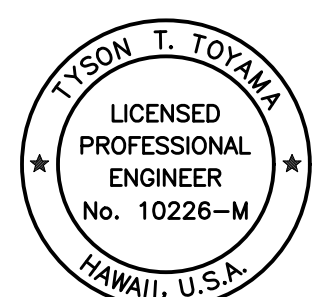


THIS WORK WAS PREPARED BY ME OR UNDER MY SUPERVISION
AND CONSTRUCTION OF THIS PROJECT WILL BE UNDER MY
OBSERVATION.

Tyson T. Toyama
SIGNATURE

04/30/2024
EXPIRATION DATE OF THE LICENSE

DSGN.	DRWN.	CHKD.	APPD.
JS/KT	KT/TJ	TTT	TTT

KEY PLAN / NOTES:

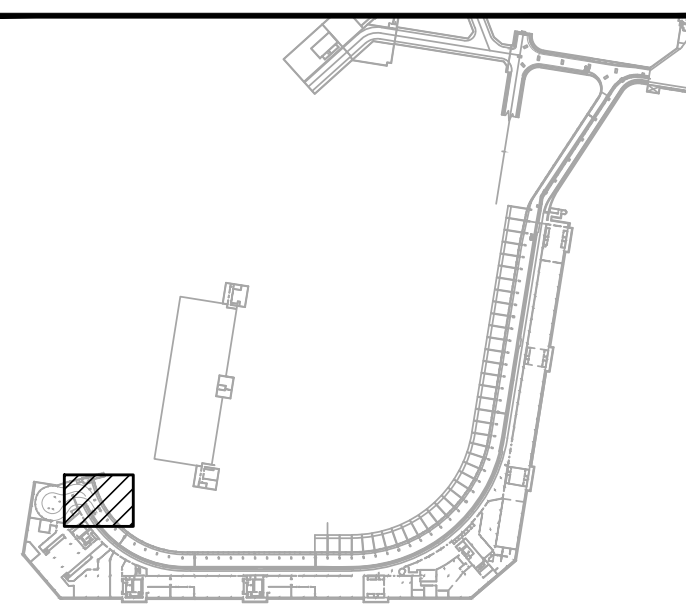

NO.	DATE	REVISIONS
-----	------	-----------

CONSTRUCTION DOCUMENTS

SEPTEMBER, 2022
DATE

PROJECT TITLE :

EWA AND DH CONCOURSE
ROADWAY IMPROVEMENTS
PHASE 1

AT
DANIEL K. INOUE INTERNATIONAL AIRPORT
HONOLULU, OAHU, HAWAII

PROJECT NO.:

AO1043-32

SHEET TITLE:

3RD FLOOR EWA
MECHANICAL DEMOLITION
PARTIAL PLAN A

DATE :

SEPTEMBER, 2022

SHEET :

157 OF 247 SHEETS

DWG. NO.

M-E-301

M:\PRC\219-000\219-076.DWG EWA DH ROADWAY DRAWINGS\HNL 3RD LEVEL - MECHANICAL PLANS.DWG

SEE 1/M-E-301

SEE 1/M-E-301

REMOVE (E) ROADWAY DRAIN,
DRAIN PAN, PIPING, SUPPORTS
AND APPURTENANCES

CUT (E) 4" SD FOR (N) CONN.

(E) 4" DS IN
COLUMN

CUT (E) 4" SD FOR (N) CONN.

REMOVE (E) ROADWAY DRAIN,
DRAIN PAN, PIPING, SUPPORTS
AND APPURTENANCES

CUT (E) 4" SD FOR (N) CONN.

REMOVE (E) ROADWAY DRAIN,
DRAIN PAN, PIPING, SUPPORTS
AND APPURTENANCES

(E) 4" DS IN
COLUMN

CUT (E) 4" SD FOR (N) CONN.

REMOVE (E) ROADWAY DRAIN,
DRAIN PAN, PIPING, SUPPORTS
AND APPURTENANCES

(E) 4" DS IN
COLUMN


CUT (E) 4" SD FOR (N) CONN.

REMOVE (E) ROADWAY DRAIN,
DRAIN PAN, PIPING, SUPPORTS
AND APPURTENANCES

(E) 4" DS IN
COLUMN

SEE
1/M-E-303

SEE
1/M-E-303

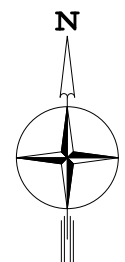


1
M-E-302


3RD FLOOR EWA MECHANICAL DEMOLITION PARTIAL PLAN B

SCALE: 3/16" = 1' - 0"

2' 0 4' 8' 12' 16'
SCALE: 3/16"=1'-0"

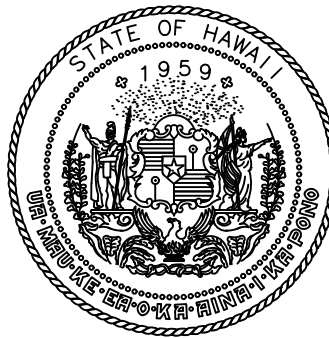

Airports Division
DEPARTMENT OF TRANSPORTATION
STATE OF HAWAII

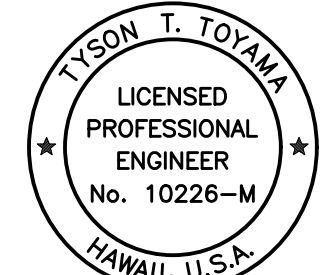


THIS WORK WAS PREPARED BY ME OR UNDER MY SUPERVISION
AND CONSTRUCTION OF THIS PROJECT WILL BE UNDER MY
OBSERVATION.

Tyson T. Toyama
SIGNATURE

04/30/2024
EXPIRATION DATE OF THE LICENSE

DSGN.	DRWN.	CHKD.	APPD.
JS/KT	KT/TJ	TTT	TTT

KEY PLAN / NOTES:

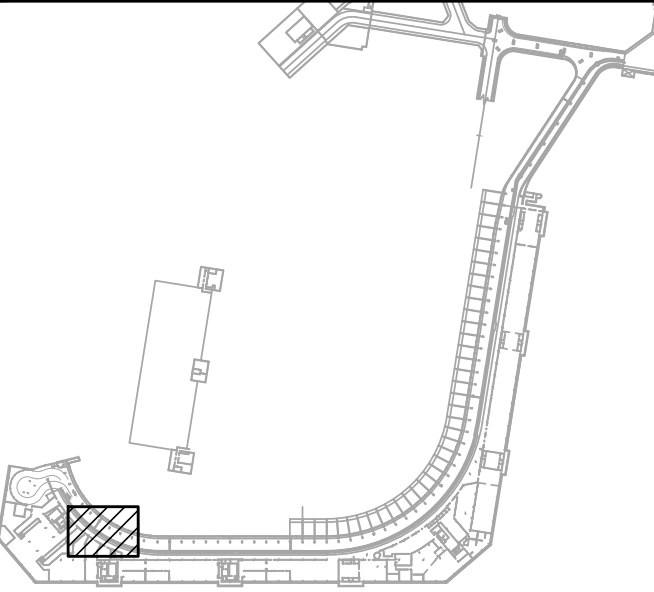

NO.	DATE	REVISIONS
-----	------	-----------

CONSTRUCTION DOCUMENTS

SEPTEMBER, 2022
DATE

PROJECT TITLE :

**EWA AND DH CONCOURSE
ROADWAY IMPROVEMENTS
PHASE 1**

AT
DANIEL K. INOUE INTERNATIONAL AIRPORT
HONOLULU, OAHU, HAWAII

PROJECT NO.:

AO1043-32

SHEET TITLE:

**3RD FLOOR EWA
MECHANICAL DEMOLITION
PARTIAL PLAN B**

DATE :



SEPTEMBER, 2022

SHEET :

158 OF 247 SHEETS

DWG. NO.

M-E-302

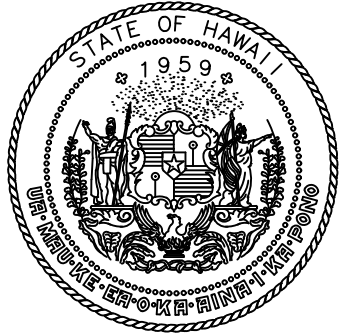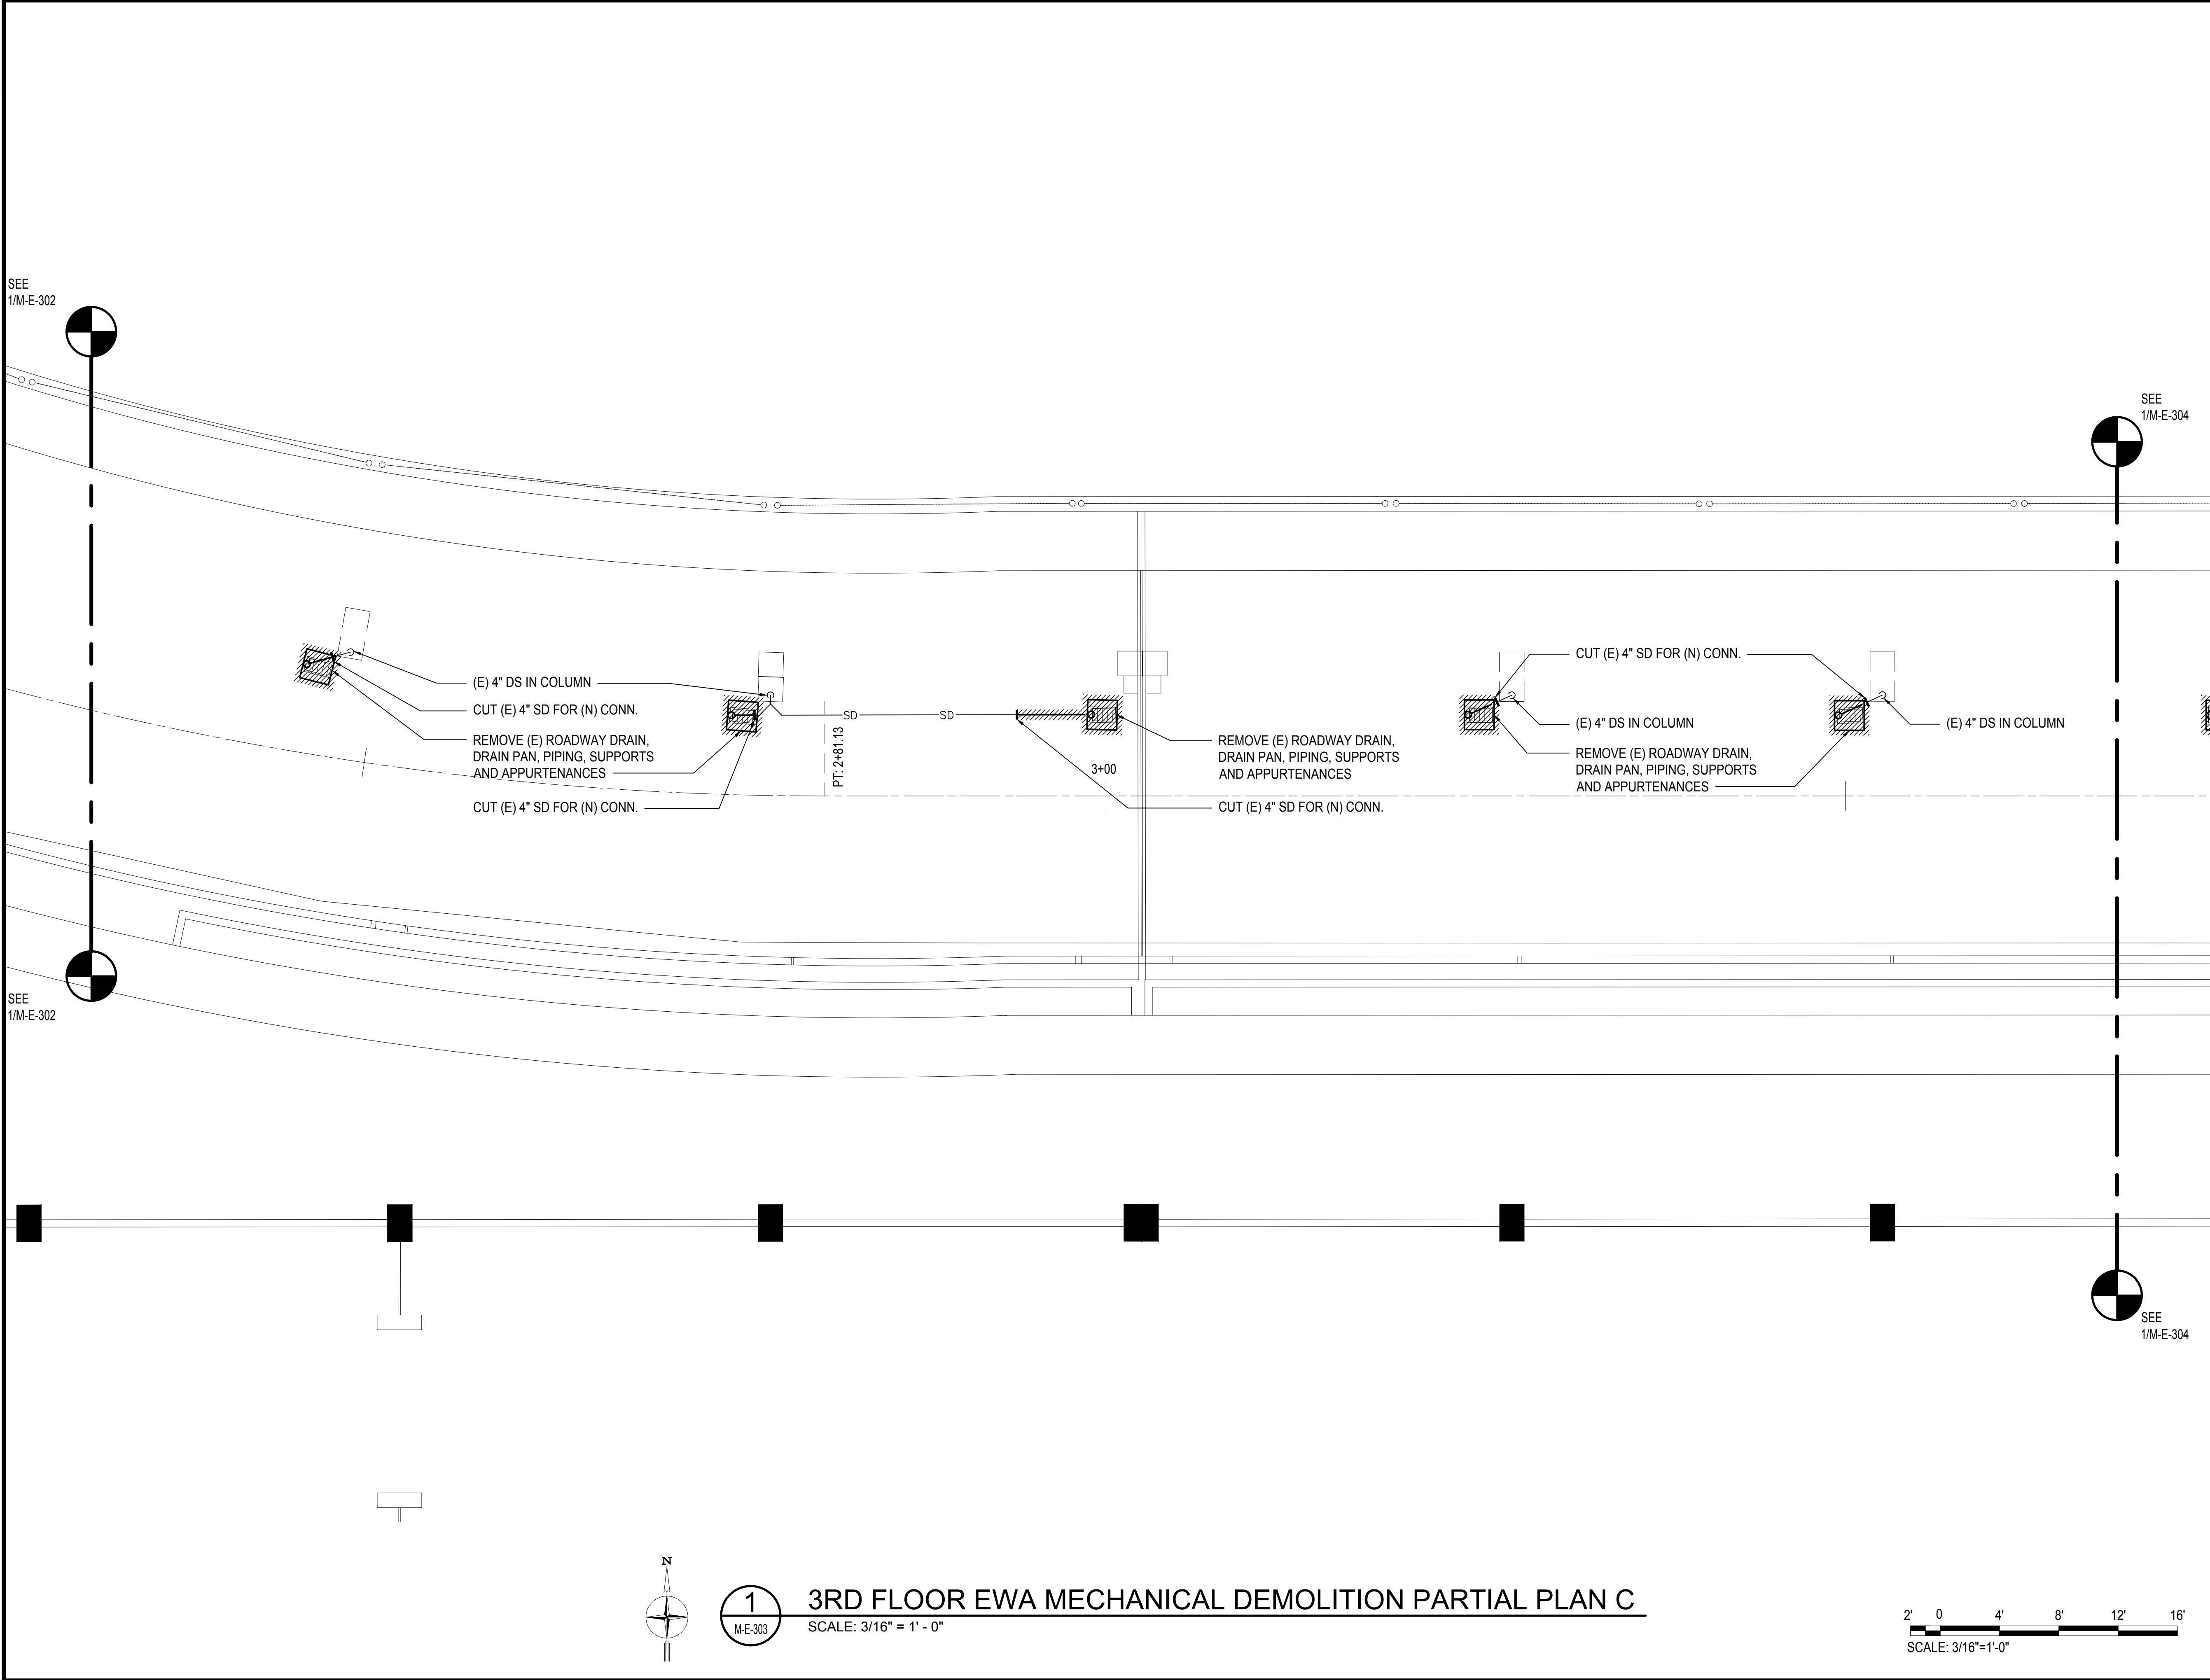

Airports Division
DEPARTMENT OF TRANSPORTATION
STATE OF HAWAII




THIS WORK WAS PREPARED BY ME OR UNDER MY SUPERVISION
AND CONSTRUCTION OF THIS PROJECT WILL BE UNDER MY
OBSERVATION.

Tyson T. Toyama
SIGNATURE

04/30/2024
EXPIRATION DATE OF THE LICENSE

DSGN.	DRWN.	CHKD.	APPD.
JS/KT	KT/TJ	TTT	TTT

KEY PLAN / NOTES:

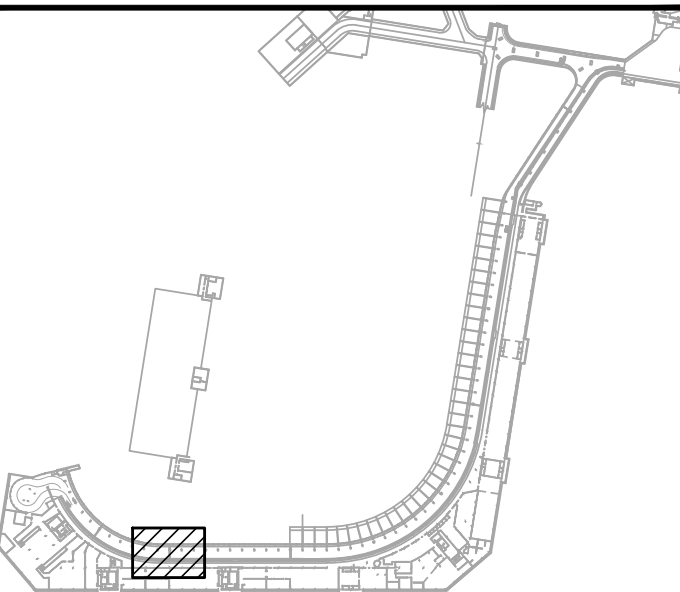

NO.	DATE	REVISIONS
-----	------	-----------

CONSTRUCTION
DOCUMENTS

SEPTEMBER, 2022
DATE

PROJECT TITLE :

EWA AND DH CONCOURSE
ROADWAY IMPROVEMENTS
PHASE 1

AT
DANIEL K. INOUE INTERNATIONAL AIRPORT
HONOLULU, OAHU, HAWAII

PROJECT NO.:

AO1043-32

SHEET TITLE:

3RD FLOOR EWA
MECHANICAL DEMOLITION
PARTIAL PLAN C

DATE :

 
SEPTEMBER, 2022

SHEET :

159 OF 247 SHEETS


DWG. NO.

M-E-303





3RD FLOOR EWA MECHANICAL DEMOLITION PARTIAL PLAN C

SCALE: 3/16" = 1' - 0"

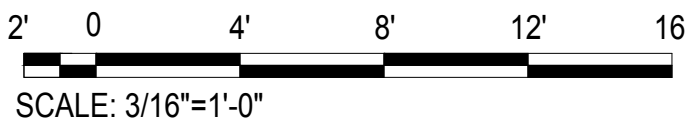


SCALE: 3/16"=1'-0"

M:\PROJECTS\2022\219-000\219-076 DOT A EWA DH ROADWAY\DRAWINGS\HNL 3RD LEVEL - MECHANICAL PLANS\DWG

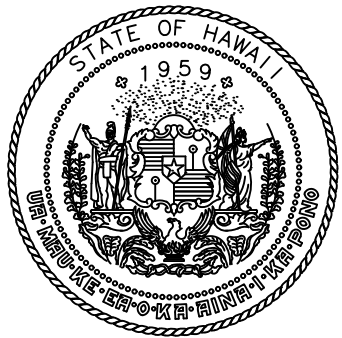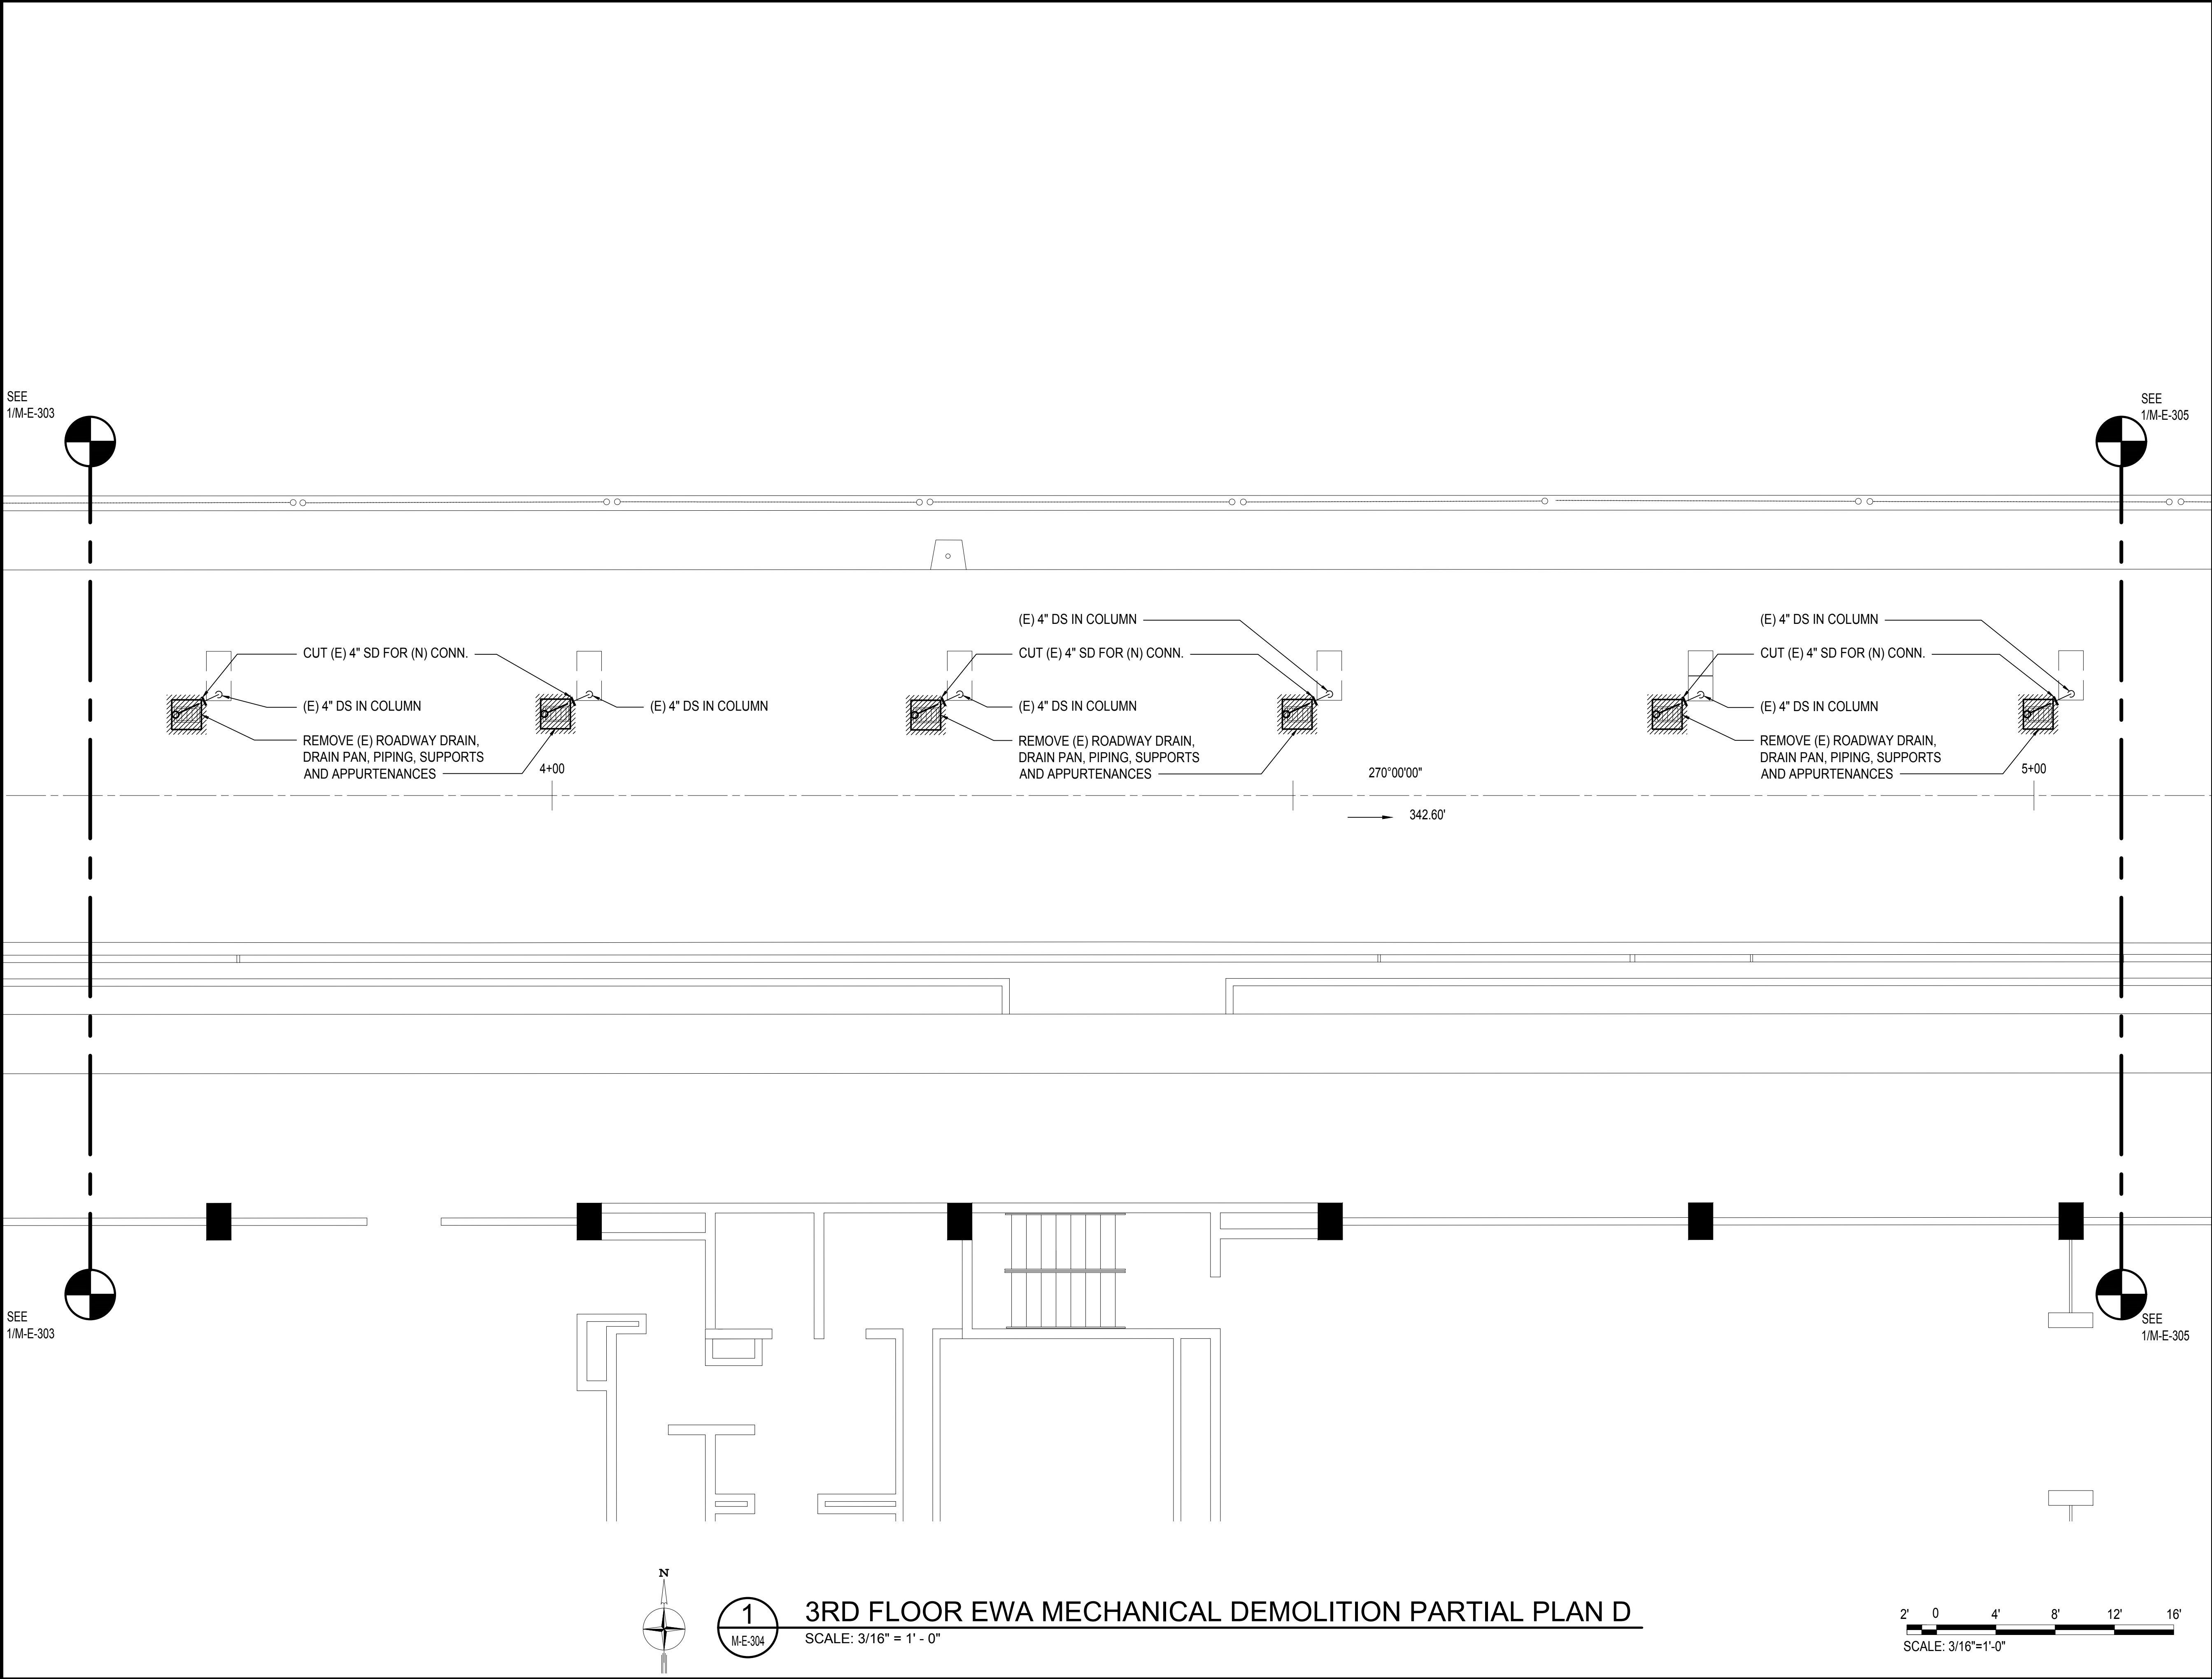

Airports Division
DEPARTMENT OF TRANSPORTATION
STATE OF HAWAII

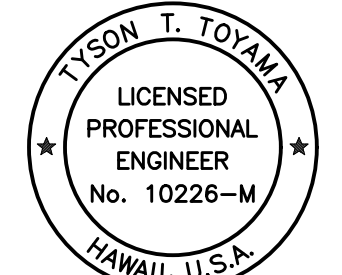


THIS WORK WAS PREPARED BY ME OR UNDER MY SUPERVISION AND CONSTRUCTION OF THIS PROJECT WILL BE UNDER MY OBSERVATION.

Tyson T. Toyama
SIGNATURE

04/30/2024
EXPIRATION DATE OF THE LICENSE

DSGN.	DRWN.	CHKD.	APPD.
JS/KT	KT/TJ	TTT	TTT

KEY PLAN / NOTES:

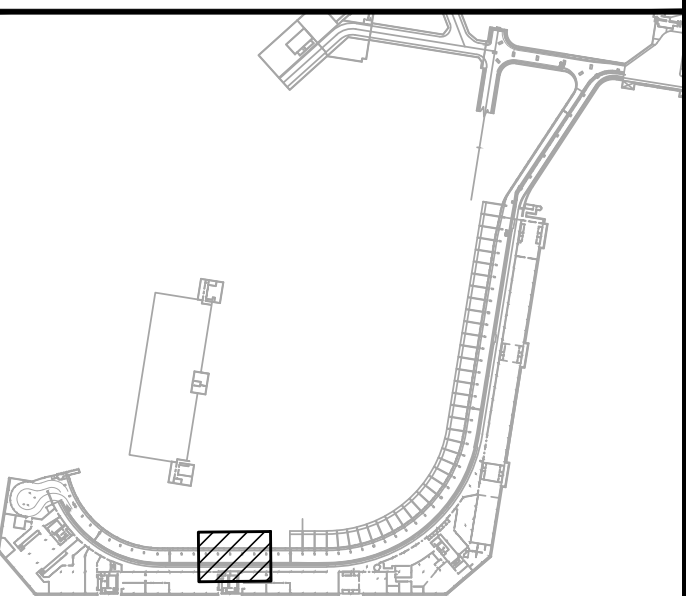

NO.	DATE	REVISIONS

CONSTRUCTION DOCUMENTS

SEPTEMBER, 2022
DATE

PROJECT TITLE :

EWA AND DH CONCOURSE
ROADWAY IMPROVEMENTS
PHASE 1

AT
DANIEL K. INOUE INTERNATIONAL AIRPORT
HONOLULU, OAHU, HAWAII



PROJECT NO.:

AO1043-32

SHEET TITLE:

3RD FLOOR EWA
MECHANICAL DEMOLITION
PARTIAL PLAN D

DATE :	DWG. NO.
SEPTEMBER, 2022	M-E-304
SHEET :	
160 OF 247 SHEETS	

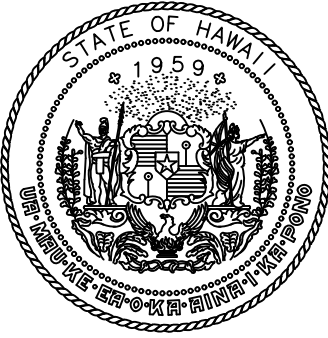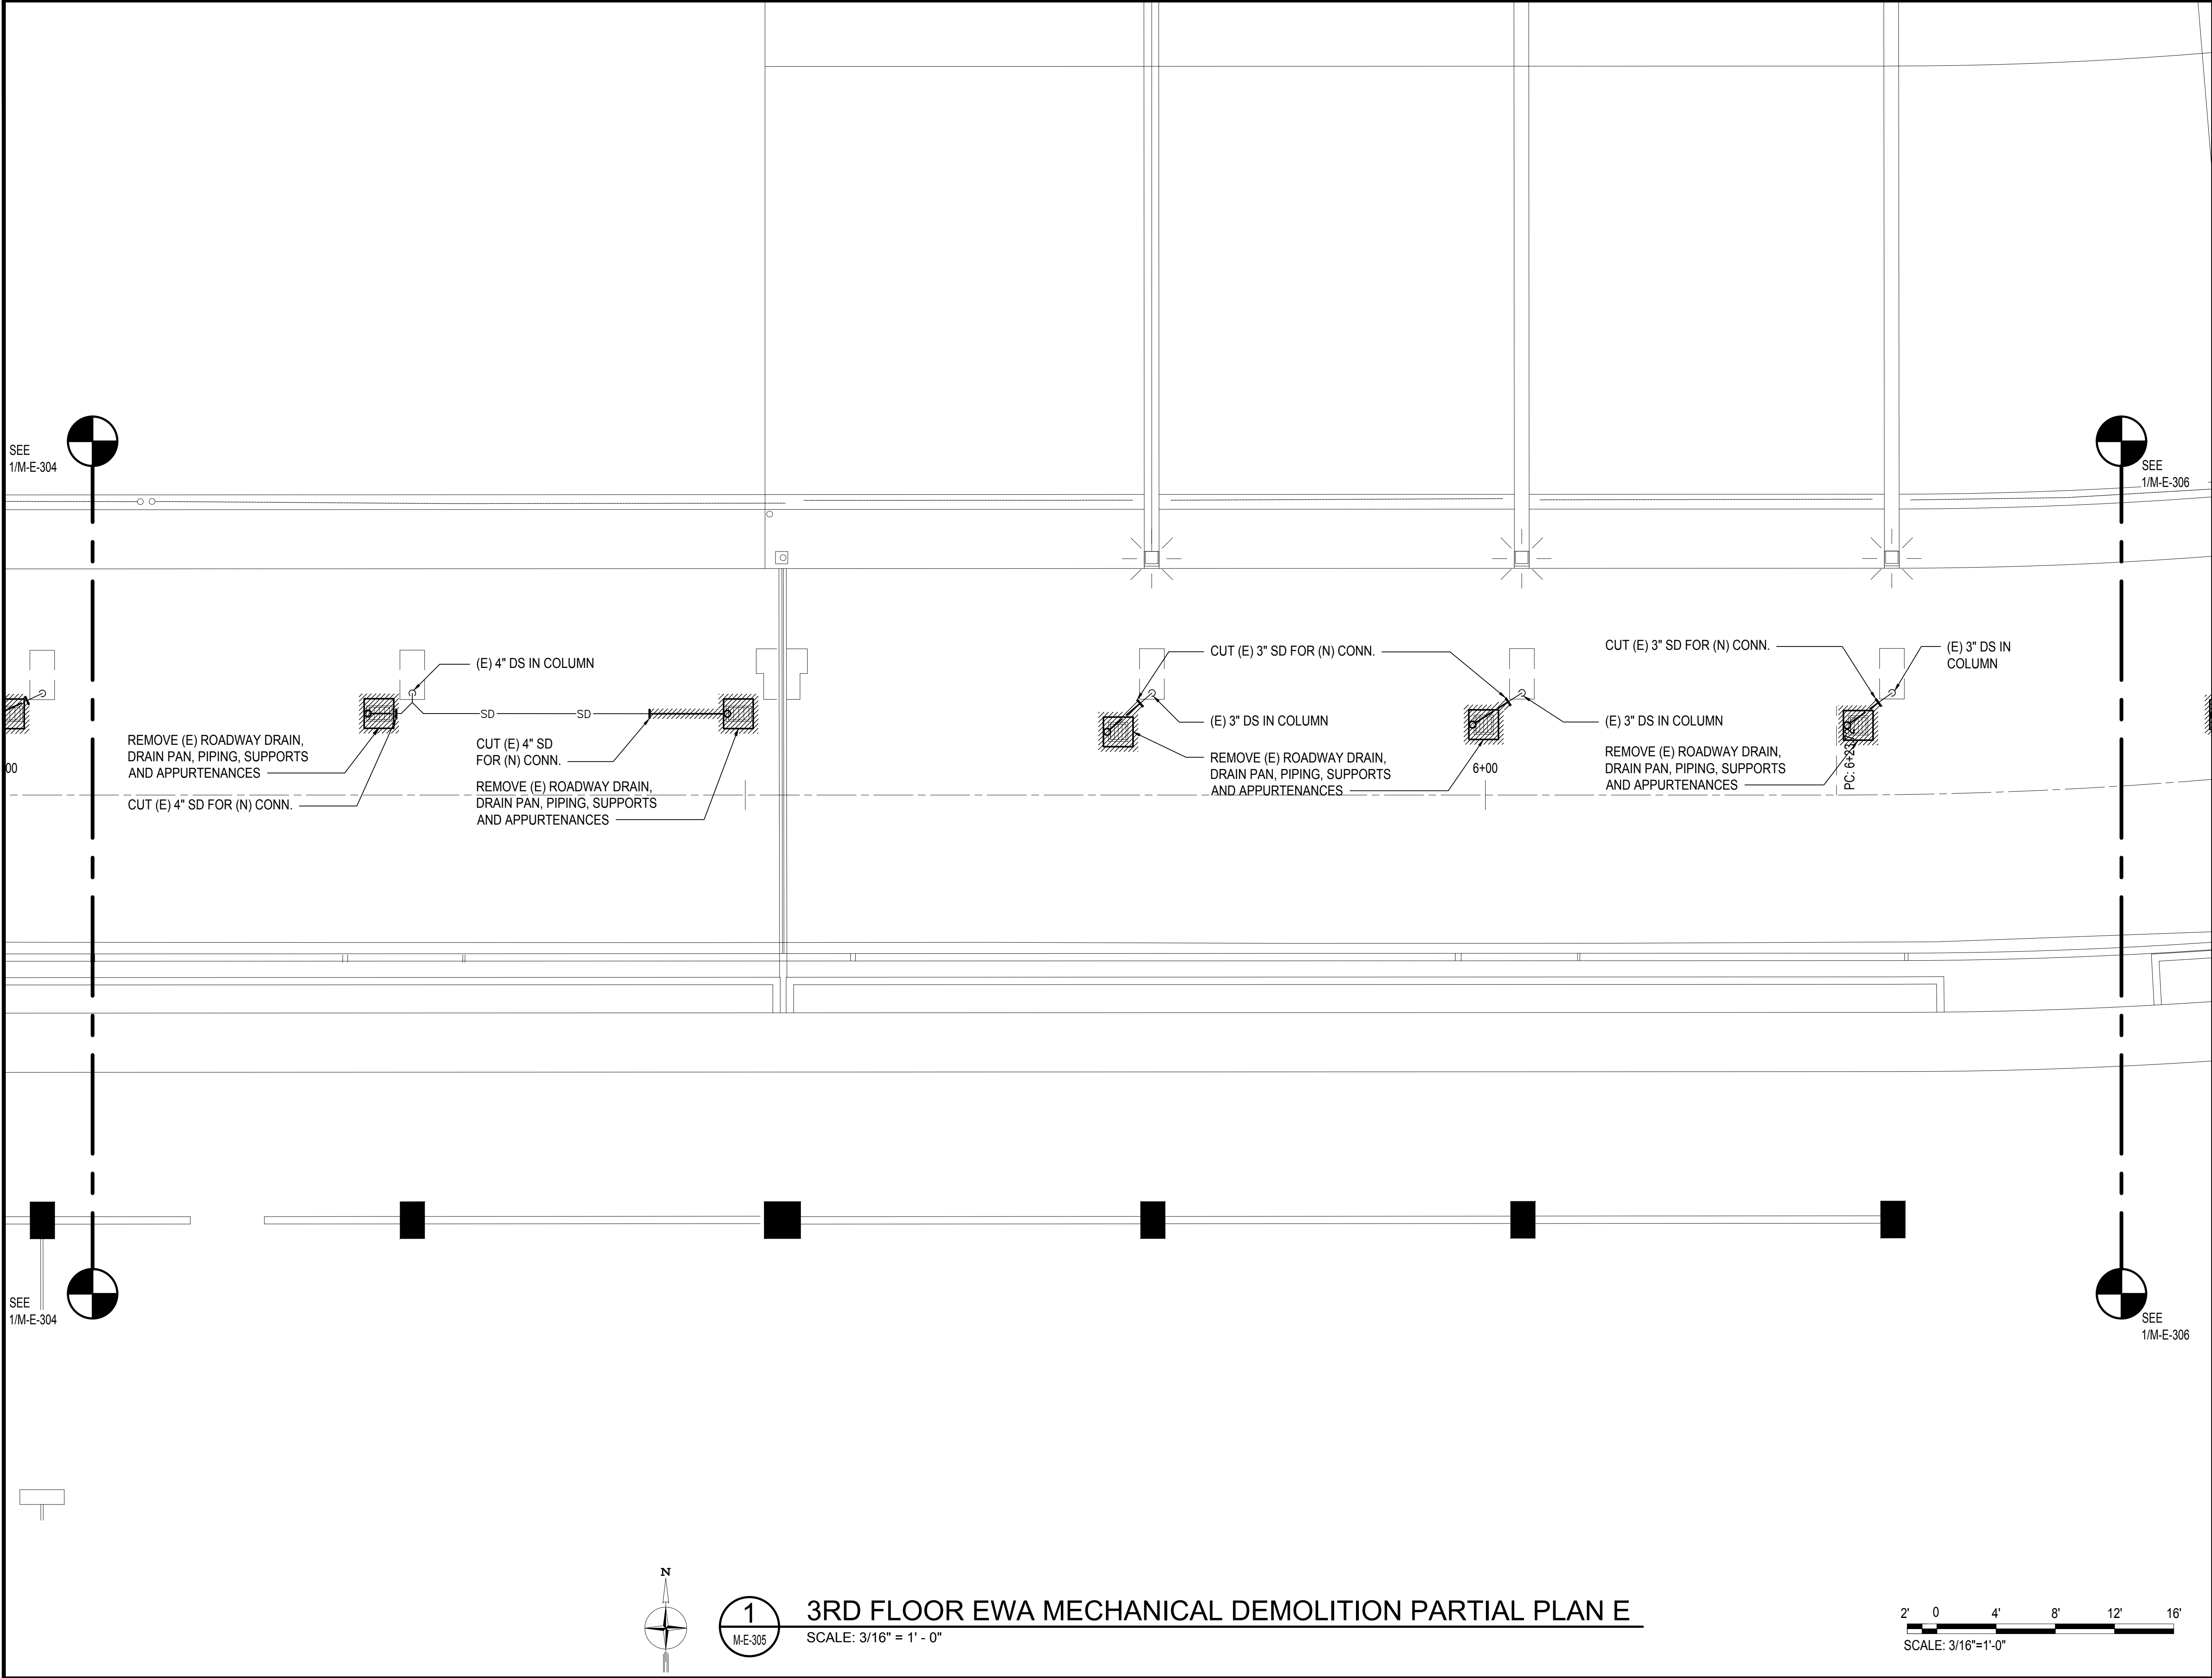

Airports Division
DEPARTMENT OF TRANSPORTATION
STATE OF HAWAII




THIS WORK WAS PREPARED BY ME OR UNDER MY SUPERVISION
AND CONSTRUCTION OF THIS PROJECT WILL BE UNDER MY
OBSERVATION.

Tyson T. Toyama
SIGNATURE

04/30/2024
EXPIRATION DATE OF THE LICENSE

DSGN.	DRWN.	CHKD.	APPD.
JS/KT	KT/TJ	TTT	TTT

KEY PLAN / NOTES:

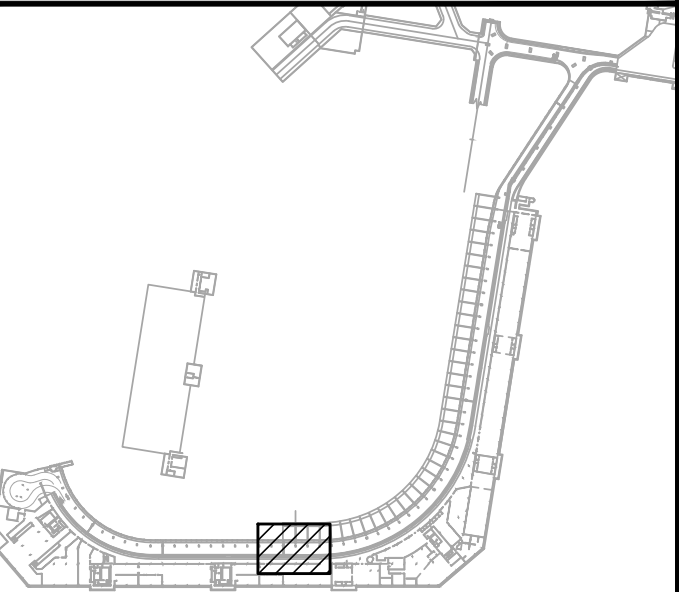

NO.	DATE	REVISIONS
-----	------	-----------

CONSTRUCTION DOCUMENTS
SEPTEMBER, 2022
DATE

PROJECT TITLE :
**EWA AND DH CONCOURSE
ROADWAY IMPROVEMENTS
PHASE 1**

AT
DANIEL K. INOUE INTERNATIONAL AIRPORT
HONOLULU, OAHU, HAWAII


PROJECT NO.:

AO1043-32

SHEET TITLE:


**3RD FLOOR EWA
MECHANICAL DEMOLITION
PARTIAL PLAN E**

DATE : SEPTEMBER, 2022	DWG. NO. M-E-305
SHEET : 161 OF 247 SHEETS	


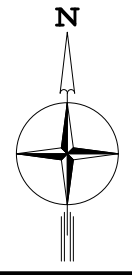


1
M-E-305

3RD FLOOR EWA MECHANICAL DEMOLITION PARTIAL PLAN E
SCALE: 3/16" = 1' - 0"

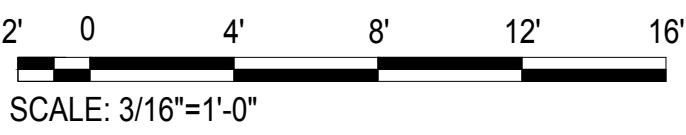

M:\PROJECTS\2019-2021\19-076 DOT A EWA DH ROADWAY\DRAWINGS\HNL 3RD LEVEL - MECHANICAL PLANS\DWG

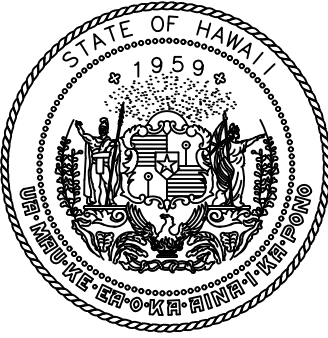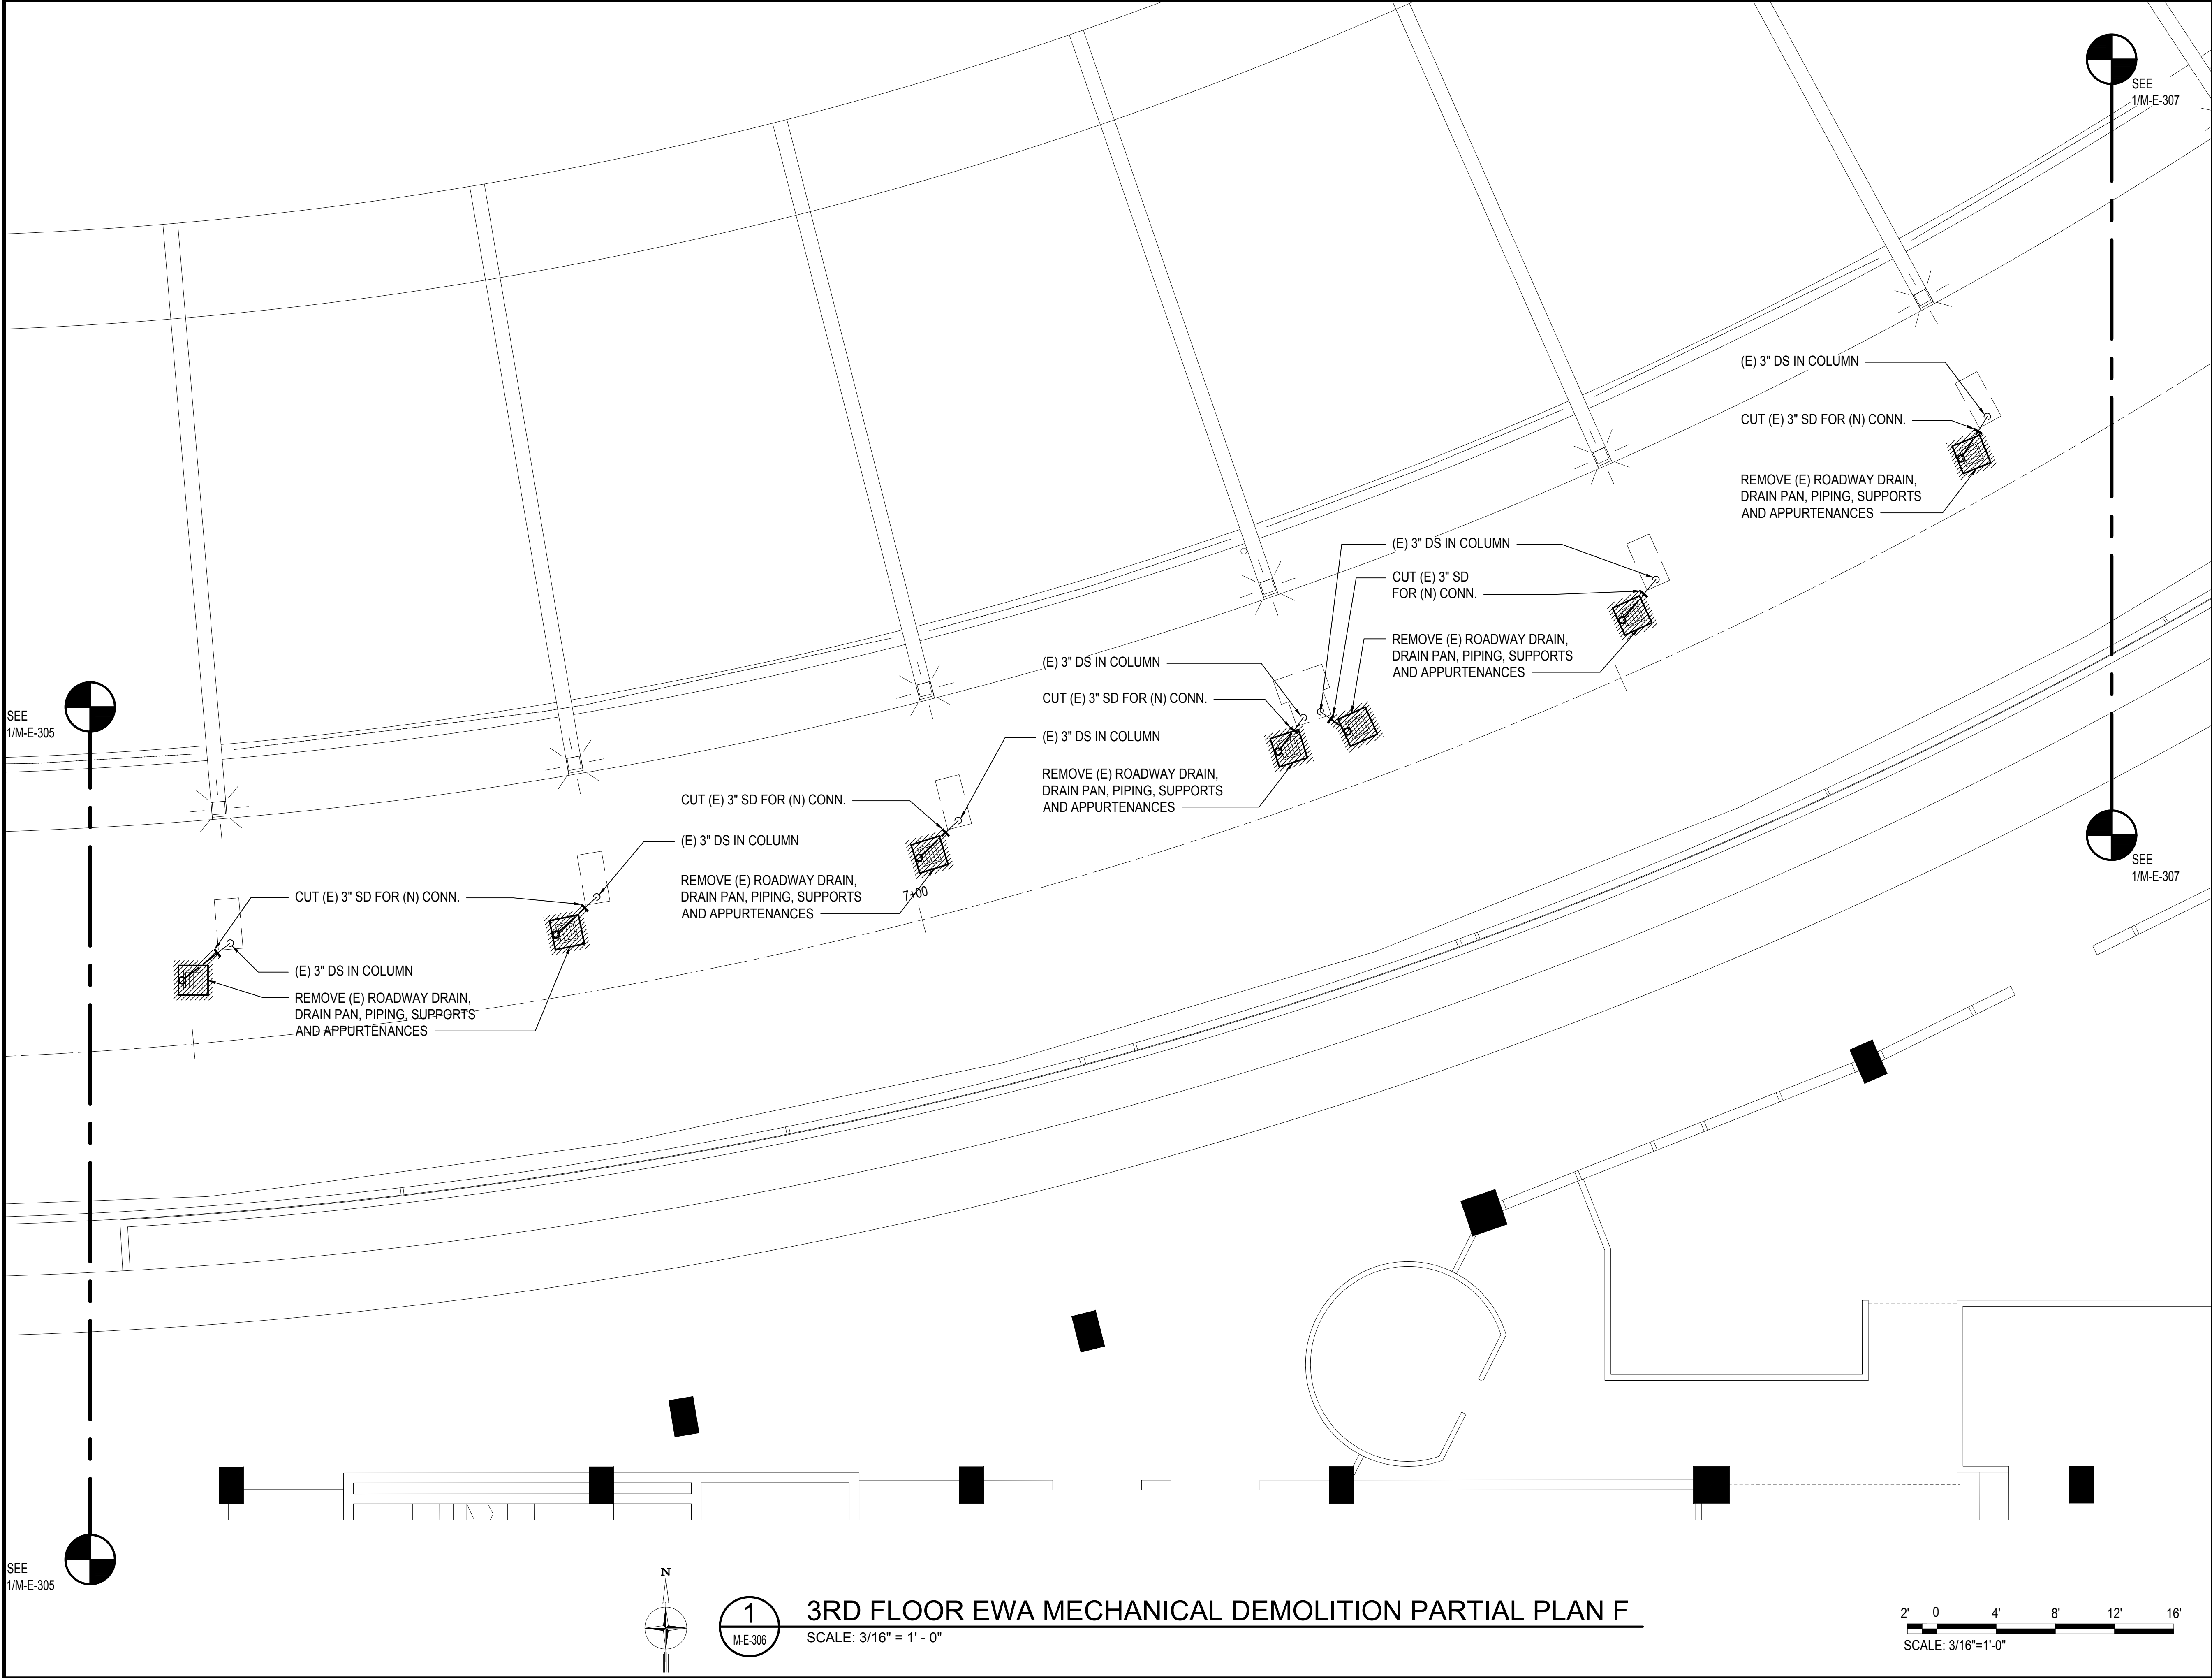

Airports Division
DEPARTMENT OF TRANSPORTATION
STATE OF HAWAII




THIS WORK WAS PREPARED BY ME OR UNDER MY SUPERVISION
AND CONSTRUCTION OF THIS PROJECT WILL BE UNDER MY
OBSERVATION.

Tyson T. Toyama
SIGNATURE
04/30/2024
EXPIRATION DATE OF THE LICENSE

DSGN.	DRWN.	CHKD.	APPD.
JS/KT	KT/TJ	TTT	TTT

KEY PLAN / NOTES:

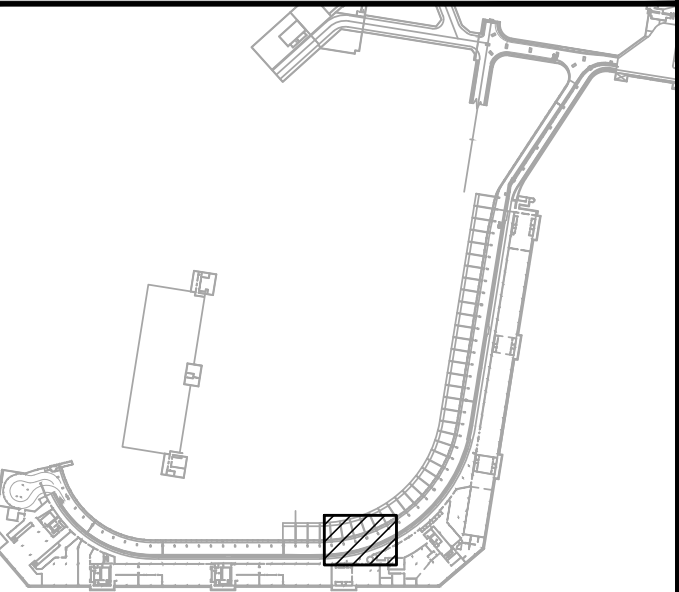

NO.	DATE	REVISIONS
-----	------	-----------

CONSTRUCTION DOCUMENTS
SEPTEMBER, 2022
DATE


PROJECT TITLE :
EWA AND DH CONCOURSE
ROADWAY IMPROVEMENTS
PHASE 1
AT
DANIEL K. INOUE INTERNATIONAL AIRPORT
HONOLULU, OAHU, HAWAII

PROJECT NO.:
AO1043-32

SHEET TITLE:


3RD FLOOR EWA
MECHANICAL DEMOLITION
PARTIAL PLAN F

DATE : SEPTEMBER, 2022	DWG. NO. M-E-306
SHEET : 162 OF 247 SHEETS	


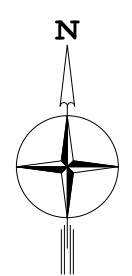


1
M-E-306


3RD FLOOR EWA MECHANICAL DEMOLITION PARTIAL PLAN F
SCALE: 3/16" = 1' - 0"

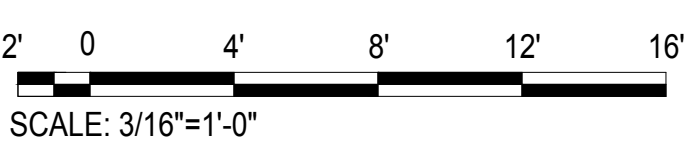

M:\PROJECTS\2020\2021\19-076 DOT A EWA DH ROADWAY DRAWINGS\SHL 3RD LEVEL - MECHANICAL PLANS.DWG

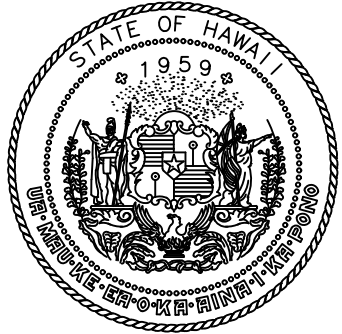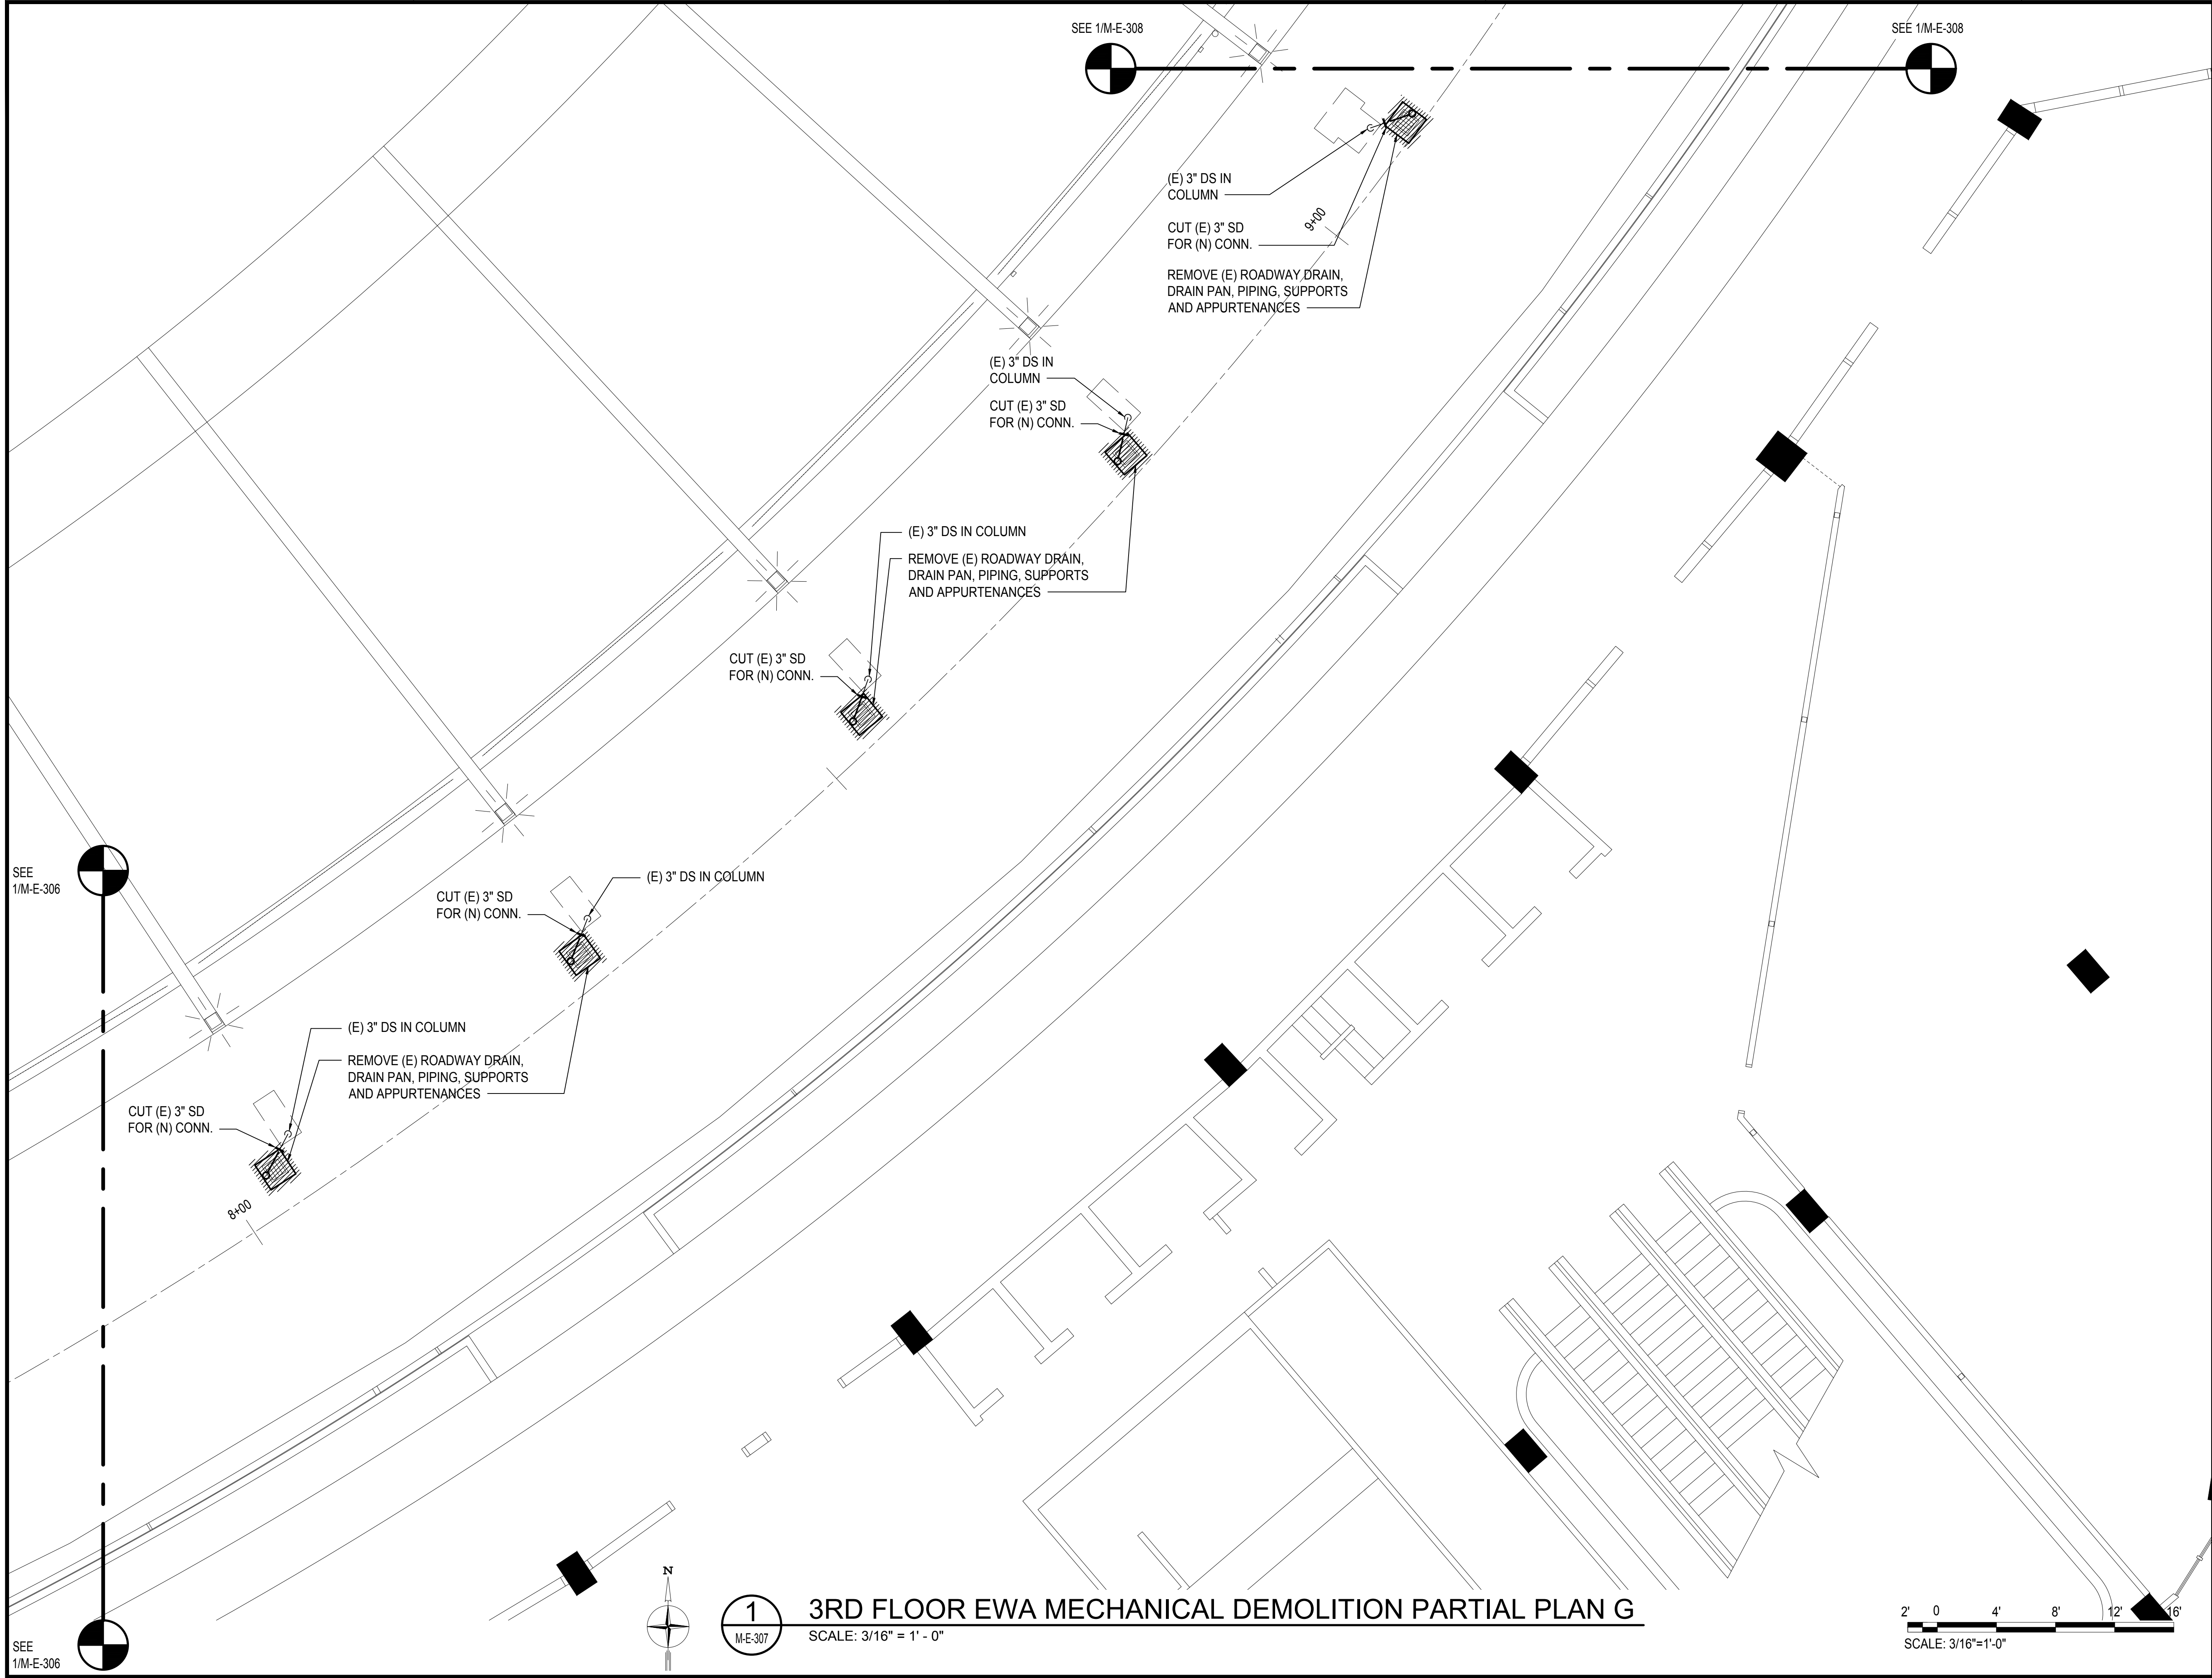

Airports Division
DEPARTMENT OF TRANSPORTATION
STATE OF HAWAII

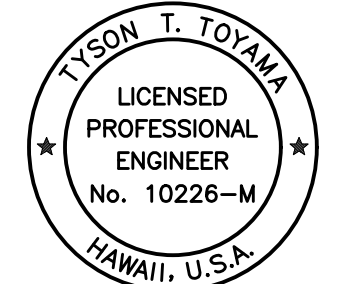


THIS WORK WAS PREPARED BY ME OR UNDER MY SUPERVISION
AND CONSTRUCTION OF THIS PROJECT WILL BE UNDER MY
OBSERVATION.

Tyson T. Toyama
SIGNATURE

04/30/2024
EXPIRATION DATE OF THE LICENSE

DSGN.	DRWN.	CHKD.	APPD.
JS/KT	KT/TJ	TTT	TTT

KEY PLAN / NOTES:

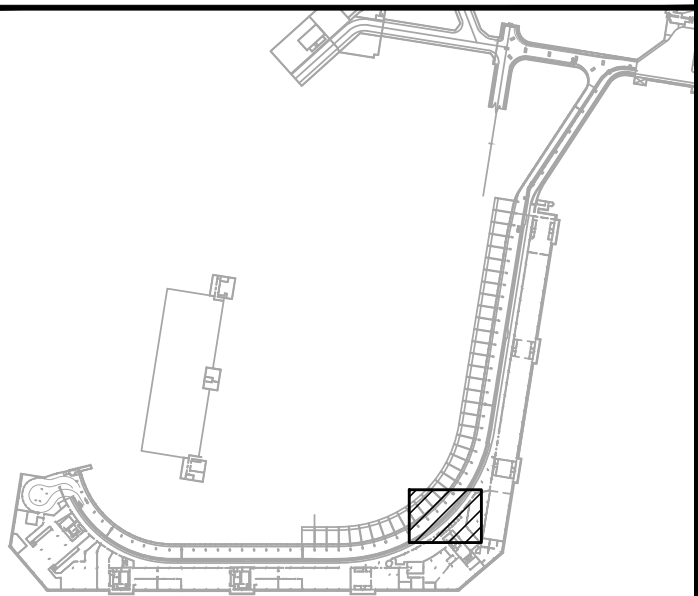

NO.	DATE	REVISIONS
-----	------	-----------

CONSTRUCTION
DOCUMENTS

SEPTEMBER, 2022
DATE

PROJECT TITLE :

EWA AND DH CONCOURSE
ROADWAY IMPROVEMENTS
PHASE 1

AT
DANIEL K. INOUE INTERNATIONAL AIRPORT
HONOLULU, OAHU, HAWAII

PROJECT NO.:

AO1043-32

SHEET TITLE:

3RD FLOOR EWA
MECHANICAL DEMOLITION
PARTIAL PLAN G



DATE :
SEPTEMBER, 2022
SHEET :

DWG. NO.


M-E-307

163 OF 247 SHEETS

M:\PROJECTS\2022\DOTA EWA DH ROADWAY\DRAWINGS\HNL 3RD LEVEL - MECHANICAL PLANS.DWG

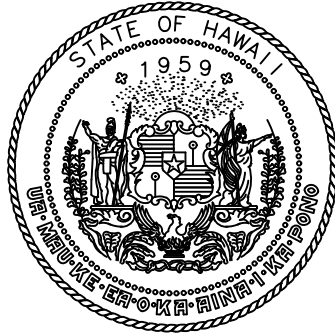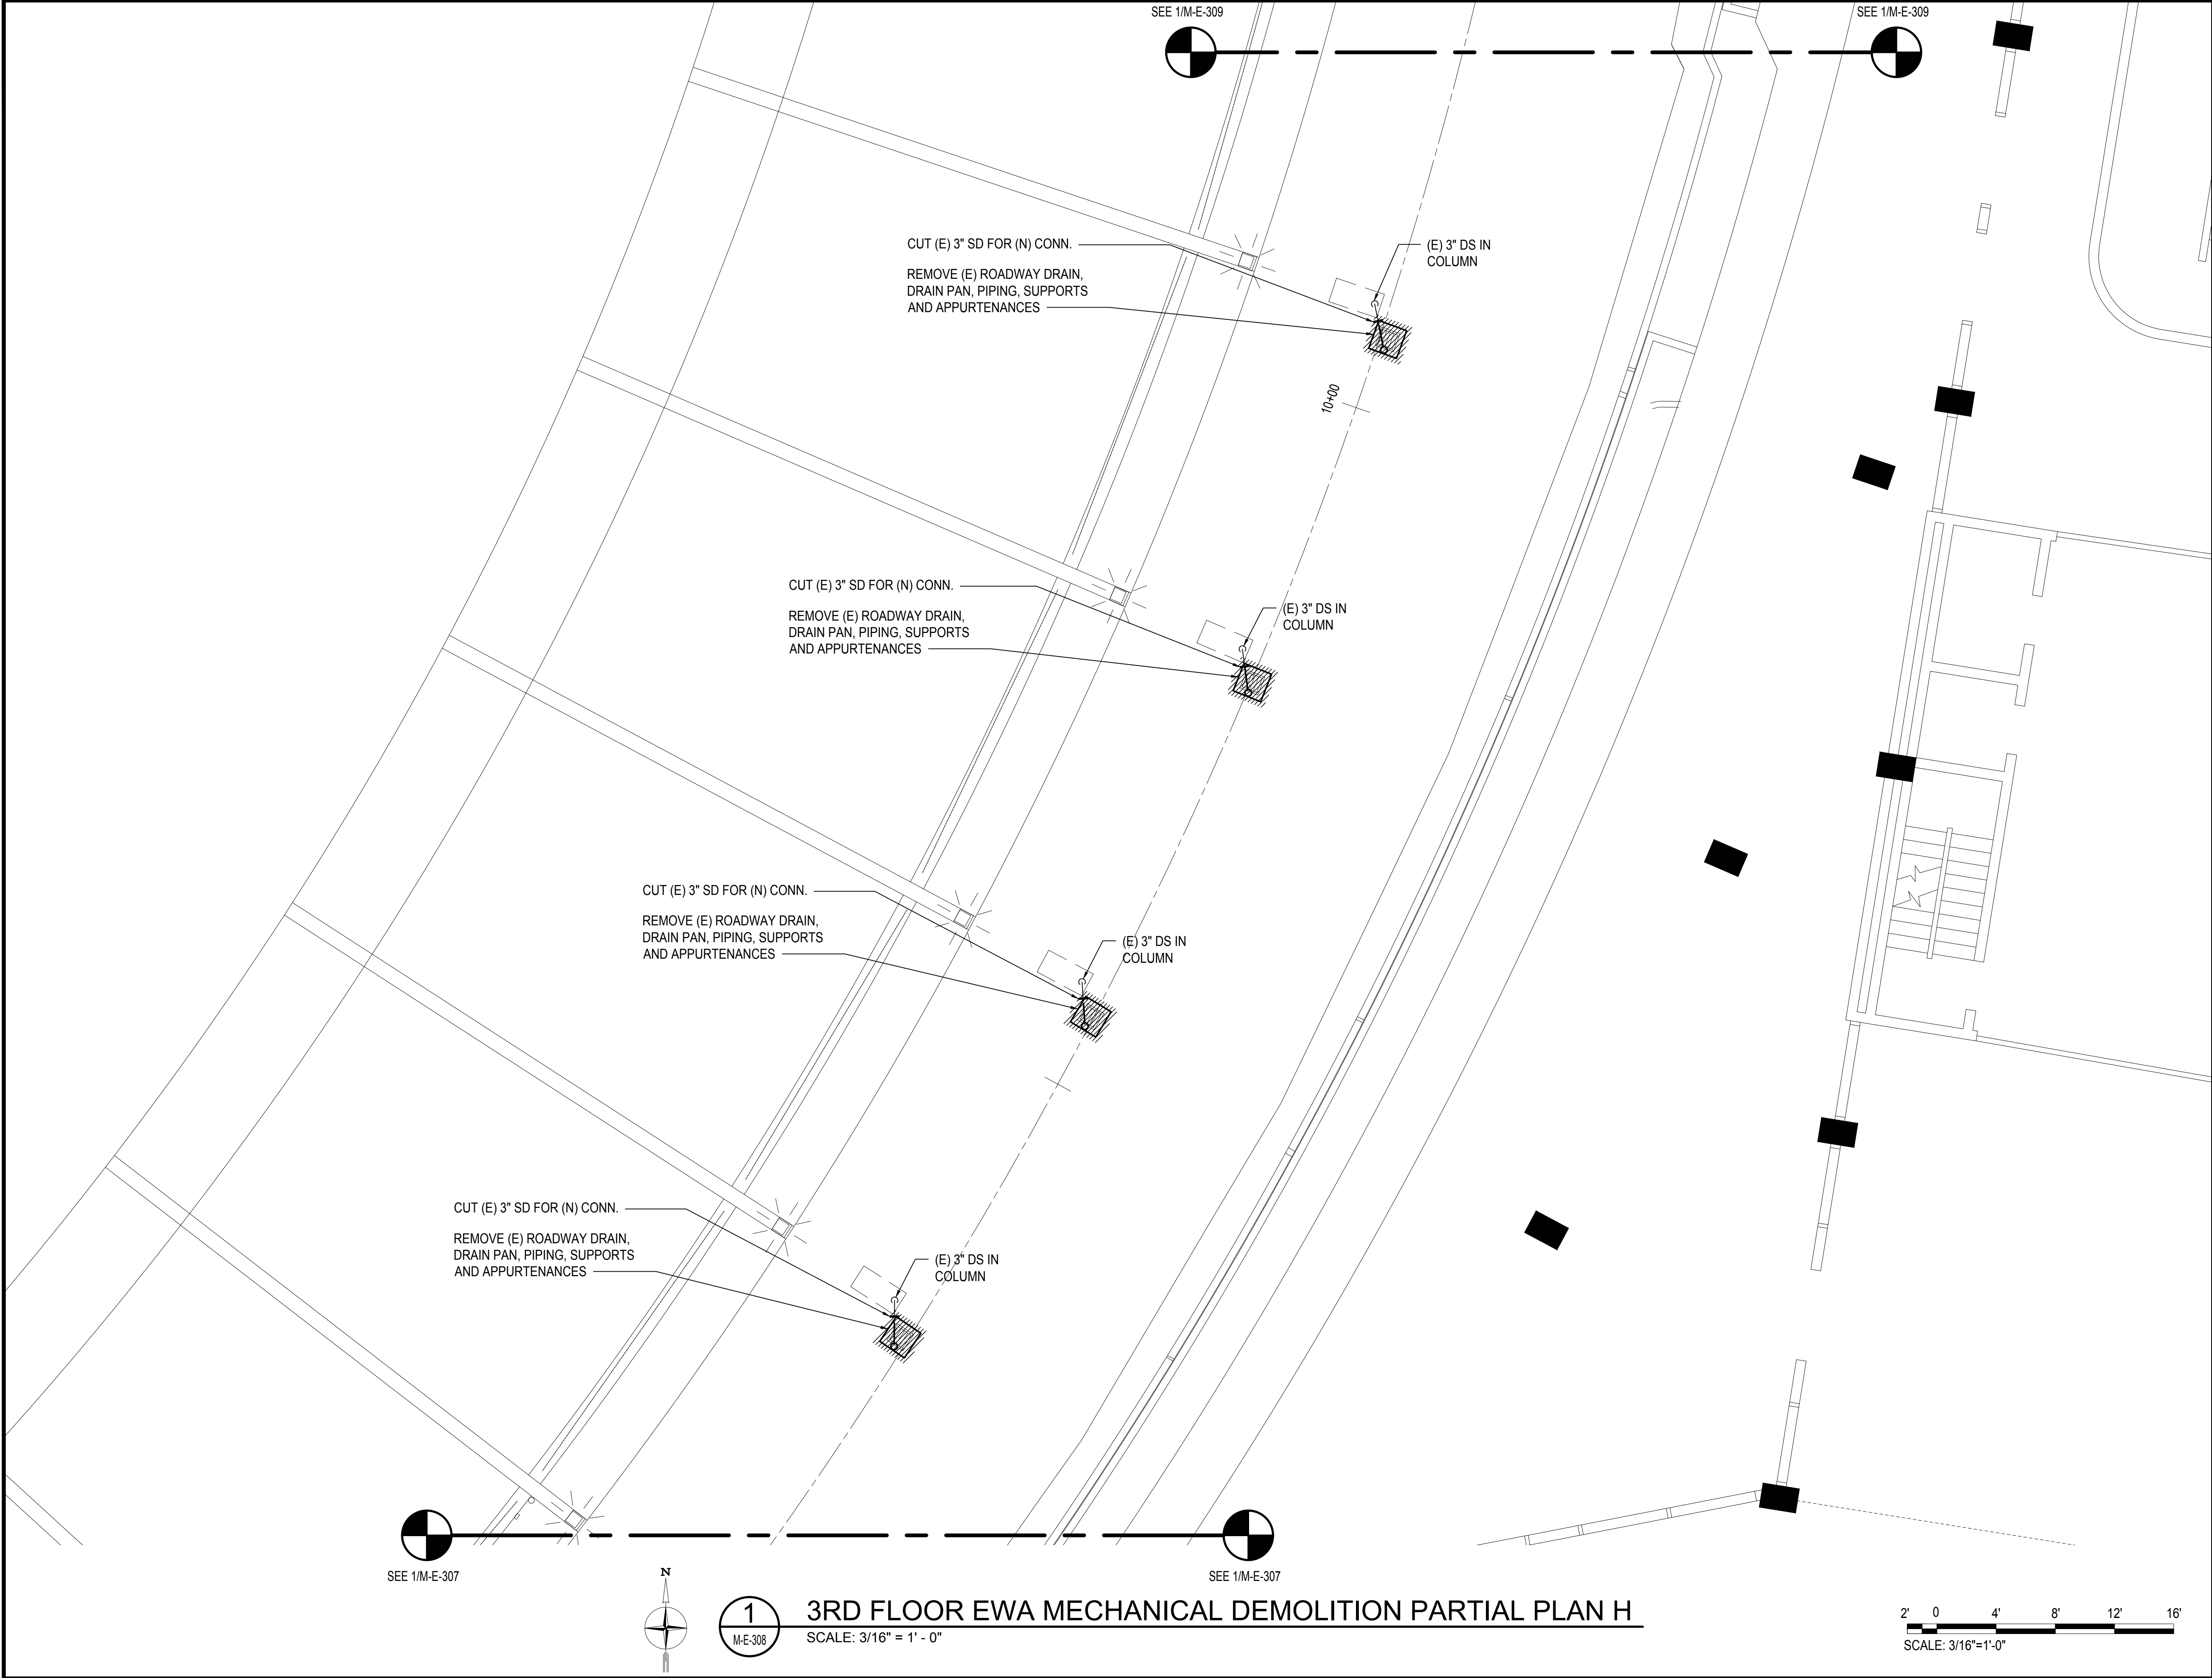

Airports Division
DEPARTMENT OF TRANSPORTATION
STATE OF HAWAII

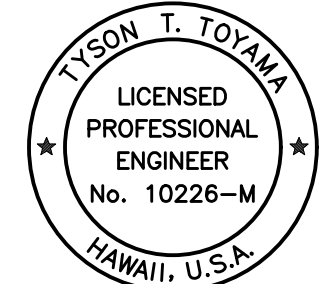


THIS WORK WAS PREPARED BY ME OR UNDER MY SUPERVISION
AND CONSTRUCTION OF THIS PROJECT WILL BE UNDER MY
OBSERVATION.

Tyson T. Toyama
SIGNATURE

04/30/2024
EXPIRATION DATE OF THE LICENSE

DSGN.	DRWN.	CHKD.	APPD.
JS/KT	KT/TJ	TTT	TTT

KEY PLAN / NOTES:

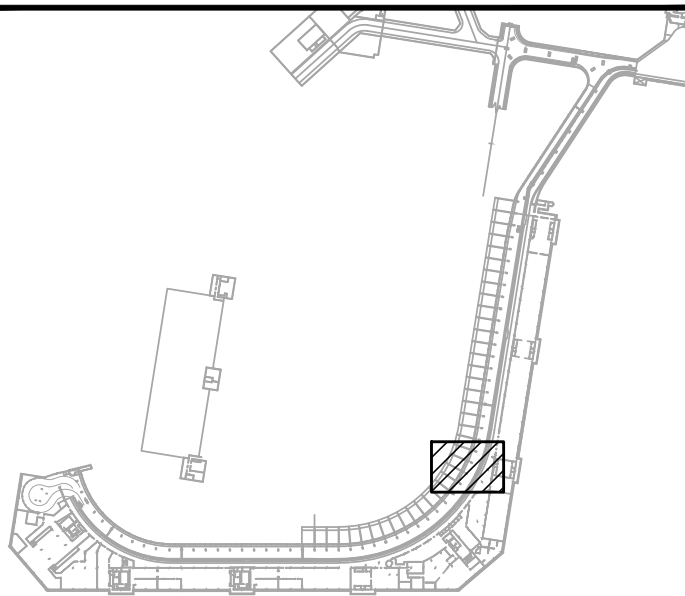

NO.	DATE	REVISIONS
-----	------	-----------

CONSTRUCTION
DOCUMENTS

SEPTEMBER, 2022
DATE

PROJECT TITLE :

EWA AND DH CONCOURSE
ROADWAY IMPROVEMENTS
PHASE 1

AT
DANIEL K. INOUE INTERNATIONAL AIRPORT
HONOLULU, OAHU, HAWAII

PROJECT NO.:

AO1043-32

SHEET TITLE:

3RD FLOOR EWA
MECHANICAL DEMOLITION
PARTIAL PLAN H

DATE :

SEPTEMBER, 2022



SHEET :

164 OF 247 SHEETS

DWG. NO.

M-E-308

M:\PROJECTS\2019-000219\076 DOTA EWA DH ROADWAY\DRAWINGS\HNL 3RD LEVEL - MECHANICAL PLANS.DWG

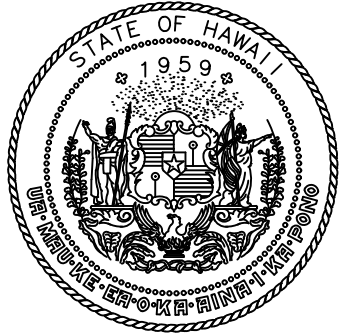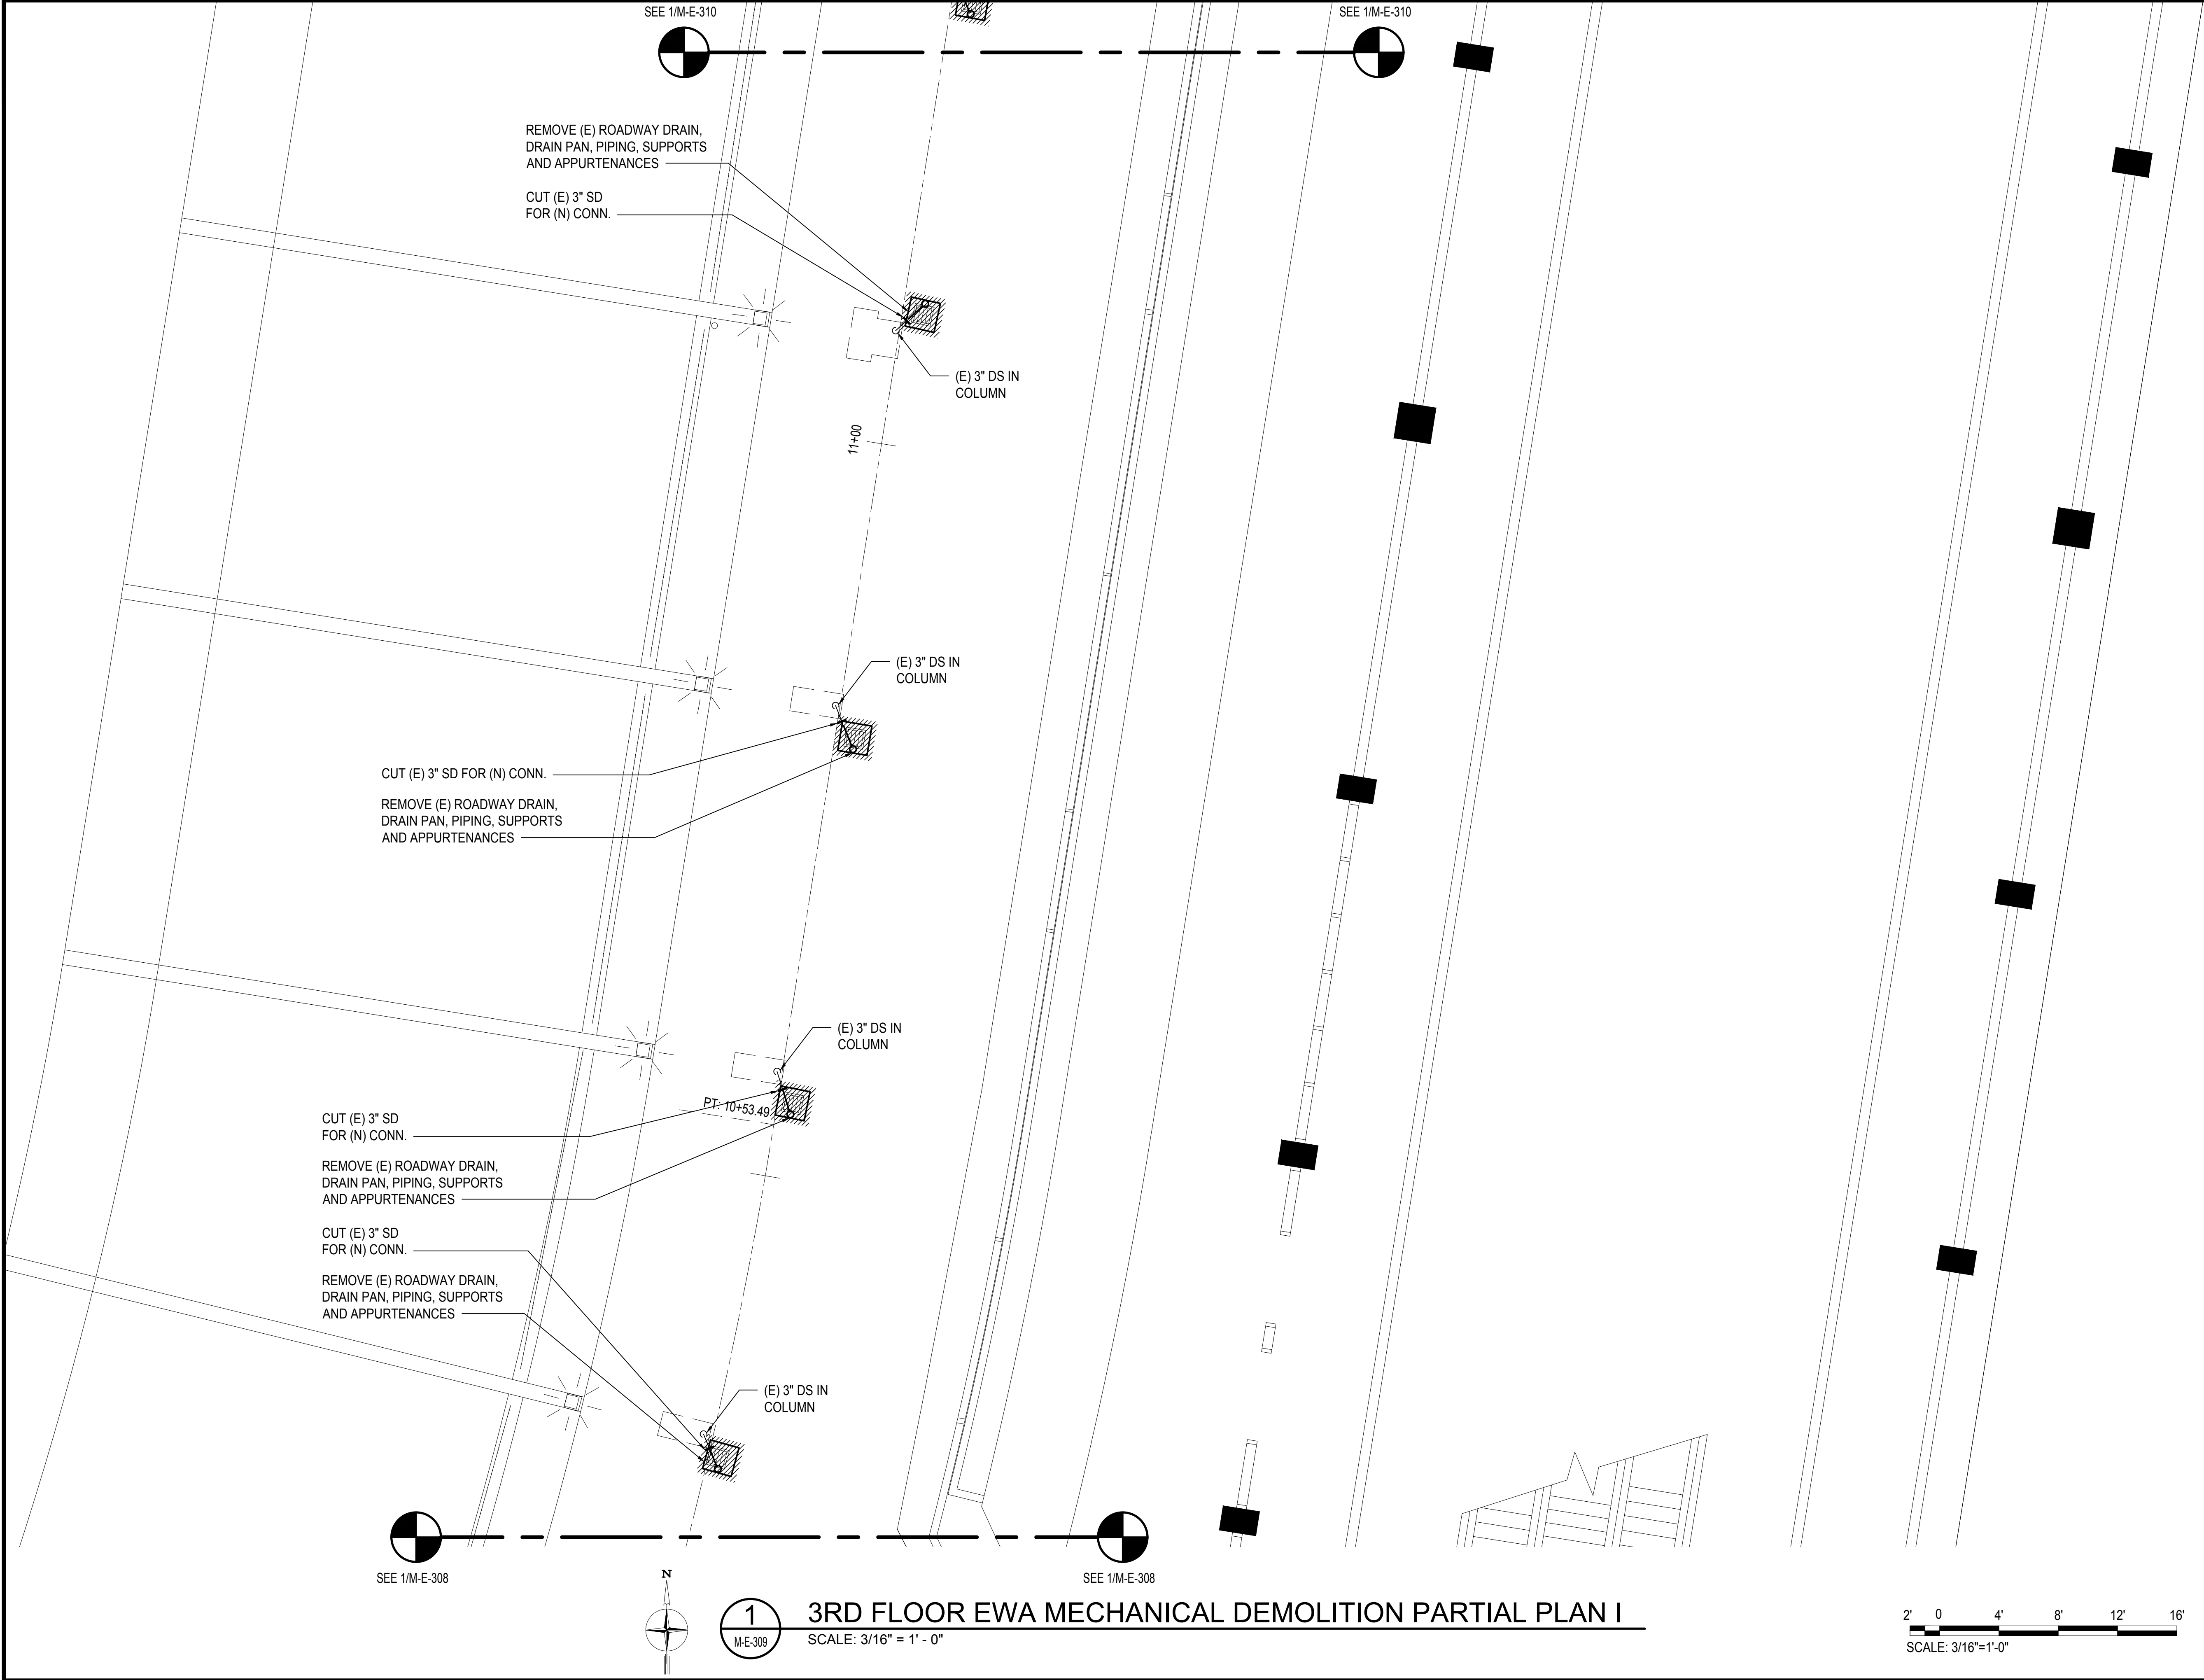

Airports Division
DEPARTMENT OF TRANSPORTATION
STATE OF HAWAII




THIS WORK WAS PREPARED BY ME OR UNDER MY SUPERVISION AND CONSTRUCTION OF THIS PROJECT WILL BE UNDER MY OBSERVATION.

Tyson T. Toyama
SIGNATURE

04/30/2024
EXPIRATION DATE OF THE LICENSE

DSGN.	DRWN.	CHKD.	APPD.
JS/KT	KT/TJ	TTT	TTT

KEY PLAN / NOTES:

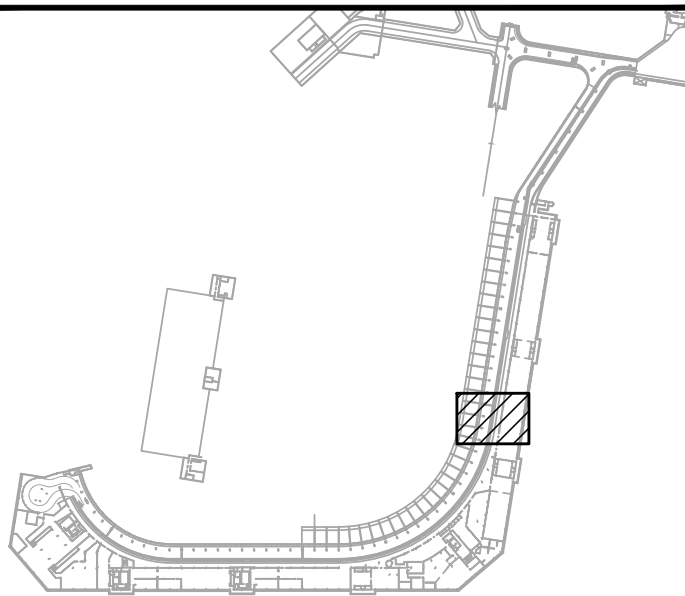

NO.	DATE	REVISIONS
-----	------	-----------

CONSTRUCTION DOCUMENTS

SEPTEMBER, 2022
DATE

PROJECT TITLE :

EWA AND DH CONCOURSE
ROADWAY IMPROVEMENTS
PHASE 1

AT
DANIEL K. INOUE INTERNATIONAL AIRPORT
HONOLULU, OAHU, HAWAII

PROJECT NO.:

AO1043-32

SHEET TITLE:

3RD FLOOR EWA
MECHANICAL DEMOLITION
PARTIAL PLAN I

DATE :

 
SEPTEMBER, 2022

SHEET :

165 OF 247 SHEETS

DWG. NO.

M-E-309





1
M-E-309

3RD FLOOR EWA MECHANICAL DEMOLITION PARTIAL PLAN I

SCALE: 3/16" = 1' - 0"

2' 0' 4' 8' 12' 16'
SCALE: 3/16"=1'-0"

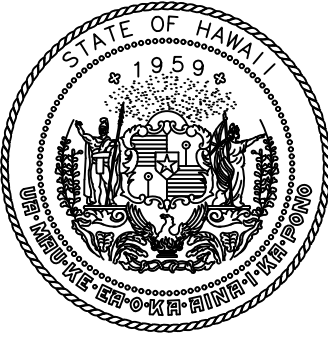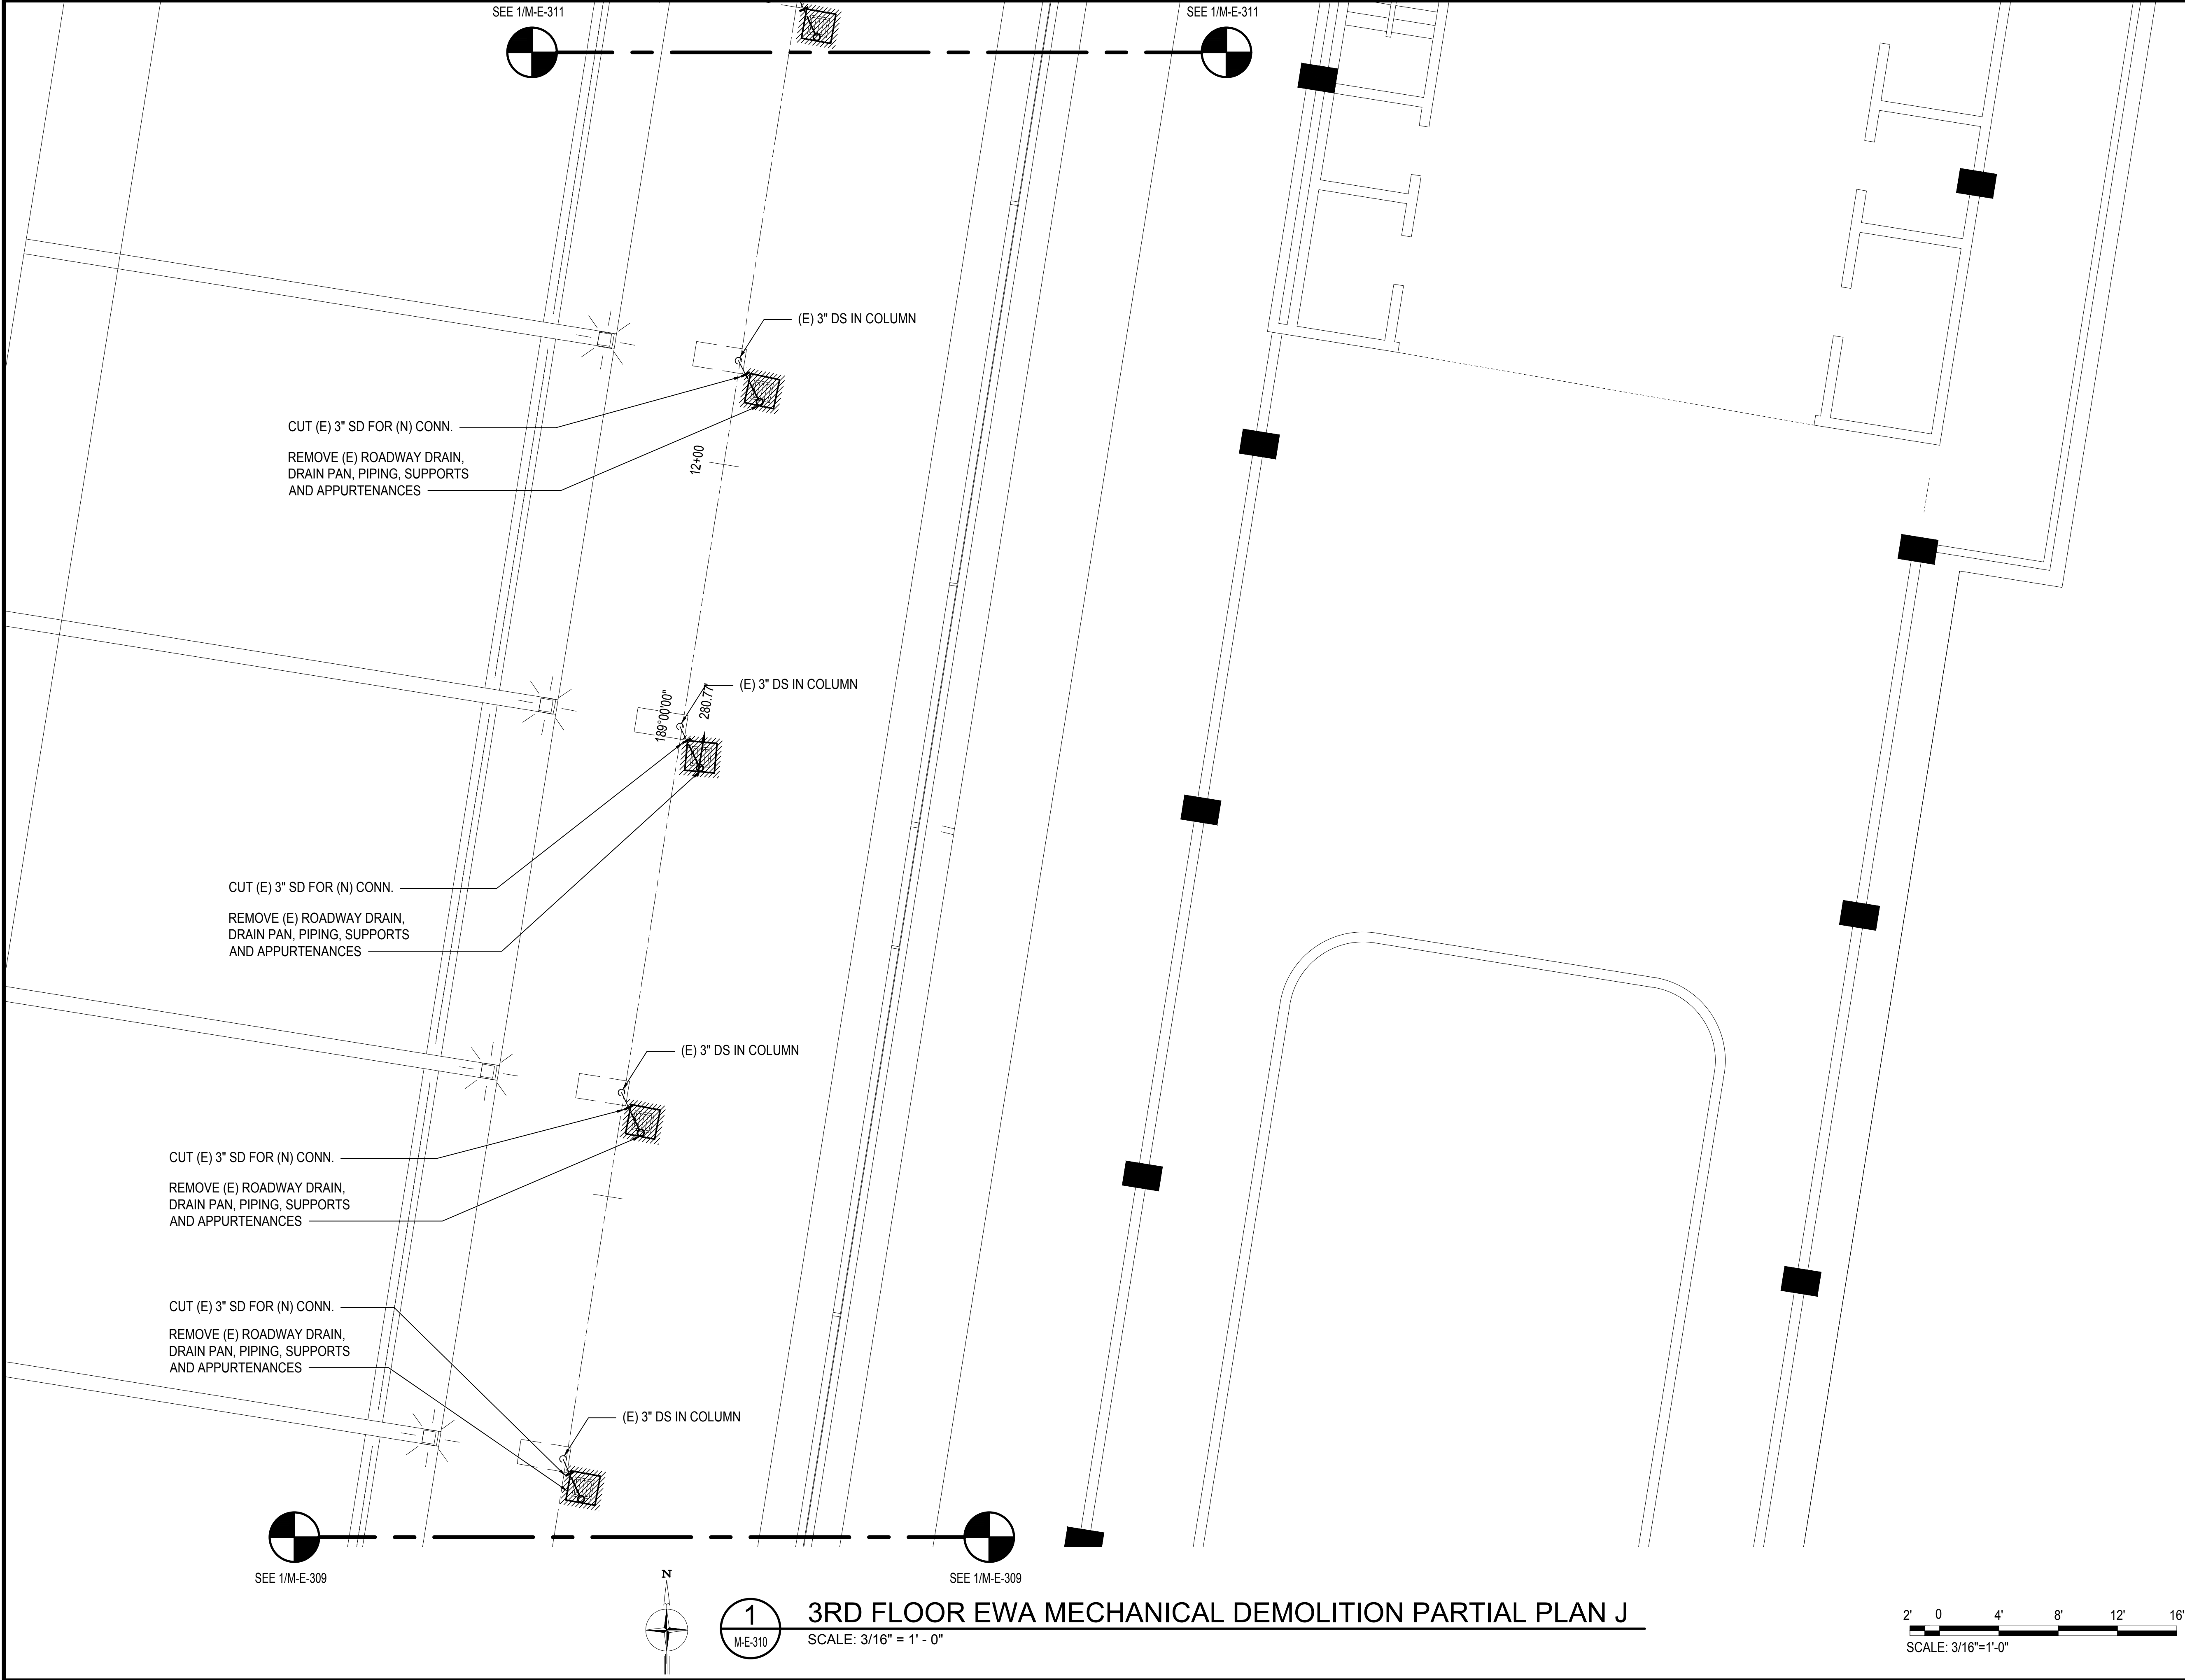

Airports Division
DEPARTMENT OF TRANSPORTATION
STATE OF HAWAII




THIS WORK WAS PREPARED BY ME OR UNDER MY SUPERVISION
AND CONSTRUCTION OF THIS PROJECT WILL BE UNDER MY
OBSERVATION.

Tyson T. Toyama
SIGNATURE
04/30/2024
EXPIRATION DATE OF THE LICENSE

DSGN.	DRWN.	CHKD.	APPD.
JS/KT	KT/TJ	TTT	TTT

KEY PLAN / NOTES:

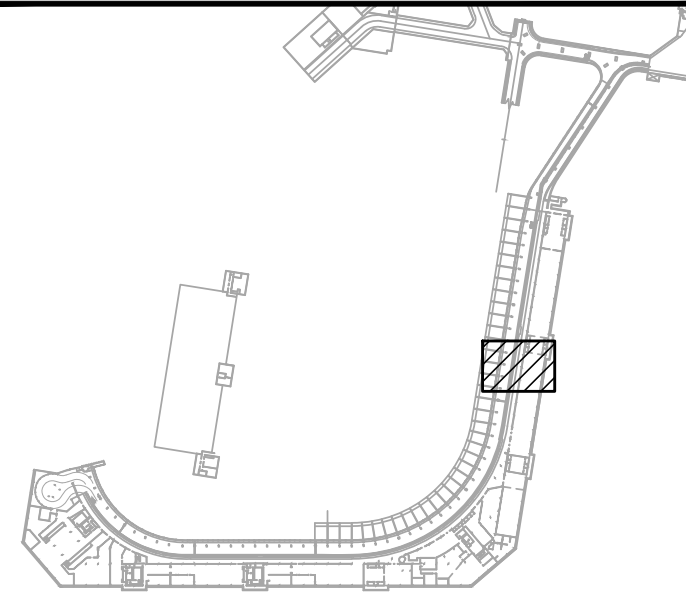

NO.	DATE	REVISIONS
-----	------	-----------

CONSTRUCTION
DOCUMENTS

SEPTEMBER, 2022
DATE

PROJECT TITLE :

EWA AND DH CONCOURSE
ROADWAY IMPROVEMENTS
PHASE 1

AT
DANIEL K. INOUE INTERNATIONAL AIRPORT
HONOLULU, OAHU, HAWAII

PROJECT NO.:

AO1043-32

SHEET TITLE:

3RD FLOOR EWA
MECHANICAL DEMOLITION
PARTIAL PLAN J

DATE :


SEPTEMBER, 2022

SHEET :

166 OF 247 SHEETS

DWG. NO.


M-E-310


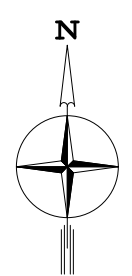


1
M-E-310

3RD FLOOR EWA MECHANICAL DEMOLITION PARTIAL PLAN J

SCALE: 3/16" = 1' - 0"

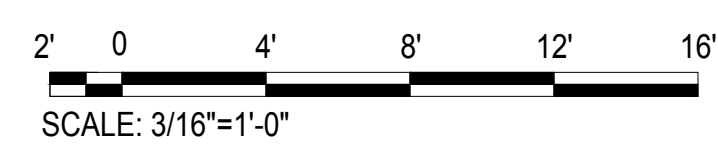

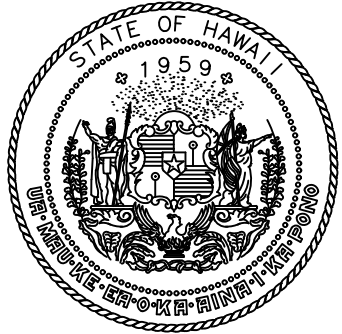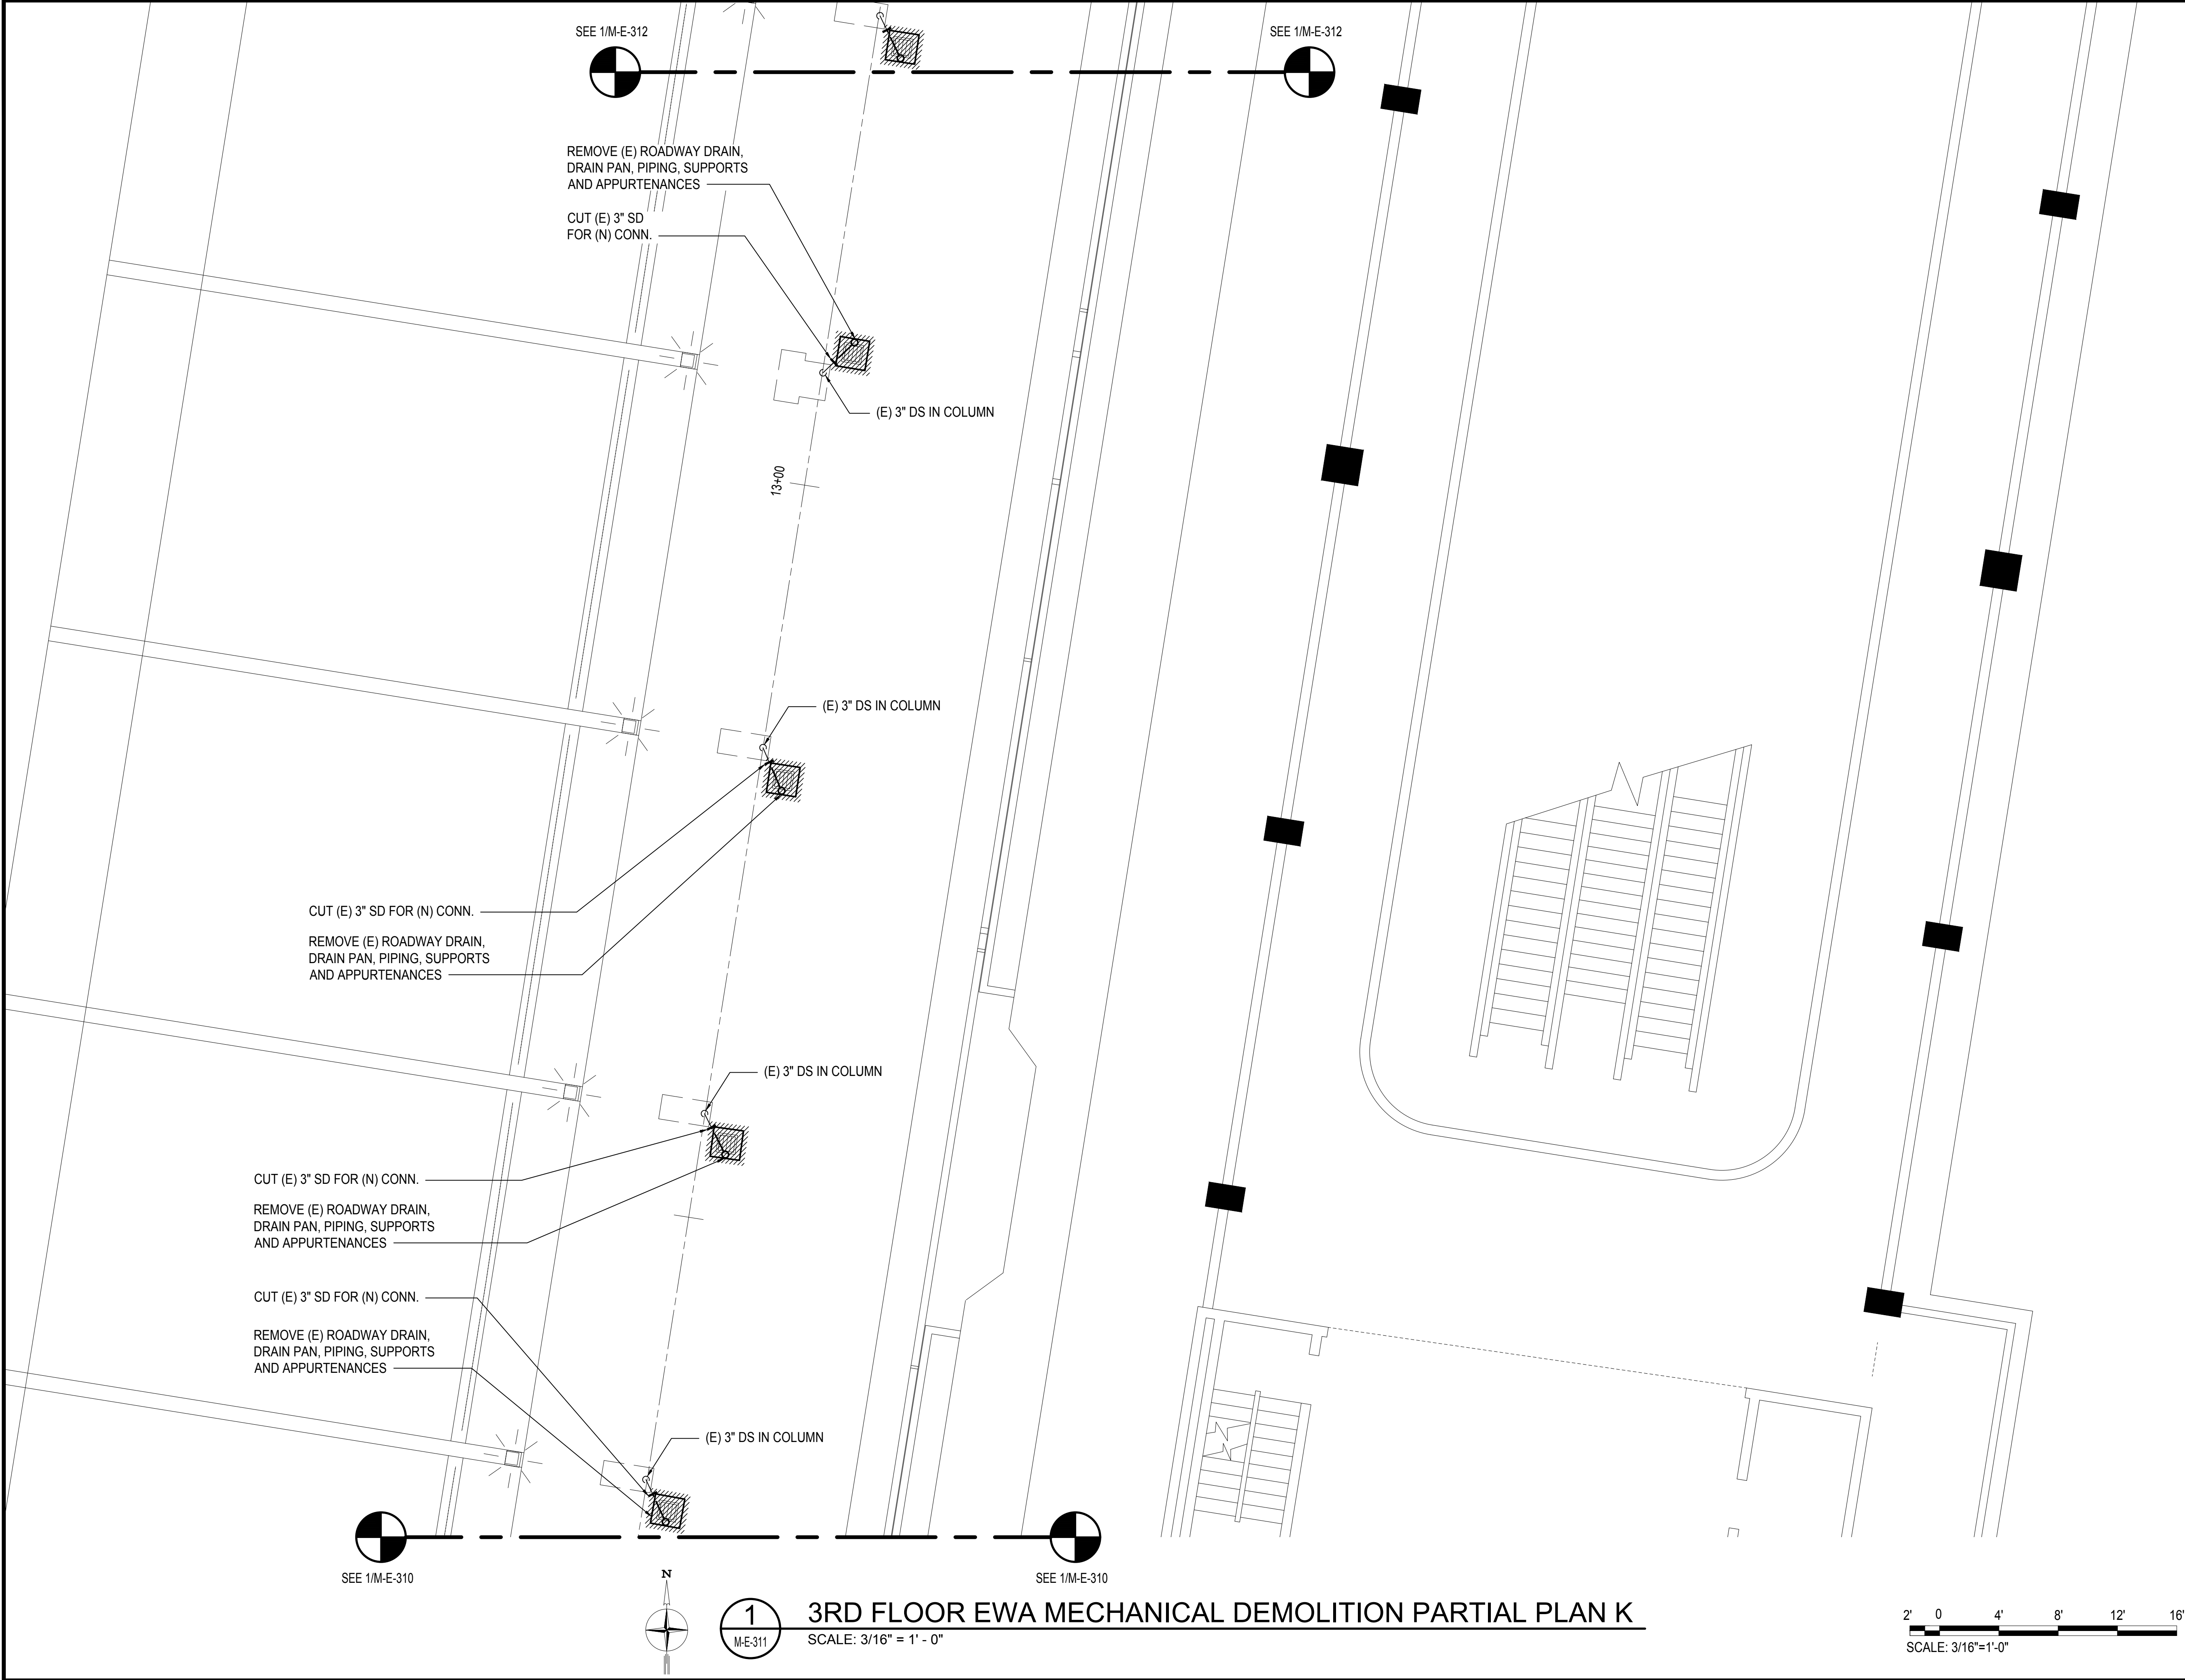

Airports Division
DEPARTMENT OF TRANSPORTATION
STATE OF HAWAII




THIS WORK WAS PREPARED BY ME OR UNDER MY SUPERVISION
AND CONSTRUCTION OF THIS PROJECT WILL BE UNDER MY
OBSERVATION.

Tyson T. Toyama
SIGNATURE

04/30/2024
EXPIRATION DATE OF THE LICENSE

DSGN.	DRWN.	CHKD.	APPD.
JS/KT	KT/TJ	TTT	TTT

KEY PLAN / NOTES:

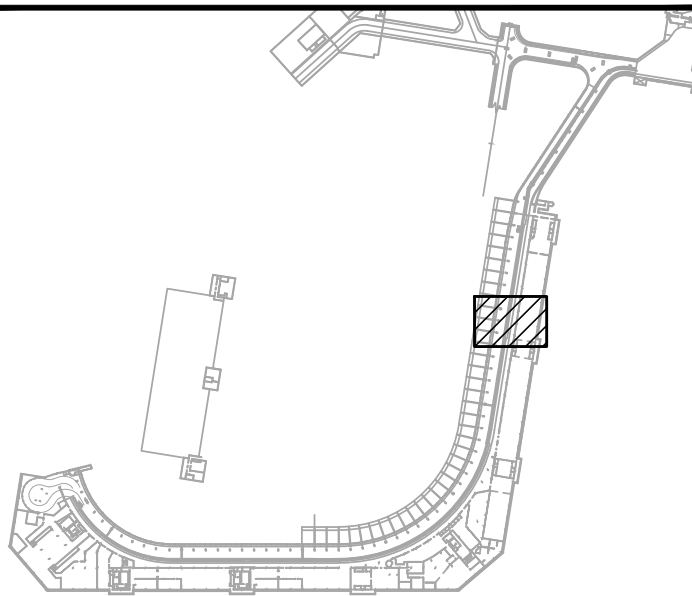

NO.	DATE	REVISIONS
-----	------	-----------

CONSTRUCTION
DOCUMENTS

SEPTEMBER, 2022
DATE

PROJECT TITLE :

EWA AND DH CONCOURSE
ROADWAY IMPROVEMENTS
PHASE 1

AT
DANIEL K. INOUE INTERNATIONAL AIRPORT
HONOLULU, OAHU, HAWAII

PROJECT NO.:

AO1043-32

SHEET TITLE:

3RD FLOOR EWA
MECHANICAL DEMOLITION
PARTIAL PLAN K

DATE :

SEPTEMBER, 2022



SHEET :

167 OF 247 SHEETS

DWG. NO.

M-E-311

M:\PROJECTS\2022\1043\DOTA EWA DH ROADWAYDRAWINGS\HNL 3RD LEVEL - MECHANICAL PLANS.DWG

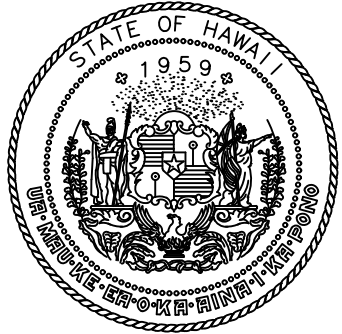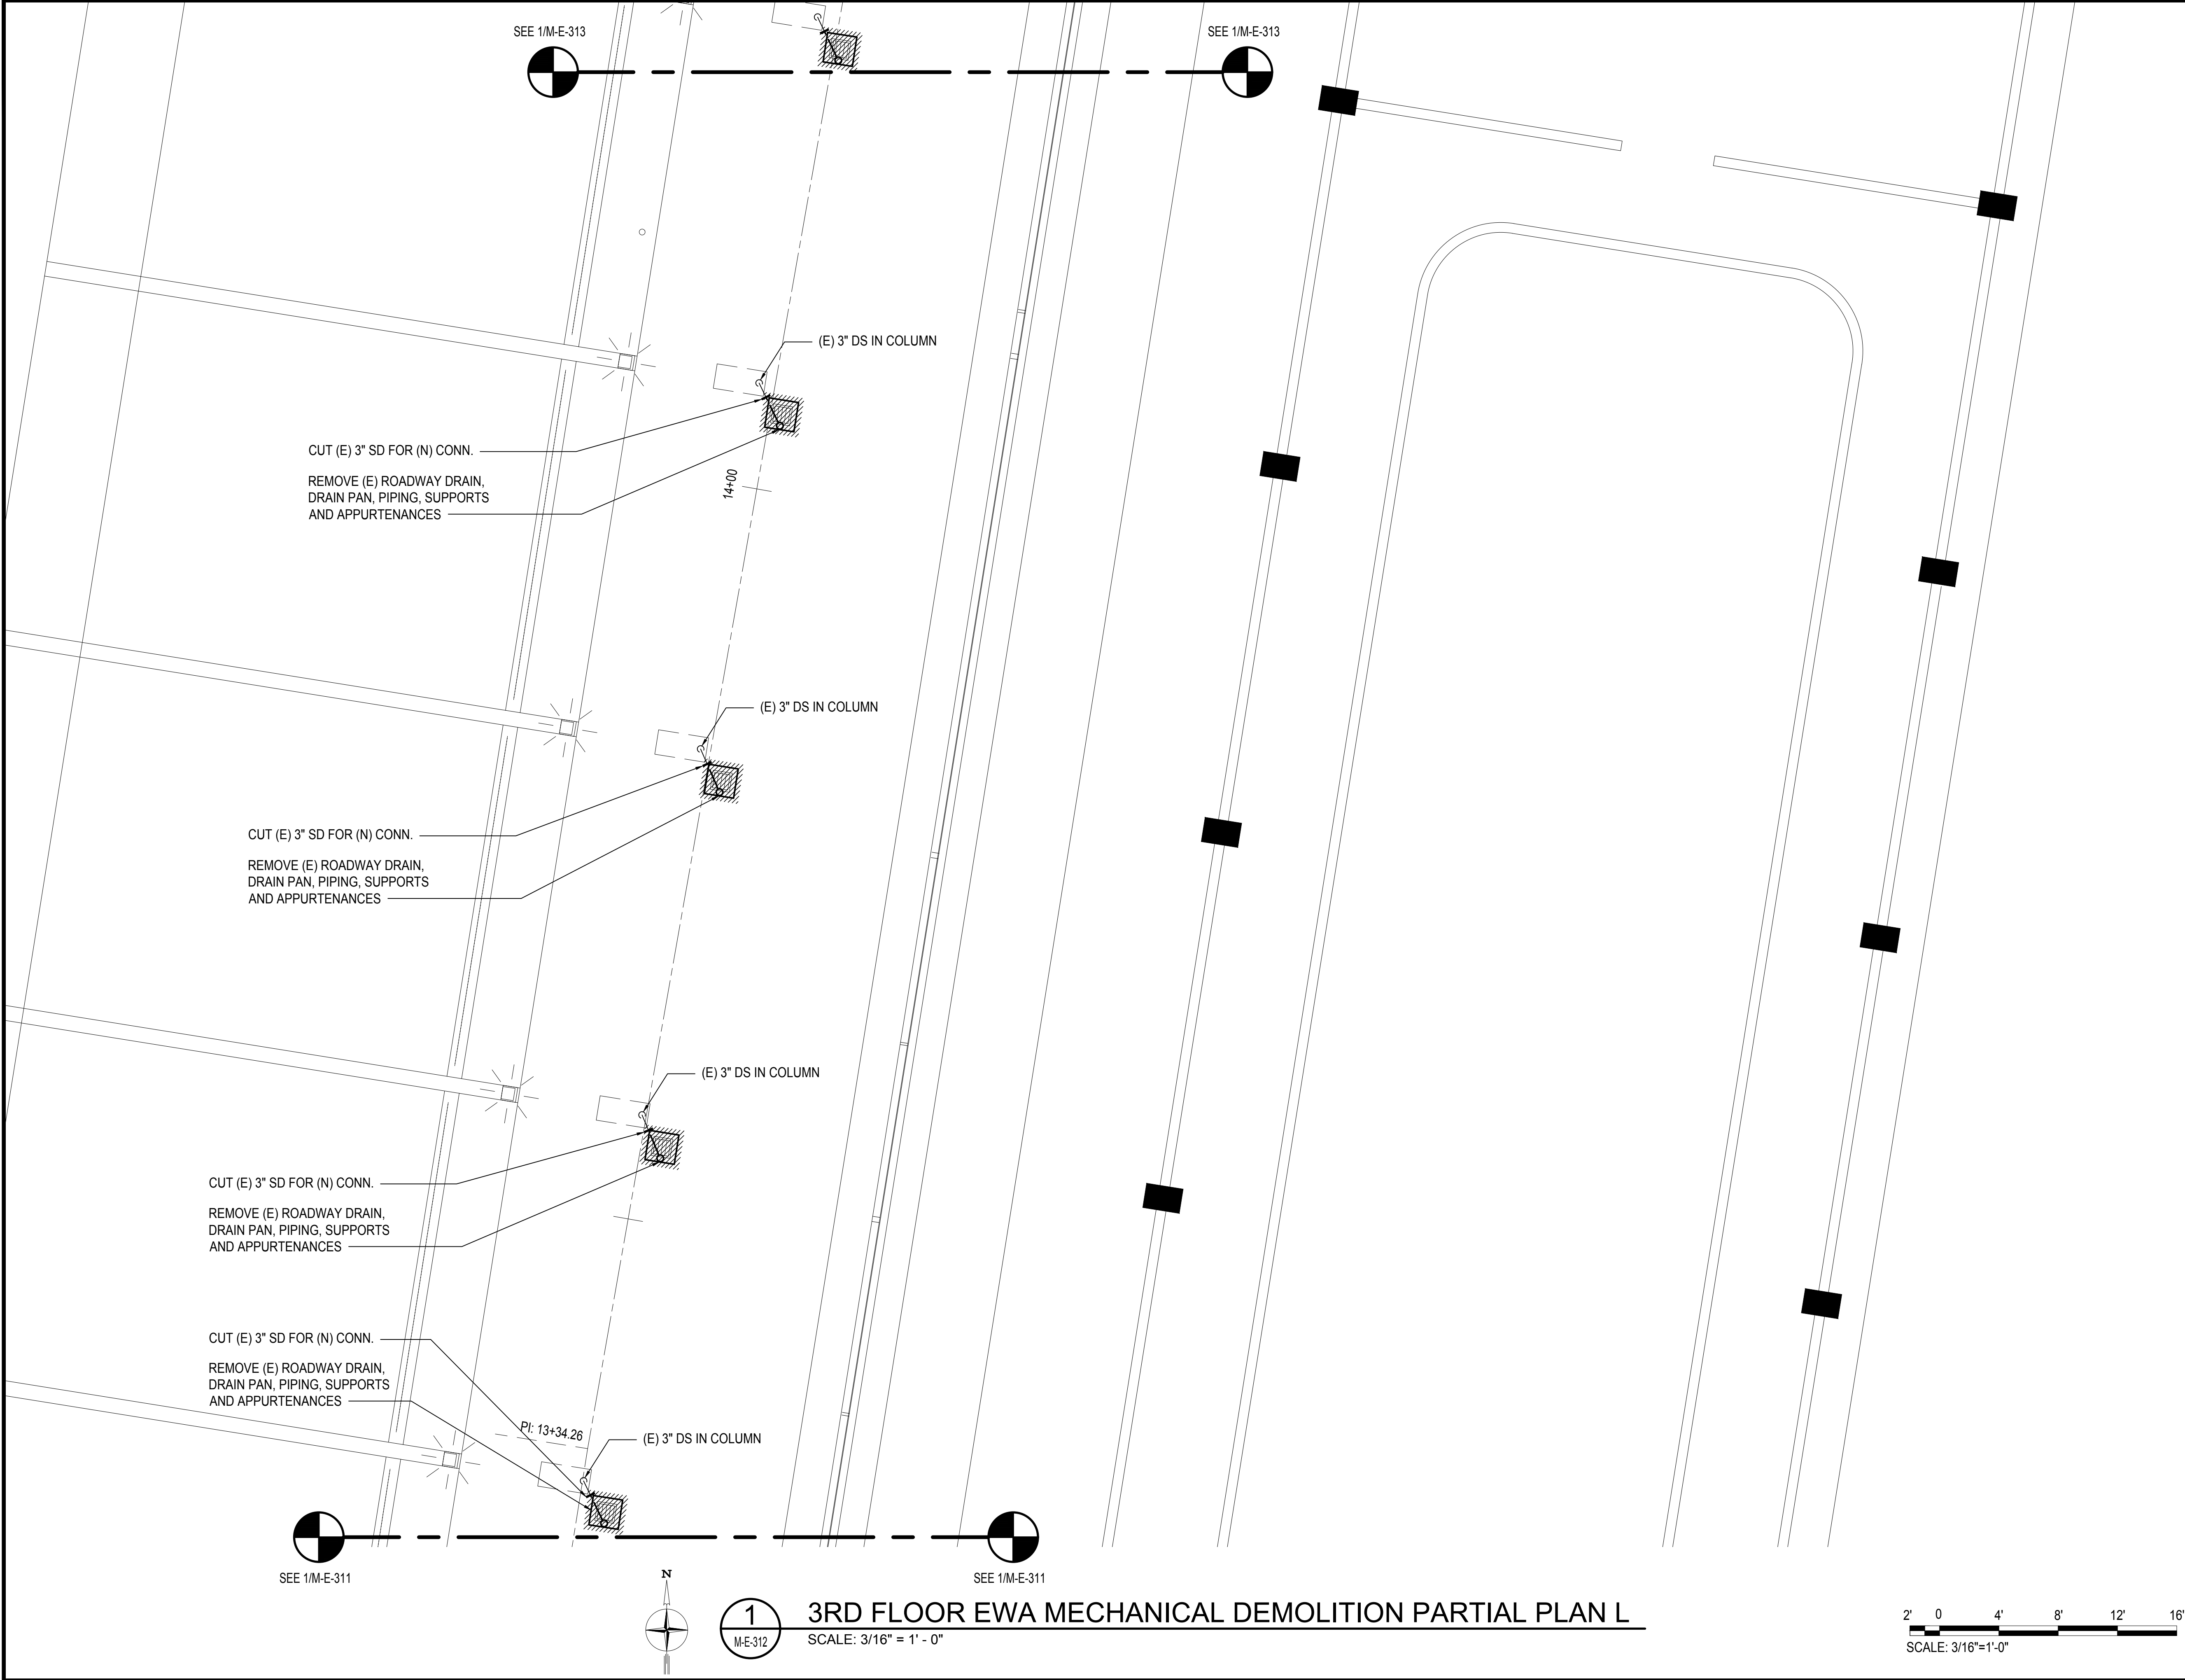

Airports Division
DEPARTMENT OF TRANSPORTATION
STATE OF HAWAII




THIS WORK WAS PREPARED BY ME OR UNDER MY SUPERVISION
AND CONSTRUCTION OF THIS PROJECT WILL BE UNDER MY
OBSERVATION.

Tyson T. Toyama
SIGNATURE

04/30/2024
EXPIRATION DATE OF THE LICENSE

DSGN.	DRWN.	CHKD.	APPD.
JS/KT	KT/TJ	TTT	TTT

KEY PLAN / NOTES:

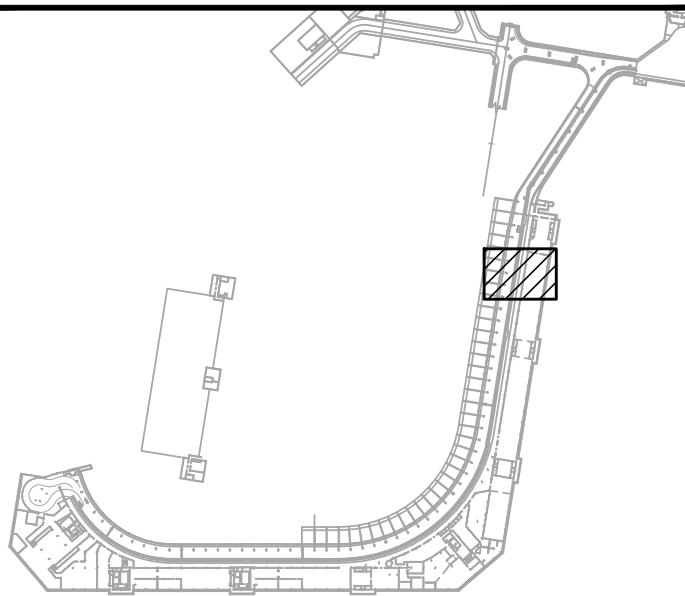

NO.	DATE	REVISIONS
-----	------	-----------

CONSTRUCTION
DOCUMENTS

SEPTEMBER, 2022
DATE

PROJECT TITLE :

EWA AND DH CONCOURSE
ROADWAY IMPROVEMENTS
PHASE 1

AT
DANIEL K. INOUE INTERNATIONAL AIRPORT
HONOLULU, OAHU, HAWAII

PROJECT NO.:

AO1043-32

SHEET TITLE:

3RD FLOOR EWA
MECHANICAL DEMOLITION
PARTIAL PLAN L

DATE :

 
SEPTEMBER, 2022

SHEET :

168 OF 247 SHEETS

DWG. NO.

M-E-312



1
M-E-312

3RD FLOOR EWA MECHANICAL DEMOLITION PARTIAL PLAN L

SCALE: 3/16" = 1' - 0"

