



1
M-E-314

3RD FLOOR EWA MECHANICAL PARTIAL PLAN A
SCALE: 3/16" = 1' - 0"

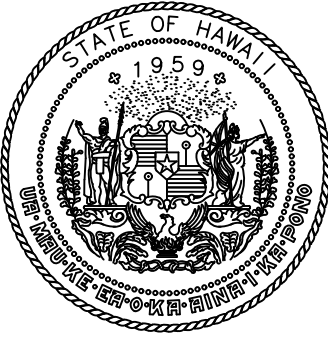

Airports Division
DEPARTMENT OF TRANSPORTATION
STATE OF HAWAII

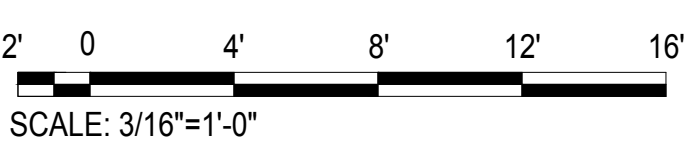


THIS WORK WAS PREPARED BY ME OR UNDER MY SUPERVISION
AND CONSTRUCTION OF THIS PROJECT WILL BE UNDER MY
OBSERVATION.

Tyson T. Toyama
SIGNATURE EXPIRATION DATE OF THE LICENSE 04/30/2024

DSGN.	DRWN.	CHKD.	APPD.
JS/KT	KT/TJ	TTT	TTT

KEY PLAN / NOTES:

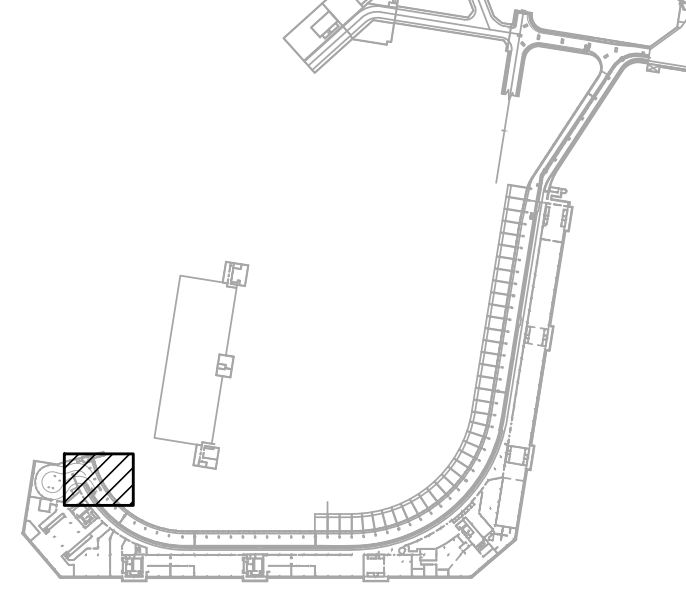

NO.	DATE	REVISIONS

CONSTRUCTION
DOCUMENTS

SEPTEMBER, 2022
DATE

PROJECT TITLE :

EWA AND DH CONCOURSE
ROADWAY IMPROVEMENTS
PHASE 1

AT
DANIEL K. INOUE INTERNATIONAL AIRPORT
HONOLULU, OAHU, HAWAII

PROJECT NO.:

AO1043-32

SHEET TITLE:

3RD FLOOR EWA
MECHANICAL PARTIAL PLAN A

DATE :

SEPTEMBER, 2022

SHEET :

170 OF 247 SHEETS

DWG. NO.

M-E-314

M:\PROJECTS\2019-000219\076 DOTA EWA DH ROADWAY\DRAWINGS\HNL 3RD LEVEL - MECHANICAL PLANS.DWG

SEE 1/M-E-314

SEE 1/M-E-314

(E) 4" DS IN
COLUMN

RD
2

CONN. (N)
4" SD TO (E)

CONN. (N)
4" SD TO (E)

RD
2

(E) 4" DS IN
COLUMN

CONN. (N)
4" SD TO (E)

RD
2

(E) 4" DS IN
COLUMN

CONN. (N)
4" SD TO (E)

RD
2


(E) 4" DS IN
COLUMN

CONN. (N)
4" SD TO (E)

RD
2

SEE
1/M-E-316



SEE
1/M-E-316

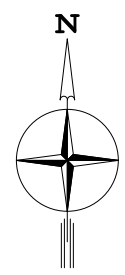


1
M-E-315

3RD FLOOR EWA MECHANICAL PARTIAL PLAN B

SCALE: 3/16" = 1' - 0"

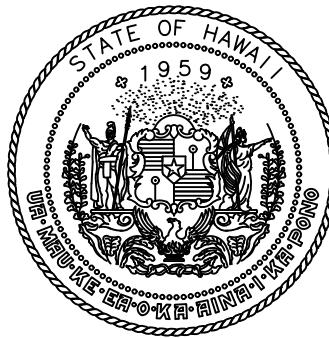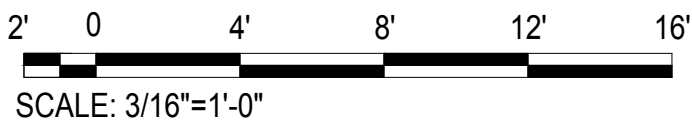

Airports Division
DEPARTMENT OF TRANSPORTATION
STATE OF HAWAII

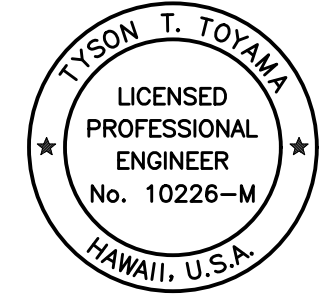


THIS WORK WAS PREPARED BY ME OR UNDER MY SUPERVISION
AND CONSTRUCTION OF THIS PROJECT WILL BE UNDER MY
OBSERVATION.

Tyson T. Toyama
SIGNATURE

04/30/2024
EXPIRATION DATE OF THE LICENSE

DSGN.	DRWN.	CHKD.	APPD.
JS/KT	KT/TJ	TTT	TTT

KEY PLAN / NOTES:

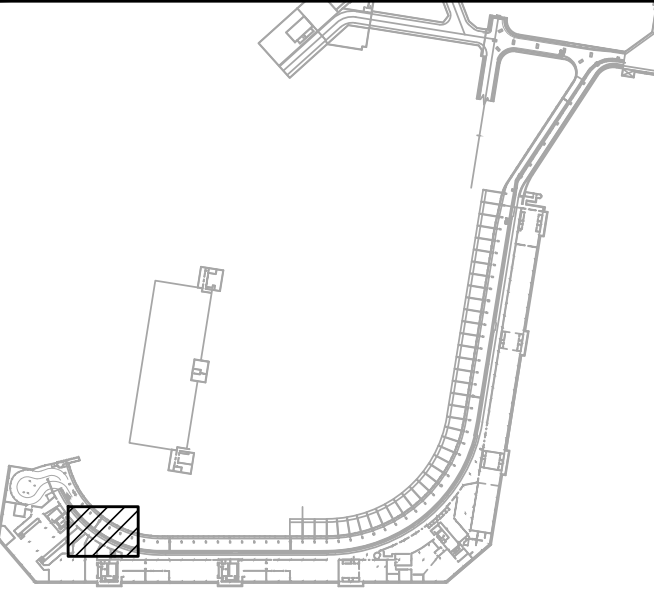

NO.	DATE	REVISIONS
-----	------	-----------

CONSTRUCTION DOCUMENTS

SEPTEMBER, 2022
DATE

PROJECT TITLE :

EWA AND DH CONCOURSE
ROADWAY IMPROVEMENTS
PHASE 1

AT
DANIEL K. INOUE INTERNATIONAL AIRPORT
HONOLULU, OAHU, HAWAII

PROJECT NO.:

AO1043-32

SHEET TITLE:

3RD FLOOR EWA
MECHANICAL PARTIAL PLAN B

DATE :



SEPTEMBER, 2022

SHEET :

171 OF 247 SHEETS

DWG. NO.

M-E-315

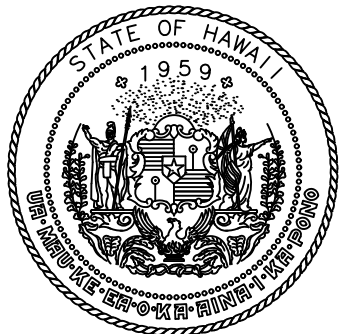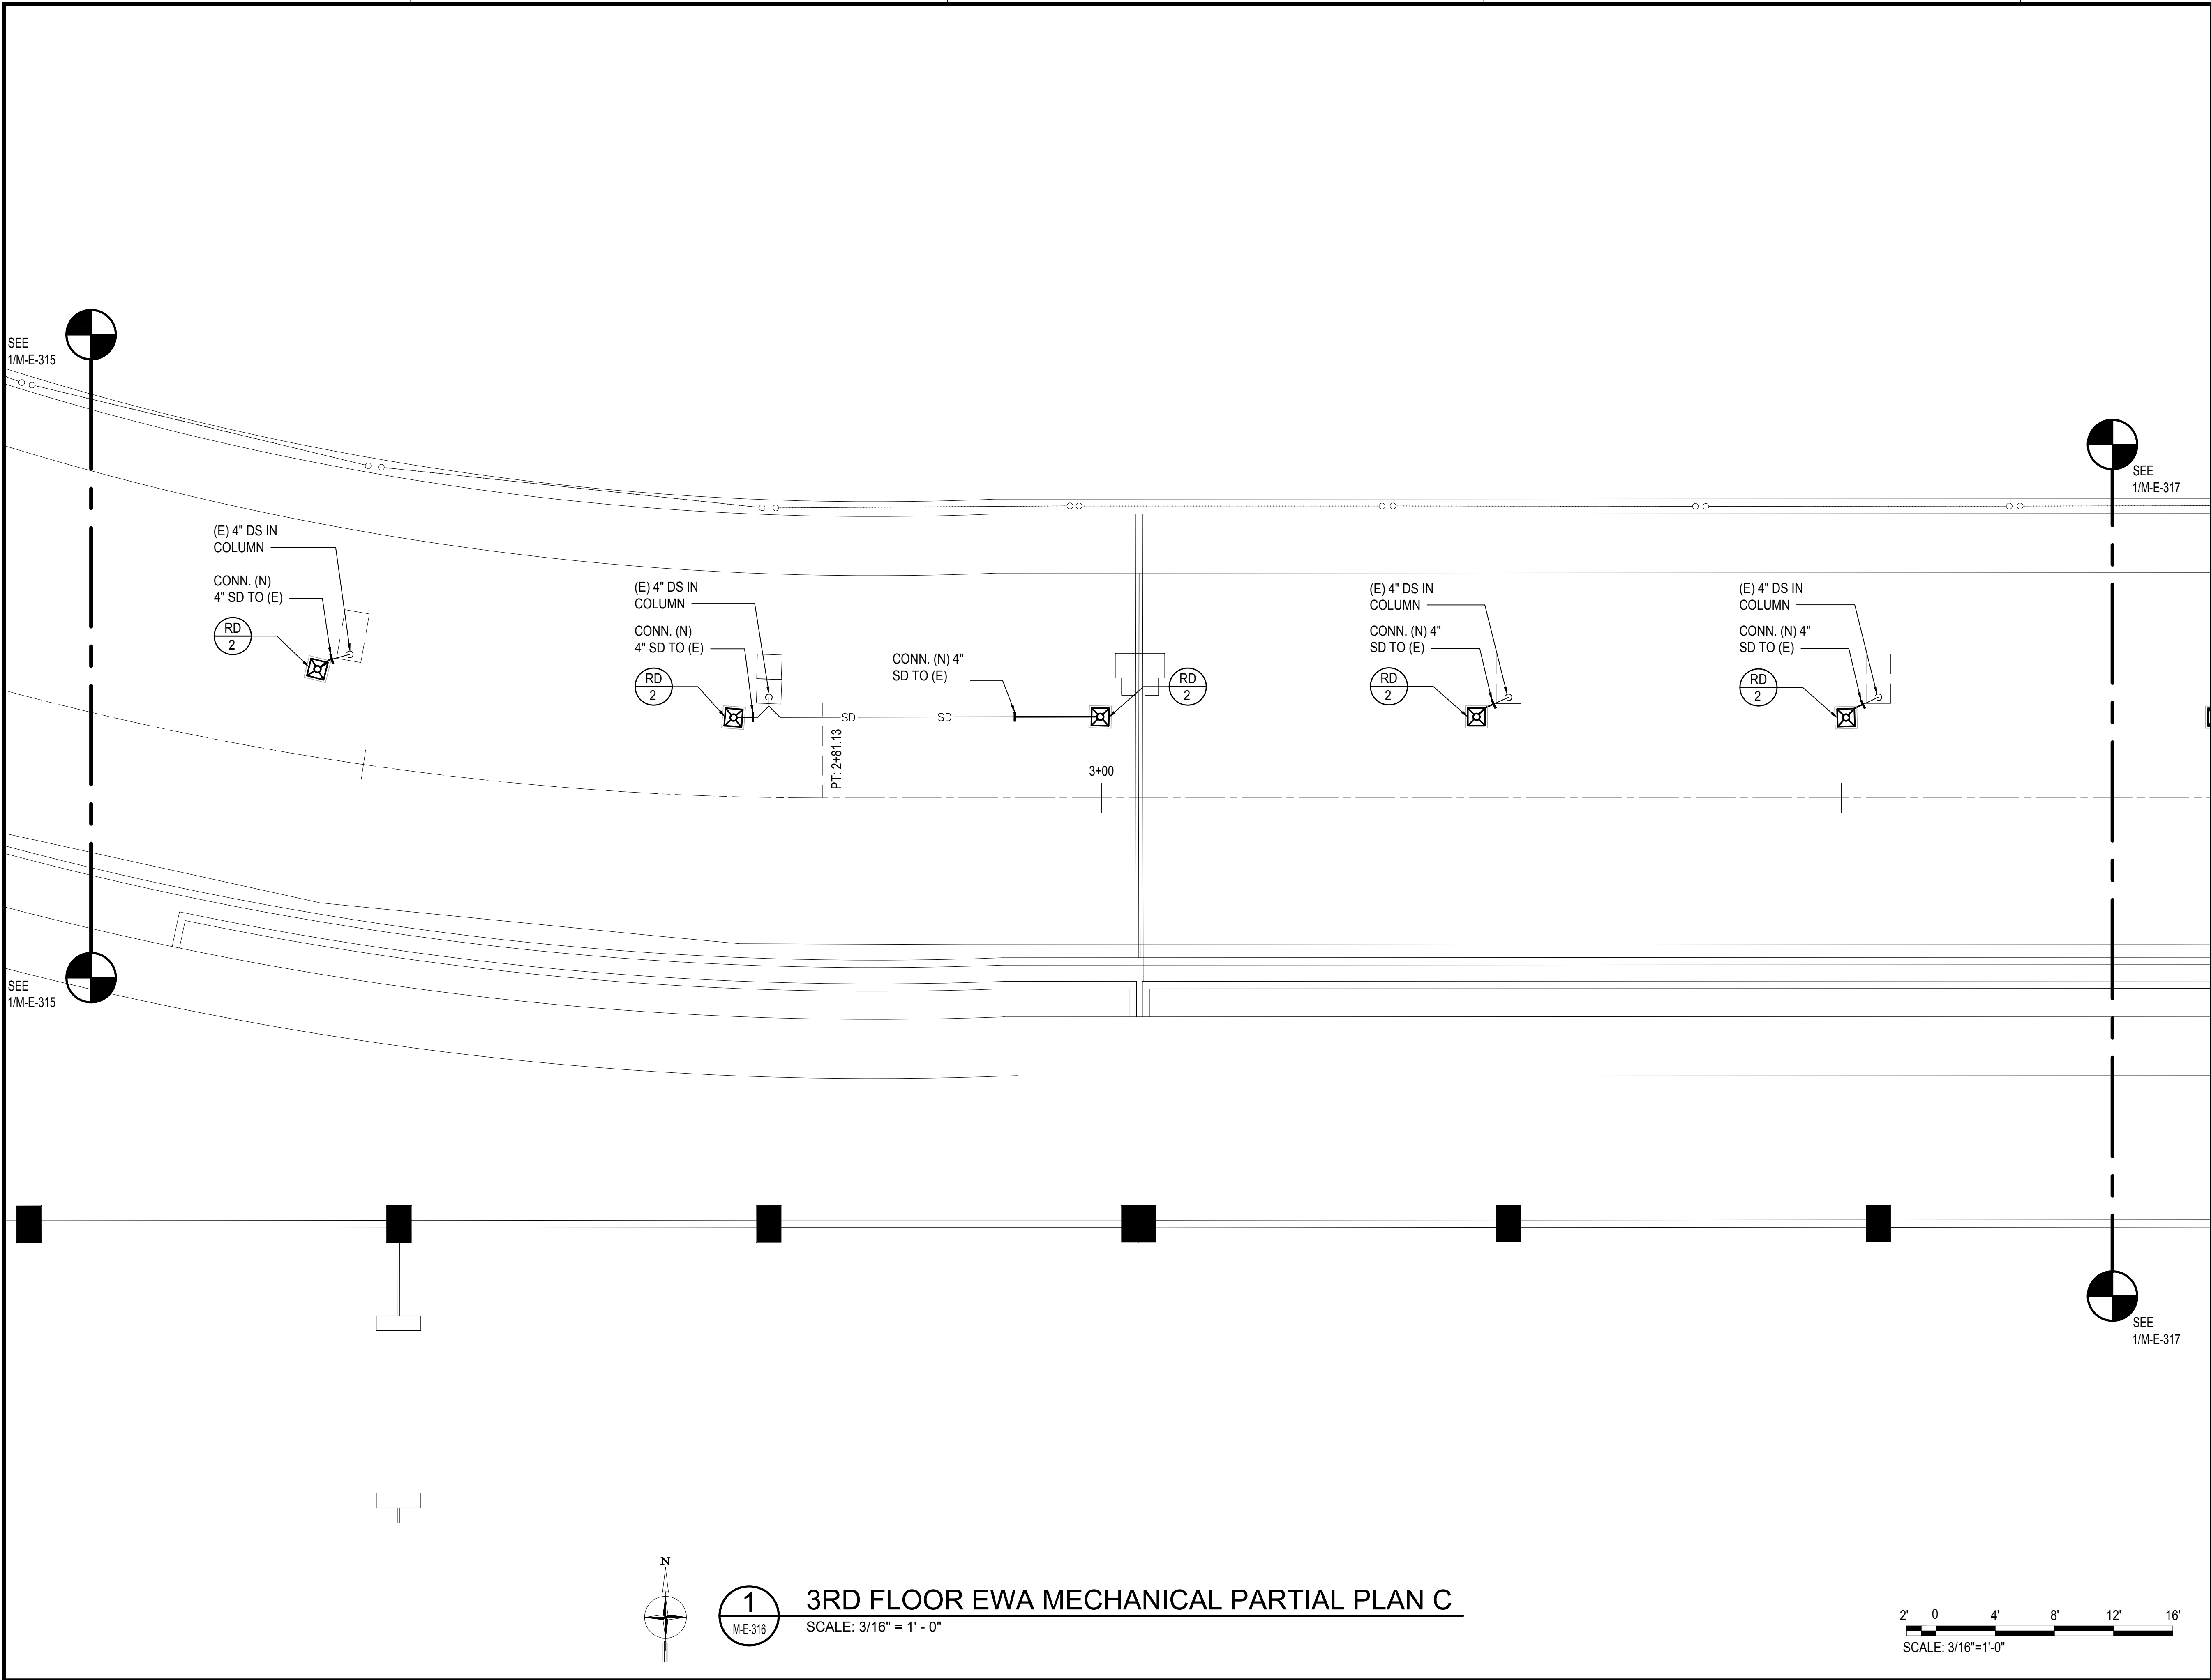

Airports Division
DEPARTMENT OF TRANSPORTATION
STATE OF HAWAII




THIS WORK WAS PREPARED BY ME OR UNDER MY SUPERVISION
AND CONSTRUCTION OF THIS PROJECT WILL BE UNDER MY
OBSERVATION.

Tyson T. Toyama
SIGNATURE

04/30/2024
EXPIRATION DATE OF THE LICENSE

DSGN.	DRWN.	CHKD.	APPD.
JS/KT	KT/TJ	TTT	TTT

KEY PLAN / NOTES:

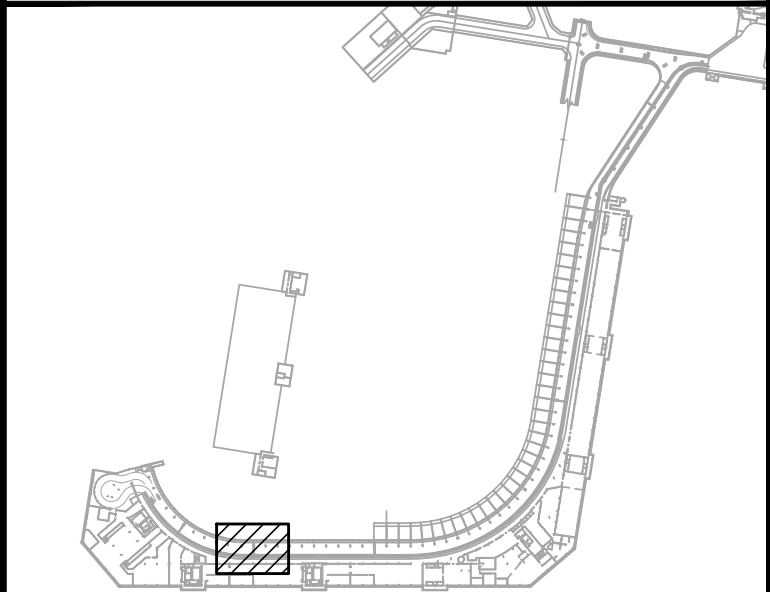

NO.	DATE	REVISIONS
-----	------	-----------

CONSTRUCTION DOCUMENTS
SEPTEMBER, 2022
DATE

PROJECT TITLE :
EWA AND DH CONCOURSE
ROADWAY IMPROVEMENTS
PHASE 1

AT
DANIEL K. INOUE INTERNATIONAL AIRPORT
HONOLULU, OAHU, HAWAII



PROJECT NO.:

AO1043-32

SHEET TITLE:

3RD FLOOR EWA
MECHANICAL PARTIAL PLAN C

DATE :	DWG. NO.
SEPTEMBER, 2022	M-E-316
SHEET :	
172 OF 247 SHEETS	

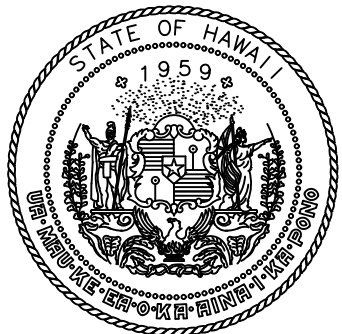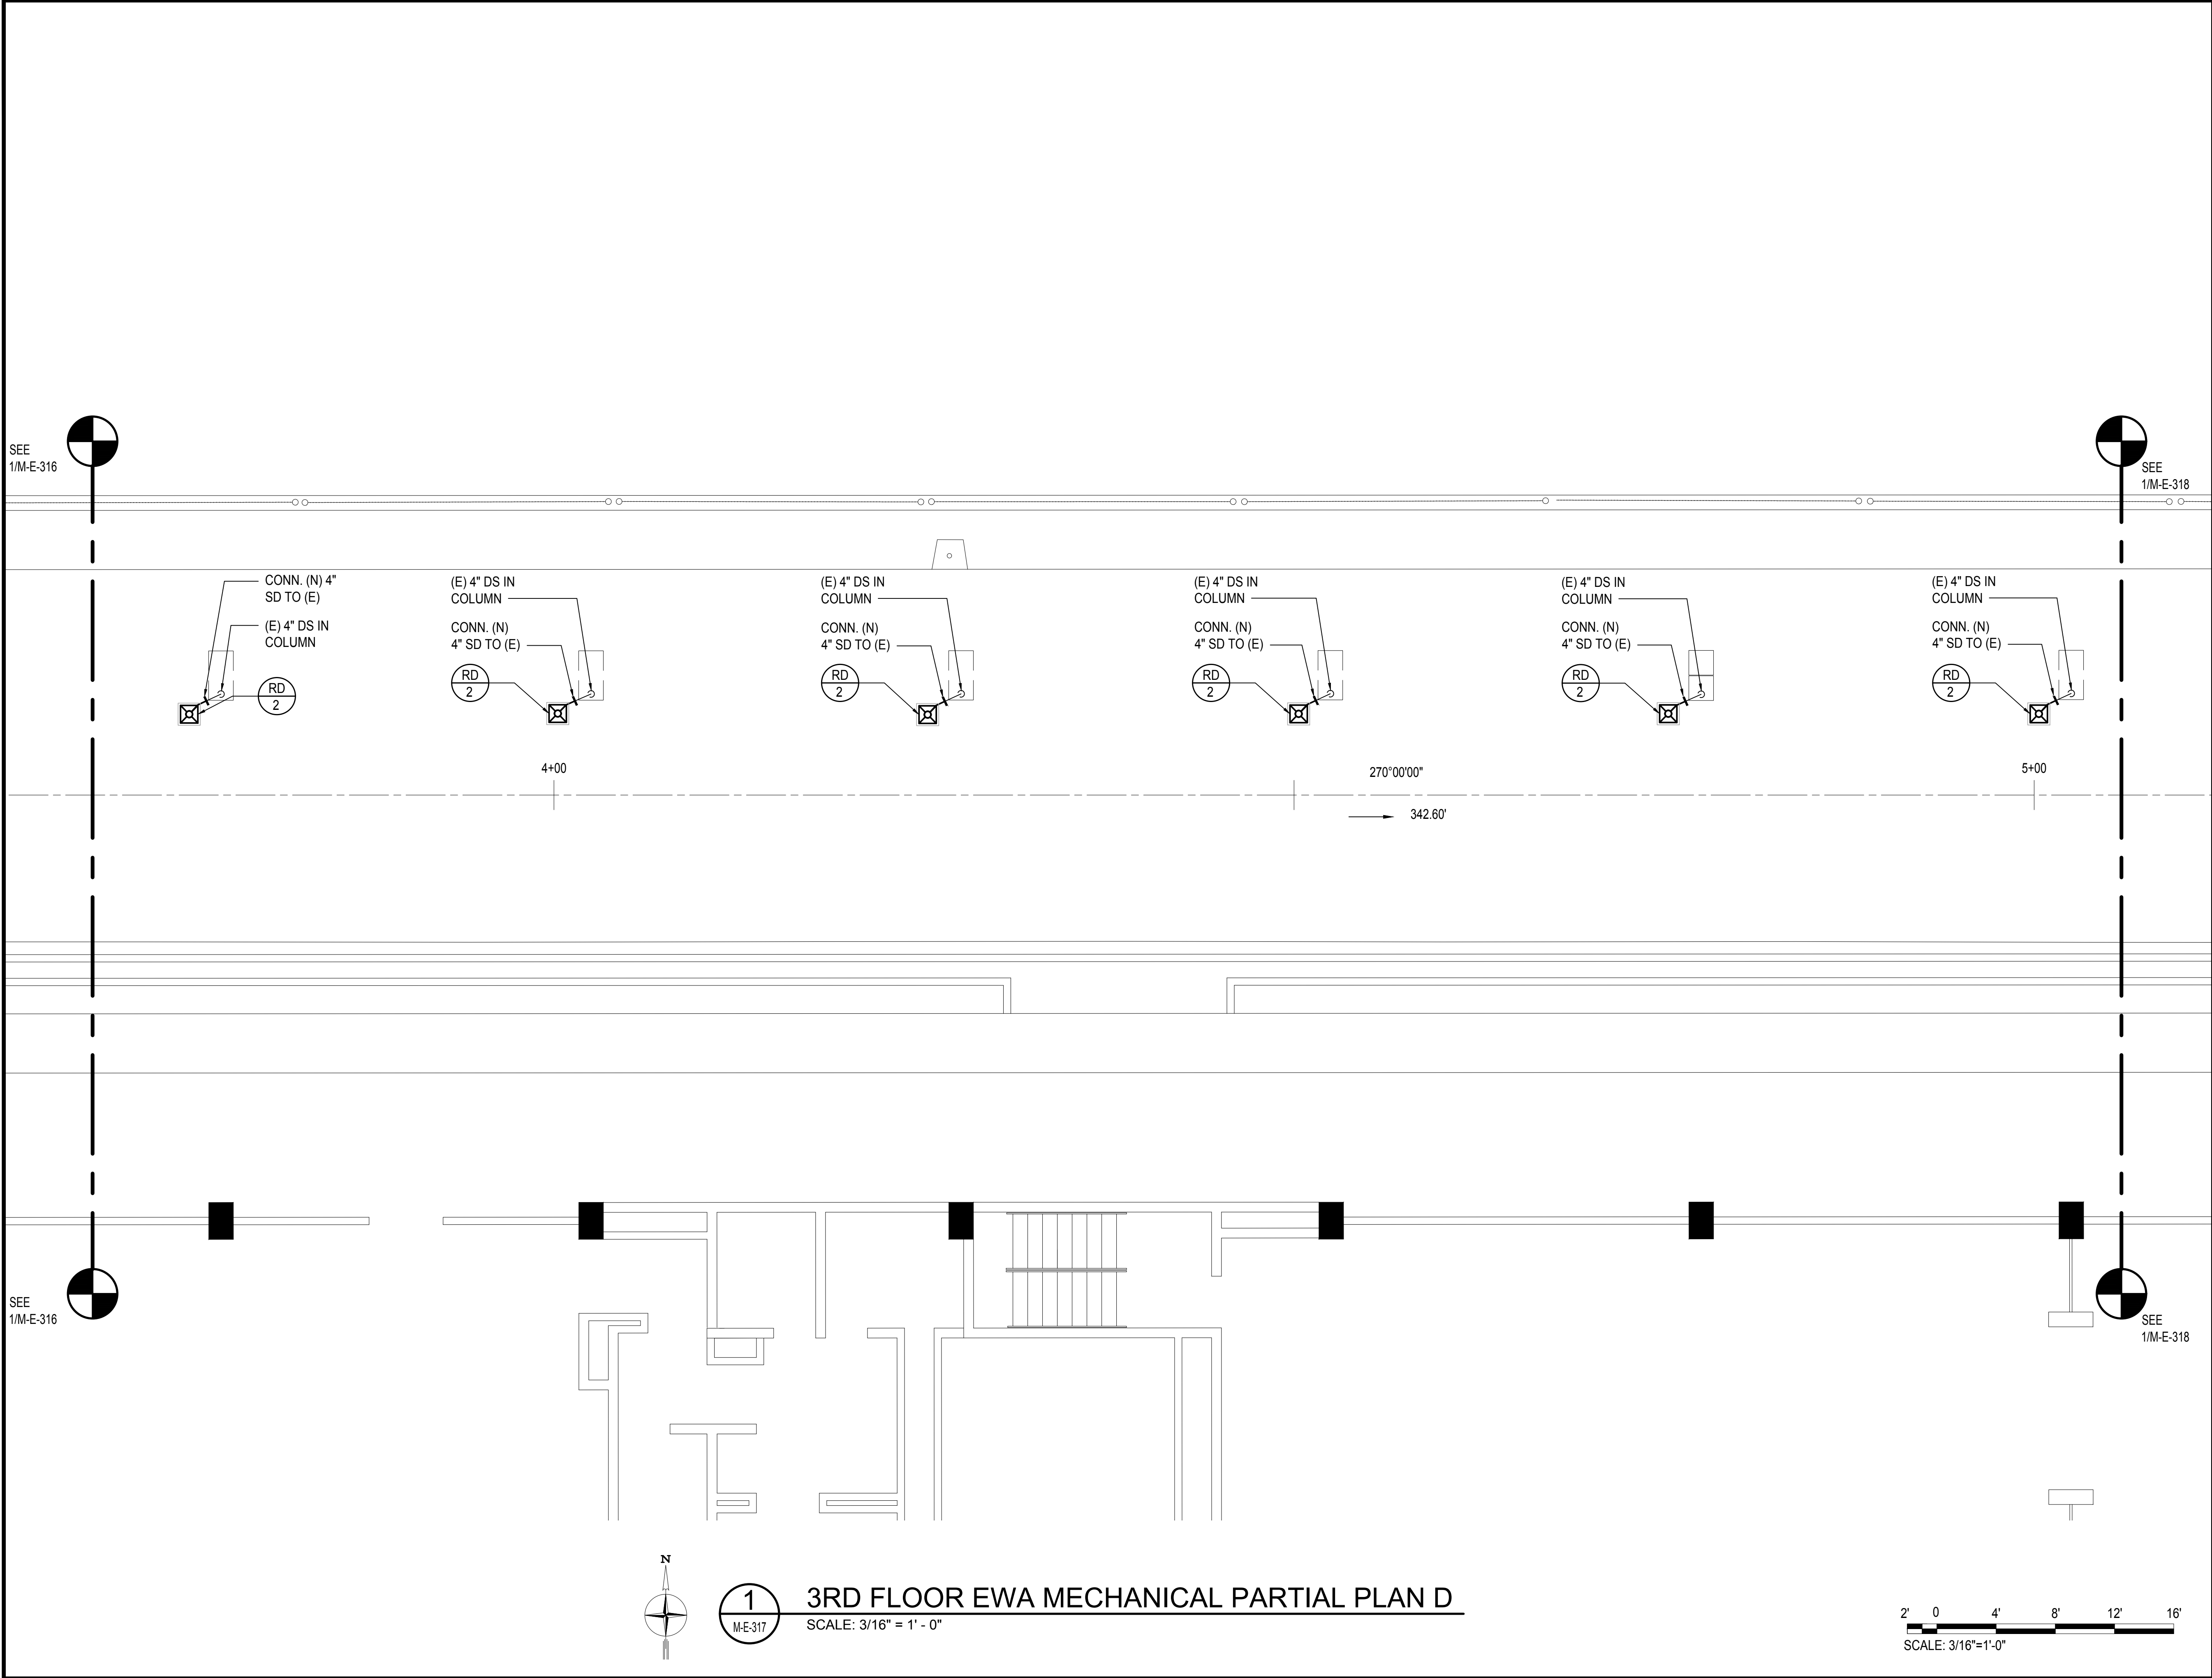

Airports Division
DEPARTMENT OF TRANSPORTATION
STATE OF HAWAII




THIS WORK WAS PREPARED BY ME OR UNDER MY SUPERVISION
AND CONSTRUCTION OF THIS PROJECT WILL BE UNDER MY
OBSERVATION.

Tyson T. Toyama
SIGNATURE
04/30/2024
EXPIRATION DATE OF THE LICENSE

DSGN.	DRWN.	CHKD.	APPD.
JS/KT	KT/TJ	TTT	TTT

KEY PLAN / NOTES:

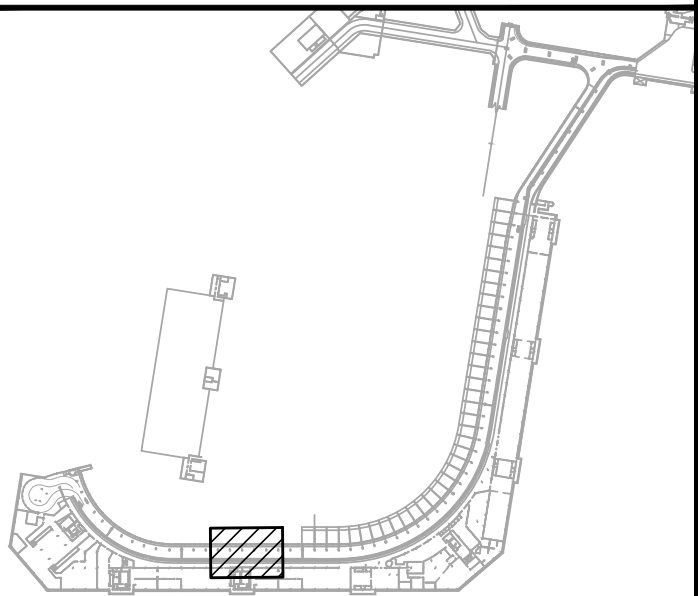

NO.	DATE	REVISIONS

CONSTRUCTION
DOCUMENTS

SEPTEMBER, 2022
DATE

PROJECT TITLE :

EWA AND DH CONCOURSE
ROADWAY IMPROVEMENTS
PHASE 1

AT
DANIEL K. INOUE INTERNATIONAL AIRPORT
HONOLULU, OAHU, HAWAII

PROJECT NO.:

AO1043-32

SHEET TITLE:

3RD FLOOR EWA
MECHANICAL PARTIAL PLAN D



DATE :
SEPTEMBER, 2022
SHEET :

DWG. NO.

M-E-317

173 OF 247 SHEETS

M:\PROJECTS\2022\219-000\219-076 DOT A EWA DH ROADWAY DRAWINGS\SHL 3RD LEVEL - MECHANICAL PLANS.DWG

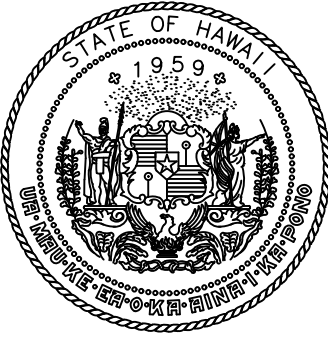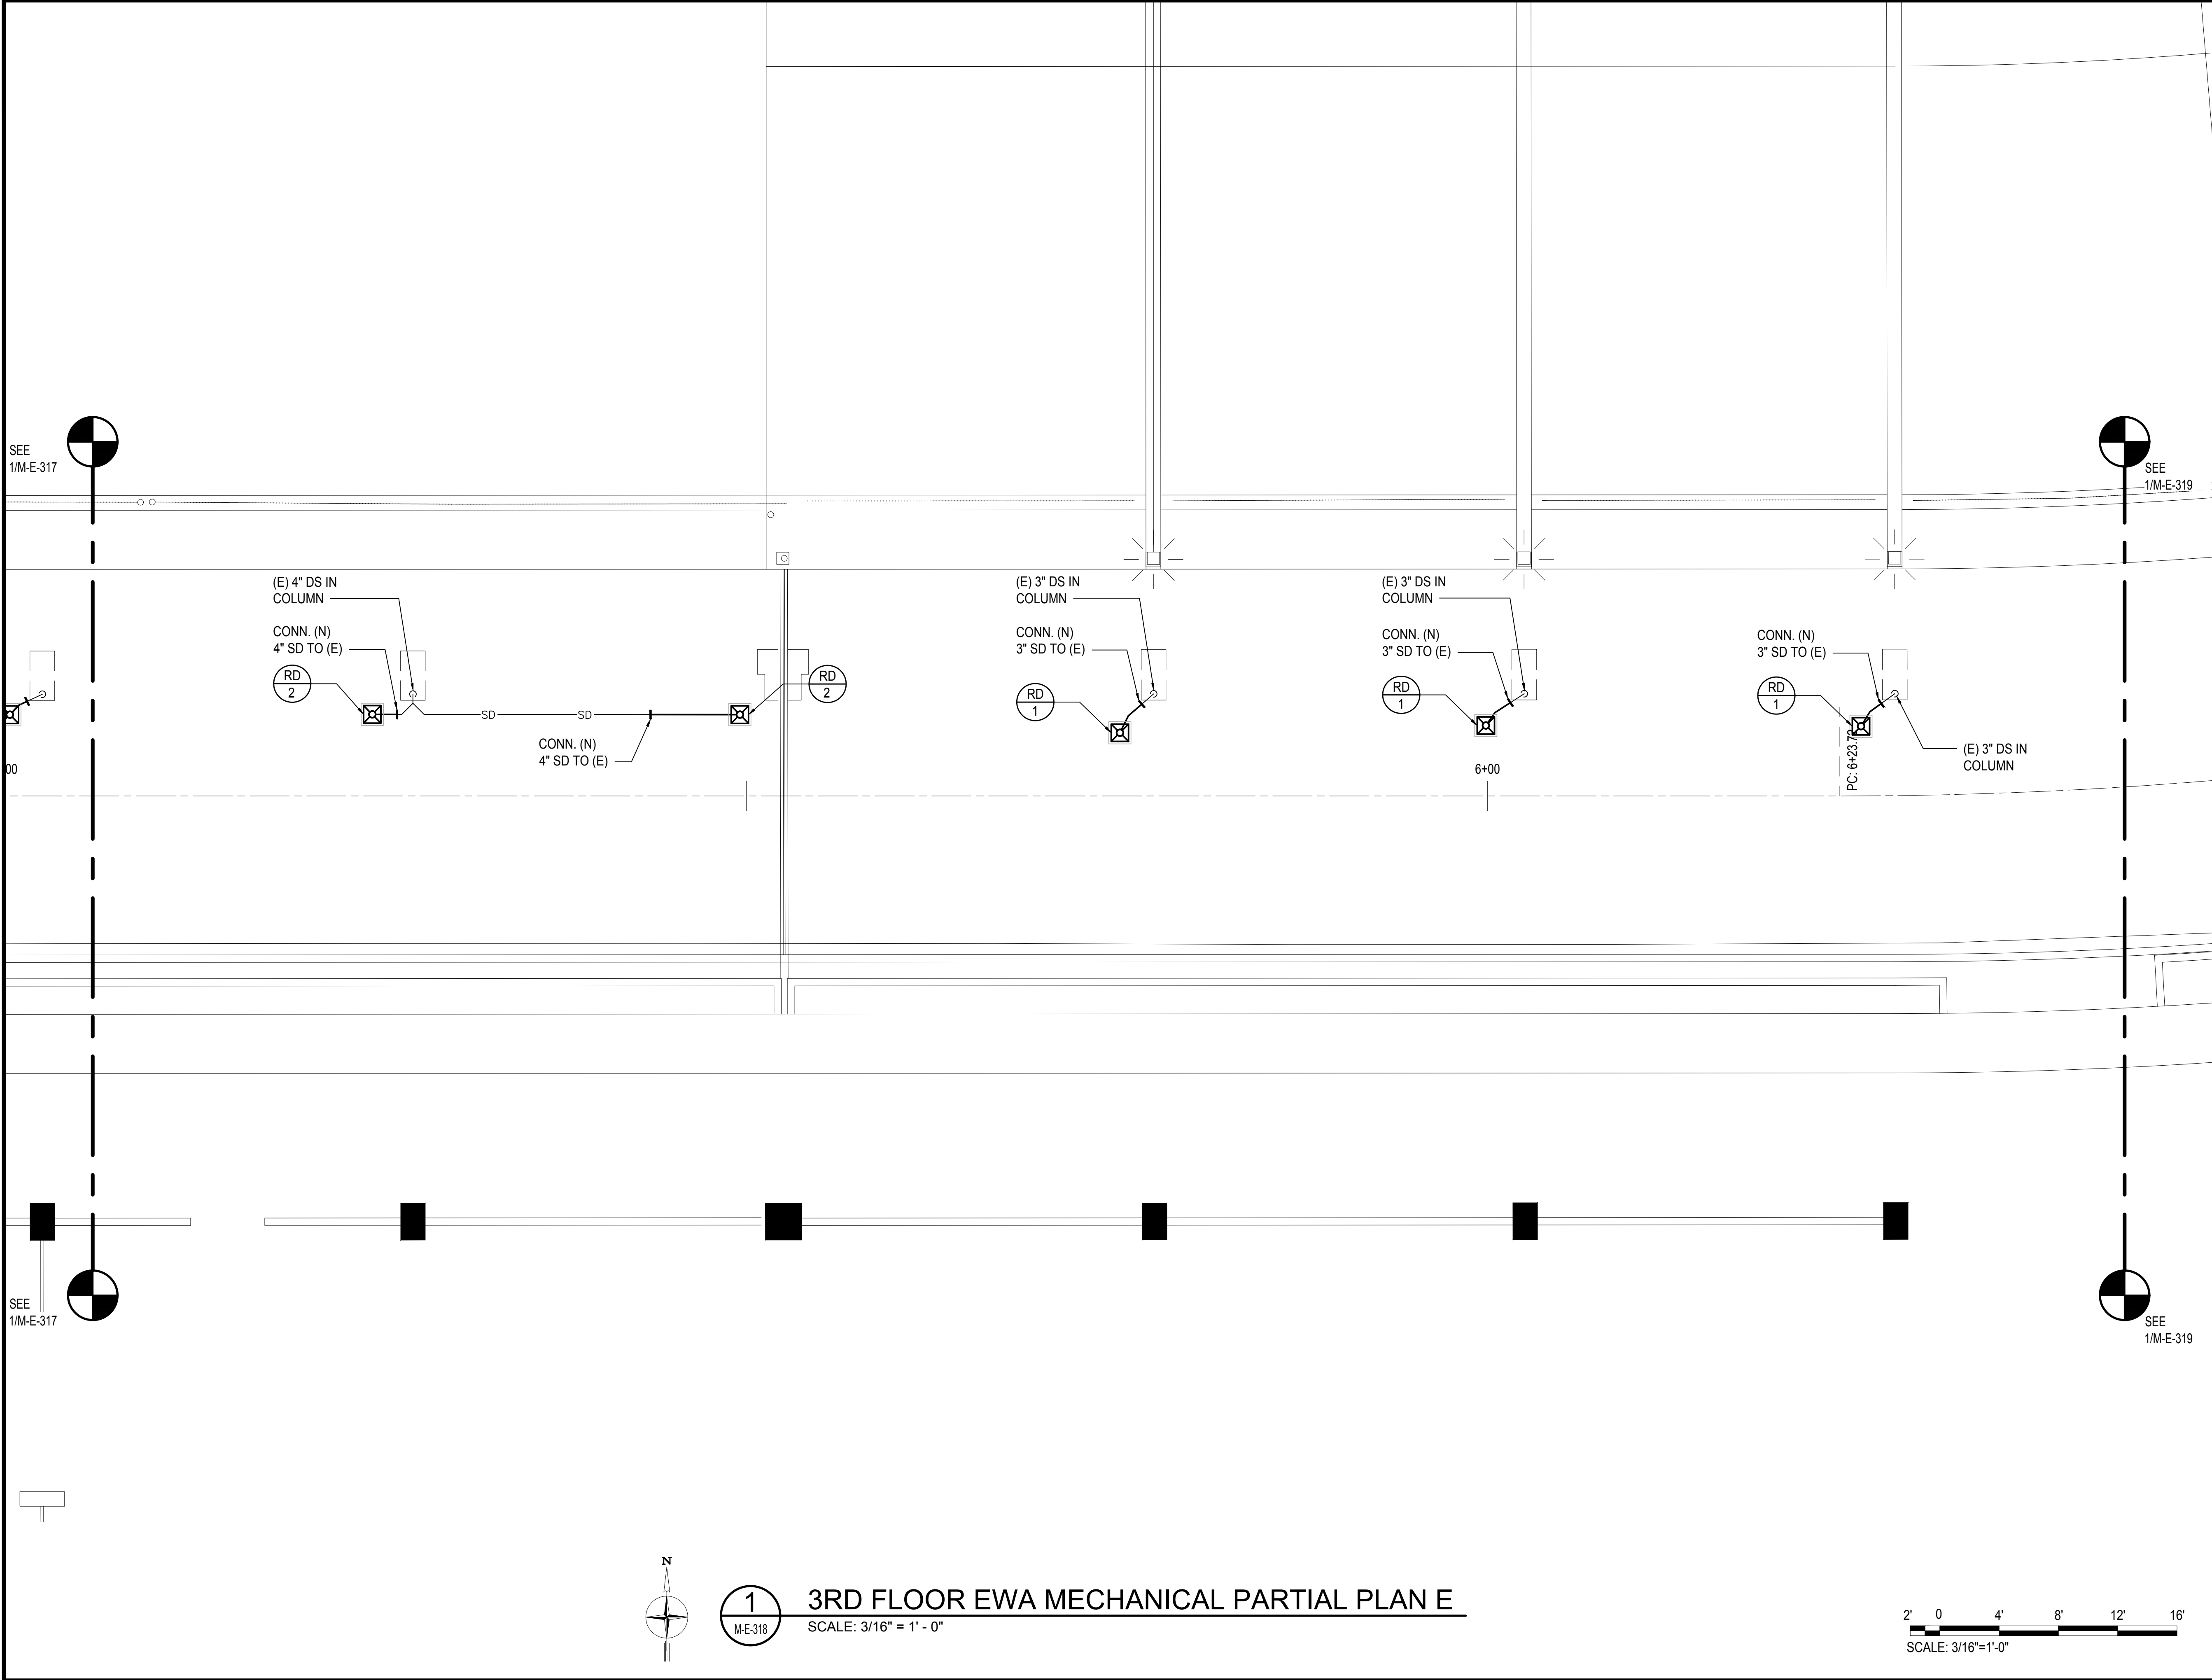

Airports Division
DEPARTMENT OF TRANSPORTATION
STATE OF HAWAII




THIS WORK WAS PREPARED BY ME OR UNDER MY SUPERVISION
AND CONSTRUCTION OF THIS PROJECT WILL BE UNDER MY
OBSERVATION.

Tyson T. Toyama
SIGNATURE

04/30/2024
EXPIRATION DATE OF THE LICENSE

DSGN.	DRWN.	CHKD.	APPD.
JS/KT	KT/TJ	TTT	TTT

KEY PLAN / NOTES:

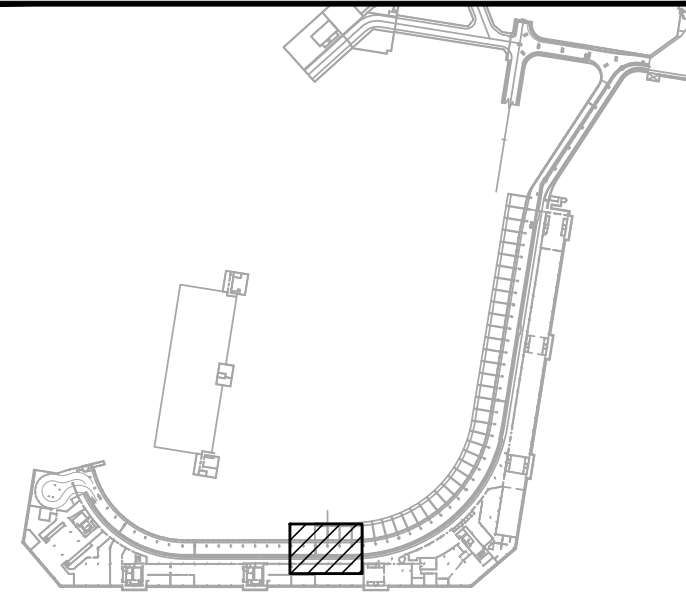

NO.	DATE	REVISIONS

CONSTRUCTION
DOCUMENTS

SEPTEMBER, 2022
DATE

PROJECT TITLE :

EWA AND DH CONCOURSE
ROADWAY IMPROVEMENTS
PHASE 1

AT
DANIEL K. INOUE INTERNATIONAL AIRPORT
HONOLULU, OAHU, HAWAII

PROJECT NO.:

AO1043-32

SHEET TITLE:

3RD FLOOR EWA
MECHANICAL PARTIAL PLAN E

DATE :


SEPTEMBER, 2022

SHEET :

174 OF 247 SHEETS

DWG. NO.


M-E-318

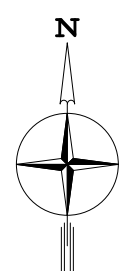

1
M-E-318



3RD FLOOR EWA MECHANICAL PARTIAL PLAN E

SCALE: 3/16" = 1' - 0"

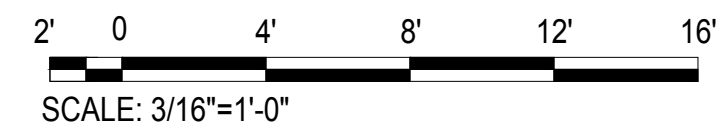

SCALE: 3/16"=1'-0"

M:\PROJECTS\2020\DOTA EWA DH ROADWAY\DRAWINGS\HNL 3RD LEVEL - MECHANICAL\PLANS\LWG

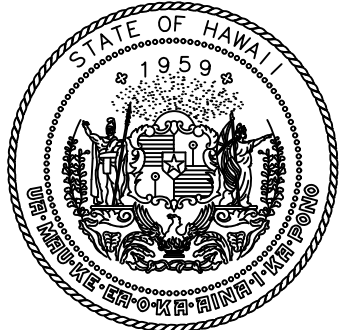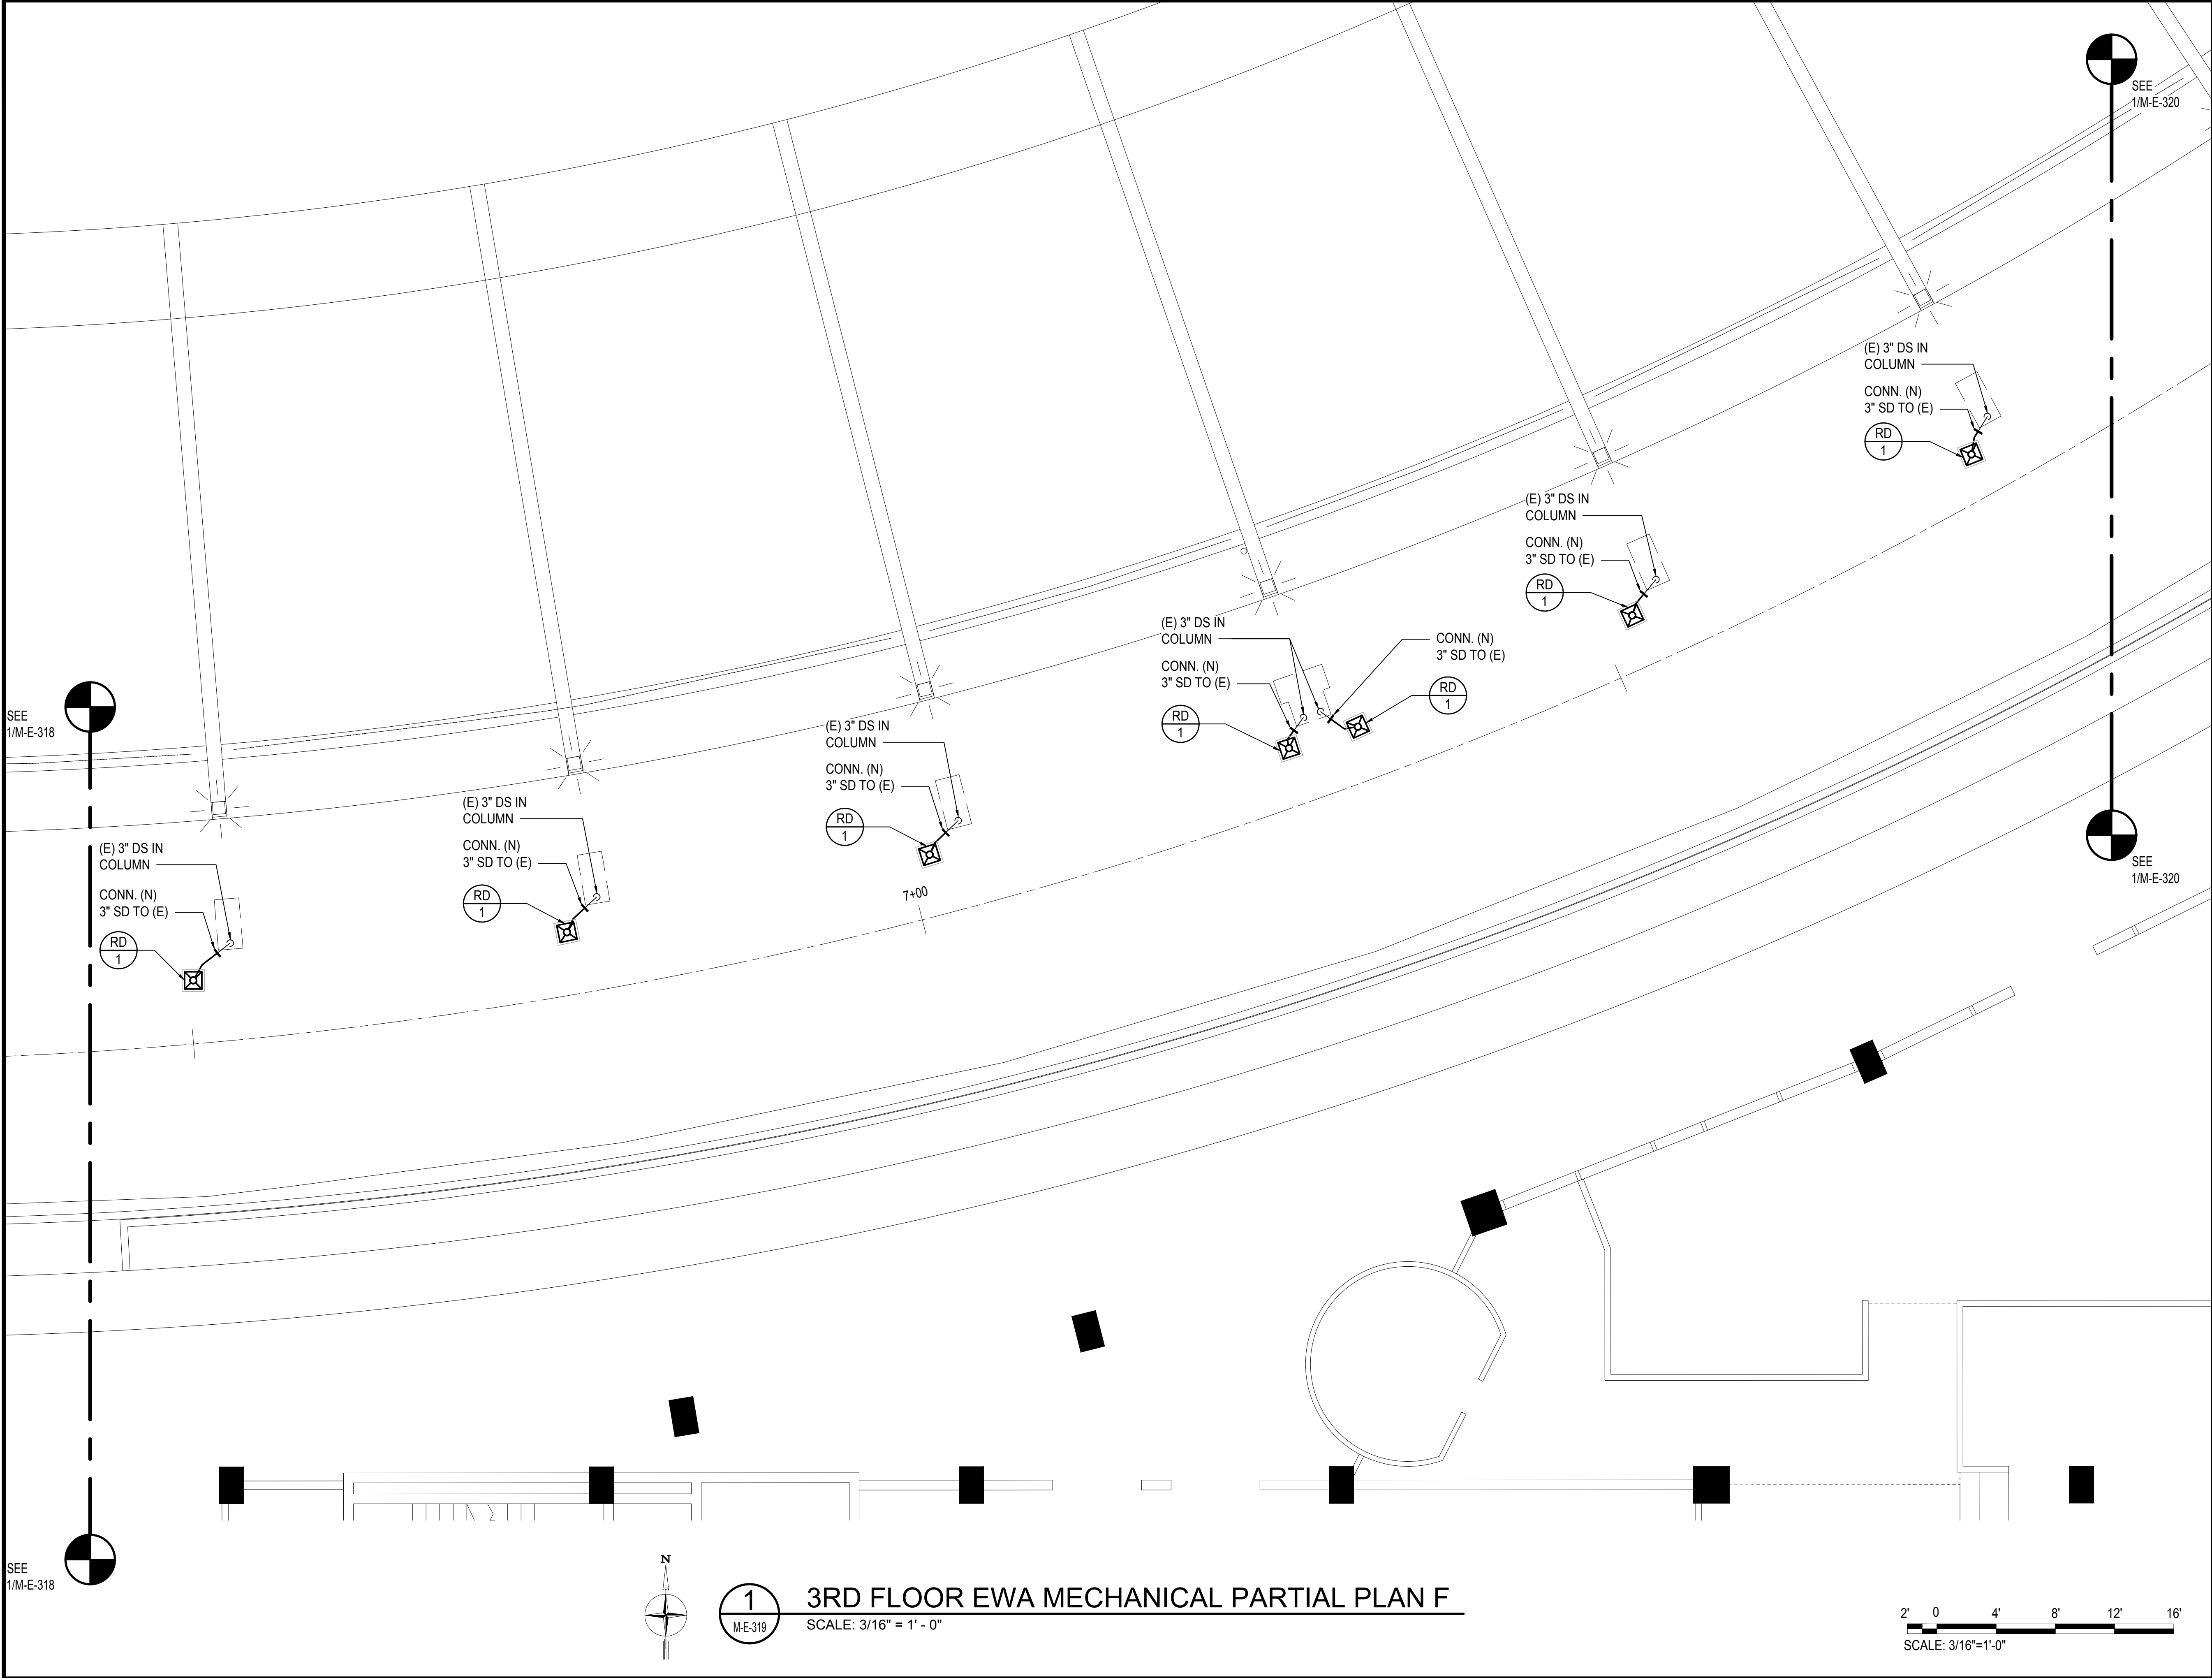

Airports Division
DEPARTMENT OF TRANSPORTATION
STATE OF HAWAII




THIS WORK WAS PREPARED BY ME OR UNDER MY SUPERVISION
AND CONSTRUCTION OF THIS PROJECT WILL BE UNDER MY
OBSERVATION.

Tyson T. Toyama
SIGNATURE

04/30/2024
EXPIRATION DATE OF THE LICENSE

DSGN.	DRWN.	CHKD.	APPD.
JS/KT	KT/TJ	TTT	TTT

KEY PLAN / NOTES:

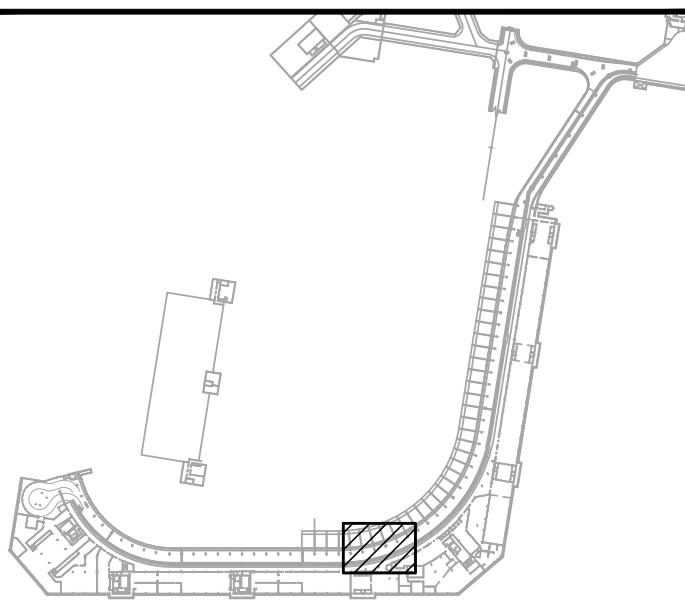

NO.	DATE	REVISIONS
-----	------	-----------

CONSTRUCTION
DOCUMENTS

SEPTEMBER, 2022
DATE

PROJECT TITLE :

EWA AND DH CONCOURSE
ROADWAY IMPROVEMENTS
PHASE 1

AT
DANIEL K. INOUE INTERNATIONAL AIRPORT
HONOLULU, OAHU, HAWAII

PROJECT NO.:

AO1043-32

SHEET TITLE:

3RD FLOOR EWA
MECHANICAL PARTIAL PLAN F

DATE :


SEPTEMBER, 2022

SHEET :


175 OF 247 SHEETS

DWG. NO.

M-E-319

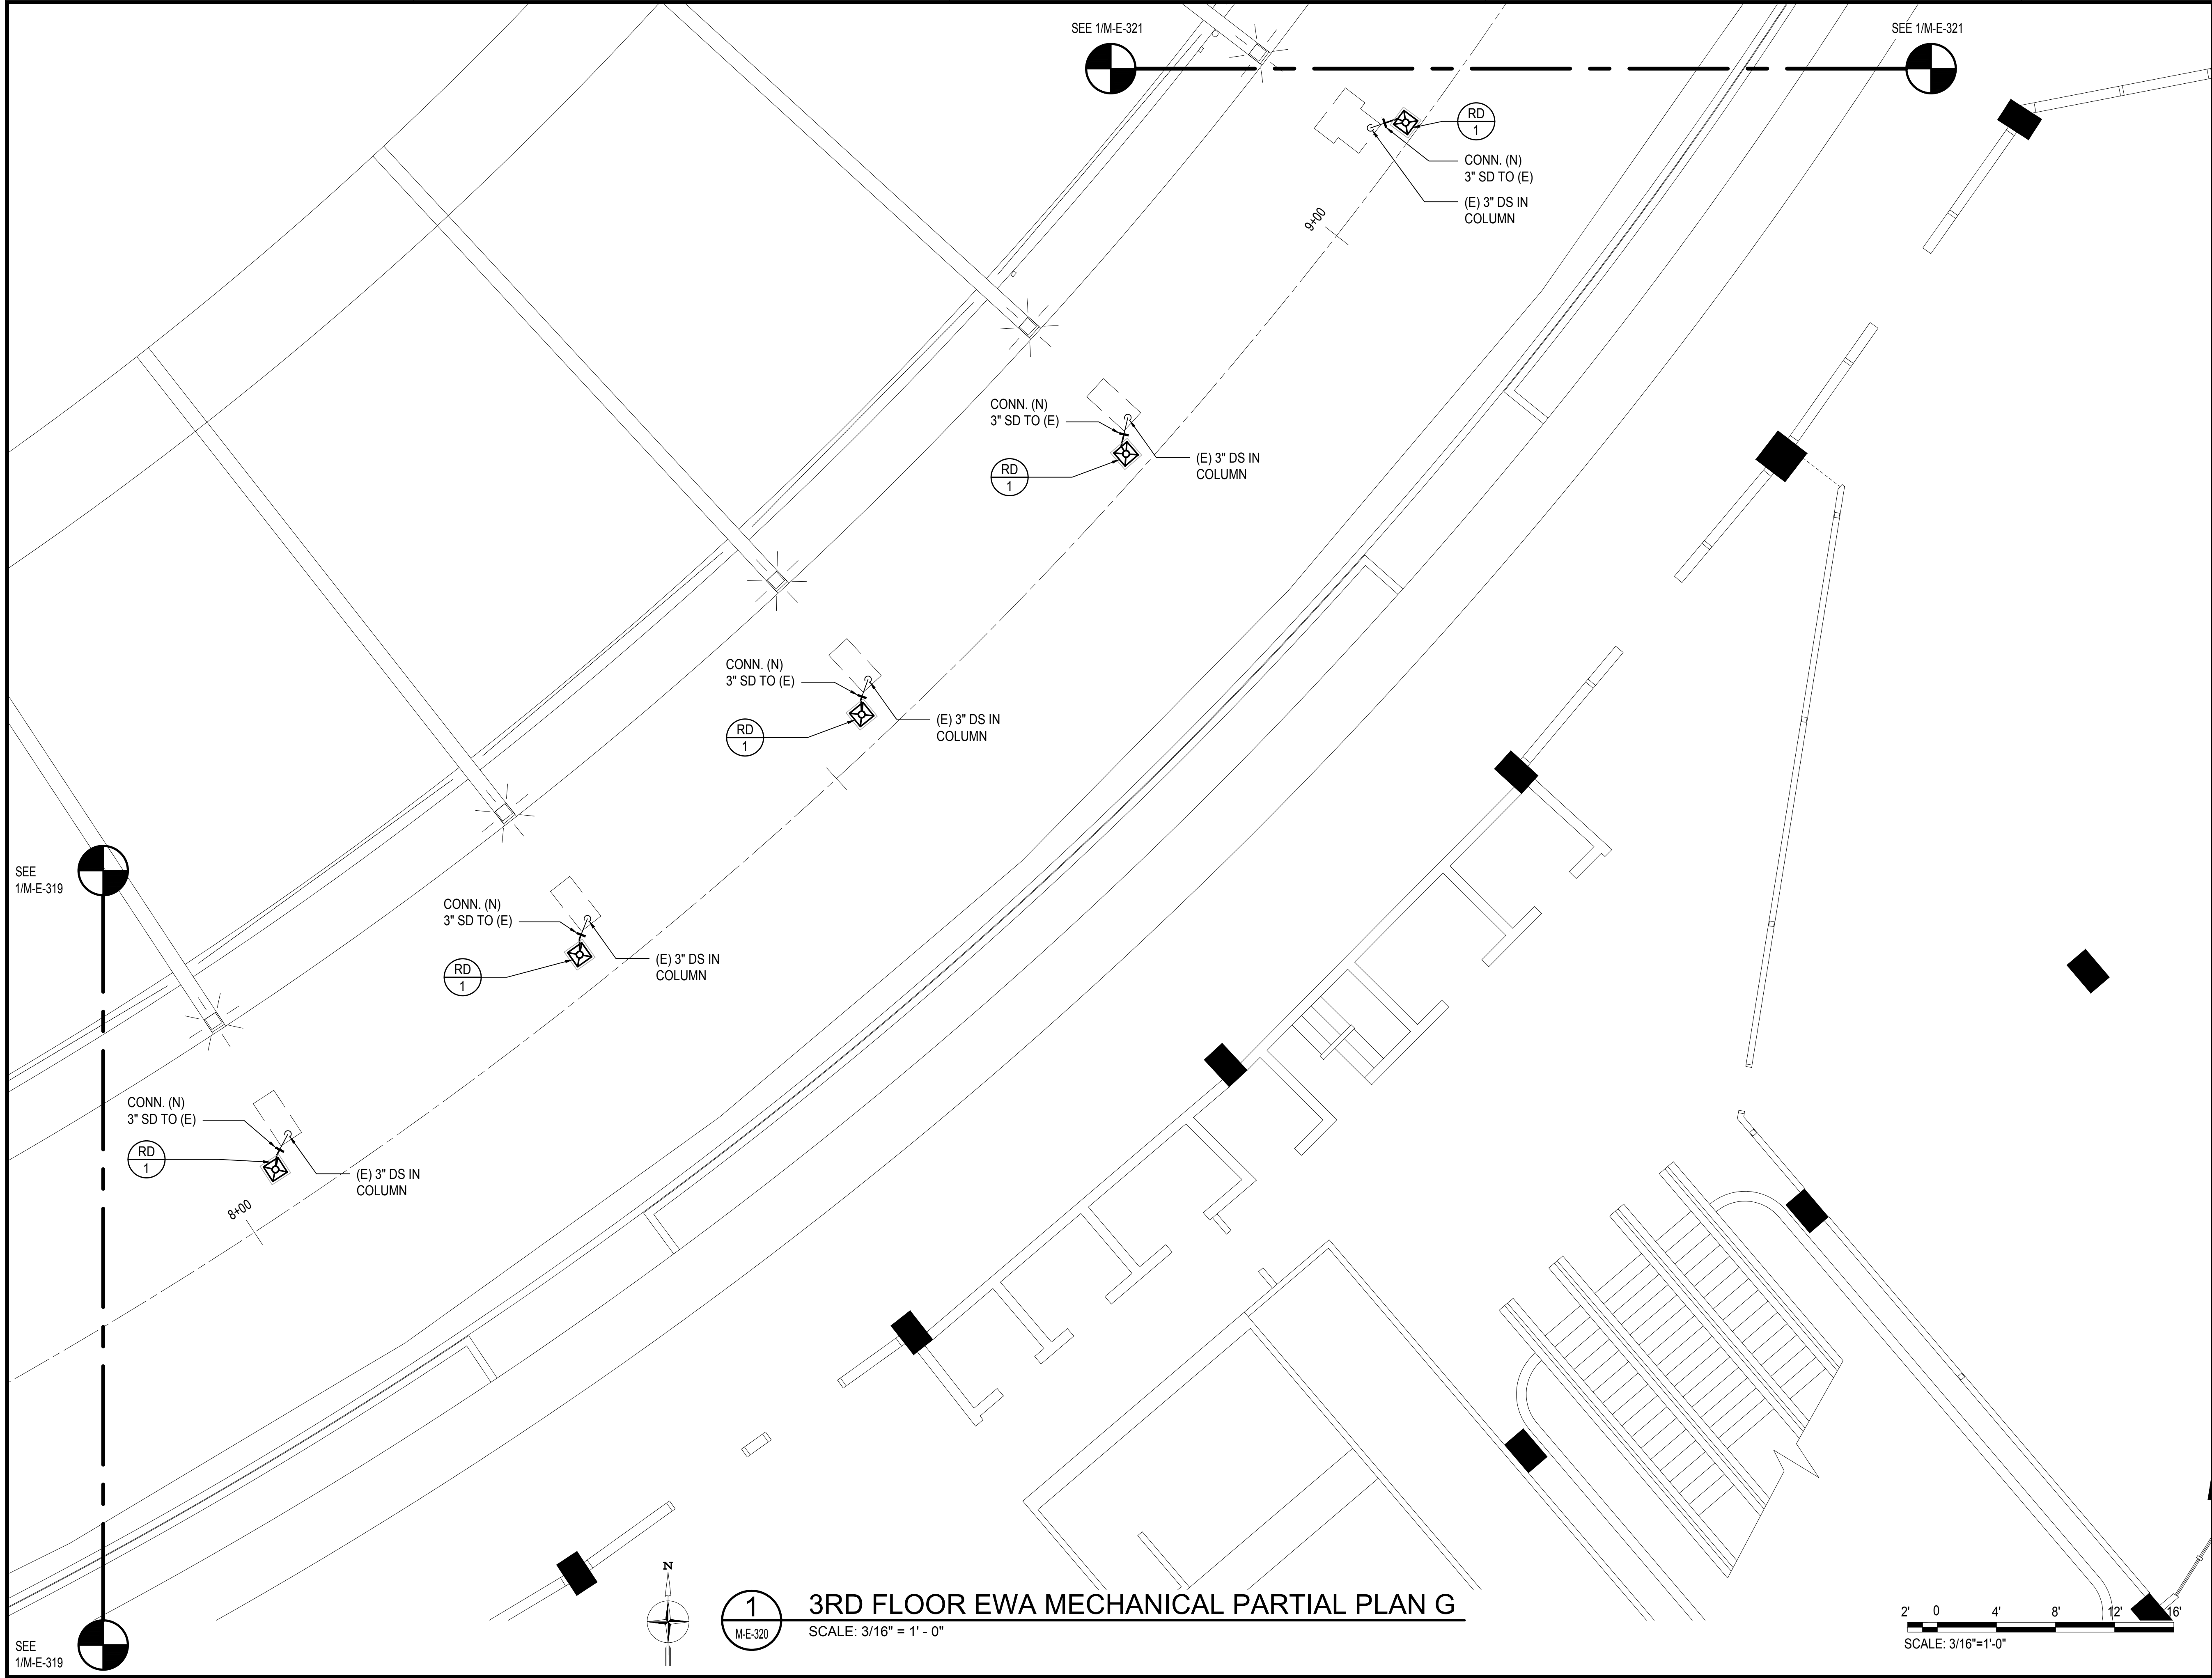

Airports Division
DEPARTMENT OF TRANSPORTATION
STATE OF HAWAII

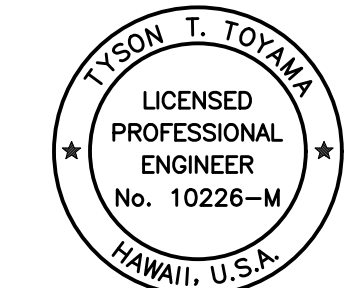


THIS WORK WAS PREPARED BY ME OR UNDER MY SUPERVISION
AND CONSTRUCTION OF THIS PROJECT WILL BE UNDER MY
OBSERVATION.

Tyson T. Toyama
SIGNATURE

04/30/2024
EXPIRATION DATE OF THE LICENSE

DSGN.	DRWN.	CHKD.	APPD.
JS/KT	KT/TJ	TTT	TTT

KEY PLAN / NOTES:

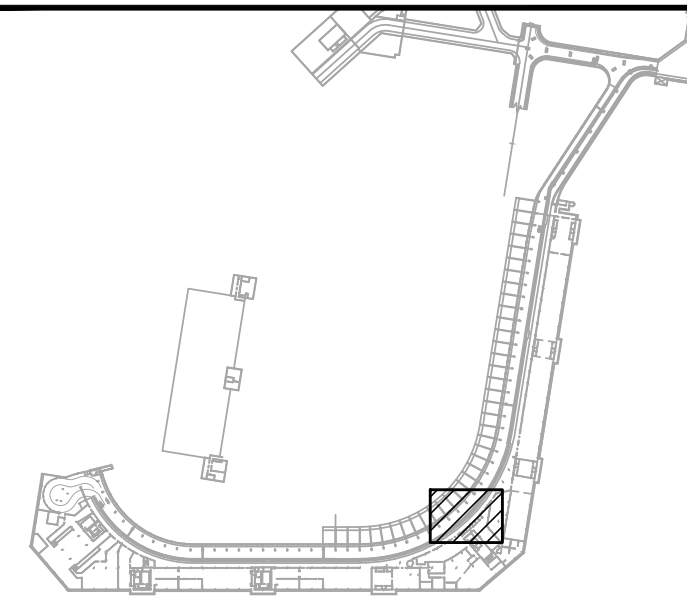

NO.	DATE	REVISIONS
-----	------	-----------

CONSTRUCTION DOCUMENTS

SEPTEMBER, 2022
DATE

PROJECT TITLE : EWA AND DH CONCOURSE ROADWAY IMPROVEMENTS PHASE 1

AT
DANIEL K. INOUE INTERNATIONAL AIRPORT
HONOLULU, OAHU, HAWAII



PROJECT NO.:

AO1043-32

SHEET TITLE:

3RD FLOOR EWA
MECHANICAL PARTIAL PLAN G

DATE :	DWG. NO.
SEPTEMBER, 2022	M-E-320
SHEET :	
176 OF 247 SHEETS	

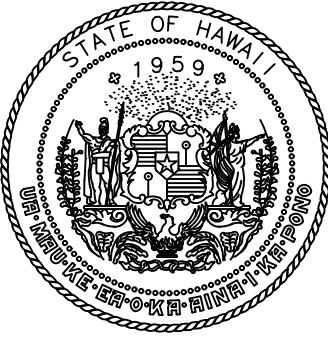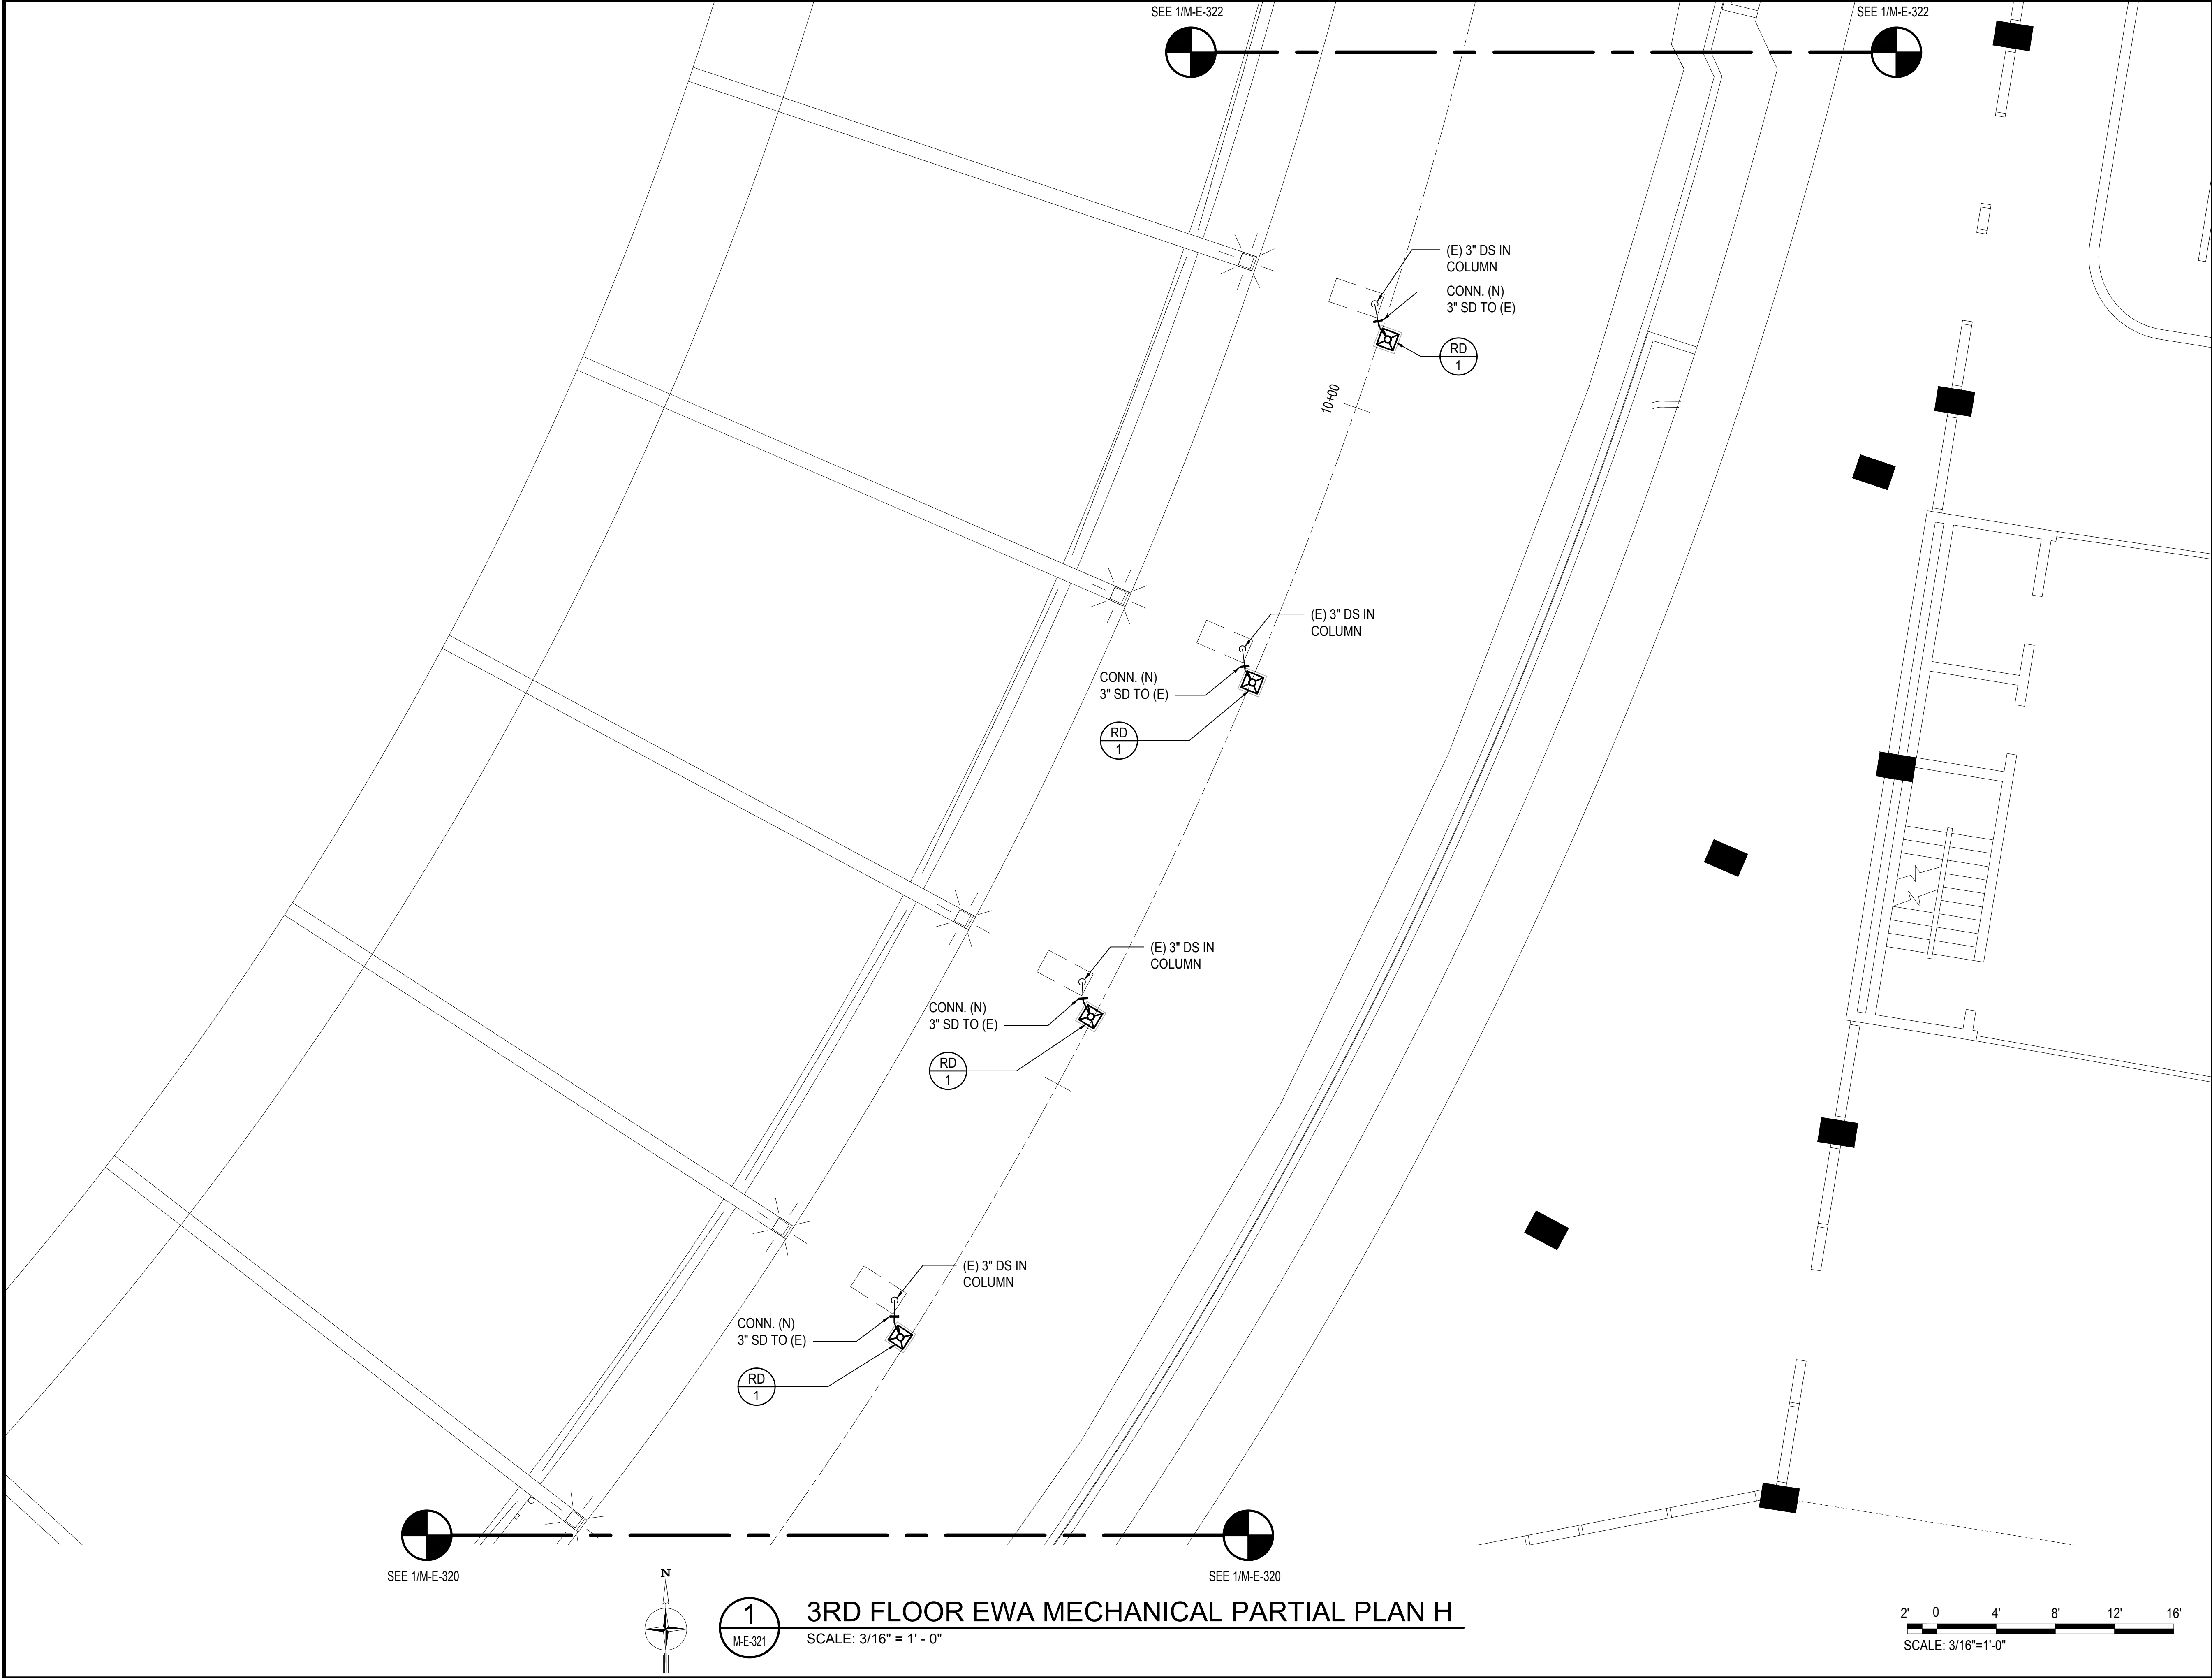

Airports Division
DEPARTMENT OF TRANSPORTATION
STATE OF HAWAII




THIS WORK WAS PREPARED BY ME OR UNDER MY SUPERVISION
AND CONSTRUCTION OF THIS PROJECT WILL BE UNDER MY
OBSERVATION.

Tyson T. Toyama
SIGNATURE

04/30/2024
EXPIRATION DATE OF THE LICENSE

DSGN.	DRWN.	CHKD.	APPD.
JS/KT	KT/TJ	TTT	TTT

KEY PLAN / NOTES:

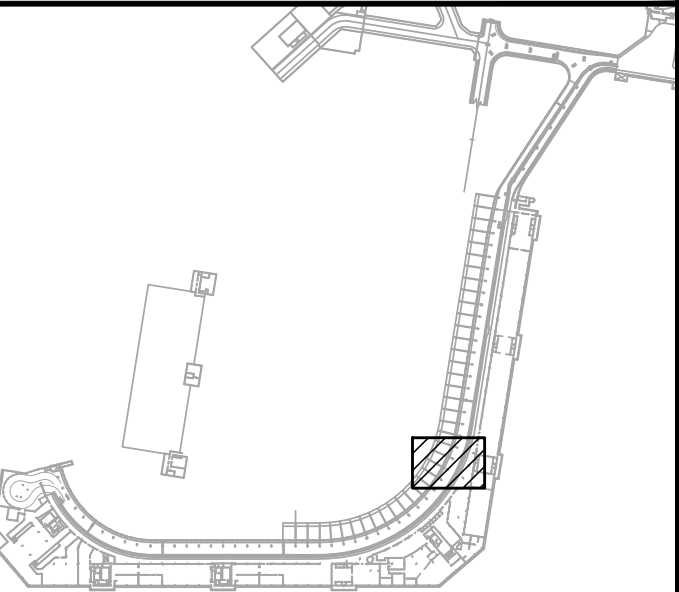

NO.	DATE	REVISIONS

CONSTRUCTION DOCUMENTS
SEPTEMBER, 2022
DATE

PROJECT TITLE :
EWA AND DH CONCOURSE
ROADWAY IMPROVEMENTS
PHASE 1
AT
DANIEL K. INOUE INTERNATIONAL AIRPORT
HONOLULU, OAHU, HAWAII

PROJECT NO.:
AO1043-32


SHEET TITLE:

3RD FLOOR EWA
MECHANICAL PARTIAL PLAN H

DATE : SEPTEMBER, 2022	DWG. NO. M-E-321
SHEET : 177 OF 247 SHEETS	


SEE 1/M-E-320


SEE 1/M-E-320

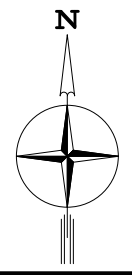

1
M-E-321

3RD FLOOR EWA MECHANICAL PARTIAL PLAN H
SCALE: 3/16" = 1' - 0"

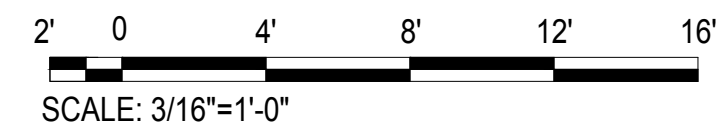

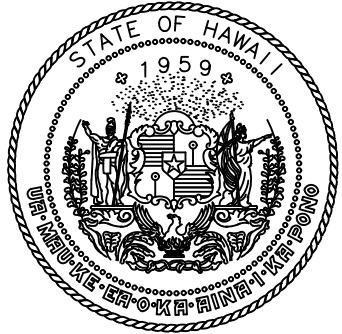

Airports Division
DEPARTMENT OF TRANSPORTATION
STATE OF HAWAII




THIS WORK WAS PREPARED BY ME OR UNDER MY SUPERVISION
AND CONSTRUCTION OF THIS PROJECT WILL BE UNDER MY
OBSERVATION.

Tyson T. Toyama
SIGNATURE

04/30/2024
EXPIRATION DATE OF THE LICENSE

DSGN.	DRWN.	CHKD.	APPD.
JS/KT	KT/TJ	TTT	TTT

KEY PLAN / NOTES:

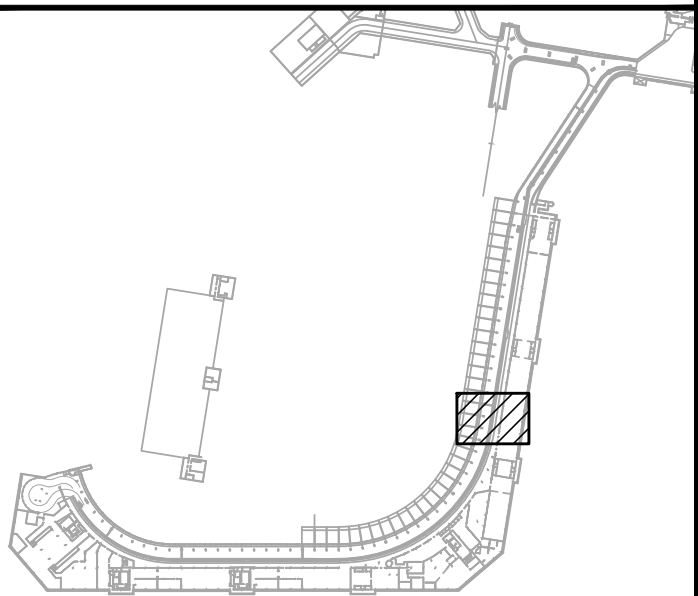

NO.	DATE	REVISIONS

CONSTRUCTION
DOCUMENTS

SEPTEMBER, 2022
DATE

PROJECT TITLE :

EWA AND DH CONCOURSE
ROADWAY IMPROVEMENTS
PHASE 1

AT
DANIEL K. INOUE INTERNATIONAL AIRPORT
HONOLULU, OAHU, HAWAII

PROJECT NO.:

AO1043-32

SHEET TITLE:

3RD FLOOR EWA
MECHANICAL PARTIAL PLAN I

DATE :
SEPTEMBER, 2022
SHEET :

DWG. NO.

M-E-322

178 OF 247 SHEETS

SEE 1/M-E-323

SEE 1/M-E-323

CONN. (N)
3" SD TO (E)

RD
1

(E) 3" DS IN
COLUMN

11+00

(E) 3" DS IN
COLUMN

CONN. (N)
3" SD TO (E)

RD
1

(E) 3" DS IN
COLUMN

CONN. (N)
3" SD TO (E)

PT: 10+53.49

RD
1

 
(E) 3" DS IN
COLUMN

CONN. (N)
3" SD TO (E)

RD
1

SEE 1/M-E-321

SEE 1/M-E-321





1
M-E-322


3RD FLOOR EWA MECHANICAL PARTIAL PLAN I

SCALE: 3/16" = 1' - 0"

2' 0' 4' 8' 12' 16'
SCALE: 3/16"=1'-0"

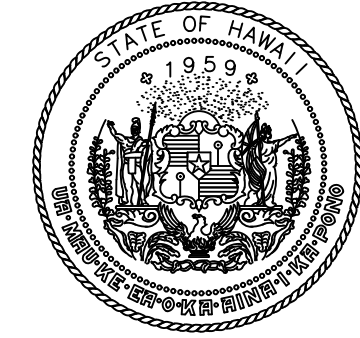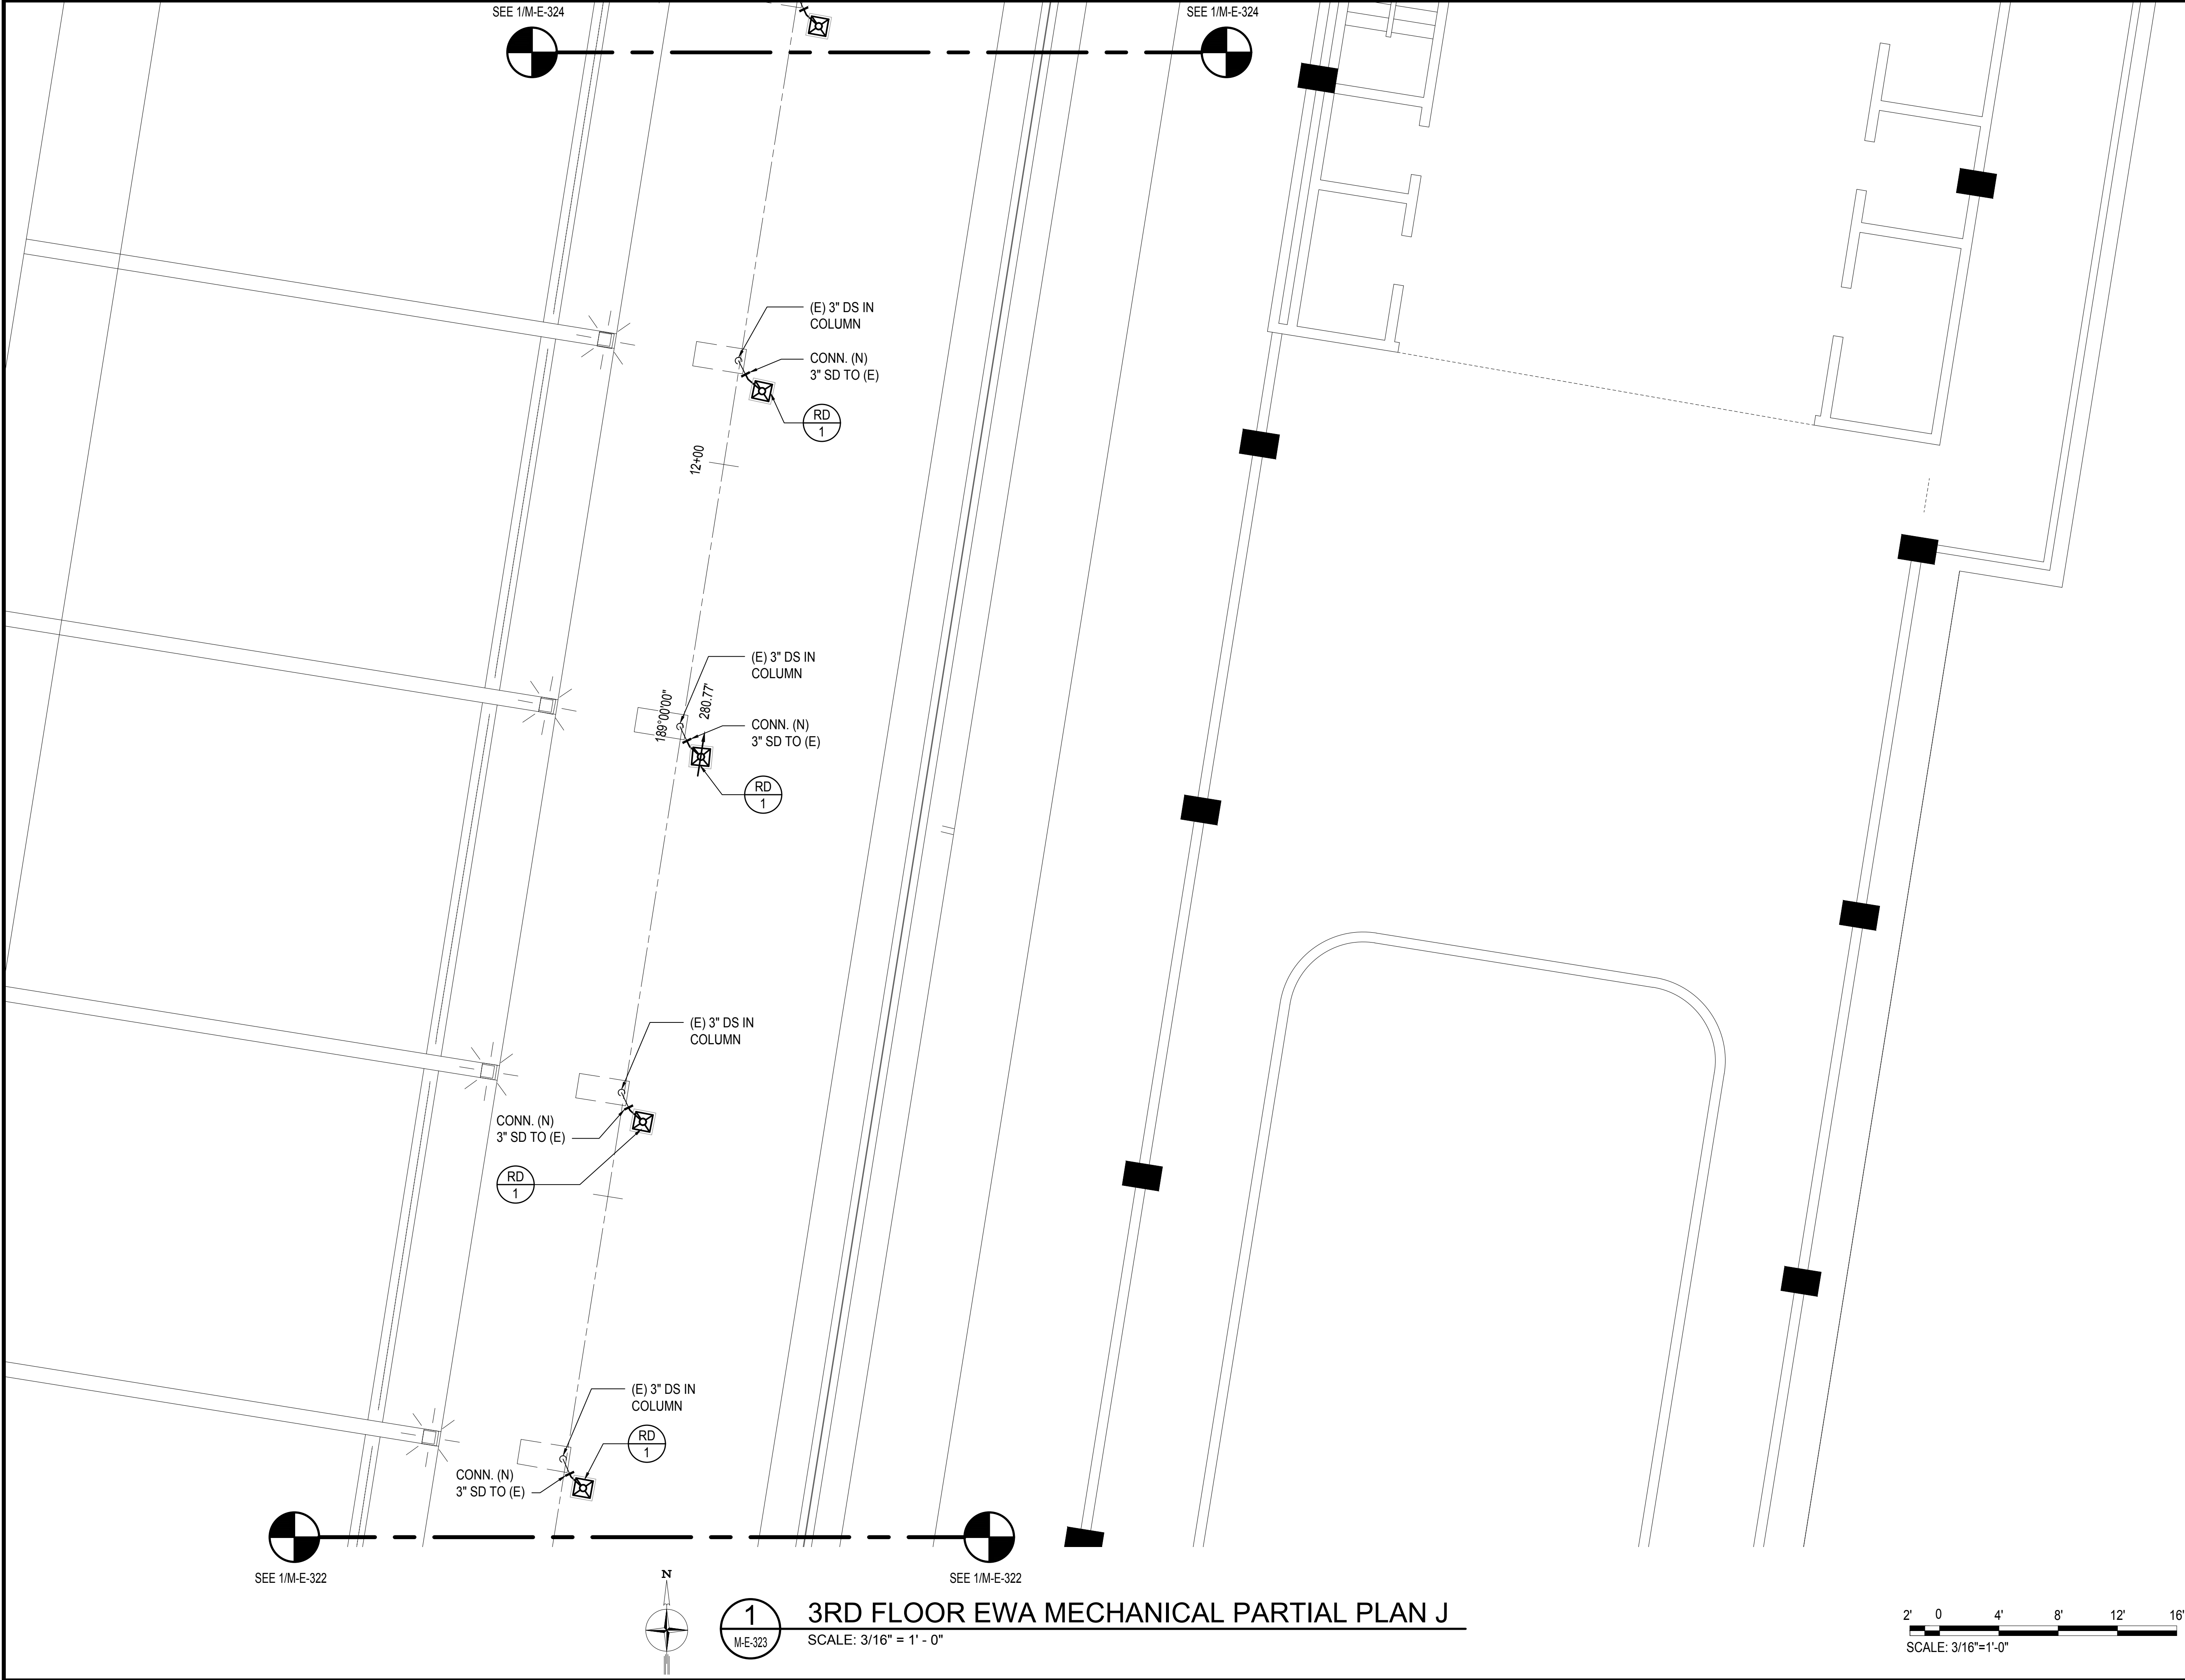

Airports Division
DEPARTMENT OF TRANSPORTATION
STATE OF HAWAII

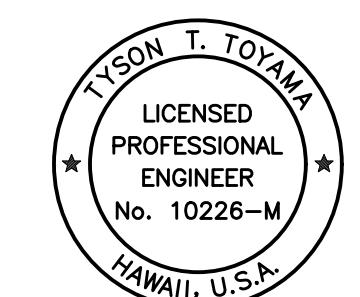


THIS WORK WAS PREPARED BY ME OR UNDER MY SUPERVISION
AND CONSTRUCTION OF THIS PROJECT WILL BE UNDER MY
OBSERVATION.

SIGNATURE: *Tyson T. Toyama* EXPIRATION DATE OF THE LICENSE: 04/30/2024

DSGN.	DRWN.	CHKD.	APPD.
JS/KT	KT/TJ	TTT	TTT

KEY PLAN / NOTES:

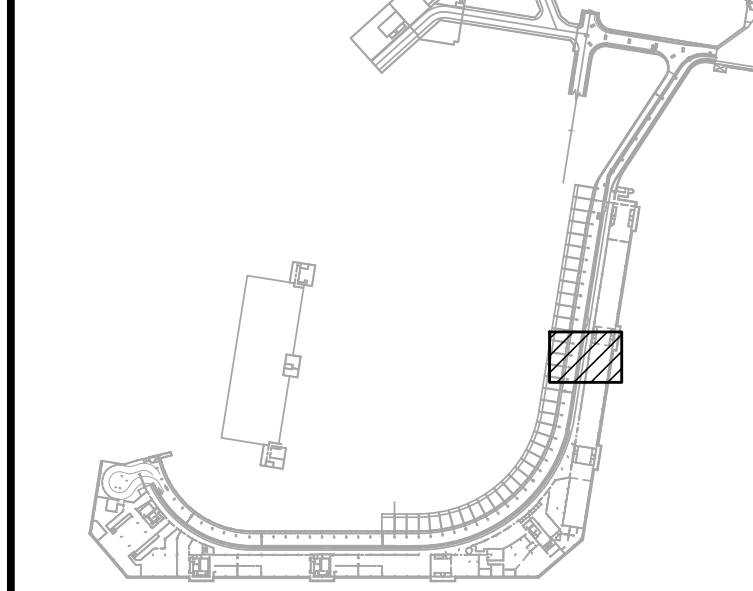

NO.	DATE	REVISIONS
-----	------	-----------

CONSTRUCTION DOCUMENTS
SEPTEMBER, 2022
DATE

PROJECT TITLE :

EWA AND DH CONCOURSE
ROADWAY IMPROVEMENTS
PHASE 1

AT
DANIEL K. INOUE INTERNATIONAL AIRPORT
HONOLULU, OAHU, HAWAII



PROJECT NO.:

AO1043-32

SHEET TITLE:

3RD FLOOR EWA
MECHANICAL PARTIAL PLAN J

DATE :	DWG. NO.
SEPTEMBER, 2022	M-E-323
SHEET :	
179 OF 247 SHEETS	

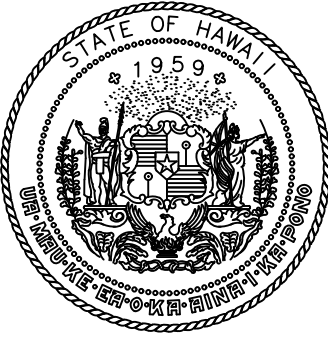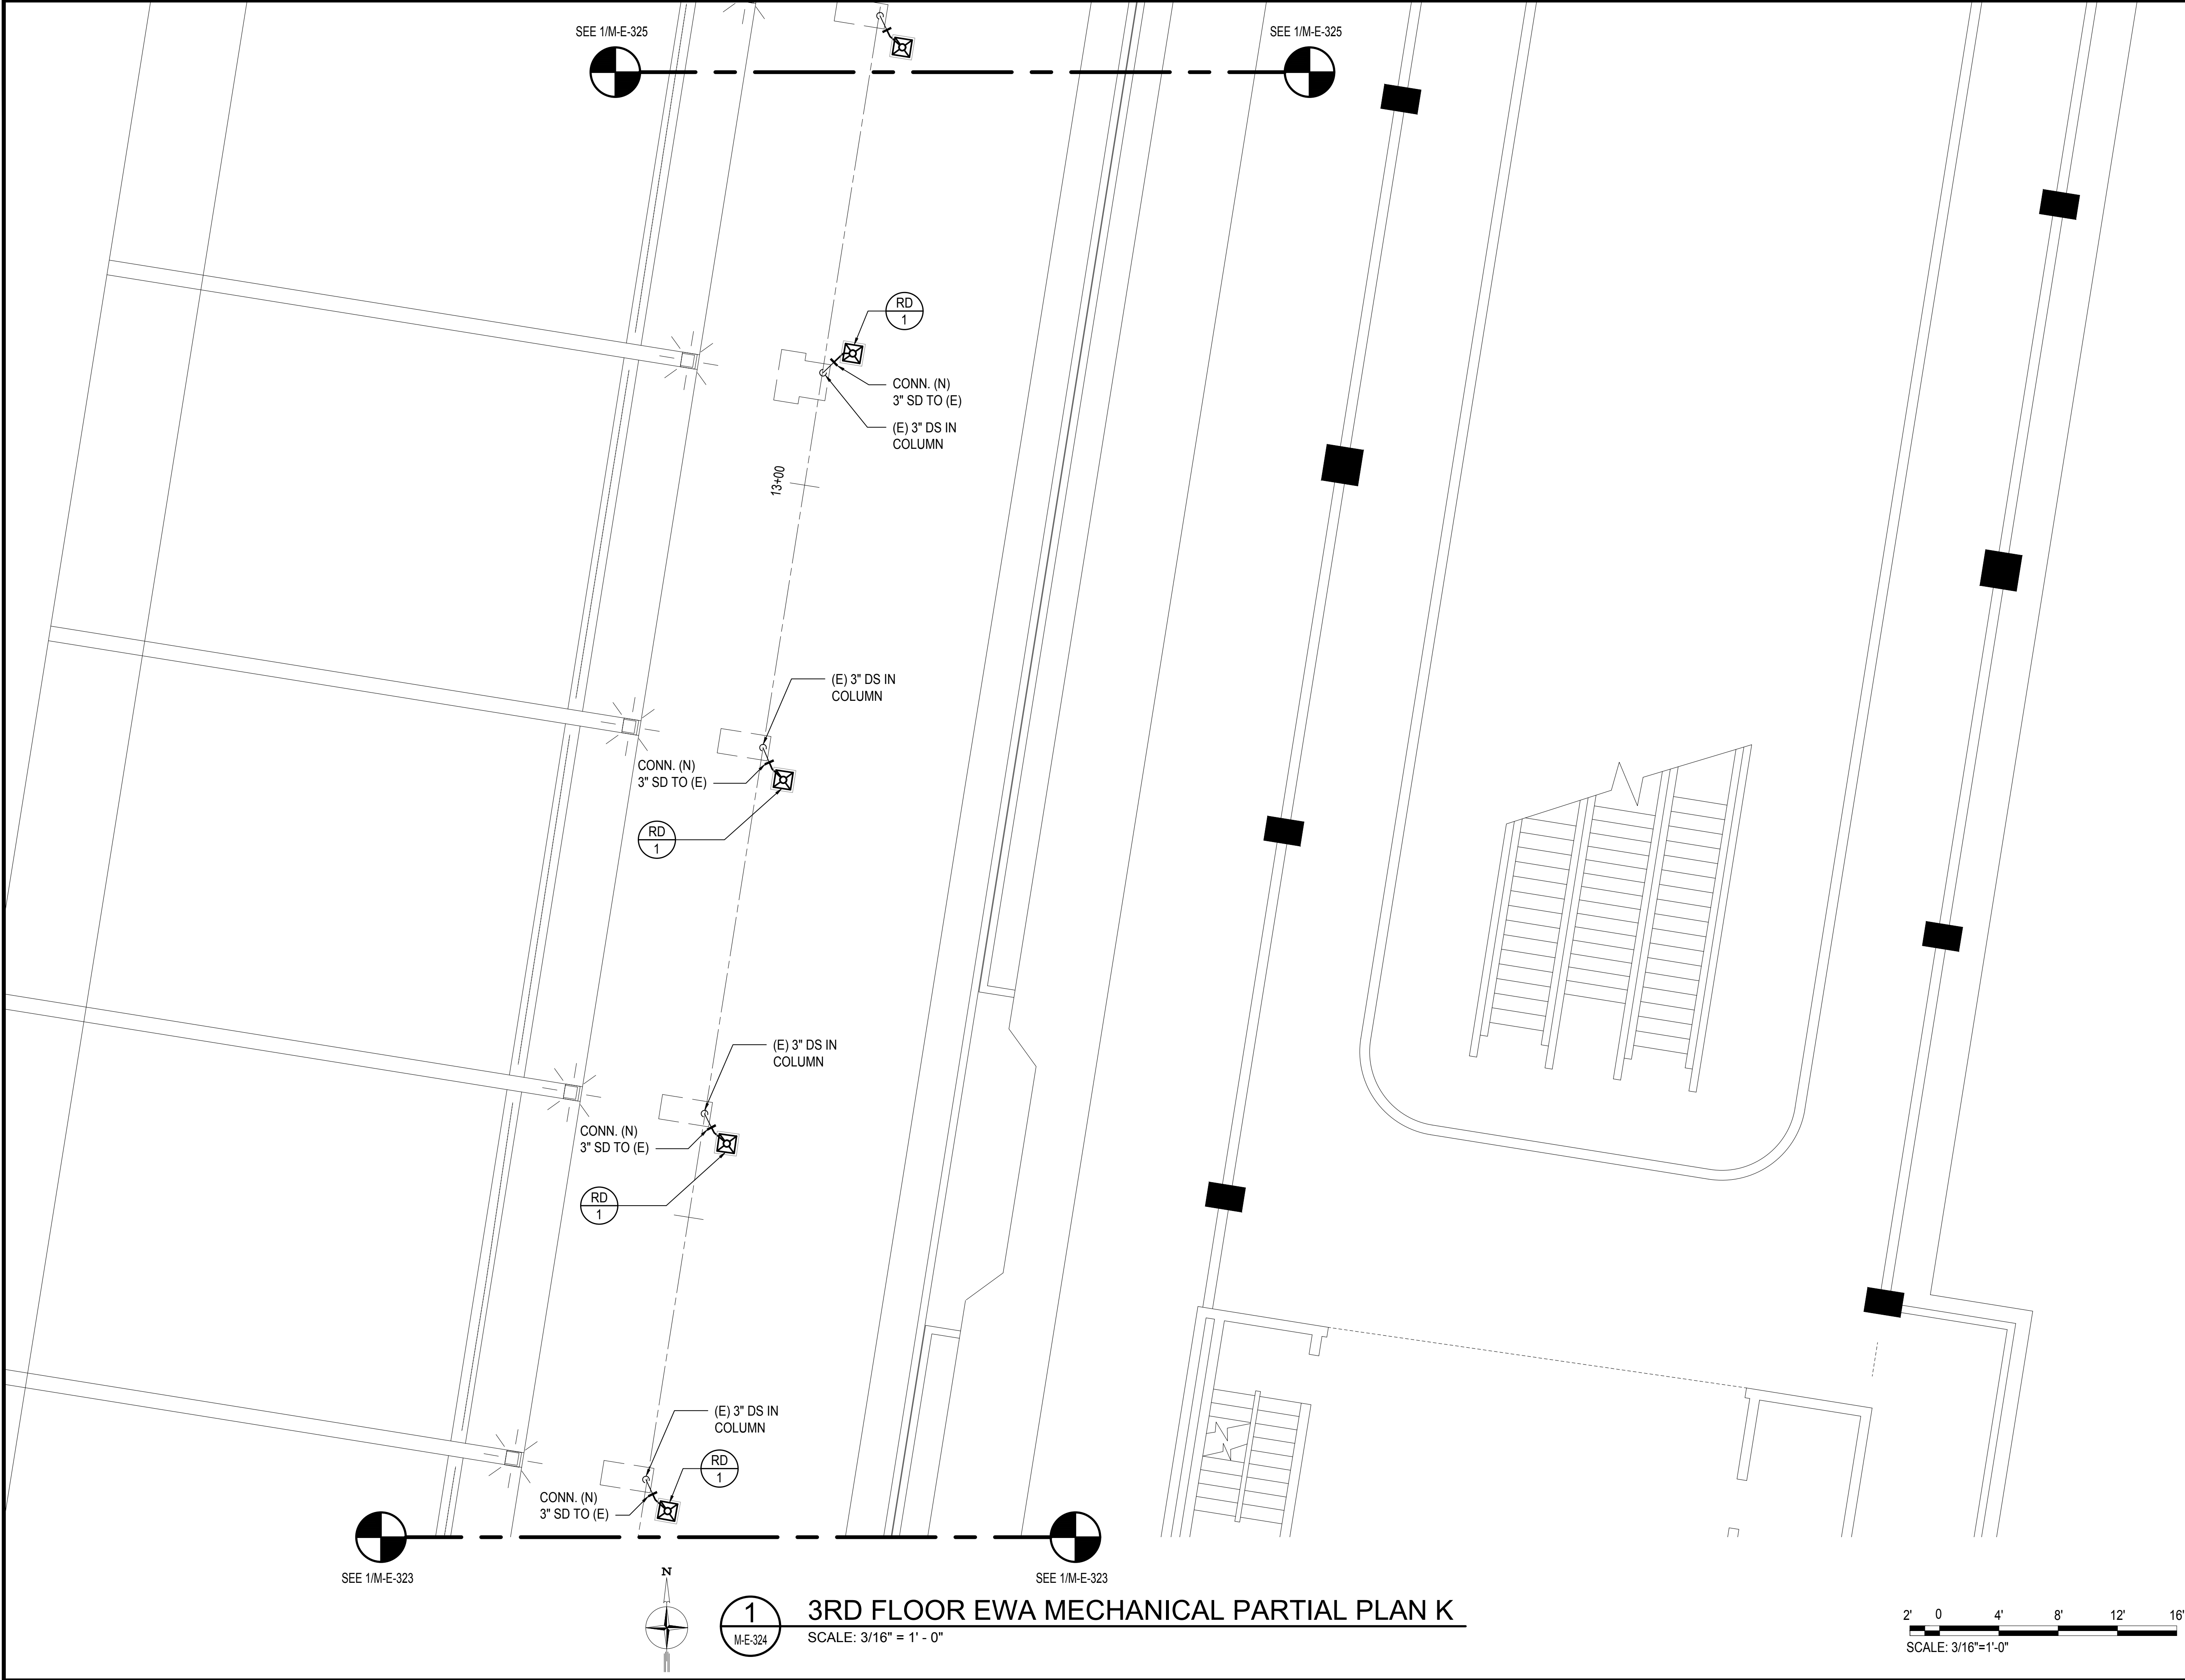

Airports Division
DEPARTMENT OF TRANSPORTATION
STATE OF HAWAII




THIS WORK WAS PREPARED BY ME OR UNDER MY SUPERVISION
AND CONSTRUCTION OF THIS PROJECT WILL BE UNDER MY
OBSERVATION.

Tyson T. Toyama
SIGNATURE
04/30/2024
EXPIRATION DATE OF THE LICENSE

DSGN.	DRWN.	CHKD.	APPD.
JS/KT	KT/TJ	TTT	TTT

KEY PLAN / NOTES:

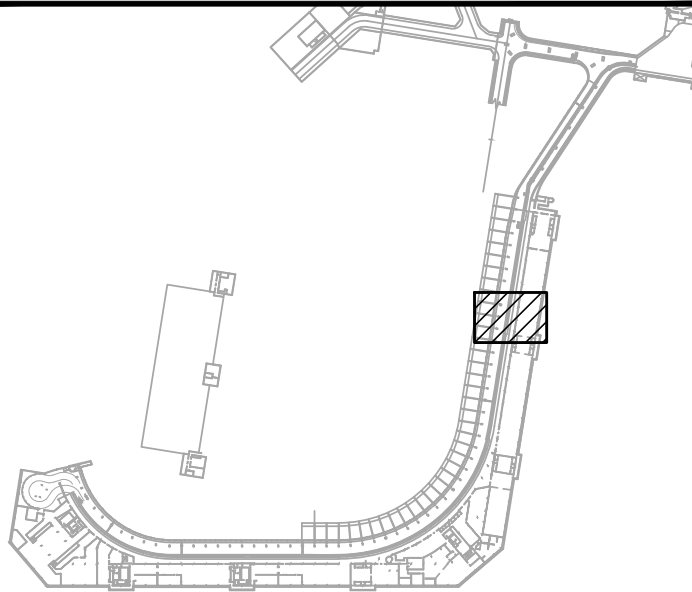

NO.	DATE	REVISIONS

CONSTRUCTION DOCUMENTS
SEPTEMBER, 2022
DATE

PROJECT TITLE :
EWA AND DH CONCOURSE
ROADWAY IMPROVEMENTS
PHASE 1


AT
DANIEL K. INOUE INTERNATIONAL AIRPORT
HONOLULU, OAHU, HAWAII

PROJECT NO.:
AO1043-32

SHEET TITLE:


3RD FLOOR EWA
MECHANICAL PARTIAL PLAN K

DATE : SEPTEMBER, 2022	DWG. NO. M-E-324
SHEET : 180 OF 247 SHEETS	


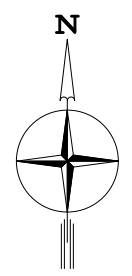


1
M-E-324

3RD FLOOR EWA MECHANICAL PARTIAL PLAN K
SCALE: 3/16" = 1' - 0"

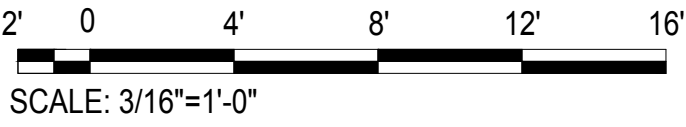

M:\PROJECTS\2020\DOTA EWA DH ROADWAY\DRAWINGS\HNL 3RD LEVEL - MECHANICAL PLANS.DWG

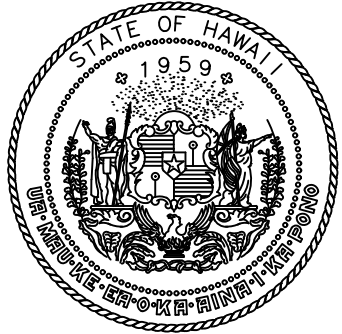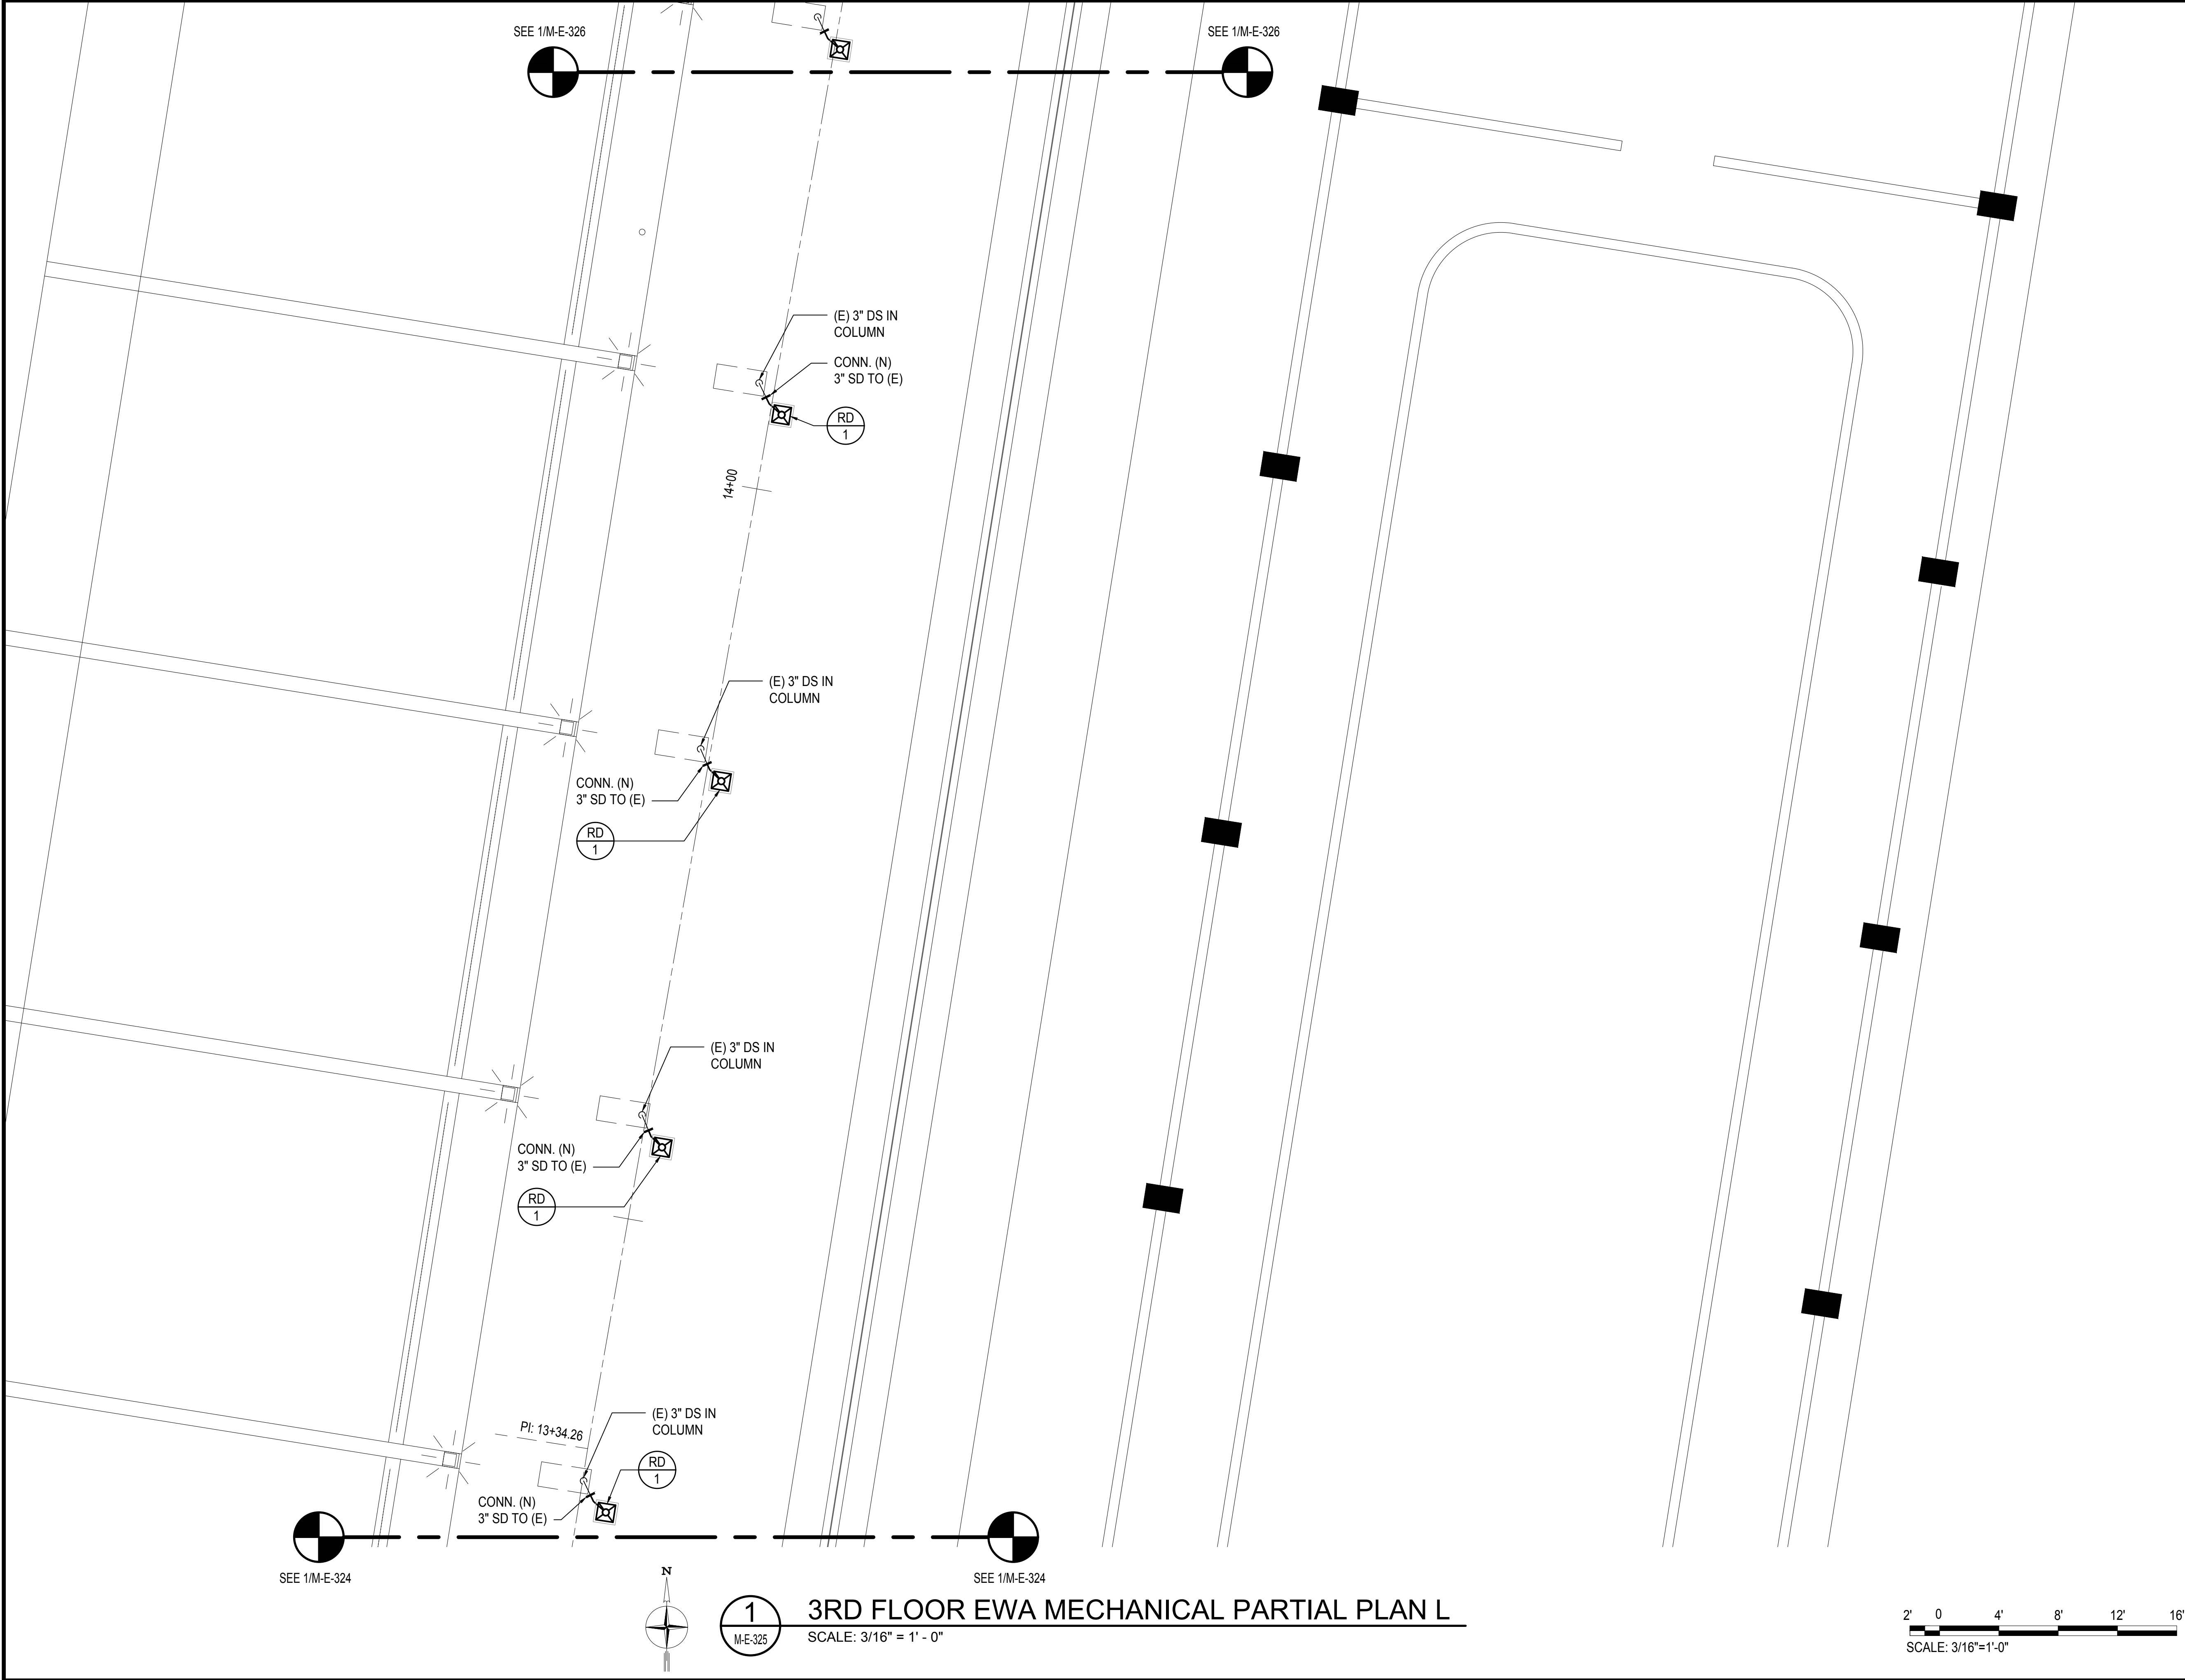

Airports Division
DEPARTMENT OF TRANSPORTATION
STATE OF HAWAII




THIS WORK WAS PREPARED BY ME OR UNDER MY SUPERVISION
AND CONSTRUCTION OF THIS PROJECT WILL BE UNDER MY
OBSERVATION.

Tyson T. Toyama
SIGNATURE

04/30/2024
EXPIRATION DATE OF THE LICENSE

DSGN.	DRWN.	CHKD.	APPD.
JS/KT	KT/TJ	TTT	TTT

KEY PLAN / NOTES:

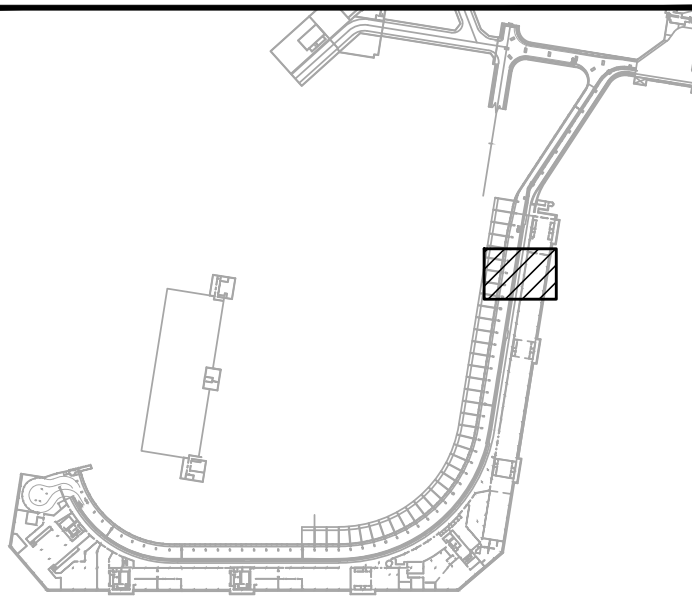

NO.	DATE	REVISIONS

CONSTRUCTION
DOCUMENTS

SEPTEMBER, 2022
DATE

PROJECT TITLE :

EWA AND DH CONCOURSE
ROADWAY IMPROVEMENTS
PHASE 1

AT
DANIEL K. INOUE INTERNATIONAL AIRPORT
HONOLULU, OAHU, HAWAII

PROJECT NO.:

AO1043-32

SHEET TITLE:

3RD FLOOR EWA
MECHANICAL PARTIAL PLAN L



DATE :
SEPTEMBER, 2022
SHEET :

DWG. NO.

M-E-325

181 OF 247 SHEETS

M:\PRJ\219-000\219-076 DOT A EWA DH ROADWAY\DRAWINGS\HNL 3RD LEVEL - MECHANICAL PLANS.DWG

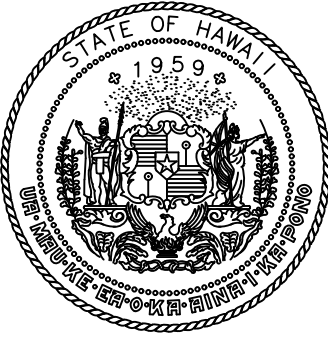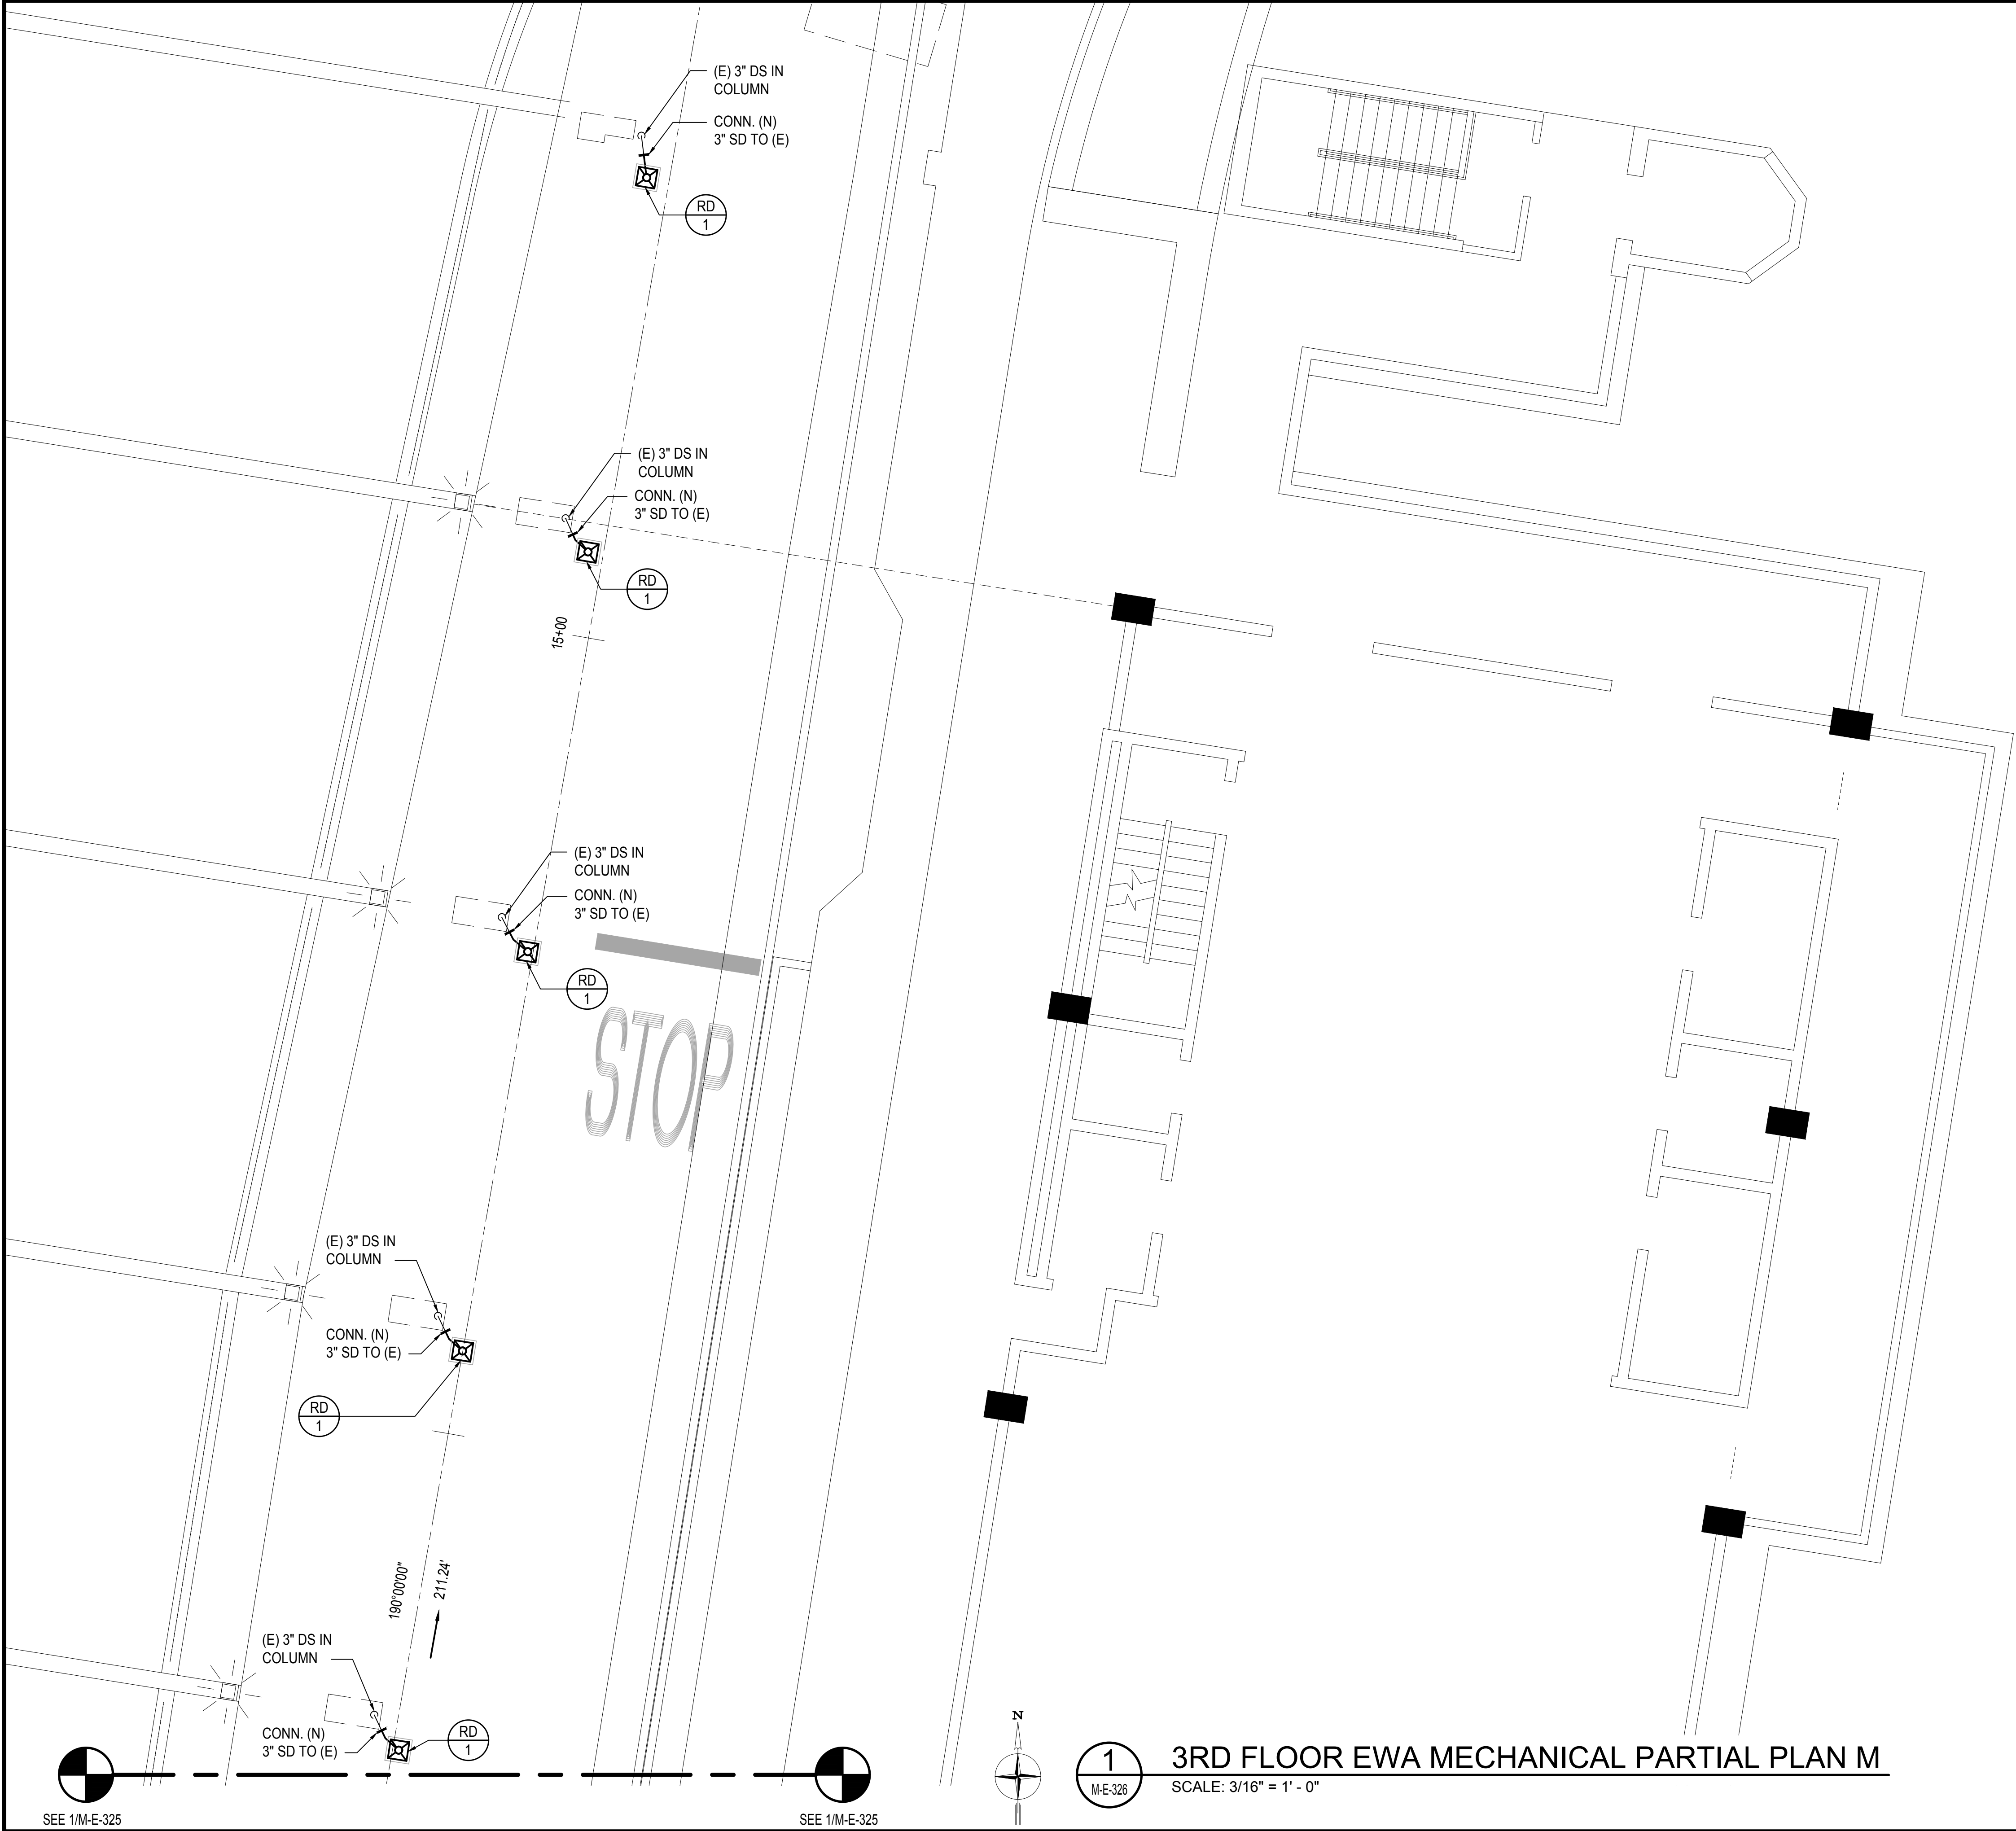

Airports Division
DEPARTMENT OF TRANSPORTATION
STATE OF HAWAII




THIS WORK WAS PREPARED BY ME OR UNDER MY SUPERVISION
AND CONSTRUCTION OF THIS PROJECT WILL BE UNDER MY
OBSERVATION.

Tyson T. Toyama
SIGNATURE

04/30/2024
EXPIRATION DATE OF THE LICENSE

DSGN.	DRWN.	CHKD.	APPD.
JS/KT	KT/TJ	TTT	TTT

KEY PLAN / NOTES:

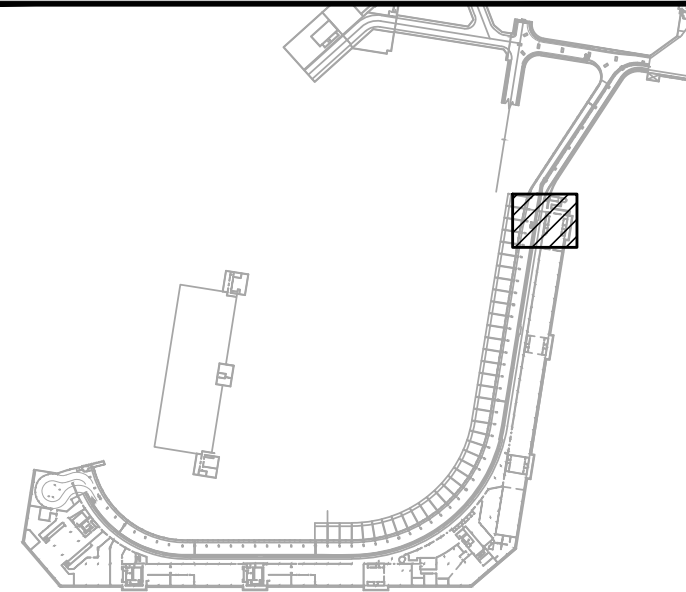

NO.	DATE	REVISIONS
-----	------	-----------

CONSTRUCTION
DOCUMENTS

SEPTEMBER, 2022
DATE

PROJECT TITLE :

EWA AND DH CONCOURSE
ROADWAY IMPROVEMENTS
PHASE 1

AT
DANIEL K. INOUE INTERNATIONAL AIRPORT
HONOLULU, OAHU, HAWAII

PROJECT NO.:

AO1043-32

SHEET TITLE:

3RD FLOOR EWA
MECHANICAL PARTIAL PLAN M

DATE :

SEPTEMBER, 2022

SHEET :

182 OF 247 SHEETS

DWG. NO.

M-E-326

M:\PRJ\219-000\219-076 DOT A EWA DH ROADWAY\DRAWINGS\HNL 3RD LEVEL - MECHANICAL PLANS.DWG