




RONALD N. S. HO & ASSOC., INC.
Electrical Engineers

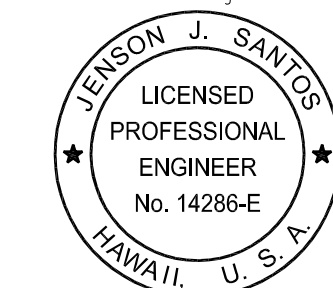

James H. Kator 2022.09.0

THIS WORK WAS PREPARED BY
ME OR UNDER MY SUPERVISION

EXPIRATION DATE OF THE LICENSE
2024.04.30

KEY PLAN / NOTES:			
-------------------	--	--	--

KEY PLAN / NOTES:			
-------------------	--	--	--

CONSTRUCTION


SEPTEMBER, 2022
DATE

AT
DANIEL K. INOUE INTERNATIONAL AIRPORT
HONOLULU, OAHU, HAWAII

PROJECT NO.:

SHEET TITLE:

DATE :	DWG. NO. E-E-300
SEPTEMBER, 2022	
SHEET :	
200 OF 247 SHEETS	

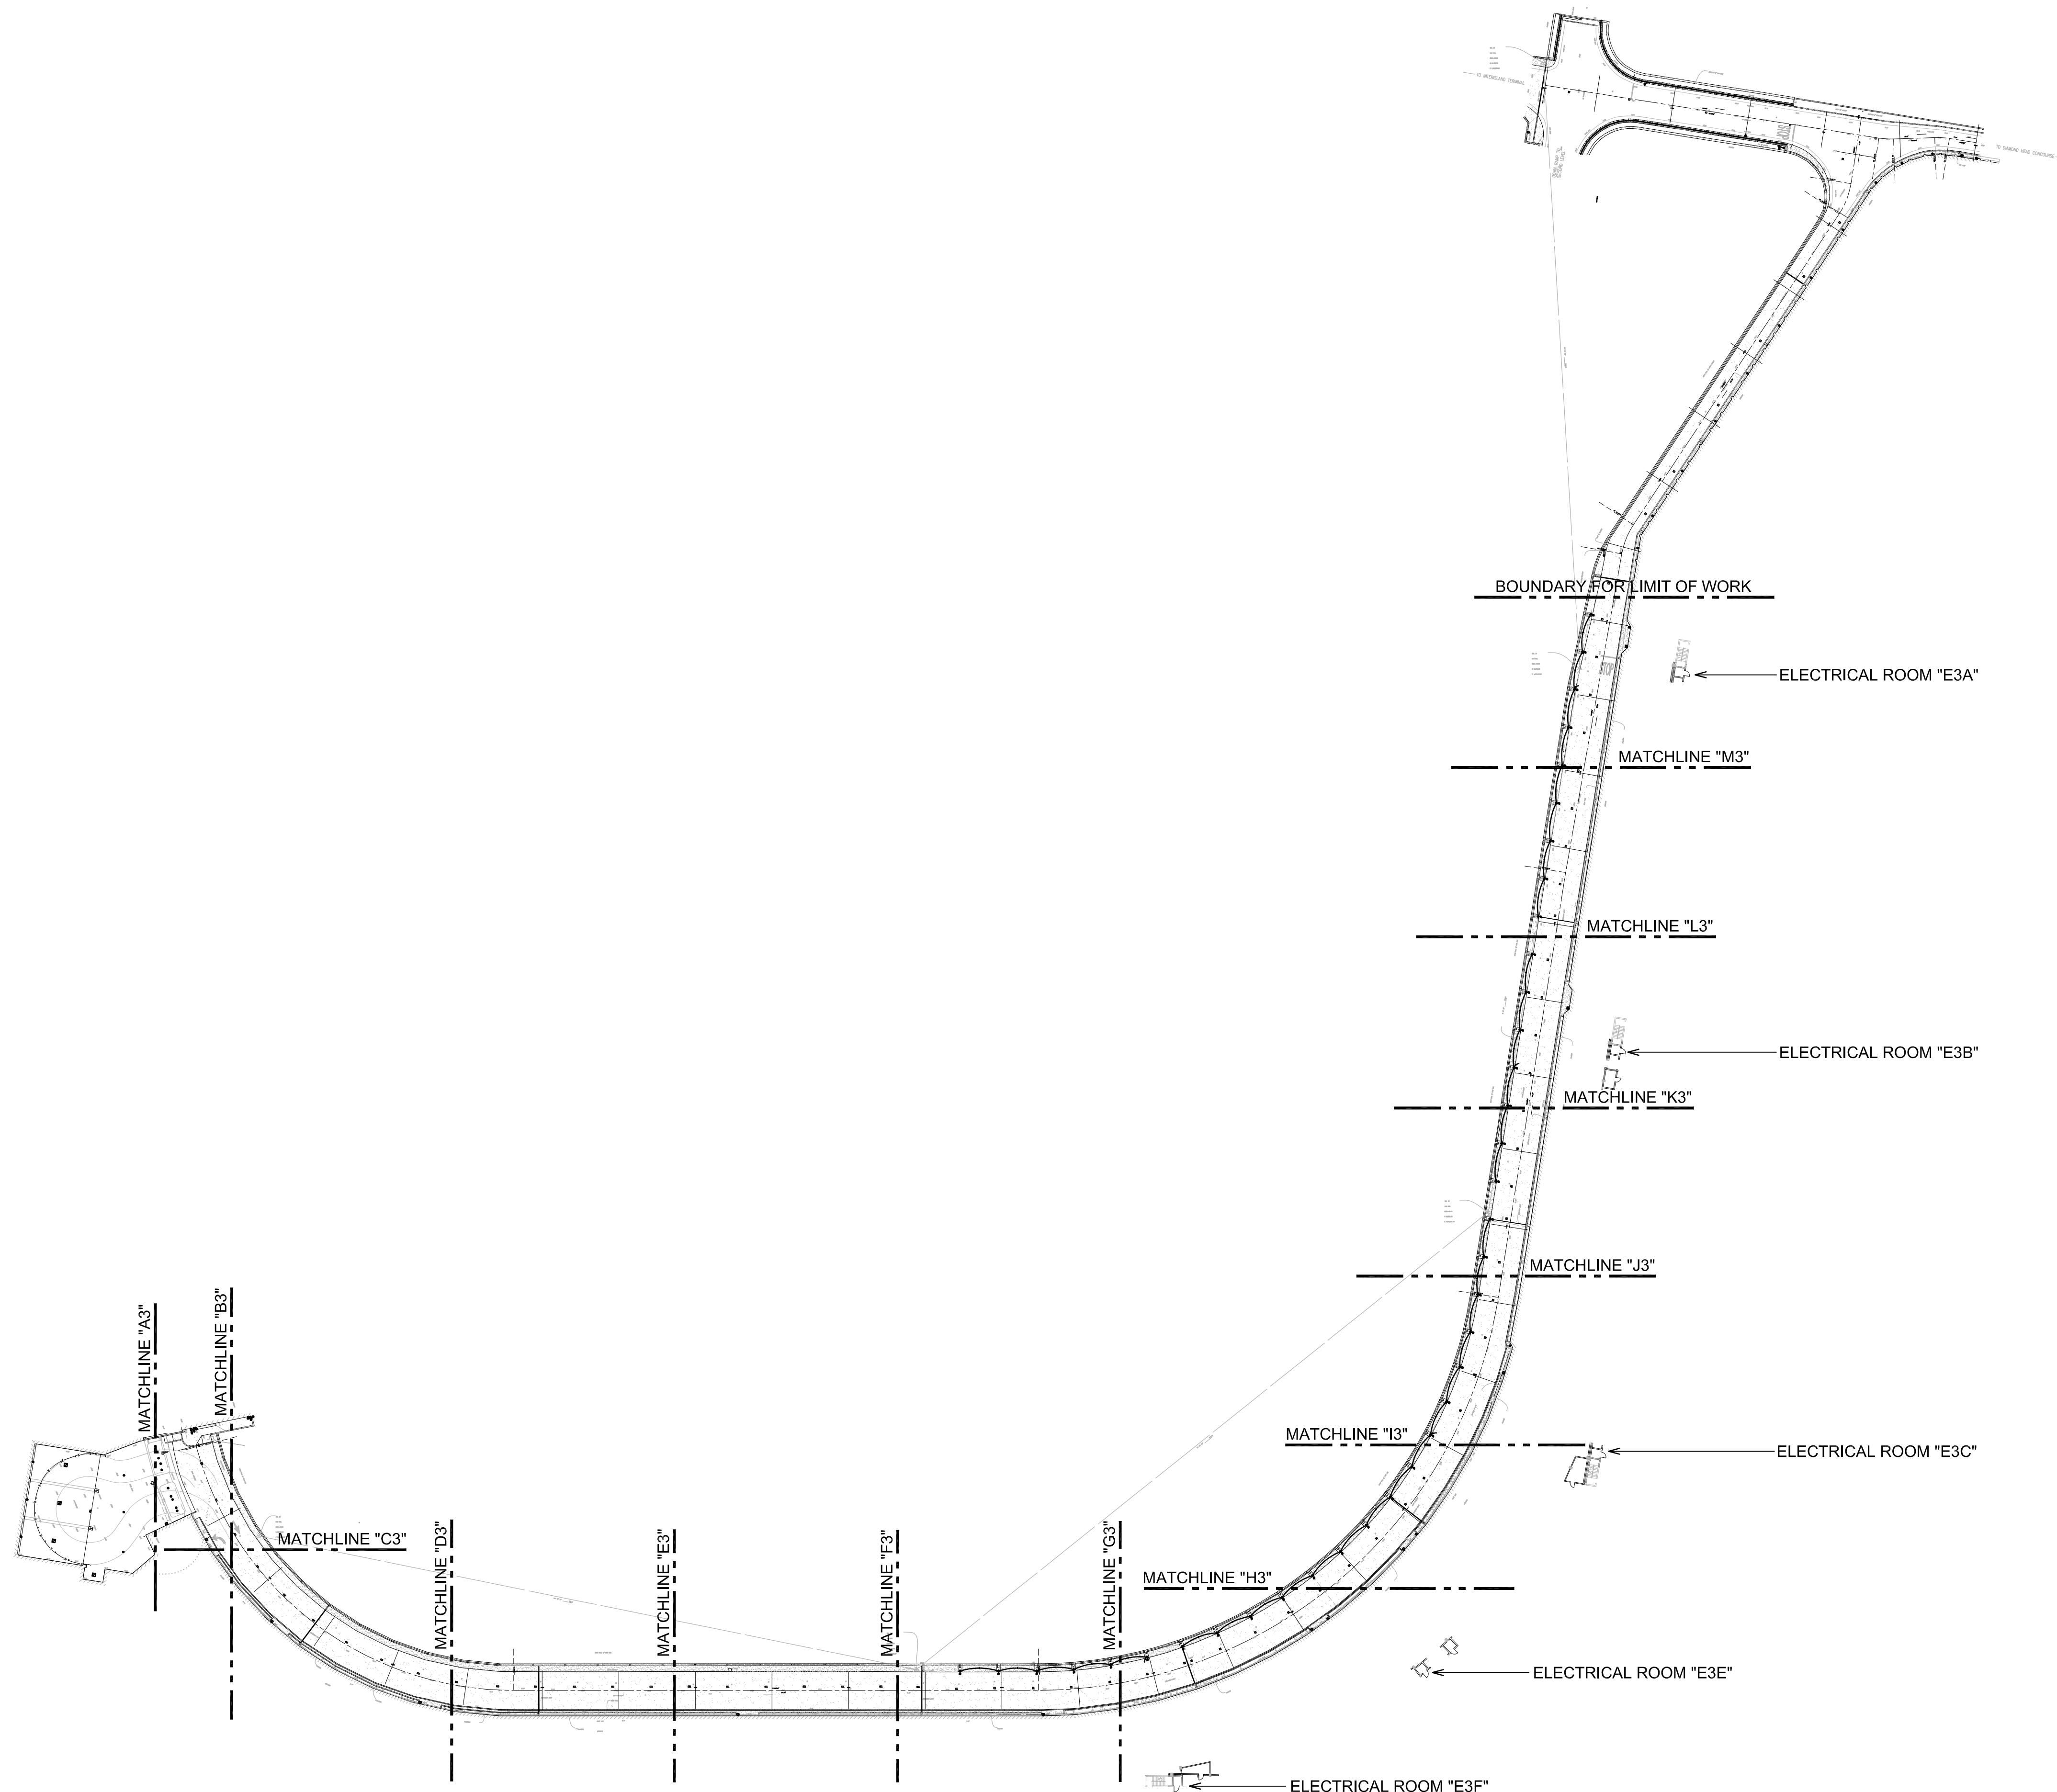

1
E-E-300

EWA THIRD FLOOR SITE PLAN
SCALE: 1"=60'-0"

