




THIS WORK WAS PREPARED BY  
ME OR UNDER MY SUPERVISION

---

EXPIRATION DATE OF THE LICENSE:  
2024.04.30

KEY PLAN / NOTES:

## 3RD LEVEL EWA ROADWAY

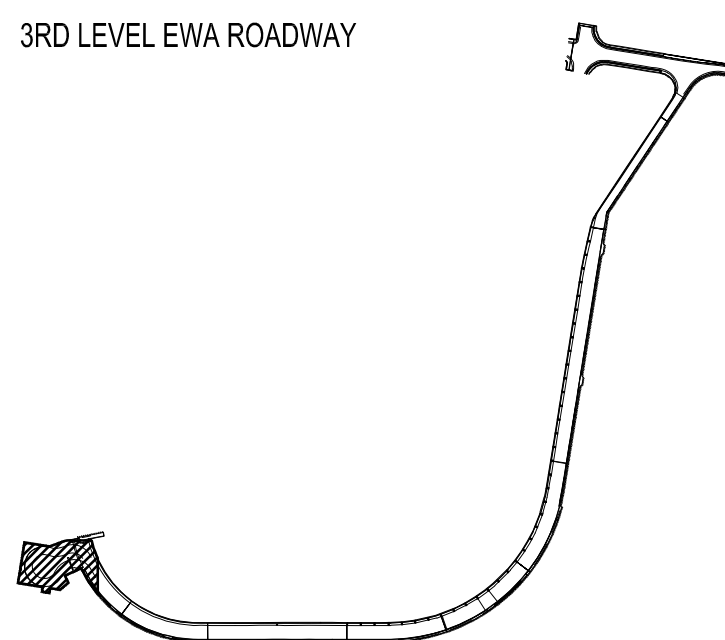

# CONSTRUCTION DOCUMENTS

SEPTEMBER, 202  
DATE

PROJECT TITLE:
----------------

# EWA AND DH CONCOURSE ROADWAY IMPROVEMENTS PHASE 1

AT  
DANIEL K. INOUE INTERNATIONAL AIRPORT  
HONOLULU, OAHU, HAWAII


PROJECT NO.:

**AO1043-32**

SHEET TITLE:
--------------

## NEW POWER AND LIGHTING PLAN EWA 3RD FLOOR AREA 1

DATE :	DWG. NO.  <b>E-E-314</b>
SEPTEMBER, 2022	
SHEET :	
214 OF 247 SHEETS	

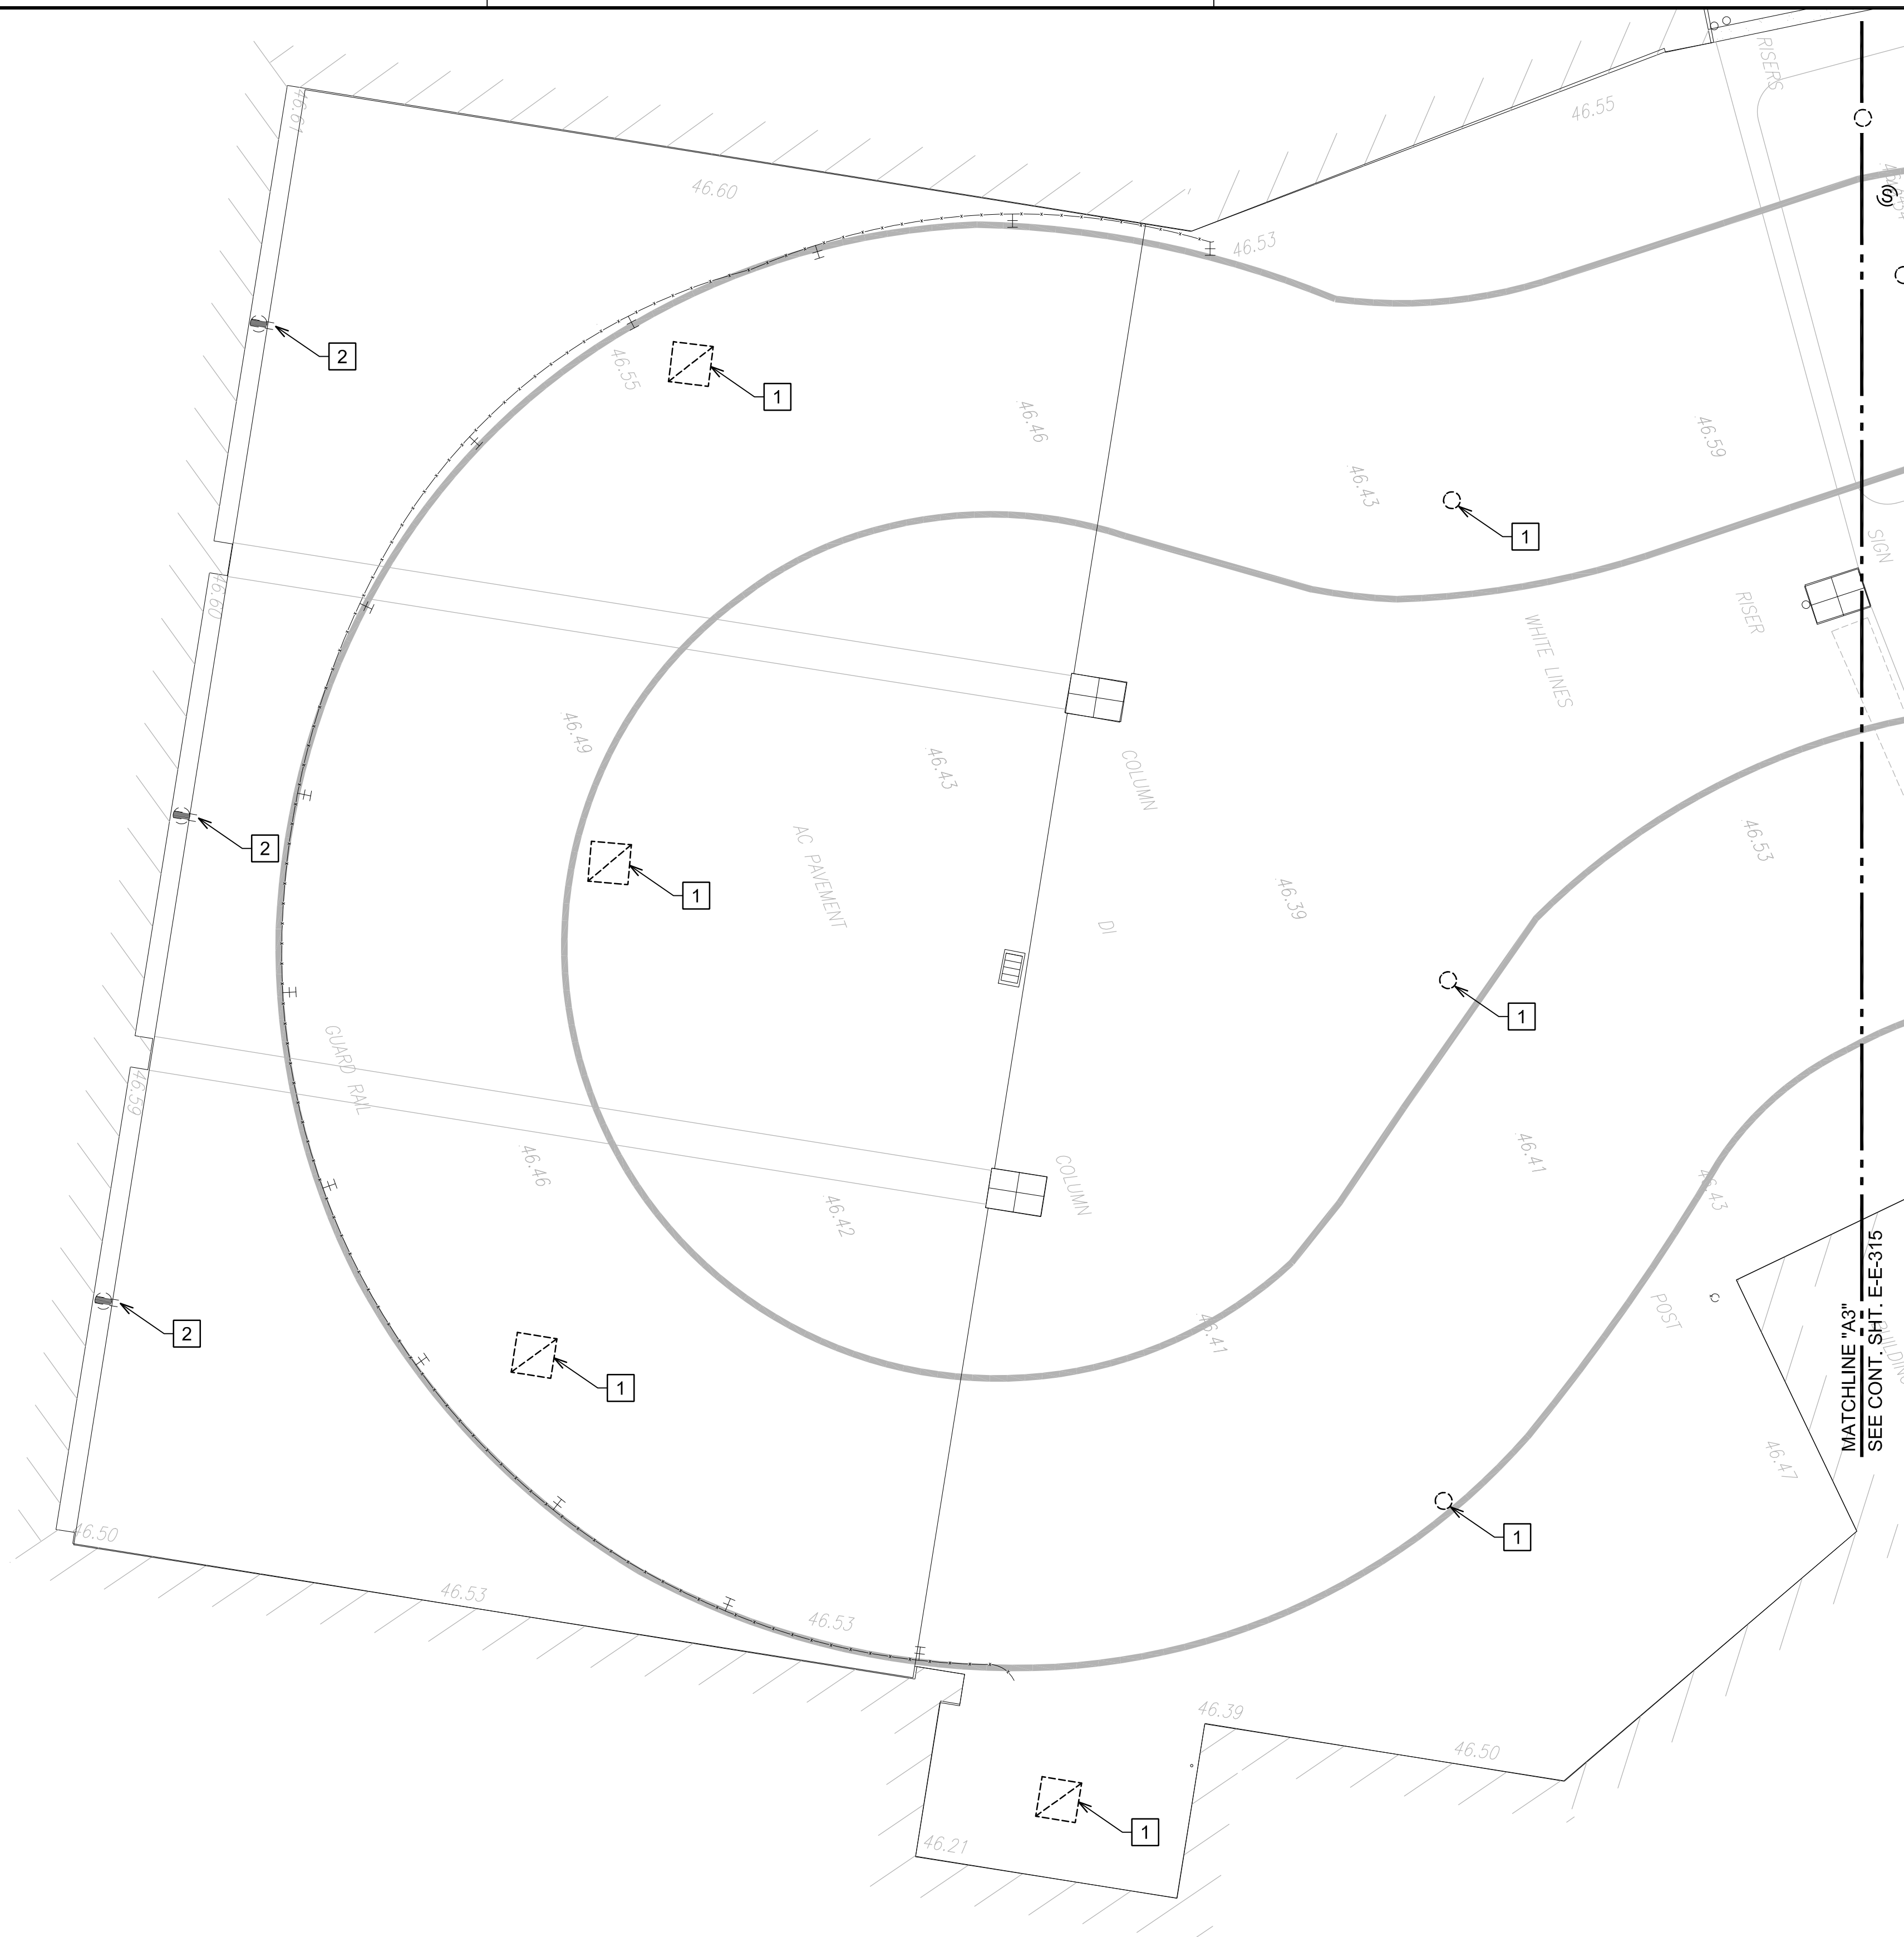

NOTE(S):

- 1 EXISTING LIGHT FIXTURE TO REMAIN
- 2 EXISTING DEVICE TO REMAIN.


MATCHLINE "B3"  
SEE CONT. SHT. E-E-316

MATCHLINE "C3"  
SEE CONT SHT E-E-316




1  
E-E-314

NEW POWER AND LIGHTING PLAN EWA 3RD FLOOR AREA 1  
SCALE: 3/16"=1'-0"

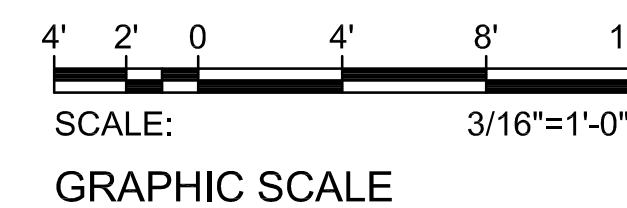

Z:\ACAD\PROJECTS\221023\_EWA\_3RD\_LEVEL\E-E-315\_221023\_EWA\_NEW\_3RD\_AREA 02 9/8/2022 2:33PM MPetner


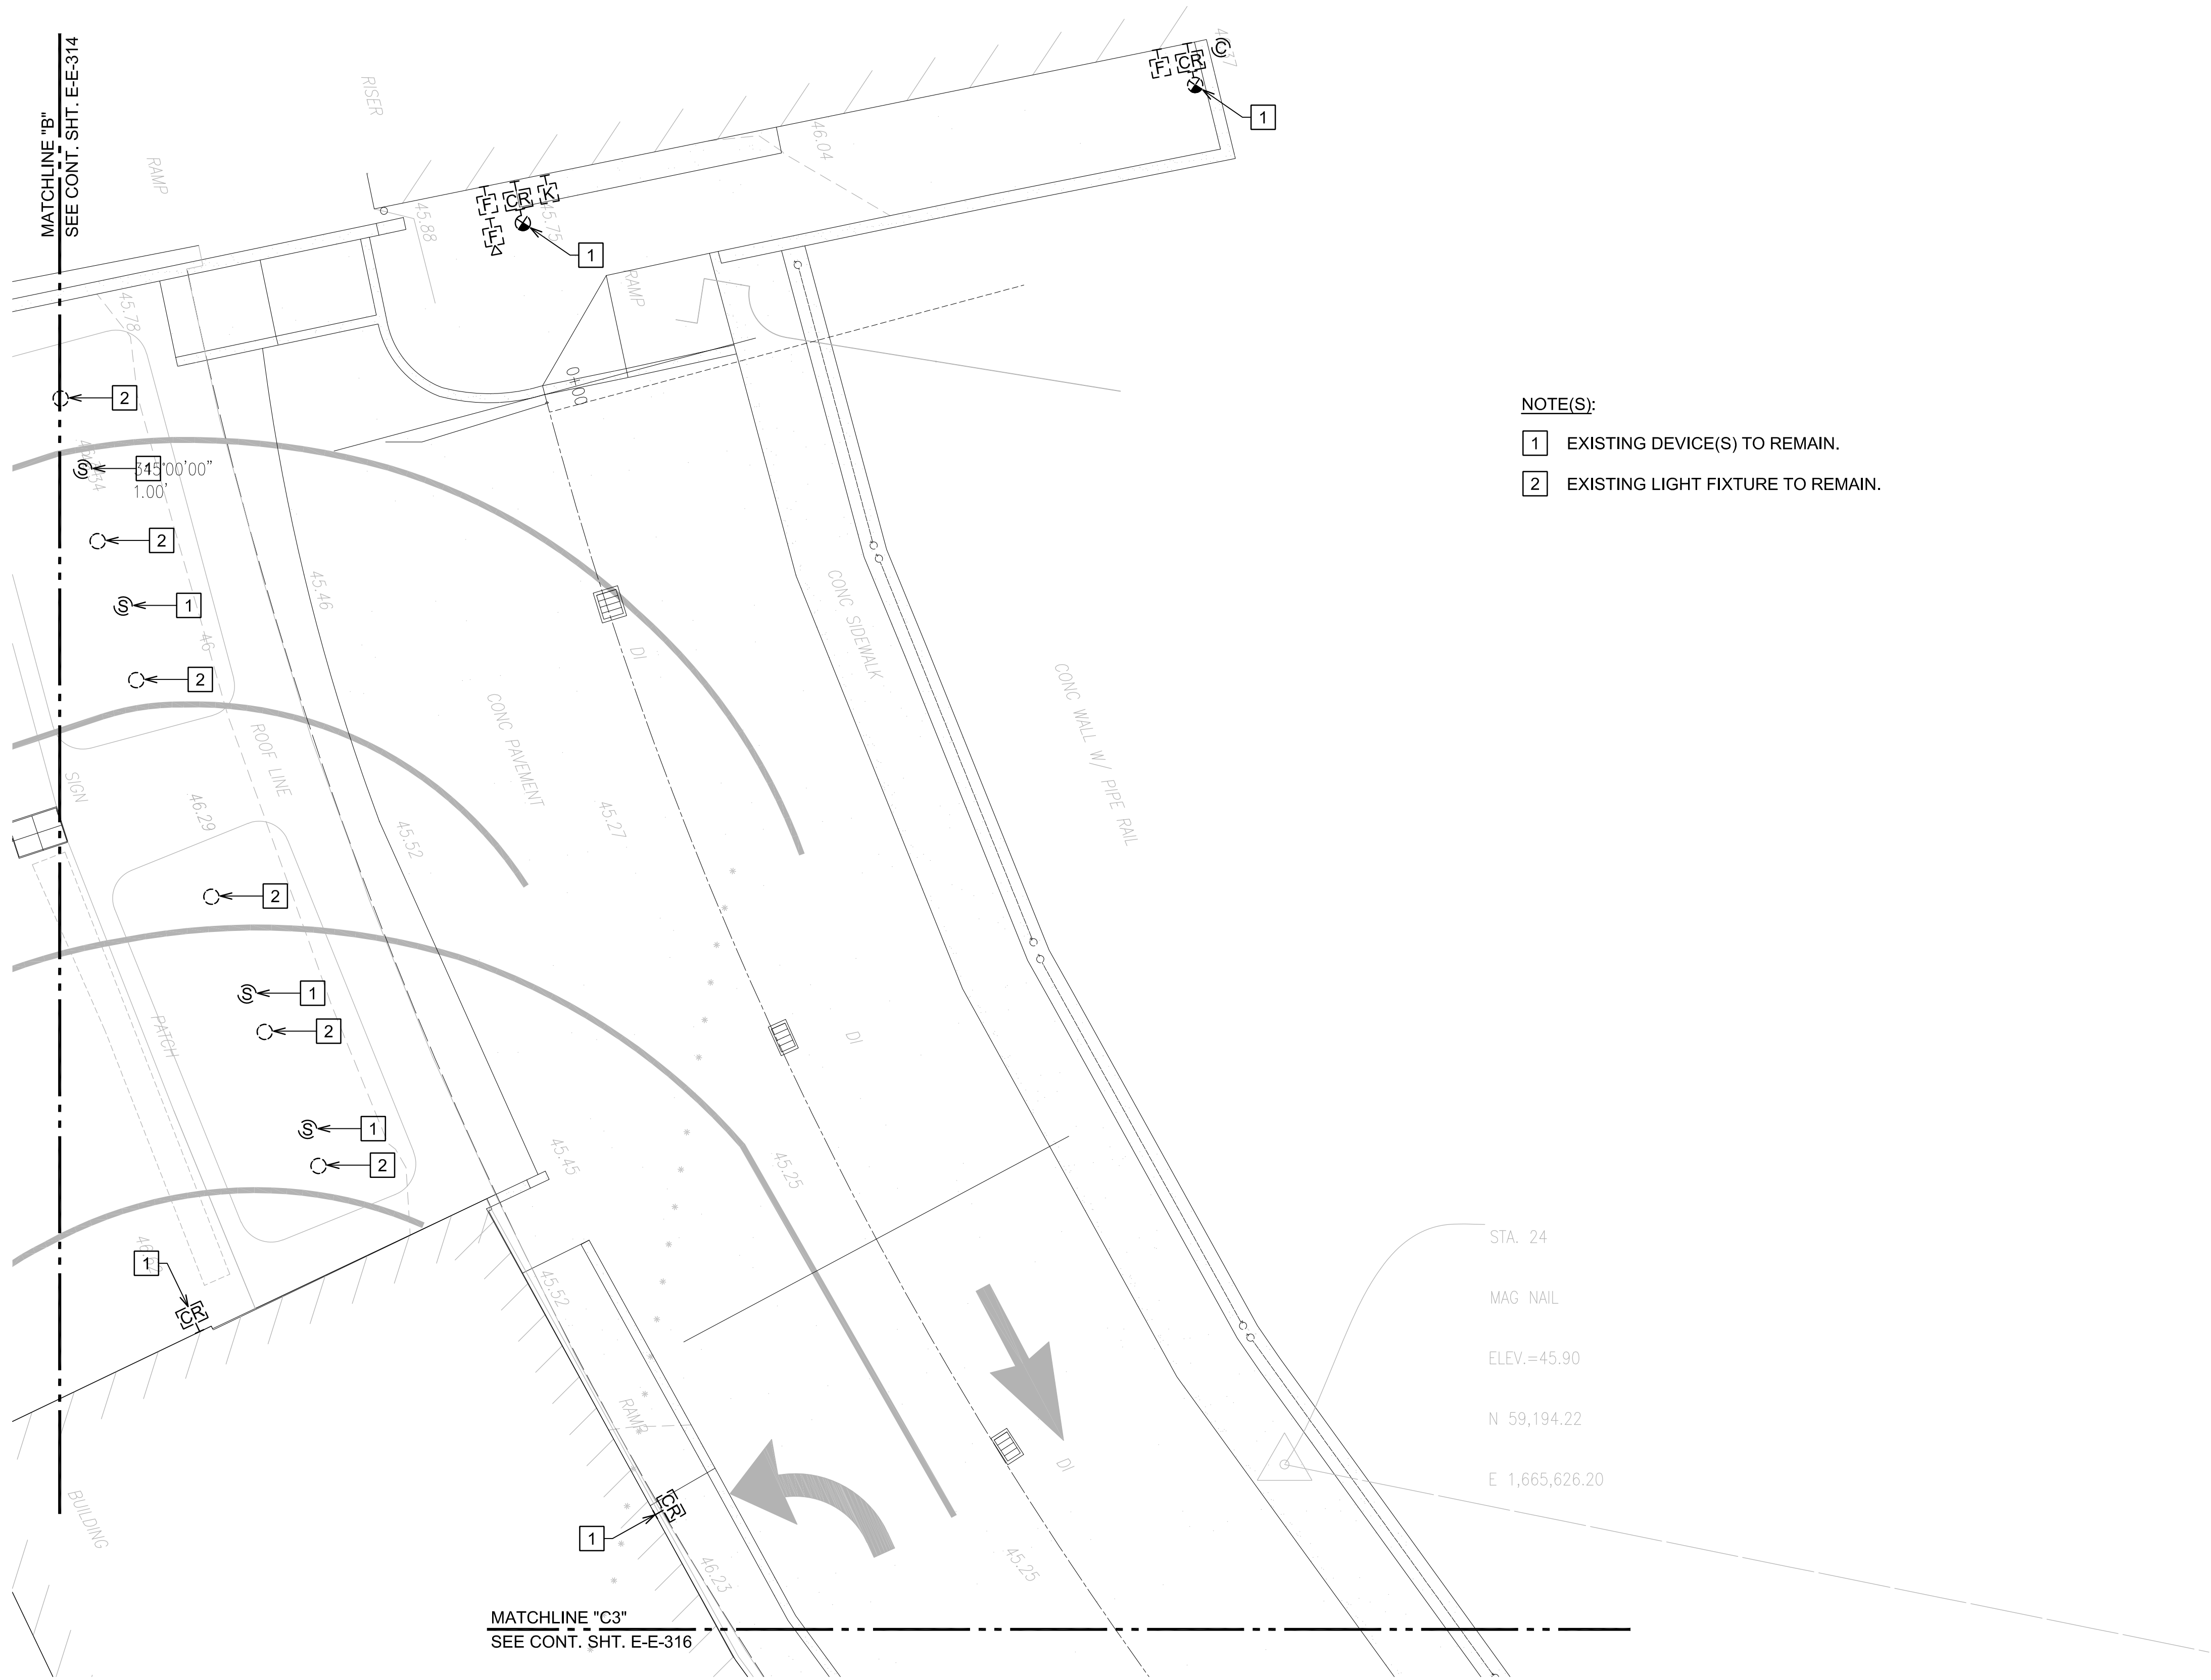


- NOTE(S):
- 1 EXISTING DEVICE(S) TO REMAIN.
  - 2 EXISTING LIGHT FIXTURE TO REMAIN.




1  
E-E-315

NEW POWER AND LIGHTING PLAN EWA 3RD FLOOR AREA 2  
SCALE: 3/16"=1'-0"

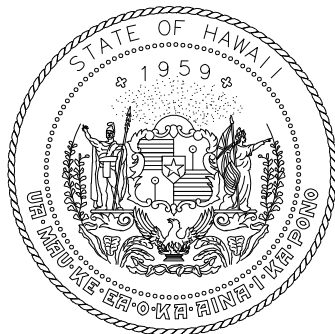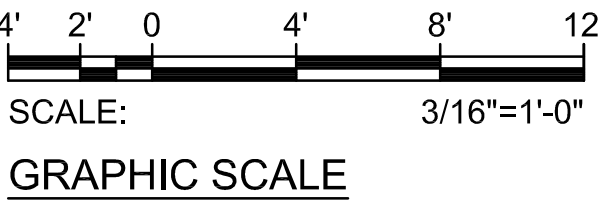

Airports Division  
DEPARTMENT OF TRANSPORTATION  
STATE OF HAWAII


RONALD N. S. HO & ASSOC., INC.  
Electrical Engineers

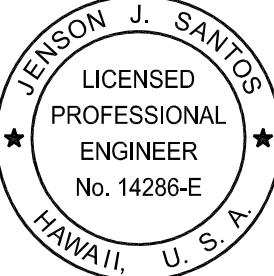

*Jenson J. Santos* 2022.09.09  
THIS WORK WAS PREPARED BY  
ME OR UNDER MY SUPERVISION  
EXPIRATION DATE OF THE LICENSE:  
2024.04.30

DSGN.	DRWN.	CHKD.	APPD.
MP	CAD	JS	JS

KEY PLAN / NOTES:

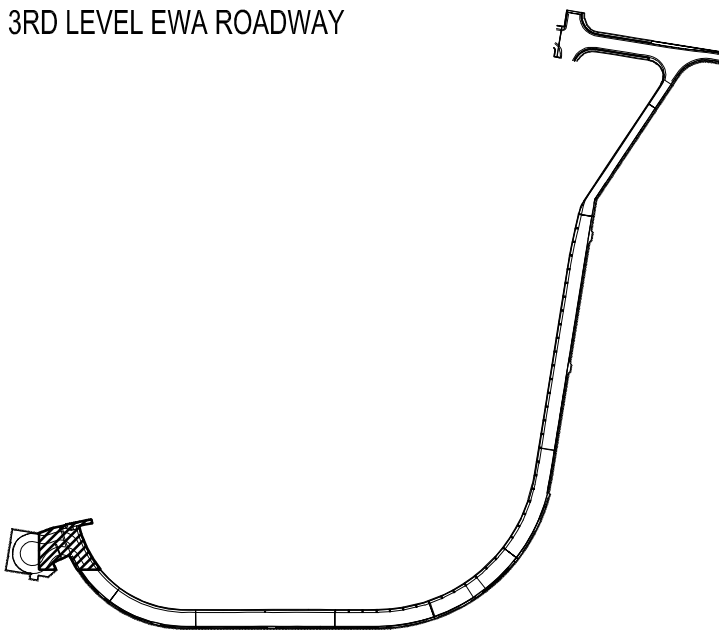

NO.	DATE	REVISIONS

CONSTRUCTION DOCUMENTS

SEPTEMBER, 2022  
DATE

PROJECT TITLE :

EWA AND DH CONCOURSE  
ROADWAY IMPROVEMENTS  
PHASE 1

AT  
DANIEL K. INOUE INTERNATIONAL AIRPORT  
HONOLULU, OAHU, HAWAII

PROJECT NO.:

AO1043-32

SHEET TITLE:

NEW POWER AND  
LIGHTING PLAN EWA  
3RD FLOOR AREA 2


DATE :  
SEPTEMBER, 2022  
SHEET :

DWG. NO.

E-E-315


215 OF 247 SHEETS

Z:\ACAD\PROJECTS\221023\_EWA\_3RD\_LEVEL\E-E-316\_221023\_EWA\_NEW\_3RD\_AREA 03 9/8/2022 2:34PM MPetner

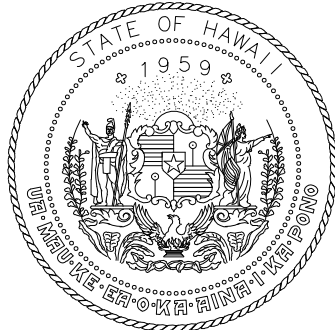

Airports Division  
DEPARTMENT OF TRANSPORTATION  
STATE OF HAWAII


RONALD N. S. HO & ASSOC., INC.  
Electrical Engineers

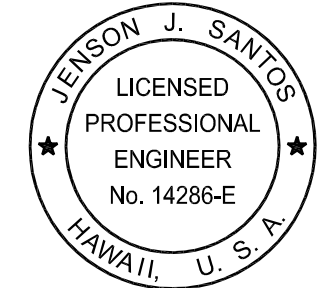

*Jenson J. Santos* 2022.09.09  
THIS WORK WAS PREPARED BY  
ME OR UNDER MY SUPERVISION  
EXPIRATION DATE OF THE LICENSE:  
2024.04.30

DSGN.	DRWN.	CHKD.	APPD.
MP	CAD	JS	JS

### KEY PLAN / NOTES:

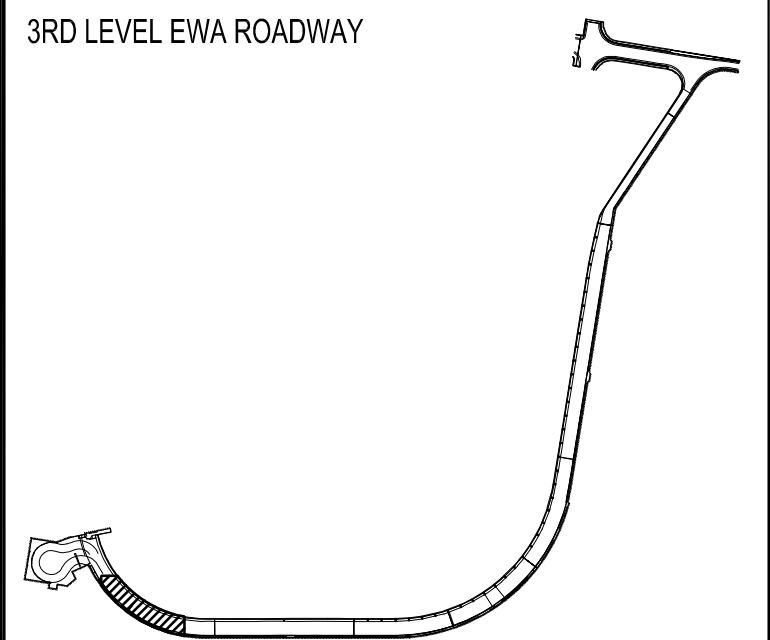

NO.	DATE	REVISIONS

**CONSTRUCTION DOCUMENTS**  
SEPTEMBER, 2022  
DATE

**PROJECT TITLE :**  
**EWA AND DH CONCOURSE ROADWAY IMPROVEMENTS PHASE 1**  
AT  
DANIEL K. INOUE INTERNATIONAL AIRPORT  
HONOLULU, OAHU, HAWAII

**PROJECT NO.:**  
**AO1043-32**

**SHEET TITLE:**

**NEW POWER AND LIGHTING PLAN EWA 3RD FLOOR AREA 3**

DATE :	DWG. NO.
SEPTEMBER, 2022	<b>E-E-316</b>
SHEET :	
216 OF 247 SHEETS	


Z:\ACAD\PROJECTS\221023\_EWA\_3RD\_LEVEL\E-E-317\_221023\_EWA\_NEW\_3RD\_AREA 04 9/8/2022 2:35PM MPetner

MATCHLINE "D3"  
SEE CONT. SHT. E-E-316

NOTE(S):



1. NO EXISTING DEVICE(S) OR LIGHT FIXTURES.

NORTH

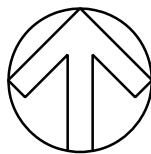

1  
E-E-317

NEW POWER AND LIGHTING PLAN EWA 3RD FLOOR AREA 4  
SCALE: 3/16"=1'-0"

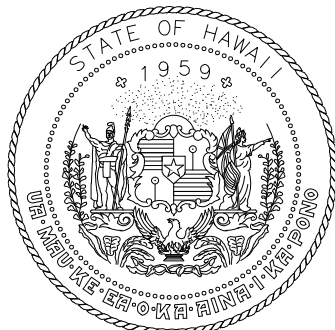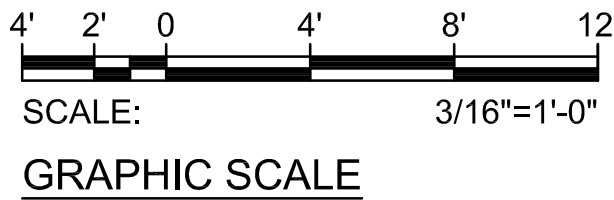

Airports Division  
DEPARTMENT OF TRANSPORTATION  
STATE OF HAWAII


RONALD N. S. HO & ASSOC., INC.  
Electrical Engineers



*Jenson J. Santos* 2022.09.09  
THIS WORK WAS PREPARED BY  
ME OR UNDER MY SUPERVISION  
EXPIRATION DATE OF THE LICENSE:  
2024.04.30

DSGN.	DRWN.	CHKD.	APPD.
MP	CAD	JS	JS

KEY PLAN / NOTES:

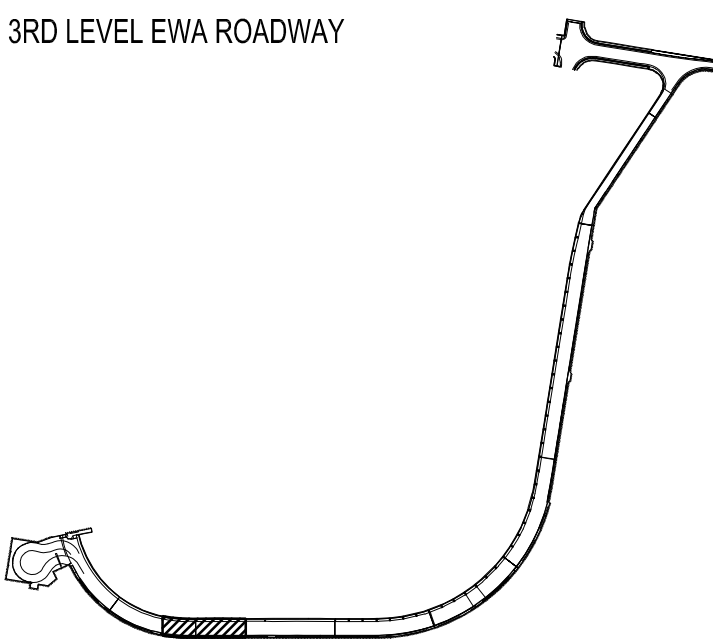

NO.	DATE	REVISIONS

CONSTRUCTION DOCUMENTS

SEPTEMBER, 2022  
DATE

PROJECT TITLE :

EWA AND DH CONCOURSE  
ROADWAY IMPROVEMENTS  
PHASE 1

AT  
DANIEL K. INOUE INTERNATIONAL AIRPORT  
HONOLULU, OAHU, HAWAII

PROJECT NO.:

AO1043-32

SHEET TITLE:

NEW POWER AND  
LIGHTING PLAN EWA  
3RD FLOOR AREA 4

DATE :	DWG. NO.
SEPTEMBER, 2022	E-E-317
SHEET :	
217 OF 247 SHEETS	



Z:\ACAD\PROJECTS\221023\_EWA\_3RD\_LEVEL\E-E-318\_221023\_EWA\_NEW\_3RD\_AREA\_05 9/8/2022 2:41PM MPetner  
MATCHLINE "E3"  
SEE CONT. SHT. E-E-317

NOTE(S):  
1 EXISTING DEVICE(S) TO REMAIN.




1  
E-E-318

NEW POWER AND LIGHTING PLAN EWA 3RD FLOOR AREA 5  
SCALE: 3/16"=1'-0"

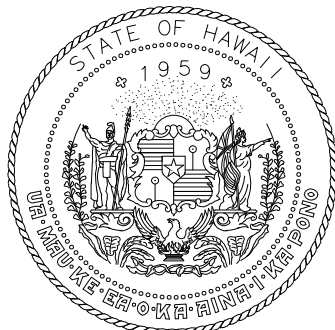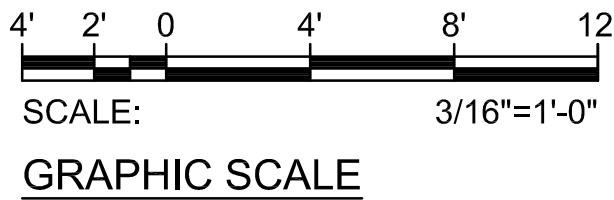

Airports Division  
DEPARTMENT OF TRANSPORTATION  
STATE OF HAWAII


RONALD N. S. HO & ASSOC., INC.  
Electrical Engineers

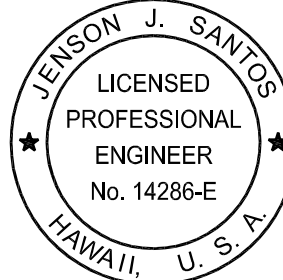

*Jenson J. Santos* 2022.09.09  
THIS WORK WAS PREPARED BY  
ME OR UNDER MY SUPERVISION  
EXPIRATION DATE OF THE LICENSE:  
2024.04.30

DSGN.	DRWN.	CHKD.	APPD.
MP	CAD	JS	JS

KEY PLAN / NOTES:

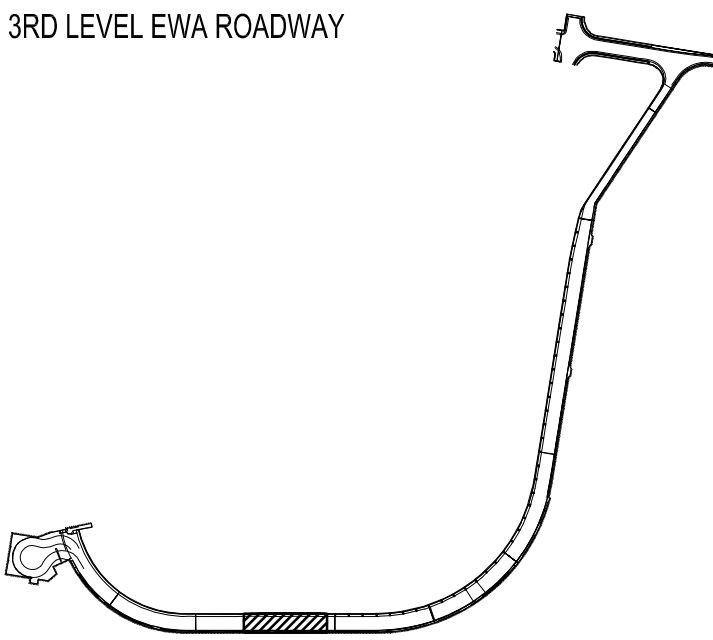

NO.	DATE	REVISIONS
-----	------	-----------

CONSTRUCTION DOCUMENTS

SEPTEMBER, 2022  
DATE

PROJECT TITLE :

EWA AND DH CONCOURSE  
ROADWAY IMPROVEMENTS  
PHASE 1

AT  
DANIEL K. INOUE INTERNATIONAL AIRPORT  
HONOLULU, OAHU, HAWAII

PROJECT NO.:

AO1043-32

SHEET TITLE:

NEW POWER AND  
LIGHTING PLAN EWA  
3RD FLOOR AREA 5


DATE :  
SEPTEMBER, 2022  
SHEET :

DWG. NO.

E-E-318

218 OF 247 SHEETS

Z:\ACAD\PROJECTS\221023\_EWA\_3RD\_LEVEL\E-E-319\_221023\_EWA\_NEW\_3RD\_AREA\_06 9/8/2022 2:42PM MPetner

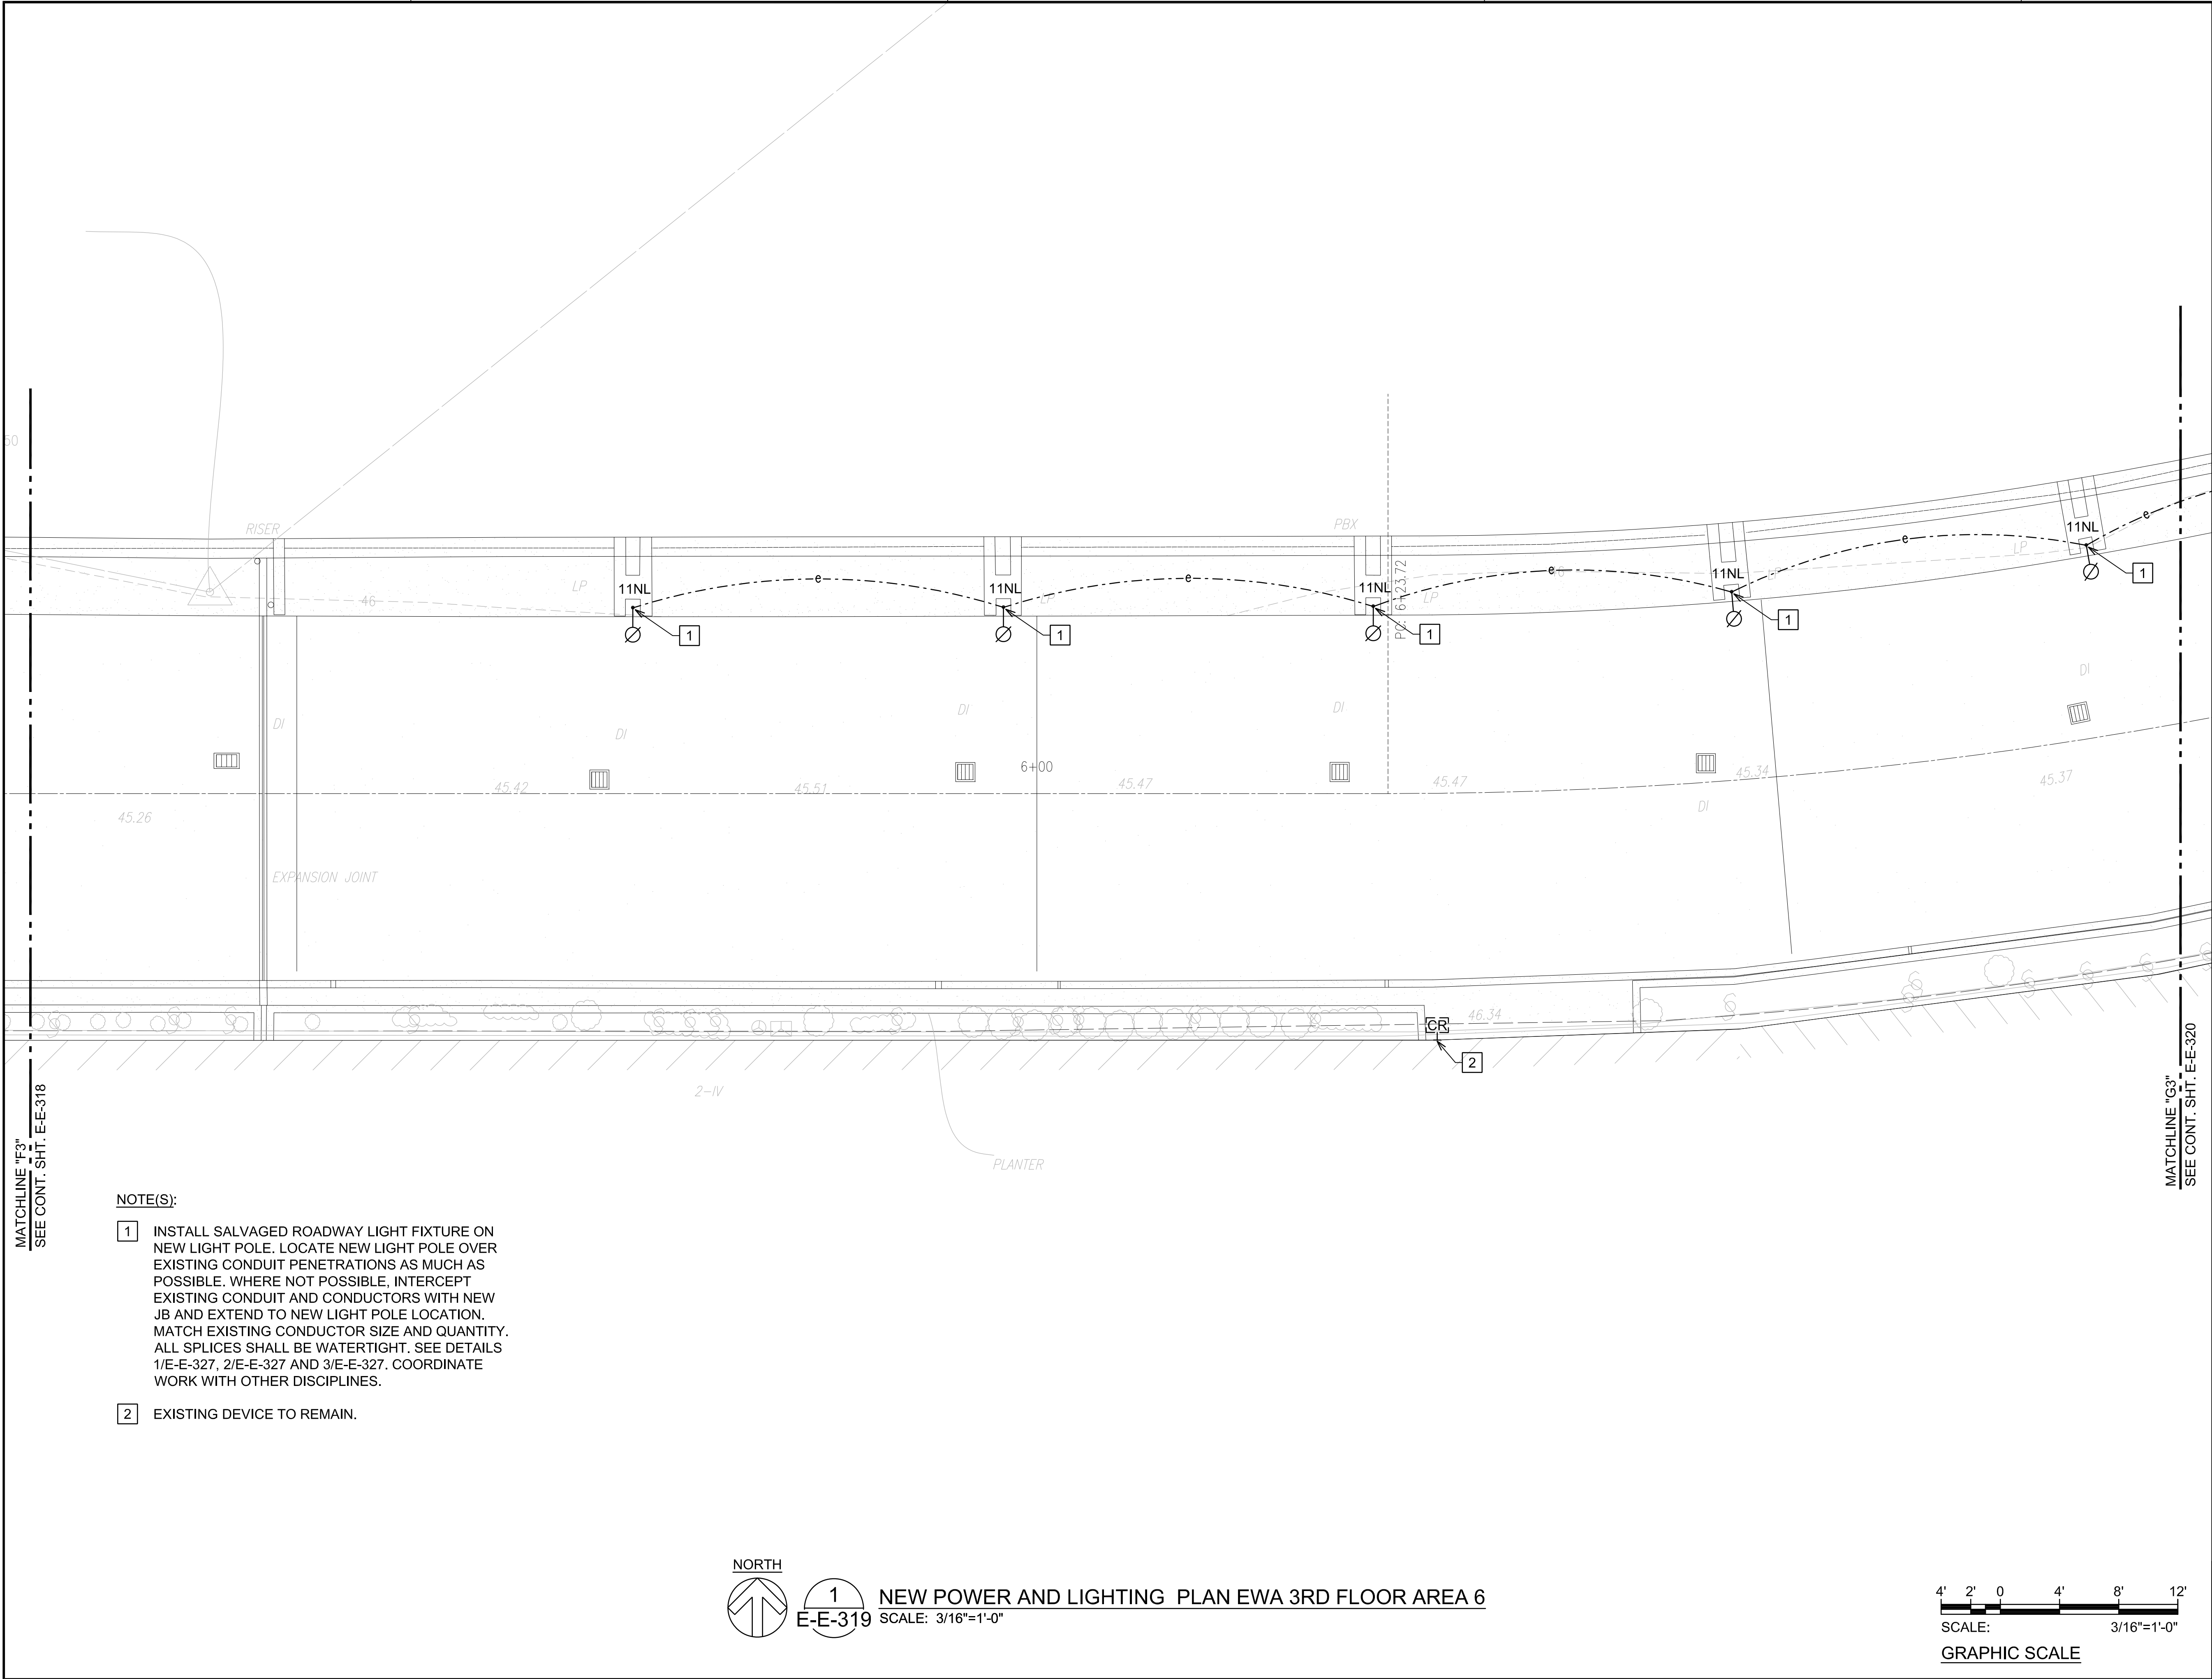



NOTE(S):

- 1 INSTALL SALVAGED ROADWAY LIGHT FIXTURE ON NEW LIGHT POLE. LOCATE NEW LIGHT POLE OVER EXISTING CONDUIT PENETRATIONS AS MUCH AS POSSIBLE. WHERE NOT POSSIBLE, INTERCEPT EXISTING CONDUIT AND CONDUCTORS WITH NEW JB AND EXTEND TO NEW LIGHT POLE LOCATION. MATCH EXISTING CONDUCTOR SIZE AND QUANTITY. ALL SPLICES SHALL BE WATERTIGHT. SEE DETAILS 1/E-E-327, 2/E-E-327 AND 3/E-E-327. COORDINATE WORK WITH OTHER DISCIPLINES.
- 2 EXISTING DEVICE TO REMAIN.



1  
E-E-319

NEW POWER AND LIGHTING PLAN EWA 3RD FLOOR AREA 6  
SCALE: 3/16"=1'-0"

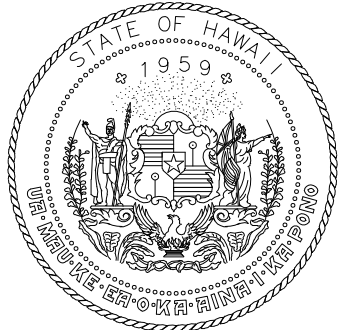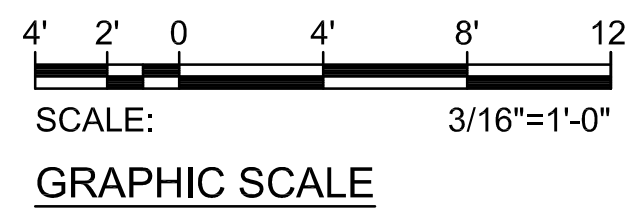

Airports Division  
DEPARTMENT OF TRANSPORTATION  
STATE OF HAWAII


RONALD N. S. HO & ASSOC., INC.  
Electrical Engineers



*Jenson J. Santos* 2022.09.09  
THIS WORK WAS PREPARED BY  
ME OR UNDER MY SUPERVISION  
EXPIRATION DATE OF THE LICENSE:  
2024.04.30

DSGN.	DRWN.	CHKD.	APPD.
MP	CAD	JS	JS

KEY PLAN / NOTES:

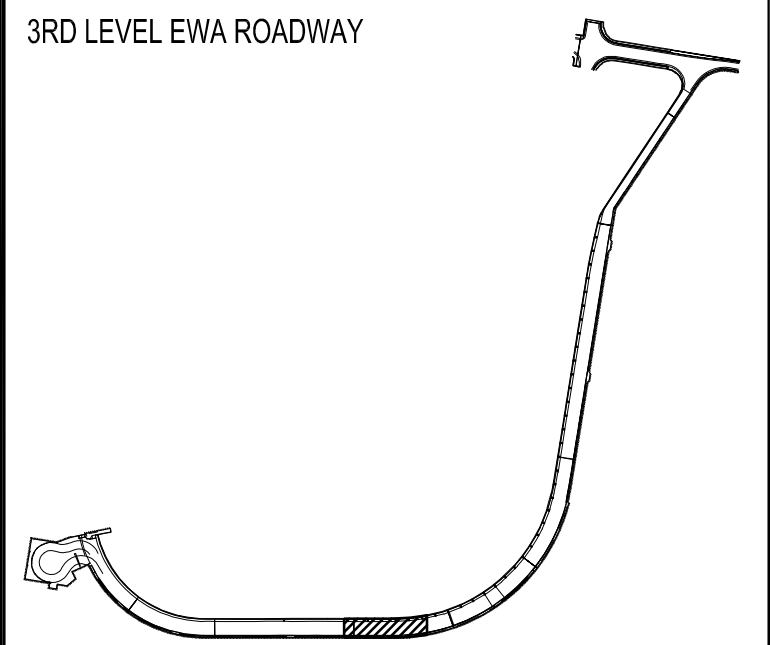

NO.	DATE	REVISIONS

CONSTRUCTION DOCUMENTS

SEPTEMBER, 2022  
DATE

PROJECT TITLE :

EWA AND DH CONCOURSE  
ROADWAY IMPROVEMENTS  
PHASE 1

AT  
DANIEL K. INOUE INTERNATIONAL AIRPORT  
HONOLULU, OAHU, HAWAII

PROJECT NO.:


AO1043-32

SHEET TITLE:

NEW POWER AND  
LIGHTING PLAN EWA  
3RD FLOOR AREA 6

DATE :	DWG. NO.
SEPTEMBER, 2022	E-E-319
SHEET :	
219 OF 247 SHEETS	

Z:\ACAD\PROJECTS\221023\_EWA\_3RD\_LEVEL\E-E-320\_221023\_EWA\_NEW\_3RD\_AREA 07 9/8/2022 2:42PM MPetner

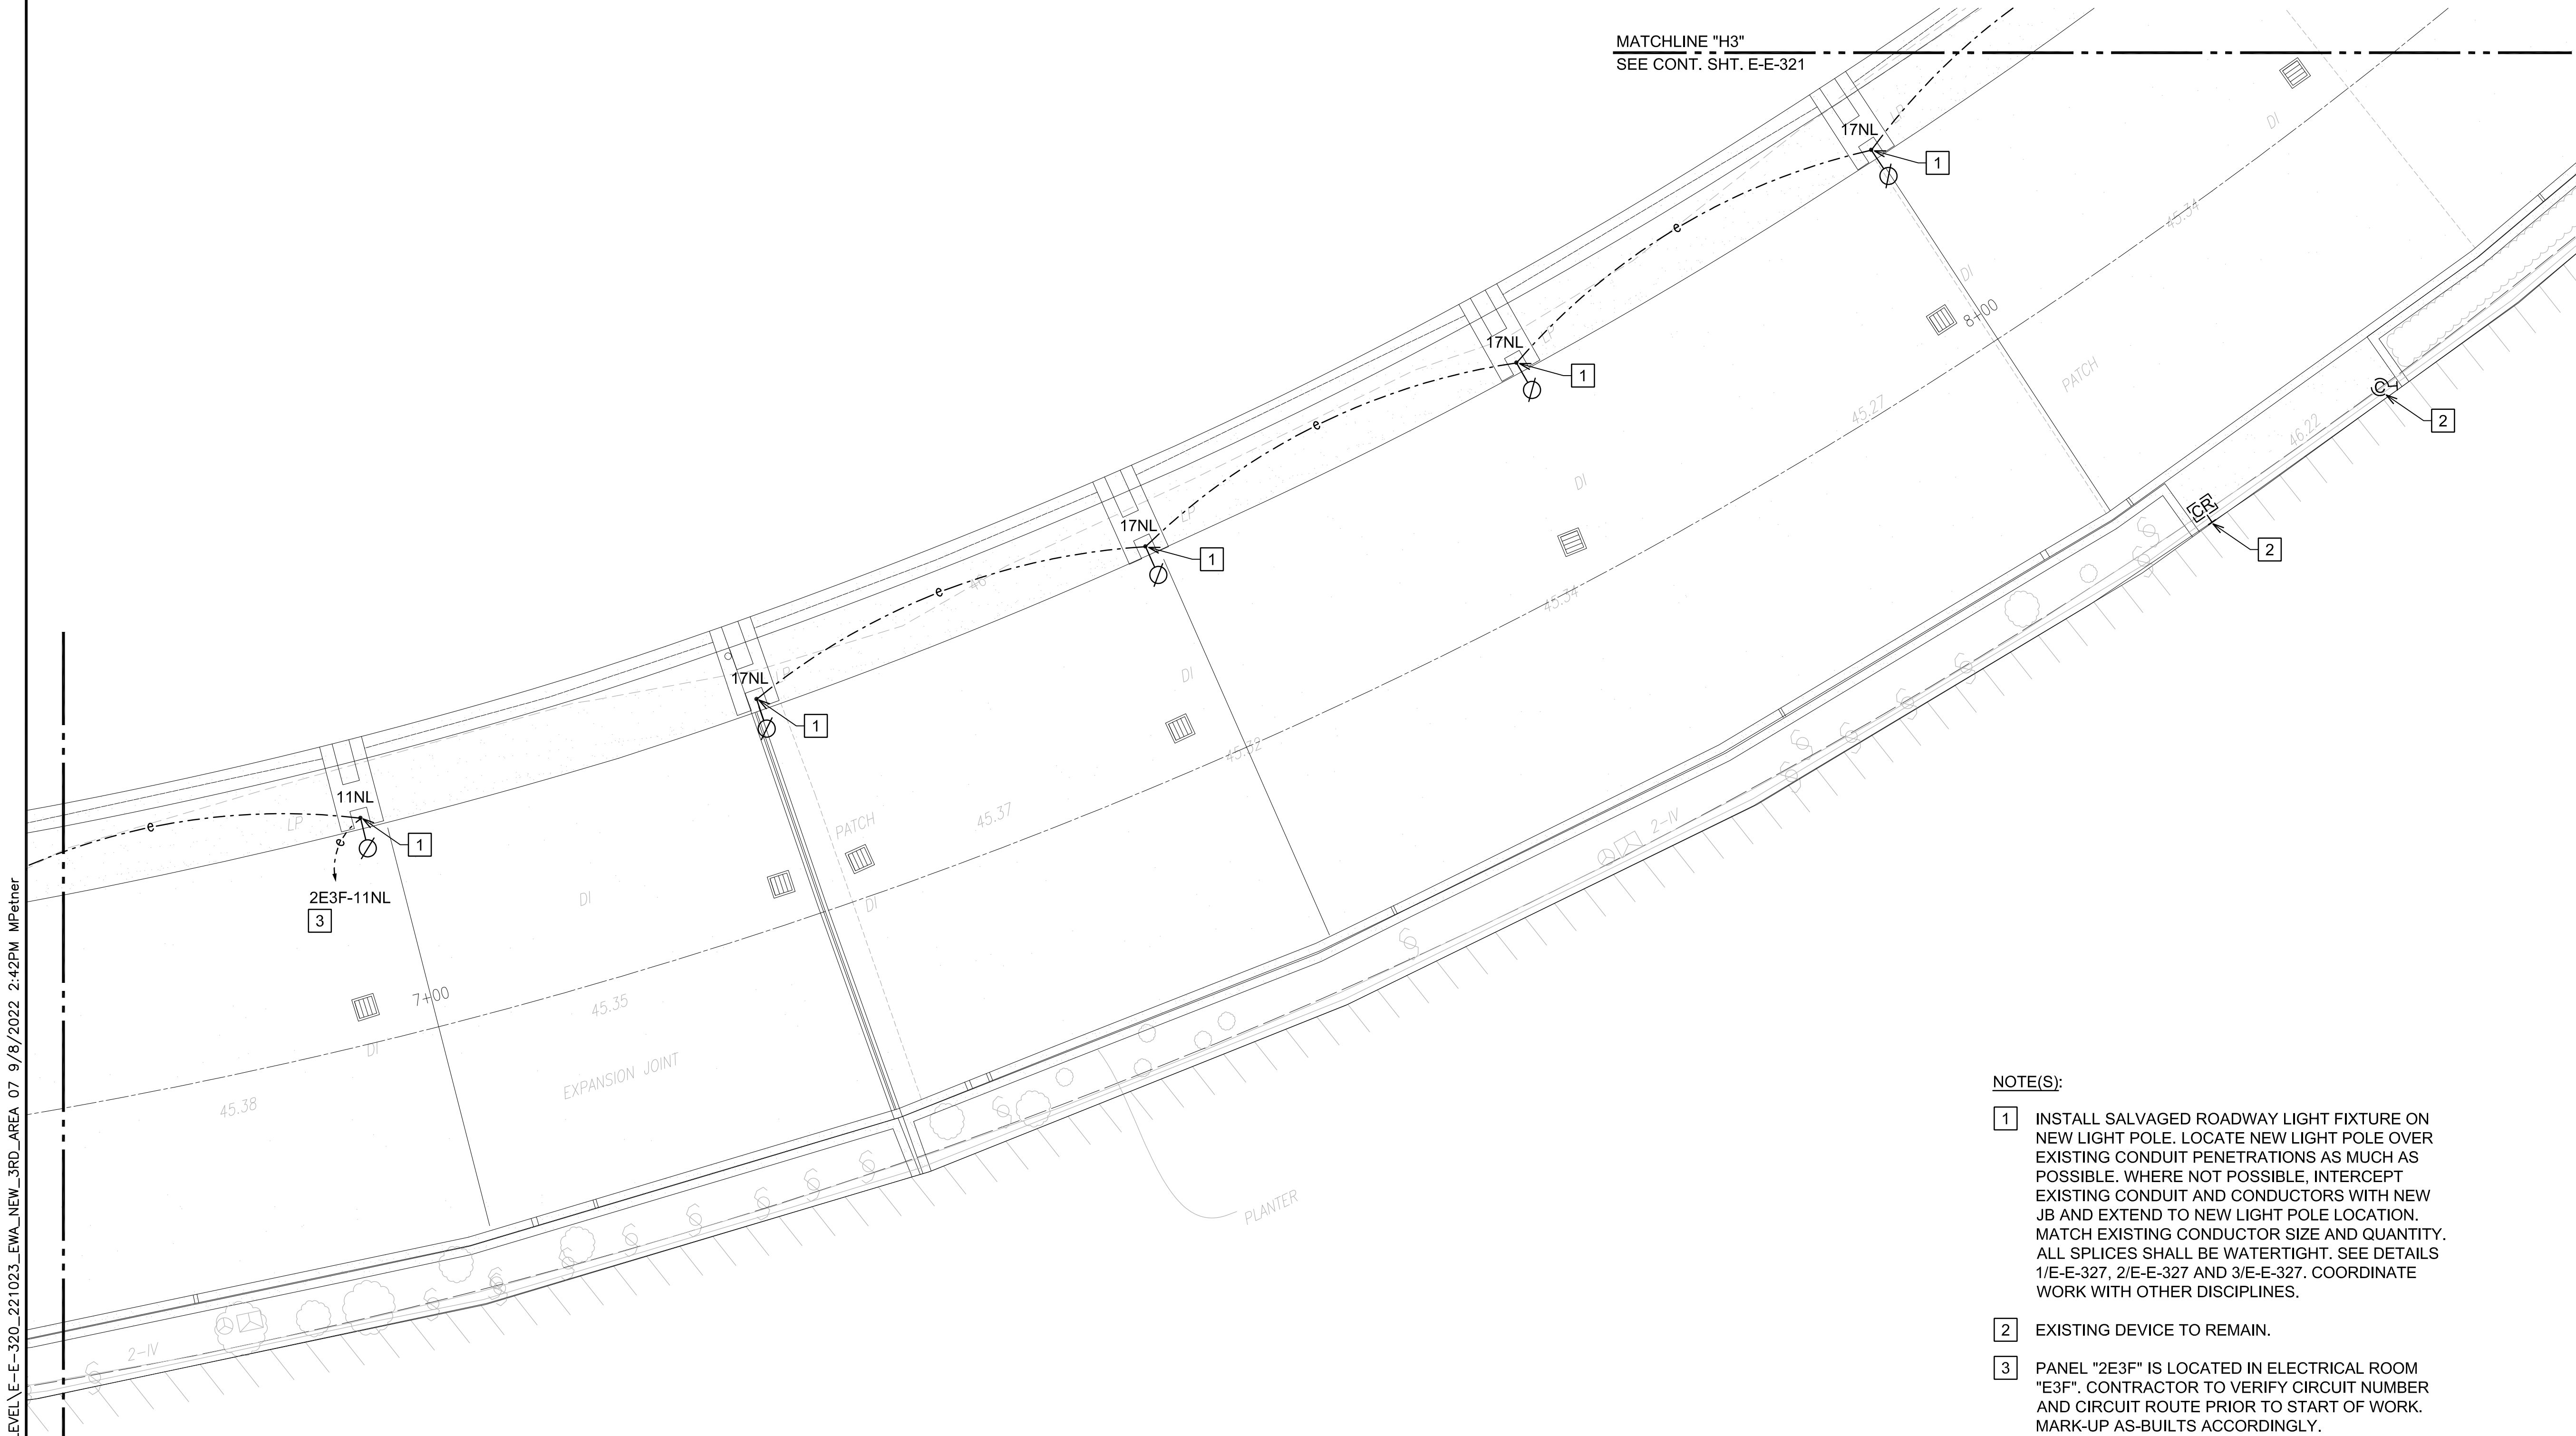

MATCHLINE "G3"  
SEE CONT. SHT. E-E-319





1  
E-E-320

NEW POWER AND LIGHTING PLAN EWA 3RD FLOOR AREA 7  
SCALE: 3/16"=1'-0"


NOTE(S):

- 1 INSTALL SALVAGED ROADWAY LIGHT FIXTURE ON NEW LIGHT POLE. LOCATE NEW LIGHT POLE OVER EXISTING CONDUIT PENETRATIONS AS MUCH AS POSSIBLE. WHERE NOT POSSIBLE, INTERCEPT EXISTING CONDUIT AND CONDUCTORS WITH NEW JB AND EXTEND TO NEW LIGHT POLE LOCATION. MATCH EXISTING CONDUCTOR SIZE AND QUANTITY. ALL SPLICES SHALL BE WATERTIGHT. SEE DETAILS 1/E-E-327, 2/E-E-327 AND 3/E-E-327. COORDINATE WORK WITH OTHER DISCIPLINES.
- 2 EXISTING DEVICE TO REMAIN.
- 3 PANEL "2E3F" IS LOCATED IN ELECTRICAL ROOM "E3F". CONTRACTOR TO VERIFY CIRCUIT NUMBER AND CIRCUIT ROUTE PRIOR TO START OF WORK. MARK-UP AS-BUILTS ACCORDINGLY.

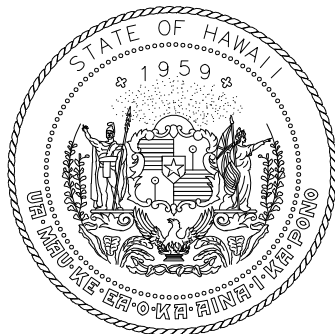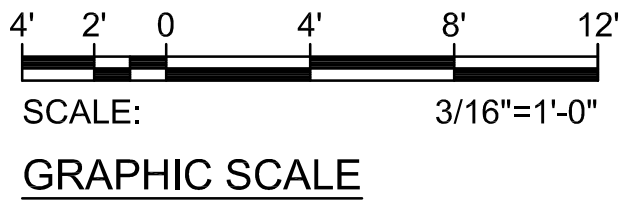

Airports Division  
DEPARTMENT OF TRANSPORTATION  
STATE OF HAWAII


RONALD N. S. HO & ASSOC., INC.  
Electrical Engineers

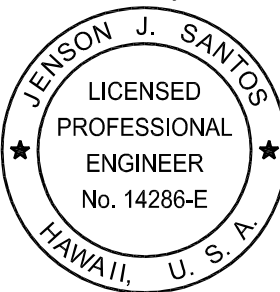

*Jenson J. Santos* 2022.09.09  
THIS WORK WAS PREPARED BY  
ME OR UNDER MY SUPERVISION  
EXPIRATION DATE OF THE LICENSE:  
2024.04.30

DSGN.	DRWN.	CHKD.	APPD.
MP	CAD	JS	JS

KEY PLAN / NOTES:

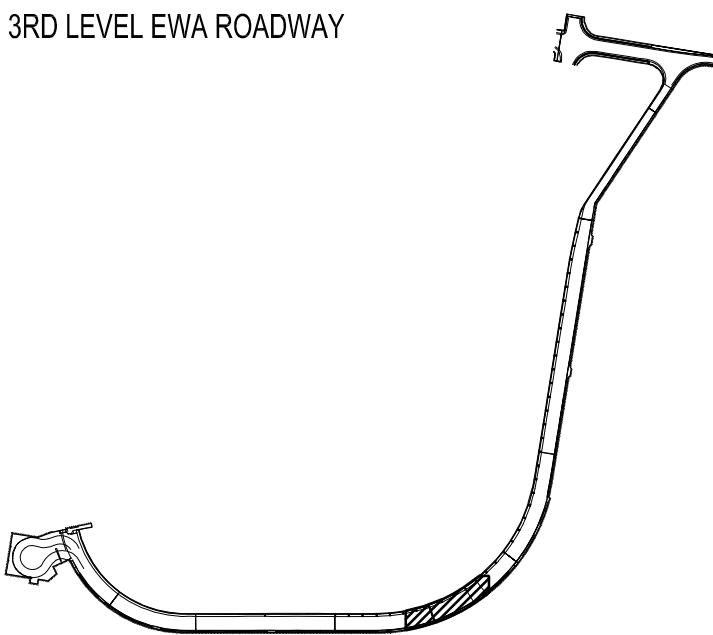

NO.	DATE	REVISIONS

CONSTRUCTION DOCUMENTS

SEPTEMBER, 2022  
DATE

PROJECT TITLE :

EWA AND DH CONCOURSE  
ROADWAY IMPROVEMENTS  
PHASE 1

AT  
DANIEL K. INOUE INTERNATIONAL AIRPORT  
HONOLULU, OAHU, HAWAII

PROJECT NO.:

AO1043-32

SHEET TITLE:



NEW POWER AND'  
LIGHTINGPLAN EWA  
3RD FLOOR AREA 7

DATE :
SEPTEMBER, 2022
SHEET :
220 OF 247 SHEETS

DWG. NO.

E-E-320

Z:\ACAD\PROJECTS\221023\_EWA\_3RD\_LEVEL\E-E-321\_221023\_EWA\_NEW\_3RD\_AREA 08 9/8/2022 2:43PM MPetner

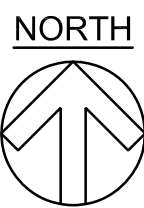
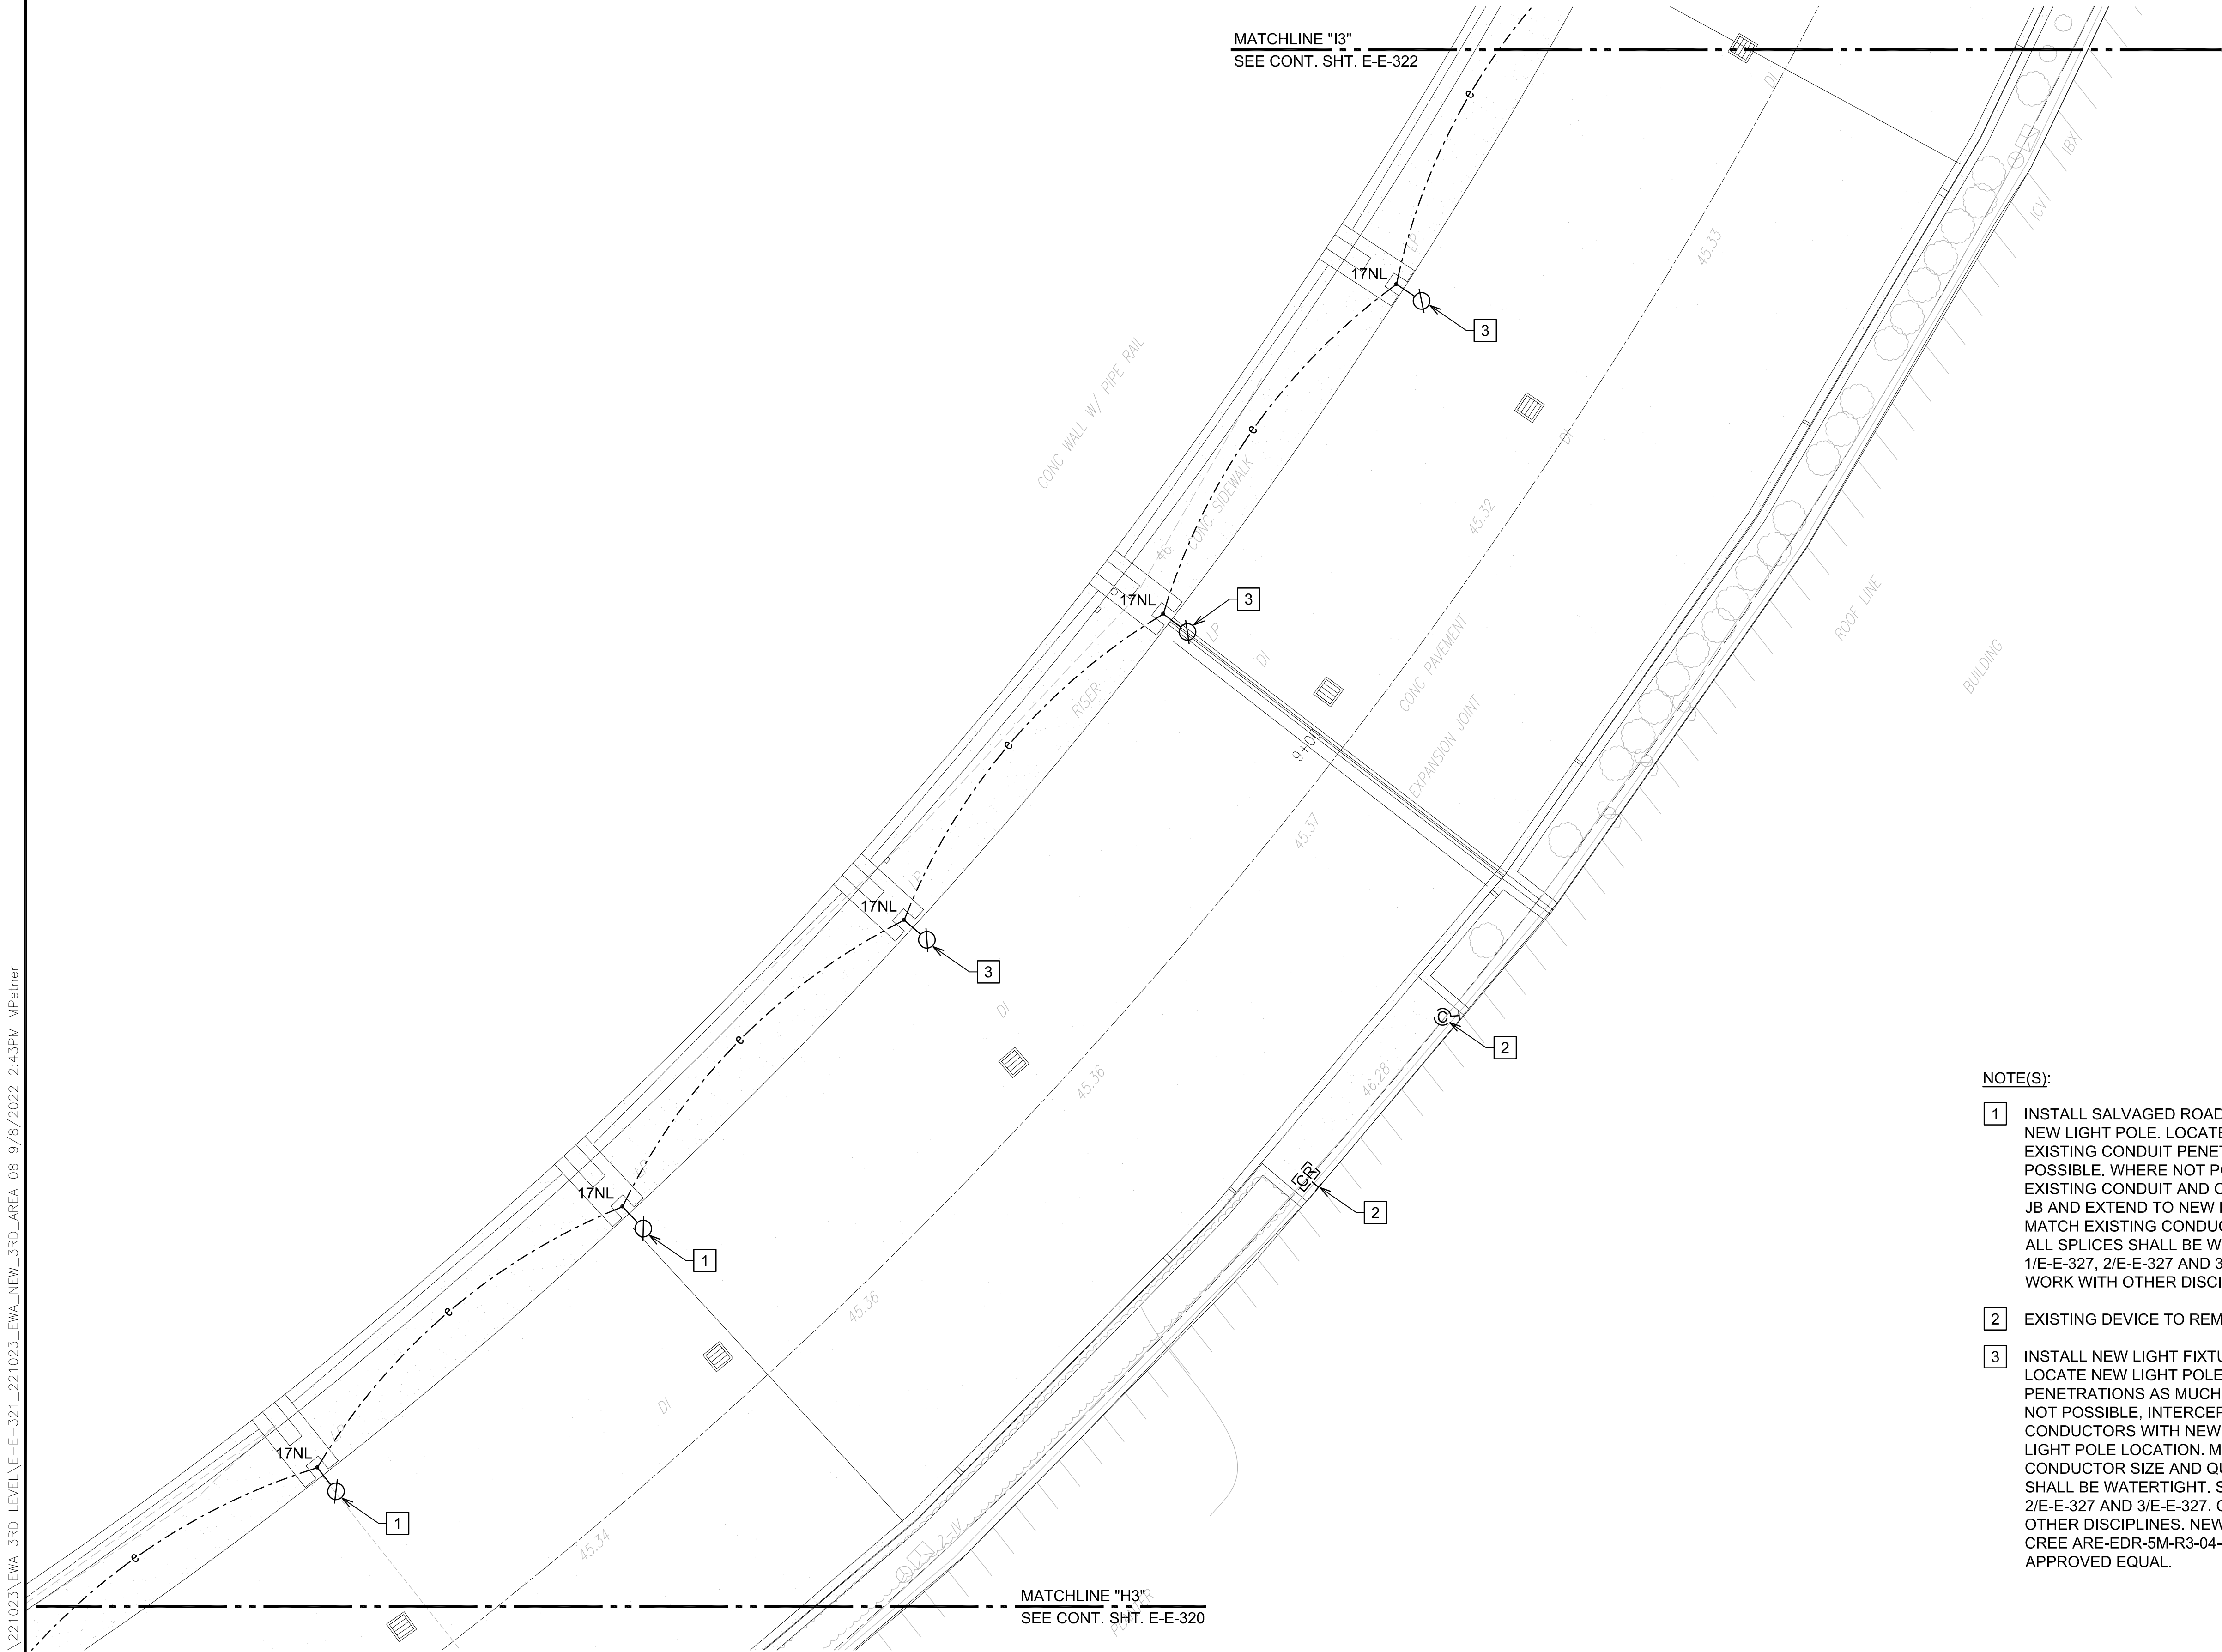


1  
E-E-321

NEW POWER AND LIGHTING PLAN EWA 3RD FLOOR AREA 8  
SCALE: 3/16"=1'-0"


NOTE(S):

- 1 INSTALL SALVAGED ROADWAY LIGHT FIXTURE ON NEW LIGHT POLE. LOCATE NEW LIGHT POLE OVER EXISTING CONDUIT PENETRATIONS AS MUCH AS POSSIBLE. WHERE NOT POSSIBLE, INTERCEPT EXISTING CONDUIT AND CONDUCTORS WITH NEW JB AND EXTEND TO NEW LIGHT POLE LOCATION. MATCH EXISTING CONDUCTOR SIZE AND QUANTITY. ALL SPLICES SHALL BE WATERTIGHT. SEE DETAILS 1/E-E-327, 2/E-E-327 AND 3/E-E-327. COORDINATE WORK WITH OTHER DISCIPLINES.
- 2 EXISTING DEVICE TO REMAIN.
- 3 INSTALL NEW LIGHT FIXTURE ON NEW LIGHT POLE. LOCATE NEW LIGHT POLE OVER EXISTING CONDUIT PENETRATIONS AS MUCH AS POSSIBLE. WHERE NOT POSSIBLE, INTERCEPT EXISTING CONDUIT AND CONDUCTORS WITH NEW JB AND EXTEND TO NEW LIGHT POLE LOCATION. MATCH EXISTING CONDUCTOR SIZE AND QUANTITY. ALL SPLICES SHALL BE WATERTIGHT. SEE DETAILS 1/E-E-327, 2/E-E-327 AND 3/E-E-327. COORDINATE WORK WITH OTHER DISCIPLINES. NEW LIGHT FIXTURE MODEL: CREE ARE-EDR-5M-R3-04-D-UL-BK-525-40K-TL OR APPROVED EQUAL.

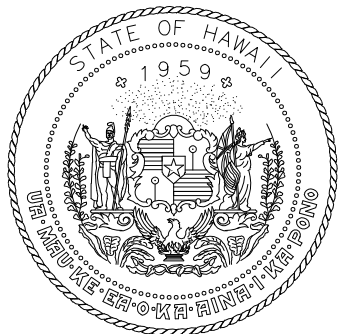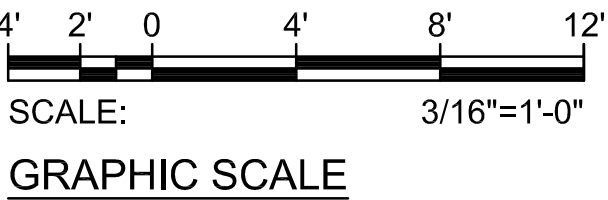

Airports Division  
DEPARTMENT OF TRANSPORTATION  
STATE OF HAWAII


RONALD N. S. HO & ASSOC., INC.  
Electrical Engineers

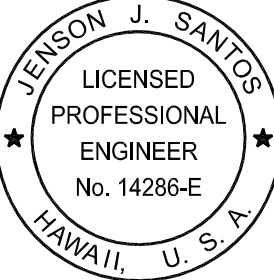

*Jenson J. Santos* 2022.09.09  
THIS WORK WAS PREPARED BY  
ME OR UNDER MY SUPERVISION  
EXPIRATION DATE OF THE LICENSE:  
2024.04.30

DSGN.	DRWN.	CHKD.	APPD.
MP	CAD	JS	JS

KEY PLAN / NOTES:

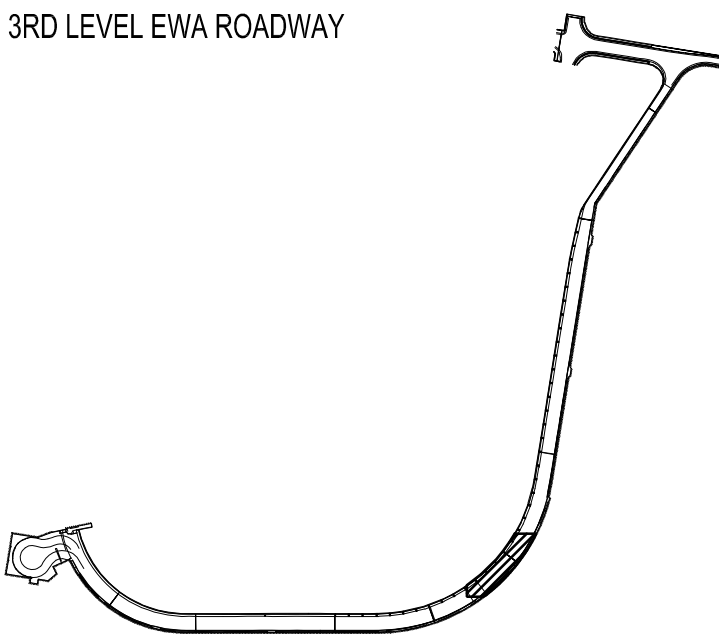

NO.	DATE	REVISIONS

CONSTRUCTION DOCUMENTS

SEPTEMBER, 2022  
DATE

PROJECT TITLE :

EWA AND DH CONCOURSE  
ROADWAY IMPROVEMENTS  
PHASE 1

AT  
DANIEL K. INOUE INTERNATIONAL AIRPORT  
HONOLULU, OAHU, HAWAII

PROJECT NO.:

AO1043-32

SHEET TITLE:

NEW POWER AND  
LIGHTING PLAN EWA  
3RD FLOOR AREA 8

DATE :  
SEPTEMBER, 2022  
SHEET :

DWG. NO.


E-E-321

221 OF 247 SHEETS

Z:\ACAD\PROJECTS\221023\_EWA\_3RD\_LEVEL\E-E-322\_221023\_EWA\_NEW\_3RD\_AREA 09 9/8/2022 2:43PM MPetner

MATCHLINE "J3"  
SEE CONT. SHT. E-E-323

MATCHLINE "I3"  
SEE CONT. SHT. E-E-321

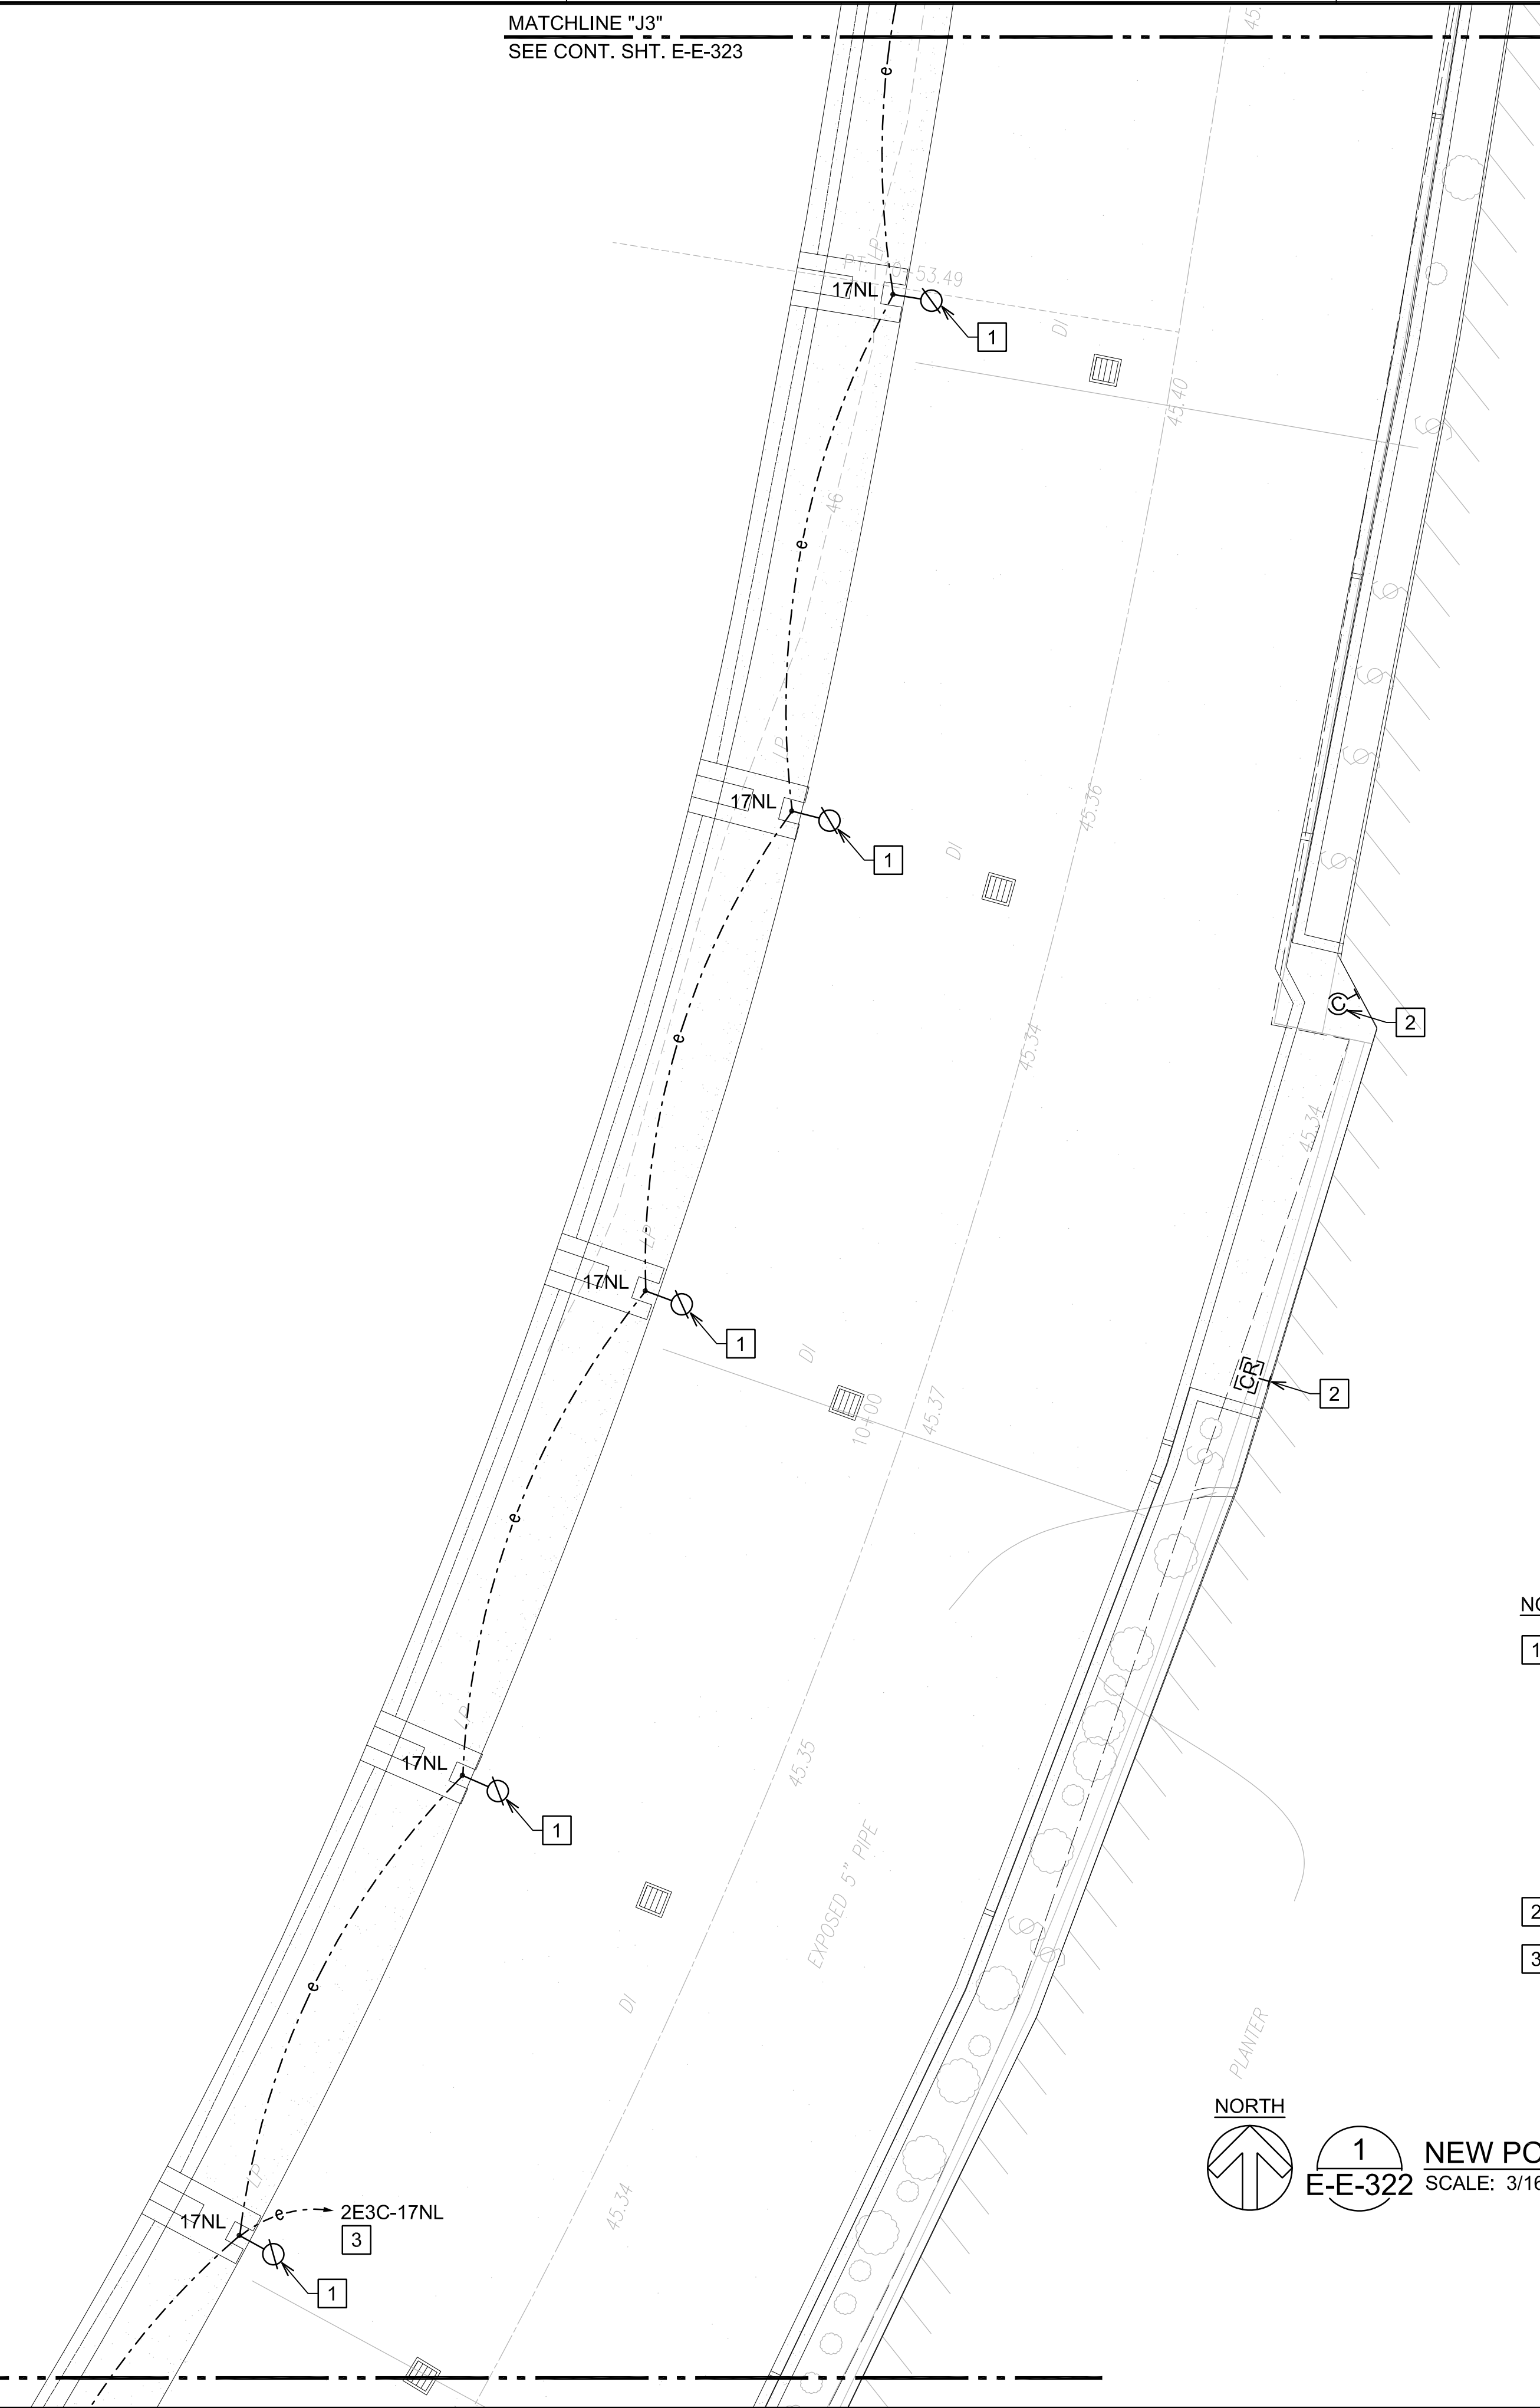



NOTE(S):

- [1] INSTALL SALVAGED ROADWAY LIGHT FIXTURE ON NEW LIGHT POLE. LOCATE NEW LIGHT POLE OVER EXISTING CONDUIT PENETRATIONS AS MUCH AS POSSIBLE. WHERE NOT POSSIBLE, INTERCEPT EXISTING CONDUIT AND CONDUCTORS WITH NEW JB AND EXTEND TO NEW LIGHT POLE LOCATION. MATCH EXISTING CONDUCTOR SIZE AND QUANTITY. ALL SPLICES SHALL BE WATERTIGHT. SEE DETAILS 1/E-E-327, 2/E-E-327 AND 3/E-E-327. COORDINATE WORK WITH OTHER DISCIPLINES.
- [2] EXISTING DEVICE TO REMAIN.
- [3] PANEL "2E3C" LOCATED IN ELECTRICAL ROOM "E3C". CONTRACTOR TO VERIFY CIRCUIT NUMBER AND CIRCUIT ROUTE PRIOR TO THE START OF WORK. MARK-UP AS-BUILTS ACCORDINGLY.




1  
E-E-322

NEW POWER AND LIGHTING PLAN EWA 3RD FLOOR AREA 9  
SCALE: 3/16"=1'-0"

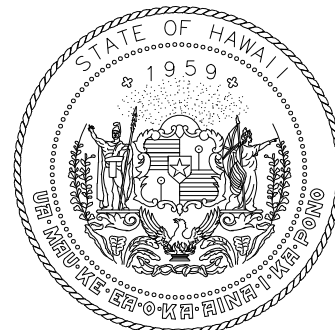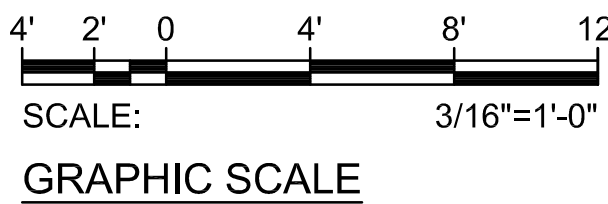

Airports Division  
DEPARTMENT OF TRANSPORTATION  
STATE OF HAWAII


RONALD N. S. HO & ASSOC., INC.  
Electrical Engineers

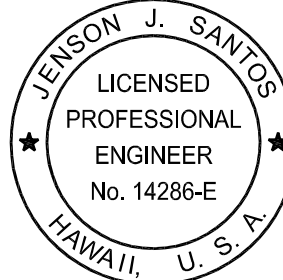

*Jenson J. Santos* 2022.09.09  
THIS WORK WAS PREPARED BY  
ME OR UNDER MY SUPERVISION  
EXPIRATION DATE OF THE LICENSE:  
2024.04.30

DSGN.	DRWN.	CHKD.	APPD.
MP	CAD	JS	JS

KEY PLAN / NOTES:

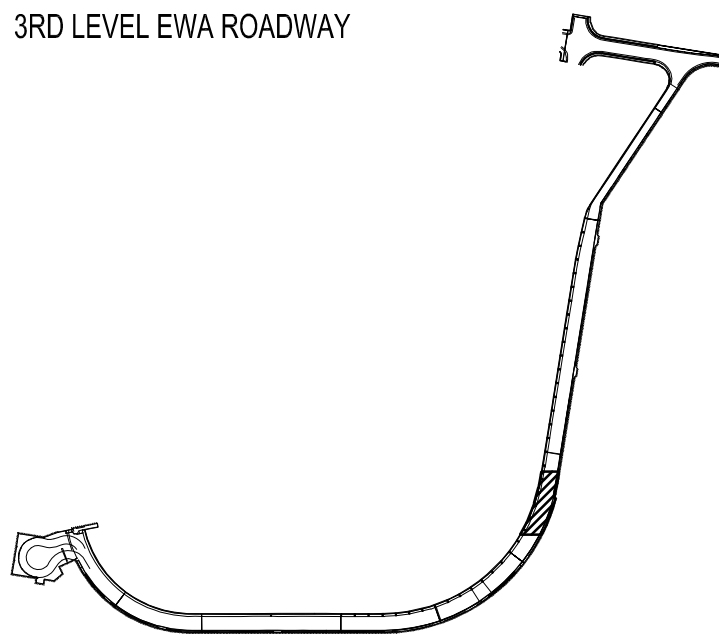

NO.	DATE	REVISIONS
-----	------	-----------

CONSTRUCTION DOCUMENTS

SEPTEMBER, 2022  
DATE

PROJECT TITLE :

EWA AND DH CONCOURSE  
ROADWAY IMPROVEMENTS  
PHASE 1

AT  
DANIEL K. INOUE INTERNATIONAL AIRPORT  
HONOLULU, OAHU, HAWAII

PROJECT NO.:

AO1043-32

SHEET TITLE:

NEW POWER AND  
LIGHTING PLAN EWA  
3RD FLOOR AREA 9

DATE :  
SEPTEMBER, 2022  
SHEET :

DWG. NO.

E-E-322


222 OF 247 SHEETS

Z:\ACAD\PROJECTS\221023\_EWA\_3RD\_LEVEL\E-E-323\_221023\_EWA\_NEW\_3RD\_AREA 10 9/9/2022 5:22PM MPetner

MATCHLINE "K3"  
SEE CONT. SHT. E-E-324

STA. 22  
MAG NAIL  
ELEV.=46.06  
N 59,405.63  
E 1,666,428.79

MATCHLINE "J3"  
SEE CONT. SHT. E-E-322

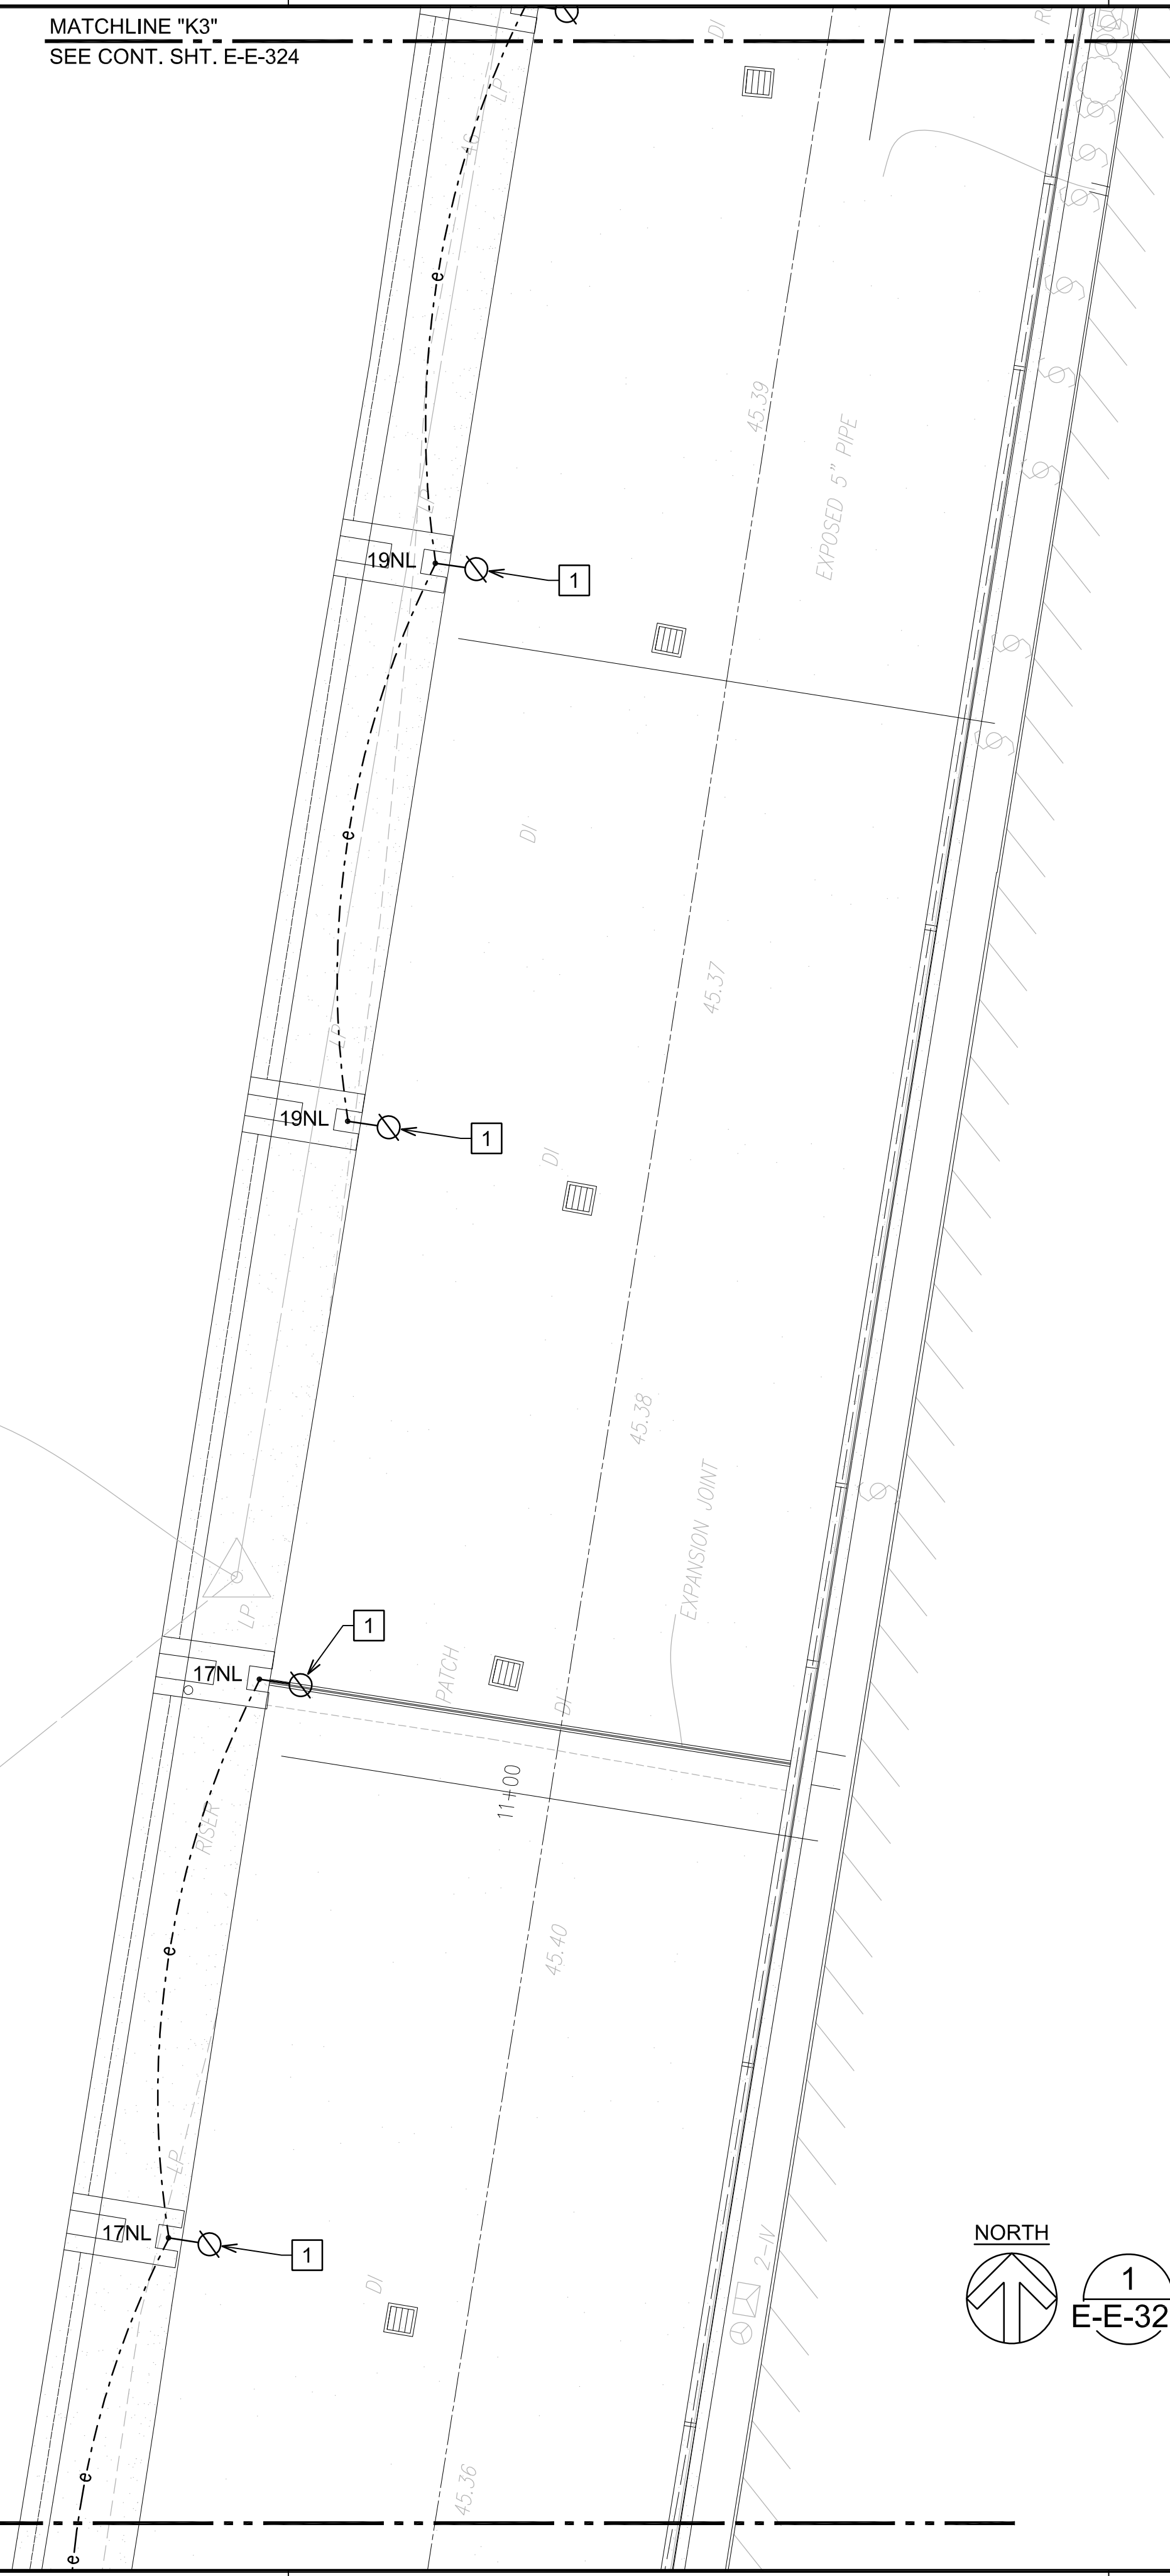



NOTE(S):

- 1 INSTALL SALVAGED ROADWAY LIGHT FIXTURE ON NEW LIGHT POLE. LOCATE NEW LIGHT POLE OVER EXISTING CONDUIT PENETRATIONS AS MUCH AS POSSIBLE. WHERE NOT POSSIBLE, INTERCEPT EXISTING CONDUIT AND CONDUCTORS WITH NEW JB AND EXTEND TO NEW LIGHT POLE LOCATION. MATCH EXISTING CONDUCTOR SIZE AND QUANTITY. ALL SPLICES SHALL BE WATERTIGHT. SEE DETAILS 1/E-E-327, 2/E-E-327 AND 3/E-E-327. COORDINATE WORK WITH OTHER DISCIPLINES.




1  
E-E-323

NEW POWER AND LIGHTING PLAN EWA 3RD FLOOR AREA 10  
SCALE: 3/16"=1'-0"

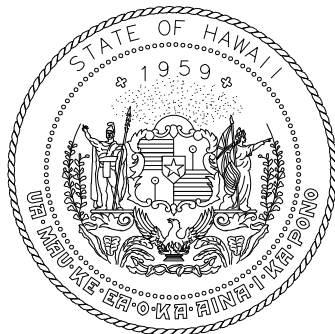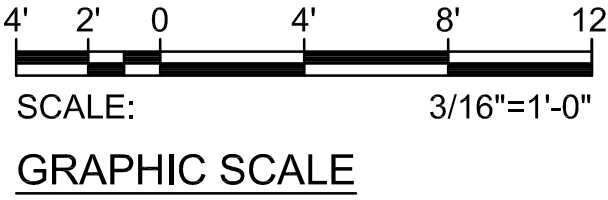

Airports Division  
DEPARTMENT OF TRANSPORTATION  
STATE OF HAWAII


RONALD N. S. HO & ASSOC., INC.  
Electrical Engineers

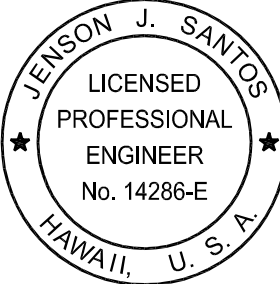

*Jenson J. Santos* 2022.09.09  
THIS WORK WAS PREPARED BY  
ME OR UNDER MY SUPERVISION  
EXPIRATION DATE OF THE LICENSE:  
2024.04.30

DSGN.	DRWN.	CHKD.	APPD.
MP	CAD	JS	JS

KEY PLAN / NOTES:

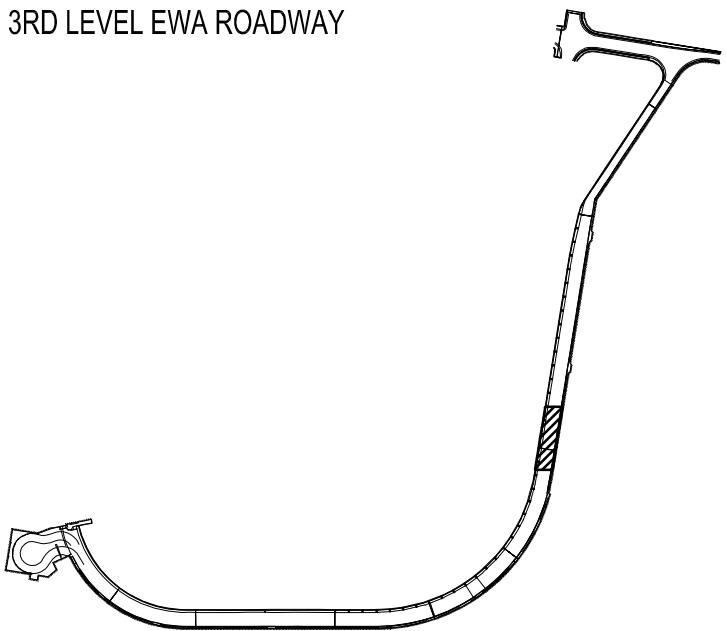

NO.	DATE	REVISIONS

CONSTRUCTION DOCUMENTS

SEPTEMBER, 2022  
DATE

PROJECT TITLE :

EWA AND DH CONCOURSE  
ROADWAY IMPROVEMENTS  
PHASE 1

AT  
DANIEL K. INOUE INTERNATIONAL AIRPORT  
HONOLULU, OAHU, HAWAII

PROJECT NO.:

AO1043-32

SHEET TITLE:

NEW POWER AND  
LIGHTING PLAN EWA  
3RD FLOOR AREA 10


DATE :  
SEPTEMBER, 2022  
SHEET :

DWG. NO.

E-E-323

223 OF 247 SHEETS

MATCHLINE "L3"  
SEE CONT. SHT. E-E-325

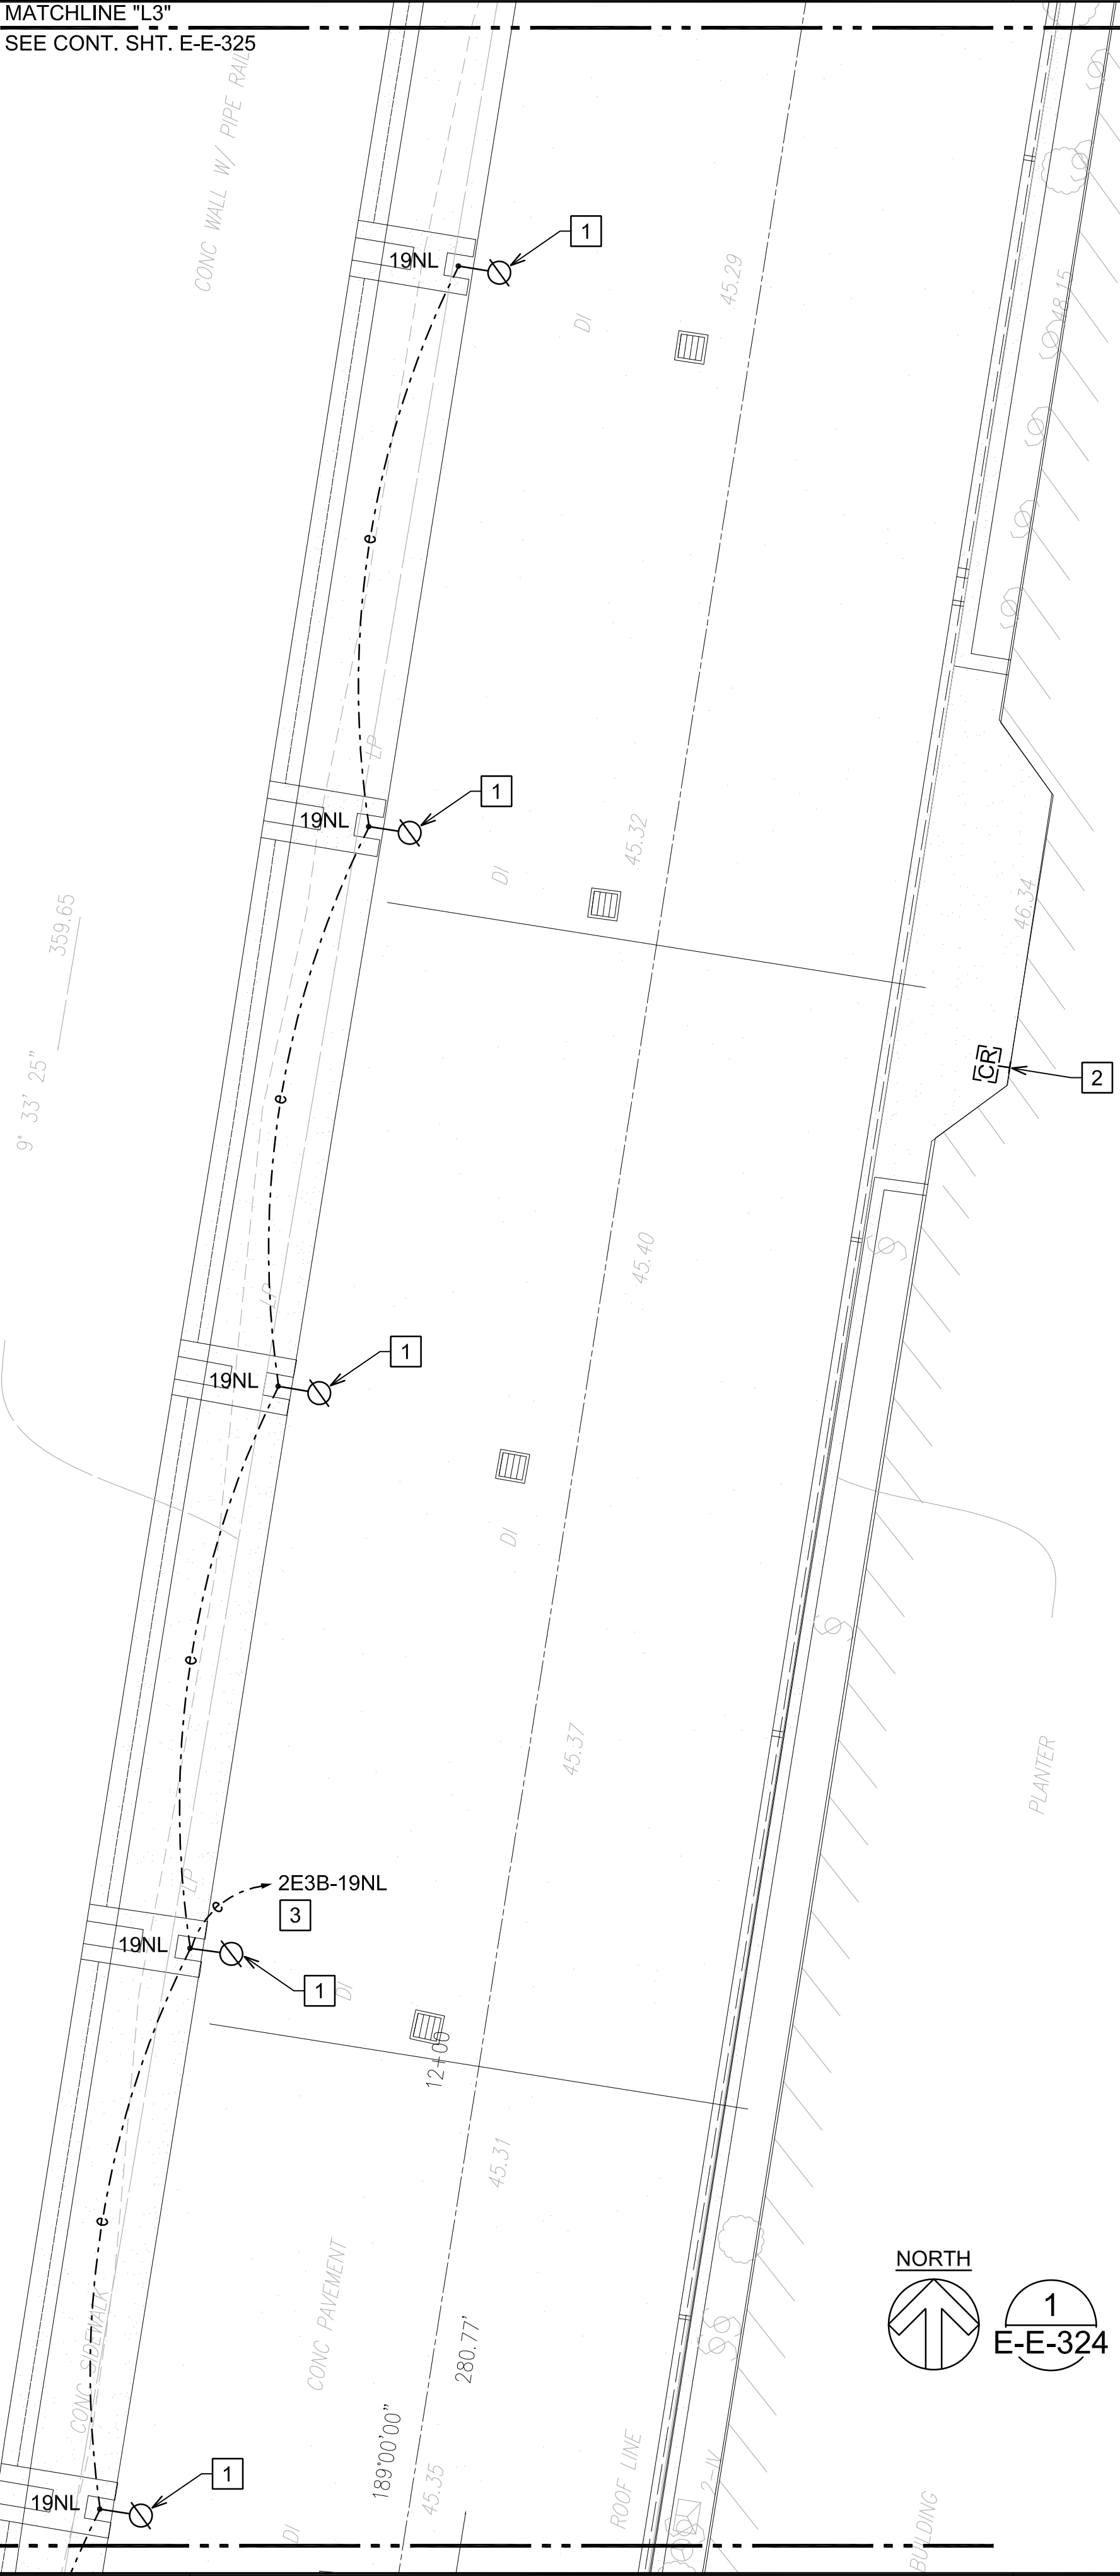

MATCHLINE "K3"  
SEE CONT. SHT. E-E-323

1  
E-E-324

NEW POWER AND LIGHTING PLAN EWA 3RD FLOOR AREA 11  
SCALE: 3/16"=1'-0"


NOTE(S):

- 1 INSTALL SALVAGED ROADWAY LIGHT FIXTURE ON NEW LIGHT POLE. LOCATE NEW LIGHT POLE OVER EXISTING CONDUIT PENETRATIONS AS MUCH AS POSSIBLE. WHERE NOT POSSIBLE, INTERCEPT EXISTING CONDUIT AND CONDUCTORS WITH NEW JB AND EXTEND TO NEW LIGHT POLE LOCATION. MATCH EXISTING CONDUCTOR SIZE AND QUANTITY. ALL SPLICES SHALL BE WATERTIGHT. SEE DETAILS 1/E-E-327, 2/E-E-327 AND 3/E-E-27. COORDINATE WORK WITH OTHER DISCIPLINES.
- 2 EXISTING DEVICE TO REMAIN.
- 3 PANEL "2E3B" LOCATED IN ELECTRICAL ROOM "E3B". CONTRACTOR TO VERIFY CIRCUIT NUMBER AND CIRCUIT ROUTE PRIOR TO THE START OF WORK. MARK-UP AS-BUILTS ACCORDINGLY.

$$\begin{array}{ccccccc} 4' & 2' & 0 & & 4' & 8' & 12' \\ | & | & | & & | & | & | \\ \hline \end{array}$$


SCALE: 3/16"=1'-0"

### GRAPHIC SCALE

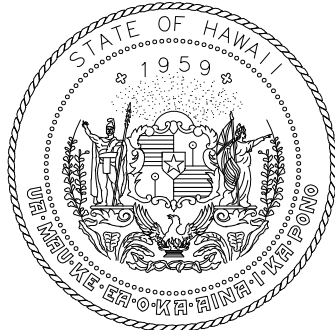

**Airports Division**  
DEPARTMENT OF TRANSPORTATION  
STATE OF HAWAII

RONALD N. S. HO & ASSOC., INC.  
Electrical Engineers

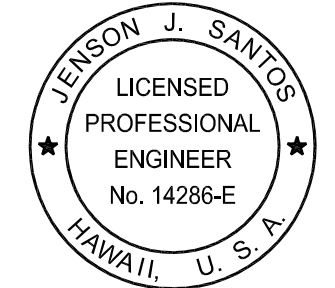

*Junia Kator* 2022.09.09


THIS WORK WAS PREPARED BY  
ME OR UNDER MY SUPERVISION

EXPIRATION DATE OF THE LICENSE:  
2024.04.30

DSGN.	DRWN.	CHKD.	APPD.
MP	CAD	JS	JS

KEY PLAN / NOTES:

3RD LEVEL EWA ROADWAY

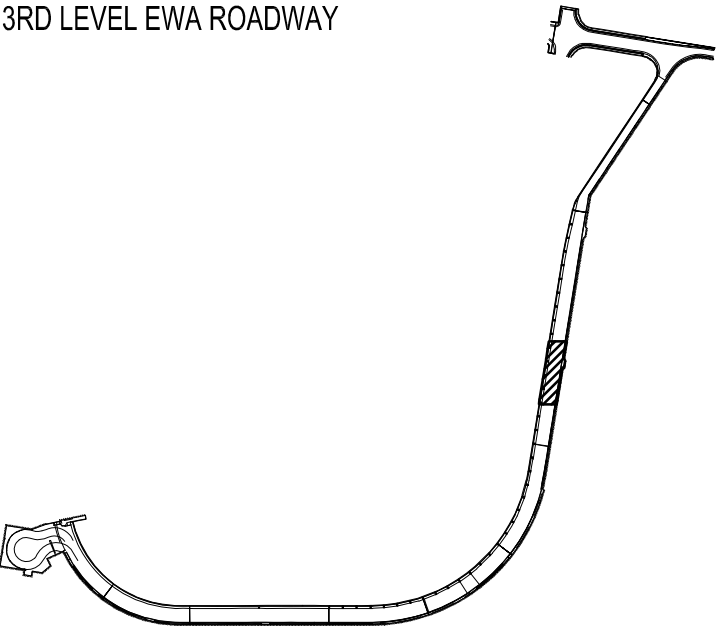

NO.	DATE	REVISIONS

# CONSTRUCTION DOCUMENTS

SEPTMBER, 2022

---

DATE

PROJECT TITLE :

# EWA AND DH CONCOURSE ROADWAY IMPROVEMENTS PHASE 1

AT  
DANIEL K. INOUE INTERNATIONAL AIRPORT  
HONOLULU, OAHU, HAWAII

PROJECT NO.:

**AO1043-32**

SHEET TITLE:


**NEW POWER AND  
LIGHTING PLAN EWA  
3RD FLOOR AREA 11**

DATE :	DWG. NO.
SEPTEMBER, 2022	E-E-324
SHEET :	
224 OF 247 SHEETS	

Z:\ACAD\PROJECTS\221023\_EWA\_3RD\_LEVEL\E-E-325\_221023\_EWA\_NEW\_3RD\_AREA 12 9/8/2022 2:45PM MPetner

MATCHLINE "M3"  
SEE CONT. SHT. E-E-326

MATCHLINE "L3"  
SEE CONT. SHT. E-E-324

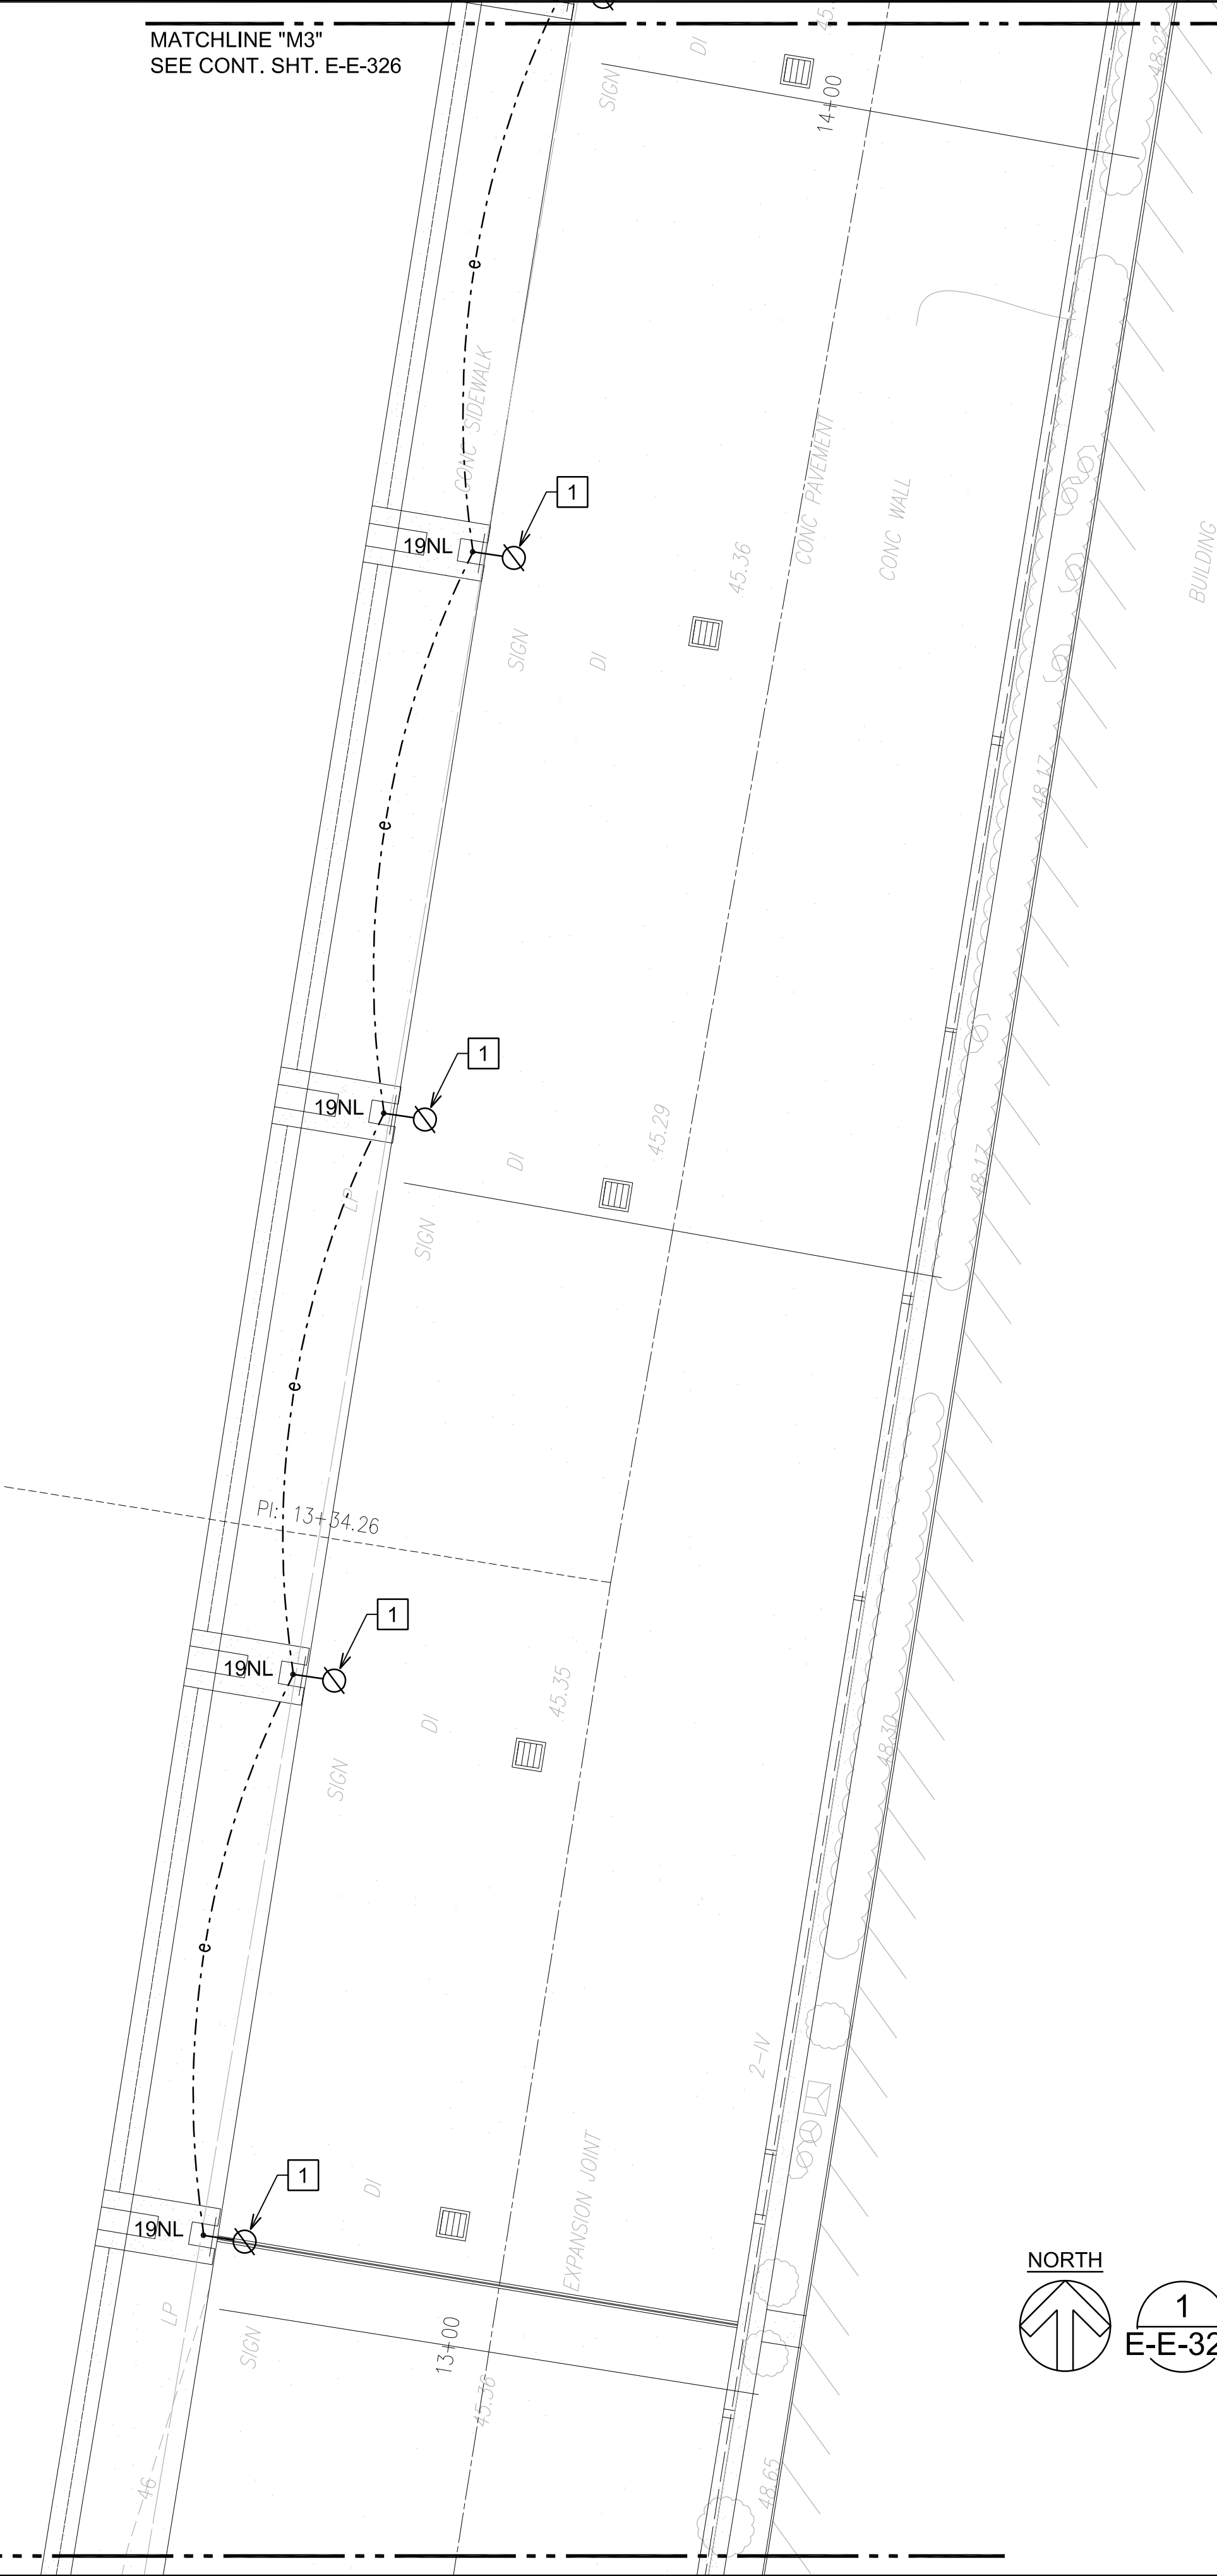



NOTE(S):

- 1 INSTALL SALVAGED ROADWAY LIGHT FIXTURE ON NEW LIGHT POLE. LOCATE NEW LIGHT POLE OVER EXISTING CONDUIT PENETRATIONS AS MUCH AS POSSIBLE. WHERE NOT POSSIBLE, INTERCEPT EXISTING CONDUIT AND CONDUCTORS WITH NEW JB AND EXTEND TO NEW LIGHT POLE LOCATION. MATCH EXISTING CONDUCTOR SIZE AND QUANTITY. ALL SPLICES SHALL BE WATERTIGHT. SEE DETAILS 1/E-E-327, 2/E-E-327 AND 3/E-E-327. COORDINATE WORK WITH OTHER DISCIPLINES.




1  
E-E-325

NEW POWER AND LIGHTING PLAN EWA 3RD FLOOR AREA 12  
SCALE: 3/16"=1'-0"

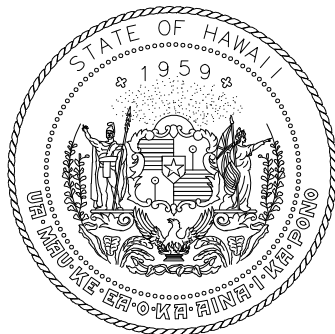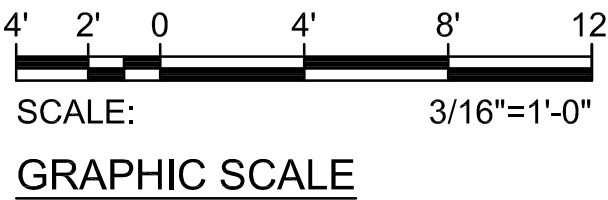

Airports Division  
DEPARTMENT OF TRANSPORTATION  
STATE OF HAWAII


RONALD N. S. HO & ASSOC., INC.  
Electrical Engineers

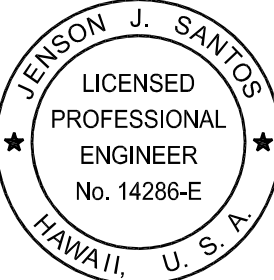

*Jenson J. Santos* 2022.09.09  
THIS WORK WAS PREPARED BY  
ME OR UNDER MY SUPERVISION  
EXPIRATION DATE OF THE LICENSE:  
2024.04.30

DSGN.	DRWN.	CHKD.	APPD.
MP	CAD	JS	JS

KEY PLAN / NOTES:

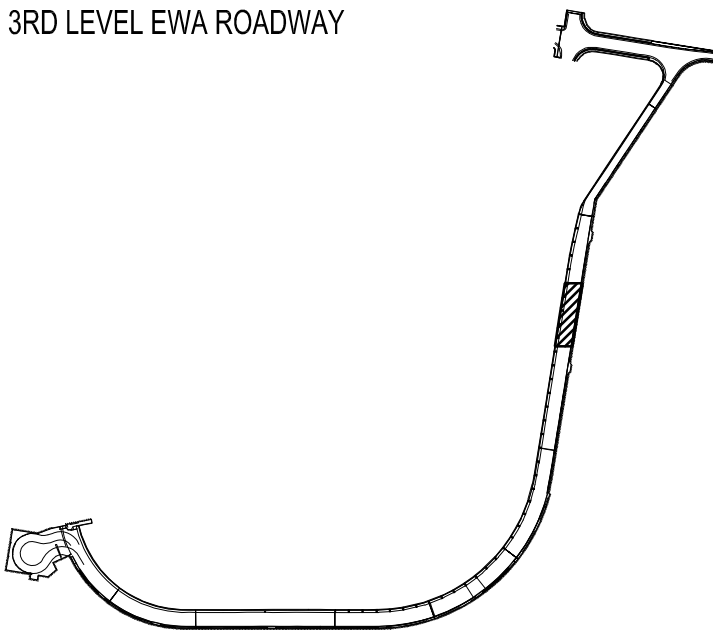

NO.	DATE	REVISIONS

CONSTRUCTION  
DOCUMENTS

SEPTEMBER, 2022  
DATE

PROJECT TITLE :

EWA AND DH CONCOURSE  
ROADWAY IMPROVEMENTS  
PHASE 1

AT  
DANIEL K. INOUE INTERNATIONAL AIRPORT  
HONOLULU, OAHU, HAWAII

PROJECT NO.:

AO1043-32

SHEET TITLE:

NEW POWER AND  
LIGHTING PLAN EWA  
3RD FLOOR AREA 12

DATE :  
SEPTEMBER, 2022  
SHEET :

DWG. NO.

E-E-325


225 OF 247 SHEETS

Z:\ACAD\PROJECTS\221023\_EWA\_3RD\_LEVEL\E-E-326\_221023\_EWA\_NEW\_3RD\_AREA\_13\_9/8/2022\_2:46PM\_MPetner

STA. 21  
MAG NAIL  
ELEV.=46.00  
N 59,760.28  
E 1,666,488.50

MATCHLINE "M3"  
SEE CONT. SHT. E-E-325

BOUNDARY FOR LIMIT OF WORK

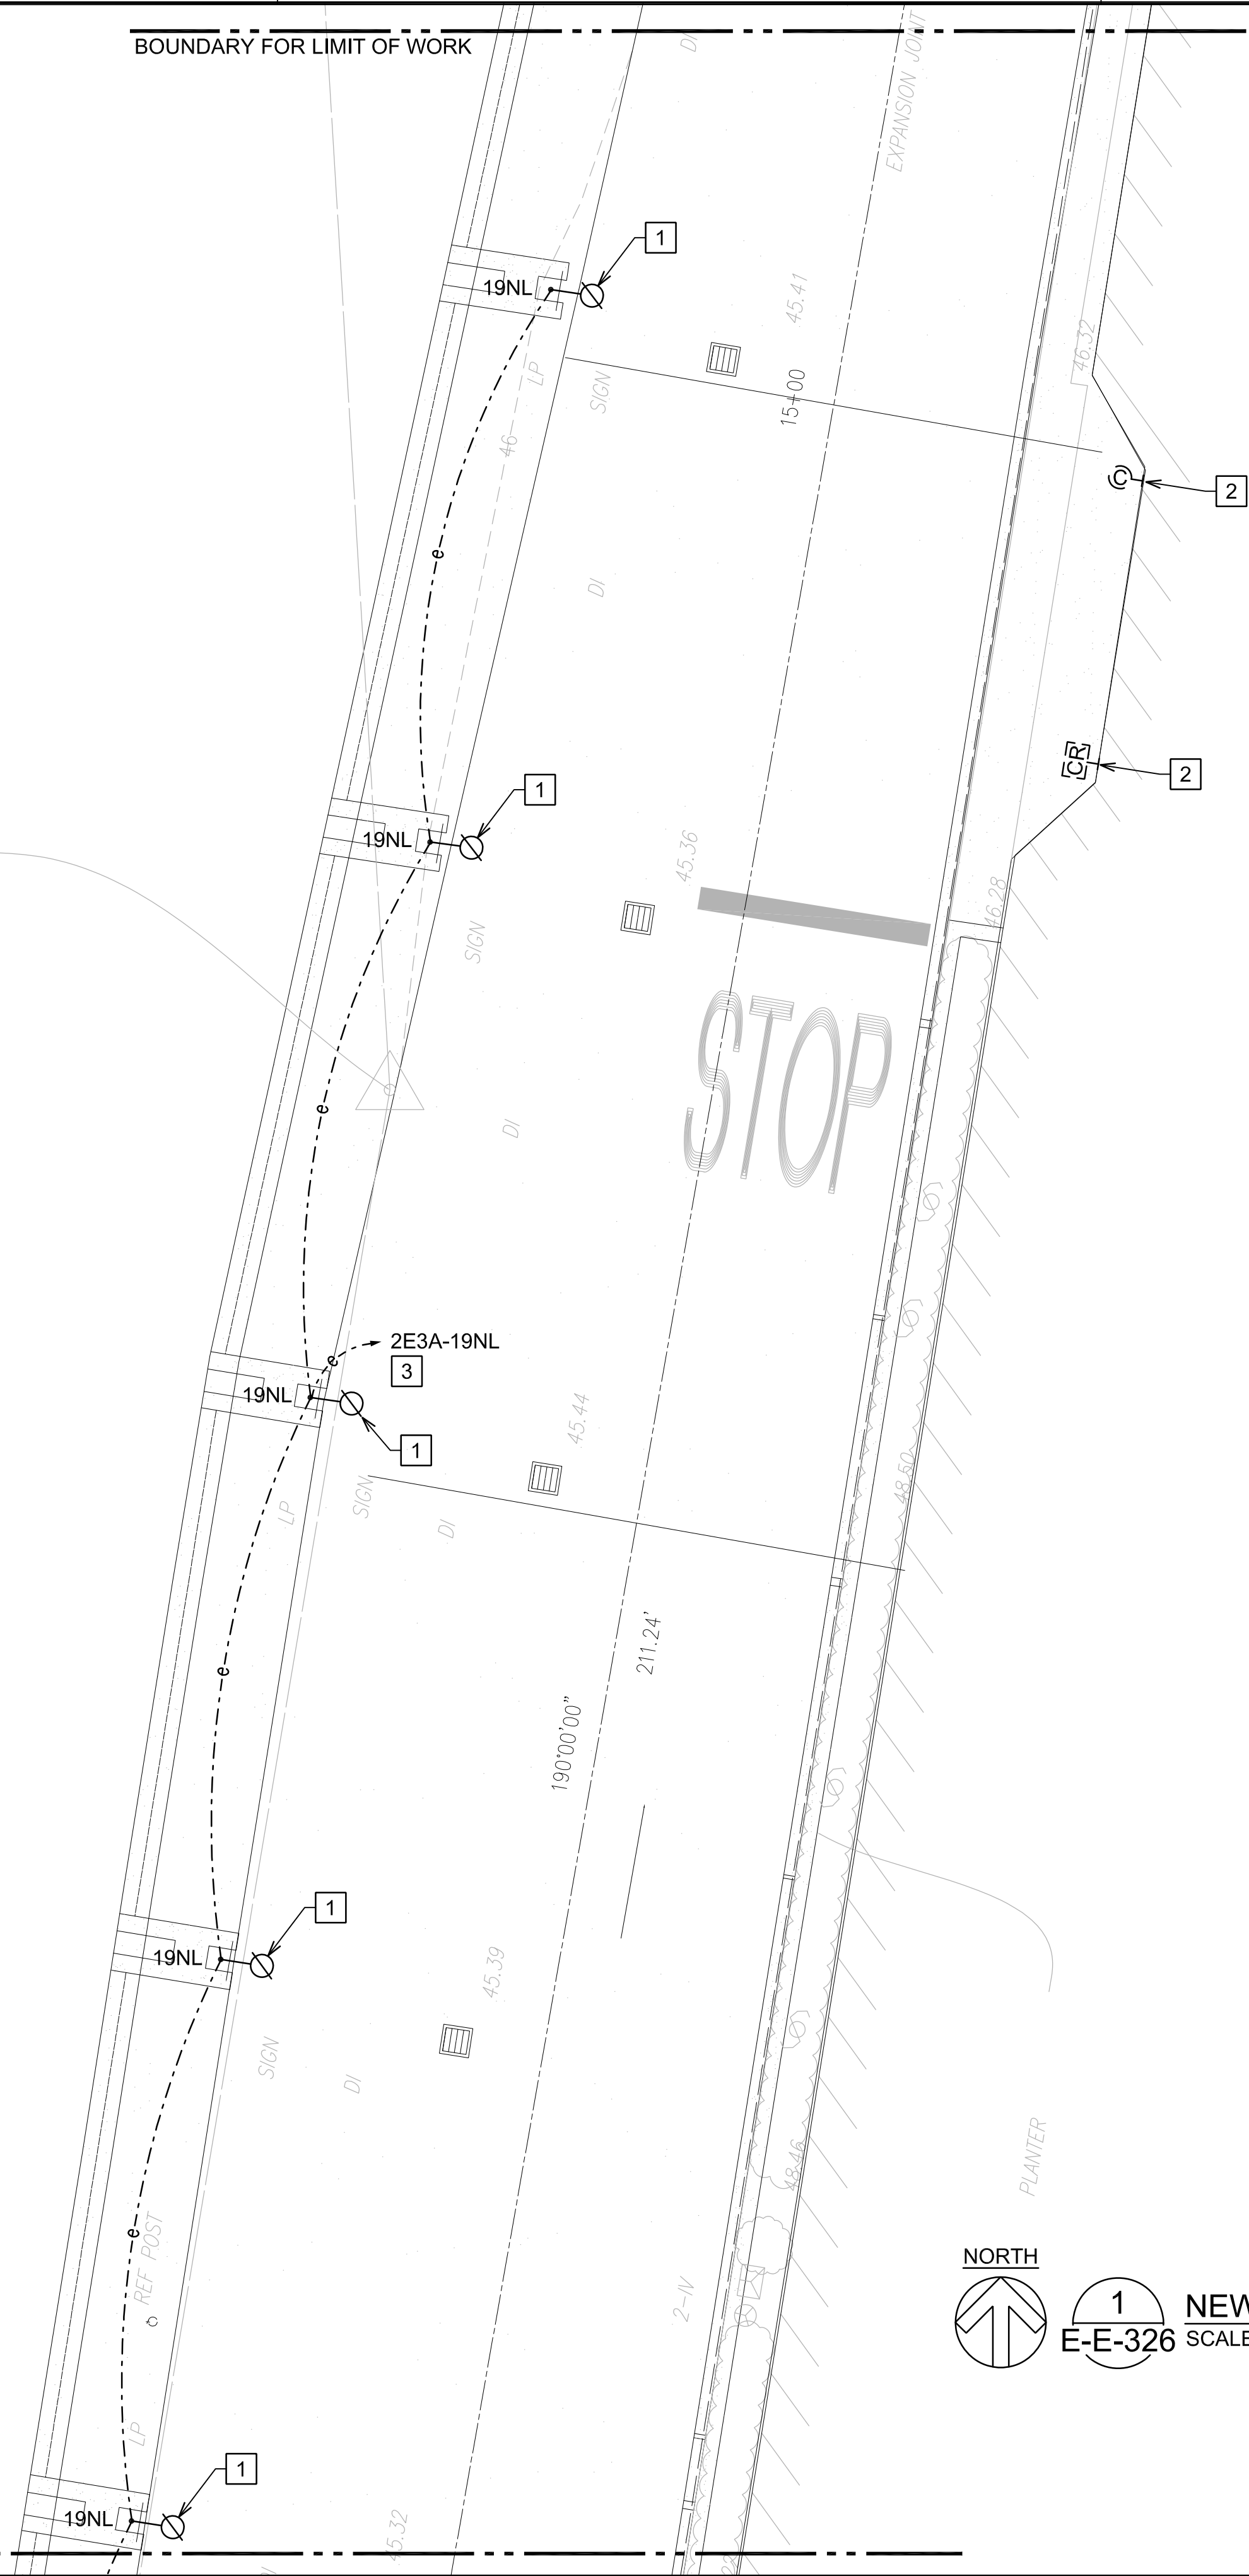



NOTE(S):

- 1 INSTALL SALVAGED ROADWAY LIGHT FIXTURE ON NEW LIGHT POLE. LOCATE NEW LIGHT POLE OVER EXISTING CONDUIT PENETRATIONS AS MUCH AS POSSIBLE. WHERE NOT POSSIBLE, INTERCEPT EXISTING CONDUIT AND CONDUCTORS WITH NEW JB AND EXTEND TO NEW LIGHT POLE LOCATION. MATCH EXISTING CONDUCTOR SIZE AND QUANTITY. ALL SPLICES SHALL BE WATERTIGHT. SEE DETAILS 1/E-E-327, 2/E-E-327 AND 3/E-E-327. COORDINATE WORK WITH OTHER DISCIPLINES.
- 2 EXISTING DEVICE TO REMAIN.
- 3 PANEL "2E3A" LOCATED IN ELECTRICAL ROOM "E3A". CONTRACTOR TO VERIFY CIRCUIT NUMBER AND CIRCUIT ROUTE PRIOR TO THE START OF WORK. MARK-UP AS-BUILTS ACCORDINGLY.




1  
E-E-326

NEW POWER AND LIGHTING PLAN EWA 3RD FLOOR AREA 13  
SCALE: 3/16"=1'-0"

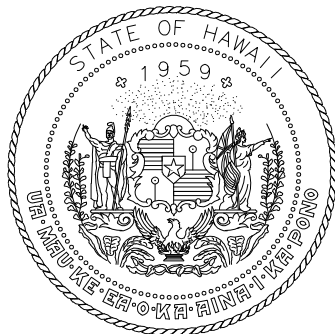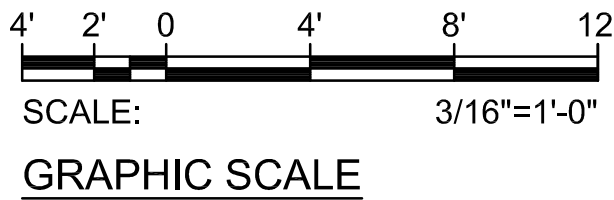

Airports Division  
DEPARTMENT OF TRANSPORTATION  
STATE OF HAWAII


RONALD N. S. HO & ASSOC., INC.  
Electrical Engineers

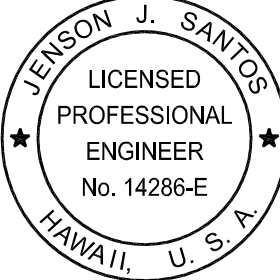

*Jenson J. Santos* 2022.09.09  
THIS WORK WAS PREPARED BY  
ME OR UNDER MY SUPERVISION  
EXPIRATION DATE OF THE LICENSE:  
2024.04.30

DSGN.	DRWN.	CHKD.	APPD.
MP	CAD	JS	JS

KEY PLAN / NOTES:

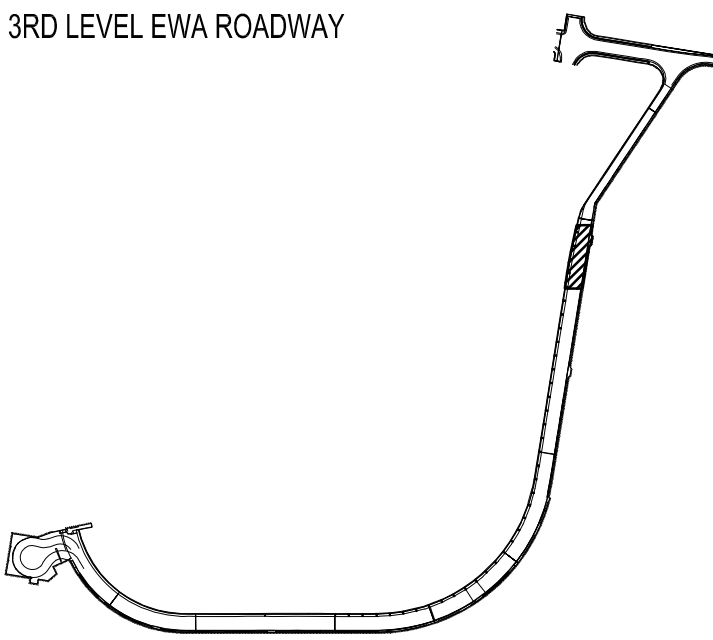

NO.	DATE	REVISIONS

CONSTRUCTION DOCUMENTS

SEPTEMBER, 2022  
DATE

PROJECT TITLE :

EWA AND DH CONCOURSE  
ROADWAY IMPROVEMENTS  
PHASE 1

AT  
DANIEL K. INOUE INTERNATIONAL AIRPORT  
HONOLULU, OAHU, HAWAII

PROJECT NO.:

AO1043-32

SHEET TITLE:

NEW POWER AND  
LIGHTING PLAN EWA  
3RD FLOOR AREA 13

DATE :  
SEPTEMBER, 2022  
SHEET :

DWG. NO.

E-E-326

226 OF 247 SHEETS