
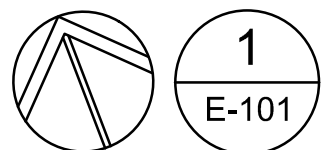




DEMOLITION NOTES:

- 1 CONTRACTOR TO VERIFY EXISTING CIRCUITS BEFORE REMOVAL.
- 2 CONTRACTOR TO KEEP AND MAINTAIN IRRIGATION CONTROL CIRCUIT.

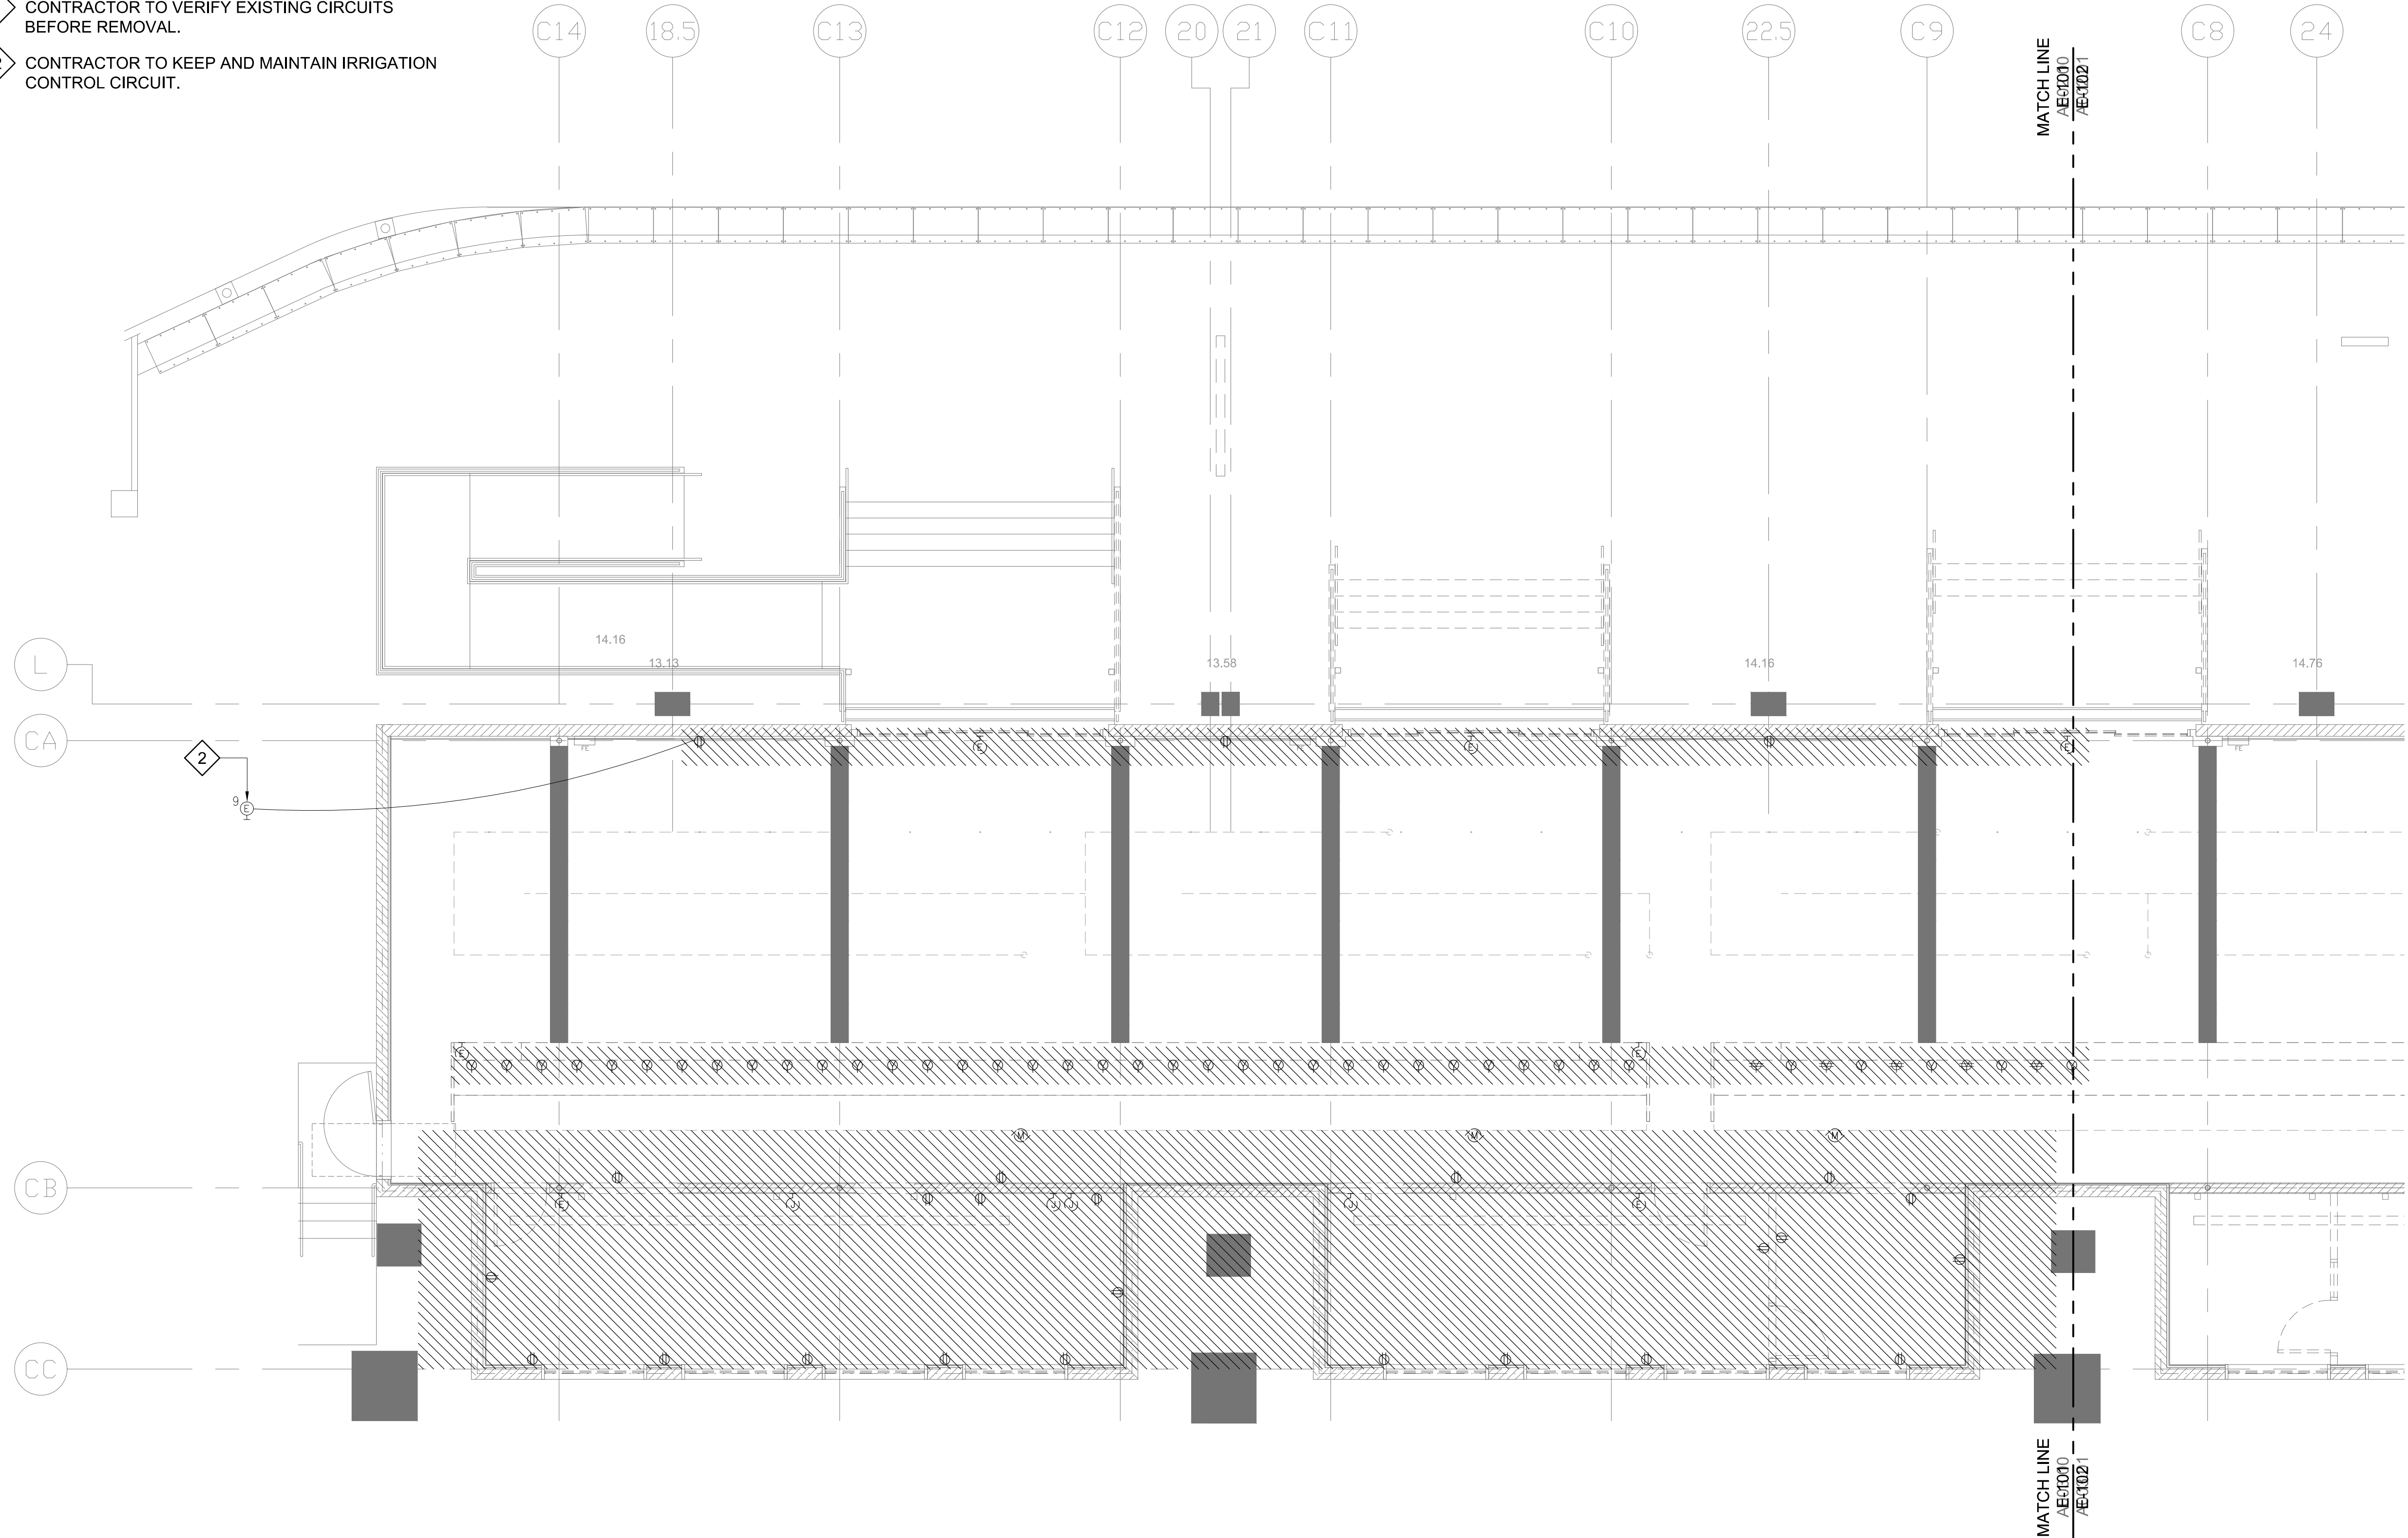


1
E-101

 ELECTRICAL FLOOR PLAN 1 - DEMO WORK
SCALE: 3/16"= 1'-0"

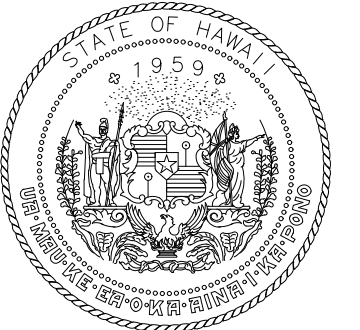

Airports Division
DEPARTMENT OF TRANSPORTATION
STATE OF HAWAII

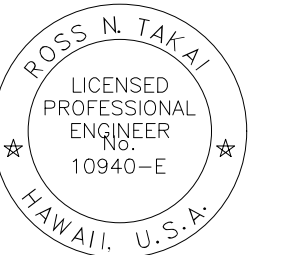

Ross N. Takai
04/30/2024
Licensed Expiration Date

This work was prepared by me or under my supervision.

DSGN.	DRWN.	CHKD.	APPD.

NO.	DATE	REVISIONS
-----	------	-----------

DATE

PROJECT TITLE :

NEW PASS AND ID OFFICE

AT
DANIEL K. INOUE INTERNATIONAL AIRPORT
HONOLULU, OAHU, HAWAII

PROJECT NO.:

CO1322-63


SHEET TITLE:

ELECTRICAL
FLOOR PLAN 1 -
DEMO WORK


DATE :	DWG. NO.
12/21/22	E-101
SHEET :	
064 OF 100	

DEMOLITION NOTES:

1 CONTRACTOR TO VERIFY EXISTING CIRCUITS BEFORE REMOVAL.

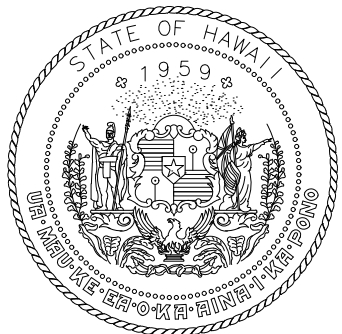

Airports Division
DEPARTMENT OF TRANSPORTATION
STATE OF HAWAII

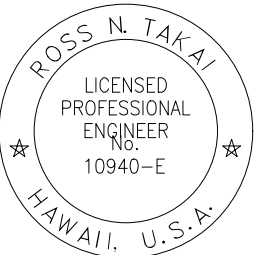

Ross N. Takai
04/30/2024
Licensed Expiration Date

This work was prepared by me or under my supervision.

DSGN.	DRWN.	CHKD.	APPD.

NO.	DATE	REVISIONS
-----	------	-----------

DATE

PROJECT TITLE :

NEW PASS AND ID OFFICE

AT
DANIEL K. INOUE INTERNATIONAL AIRPORT
HONOLULU, OAHU, HAWAII

PROJECT NO.:

CO1322-63

SHEET TITLE:

ELECTRICAL
FLOOR PLAN 2 -
DEMO WORK

DATE :

12/21/22

SHEET :

065 OF 100

DWG. NO.

E-102

MATCH LINE
/AE1010
/AE1021

MATCH LINE
/AE1010
/AE1021

C8

24

C7

C6

25.5

C5

C4

27

C3

C2

28.5

C1

14.76

15.25

15.82

16.41'

16.53

16.61

16.76


16.65

CA

CB

CC

PNL "4CSB"
XFMR "CSB"
PNL "2CSB"
PNL "2CSB2"
2CSB-29 DDC PNL
2CSB-11,13,15
2CSB-5,7,9

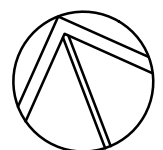

1
E-102

ELECTRICAL FLOOR PLAN 2 - DEMO WORK

SCALE: 3/16"= 1'-0"

