
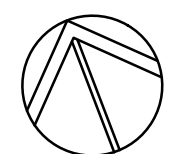


KEYNOTES:


 
- 1 COORDINATE FINAL LOCATIONS OF EQUIPMENT WITH OTHER DISCIPLINES.

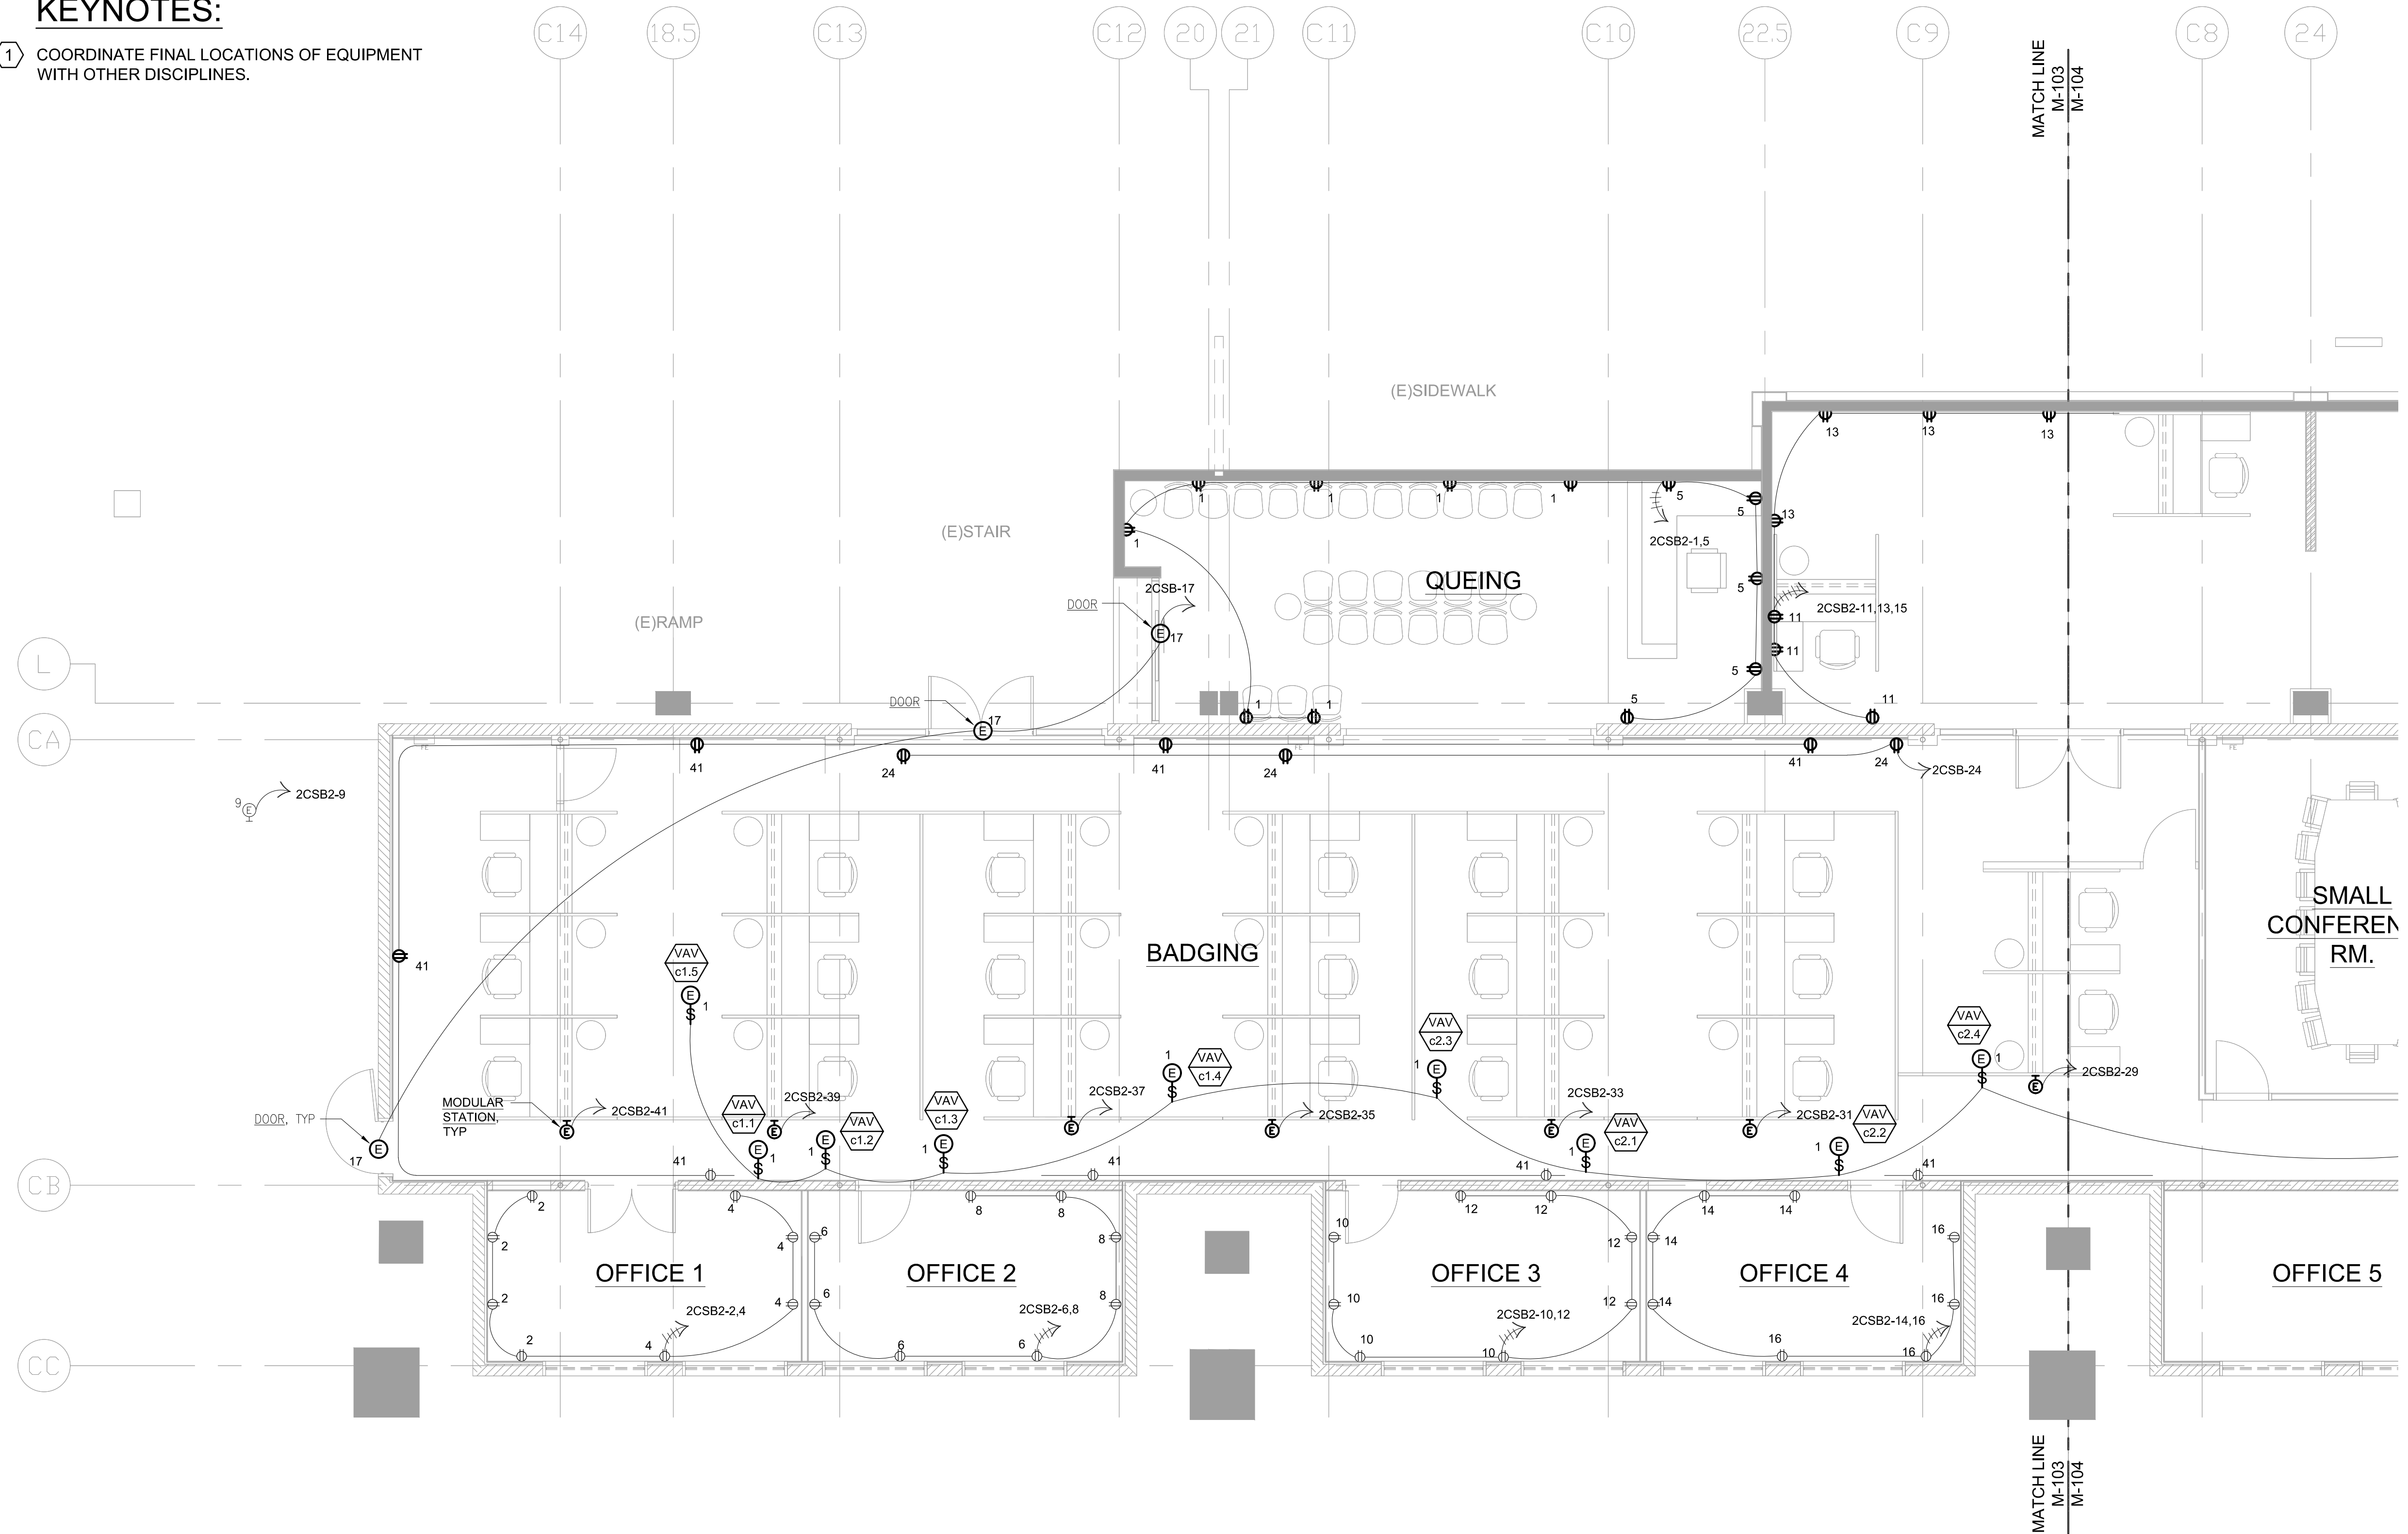


1
E-201

ELECTRICAL FLOOR PLAN 1

SCALE: 3/16"= 1'-0"

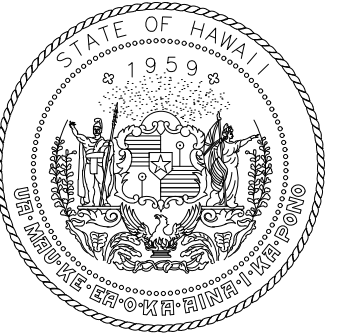

Airports Division
DEPARTMENT OF TRANSPORTATION
STATE OF HAWAII

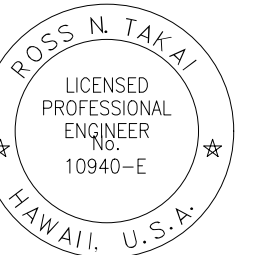

Ross N. Takai
04/30/2024
Licensed Expiration Date

This work was prepared by me or under my supervision.

DSGN.	DRWN.	CHKD.	APPD.

NO.	DATE	REVISIONS

DATE

PROJECT TITLE :

NEW PASS AND ID OFFICE

AT
DANIEL K. INOUE INTERNATIONAL AIRPORT
HONOLULU, OAHU, HAWAII

PROJECT NO.:

CO1322-63

SHEET TITLE:

ELECTRICAL
FLOOR PLAN 1

DATE :

12/21/22

SHEET :


068 OF 100

DWG. NO.

E-201

MATCH LINE
E-201
E-202


MATCH LINE
E-201
E-202

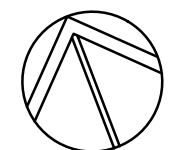

1
E-202


ELECTRICAL FLOOR PLAN 2

 SCALE: 3/16"= 1'-0"




KEYNOTES:

- 1 COORDINATE FINAL LOCATIONS OF EQUIPMENT WITH OTHER DISCIPLINES.

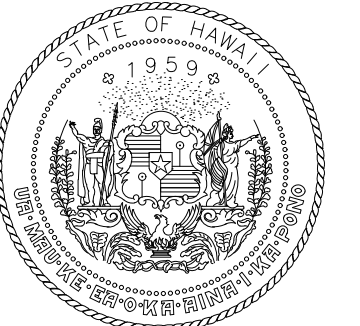

Airports Division
DEPARTMENT OF TRANSPORTATION
STATE OF HAWAII

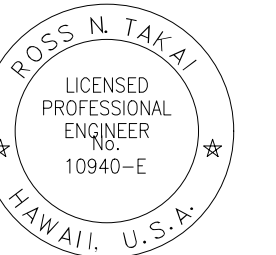

Ross N. Takai
04/30/2024
Licensed Expiration Date

This work was prepared by me or under my supervision.

DSGN.	DRWN.	CHKD.	APPD.

NO.	DATE	REVISIONS
-----	------	-----------

DATE

PROJECT TITLE :

NEW PASS AND ID OFFICE

AT
DANIEL K. INOUE INTERNATIONAL AIRPORT
HONOLULU, OAHU, HAWAII

PROJECT NO.:

CO1322-63

SHEET TITLE:

ELECTRICAL
FLOOR PLAN 2

DATE :

12/21/22

SHEET :

069 OF 100

DWG. NO.

E-202