

 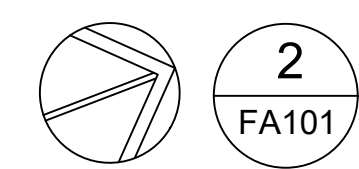
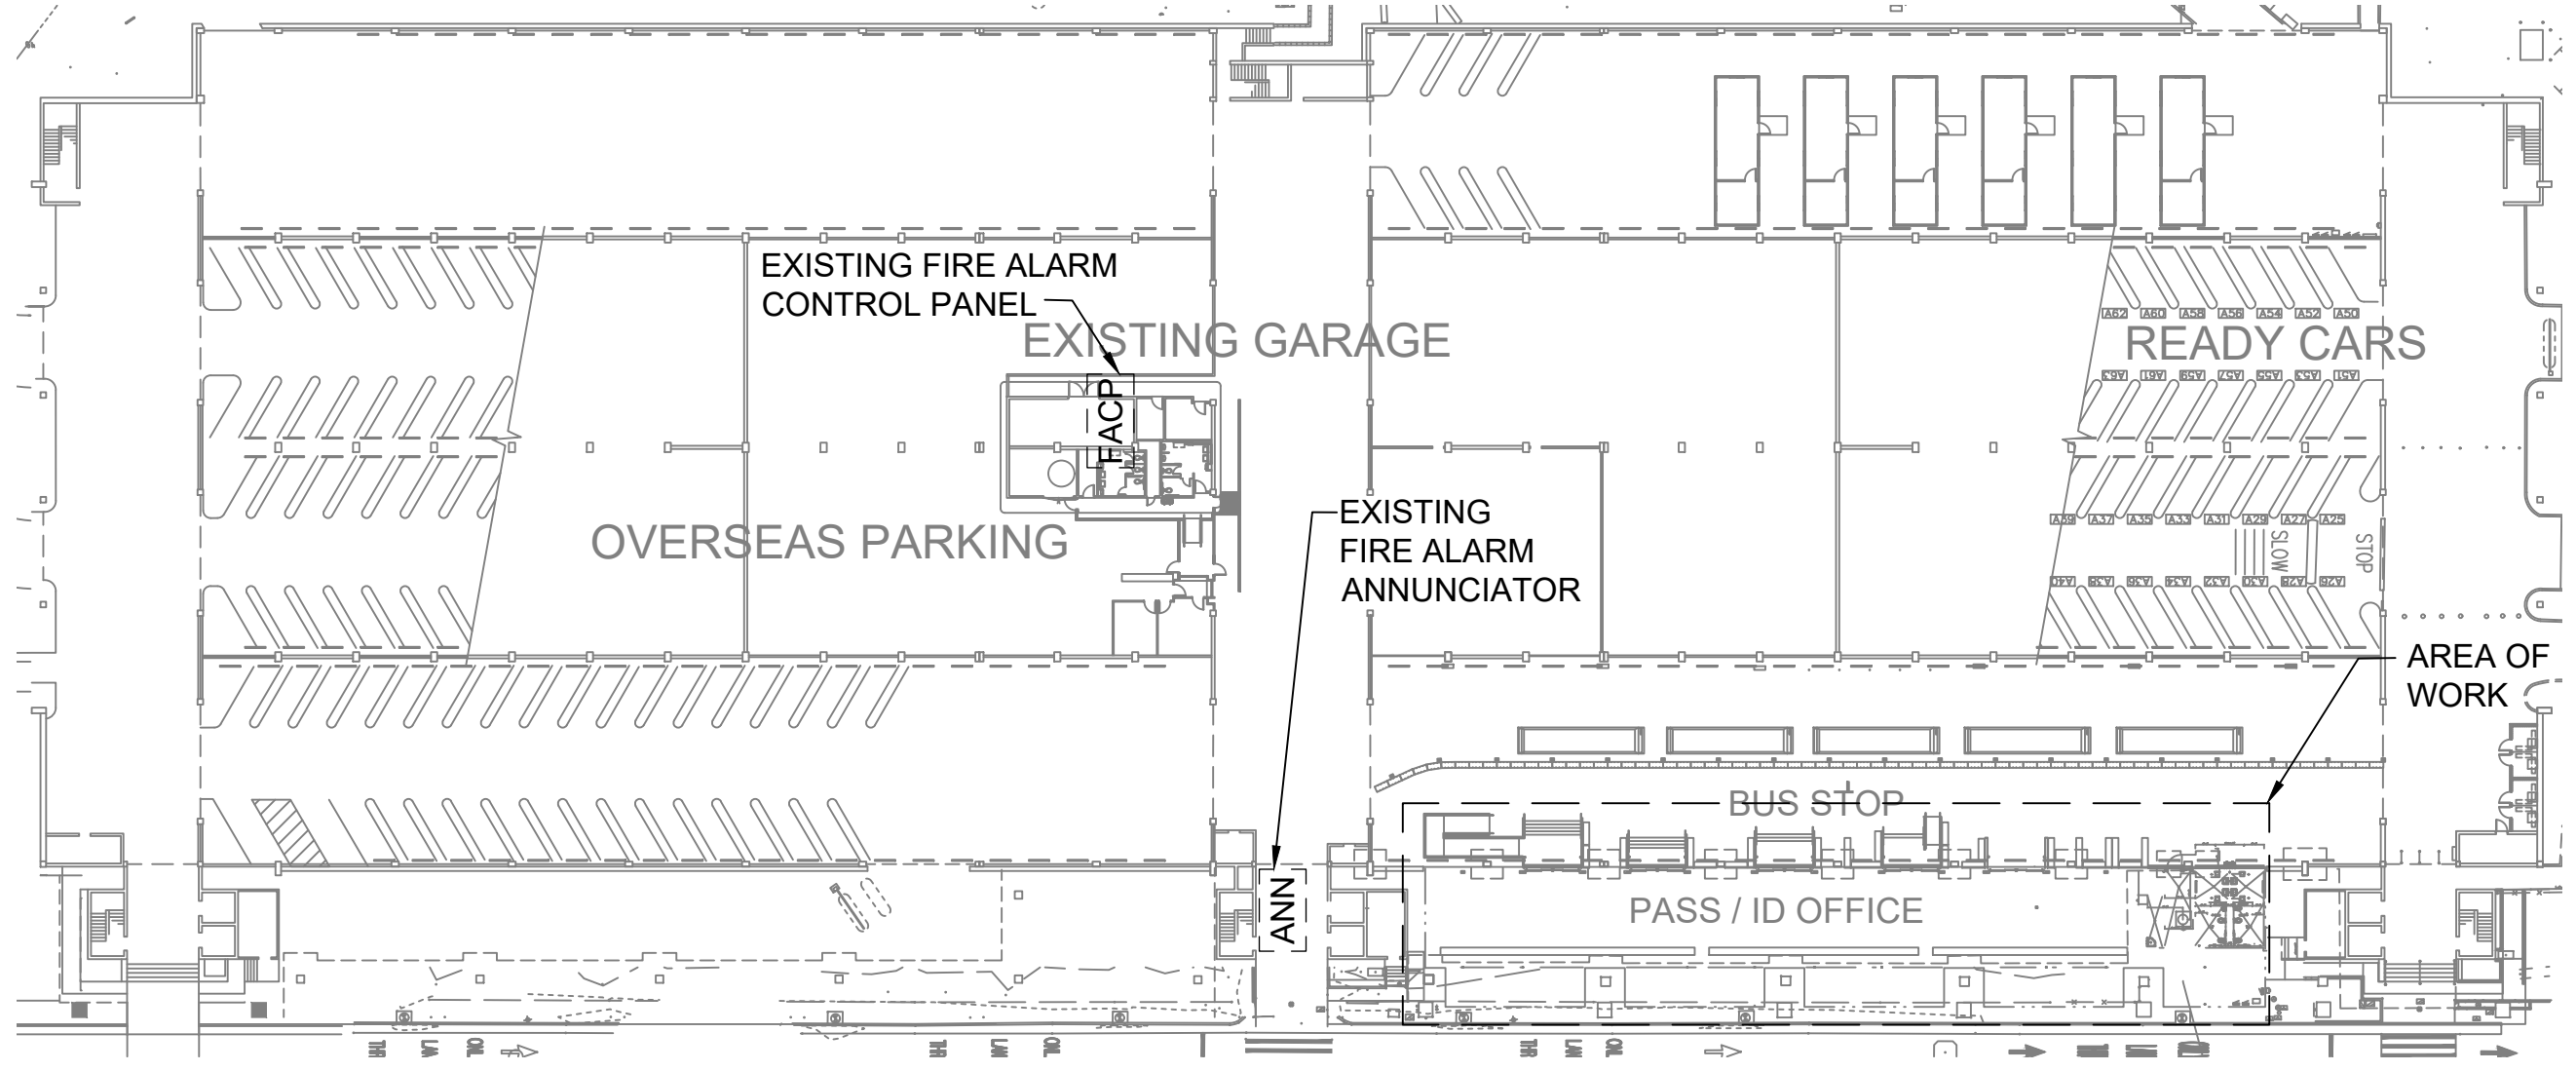



1  
FA101  
FIRE ALARM FLOOR PLAN  
SCALE: 1/8" = 1'-0"




2  
FA101  
OVERALL GARAGE FIRE ALARM PLAN  
SCALE: 1" = 50'

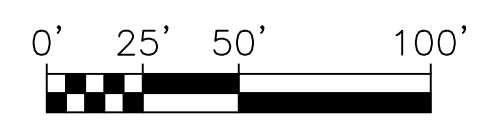

- FIRE ALARM NOTES:
1. PROVIDE AIR SAMPLING SMOKE DETECTION WITHIN INDICATED BOUNDARY.
  2. PROVIDE CLEAN AGENT SWITCHES ON CYLINDER MANIFOLD. SEE DETAIL 3 / F-501.
  3. PROVIDE DUCT SMOKE DETECTORS AT ROOF LEVEL, TYP. SEE SHEETS M-107 AND M-108 FOR DETAILS.

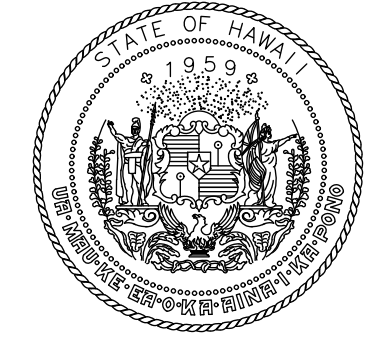

Airports Division  
DEPARTMENT OF TRANSPORTATION  
STATE OF HAWAII

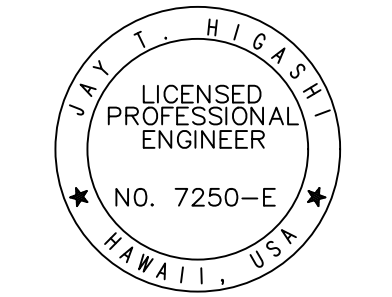

J. T. Higashi  
04/30/24  
Licensed Expiration Date

This work was prepared by me or under my supervision.

| DSGN. | DRWN. | CHKD. | APPD. |
|-------|-------|-------|-------|
| JTH   | AM    | JTH   | JTH   |

| NO. | DATE | REVISIONS |
|-----|------|-----------|
|-----|------|-----------|

DATE

PROJECT TITLE :

NEW PASS AND ID OFFICE

AT  
DANIEL K. INOUE INTERNATIONAL AIRPORT  
HONOLULU, HAWAII

PROJECT NO.:

CO1322-63

SHEET TITLE:

FIRE ALARM  
FLOOR PLAN

|                  |          |
|------------------|----------|
| DATE :           | DWG. NO. |
| 12/21/22         | FA101    |
| SHEET :          |          |
| 81 OF 100 SHEETS |          |