
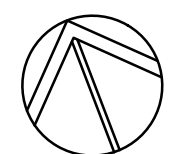




DEMOLITION NOTES:

1 DEMO EXISTING DUCTWORK, T-STAT, DIFFUSER, REGISTER, VAV BOX, AND ANNUNCIATOR PANEL.

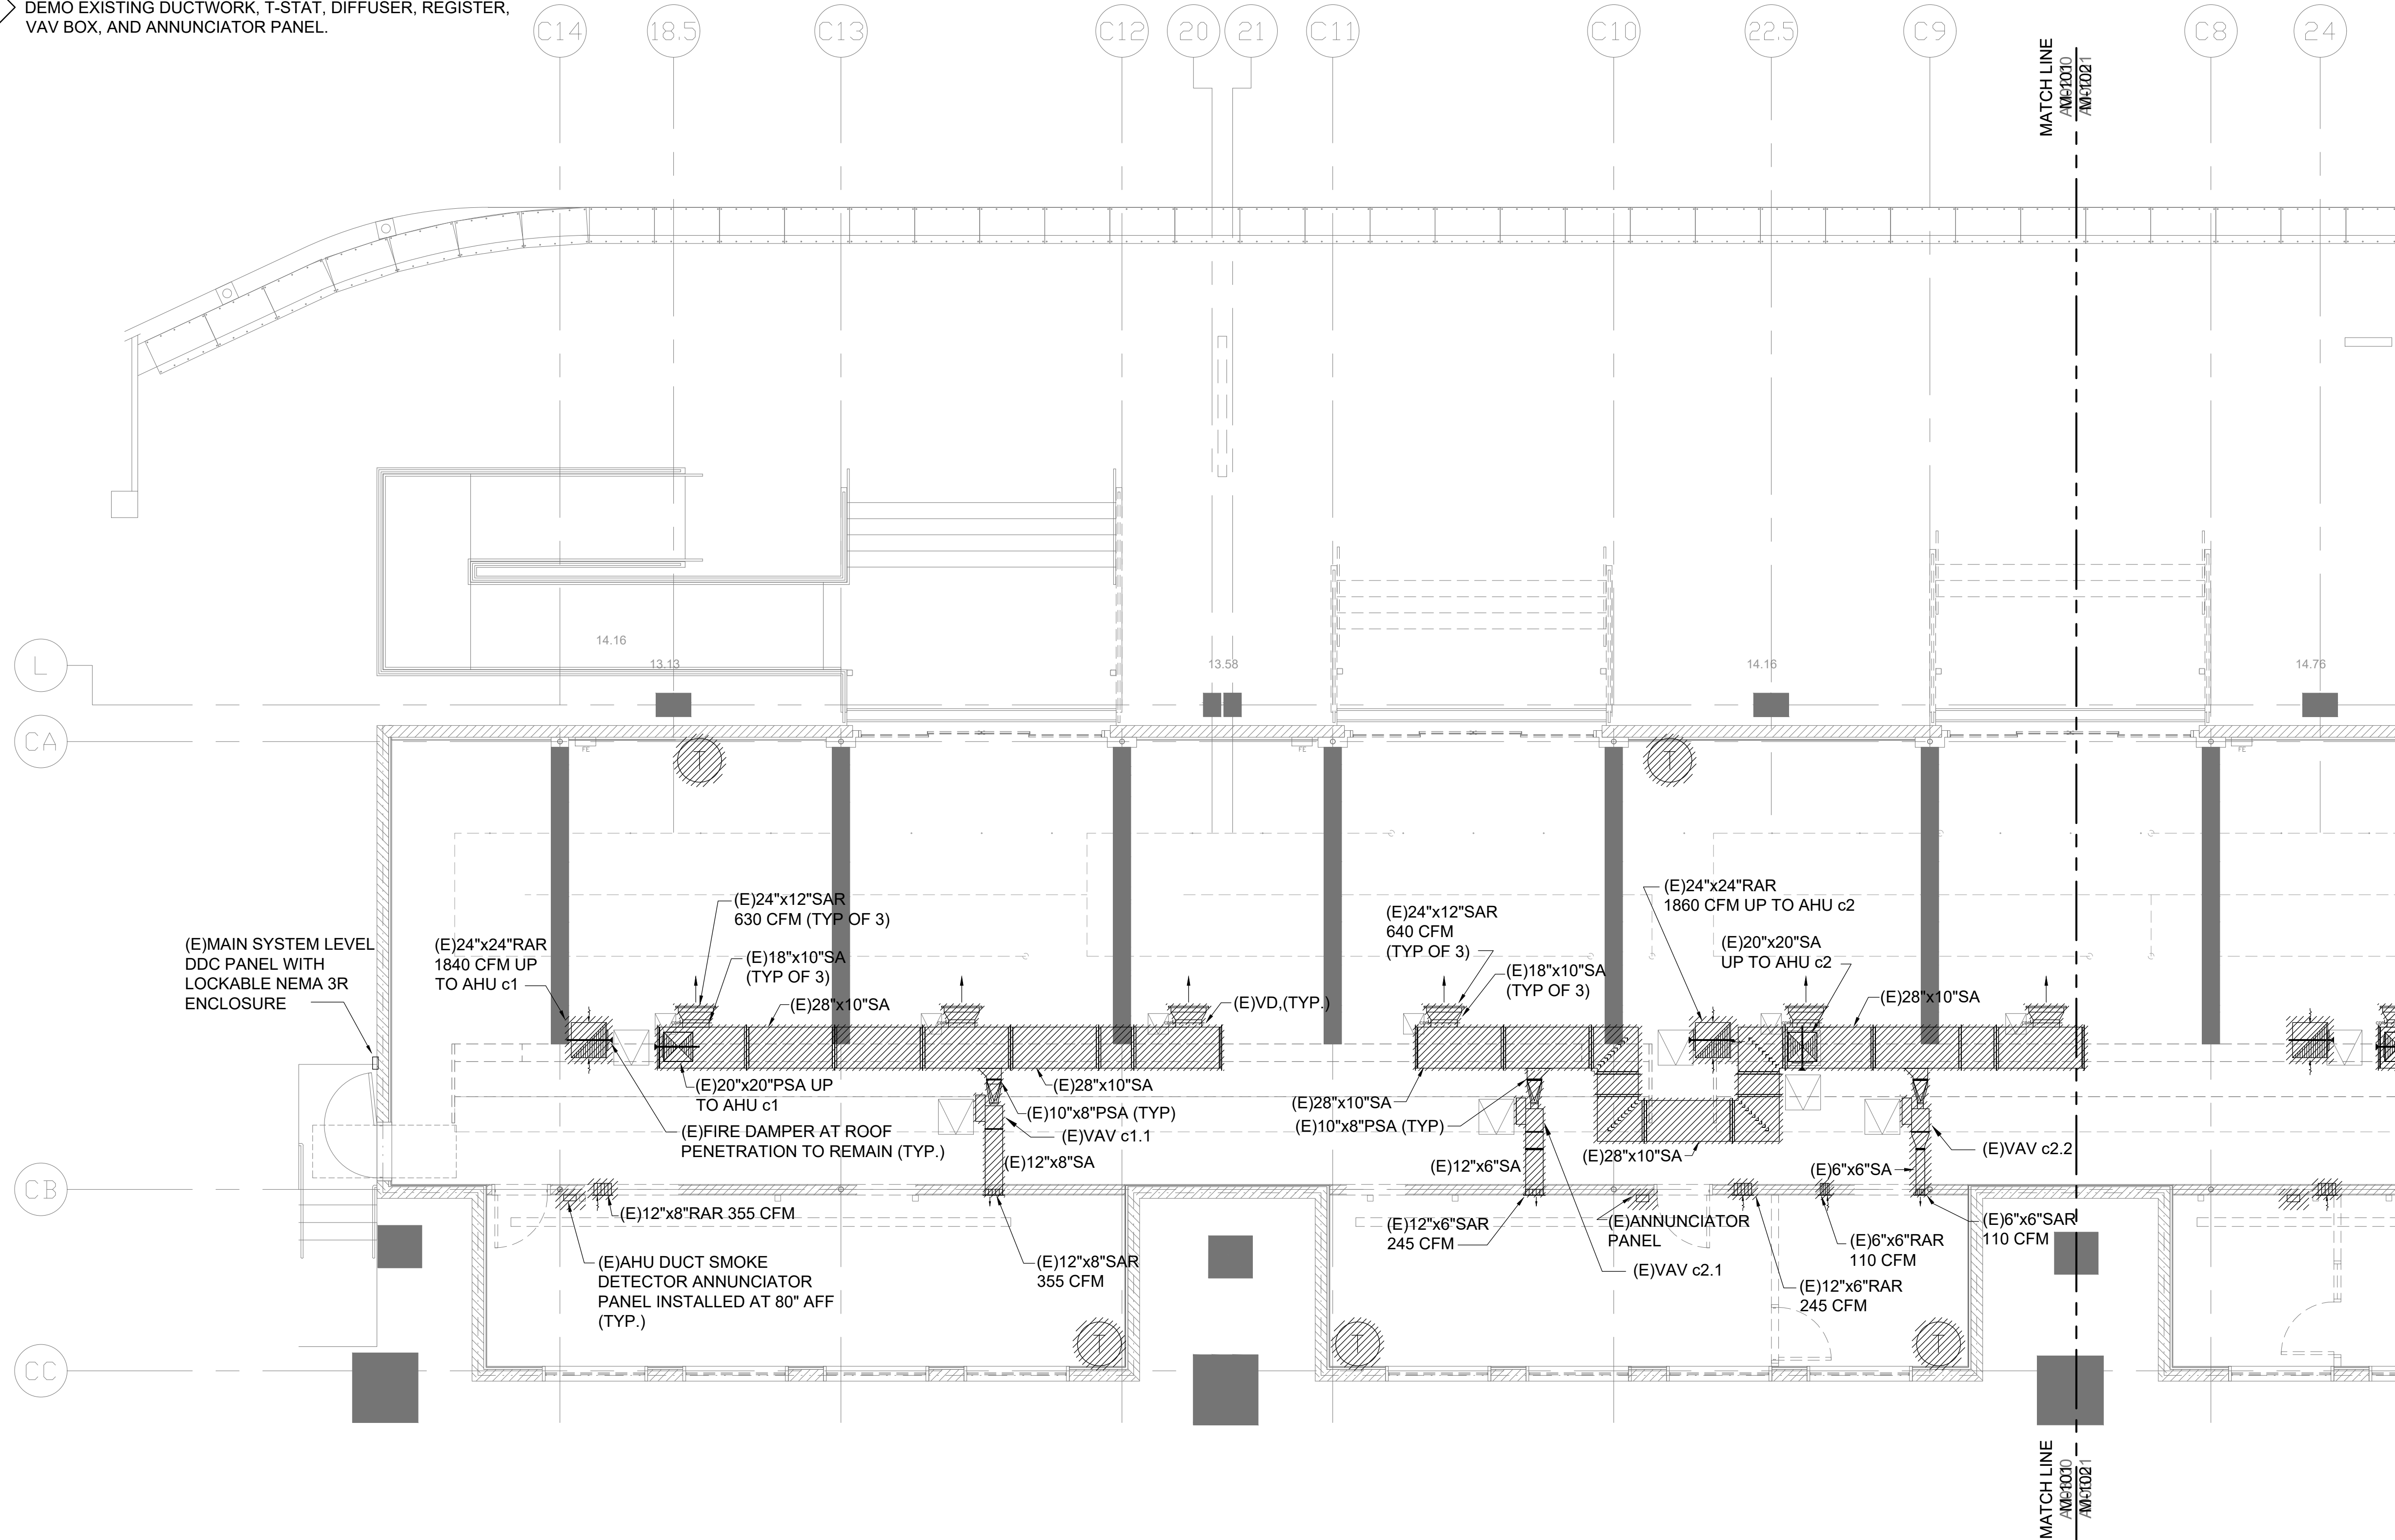


1
M-101

 MECHANICAL FLOOR PLAN - DEMO WORK
SCALE: 3/16"= 1'-0"

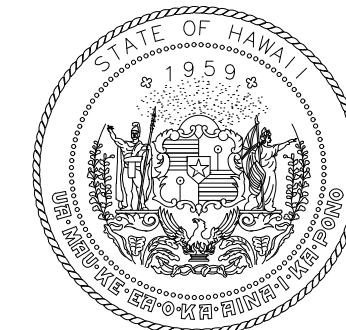

Airports Division
DEPARTMENT OF TRANSPORTATION
STATE OF HAWAII

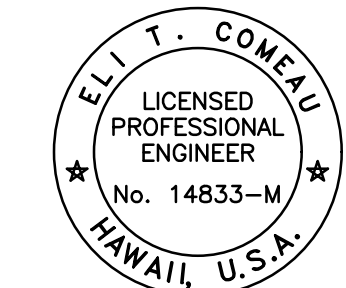

gk. ComEAU
04/30/2024
Licensed Expiration Date

This work was prepared by me or under my supervision.

DSGN.	DRWN.	CHKD.	APPD.

NO.	DATE	REVISIONS
-----	------	-----------

DATE

PROJECT TITLE :

NEW PASS AND ID OFFICE

AT
DANIEL K. INOUE INTERNATIONAL AIRPORT
HONOLULU, OAHU, HAWAII

PROJECT NO.:

CO1322-63

SHEET TITLE:

MECHANICAL
FLOOR PLAN -
DEMO WORK

DATE :

12/21/22

SHEET :

42 OF 100 SHEETS

DWG. NO.


M-101

DEMOLITION NOTES:

- 1 DEMO EXISTING DUCTWORK, T-STAT, DIFFUSER, REGISTER, VAV BOX, AND ANNUNCIATOR PANEL.
- 2 RELOCATE (E)DDC PANEL FOR EF.



Airports Division
DEPARTMENT OF TRANSPORTATION
STATE OF HAWAII

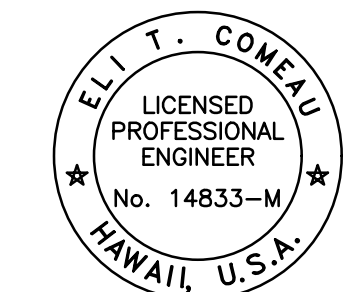

gk. ComEAU
04/30/2024
Licensed Expiration Date

This work was prepared by me or under my supervision.

DSGN.	DRWN.	CHKD.	APPD.

NO.	DATE	REVISIONS
-----	------	-----------

DATE

PROJECT TITLE :

NEW PASS AND ID OFFICE

AT
DANIEL K. INOUE INTERNATIONAL AIRPORT
HONOLULU, OAHU, HAWAII


PROJECT NO.:

CO1322-63

SHEET TITLE:

MECHANICAL
FLOOR PLAN -
DEMO WORK

DATE :	DWG. NO.
12/21/22	M-102
SHEET :	
43 OF 100 SHEETS	

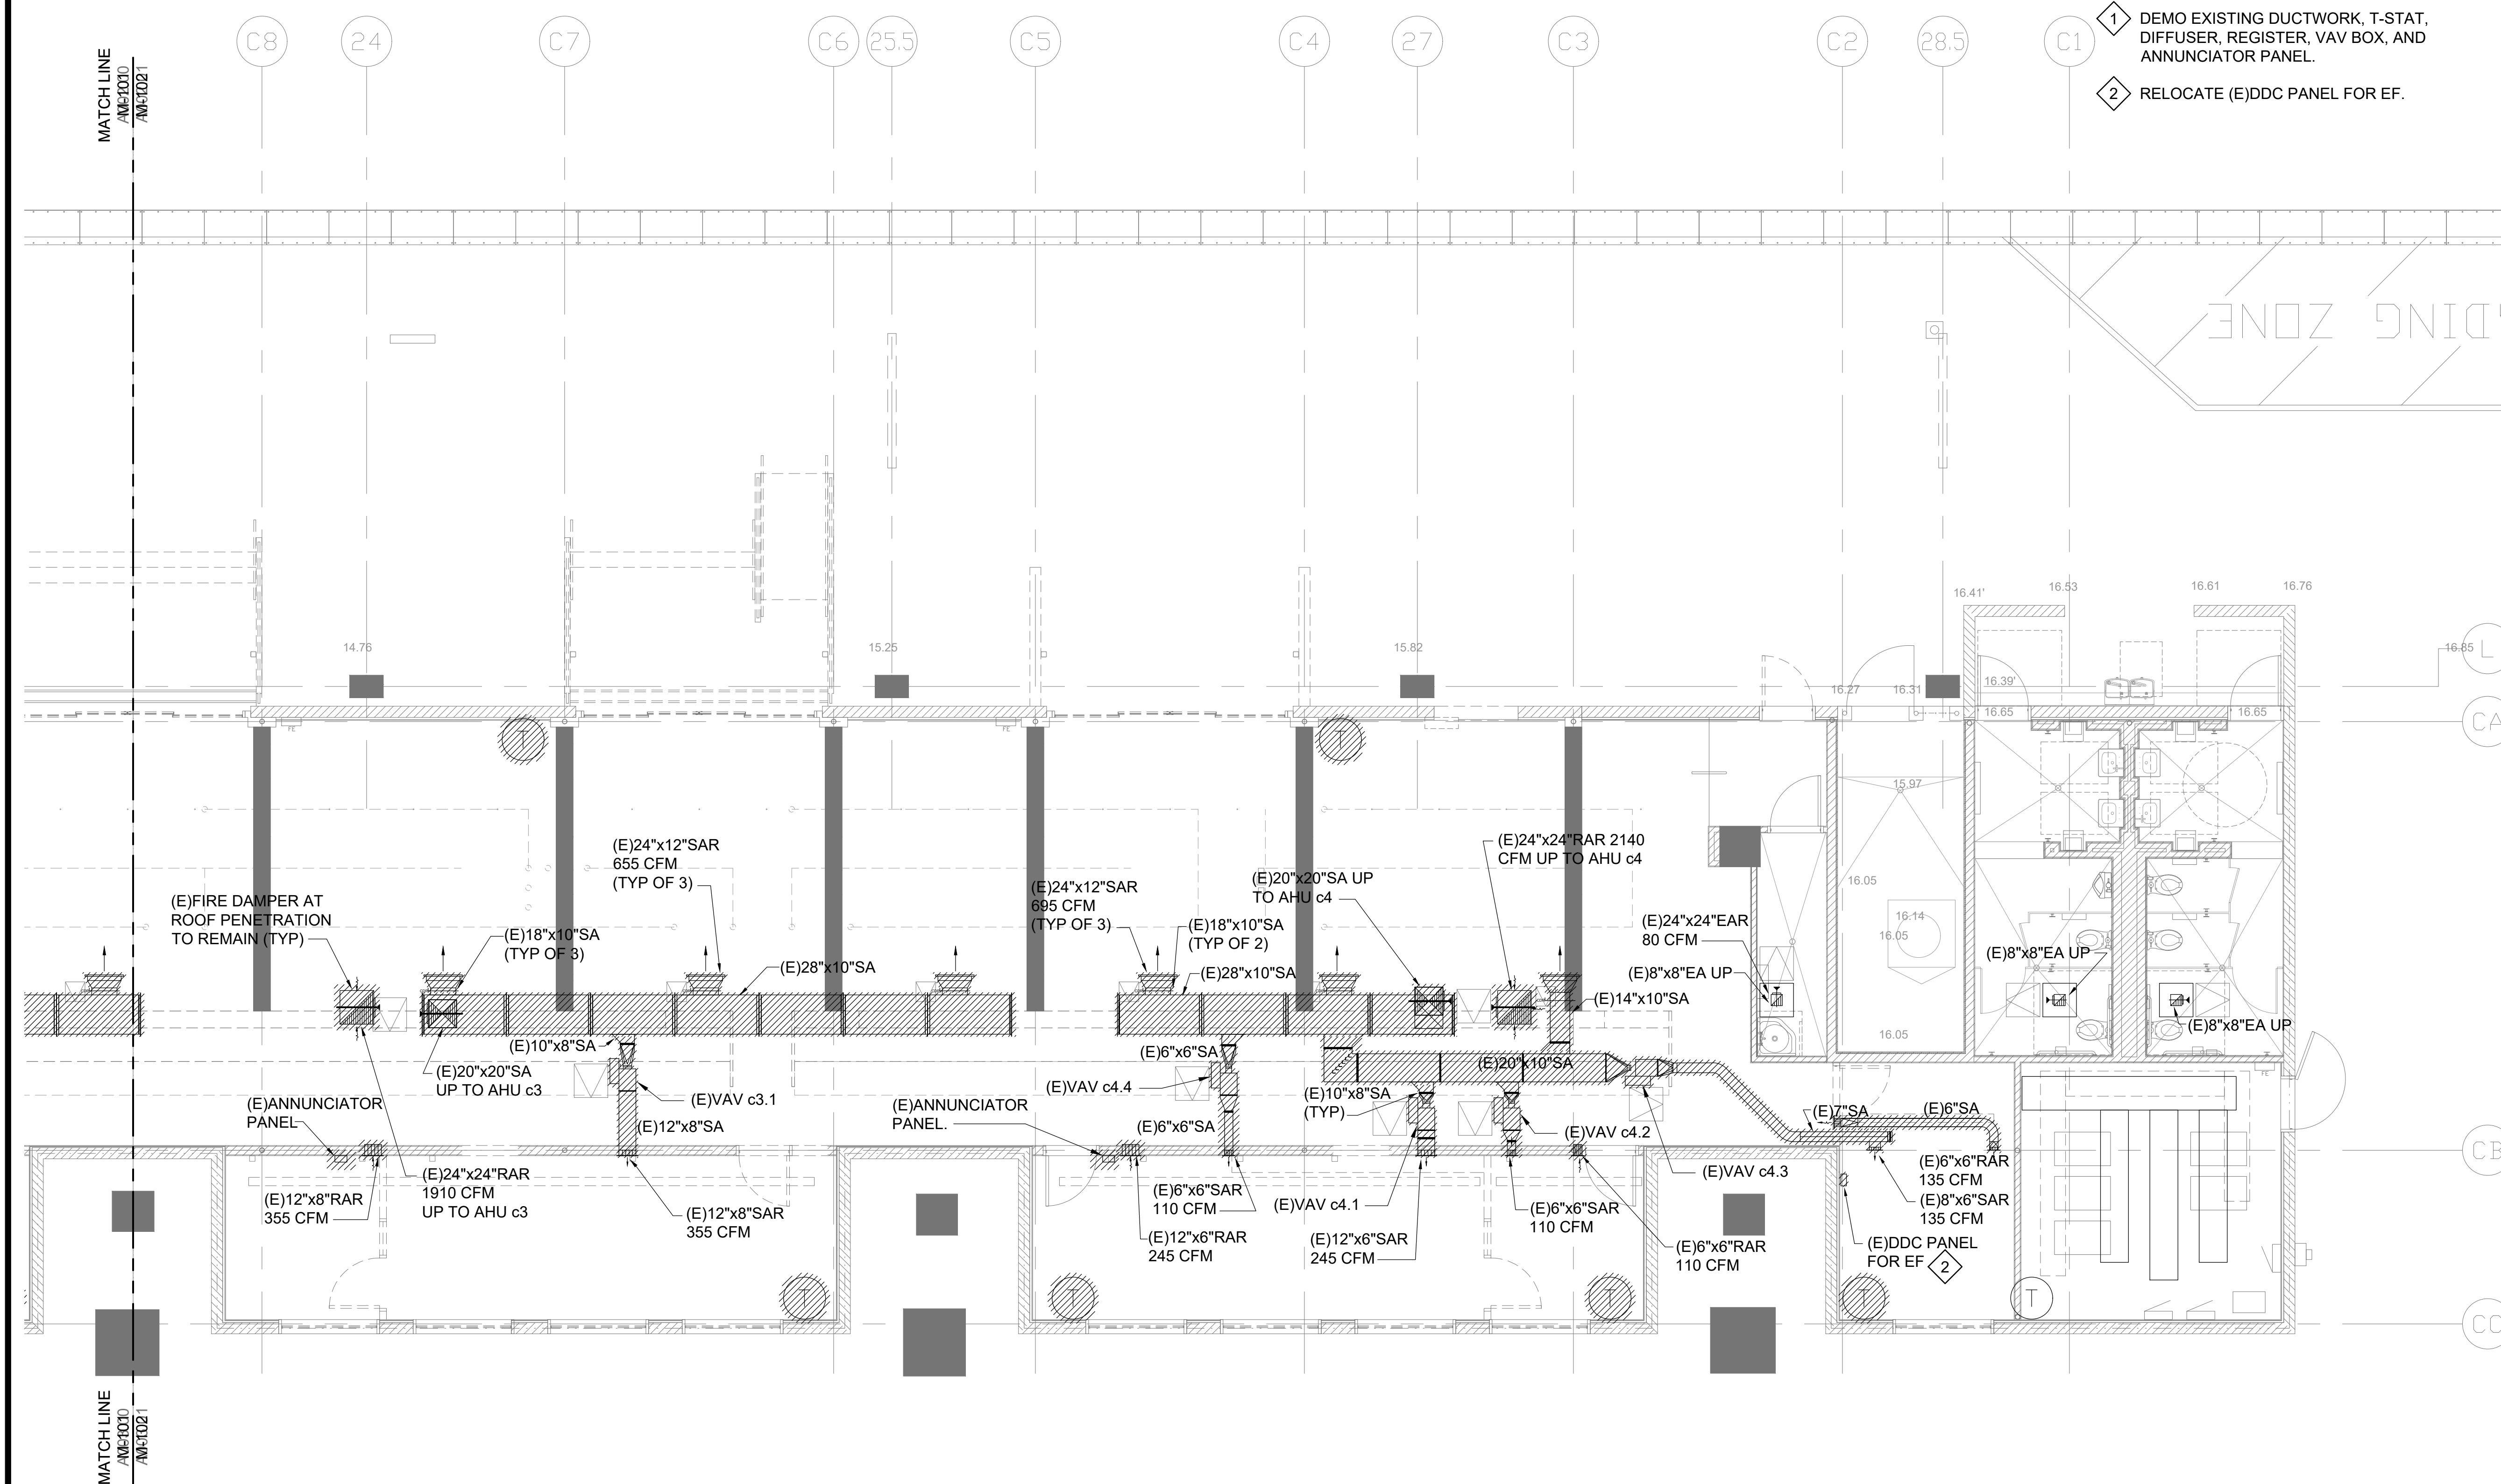

1
M-102

MECHANICAL FLOOR PLAN - DEMO WORK

SCALE: 3/16"= 1'-0"

