
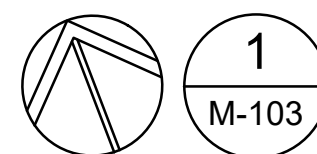


DEMOLITION NOTES:


 
- 1 DEMO EXISTING MODULATING CHILLED WATER VALVES AND ACTUATORS.

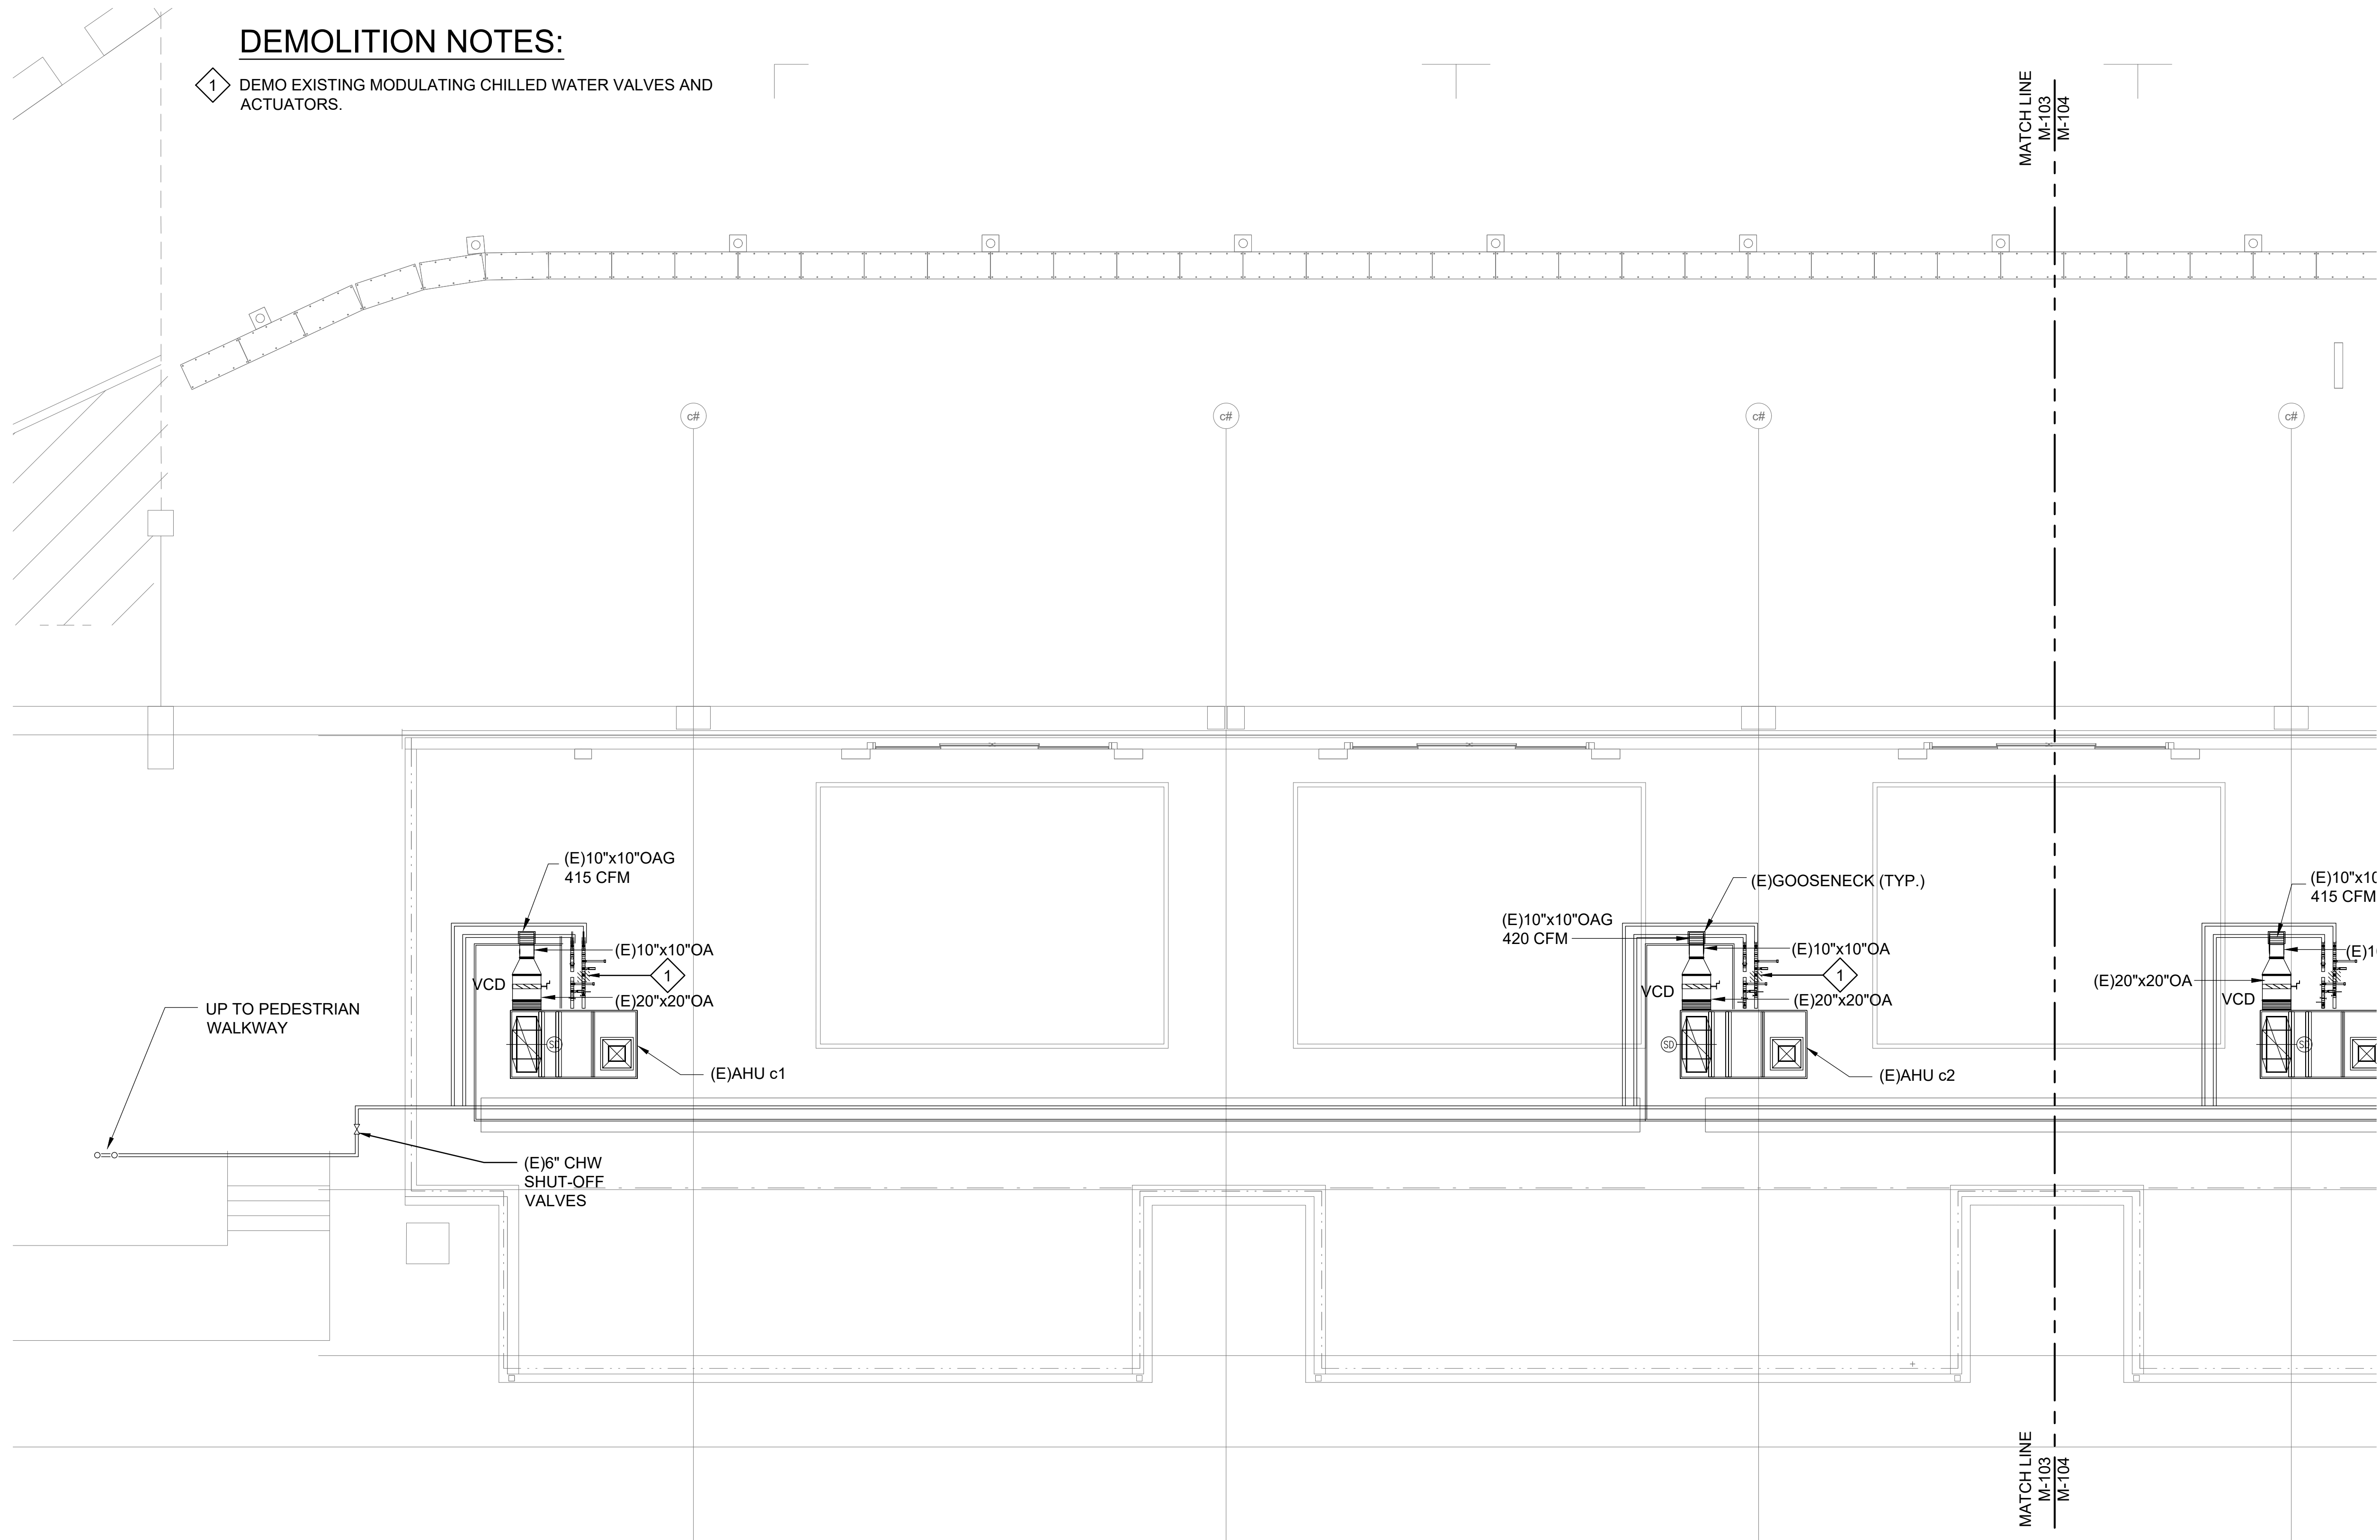


1
M-103

MECHANICAL ROOF PLAN - DEMO WORK

SCALE: 3/16"= 1'-0"

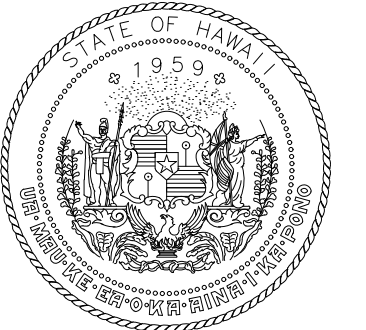

Airports Division
DEPARTMENT OF TRANSPORTATION
STATE OF HAWAII

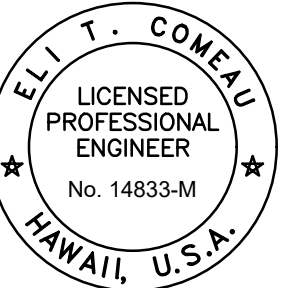

gk. ComEAU
04/30/2024
Licensed Expiration Date

This work was prepared by me or under my supervision.

DSGN.	DRWN.	CHKD.	APPD.

NO.	DATE	REVISIONS
-----	------	-----------

DATE

PROJECT TITLE :

NEW PASS AND ID OFFICE

AT
DANIEL K. INOUE INTERNATIONAL AIRPORT
HONOLULU, OAHU, HAWAII

PROJECT NO.:

CO1322-63



SHEET TITLE:

MECHANICAL
ROOF PLAN -
DEMO WORK


DATE :	DWG. NO.
12/21/22	M-103
SHEET :	
44 OF 100 SHEETS	

DEMOLITION NOTES:

1 DEMO EXISTING MODULATING CHILLED WATER VALVES AND ACTUATORS.

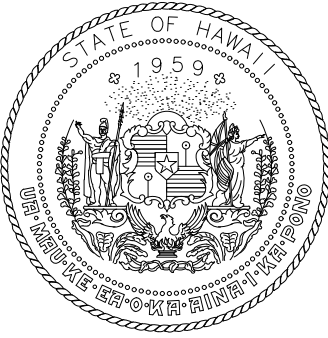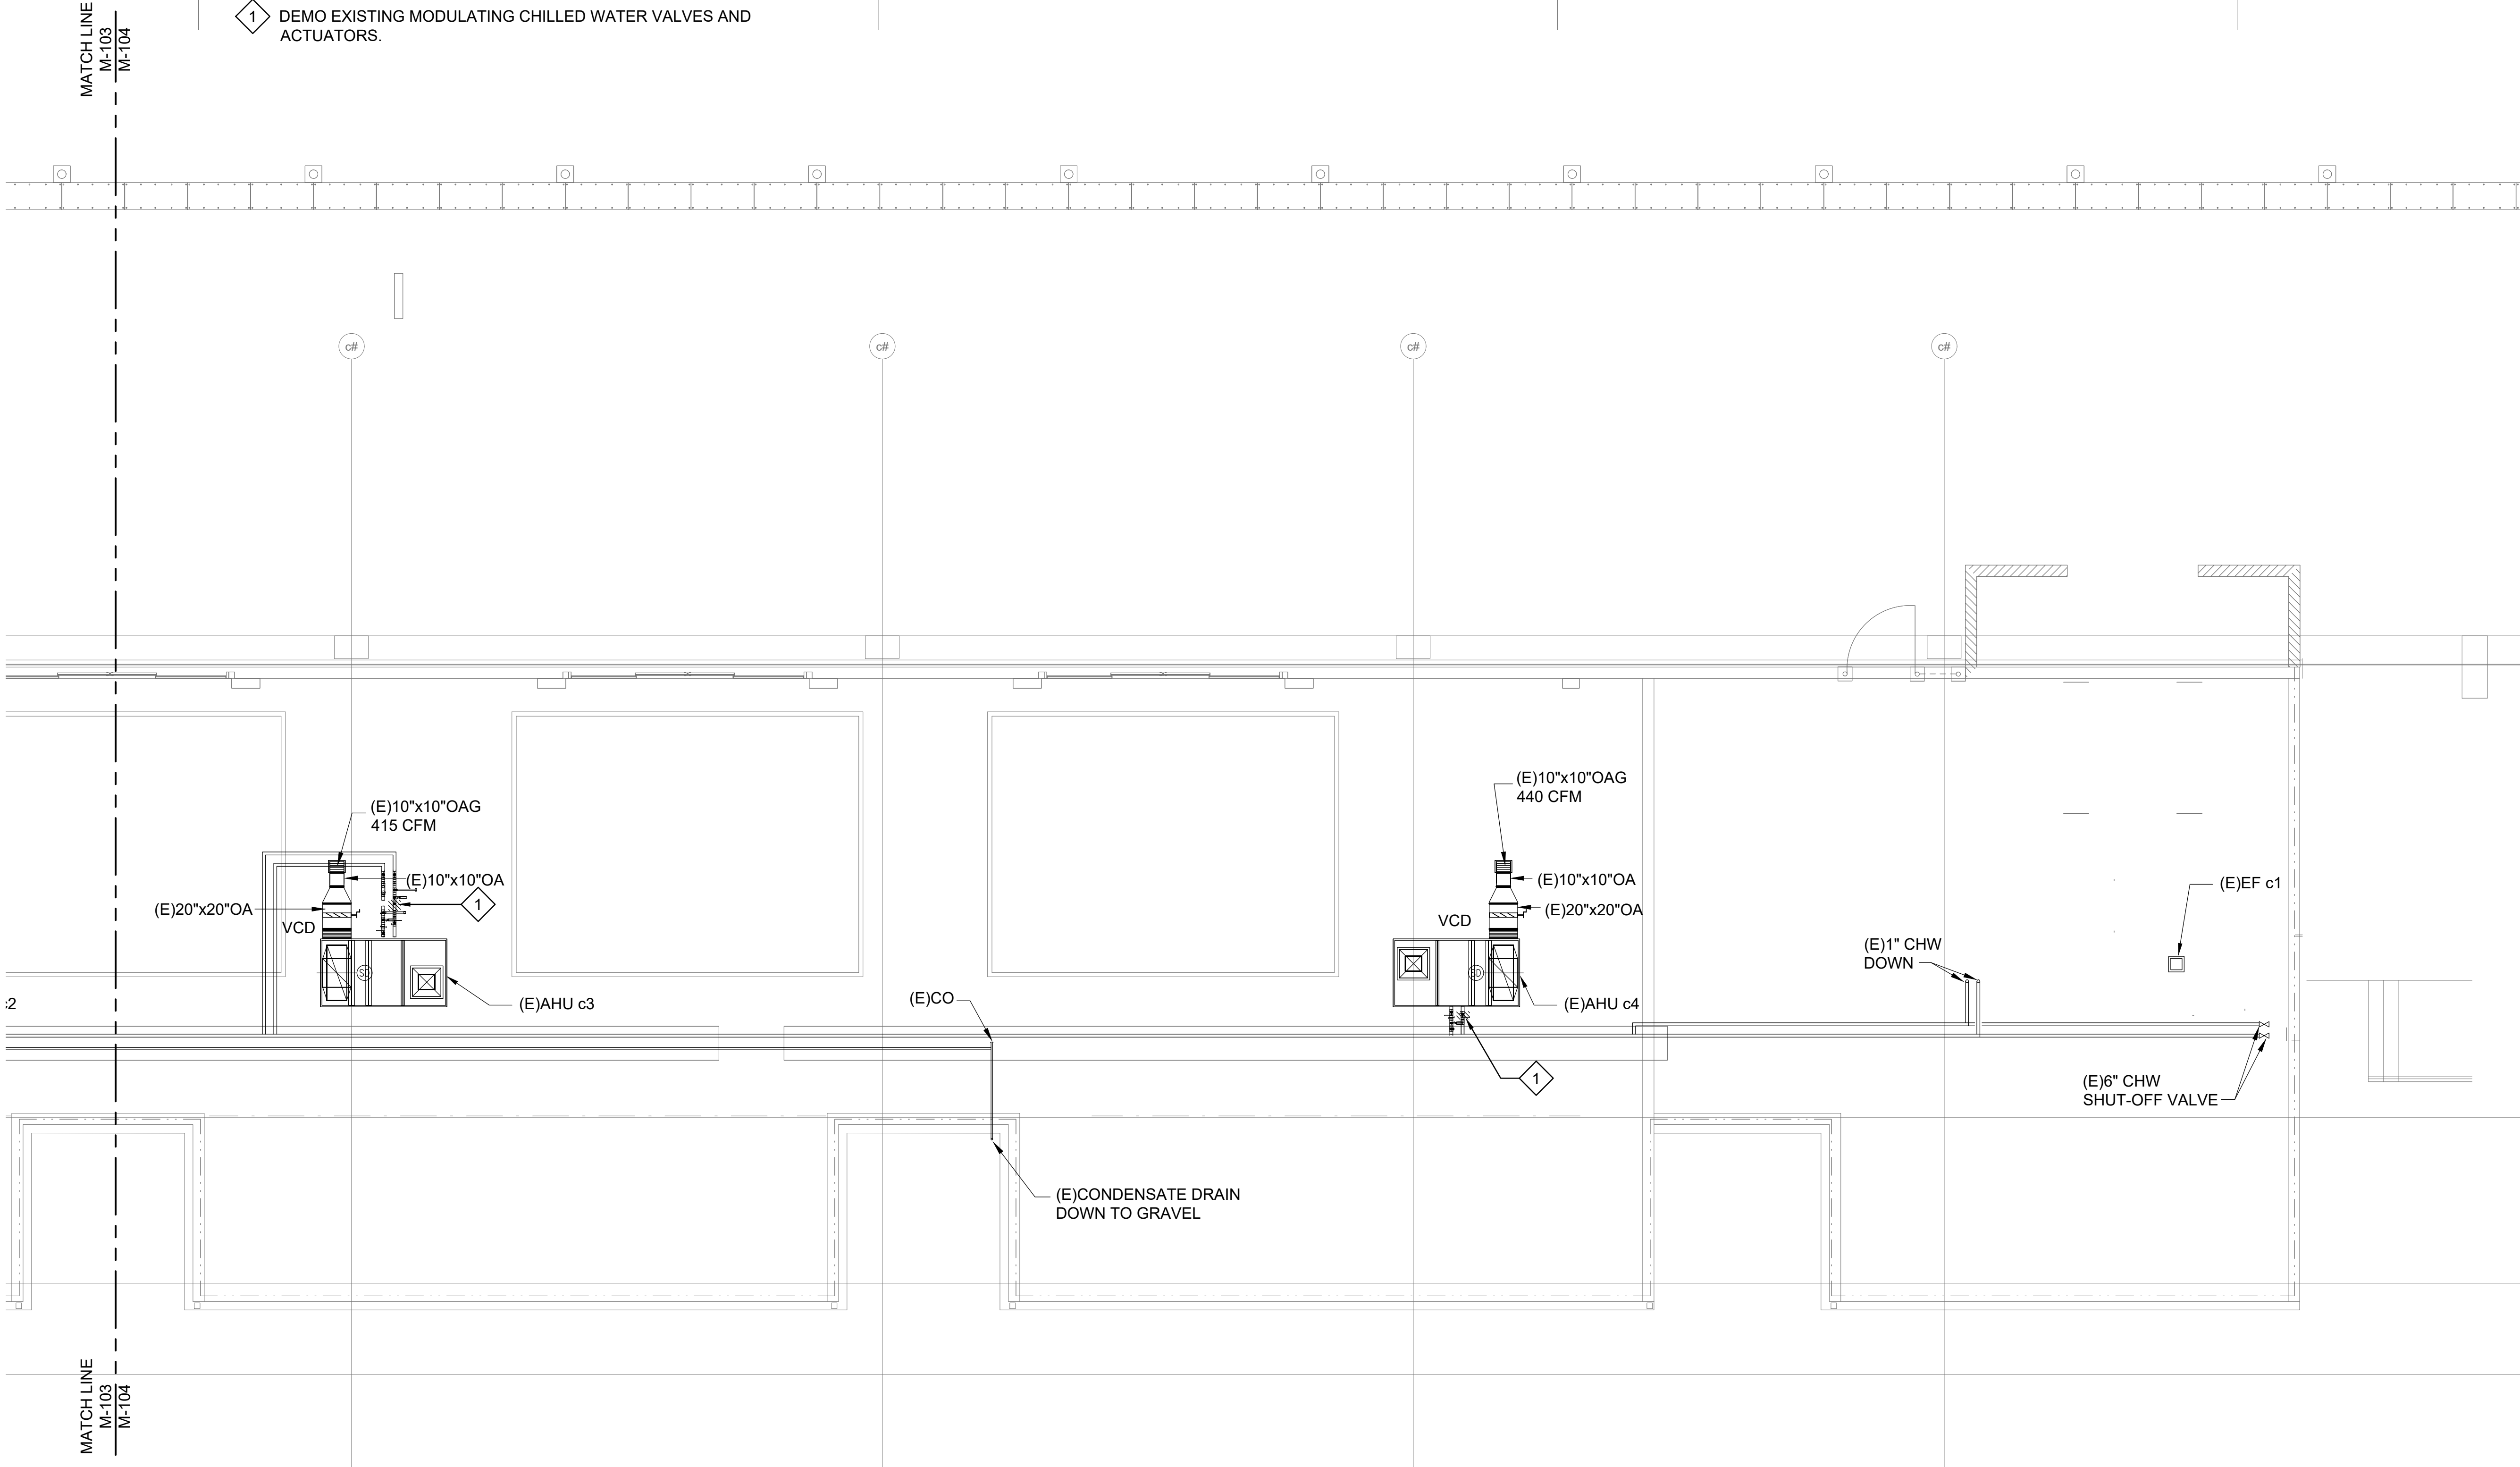

Airports Division
DEPARTMENT OF TRANSPORTATION
STATE OF HAWAII

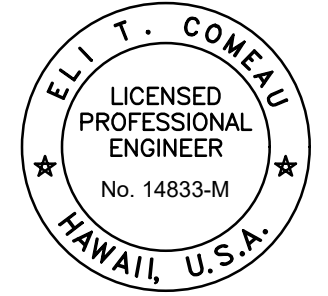

Eli T. Comeau
04/30/2024
Licensed Expiration Date

This work was prepared by me or under my supervision.

DSGN.	DRWN.	CHKD.	APPD.

NO.	DATE	REVISIONS
-----	------	-----------

PROJECT TITLE :

NEW PASS AND ID OFFICE

AT
DANIEL K. INOUE INTERNATIONAL AIRPORT
HONOLULU, OAHU, HAWAII

PROJECT NO.:

CO1322-63

SHEET TITLE:

MECHANICAL
ROOF PLAN -
DEMO WORK

DATE :


12/21/22

SHEET :

DWG. NO.

M-104

45 OF 100 SHEETS

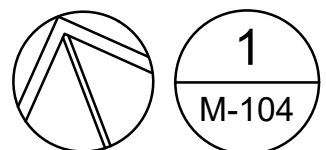

1
M-104

MECHANICAL ROOF PLAN - DEMO WORK

SCALE: 3/16"= 1'-0"

