



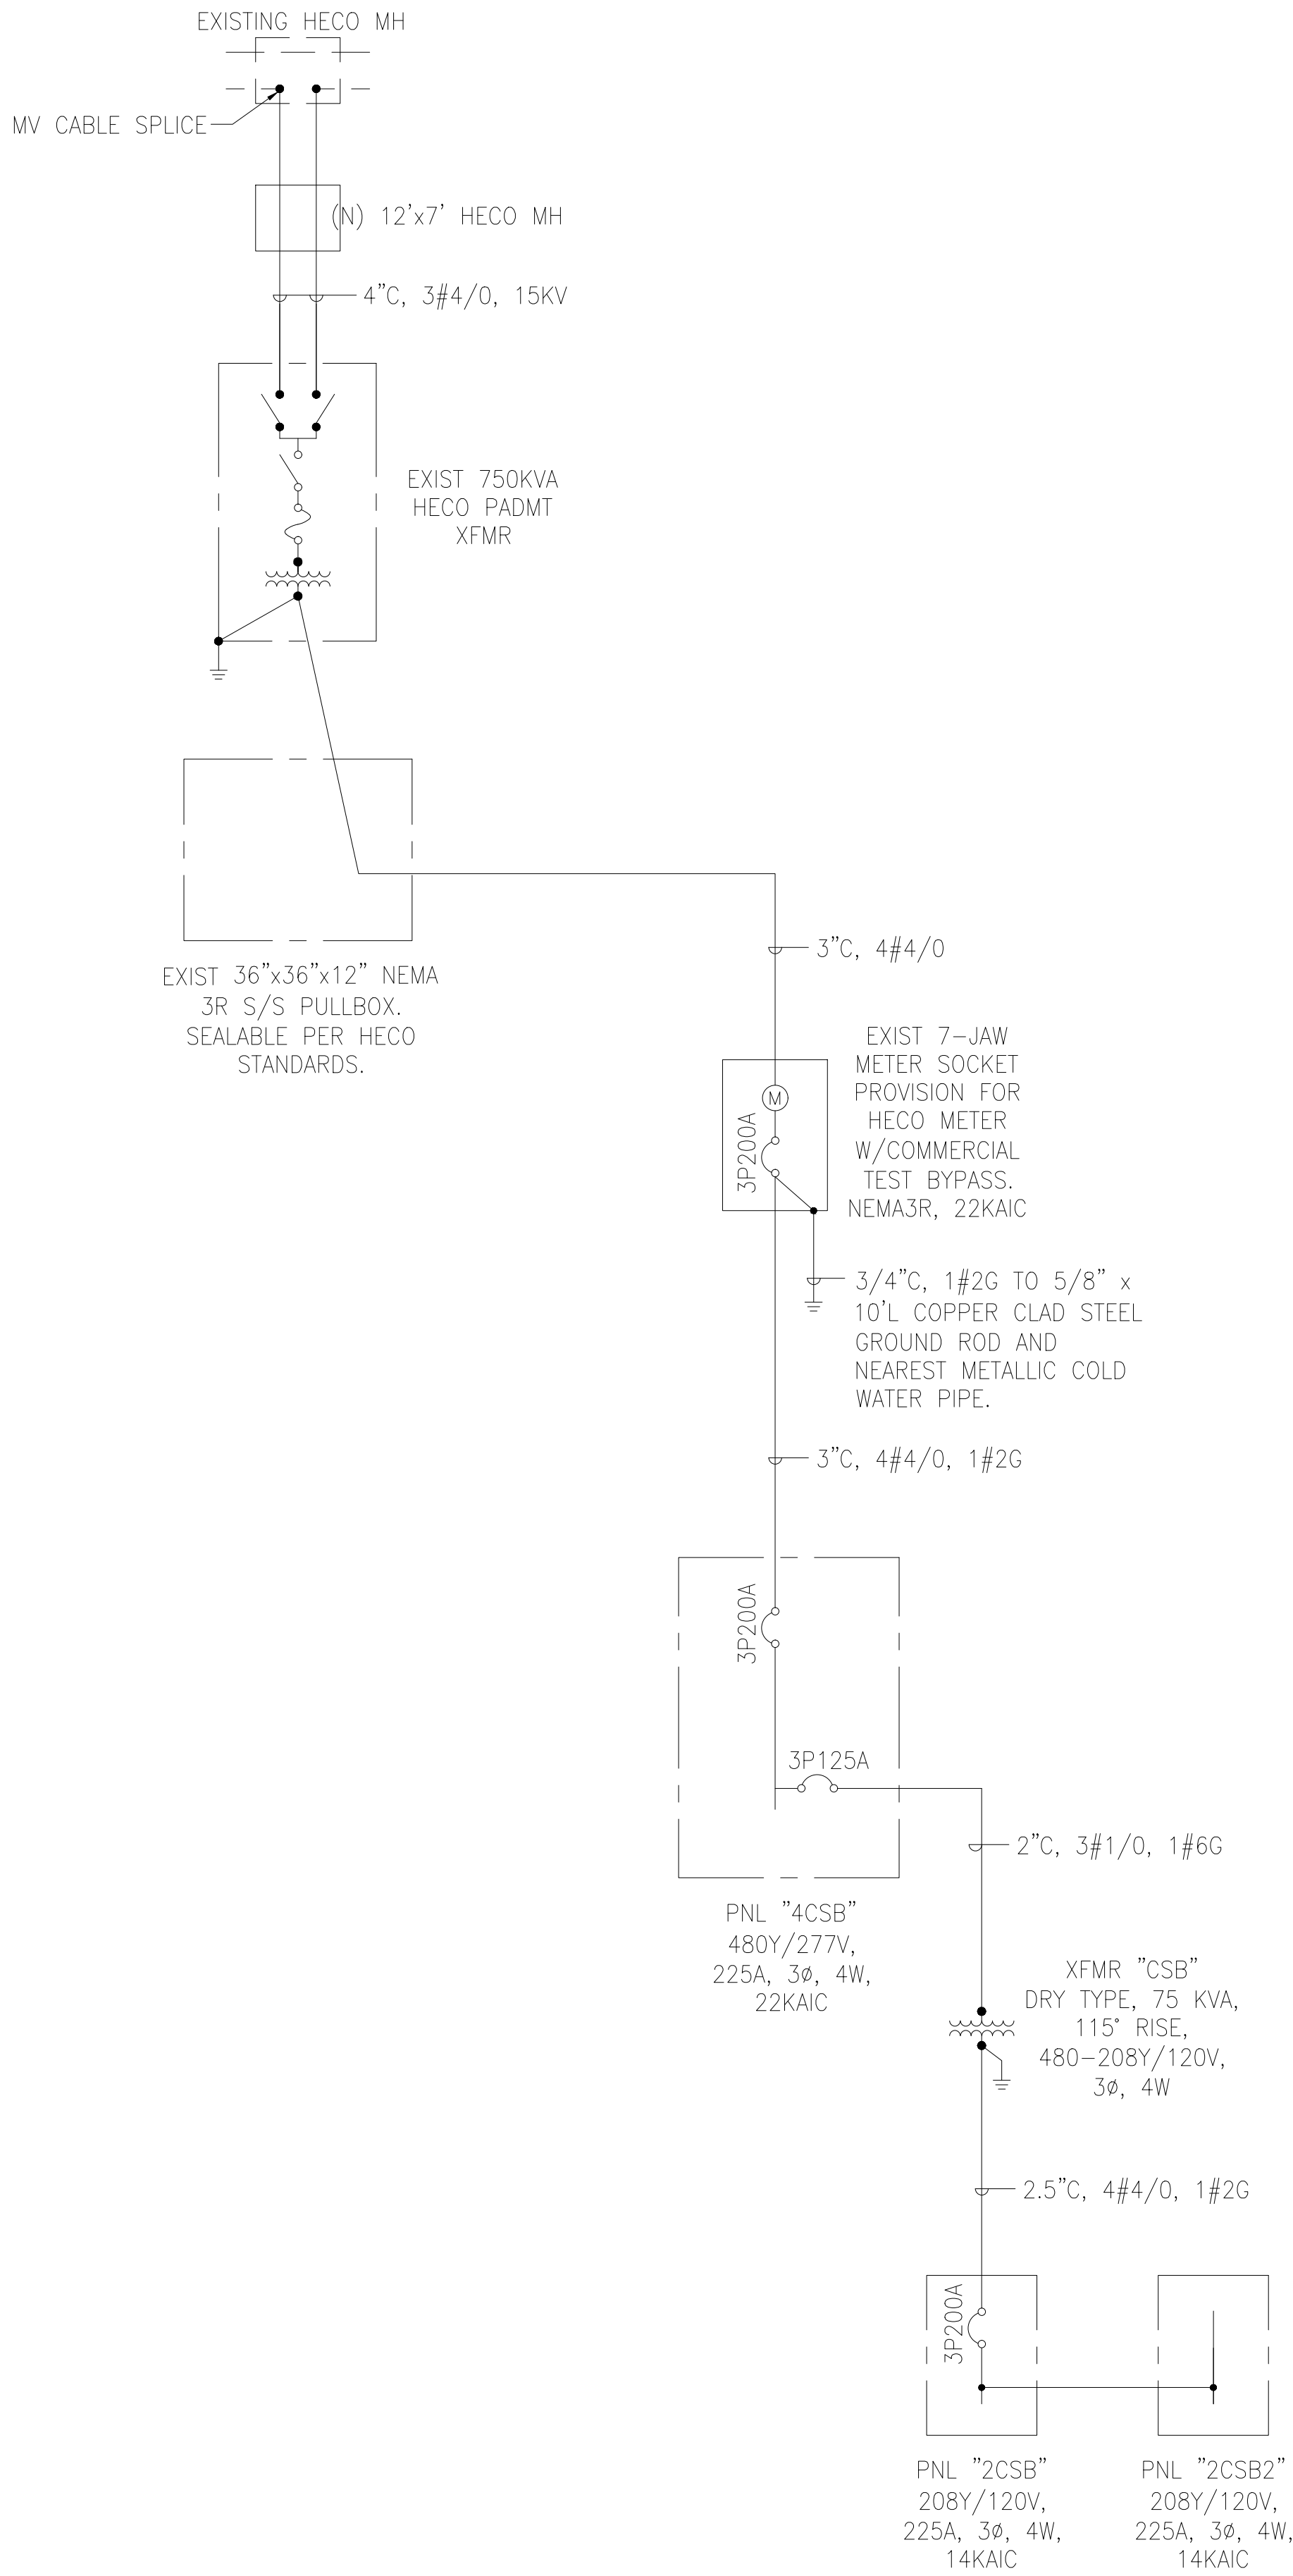


1
E-401

ELECTRICAL ONE-LINE DIAGRAM

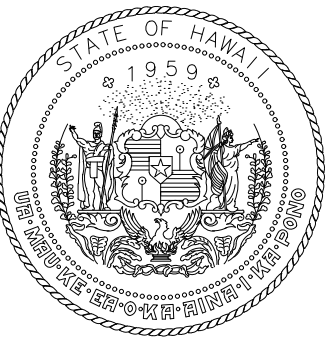

Airports Division
DEPARTMENT OF TRANSPORTATION
STATE OF HAWAII

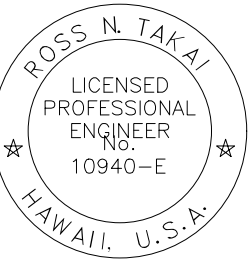

Ross N. Takai

04/30/2024
Licensed Expiration Date

This work was prepared by me or under my supervision.

DSGN.	DRWN.	CHKD.	APPD.

NO.	DATE	REVISIONS

DATE

PROJECT TITLE :

NEW PASS AND ID OFFICE

AT
DANIEL K. INOUE INTERNATIONAL AIRPORT
HONOLULU, OAHU, HAWAII

PROJECT NO.:

CO1322-63

SHEET TITLE:

ONLINE DIAGRAM

DATE :	DWG. NO.
12/21/22	E-401
SHEET :	
072 OF 100	