
 
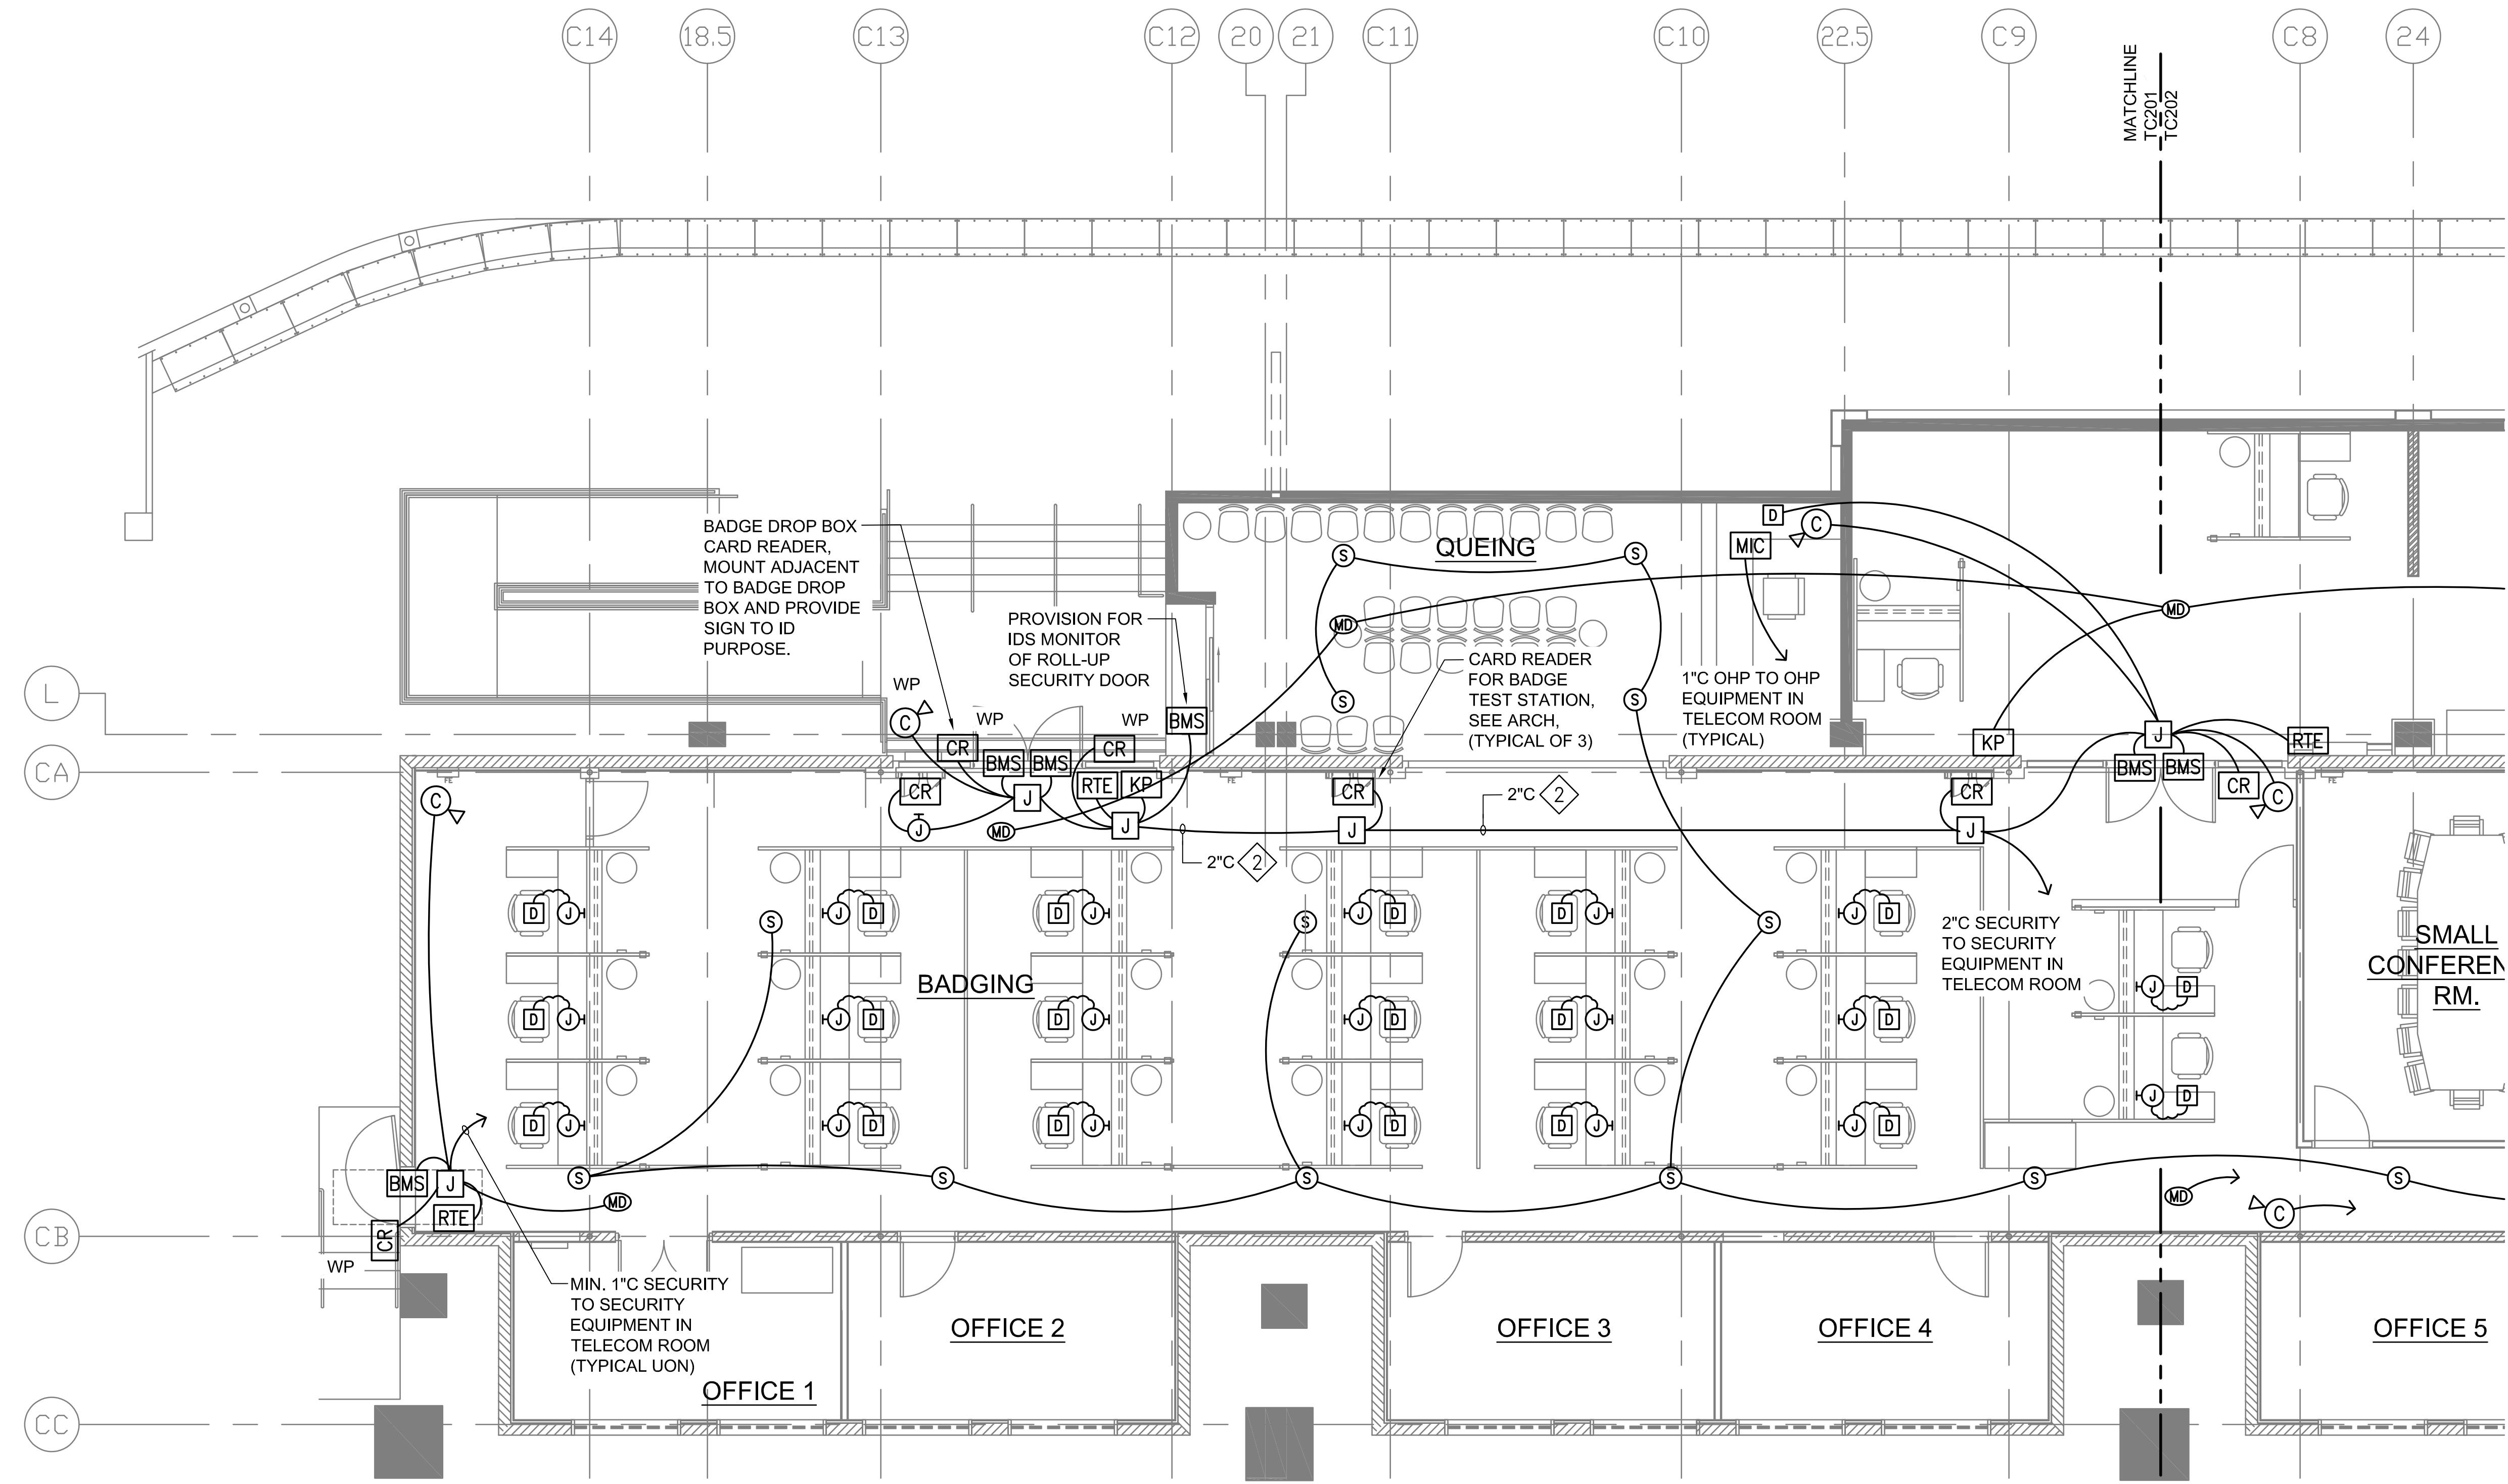


PARTIAL TELECOMMUNICATIONS PLAN 1 - MISC COMM




NOTES:

- CONTRACTOR SHALL SAWCUT/PATCH EXISTING GYPBOARD CEILINGS/SOFFITS, AS REQUIRED, TO INSTALL CONCEALED CONDUITS/WIRING.
- 2 ROUTE AS HIGH ON WALL AS PRACTICAL. COORDINATE EXACT ROUTING WITH OTHER TRADES PRIOR TO ROUGH-IN. PAINT JUNCTION BOXES AND EXPOSED CONDUITS TO MATCH SURROUNDING FINISH.

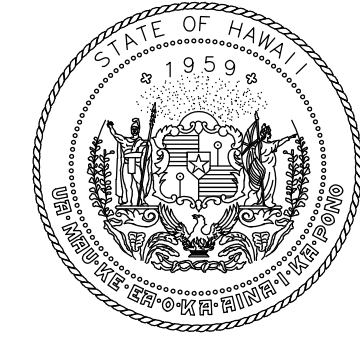

Airports Division
DEPARTMENT OF TRANSPORTATION
STATE OF HAWAII

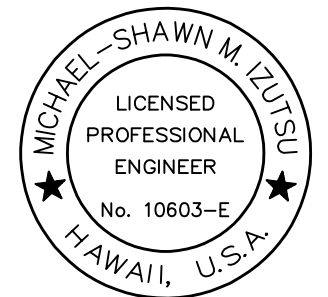

Michael-Shawn M. Zutsu
04/30/24
Licensed Expiration Date

This work was prepared by me or under my supervision.

DSGN.	DRWN.	CHKD.	APPD.
MMI	FCC	MMI	MMI

NO.	DATE	REVISIONS
-----	------	-----------

DATE

PROJECT TITLE :

NEW PASS AND ID OFFICE

AT
DANIEL K. INOUE INTERNATIONAL AIRPORT
HONOLULU, OAHU, HAWAII



PROJECT NO.:

CO1322-63


SHEET TITLE:

PARTIAL TELECOM
PLAN 1 - MISC COMM

DATE :	DWG. NO.
12/21/22	TC201
SHEET :	
091 OF 100	

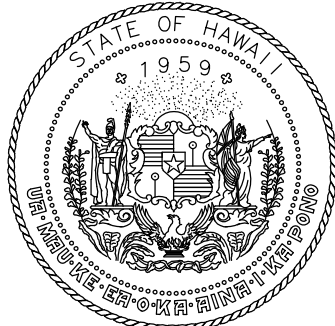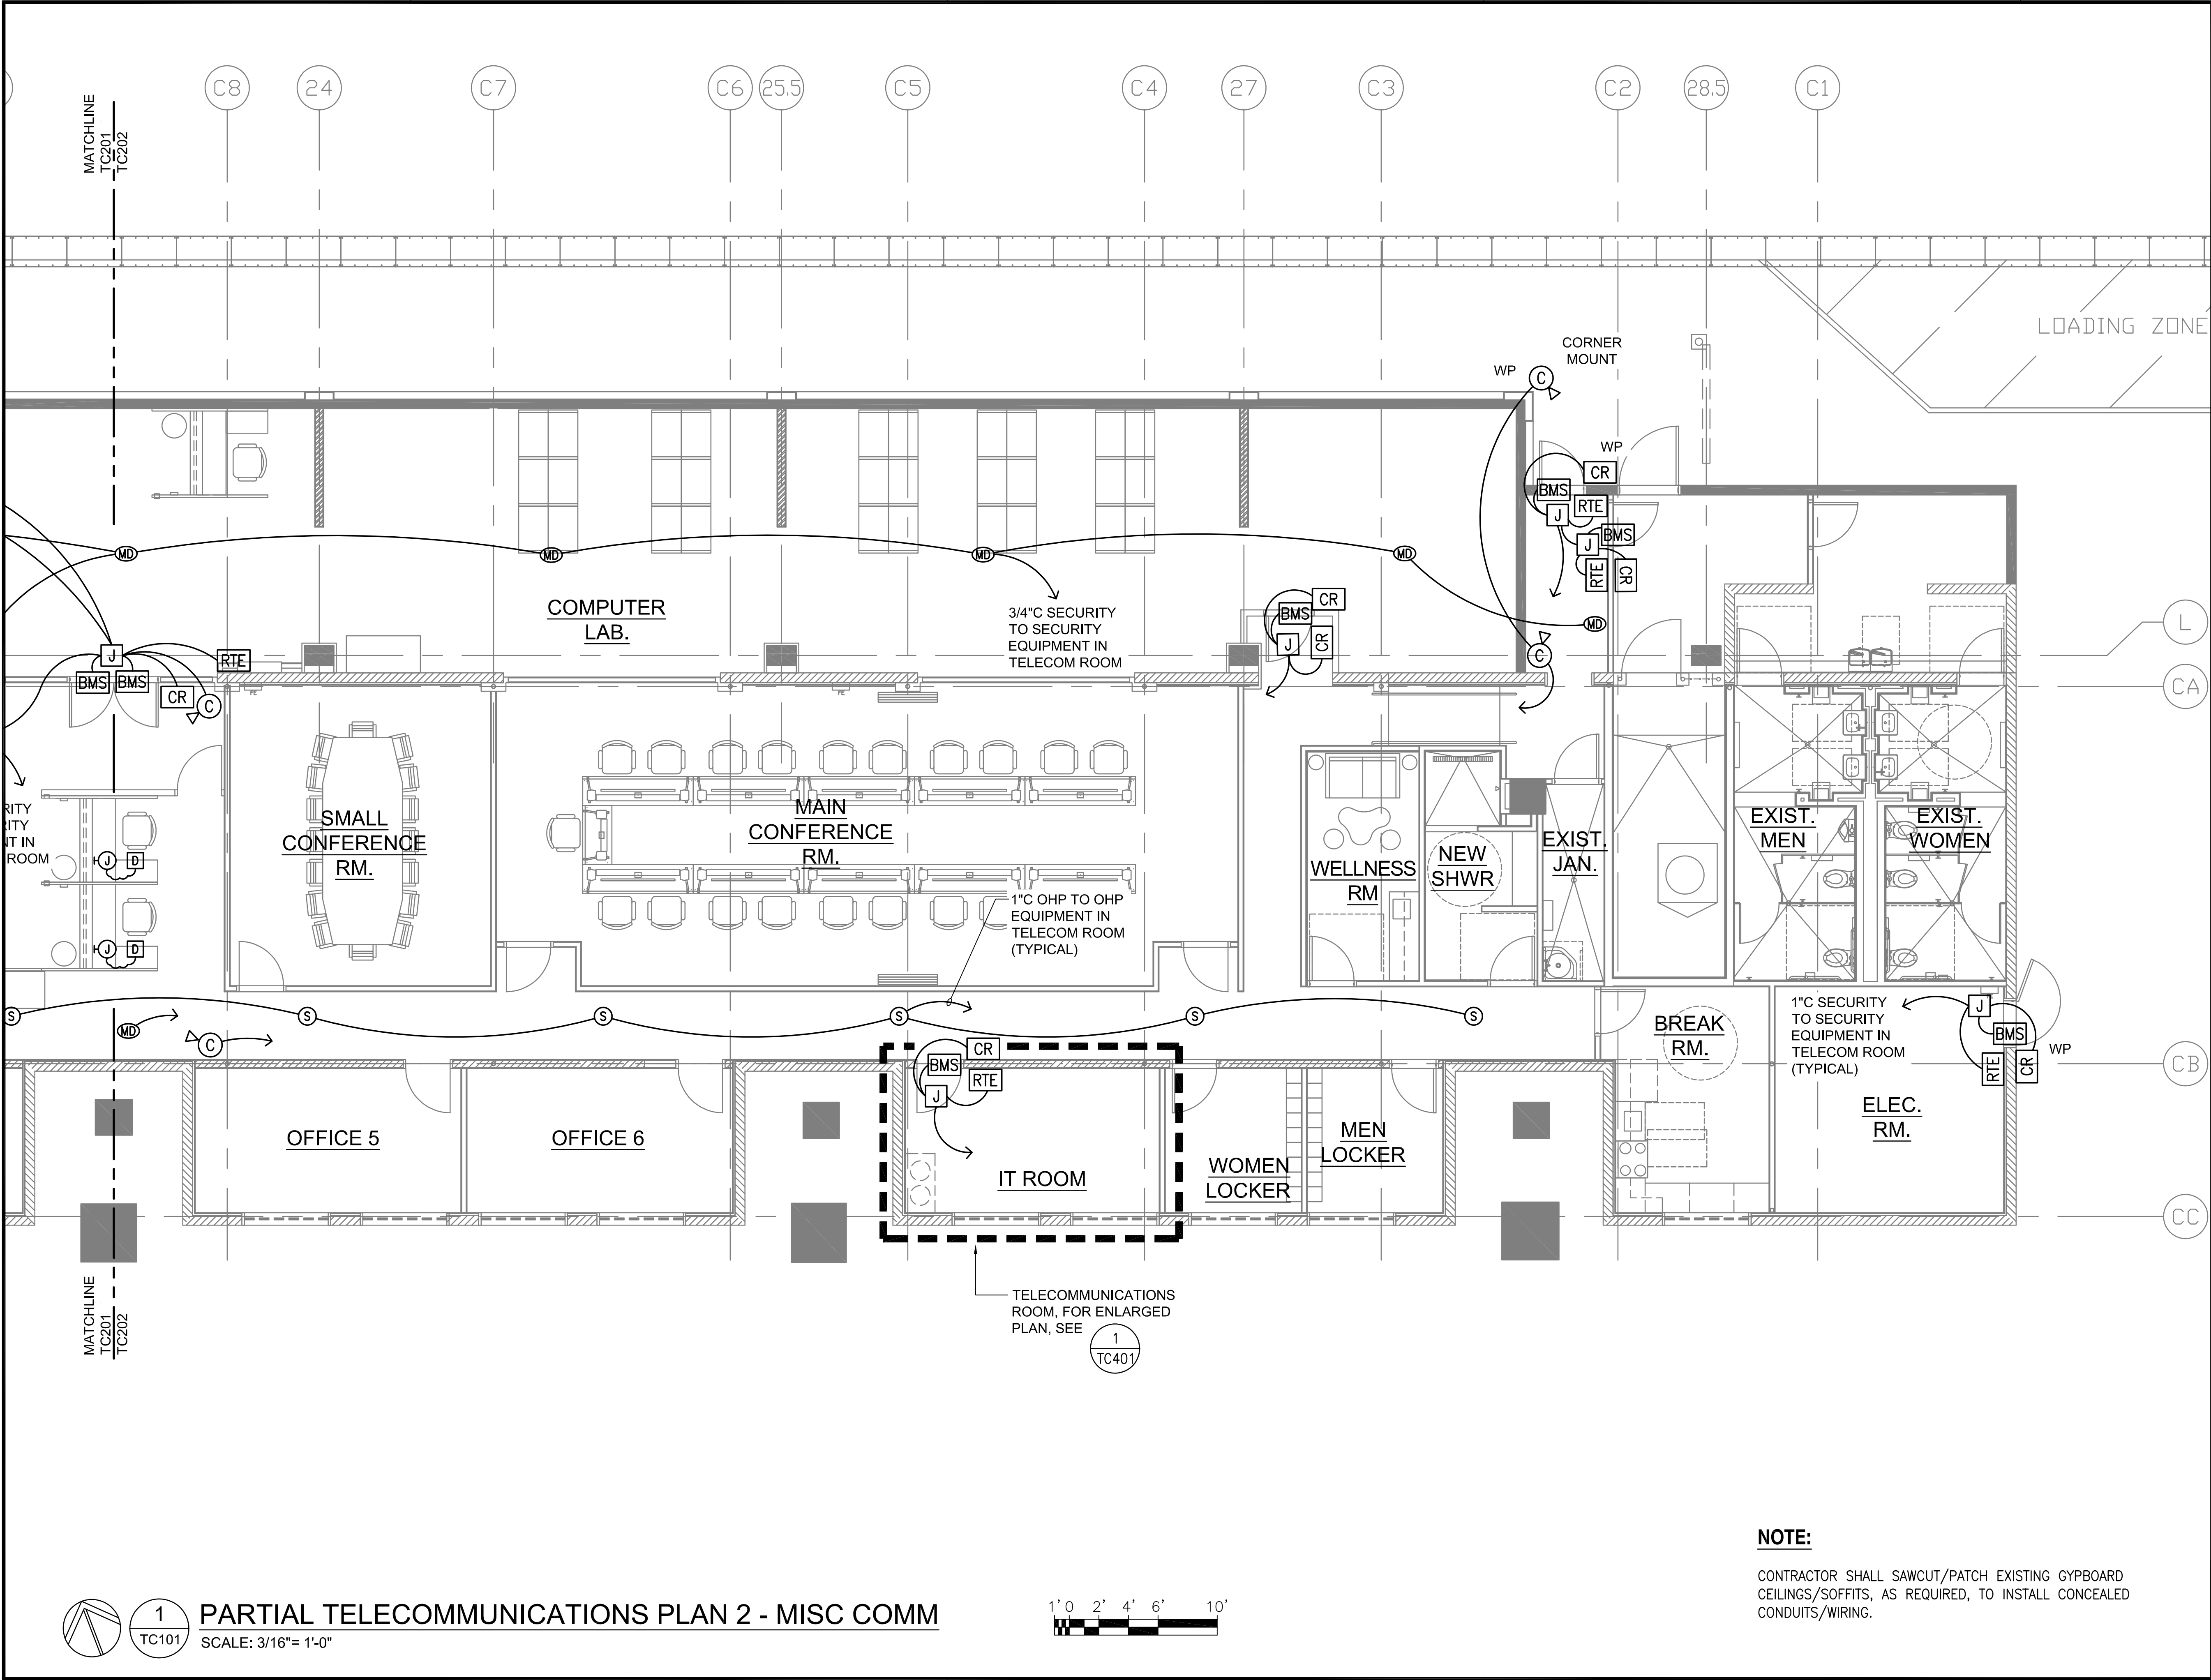

Airports Division
DEPARTMENT OF TRANSPORTATION
STATE OF HAWAII

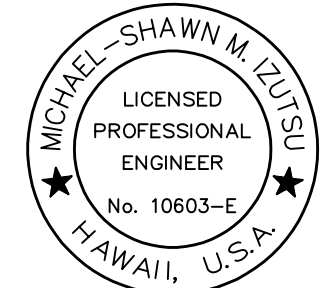

Michael-Shawn M. Zylstra

04/30/24
Licensed Expiration Date

This work was prepared by me or under my supervision.

DSGN.	DRWN.	CHKD.	APPD.
MMI	FCC	MMI	MMI

NO.	DATE	REVISIONS
-----	------	-----------

DATE


PROJECT TITLE :
NEW PASS AND ID OFFICE

AT
DANIEL K. INOUE INTERNATIONAL AIRPORT
HONOLULU, OAHU, HAWAII

PROJECT NO.:
CO1322-63


SHEET TITLE:
**PARTIAL TELECOM
PLAN 2 - MISC COMM**

DATE :	DWG. NO. TC202
12/21/22	
SHEET :	
092 OF 100	

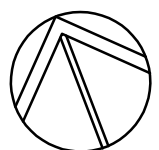

1
TC101

 PARTIAL TELECOMMUNICATIONS PLAN 2 - MISC COMM
SCALE: 3/16"= 1'-0"



NOTE:

CONTRACTOR SHALL SAWCUT/PATCH EXISTING GYPBOARD
CEILINGS/SOFFITS, AS REQUIRED, TO INSTALL CONCEALED
CONDUITS/WIRING.