


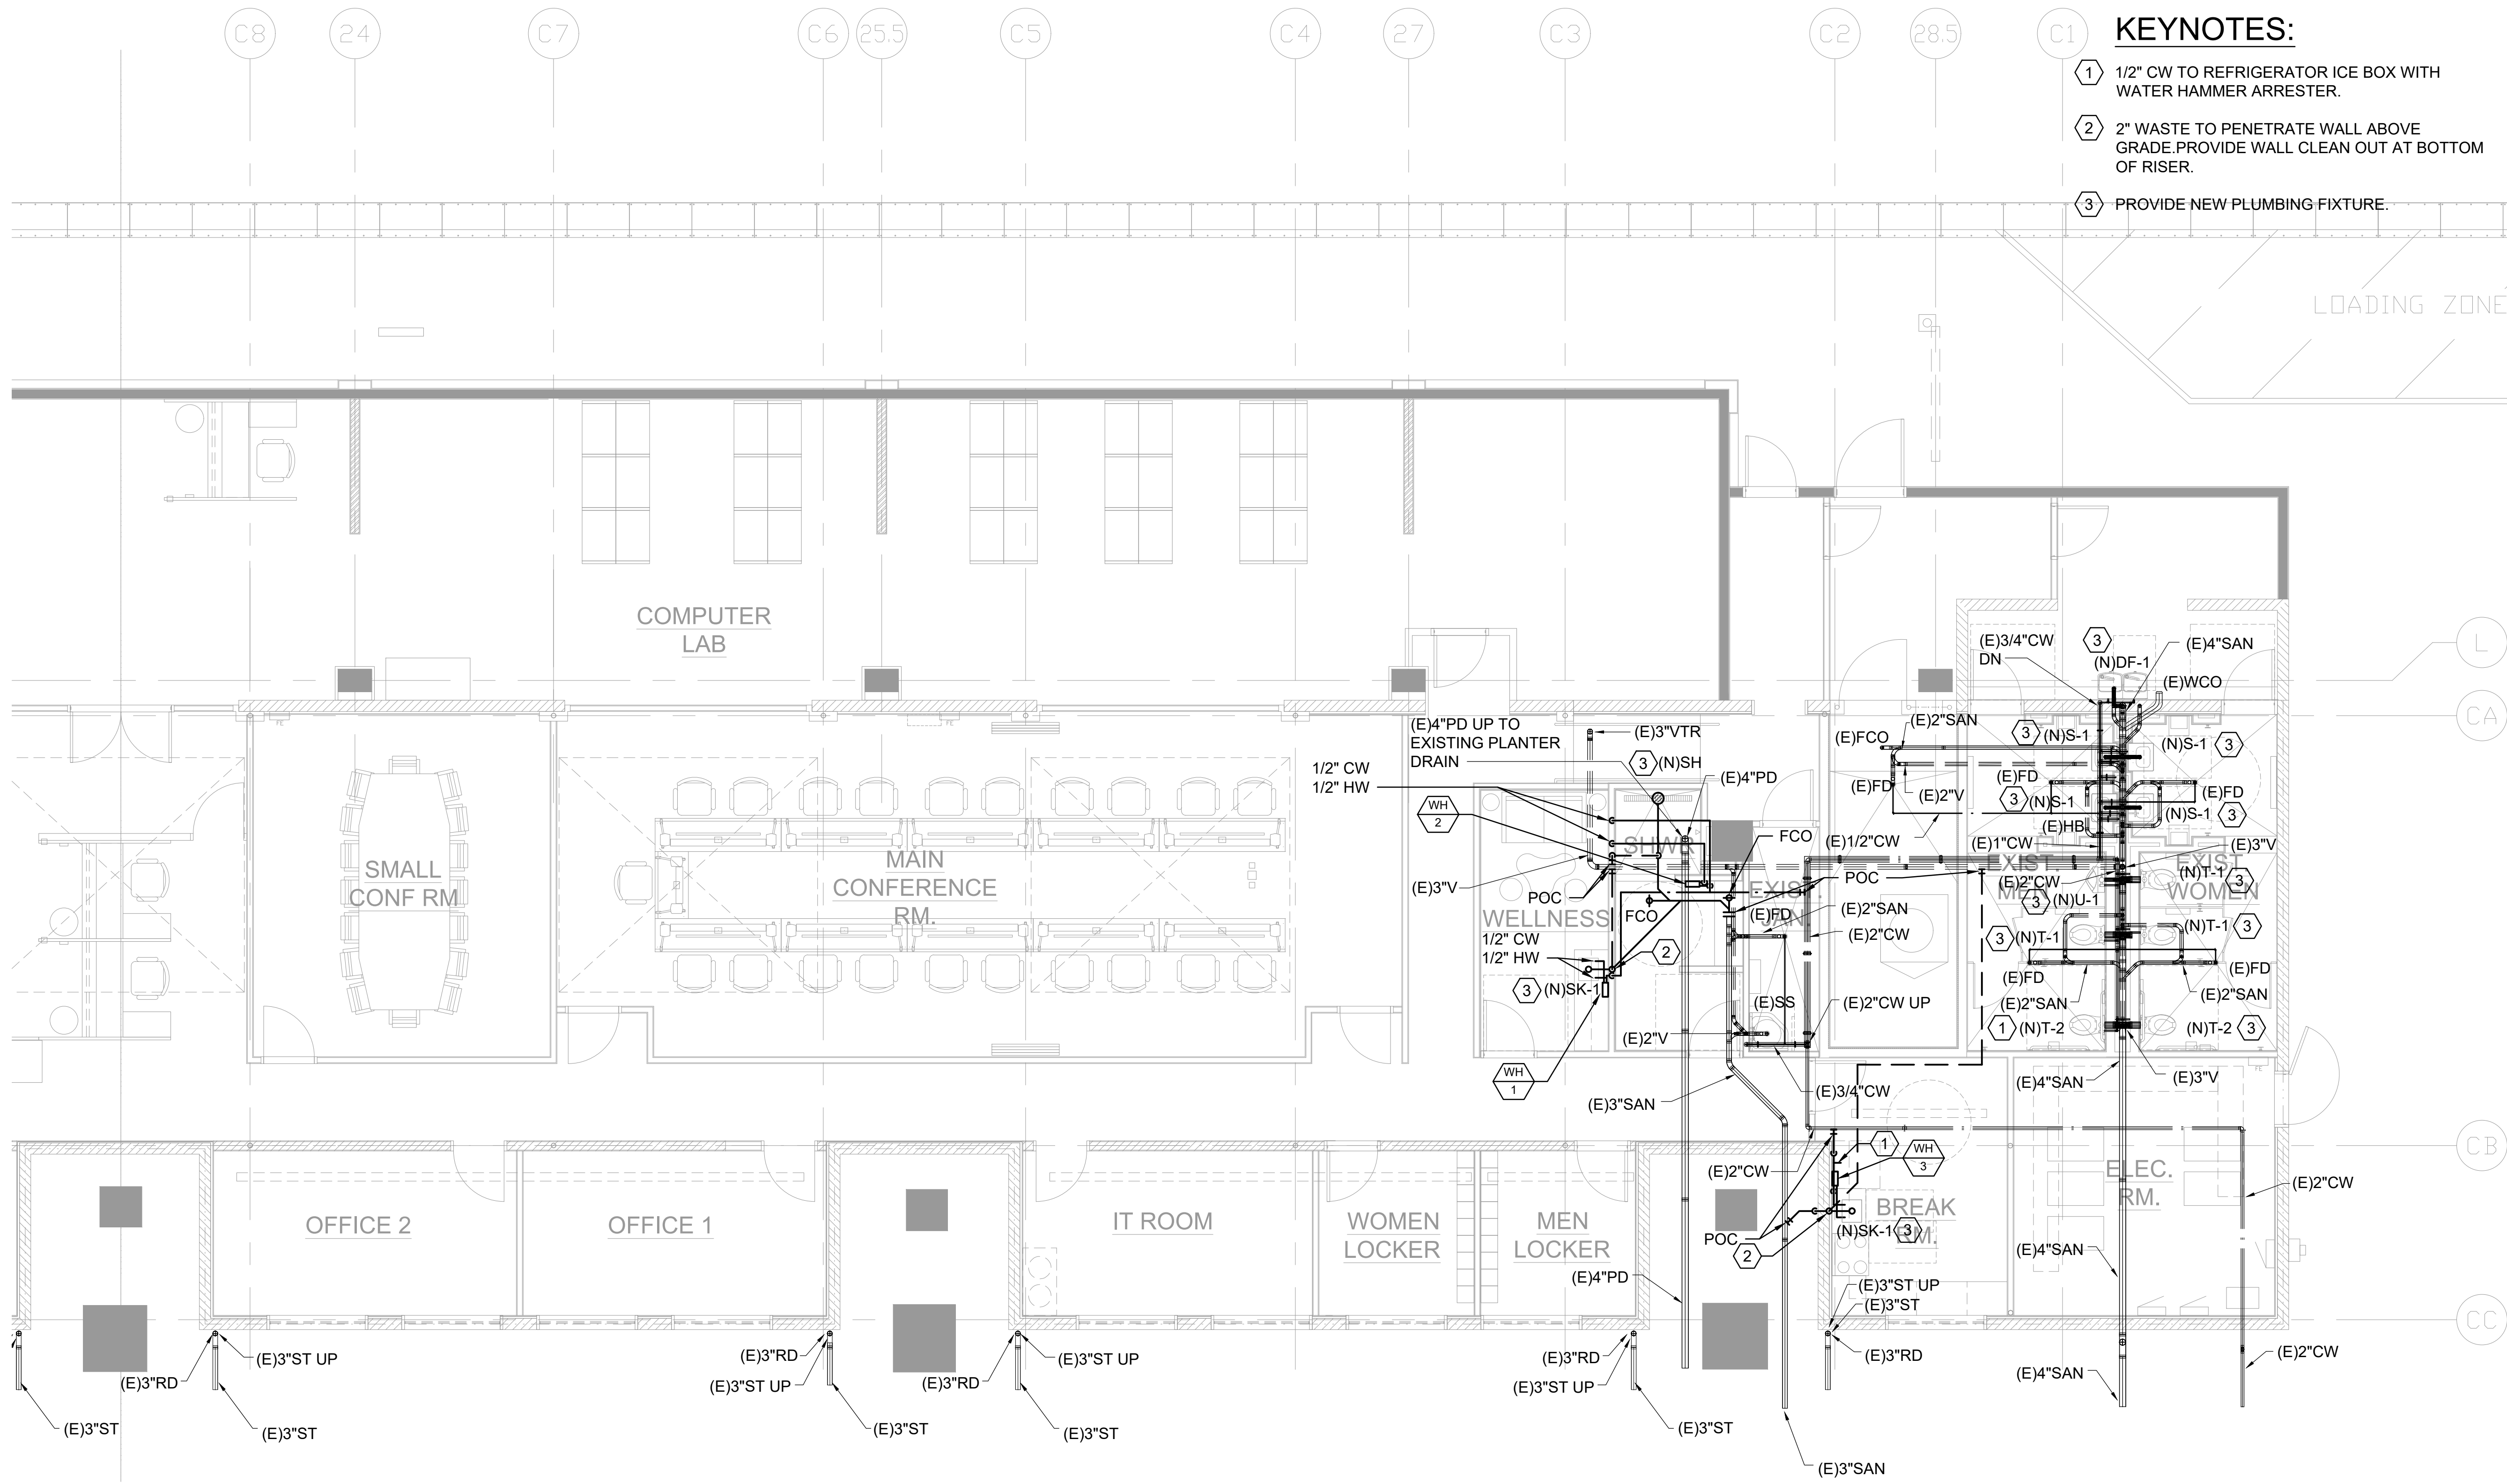


KEYNOTES:

- 1/2" CW TO REFRIGERATOR ICE BOX WITH WATER HAMMER ARRESTER.
- 2" WASTE TO PENETRATE WALL ABOVE GRADE. PROVIDE WALL CLEAN OUT AT BOTTOM OF RISER.
- PROVIDE NEW PLUMBING FIXTURE.



Airports Division
DEPARTMENT OF TRANSPORTATION
STATE OF HAWAII

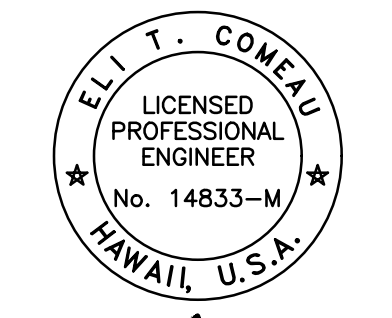

Eli T. Comeau
04/30/2024
Licensed Expiration Date

This work was prepared by me or under my supervision.

DSGN.	DRWN.	CHKD.	APPD.

NO.	DATE	REVISIONS
-----	------	-----------

DATE

PROJECT TITLE :

NEW PASS AND ID OFFICE

AT
DANIEL K. INOUE INTERNATIONAL AIRPORT
HONOLULU, OAHU, HAWAII

PROJECT NO.:

CO1322-63

SHEET TITLE:

**PLUMBING
FLOOR PLAN -
NEW WORK**

DATE : 12/21/22

SHEET : **P-102**

57 OF 100 SHEETS

DWG. NO.

