




1 TELECOMMUNICATIONS RISER DIAGRAM - STATE (DOT-A) SECURITY ESS DISTRIBUTION
TC602 NO SCALE

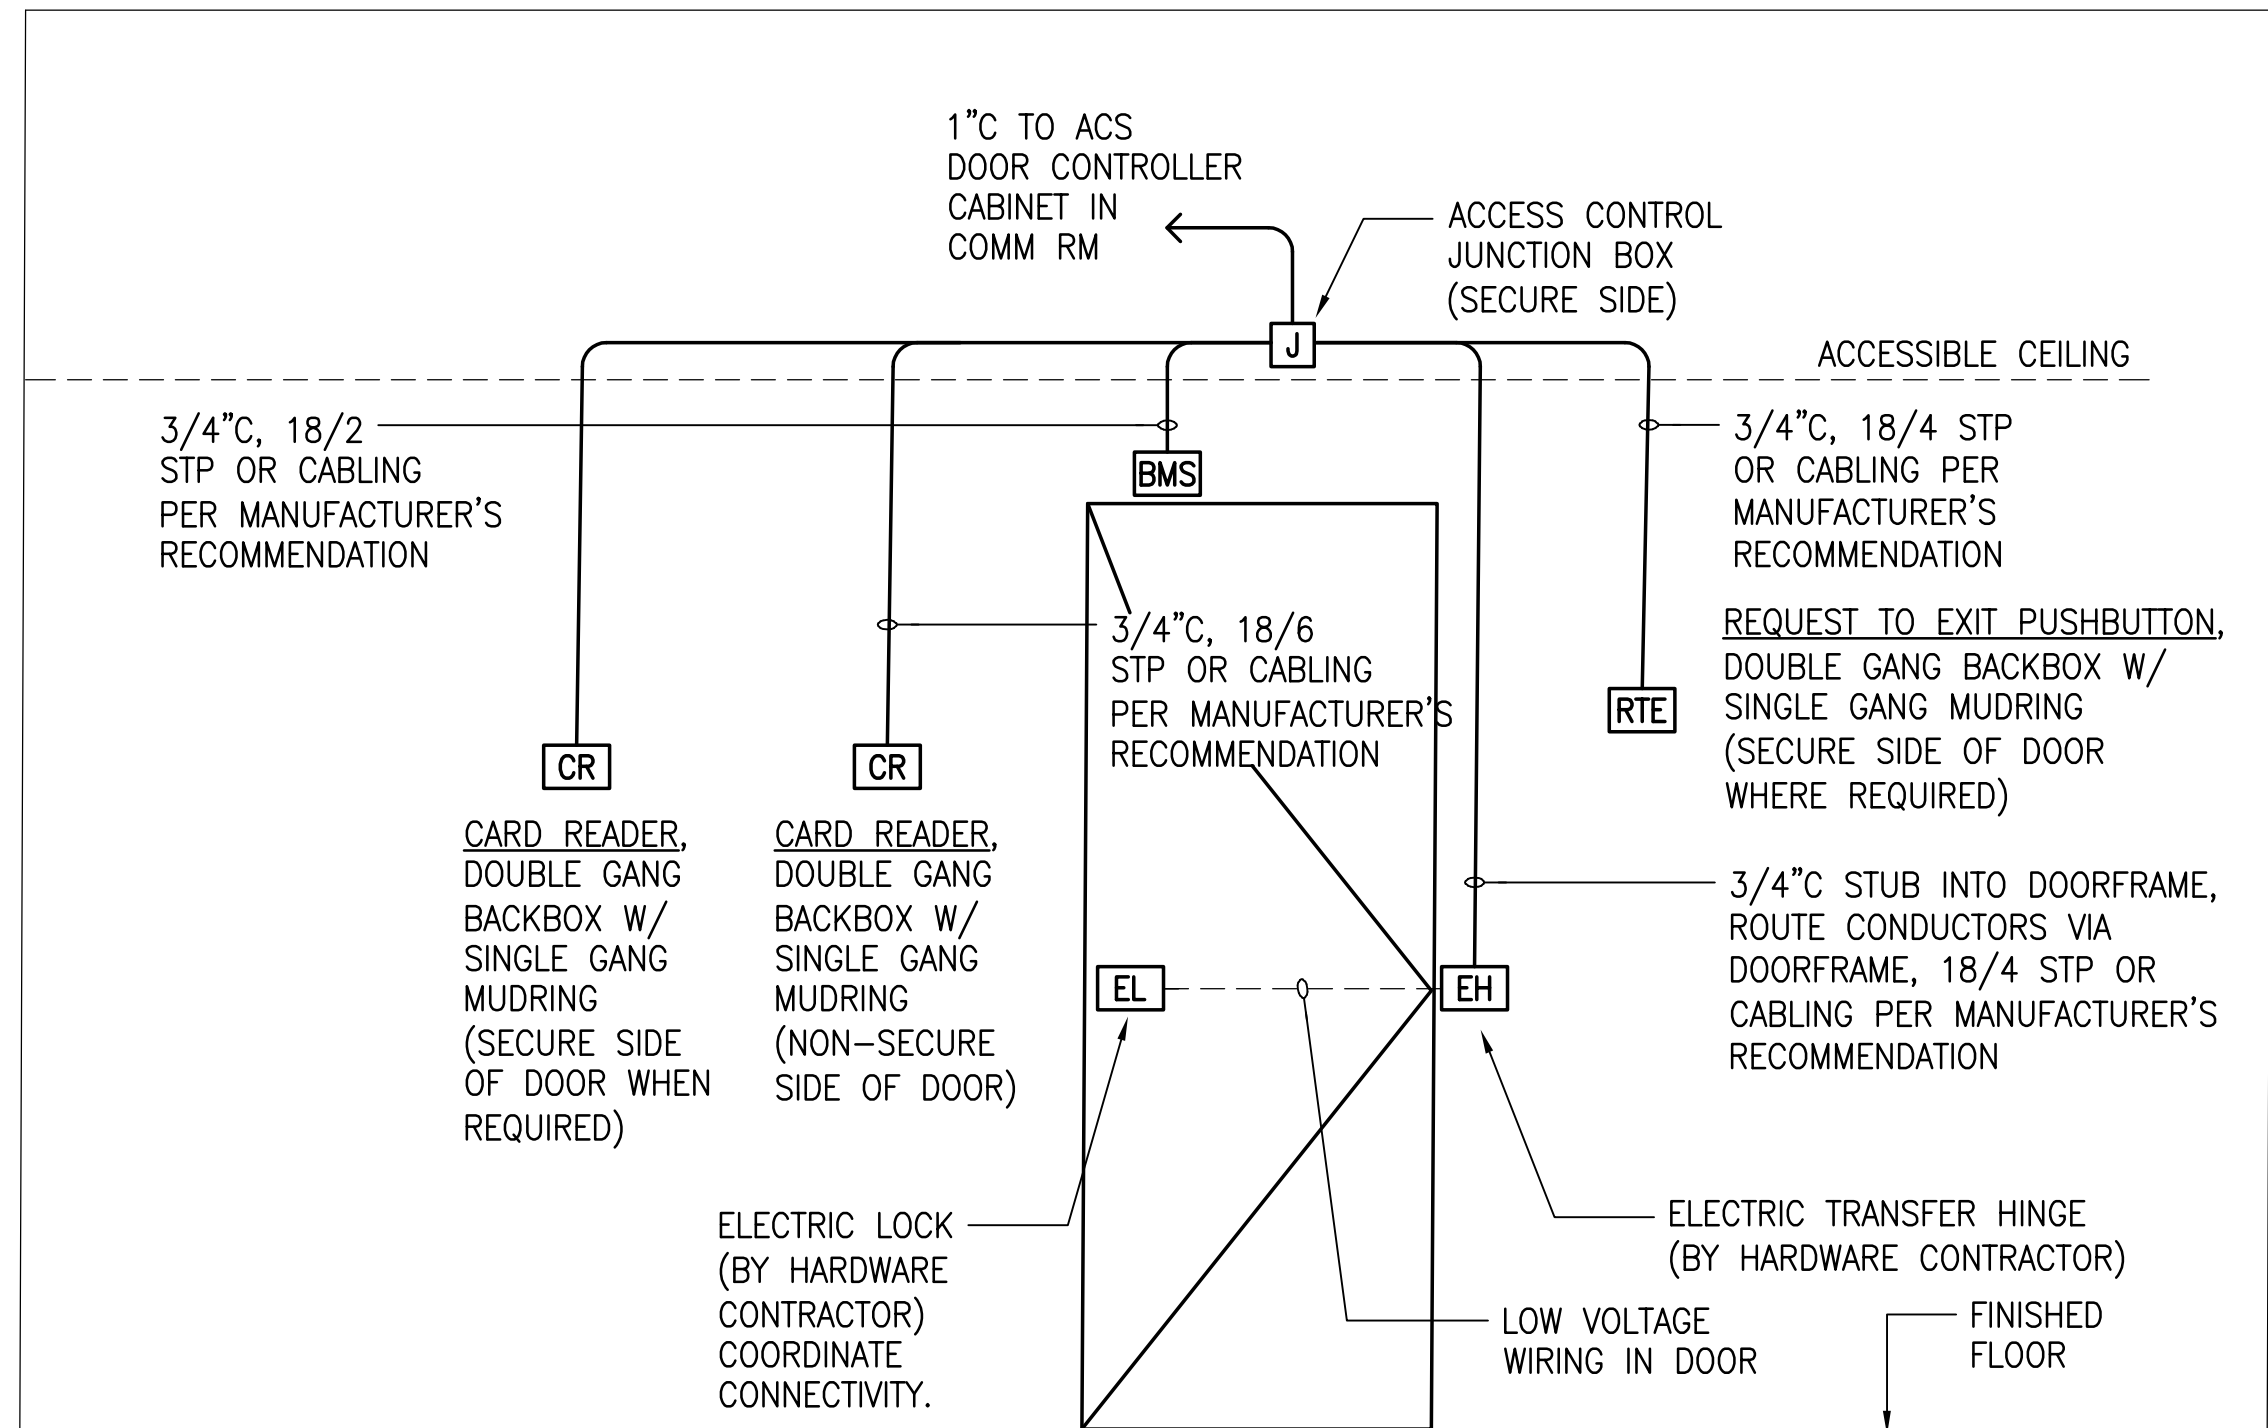


2 ACS DOOR CONNECTION DIAGRAM - SINGLE DOOR W/ ELECTRIC LOCKSET
TC602 NO SCALE

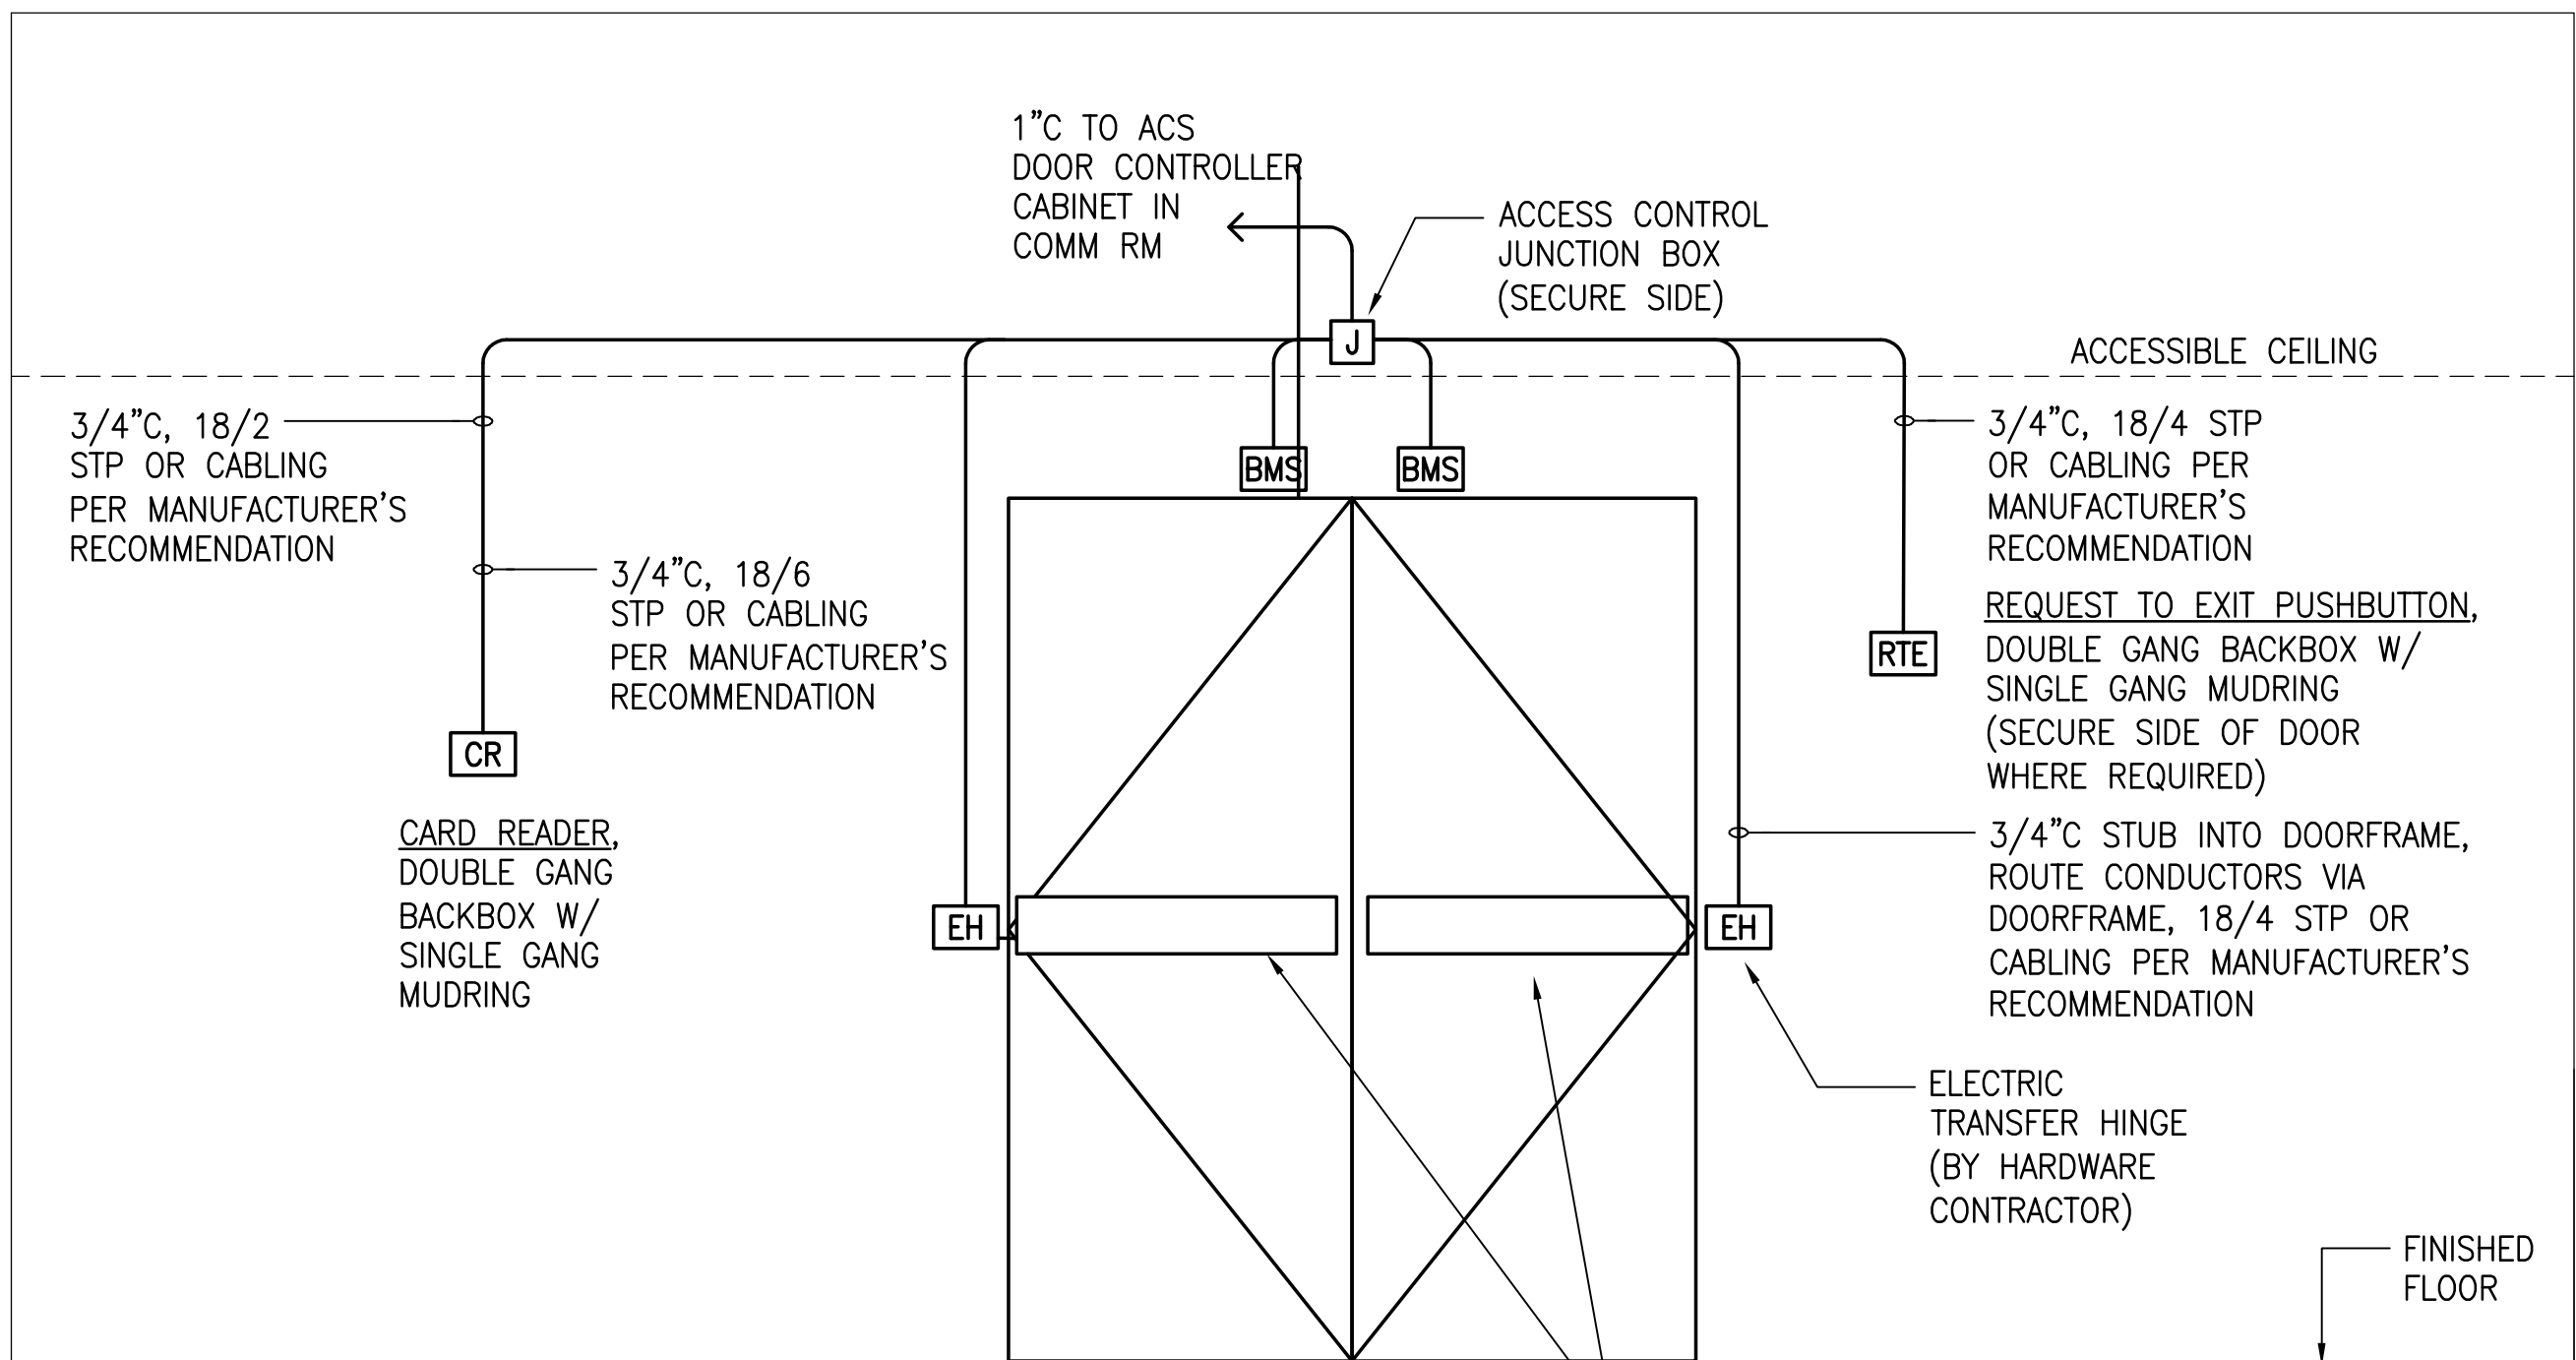

3 ACS DOOR CONNECTION DIAGRAM - DOUBLE DOOR W/ PANIC HARDWARE
TC602 NO SCALE

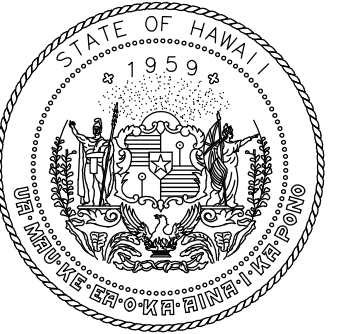

Airports Division
DEPARTMENT OF TRANSPORTATION
STATE OF HAWAII

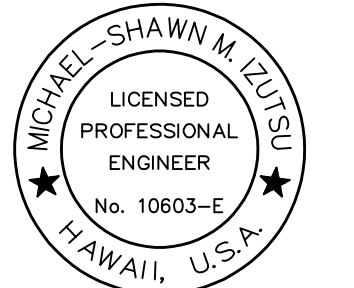

Michael-Shawn M. Zutsu
04/30/24
Licensed Expiration Date

This work was prepared by me or under my supervision.

DSGN.	DRWN.	CHKD.	APPD.
MMI	FCC	MMI	MMI

NO.	DATE	REVISIONS
-----	------	-----------

DATE

PROJECT TITLE :

NEW PASS AND ID OFFICE

AT
DANIEL K. INOUE INTERNATIONAL AIRPORT
HONOLULU, OAHU, HAWAII

PROJECT NO.:

CO1322-63

SHEET TITLE:

TELECOMMUNICATIONS
RISER DIAGRAM -
STATE (DOT-A)
ESS INFRASTRUCTURE

DATE :	DWG. NO.
12/21/22	TC603
SHEET :	
100 OF 100	