



EXISTING VAULT M
(APRON LEVEL LOBBY 5)


EXISTING ACC ROOM
(APRON LEVEL LOBBY 7)

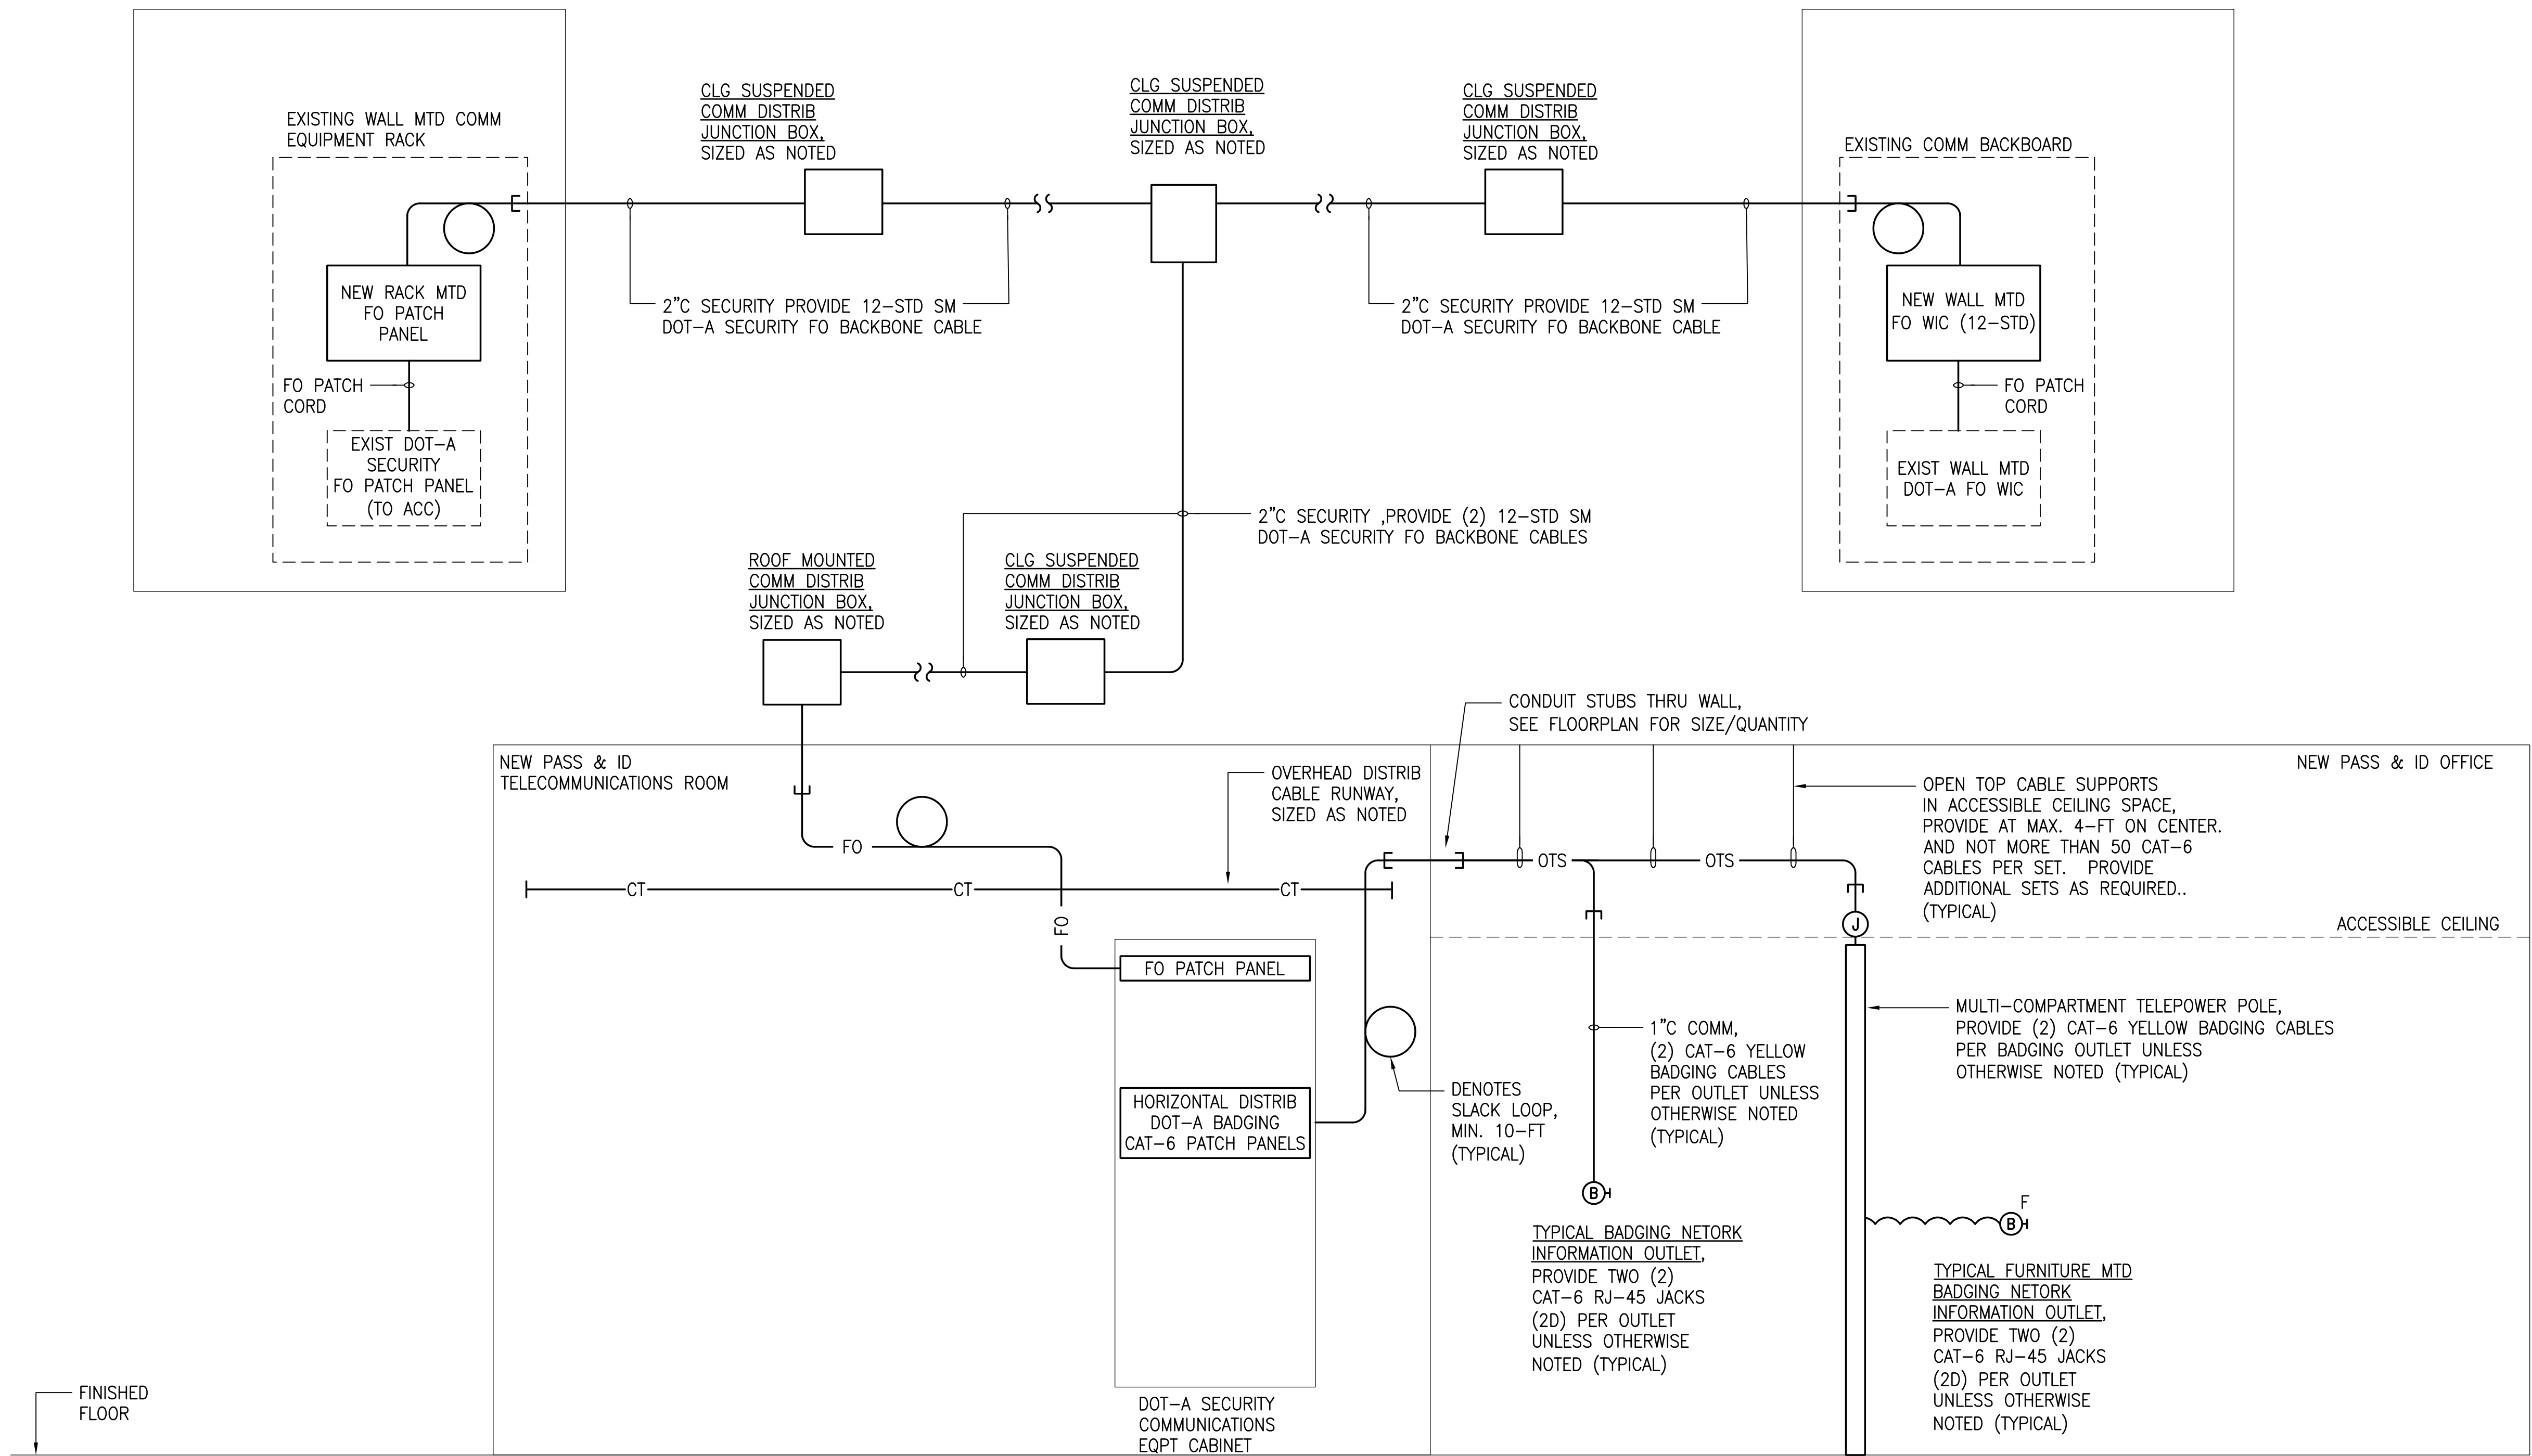

1 TELECOMMUNICATIONS RISER DIAGRAM - STATE (DOT-A) SECURITY FO BACKBONE/BADGING NETWORK
TC602 NO SCALE

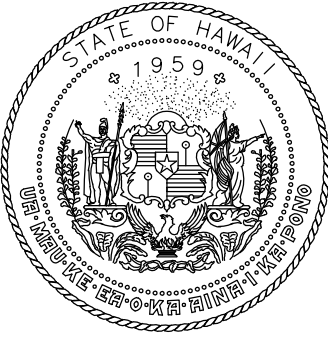

Airports Division
DEPARTMENT OF TRANSPORTATION
STATE OF HAWAII

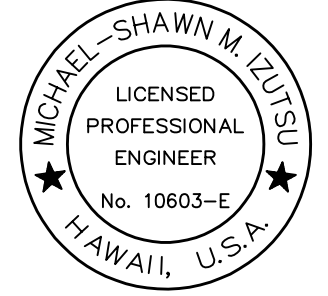

Michael-Shawn M. Zupic

04/30/24
Licensed Expiration Date

This work was prepared by me or under my supervision.

DSGN.	DRWN.	CHKD.	APPD.
MMI	FCC	MMI	MMI

NO.	DATE	REVISIONS
-----	------	-----------

DATE

PROJECT TITLE :

NEW PASS AND ID OFFICE

AT
DANIEL K. INOUE INTERNATIONAL AIRPORT
HONOLULU, OAHU, HAWAII

PROJECT NO.:

CO1322-63

SHEET TITLE:

TELECOMMUNICATIONS
RISER DIAGRAM -
STATE (DOT-A)
SECURITY FO
BACKBONE/BADGING

DATE :	DWG. NO.
12/21/22	TC602
SHEET :	
099 OF 100	