


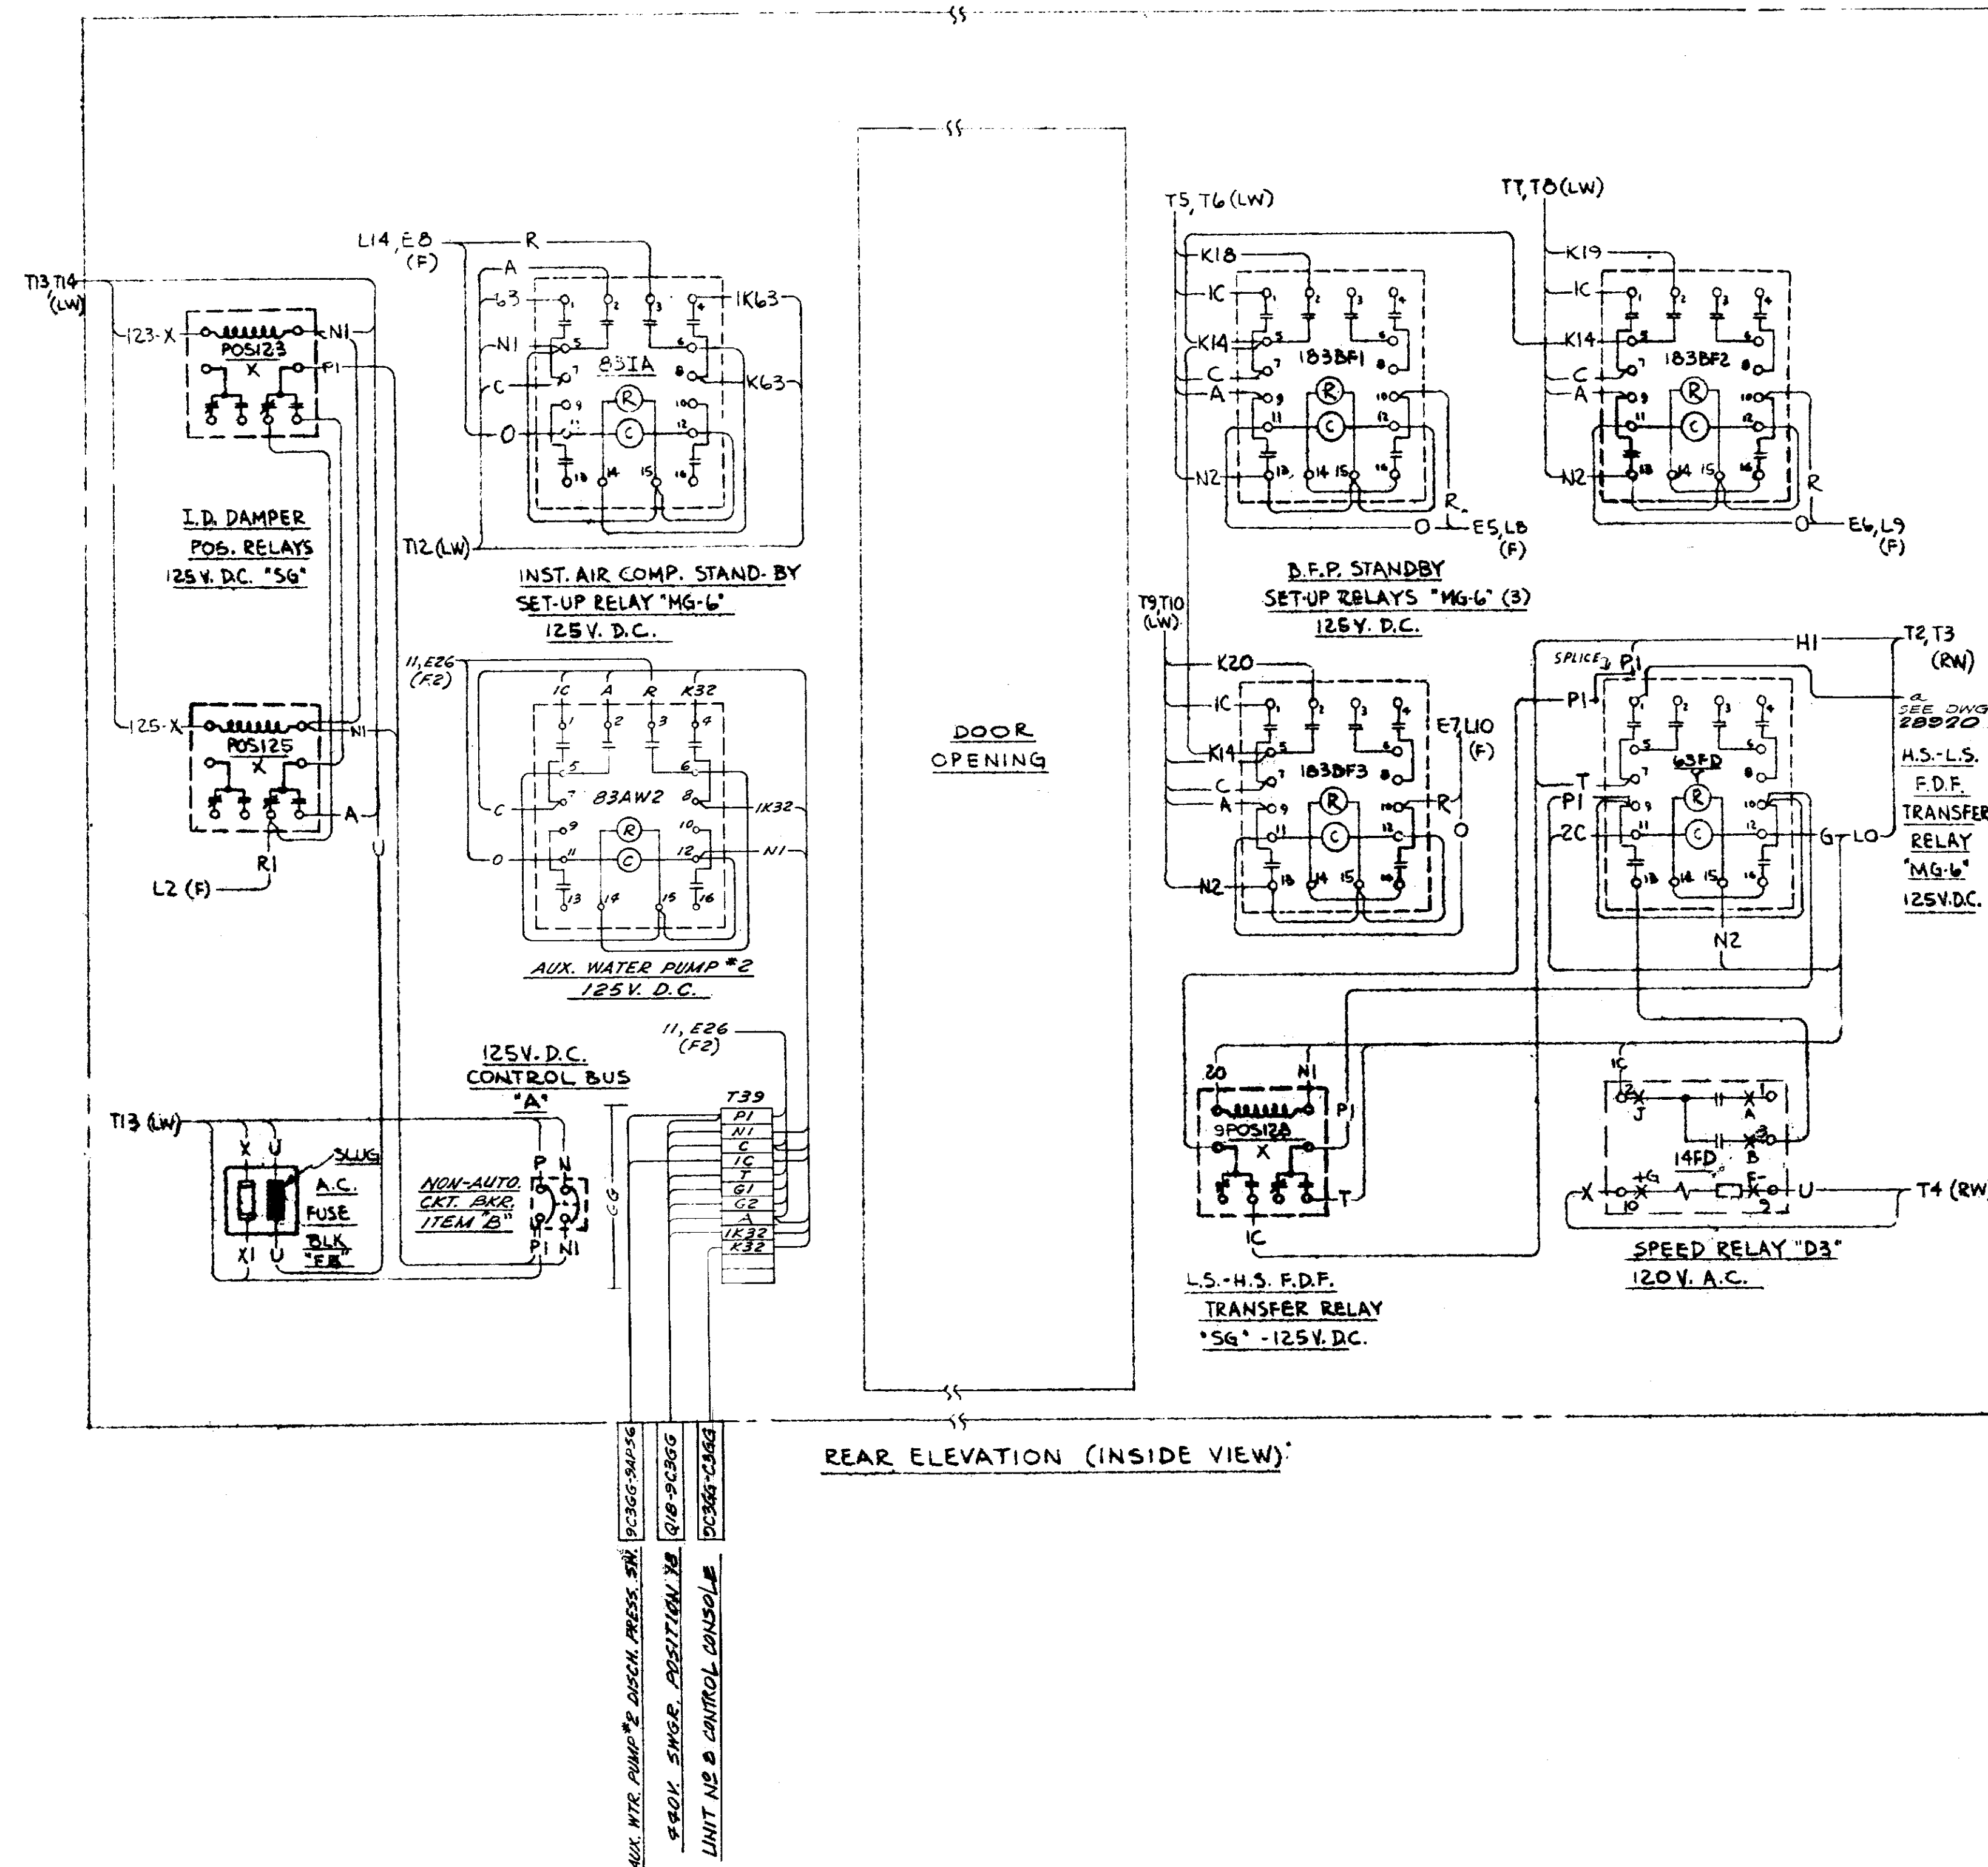


NOTES

- UNLESS OTHERWISE SPECIFIED ALL WIRING TO BE B.M. CO. NO. 55 LEAD WIRE.
- FOR CONTINUATION OF WIRE GROUPS CODED:
 - (F) - FRONT - DWG 28920
 - (RW) - RIGHT WING - DWG 28922
 - (LW) - LEFT WING - DWG 28921
 - (F2) - FRONT SECT 2 - DWG 27920
- FOR REFERENCE SEE DWG 28920.

NO. 4-21-80		DATE		REVISIONS		BY		CHK'D		APP'D	
CONTROL CONSOLE WIRING DIAGRAM - REAR ELEVATION, SECTION 1 HONOLULU UNIT NO. 9											
DESIGNED		B.M. CO.		DRAWN		DATE: 1-7-80		SCALE: NONE			
CHECKED		ELEC.		MECH.		STRUC.		ENGINEERING DEPARTMENT		HAWAIIAN ELECTRIC CO., INC.	
APPROVAL		BAILEY METER CO.		C903324-C		DRAWING NUMBER		REV			
HONO FILE NO. 9-2393		28923									

KALANIANA'OLE HIGHWAY WIDENING PHASE I

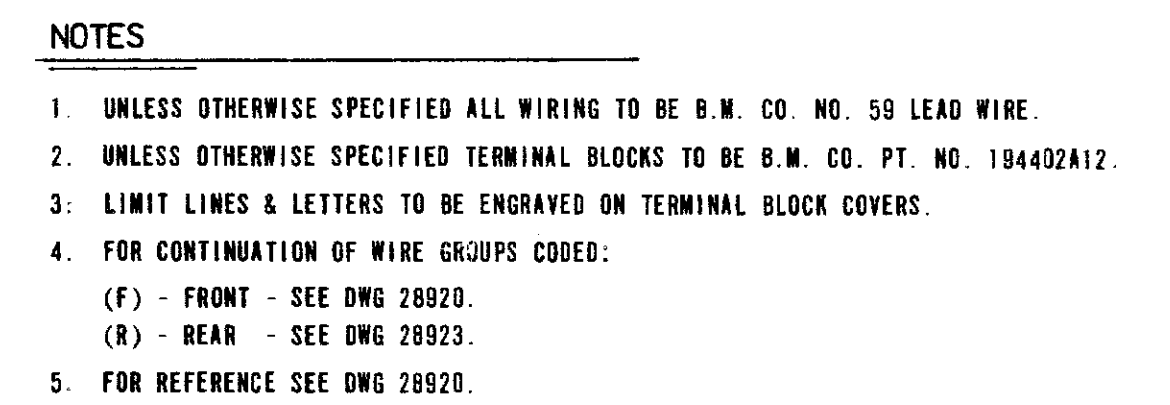

0 4-21-86		REDUN FROM BAILEY METER CO DWG		11 2	
NO. DATE		REVISIONS		BY CHK'D APP'D	
CONTROL CONSOLE WIRING DIAGRAM - RIGHT WING, SECTION 1 HONOLULU UNIT NO. 9					
DESIGNED BN CO.		DRAWN 11		DATE: 4-4-86 SCALE: NONE	
CHECKED		ELEC. MECH. STRUC.		ENGINEERING DEPARTMENT	
APPROVAL				HAWAIIAN ELECTRIC CO. INC.	
BAILEY METER CO.				HONOLULU, HAWAII	
C803325-B				DRAWING NUMBER	
HECO FILE NO. 9-2394				2 8 9 2 2	

KALANIANA'OLE HIGHWAY WIDENING PHASE I